


NOTES:

1. ALLOW TO REMOVE ALL REDUNDANT IRRIGATION LINES ON SITE.

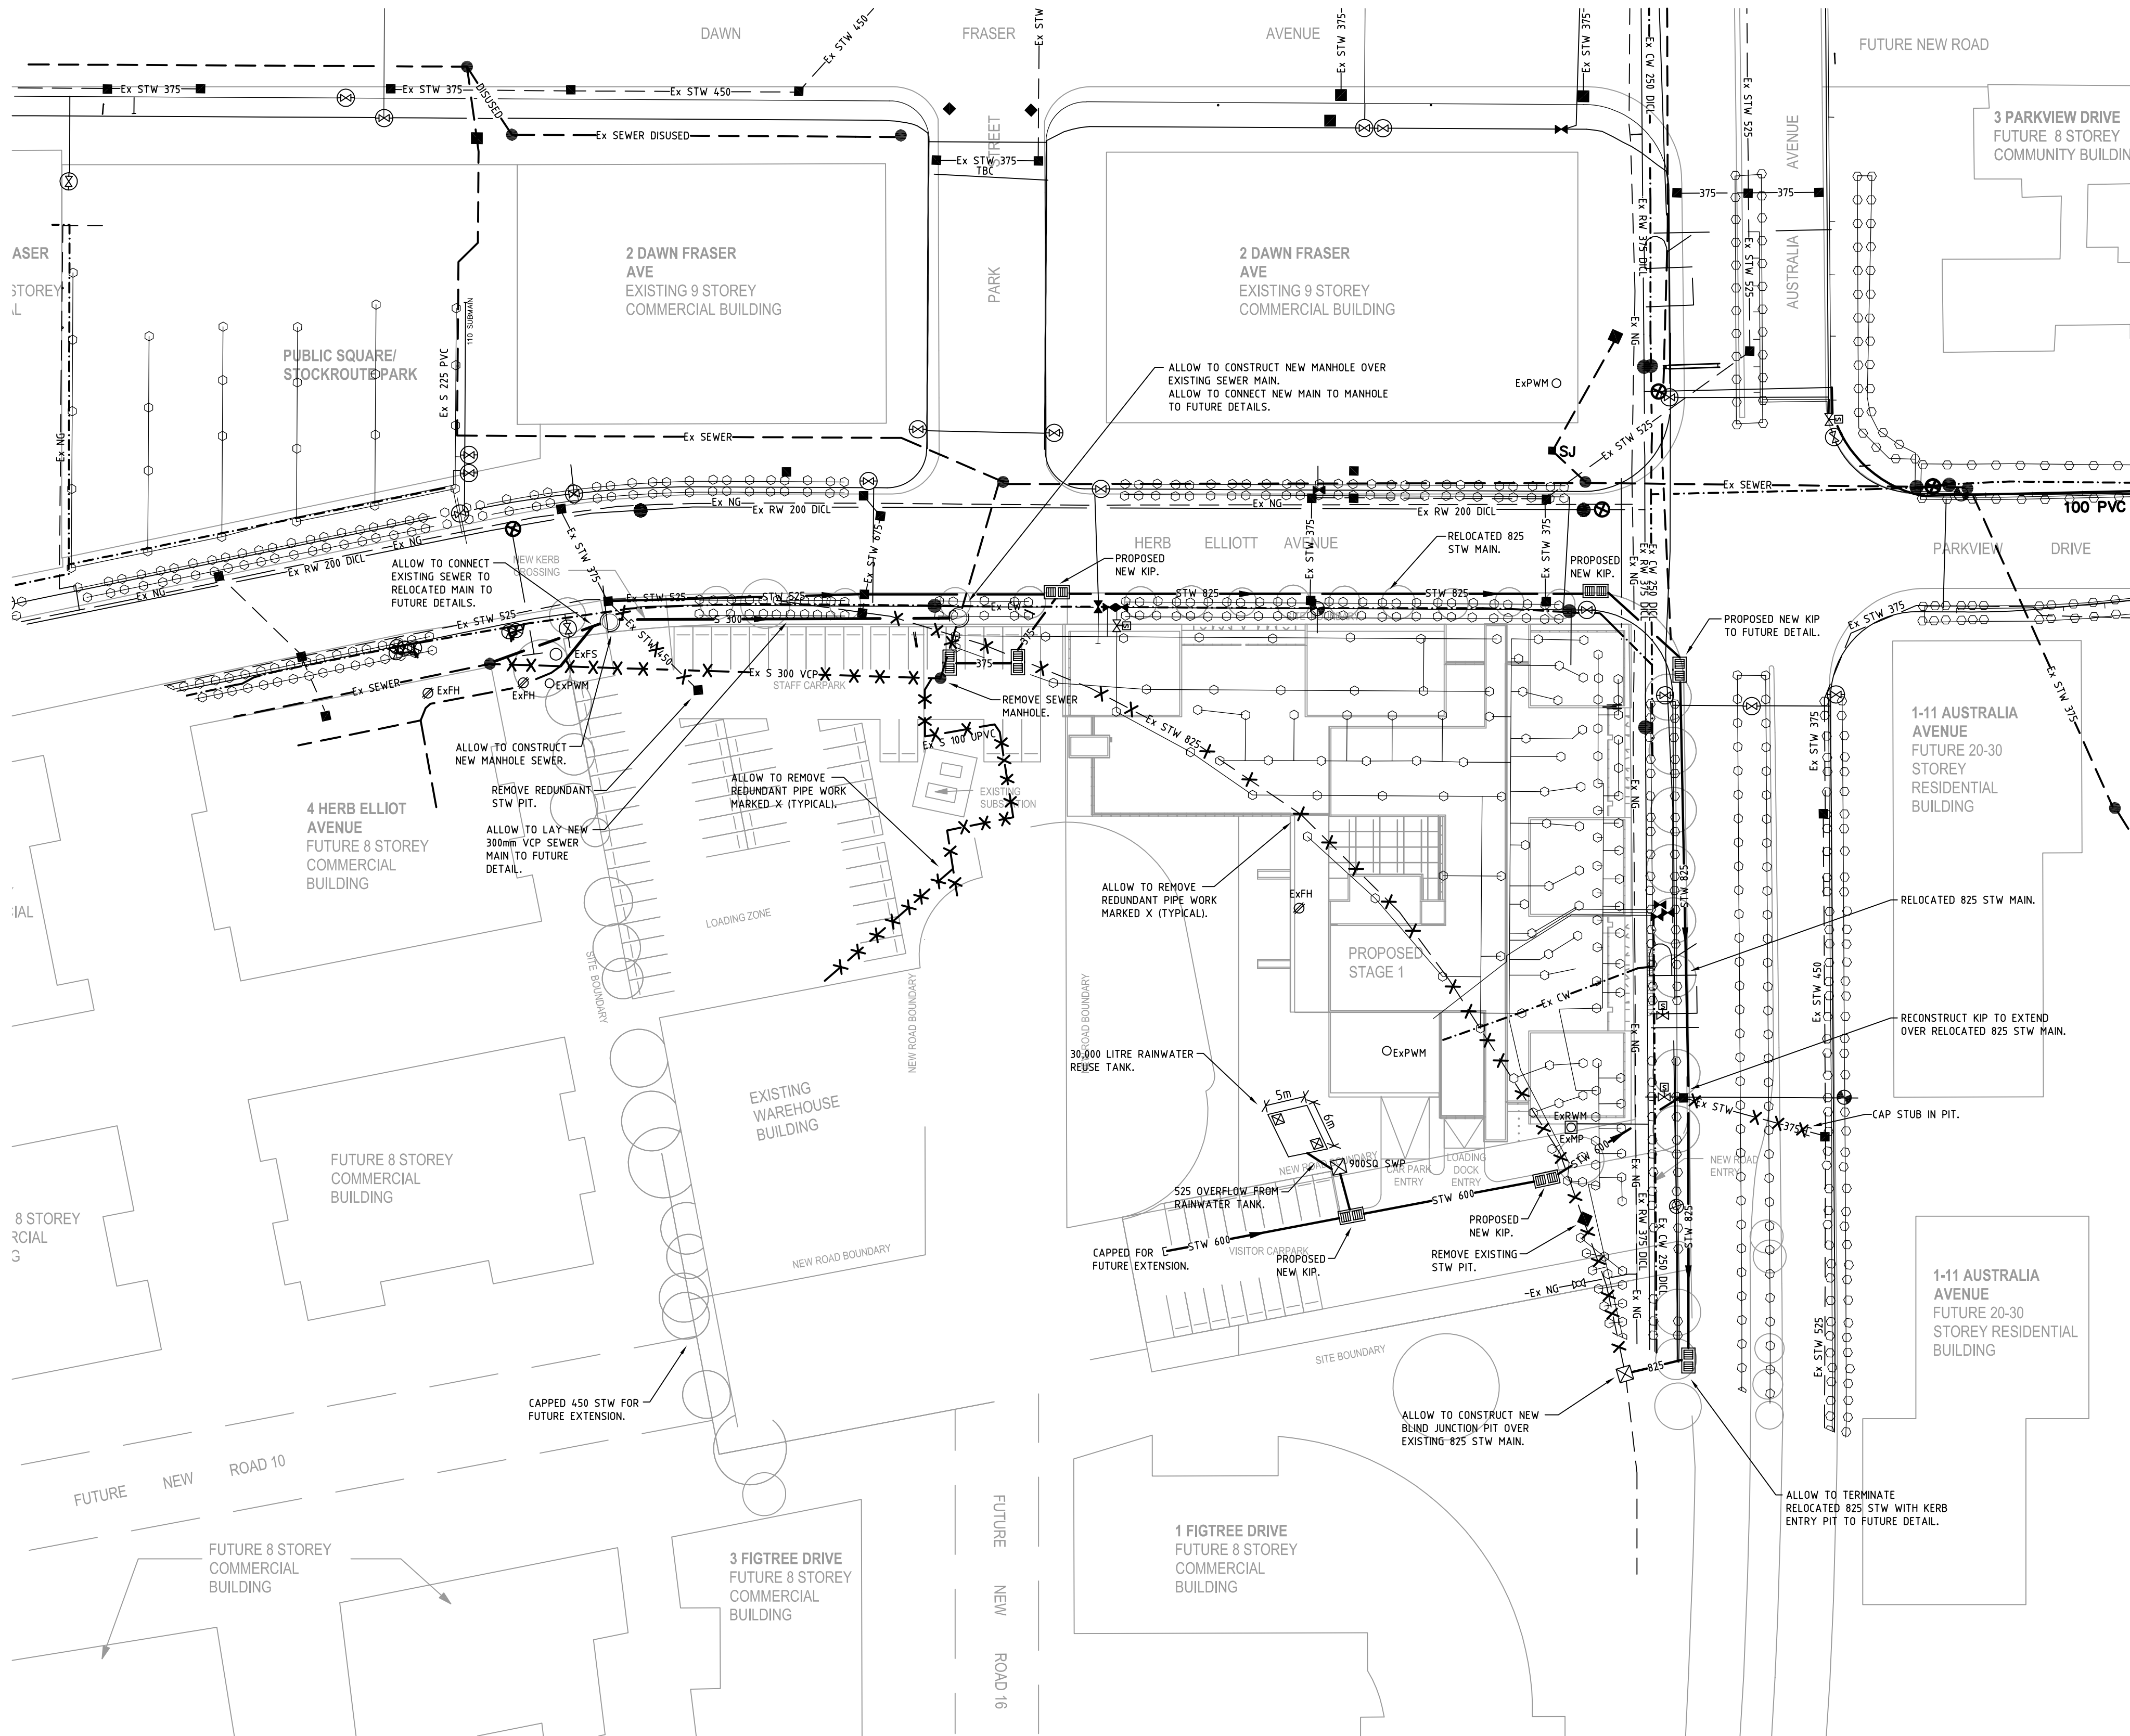

APPLICATION ISSUE

A DEVELOPMENT APPLICATION ISSUE

97.06.12

NL

NL

No.

REVISION/ISSUE

DATE

BY

CHECKED

CLIENT

Capital Corporation Pty Ltd

Suite 705/12 Century Circuit, Baulkham Hills NSW 2153
Tel: 02 8853 5000 Fax: 02 8853 5099

HYDRAULIC CONSULTANT

Neil Lowry & Associates Pty Ltd
hydraulic & fire services consultants

Level 3, Suite 1, 29 Kiora Road, Miranda NSW 2228
Tel: 61 2 9526 7922 Fax: 61 2 9526 7944
Email: admin@nlaapl.com.au
Neil Lowry & Associates Pty Ltd ABN 72 101 872 984

ARCHITECT

architectus™

Architectus Sydney
Level 3 341 George Street
Sydney NSW 2000
T (61 2) 8252 8400
F (61 2) 8252 8600
sydney@architectus.com.au
ABN 11 098 489 448

PROJECT

SITE 43/44
SYDNEY OLYMPIC
PARK

DRAWING

STORMWATER CONCEPT
SITE PLAN

DRAWN

DESIGNED

CHECKED

KJ

NL

NL

DATE

SCALE

JUNE 12

1:500@A1

PROJECT

DWG No.

REV

STATUS

0583

SC02

A

DA ISSUE