



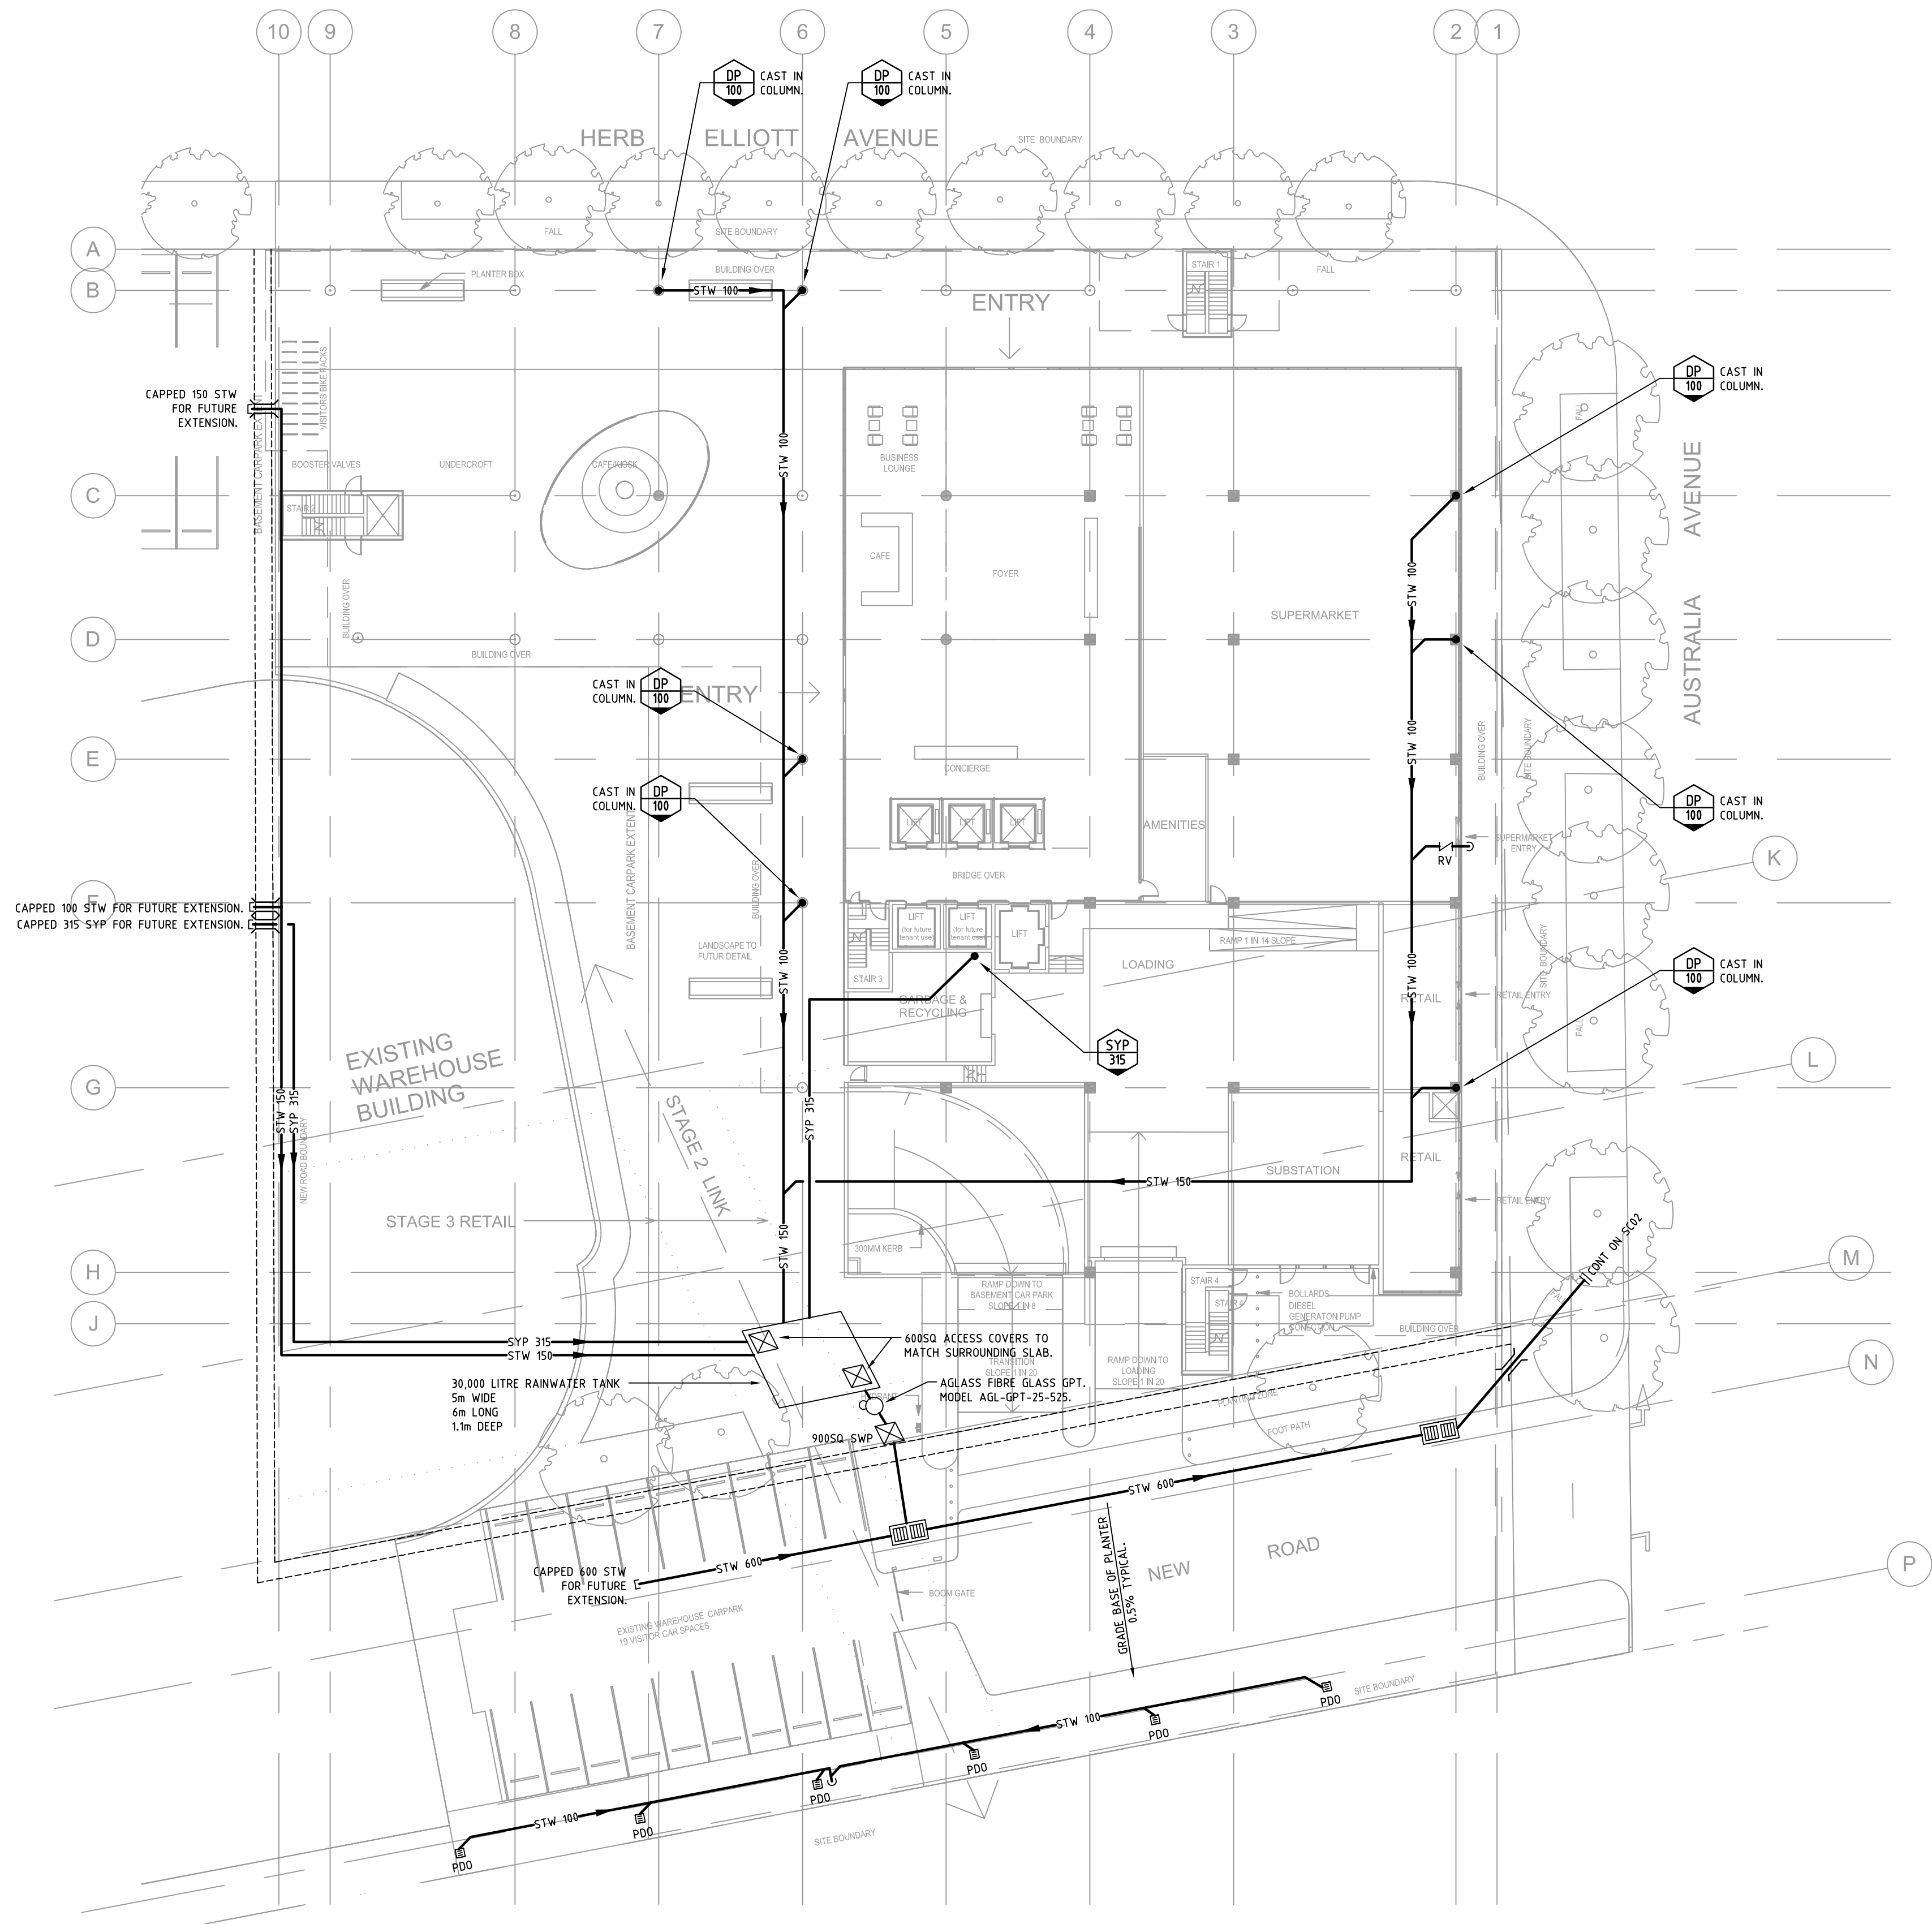

APPLICATION ISSUE

A	DEVELOPMENT APPLICATION ISSUE	07.06.12	NL	NL
No.	REVISION/ISSUE	DATE	BY	CHECKED

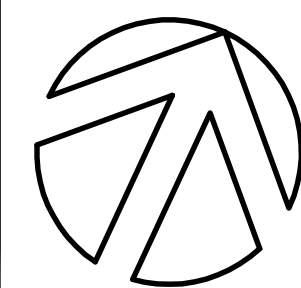

CLIENT
Capital Corporation Pty Ltd

Suite 705/12 Century Circuit, Baulkham Hills NSW 2153
Tel: 02 8853 5000 Fax: 02 8853 5099

HYDRAULIC CONSULTANT
Neil Lowry & Associates Pty Ltd
hydraulic & fire services consultants

Level 3, Suite 1, 29 Kiara Road, Miranda NSW 2228
Tel: 61 2 9526 7922 Fax: 61 2 9526 7944
Email: admin@nlaapl.com.au
Neil Lowry & Associates Pty Ltd ABN 72 101 872 984

ARCHITECT
architectusTM
Architectus Sydney
Level 3 341 George Street
Sydney NSW 2000
Sydney Melbourne
Auckland
Brisbane
Shanghai
T (61 2) 8252 8400
F (61 2) 8252 8600
sydney@architectus.com.au
ABN 11 098 489 448

PROJECT
**SITE 43/44
SYDNEY OLYMPIC
PARK**

DRAWING
**STORMWATER CONCEPT
GROUND FLOOR PLAN**

DRAWN	DESIGNED	CHECKED	DATE	SCALE
KJ	NL	NL	JUNE 12	1:250@A1
PROJECT	DWG No.	REV	STATUS	
0583	SC05	A	DA ISSUE	