

200

150

100

90

80

70

60

50

40


30

20


10

0

A1 SHEET

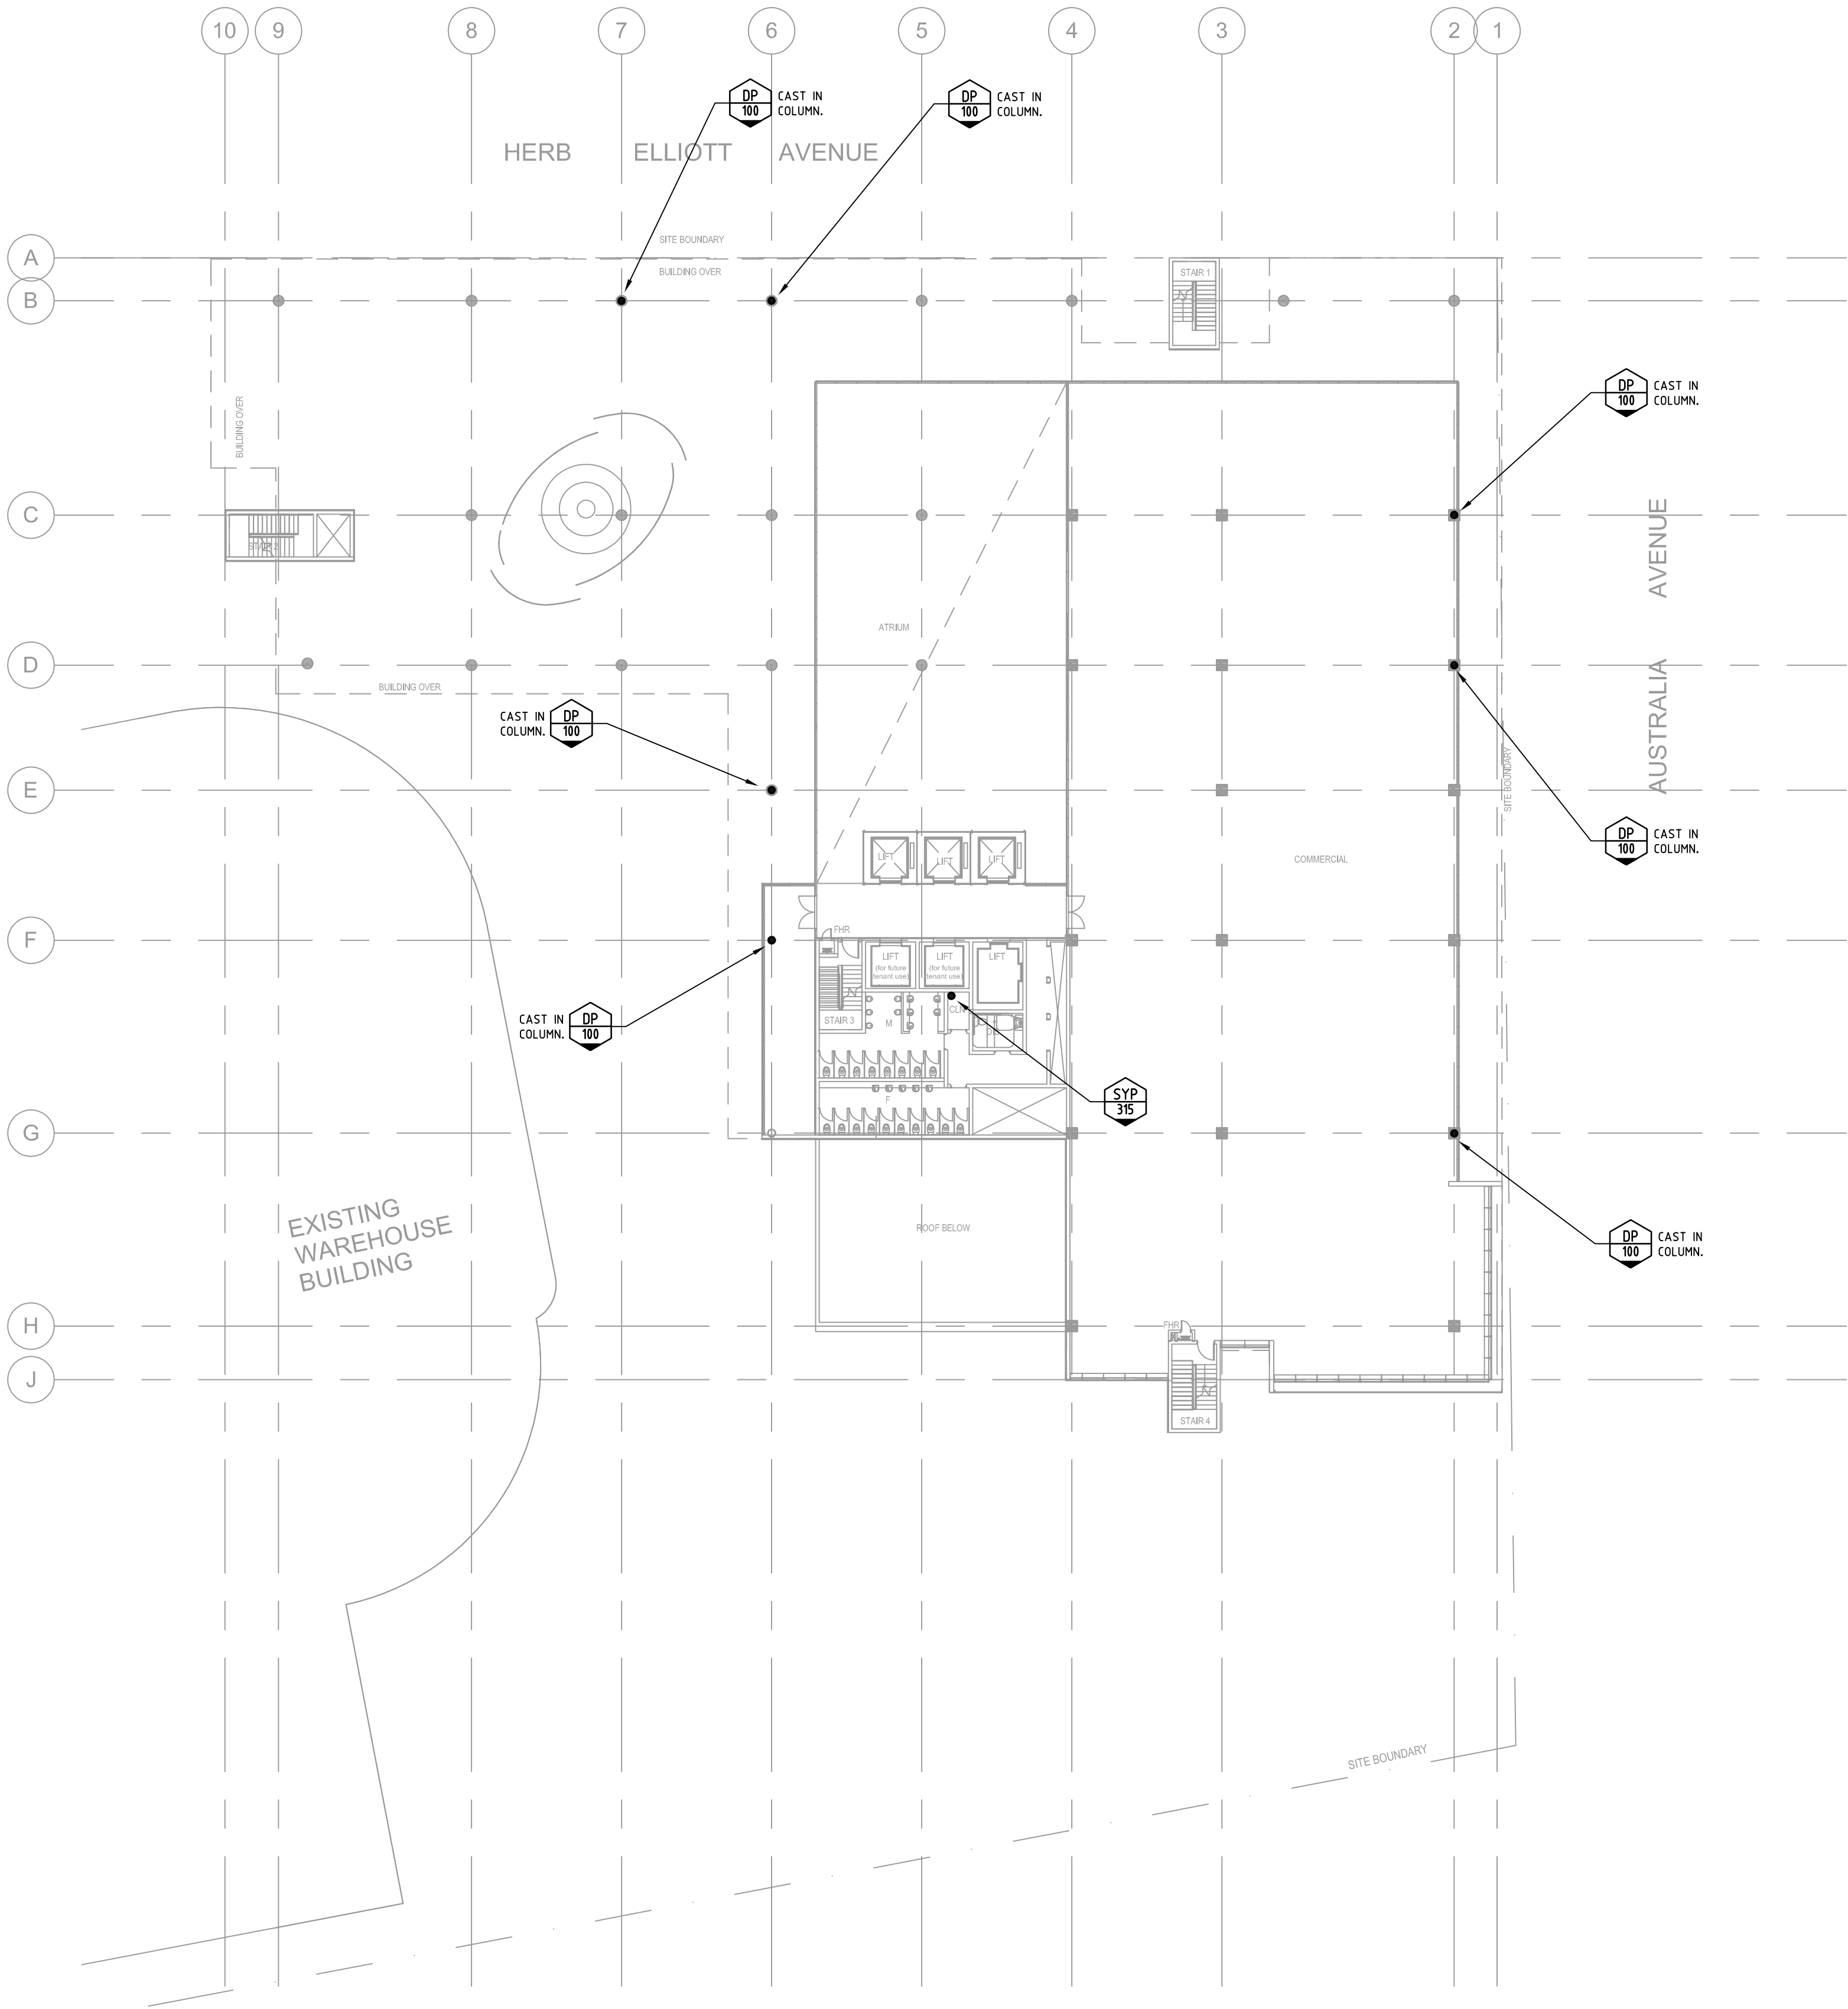

CONSTRUCTION

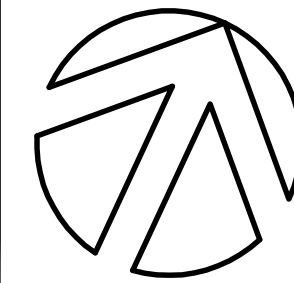

CLIENT
Capital Corporation Pty Ltd

Suite 705/12 Century Circuit, Baulkham Hills NSW 2153
Tel: 02 8853 5000 Fax: 02 8853 5099

HYDRAULIC CONSULTANT
Neil Lowry & Associates Pty Ltd
hydraulic & fire services consultants

Level 3, Suite 1, 29 Kiara Road, Miranda NSW 2228
Tel: 61 2 9526 7922 Fax: 61 2 9526 7944
Email: admin@nlaapl.com.au
Neil Lowry & Associates Pty Ltd ABN 72 101 872 984

ARCHITECT
architectus™
Architectus Sydney
Level 3 341 George Street
Sydney NSW 2000
Sydney Melbourne Auckland Brisbane Shanghai
T (61 2) 8252 8400
F (61 2) 8252 8600
sydney@architectus.com.au
ABN 11 098 489 448

PROJECT
**SITE 43/44
SYDNEY OLYMPIC
PARK**

DRAWING
**STORMWATER CONCEPT
FIRST FLOOR PLAN**

DRAWN KJ	DESIGNED NL	CHECKED NL	DATE JUNE 12	SCALE 1:250@A1
PROJECT 0583	DWG No. SC06	REV A	STATUS DA ISSUE	