



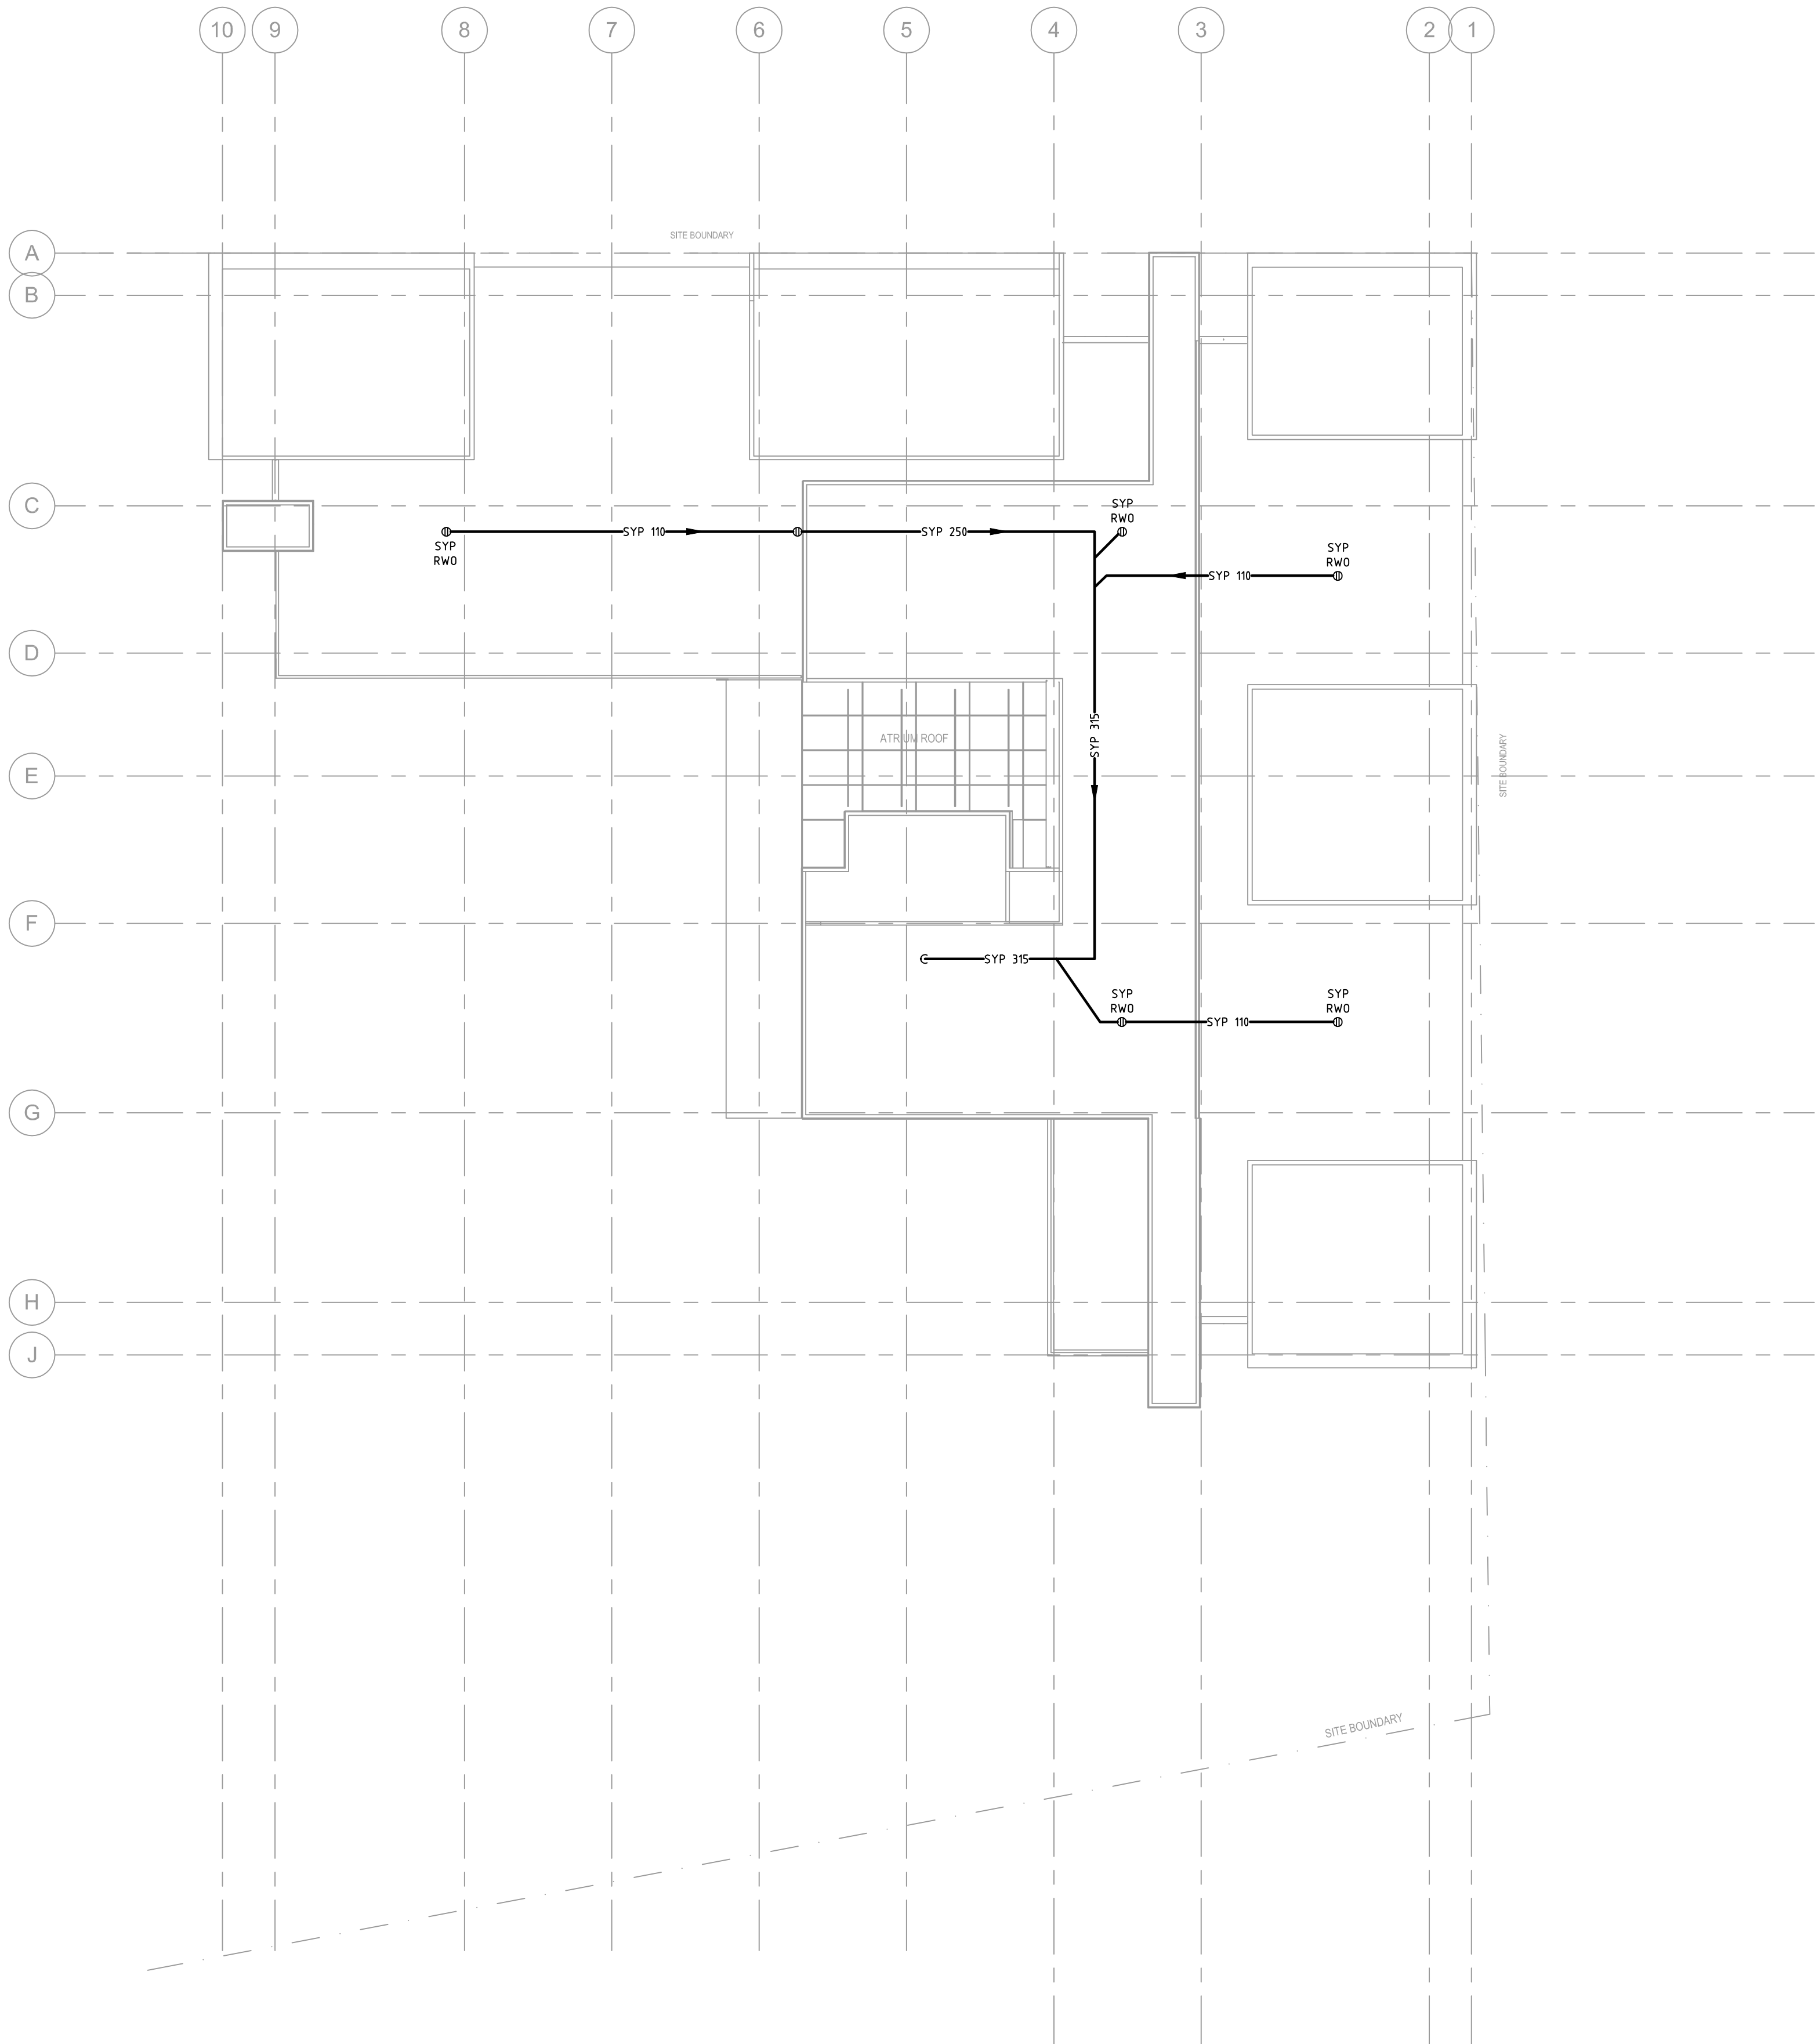

CON ISSUE

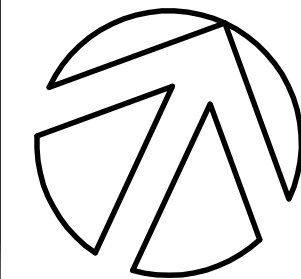

APPLICANT

CLIENT  
**Capital Corporation Pty Ltd**  
  
Suite 705/12 Century Circuit, Baulkham Hills NSW 2153  
Tel: 02 8853 5000 Fax: 02 8853 5099

HYDRAULIC CONSULTANT  
**Neil Lowry & Associates Pty Ltd**  
hydraulic & fire services consultants  
  
Level 3, Suite 1, 29 Kiara Road, Miranda NSW 2228  
Tel: 61 2 9526 7922 Fax: 61 2 9526 7944  
Email: admin@nlaapl.com.au  
Neil Lowry & Associates Pty Ltd ABN 72 101 872 984

ARCHITECT  
**architectus™**  
  
Architectus Sydney  
Level 3 341 George Street  
Sydney NSW 2000  
T (61 2) 8252 8400  
F (61 2) 8252 8600  
sydney@architectus.com.au  
ABN 11 098 489 448

PROJECT

SITE 43/44  
SYDNEY OLYMPIC  
PARK

DRAWING

STORMWATER CONCEPT  
ROOF PLAN

DRAWN

KJ

DESIGNED

NL

CHECKED

NL

DATE

JUNE 12

SCALE

1:250@A1

PROJECT

DWG No.

REV

STATUS

DA ISSUE

0583

SC09

A