
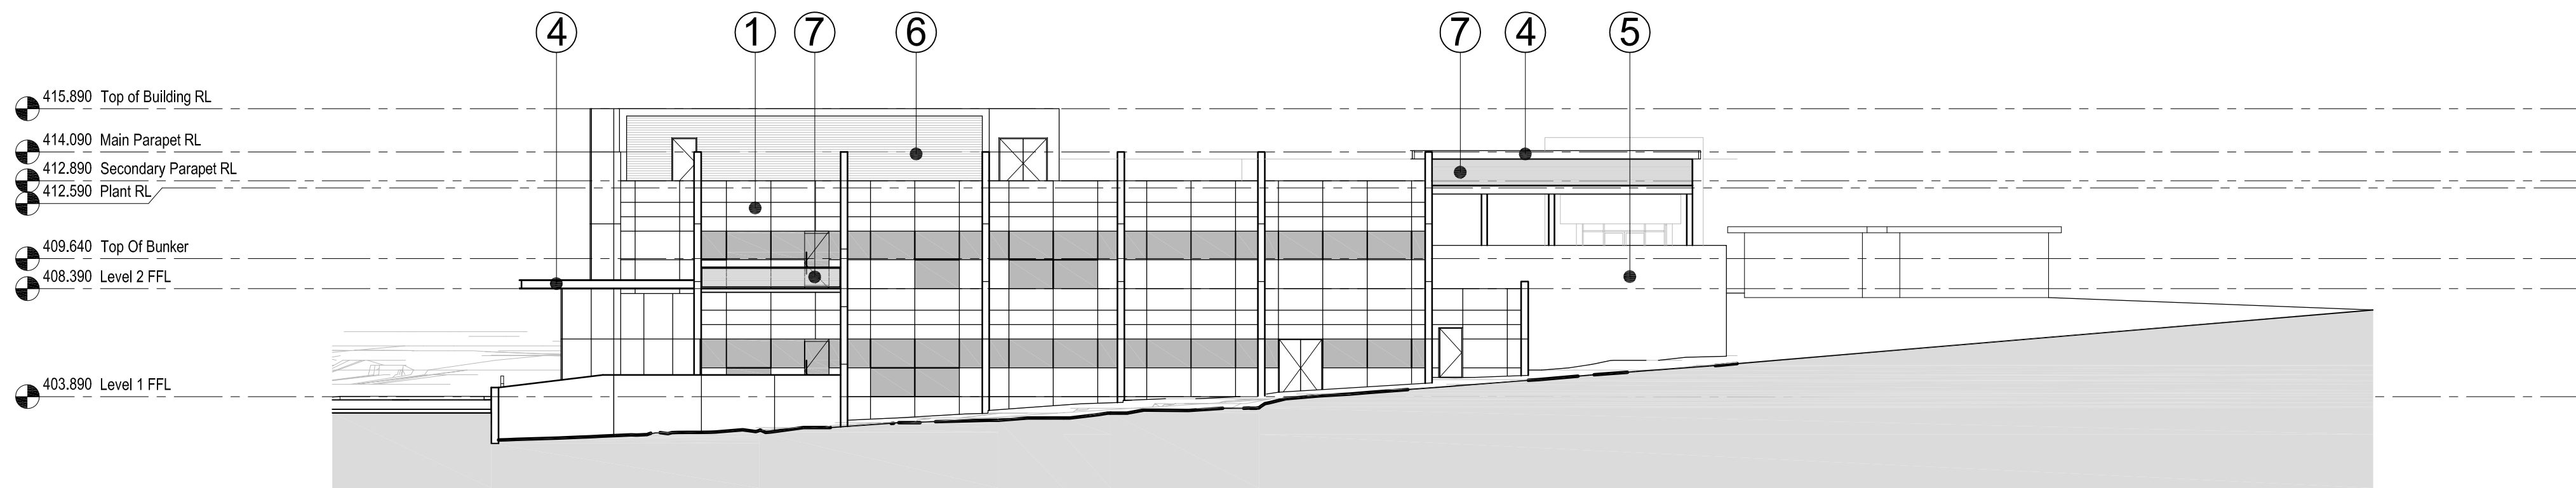


NORTH ELEVATION
1:200

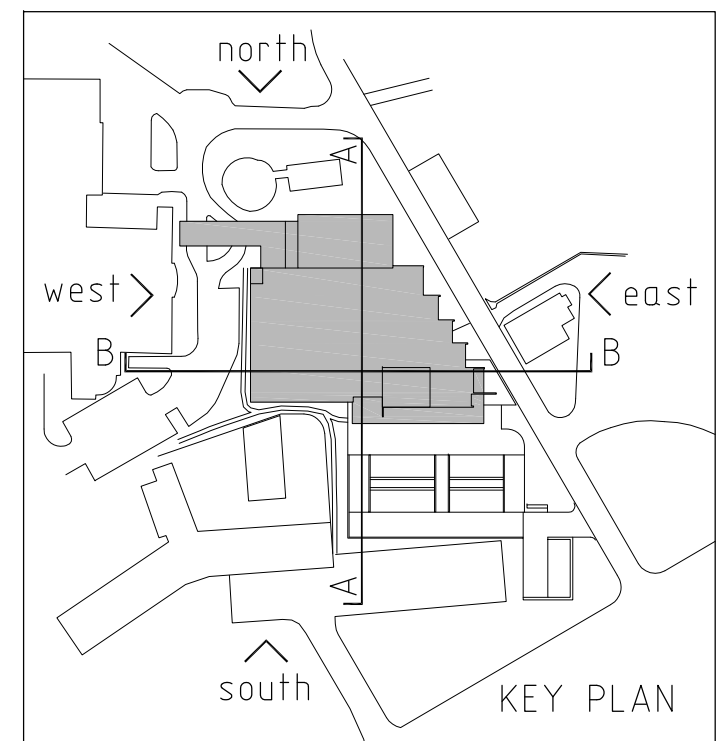

EAST ELEVATION
1:200

- ① TYPE A panel and aluminium framed window infill
- ② TYPE B panel and aluminium framed strip windows
- ③ TYPE C panel and aluminum framed window infill
- ④ steel structure awning
- ⑤ off-form concrete (applied texture finish)
- ⑥ mechanical plant room louvre wall
- ⑦ Translucent fibreglass cladding to exterior handrails and awning bulkheads

rev	date	by	description
01	12.11.10	DJM	PART 3A TEST FOR ADEQUACY
02	19.11.10	DJM	PART 3A TEST FOR ADEQUACY
03	-	-	-
04	02.02.11	DJM	PART 3A PROJECT APPLICATION



Health
Hunter New England
Local Health Network

HUNTER NEW ENGLAND LOCAL HEALTH
NETWORK REGIONAL CANCER CENTRE
(HNELHN RCC) AT TAMWORTH



HEALTH INFRASTRUCTURE
NSW HEALTH



TITLE:
ELEVATIONS & SECTIONS
SCALE:
1 : 200 @ A1
DATE:
12. Nov. 2010



LEVEL 3, 73 YORK STREET
SYDNEY NSW 2000
AUSTRALIA
T. +61 2 8299 4600
F. +61 2 8299 4646
E: sth@sth悉尼.com.au
W: www.sth.com.au

DRG No:
DoP 10
REVISION:
04