



# BREAKFAST POINT

---

## APPENDIX F: STORMWATER CONCEPT PLAN



[illegible]

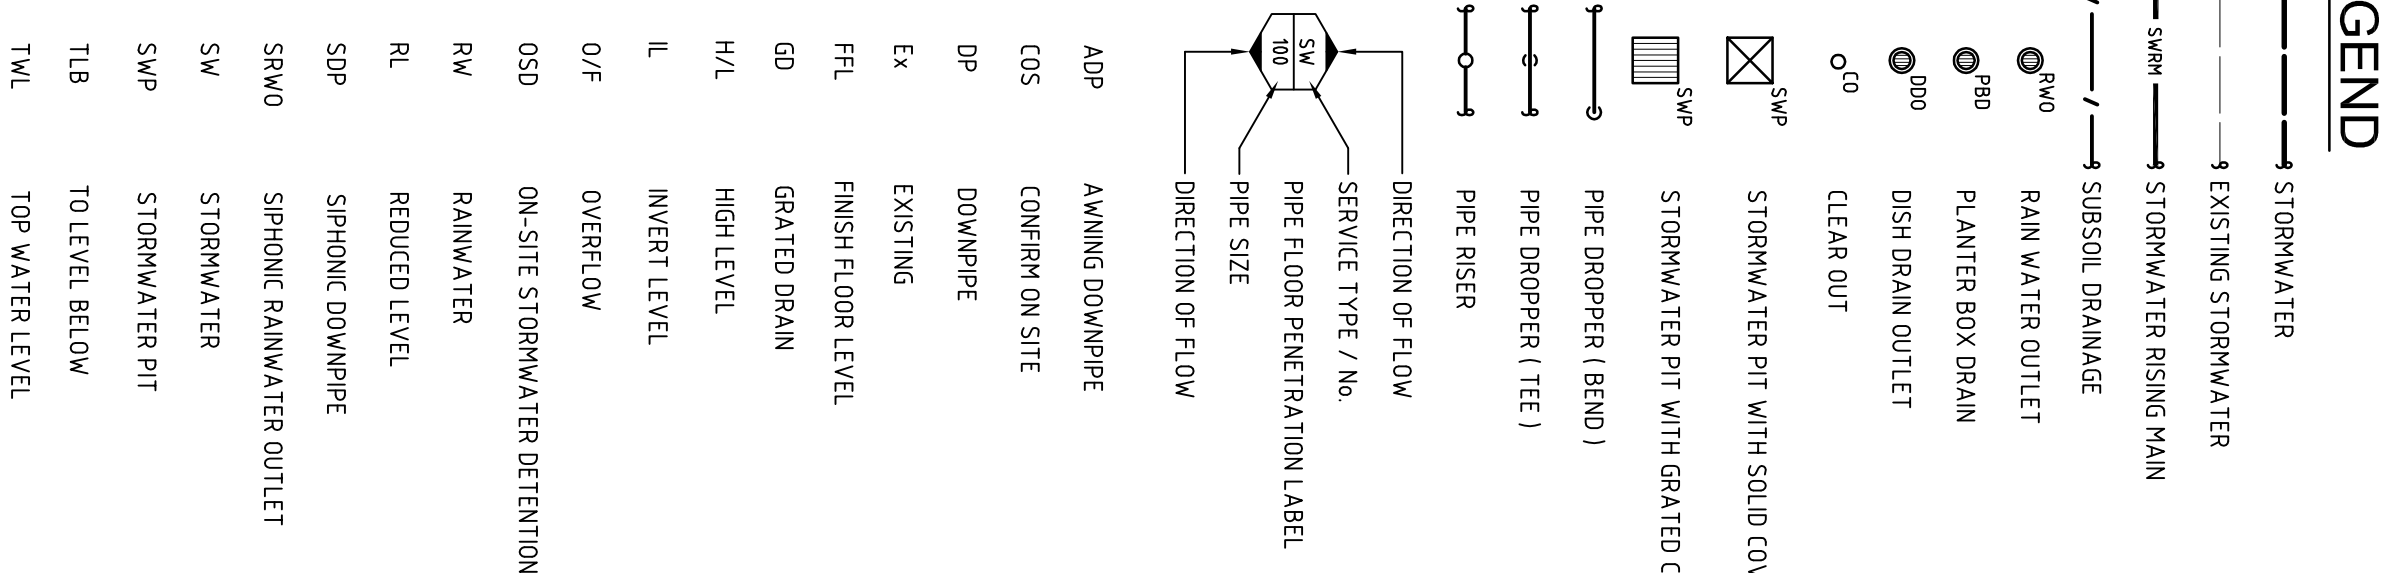



REV / DESCRIPTION	DATE	DRAWING CHECK		CO-ORDINATION CHECK		CLIENT	 <b>SEYF</b> S C I E N T I S T S E N G I N E E R S A R C H I T E C T S M A N A G E R S & F A C I L I T A T O R S OFFICES LOCATED: Brisbane, Canberra, Melbourne, Perth, London, Melbourne and Sydney	SEYF Pty Ltd Level 3, 50 Berry Street Melbourne, VIC 3006 Tel: (03) 9211 2000 Fax: (03) 9211 2000 Email: info@seyf.com.au Web: www.seyf.com.au	PROJECT <b>PROPOSED RESIDENTIAL          LOT 705          7.9 &amp; 11 MAGNOLIA DRIVE          BREAKFAST POINT</b>	TITLE <b>HYDRAULIC SERVICES          BASEMENT LEVEL 1          STORMWATER CONCEPT PLAN</b>
		DRAWN BY CHECKED BY DESIGNED BY DATE	DATE STRUCT. MECH. ELEC. HYDRAUL. PRELIM.	DRAWN BY CHECKED BY DESIGNED BY DATE	DATE STRUCT. MECH. ELEC. HYDRAUL. PRELIM.					
A	ISSUE FOR DA	AP	TS							
		DRN	CHK	APP	DATE					
DRAWING NO. <b>1357.031-H02</b>						SCALE: 1:100 PRELIMINARY ONLY (NOT TO BE USED FOR CONSTRUCTION) MILLMERRIES				
REV. <b>A</b>						2000 0 2000 4000 6000 1:100 1357.031-H02 A				

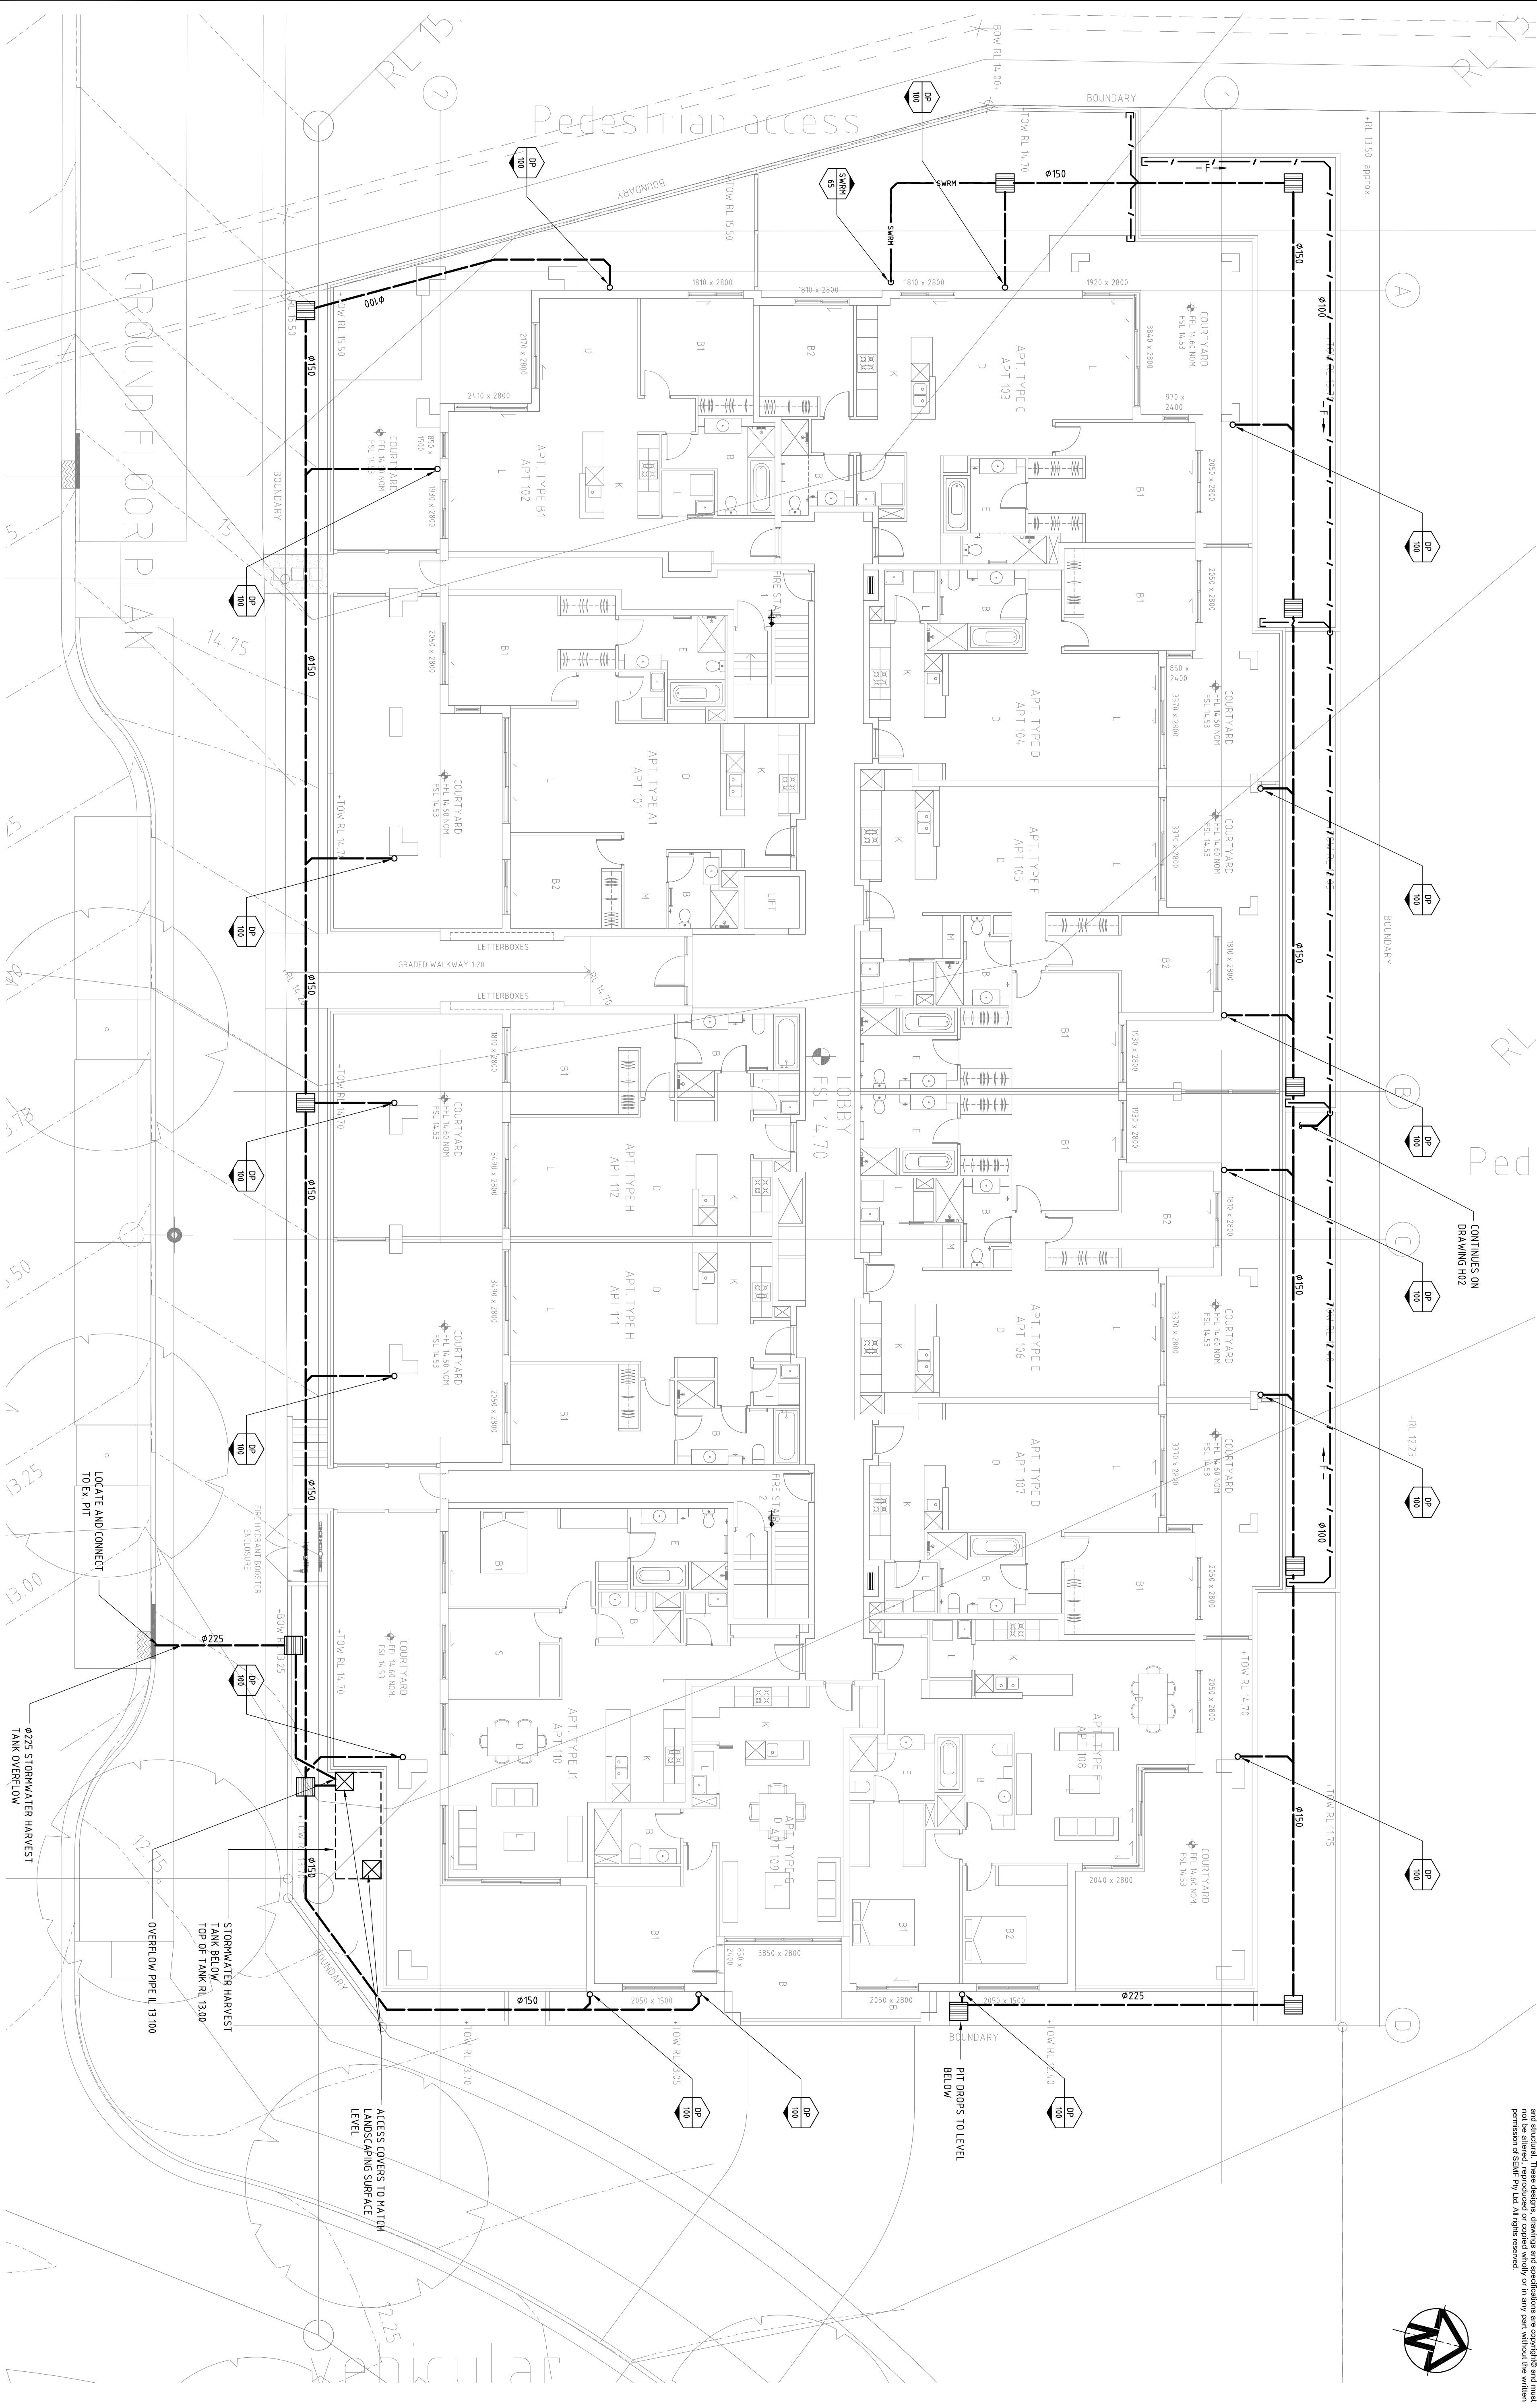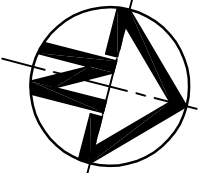

DO NOT SCALE THIS DRAWING. Use only dimensions shown. All dimensions should be taken from the drawing. Dimensions are given in millimetres unless otherwise stated. These drawings, drawings and specifications are copyright and must not be reproduced, stored in a retrieval system or in any form without the written permission of SEWPF Pty Ltd. All rights reserved.



DRAWING CHECK		CO-ORDINATION CHECK		CLIENT	<div><div>SCIENTISTS ENGINEERS MANAGERS &amp; FACILITATORS</div><div>Level 3, 50 Berry Street Sydney NSW 2000 Tel: (61) 2 9597 1112 Fax: (61) 2 9597 4815</div><div>Offices located: Brisbane, Canberra, Melbourne, Hobart, Lismore, Perth, and Sydney</div><div>Website: <a href="http://www.sewfp.com.au">www.sewfp.com.au</a> ACN 117 492 814 ABN 24 117 492 814</div></div>	PROJECT	TITLE
SIGNATURE		SIGNATURE					
DATE	DATE	DATE					
DATE	DATE	DATE					
AP	TS	08.12.10		ROSE GROUP Pty Ltd	<div><div>SCIENTISTS ENGINEERS MANAGERS &amp; FACILITATORS</div><div>Level 3, 50 Berry Street Sydney NSW 2000 Tel: (61) 2 9597 1112 Fax: (61) 2 9597 4815</div><div>Offices located: Brisbane, Canberra, Melbourne, Hobart, Lismore, Perth, and Sydney</div><div>Website: <a href="http://www.sewfp.com.au">www.sewfp.com.au</a> ACN 117 492 814 ABN 24 117 492 814</div></div>	PROPOSED RESIDENTIAL LOT 705	HYDRAULIC SERVICES GROUND FLOOR PLAN
DN	DN	DN	DN	51 RILEY STREET		7,9 & 11 MAGNOLIA DRIVE	STORMWATER CONCEPT PLAN
DN	DN	DN	DN	WOOLLOOMOOLOO NSW 2011		BREAKFAST POINT	
DN	DN	DN	DN				
AP	TS	08.12.10					
DN	DN	DN	DN				
DN	DN	DN	DN				
