


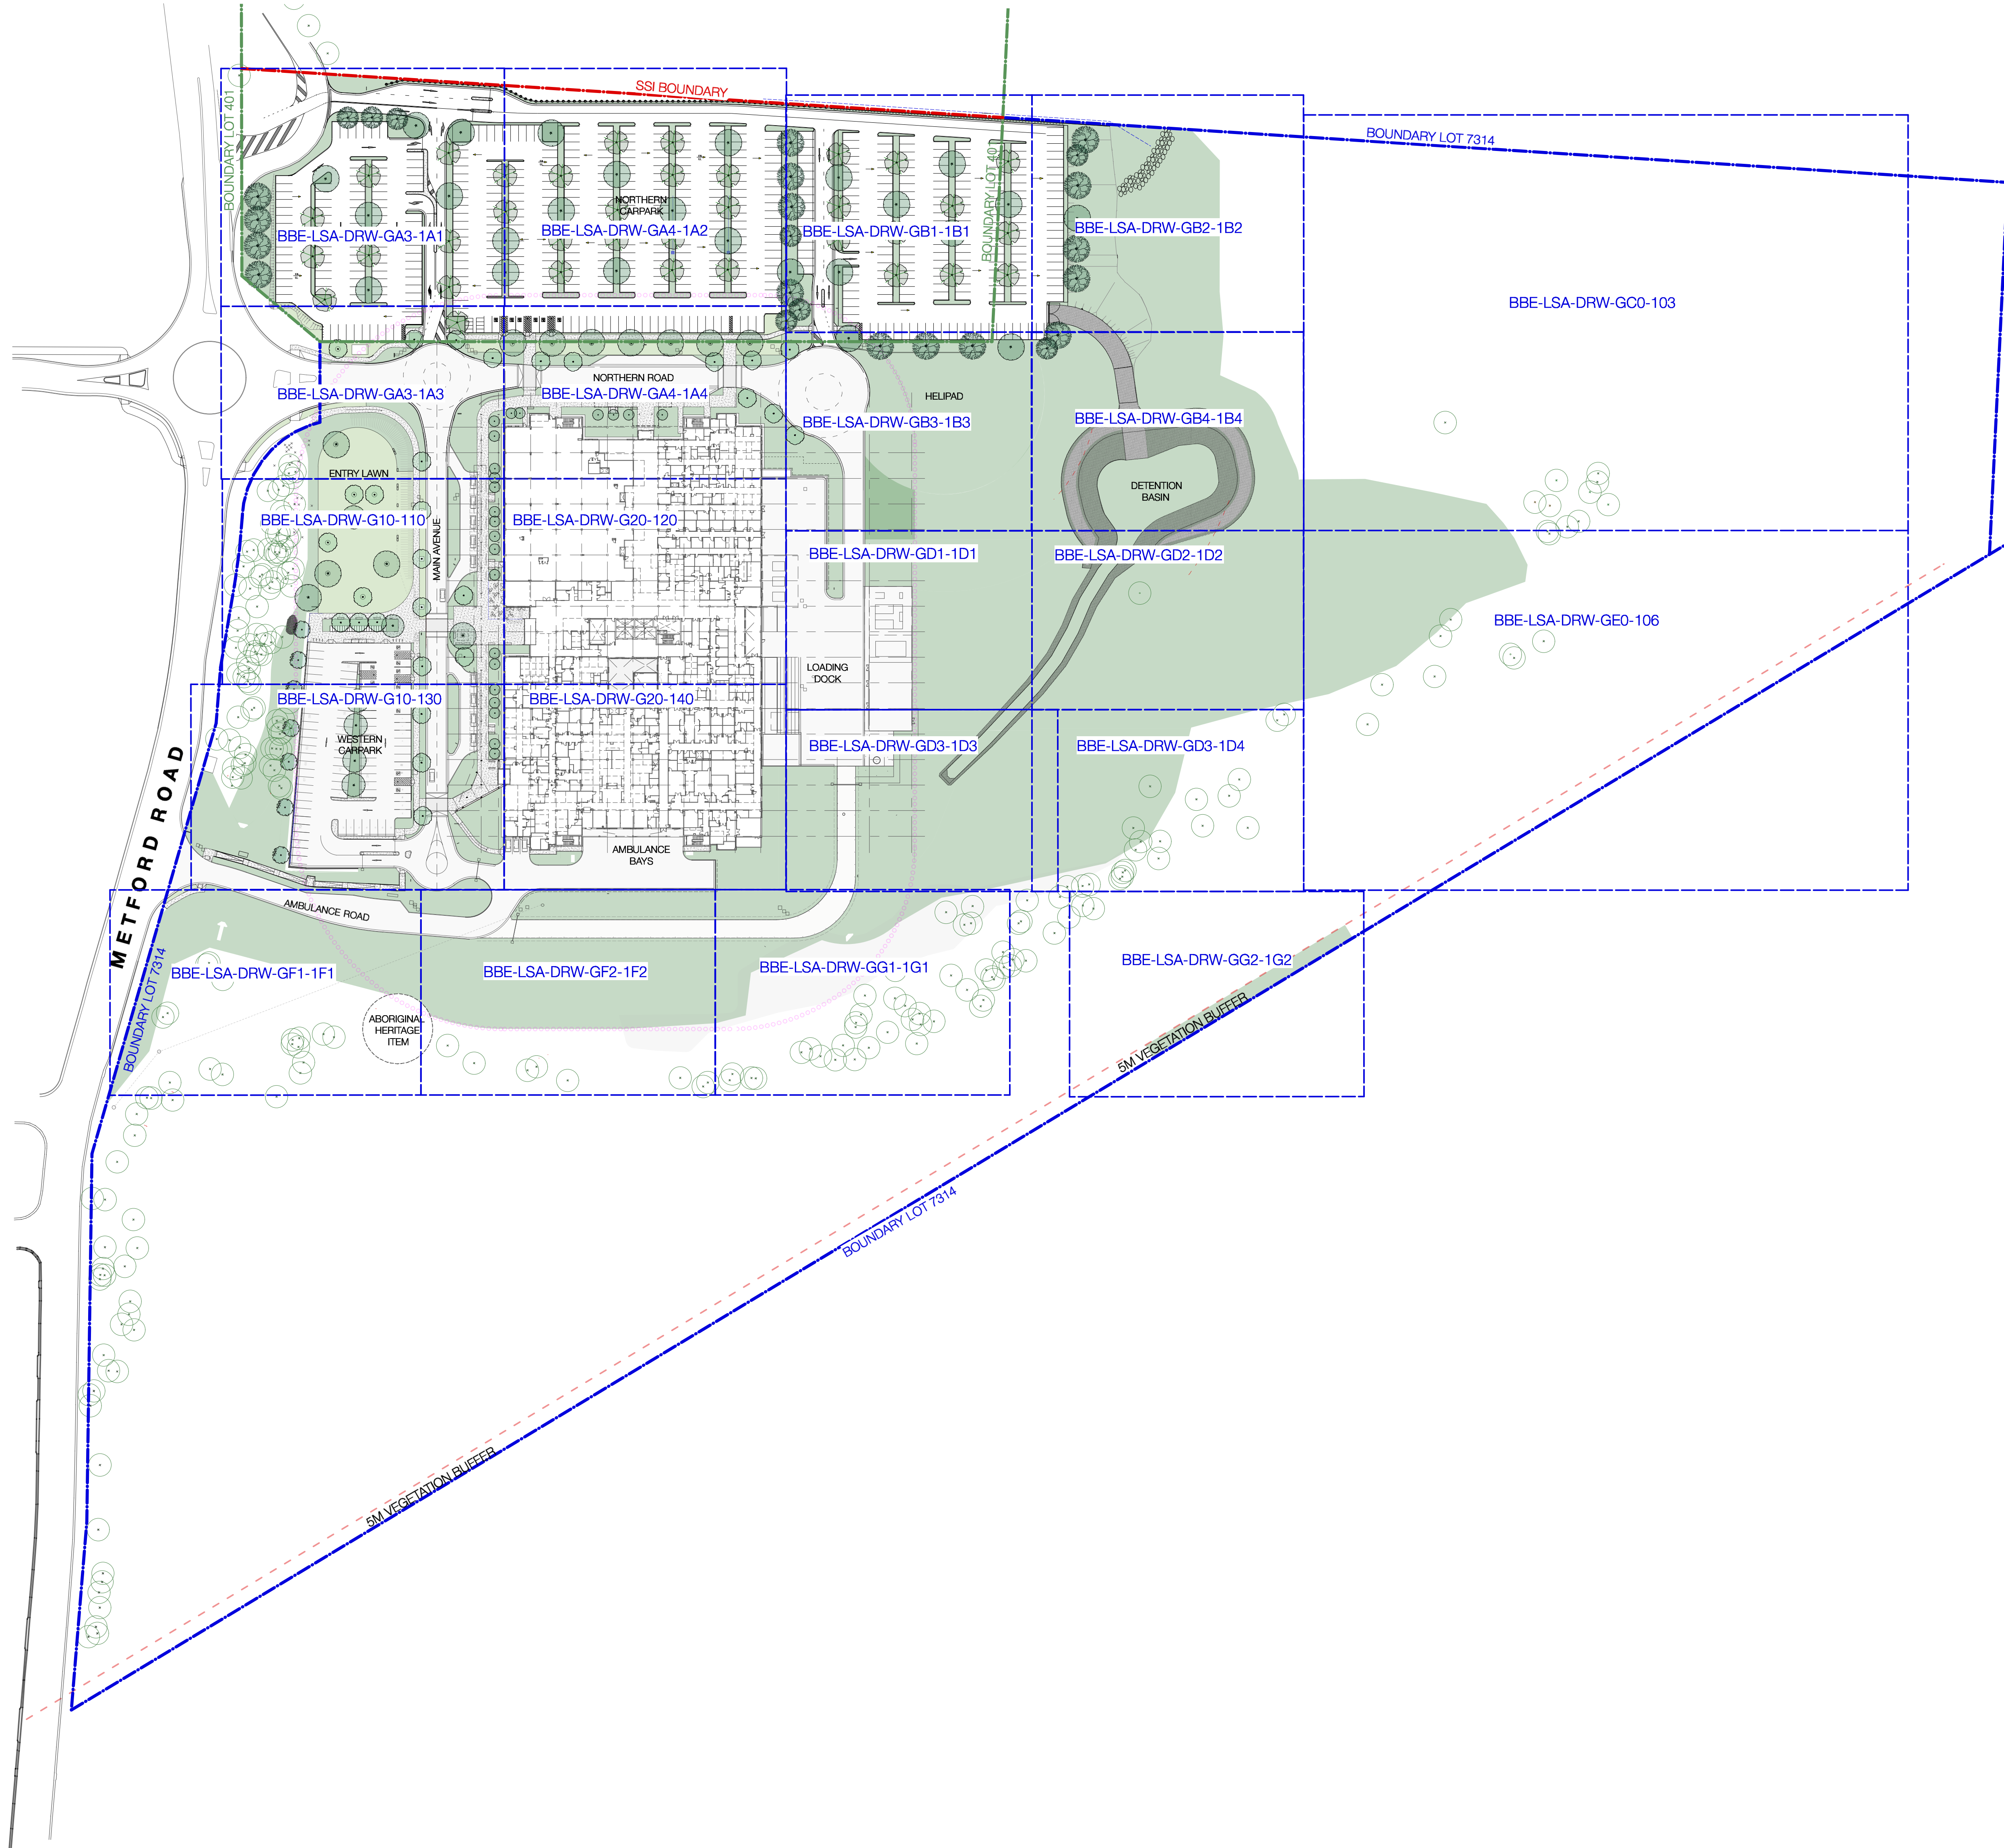

LEGEND

BOUNDARY LINE

PM1 PLANT MIX 01 - NATIVE GRASSES AND GROUND COVERS. REFER TO PLANT SCHEDULE BBE-LSA-DRW-GX0-300

PM2 PLANT MIX 02 - MIXED SHRUBS AND GROUND COVERS. (IRRIGATION EXTENT) REFER TO PLANT SCHEDULE BBE-LSA-DRW-GX0-300

PM3 PLANT MIX 03 - WILD NATIVE GRASSES AND GROUND COVERS. REFER TO PLANT SCHEDULE BBE-LSA-DRW-GX0-300

PM4 PLANT MIX 04 - BUSH REGENERATION TO BE UNDERTAKEN BY HI

PM5 PLANT MIX 05 - HYDROMULCH NATIVE GRASSES. REFER TO PLANT SCHEDULE BBE-LSA-DRW-GX0-300

PM6 PLANT MIX 06 - HYDROMULCH NATIVE GRASSES AND TUBESTOCK TREES. REFER TO PLANT SCHEDULE BBE-LSA-DRW-GX0-300

PM7 PLANT MIX 07 - SCREENING SHRUBS. REFER TO PLANT SCHEDULE BBE-LSA-DRW-GX0-300

T1 TURF PROFILE 01 - TURF ON GRADE (60-100MM IMPORTED TURF UNDERLAY).

P1 PAVEMENT TYPE 01 - CONCRETE FOOTPATH SOFT COVE FINISH (NO TOOLED MARGINS).

P2 PAVEMENT TYPE 02 - CONCRETE FOOTPATH EXPOSED AGGREGATE FINISH (NO TOOLED MARGINS). REFER

P3 PAVEMENT TYPE 03 - ROAD SURFACE

P4 PAVEMENT TYPE 04 - GRAVEL

TP-1 TREE PIT

E1 EDGE TYPE 01 - METAL EDGE. REFER TO

B-1 BENCH TYPE 01 - 1800MM PROPRIETARY BENCH.

B-2 BENCH TYPE 02 - 1800MM PROPRIETARY BENCH.

B-3 BENCH TYPE 03 - SANDSTONE BENCH.

BOL-1 BOLLARD TYPE 01, 90 X 90 X 1000 SQUARE BOLLARD. CS9086 AVAILABLE FROM BARRIER GROUP OR SIMILAR APPROVED. POWDER COAT COLOUR TO MATCH AWNING COLUMNS (MONUMENT TBC)

TGS-1 TGS'S.

K&G CONCRETE KERB AND GUTTER.

K/O CONCRETE KERB ONLY.

T/K TRANSITION KERB.

F/K FLUSH KERB.

S STORMWATER LINE.

INLET PIT / STORMWATER PIT.

O T 985 EXISTING TREE TO BE REMOVED. REFER TO ARBORISTS REPORT

T 985 EXISTING TREE TO BE RETAINED AND PROTECTED. REFER TO ARBORISTS REPORT

P5 PAVEMENT TYPE 05 - TILE

P6a PAVEMENT TYPE 06 - SYNTHETIC TURF 6A - VELOUR

P6b PAVEMENT TYPE 06 - SYNTHETIC TURF 6B - SHORT PILE

P7 PAVEMENT TYPE 07 - DECK

P8 PAVEMENT TYPE 08 - SOFTFALL.

LX-PLX LX-PLX PLANTER / POT AS SELECTED

W-1 W-1 - RETAINING WALL - REFER TO ENGINEERS DOCUMENTATION.

W-2 W-2 - RETAINING WALL RENDURED AND PAINTED WALL

BAL-1 BAL-1 BALUSTRADE (WESTERN CARPARK) - BARRIER / BALUSTRADE.

BAL-2 BAL-2 BALUSTRADE (LOADING DOCK) 1050MM HIGH BLACK PAULISADE BALUSTRADE.

BAL-3 BAL-3 BALUSTRADE (AMBULANCE ROAD RAMP) - 1050MM HIGH BLACK HANDRAIL.

PIT PIT - REFER TO SERVICES DOCUMENTATION FOR DETAILS

PH PH - FIRE HYDRANT

P1 P1 - POLE LIGHT

P2 P2 - STREET LIGHT

PROPOSED TREE PLANTING. REFER TO PLANT SCHEDULE BBE-LSA-DRW-GX0-300

15 SSI 2 31.10.19

14 SSI 2 16.08.19

13 SSI 2 05.08.19

12 Design Development 19.08.19

11 Design Development 30.07.19

10 Design Development 21.07.19

09 Design Development 03.07.19

08 Design Development 50% 03.06.19

07 SSI Submission 18.02.19

06 SSI Submission 17.02.19

05 SSI Submission 14.02.19

04 Schematic Design 11.02.19


03 Schematic Design 17.01.19

02 Preliminary Schematic Design 10.12.18

01 Draft for Review 30.11.18

Rev	Description	Date
MANAGING CONTRACTOR		
MULTIPLEX		
CONSULTANTS		
PROJECT MANAGEMENT		
CBRE		
ARCHITECTURE		
BVN		
STRUCTURES & CIVIL		
TTW Taylor Thomson Whitting		
HYDRAULIC & FIRE		
MECHANICAL		
ELECTRICAL		
CLIENT		
NSW Health Infrastructure		
PROJECT		
NEW MAITLAND HOSPITAL		
Metford Road, Metford		
DRAWING TITLE		
COVER SHEET & KEY PLAN		
STATUS		JOB NO.
Design Development		1229
SCALE AT A0	DRAWN	CO-ORDINATED
1:1000	GB	GB/IK
DWG NO.	ISSUE	APPROVED
BBE-LSA-DRW-GX0-100	14	GB/IK

FOR INFORMATION

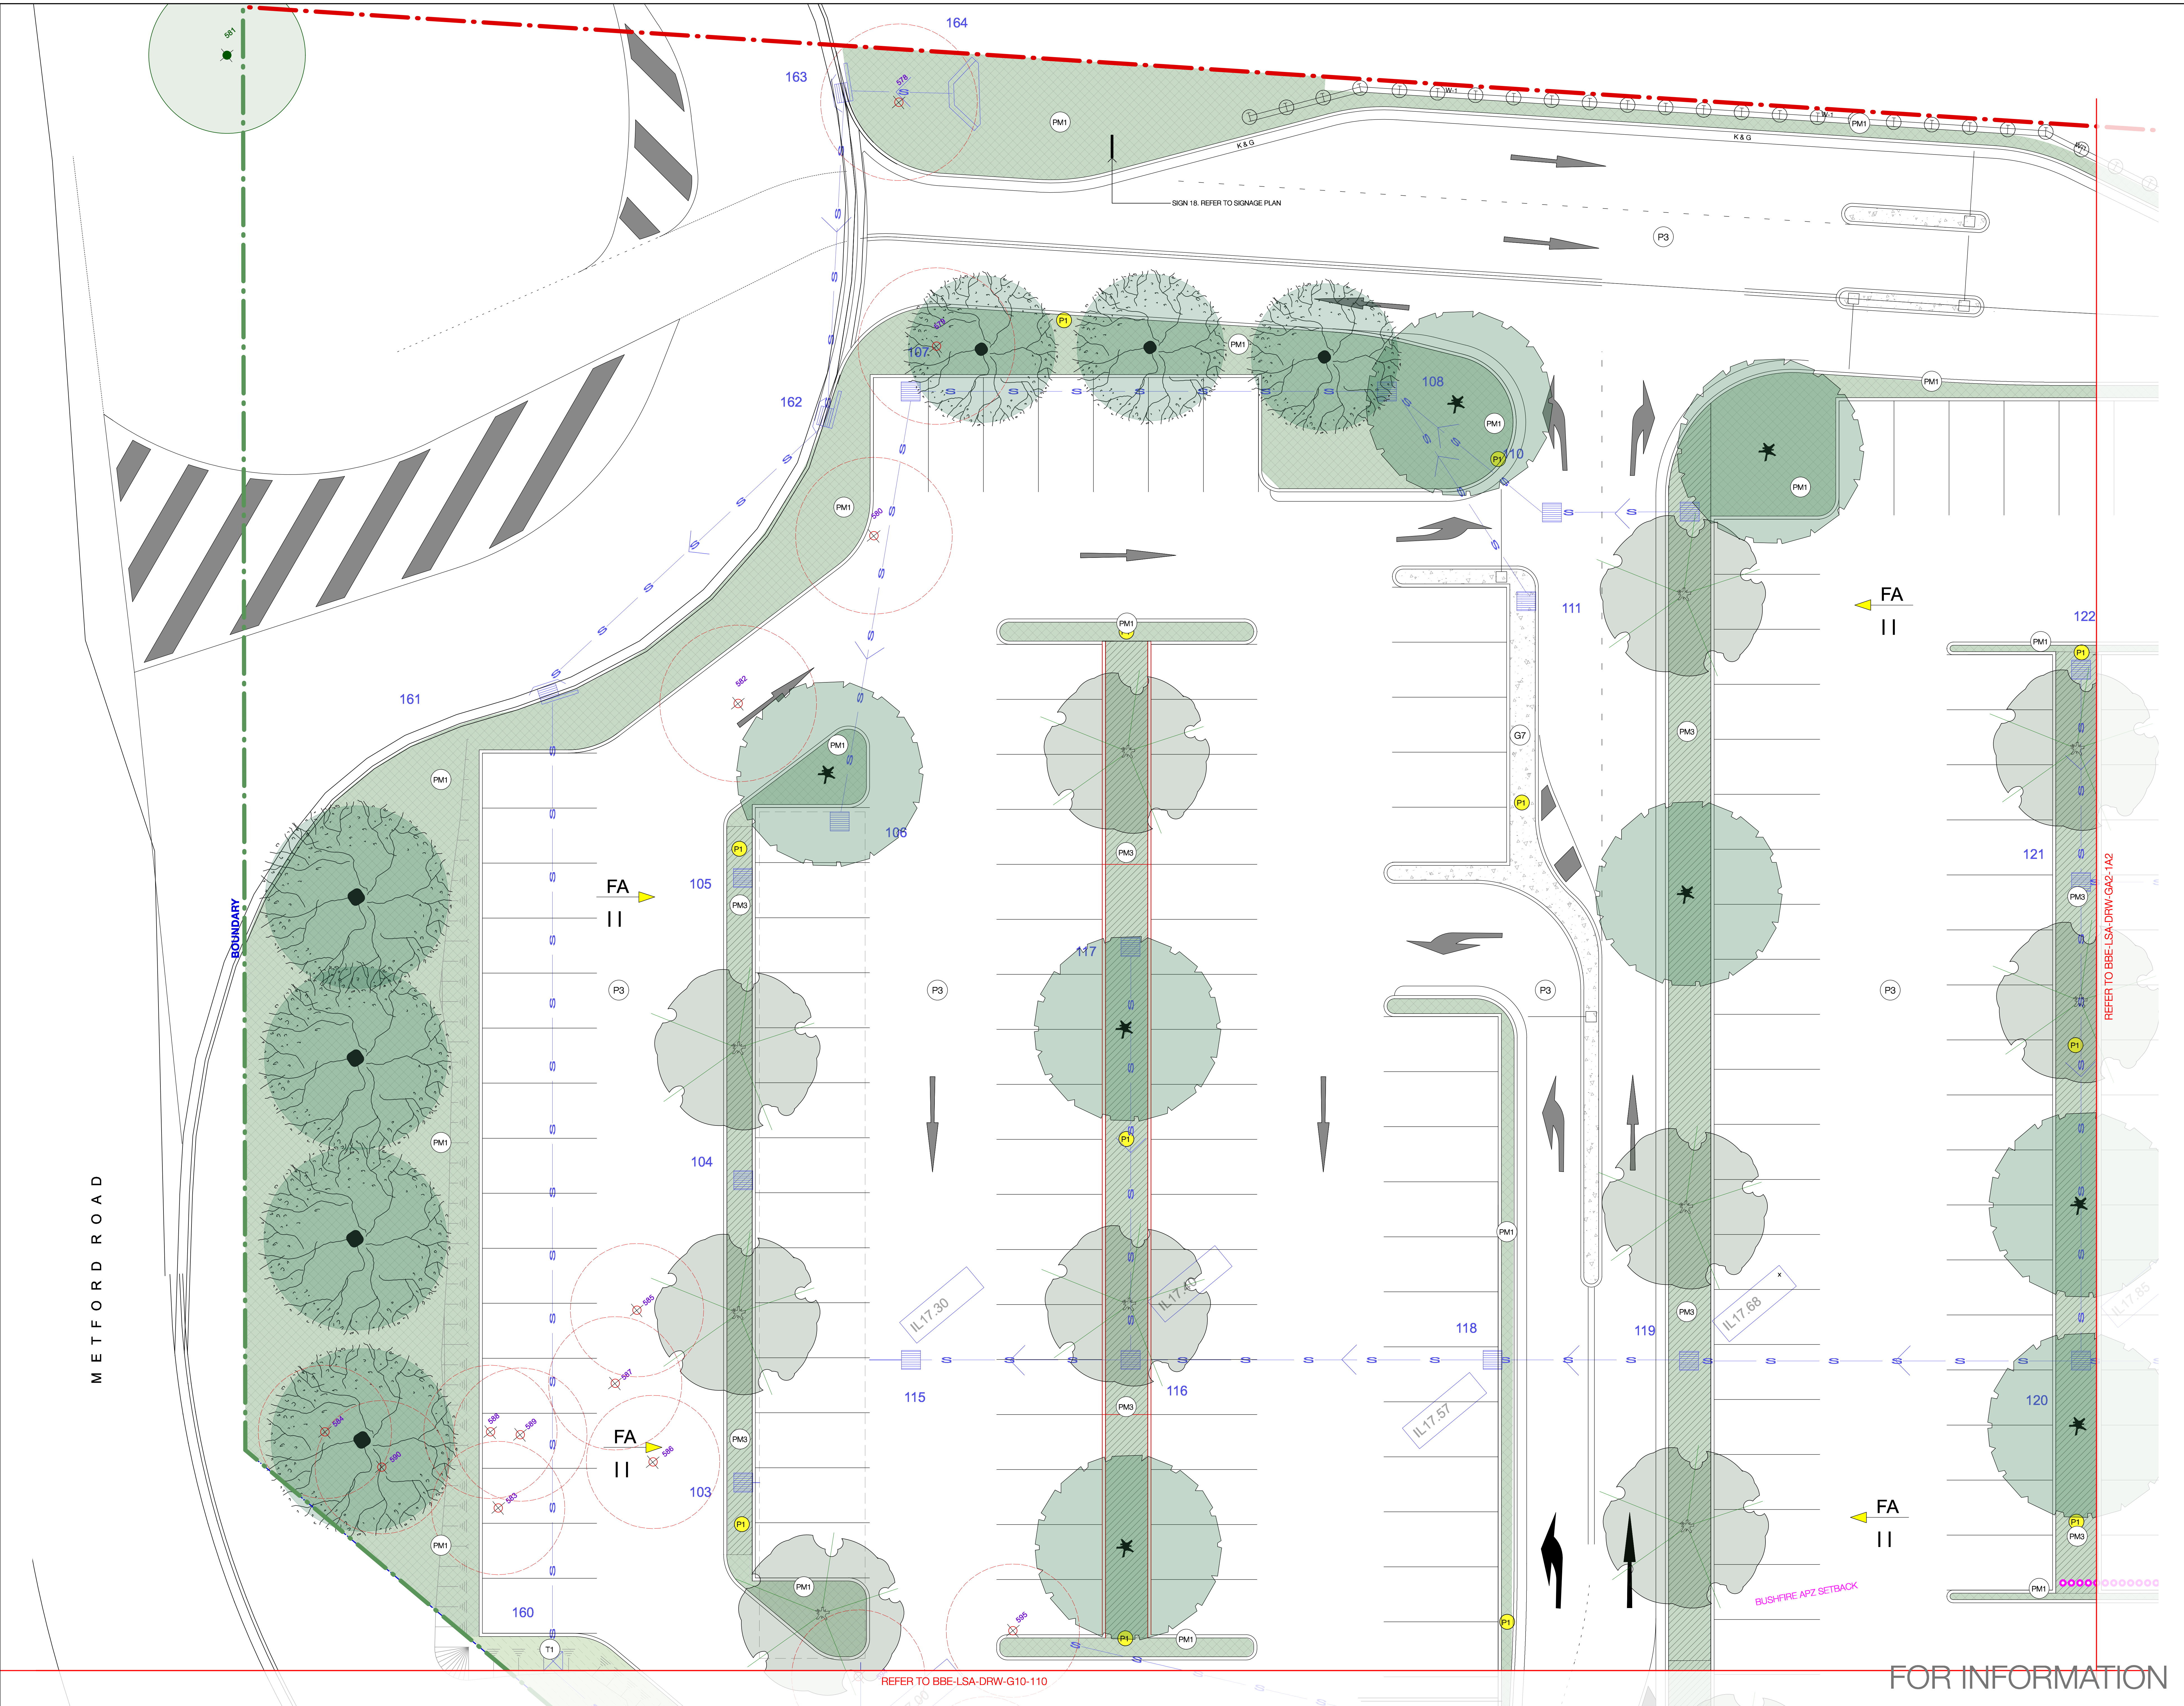

black beetle

Landscape Architecture and Design

Black Beetle Pty Ltd
Level 01 | 1073 Pittwater Road, Collaroy NSW 2007
Tel: 0422 104 416
email: blackbeetle@blackbeetle.com.au

KEY PLAN

1:100 @ A0

0 1 2.5 5 7.5 10m

NOTES

Contractor must verify all dimensions on site before commencing work or preparing shop drawings. Do not scale drawings. Resolve discrepancies with Black Beetle before proceeding. Copyright of this drawing and the design executed remain vested in Black Beetle.

REFER TO BBE-LSA-DRW-GX0-100 FOR LEGEND AND GENERAL NOTES

REFER TO BBE-LSA-DRW-GX0-300 FOR PLANT SCHEDULE

02 SSI 2 05.09.19

01 Design Development 19.08.19

Rev Description Date

MANAGING CONTRACTOR

MULTIPLEX

CONSULTANTS

PROJECT MANAGEMENT

CBRE

ARCHITECTURE

BUN

TTW Taylor Thomson Whitting

STRUCTURES & CIVIL

HYDRAULIC & FIRE

MECHANICAL

ELECTRICAL

CLIENT

Health Infrastructure

PROJECT

NEW MAITLAND HOSPITAL

Metford Road, Metford

DRAWING TITLE

Landscape General Arrangement Plan

Quadrant A1

STATUS

Design Development

JOB NO.

1229

SCALE AT A0

1:100

DRAWN

GB/LT

CO-ORDINATED

GB/IK

CHECKED

IK

APPROVED

GB/IK

DWG NO.

BBE-LSA-DRW-GA1-1A1

ISSUE


02

FOR INFORMATION

Original Sheet Size A0 - 1188 x 841mm



KEY PLAN

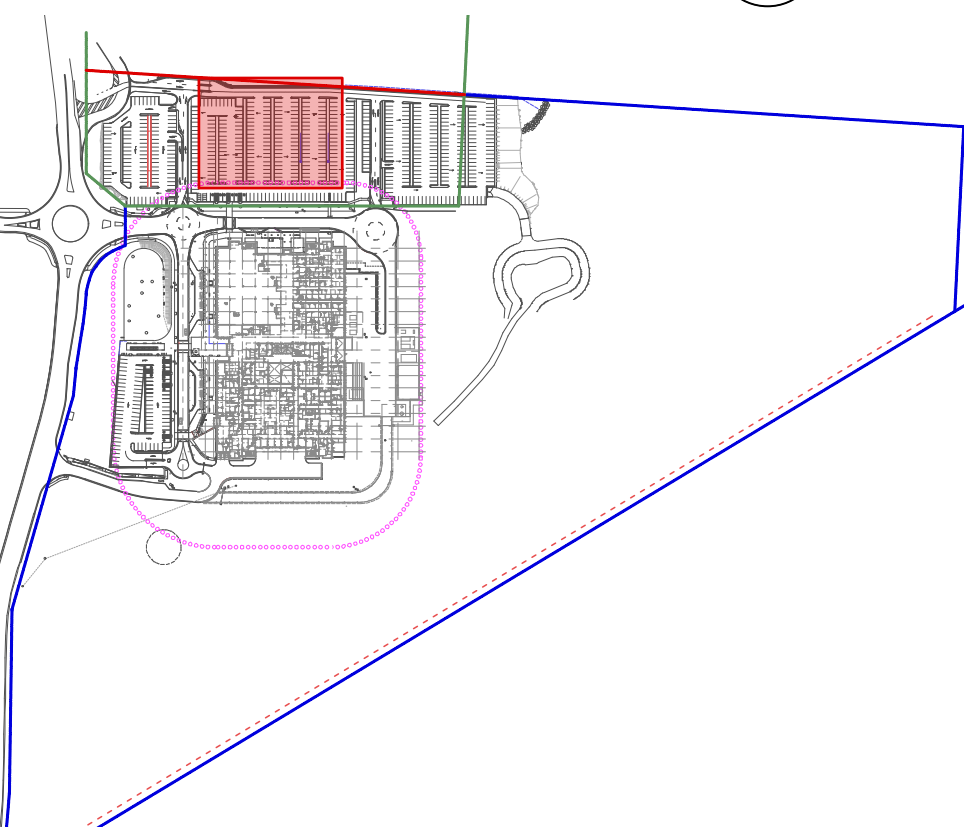

NOTES
Contractor must verify all dimensions on site before commencing work or
reporting shop drawings. Do not scale drawings. Resolve discrepancies with
Black Beetle before proceeding. Copyright of this drawing and the design
executed remain vested in Black Beetle.
REFER TO BBE-LSA-DRW-GX0-100 FOR
LEGEND AND GENERAL NOTES
REFER TO BBE-LSA-DRW-GX0-300 FOR
PLANT SCHEDULE

02 SSI 2 05.09.19
01 Design Development 19.08.19

Rev	Description	Date
-----	-------------	------

MANAGING CONTRACTOR
MULTIPLEX

CONSULTANTS
PROJECT MANAGEMENT
CBRE

ARCHITECTURE
BUN
BUN

STRUCTURES & CIVIL
TTW Taylor
Thomson
Whitting
612 8409 1000 | 401 Chardon Street St. Leonards NSW 2060

HYDRAULIC & FIRE

MECHANICAL

ELECTRICAL

CLIENT


NSW Health
GOVERNMENT Infrastructure

PROJECT
NEW MAITLAND HOSPITAL
Metford Road, Metford

DRAWING TITLE
Landscape General Arrangement Plan
Quadrant A2

STATUS Design Development	JOB NO. 1229
SCALE AT A0 1:100	DRAWN GB/LT
CO-ORDINATED GB/IK	CHECKED IK
DWG NO. BBE-LSA-DRW-GA2-1A2	APPROVED GB/IK
	ISSUE 02

Original Sheet Size A0 - 1188 x 841mm

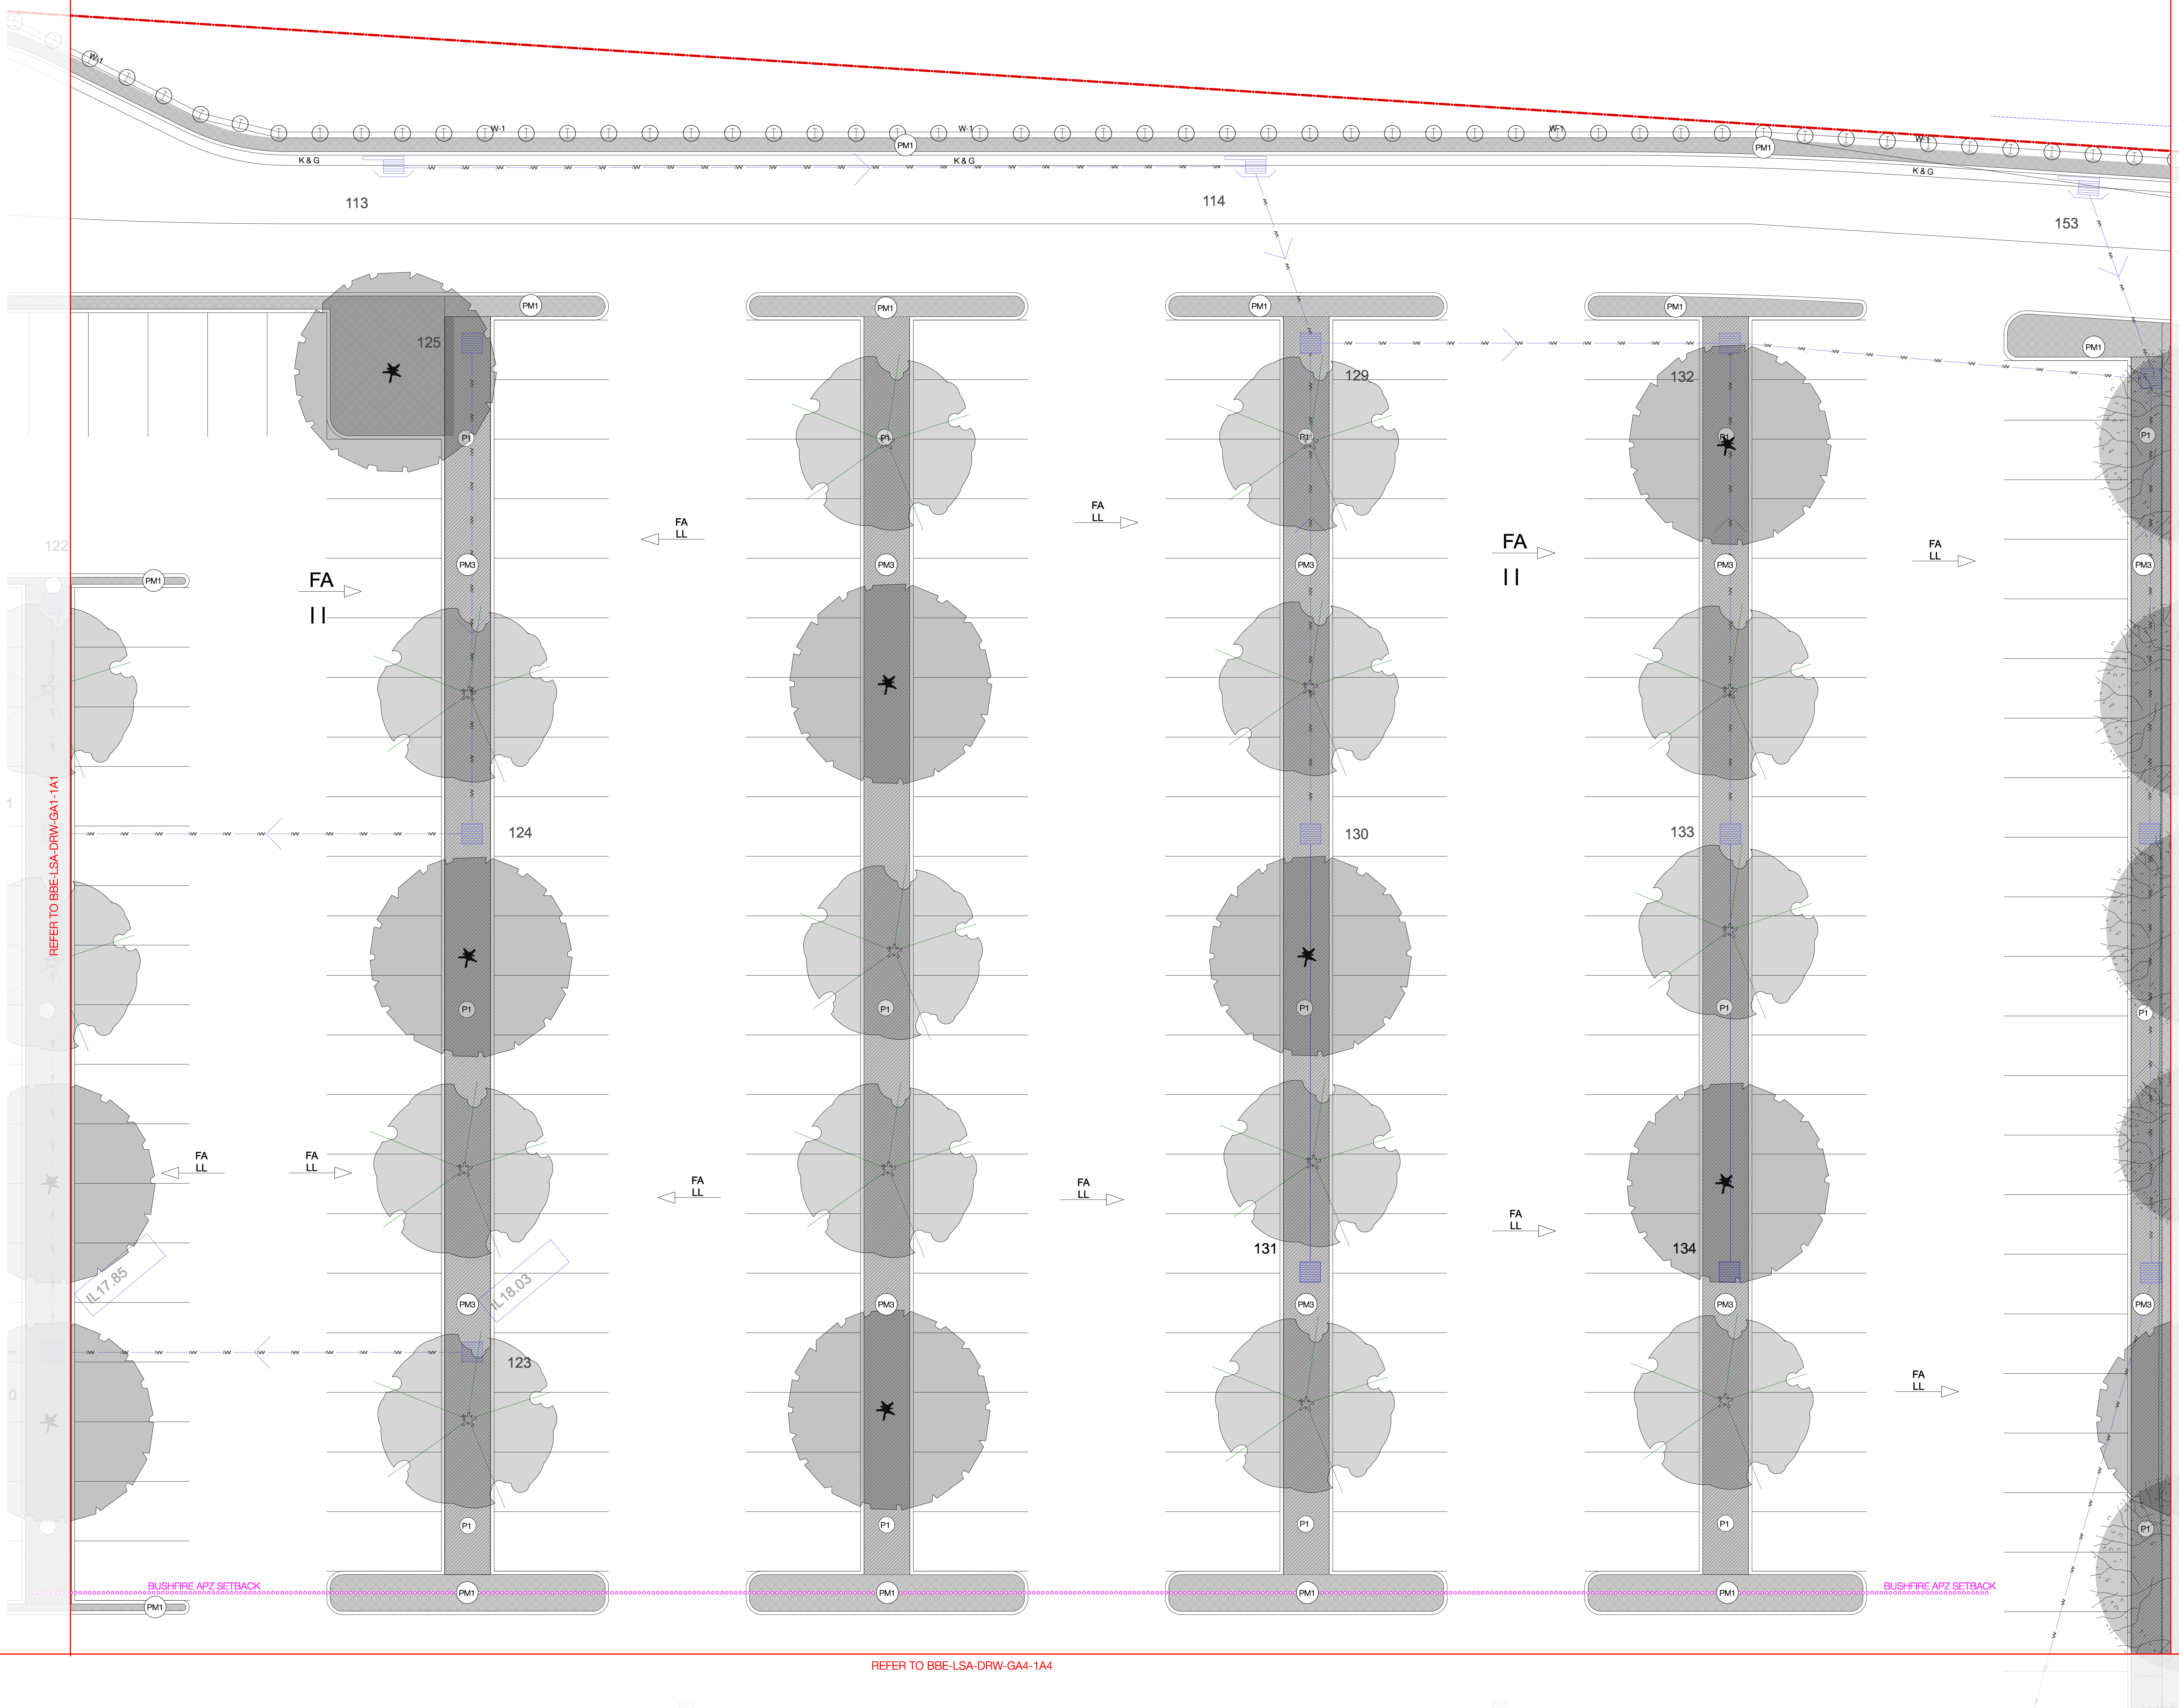


REFER TO BBE-LSA-DRW-GA1-1A1

REFER TO BBE-LSA-DRW-GB1-1B1

REFER TO BBE-LSA-DRW-GA4-1A4

FOR INFORMATION

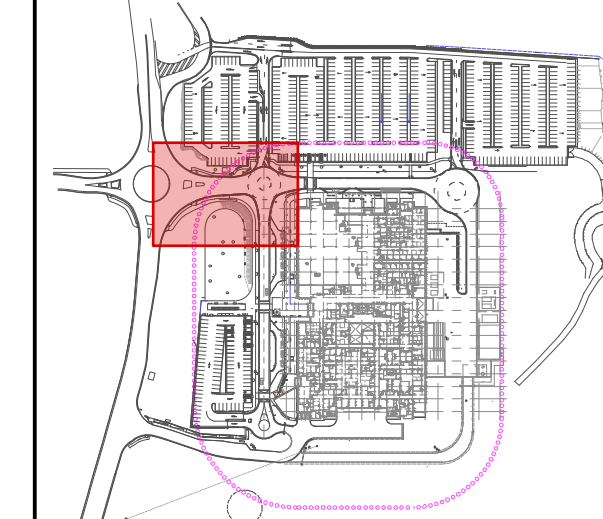

NOTES

Contractor must verify all dimensions on site before commencing work or preparing shop drawings. Do not scale drawings. Resolve discrepancies with Black Beetle before proceeding. Copyright of this drawing and the design executed remain vested in Black Beetle

REFER TO BBE-LSA-DRW-GX0-100 FOR
LEGEND AND GENERAL NOTES
REFER TO BBE-LSA-DRW-GX0-300 FOR
PLANT SCHEDULE

06	SSI 2	09.09.19
05	SSI 2	06.09.19
04	Design Development	19.08.19
03	Design Development	30.07.19
02	Design Development	21.07.19
01	Design Development 50%	03.06.19

Rev	Description	Date
-----	-------------	------

MANAGING CONTRACTOR

MULTIPLEX

CONSULTANTS

PROJECT MANAGEMENT

CBF



ARCHITECTURE

BNN

OVERLAPPING A. CHEN

TTW Taylor
Thomson
Whitting

HYDRAULIC & FIRE

MECHANICAL

ELECTRICAL

—
QUE



PROJECT


NEW MAITLAND HOSPITAL
Metford Road, Metford

DRAWING TITLE

Landscape General Arrangement Plan
Quadrant A3

STATUS Design Development			JOB NO. 1229	
SCALE AT A0 1:100	DRAWN GB/LT	CO-ORDINATED GB/IK	CHECKED IK	APPROVED GB
DWG NO. BBE-LSA-DRW-GA3-1A3			ISSUE 06	

Original Sheet Size A0 - 1188 x 841mm

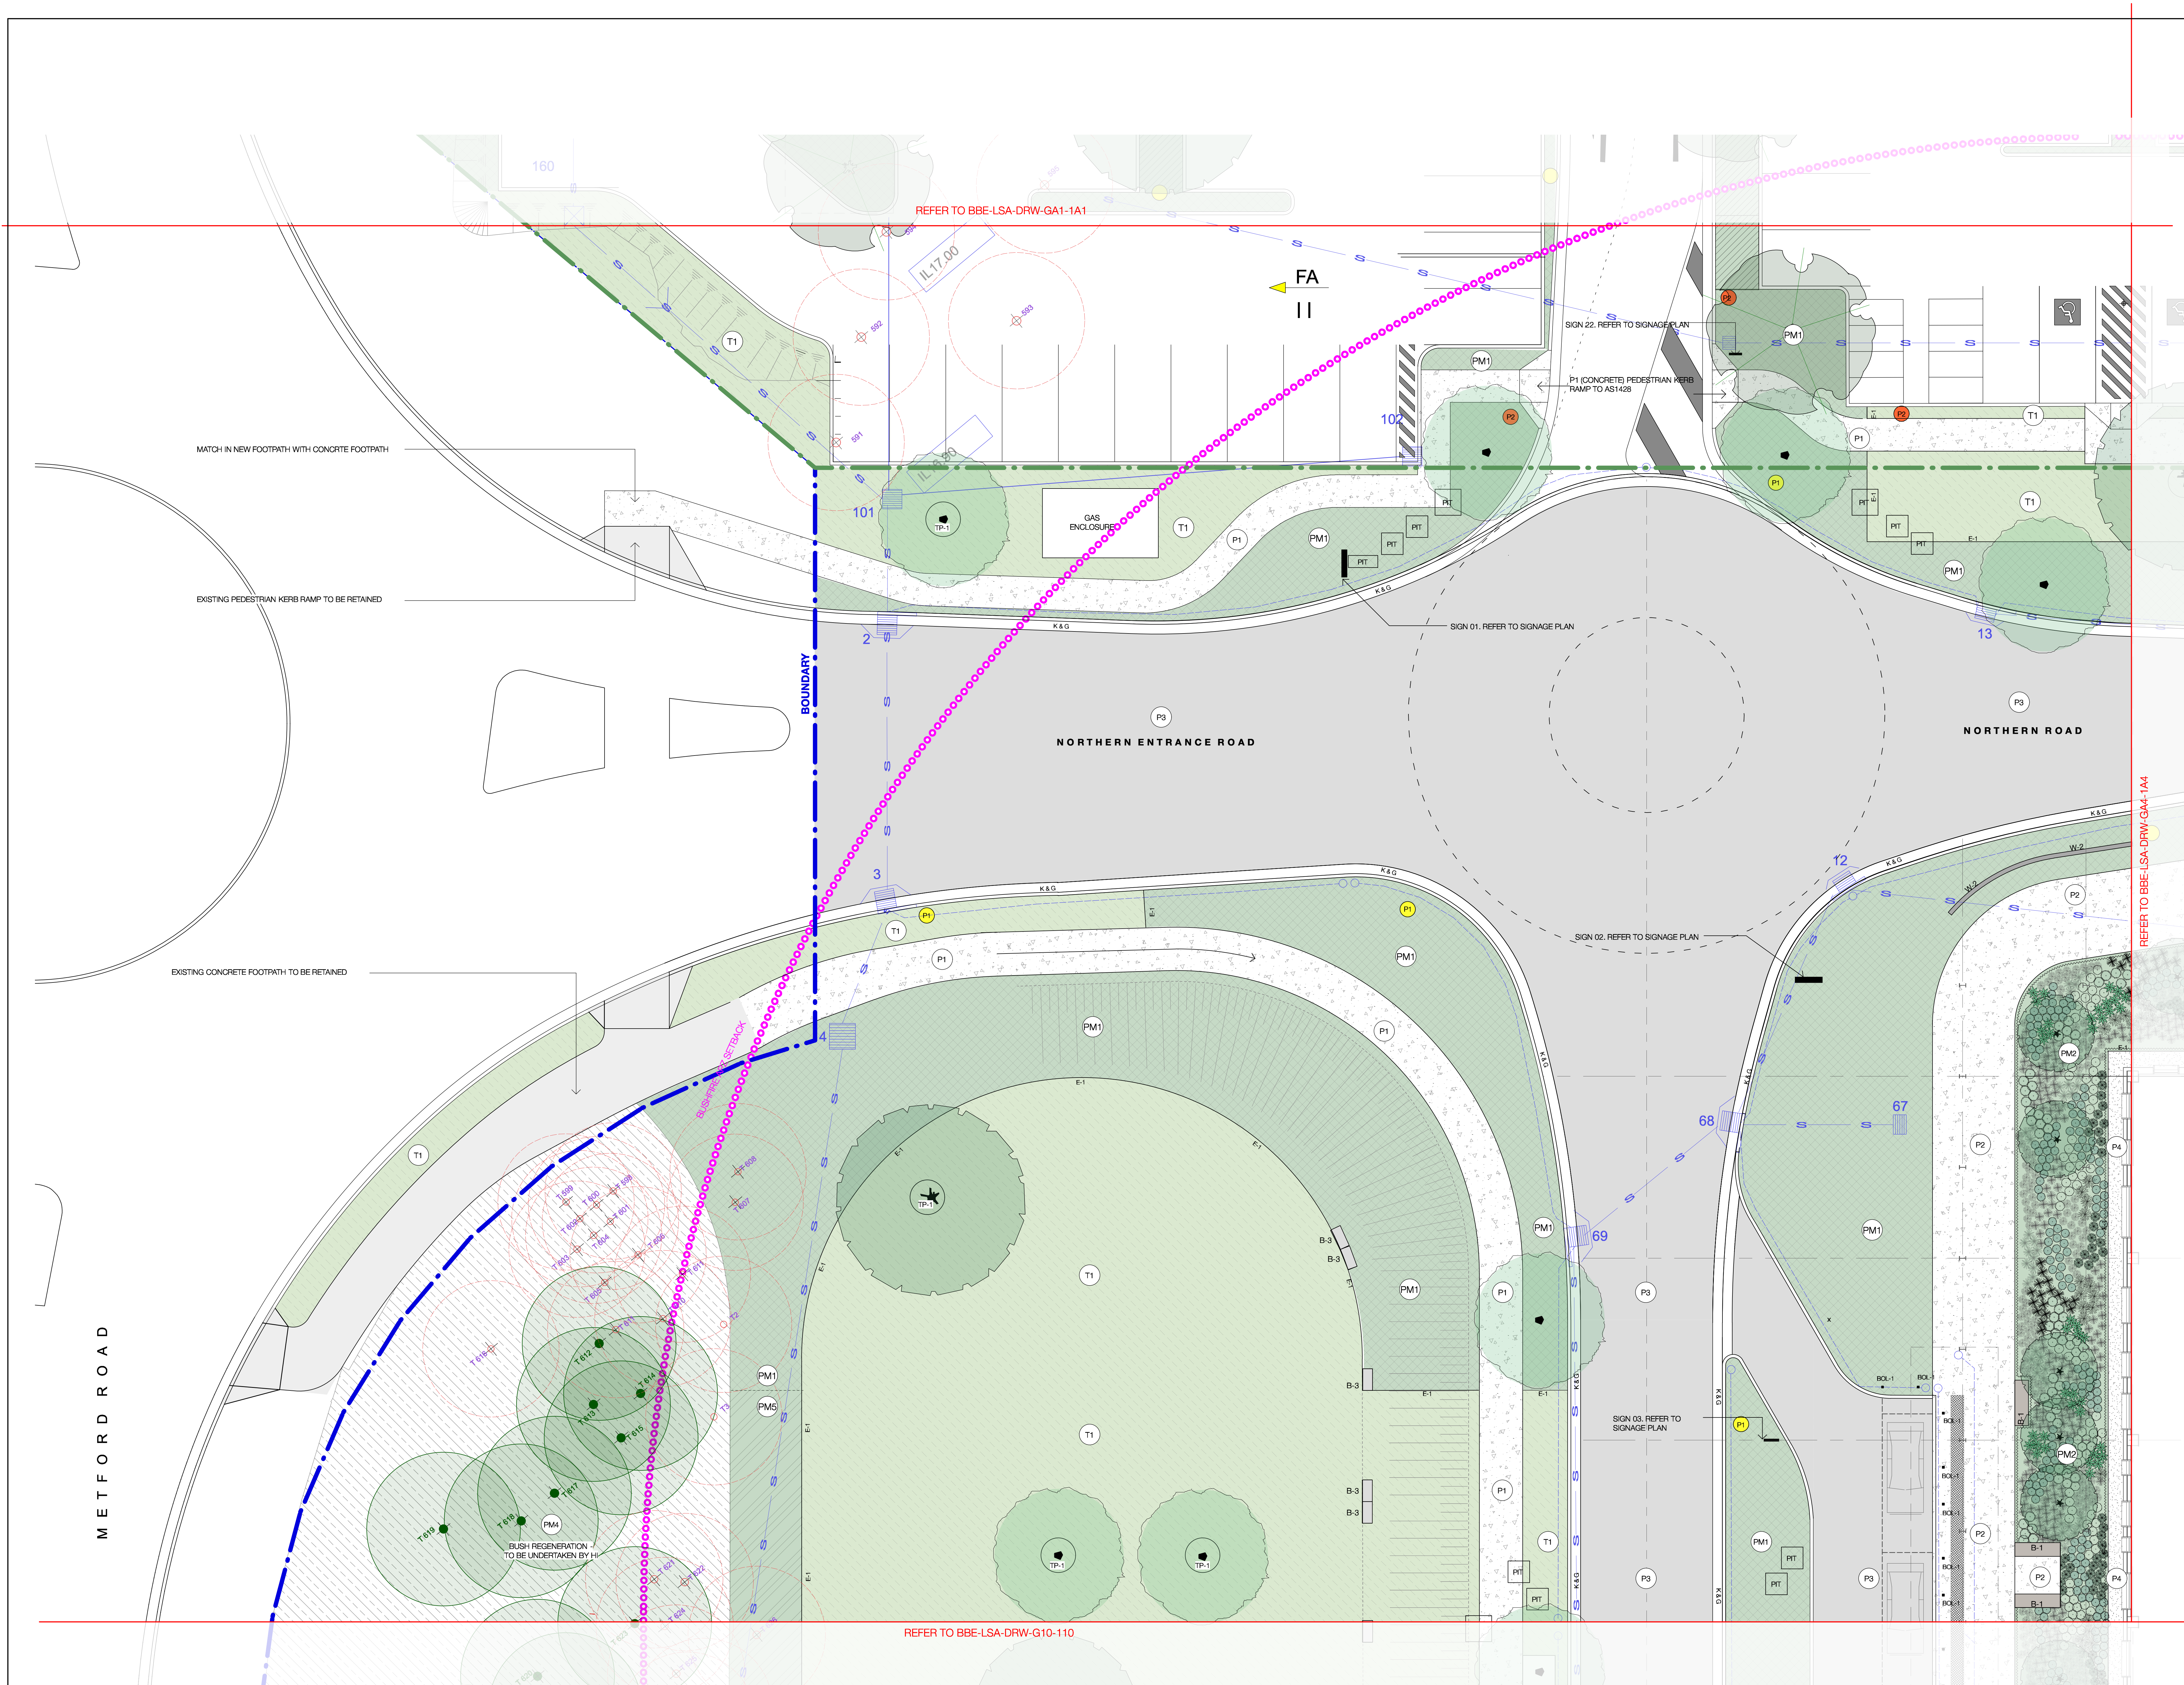

FOR INFORMATION