
 



An architectural rendering of the Tweed Valley Hospital. The building is a modern, multi-story structure with a facade of vertical wooden slats and large glass windows. The name "Tweed Valley Hospital" is visible on the left side of the building. The hospital is surrounded by lush greenery, including tall grasses and various plants in the foreground. A paved road with a few cars leads towards the building. The sky is blue with scattered white clouds. The entire scene is framed by the branches of trees in the upper corners.


ELECTRICAL ENGINEERING DRAWINGS

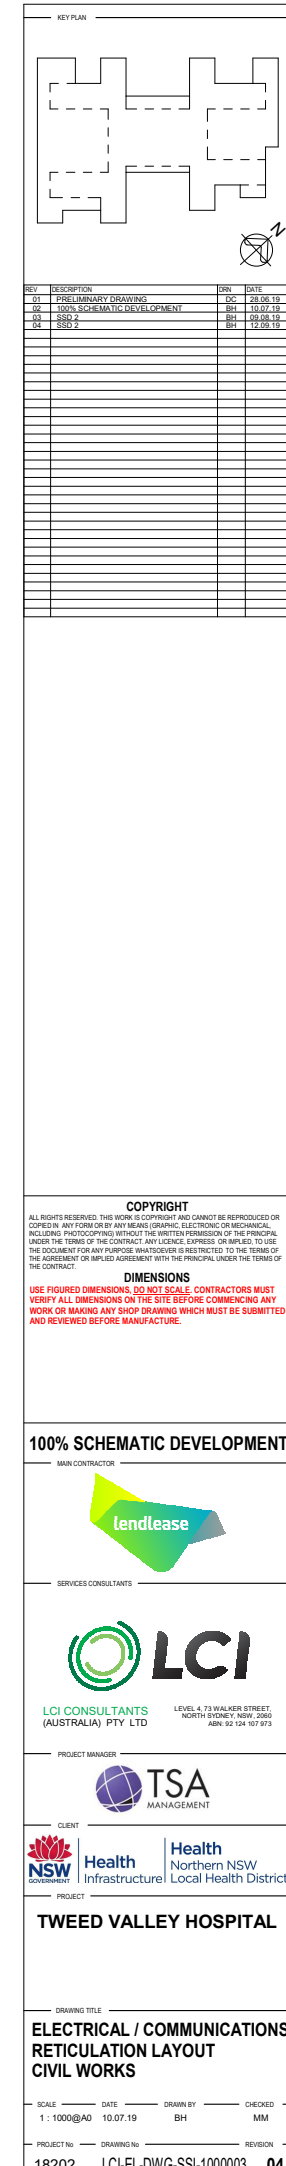



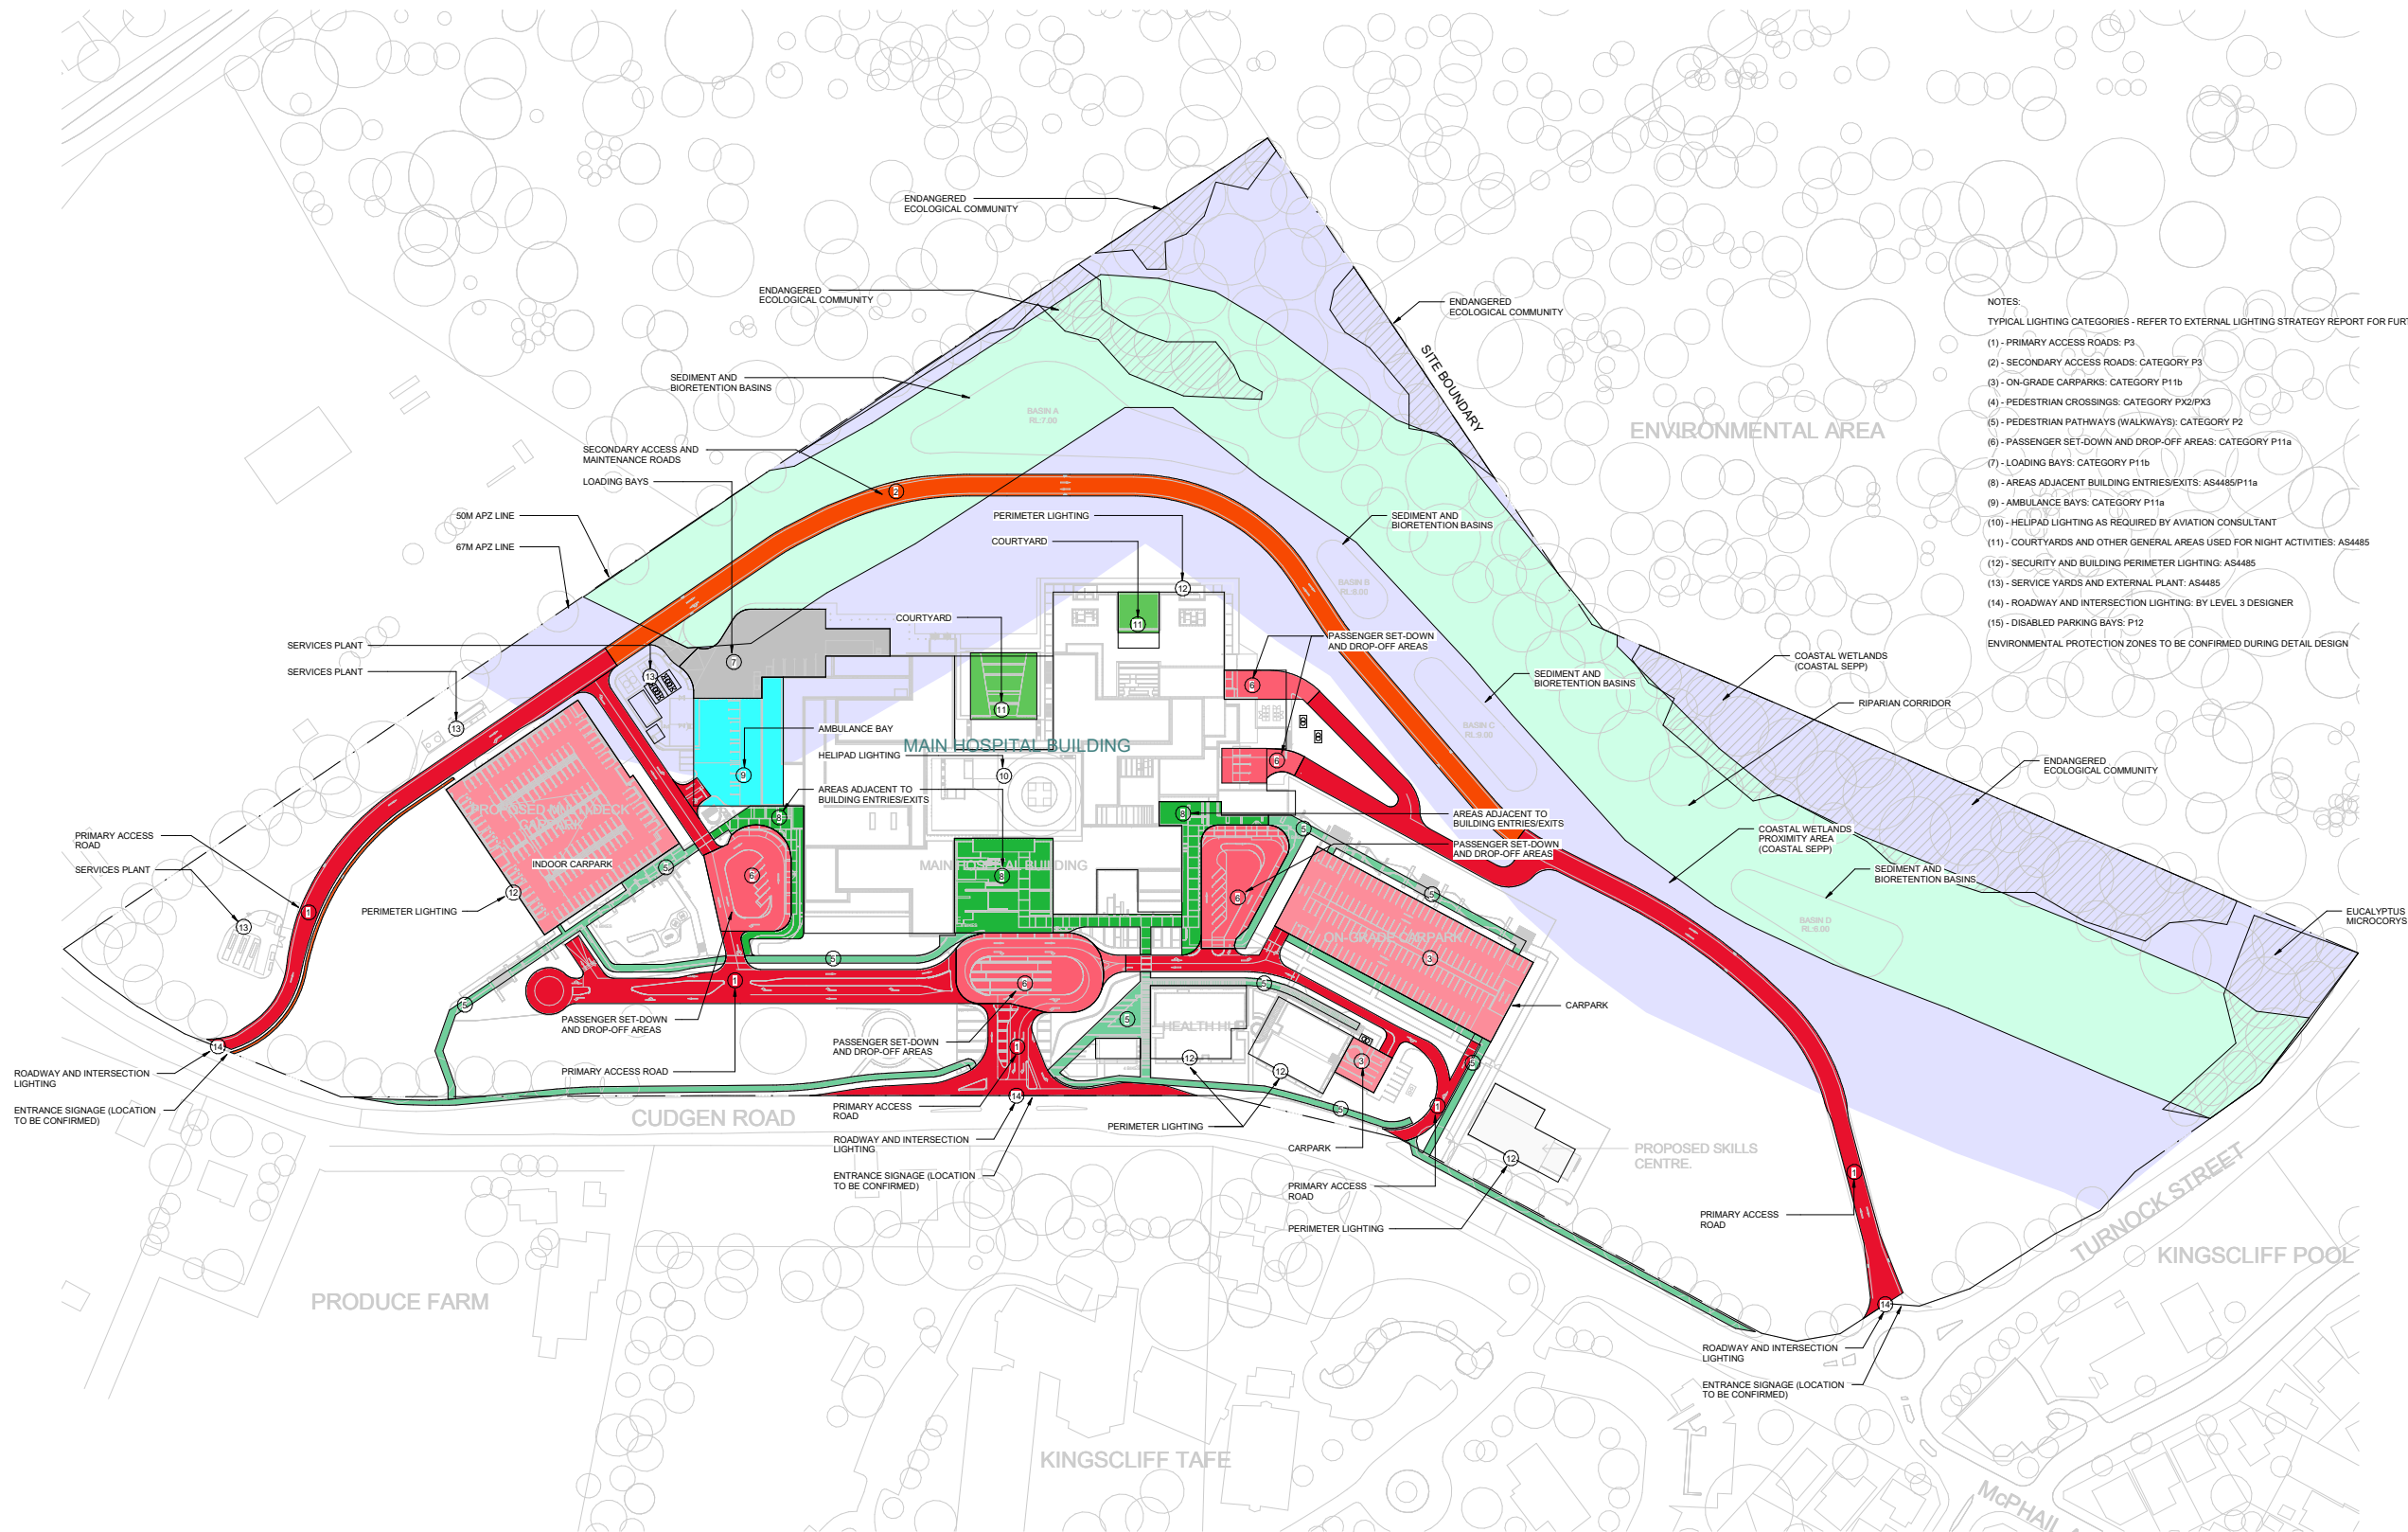

- NOTES:
- TYPICAL LIGHTING CATEGORIES - REFER TO EXTERNAL LIGHTING STRATEGY REPORT FOR FURTHER DETAILS:
- (1) - PRIMARY ACCESS ROADS: P3
 - (2) - SECONDARY ACCESS ROADS: CATEGORY P3
 - (3) - ON-GRADE CARPARKS: CATEGORY P11b
 - (4) - PEDESTRIAN CROSSINGS: CATEGORY PX2/PX3
 - (5) - PEDESTRIAN PATHWAYS (WALKWAYS): CATEGORY P2
 - (6) - PASSENGER SET-DOWN AND DROP-OFF AREAS: CATEGORY P11a
 - (7) - LOADING BAYS: CATEGORY P11b
 - (8) - AREAS ADJACENT BUILDING ENTRIES/EXITS: AS4485/P11a
 - (9) - AMBULANCE BAYS: CATEGORY P11a
 - (10) - HELIPAD LIGHTING AS REQUIRED BY AVIATION CONSULTANT
 - (11) - COURTYARDS AND OTHER GENERAL AREAS USED FOR NIGHT ACTIVITIES: AS4485
 - (12) - SECURITY AND BUILDING PERIMETER LIGHTING: AS4485
 - (13) - SERVICE YARDS AND EXTERNAL PLANT: AS4485
 - (14) - ROADWAY AND INTERSECTION LIGHTING: BY LEVEL 3 DESIGNER
 - (15) - DISABLED PARKING BAYS: P12
- ENVIRONMENTAL PROTECTION ZONES TO BE CONFIRMED DURING DETAIL DESIGN

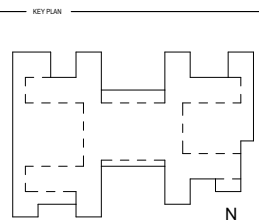

REV	DESCRIPTION	DATE
01	PRELIMINARY DRAWING	10.07.19
02	100% SCHEMATIC DEVELOPMENT	10.07.19
03	SSD 1	10.07.19
04	SSD 2	12.08.19

COPYRIGHT
ALL RIGHTS RESERVED. THIS WORK IS COPYRIGHT AND CANNOT BE REPRODUCED OR COPIED IN ANY FORM OR BY ANY MEANS (GRAPHIC, ELECTRONIC OR MECHANICAL) INCLUDING PHOTOCOPYING WITHOUT THE WRITTEN PERMISSION OF THE PRINCIPAL UNDER THE TERMS OF THE CONTRACT ANY LICENSE EXPRESS OR IMPLIED TO USE THE DOCUMENT FOR ANY PURPOSE WHATSOEVER IS RESTRICTED TO THE TERMS OF THE CONTRACT.

DIMENSIONS
USE FIGURED DIMENSIONS. DO NOT SCALE. CONTRACTORS MUST VERIFY ALL DIMENSIONS ON THE SITE BEFORE COMMENCING ANY WORK OR MAKING ANY SHOP DRAWING WHICH MUST BE SUBMITTED AND REVIEWED BEFORE MANUFACTURE.

100% SCHEMATIC DEVELOPMENT



TWEED VALLEY HOSPITAL

ELECTRICAL SERVICES LIGHTING STRATEGY SITE PLAN

SCALE: 1:1000@A0 DATE: 10.07.19 DRAWN BY: BH CHECKED: MM

PROJECT No: 18202 DRAWING No: LCI-EL-DWG-SSI-1000002 REVISION: 04

DRAWING TO BE PRINTED IN COLOUR