


REFER TO SHEET C022 FOR CONTINUATION

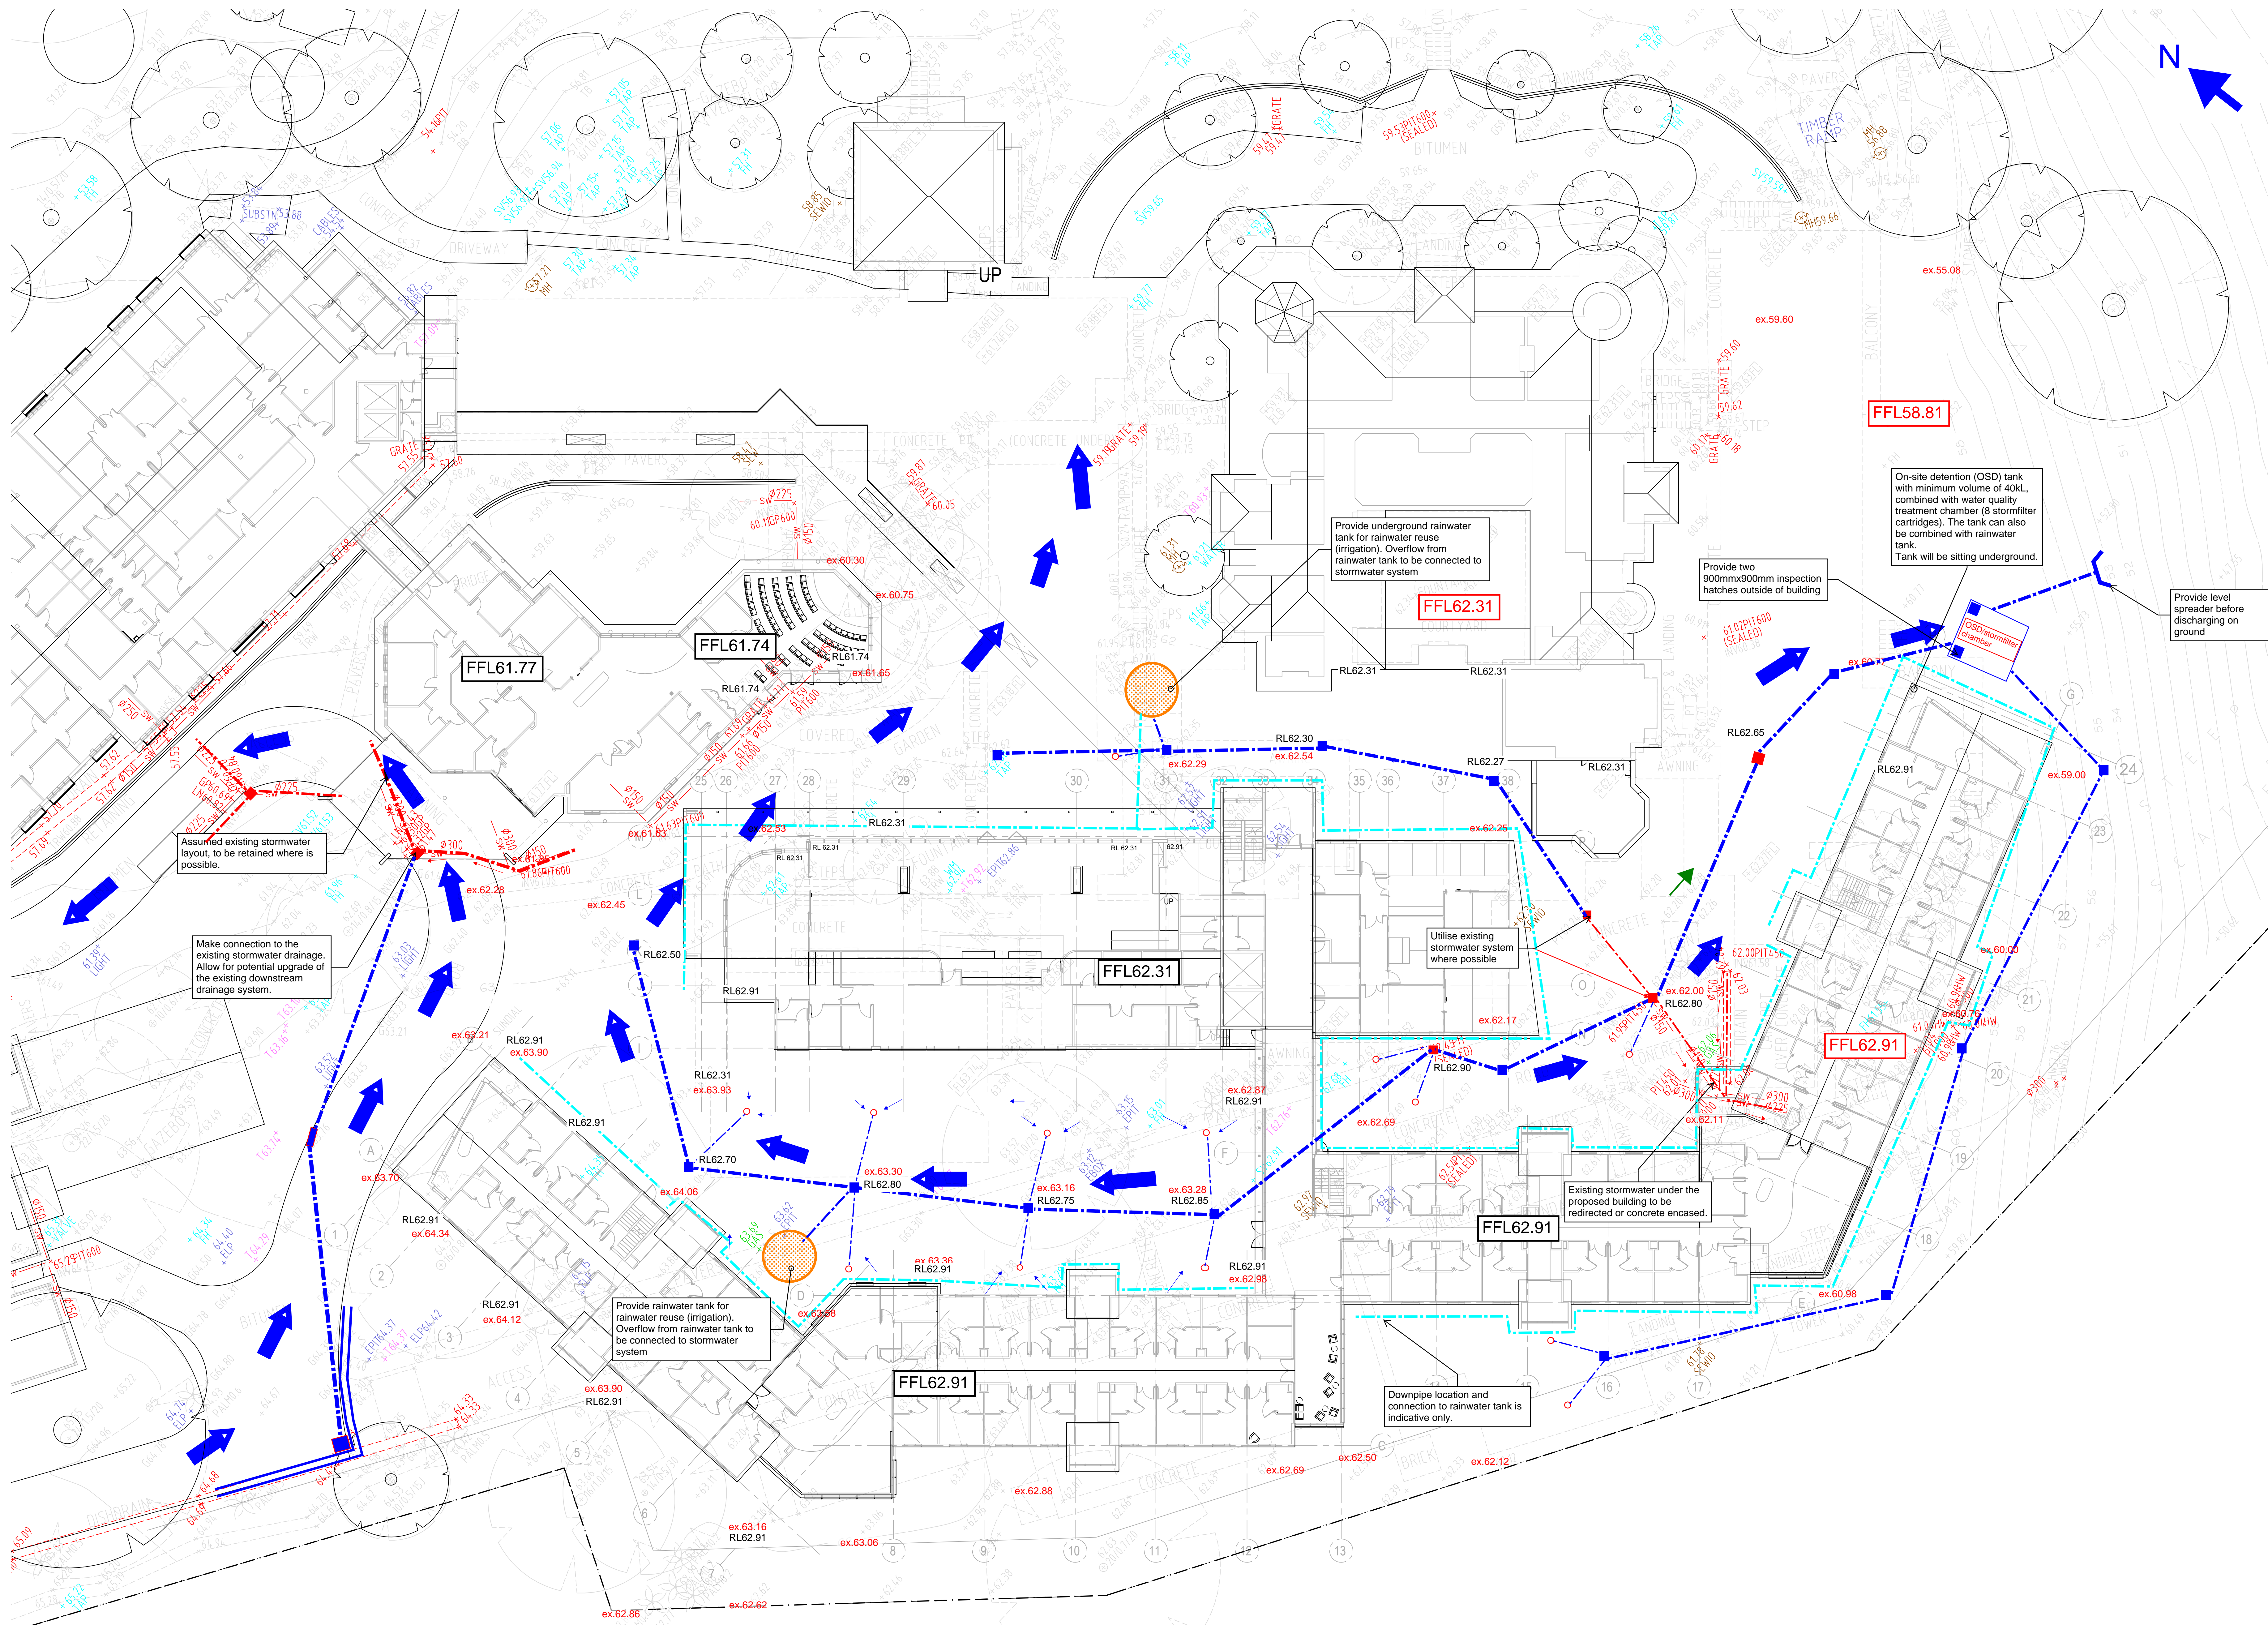

Legend

Proposed stormwater pipe

Proposed stormwater pit

Proposed rainwater outlet

Proposed grade

Proposed pipe flow

Indicative roof drainage to rainwater tank

Existing stormwater pipe

Existing stormwater pit

Proposed overland flow path

RL62.9

Design level (preliminary)

ex.63.93

Existing ground level (survey)

Background

Architectural Ground Floor Plan
(17/01/2020)

COPYRIGHT		All rights reserved.	
These drawings, plans and specifications and the copyright therein are the property of the Bonacci Group and must not be used, reproduced or copied, wholly or in part without the written permission of the Bonacci Group.			
Rev	Description	Date	By
PT	ISSUED FOR SDA		



Project Name		ST JOHN OF GOD HOSPITAL REDEVELOPMENT	
Address		177 GROSE VALE RD NORTH RICHMOND NSW 2753	
Drawing Title		STORMWATER DRAINAGE PLAN SHEET 1	
Design		EJ	
Scale		1:200	
Date		OCT 2020	
Sheet		A0	
Approval		Date	
Project Ref		12056 01	
Drawing No		C021	
Rev		P1	

THIS DRAWING MAY BE PREPARED IN COLOUR AND MAY BE INCOMPLETE IF COPIED

