

RIDBC MACQUARIE UNIVERSITY

STORMWATER DRAINAGE INFRASTRUCTURE



LOCALITY PLAN
NOT TO SCALE

STATE SIGNIFICANT DEVELOPMENT APPLICATION

X:\46-2020-1773-14\TITLE-BK-A1.dwg
C:\Users\michael\OneDrive\Documents\2020-1773\DRAWINGS\2020-1773-14\STW-001.dwg
Plot Date: 11/11/2020 15:48:23
User: michael

DO NOT SCALE FROM DRAWINGS. CHECK & VERIFY ALL DIMENSIONS & LEVELS BEFORE COMMENCEMENT OF ANY WORK.	NORTH POINT SHEET SIZE: A1	NOTES 1. REFER TO DRAWING DA-STW-002 FOR DRAWING LIST. 2. CONTRACTOR TO CHECK AND CONFIRM ALL LEVELS ON SITE. 3. CONTRACTOR TO INVESTIGATE ALL EXISTING SERVICES, SUCH AS APPLY FOR "DIAL BEFORE YOU DIG" SERVICES PRIOR TO START OF WORKS ON SITE.	ISSUE A B C	AMENDMENT DEVELOPMENT APPLICATION - ISSUE FOR COORDINATION ISSUE FOR DEVELOPMENT APPLICATION ISSUE FOR SSDA	DATE 30.09.2020 16.10.2020 11.11.2020	PROJECT ROYAL INSTITUTE FOR DEAF & BLIND CHILDREN MACQUARIE UNIVERSITY	PROJECT MANAGER M PROJECTS Suite C2.08, Level 2 22-36 Mountain Street, Ultimo NSW 2007 Tel: (02) 9262 5530 Fax: (02) 9262 5529 Web: mprojects.com.au	CLIENT	CONSULTANT LP CONSULTING AUSTRALIA PTY LTD A: Suite 12.01, Level 12, 300 George Street Sydney NSW Australia 2000 P: GPO Box 2662 Sydney NSW 2001 E: info@lp-consulting.com.au T: +61 (2) 9223 4444 W: www.lp-consulting.com.au	TITLE STORMWATER DRAINAGE SITE & LOCATION PLAN							
						ARCHITECT WMK Architecture L2 364 Kent Street Sydney NSW 2000 Tel: (02) 9262 5530 Fax: (02) 9262 5529 Web: mprojects.com.au	SCALE N.T.S					DRAWN RMW	DESIGNED LP	CHECKED LP	APPROVED		
						DATE Nov 11, 2020					DRAWING No. DA-STW - 001					ISSUE C	
						JOB No. 2020-1773					STATE SIGN. DA						

LEGEND

LINETYPES

	OVERFLOW
	RAINWATER RE-USE
	SIPHONIC DRAINAGE
	SUBSOIL DRAINAGE
	SUBSOIL RISING MAIN
	STORMWATER DRAINAGE
	STORMWATER RISING MAIN
	STORMWATER DRAINAGE
	FILTERED RAINWATER RE-USE
	IRRIGATION
	RECYCLED COLD WATER
	ELECTRICAL WIRING
	ELECTRICAL CONDUIT
	EXISTING CONTOUR LINE
	PROPOSED CONTOUR LINE

SERVICES & UTILITIES

 
	EXISTING ELECTRICAL
	EXISTING GAS
	EXISTING TELSTRA
	EXISTING SEWER
	EXISTING STORMWATER
	EXISTING SERVICE TO BE ABANDONED
	EXISTING FIBRE OPTIC
	EXISTING GAS MEDIUM PRESSURE
	EXISTING TELECOMMUNICATIONS
	EXISTING TELECOMMUNICATIONS
	EXISTING TELECOMMUNICATIONS
	EXISTING ELECTRICITY
	EXISTING WATER

NOTE:
'e' ON SERVICE LINE DENOTES EXISTING SERVICE.
'x' ON SERVICE LINE DENOTES SERVICE TO BE ABANDONED.


EROSION & SEDIMENT SYMBOLS

	BARRIER FENCE
	SILT FENCE
	STABILISED CONSTRUCTION SITE VEHICLE ENTRY/EXIT GRID
	STRAW BALE SEDIMENT FILTER


DRAWING INFORMATION SYMBOLS



PIPEWORK SHOWN IN STRATA
UNLESS NOTED OTHERWISE

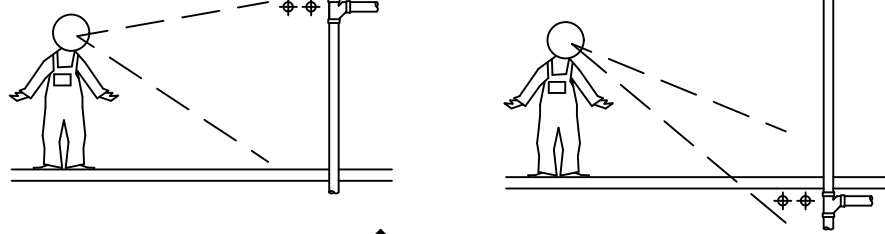

PIPEWORK SHOWN OUT OF STRATA
UNLESS NOTED OTHERWISE

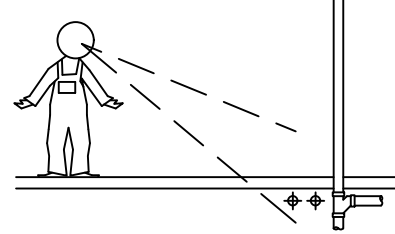

	SECTION No.
	DRAWING REFERENCE No.
	DETAIL No.
	DRAWING REFERENCE No.
	AMENDMENT REFERENCE

ABBREVIATIONS, SYMBOLS AND LINETYPES IN
THE LEGEND MAY NOT APPEAR ELSEWHERE
ON THE DRAWINGS. THIS LEGEND SHOULD BE
USED AS A GUIDE ONLY

HYDRAULIC SERVICES SYMBOLS

	VERTICAL RISER IN DRAINAGE
	CLEAROUT OR INSPECTION OPENING
	DRAINAGE TURN-UP
	FLOW DIRECTION ARROW
	PENETRATION CORE THROUGH STRUCTURAL ELEMENT
	DOWNPipe (150mm DIAMETER)
	RISER
	DROPPER
	DROPS TO BELOW / RISES FROM BELOW
	CAPPED OFF SERVICE
	CONTINUATION OF SERVICE NOT SHOWN
	CONTINUATION OF SERVICE SHOWN ELSEWHERE
	FLANGED CONNECTION
	SERVICE CAST IN SLAB
	SERVICE CONCRETE ENCASED
	ISOLATION VALVE
	BALANCING VALVE (STAD)
	CHECK VALVE
	BACKFLOW PREVENTION DEVICE
	PRESSURE LIMITING VALVE
	PRESSURE REDUCTION VALVE
	STRAINER
	FILTER
	PUMP
	HOSE TAP
	COLD WATER POINT
	THRUST BLOCK
	TUNDISH
	REFLUX VALVE
	RAINWATER OUTLET
	SQUARE RAINWATER OUTLET
	SPREADER
	RAINWATER HEAD
	STORMWATER PIT (ACCESS ONLY)
	STORMWATER PIT (INLET)
	KERB INLET PIT
	GRATED TRENCH DRAIN
	FALL ARROW
	OVERLAND FLOW PATH DIRECTIONAL ARROW
	STORMWATER HEADWALL
	SWALE OR SPEED HUMP
	ELECTRICAL CONTROL PANEL
	DIRECTION OF FLOW
	SERVICE
	SIZE
	CONTINUED ON DWG XX

GENERAL ABBREVIATIONS

AAV	AIR ADMITTANCE VALVE
AB	ACCESSIBLE BASIN
AC	AIR CONDITIONING
AV	AIR RELEASE VALVE
AWC	ACCESSIBLE TOILET (WATER CLOSET)
B	BASIN
BG	BOX GUTTER
BGO	BOX GUTTER OUTLET
BT	BOUNDARY TRAP
BTFW	BUCKET TRAP FLOOR WASTE
BTH	BATH
BWU	BOILING WATER UNIT
CAC	CIRCULAR ACCESS CHAMBER
CHVP	CHAMBER VENT PIPE
CTS	CENTRES
CL	CENTRE LINE
CI	CAST IRON
CIC	CAST IN COLUMN
CIS	CAST IN SLAB
CO	CLEAR OUT
Cu	COPPER
CW	COLD WATER
DIA	DUCTILE IRON
DI	DIAMETER
DP	DOWN PIPE
DPFH	DOUBLE PILLAR FIRE HYDRANT
DST	DRAINAGE STACK
DTU	DRAINAGE TURN-UP
DWG	DRAWING
ED	ELEVATED DRAINAGE
EGL	EXISTING GROUND LEVEL
EGO	EAVES GUTTER OUTLET
EJ	EXPANSION JOINT
Ex	EXISTING
FFL	FINISHED FLOOR LEVEL
FH	FIRE HYDRANT
FHR	FIRE HOSE REEL
FSC	FIRE STOP COLLAR
FW	FLOOR WASTE
GALV	GALVANISED
GDO	GRATED DRAIN OUTLET
GMS	GALVANISED MILD STEEL
GVP	GREASE VENT PIPE
HD	HEAVY DUTY
HDC	HEAVY DUTY COVER
HDG	HEAVY DUTY GRATE
HDPE	HIGH DENSITY POLYETHYLENE
H/L	HIGH LEVEL
HP	HIGH POINT
HT	HOSE TAP
HW	HOT WATER
HWU	HOT WATER UNIT
ID	INTERNAL DIAMETER
IL	INVERT LEVEL
IO	INSPECTION OPENING
IPMF	INDUCT PIPE MICA FLAP
KIP	KERB INLET PIT
KFW	KITCHEN FLOOR WASTE
KO	KEY OPERATED
LDC	LIGHT DUTY COVER
LDG	LIGHT DUTY GRATE
LL	LOW LEVEL
L.O.C.	LIMIT OF CONTRACT
MAX.	MAXIMUM
MIN.	MINIMUM
NB	NOMINAL BORE
NG	NATURAL GAS
N.I.C	NOT IN CONTRACT
NOM	NOMINAL
No.	NUMBER
NTS	NOT TO SCALE
OD	OUTSIDE DIAMETER
O/F	OVERFLOW
OLF	OVERLAND FLOW
ORG	OVERFLOW RELIEF GULLY
P	PENETRATION
PDO	PLANTER DRAIN OUTLET
PLV	PRESSURE LIMITING VALVE
PRV	PRESSURE REDUCING VALVE
RCBC	REINFORCED CONCRETE BOX CULVERT
REV	REVISION
RHS	RECTANGULAR HOLLOW SECTION
RL	REDUCED LEVEL
RO	RAINWATER OUTLET
RPZD	REDUCED PRESSURE ZONE DEVICE
RST	RECESSED STOP TAP
RTD	RECESSED TUNDISH
RV	REFLUX VALVE
RWH	RAINWATER HEAD
RWO	RAINWATER OUTLET

GENERAL ABBREVIATIONS CONT.

S	SINK
SHR	SHOWER
SMH	SEWER MANHOLE
SQ	SQUARE
SST	SOIL STACK
ST	STOP TAP
STD	STANDARD
STW	STORMWATER
SV	STOP VALVE (ISOLATION VALVE)
SWP	STORMWATER PIT
TBC	TO BE CONFIRMED
TD	TUNDISH
TG	TRENCH GRATE
TMV	THERMOSTATIC MIXING VALVE
TOK	TOP OF KERB
TTD	TRAPPED TUNDISH
TWL	TOP WATER LEVEL
TWVP	TRADE WASTE VENT PIPE
U.N.O.	UNLESS NOTED OTHERWISE
UPVC	UNPLASTICISED POLYVINYL CHLORIDE
UV	UTENSIL WASHING MACHINE
VB	VANITY BASIN / VACUUM BREAKER
VERT	VERTICAL
VP	VENT PIPE
WC	TOILET SUITE (WATER CLOSET)
WST	WASTE STACK

CIVIL ABBREVIATIONS

BWL	DRAINAGE LEVELS BOTTOM WATER LEVEL
IL	INVERT LEVEL
OL	OBVERT LEVEL
RL	REDUCED LEVEL
SL	SURFACE LEVEL
TWL	TOP WATER LEVEL

LD	GRATES & COVERS LIGHT DUTY CLASS 'B'
MD	MEDIUM DUTY CLASS 'C'
HD	HEAVY DUTY CLASS 'D'
EHD	EXTRA HEAVY DUTY CLASS 'E'
MP	MULTI PART COVER OR GRATE

DCP	PITS DISCHARGE CONTROL PIT
JP	JUNCTION PIT
KEP	KERB ENTRY PIT
SWP	STORMWATER PIT

SS	DRAINAGE LINES SUBSOIL DRAINAGE
STW	STORMWATER DRAIN

CO	FEATURES CLEAROUT
DP	DOWN PIPE
FP	FLUSHING POINT
IO	INSPECTION OPENING
OF	GUTTER OVERFLOW PIPE
RWO	RAINWATER OUTLET
DTU	DRAINAGE TURNUP

CATCHMENT ABBREVIATIONS

L/s	LITRES PER SECOND
m/s	METRES PER SECOND
CUMCS	CUBIC METRES PER SECOND
Q	QUANTITY OF FLOW

DRAWING NOTES

- DRAWINGS ARE DIAGRAMMATIC ONLY. FOR DIMENSIONS AND CONSTRUCTION DETAILS OF BUILDING REFER ARCHITECTURAL DRAWINGS AND SITE.
- PIPEWORK SIZES ARE NOMINAL BORE FOR COPPER AND CAST IRON AND INTERNAL BORE FOR POLYMER BASED PIPEWORK. REFER SPECIFICATION FOR MATERIAL TYPE.
- ALL PIPEWORK ON DRAWINGS IS SHOWN BELOW SLAB (OR GROUND) UNLESS NOTED OTHERWISE.

DRAWING LIST

DA - STW - 001	TITTLE SHEET AND LOCALITY PLAN	DA - STW - 101	STORMWATER DRAINAGE BASEMENT PLAN - ZONE 1
DA - STW - 002	LEGEND, ABBREVIATIONS AND DRAWING LIST	DA - STW - 102	STORMWATER DRAINAGE LOWER GROUND FLOOR PLAN - ZONE 1
DA - STW - 003	STORMWATER DRAINAGE GENERAL NOTES	DA - STW - 103	STORMWATER DRAINAGE UPPER GROUND FLOOR PLAN - ZONE 2
DA - STW - 004	STORMWATER DRAINAGE SURVEY PLAN SERVICES LAYOUT - SHEET 1	DA - STW - 104	STORMWATER DRAINAGE LEVEL 01 - ZONE 1
DA - STW - 005	STORMWATER DRAINAGE SURVEY PLAN SERVICES LAYOUT - SHEET 2	DA - STW - 105	STORMWATER DRAINAGE ROOF PLAN - ZONE 1
DA - STW - 006	STORMWATER DRAINAGE SURVEY PLAN SERVICES LAYOUT - SHEET 3	DA - STW - 106	STORMWATER DRAINAGE ROOF PLAN - ZONE 2
DA - STW - 007	STORMWATER DRAINAGE SURVEY PLAN SERVICES LAYOUT - SHEET 4	DA - C - 107	SCHOOL BUILDING DRIVEWAY ENTRY LAYOUT PLAN
DA - STW - 008	STORMWATER DRAINAGE SURVEY PLAN SERVICES LAYOUT - SHEET 5	DA - C - 108	CONSULTING BUILDING DRIVEWAY ENTRY LAYOUT PLAN
DA - STW - 009	STORMWATER DRAINAGE UTILITY SERVICES SERVICES LAYOUT - SHEET 1	DA - C - 109	SCHOOL BUILDING CL 1 & 2 LONGITUDENAL SECTIONS
DA - STW - 010	STORMWATER DRAINAGE UTILITY SERVICES SERVICES LAYOUT - SHEET 2	DA - C - 110	SCHOOL BUILDING CL 3 & 4 LONGITUDENAL SECTIONS
DA - STW - 011	STORMWATER DRAINAGE UTILITY SERVICES SERVICES LAYOUT - SHEET 3	DA - C - 111	CONSULTING BUILDING CL 5 & 6 LONGITUDENAL SECTIONS
DA - STW - 012	STORMWATER DRAINAGE UTILITY SERVICES SERVICES LAYOUT - SHEET 4	DA - C - 112	CONSULTING BUILDING CL 7 & 8 LONGITUDENAL SECTIONS
DA - STW - 013	STORMWATER DRAINAGE STORMWATER QUANTITY - CATCHMENT PLAN		
DA - STW - 014	STORMWATER DRAINAGE STORMWATER QUALITY - WSUD CATCHMENT PLAN		
DA - STW - 015	STORMWATER DRAINAGE EROSION + SEDIMENT CONTROL		
DA - STW - 016	STORMWATER DRAINAGE EROSION + SEDIMENT CONTROL DETAIL SHEET - 1		
DA - STW - 017	STORMWATER DRAINAGE EROSION + SEDIMENT CONTROL DETAIL SHEET - 2		
DA - STW - 300	STORMWATER DRAINAGE DETENTION TANK DETAIL PLAN		
DA - STW - 301	STORMWATER DRAINAGE DETENTION TANK SECTION		

DO NOT SCALE FROM DRAWINGS. CHECK & VERIFY ALL DIMENSIONS & LEVELS BEFORE COMMENCEMENT OF ANY WORK.	NORTH POINT	NOTES 1. REFER TO DRAWING DA-STW-002 FOR DRAWING LIST. 2. CONTRACTOR TO CHECK AND CONFIRM ALL LEVELS ON SITE. 3. CONTRACTOR TO INVESTIGATE ALL EXISTING SERVICES, SUCH AS APPLY FOR "DIAL BEFORE YOU DIG" SERVICES PRIOR TO START OF WORKS ON SITE.	ISSUE A B C	AMENDMENT DEVELOPMENT APPLICATION - ISSUE FOR COORDINATION ISSUE FOR DEVELOPMENT APPLICATION ISSUE FOR SSDA	DATE 30.09.2020 16.10.2020 11.11.2020	PROJECT ROYAL INSTITUTE FOR DEAF & BLIND CHILDREN MACQUARIE UNIVERSITY	PROJECT MANAGER M PROJECTS Suite C2.08, Level 2 22-36 Mountain Street, Ultimo NSW 2007 Tel: (02) 9262 5530 Fax: (02) 9262 5529 Web: mprojects.com.au	CLIENT Royal Institute for Deaf and Blind Children	CONSULTANT LP CONSULTING AUSTRALIA PTY LTD A: Suite 12.01, Level 12, 300 George Street Sydney NSW Australia 2000 P: GPO Box 2662 Sydney NSW 2001 E: info@lp-consulting.com.au T: +61 (2) 9223 4444 W: www.lp-consulting.com.au	TITLE STORMWATER DRAINAGE LEGEND, ABBREVIATION & DRAWING LIST
THIS DRAWING IS NOT TO BE COPIED IN PART OR WHOLE WITHOUT WRITTEN PERMISSION FROM LP CONSULTING AUSTRALIA PTY LTD	SHEET SIZE: A1					ARCHITECT WMK Architecture L2 364 Kent Street Sydney NSW 2000				SCALE N.T.S. DRAWN WW DESIGNED LP CHECKED LP APPROVED DATE Nov 11, 2020 DRAWING No. DA - STW - 002 JOB No. 2020-1773 ISSUE C STATE SIGN. DA

NOTES

GENERAL

1. ALL DIMENSIONS IN MILLIMETRES UNO. REDUCED LEVELS AND CHAINAGES ARE IN METRES. DO NOT SCALE DRAWINGS. USE FIGURED DIMENSIONS.
2. THE PROPOSED WORKS DETAILED HEREIN SHALL BE CONSTRUCTED TO THE REQUIREMENTS OF COUNCIL. GENERALLY AS DETAILED HEREUNDER.
3. ALL EXISTING SERVICES SHALL BE VERIFIED FOR DEPTH AND HORIZONTAL POSITION BY PHYSICAL MEANS PRIOR TO EXCAVATION. ANY DISCREPANCIES SHALL BE BROUGHT FORTHWITH TO THE PROJECT MANAGER'S ATTENTION.

STORMWATER AND SUBSOIL DRAINAGE

MATERIALS:

1. PIPES AND FITTINGS FOR STORMWATER DRAINAGE SHALL BE AS FOLLOWS UNO ON THE DRAWINGS:
- A. POLYVINYL CHLORIDE (PVC) WITH SOLVENT WELDED JOINTS FOR BELOW GROUND DRAINAGE UP TO 225mm.
- B. REINFORCED CONCRETE WITH RUBBER RINGS FOR PIPE DIA'S GREATER THAN 225mm UNO.
- C. REINFORCED CONCRETE WHERE REQUIRED BY AS/NZ S3500 FOR EXCESSIVE DEPTH.
- BY D. INSTALL IN ACCORDANCE WITH AUSTRALIAN STANDARD AS/NZ S3500 EXCEPT WHERE VARIED THE CONTRACT DOCUMENTS.
2. PIPES & FITTINGS FOR SUBSOIL DRAINAGE SHALL BE SLOTTED POLYVINYL CHLORIDE (PVC) WITH SOLVENT WELDED JOINTS, MIN. 150mm DIAMETER.
3. IN GROUND DRAINAGE PIPEWORK SERVING DP's SHALL BE MINIMUM 150mm DIA. UNO.
4. GRATED DRAINS SHALL BE 150mm NOM.
- A. 150mm NOM. WIDTH IN NON TRAFFICABLE AREAS.
- B. 225mm NOM. WIDTH IN TRAFFICABLE AREAS.
5. STORMWATER PITS ARE AS SHOWN & SPECIFIED ON THE PLANS , PRECAST TYPE ACCEPTABLE WITH STEP IRONS FOR DEPTH GREATER THAN 1000. BENCH ALL PITS MIN. 50mm & FORM SMOOTH TRANSITION FROM INLET TO OUTLET.
6. SELECT FILL SHALL BE MATERIAL OBTAINED FROM EXCAVATION OF THE PIPE TRENCH OR IMPORTED WITH A PARTICLE SIZE FOR ROCK NOT GREATER THAN 75mm OR FOR OTHER THAN ROCK NOT GREATER THAN 150mm.
7. IMPORTED FILL SHALL BE EITHER, AND GENERALLY CONSIST OF SINGLE SIZED AGGREGATE WITH PARTICLE SIZE NOT GREATER THAN 5mm WRAPPED ALL ROUND WITH GEOTEXTILE FILTER FABRIC OR APPROVED HIGH COMPACTION SAND OR APPROVED CRUSHED ROAD GRAVEL CONFORMING TO RTA FORM 3051 OR SIMILAR.
8. STORMWATER PITS AND GRATES TO CONFORM WITH STANDARD COUNCIL REQUIREMENTS, WHERE ON PUBLIC LAND. GRATES TO BE SUPPLIED IN CLASS SHOWN ON THE DRAWINGS.

INSTALLATION REQUIREMENTS:

9. PIPES SHALL BE TRUE TO GRADES SHOWN AND ALIGNED SO THAT THE CENTRES OF THE INLET PIPES INTERSECT WITH THE CENTRE OF THE OUTLET PIPE AT THE DOWNSTREAM FACE OF THE PIT.
10. MINIMUM GRADES FOR GRAVITY STORMWATER DRAINAGE SHALL CONFORM TO AS3500 PART3 AS FOLLOWS, UNO:
- 1% FOR 100 AND 150 mm DIA
- 0.5% FOR 225 mm DIA
- 0.4% FOR 300 mm DIA
- 0.35% FOR 375 mm DIA
11. MINIMUM DEPTH OF COVER SHALL BE :-
- 300mm IN PRIVATE PROPERTY (NON VEHICULAR TRAFFIC).
- 450mm IN PUBLIC AREAS.
- 600mm IN VEHICULAR TRAFFICABLE AREAS (FOOTWAY/ROADWAY).
12. BED ALL PIPES FIRMLY AND EVENLY ONTO IMPORTED BEDDING FILL MATERIAL.
13. LAY AND JOINT ALL PIPES IN ACCORDANCE WITH THE MANUFACTURERS RECOMMENDATIONS AND:
- AS 3725-1989 LOADS ON BURIED CONCRETE PIPES
- AS 2566-1998 BURIED FLEXIBLE PIPELINES
- AS/NZ S3500.3-2018 PRECAST REINFORCED CONCRETE BOX CULVERTS.
- AS 3500-1990 NATIONAL PLUMBING & DRAINAGE CODE.
- PART 2, SANITARY PLUMBING AND SANITARY DRAINAGE.
- SYDNEY WATER REQUIREMENTS.
- GEORGES RIVER COUNCIL REQUIREMENTS
14. ALLOW TO TEST ALL PIPES AND PITS TO MANUFACTURERS REQUIREMENTS.

CONCRETE WORKS

1. ALL WORKMANSHIP AND MATERIALS SHALL BE IN ACCORDANCE WITH AS/NZ S3500, THE STANDARDS ASSOCIATION AUSTRALIA, STANDARDS CITED IN AS3600, THE DRAWINGS AND THE SPECIFICATION
2. ALL CONCRETE SHALL BE 80mm NOMINAL SLUMP, 20mm MAXIMUM AGGREGATE WITH NO ADMIXTURES OR FLY ASH, UNLESS OTHERWISE APPROVED.
- ALL CONCRETE WORK IN CONTACT WITH STORMWATER TO HAVE TYPE SL PORTLAND CEMENT, OTHERWISE TYPE A CEMENT.
- FOR BRIDGE WORKS, A MAXIMUM 56 DAYS SHRINKAGE OF 600 MICROSTRAIN, A MINIMUM CEMENT CONTENT 350kg/m3 AND MAXIMUM WATER:CEMENT RATIO OF 0.40
3. STRENGTH GRADE OF CONCRETE SHALL BE:
- 25 MPa (KERBS, EDGE STRIPS & CONCRETE ENCASEMENT) AND 32 MPa ELSEWHERE.
4. CONSTRUCTION JOINTS SHALL BE PROPERLY FORMED AND USED ONLY WHERE SHOWN OR APPROVED. GENERALLY FOR HAND PLACED KERB & GUTTER 6mm THICK APPROVED BITUMINOUS MASTIC JOINTING MATERIAL SHALL BE PROVIDED AT INTERVALS NOT EXCEEDING 6m. FOR MACHINE PLACED KERB & GUTTER 6mm THICK APPROVED BITUMINOUS MASTIC JOINTING MATERIAL SHALL BE PROVIDED AT INTERVALS NOT EXCEEDING 12m & GUILLOTINED DUMMY GROOVED JOINTS, 25mm IN DEPTH, SHALL BE FORMED EVERY 3m OF GUTTER. JOINTS ARE ALSO REQUIRED AT EACH END OF GUTTER CROSSING AND GULLY PITS. JOINTS SHALL BE SET VERTICAL AND SQUARE TO THE KERB.
5. REINFORCEMENT IS REPRESENTED DIAGRAMMATICALLY AND IS NOT NECESSARILY SHOWN IN TRUE PROJECTION.
6. WELDING OR SPLICES IN REINFORCEMENT SHALL BE USED ONLY IN POSITIONS APPROVED BY THE ENGINEER.
7. CONCRETE CURING SHALL BE IN ACCORDANCE WITH AS3600. CURING SHALL BE COMMENCED WITHIN TWO HOURS OF FINISHING OPERATIONS AND SHALL BE CONTINUED FOR A MINIMUM OF SEVEN DAYS BY AN APPROVED PROPRIETARY COMPOUND OR BY KEEPING CONTINUOUSLY WET.
8. FORMWORK SHALL BE DESIGNED AND CONSTRUCTED IN ACCORDANCE WITH AS3610. FORMWORK SHALL NOT BE STRIPPED NOR PROPS REMOVED WITHOUT APPROVAL.
9. FABRIC LAP DETAILS SHALL BE IN ACCORDANCE WITH FIG.13.2.4 OFAS3600.
10. HOOKS, LAPS AND BENDS SHALL BE IN ACCORDANCE WITH AS3600 UNO.
11. ALL CHEMICAL ANCHORS SHALL BE EITHER "CHEMSET" BY "RAMSET" WITH THE GLASS CAPSULE SYSTEM INSTALLED IN STRICT ACCORDANCE WITH MANUFACTURERS INSTRUCTIONS OR HILTI HVU ADHESIVE ANCHOR WITH FOIL CAPSULE SYSTEM INSTALLED IN STRICT ACCORDANCE WITH MANUFACTURERS INSTRUCTION. ALL CHEMICAL ANCHORS SHALL BE HOT DIPPED GALVANIZED AND BE MIN M16 DIA. U.N.O.

GENERAL EARTHWORKS, SITEWORKS & FILLING:

FILLING:

THESE CLAUSES SHALL BE READ IN CONJUNCTION WITH "GEOTECHNICAL INVESTIGATION" PREPARED BY: CROZIER GEOTECHNICAL CONSULTANTS

REPORT No: 2020 - 132

DATED: JULY 2020

1. THE RECOMMENDATIONS CONTAINED IN THE GEOTECH REPORT SHALL OVERRIDE THE CLAUSES PRESENTED HEREIN.
2. STRIP ALL TOPSOIL AND UNDERLYING FILL AND STOCKPILE TOPSOIL FOR LATER REUSE FOR LANDSCAPING PURPOSES.
3. NEW FILL REQUIRED TO REINSTATE CUT LEVELS TO PROPOSED BENCHING LEVELS SHALL BE SOURCED FROM OTHER PARTS OF THE EXCAVATION AS SELECT FILL OR IMPORTED FILL AS SPECIFIED BELOW IN NOTES 5 AND 6.
4. SELECT FILL SHALL CONSIST OF LOCALLY DERIVED OR CUT NATURAL CLAYS.
5. IMPORTED FILL SHALL CONSIST OF RIPPED SANDSTONE OR SHALE OR SIMILAR MATERIAL WITH MAXIMUM PARTICLE SIZE NOT GREATER THAN 120mm AND A MOISTURE CONTENT WITHIN 2-3% OF STANDARD OPTIMUM.
6. ALL FILL (COHESIVE SOIL) SHALL BE PLACED IN LAYERS OF 200mm MAXIMUM THICKNESS, COMPACTED BY MACHINE ROLLING TO ACHIEVE A DRY DENSITY RATIO OF NOT LESS THAN 98% STANDARD MAXIMUM AT A CORRESPONDING MOISTURE CONTENT WITHIN 2-3% OF STANDARD OPTIMUM.
7. IN AREAS WHERE HIGH IMPACT ROLLING IS USED TEST EACH FINAL LAYER OF NOT GREATER THAN 300mm TO 400mm TO ACHIEVE A DRY DENSITY RATIO OF NOT LESS THAN 98% STANDARD MAXIMUM AT A CORRESPONDING MOISTURE CONTENT WITHIN 2-3% OF STANDARD OPTIMUM.

EXCAVATION BATTERS:

8. ALL TEMPORARY BATTERS CUT IN CLAY SUBSTRATE SHALL BE 1 HORIZ : 1 VERT. ALL LONG TERM EXPOSED BATTERS CUT IN CLAY SUBSTRATE SHALL BE 2 HORIZ : 1 VERT. ALL DETENTION BASIN BATTERS IN CLAY SUBSTRATE SHALL BE 3 HORIZ : 1 VERT. ALL DETENTION BASIN BATTERS IN ROCK SUBSTRATE SHALL BE NEAR VERTICAL.
9. GEOTECHNICAL TESTING IS TO BE UNDERTAKEN TO AT LEAST LEVEL 1 CONTROL OF FILL COMPACTION STANDARD, AS DEFINED IN AS. 3738 AS FOLLOWS:
- FOR GENERAL FILL OR CUT AREAS OVER THE AREA PROVIDE ONE (1) TEST PER 200mm LAYER, OVER AN AREA NOT GREATER THAN 500 m².
- FOR GENERAL FILL AREAS IN CONCENTRATED AREAS ADJACENT TO AND BEHIND THE STRUCTURE AND ADJACENT TO AND BEHIND RETAINING WALLS PROVIDE ONE (1) TEST PER 200mm LAYER, OVER AN AREA NOT GREATER THAN 50m².
10. SUBMIT ALL GEOTECHNICAL TEST RESULTS TO LP CONSULTING AUSTRALIA FOR REVIEW PRIOR TO CONTINUATION WITH SUBSEQUENT SECTION OF WORK.

EARTHWORKS FOR SERVICES

1. EXCAVATE TRENCHES AND STOCKPILE ALL MATERIAL FOR INSPECTION WITH REGARD TO RE-USE FOR TRENCH BACKFILL. REMAINING MATERIAL TO BE REMOVED FROM SITE.
2. BEDDING MATERIAL SHALL CONSIST OF IMPORTED FILL ONLY. THICKNESS OF BEDDING LAYER SHALL BE 75mm IN O.T.R. AND 200mm IN ROCK.
3. EMBED ALL PIPES WITH IMPORTED FILL. PROVIDE 200mm SIDE SUPPORT AND 150mm OVERLAY ABOVE PIPE CROWN.
4. TRENCH FILL ABOVE THE EMBEDMENT ZONE TO THE UNDERSIDE OF THE ROAD PAVEMENT OR FOOTWAY FILL. MATERIAL SHALL BE AS FOLLOWS :

UNDER ROADWAY:

TRENCH FILL MATERIAL SHALL CONSIST OF IMPORTED FILL AS SPECIFIED HEREIN OF EITHER HIGH GRADE COMPACTION SAND OR APPROVED CRUSHED ROAD GRAVEL CONFORMING TO RTA FORM 3051 OR SIMILAR.

OTHER THAN ROADWAY:

TRENCH FILL MATERIAL EXCAVATED SHALL CONSIST OF SELECT FILL AS SPECIFIED HEREIN AND SHALL NOT CONTAIN MORE THAN 20% OF STONES OF SIZE BETWEEN 75mm & 150mm AND NONE LARGER THAN 150mm. PRIOR TO THE USE OF THE EXCAVATED MATERIAL IT SHALL BE INSPECTED AND APPROVED BY THE CONSULTANT.

5. COMPACT BEDDING, EMBEDMENT AND TRENCH FILL MATERIALS AS FOLLOWS:

EMBEDMENT:-

FOR GRANULAR FILL MATERIAL (NON-COHESIVE SOILS) EG. COARSE AGGREGATE FILL, HIGH GRADE COMPACTION SAND, THE DENSITY INDEX (ID) SHALL BE NOT LESS THAN 70%.

TRENCH FILL:-

FOR GRANULAR MATERIAL (NON-COHESIVE SOILS), THE DENSITY INDEX (ID) SHALL BE NOT LESS THAN 70%.

FOR NON-GRANULAR FILL MATERIAL (COHESIVE SOILS), THE DRY DENSITY RATIO (RD) SHALL BE NOT LESS THAN 95%.

6. MEASURE OF COMPACTION:-

THE DEGREE OF COMPACTION SHALL BE MEASURED BY ONE OF THE FOLLOWING PARAMETERS :-

GRANULAR FILL (NON-COHESIVE SOILS). THE DENSITY INDEX (ID) DETERMINED IN ACCORDANCE WITH AS 1289.E6.1 BASED ON THE MAXIMUM AND MINIMUM DRY DENSITIES IN ACCORDANCE WITH AS 1289.E5.1 AND THE FIELD DRY DENSITY IN ACCORDANCE WITH AS 1289.5.3.2, AS 1289.E3.5 OR AS 1289.E8.1.

NON-GRANULAR FILL (COHESIVE SOILS). THE DRY DENSITY RATION (RD) DETERMINED IN ACCORDANCE WITH AS 1289.5.4.1 BASED ON THE FIELD DRY DENSITY IN ACCORDANCE WITH AS 1289.5.3.2 AND THE MAXIMUM DRY DENSITY IN ACCORDANCE WITH AS 1289.5.1.1.

7. GEOTECHNICAL TESTING IS TO BE UNDERTAKEN TO AT LEAST LEVEL 1 CONTROL OF FILL COMPACTION STANDARD, AS DEFINED IN AS. 3738 AS FOLLOWS:

TEST EACH 300mm LAYER ABOVE PIPE CROWN.

TEST BASE & SUB-BASE LAYERS WHERE APPLICABLE.

TESTS SHALL BE REQUIRED AT EACH 50m CENTRES WHERE THE LENGTH OF TRENCH IS WITHIN THE 50m REQUIREMENT.

8. SUBMIT ALL GEOTECHNICAL TEST RESULTS TO LP CONSULTING AUSTRALIA FOR REVIEW PRIOR TO CONTINUATION WITH SUBSEQUENT SECTION OF WORK.

RESTORATION

1. RESTORE ALL TRAFFIC AREAS TO PRE EXISTING CONDITION.
2. FOR ALL SURFACES OTHER THAN IN TRAFFIC AREAS RESTORE DISTURBED SURFACES TO PRE-EXISTING CONDITIONS AND COMPACT AS SPECIFIED.
3. RESTORE ALL AUTHORITY OWNED AREAS TO COUNCIL STANDARDS.

APPROVALS

1. THE AS CONSTRUCTED WORKS SHALL BE INSPECTED BY DESIGN CONSULTANT. MINIMUM 48 HOURS NOTICE SHALL APPLY TO ALL INSPECTIONS.
2. THE DESIGN PLANS HEREIN ARE SUBJECT TO COUNCIL APPROVAL PRIOR TO CONSTRUCTION. OBTAIN EXPRESS (WRITTEN) ADVICE TO PROCEED FROM PROJECT MANAGER PRIOR TO COMMENCEMENT.
3. SUBMIT WORK-AS-EXECUTED DRAWINGS IN CIVILCAD OR DXF DIGITAL FORMAT AND HARD COPY FORMAT. VERIFY ALL CONSTRUCTION WORKS SHOWN HEREON.
4. CERTIFY THAT THE AS CONSTRUCTED SYSTEM HAS BEEN BUILT IN ACCORDANCE WITH THE APPROVED PLANS ISSUED FOR CONSTRUCTION.


SERVICES UNDER ROAD SURFACES

1. ALL OTHER SERVICES INCLUDING BUT NOT LIMITED TO WATER, HYDRANT, GAS, SEWER, ELECTRICAL AND COMMUNICATIONS CONDUITS OR CABLES SHALL BE LAID WITH MINIMUM 600mm U.N.O. COVER BELOW PROPOSED ROAD SURFACE OR APPROVED OTHER MEANS TO PROTECT DURING CONSTRUCTION.

HYDRAULIC SERVICES

1. ALL WORKS CARRIED OUT SHALL COMPLY WITH AS/NZ S3500, SYDNEY WATER & COUNCIL REQUIREMENTS. OBTAIN NECESSARY AUTHORITIES APPROVALS PRIOR TO COMMENCING WORKS.
2. PRIOR TO COMMENCING WORKS SURVEY & INSPECT SITE & CONFIRM LOCATION & LEVELS OF ALL HYDRAULIC SERVICES PIPEWORK. NO CLAIMS FOR ADDITIONAL COSTS RESULTING FROM THE LACK OF KNOWLEDGE OF SITE CONDITIONS RELATING TO WORKS TO BE DONE OR LOCATIONS AND LEVELS OF EXISTING AND NEW SERVICES WILL BE ACCEPTED.
3. PRIOR TO CAPPING OFF & REMOVAL OF REDUNDANT SERVICES CONFIRM ON SITE THAT SERVICE IS NOT SUPPLYING EXISTING BUILDINGS OR AMENITIES.
4. COLD WATER PIPEWORK SHALL CONSIST OF COPPER TUBE & FITTINGS IN ACCORDANCE WITH AS 1432 TYPE B. PIPES AND FITTINGS SHALL BE JOINTED WITH 15% SILVER SOLDER.
5. ALL NEW UNDERGROUND METAL PIPEWORK SHALL BE INSTALLED WITH POLYETHYLENE SLEEVING OBTAINED FROM "TYCO WATER AUST" AND INSTALLED TO MANUFACTURE'S REQUIREMENTS.
6. LANDSCAPE IRRIGATION WATERING PIPEWORK SHALL CONSIST OF MEDIUM DENSITY POLYETHYLENE PIPE CLASS PN16 WITH ELECTRO FUSION JOINTS OR EQUAL TO EXISTING PIPEWORK.

DO NOT SCALE FROM DRAWINGS, CHECK & VERIFY ALL DIMENSIONS & LEVELS BEFORE COMMENCEMENT OF ANY WORK.	NORTH POINT	NOTES 1. REFER TO DRAWING DA-STW-002 FOR DRAWING LIST. 2. CONTRACTOR TO CHECK AND CONFIRM ALL LEVELS ON SITE. 3. CONTRACTOR TO INVESTIGATE ALL EXISTING SERVICES, SUCH AS APPLY FOR "DIAL BEFORE YOU DIG" SERVICES PRIOR TO START OF WORKS ON SITE.	ISSUE A B C	AMENDMENT DEVELOPMENT APPLICATION - ISSUE FOR COORDINATION ISSUE FOR DEVELOPMENT APPLICATION ISSUE FOR SSDA	DATE 30.09.2020 16.10.2020 11.11.2020	PROJECT ROYAL INSTITUTE FOR DEAF & BLIND CHILDREN MACQUARIE UNIVERSITY	PROJECT MANAGER M PROJECTS Suite C2.08, Level 2 22-36 Mountain Street, Ultimo NSW 2007 Tel: (02) 9262 5530 Fax: (02) 9262 5529 Web: mprojects.com.au	CLIENT Royal Institute for Deaf and Blind Children	CONSULTANT LP CONSULTING AUSTRALIA PTY LTD A: Suite 12.01, Level 12, 300 George Street Sydney NSW Australia 2000 P: GPO Box 2662 Sydney NSW 2001 E: info@lp-consulting.com.au T: +61 (2) 9223 4444 W: www.lp-consulting.com.au	TITLE STORMWATER DRAINAGE GENERAL NOTES	
						ARCHITECT WMK Architecture L2 364 Kent Street Sydney NSW 2000 Tel: (02) 9262 5530 Fax: (02) 9262 5529 Web: mprojects.com.au					
						THIS DRAWING IS NOT TO BE COPIED IN PART OR WHOLE WITHOUT WRITTEN PERMISSION FROM LP CONSULTING AUSTRALIA PTY LTD	SHEET SIZE: A1				

 


TITLE STORMWATER DRAINAGE SURVEY PLAN SERVICES LAYOUT - SHEET 3					
SCALE	1: 200 & A1 1: 400 @ A3	DRAWN RMW	DESIGNED LP	CHECKED LP	APPROVED
DATE	Nov 11, 2020	DRAWING No.		ISSUE	
JOB No.	DA - STW - 006			C	
2020-1773	STATE SIGN. DA				

REFER DRG DA - STW - 006_SHEET 3 & DA - STW - 005_SHEET 2 FOR CONTINUATION




REFER DRG DA - STW - 008_SHEET 5 FOR CONTINUATION

DO NOT SCALE FROM DRAWINGS, CHECK & VERIFY ALL DIMENSIONS & LEVELS BEFORE COMMENCEMENT OF ANY WORK.	DO NOT SCALE FROM DRAWINGS, CHECK & VERIFY ALL DIMENSIONS & LEVELS BEFORE COMMENCEMENT OF ANY WORK.  SHEET SIZE: A1	NOTES 1. REFER TO DRAWING DA-STW-002 FOR DRAWING LIST. 2. CONTRACTOR TO CHECK AND CONFIRM ALL LEVELS ON SITE. 3. CONTRACTOR TO INVESTIGATE ALL EXISTING SERVICES, SUCH AS APPLY FOR "DIAL BEFORE YOU DIG" SERVICES PRIOR TO START OF WORKS ON SITE.	ISSUE	AMENDMENT	DATE	PROJECT	PROJECT MANAGER	CLIENT	CONSULTANT	TITLE
			A B C	DEVELOPMENT APPLICATION - ISSUE FOR COORDINATION ISSUE FOR DEVELOPMENT APPLICATION ISSUE FOR SSDA	30.09.2020 16.10.2020 11.11.2020	ROYAL INSTITUTE FOR DEAF & BLIND CHILDREN MACQUARIE UNIVERSITY	ARCHITECT  WMK Architecture L2 364 Kent Street Sydney NSW 2000 Tel: (02) 9262 5530 Fax: (02) 9262 5529 Web: mprojects.com.au	 M PROJECTS Suite C2.08, Level 2 22-36 Mountain Street, Ultimo NSW 2007 Tel: (02) 9262 5530 Web: mprojects.com.au	 Royal Institute for Deaf and Blind Children	 LP CONSULTING AUSTRALIA PTY LTD A: Suite 12.01, Level 12, 300 George Street Sydney NSW Australia 2000 P: GPO Box 2662 Sydney NSW 2001 E: info@lp-consulting.com.au T: +61 (2) 9223 4444 www.lp-consulting.com.au

 


DO NOT SCALE FROM DRAWINGS, CHECK & VERIFY ALL DIMENSIONS & LEVELS BEFORE COMMENCEMENT OF ANY WORK. THIS DRAWING IS NOT TO BE COPIED IN PART OR WHOLE WITHOUT WRITTEN PERMISSION FROM LP CONSULTING AUSTRALIA PTY LTD	NORTH POINT  SHEET SIZE: A1	NOTES 1. REFER TO DRAWING DA-STW-002 FOR DRAWING LIST. 2. CONTRACTOR TO CHECK AND CONFIRM ALL LEVELS ON SITE. 3. CONTRACTOR TO INVESTIGATE ALL EXISTING SERVICES, SUCH AS APPLY FOR "DIAL BEFORE YOU DIG" SERVICES PRIOR TO START OF WORKS ON SITE.	<table><tr><th>ISSUE</th><th>AMENDMENT</th><th>DATE</th></tr><tr><td>A</td><td>DEVELOPMENT APPLICATION - ISSUE FOR COORDINATION</td><td>30.09.2020</td></tr><tr><td>B</td><td>ISSUE FOR DEVELOPMENT APPLICATION</td><td>16.10.2020</td></tr><tr><td>C</td><td>ISSUE FOR SSDA</td><td>11.11.2020</td></tr></table>	ISSUE	AMENDMENT	DATE	A	DEVELOPMENT APPLICATION - ISSUE FOR COORDINATION	30.09.2020	B	ISSUE FOR DEVELOPMENT APPLICATION	16.10.2020	C	ISSUE FOR SSDA	11.11.2020	PROJECT ROYAL INSTITUTE FOR DEAF & BLIND CHILDREN MACQUARIE UNIVERSITY ARCHITECT WMK WMK Architecture L2 364 Kent Street Sydney NSW 2000	PROJECT MANAGER m M PROJECTS Suite C2.08, Level 2 22-36 Mountain Street, Ultimo NSW 2007 Tel: (02) 9262 5530 Fax: (02) 9262 5529 Web: mprojects.com.au	CLIENT  Royal Institute for Deaf and Blind Children	CONSULTANT  LP CONSULTING AUSTRALIA PTY LTD A: Suite 12.01, Level 12, 300 George Street Sydney NSW Australia 2000 P: GPO Box 2662 Sydney NSW 2001 E: info@lp-consulting.com.au T: +61 (2) 9223 4444	<table><tr><td colspan="5">TITLE</td></tr><tr><td colspan="5">STORMWATER DRAINAGE UTILITY SERVICES PLAN SHEET - 2</td></tr><tr><td>SCALE</td><td>1: 100 @ A1 1: 200 @ A3</td><td>DRAWN WW</td><td>DESIGNED LP</td><td>CHECKED LP</td><td>APPROVED</td></tr><tr><td>DATE</td><td>Nov 11, 2020</td><td colspan="2">DRAWING No. DA - STW - 010</td><td colspan="2">ISSUE C</td></tr><tr><td>JOB No.</td><td>2020-1773</td><td colspan="4">STATE SIGN. DA</td></tr></table>	TITLE					STORMWATER DRAINAGE UTILITY SERVICES PLAN SHEET - 2					SCALE	1: 100 @ A1 1: 200 @ A3	DRAWN WW	DESIGNED LP	CHECKED LP	APPROVED	DATE	Nov 11, 2020	DRAWING No. DA - STW - 010		ISSUE C		JOB No.	2020-1773	STATE SIGN. DA			
ISSUE	AMENDMENT	DATE																																														
A	DEVELOPMENT APPLICATION - ISSUE FOR COORDINATION	30.09.2020																																														
B	ISSUE FOR DEVELOPMENT APPLICATION	16.10.2020																																														
C	ISSUE FOR SSDA	11.11.2020																																														
TITLE																																																
STORMWATER DRAINAGE UTILITY SERVICES PLAN SHEET - 2																																																
SCALE	1: 100 @ A1 1: 200 @ A3	DRAWN WW	DESIGNED LP	CHECKED LP	APPROVED																																											
DATE	Nov 11, 2020	DRAWING No. DA - STW - 010		ISSUE C																																												
JOB No.	2020-1773	STATE SIGN. DA																																														

X:\04-2020\1773_XANTHUS\1773-010_SHEET 4 - STW - 010_SHEET 4 FOR CONTINUATION.dwg
PLOT Date: 11/11/2020 15:46:55 User: M. H. H. Cad File: 2-Proposed\2021\1773\DRAWINGS\DRAWINGS - WORKING\STORMWATER\1773-010_SHEET 4.dwg

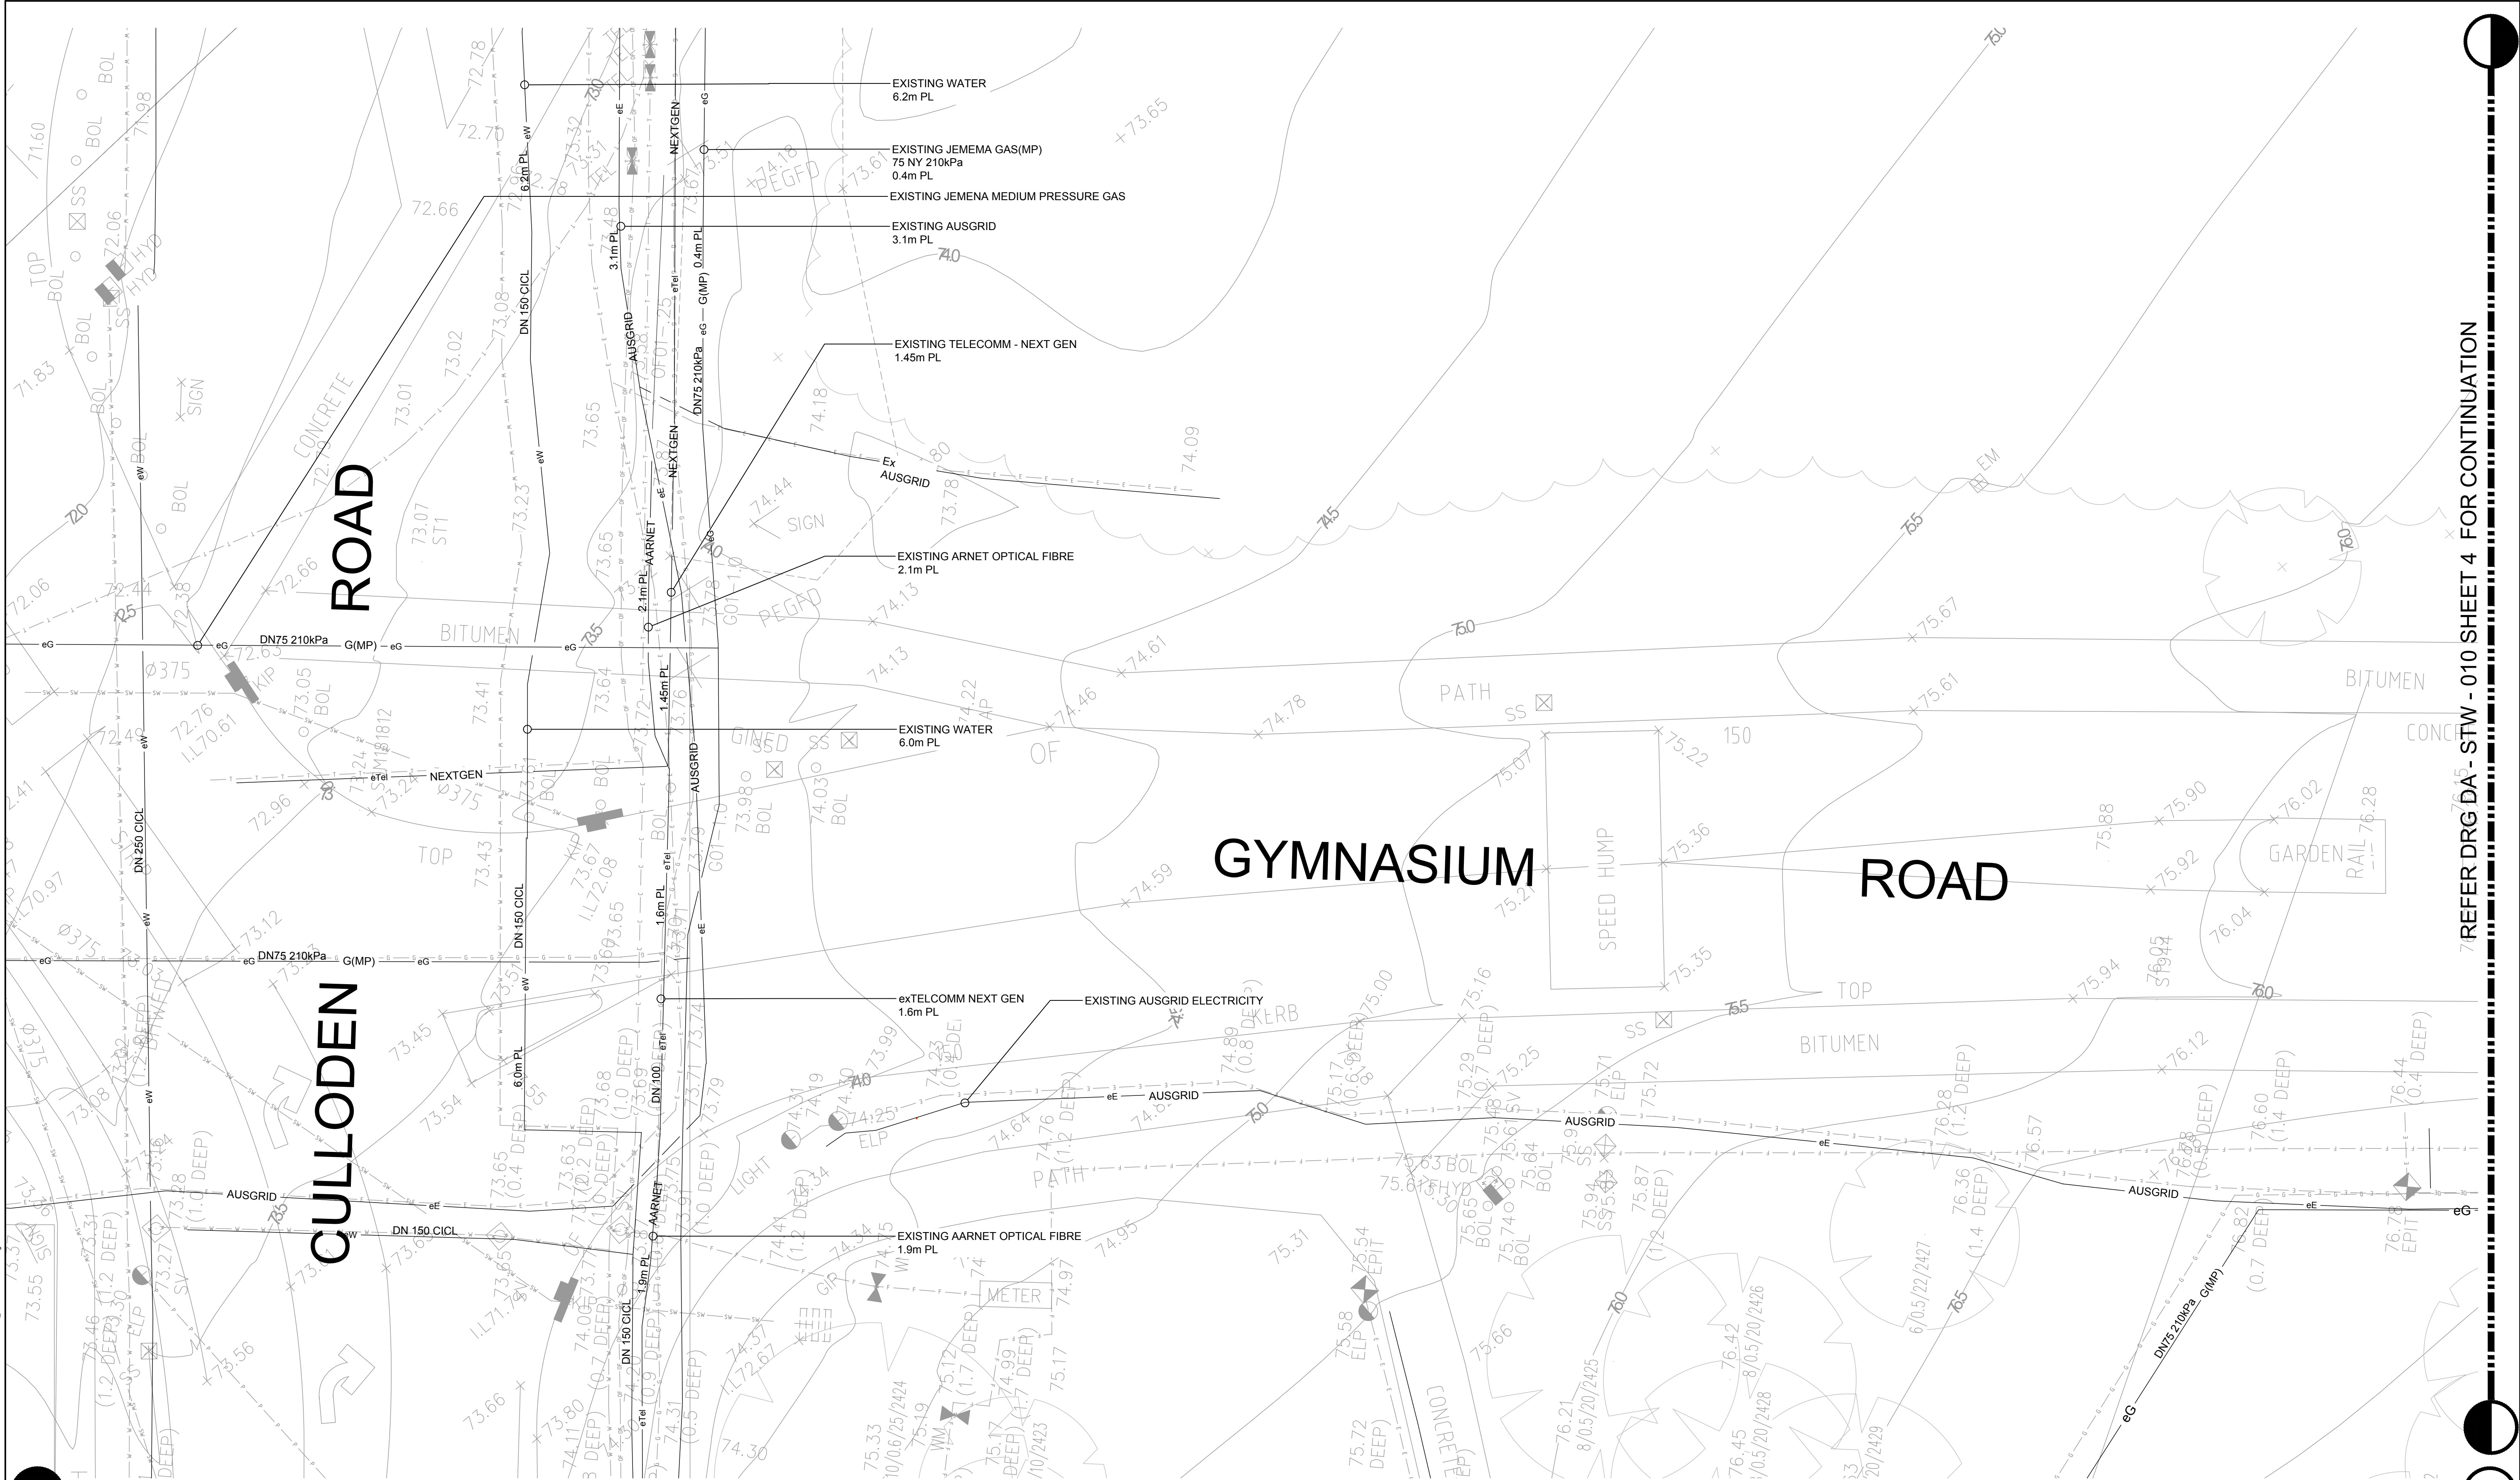

 REFER DRG DA - STW - 008 SHEET 2 FOR CONTINUATION




DO NOT SCALE FROM DRAWINGS. CHECK & VERIFY ALL DIMENSIONS & LEVELS BEFORE COMMENCEMENT OF ANY WORK. THIS DRAWING IS NOT TO BE COPIED IN PART OR WHOLE WITHOUT WRITTEN PERMISSION FROM LP CONSULTING AUSTRALIA PTY LTD	NORTH POINT  SHEET SIZE: A1	NOTES 1. REFER TO DRAWING DA-STW-002 FOR DRAWING LIST. 2. CONTRACTOR TO CHECK AND CONFIRM ALL LEVELS ON SITE. 3. CONTRACTOR TO INVESTIGATE ALL EXISTING SERVICES, SUCH AS APPLY FOR "DIAL BEFORE YOU DIG" SERVICES PRIOR TO START OF WORKS ON SITE.	ISSUE A B C	AMENDMENT DEVELOPMENT APPLICATION - ISSUE FOR COORDINATION ISSUE FOR DEVELOPMENT APPLICATION ISSUE FOR SSDA	DATE 30.09.2020 16.10.2020 11.11.2020	PROJECT ROYAL INSTITUTE FOR DEAF & BLIND CHILDREN MACQUARIE UNIVERSITY	PROJECT MANAGER  M PROJECTS Suite C2.08, Level 2 22-36 Mountain Street, Ultimo NSW 2007	CLIENT  Royal Institute for Deaf and Blind Children	CONSULTANT  LP CONSULTING — AUSTRALIA PTY LTD A: Suite 12.01, Level 12, 300 George Street Sydney NSW Australia 2000 P: GPO Box 2662 Sydney NSW 2001 E: info@lp-consulting.com.au T: +61 (2) 9223 4444 W: www.lp-consulting.com.au	TITLE STORMWATER DRAINAGE UTILITY SERVICES PLAN SHEET - 3
	ARCHITECT  WMK Architecture L2 364 Kent Street Sydney NSW 2000 Tel: (02) 9262 5530 Fax: (02) 9262 5529 Web: mprojects.com.au			SCALE 1:100 @ A1 1:200 @ A3	DRAWN VVW	DESIGNED LP	CHECKED LP	APPROVED		
				DATE Nov 11, 2020	DRAWING No. DA - STW - 011	ISSUE C				
				JOB No. 2020-1773	STATE SIGN. DA					



DO NOT SCALE FROM DRAWINGS, CHECK & VERIFY ALL DIMENSIONS & LEVELS BEFORE COMMENCEMENT OF ANY WORK. THIS DRAWING IS NOT TO BE COPIED IN PART OR WHOLE WITHOUT WRITTEN PERMISSION FROM LP CONSULTING AUSTRALIA PTY LTD	NORTH POINT  SHEET SIZE: A1	NOTES 1. REFER TO DRAWING DA-STW-002 FOR DRAWING LIST. 2. CONTRACTOR TO CHECK AND CONFIRM ALL LEVELS ON SITE. 3. CONTRACTOR TO INVESTIGATE ALL EXISTING SERVICES, SUCH AS APPLY FOR "DIAL BEFORE YOU DIG" SERVICES PRIOR TO START OF WORKS ON SITE.	<table><tr><th>ISSUE</th><th>AMENDMENT</th><th>DATE</th></tr><tr><td>A</td><td>DEVELOPMENT APPLICATION - ISSUE FOR COORDINATION</td><td>30.09.2020</td></tr><tr><td>B</td><td>ISSUE FOR DEVELOPMENT APPLICATION</td><td>16.10.2020</td></tr><tr><td>C</td><td>ISSUE FOR SSDA</td><td>11.11.2020</td></tr></table>	ISSUE	AMENDMENT	DATE	A	DEVELOPMENT APPLICATION - ISSUE FOR COORDINATION	30.09.2020	B	ISSUE FOR DEVELOPMENT APPLICATION	16.10.2020	C	ISSUE FOR SSDA	11.11.2020	PROJECT ROYAL INSTITUTE FOR DEAF & BLIND CHILDREN MACQUARIE UNIVERSITY ARCHITECT WMK WMK Architecture L2 364 Kent Street Sydney NSW 2000 Tel: (02) 9262 5530 Fax: (02) 9262 5529 Web: mprojects.com.au	PROJECT MANAGER m M PROJECTS Suite C2.08, Level 2 22-36 Mountain Street, Ultimo NSW 2007 Tel: (02) 9262 5530 Fax: (02) 9262 5529 Web: mprojects.com.au	CLIENT  Royal Institute for Deaf and Blind Children	CONSULTANT  LP CONSULTING AUSTRALIA PTY LTD A: Suite 12.01, Level 12, 300 George Street Sydney NSW Australia 2000 P: GPO Box 2662 Sydney NSW 2001 E: info@lp-consulting.com.au T: +61 (2) 9223 4444 W: www.lp-consulting.com.au	<table><tr><th colspan="5">TITLE</th></tr><tr><th colspan="5">STORMWATER DRAINAGE UTILITY SERVICES PLAN SHEET - 4</th></tr><tr><th>SCALE</th><th>DRAWN</th><th>DESIGNED</th><th>CHECKED</th><th>APPROVED</th></tr><tr><td>1: 100 @ A1 1: 200 @ A3</td><td>WW</td><td>LP</td><td>LP</td><td></td></tr><tr><th>DATE</th><th>DRAWING No.</th><th colspan="3">ISSUE</th></tr><tr><td>Nov 11, 2020</td><td rowspan="2">DA - STW - 012</td><td colspan="3" rowspan="2">C</td></tr><tr><td>JOB No.</td></tr><tr><td>2020-1773</td><td colspan="4">STATE SIGN. DA</td></tr></table>	TITLE					STORMWATER DRAINAGE UTILITY SERVICES PLAN SHEET - 4					SCALE	DRAWN	DESIGNED	CHECKED	APPROVED	1: 100 @ A1 1: 200 @ A3	WW	LP	LP		DATE	DRAWING No.	ISSUE			Nov 11, 2020	DA - STW - 012	C			JOB No.	2020-1773	STATE SIGN. DA			
ISSUE	AMENDMENT	DATE																																																						
A	DEVELOPMENT APPLICATION - ISSUE FOR COORDINATION	30.09.2020																																																						
B	ISSUE FOR DEVELOPMENT APPLICATION	16.10.2020																																																						
C	ISSUE FOR SSDA	11.11.2020																																																						
TITLE																																																								
STORMWATER DRAINAGE UTILITY SERVICES PLAN SHEET - 4																																																								
SCALE	DRAWN	DESIGNED	CHECKED	APPROVED																																																				
1: 100 @ A1 1: 200 @ A3	WW	LP	LP																																																					
DATE	DRAWING No.	ISSUE																																																						
Nov 11, 2020	DA - STW - 012	C																																																						
JOB No.																																																								
2020-1773	STATE SIGN. DA																																																							


EROSION AND SEDIMENTATION CONTROL NOTES:

1. EROSION AND SEDIMENT CONTROL MEASURES ARE TO BE INSTALLED IN ACCORDANCE WITH THE PUBLICATION 'URBAN STORMWATER: SOILS AND CONSTRUCTION' 'THE BLUE BOOK' 2004 (4TH EDITION) PRIOR TO THE COMMENCEMENT OF ANY DEMOLITION, EXCAVATION OR CONSTRUCTION WORKS UPON THE SITE.
2. BUILDER SHALL PROVIDE SEDIMENT FENCING MATERIAL DURING CONSTRUCTION TO THE LOW SIDE BOUNDARIES. SEDIMENT CONTROL FABRIC SHALL BE AN APPROVED MATERIAL (Eg. PROFAB® SILT FENCE, OR SIMILAR) STANDING MINIMUM 500mm ABOVE GROUND AND EXTENDING 250mm BELOW GROUND.
3. GRASS VERGES AND VEGETATION SHALL BE MAINTAINED AS MUCH AS PRACTICAL AND SHALL NOT BE CLEARED FROM NEIGHBORING SITES TO PROVIDE A BUFFER ZONE TO THE CONSTRUCTION SITE.
4. NO PARKING OR STOCK PILING OF MATERIALS IS PERMITTED ON THE LOWER SIDE OF THE SEDIMENT FENCE.
5. VEHICLE ACCESS SHALL BE RESTRICTED TO ONE DESIGNATED POINT AS SHOWN, AND VEHICLE CROSSINGS ARE TO BE ADEQUATELY COVERED AT ALL TIMES WITH BLUE METAL OR THE LIKE.
6. TEMPORARY CONSTRUCTION ENTRY / EXIT SHALL BE AS PER DETAIL ON DWG DA-STW-016. BUILDER SHALL ENSURE ALL DROPPABLE SOIL AND SEDIMENT IS REMOVED PRIOR TO CONSTRUCTION TRAFFIC EXITING SITE USING VEHICLE WHEEL WASH, CATTLE GRID, WHEEL SHAKER OR OTHER APPROPRIATE DEVICE. BUILDER SHALL ENSURE ALL CONSTRUCTION TRAFFIC ENTERING AND LEAVING THE SITE, DO SO, IN A FORWARD DIRECTION.
7. ALL STORMWATER INCIDENT ON THE CONSTRUCTION SITE MUST BE COLLECTED AND APPROPRIATELY DISPOSED OF IN A MANNER THAT DOES NOT INCREASE THE FLOOD RISK FOR THE CATCHMENT AREA OR DEGRADE THE QUALITY OF WATER BEING DISPOSED OF TO COUNCIL STORMWATER INFRASTRUCTURE.

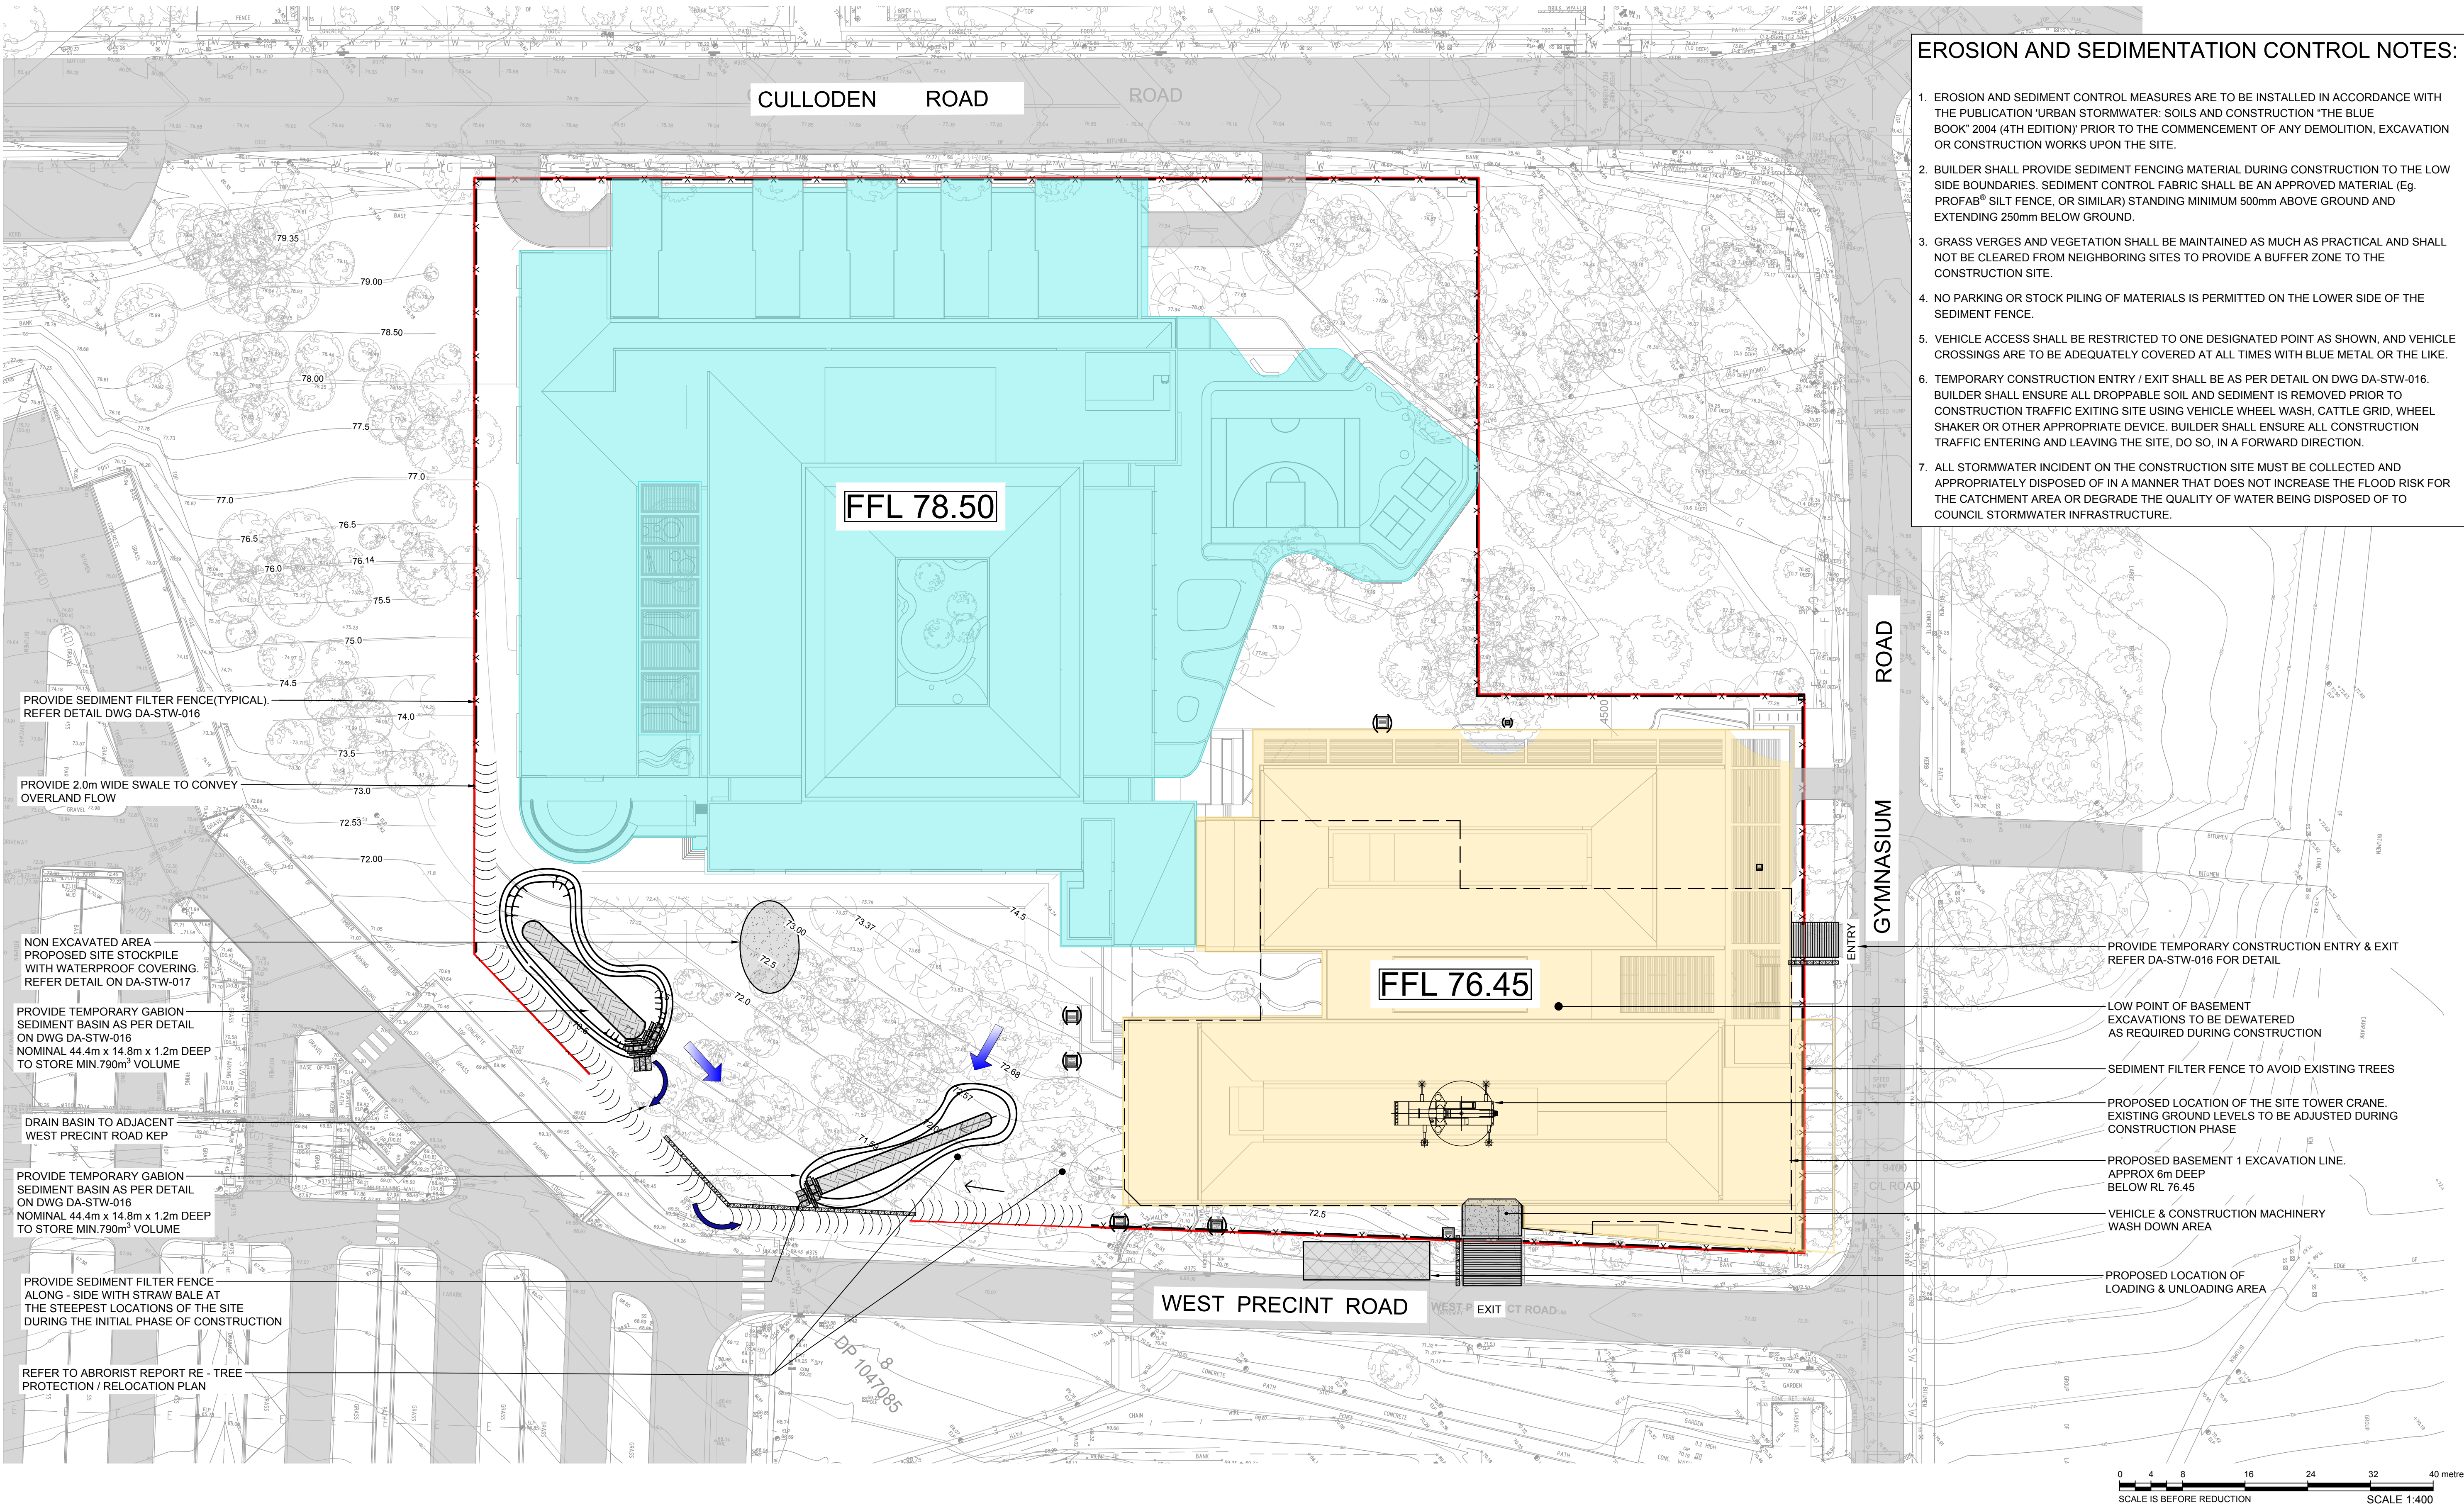


DO NOT SCALE FROM DRAWINGS, CHECK & VERIFY ALL DIMENSIONS & LEVELS BEFORE COMMENCEMENT OF ANY WORK.		TV MN	SHEET SIZE: A1	NOTES 1. REFER TO DRAWING DA-STW-002 FOR DRAWING LIST. 2. CONTRACTOR TO CHECK AND CONFIRM ALL LEVELS ON SITE. 3. CONTRACTOR TO INVESTIGATE ALL EXISTING SERVICES, SUCH AS APPLY FOR "DIAL BEFORE YOU DIG" SERVICES PRIOR TO START OF WORKS ON SITE.	ISSUE A B C	AMENDMENT DEVELOPMENT APPLICATION - ISSUE FOR COORDINATION ISSUE FOR DEVELOPMENT APPLICATION ISSUE FOR SSDA	DATE 30.09.2020 16.10.2020 11.11.2020	PROJECT ROYAL INSTITUTE FOR DEAF & BLIND CHILDREN MACQUARIE UNIVERSITY	PROJECT MANAGER m M PROJECTS Suite C2.08, Level 2 22-36 Mountain Street, Ultimo NSW 2007 Tel: (02) 9262 5530 Fax: (02) 9262 5529 Web: mprojects.com.au	CLIENT Royal Institute for Deaf and Blind Children	CONSULTANT LP CONSULTING AUSTRALIA PTY LTD A: Suite 12.01, Level 12, 300 George Street Sydney NSW Australia 2000 P: GPO Box 2662 Sydney NSW 2001 E: info@lp-consulting.com.au T: +61 (2) 9223 4444 W: www.lp-consulting.com.au	TITLE STORMWATER DRAINAGE EROSION & SEDIMENT CONTROL PLAN			
THIS DRAWING IS NOT TO BE COPIED IN PART OR WHOLE WITHOUT WRITTEN PERMISSION FROM LP CONSULTING AUSTRALIA PTY LTD								SCALE 1:400 @ A1 1:800 @ A3				DRAWN VVW	DESIGNED LP	CHECKED LP	APPROVED C
		DATE Nov 11, 2020	DRAWING No. DA - STW - 015		ISSUE C										
		JOB No. 2020-1773									STATE SIGN. DA				


X:\2020\1773_XS\SUB\CV\2020\1773_XS\SITE PLAN FOR CATCHMENT PLANS\2020\1773_XS\ASSET\EROSION & SEDIMENT CONTROL PLAN.DWG
Prel Date: 11.11.2020 14:45:56 Logon Name: Alana.Cad File: Z:\p\2020\1773_XS\DRAWINGS\2020\1773_XS\ASSET\EROSION & SEDIMENT CONTROL PLAN.DWG

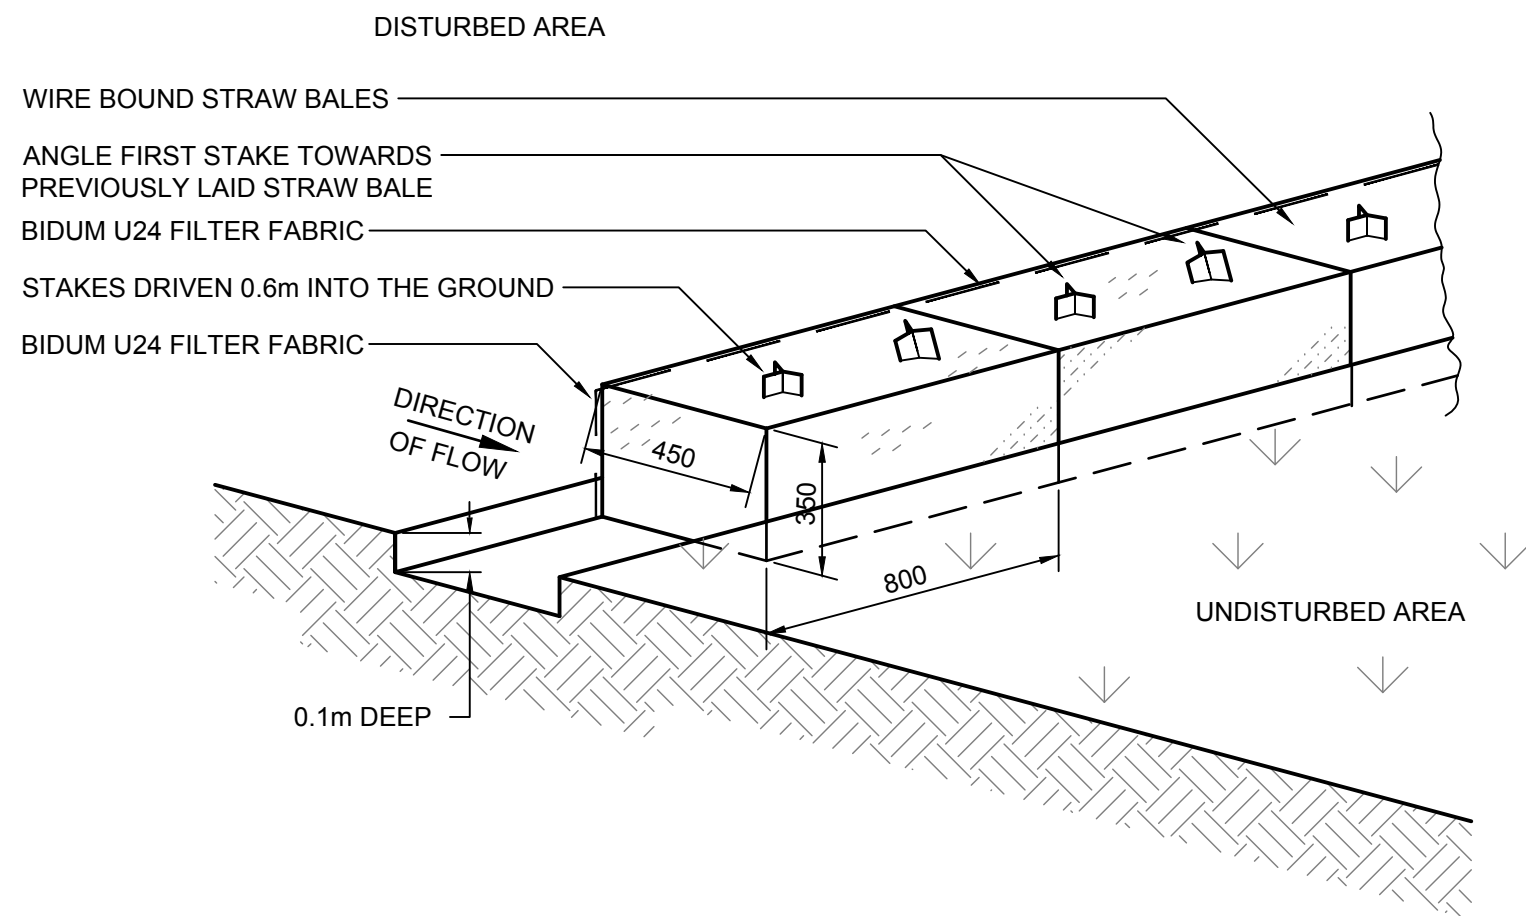


STRAW BALE SEDIMENT FILTER
N.T.S

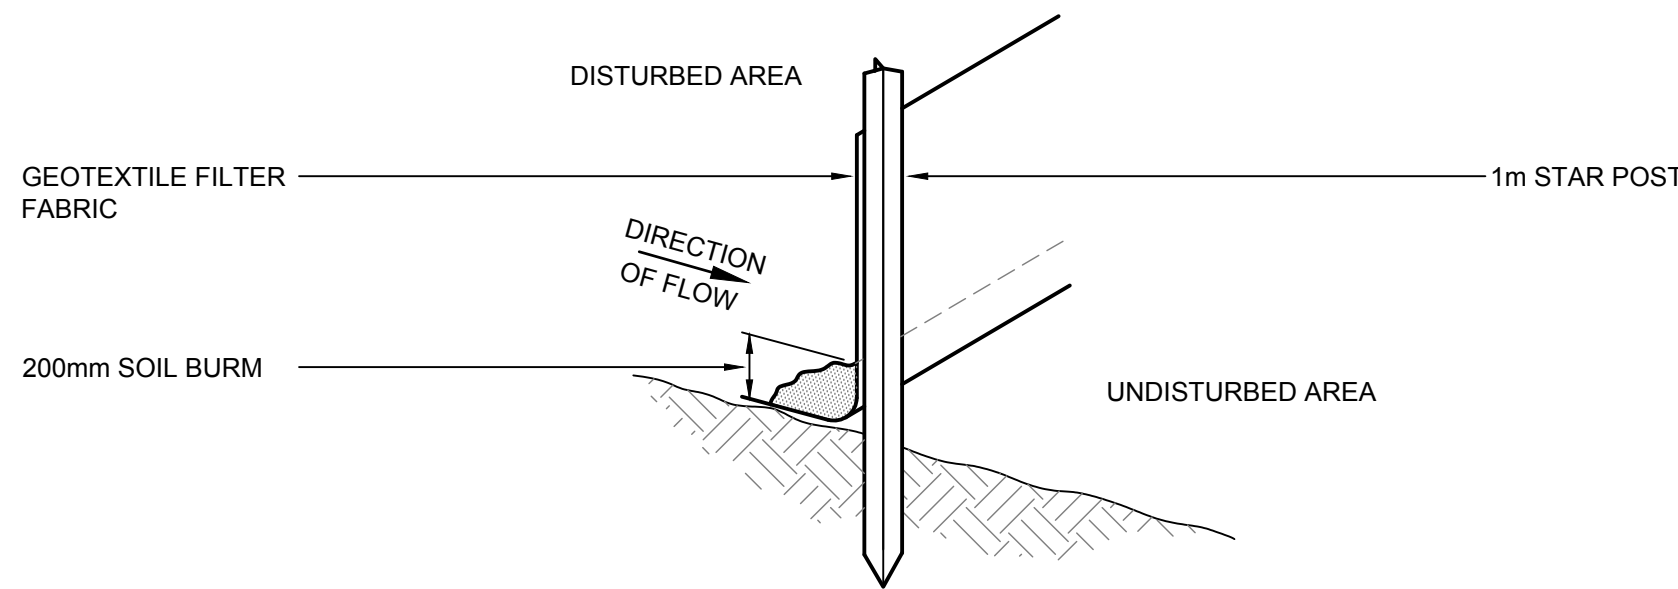


SEDIMENT FILTER FENCE
N.T.S

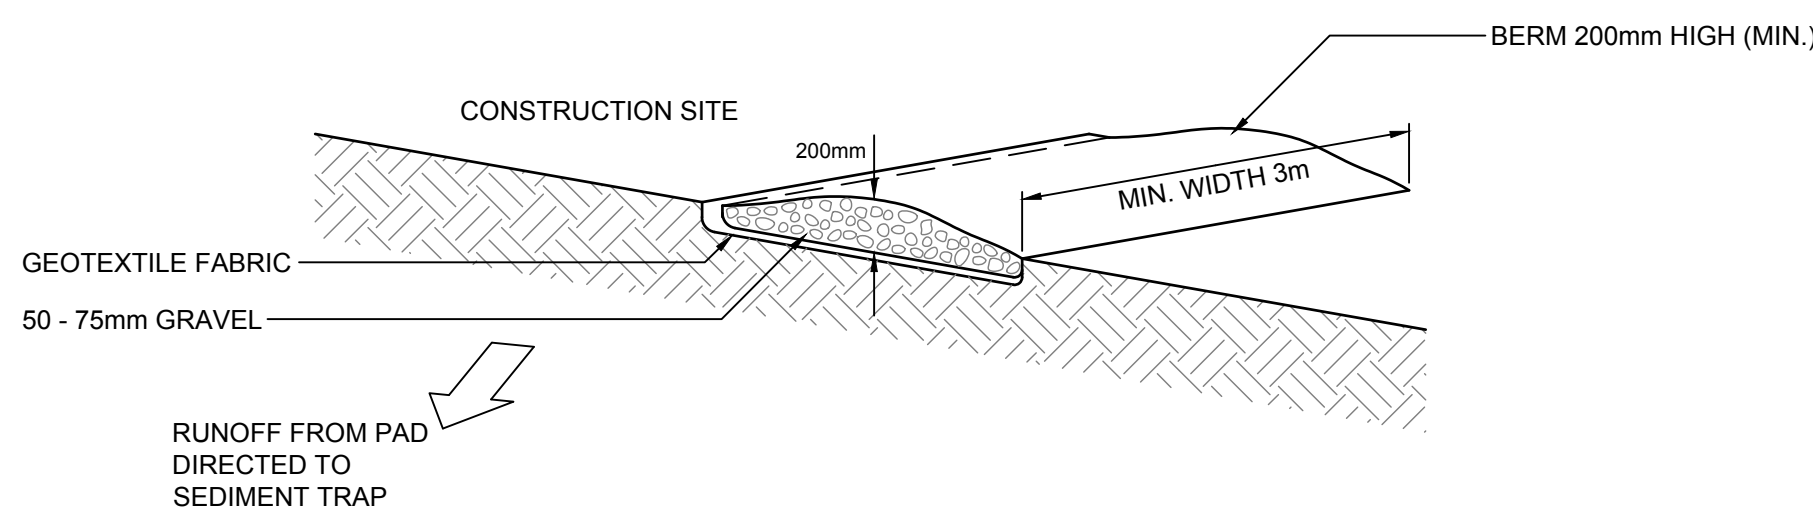



VEHICLE ACCESS TO SITE
N.T.S

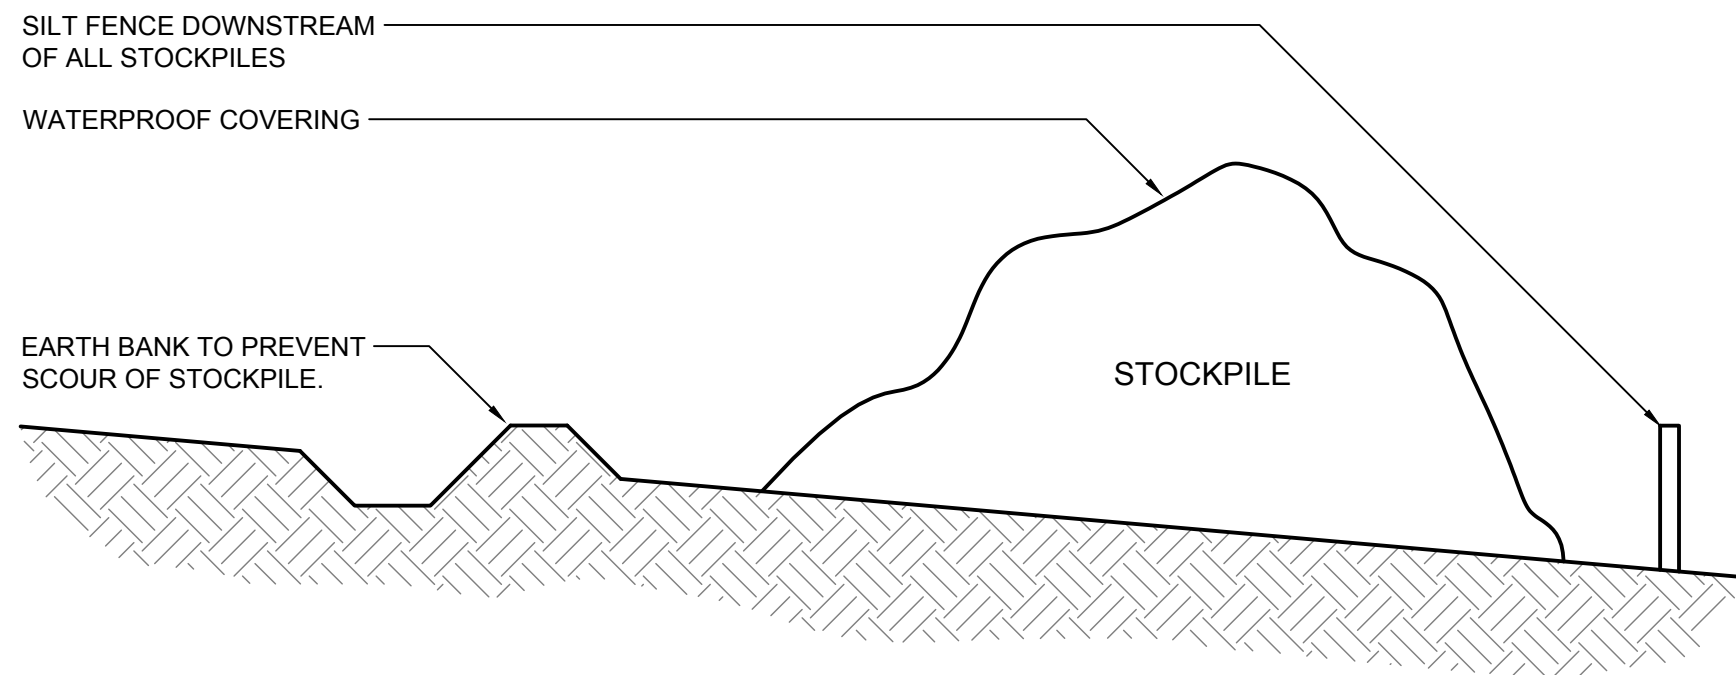

BUILDING MATERIALS STOCKPILE
N.T.S

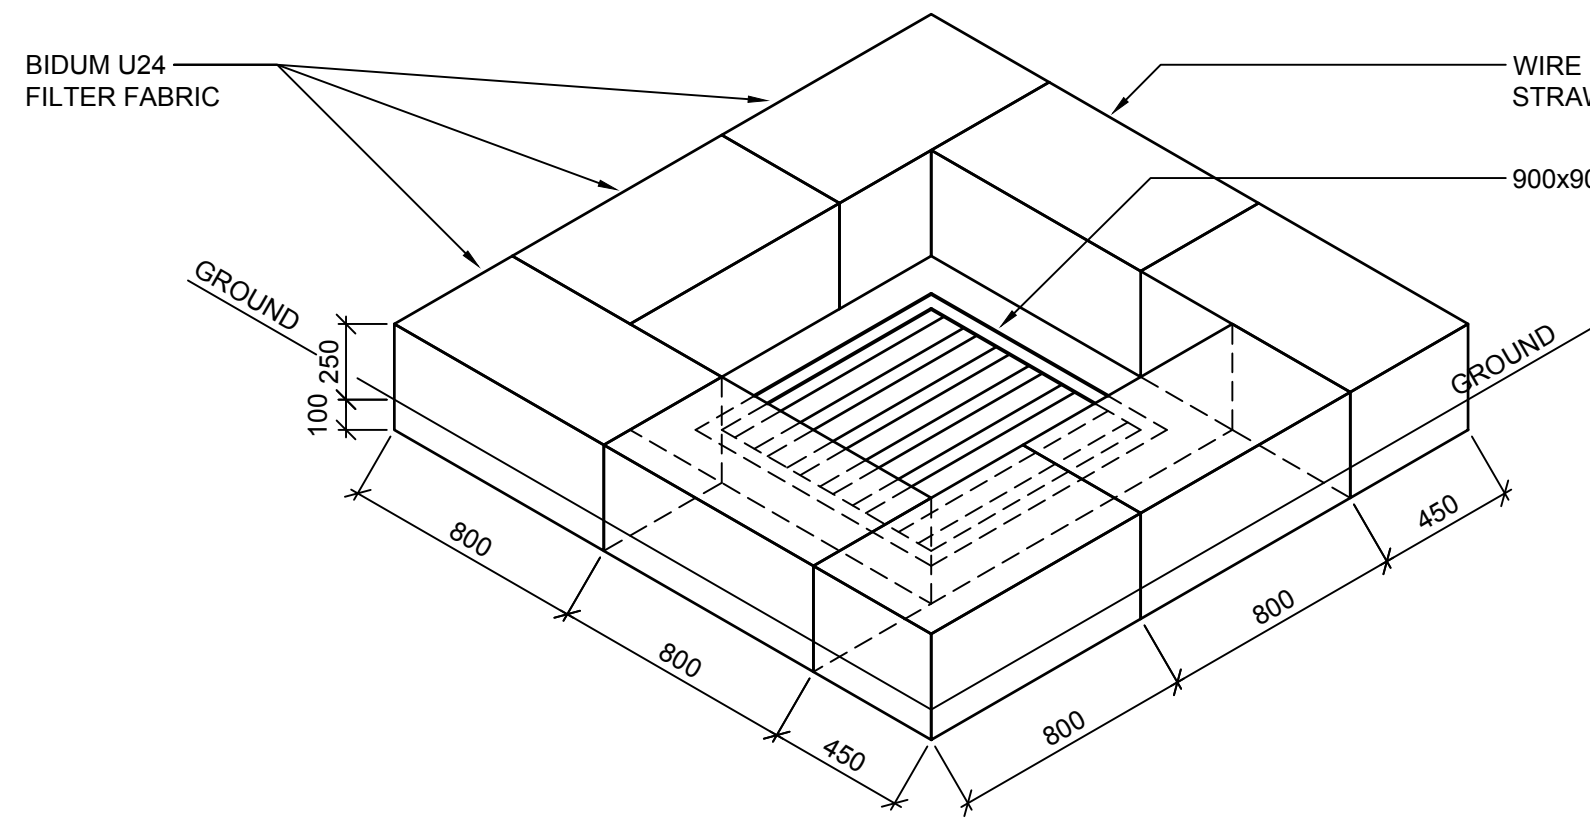


SWP WITH STRAW BALE
SEDIMENT FILTER
N.T.S

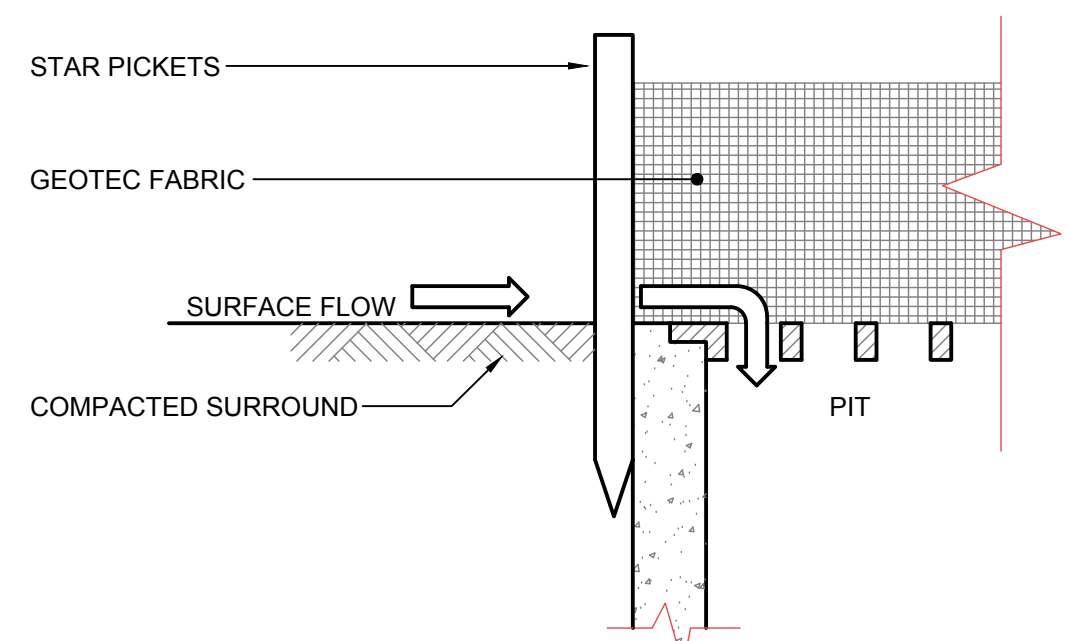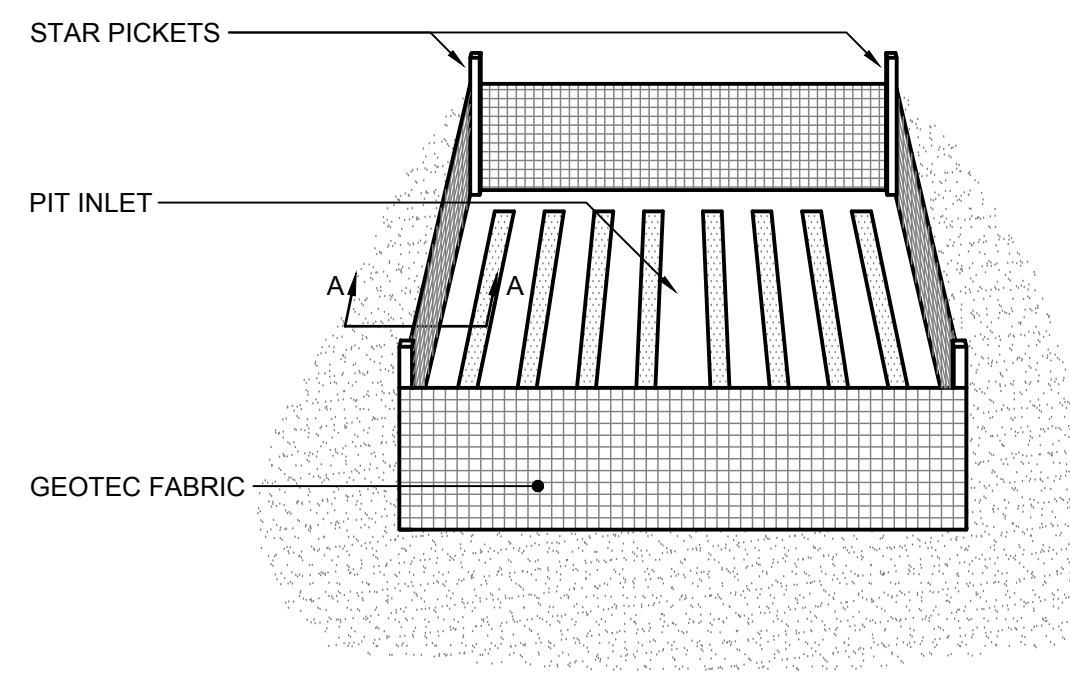

SECTION A-A
TYPICAL DETAIL

GEOTEXTILE FILTER FABRIC DROP
INLET SEDIMENT TRAP
N.T.S

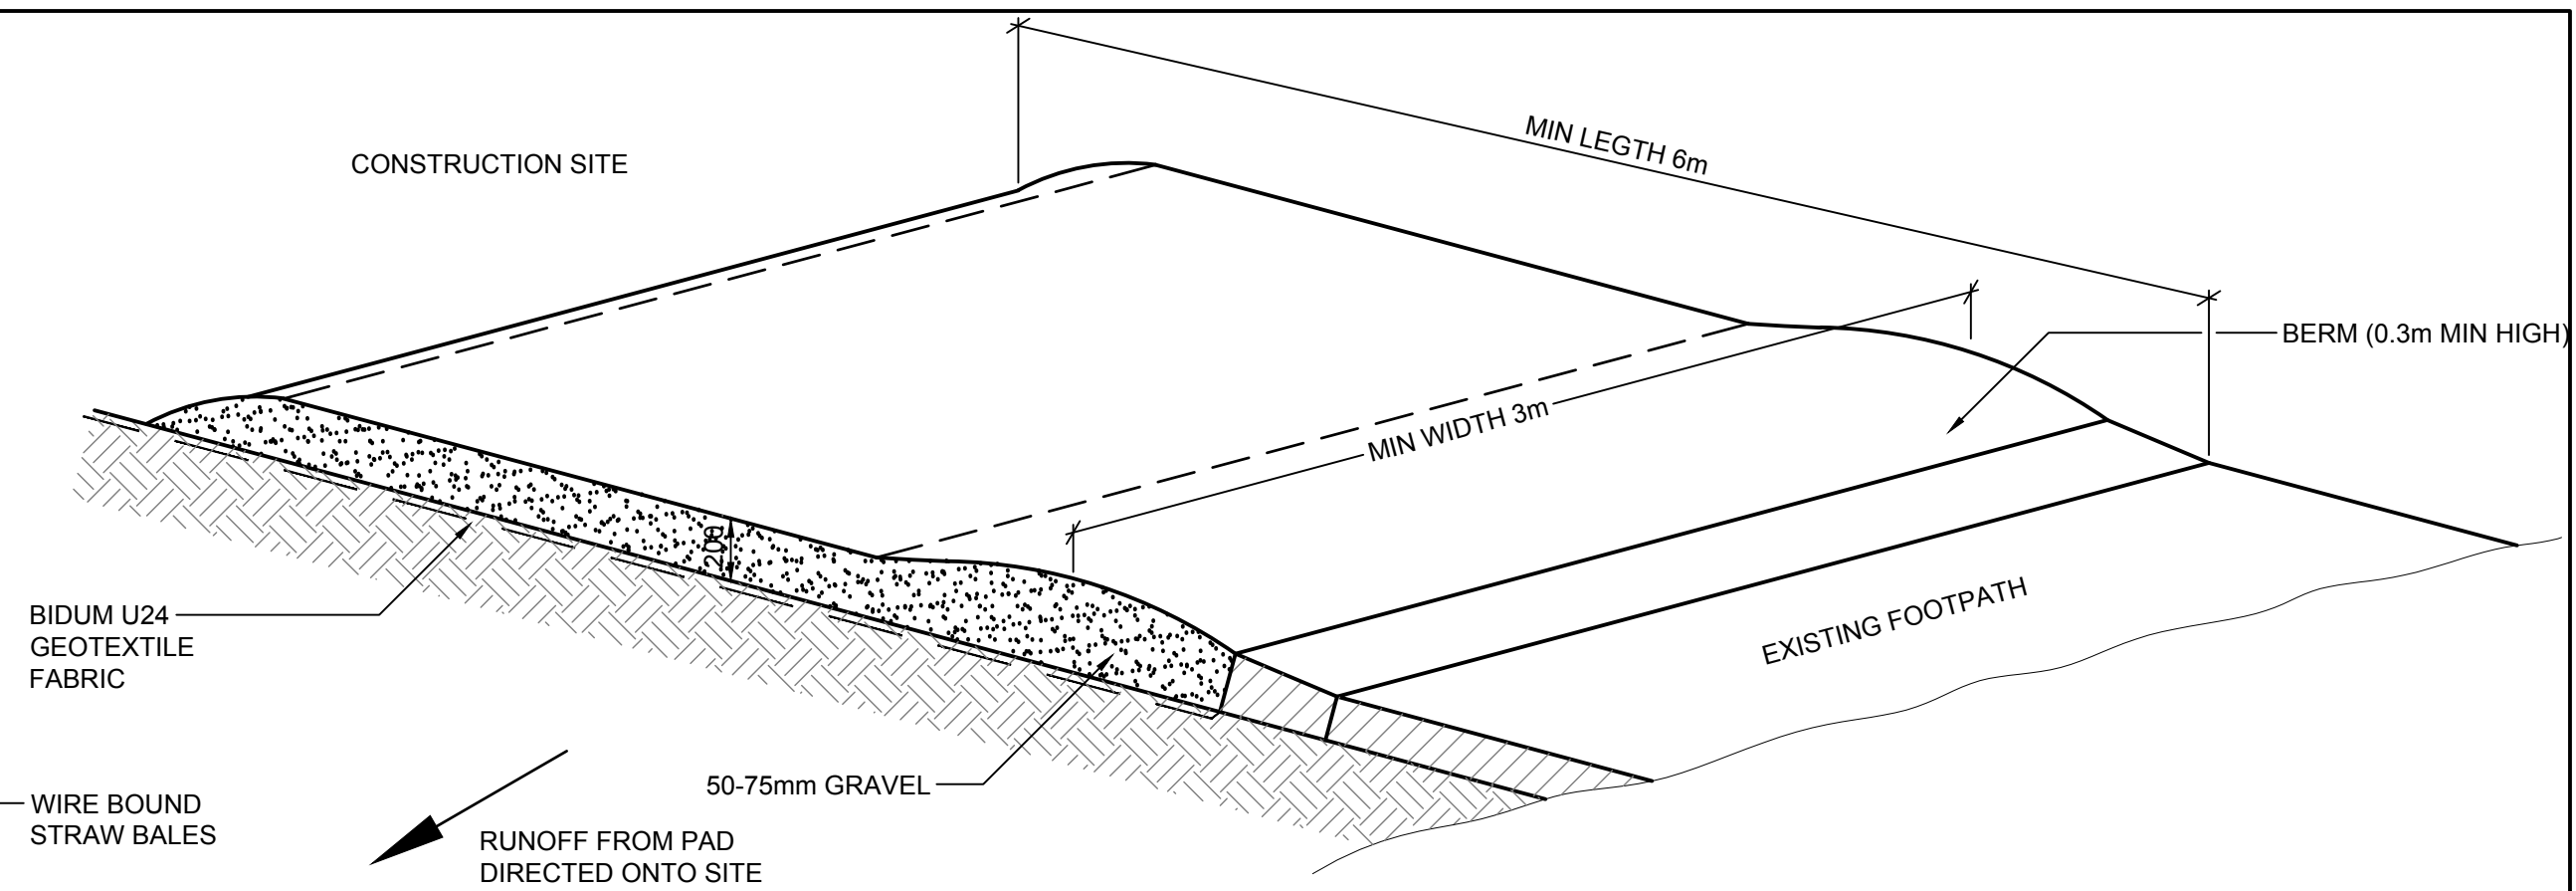


TEMPORARY CONSTRUCTION EXIT
N.T.S


ALL FILL TO BE PERFORMED UNDER LEVEL 1 GEOTECHNICAL SUPERVISION IN ACCORDANCE WITH AS.3798-1990 + AMENDMENTS. FILL TO BE CLEAN & UNCONTAMINATED. DETAILS OF COMPLIANCE OF THIS CONDITION INCLUDING SOURCE OF MATERIAL AND CERTIFICATION THAT IT IS NOT CONTAMINATED MUST BE SUBMITTED TO THE PRINCIPAL AUTHORITY.

TOPSOIL FREE OF HARDPANS AND OF DEPTH ADEQUATE TO PROVIDE SEED BED. SEED TO BE DISTRIBUTED CONSISTANTLY OVER TOPSOIL.


SOIL PROFILE TO BE ESTABLISHED AND CULTIVATED WITH SUBGRADE CAPABLE OF ACCEPTING PEGS REQUIRED TO FIX MAT.

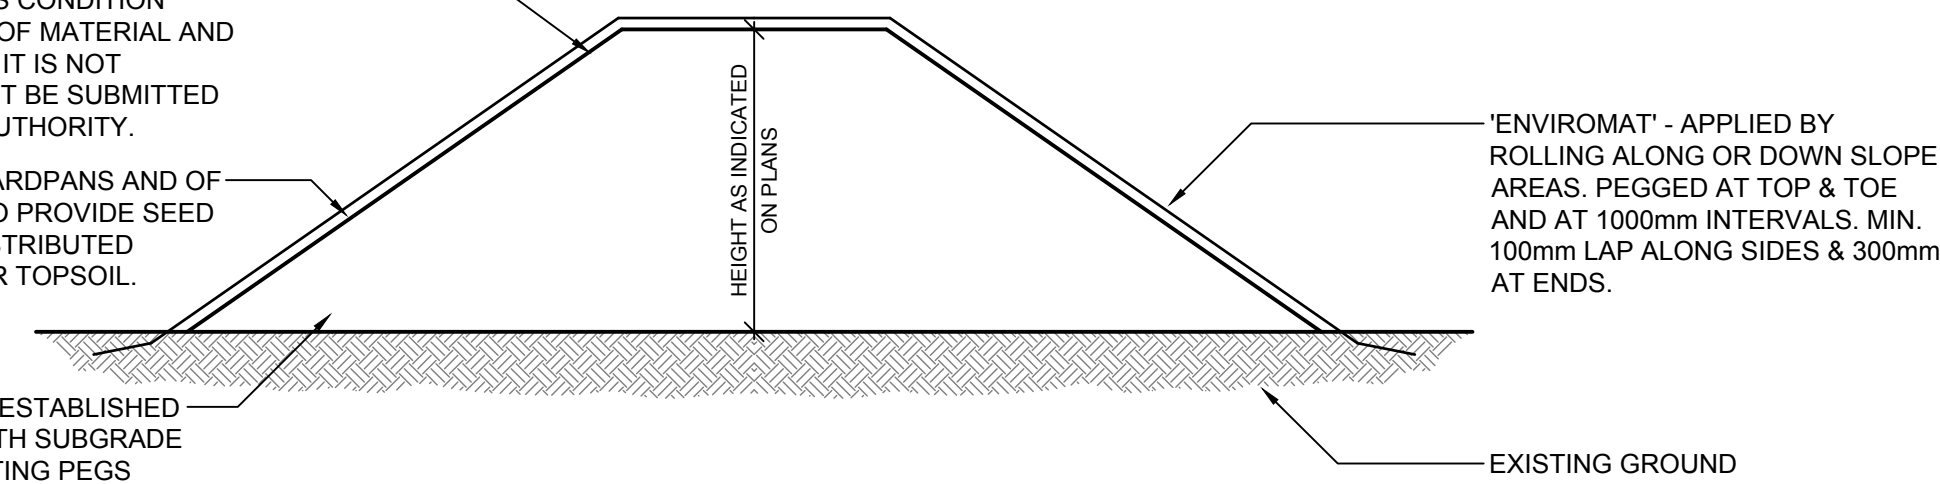


FLOOD RETENTION BANKING DETAIL
+ ANTI-SOUR TREATMENT

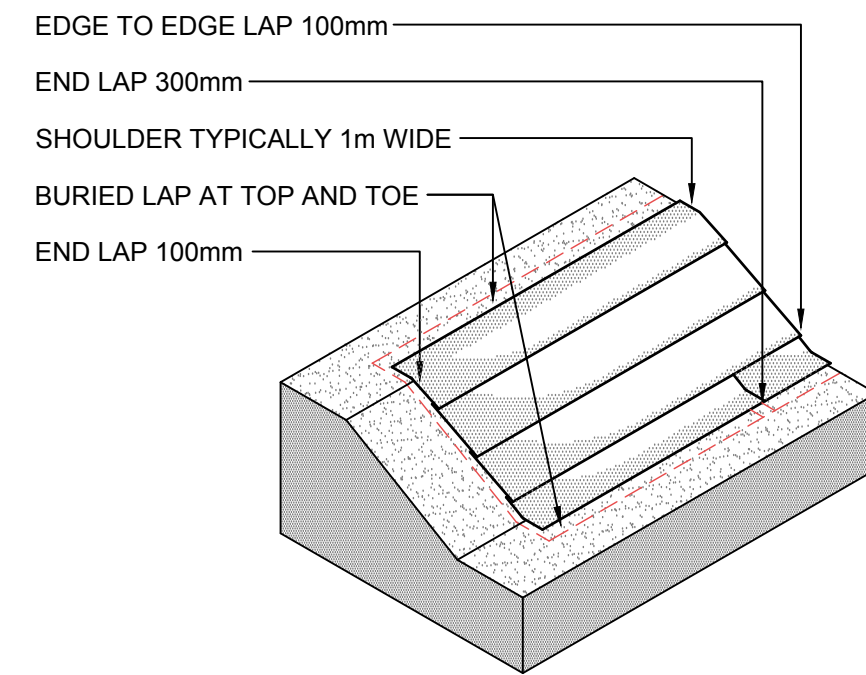


TREATMENT OF SLOPES UP TO
35° FROM THE HORIZONTAL

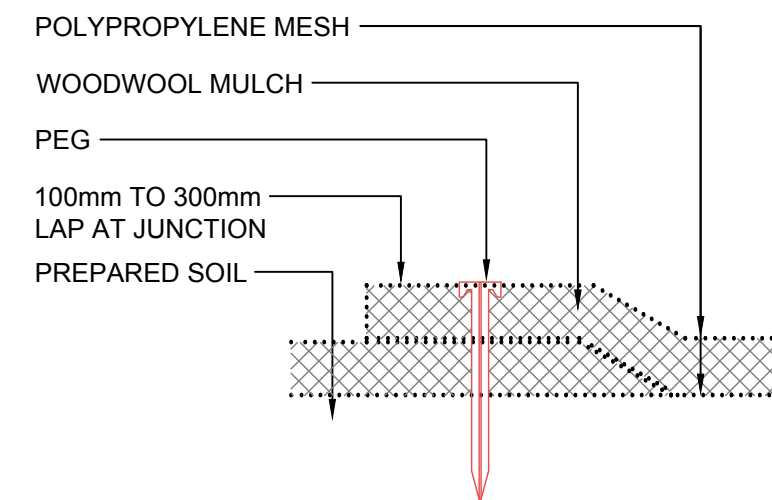

TYPICAL CROSS SECTION
THROUGH INSTALLED ENVIROMAT

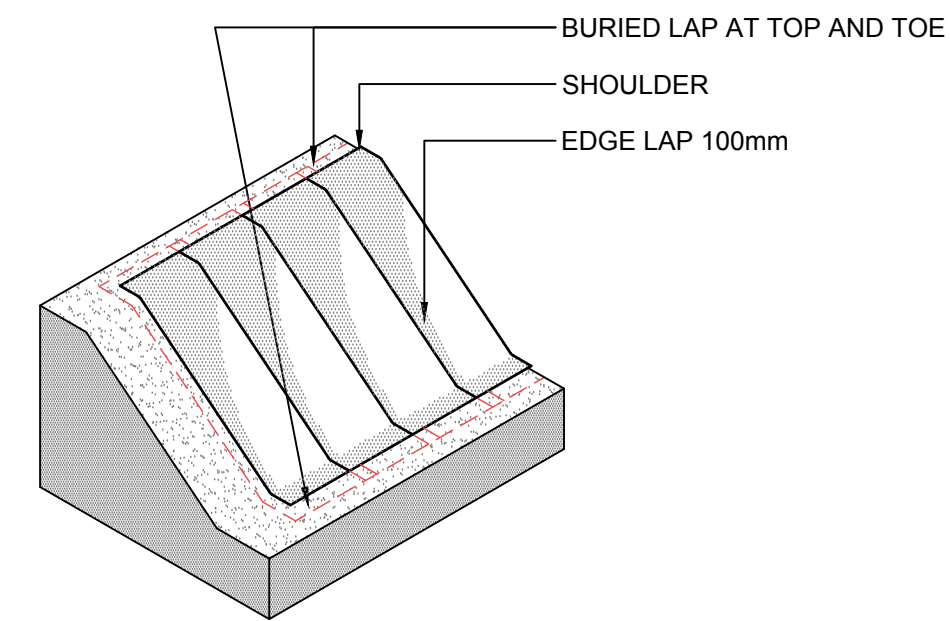

TREATMENT OF SLOPES GREATER
THAN 35° FROM THE HORIZONTAL

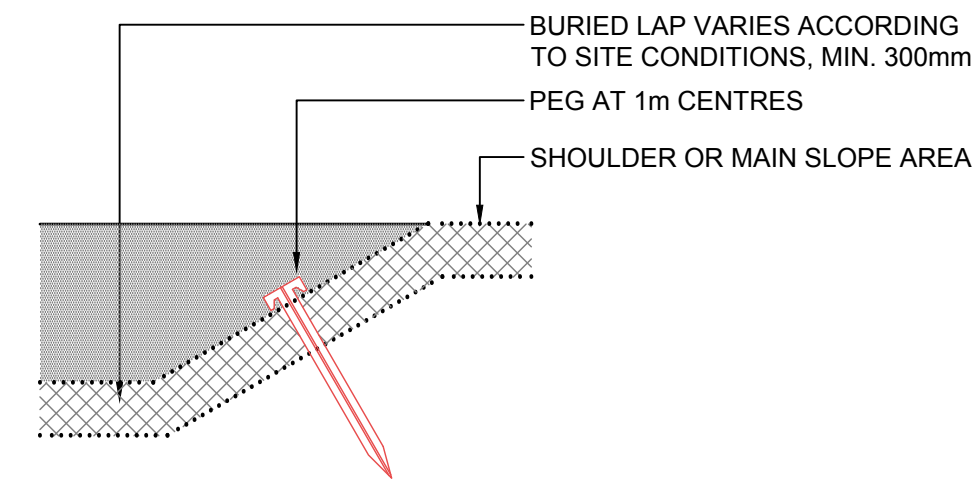

TYPICAL CROSS SECTION
SHOWING EDGE TREATMENT


FLOOD RETENTION BANKING
N.T.S



Xref: 2020-1773_X4/TITLE.BAK A1
Plot Date: 11/11/2020 15:50:03 User: Name: Michael
Caf File: Z:\projects\2020\1773\DRAWINGS\DRAWINGS - WORKING\STORMWATER\2020-1773_DA-STW-016.dwg

DO NOT SCALE FROM DRAWINGS. CHECK & VERIFY ALL DIMENSIONS & LEVELS BEFORE COMMENCEMENT OF ANY WORK.	North East South West	NOTES 1. REFER TO DRAWING DA-STW-002 FOR DRAWING LIST. 2. CONTRACTOR TO CHECK AND CONFIRM ALL LEVELS ON SITE. 3. CONTRACTOR TO INVESTIGATE ALL EXISTING SERVICES, SUCH AS APPLY FOR "DIAL BEFORE YOU DIG" SERVICES PRIOR TO START OF WORKS ON SITE.	ISSUE A B C	AMENDMENT DEVELOPMENT APPLICATION - ISSUE FOR COORDINATION ISSUE FOR DEVELOPMENT APPLICATION ISSUE FOR SSDA	DATE 30.09.2020 16.10.2020 11.11.2020	PROJECT ROYAL INSTITUTE FOR DEAF & BLIND CHILDREN MACQUARIE UNIVERSITY	PROJECT MANAGER M PROJECTS Suite C2.08, Level 2 22-36 Mountain Street, Ultimo NSW 2007	CLIENT Royal Institute for Deaf and Blind Children	CONSULTANT LP CONSULTING AUSTRALIA PTY LTD A: Suite 12.01, Level 12, 300 George Street Sydney NSW Australia 2000 P: GPO Box 2662 Sydney NSW 2001 E: info@lp-consulting.com.au T: +61 (2) 9223 4444 W: www.lp-consulting.com.au	TITLE STORMWATER DRAINAGE EROSION + SEDIMENT CONTROL DETAIL SHEET - 1	
						ARCHITECT WMK WMK Architecture L2 364 Kent Street Sydney NSW 2000 Tel: (02) 9262 5530 Fax: (02) 9262 5529	SCALE Nov 11, 2020	DRAWN VW	DESIGNED LP	CHECKED LP	APPROVED C
THIS DRAWING IS NOT TO BE COPIED IN PART OR WHOLE WITHOUT WRITTEN PERMISSION FROM LP CONSULTING AUSTRALIA PTY LTD						JOB No. 2020-1773		DRAWING No. DA - STW - 016		STATE SIGN. DA	

Xref: 2020-1773_X4-TITLE-BLK-A1
Plot Date: 11.11.2020@15:50:08 User Name: Mlczah
Caf File: Z:\pgecad\2020\1773\DRAWINGS\DRAWINGS - WORKINGS\STORMWATER\2020-1773_DA-STW-017.dwg

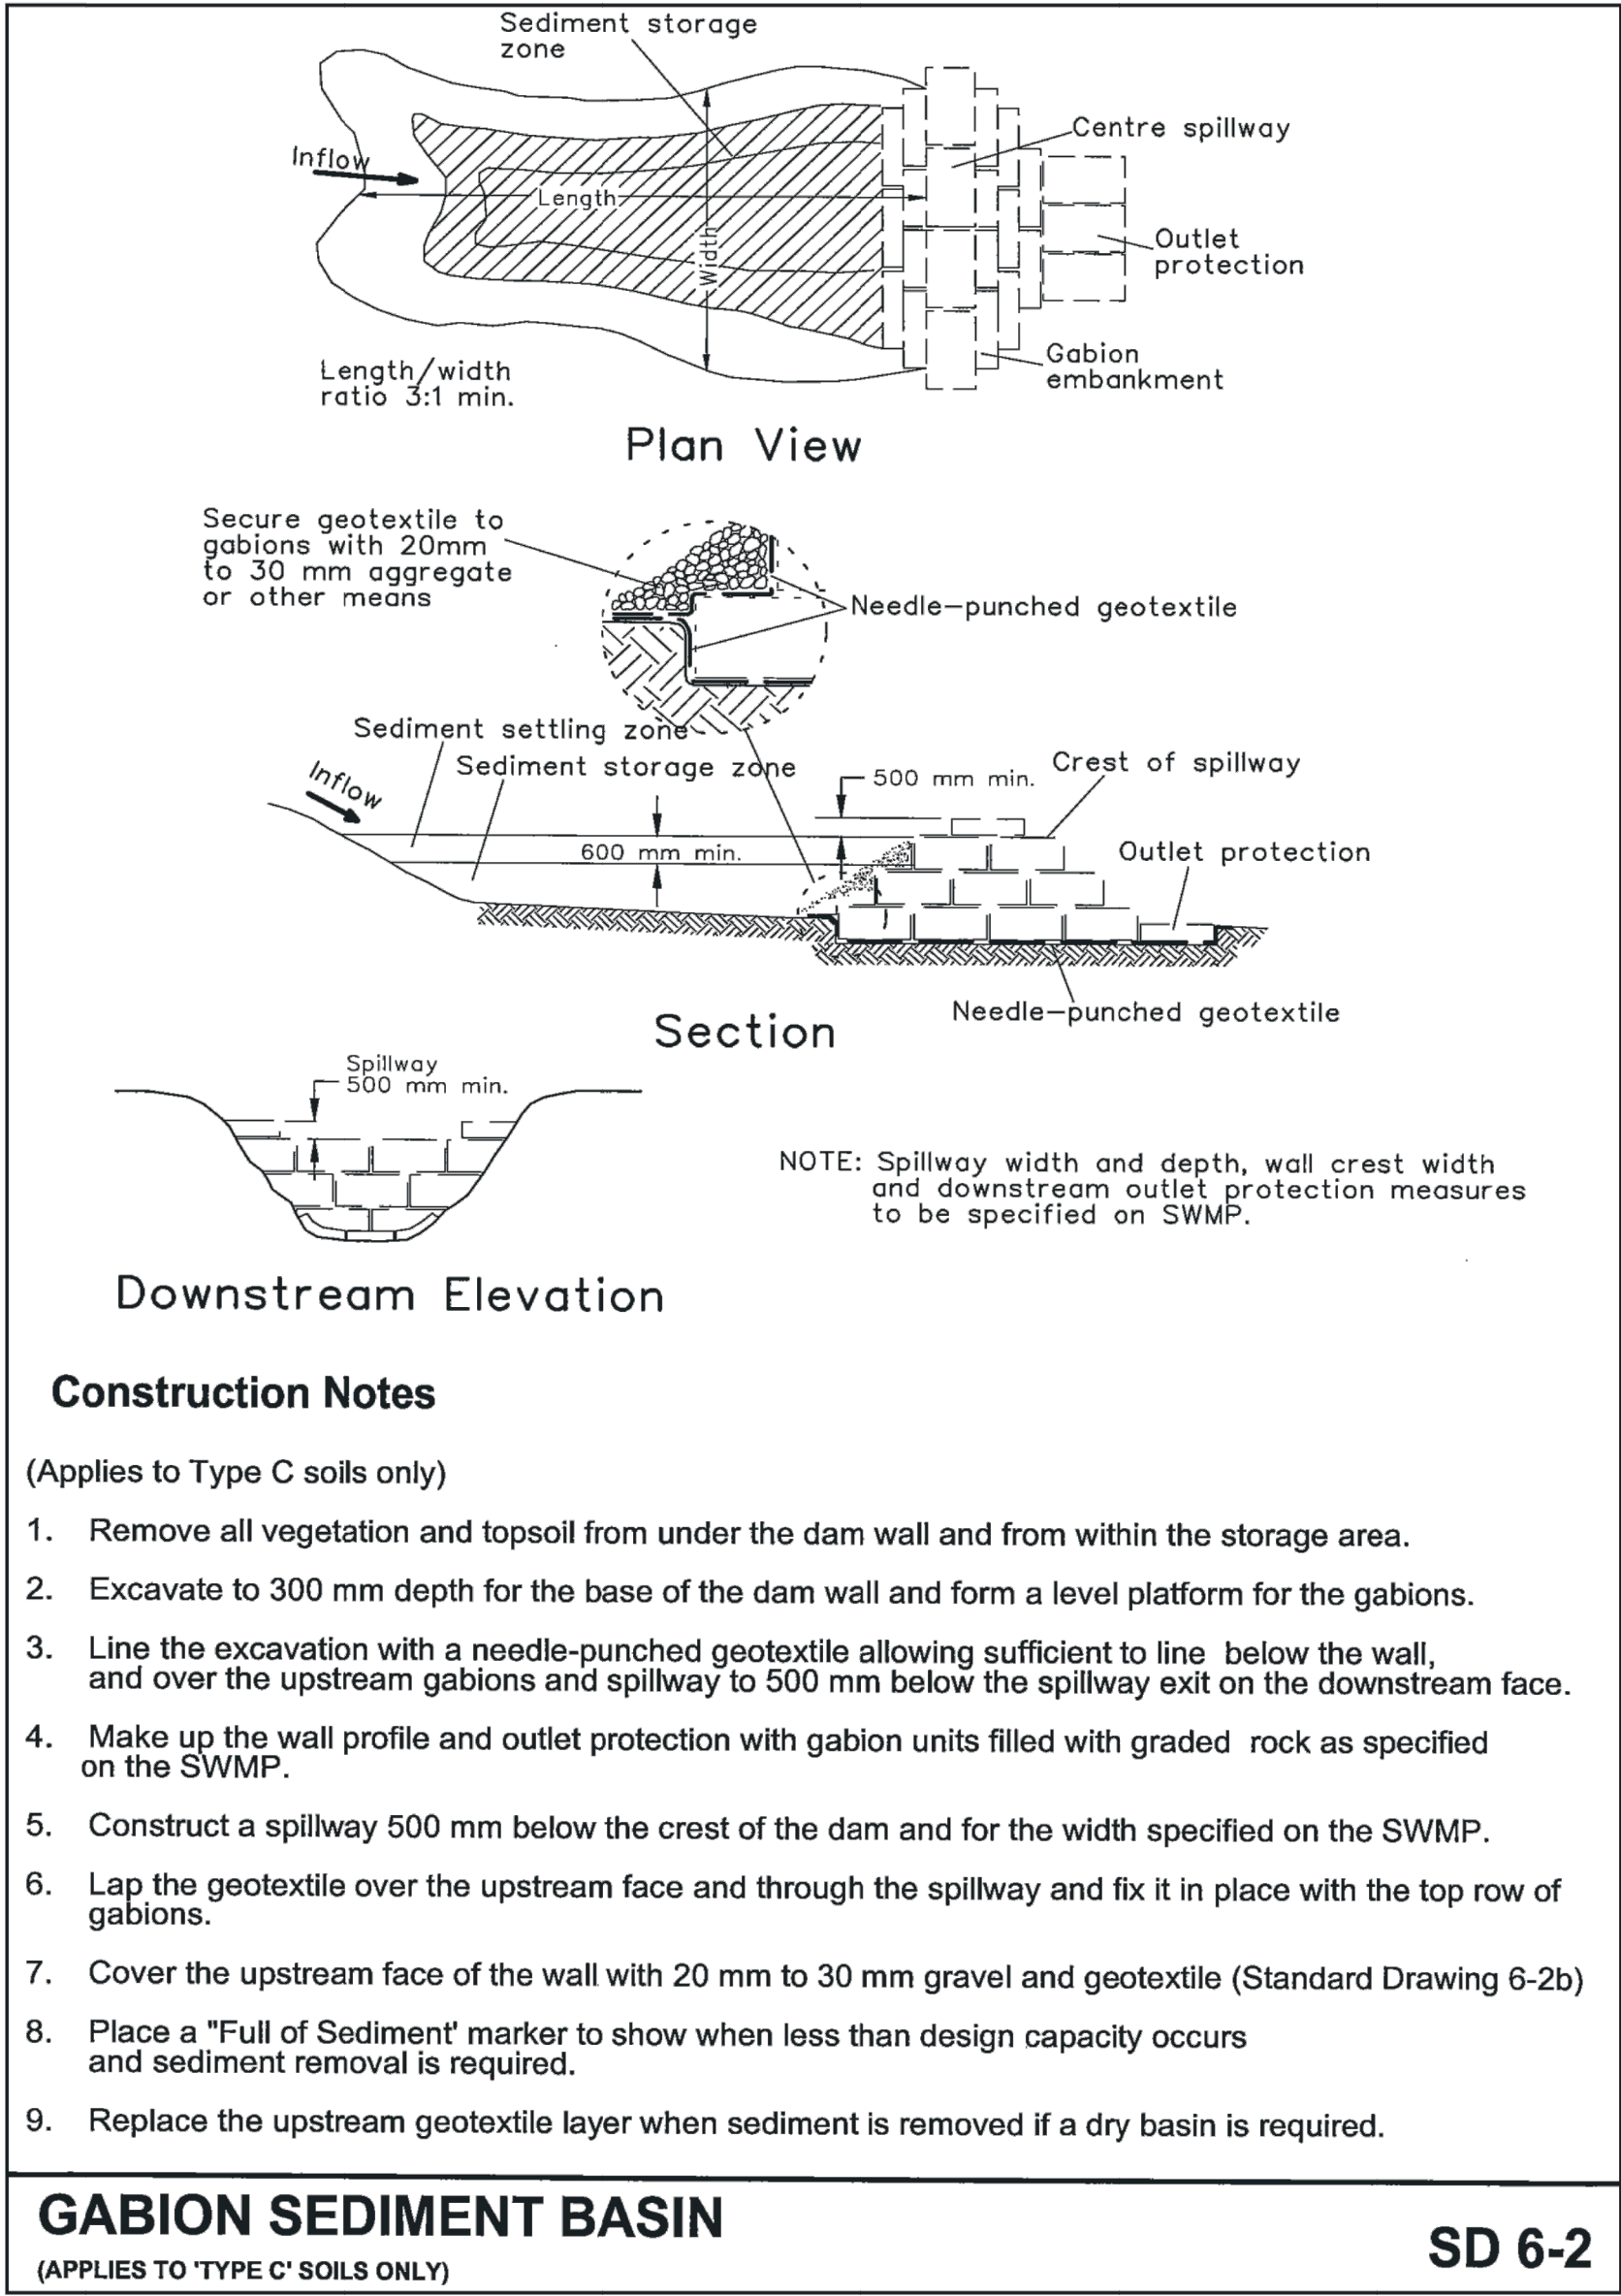

EROSION & SEDIMENT CONTROL ASSESSMENT

 
BASED ON SOILS & CONSTRUCTION: MANAGING URBAN STORMWATER 4TH EDITION, MARCH 2004 AVAILABLE FROM LANDCOM

ASSUMED AREA OF SOIL DISTURBANCE = APPROX. 19,340m²
TAKE RAINFALL EROSIONITY FACTOR R = 4000 FOR MACQUARIE UNIVERSITY (FROM APPENDIX B: MAP 10 ON PAGE B-12)
TAKE SITE SLOPE = 7.6%
INDICATIVE EROSION HAZARD IS HIGH (BASED ON SECTION 4.4.1 FIGURE 4.6 ON PAGE 4-10)
USE REVISED UNIVERSAL SOIL LOSS EQUATION (RUSLE) TO CHECK:
TAKE SOIL ERODIBILITY FACTOR K = 0.019 (FROM APPENDIX C: TABLE 20 FOR LANE COVE ON PAGE C-105)
TAKE SLOPE LENGTH / GRADIENT FACTOR L/s = 2.05 (FROM APPENDIX A: USING 80m LENGTH IN TABLE A1 ON PAGE A-9)
TAKE EROSION CONTROL PRACTICE FACTOR P = 1.3 (FROM APPENDIX A: TABLE A2 ON PAGE A-11)
TAKE GROUND COVER & MANAGEMENT FACTOR C = 1.0 (FROM APPENDIX A: FIGURE A5 ON PAGE A-12)
SOIL LOSS = 4000 x 0.019 x 2.05 x 1.3 x 1.0 = APPROX. 203t/ha/yr
SOIL LOSS CLASS = 2 (BETWEEN 151 to 225t/ha/yr) (BASED ON SECTION 4.4.2 TABLE 4.2 ON PAGE 4-13)
EROSION HAZARD IS THEREFORE LOW & THERE ARE NO SEASONAL RESTRICTIONS ON SITE ACTIVITY.
FOR A SOIL DENSITY OF 1.0t/m³ AVERAGE ANNUAL SOIL LOSS = 203m³/yr
SINCE THIS IS GREATER THAN 150m³/yr, A SEDIMENT BASIN IS CONSIDERED NECESSARY WHERE EXCAVATED SITE PORTIONS & AREAS OF SOIL DISTURBANCE EXCEED 2,500m² (REFER TO SECTION 6.3.2(d) ON PAGE 6-8).
FOR THE AREA TO BE DISTURBED ON THIS SITE, SEDIMENT FENCES ARE CONSIDERED SATISFACTORY WHERE THEY CAN BE ARRANGED TO LIMIT AREAS DRAINING TOWARDS A SINGLE SECTION OF SEDIMENT FENCING TO 2,500m² (REFER TO SECTION 2.1 ON PAGE 2-1, SECTION 4.4.1(a) ON PAGE 4-9 & SECTION 4.3.2(h)(iv) ON PAGE 4-4).
LENGTHS OF SEDIMENT FENCING SHOULD BE ARRANGED TO LIMIT SUBCATCHMENT FLOWS TO 50L/s (REFER TO SECTION 6.3.7(e) ON PAGE 6-33 & SECTION 2.3.1(e) ON PAGE 2-4).
FOR 10yr 5min INTENSITY = 163mm/h & 10yr 1hr INTENSITY 46.9mm/h A FULLY PERVIOUS AREA OF UP TO 2,500m² CAN BE ACCOMMODATED BY ONE LENGTH OF SEDIMENT FENCING (REFER TO FIGURE 6-10 ON PAGE 6-34).


ALL PITS & PIPEWORK ASSOCIATED WITH PROPOSED DRAINAGE SYSTEMS SHALL BE KEPT FREE OF SOIL, WATER & DEBRIS FOR THE DURATION OF THE CONSTRUCTION WORKS.
ALL LOOSE IMPORTED FILL & EXCAVATED MATERIAL SHALL BE STOCKPILED AS FAR AS POSSIBLE FROM SEDIMENT FENCES PRIOR TO FINAL PLACEMENT, COMPACTION OR REMOVAL FROM SITE.
EXCESSIVE SEDIMENT BUILDUP SHALL BE AVOIDED BY REGULAR MAINTENANCE OF SEDIMENT FENCES.
WHERE APPLICABLE, APPROVED LANDSCAPING & REVEGETATION OF DISTURBED AREAS SHALL COMMENCE AT THE EARLIEST OPPORTUNITY AFTER COMPLETION OF EARTHWORKS OPERATIONS.
WHERE BASEMENT EXCAVATION EXTENDS LOWER THAN THE SURROUNDING GROUND SURFACE, THE DEEPEST PART OF THE AREA SHALL EFFECTIVELY FUNCTION AS A TEMPORARY SEDIMENT BASIN UNTIL DEWATERING OPERATIONS CONVEY THE CONTAMINATED RUNOFF UP TO THE FORMAL SEDIMENT BASIN AREA AT GROUND LEVEL. WHERE PUMP DISCHARGE IS DIRECTED TO THE STREET SYSTEM, THE CONTRACTOR MUST ENSURE ADEQUATE SETTLEMENT OF PARTICULATE MATTER HAS OCCURRED (e.g. 50mg/L TOTAL SUSPENDED SOLIDS) PRIOR TO PUMPING.

DO NOT SCALE FROM DRAWINGS,
CHECK & VERIFY ALL
DIMENSIONS & LEVELS BEFORE
COMMENCEMENT OF ANY WORK.

THIS DRAWING IS NOT TO BE
COPIED IN PART OR WHOLE
WITHOUT WRITTEN PERMISSION
FROM LP CONSULTING
AUSTRALIA PTY LTD



Xrefs: 2020-1773_XS_SURVEY; 2020-1773_X-H_TITILE_BLK-41; 2020-1773_X4-BASEMENT PLAN
 Plot Date: 11/11/2020@15:50:09 Cad File: Z:\Projects\2020\1773\DRAWINGS\SSD\DRAWINGS_SS - WORKING\SSD\WATER\2020-1773_Da-STDW-101.dwg

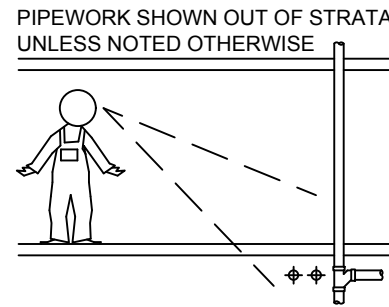

PIPEWORK SHOWN OUT OF STRATA
UNLESS NOTED OTHERWISE

300 HALF ROUND PIPE @ 1%
 $Q_{AD} = 47.2 \text{ L/sec}$

DP
150

1200mm SQ SWP
CLASS 'B' GRATE
RL 77.70
IL 75.80

DP
150

1200mm SQ SWP
CLASS 'B' SEALED PIT
RL 77.60
IL 76.27

DP
150

150
DP

6 x 225Ø DETENTION TANK
OVERFLOW PIPELINES

RAINWATER TANK
10m³ CAPACITY
TWL / OVERFLOW
RL 76.00
IL 74.35

1200mm SQ SWP
CLASS 'B' GRATE
RL 74.00
IL 73.075

1200mm SQ SWP
CLASS 'B' GRATE
RL 73.20
IL 72.475

DETENTION CONTROL
PIT/SUMP
CLASS 'B' SOLID LID/BOLTED
RL 76.35
IL 73.075
SUMP IL 73.075

DP
150

1200mm SQ SWP
CLASS 'B' GRATE
RL 72.00
IL 70.275

1200mm SQ SWP
CLASS 'B' GRATE
RL 73.00
IL 69.66

WEST PRECINCT
ROAD

DP
150

DP
150


DP
150

DP
150

0 2 4 8 12 16 20 metres
SCALE IS BEFORE REDUCTION SCALE 1:200

DO NOT SCALE FROM DRAWINGS.
CHECK & VERIFY ALL
DIMENSIONS & LEVELS BEFORE
COMMENCEMENT OF ANY WORK.

THIS DRAWING IS NOT TO BE
COPIED IN PART OR WHOLE
WITHOUT WRITTEN PERMISSION
FROM LP CONSULTING
AUSTRALIA PTY LTD

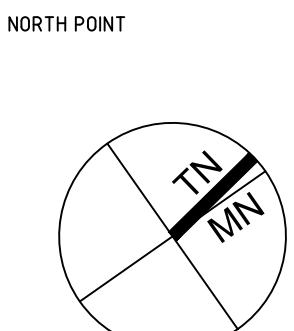

SHEET SIZE: A1

- NOTES
- REFER TO DRAWING DA-STW-002 FOR DRAWING LIST.
 - CONTRACTOR TO CHECK AND CONFIRM ALL LEVELS ON SITE.
 - CONTRACTOR TO INVESTIGATE ALL EXISTING SERVICES, SUCH AS APPLY FOR "DIAL BEFORE YOU DIG" SERVICES PRIOR TO START OF WORKS ON SITE.

ISSUE

A	DEVELOPMENT APPLICATION - ISSUE FOR COORDINATION
B	ISSUE FOR DEVELOPMENT APPLICATION
C	ISSUE FOR SSDA

DATE

30.09.2020
16.10.2020
11.11.2020

PROJECT

ROYAL INSTITUTE FOR
DEAF & BLIND CHILDREN
MACQUARIE UNIVERSITY

ARCHITECT

WMK Architecture
L2 364 Kent
Street
Sydney NSW 2000

PROJECT MANAGER

M PROJECTS

Suite C2.08, Level 2
22-36 Mountain Street,
Ultimo NSW 2007

Tel: (02) 9262 5530
Fax: (02) 9262 5529
Web: mprojects.com.au

CLIENT

Royal Institute for
Deaf and Blind Children

CONSULTANT

LP CONSULTING
AUSTRALIA PTY LTD


A: Suite 12.01, Level 12, 300 George Street
Sydney NSW Australia 2000
P: GPO Box 2662 Sydney NSW 2001
E: info@lp-consulting.com.au





T: +61 (2) 9223 4444
W: www.lp-consulting.com.au


TITLE

STORMWATER DRAINAGE
LOWER GROUND FLOOR PLAN
ZONE 1


SCALE 1:200 @ A1 1:400 @ A3	DRAWN VWW	DESIGNED LP	CHECKED LP	APPROVED
DATE Nov 11, 2020	DRAWING No.	C		
JOB No. 2020-1773	DA - STW - 102			
STATE SIGN. DA				

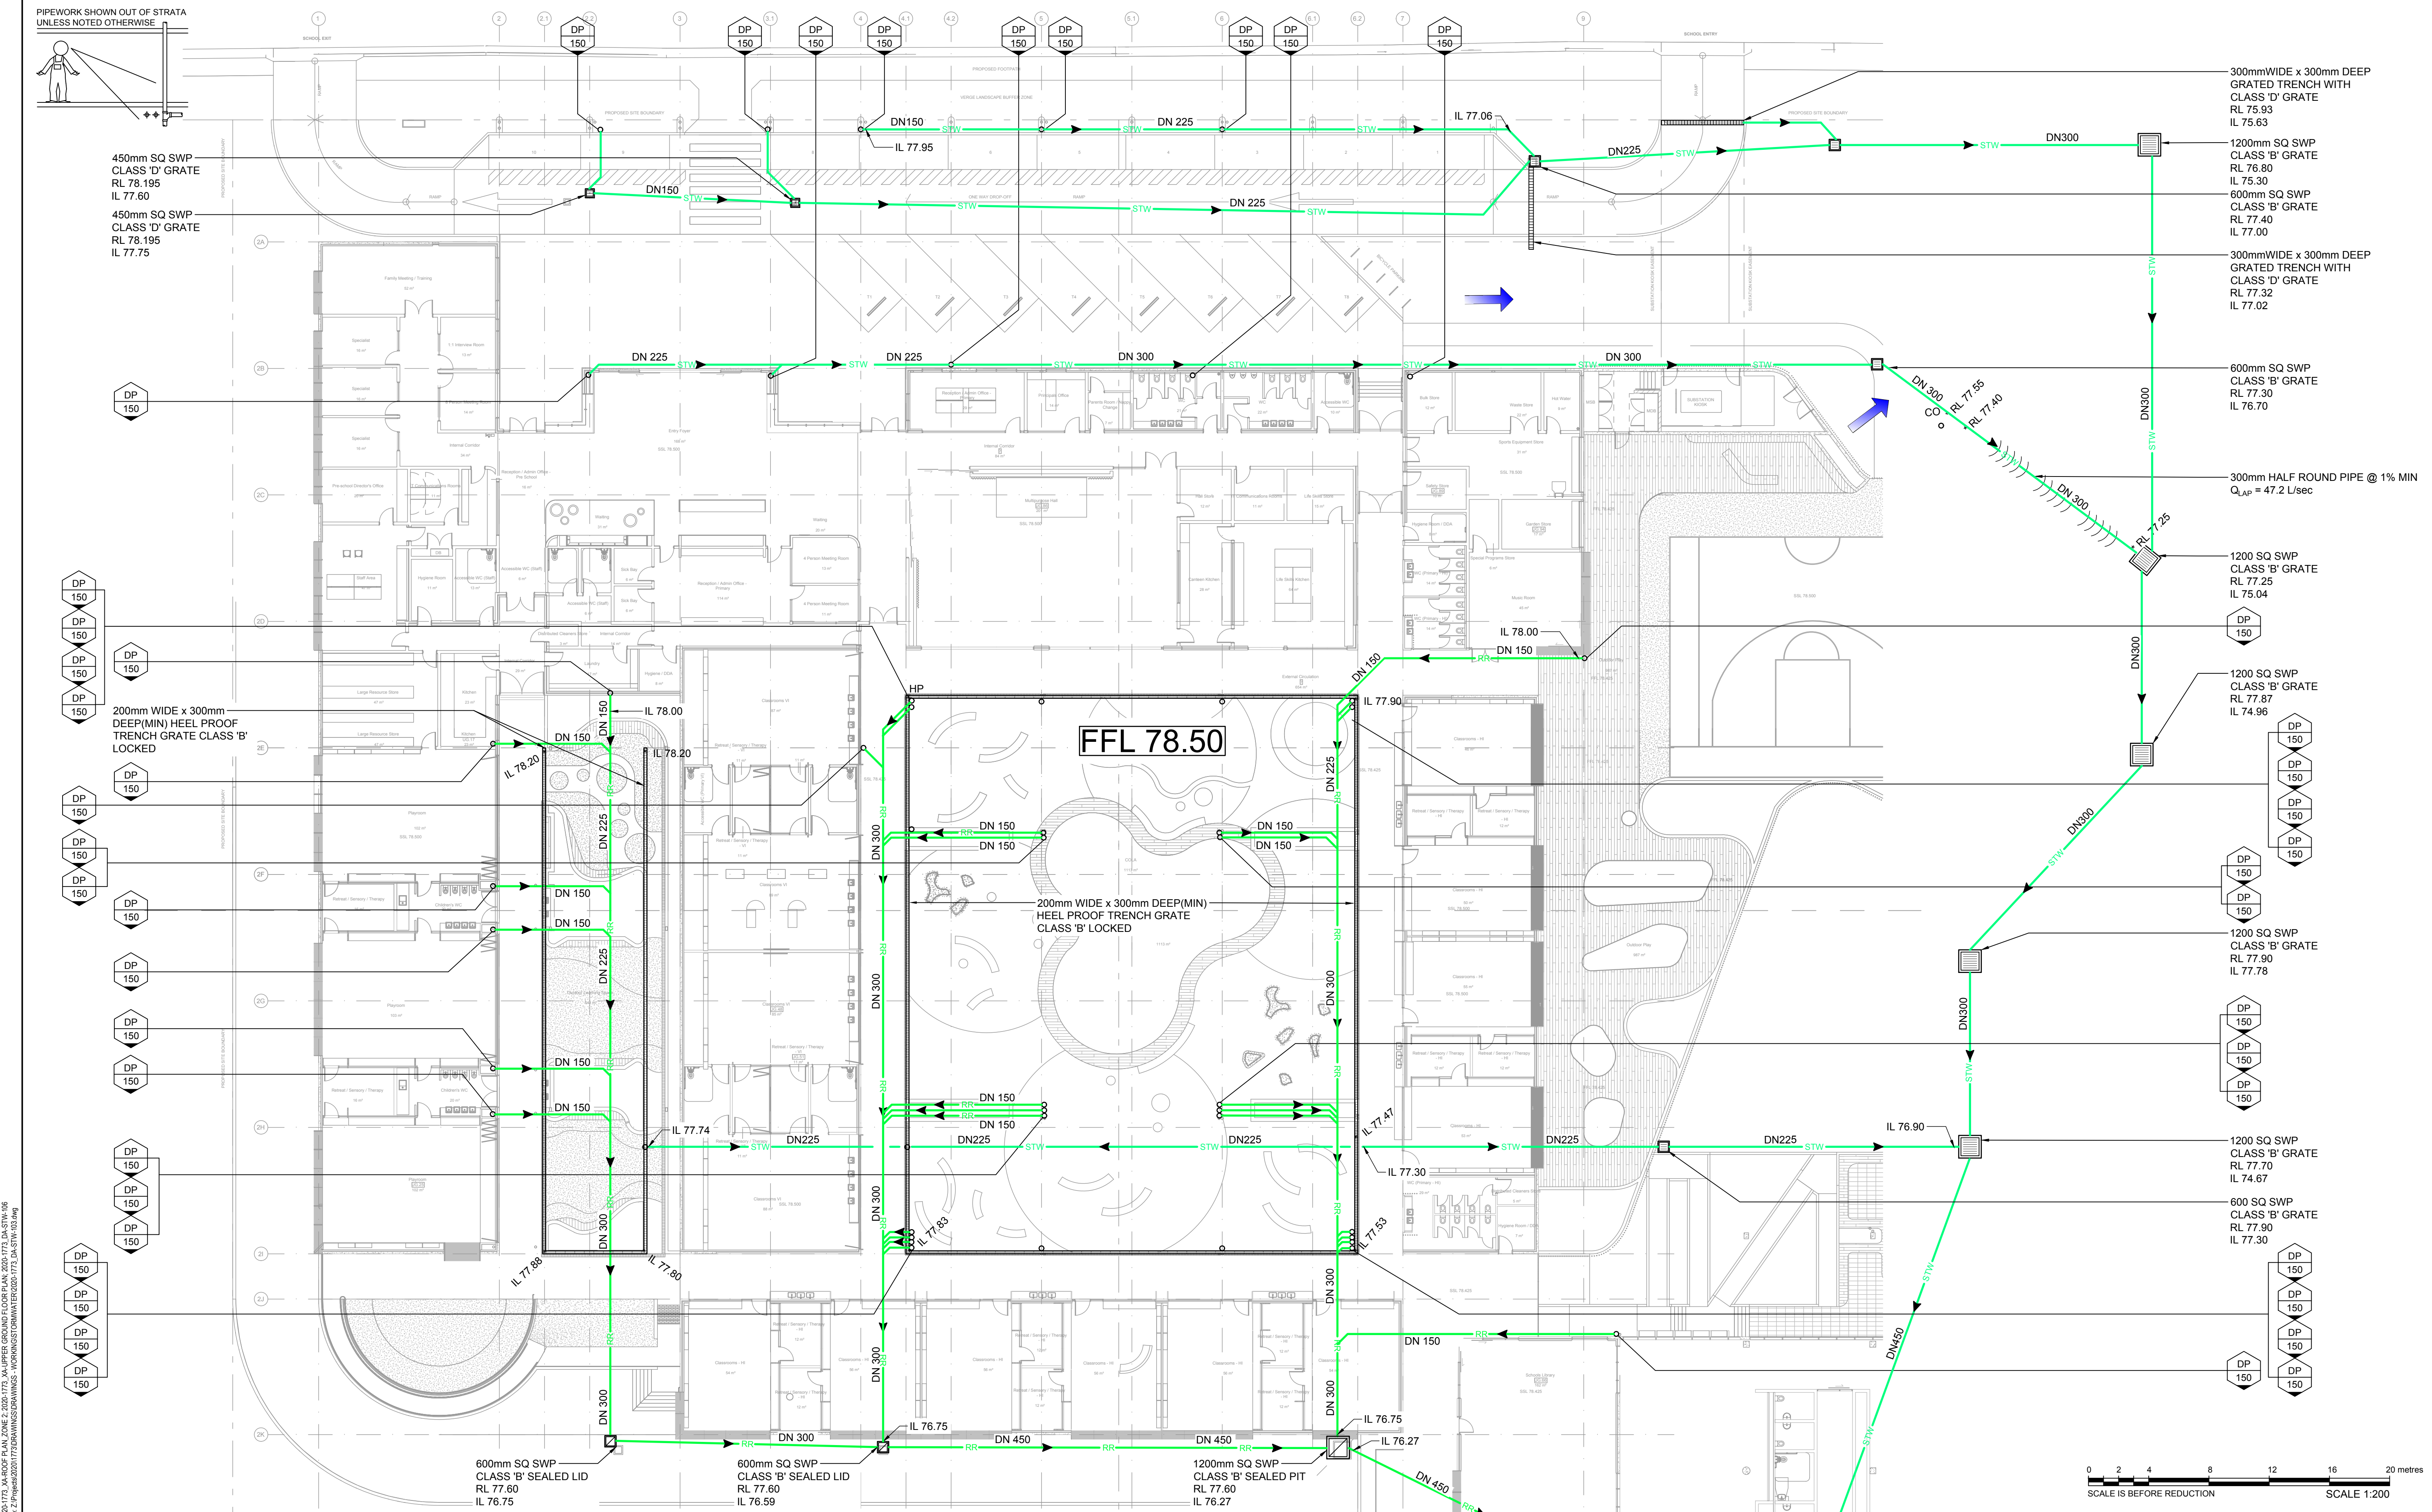

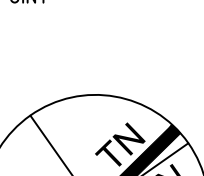   DO NOT SCALE FROM DRAWINGS. CHECK & VERIFY ALL DIMENSIONS & LEVELS BEFORE COMMENCEMENT OF ANY WORK. THIS DRAWING IS NOT TO BE COPIED IN PART OR WHOLE WITHOUT WRITTEN PERMISSION FROM LP CONSULTING AUSTRALIA PTY LTD		NORTH POINT  SHEET SIZE: A1	NOTES 1. REFER TO DRAWING DA-STW-002 FOR DRAWING LIST. 2. CONTRACTOR TO CHECK AND CONFIRM ALL LEVELS ON SITE. 3. CONTRACTOR TO INVESTIGATE ALL EXISTING SERVICES, SUCH AS APPLY FOR "DIAL BEFORE YOU DIG" SERVICES PRIOR TO START OF WORKS ON SITE.	<table><tr><th>ISSUE</th><th>AMENDMENT</th><th>DATE</th></tr><tr><td>A</td><td>DEVELOPMENT APPLICATION - ISSUE FOR COORDINATION</td><td>30.09.2020</td></tr><tr><td>B</td><td>ISSUE FOR DEVELOPMENT APPLICATION</td><td>16.10.2020</td></tr><tr><td>C</td><td>ISSUE FOR SSDA</td><td>11.11.2020</td></tr></table>	ISSUE	AMENDMENT	DATE	A	DEVELOPMENT APPLICATION - ISSUE FOR COORDINATION	30.09.2020	B	ISSUE FOR DEVELOPMENT APPLICATION	16.10.2020	C	ISSUE FOR SSDA	11.11.2020	<table><tr><td>PROJECT</td><td>ROYAL INSTITUTE FOR DEAF & BLIND CHILDREN MACQUARIE UNIVERSITY</td></tr><tr><td>ARCHITECT</td><td> WMK Architecture L2 364 Kent Street Sydney NSW 2000</td></tr><tr><td>PROJECT MANAGER</td><td> M PROJECTS Suite C2.08, Level 2 22-36 Mountain Street, Ultimo NSW 2007 Tel: (02) 9262 5530 Fax: (02) 9262 5529 Web: mprojects.com.au</td></tr><tr><td>CLIENT</td><td> Royal Institute for Deaf and Blind Children</td></tr><tr><td>CONSULTANT</td><td> LP CONSULTING AUSTRALIA PTY LTD A: Suite 12.01, Level 12, 300 George Street Sydney NSW Australia 2000 P: GPO Box 2662 Sydney NSW 2001 E: info@lp-consulting.com.au T: +61 (2) 9223 4444 W: www.lp-consulting.com.au</td></tr></table>	PROJECT	ROYAL INSTITUTE FOR DEAF & BLIND CHILDREN MACQUARIE UNIVERSITY	ARCHITECT	 WMK Architecture L2 364 Kent Street Sydney NSW 2000	PROJECT MANAGER	 M PROJECTS Suite C2.08, Level 2 22-36 Mountain Street, Ultimo NSW 2007 Tel: (02) 9262 5530 Fax: (02) 9262 5529 Web: mprojects.com.au	CLIENT	 Royal Institute for Deaf and Blind Children	CONSULTANT	 LP CONSULTING AUSTRALIA PTY LTD A: Suite 12.01, Level 12, 300 George Street Sydney NSW Australia 2000 P: GPO Box 2662 Sydney NSW 2001 E: info@lp-consulting.com.au T: +61 (2) 9223 4444 W: www.lp-consulting.com.au	<table><tr><td>TITLE</td><td colspan="4">STORMWATER DRAINAGE UPPER GROUND FLOOR PLAN ZONE 2</td></tr><tr><td>SCALE</td><td>1:200 @ A1 1:400 @ A3</td><td>DRAWN WW</td><td>DESIGNED LP</td><td>CHECKED LP</td><td>APPROVED</td></tr><tr><td>DATE</td><td>Nov 11, 2020</td><td colspan="2">DRAWING No.</td><td colspan="2">ISSUE</td></tr><tr><td>JOB No.</td><td>2020-1773</td><td colspan="2">DA - STW - 103</td><td colspan="2">C</td></tr><tr><td colspan="6">STATE SIGN. DA</td></tr></table>	TITLE	STORMWATER DRAINAGE UPPER GROUND FLOOR PLAN ZONE 2				SCALE	1:200 @ A1 1:400 @ A3	DRAWN WW	DESIGNED LP	CHECKED LP	APPROVED	DATE	Nov 11, 2020	DRAWING No.		ISSUE		JOB No.	2020-1773	DA - STW - 103		C		STATE SIGN. DA					
ISSUE	AMENDMENT	DATE																																																							
A	DEVELOPMENT APPLICATION - ISSUE FOR COORDINATION	30.09.2020																																																							
B	ISSUE FOR DEVELOPMENT APPLICATION	16.10.2020																																																							
C	ISSUE FOR SSDA	11.11.2020																																																							
PROJECT	ROYAL INSTITUTE FOR DEAF & BLIND CHILDREN MACQUARIE UNIVERSITY																																																								
ARCHITECT	 WMK Architecture L2 364 Kent Street Sydney NSW 2000																																																								
PROJECT MANAGER	 M PROJECTS Suite C2.08, Level 2 22-36 Mountain Street, Ultimo NSW 2007 Tel: (02) 9262 5530 Fax: (02) 9262 5529 Web: mprojects.com.au																																																								
CLIENT	 Royal Institute for Deaf and Blind Children																																																								
CONSULTANT	 LP CONSULTING AUSTRALIA PTY LTD A: Suite 12.01, Level 12, 300 George Street Sydney NSW Australia 2000 P: GPO Box 2662 Sydney NSW 2001 E: info@lp-consulting.com.au T: +61 (2) 9223 4444 W: www.lp-consulting.com.au																																																								
TITLE	STORMWATER DRAINAGE UPPER GROUND FLOOR PLAN ZONE 2																																																								
SCALE	1:200 @ A1 1:400 @ A3	DRAWN WW	DESIGNED LP	CHECKED LP	APPROVED																																																				
DATE	Nov 11, 2020	DRAWING No.		ISSUE																																																					
JOB No.	2020-1773	DA - STW - 103		C																																																					
STATE SIGN. DA																																																									

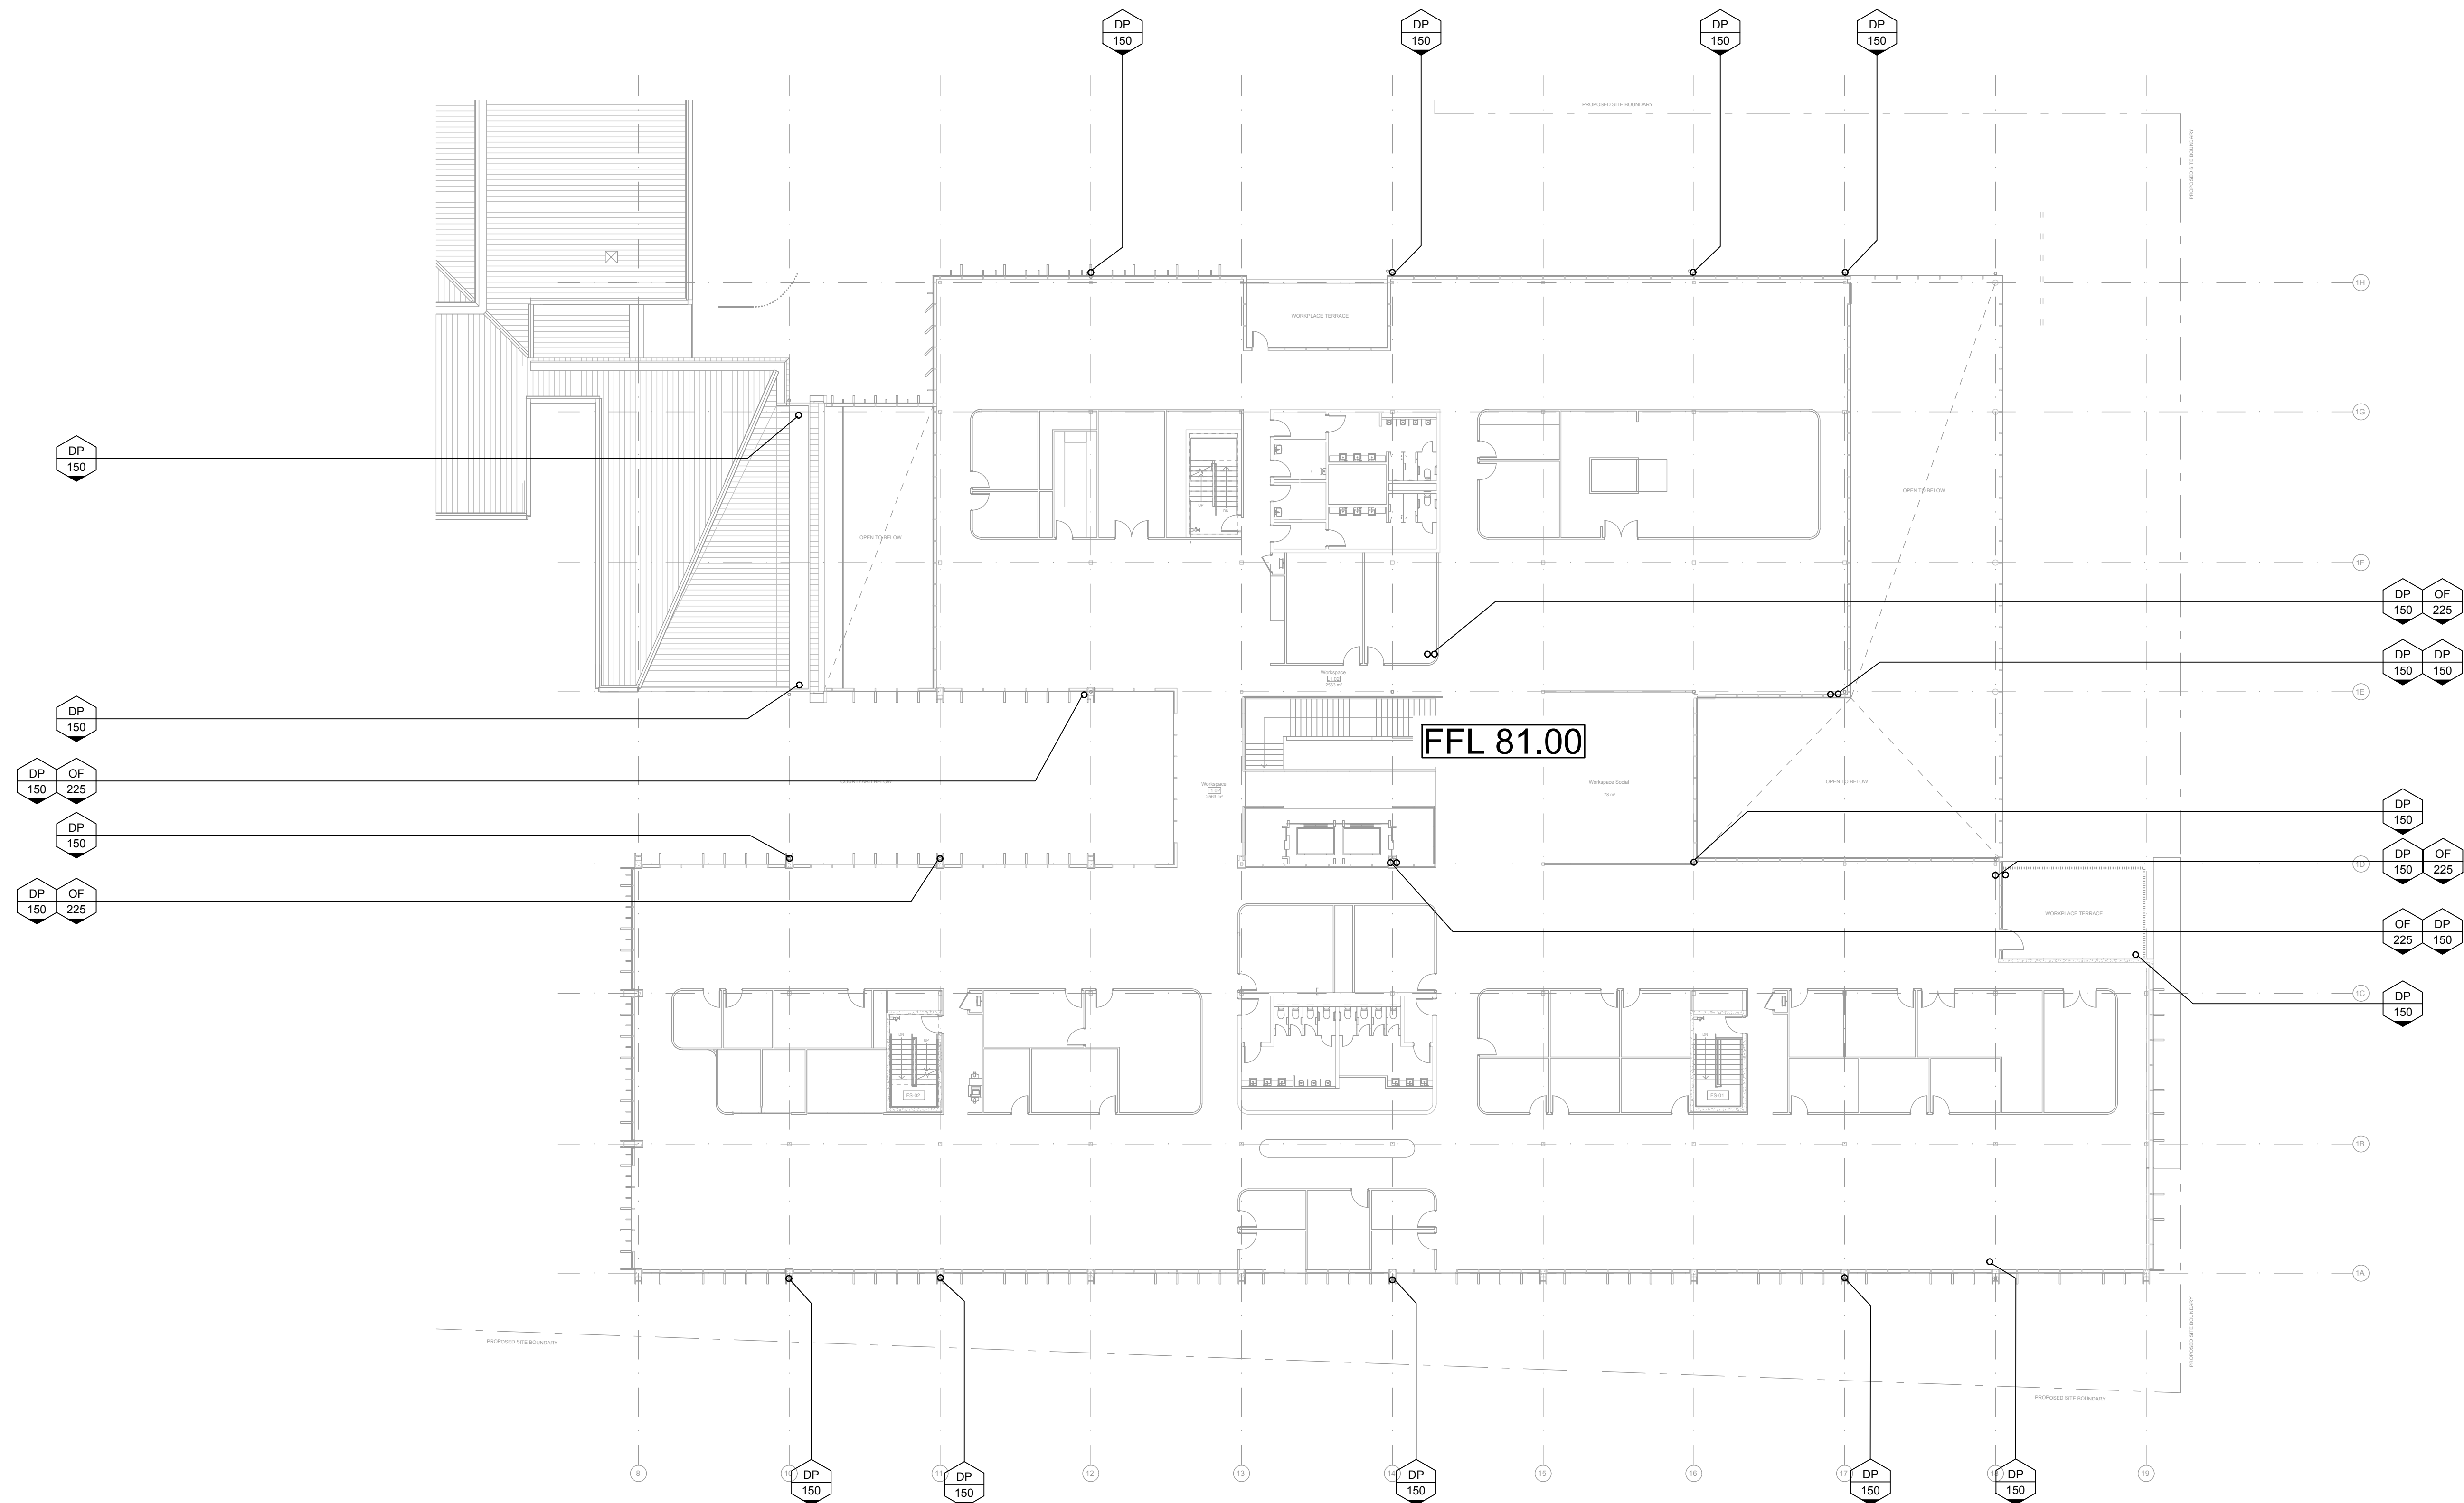

THIS DRAWING IS NOT TO BE
COPIED IN PART OR WHOLE
WITHOUT WRITTEN PERMISSION
FROM LP CONSULTING
AUSTRALIA PTY LTD

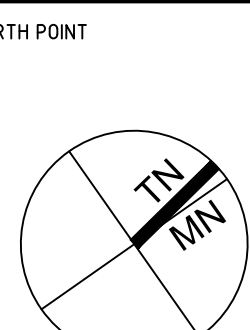

SHEET SIZE: A1

- NOTES
1. REFER TO DRAWING DA-STW-002 FOR DRAWING LIST.
 2. CONTRACTOR TO CHECK AND CONFIRM ALL LEVELS ON SITE.
 3. CONTRACTOR TO INVESTIGATE ALL EXISTING SERVICES, SUCH AS APPLY FOR "DIAL BEFORE YOU DIG" SERVICES PRIOR TO START OF WORKS ON SITE.

ISSUE	AMENDMENT
A	DEVELOPMENT APPLICATION - ISSUE FOR COORDINATION
B	ISSUE FOR DEVELOPMENT APPLICATION
C	ISSUE FOR SSDA

DATE
30.09.2020
16.10.2020
11.11.2020

PROJECT
ROYAL INSTITUTE FOR
DEAF & BLIND CHILDREN
MACQUARIE UNIVERSITY

ARCHITECT

WMK

WMK Architecture
L2 364 Kent
Street
Sydney NSW 2000

PROJECT MANAGER

 
 M PROJECTS

M PROJECTS

Suite C2.08, Level 2
22-36 Mountain Street,
Ultimo NSW 2007

Tel: (02) 9262 5530
Fax: (02) 9262 5529
Web: mprojects.com.au

CLIENT



CONSULTANT



LP CONSULTING
AUSTRALIA PTY LTD

A: Suite 12.01, Level 12, 300 George Street
Sydney NSW Australia 2000
P: GPO Box 2662 Sydney NSW 2001
E: info@lp-consulting.com.au


T: +61 (2) 9223 4444
W: www.lp-consulting.com.au

TITLE	STORMWATER DRAINAGE LEVEL 01 ZONE 1
-------	---

SCALE 1:200 @A1 1:400 @A3	DRAWN WW	DESIGNED LP	CHECKED LP	APPROVE
DATE Nov 11, 2020	DRAWING No.		ISSUE	
JOB No.	DA - STW - 104		C	
2020-1773	STATE SIGN DA			



TITLE STORMWATER DRAINAGE ROOF PLAN ZONE 1				
SCALE 1 : 200 @ A1 1 : 400 @ A3	DRAWN WW	DESIGNED LP	CHECKED LP	APPROVED
DATE Nov 11, 2020	DRAWING No.		ISSUE	
JOB No. 2020-1773	DA - STW - 105		C	
STATE SIGN. DA				

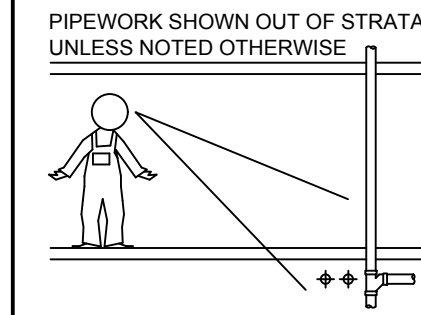

EAVES GUTTER
250mm HALF ROUND

CONCEALED
EAVES GUTTER
200mm HALF ROUND
150mm DOWN PIPE

BOX GUTTER - LOWER ROOF
450mm WIDE X 135mm HIGH
SUMP
WIDTH : 450mm
LENGTH: 600mm
DEPTH: 130mm
DP'S
3 x DN150mm IN SUMP
OVERFLOW
3 x DN 225mm
STANDPIPE O/FLOW
SET 45mm ABOVE GUTTER IL

BOX GUTTER
450mm WIDE X 140mm HIGH
SUMP
WIDTH : 450mm
LENGTH: 600mm
DEPTH: 150mm
DP'S
4 x DN150mm IN SUMP
OVERFLOW
4 x DN 225mm
STANDPIPE O/FLOW
SET 45mm ABOVE GUTTER IL

CONCEALED
EAVES GUTTER
250mm HALF ROUND
10 x 150mm DOWNPIPES

BOX GUTTER
450mm WIDE X 130mm HIGH
SUMP
WIDTH : 450mm
LENGTH: 600mm
DEPTH: 130mm
DP'S
6 x DN150mm IN SUMP
OVERFLOW
6 x DN 225mm IN SUMP
STANDPIPE O/FLOW
SET 40mm ABOVE GUTTER IL

CONCEALED EAVES GUTTER
250mm HALF ROUND 1 x 150mm DOWN PIPES

BOX GUTTER
450mm WIDE X 140mm HIGH
SUMP
WIDTH : 450mm
LENGTH: 600mm
DEPTH: 150mm
DP'S
4 x DN150mm IN SUMP
OVERFLOW
4 x DN 225mm
STANDPIPE O/FLOW
SET 45mm ABOVE GUTTER IL

BOX GUTTER - LOWER ROOF
300mm WIDE X 120mm HIGH
SUMP
WIDTH : 300mm
LENGTH: 600mm
DEPTH: 150mm
WEIR : WEIR OVERFLOW
200mm LENGTH
120mm DEEP
SET 30mm ABOVE IL

EAVES GUTTER
250mm HALF ROUND

BOX GUTTER - LOWER ROOF
450mm WIDE X 135mm HIGH
SUMP
WIDTH : 450mm
LENGTH: 600mm
DEPTH: 130mm
DP'S
3 x DN150mm IN SUMP
OVERFLOW
3 x DN 225mm
STANDPIPE O/FLOW
SET 45mm ABOVE GUTTER IL

DP 150 DP 150 DP 150 DP 150

CONCEALED EAVES GUTTER
250mm HALF ROUND
UPPER ROOF

DP 150

BOX GUTTER
450mm WIDE X 140mm HIGH
SUMP
WIDTH : 450mm
LENGTH: 600mm
DEPTH: 150mm
DP'S
4 x DN150mm IN SUMP
OVERFLOW
4 x DN 225mm
STANDPIPE O/FLOW
SET 45mm ABOVE GUTTER IL

EAVES GUTTER
250mm HALF ROUND
10 x 150mm DOWNPIPES

BOX GUTTER
450mm WIDE X 140mm HIGH
SUMP
WIDTH : 450mm
LENGTH: 600mm
DEPTH: 150mm
DP'S
4 x DN150mm IN SUMP
OVERFLOW
4 x DN 225mm
STANDPIPE O/FLOW
SET 45mm ABOVE GUTTER IL

DP 150 DP 150 DP 150 DP 150


DP 150

CONCEALED EAVES GUTTER
250mm HALF ROUND
1 x 150mm DOWNPIPES


0 2 4 8 12 16 20 metres
SCALE IS BEFORE REDUCTION SCALE 1:200

DO NOT SCALE FROM DRAWINGS. CHECK & VERIFY ALL DIMENSIONS & LEVELS BEFORE COMMENCEMENT OF ANY WORK. THIS DRAWING IS NOT TO BE COPIED IN PART OR WHOLE WITHOUT WRITTEN PERMISSION FROM LP CONSULTING AUSTRALIA PTY LTD	NORTH POINT SHEET SIZE: A1	NOTES 1. REFER TO DRAWING DA-STW-002 FOR DRAWING LIST. 2. CONTRACTOR TO CHECK AND CONFIRM ALL LEVELS ON SITE. 3. CONTRACTOR TO INVESTIGATE ALL EXISTING SERVICES, SUCH AS APPLY FOR "DIAL BEFORE YOU DIG" SERVICES PRIOR TO START OF WORKS ON SITE.	ISSUE A B C AMENDMENT DEVELOPMENT APPLICATION - ISSUE FOR COORDINATION ISSUE FOR DEVELOPMENT APPLICATION ISSUE FOR SSDA	DATE 30.09.2020 16.10.2020 11.11.2020	PROJECT ROYAL INSTITUTE FOR DEAF & BLIND CHILDREN MACQUARIE UNIVERSITY ARCHITECT WMK Architecture L2 364 Kent Street Sydney NSW 2000	PROJECT MANAGER M PROJECTS Suite C2.08, Level 2 22-36 Mountain Street, Ultimo NSW 2007 Tel: (02) 9262 5530 Fax: (02) 9262 5529 Web: mprojects.com.au	CLIENT Royal Institute for Deaf and Blind Children	CONSULTANT LP CONSULTING AUSTRALIA PTY LTD A: Suite 12.01, Level 12, 300 George Street Sydney NSW Australia 2000 P: GPO Box 2662 Sydney NSW 2001 E: info@lp-consulting.com.au T: +61 (2) 9223 4444 W: www.lp-consulting.com.au	TITLE STORMWATER DRAINAGE ROOF PLAN ZONE 2 SCALE 1:200 @ A1 1:400 @ A3 DATE Nov 11, 2020 JOB No. 2020-1773	DRAWN VW DESIGNED LP CHECKED LP APPROVED C STATE SIGN. DA
---	-----------------------------------	--	--	--	--	---	--	--	---	---

Xref: 2020-1773_X4\\TITLE.BAK
Plot Date: 11/11/2020 15:50:43 Cpl File: Z:\\p\\da\\20201773\\DRAWINGS\\DRAWINGS - WORKING\\STORMWATER\\2020-1773_DA-STW-300.dwg

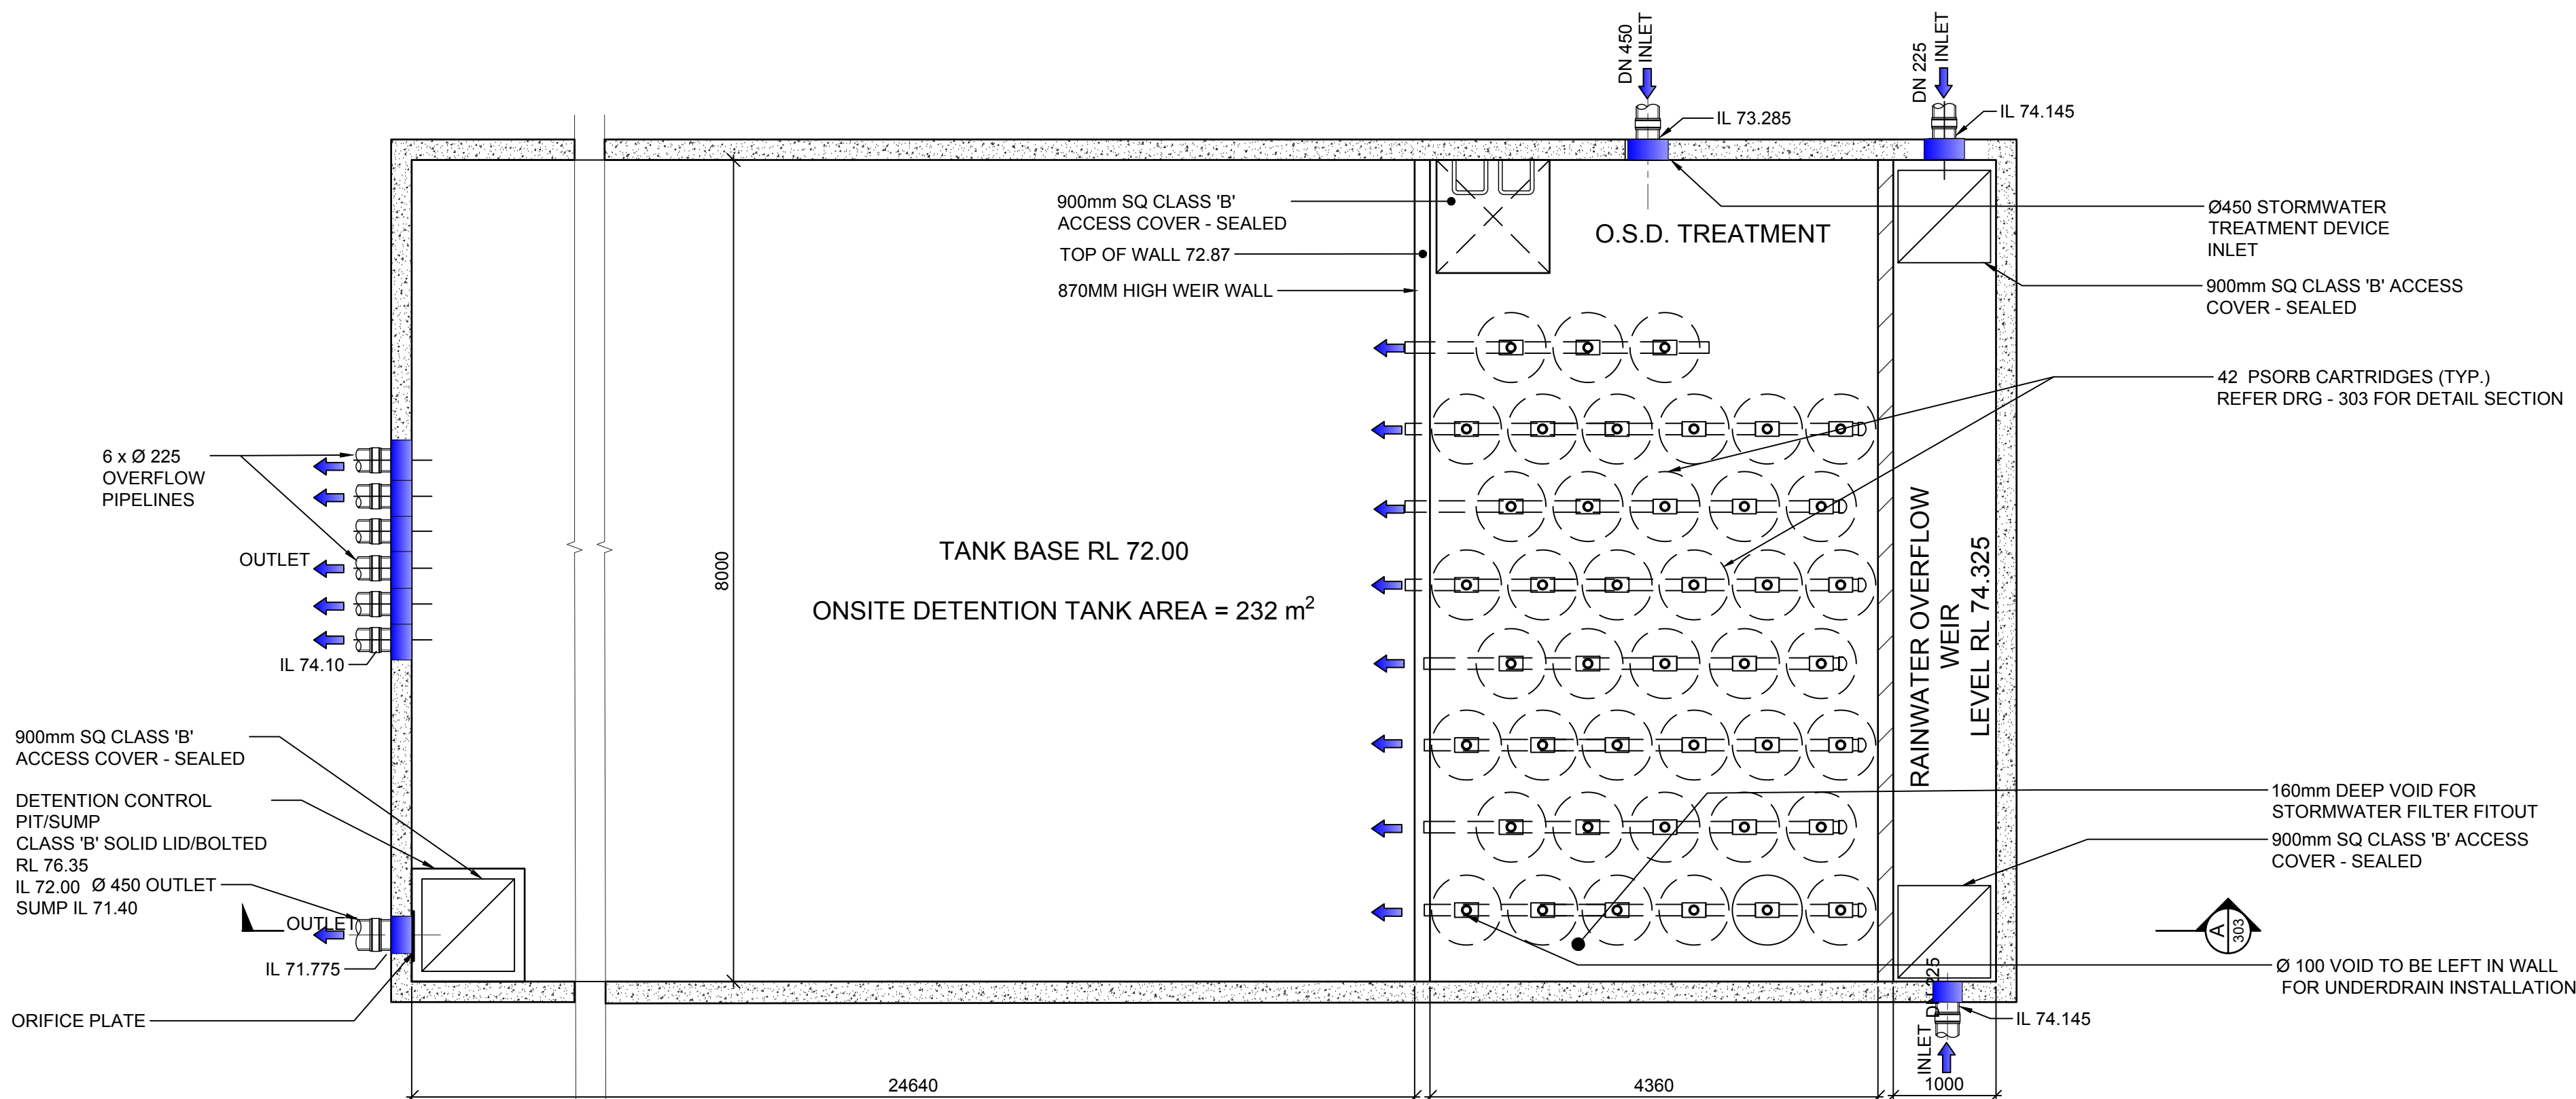

DETENTION TANK DETAIL - PLAN
SCALE: 1 : 50

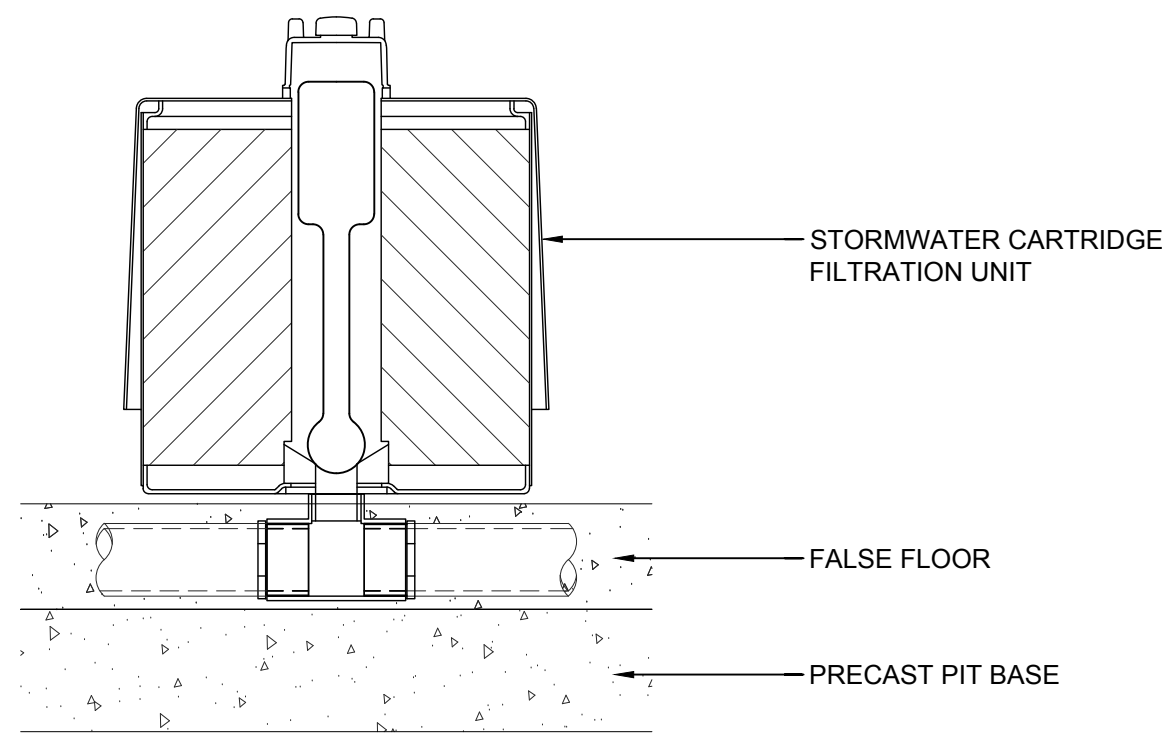

STORMWATER CARTRIDGE DETAIL
302

GENERAL NOTES

- STORMFILTER IS PROVIDED WITH OPENINGS AT INLET AND OUTLET LOCATIONS.
- IF THE PEAK FLOW RATE, AS DETERMINED BY THE SITE CIVIL ENGINEER, EXCEEDS THE PEAK HYDRAULIC CAPACITY OF THE PRODUCT, AN UPSTREAM BYPASS STRUCTURE IS REQUIRED. PLEASE CONTACT STORMWATER360 FOR OPTIONS.
- THE FILTER CARTRIDGE(S) ARE SIPHON-ACTUATED AND SELF-CLEANING. THE STANDARD DETAIL DRAWING SHOWS THE MAXIMUM NUMBER OF CARTRIDGES. THE ACTUAL NUMBER SHALL BE SPECIFIED BY THE SITE CIVIL ENGINEER ON SITE PLANS OR IN DATA TABLE BELOW. CONCRETE STRUCTURE TO BE PROVIDED BY OTHERS.
- SEE STORMFILTER DESIGN TABLE FOR REQUIRED HYDRAULIC DROP. FOR SHALLOW, LOW DROP OR SPECIAL DESIGN CONSTRAINTS, CONTACT STORMWATER360 FOR DESIGN OPTIONS.
- ALL WATER QUALITY PRODUCTS REQUIRE PERIODIC MAINTENANCE AS OUTLINED IN THE O&M GUIDELINES. PROVIDE MINIMUM CLEARANCE FOR MAINTENANCE ACCESS.
- STRUCTURE AND ACCESS COVERS DESIGNED BY OTHERS. ACCESS COVERS TO BE A MINIMUM 900X900 ABOVE CARTRIDGES.
- THE STRUCTURE THICKNESSES SHOWN ARE FOR REPRESENTATIONAL PURPOSES AND VARY REGIONALLY.
- ANY BACKFILL DEPTH, SUB-BASE, AND OR ANTI-FLOTATION PROVISIONS ARE SITE-SPECIFIC DESIGN CONSIDERATIONS AND SHALL BE SPECIFIED BY SITE CIVIL ENGINEER.
- CARTRIDGE HEIGHT AND ASSOCIATED DESIGN PARAMETERS PER STORMFILTER DESIGN TABLE.
- STORMFILTER BY STORMWATER360: SYDNEY (AU) PHONE: 1300 354 722 www.stormwater360.com.au

STORMFILTER DESIGN TABLE

- THE SIZE 4.5 x 3.0m STORMFILTER TREATMENT CAPACITY VARIES BY NUMBER OF FILTER CARTRIDGES INSTALLED AND BY REGION SPECIFIC INTERNAL FLOW CONTROLS.
- THE STANDARD CONFIGURATION IS SHOWN. ACTUAL CONFIGURATION OF THE SPECIFIED STRUCTURE(S) PER CIVIL ENGINEER WILL BE SHOWN ON SUBMITTAL DRAWING(S).
- ALL PARTS PROVIDED AND INTERNAL ASSEMBLY BY STORMWATER360 UNLESS OTHERWISE NOTED.


CARTRIDGE HEIGHT	690		460		310	
SYSTEM HYDRAULIC DROP (H - REQ'D. MIN.)	930		700		550	
TREATMENT BY MEDIA SURFACE AREA L/S/m2	1.4	0.7	1.4	0.7	1.4	0.7
CARTRIDGE FLOW RATE (L/s)	1.42	0.71	0.95	0.47	0.63	0.32

SITE SPECIFIC DATA REQUIREMENTS

STRUCTURE ID	XXX
WATER QUALITY FLOW RATE (L/S)	XXX
PEAK FLOW RATE (L/S)	XXX
RETURN PERIOD OF PEAK FLOW (yrs)	6 MONTH
# OF CARTRIDGES REQUIRED	42
CARTRIDGE HEIGHT (310, 460 or 690mm)	690
MEDIA TYPE (PERLITE, PERLITE/ZEOLITE OR ZPG)	ZPG


PRECAST VAULT WEIGHT	- kg
PRECAST LID WEIGHT	- kg

PIPE DATA:	I.L.	MATERIAL	DIAMETER
INLET PIPE #1	73.285	MATERIAL	PVC
INLET PIPE #2	XXX	MATERIAL	PVC
OUTLET PIPE	74.10	MATERIAL	PVC

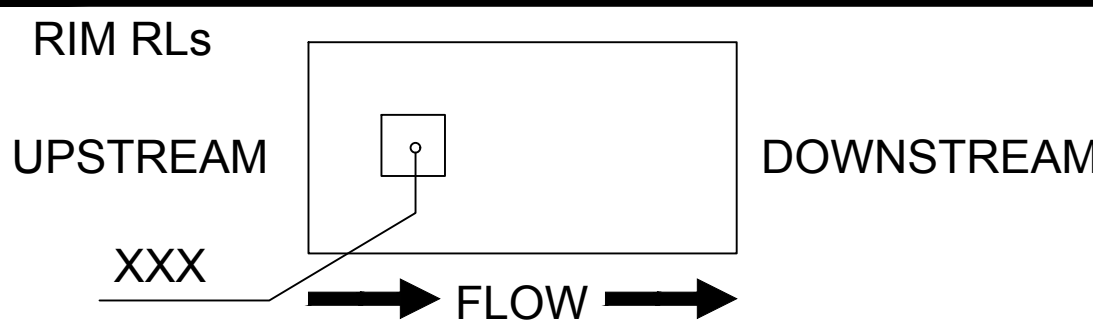

DO NOT SCALE FROM DRAWINGS. CHECK & VERIFY ALL DIMENSIONS & LEVELS BEFORE COMMENCEMENT OF ANY WORK.

THIS DRAWING IS NOT TO BE COPIED IN PART OR WHOLE WITHOUT WRITTEN PERMISSION FROM LP CONSULTING AUSTRALIA PTY LTD

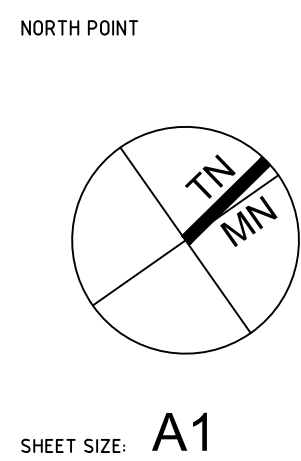

- NOTES
- REFER TO DRAWING DA-STW-002 FOR DRAWING LIST.
 - CONTRACTOR TO CHECK AND CONFIRM ALL LEVELS ON SITE.
 - CONTRACTOR TO INVESTIGATE ALL EXISTING SERVICES, SUCH AS APPLY FOR "DIAL BEFORE YOU DIG" SERVICES PRIOR TO START OF WORKS ON SITE.

ISSUE	AMENDMENT	DATE
A	DEVELOPMENT APPLICATION - ISSUE FOR COORDINATION	30.09.2020
B	ISSUE FOR DEVELOPMENT APPLICATION	16.10.2020
C	ISSUE FOR SSDA	11.11.2020

PROJECT
ROYAL INSTITUTE FOR
DEAF & BLIND CHILDREN
MACQUARIE UNIVERSITY

ARCHITECT
WMK
WMK Architecture
L2 364 Kent
Street
Sydney NSW 2000

PROJECT MANAGER
M PROJECTS
Suite C2.08, Level 2
22-36 Mountain Street,
Ultimo NSW 2007
Tel: (02) 9262 5530
Fax: (02) 9262 5529
Web: mprojects.com.au




CONSULTANT
LP CONSULTING
AUSTRALIA PTY LTD
A: Suite 12.01, Level 12, 300 George Street
Sydney NSW Australia 2000
P: GPO Box 2662 Sydney NSW 2001
E: info@lp-consulting.com.au
T: +61 (2) 9223 4444
W: www.lp-consulting.com.au

TITLE
STORMWATER DRAINAGE
DETENTION TANK PLAN


SCALE	DRAWN	DESIGNED	CHECKED	APPROVED
1 : 50 @ A1 1 : 100 @ A3	VW	LP	LP	LP
DATE Nov 11, 2020	DRAWING No. DA - STW - 300	ISSUE C		
JOB No. 2020-1773				STATE SIGN. DA

Xref: 2020-1773_X4-TITLE.BAK-A1
Plot Date: 11/11/2020 15:50:48 Log Name: M02a41
Caf File: Z:\projects\20201773\DRAWINGS\DRAWINGS - WORKING\STORMWATER\2020-1773_DA-STW-301.dwg

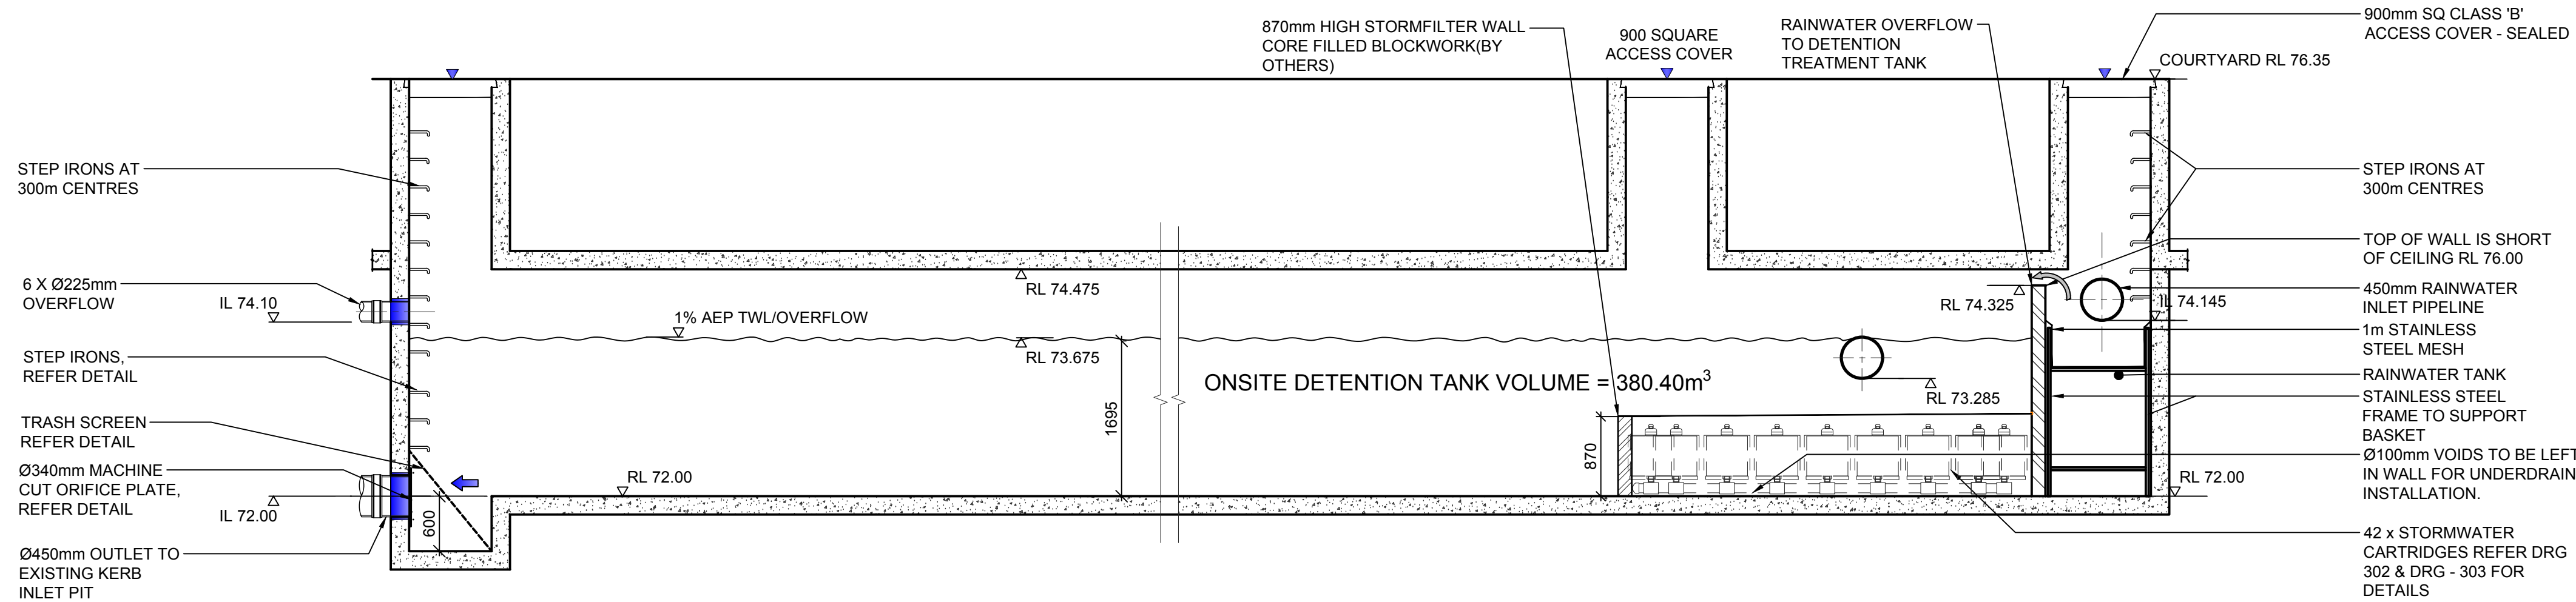

DETENTION TANK DETAIL - SECTION A-300

SCALE: 1 : 50

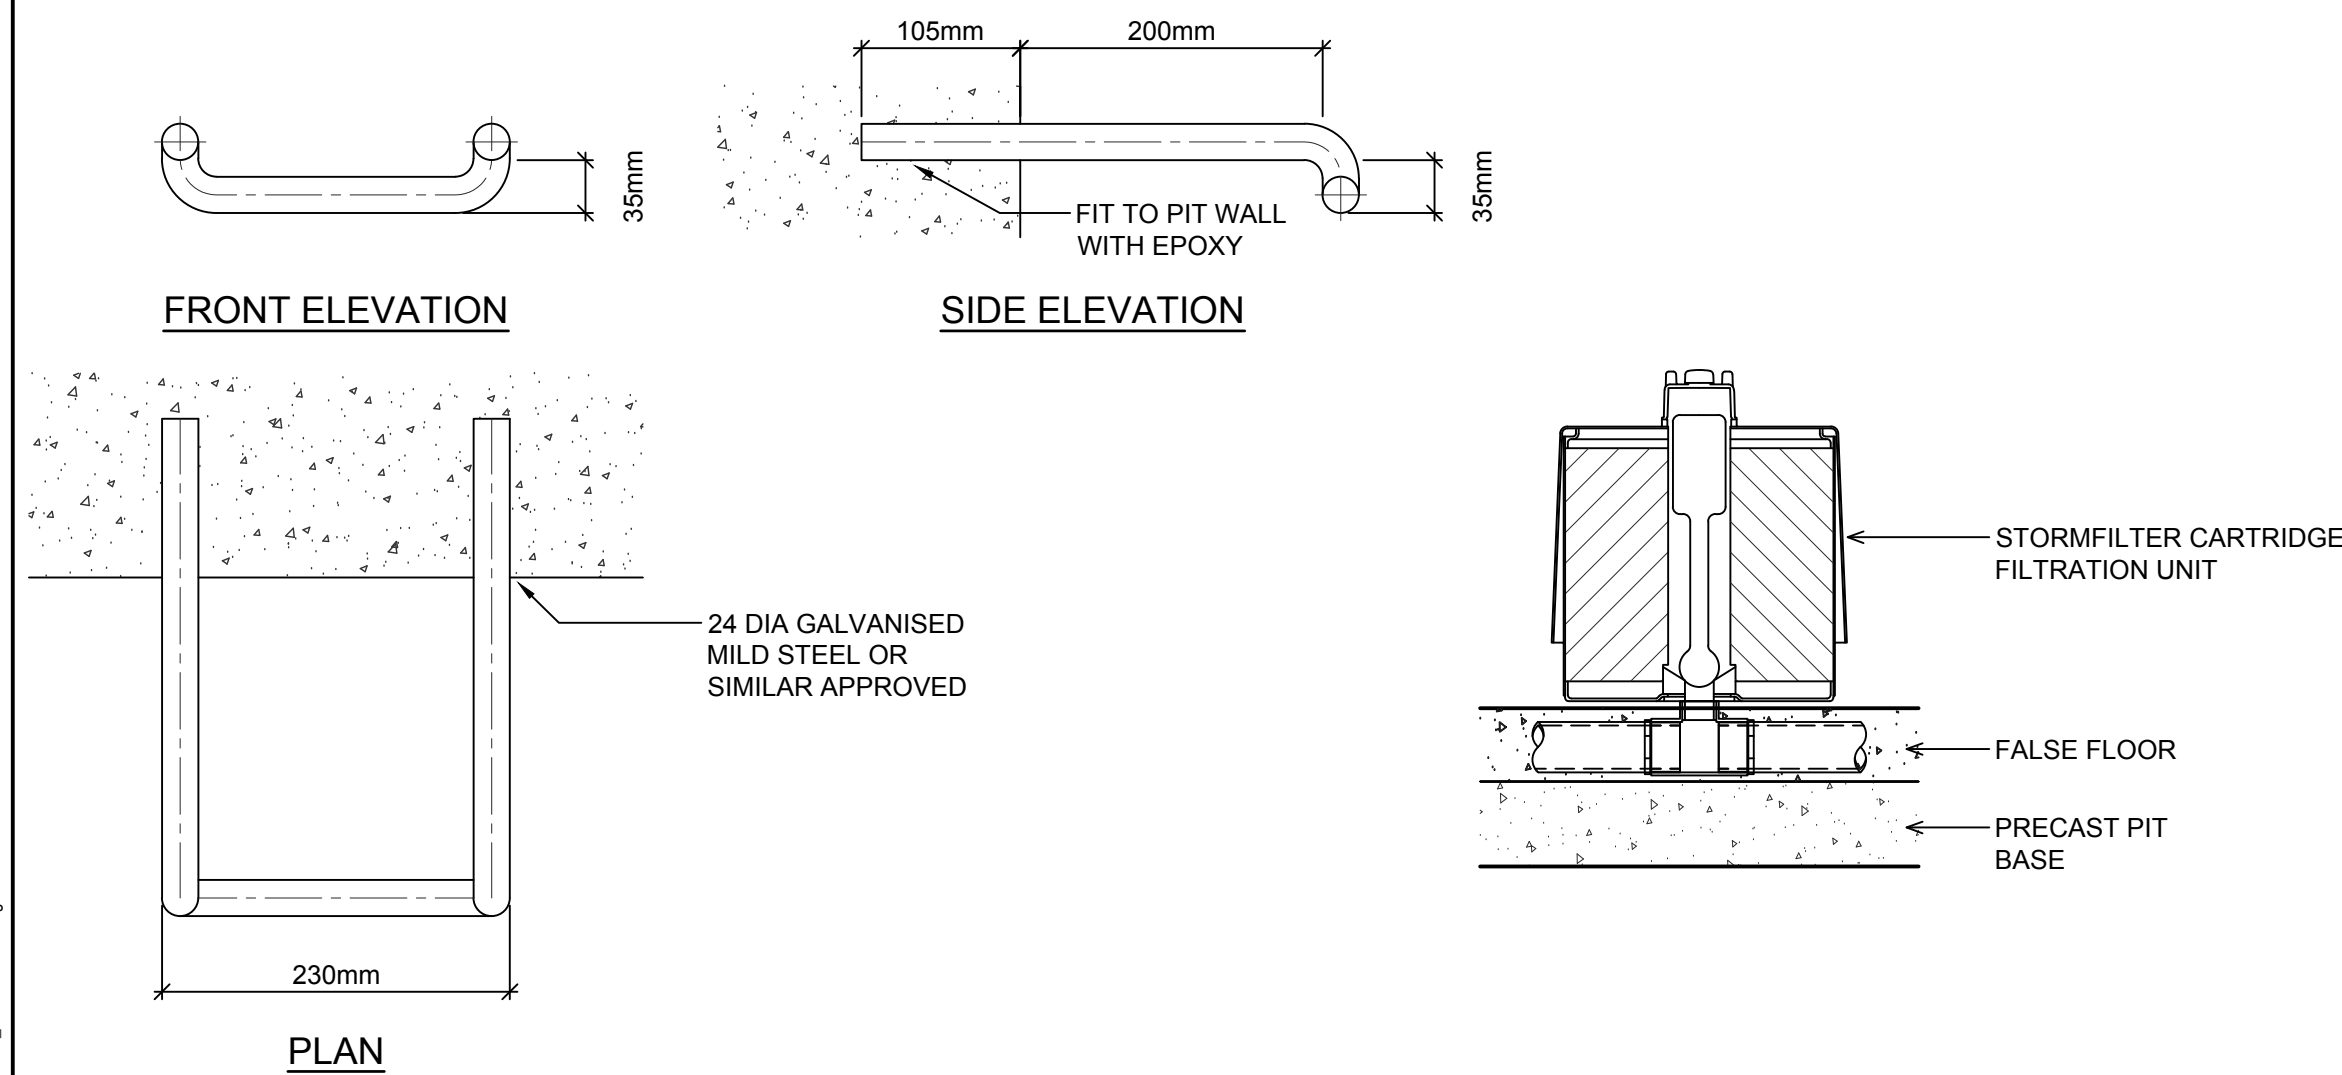


DETAIL STEP IRONS D6

SCALE: 1:5



DETAIL STORMFILTER CARTRIDGE D3

NOT TO SCALE

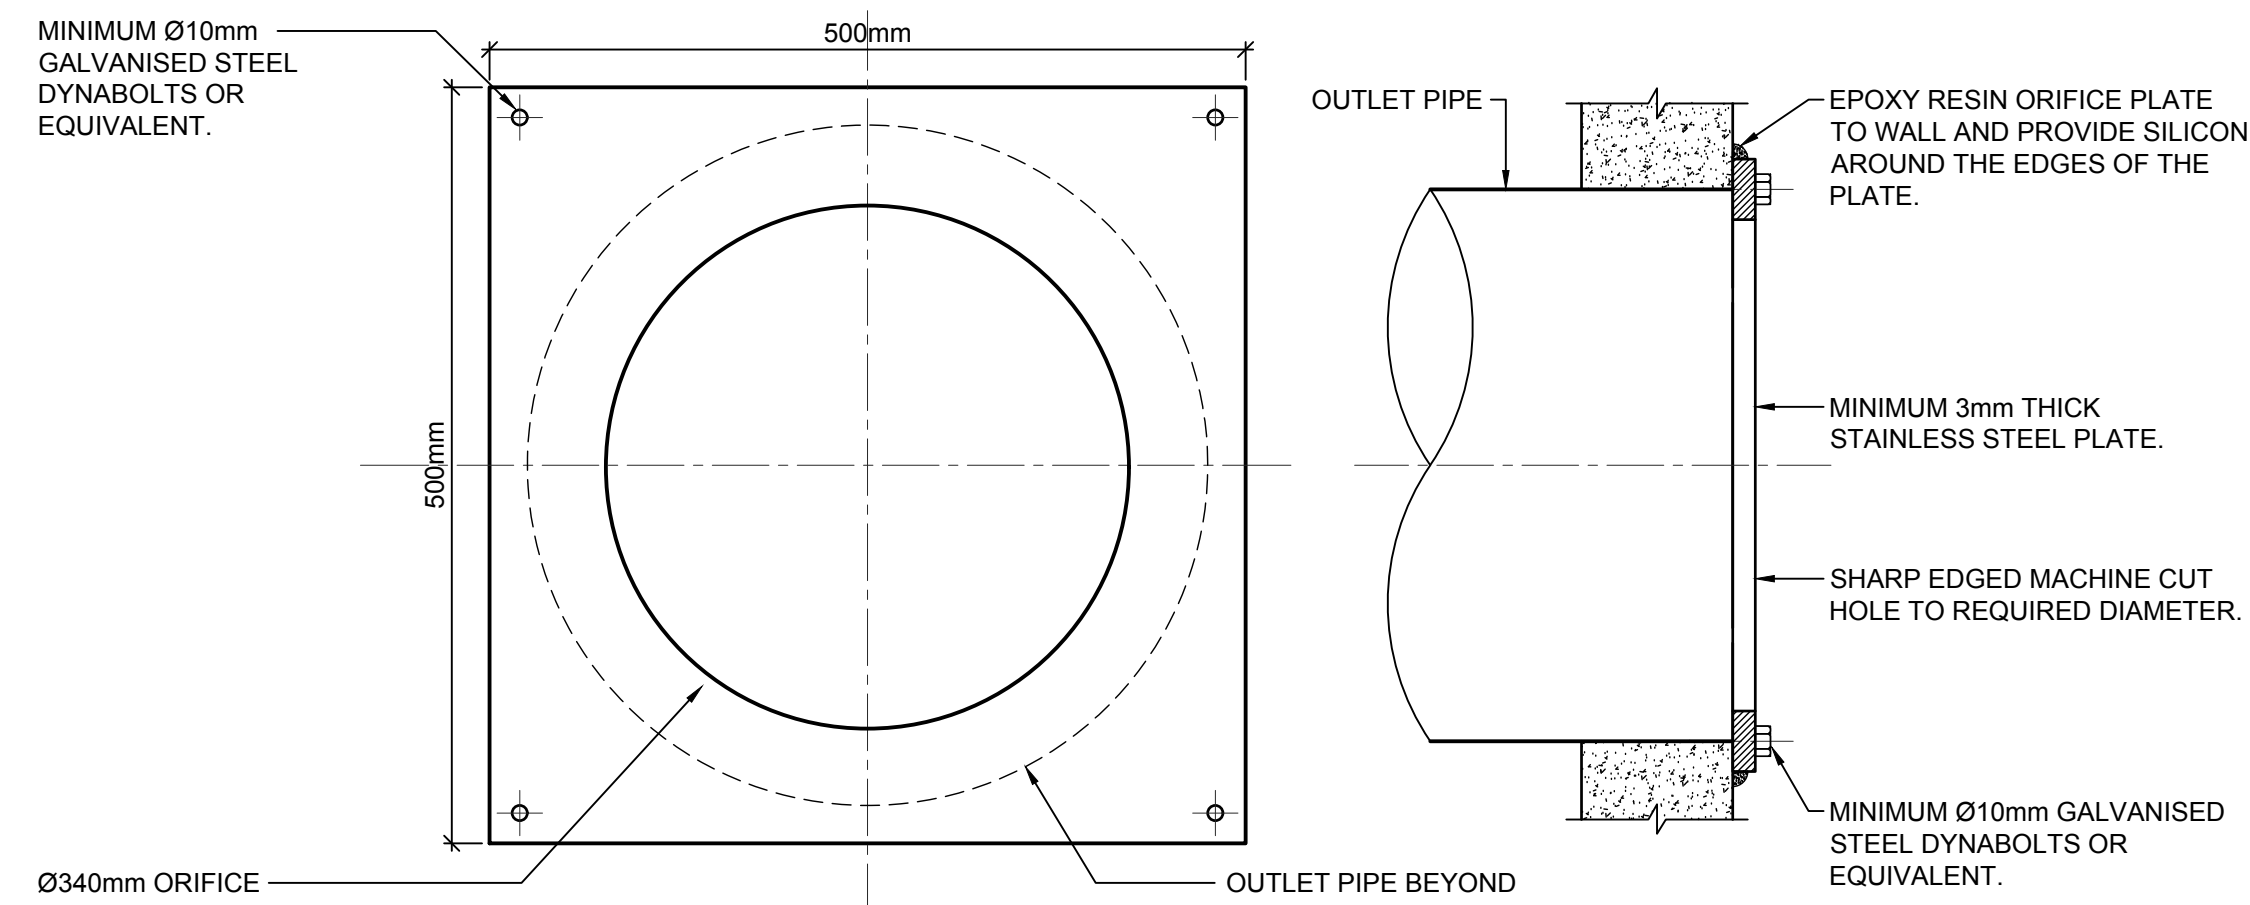

ORIFICE PLATE DETAIL D5

 
SCALE: 1:5

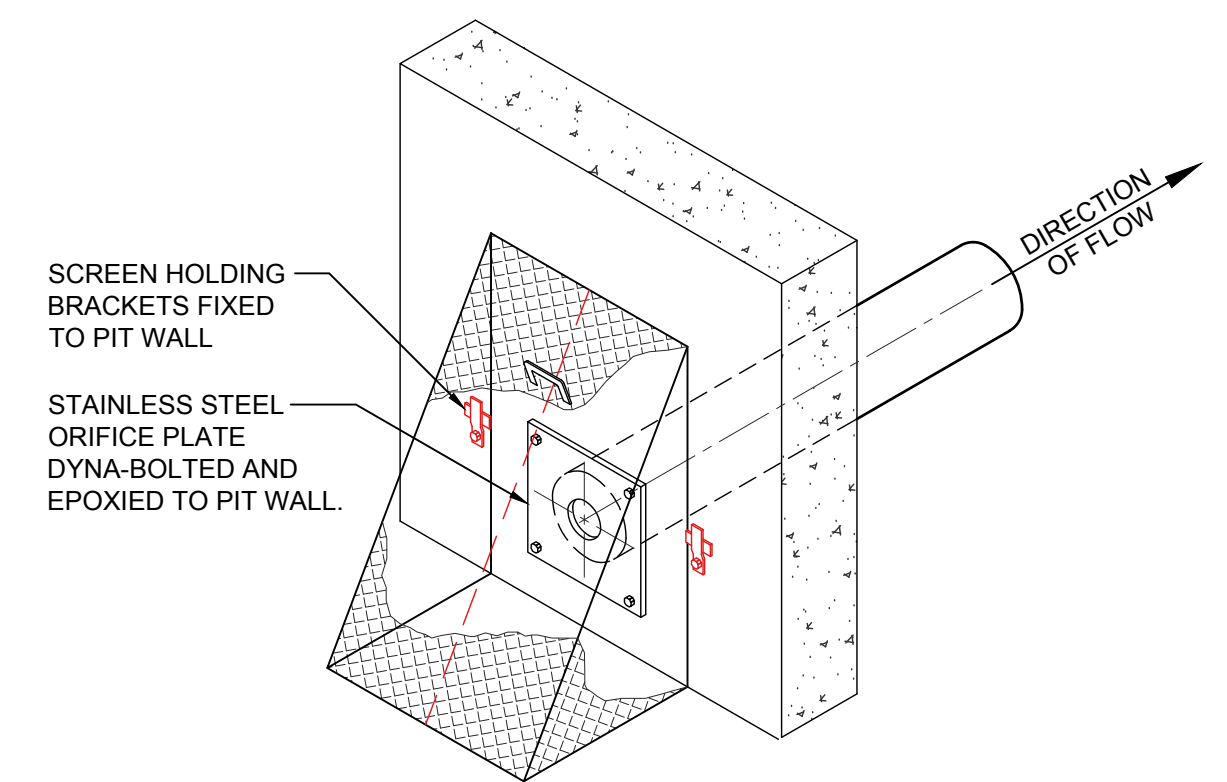


DO NOT SCALE FROM DRAWINGS. CHECK & VERIFY ALL DIMENSIONS & LEVELS BEFORE COMMENCEMENT OF ANY WORK.

STATE SIGN. DA

X:\06 - 2020\1773 - SS SURVEY\2020\1773 - SS SURVEY\06 - PLAN\1773 - SS CONSULTING BUILDING PLAN
Rev Date: 11.11.2020 15:57:23 Log Name: Michael Cad File: Z:\projects\2020\1773\DRAWINGS\DRAWINGS - WORKING\06\1773_DAC-188.dwg


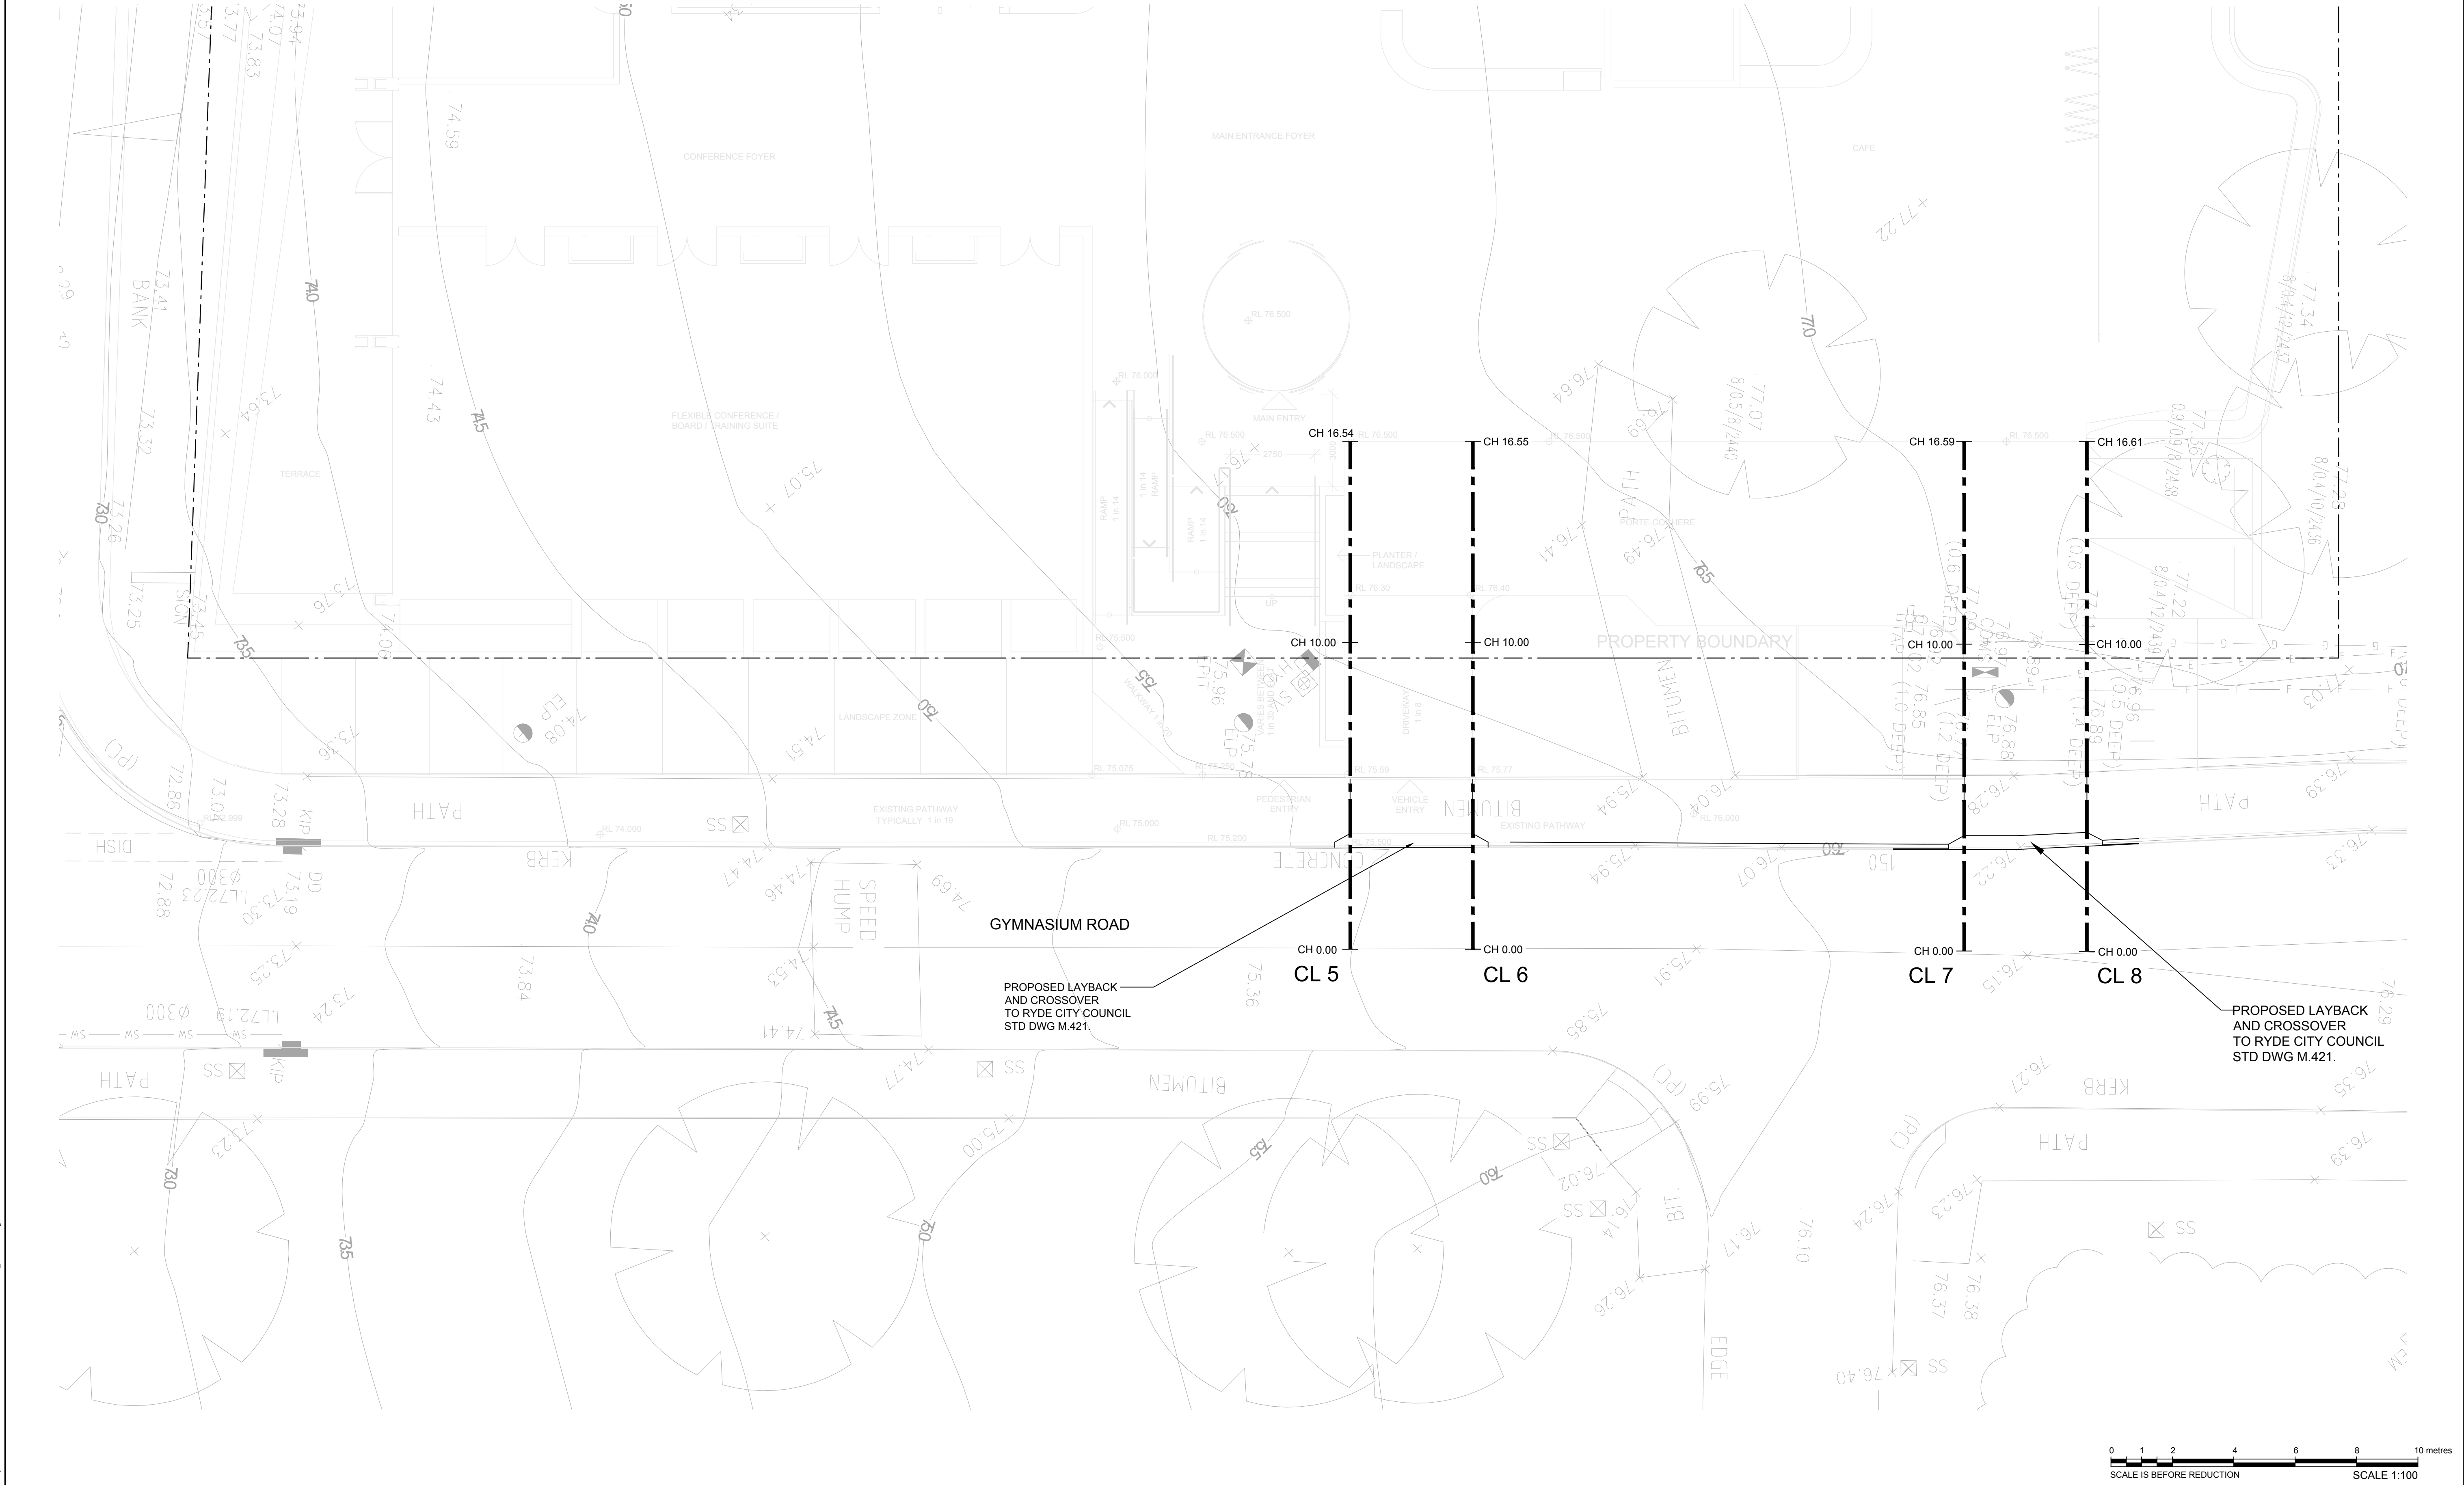


DO NOT SCALE FROM DRAWINGS. CHECK & VERIFY ALL DIMENSIONS & LEVELS BEFORE COMMENCEMENT OF ANY WORK.		North SHEET SIZE: A1	NOTES 1. REFER TO DRAWING DA-STW-002 FOR DRAWING LIST. 2. CONTRACTOR TO CHECK AND CONFIRM ALL LEVELS ON SITE. 3. CONTRACTOR TO INVESTIGATE ALL EXISTING SERVICES, SUCH AS APPLY FOR "DIAL BEFORE YOU DIG" SERVICES PRIOR TO START OF WORKS ON SITE.		ISSUE A B C	AMENDMENT DEVELOPMENT APPLICATION - ISSUE FOR COORDINATION ISSUE FOR DEVELOPMENT APPLICATION ISSUE FOR SSDA	DATE 30.09.2020 16.10.2020 11.11.2020	PROJECT ROYAL INSTITUTE FOR DEAF & BLIND CHILDREN MACQUARIE UNIVERSITY ARCHITECT WMK Architecture L2 364 Kent Street Sydney NSW 2000	PROJECT MANAGER M PROJECTS Suite C2.08, Level 2 22-36 Mountain Street, Ultimo NSW 2007 Tel: (02) 9262 5530 Fax: (02) 9262 5529 Web: mprojects.com.au	CLIENT Royal Institute for Deaf and Blind Children	CONSULTANT LP CONSULTING AUSTRALIA PTY LTD A: Suite 12.01, Level 12, 300 George Street Sydney NSW Australia 2000 P: GPO Box 2662 Sydney NSW 2001 E: info@lp-consulting.com.au T: +61 (2) 9223 4444 W: www.lp-consulting.com.au	TITLE CONSULTING BUILDING DRIVEWAY ENTRY LAYOUT PLAN SCALE 1:100 @ A1 1:200 @ A3 DATE Nov 11, 2020 JOB No. 2020-1773 DRAWN WW DESIGNED LP CHECKED LP APPROVED LP DA - C - 108 STATE SIGN. DA C				
THIS DRAWING IS NOT TO BE COPIED IN PART OR WHOLE WITHOUT WRITTEN PERMISSION FROM LP CONSULTING AUSTRALIA PTY LTD																

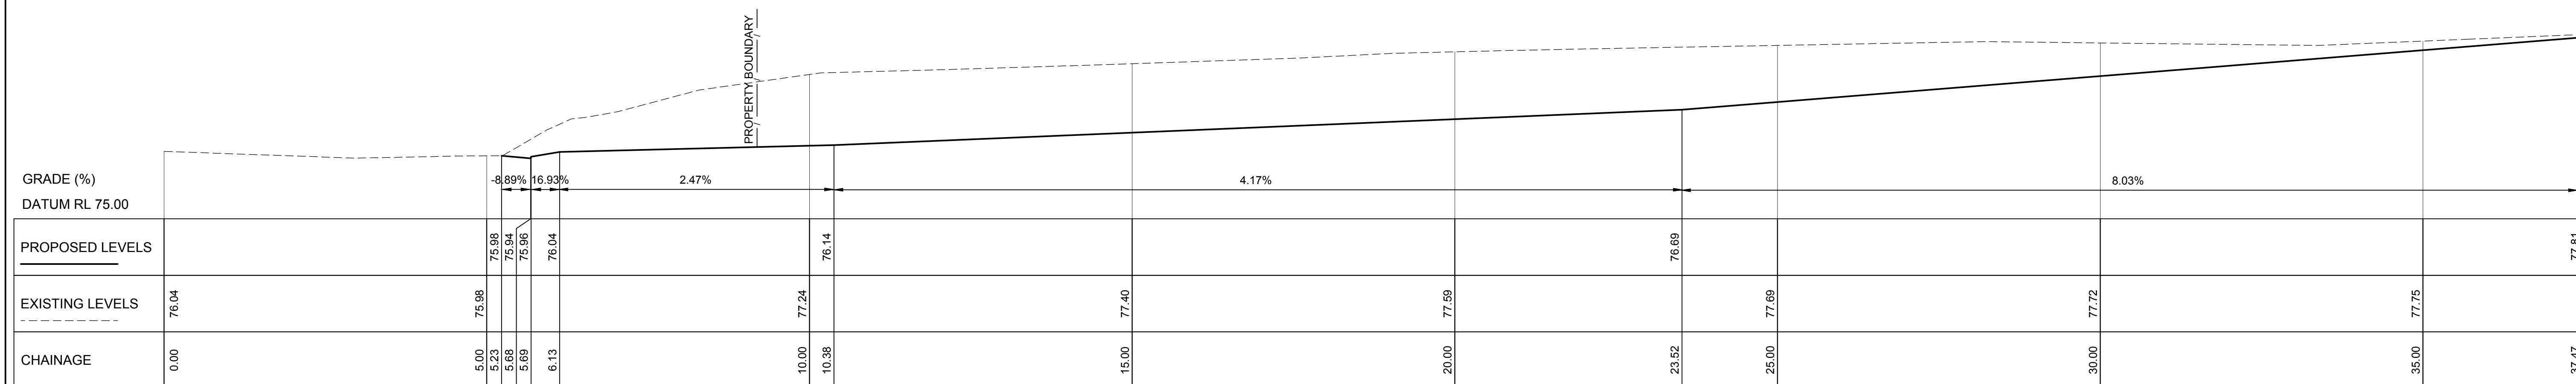


LONGITUDINAL SECTION
CL 1

 SCALE 1:50 (HORIZONTAL)
1:50 (VERTICAL)

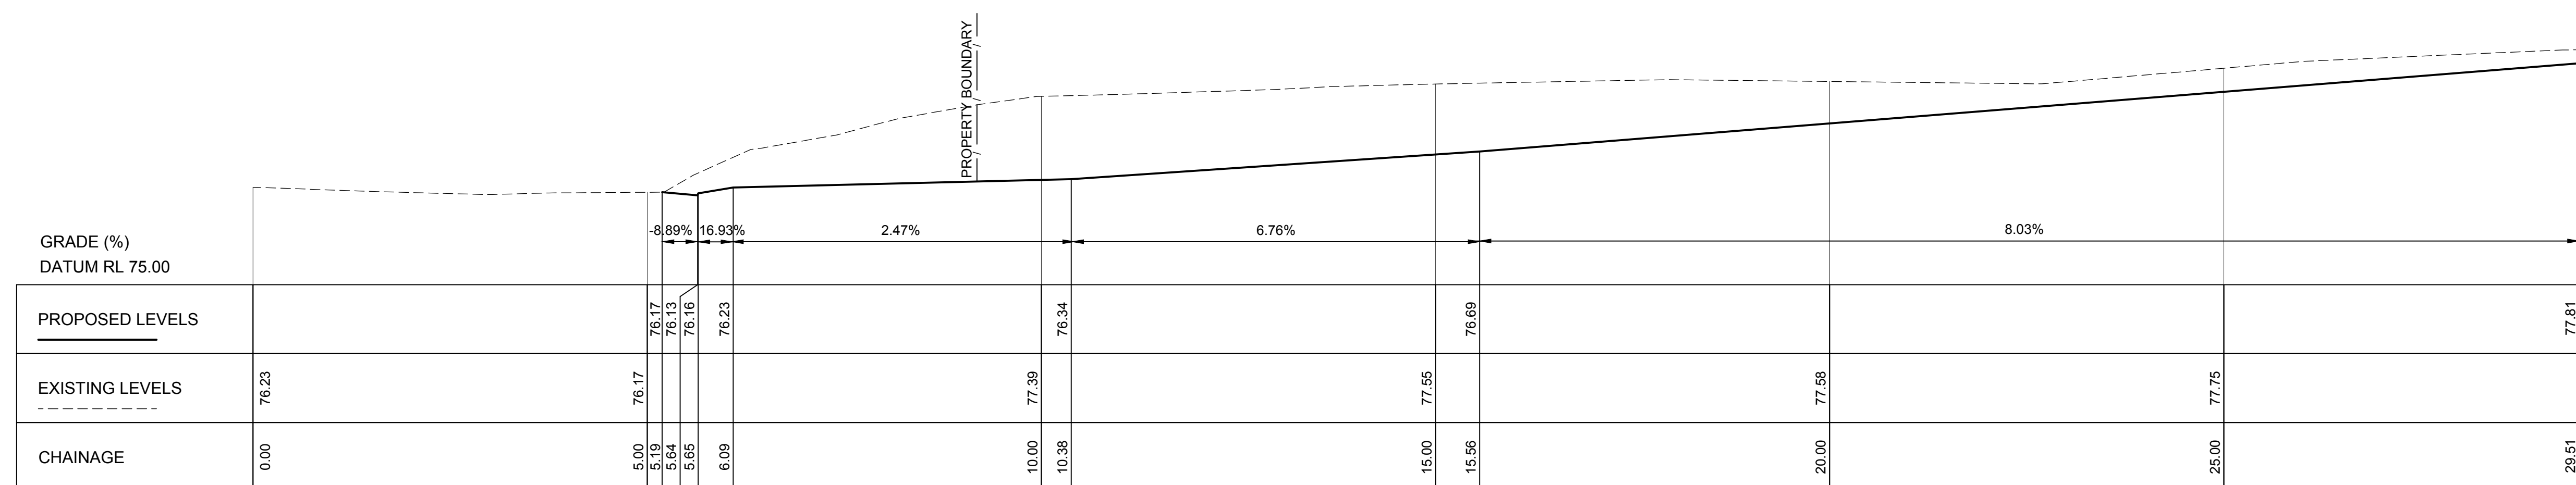




LONGITUDINAL SECTION
CL 2

 SCALE 1:50 (HORIZONTAL)
1:50 (VERTICAL)



DO NOT SCALE FROM DRAWINGS, CHECK & VERIFY ALL DIMENSIONS & LEVELS BEFORE COMMENCEMENT OF ANY WORK. THIS DRAWING IS NOT TO BE COPIED IN PART OR WHOLE WITHOUT WRITTEN PERMISSION FROM LP CONSULTING AUSTRALIA PTY LTD	NORTH POINT	NOTES - REFER TO DRAWING DA-STW-002 FOR DRAWING LIST. - CONTRACTOR TO CHECK AND CONFIRM ALL LEVELS ON SITE. - CONTRACTOR TO INVESTIGATE ALL EXISTING SERVICES, SUCH AS APPLY FOR "DIAL BEFORE YOU DIG" SERVICES PRIOR TO START OF WORKS ON SITE.	ISSUE A B C	AMENDMENT DEVELOPMENT APPLICATION - ISSUE FOR COORDINATION ISSUE FOR DEVELOPMENT APPLICATION ISSUE FOR SSDA	DATE 30.09.2020 16.10.2020 11.11.2020	PROJECT ROYAL INSTITUTE FOR DEAF & BLIND CHILDREN MACQUARIE UNIVERSITY	PROJECT MANAGER M PROJECTS Suite C2.08, Level 2 22-36 Mountain Street, Ultimo NSW 2007 Tel: (02) 9262 5530 Fax: (02) 9262 5529 Web: mprojects.com.au	CLIENT  Royal Institute for Deaf and Blind Children	CONSULTANT  LP CONSULTING AUSTRALIA PTY LTD A: Suite 12.01, Level 12, 300 George Street Sydney NSW Australia 2000 P: GPO Box 2662 Sydney NSW 2001 E: info@lp-consulting.com.au T: +61 (2) 9223 4444 W: www.lp-consulting.com.au	TITLE SCHOOL BUILDING CL 1 AND 2 LONGITUDINAL SECTIONS	SCALE 1:50 @ A1 1:100 @ A3	DRAWN WW	DESIGNED LP	CHECKED LP	APPROVED	DATE Nov 11, 2020	DRAWING No. DA - C - 109	ISSUE C	JOB No. 2020-1773	STATE SIGN. DA
---	--------------------	---	-----------------------------------	---	---	--	--	--	--	--	---------------------------------------	-----------------	--------------------	-------------------	-----------------	--------------------------	---------------------------------	----------------	--------------------------	-----------------------

 Xref: 2020-1773_X4-TITLE-BLK-A1
Prel Date: 11.11.2020@15:58:07 Logn Name: Michael Cad File: Z:\projects\20201773\DRAWINGS\DRAWINGS - WORKING\CIVIL\0203-1773_DA-C-109-12.dwg

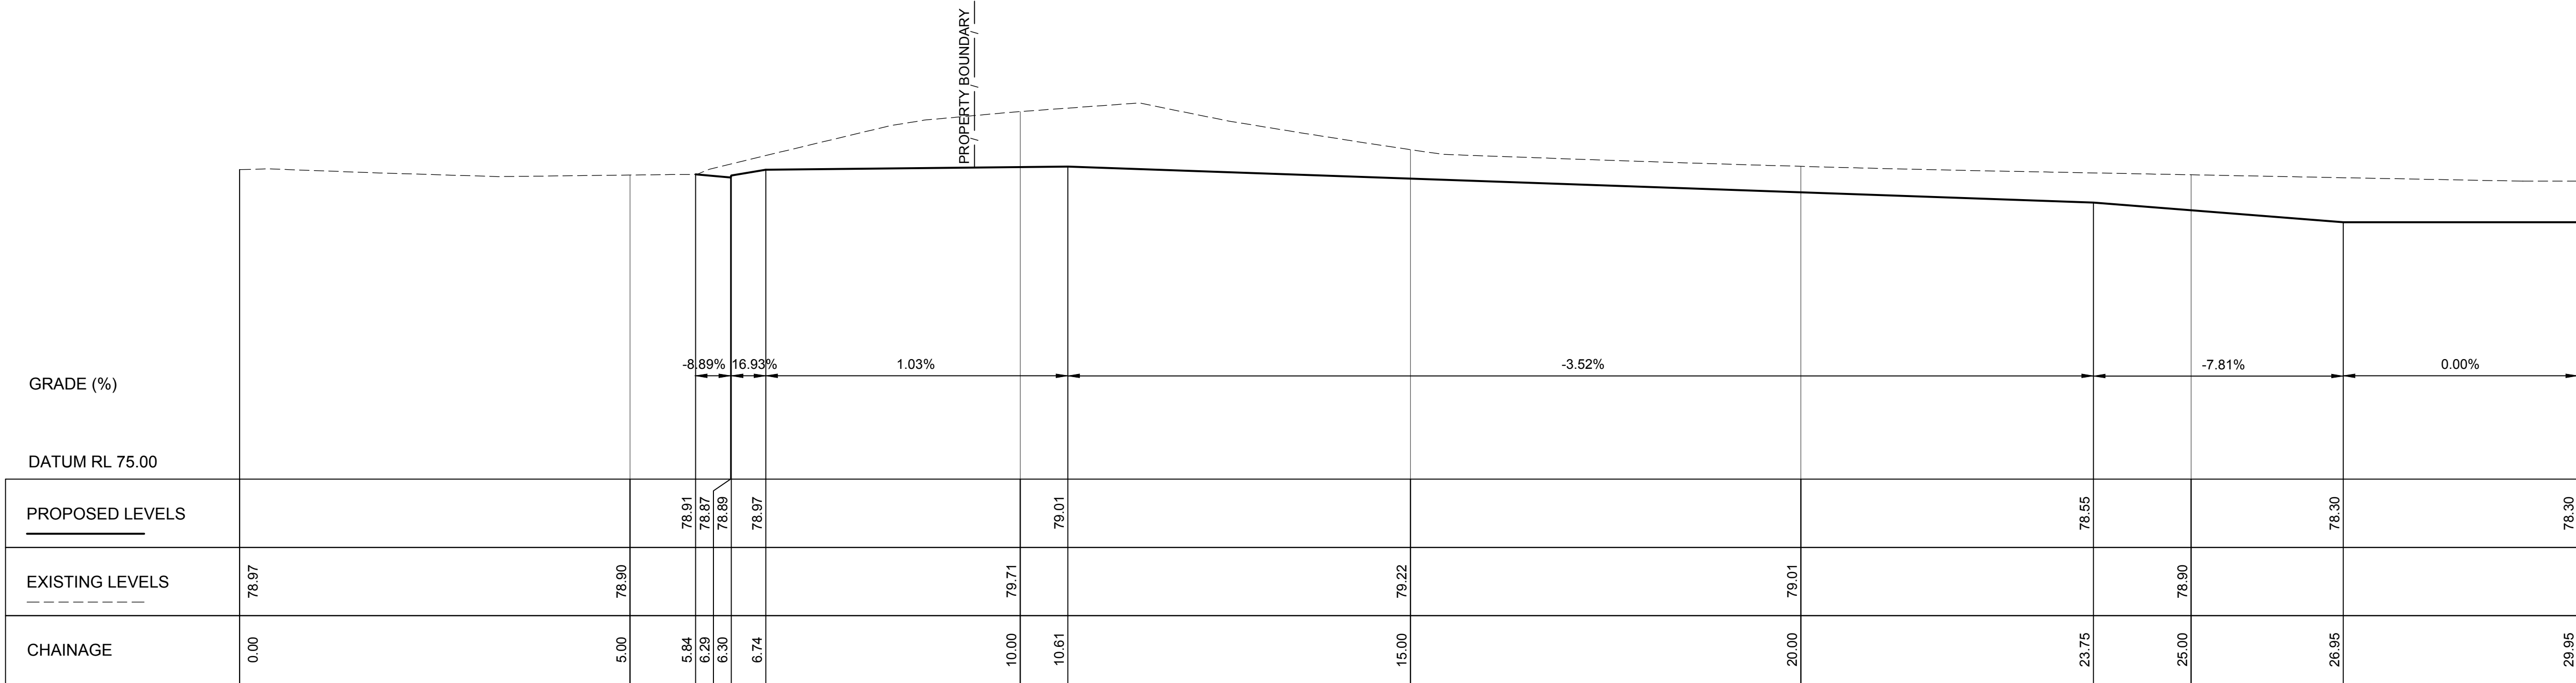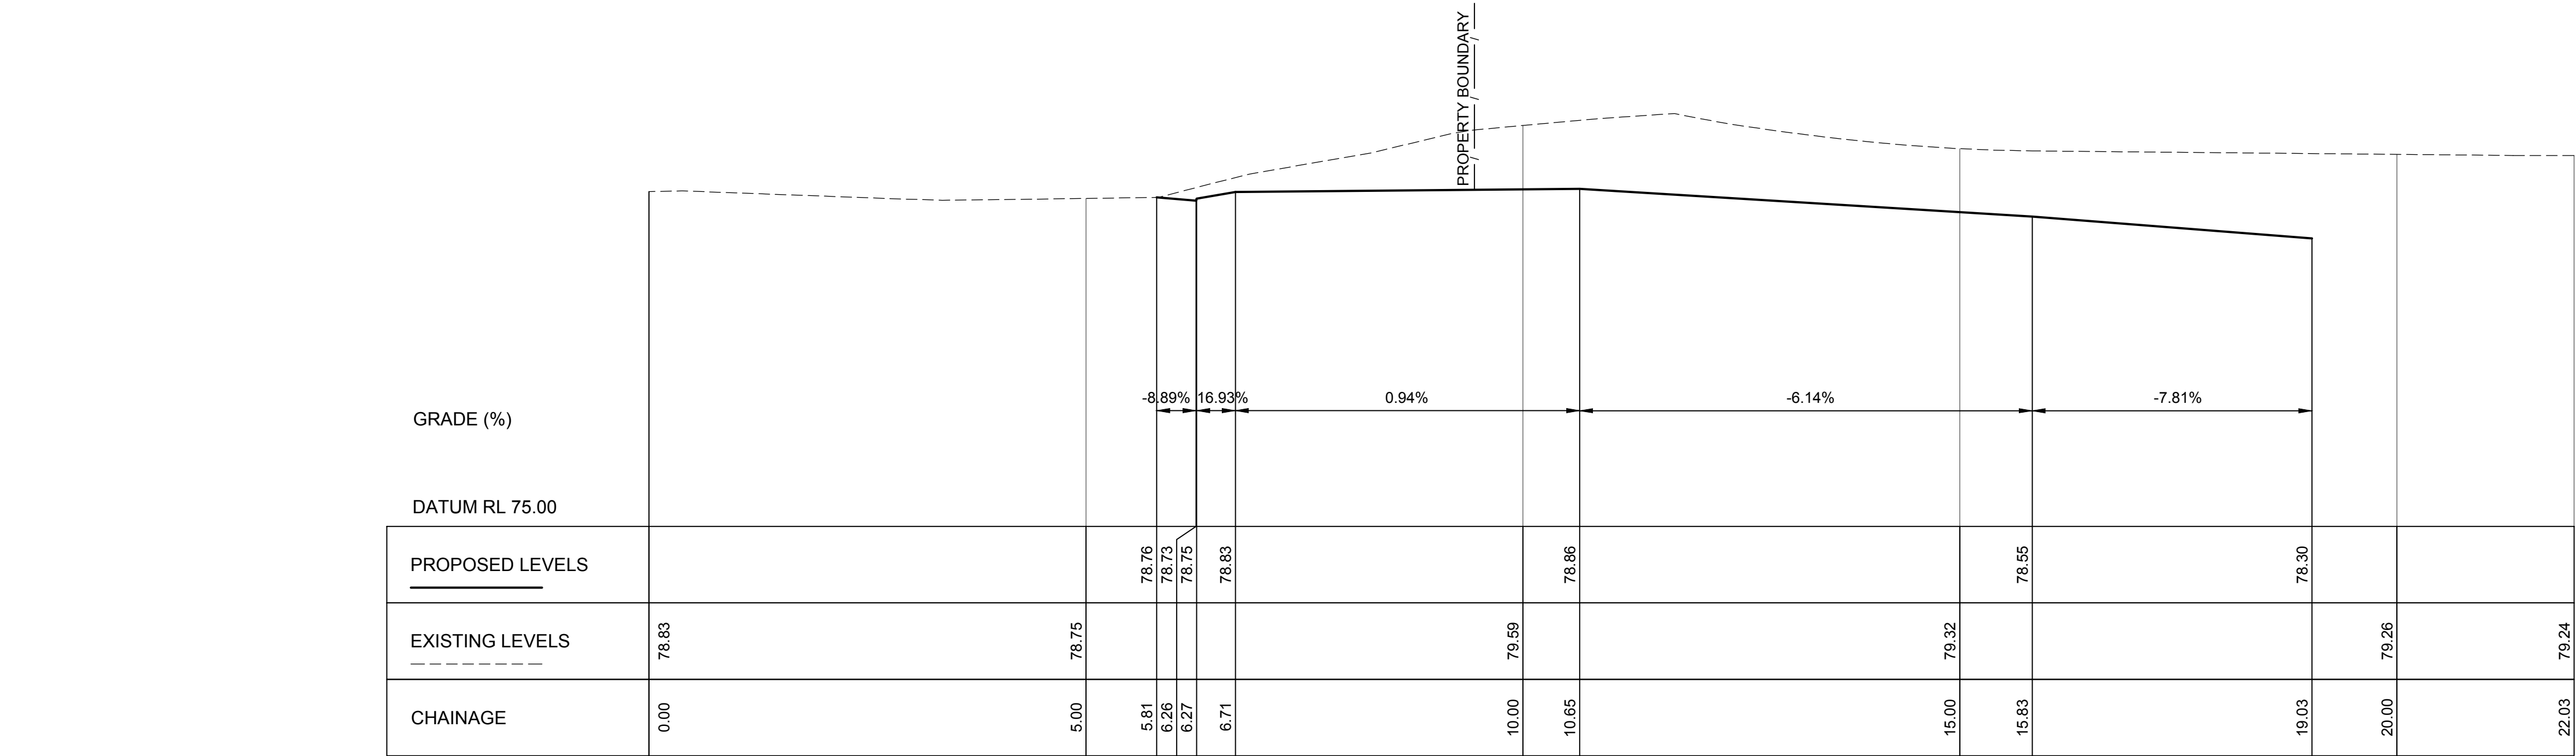

DO NOT SCALE FROM DRAWINGS.
CHECK & VERIFY ALL
DIMENSIONS & LEVELS BEFORE
COMMENCEMENT OF ANY WORK.

THIS DRAWING IS NOT TO BE
COPIED IN PART OR WHOLE
WITHOUT WRITTEN PERMISSION
FROM LP CONSULTING
AUSTRALIA PTY LTD

NORTH POINT

SHEET SIZE: A1

NOTES

- REFER TO DRAWING DA-STW-002 FOR DRAWING LIST.
- CONTRACTOR TO CHECK AND CONFIRM ALL LEVELS ON SITE.
- CONTRACTOR TO INVESTIGATE ALL EXISTING SERVICES, SUCH AS APPLY FOR "DIAL BEFORE YOU DIG" SERVICES PRIOR TO START OF WORKS ON SITE.

ISSUE

A
B
C

AMENDMENT
DEVELOPMENT APPLICATION - ISSUE FOR COORDINATION
ISSUE FOR DEVELOPMENT APPLICATION
ISSUE FOR SSDA

DATE

30.09.2020
16.10.2020
11.11.2020

PROJECT

ROYAL INSTITUTE FOR
DEAF & BLIND CHILDREN
MACQUARIE UNIVERSITY

ARCHITECT



 
WMK Architecture
L2 364 Kent
Street
Sydney NSW 2000

PROJECT MANAGER



M PROJECTS
Suite C2.08, Level 2
22-36 Mountain Street,
Ultimo NSW 2007
Tel: (02) 9262 5530
Fax: (02) 9262 5529
Web: mprojects.com.au

CLIENT



CONSULTANT



A: Suite 12.01, Level 12, 300 George Street
Sydney NSW Australia 2000
P: GPO Box 2662 Sydney NSW 2001
E: info@lp-consulting.com.au

T: +61 (2) 9223 4444
W: www.lp-consulting.com.au

TITLE

SCHOOL BUILDING
CL 3 AND 4 LONGITUDINAL SECTIONS

SCALE 1:50 @ A1
1:100 @ A3

DATE Nov 11, 2020

JOB No. 2020-1773

DRAWN WW

DESIGNED LP

CHECKED LP

ISSUE


DA - C - 110

APPROVED

C


STATE SIGN. DA

Xref: 2020-1773_X4-TITLE.BAK A1
Prel Date: 11.11.2020 15:56:22 Logn Name: Michael Cad File: Z:\projects\2020\1773\DRAWINGS\DRAWINGS - WORKING\CIVIL\2020\1773_DA-C-109-12.dwg

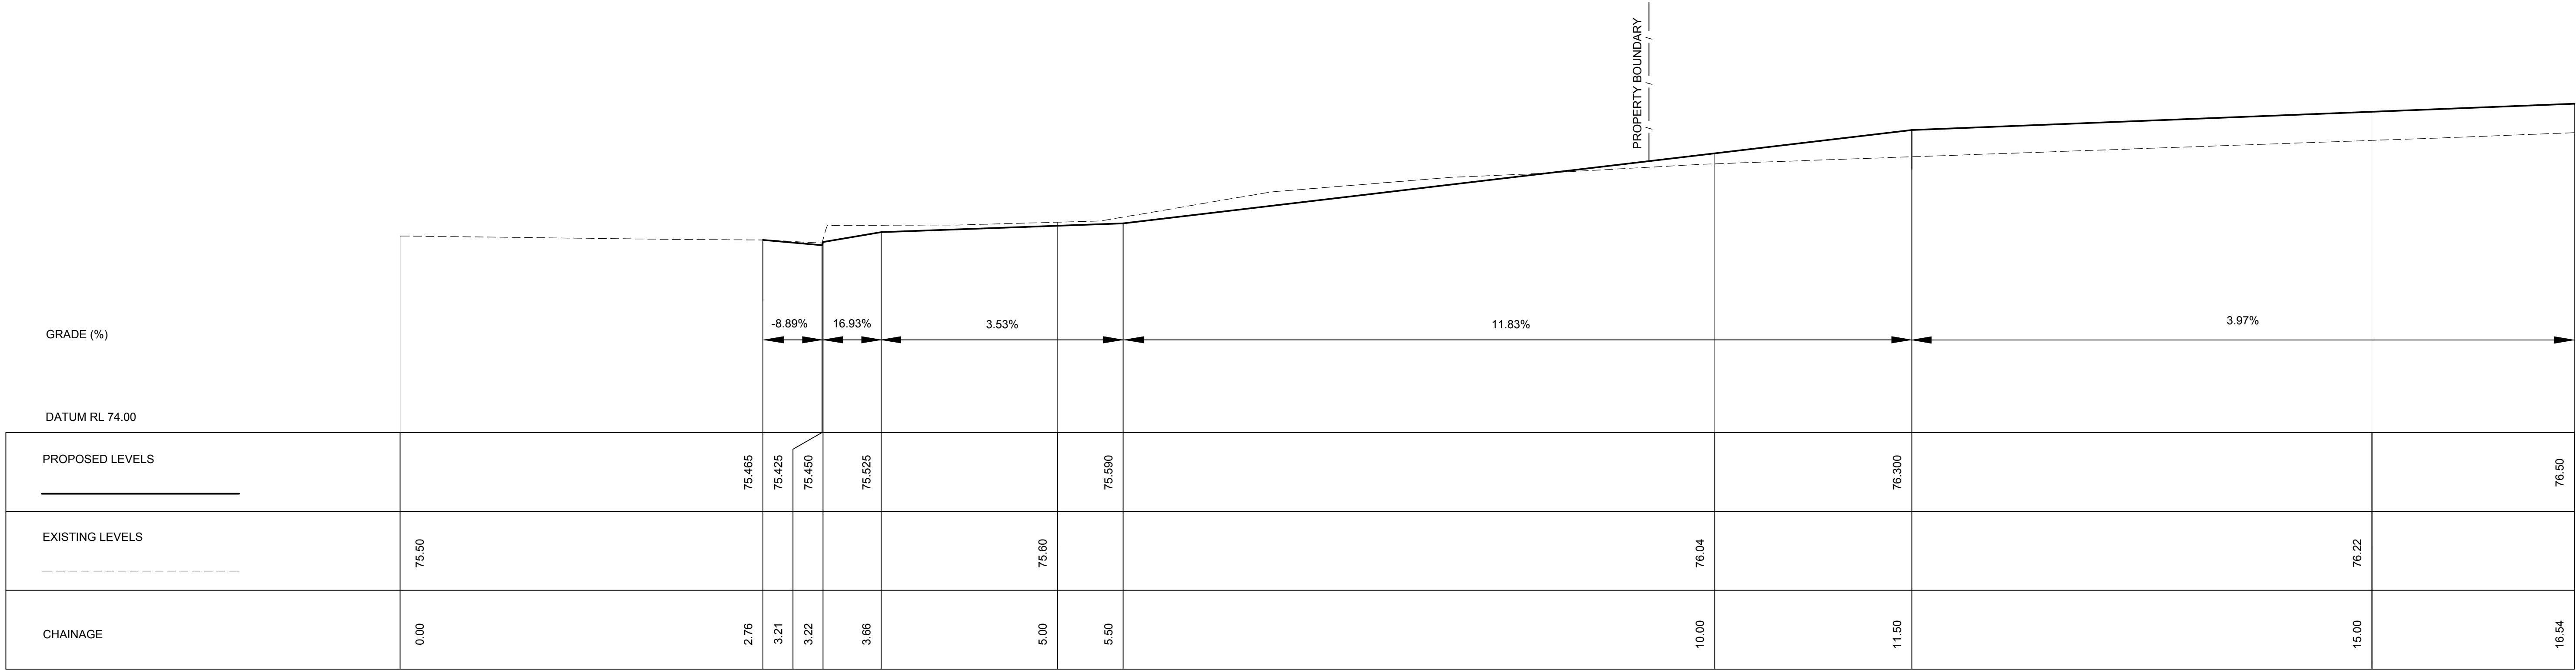


LONGITUDINAL SECTION
CL 5
SCALE 1:25 (HORIZONTAL)
1:25 (VERTICAL)

1
C-108

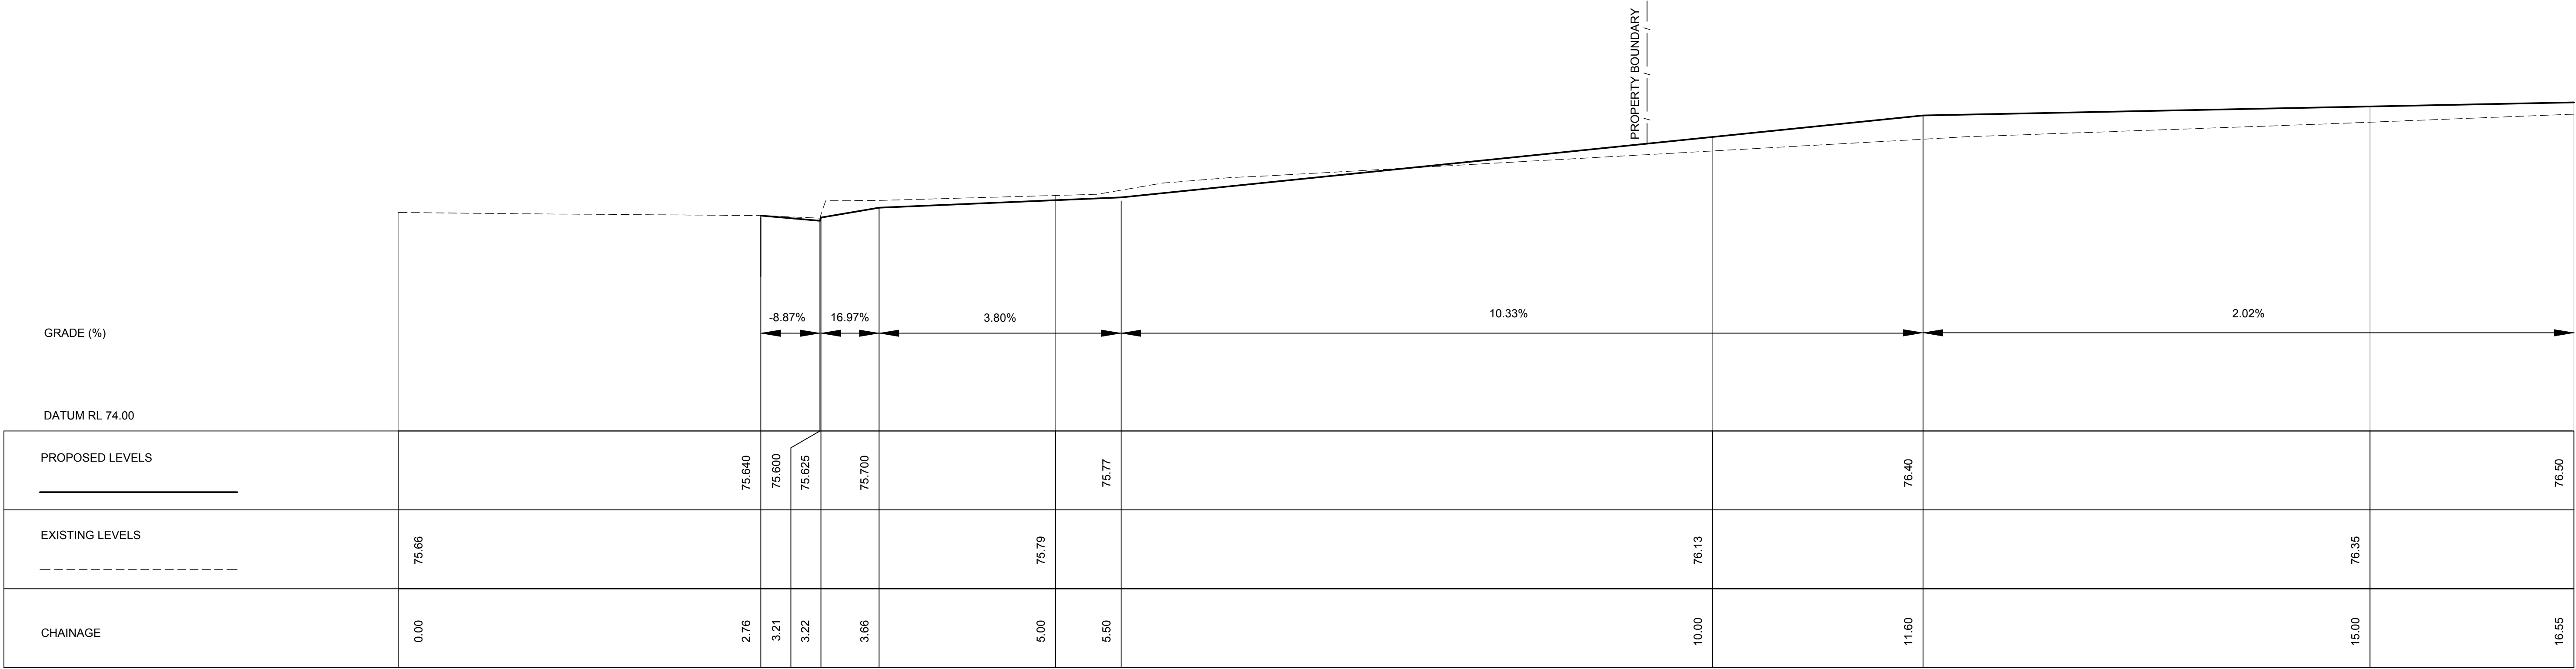

LONGITUDINAL SECTION
CL 6
SCALE 1:25 (HORIZONTAL)
1:25 (VERTICAL)

 2
C-108



DO NOT SCALE FROM DRAWINGS.
CHECK & VERIFY ALL
DIMENSIONS & LEVELS BEFORE
COMMENCEMENT OF ANY WORK.

THIS DRAWING IS NOT TO BE
COPIED IN PART OR WHOLE
WITHOUT WRITTEN PERMISSION
FROM LP CONSULTING
AUSTRALIA PTY LTD

NORTH POINT

SHEET SIZE: A1

NOTES

1. REFER TO DRAWING DA-STW-002 FOR DRAWING LIST.

2. CONTRACTOR TO CHECK AND CONFIRM ALL LEVELS ON SITE.

3. CONTRACTOR TO INVESTIGATE ALL EXISTING SERVICES, SUCH AS
APPLY FOR "DIAL BEFORE YOU DIG" SERVICES PRIOR TO START
OF WORKS ON SITE.

ISSUE	AMENDMENT	DATE
A	DEVELOPMENT APPLICATION - ISSUE FOR COORDINATION	30.09.2020
B	ISSUE FOR DEVELOPMENT APPLICATION	16.10.2020
C	ISSUE FOR SSDA	11.11.2020

PROJECT

ROYAL INSTITUTE FOR
DEAF & BLIND CHILDREN
MACQUARIE UNIVERSITY

ARCHITECT

WMK Architecture
L2 364 Kent
Street
Sydney NSW 2000

PROJECT MANAGER

M PROJECTS

Suite C2.08, Level 2
22-36 Mountain Street,
Ultimo NSW 2007

Tel: (02) 9262 5530
Fax: (02) 9262 5529
Web: mprojects.com.au

CLIENT

Royal Institute for
Deaf and Blind Children

CONSULTANT

LP CONSULTING
AUSTRALIA PTY LTD

A: Suite 12.01, Level 12, 300 George Street
Sydney NSW Australia 2000
P: GPO Box 2662 Sydney NSW 2001
E: info@lp-consulting.com.au


T: +61 (2) 9223 4444
W: www.lp-consulting.com.au

TITLE

CONSULTING BUILDING
CL 5 TO 6 LONGITUDINAL SECTIONS

SCALE 1: 25 @ A1 1: 50 @ A3	DRAWN VVW	DESIGNED LP	CHECKED LP	APPROVED
DATE Nov 11, 2020	DRAWING No. DA - C - 111		ISSUE C	
JOB No. 2020-1773	STATE SIGN. DA			


Xref: 2020-1773_X4-TITLE-BLK-A1
Prel Date: 11.11.2020@15:58:39 Log Name: Michael Cad File: Z:\projects\2020-1773\DRAWINGS\DRAWINGS - WORKING\CIVIL\2020-1773_DA-C-109-12.dwg

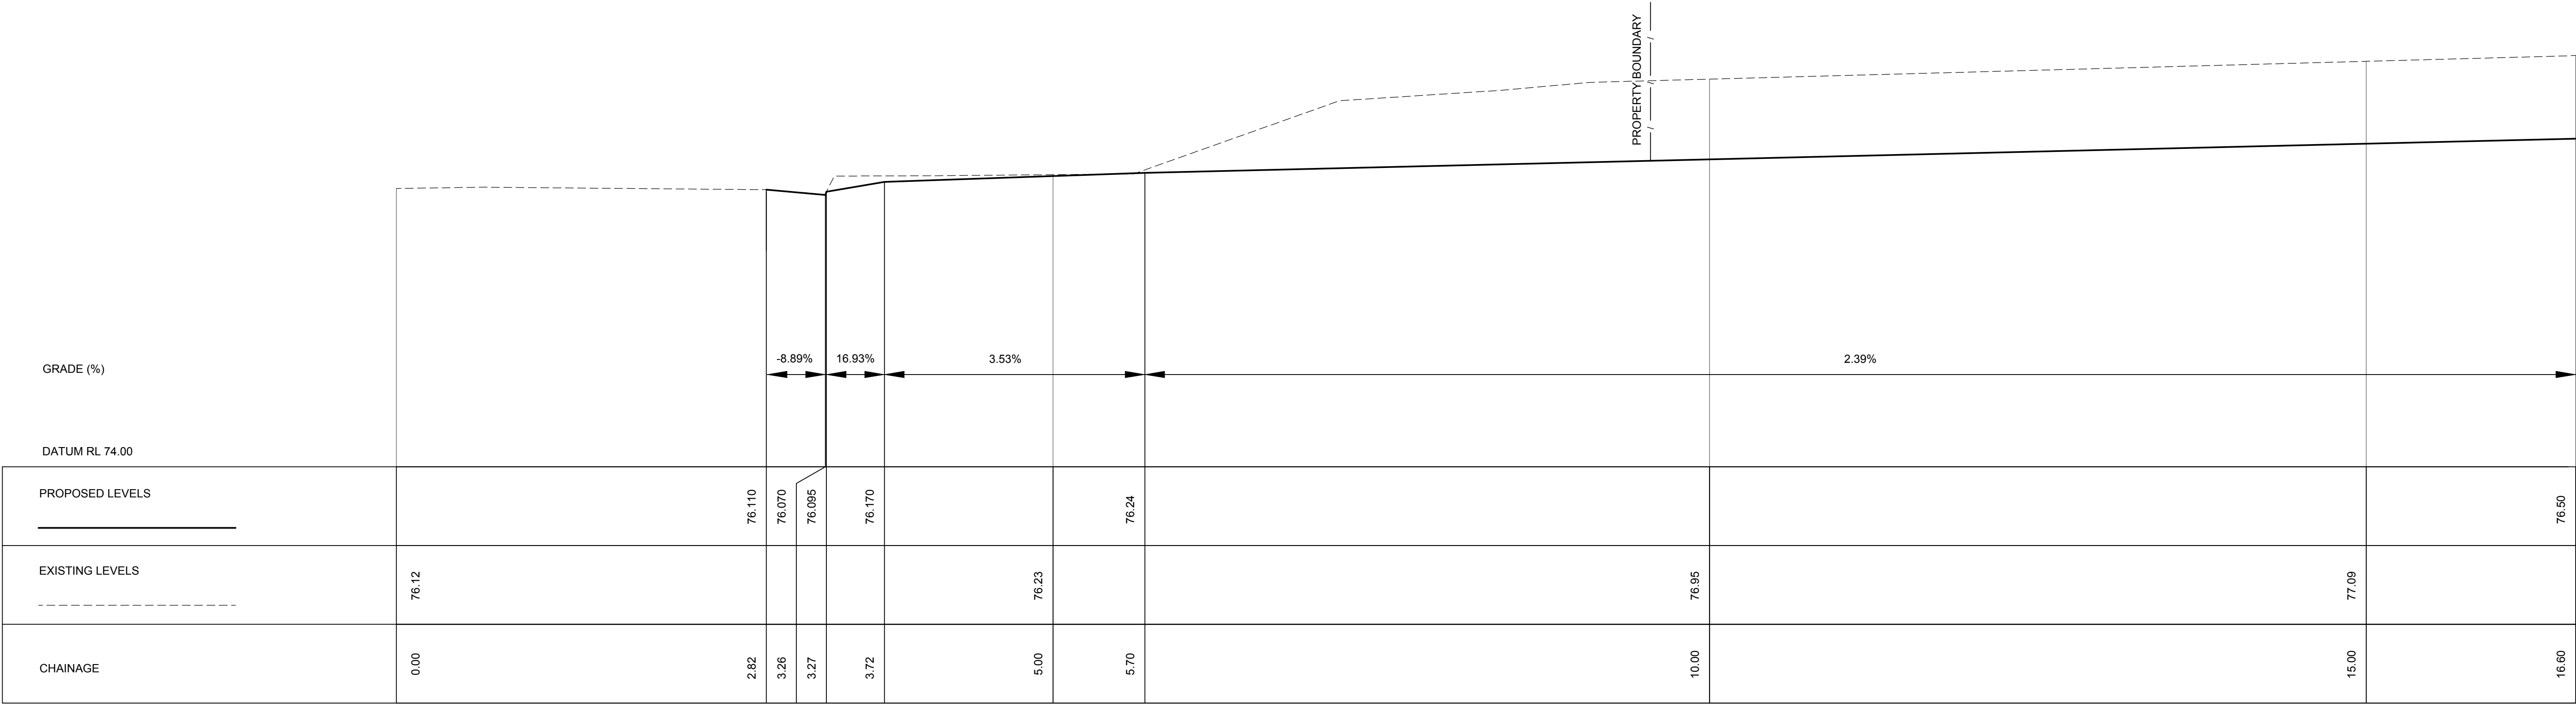

LONGITUDINAL SECTION
CL 7

SCALE 1:25 (HORIZONTAL)
1:25 (VERTICAL)


1
C-108

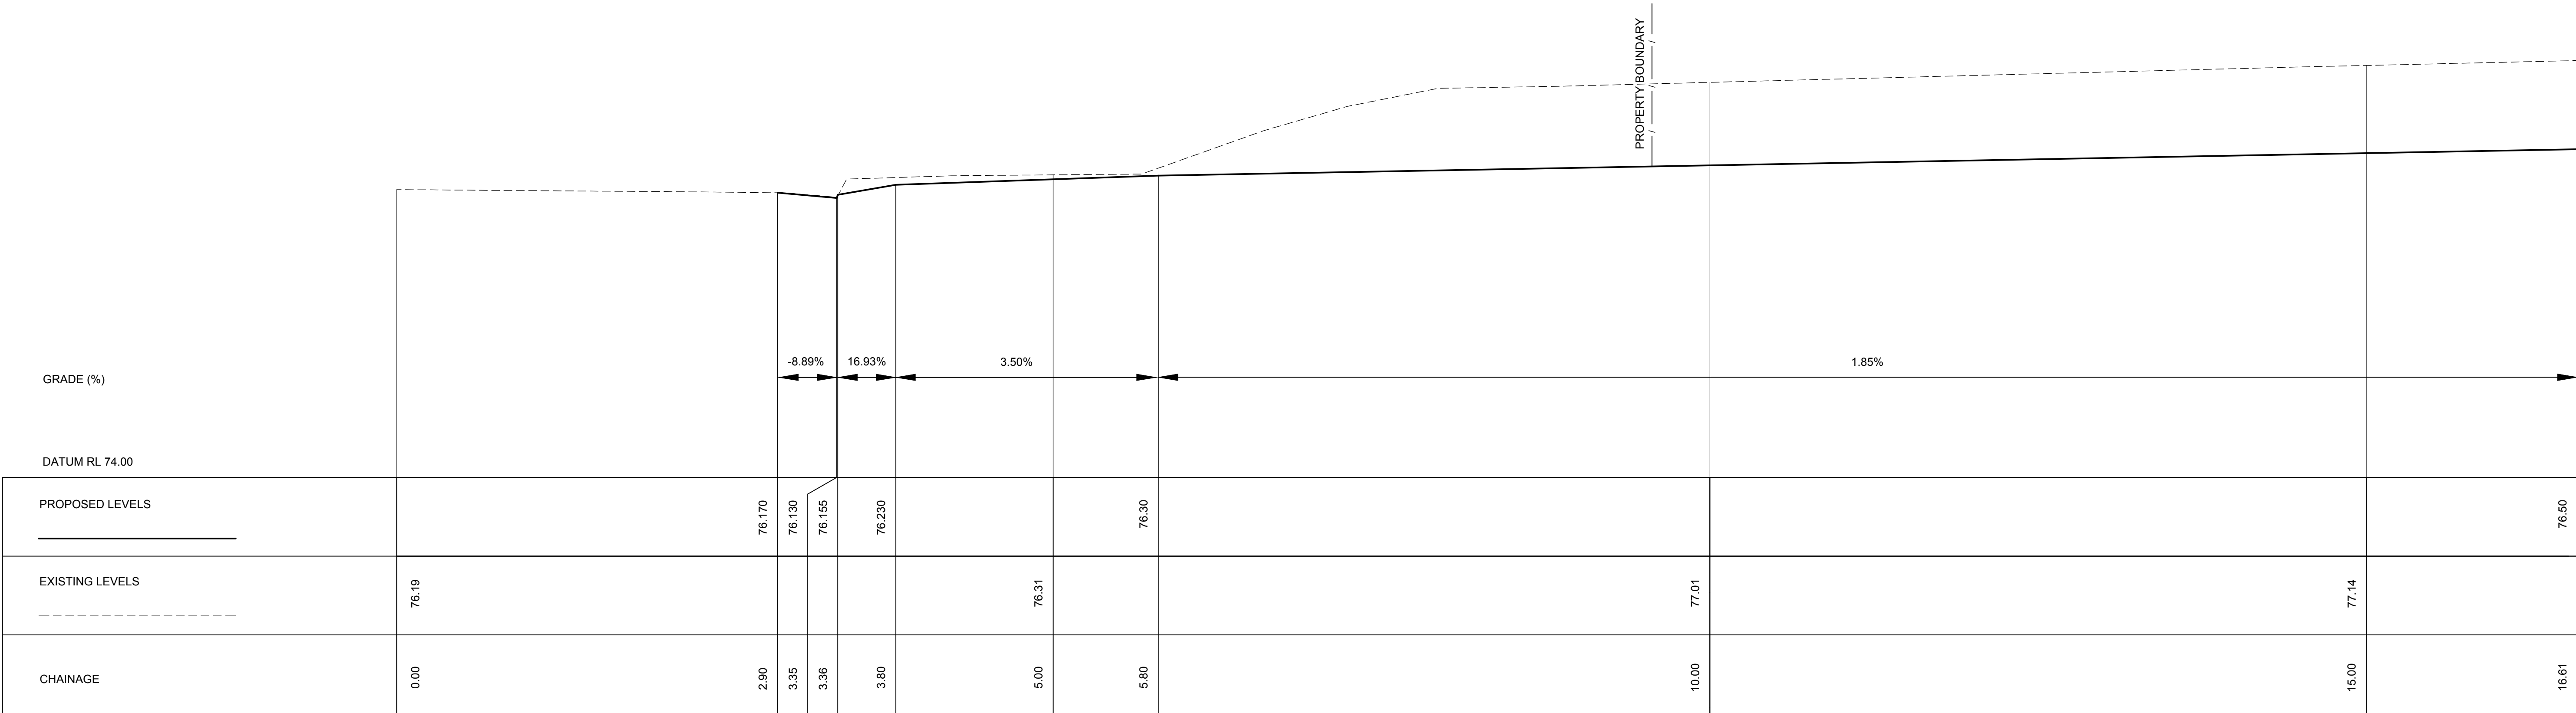

LONGITUDINAL SECTION
CL 8

SCALE 1:25 (HORIZONTAL)
1:25 (VERTICAL)

 2
C-108



DO NOT SCALE FROM DRAWINGS.
CHECK & VERIFY ALL
DIMENSIONS & LEVELS BEFORE
COMMENCEMENT OF ANY WORK.

THIS DRAWING IS NOT TO BE
COPIED IN PART OR WHOLE
WITHOUT WRITTEN PERMISSION
FROM LP CONSULTING
AUSTRALIA PTY LTD

NORTH POINT

SHEET SIZE: A1

NOTES

- REFER TO DRAWING DA-STW-002 FOR DRAWING LIST.
- CONTRACTOR TO CHECK AND CONFIRM ALL LEVELS ON SITE.
- CONTRACTOR TO INVESTIGATE ALL EXISTING SERVICES, SUCH AS APPLY FOR "DIAL BEFORE YOU DIG" SERVICES PRIOR TO START OF WORKS ON SITE.

ISSUE

A
B
C

AMENDMENT
DEVELOPMENT APPLICATION - ISSUE FOR COORDINATION
ISSUE FOR DEVELOPMENT APPLICATION
ISSUE FOR SSDA

DATE

30.09.2020
16.10.2020
11.11.2020

PROJECT

ROYAL INSTITUTE FOR
DEAF & BLIND CHILDREN
MACQUARIE UNIVERSITY

ARCHITECT

WMK

WMK Architecture
L2 364 Kent
Street
Sydney NSW 2000

PROJECT MANAGER

M PROJECTS

Suite C2.08, Level 2
22-36 Mountain Street,
Ultimo NSW 2007

Tel: (02) 9262 5530
Fax: (02) 9262 5529
Web: mprojects.com.au

CLIENT

Royal Institute for
Deaf and Blind Children

CONSULTANT



LP CONSULTING
AUSTRALIA PTY LTD

A: Suite 12.01, Level 12, 300 George Street
Sydney NSW Australia 2000
P: GPO Box 2662 Sydney NSW 2001
E: info@lp-consulting.com.au

T: +61 (2) 9223 4444
W: www.lp-consulting.com.au

TITLE

CONSULTING BUILDING
CL 7 TO 8 LONGITUDINAL SECTIONS

SCALE 1: 25 @ A1
1: 50 @ A3

DATE Nov 11, 2020

JOB No. 2020-1773

DRAWN WW

DESIGNED LP

CHECKED LP

ISSUE

DA - C - 112

C

STATE SIGN. DA