

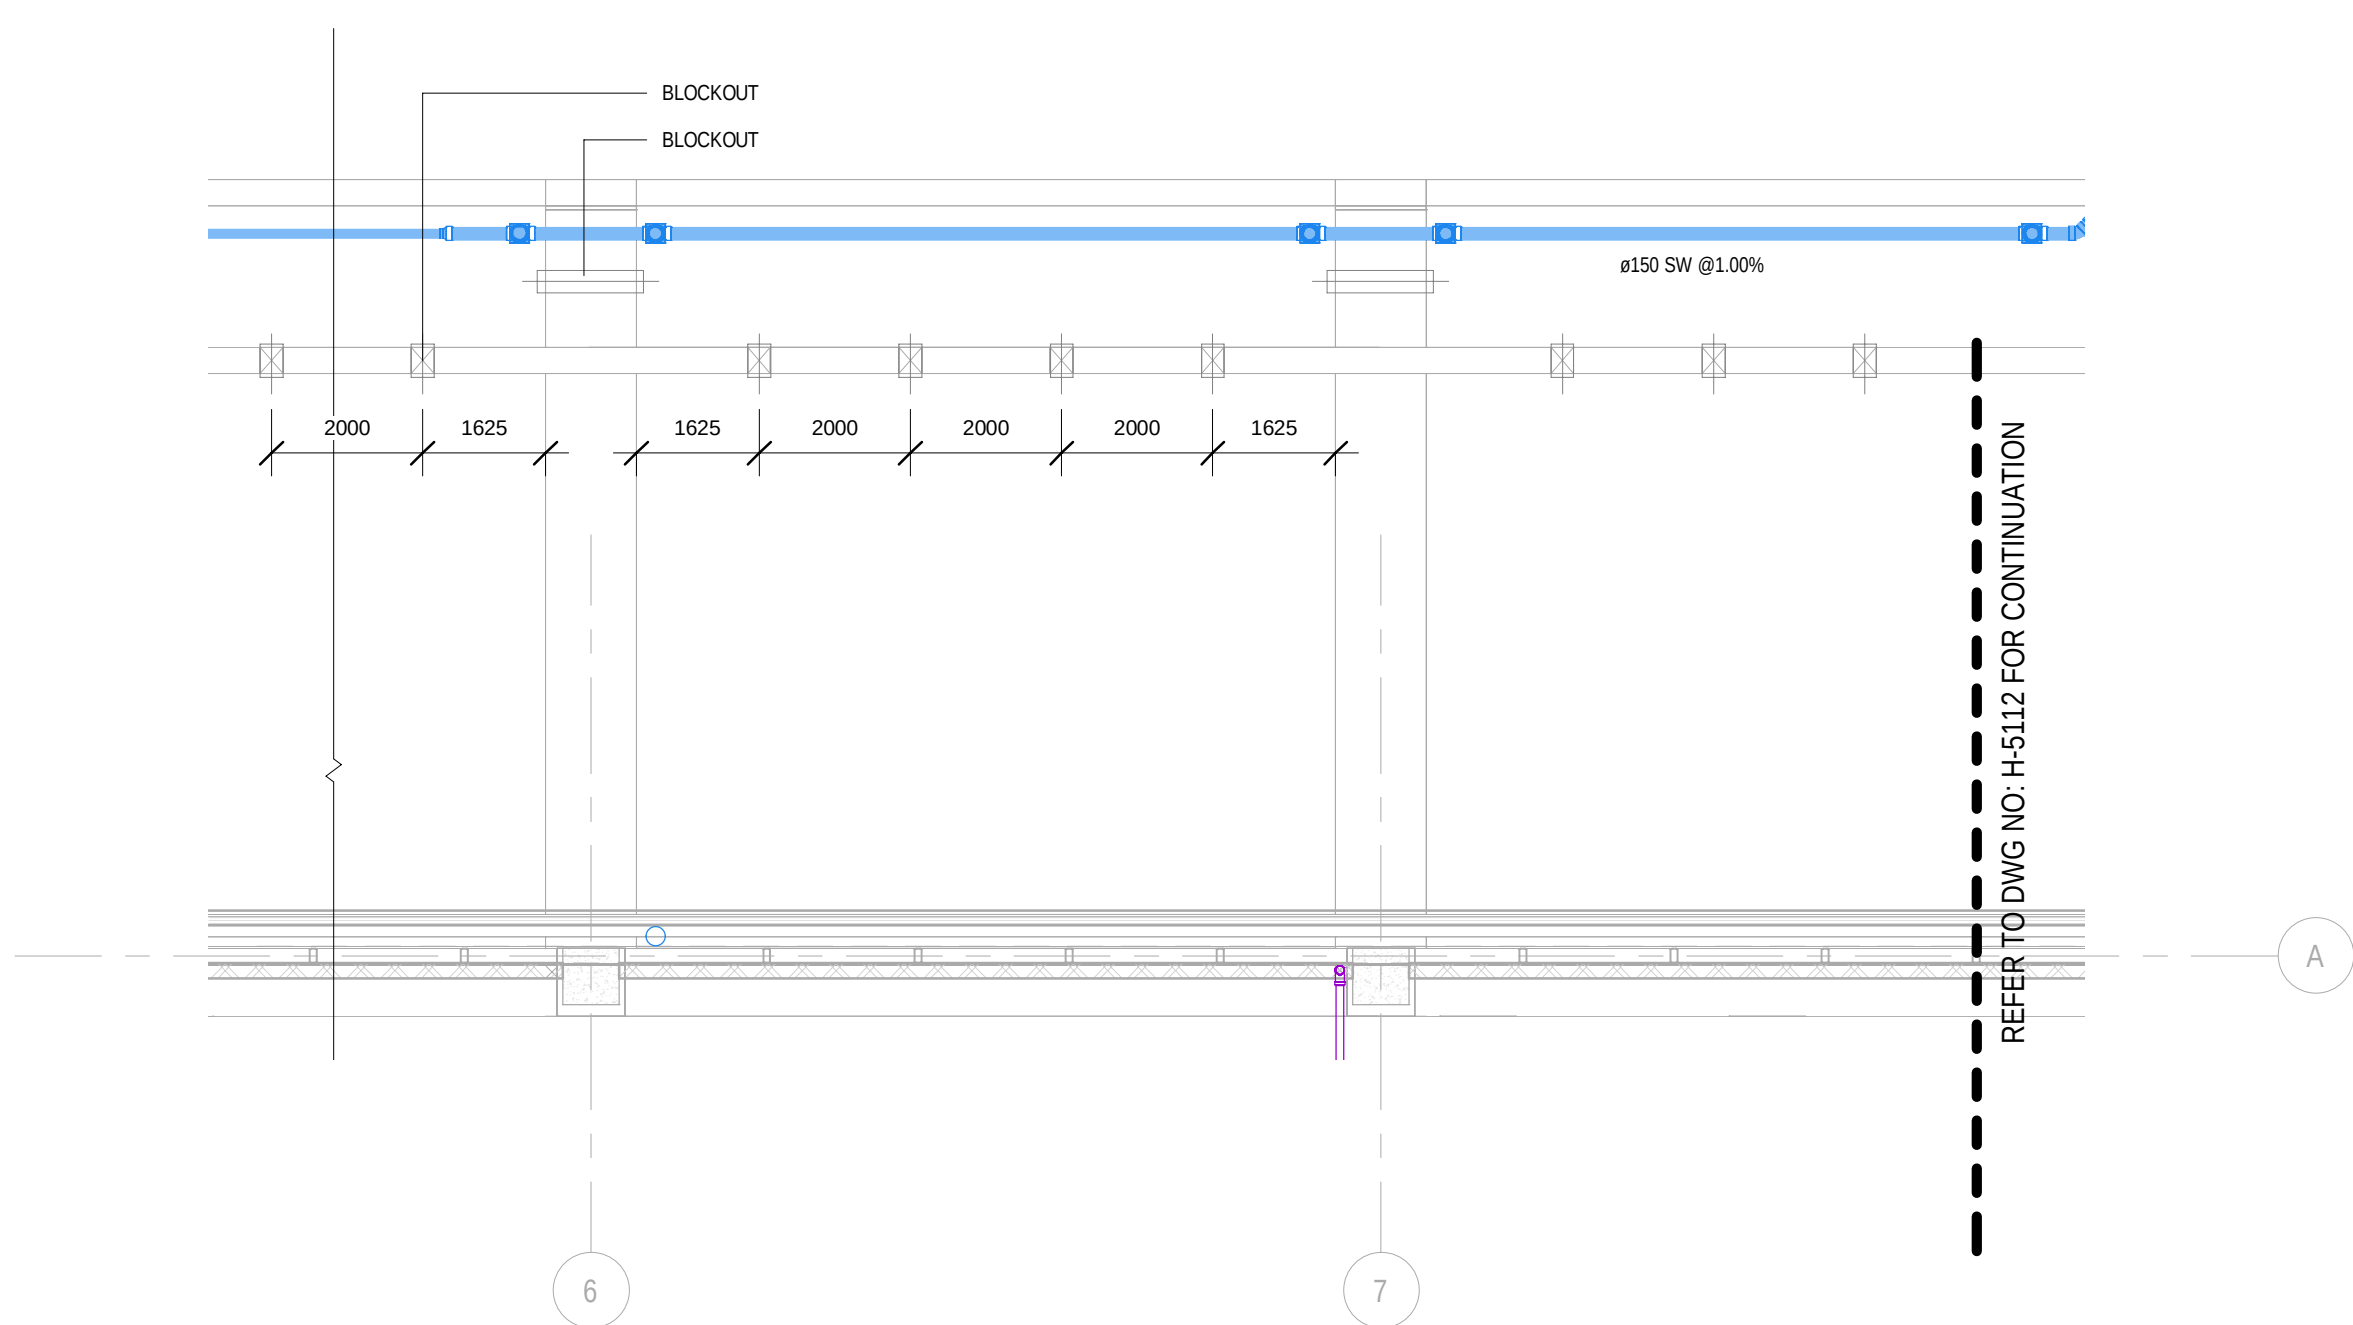


Appendix S

Hydrological plans

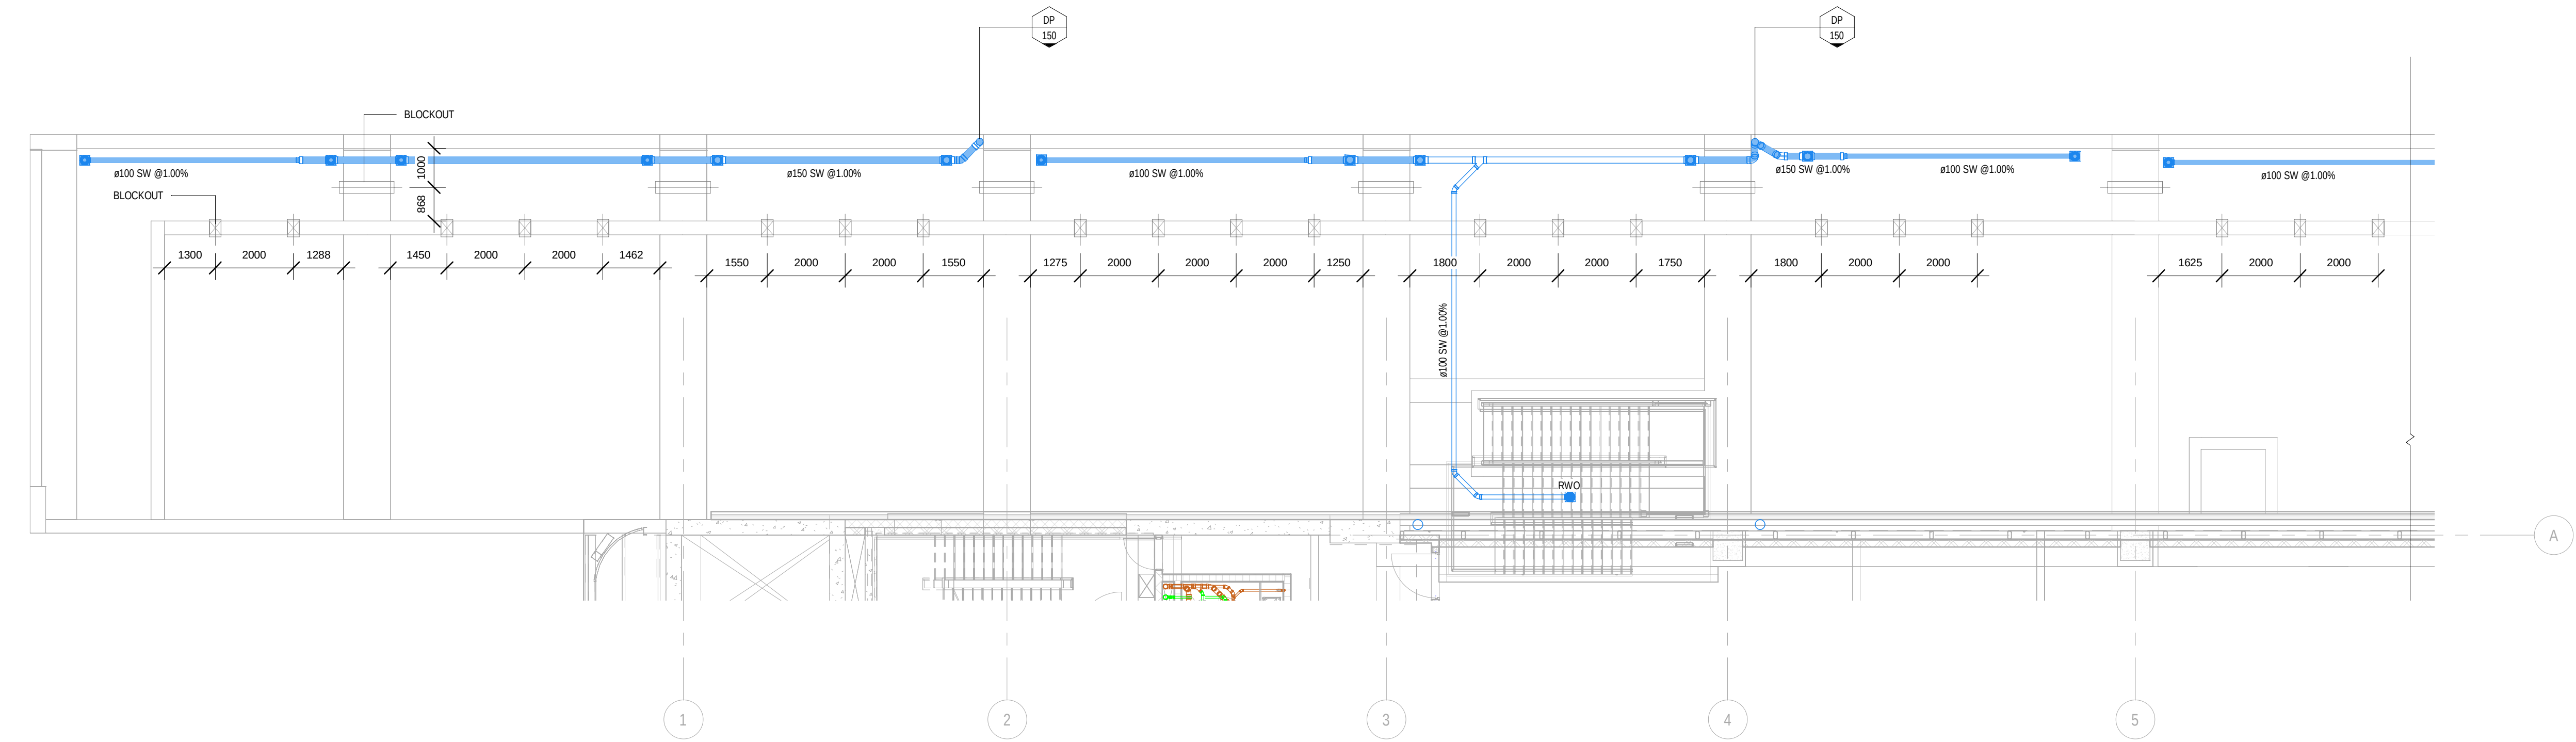


2 LEVEL 1 PODIUM DRAINAGE LAYOUT - SHEET -1
scale 1 : 100

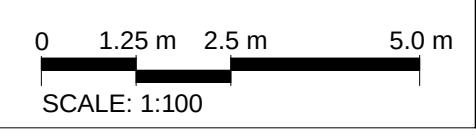


NOTES

THE CONTRACTOR MUST VERIFY IN FIELD (VIF) ALL DIMENSIONS AND CONDITIONS SHOWN ON THIS DRAWING PRIOR TO CONSTRUCTION.

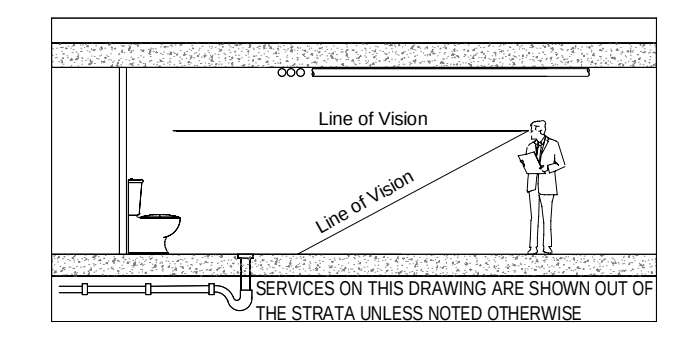

SAFETY IN DESIGN INFORMATION

SAFETY IN DESIGN ISSUES HAVE BEEN ASSESSED AS PART OF THE DESIGN PROCESS. ALL REASONABLE STEPS HAVE BEEN TAKEN TO ENSURE HAZARDS AND RISKS NORMALLY ASSOCIATED WITH THIS TYPE OF DESIGN HAVE BEEN MITIGATED AND/OR COMMUNICATED. RESIDUAL HAZARDS AND RISKS AND/OR HAZARDS AND RISKS NOT NORMALLY ASSOCIATED WITH THIS TYPE OF WORK WHICH MAY REQUIRE SUBSEQUENT CONSIDERATION AND/OR ACTION ARE DESCRIBED IN -
SiD_Report

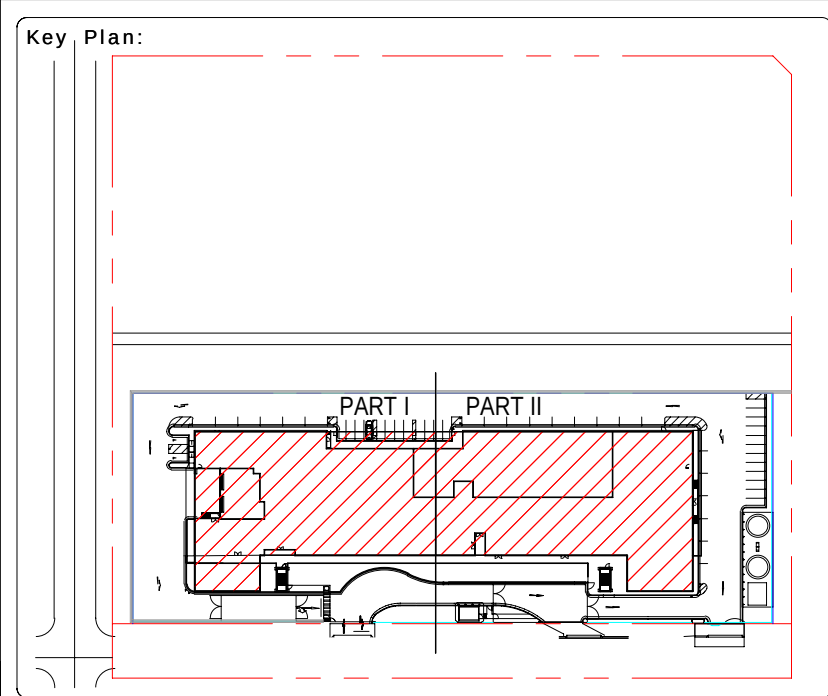

Project Status: 80% DESIGN DEVELOPMENT

Project No.:

REV.	DATE	DESCRIPTION	DRWN	ENGR	CHK	APP'D
A	30-Oct-2020	80% DESIGN DEVELOPMENT RE-ISSUE	RR	JB	FC	DP

ARCHITECT:

AECOM

CIVIL / STRUCTURAL ENGINEER:

AECOM

MEP ENGINEER:


AECOM

AGILE No.: 800-040046-001

PROJECT:

TITLE: LEVEL 1 PODIUM DRAINAGE LAYOUT - SHEET 1


SCALE: 1:100 @A1
DRAWING NO.:
REV.: A

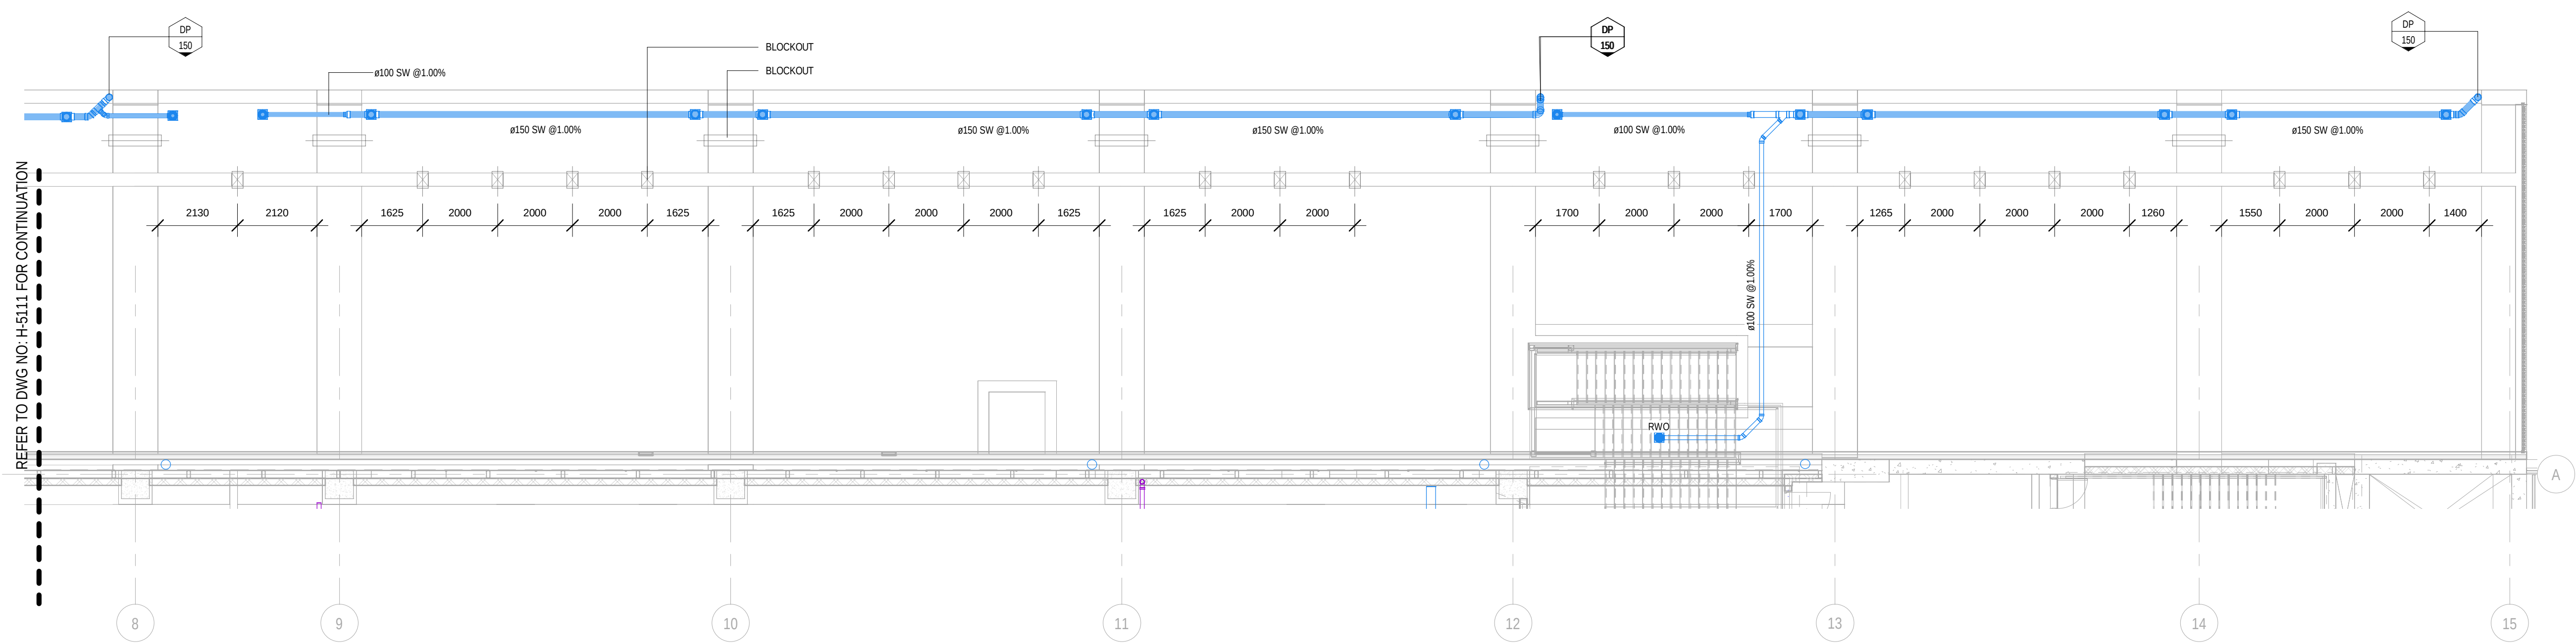

1 LEVEL 1 PODIUM DRAINAGE LAYOUT - SHEET -2
scale 1 : 100

NOTES


THE CONTRACTOR MUST VERIFY IN FIELD (VIF) ALL DIMENSIONS AND CONDITIONS SHOWN ON THIS DRAWING PRIOR TO CONSTRUCTION.

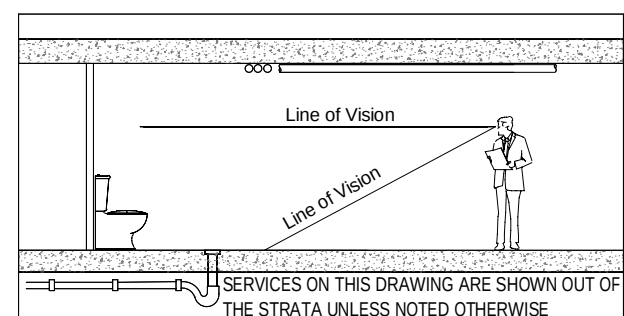

SAFETY IN DESIGN INFORMATION

SAFETY IN DESIGN ISSUES HAVE BEEN ASSESSED AS PART OF THE DESIGN PROCESS. ALL REASONABLE STEPS HAVE BEEN TAKEN TO ENSURE HAZARDS AND RISKS NORMALLY ASSOCIATED WITH THIS TYPE OF DESIGN HAVE BEEN MITIGATED AND/OR COMMUNICATED. RESIDUAL HAZARDS AND RISKS AND/OR HAZARDS AND RISKS NOT NORMALLY ASSOCIATED WITH THIS TYPE OF WORK WHICH MAY REQUIRE SUBSEQUENT CONSIDERATION AND/OR ACTION ARE DESCRIBED IN -

Key Plan:

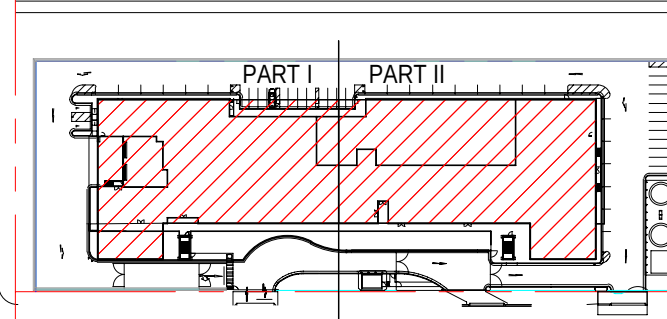

Project Status: 80% DESIGN DEVELOPMENT

Project No.:

REV.	DATE	DESCRIPTION	DRWN	ENGR	CHK	APP'D
A	30-Oct-2020	80% DESIGN DEVELOPMENT RE-ISSUE	RR	JB	FC	DP

ARCHITECT:

AECOM

CIVIL / STRUCTURAL ENGINEER:

AECOM

MEP ENGINEER:

AECOM

AGILE No.: 800-040046-001

PROJECT:

TITLE: LEVEL 1 PODIUM DRAINAGE LAYOUT - SHEET 2

SCALE: 1 : 100 @A1
DRAWING NO.:
REV.: A