

UNSW - HEALTH TRANSLATION HUB

RANDWICK HEALTH AND INNOVATION PRECINCT

SHEET NUMBER	SHEET NAME	CURRENT REVISION	CURRENT REVISION DATE
DA0000	Cover Sheet	A	18.02.21
DA0010	Context & Locality Plan	A	18.02.21
DA0015	Site Analysis	A	18.02.21
DA0020	Site Plan	A	18.02.21
DA0030	Site Boundary & Building Setbacks	A	18.02.21
DA0050	Site Survey	A	18.02.21
DA1000	Basement Level -01	A	18.02.21
DA1001	Ground 00	A	18.02.21
DA1002	Level 01	A	18.02.21
DA1003	Level 02	A	18.02.21
DA1004	Level 03	A	18.02.21
DA1005	Level 04	A	18.02.21
DA1006	Level 05	A	18.02.21
DA1007	Level 06	A	18.02.21
DA1008	Level 07	A	18.02.21
DA1009	Level 08	A	18.02.21
DA1010	Level 09	A	18.02.21
DA1011	Level 10	A	18.02.21
DA1012	Level 11	A	18.02.21
DA1013	Level 12	A	18.02.21
DA1014	Level 13	A	18.02.21
DA1015	Level 14 - Plant	A	18.02.21
DA1016	Level 15 - Roof	A	18.02.21
DA2001	North Elevation	A	18.02.21
DA2002	South Elevation	A	18.02.21
DA2003	East Elevation	A	18.02.21
DA2004	West Elevation	A	18.02.21
DA2101	Section A	A	18.02.21
DA2102	Section B	A	18.02.21
DA2103	Section C	A	18.02.21
DA5700	UNSW Campus Connection - Floor Plan	A	18.02.21
DA5701	UNSW Campus Connection - Roof + Soffit Plan	A	18.02.21
DA5750	UNSW Campus Connection - Elevation	A	18.02.21
DA5751	UNSW Campus Connection - Elevation Wallace Wurth	A	18.02.21
DA5755	UNSW Campus Connection - Section	A	18.02.21
DA5760	SCH - Bridge Connection - Floor Plan	A	18.02.21
DA5765	SCH - Bridge Connection - Elevation	A	18.02.21
DA5766	SCH - Bridge Connection - Section	A	18.02.21
DA9100	Independent Basement Plan	A	18.02.21
DA9101	Independent Ground Floor Plan	A	18.02.21
DA9200	Shadow Analysis	A	18.02.21
DA9300	External Materials Schedule	A	18.02.21
DA9310	External Renders	A	18.02.21
DA9311	External Renders	A	18.02.21
DA9312	External Renders	A	18.02.21
DA9313	External Renders	A	18.02.21
DA9314	External Renders	A	18.02.21
DA9315	Signage	A	18.02.21
DA9502	Area Schedule GFA 01	A	18.02.21
DA9503	Area Schedule GFA 02	A	18.02.21

Total: 50



UNSW
SYDNEY

architectus

Architectus Australia Pty Ltd is the owner of the copyright subsisting in these drawings, plans, designs and specifications. They must not be used, reproduced or copied, in whole or in part, nor may the information, ideas and concepts therein contained (which are confidential to Architectus Australia Pty Ltd) be disclosed to any person without the prior written consent of that company.

Nominated Architect
Ray Brown, NSWARB 6359

Do not scale drawings. Verify all dimensions on site

issue	amendment	date
A	ISSUED FOR STATE SIGNIFICANT DEVELOPMENT APPLICATION	18.02.21

GENERAL NOTES:

- DO NOT SCALE FROM THE DRAWINGS. USE ONLY FIGURED DIMENSIONS.
- ALL DIMENSIONS ARE IN MILLIMETRES UNLESS OTHERWISE STATED.
- REDUCED LEVELS (RL) ARE TO AUSTRALIAN HEIGHT DATUM (AHD).
- COORDINATES ARE TO MAP GRID AUSTRALIA (MGA).
- THE ARCHITECTURAL DOCUMENTATION IS ONLY ALLOWED TO BE USED FOR THE PURPOSE FOR WHICH IT WAS COMMISSIONED. UNAUTHORISED USE OF THE DOCUMENTATION IS PROHIBITED.

architectus™



ABN 90 131 245 684

project

UNSW Health Translation Hub

drawing


Cover Sheet

scale	NTS	drawing no.
drawn	TH	DA0000
checked	JC	issue
project no	190551.00	A

26/02/2021 4:08:12 PM

STATE SIGNIFICANT DEVELOPMENT
APPLICATION ARCHITECTURAL DRAWINGS

SSD APPLICATION - SSD-10822510

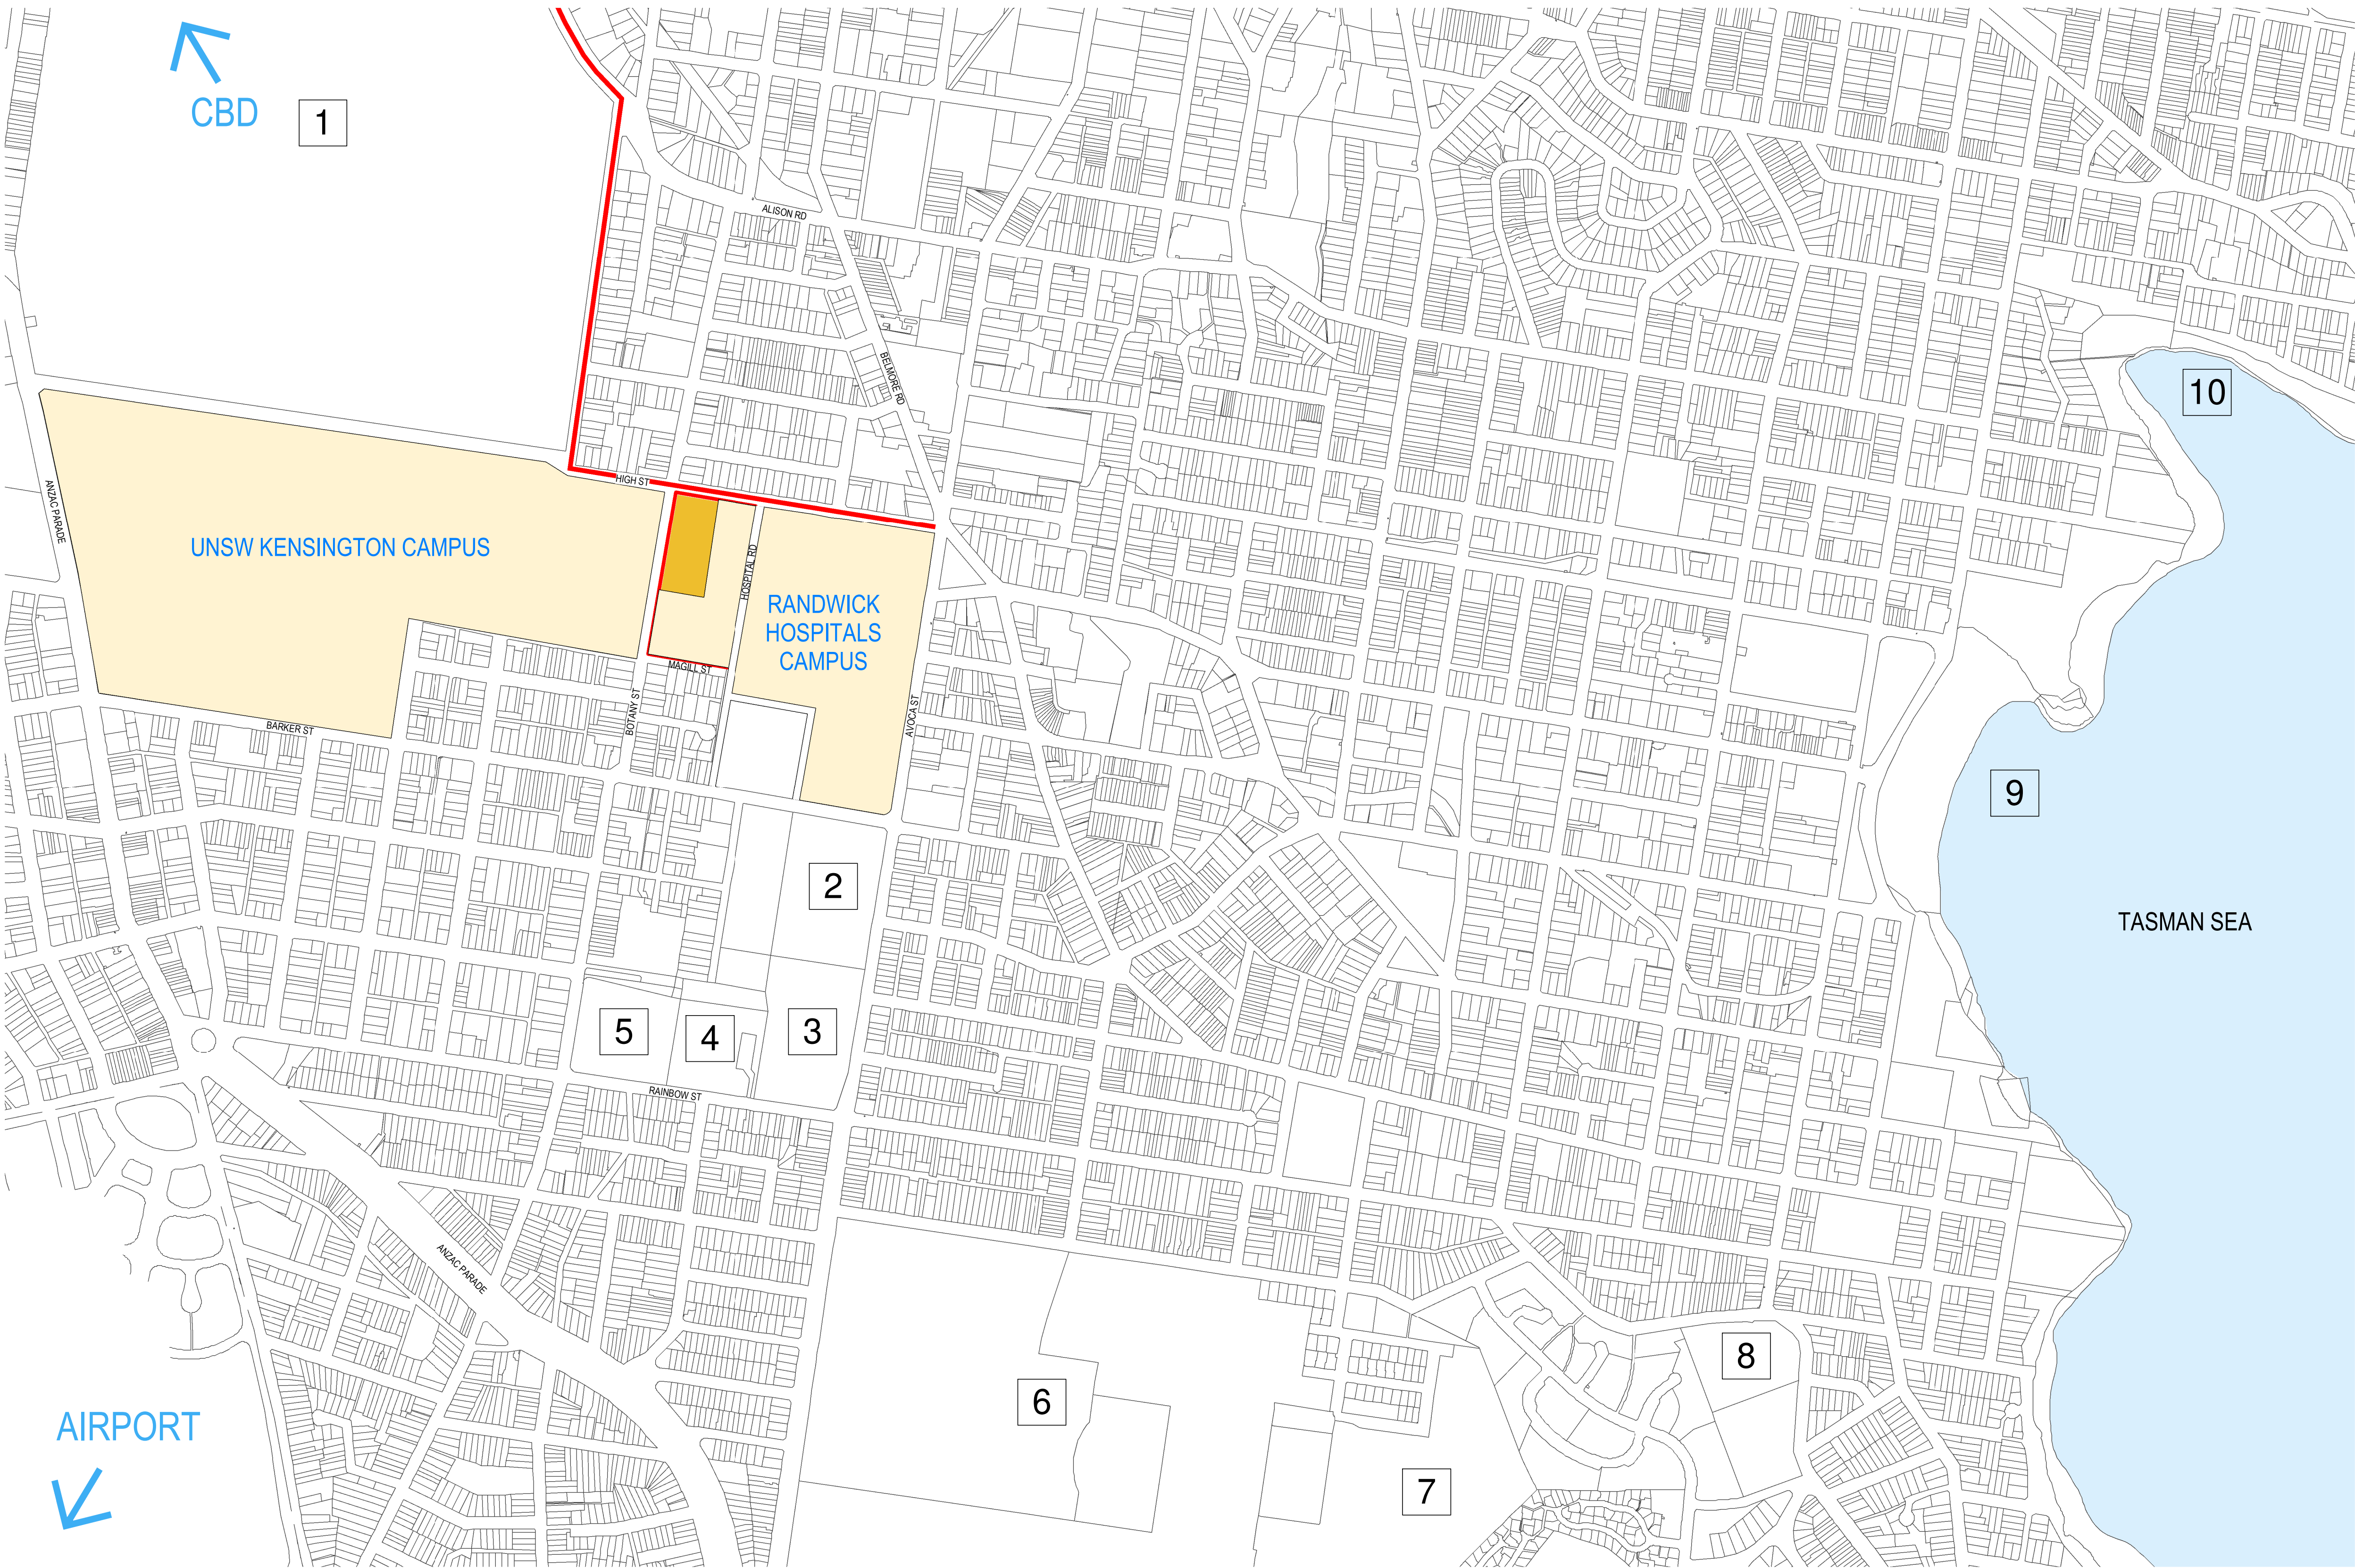

architectus™

Architectus Australia Pty Ltd is the owner of the copyright subsisting in these drawings, plans, designs and specifications. They must not be used, reproduced or copied, in whole or in part, nor may the information, ideas and concepts therein contained (which are confidential to Architectus Australia Pty Ltd) be disclosed to any person without the prior written consent of that company.

Nominated Architect
Ray Brown, NSWARB 6359

Do not scale drawings. Verify all dimensions on site


issue	amendment	date
A	ISSUED FOR STATE SIGNIFICANT DEVELOPMENT APPLICATION	18.02.21

GENERAL NOTES:

- DO NOT SCALE FROM THE DRAWINGS. USE ONLY FIGURED DIMENSIONS. ALL DIMENSIONS ARE IN MILLIMETRES UNLESS OTHERWISE STATED.
- REDUCED LEVELS (RL) ARE TO AUSTRALIAN HEIGHT DATUM (AHD).
- COORDINATES ARE TO MAP GRID AUSTRALIA (MGA).
- THE ARCHITECTURAL DOCUMENTATION IS ONLY ALLOWED TO BE USED FOR THE PURPOSE FOR WHICH IT WAS COMMISSIONED. UNAUTHORISED USE OF THE DOCUMENTATION IS PROHIBITED.

- LEGEND
- PROPOSED UNSW HEALTH TRANSLATION HUB SITE
 - L2 - RANDWICK LIGHTRAIL LINE
 - RANDWICK HOSPITALS CAMPUS EXPANSION

- RANDWICK RACECOURSE
- RANDWICK GIRLS HIGH SCHOOL
- RANDWICK BOYS HIGH SCHOOL
- RAINBOW STREET PUBLIC SCHOOL
- PAINE RESERVE
- RANDWICK BARRACKS
- RANDWICK ENVIRONMENTAL PARK
- RANDWICK CEMETERY
- COOGEE BEACH
- GORDONS BAY

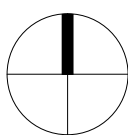

architectus™




ABN 90 131 245 684

project
UNSW Health Translation Hub

drawing

Context & Locality Plan

scale	NTS	drawing no.
drawn	TH	DA0010
checked	JC	issue
project no	190551.00	A

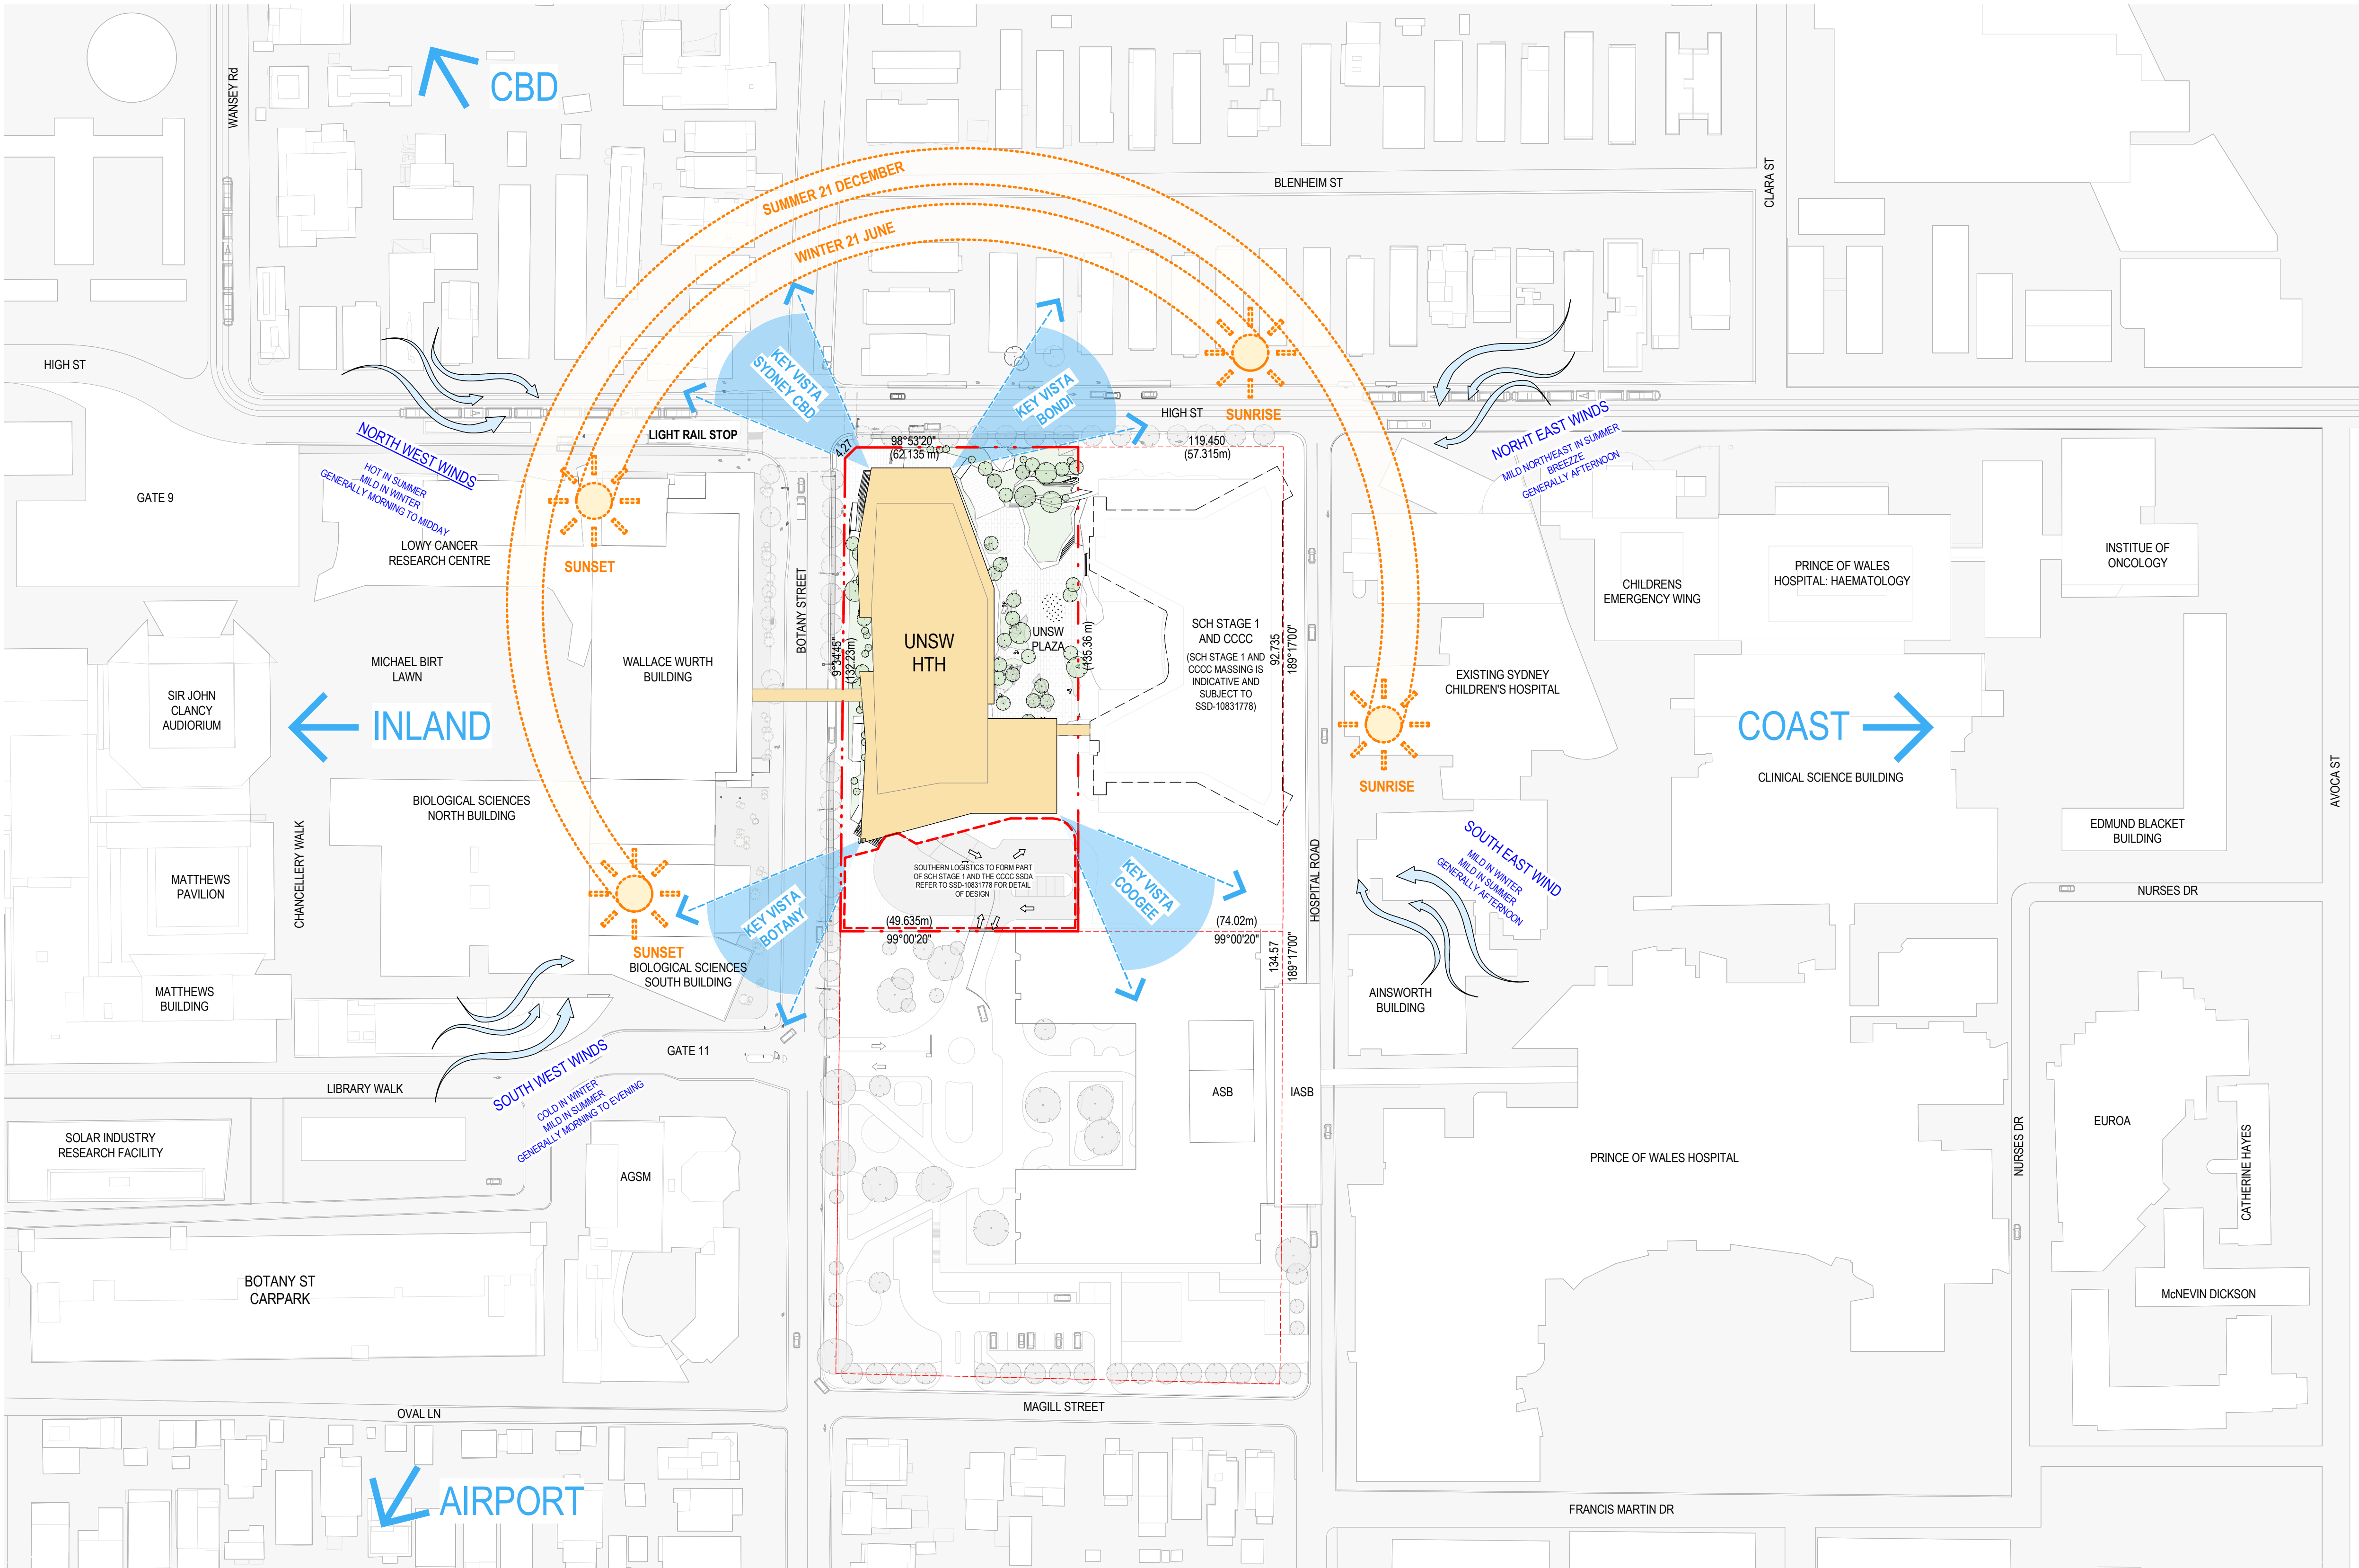

°architectus™

Architectus Australia Pty Ltd is the owner of the copyright subsisting in these drawings, plans, designs and specifications. They must not be used, reproduced or copied, in whole or in part, nor may the information, ideas and concepts therein contained (which are confidential to Architectus Australia Pty Ltd) be disclosed to any person without the prior written consent of that company.

Nominated Architect
Ray Brown, NSWARB 6359

Do not scale drawings. Verify all dimensions on site

issue	amendment	date
A	ISSUED FOR STATE SIGNIFICANT DEVELOPMENT APPLICATION	18.02.21

GENERAL NOTES:

- DO NOT SCALE FROM THE DRAWINGS. USE ONLY FIGURED DIMENSIONS.
- ALL DIMENSIONS ARE IN MILLIMETRES UNLESS OTHERWISE STATED.
- REDUCED LEVELS (RL) ARE TO AUSTRALIAN HEIGHT DATUM (AHD).
- COORDINATES ARE TO MAP GRID AUSTRALIA (MGA).
- THE ARCHITECTURAL DOCUMENTATION IS ONLY ALLOWED TO BE USED FOR THE PURPOSE FOR WHICH IT WAS COMMISSIONED. UNAUTHORISED USE OF THE DOCUMENTATION IS PROHIBITED.

ROAD INFRASTRUCTURE LEGEND

- SOUTHERN LOGISTICS TO FORM PART OF SCH STAGE 1 AND THE COCC SSDA REFER TO SSD-10831778 FOR DETAIL OF DESIGN

Scale:
1:1000 @ A1
1:2000 @ A3

0 10 20 30 40

architectus™

UNSW SYDNEY


ABN 90 131 245 684

project

UNSW Health Translation Hub

drawing

Site Analysis			
scale	1 : 1000@A1	drawing no.	
drawn	TH	DA0015	
checked	JC	issue	
project no	190551.00	A	

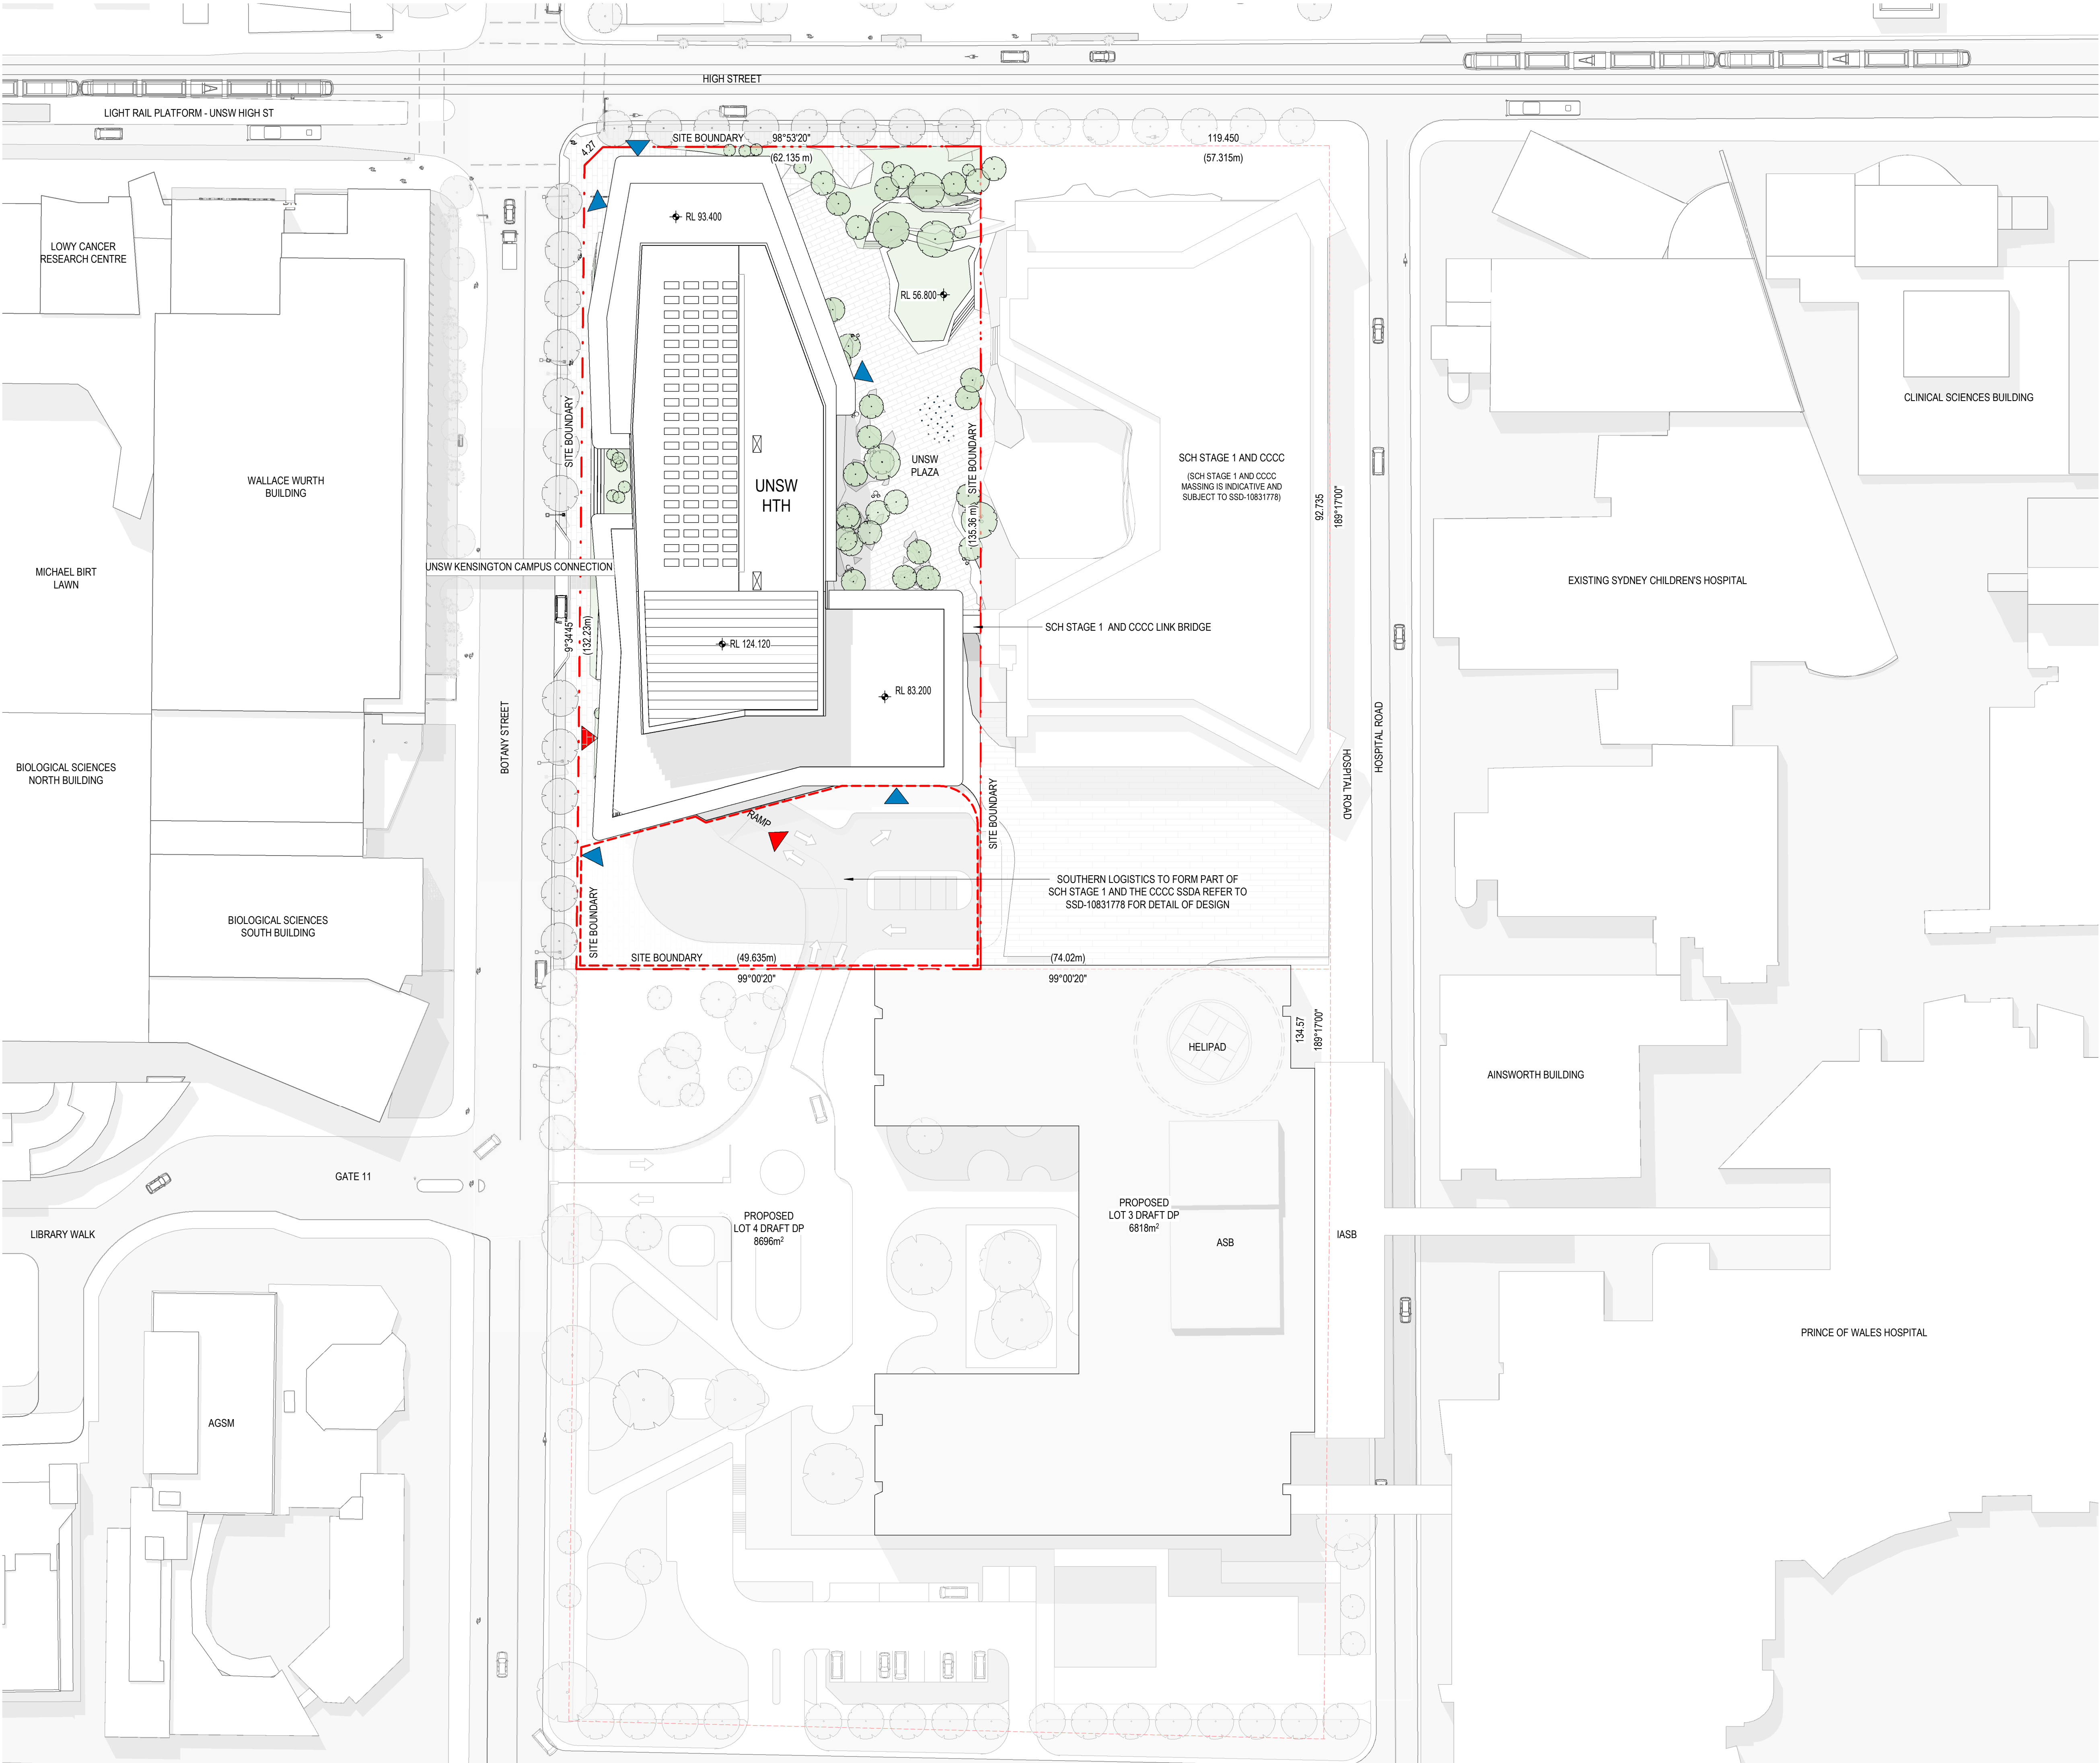

architectus[™]

Architectus Australia Pty Ltd is the owner of the copyright subsisting in these drawings, plans, designs and specifications. They must not be used, reproduced or copied, in whole or in part, nor may the information, ideas and concepts therein contained (which are confidential to Architectus Australia Pty Ltd) be disclosed to any person without the prior written consent of that company.

Nominated Architect
Ray Brown, NSWARB 6359

Do not scale drawings. Verify all dimensions on site

issue	amendment	date
A	ISSUED FOR STATE SIGNIFICANT DEVELOPMENT APPLICATION	18.02.21

- GENERAL NOTES:
- DO NOT SCALE FROM THE DRAWINGS. USE ONLY FIGURED DIMENSIONS. ALL DIMENSIONS ARE IN MILLIMETRES UNLESS OTHERWISE STATED.
 - REDUCED LEVELS (RL) ARE TO AUSTRALIAN HEIGHT DATUM (AHD). COORDINATES ARE TO MAP GRID AUSTRALIA (MGA).
 - THE ARCHITECTURAL DOCUMENTATION IS ONLY ALLOWED TO BE USED FOR THE PURPOSE FOR WHICH IT WAS COMMISSIONED. UNAUTHORISED USE OF THE DOCUMENTATION IS PROHIBITED.


ROAD INFRASTRUCTURE LEGEND

- SOUTHERN LOGISTICS TO FORM PART OF SCH STAGE 1 AND THE CCCC SSDA REFER TO SSD-10831778 FOR DETAIL OF DESIGN

GROUND ENTRY POINT

BASEMENT ENTRY POINT

Scale:
1:500 @ A1
1:1000 @ A3

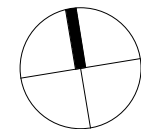

architectus[™]



ABN 90 131 245 684

project

UNSW Health Translation Hub

drawing

Site Plan

scale 1 : 500@A1

drawing no.

drawn TH

DA0020

checked JC

issue


project no 190551.00

A

22/02/2021 6:28:48 PM

[illegible]

DO NOT SCALE FROM THE DRAWINGS, USE ONLY FIGURED DIMENSIONS.
ALL DIMENSIONS ARE IN MILLIMETRES UNLESS OTHERWISE STATED.
REDUCED LEVELS (RL) ARE TO AUSTRALIAN HEIGHT DATUM (AHD).
COORDINATES ARE TO MAP GRID AUSTRALIA (MGA).
THE ARCHITECTURAL DOCUMENTATION IS ONLY ALLOWED TO BE USED
FOR THE PURPOSE FOR WHICH IT WAS COMMISSIONED. UNAUTHORISED
USE OF THE DOCUMENTATION IS PROHIBITED.


 - SOUTHERN LOGISTICS TO FORM PART OF SCH STAGE 1 AND THE CCCC SSDA REFER TO SSD-10831778 FOR DETAIL OF DESIGN



Project

Drawing

scale	1 : 500@A1	drawing no.
awn	TH	DA0030
checked	JC	issue
project no	190551.00	A

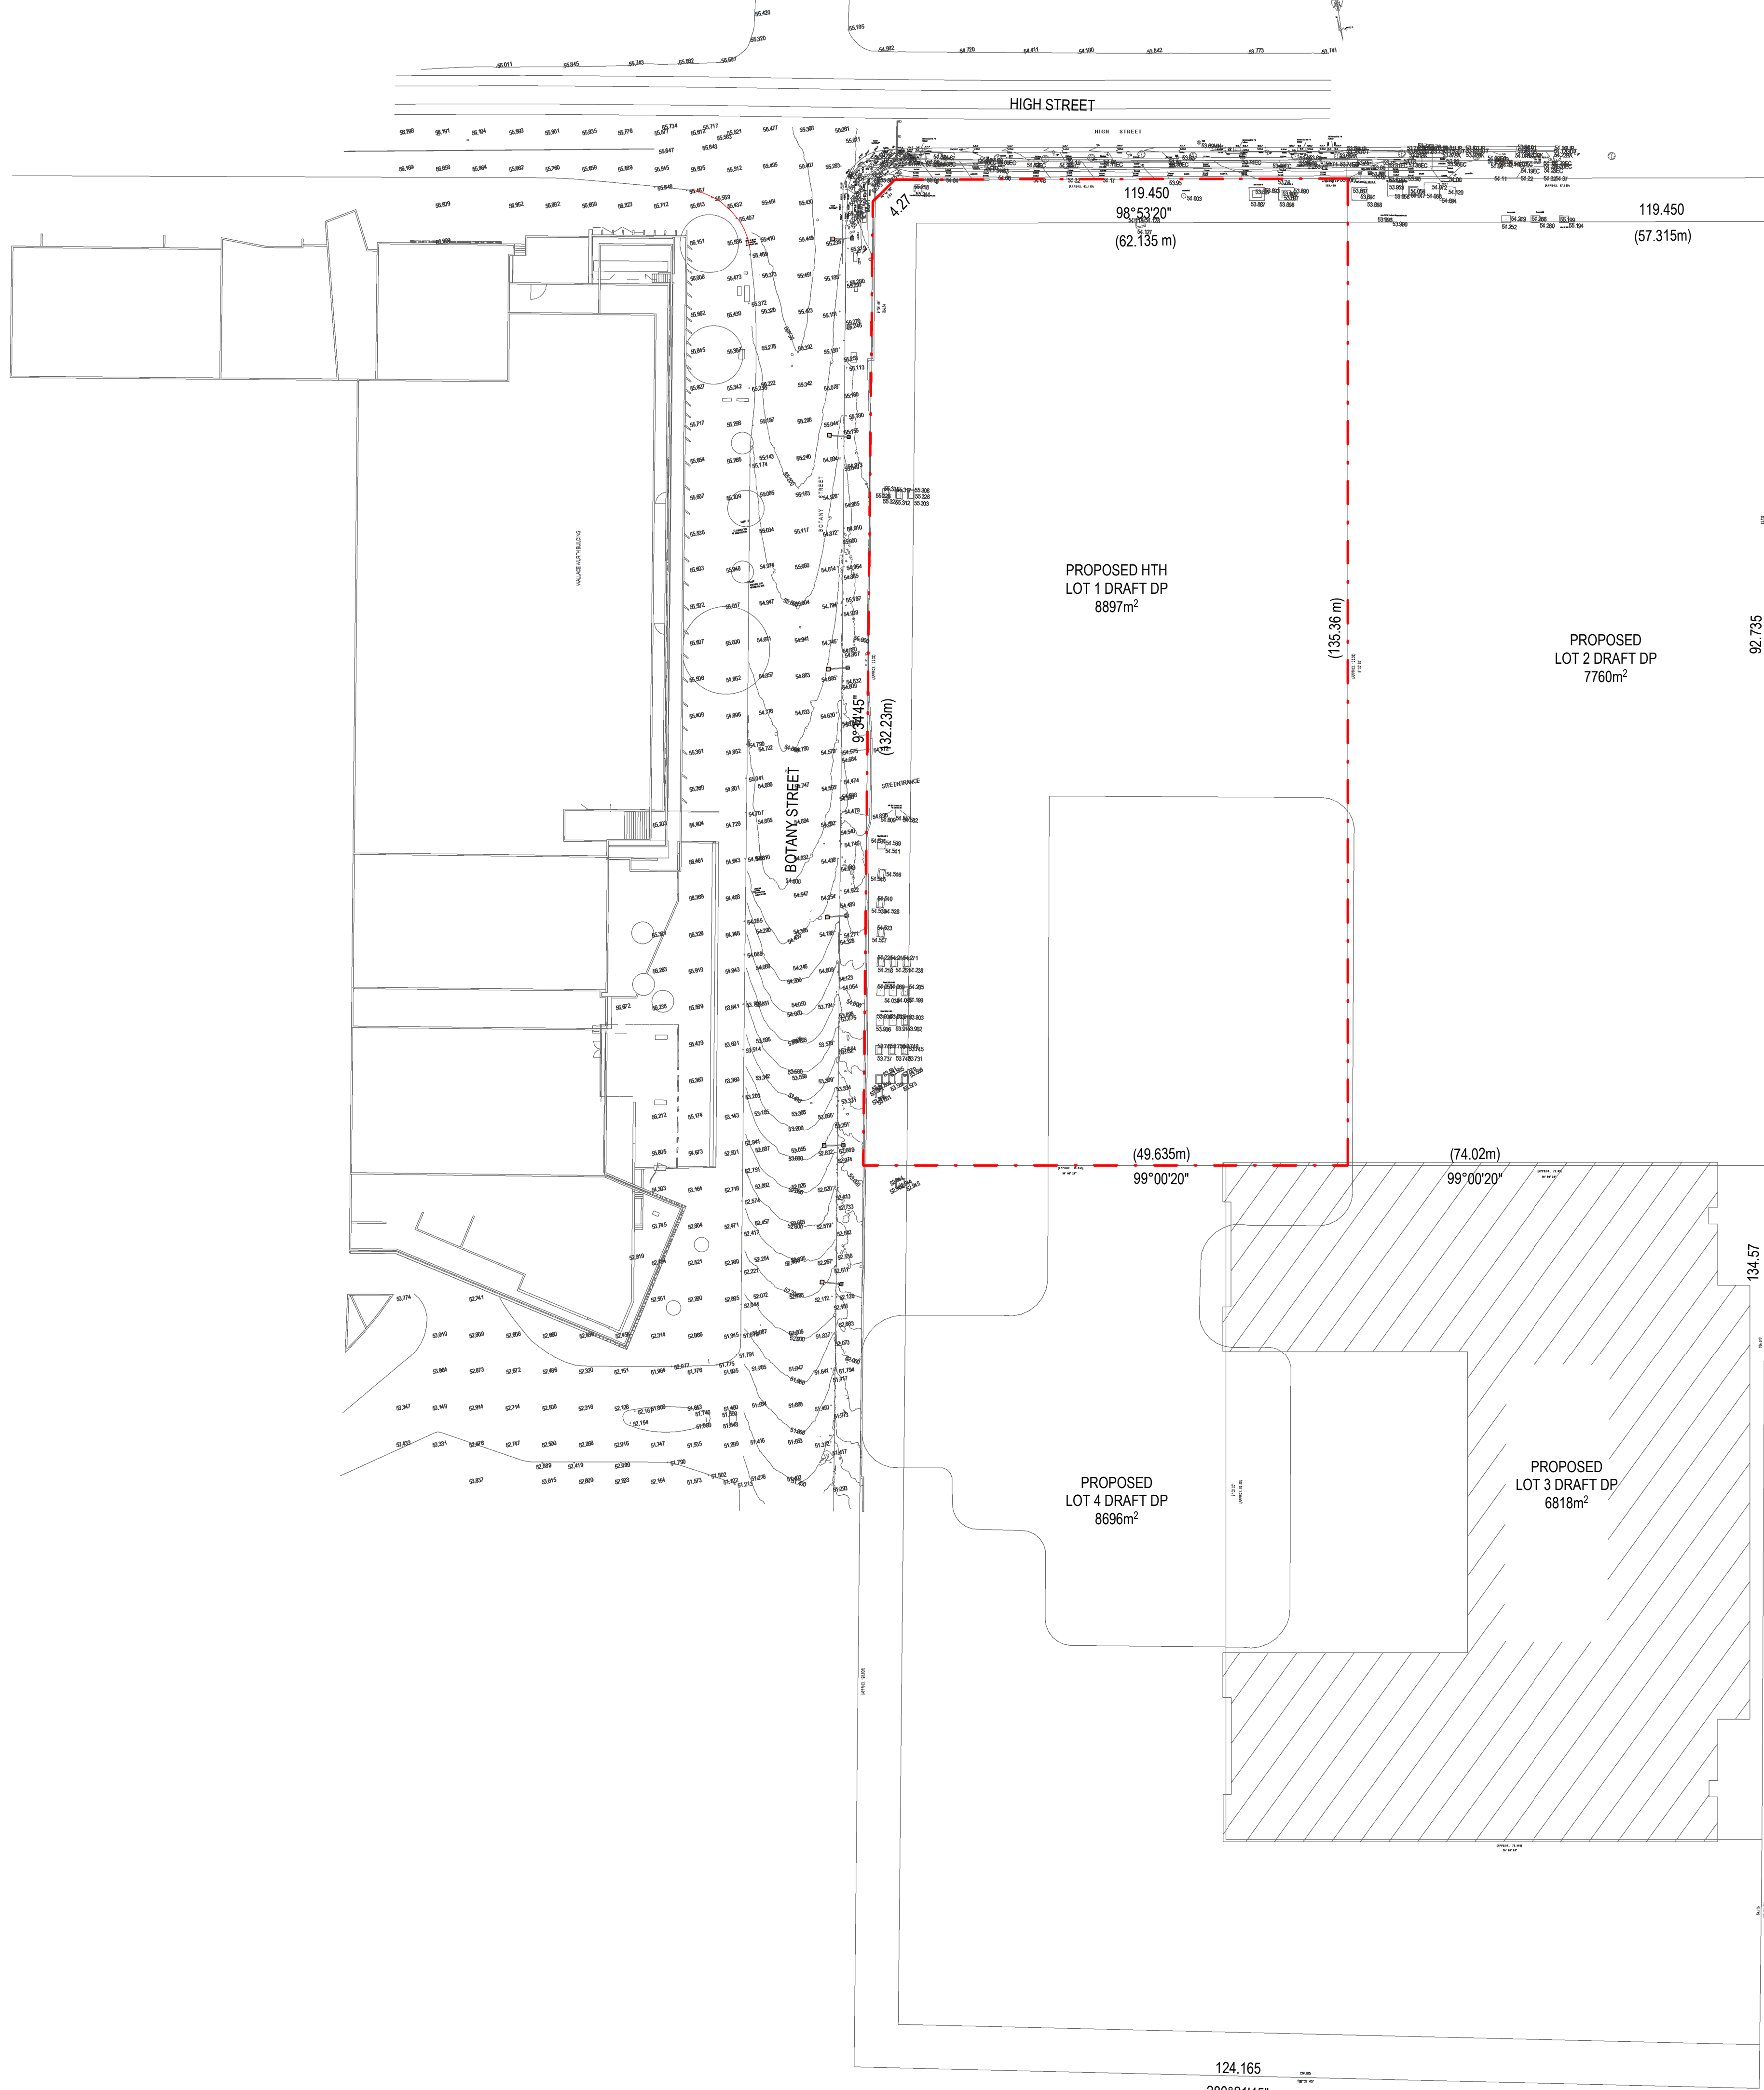

architectus™

Architectus Australia Pty Ltd is the owner of the copyright subsisting in these drawings, plans, designs and specifications. They must not be used, reproduced or copied, in whole or in part, nor may the information, ideas and concepts therein contained (which are confidential to Architectus Australia Pty Ltd) be disclosed to any person without the prior written consent of that company.

Nominated Architect
Ray Brown, NSWARB 6359

Do not scale drawings. Verify all dimensions on site

issue	amendment	date
A	ISSUED FOR STATE SIGNIFICANT DEVELOPMENT APPLICATION	18.02.21

GENERAL NOTES:

- DO NOT SCALE FROM THE DRAWINGS. USE ONLY FIGURED DIMENSIONS.
- ALL DIMENSIONS ARE IN MILLIMETRES UNLESS OTHERWISE STATED.
- REDUCED LEVELS (RL) ARE TO AUSTRALIAN HEIGHT DATUM (AHD).
- COORDINATES ARE TO MAP GRID AUSTRALIA (MGA).
- THE ARCHITECTURAL DOCUMENTATION IS ONLY ALLOWED TO BE USED FOR THE PURPOSE FOR WHICH IT WAS COMMISSIONED. UNAUTHORISED USE OF THE DOCUMENTATION IS PROHIBITED.

Survey by Total Surveying Solutions - 26/11/2020

DESIGN DRAWINGS ARE BASED ON 3RD PARTY SURVEY INFORMATION. PRIOR TO CONSTRUCTION ALL SET-OUT DIMENSION AND SUITE AND PROPERTY BOUNDARIES ARE TO BE VERIFIED ON SITE BY A REGISTERED SURVEYOR. NOTIFY THE SUPERINTENDENT IN WRITING OF COMPLIANCE TO THE DRAWING AND OR ANY DISCREPANCIES

1:200 @ A1
1:400 @ A3




ABN 90 131 245 684

project
UNSW Health Translation Hub

drawing

Site Survey		
scale	1 : 500@A1	drawing no.
drawn	TH	DA0050
checked	JC	issue
project no	190551.00	A

17/02/2021 3:21:12 PM

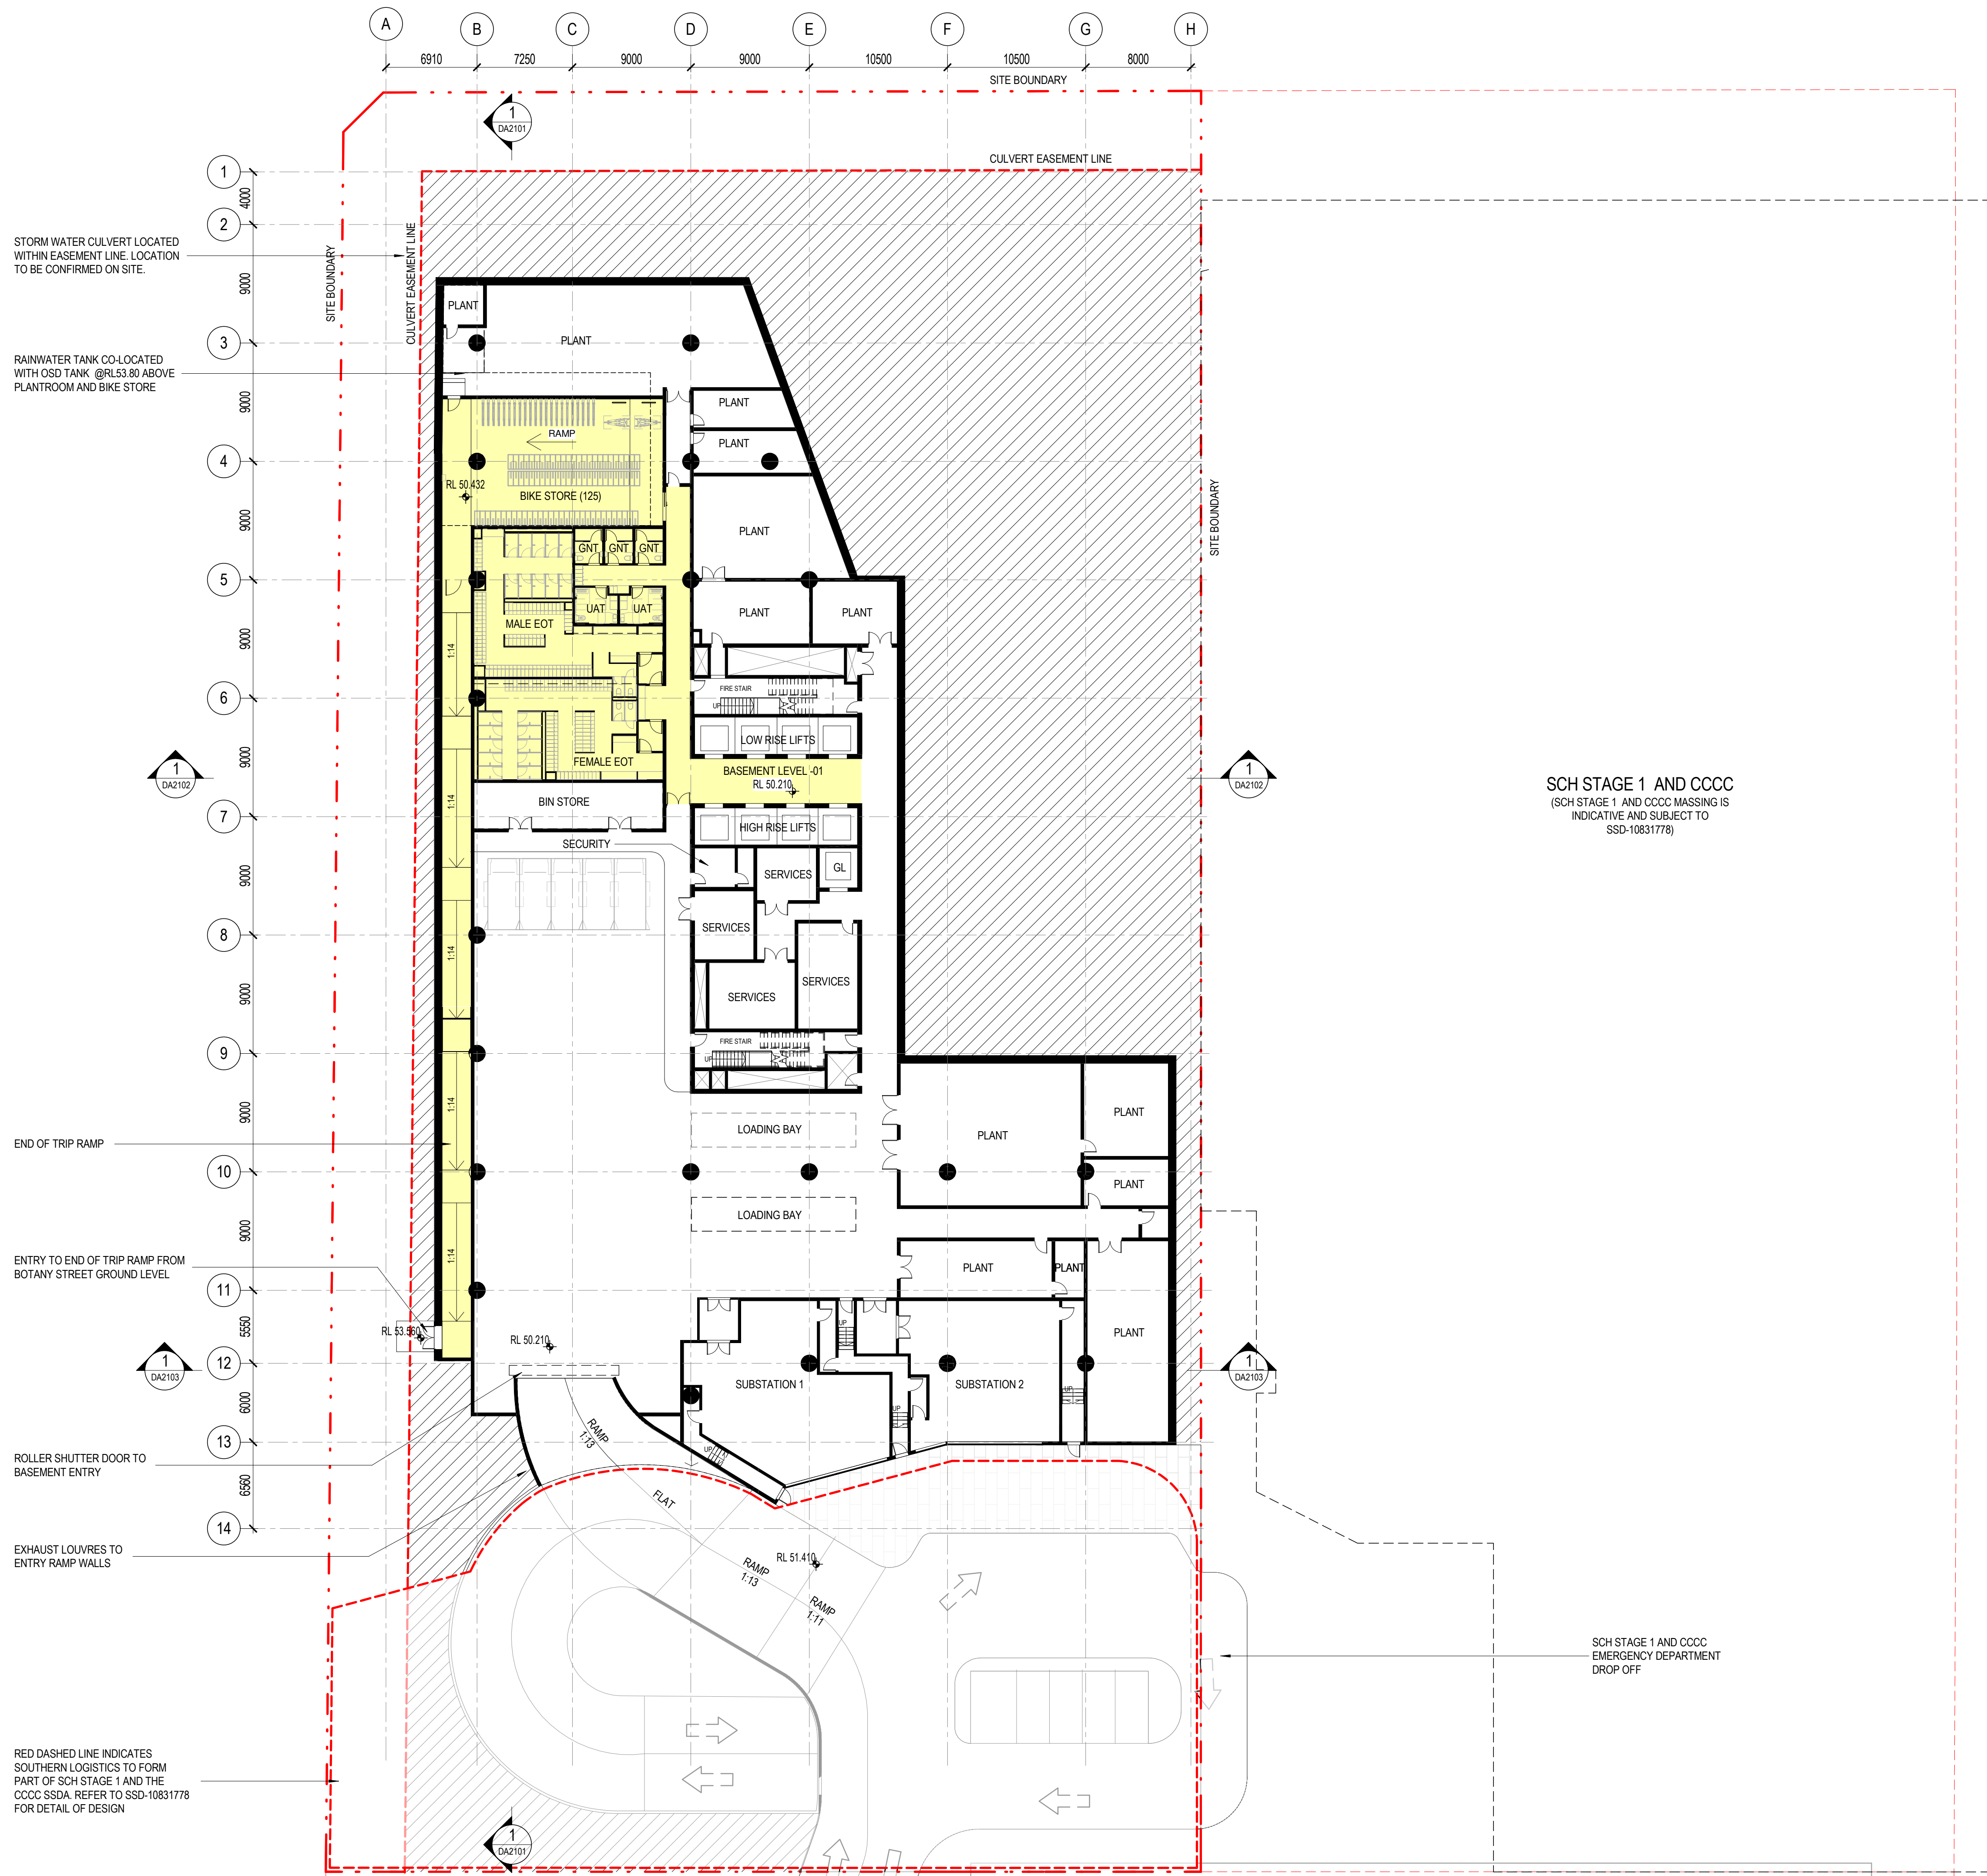

architectus™

Architectus Australia Pty Ltd is the owner of the copyright subsisting in these drawings, plans, designs and specifications. They must not be used, reproduced or copied, in whole or in part, nor may the information, ideas and concepts therein contained (which are confidential to Architectus Australia Pty Ltd) be disclosed to any person without the prior written consent of that company.

Nominated Architect
Ray Brown, NSWARB 6359

Do not scale drawings. Verify all dimensions on site

issue	amendment	date
A	ISSUED FOR STATE SIGNIFICANT DEVELOPMENT APPLICATION	18.02.21

- GENERAL NOTES:
- DO NOT SCALE FROM THE DRAWINGS. USE ONLY FIGURED DIMENSIONS.
 - ALL DIMENSIONS ARE IN MILLIMETRES UNLESS OTHERWISE STATED.
 - REDUCED LEVELS (RL) ARE TO AUSTRALIAN HEIGHT DATUM (AHD).
 - COORDINATES ARE TO MAP GRID AUSTRALIA (MGA).
 - THE ARCHITECTURAL DOCUMENTATION IS ONLY ALLOWED TO BE USED FOR THE PURPOSE FOR WHICH IT WAS COMMISSIONED. UNAUTHORISED USE OF THE DOCUMENTATION IS PROHIBITED.
- ROAD INFRASTRUCTURE LEGEND
- SOUTHERN LOGISTICS TO FORM PART OF SCH STAGE 1 AND THE CCCC SSDA REFER TO SSD-10831778 FOR DETAIL OF DESIGN
 - EOT FACILITY AREAS

Scale:
1:250 @ A1
1:500 @ A3

0 2.5 5 7.5 10

architectus™

UNSW SYDNEY

ABN 90 131 245 684

project
UNSW Health Translation Hub

drawing
Basement Level -01

scale
1 : 250@A1

drawn
TH


checked
JC

project no
190551.00

drawing no.
DA1000

issue
A

22/02/2021 5:59:17 PM

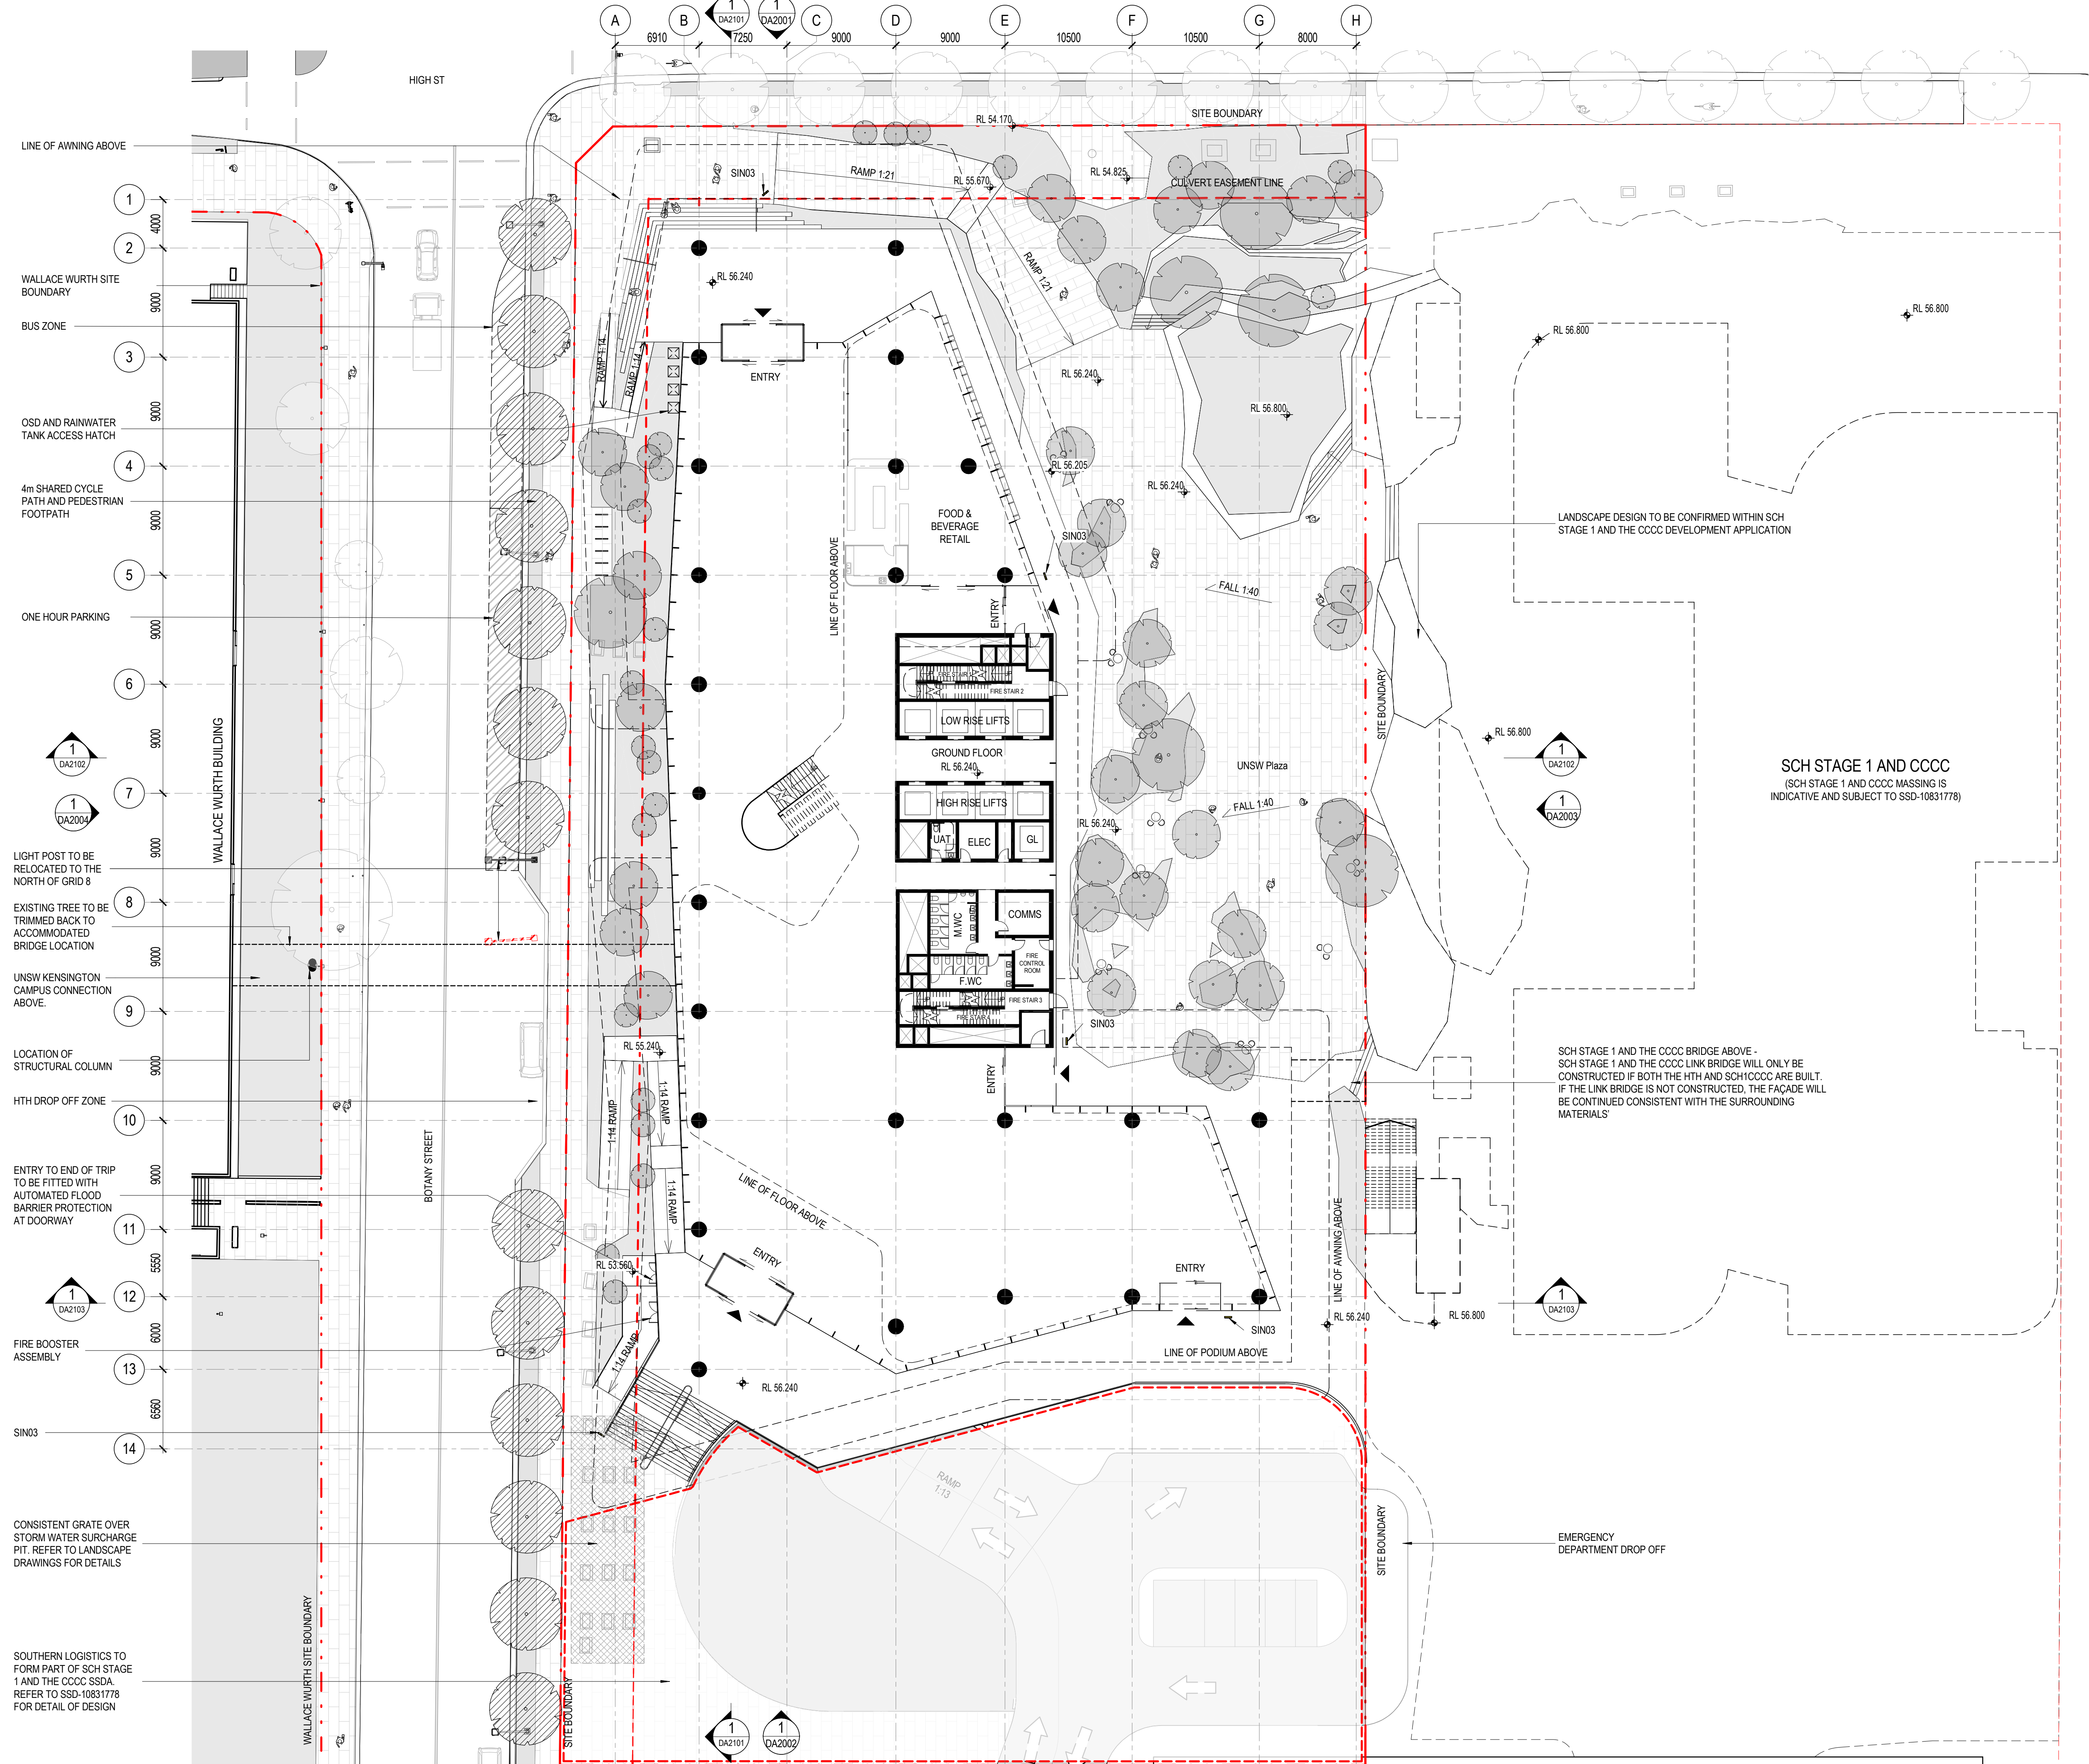

architectus™

Architectus Australia Pty Ltd is the owner of the copyright subsisting in these drawings, plans, designs and specifications. They must not be used, reproduced or copied, in whole or in part, nor may the information, ideas and concepts therein contained (which are confidential to Architectus Australia Pty Ltd) be disclosed to any person without the prior written consent of that company.

Nominated Architect
Ray Brown, NSWARB 6359

Do not scale drawings. Verify all dimensions on site

issue	amendment	date
A	ISSUED FOR STATE SIGNIFICANT DEVELOPMENT APPLICATION	18.02.21



GENERAL NOTES:

- DO NOT SCALE FROM THE DRAWINGS. USE ONLY FIGURED DIMENSIONS. ALL DIMENSIONS ARE IN MILLIMETRES UNLESS OTHERWISE STATED.
- REDUCED LEVELS (RL) ARE TO AUSTRALIAN HEIGHT DATUM (AHD).
- COORDINATES ARE TO MAP GRID AUSTRALIA (MGA).
- THE ARCHITECTURAL DOCUMENTATION IS ONLY ALLOWED TO BE USED FOR THE PURPOSE FOR WHICH IT WAS COMMISSIONED. UNAUTHORISED USE OF THE DOCUMENTATION IS PROHIBITED.

LEGEND

- SOUTHERN LOGISTICS TO FORM PART OF SCH STAGE 1 AND THE CCCC SSDA REFER TO SSD-10831778 FOR DETAIL OF DESIGN

  SIN03 - STREET LEVEL DIRECTIONAL SIGN




SCH STAGE 1 AND CCCC
(SCH STAGE 1 AND CCCC MASSING IS INDICATIVE AND SUBJECT TO SSD-10831778)

SCH STAGE 1 AND THE CCCC BRIDGE ABOVE - SCH STAGE 1 AND THE CCCC LINK BRIDGE WILL ONLY BE CONSTRUCTED IF BOTH THE HTH AND SCH1CCCC ARE BUILT. IF THE LINK BRIDGE IS NOT CONSTRUCTED, THE FAÇADE WILL BE CONTINUED CONSISTENT WITH THE SURROUNDING MATERIALS

Scale:
1:250 @ A1
1:500 @ A3

0 2.5 5 7.5 10

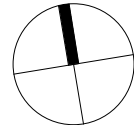

architectus™



ABN 90 131 245 684

project


UNSW Health Translation Hub

drawing

Ground 00

scale	1 : 250@A1	drawing no.	DA1001
drawn	TH	issue	
checked	JC		
project no	190551.00		A

22/02/2021 6:00:22 PM

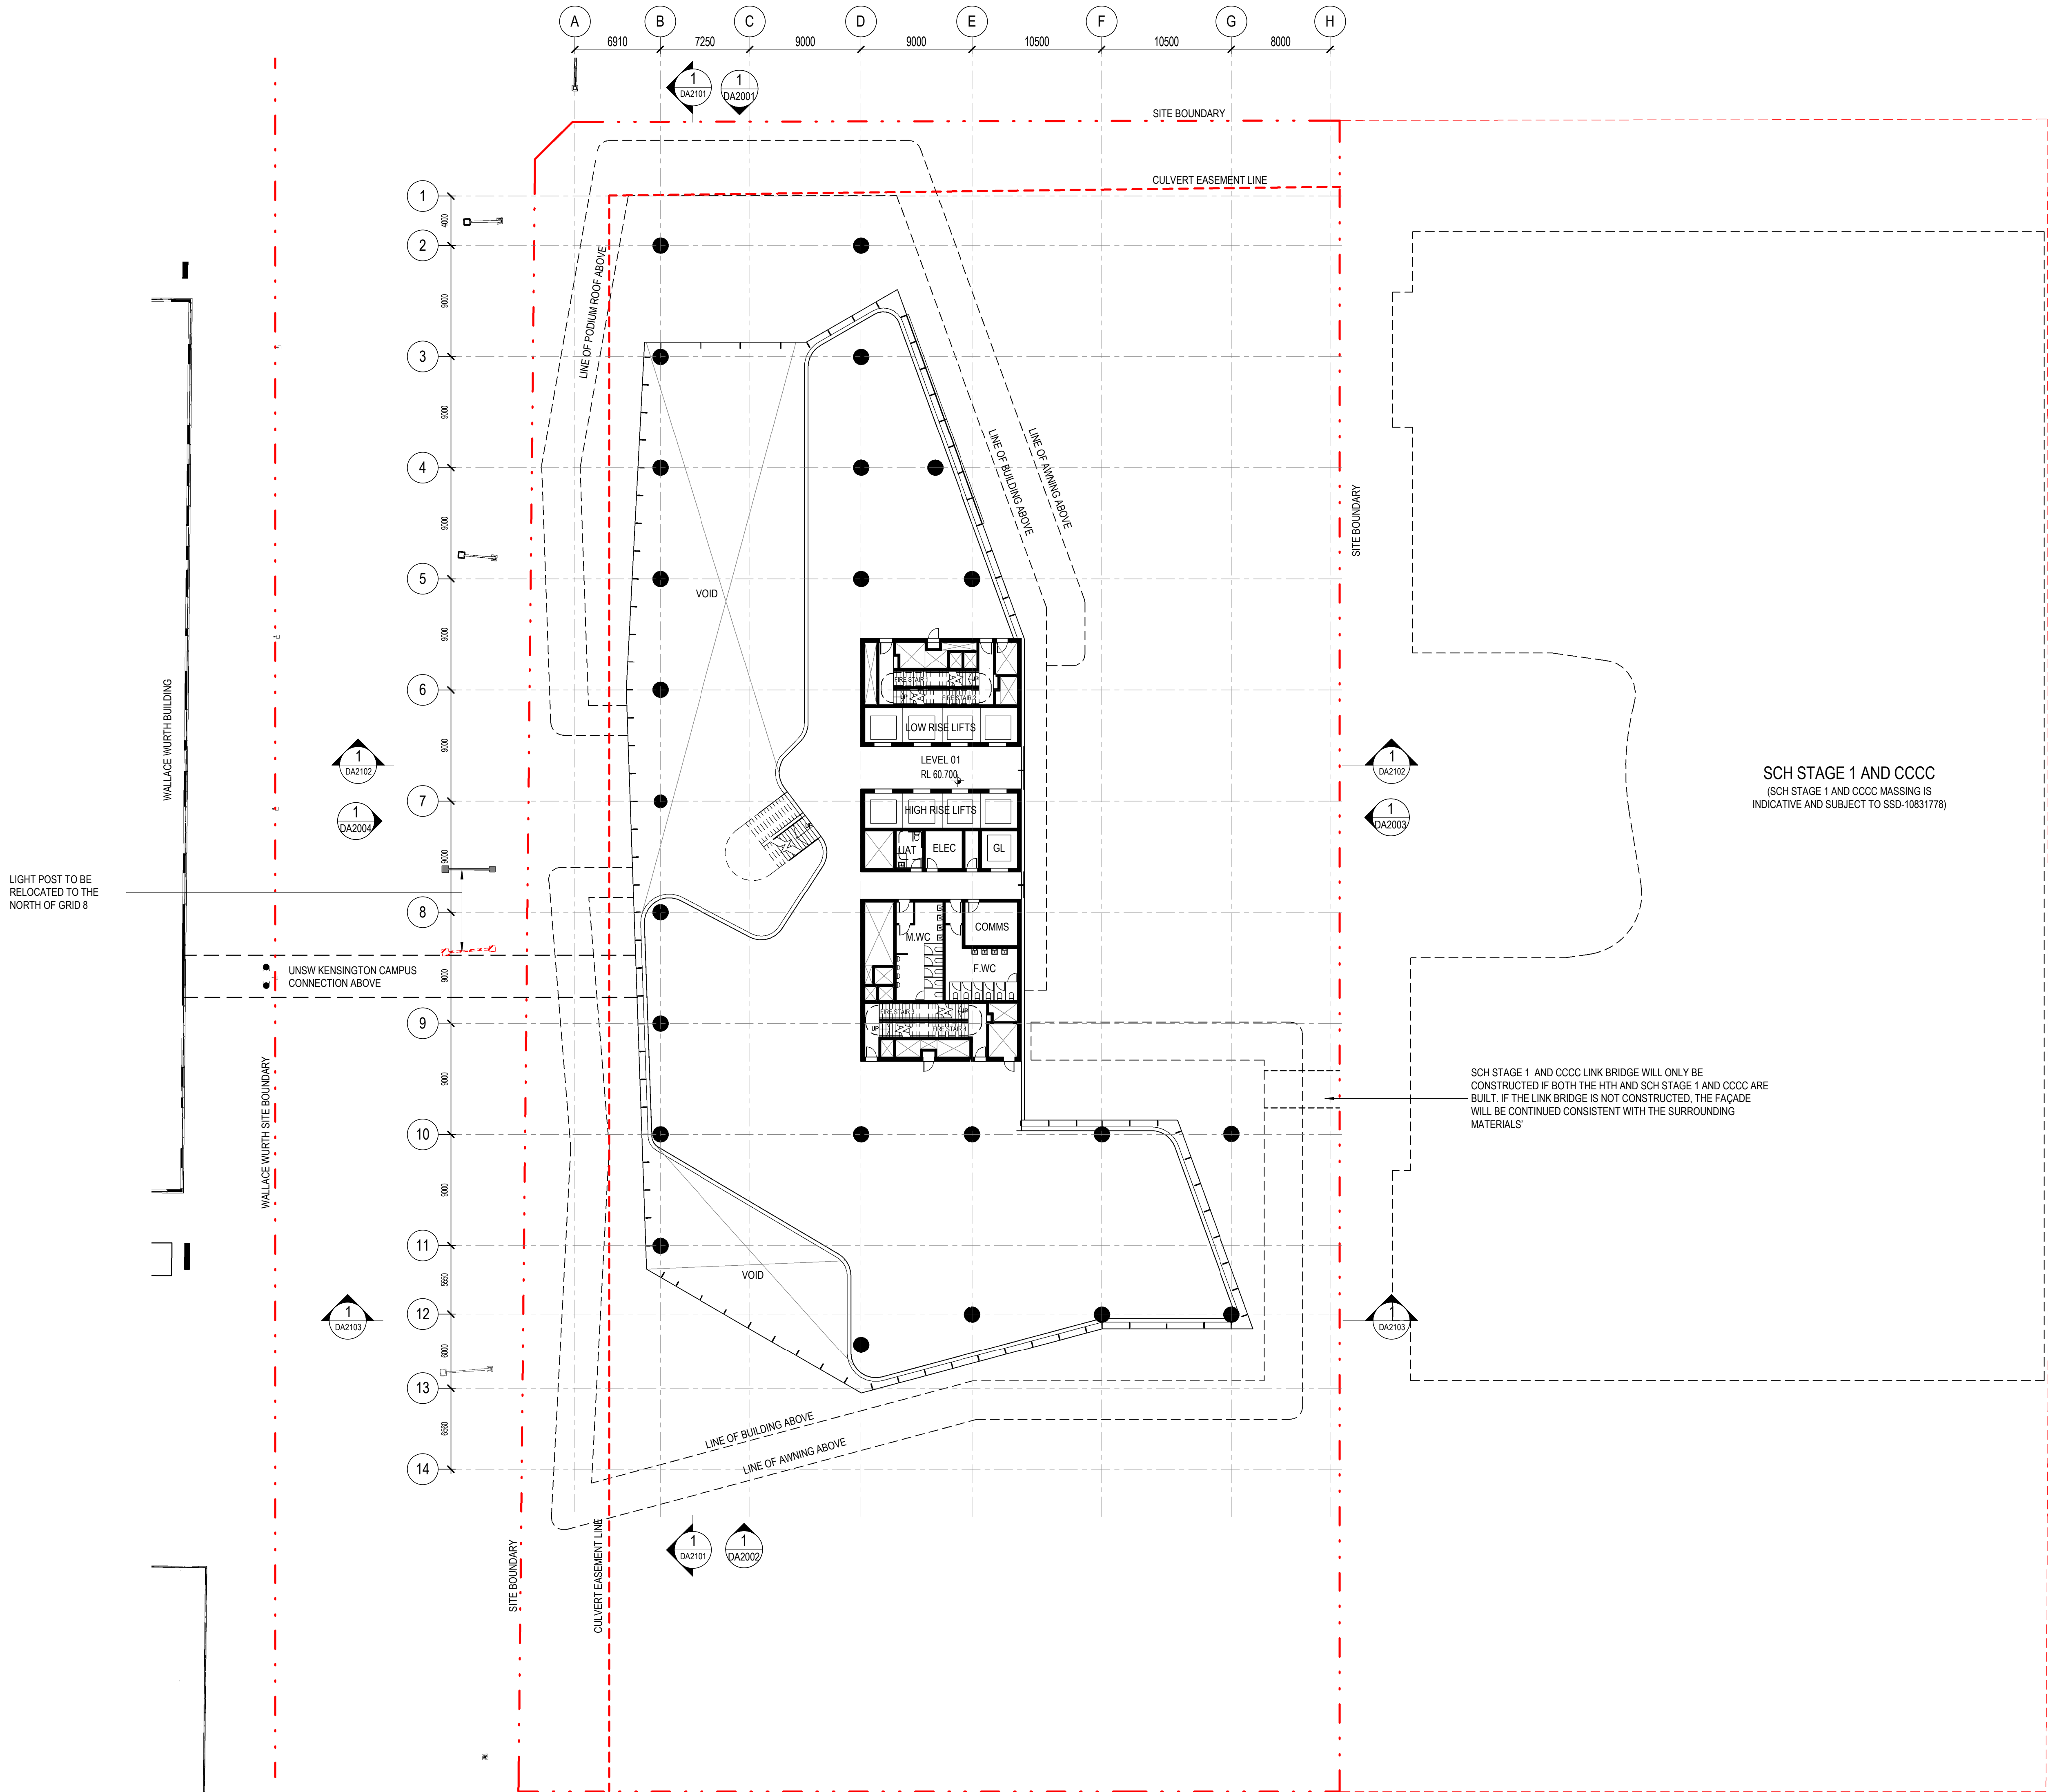

architectus™

Architectus Australia Pty Ltd is the owner of the copyright subsisting in these drawings, plans, designs and specifications. They must not be used, reproduced or copied, in whole or in part, nor may the information, ideas and concepts therein contained (which are confidential to Architectus Australia Pty Ltd) be disclosed to any person without the prior written consent of that company.

Nominated Architect
Ray Brown, NSWARB 6359

Do not scale drawings. Verify all dimensions on site


issue	amendment	date
A	ISSUED FOR STATE SIGNIFICANT DEVELOPMENT APPLICATION	18.02.21

GENERAL NOTES:

- DO NOT SCALE FROM THE DRAWINGS. USE ONLY FIGURED DIMENSIONS.
- ALL DIMENSIONS ARE IN MILLIMETRES UNLESS OTHERWISE STATED.
- REDUCED LEVELS (RL) ARE TO AUSTRALIAN HEIGHT DATUM (AHD).
- COORDINATES ARE TO MAP GRID AUSTRALIA (MGA).
- THE ARCHITECTURAL DOCUMENTATION IS ONLY ALLOWED TO BE USED FOR THE PURPOSE FOR WHICH IT WAS COMMISSIONED. UNAUTHORISED USE OF THE DOCUMENTATION IS PROHIBITED.

Scale:
1:250 @ A1
1:500 @ A3

0 2.5 5 7.5 10

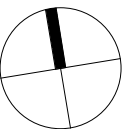

architectus™




ABN 90 131 245 684

project
UNSW Health Translation Hub

drawing

scale	1 : 250@A1	drawing no.	Level 01
drawn	TH	DA1002	
checked	JC	issue	
project no	190551.00	A	

22/02/2021 1:23:38 PM

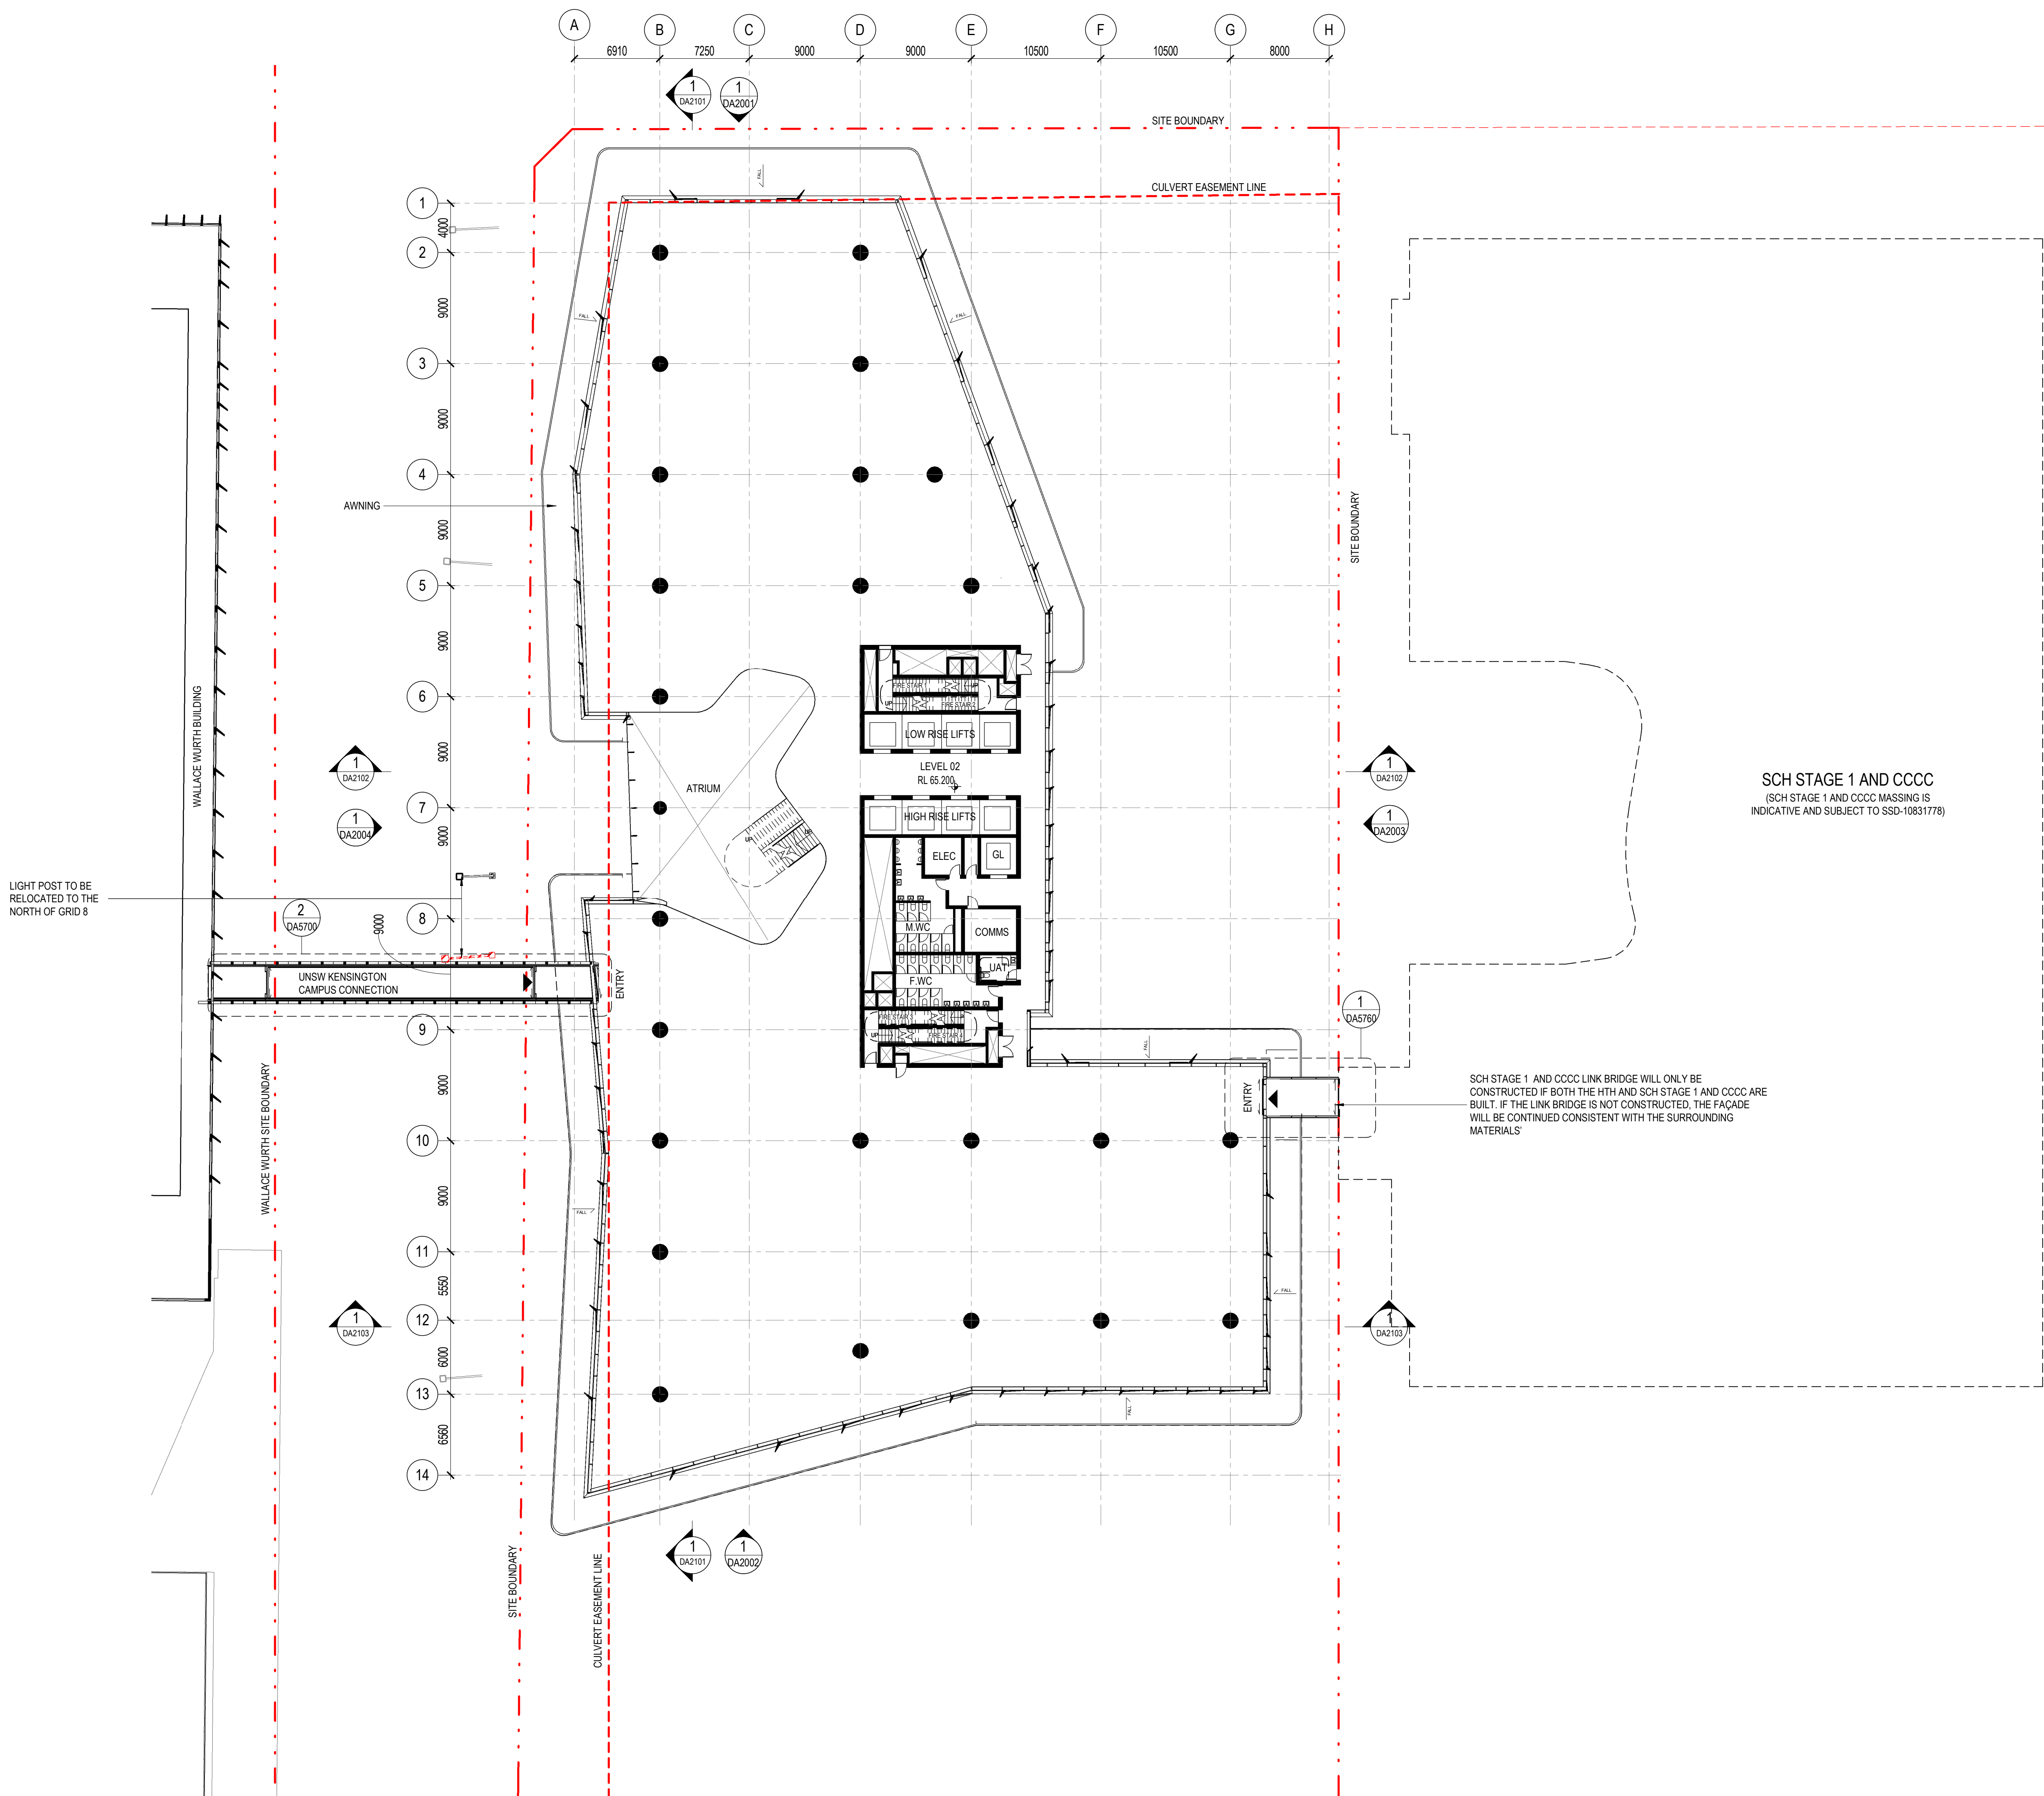

architectus™

Architectus Australia Pty Ltd is the owner of the copyright subsisting in these drawings, plans, designs and specifications. They must not be used, reproduced or copied, in whole or in part, nor may the information, ideas and concepts therein contained (which are confidential to Architectus Australia Pty Ltd) be disclosed to any person without the prior written consent of that company.

Nominated Architect
Ray Brown, NSWARB 6359


Do not scale drawings. Verify all dimensions on site

issue	amendment	date
A	ISSUED FOR STATE SIGNIFICANT DEVELOPMENT APPLICATION	18.02.21

- GENERAL NOTES:
- DO NOT SCALE FROM THE DRAWINGS. USE ONLY FIGURED DIMENSIONS. ALL DIMENSIONS ARE IN MILLIMETRES UNLESS OTHERWISE STATED.
 - REDUCED LEVELS (RL) ARE TO AUSTRALIAN HEIGHT DATUM (AHD).
 - COORDINATES ARE TO MAP GRID AUSTRALIA (MGA).
 - THE ARCHITECTURAL DOCUMENTATION IS ONLY ALLOWED TO BE USED FOR THE PURPOSE FOR WHICH IT WAS COMMISSIONED. UNAUTHORISED USE OF THE DOCUMENTATION IS PROHIBITED.

Scale:
1:250 @ A1
1:500 @ A3

0 2.5 5 7.5 10

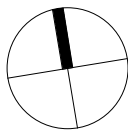

architectus™




ABN 90 131 245 684

project
UNSW Health Translation Hub

drawing

scale	1 : 250@A1	drawing no.	Level 02
drawn	TH	DA1003	
checked	JC	issue	
project no	190551.00	A	

22/02/2021 12:57:58 PM

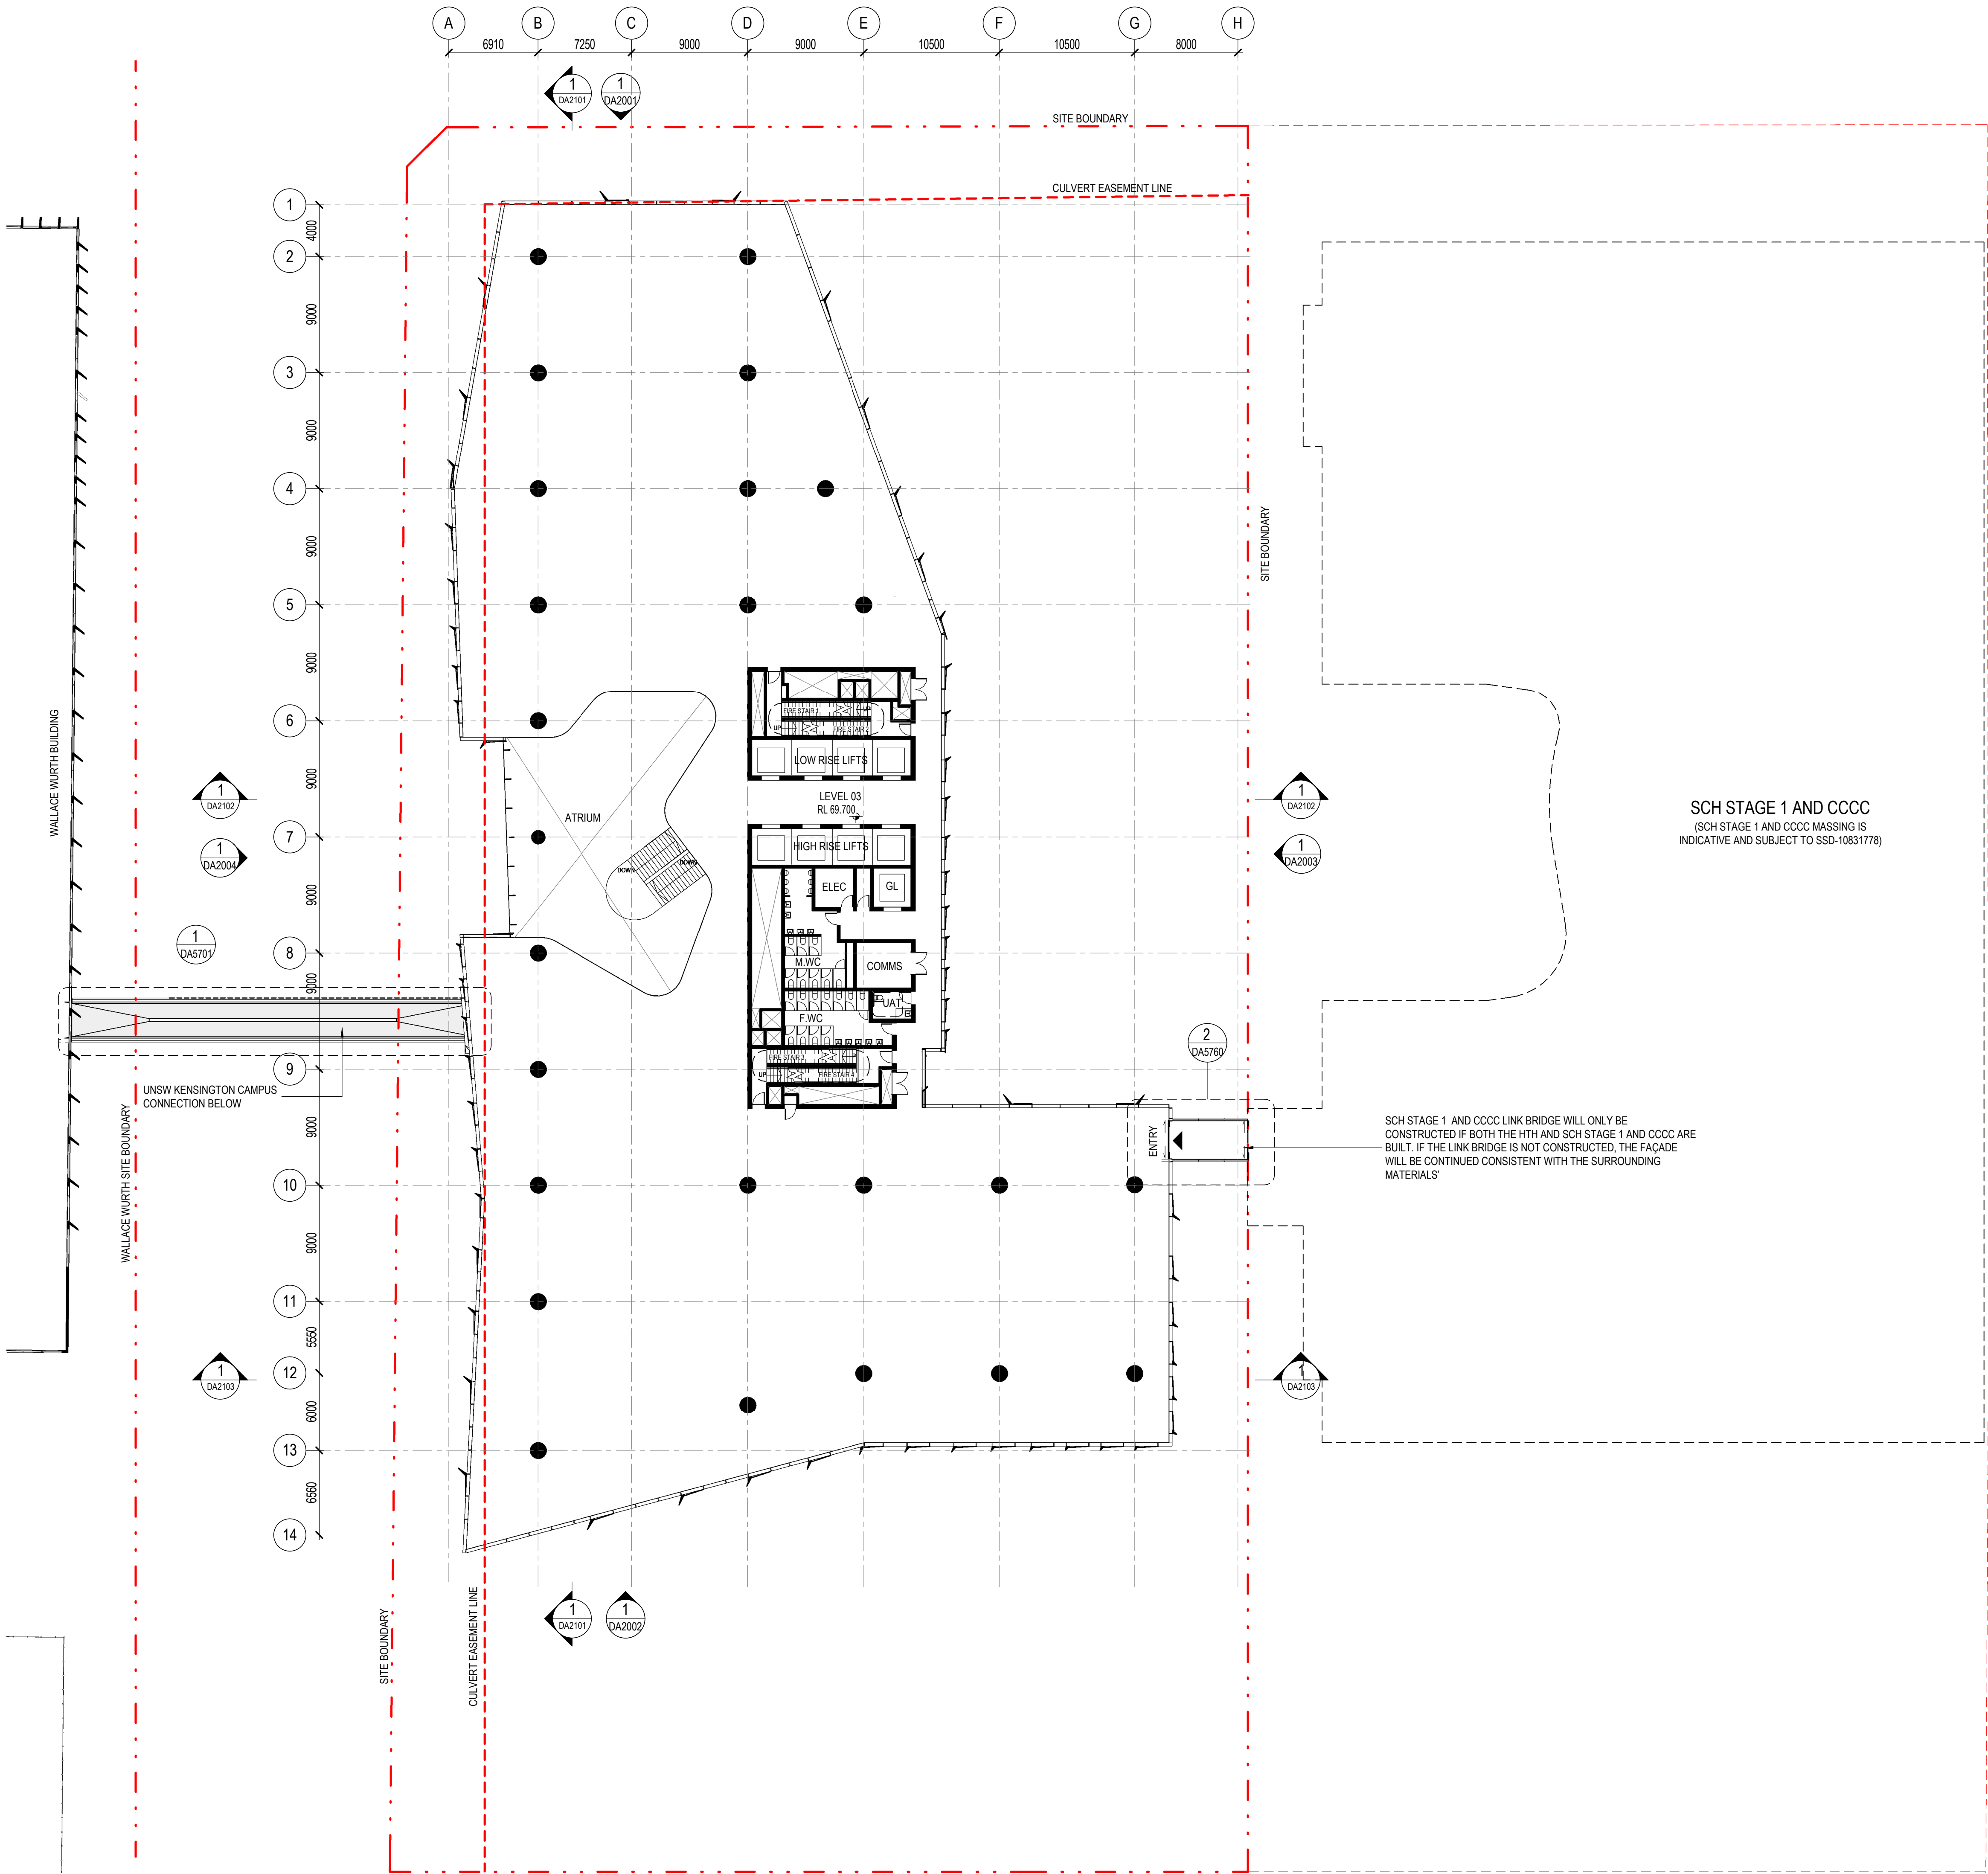

architectus™

Architectus Australia Pty Ltd is the owner of the copyright subsisting in these drawings, plans, designs and specifications. They must not be used, reproduced or copied, in whole or in part, nor may the information, ideas and concepts therein contained (which are confidential to Architectus Australia Pty Ltd) be disclosed to any person without the prior written consent of that company.

Nominated Architect
Ray Brown, NSWARB 6359

Do not scale drawings. Verify all dimensions on site

issue	amendment	date
A	ISSUED FOR STATE SIGNIFICANT DEVELOPMENT APPLICATION	18.02.21

- GENERAL NOTES:
- DO NOT SCALE FROM THE DRAWINGS. USE ONLY FIGURED DIMENSIONS.
 - ALL DIMENSIONS ARE IN MILLIMETRES UNLESS OTHERWISE STATED.
 - REDUCED LEVELS (RL) ARE TO AUSTRALIAN HEIGHT DATUM (AHD).
 - COORDINATES ARE TO MAP GRID AUSTRALIA (MGA).
 - THE ARCHITECTURAL DOCUMENTATION IS ONLY ALLOWED TO BE USED FOR THE PURPOSE FOR WHICH IT WAS COMMISSIONED. UNAUTHORISED USE OF THE DOCUMENTATION IS PROHIBITED.

Scale:

1:250 @ A1
1:500 @ A3

0 2.5 5 7.5 10

architectus™

UNSW SYDNEY

ABN 90 131 245 684

project

UNSW Health Translation Hub

drawing


Level 03

scale 1 : 250@A1 drawing no. DA1004

drawn TH

checked JC issue

project no 190551.00 A

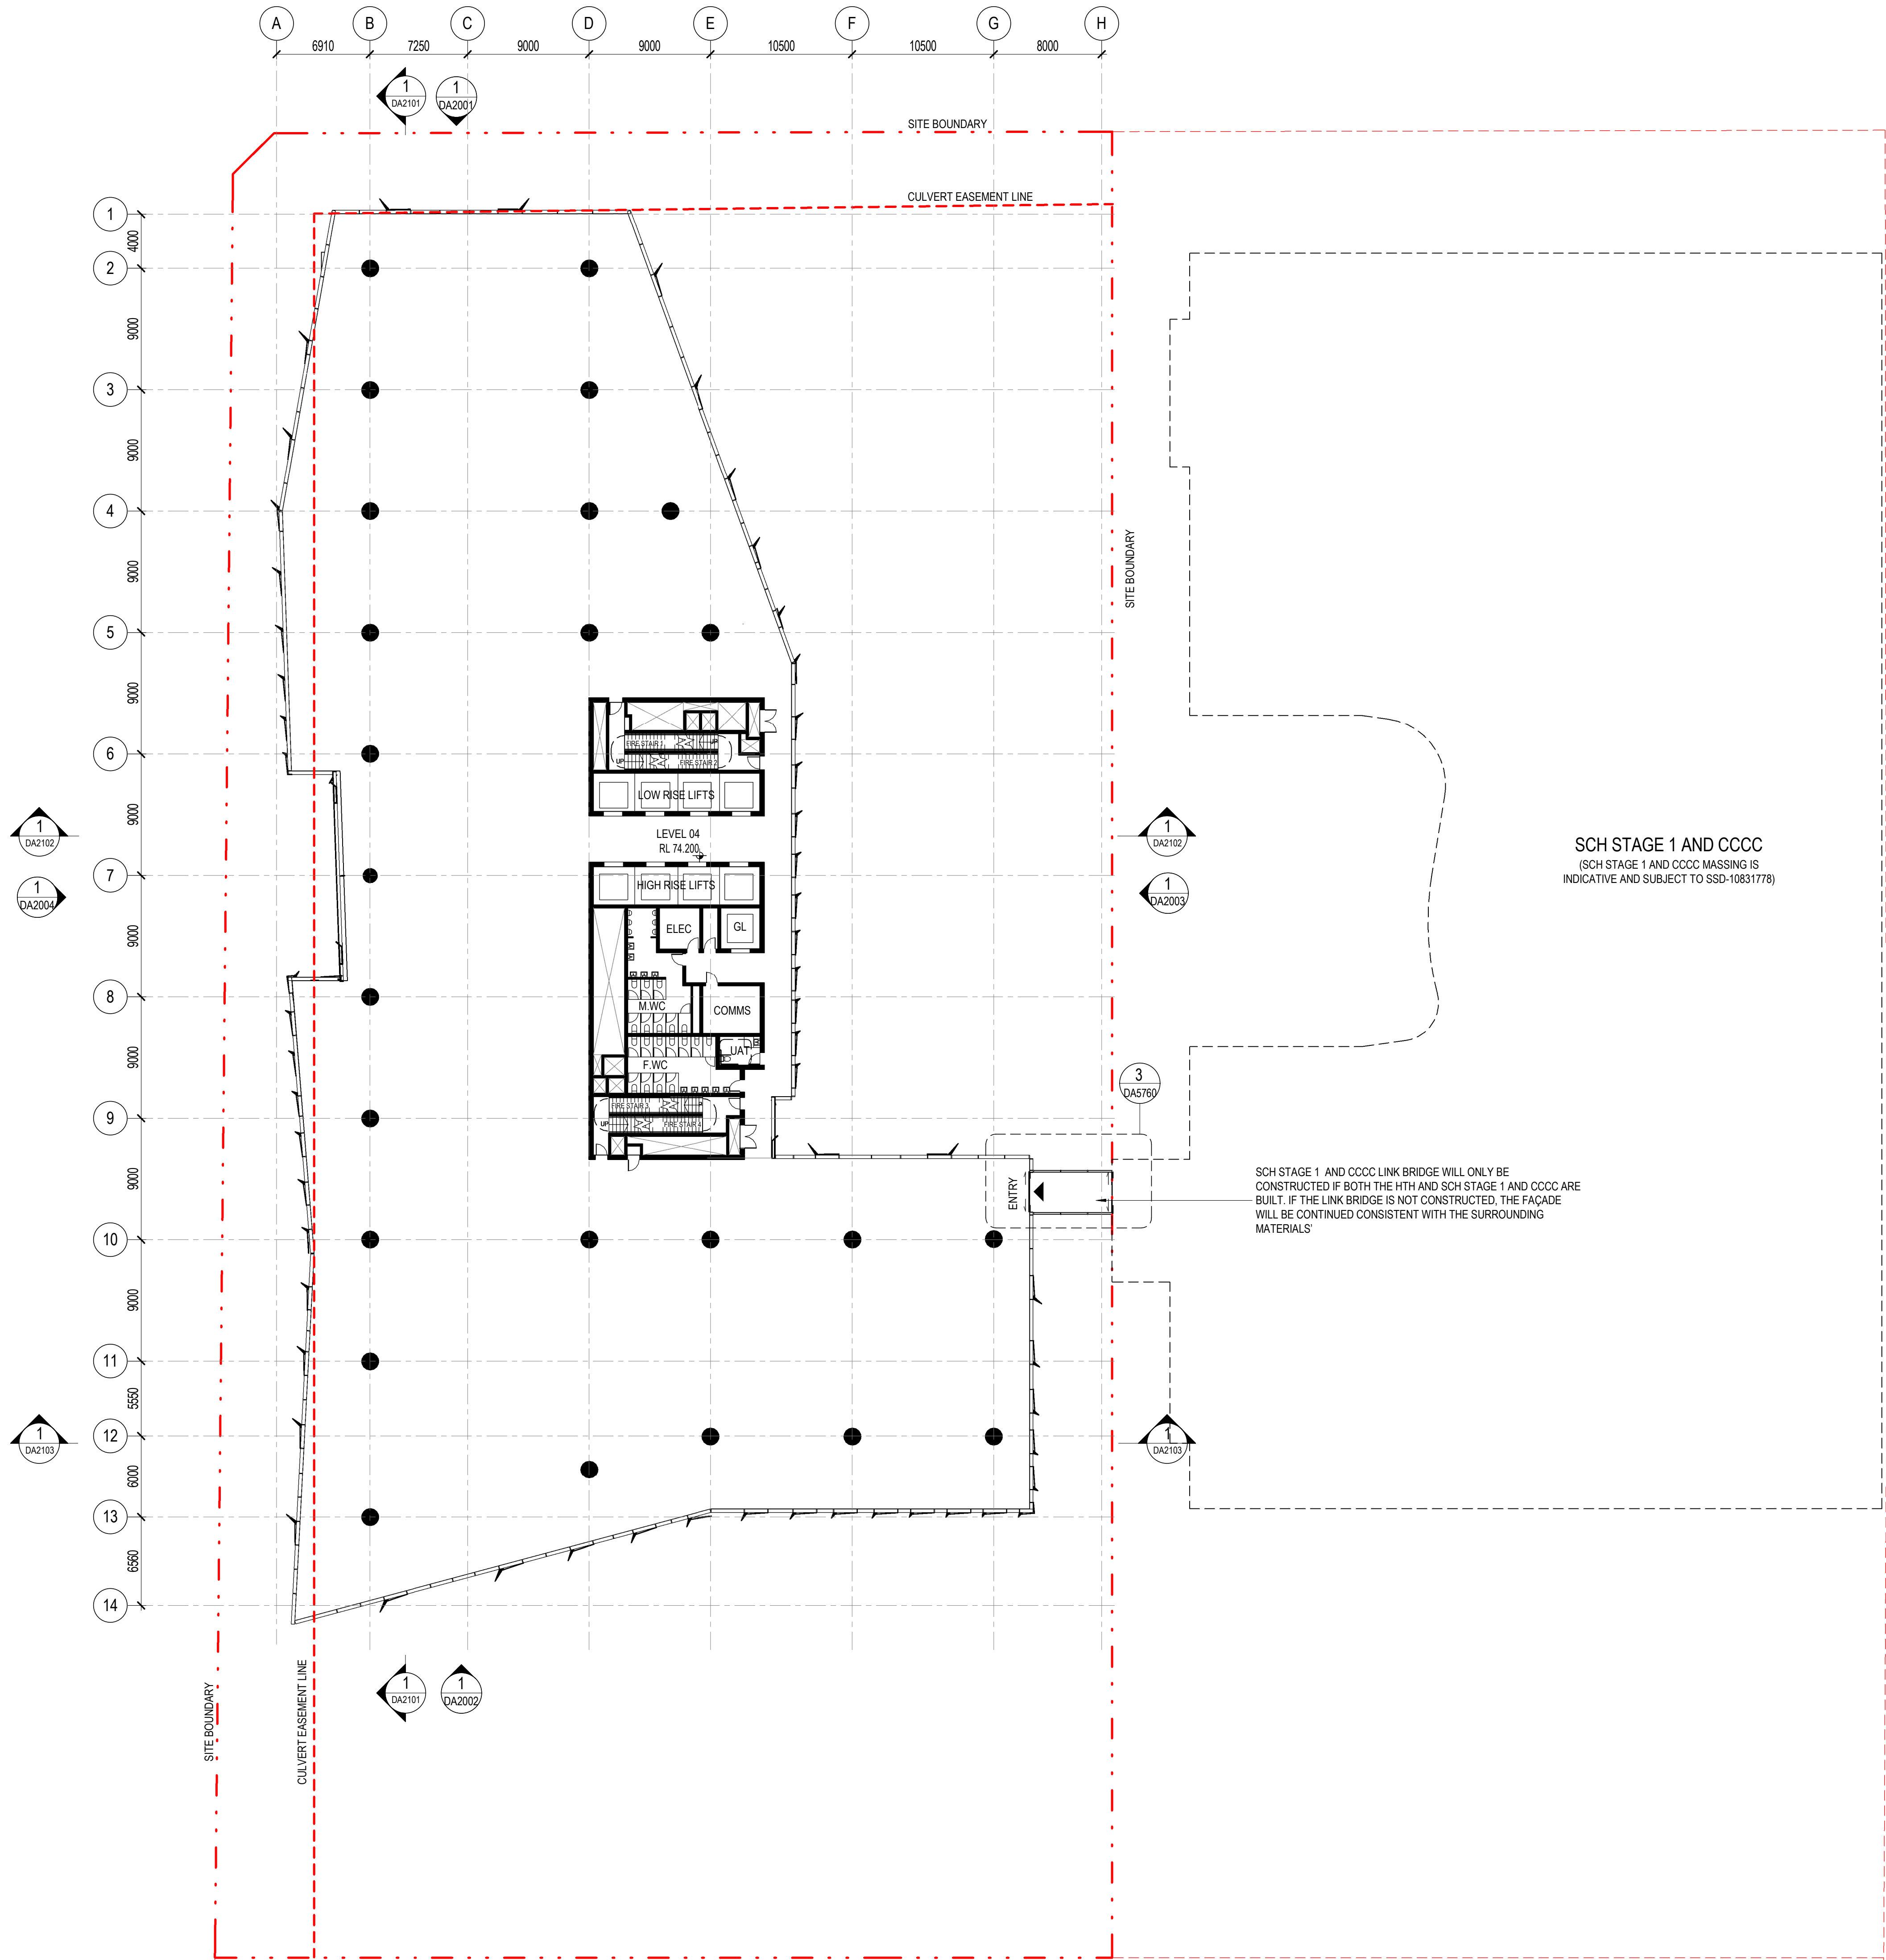

architectus™

Architectus Australia Pty Ltd is the owner of the copyright subsisting in these drawings, plans, designs and specifications. They must not be used, reproduced or copied, in whole or in part, nor may the information, ideas and concepts therein contained (which are confidential to Architectus Australia Pty Ltd) be disclosed to any person without the prior written consent of that company.

Nominated Architect
Ray Brown, NSWARB 6359


Do not scale drawings. Verify all dimensions on site

issue	amendment	date
A	ISSUED FOR STATE SIGNIFICANT DEVELOPMENT APPLICATION	18.02.21

- GENERAL NOTES:
- DO NOT SCALE FROM THE DRAWINGS. USE ONLY FIGURED DIMENSIONS.
 - ALL DIMENSIONS ARE IN MILLIMETRES UNLESS OTHERWISE STATED.
 - REDUCED LEVELS (RL) ARE TO AUSTRALIAN HEIGHT DATUM (AHD).
 - COORDINATES ARE TO MAP GRID AUSTRALIA (MGA).
 - THE ARCHITECTURAL DOCUMENTATION IS ONLY ALLOWED TO BE USED FOR THE PURPOSE FOR WHICH IT WAS COMMISSIONED. UNAUTHORISED USE OF THE DOCUMENTATION IS PROHIBITED.

Scale:
1:250 @ A1
1:500 @ A3

0 2.5 5 7.5 10

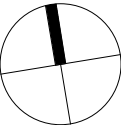

architectus™




ABN 90 131 245 684

project
UNSW Health Translation Hub

drawing

scale	1 : 250@A1	drawing no.	DA1005
drawn	TH	issue	
checked	JC		
project no	190551.00		A

22/02/2021 12:58:17 PM

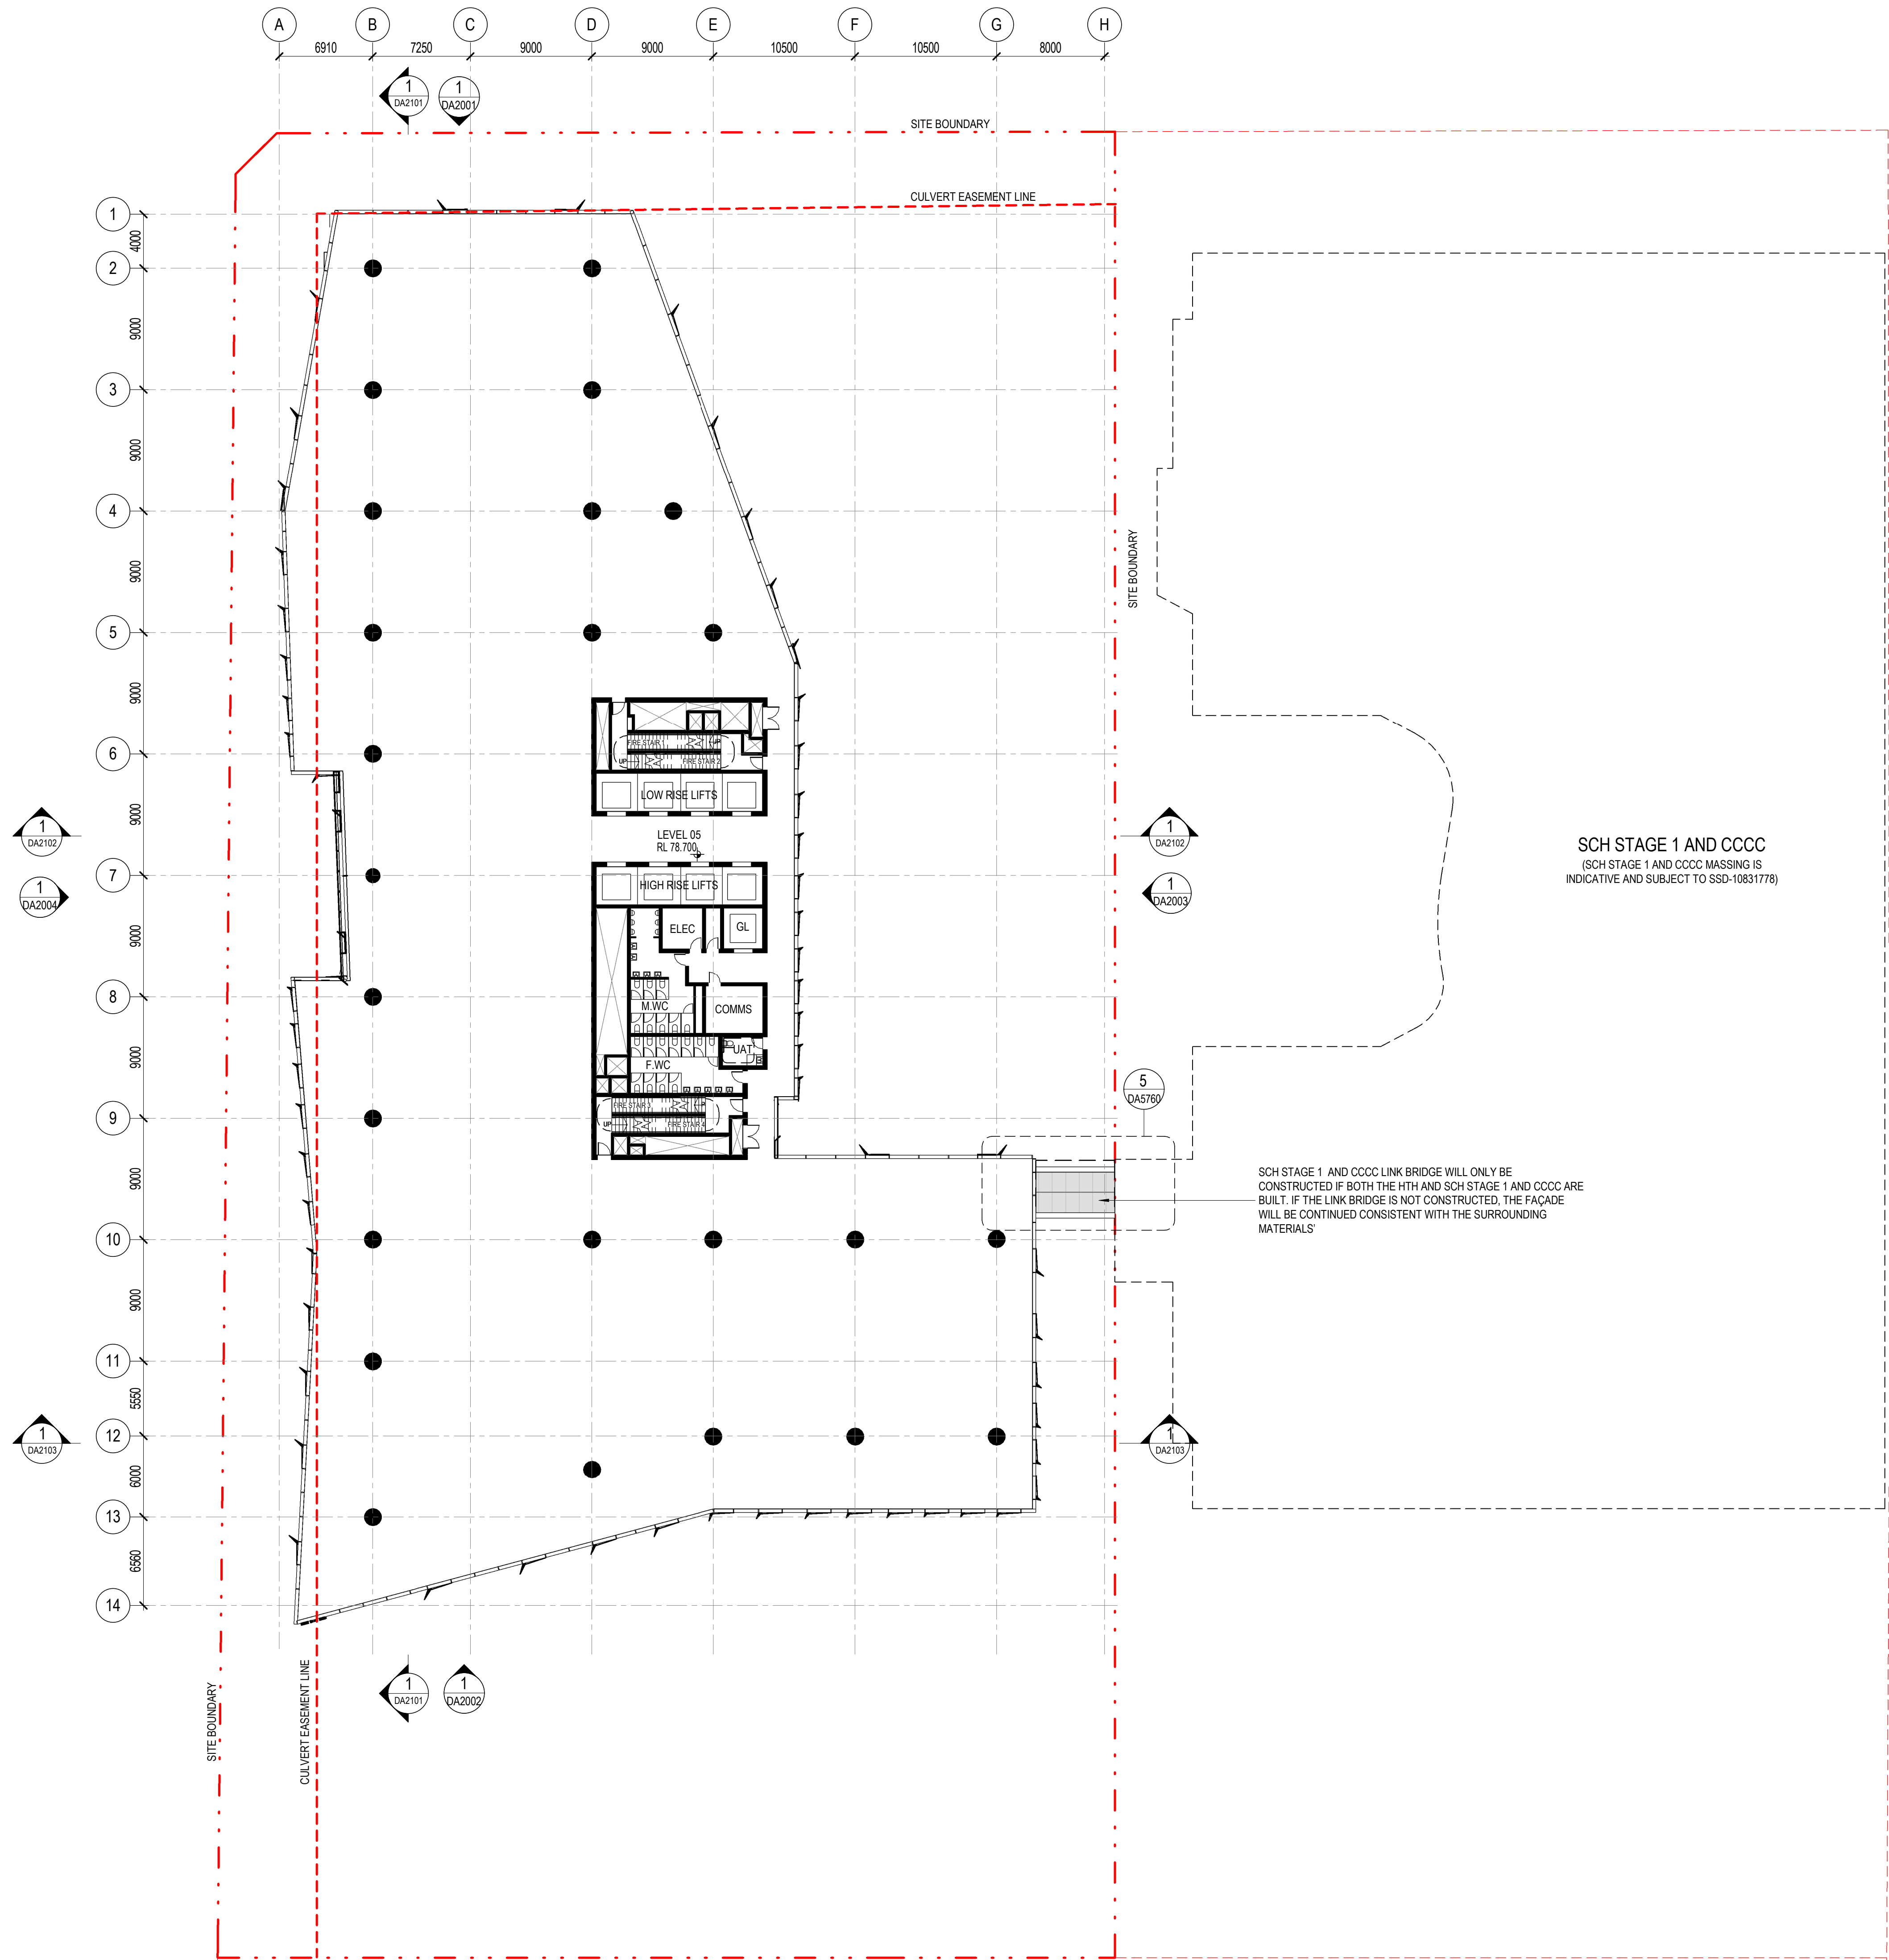

architectus™

Architectus Australia Pty Ltd is the owner of the copyright subsisting in these drawings, plans, designs and specifications. They must not be used, reproduced or copied, in whole or in part, nor may the information, ideas and concepts therein contained (which are confidential to Architectus Australia Pty Ltd) be disclosed to any person without the prior written consent of that company.

Nominated Architect
Ray Brown, NSWARB 6359

Do not scale drawings. Verify all dimensions on site

issue	amendment	date
A	ISSUED FOR STATE SIGNIFICANT DEVELOPMENT APPLICATION	18.02.21

GENERAL NOTES:

- DO NOT SCALE FROM THE DRAWINGS. USE ONLY FIGURED DIMENSIONS.
- ALL DIMENSIONS ARE IN MILLIMETRES UNLESS OTHERWISE STATED.
- REDUCED LEVELS (RL) ARE TO AUSTRALIAN HEIGHT DATUM (AHD).
- COORDINATES ARE TO MAP GRID AUSTRALIA (MGA).
- THE ARCHITECTURAL DOCUMENTATION IS ONLY ALLOWED TO BE USED FOR THE PURPOSE FOR WHICH IT WAS COMMISSIONED. UNAUTHORISED USE OF THE DOCUMENTATION IS PROHIBITED.

Scale:

1:250 @ A1
1:500 @ A3

0 2.5 5 7.5 10

architectus™




ABN 90 131 245 684

project
UNSW Health Translation Hub

drawing

scale	1 : 250@A1	drawing no.	Level 05
drawn	TH	DA1006	
checked	JC	issue	
project no	190551.00	A	

22/02/2021 12:58:24 PM

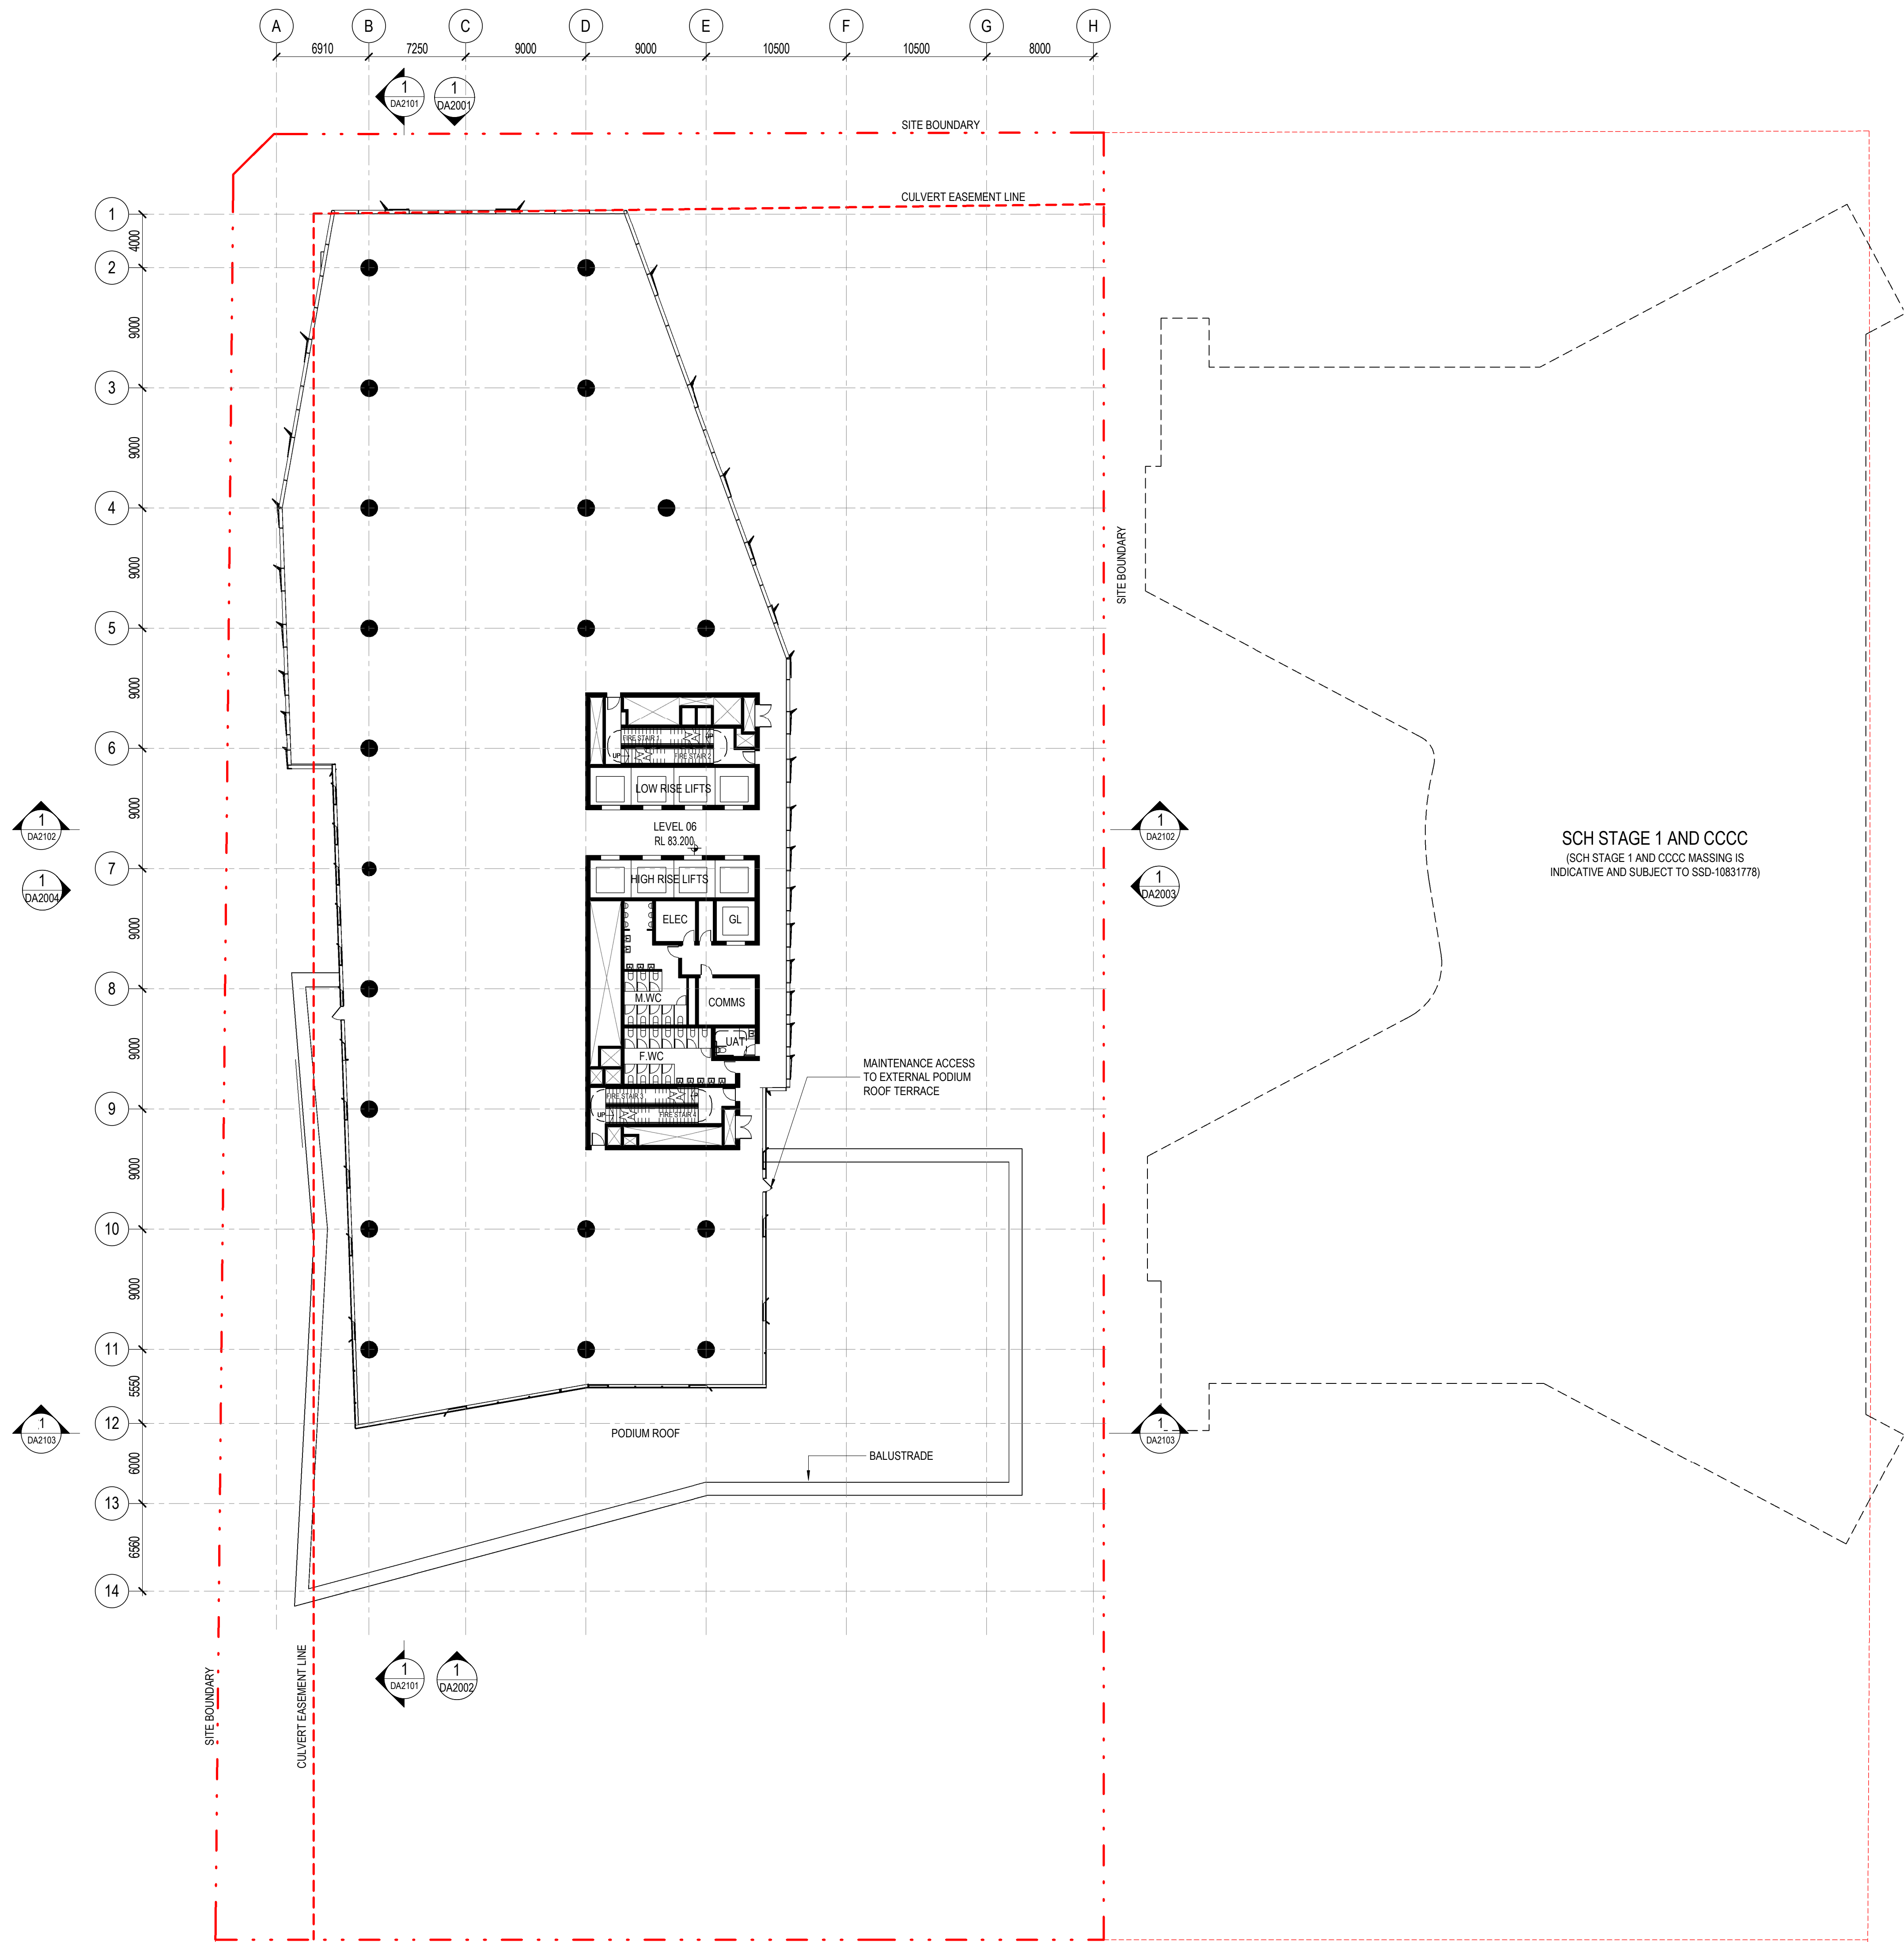

architectus™

Architectus Australia Pty Ltd is the owner of the copyright subsisting in these drawings, plans, designs and specifications. They must not be used, reproduced or copied, in whole or in part, nor may the information, ideas and concepts therein contained (which are confidential to Architectus Australia Pty Ltd) be disclosed to any person without the prior written consent of that company.

Nominated Architect
Ray Brown, NSWARB 6359

Do not scale drawings. Verify all dimensions on site

issue	amendment	date
A	ISSUED FOR STATE SIGNIFICANT DEVELOPMENT APPLICATION	18.02.21


GENERAL NOTES:

- DO NOT SCALE FROM THE DRAWINGS. USE ONLY FIGURED DIMENSIONS.
- ALL DIMENSIONS ARE IN MILLIMETRES UNLESS OTHERWISE STATED.
- REDUCED LEVELS (RL) ARE TO AUSTRALIAN HEIGHT DATUM (AHD).
- COORDINATES ARE TO MAP GRID AUSTRALIA (MGA).
- THE ARCHITECTURAL DOCUMENTATION IS ONLY ALLOWED TO BE USED FOR THE PURPOSE FOR WHICH IT WAS COMMISSIONED. UNAUTHORISED USE OF THE DOCUMENTATION IS PROHIBITED.

Scale:

1:250 @ A1
1:500 @ A3

0 2.5 5 7.5 10

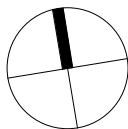

architectus™




ABN 90 131 245 684

project
UNSW Health Translation Hub

drawing

scale	1 : 250@A1	drawing no.	DA1007
drawn	TH	issue	
checked	JC		
project no	190551.00		A

18/02/2021 10:29:12 AM

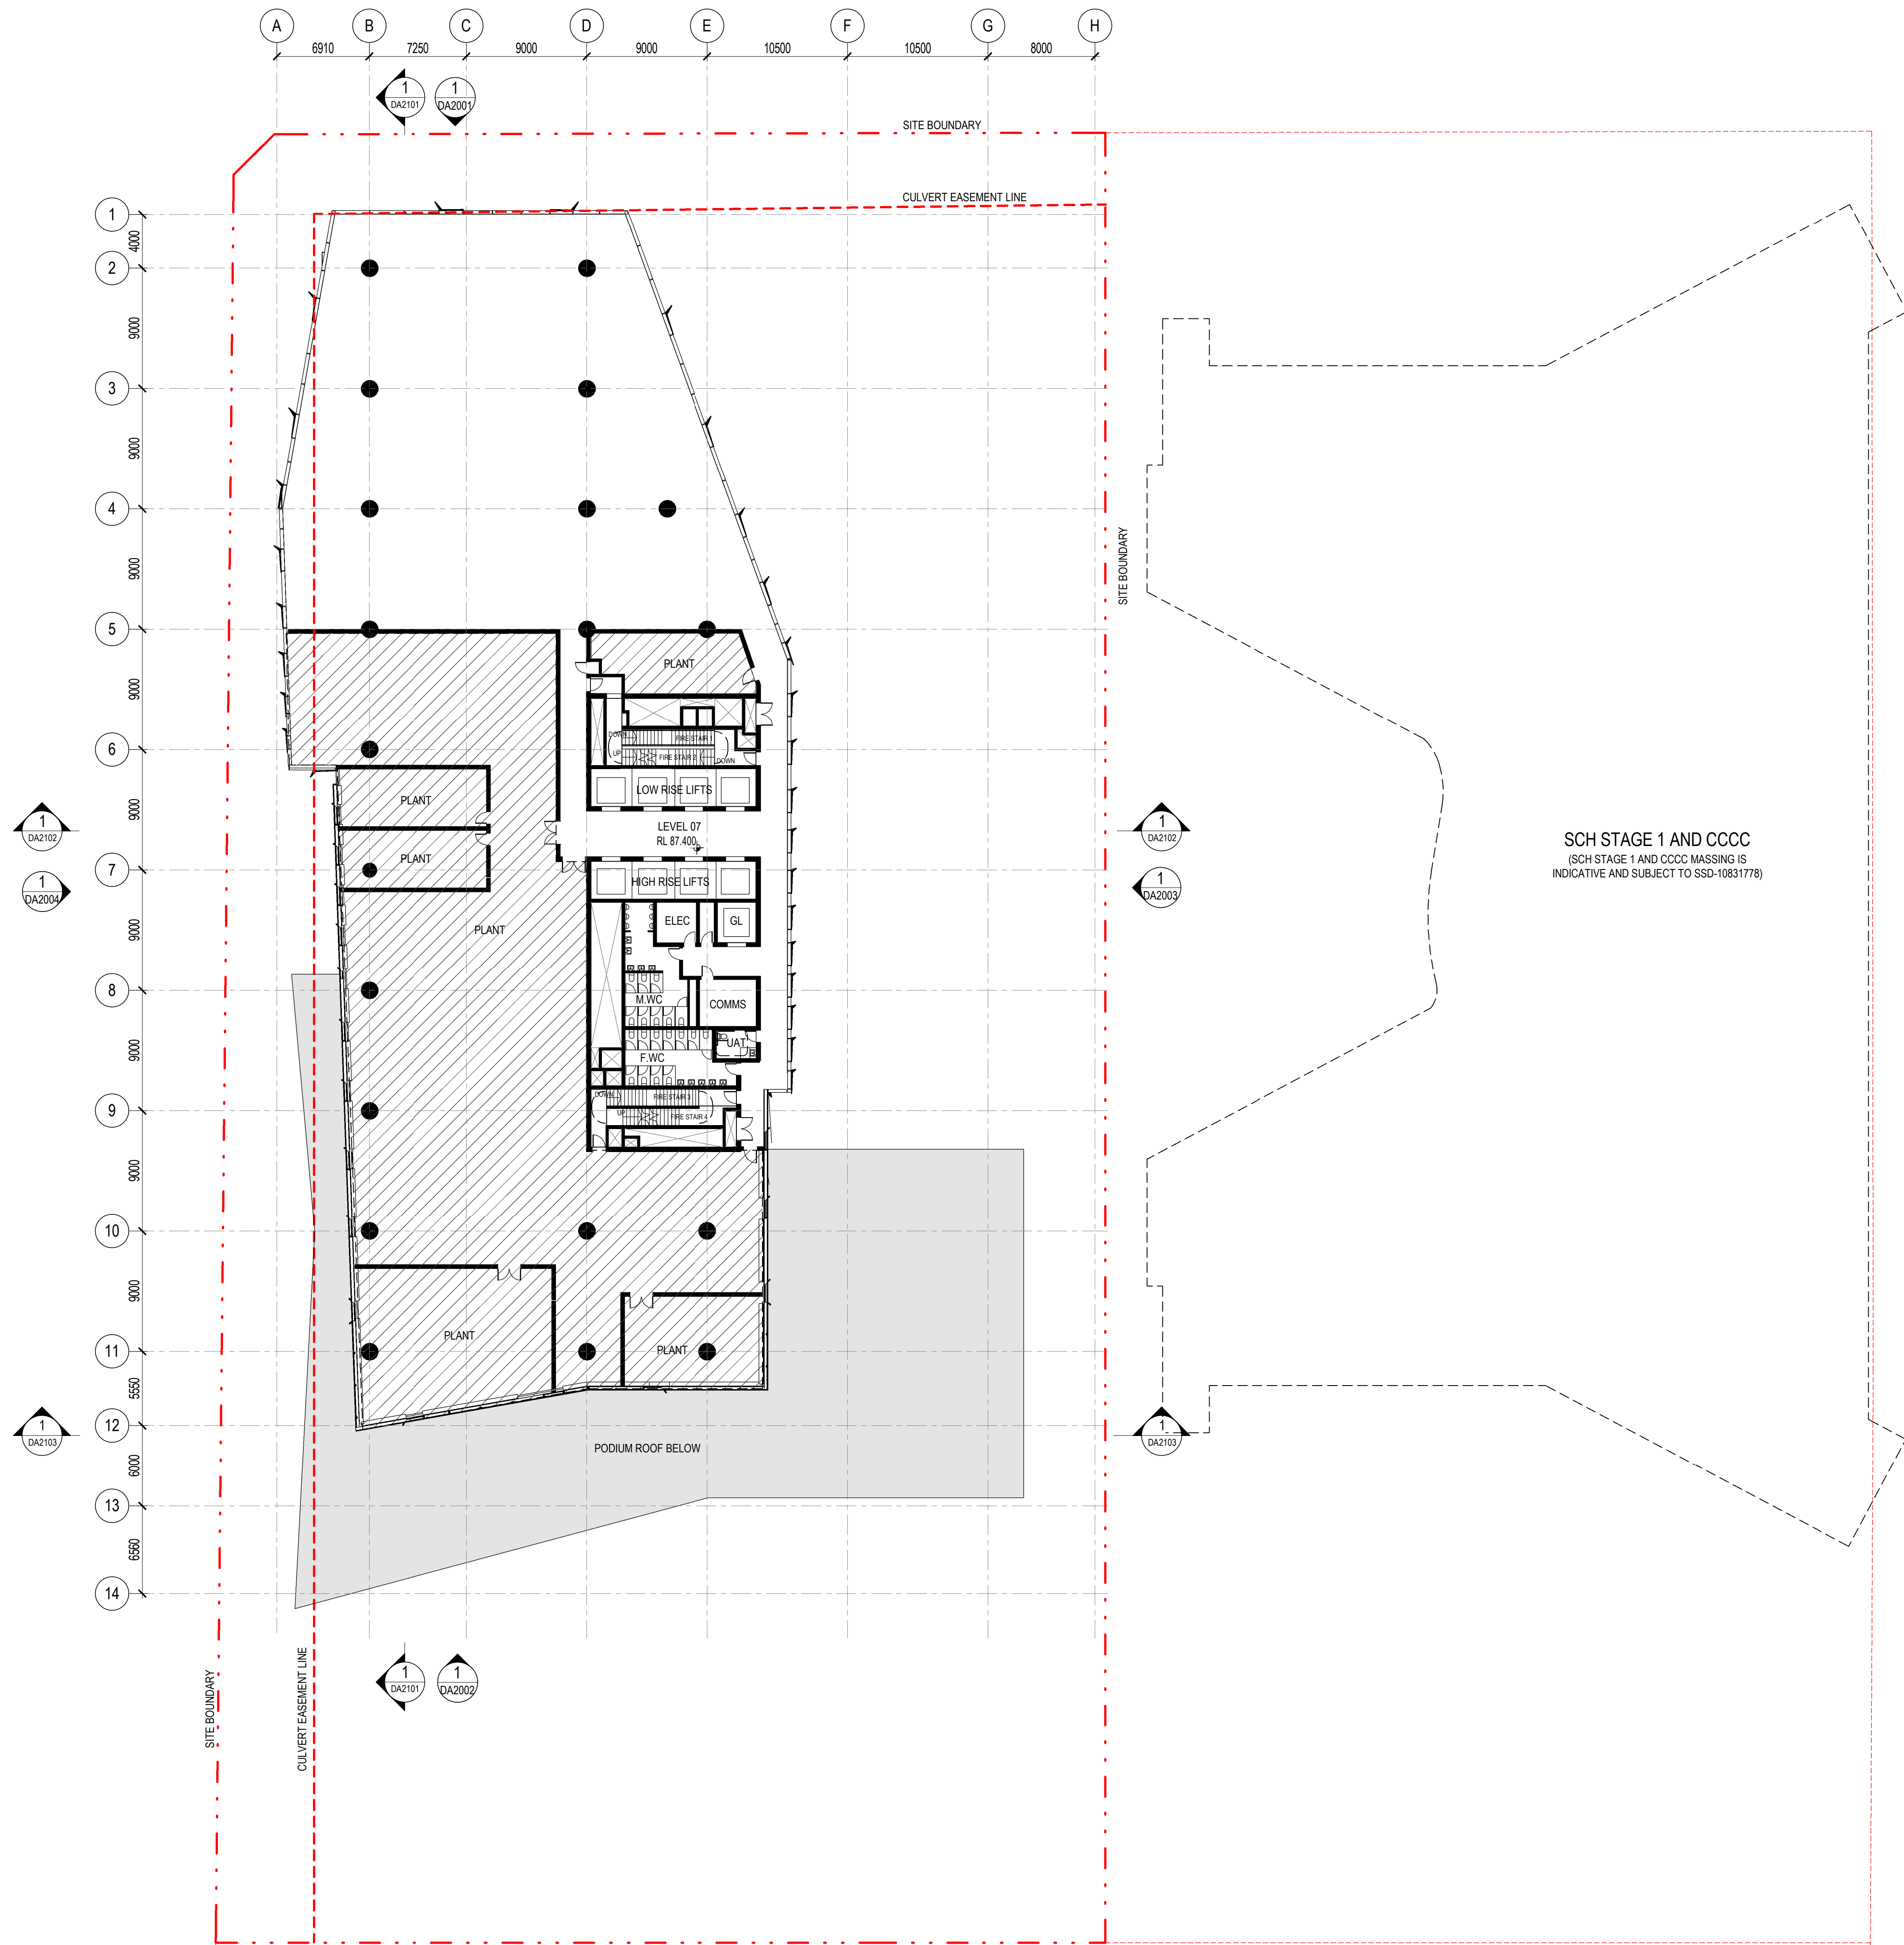

architectus™

Architectus Australia Pty Ltd is the owner of the copyright subsisting in these drawings, plans, designs and specifications. They must not be used, reproduced or copied, in whole or in part, nor may the information, ideas and concepts therein contained (which are confidential to Architectus Australia Pty Ltd) be disclosed to any person without the prior written consent of that company.

Nominated Architect
Ray Brown, NSWARB 6359

Do not scale drawings. Verify all dimensions on site

issue	amendment	date
A	ISSUED FOR STATE SIGNIFICANT DEVELOPMENT APPLICATION	18.02.21

GENERAL NOTES:

- DO NOT SCALE FROM THE DRAWINGS. USE ONLY FIGURED DIMENSIONS.
- ALL DIMENSIONS ARE IN MILLIMETRES UNLESS OTHERWISE STATED.
- REDUCED LEVELS (RL) ARE TO AUSTRALIAN HEIGHT DATUM (AHD).
- COORDINATES ARE TO MAP GRID AUSTRALIA (MGA).
- THE ARCHITECTURAL DOCUMENTATION IS ONLY ALLOWED TO BE USED FOR THE PURPOSE FOR WHICH IT WAS COMMISSIONED. UNAUTHORISED USE OF THE DOCUMENTATION IS PROHIBITED.

Scale:

1:250 @ A1
1:500 @ A3

0 2.5 5 7.5 10

architectus™




ABN 90 131 245 684

project
UNSW Health Translation Hub

drawing

scale	1 : 250@A1	drawing no.	DA1008
drawn	TH	issue	
checked	JC		
project no	190551.00		A

18/02/2021 10:29:19 AM

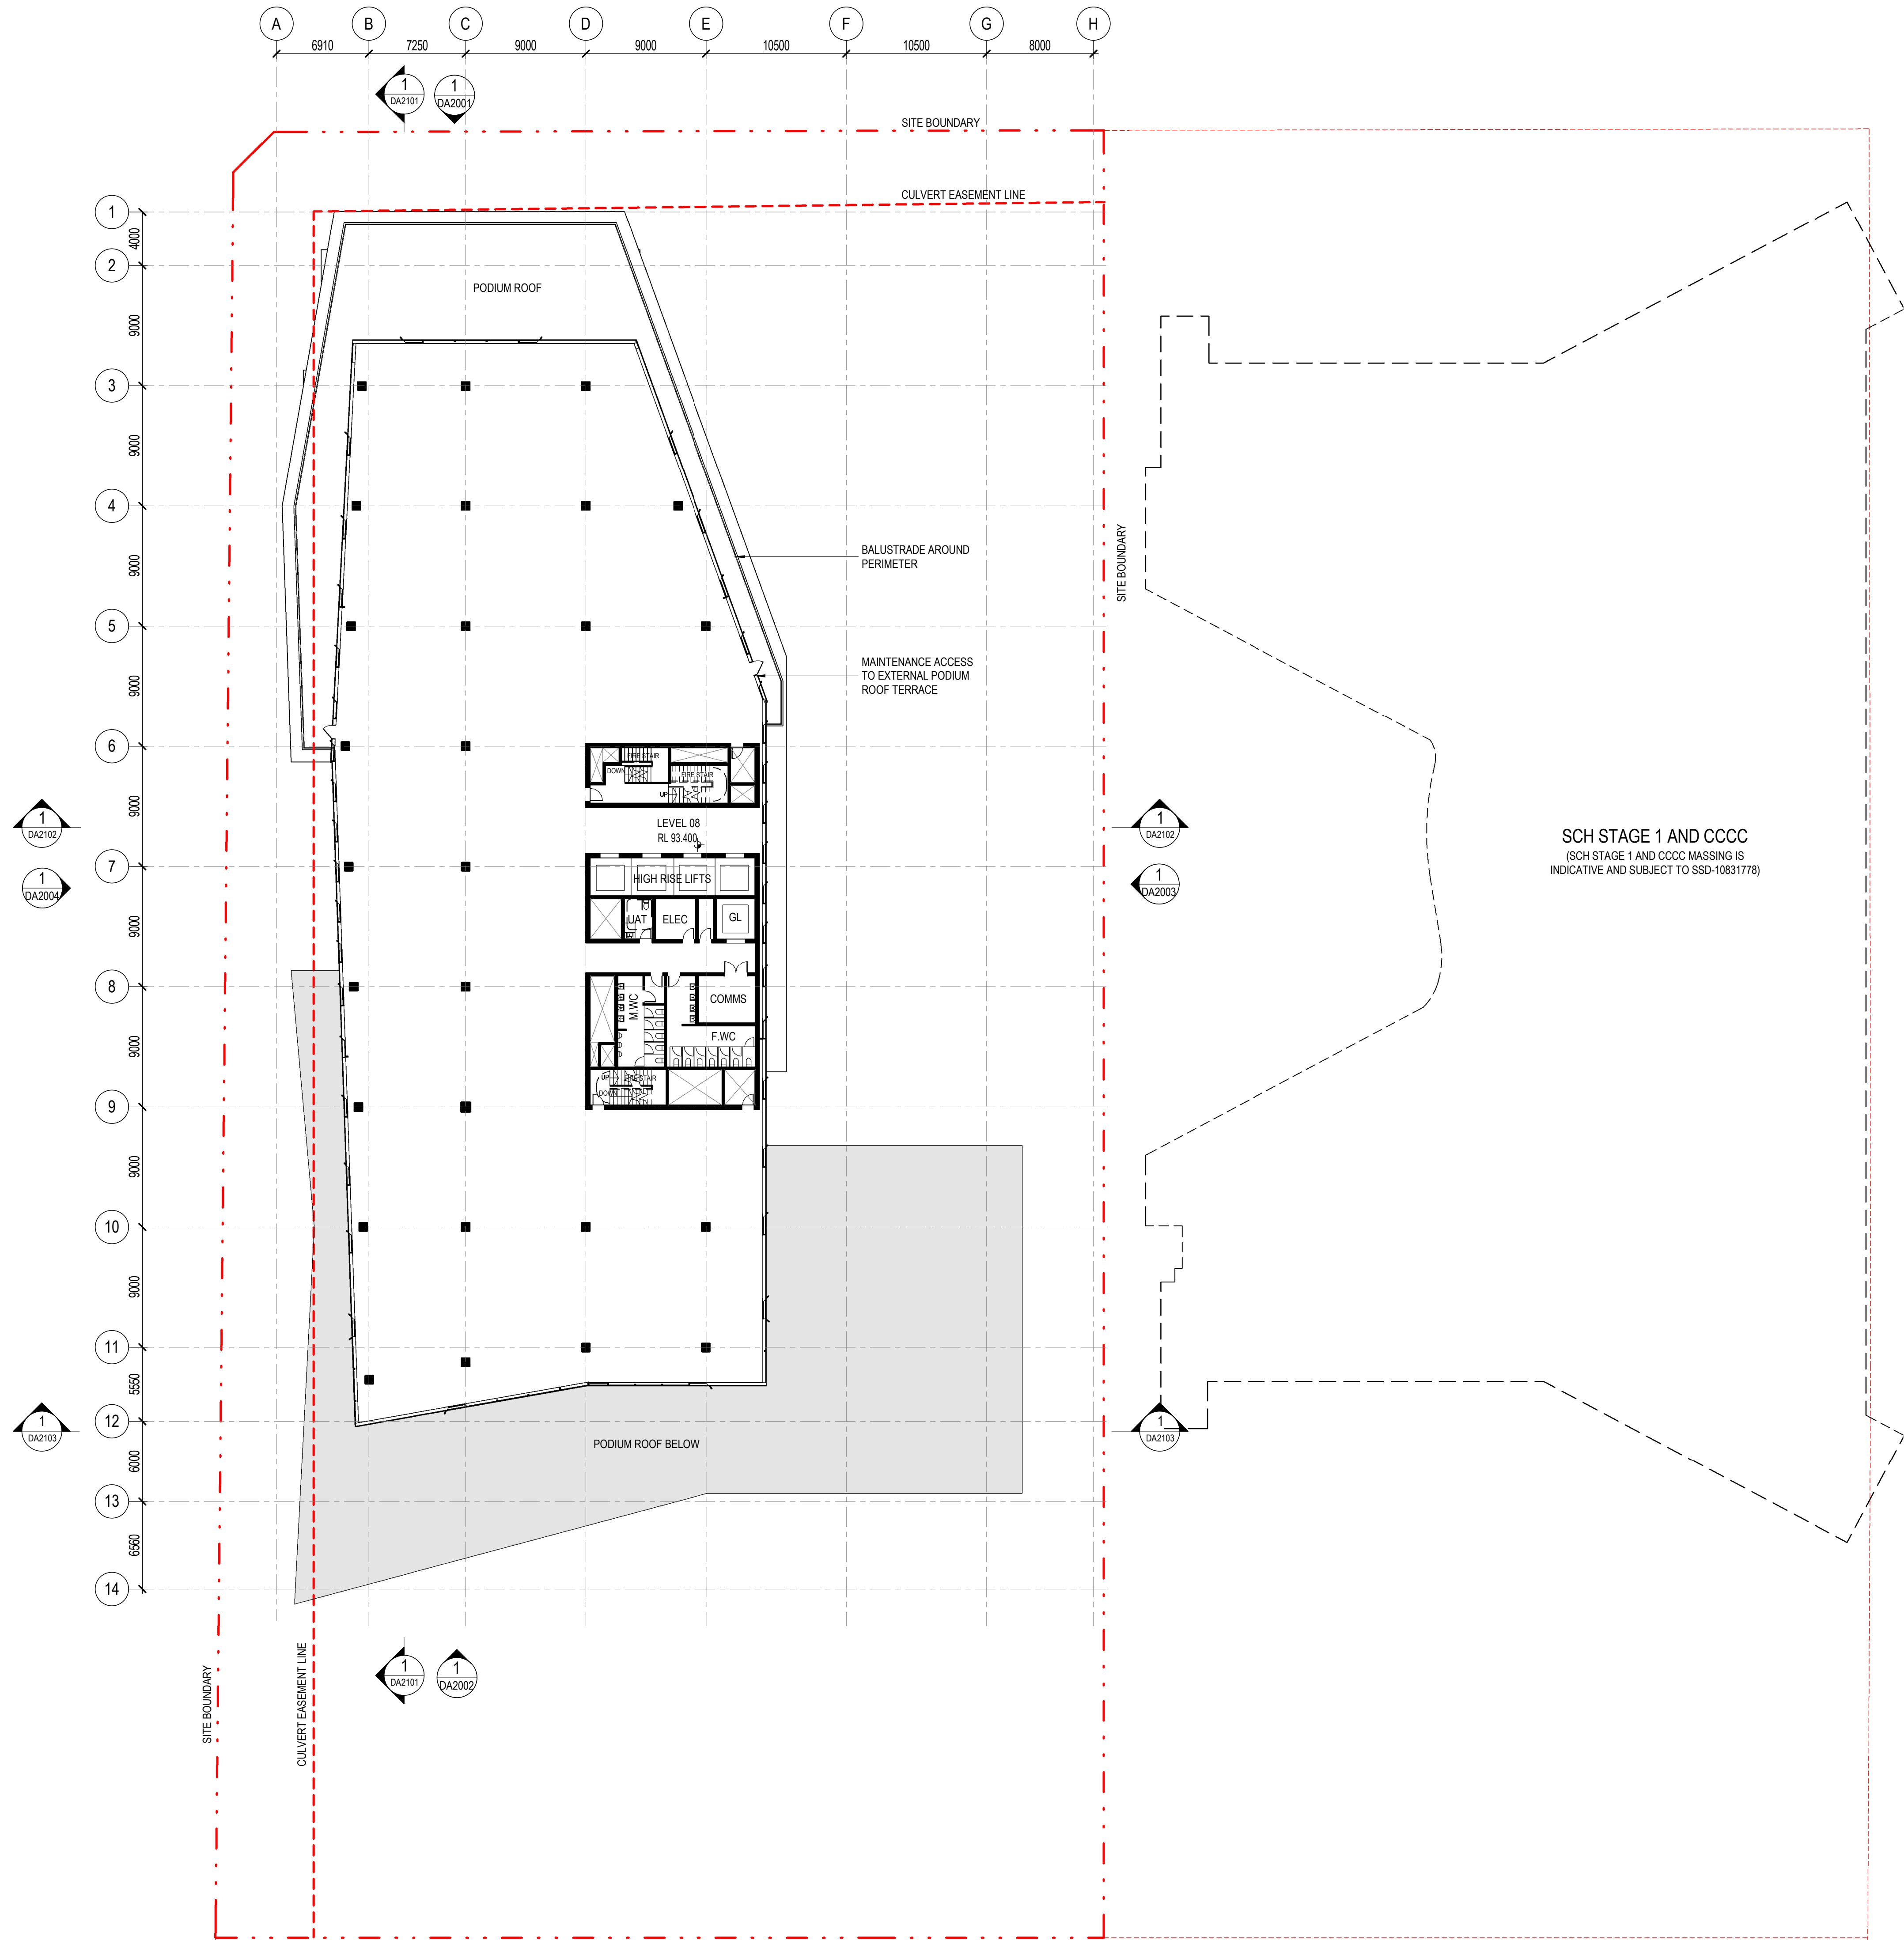

architectus™

Architectus Australia Pty Ltd is the owner of the copyright subsisting in these drawings, plans, designs and specifications. They must not be used, reproduced or copied, in whole or in part, nor may the information, ideas and concepts therein contained (which are confidential to Architectus Australia Pty Ltd) be disclosed to any person without the prior written consent of that company.

Nominated Architect
Ray Brown, NSWARB 6359

Do not scale drawings. Verify all dimensions on site

issue	amendment	date
A	ISSUED FOR STATE SIGNIFICANT DEVELOPMENT APPLICATION	18.02.21


GENERAL NOTES:

- DO NOT SCALE FROM THE DRAWINGS. USE ONLY FIGURED DIMENSIONS.
- ALL DIMENSIONS ARE IN MILLIMETRES UNLESS OTHERWISE STATED.
- REDUCED LEVELS (RL) ARE TO AUSTRALIAN HEIGHT DATUM (AHD).
- COORDINATES ARE TO MAP GRID AUSTRALIA (MGA).
- THE ARCHITECTURAL DOCUMENTATION IS ONLY ALLOWED TO BE USED FOR THE PURPOSE FOR WHICH IT WAS COMMISSIONED. UNAUTHORISED USE OF THE DOCUMENTATION IS PROHIBITED.

Scale:

1:250 @ A1
1:500 @ A3

0 2.5 5 7.5 10

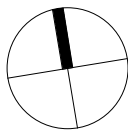

architectus™



ABN 90 131 245 684

project
UNSW Health Translation Hub

drawing

Level 08

scale
1 : 250@A1

drawn
TH

checked
JC


project no
190551.00

18/02/2021 10:29:25 AM

DA1009

issue

A

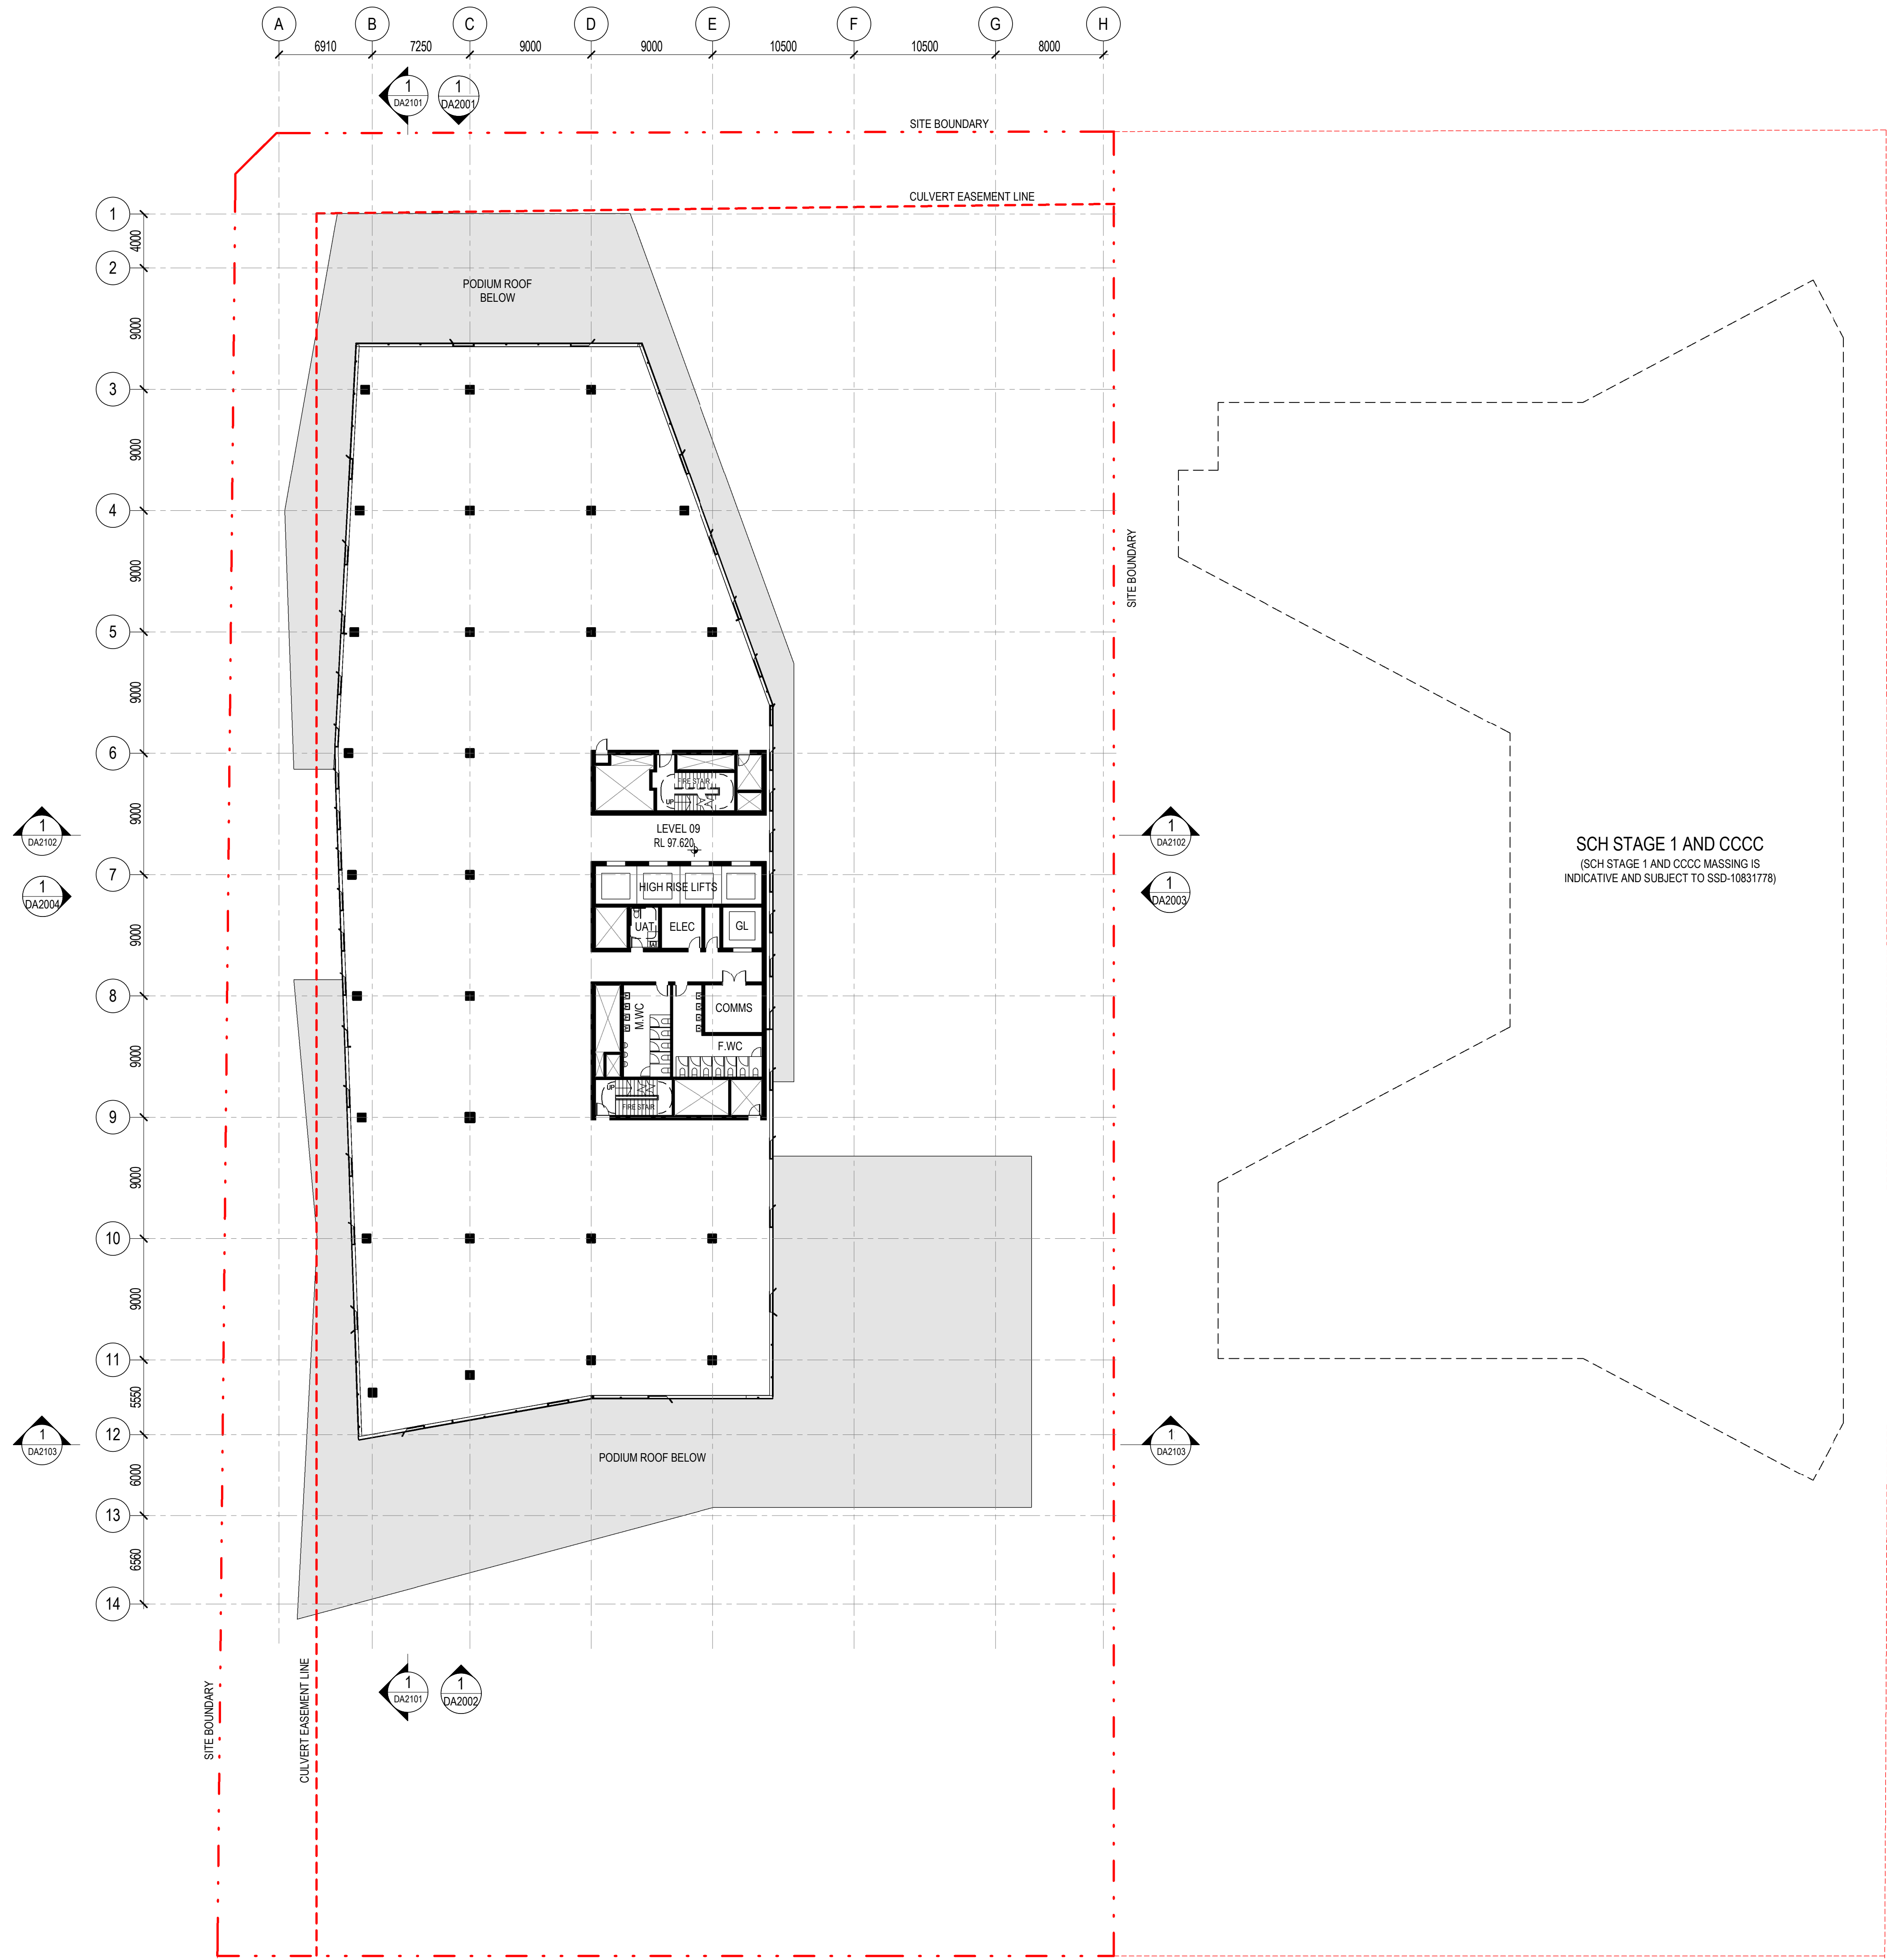

architectus™

Architectus Australia Pty Ltd is the owner of the copyright subsisting in these drawings, plans, designs and specifications. They must not be used, reproduced or copied, in whole or in part, nor may the information, ideas and concepts therein contained (which are confidential to Architectus Australia Pty Ltd) be disclosed to any person without the prior written consent of that company.

Nominated Architect
Ray Brown, NSWARB 6359

Do not scale drawings. Verify all dimensions on site

issue	amendment	date
A	ISSUED FOR STATE SIGNIFICANT DEVELOPMENT APPLICATION	18.02.21


GENERAL NOTES:

- DO NOT SCALE FROM THE DRAWINGS. USE ONLY FIGURED DIMENSIONS.
- ALL DIMENSIONS ARE IN MILLIMETRES UNLESS OTHERWISE STATED.
- REDUCED LEVELS (RL) ARE TO AUSTRALIAN HEIGHT DATUM (AHD).
- COORDINATES ARE TO MAP GRID AUSTRALIA (MGA).
- THE ARCHITECTURAL DOCUMENTATION IS ONLY ALLOWED TO BE USED FOR THE PURPOSE FOR WHICH IT WAS COMMISSIONED. UNAUTHORISED USE OF THE DOCUMENTATION IS PROHIBITED.


Scale:

1:250 @ A1
1:500 @ A3

0 2.5 5 7.5 10

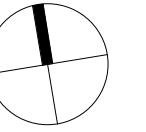

architectus™

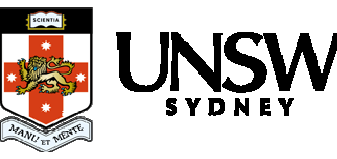

ABN 90 131 245 684

project

UNSW Health Translation Hub

drawing

Level 09


scale 1 : 250@A1 drawing no.

drawn TH DA1010

checked JC issue

project no 190551.00 A

18/02/2021 10:29:31 AM

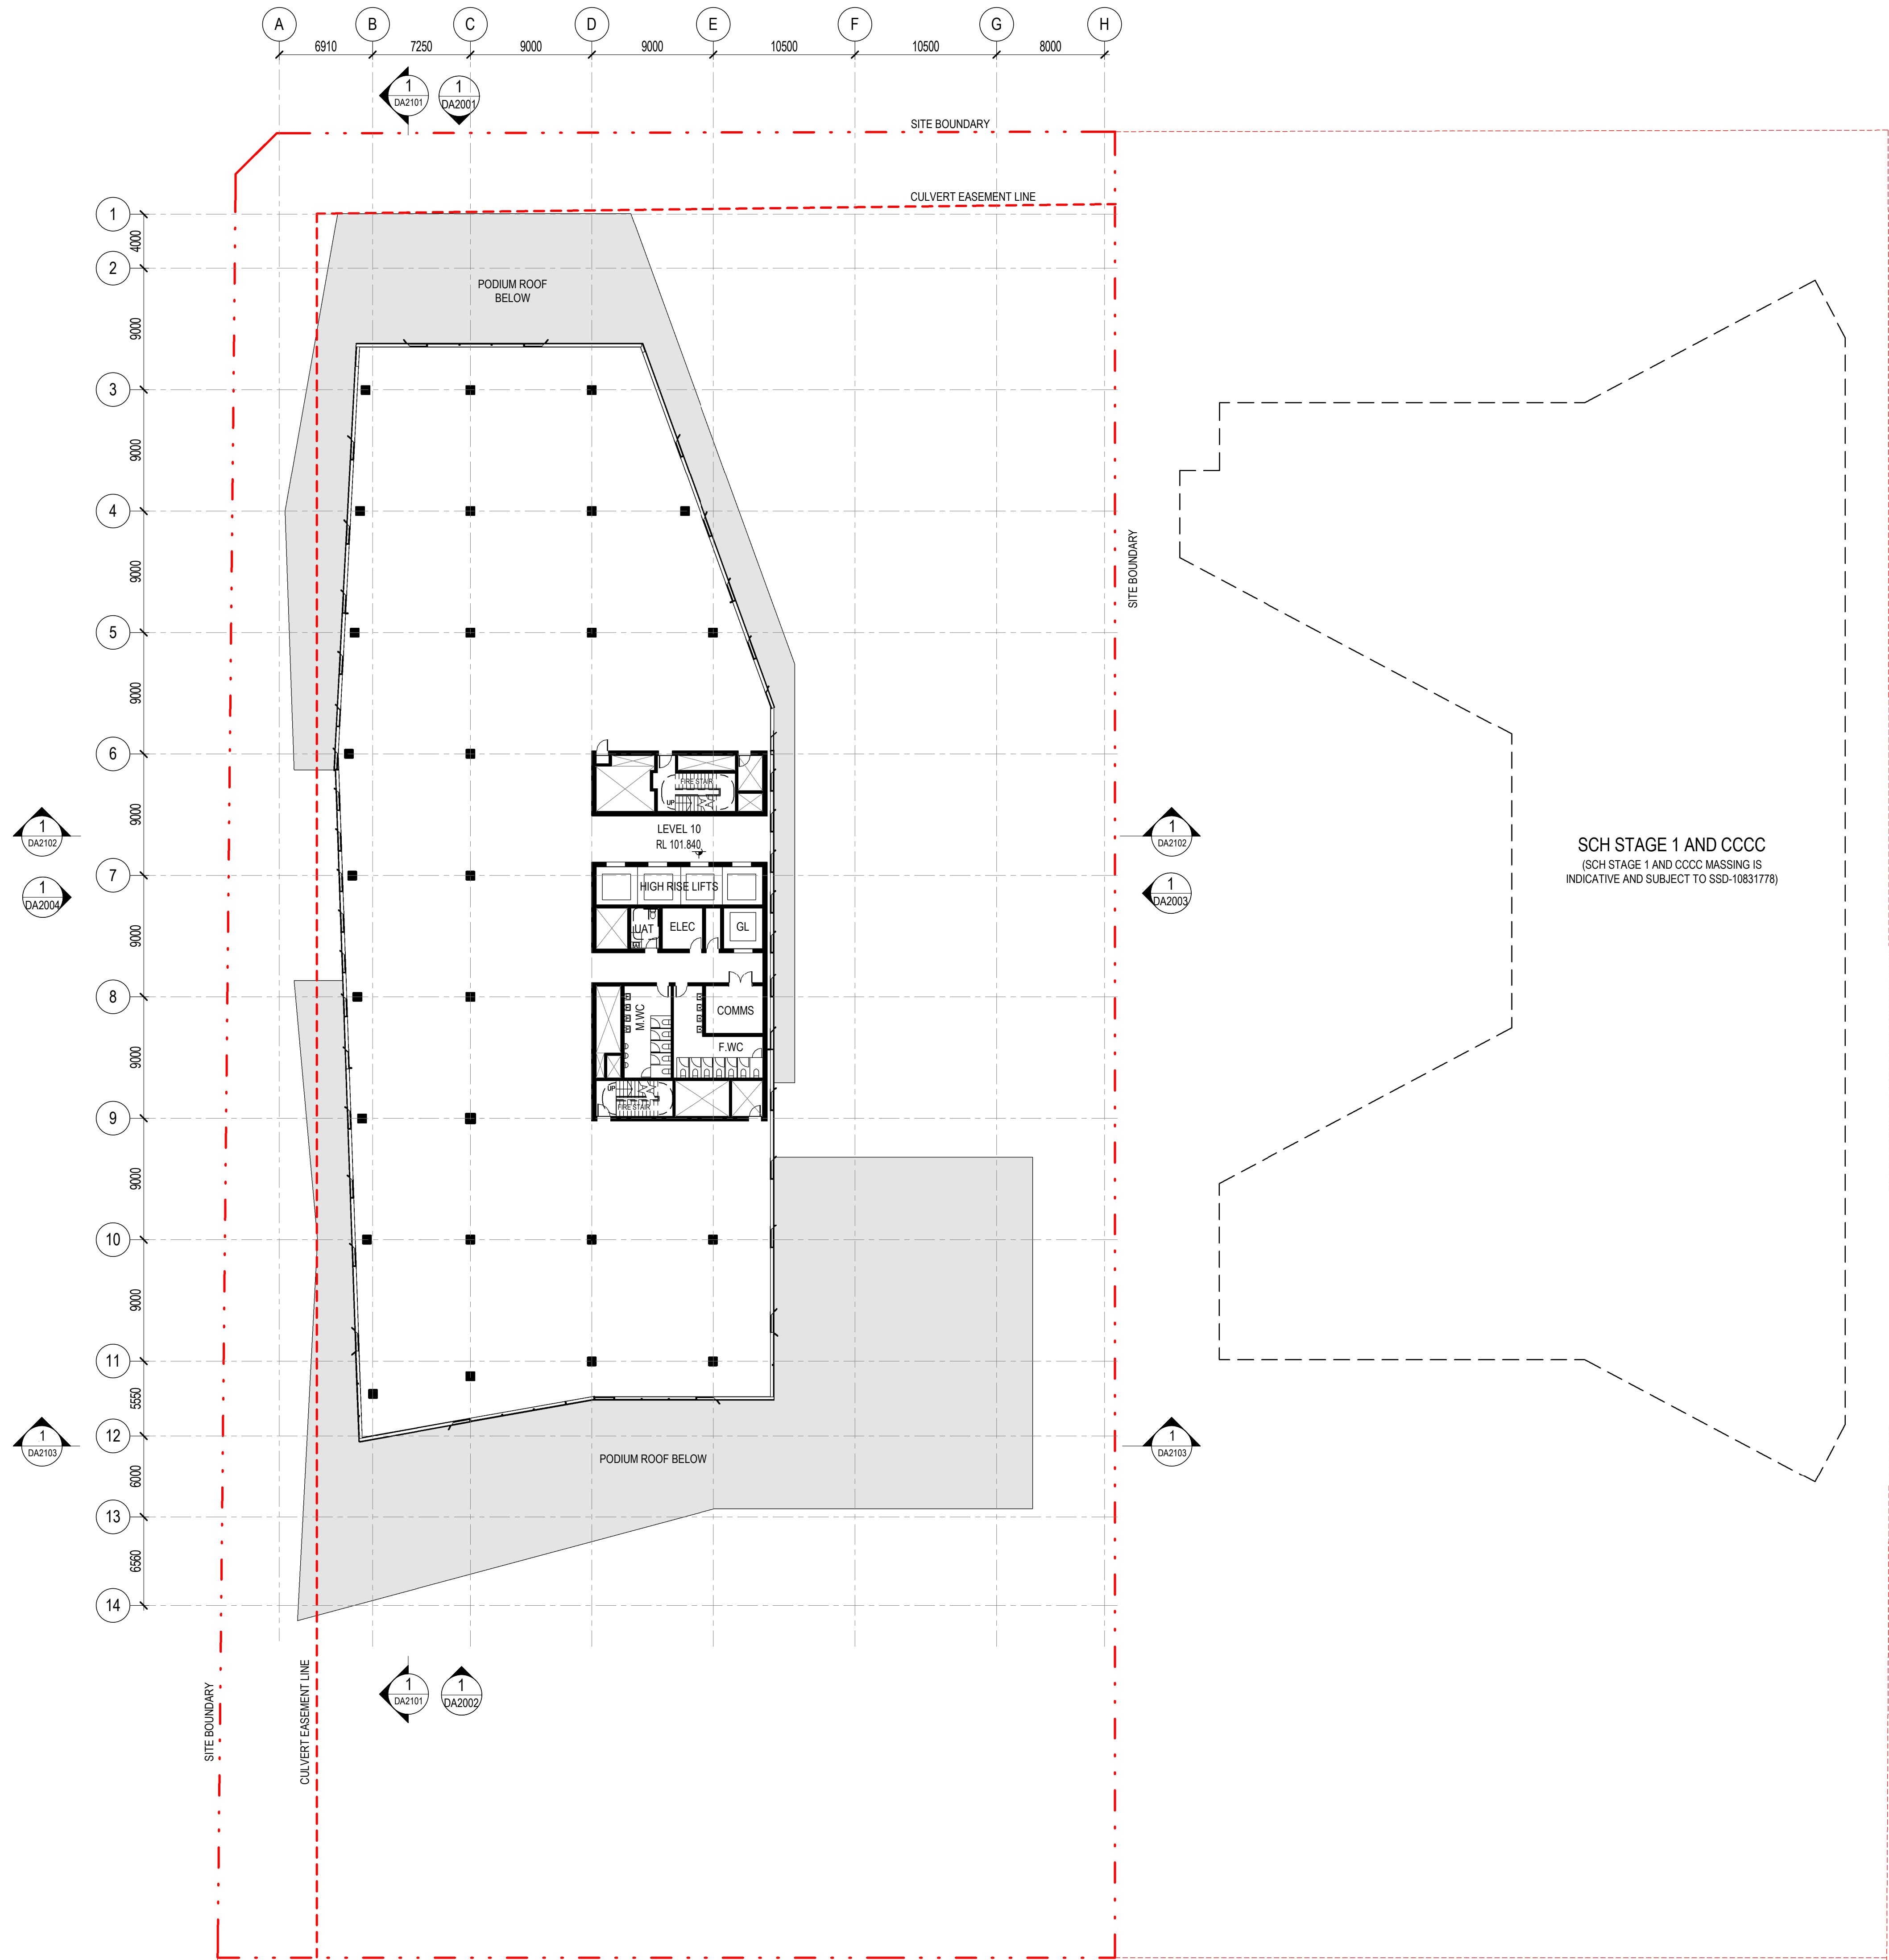

architectus™

Architectus Australia Pty Ltd is the owner of the copyright subsisting in these drawings, plans, designs and specifications. They must not be used, reproduced or copied, in whole or in part, nor may the information, ideas and concepts therein contained (which are confidential to Architectus Australia Pty Ltd) be disclosed to any person without the prior written consent of that company.

Nominated Architect
Ray Brown, NSWARB 6359

Do not scale drawings. Verify all dimensions on site

issue	amendment	date
A	ISSUED FOR STATE SIGNIFICANT DEVELOPMENT APPLICATION	18.02.21


GENERAL NOTES:

- DO NOT SCALE FROM THE DRAWINGS. USE ONLY FIGURED DIMENSIONS.
- ALL DIMENSIONS ARE IN MILLIMETRES UNLESS OTHERWISE STATED.
- REDUCED LEVELS (RL) ARE TO AUSTRALIAN HEIGHT DATUM (AHD).
- COORDINATES ARE TO MAP GRID AUSTRALIA (MGA).
- THE ARCHITECTURAL DOCUMENTATION IS ONLY ALLOWED TO BE USED FOR THE PURPOSE FOR WHICH IT WAS COMMISSIONED. UNAUTHORISED USE OF THE DOCUMENTATION IS PROHIBITED.

Scale:

1:250 @ A1
1:500 @ A3

0 2.5 5 7.5 10

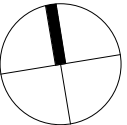

architectus™




ABN 90 131 245 684

project
UNSW Health Translation Hub

drawing

scale	1 : 250@A1	drawing no.	DA1011
drawn	TH	issue	
checked	JC		
project no	190551.00		A

18/02/2021 10:29:36 AM

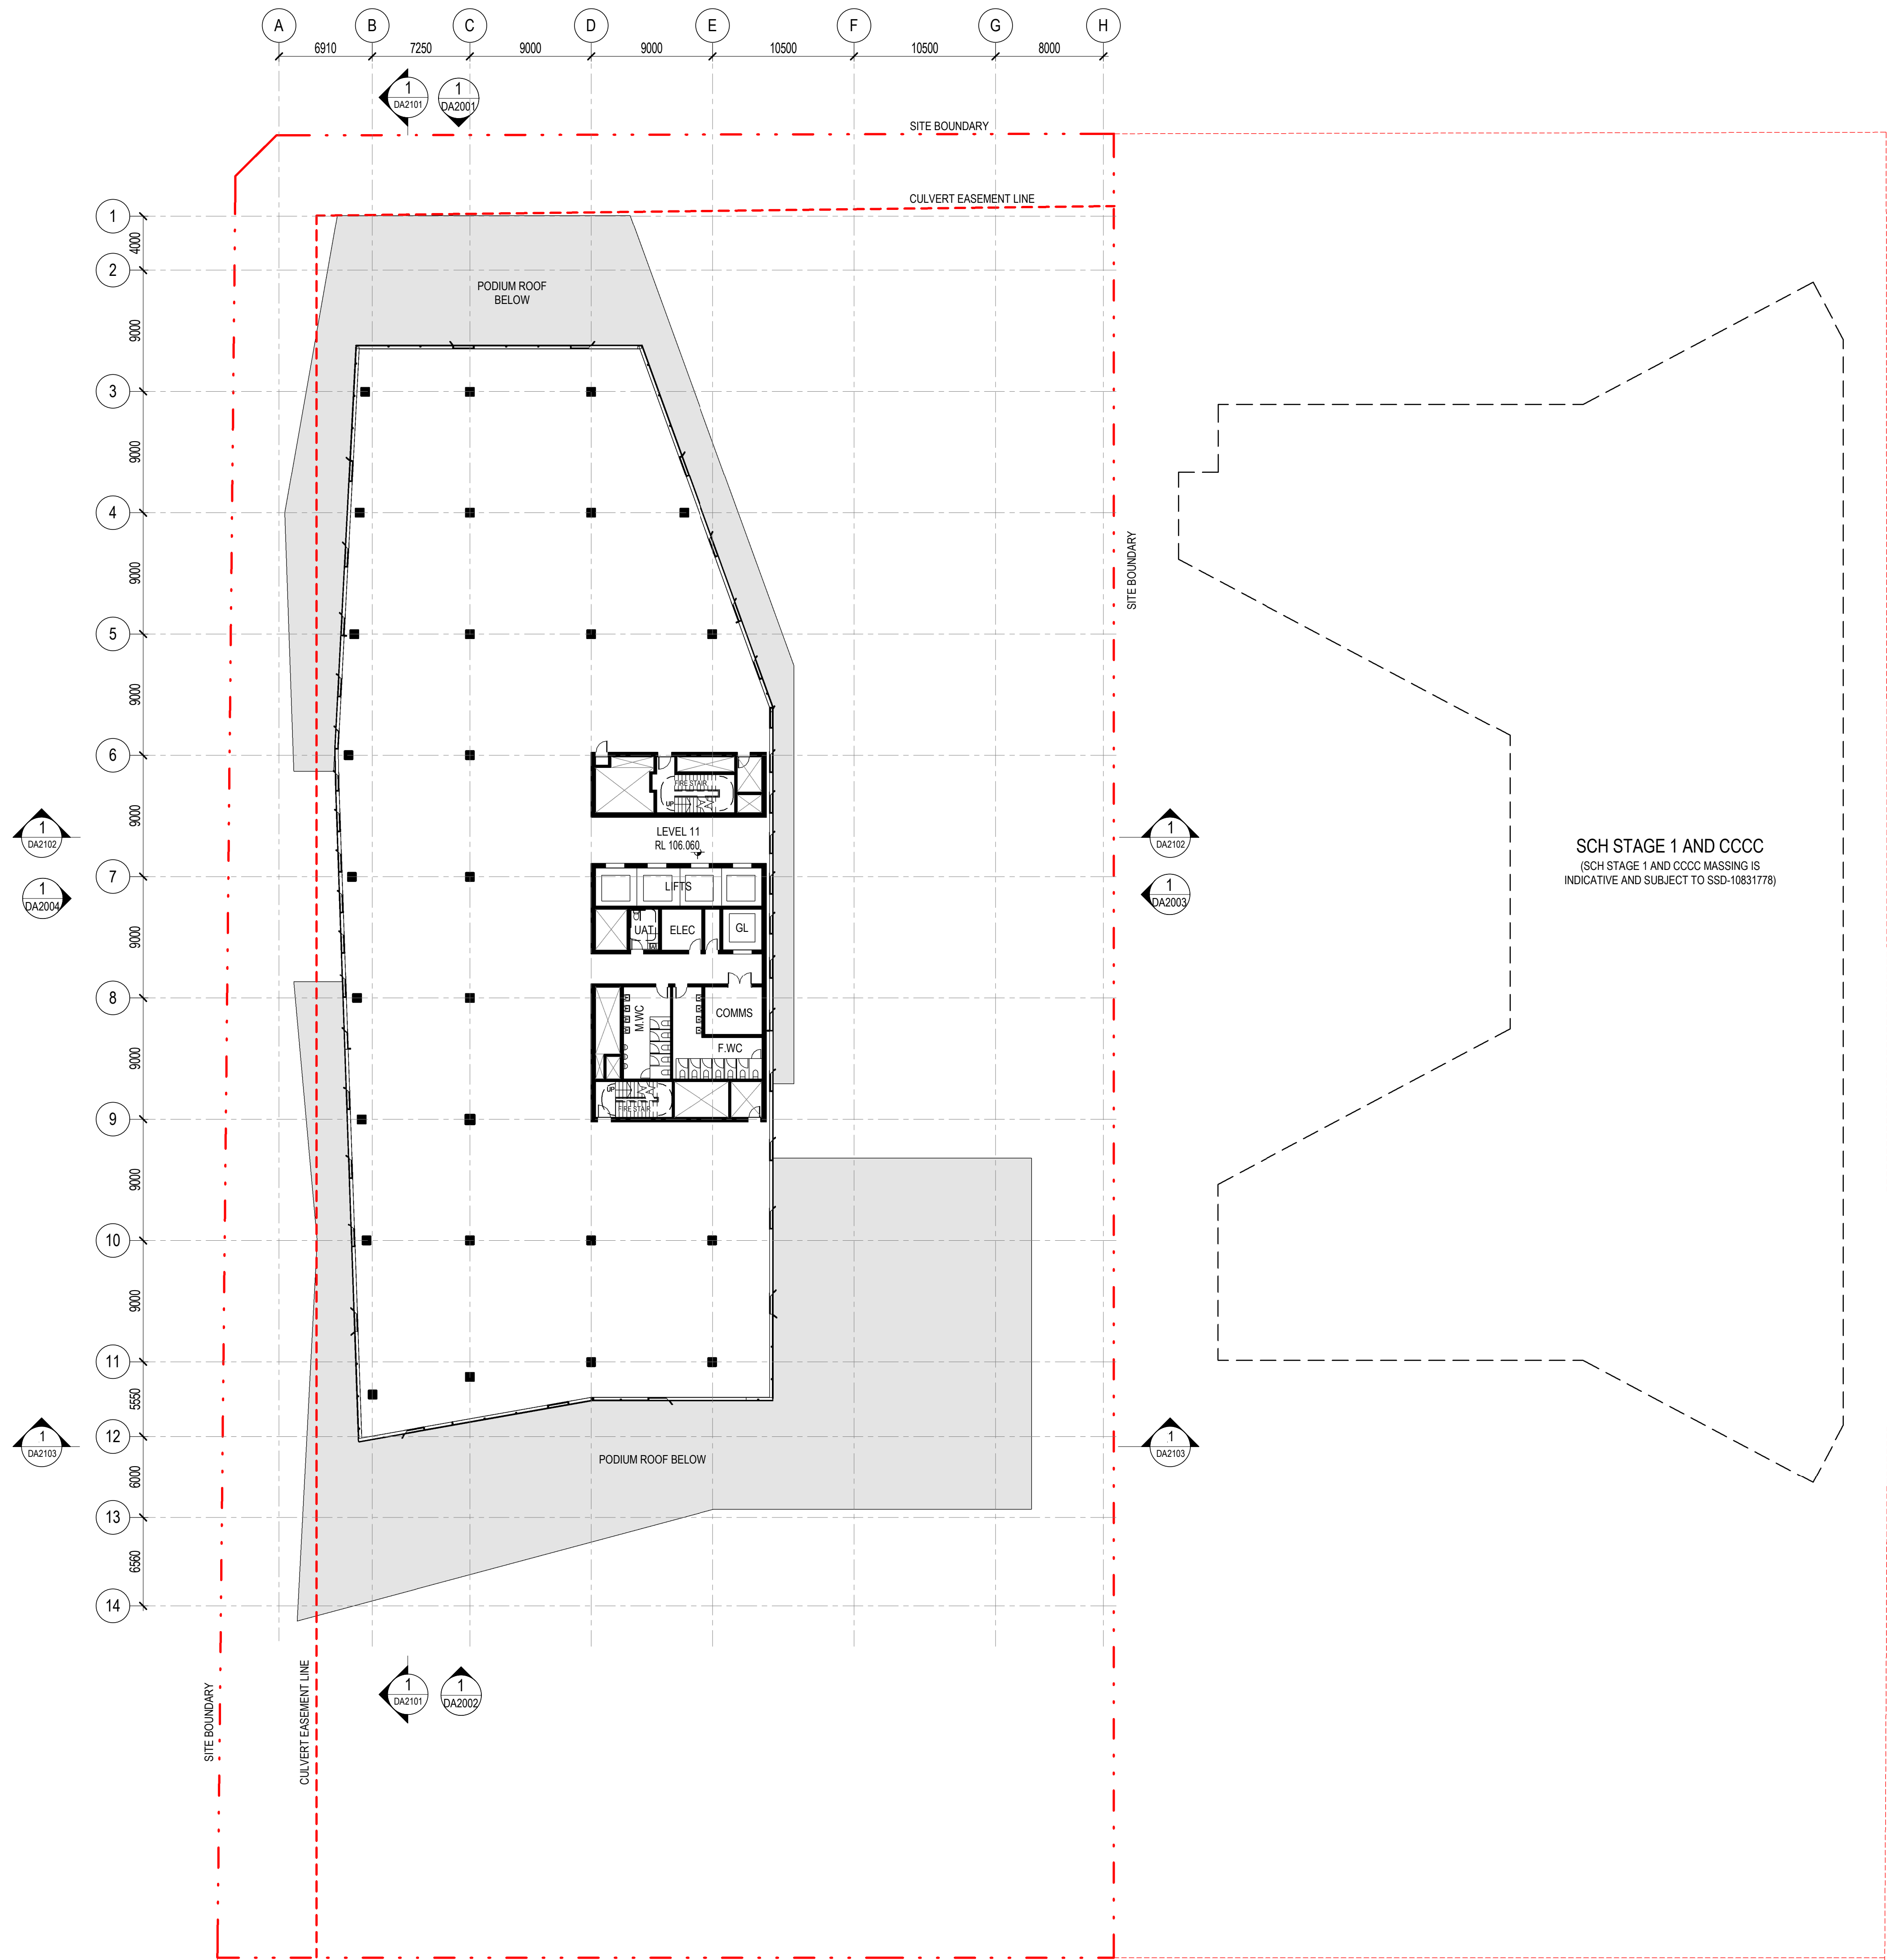

architectus™

Architectus Australia Pty Ltd is the owner of the copyright subsisting in these drawings, plans, designs and specifications. They must not be used, reproduced or copied, in whole or in part, nor may the information, ideas and concepts therein contained (which are confidential to Architectus Australia Pty Ltd) be disclosed to any person without the prior written consent of that company.

Nominated Architect
Ray Brown, NSWARB 6359

Do not scale drawings. Verify all dimensions on site

issue	amendment	date
A	ISSUED FOR STATE SIGNIFICANT DEVELOPMENT APPLICATION	18.02.21


GENERAL NOTES:

- DO NOT SCALE FROM THE DRAWINGS. USE ONLY FIGURED DIMENSIONS.
- ALL DIMENSIONS ARE IN MILLIMETRES UNLESS OTHERWISE STATED.
- REDUCED LEVELS (RL) ARE TO AUSTRALIAN HEIGHT DATUM (AHD).
- COORDINATES ARE TO MAP GRID AUSTRALIA (MGA).
- THE ARCHITECTURAL DOCUMENTATION IS ONLY ALLOWED TO BE USED FOR THE PURPOSE FOR WHICH IT WAS COMMISSIONED. UNAUTHORISED USE OF THE DOCUMENTATION IS PROHIBITED.


Scale:

1:250 @ A1
1:500 @ A3

0 2.5 5 7.5 10

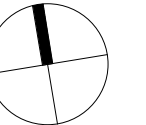

architectus™

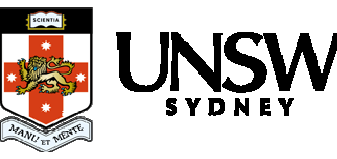

ABN 90 131 245 684

project

UNSW Health Translation Hub

drawing

Level 11


scale 1 : 250@A1 drawing no.

drawn TH DA1012

checked JC issue

project no 190551.00 A

18/02/2021 10:29:42 AM

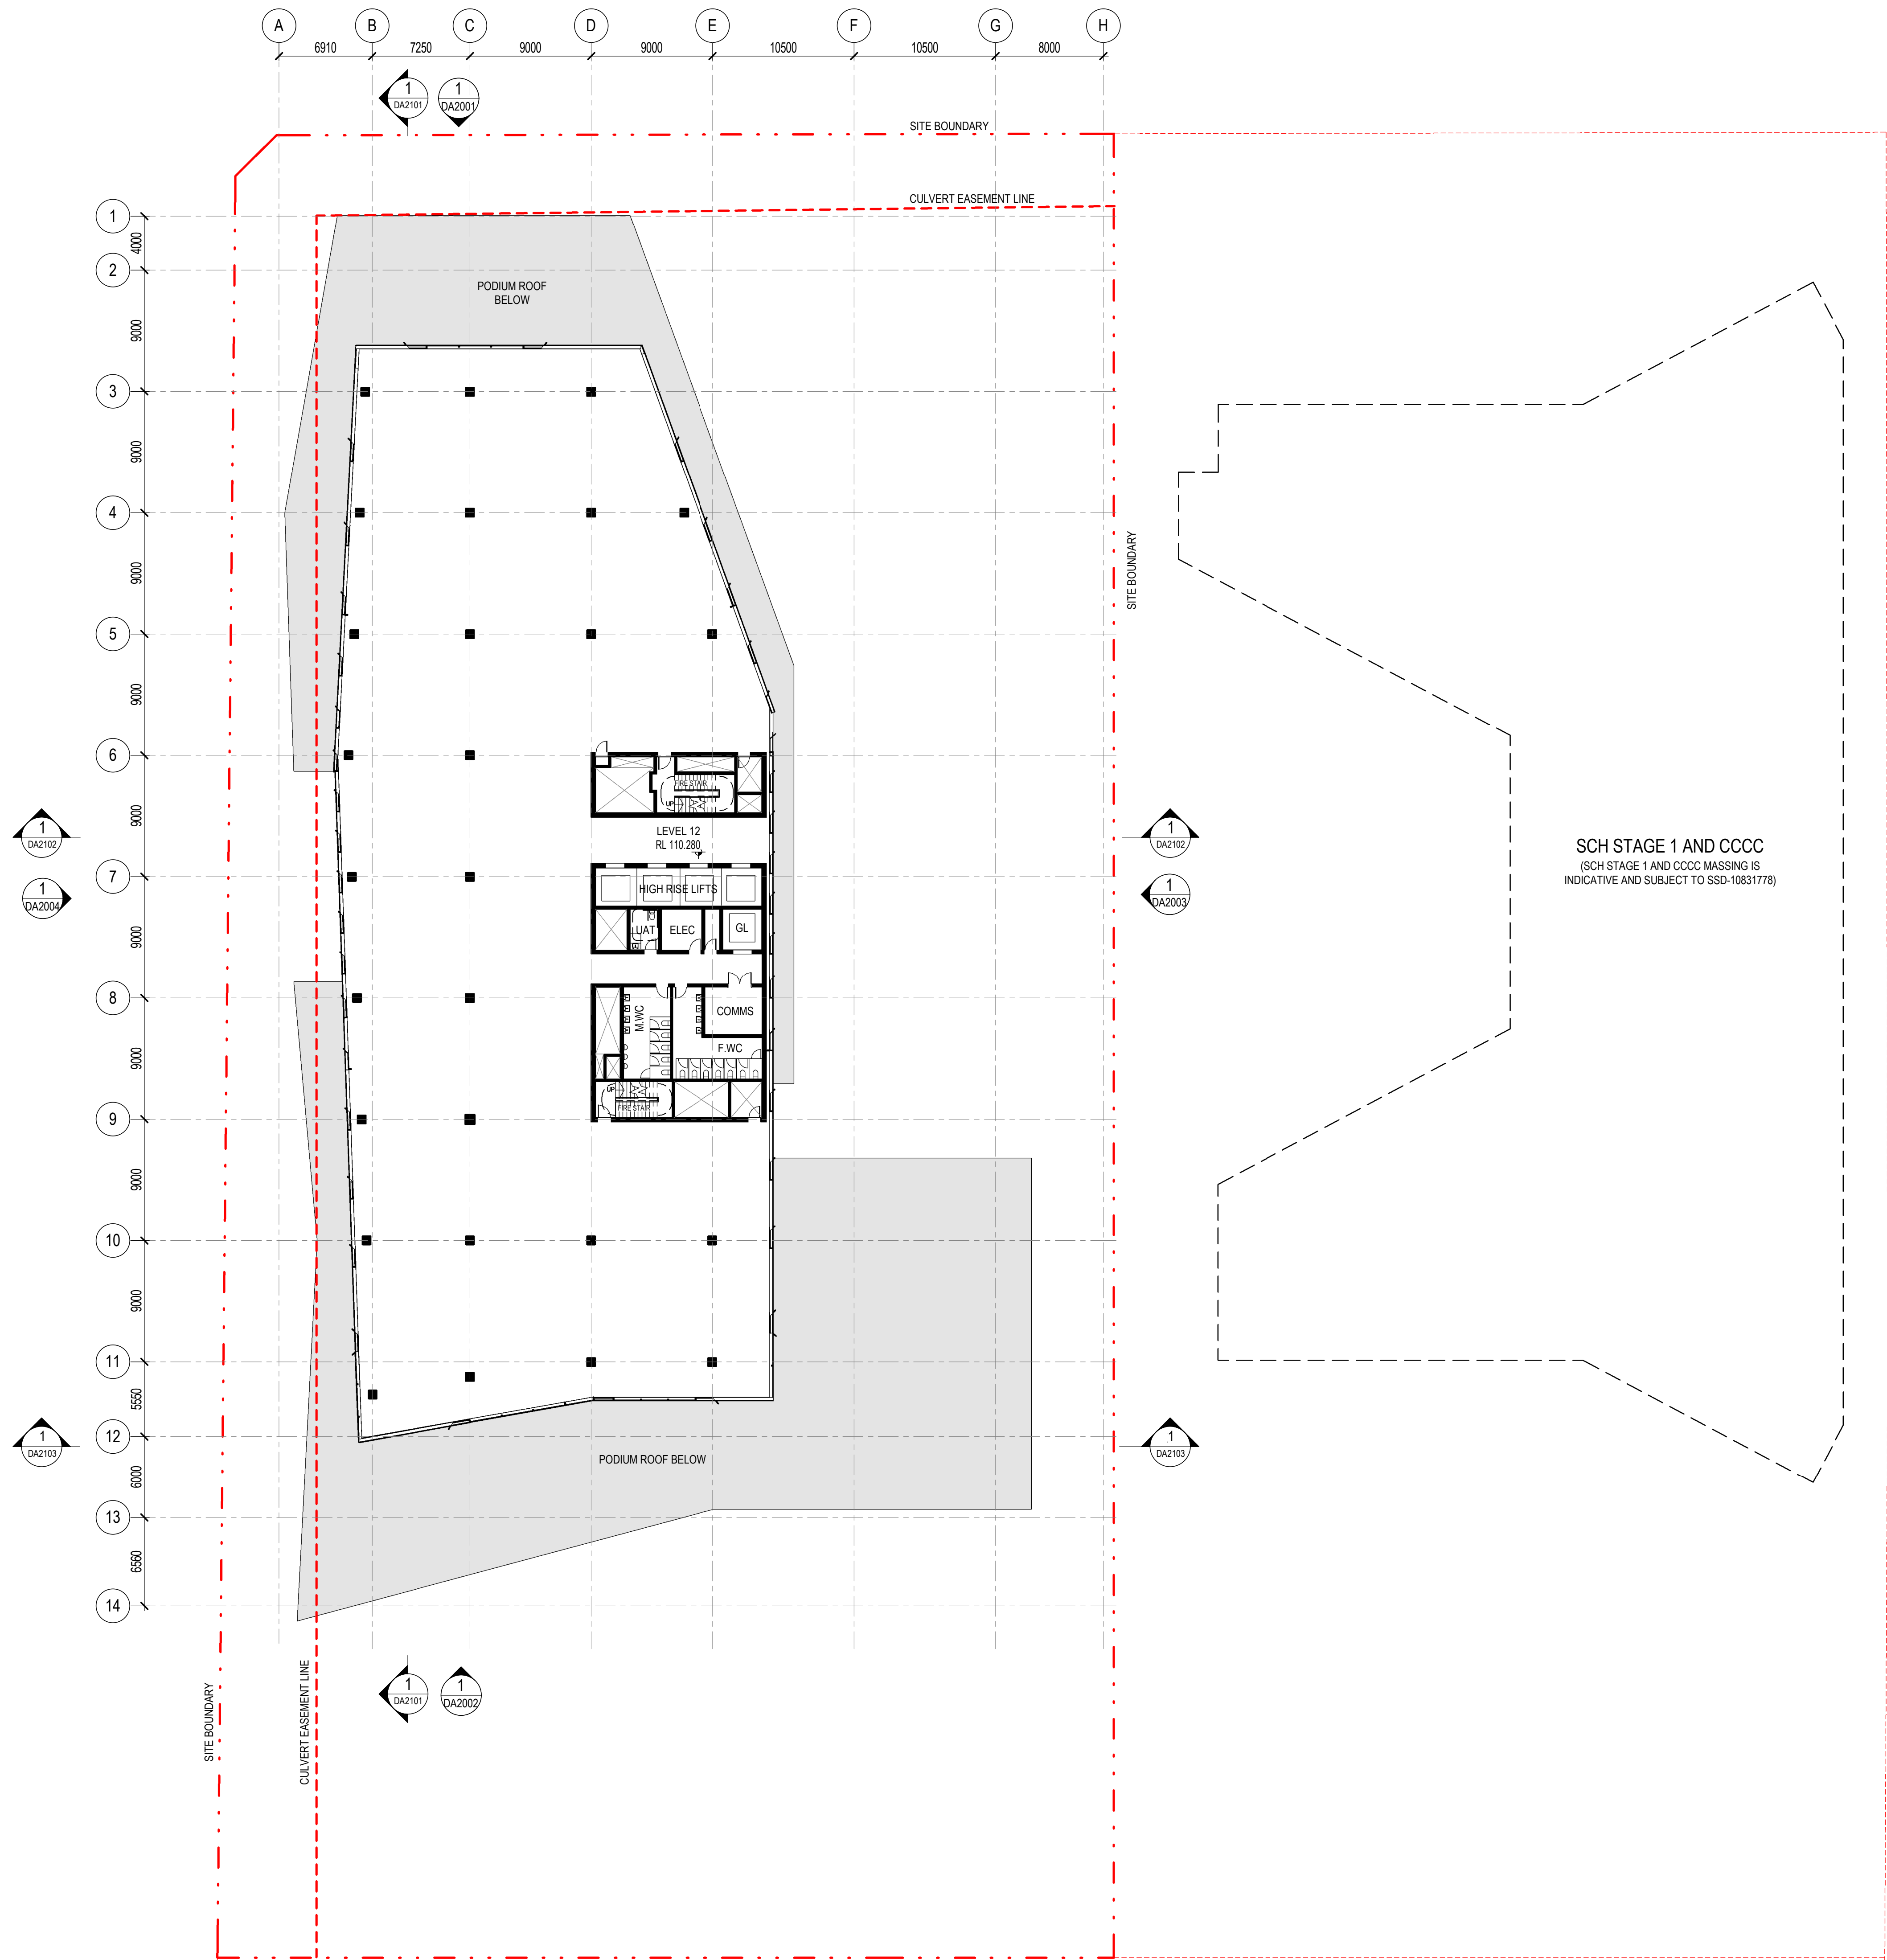

architectus™

Architectus Australia Pty Ltd is the owner of the copyright subsisting in these drawings, plans, designs and specifications. They must not be used, reproduced or copied, in whole or in part, nor may the information, ideas and concepts therein contained (which are confidential to Architectus Australia Pty Ltd) be disclosed to any person without the prior written consent of that company.

Nominated Architect
Ray Brown, NSWARB 6359

Do not scale drawings. Verify all dimensions on site

issue	amendment	date
A	ISSUED FOR STATE SIGNIFICANT DEVELOPMENT APPLICATION	18.02.21


GENERAL NOTES:

- DO NOT SCALE FROM THE DRAWINGS. USE ONLY FIGURED DIMENSIONS.
- ALL DIMENSIONS ARE IN MILLIMETRES UNLESS OTHERWISE STATED.
- REDUCED LEVELS (RL) ARE TO AUSTRALIAN HEIGHT DATUM (AHD).
- COORDINATES ARE TO MAP GRID AUSTRALIA (MGA).
- THE ARCHITECTURAL DOCUMENTATION IS ONLY ALLOWED TO BE USED FOR THE PURPOSE FOR WHICH IT WAS COMMISSIONED. UNAUTHORISED USE OF THE DOCUMENTATION IS PROHIBITED.


Scale:

1:250 @ A1
1:500 @ A3

0 2.5 5 7.5 10

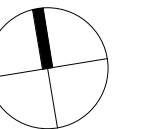

architectus™

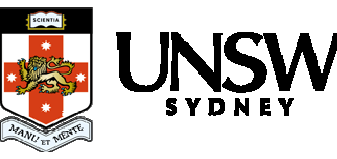


ABN 90 131 245 684

project
UNSW Health Translation Hub

drawing

scale	1 : 250@A1	drawing no.	Level 12
drawn	TH	DA1013	
checked	JC	issue	
project no	190551.00	A	

18/02/2021 10:29:48 AM

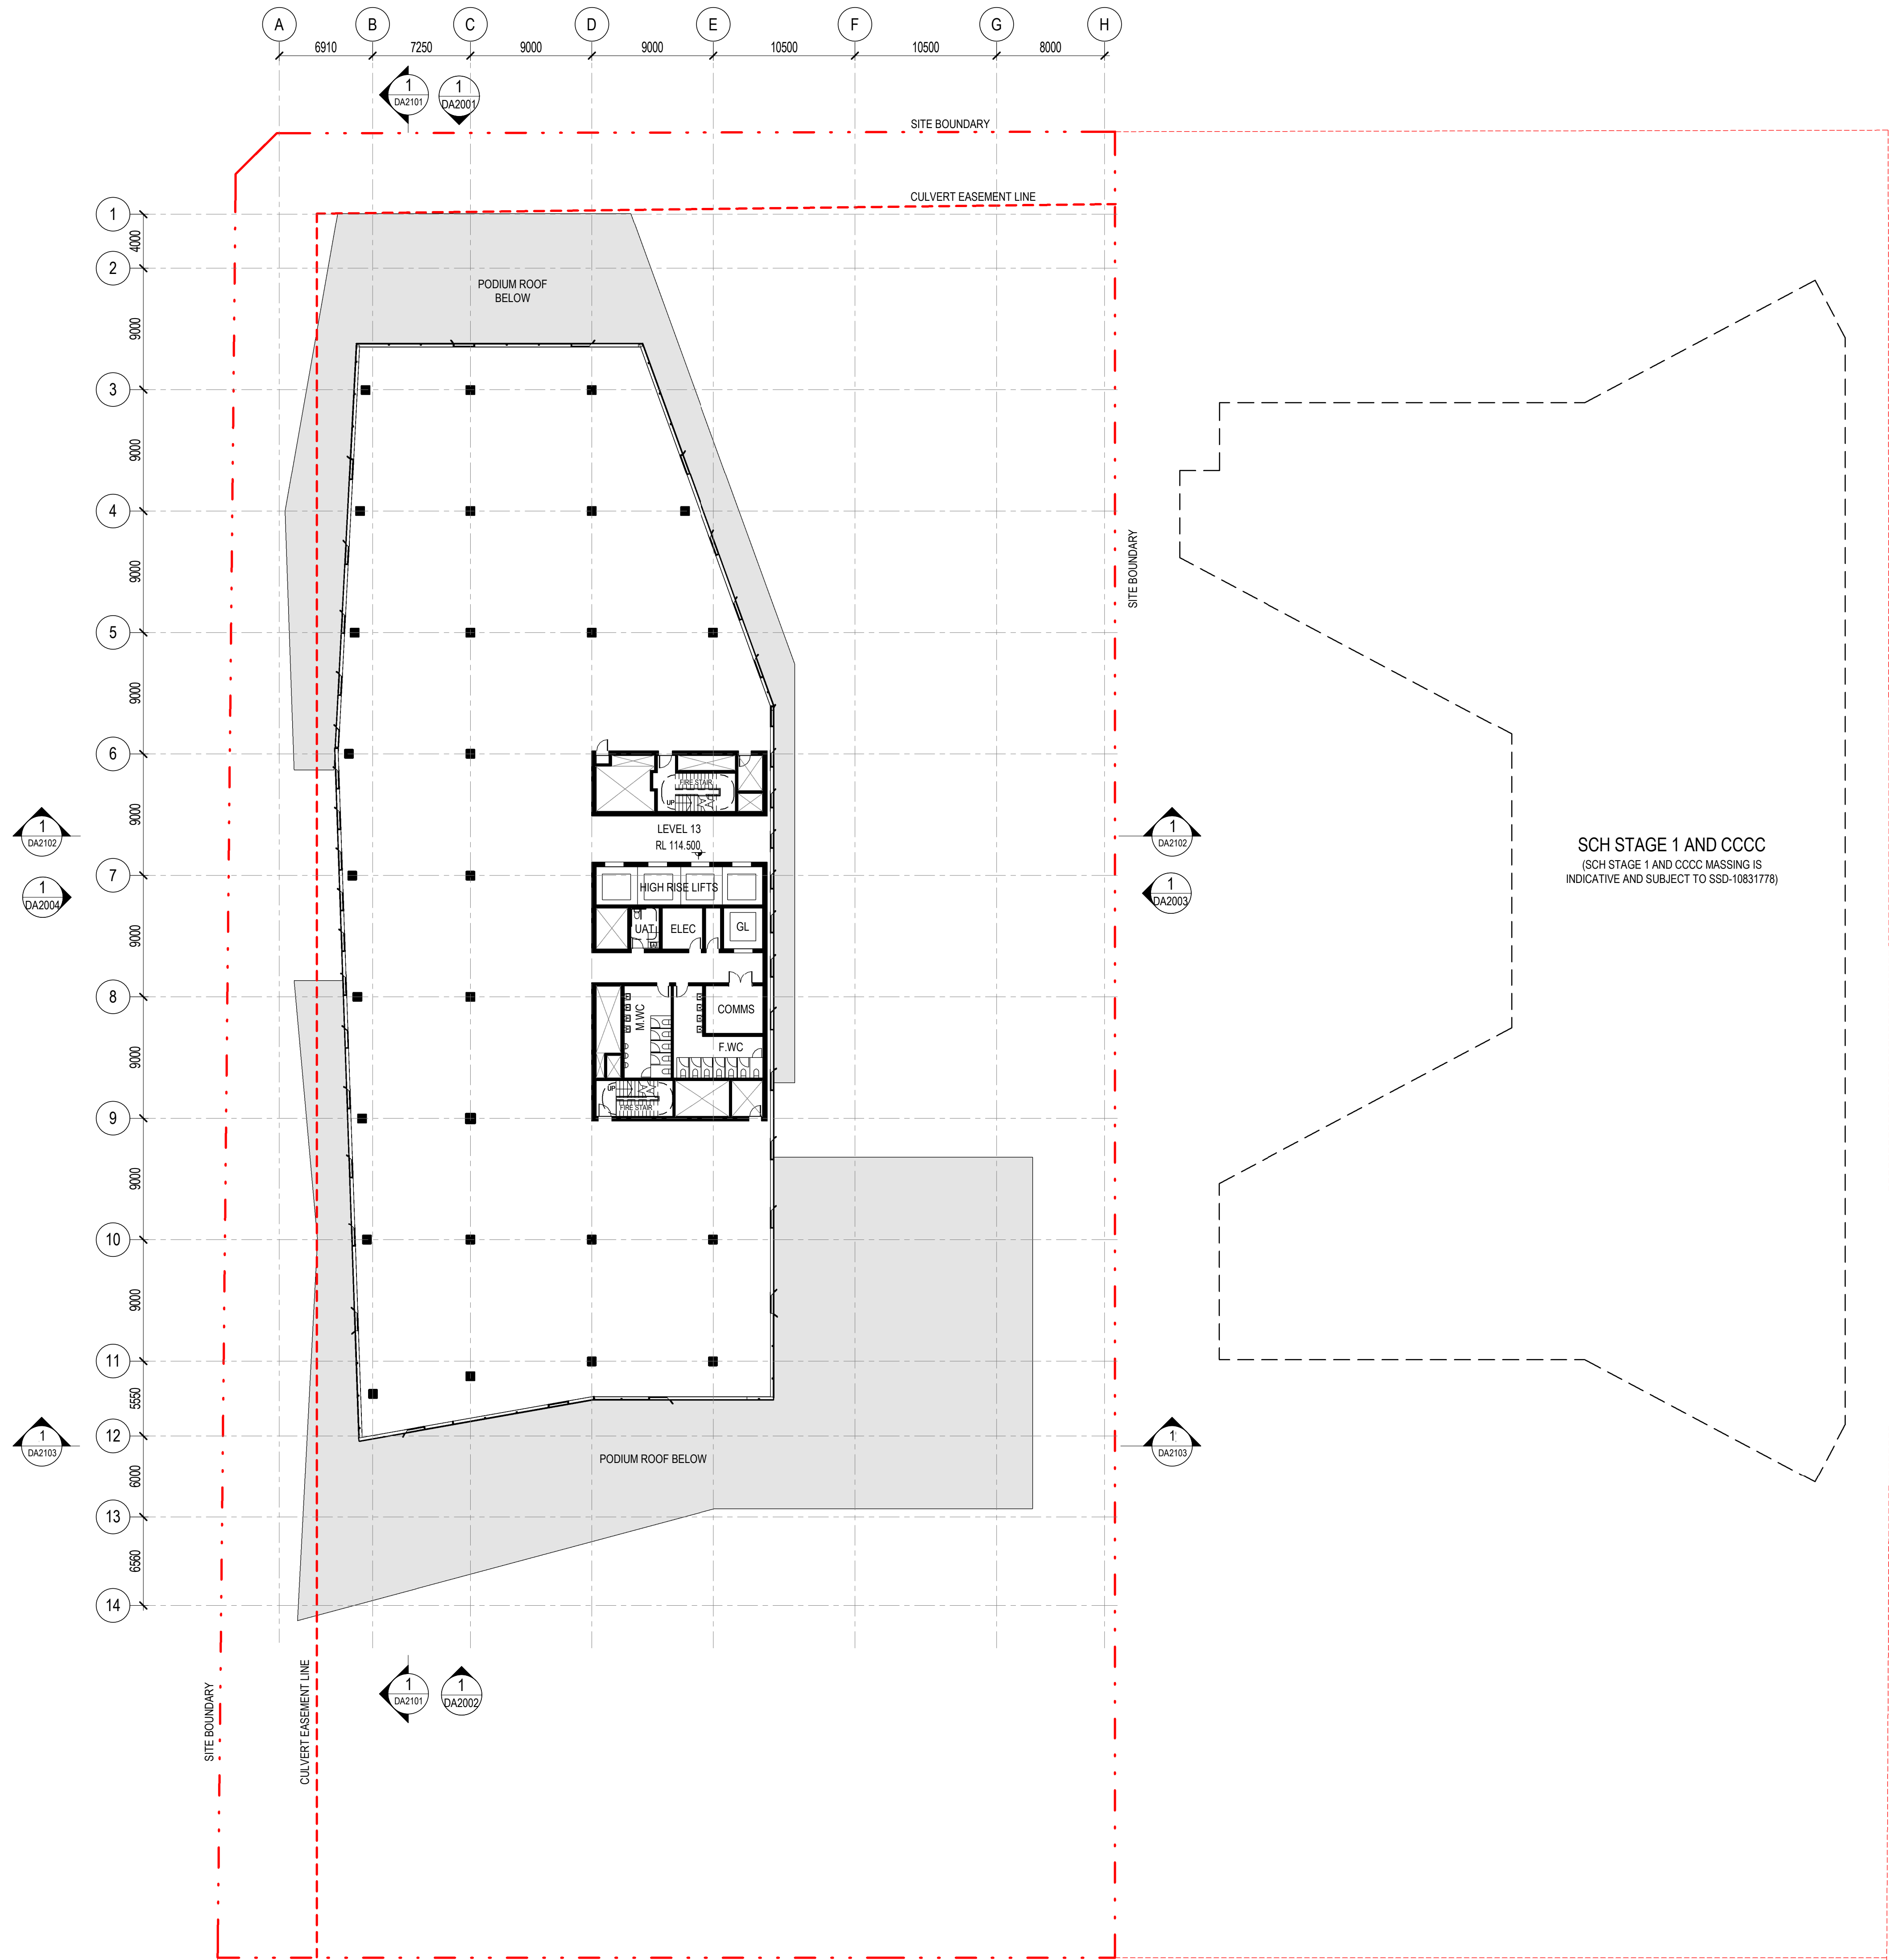

architectus™

Architectus Australia Pty Ltd is the owner of the copyright subsisting in these drawings, plans, designs and specifications. They must not be used, reproduced or copied, in whole or in part, nor may the information, ideas and concepts therein contained (which are confidential to Architectus Australia Pty Ltd) be disclosed to any person without the prior written consent of that company.

Nominated Architect
Ray Brown, NSWARB 6359

Do not scale drawings. Verify all dimensions on site

issue	amendment	date
A	ISSUED FOR STATE SIGNIFICANT DEVELOPMENT APPLICATION	18.02.21


GENERAL NOTES:

- DO NOT SCALE FROM THE DRAWINGS. USE ONLY FIGURED DIMENSIONS.
- ALL DIMENSIONS ARE IN MILLIMETRES UNLESS OTHERWISE STATED.
- REDUCED LEVELS (RL) ARE TO AUSTRALIAN HEIGHT DATUM (AHD).
- COORDINATES ARE TO MAP GRID AUSTRALIA (MGA).
- THE ARCHITECTURAL DOCUMENTATION IS ONLY ALLOWED TO BE USED FOR THE PURPOSE FOR WHICH IT WAS COMMISSIONED. UNAUTHORISED USE OF THE DOCUMENTATION IS PROHIBITED.


Scale:

1:250 @ A1
1:500 @ A3

0 2.5 5 7.5 10

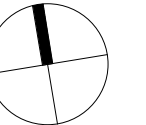

architectus™

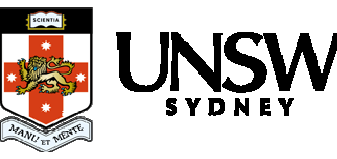

ABN 90 131 245 684

project

UNSW Health Translation Hub

drawing

Level 13


scale 1 : 250@A1 drawing no.

drawn TH DA1014

checked JC issue

project no 190551.00 A

18/02/2021 10:29:53 AM

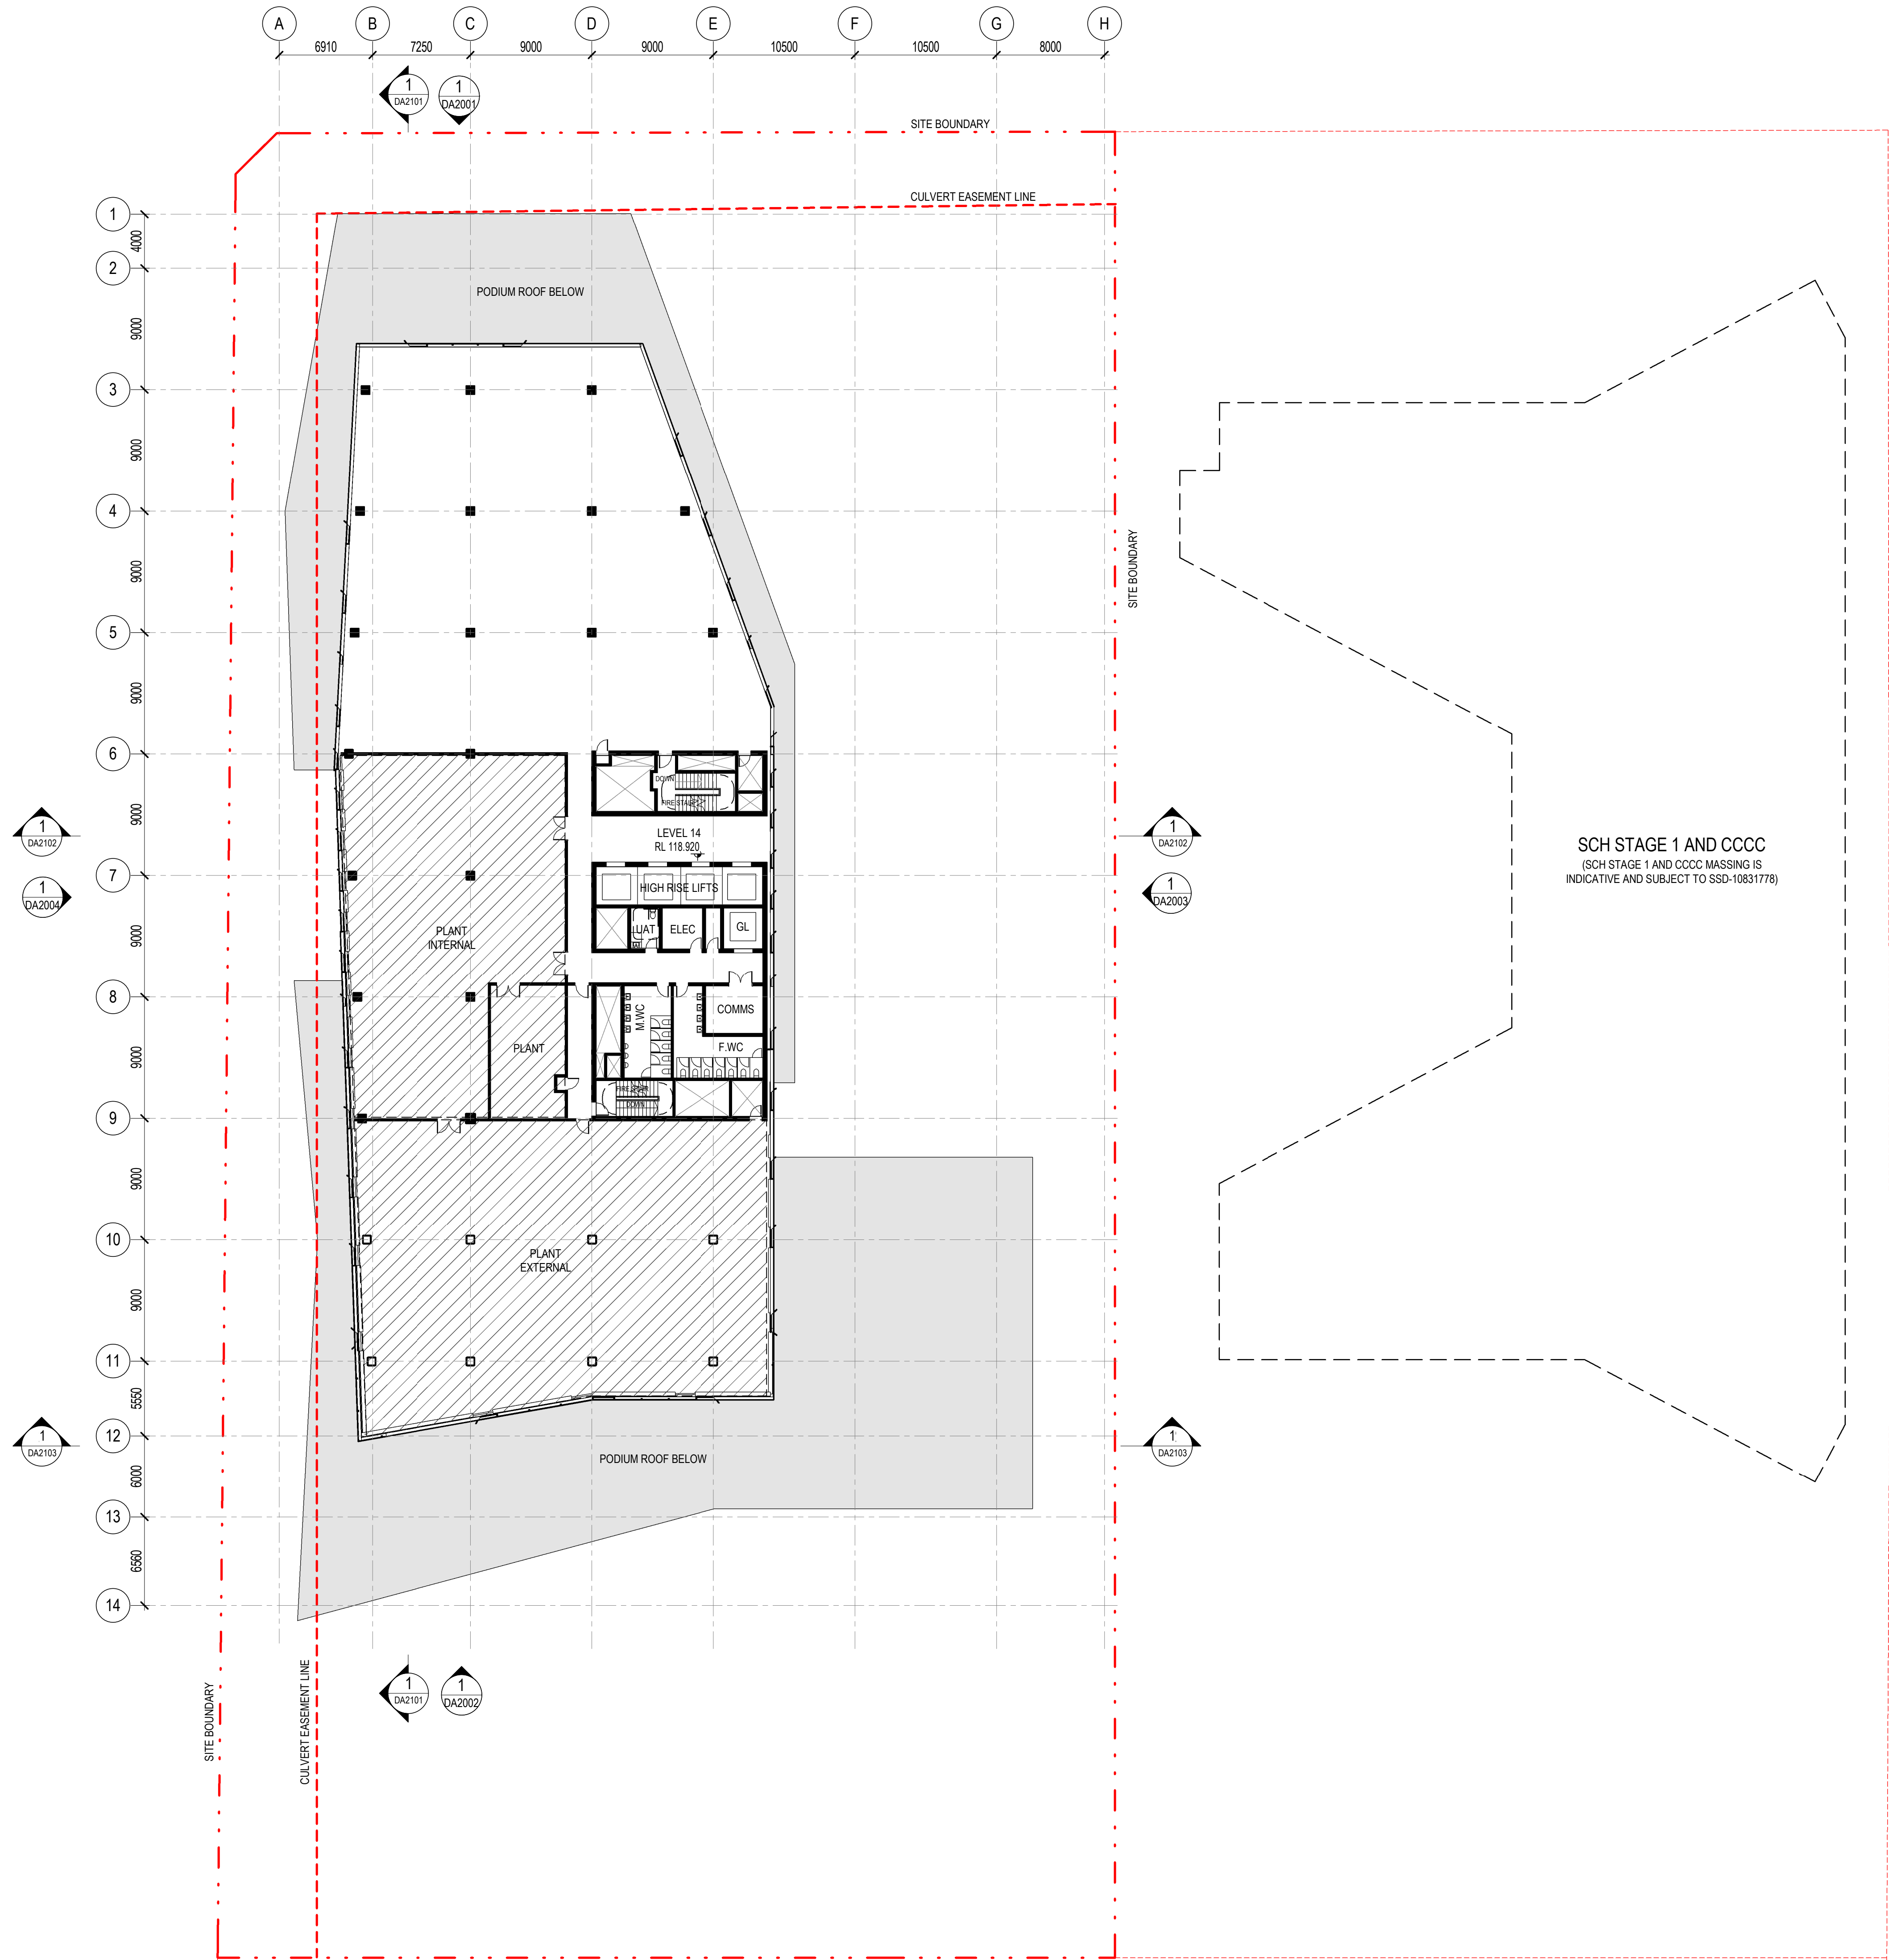

architectus™

Architectus Australia Pty Ltd is the owner of the copyright subsisting in these drawings, plans, designs and specifications. They must not be used, reproduced or copied, in whole or in part, nor may the information, ideas and concepts therein contained (which are confidential to Architectus Australia Pty Ltd) be disclosed to any person without the prior written consent of that company.

Nominated Architect
Ray Brown, NSWARB 6359

Do not scale drawings. Verify all dimensions on site


issue	amendment	date
A	ISSUED FOR STATE SIGNIFICANT DEVELOPMENT APPLICATION	18.02.21

GENERAL NOTES:

- DO NOT SCALE FROM THE DRAWINGS. USE ONLY FIGURED DIMENSIONS.
- ALL DIMENSIONS ARE IN MILLIMETRES UNLESS OTHERWISE STATED.
- REDUCED LEVELS (RL) ARE TO AUSTRALIAN HEIGHT DATUM (AHD).
- COORDINATES ARE TO MAP GRID AUSTRALIA (MGA).
- THE ARCHITECTURAL DOCUMENTATION IS ONLY ALLOWED TO BE USED FOR THE PURPOSE FOR WHICH IT WAS COMMISSIONED. UNAUTHORISED USE OF THE DOCUMENTATION IS PROHIBITED.

Scale:
1:250 @ A1
1:500 @ A3

0 2.5 5 7.5 10

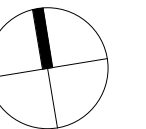

architectus™



ABN 90 131 245 684

project


UNSW Health Translation Hub

drawing

Level 14 - Plant

scale	1 : 250@A1	drawing no.
drawn	TH	DA1015
checked	JC	issue
project no	190551.00	A

18/02/2021 10:29:59 AM

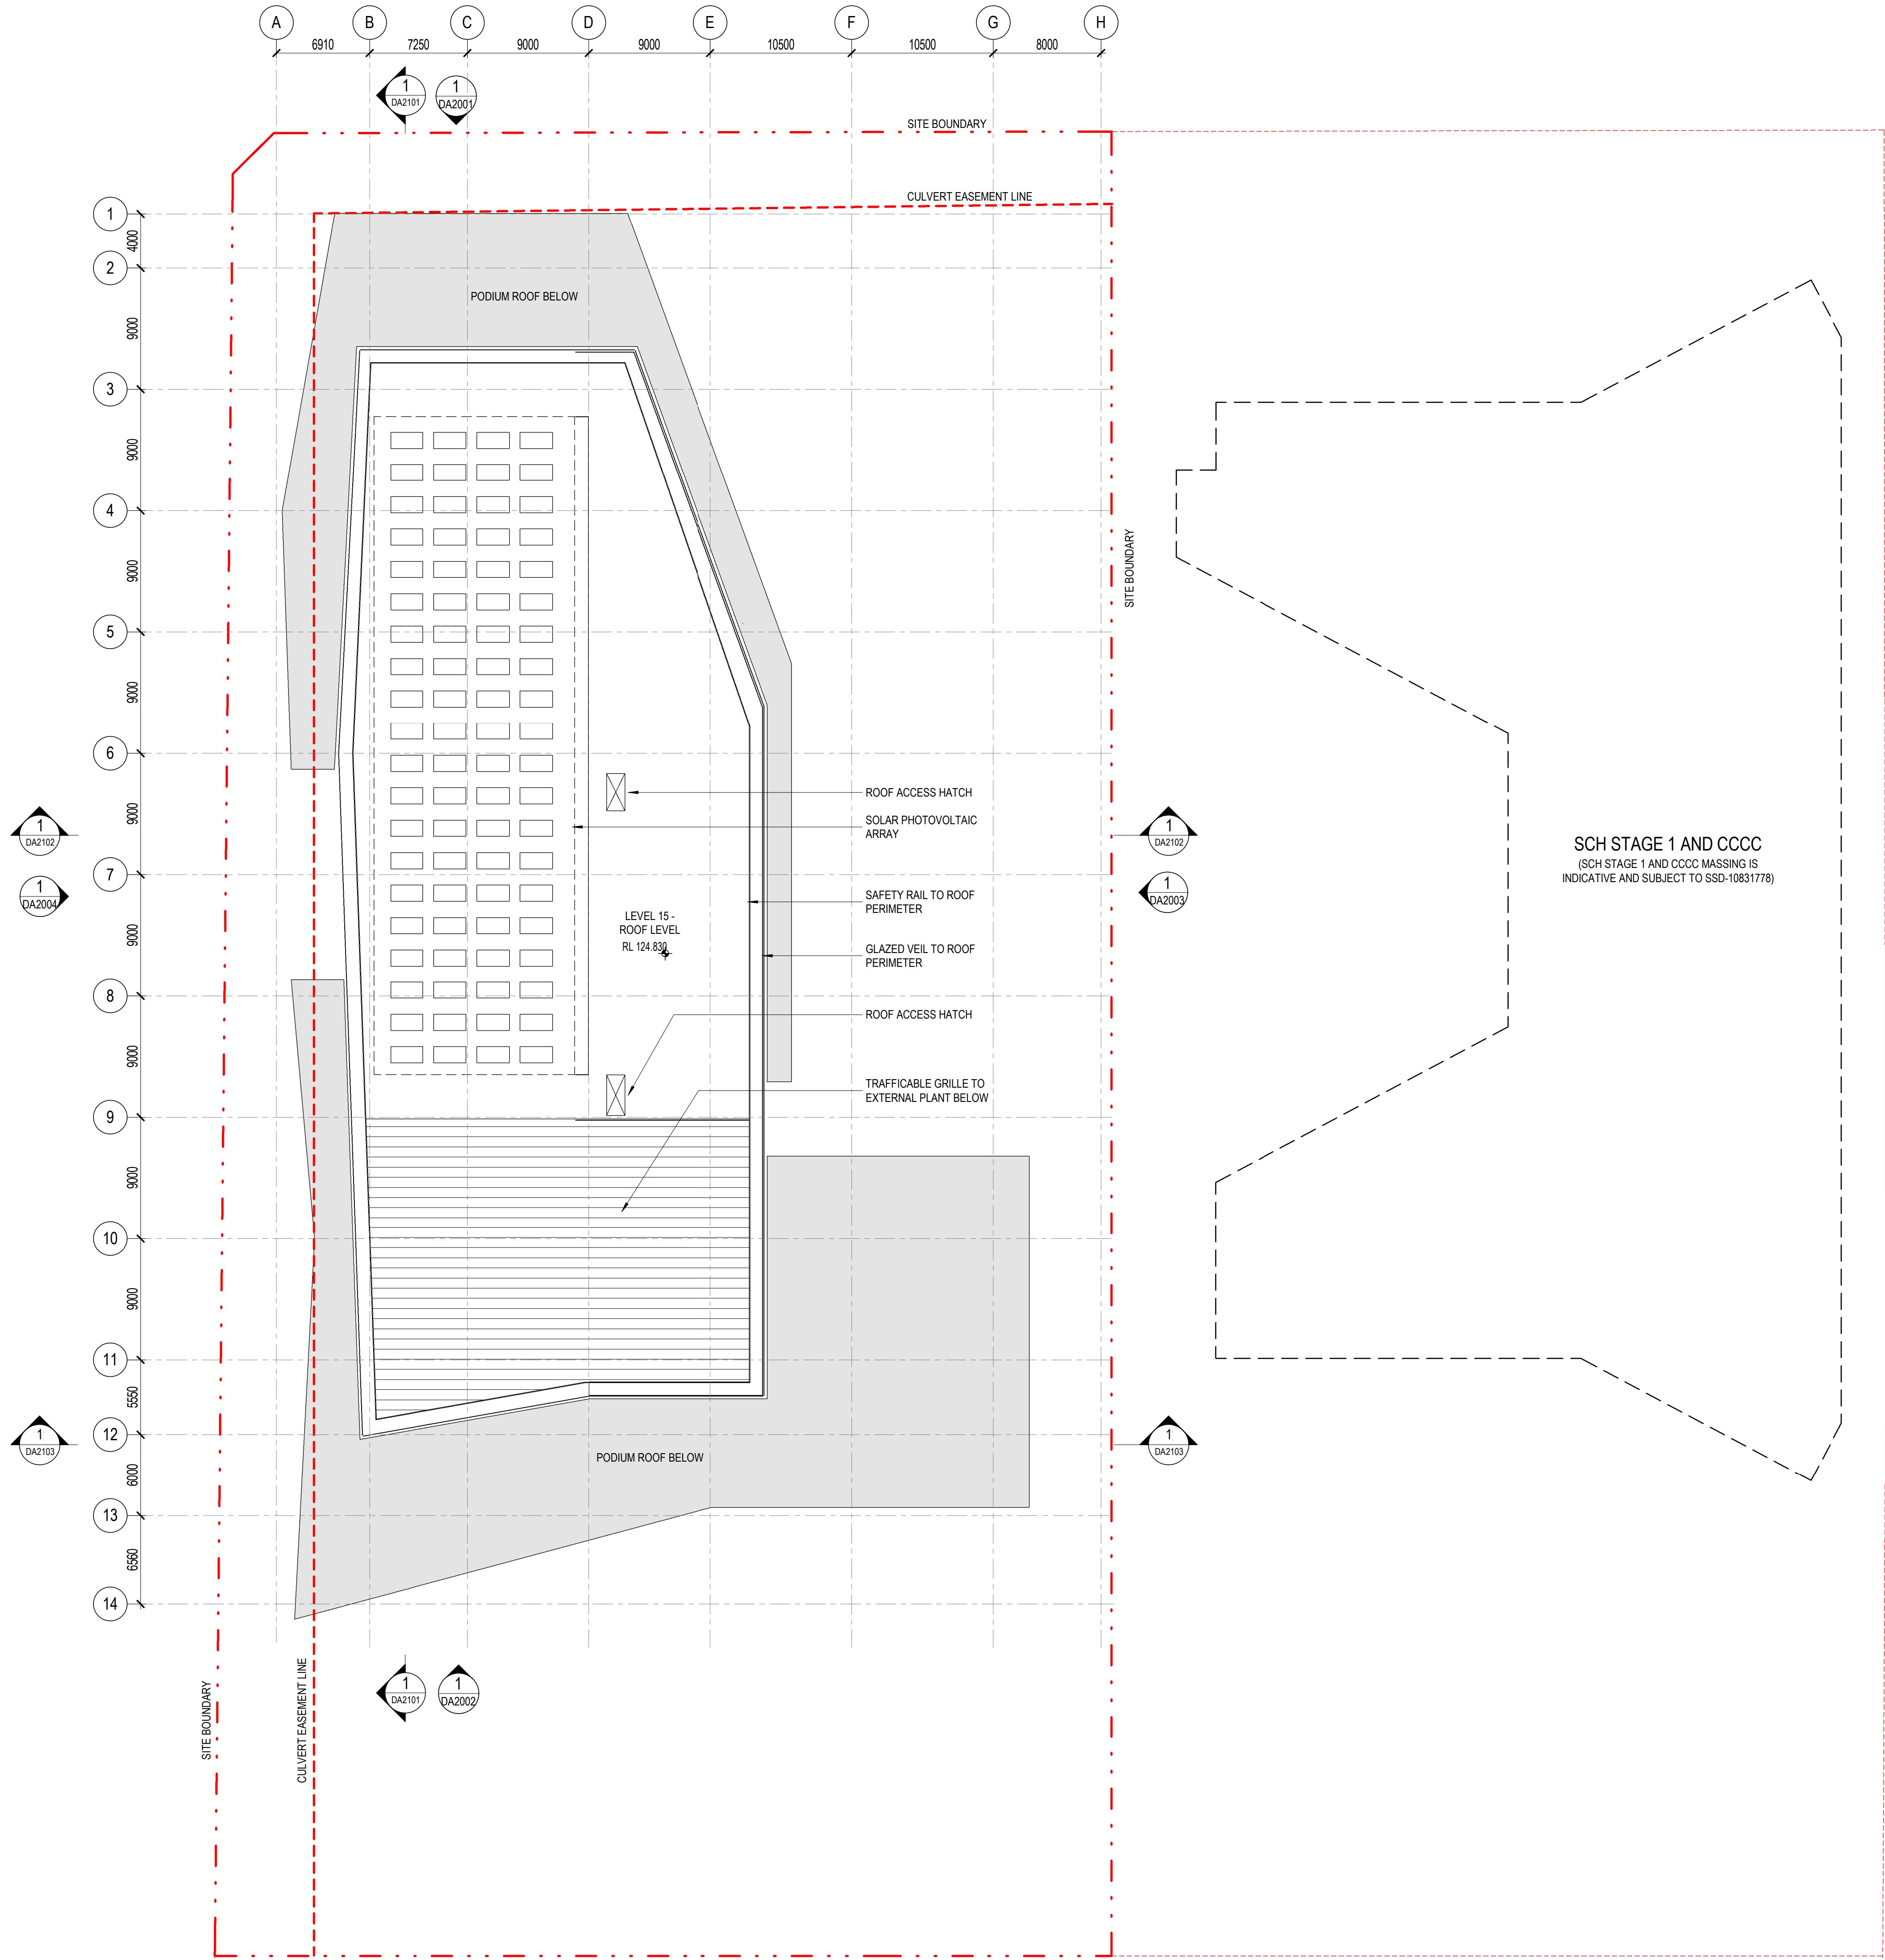

architectus™

Architectus Australia Pty Ltd is the owner of the copyright subsisting in these drawings, plans, designs and specifications. They must not be used, reproduced or copied, in whole or in part, nor may the information, ideas and concepts therein contained (which are confidential to Architectus Australia Pty Ltd) be disclosed to any person without the prior written consent of that company.

Nominated Architect
Ray Brown, NSWARB 6359

Do not scale drawings. Verify all dimensions on site

issue	amendment	date
A	ISSUED FOR STATE SIGNIFICANT DEVELOPMENT APPLICATION	18.02.21

GENERAL NOTES:

- DO NOT SCALE FROM THE DRAWINGS. USE ONLY FIGURED DIMENSIONS.
- ALL DIMENSIONS ARE IN MILLIMETRES UNLESS OTHERWISE STATED.
- REDUCED LEVELS (RL) ARE TO AUSTRALIAN HEIGHT DATUM (AHD).
- COORDINATES ARE TO MAP GRID AUSTRALIA (MGA).
- THE ARCHITECTURAL DOCUMENTATION IS ONLY ALLOWED TO BE USED FOR THE PURPOSE FOR WHICH IT WAS COMMISSIONED. UNAUTHORISED USE OF THE DOCUMENTATION IS PROHIBITED.

Scale:

1:250 @ A1
1:500 @ A3

0 2.5 5 7.5 10

architectus™

UNSW SYDNEY

ABN 90 131 245 684

project

UNSW Health Translation Hub

drawing

Level 15 - Roof


scale 1 : 250@A1 drawing no. DA1016

drawn TH

checked JC issue

project no 190551.00

18/02/2021 10:30:04 AM

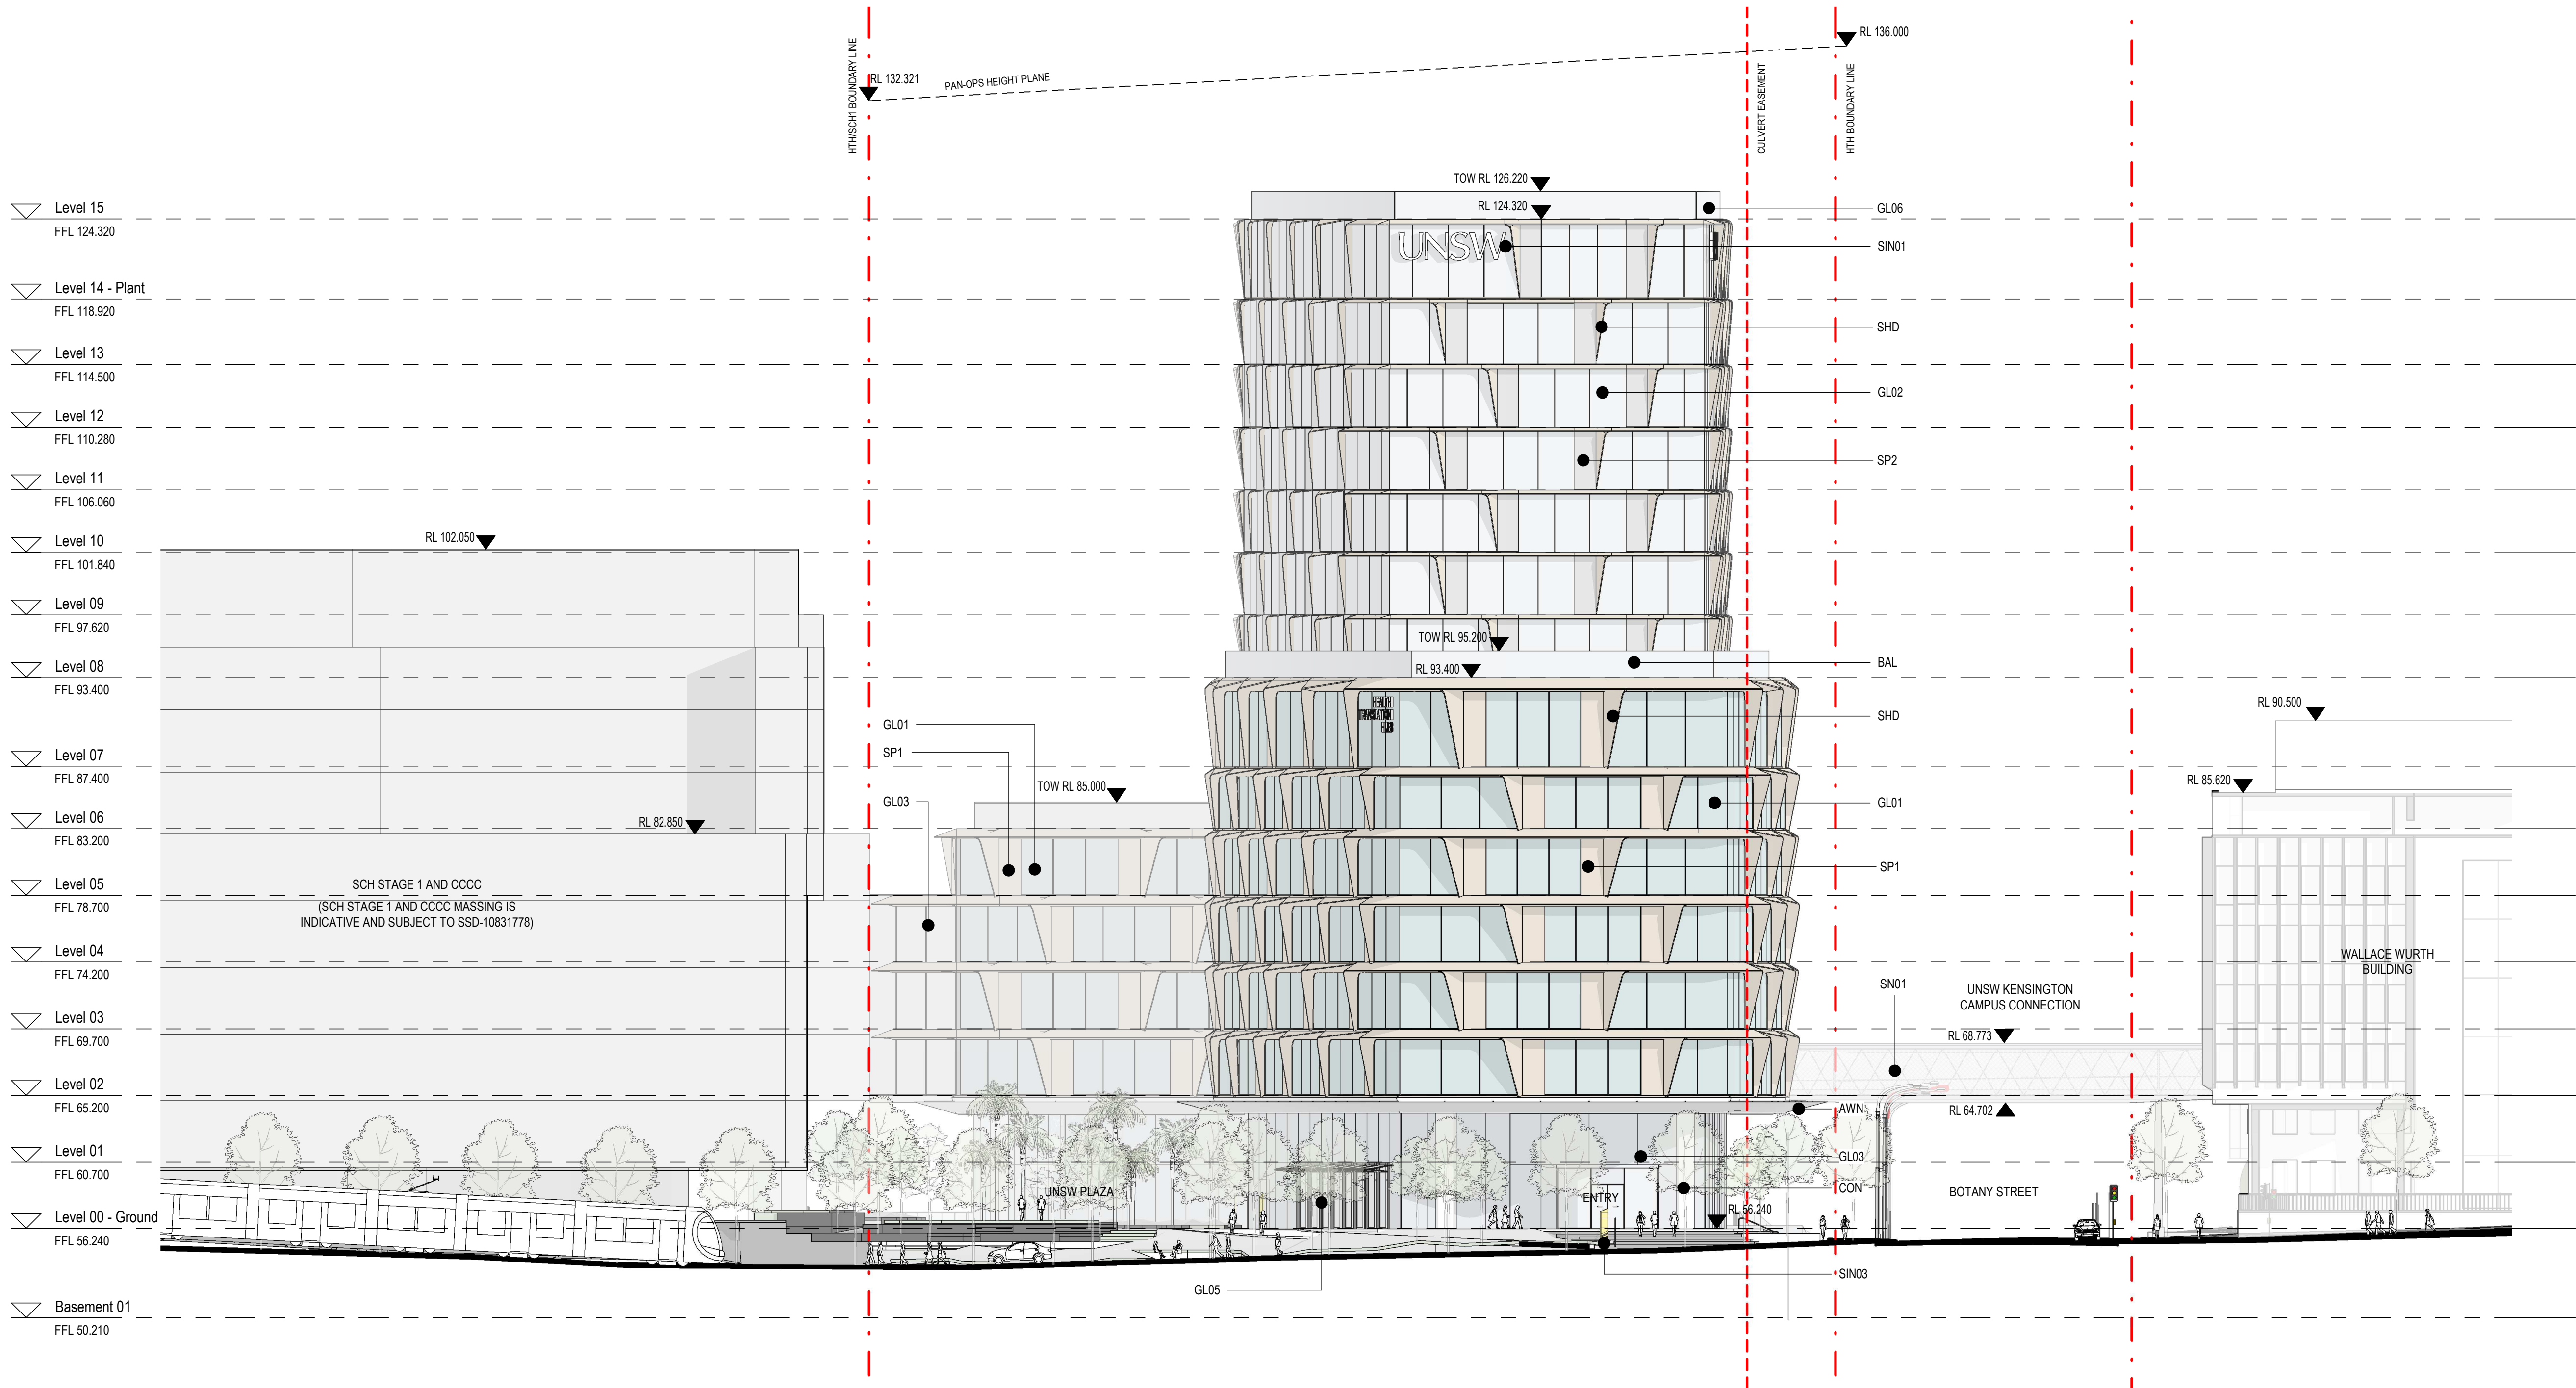



issue	amendment	date
A	ISSUED FOR STATE SIGNIFICANT DEVELOPMENT APPLICATION	18.02.21

GENERAL NOTES:

- DO NOT SCALE FROM THE DRAWINGS. USE ONLY FIGURED DIMENSIONS.
- ALL DIMENSIONS ARE IN MILLIMETRES UNLESS OTHERWISE STATED.
- REDUCED LEVELS (RL) ARE TO AUSTRALIAN HEIGHT DATUM (AHD).
- COORDINATES ARE TO MAP GRID AUSTRALIA (MGA).
- THE ARCHITECTURAL DOCUMENTATION IS ONLY ALLOWED TO BE USED FOR THE PURPOSE FOR WHICH IT WAS COMMISSIONED. UNAUTHORISED USE OF THE DOCUMENTATION IS PROHIBITED.


- AWN – Glass Awning
- GL01 – Podium Double Glazed Unit
- GL02 – Tower Double Glazed Unit
- GL03 – Ground Floor & Atrium Double Glazed Unit
- GL04 – Glazed Door
- GL05 – Glazed Retail Door
- GL06 – Glazed Veil
- SHD – Solar Shading Hood
- SP1 – Solid Podium Spandrel Panel
- SP2 – Backpan Spandrel Panel
- LV1 – Anodized Mechanical Louvre/Grill with External Mesh screen
- CON – Concrete
- BAL – Balustrade
- SIN01 – Tower UNSW sign
- SIN02 – Podium Health Translation Hub sign
- SIN03 – Street Level Directional Sign
- SN01 – Mesh Screen
- CONS – Concrete Filled Steel Column

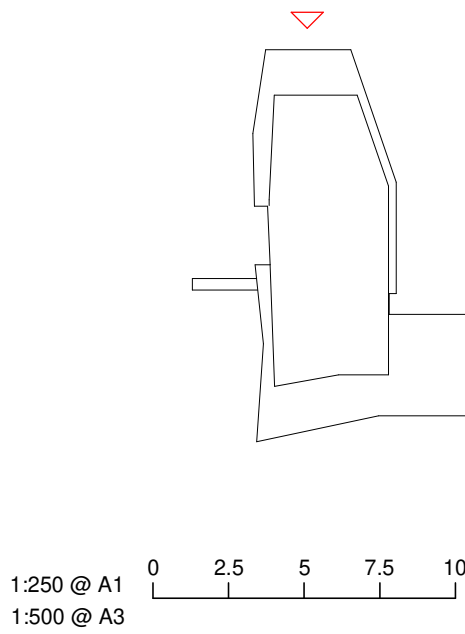

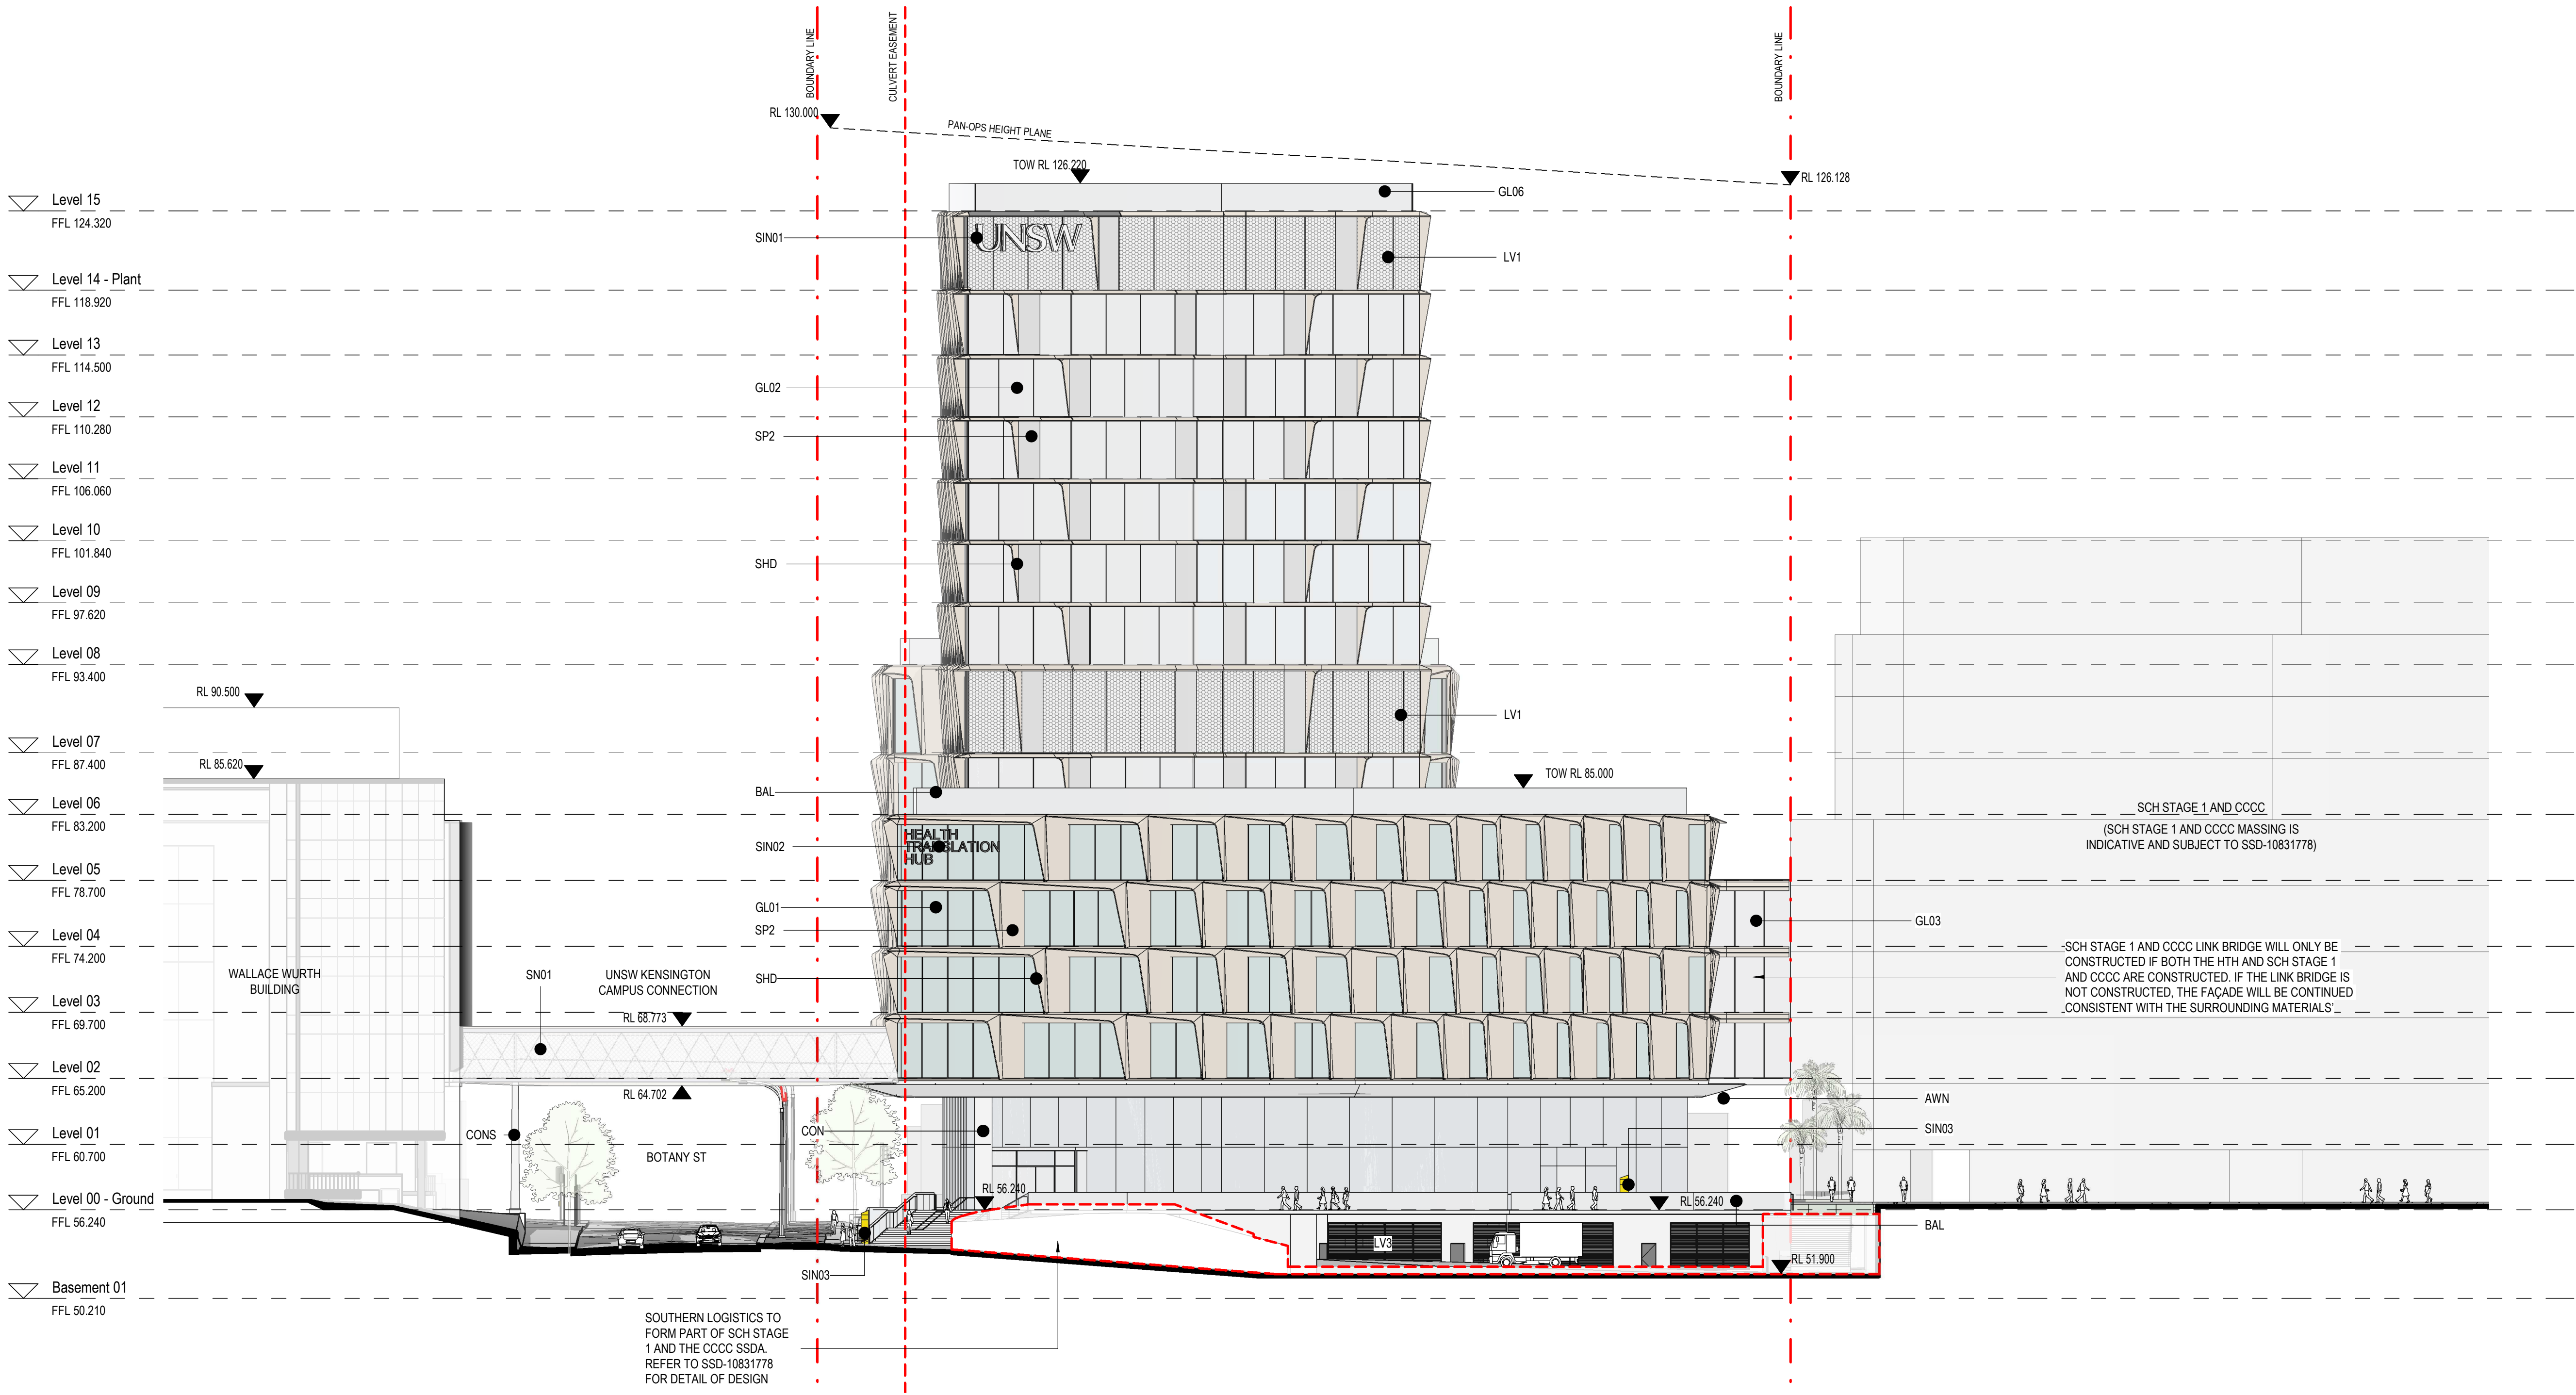

architectus™		
Architectus Australia Pty Ltd is the owner of the copyright subsisting in these drawings, plans, designs and specifications. They must not be used, reproduced or copied, in whole or in part, nor may the information, ideas and concepts therein contained (which are confidential to Architectus Australia Pty Ltd) be disclosed to any person without the prior written consent of that company.		
Nominated Architect Ray Brown, NSWARB 6359		
Do not scale drawings. Verify all dimensions on site		
issue	amendment	date
A	ISSUED FOR STATE SIGNIFICANT DEVELOPMENT APPLICATION	18.02.21

- GENERAL NOTES:
- DO NOT SCALE FROM THE DRAWINGS. USE ONLY FIGURED DIMENSIONS.
 - ALL DIMENSIONS ARE IN MILLIMETRES UNLESS OTHERWISE STATED.
 - REDUCED LEVELS (RL) ARE TO AUSTRALIAN HEIGHT DATUM (AHD).
 - COORDINATES ARE TO MAP GRID AUSTRALIA (MGA).
 - THE ARCHITECTURAL DOCUMENTATION IS ONLY ALLOWED TO BE USED FOR THE PURPOSE FOR WHICH IT WAS COMMISSIONED. UNAUTHORISED USE OF THE DOCUMENTATION IS PROHIBITED.
- AWN – Glass Awning
- GL01 – Podium Double Glazed Unit
- GL02 – Tower Double Glazed Unit
- GL03 – Ground Floor & Atrium Double Glazed Unit
- GL04 – Glazed Door
- GL05 – Glazed Retail Door
- GL06 – Glazed Veil
- SHD – Solar Shading Hood
- SP1 – Solid Podium Spandrel Panel
- SP2 – Backpan Spandrel Panel
- LV1 – Anodized Mechanical Louvre/Grill with External Mesh screen
- CON – Concrete
- BAL – Balustrade
- SIN01 – Tower UNSW sign
- SIN02 – Podium Health Translation Hub sign
- SIN03 – Street Level Directional Sign
- SN01 – Mesh Screen
- CONS – Concrete Filled Steel Column
- SOUTHERN LOGISTICS TO FORM PART OF SCH STAGE 1 AND THE CCCC SSDA REFER TO SSD-10831778 FOR DETAIL OF DESIGN
- SCH STAGE 1 AND CCCC LINK BRIDGE WILL ONLY BE CONSTRUCTED IF BOTH THE HTH AND SCH STAGE 1 AND CCCC ARE CONSTRUCTED. IF THE LINK BRIDGE IS NOT CONSTRUCTED, THE FAÇADE WILL BE CONTINUED CONSISTENT WITH THE SURROUNDING MATERIALS

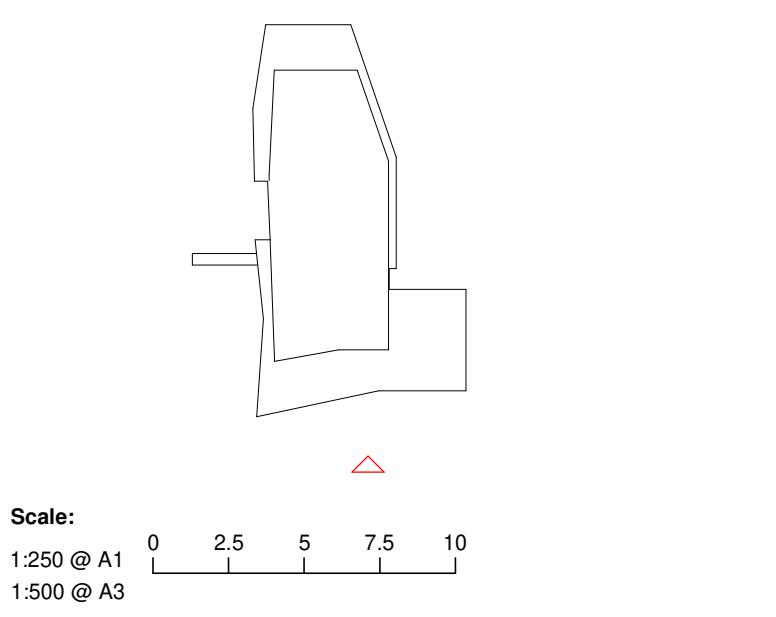


project

UNSW Health Translation Hub

drawing

South Elevation		
scale	1 : 250@A1	drawing no.
drawn	TH	DA2002
checked	JC	issue
project no	190551.00	A

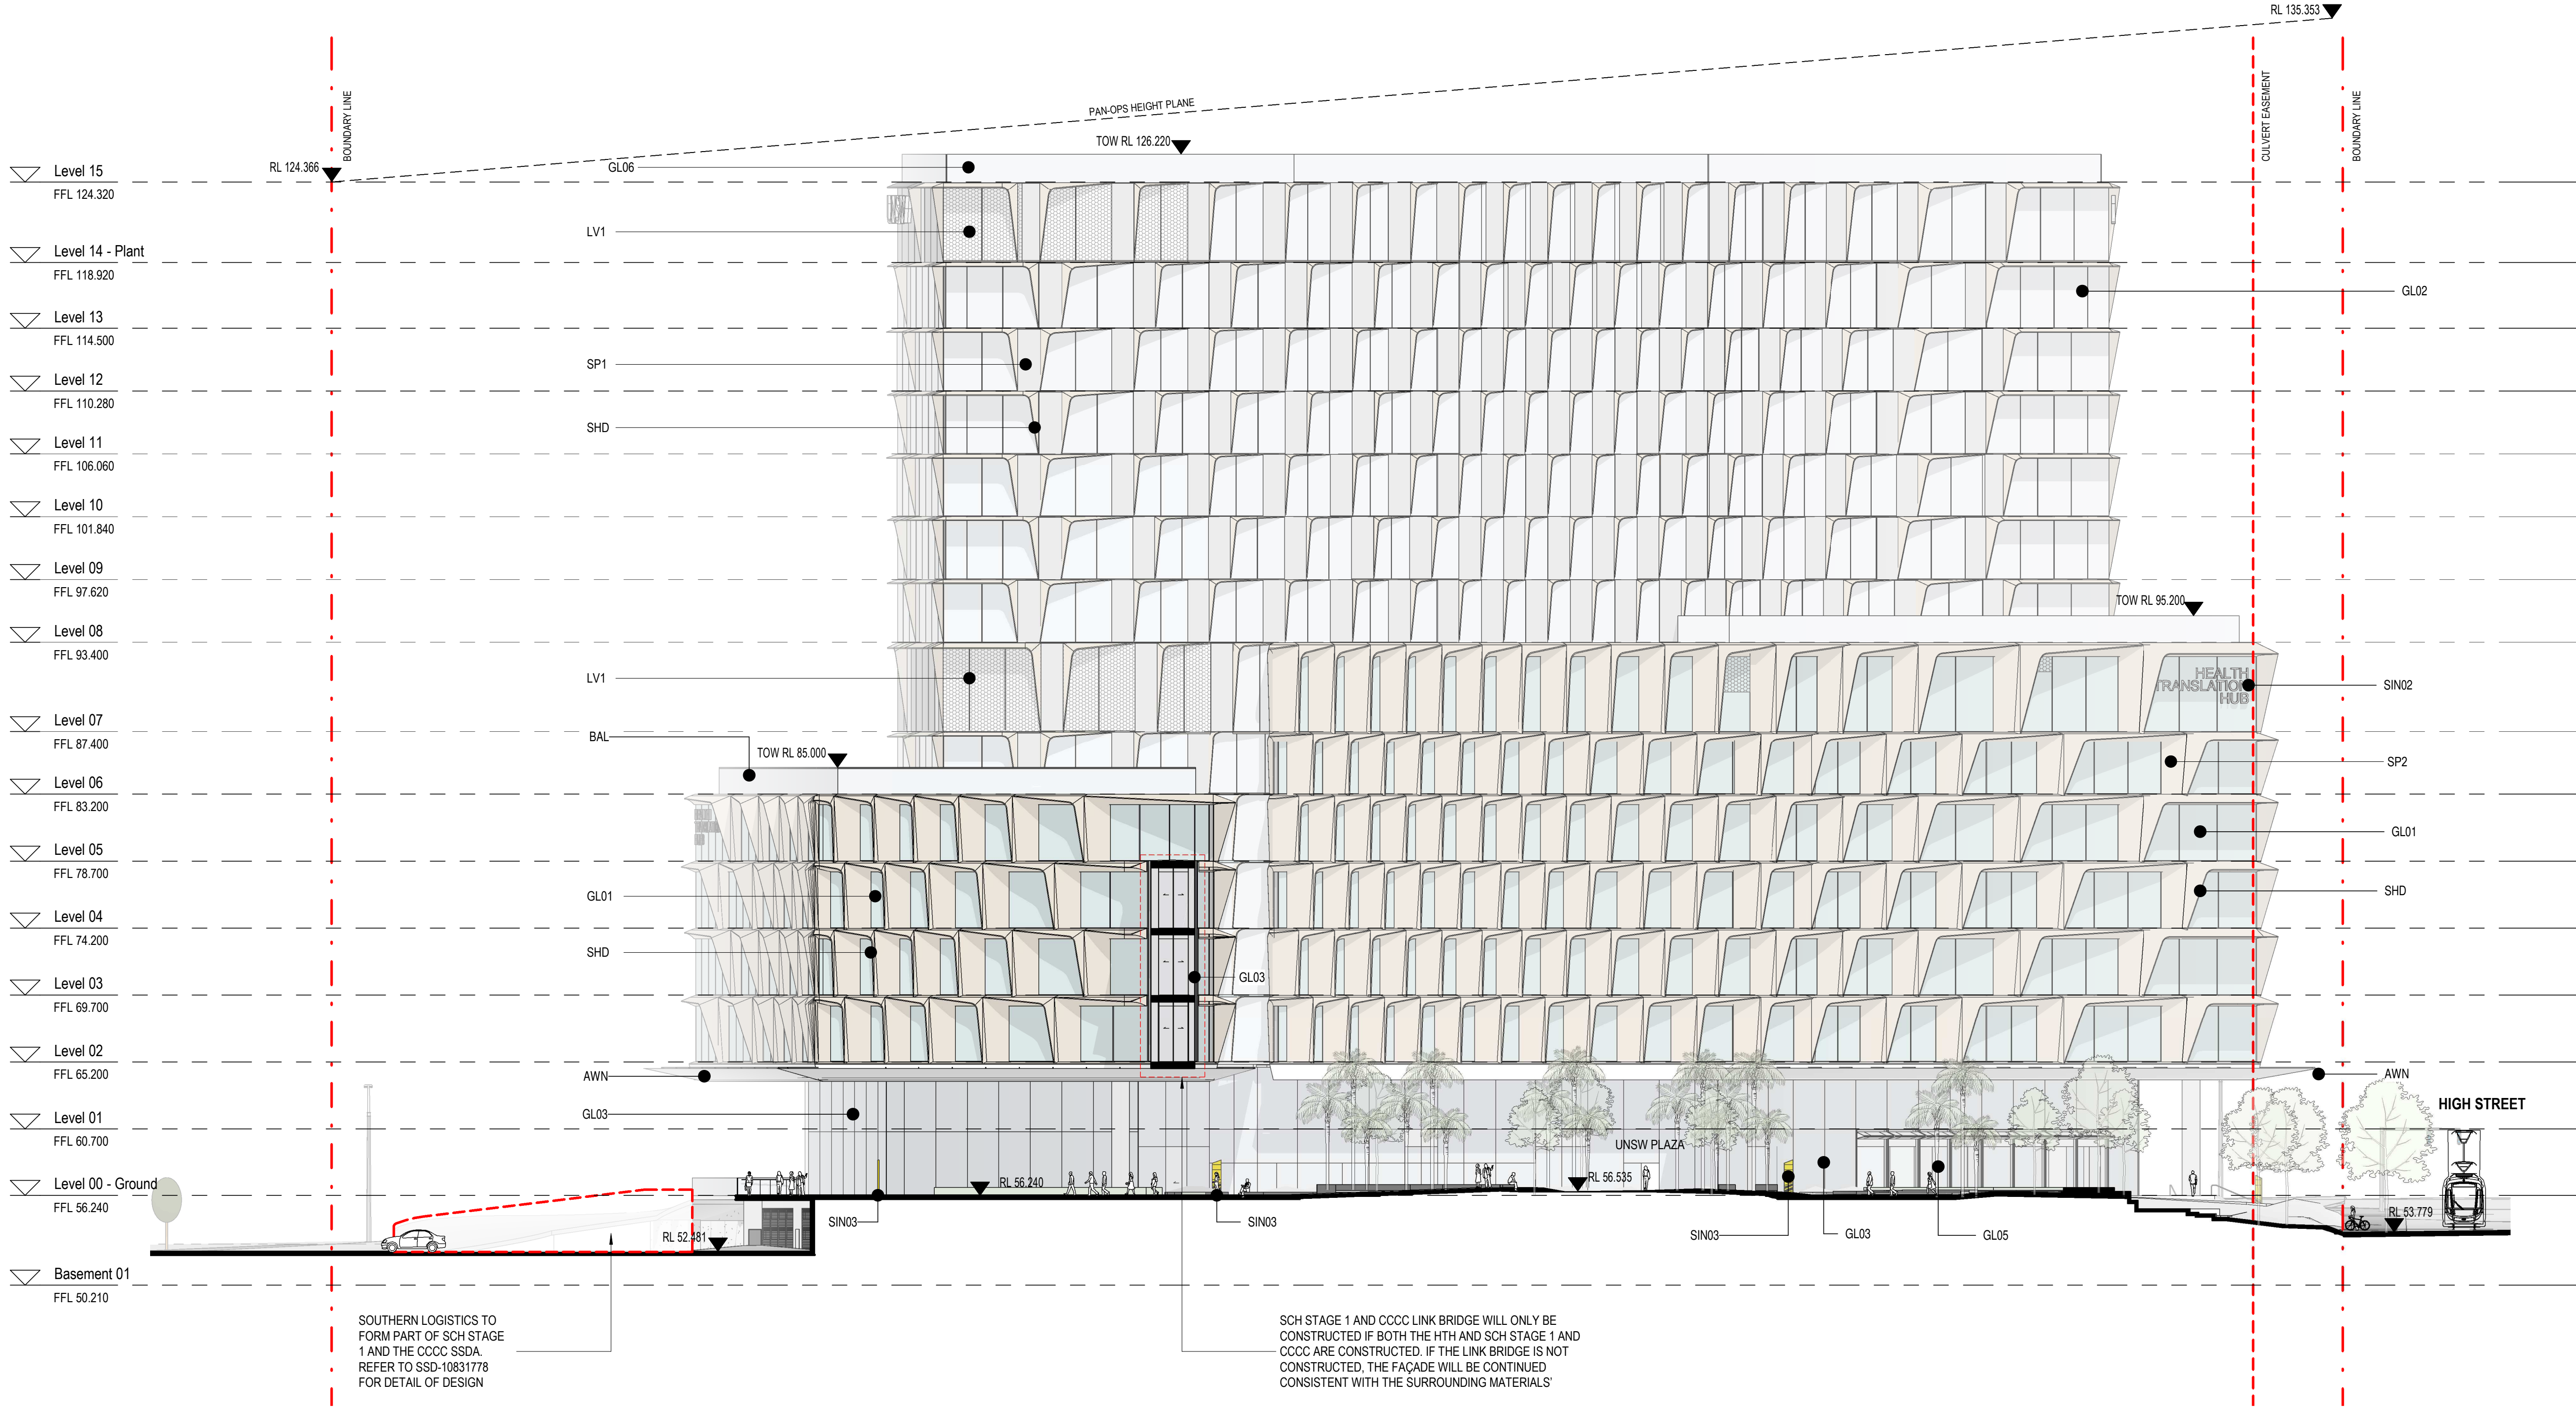

architectus™

Architectus Australia Pty Ltd is the owner of the copyright subsisting in these drawings, plans, designs and specifications. They must not be used, reproduced or copied, in whole or in part, nor may the information, ideas and concepts therein contained (which are confidential to Architectus Australia Pty Ltd) be disclosed to any person without the prior written consent of that company.

Nominated Architect
Ray Brown, NSWARB 6359

Do not scale drawings. Verify all dimensions on site


issue	amendment	date
A	ISSUED FOR STATE SIGNIFICANT DEVELOPMENT APPLICATION	18.02.21

GENERAL NOTES:

- DO NOT SCALE FROM THE DRAWINGS. USE ONLY FIGURED DIMENSIONS. ALL DIMENSIONS ARE IN MILLIMETRES UNLESS OTHERWISE STATED.
- REDUCED LEVELS (RL) ARE TO AUSTRALIAN HEIGHT DATUM (AHD). COORDINATES ARE TO MAP GRID AUSTRALIA (MGA).
- THE ARCHITECTURAL DOCUMENTATION IS ONLY ALLOWED TO BE USED FOR THE PURPOSE FOR WHICH IT WAS COMMISSIONED. UNAUTHORISED USE OF THE DOCUMENTATION IS PROHIBITED.

- AWN – Glass Awning
- GL01 – Podium Double Glazed Unit
- GL02 – Tower Double Glazed Unit
- GL03 – Ground Floor & Atrium Double Glazed Unit
- GL04 – Glazed Door
- GL05 – Glazed Retail Door
- GL06 – Glazed Veil
- SHD – Solar Shading Hood
- SP1 – Solid Podium Spandrel Panel
- SP2 – Backpan Spandrel Panel
- LV1 – Anodized Mechanical Louvre/Grill with External Mesh screen
- CON – Concrete
- BAL – Balustrade
- SIN01 – Tower UNSW sign
- SIN02 – Podium Health Translation Hub sign
- SIN03 – Street Level Directional Sign
- SN01 – Mesh Screen
- CONS – Concrete Filled Steel Column


— SOUTHERN LOGISTICS TO FORM PART OF SCH STAGE 1 AND THE CCCC SSDA REFER TO SSD-10831778 FOR DETAIL OF DESIGN

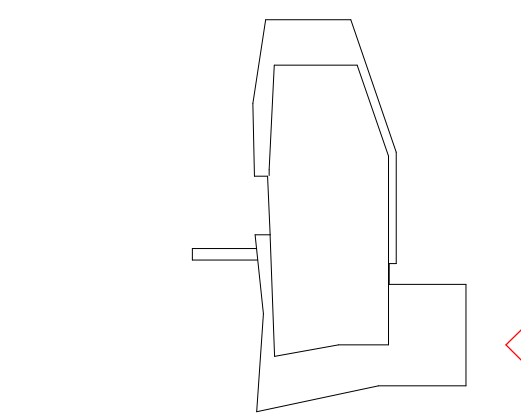

Scale:
1:250 @ A1
1:500 @ A3

0 2.5 5 7.5 10

architectus™

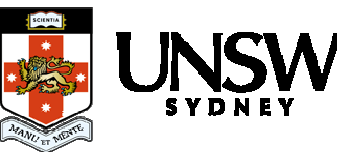

ABN 90 131 245 684

project

UNSW Health Translation Hub

drawing

East Elevation

scale	1 : 250@A1	drawing no.
drawn	TH	DA2003
checked	JC	issue
project no	190551.00	A


26/02/2021 5:36:37 PM

Do not scale drawings. Verify all dimensions on site

[illegible]

DO NOT SCALE FROM THE DRAWINGS. USE ONLY FIGURED DIMENSIONS.
ALL DIMENSIONS ARE IN MILLIMETRES UNLESS OTHERWISE STATED.
REDUCED LEVELS (RL) ARE TO AUSTRALIAN HEIGHT DATUM (AHD).
COORDINATES ARE TO MAP GRID AUSTRALIA (MGA).
THE ARCHITECTURAL DOCUMENTATION IS ONLY ALLOWED TO BE USED
FOR THE PURPOSE FOR WHICH IT WAS COMMISSIONED. UNAUTHORISED
USE OF THE DOCUMENTATION IS PROHIBITED.

**[] - SOUTHERN LOGISTICS TO FORM PART OF SCH
STAGE 1 AND THE CCCC SSDA REFER
TO SSD-10831778 FOR DETAIL OF DESIGN**

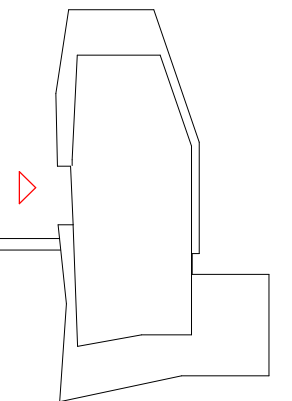

Scale:

0 2.5 5 7.5 10

1:250 @ A1

1:500 @ A3



project


UNSW Health Translation Hub


rawing

West Elevation

scale	1 : 250@A1	drawing no.
drawn	TH	DA2004
checked	JC	issue
project no	190551.00	A

6/02/2021 5:28:55 PM

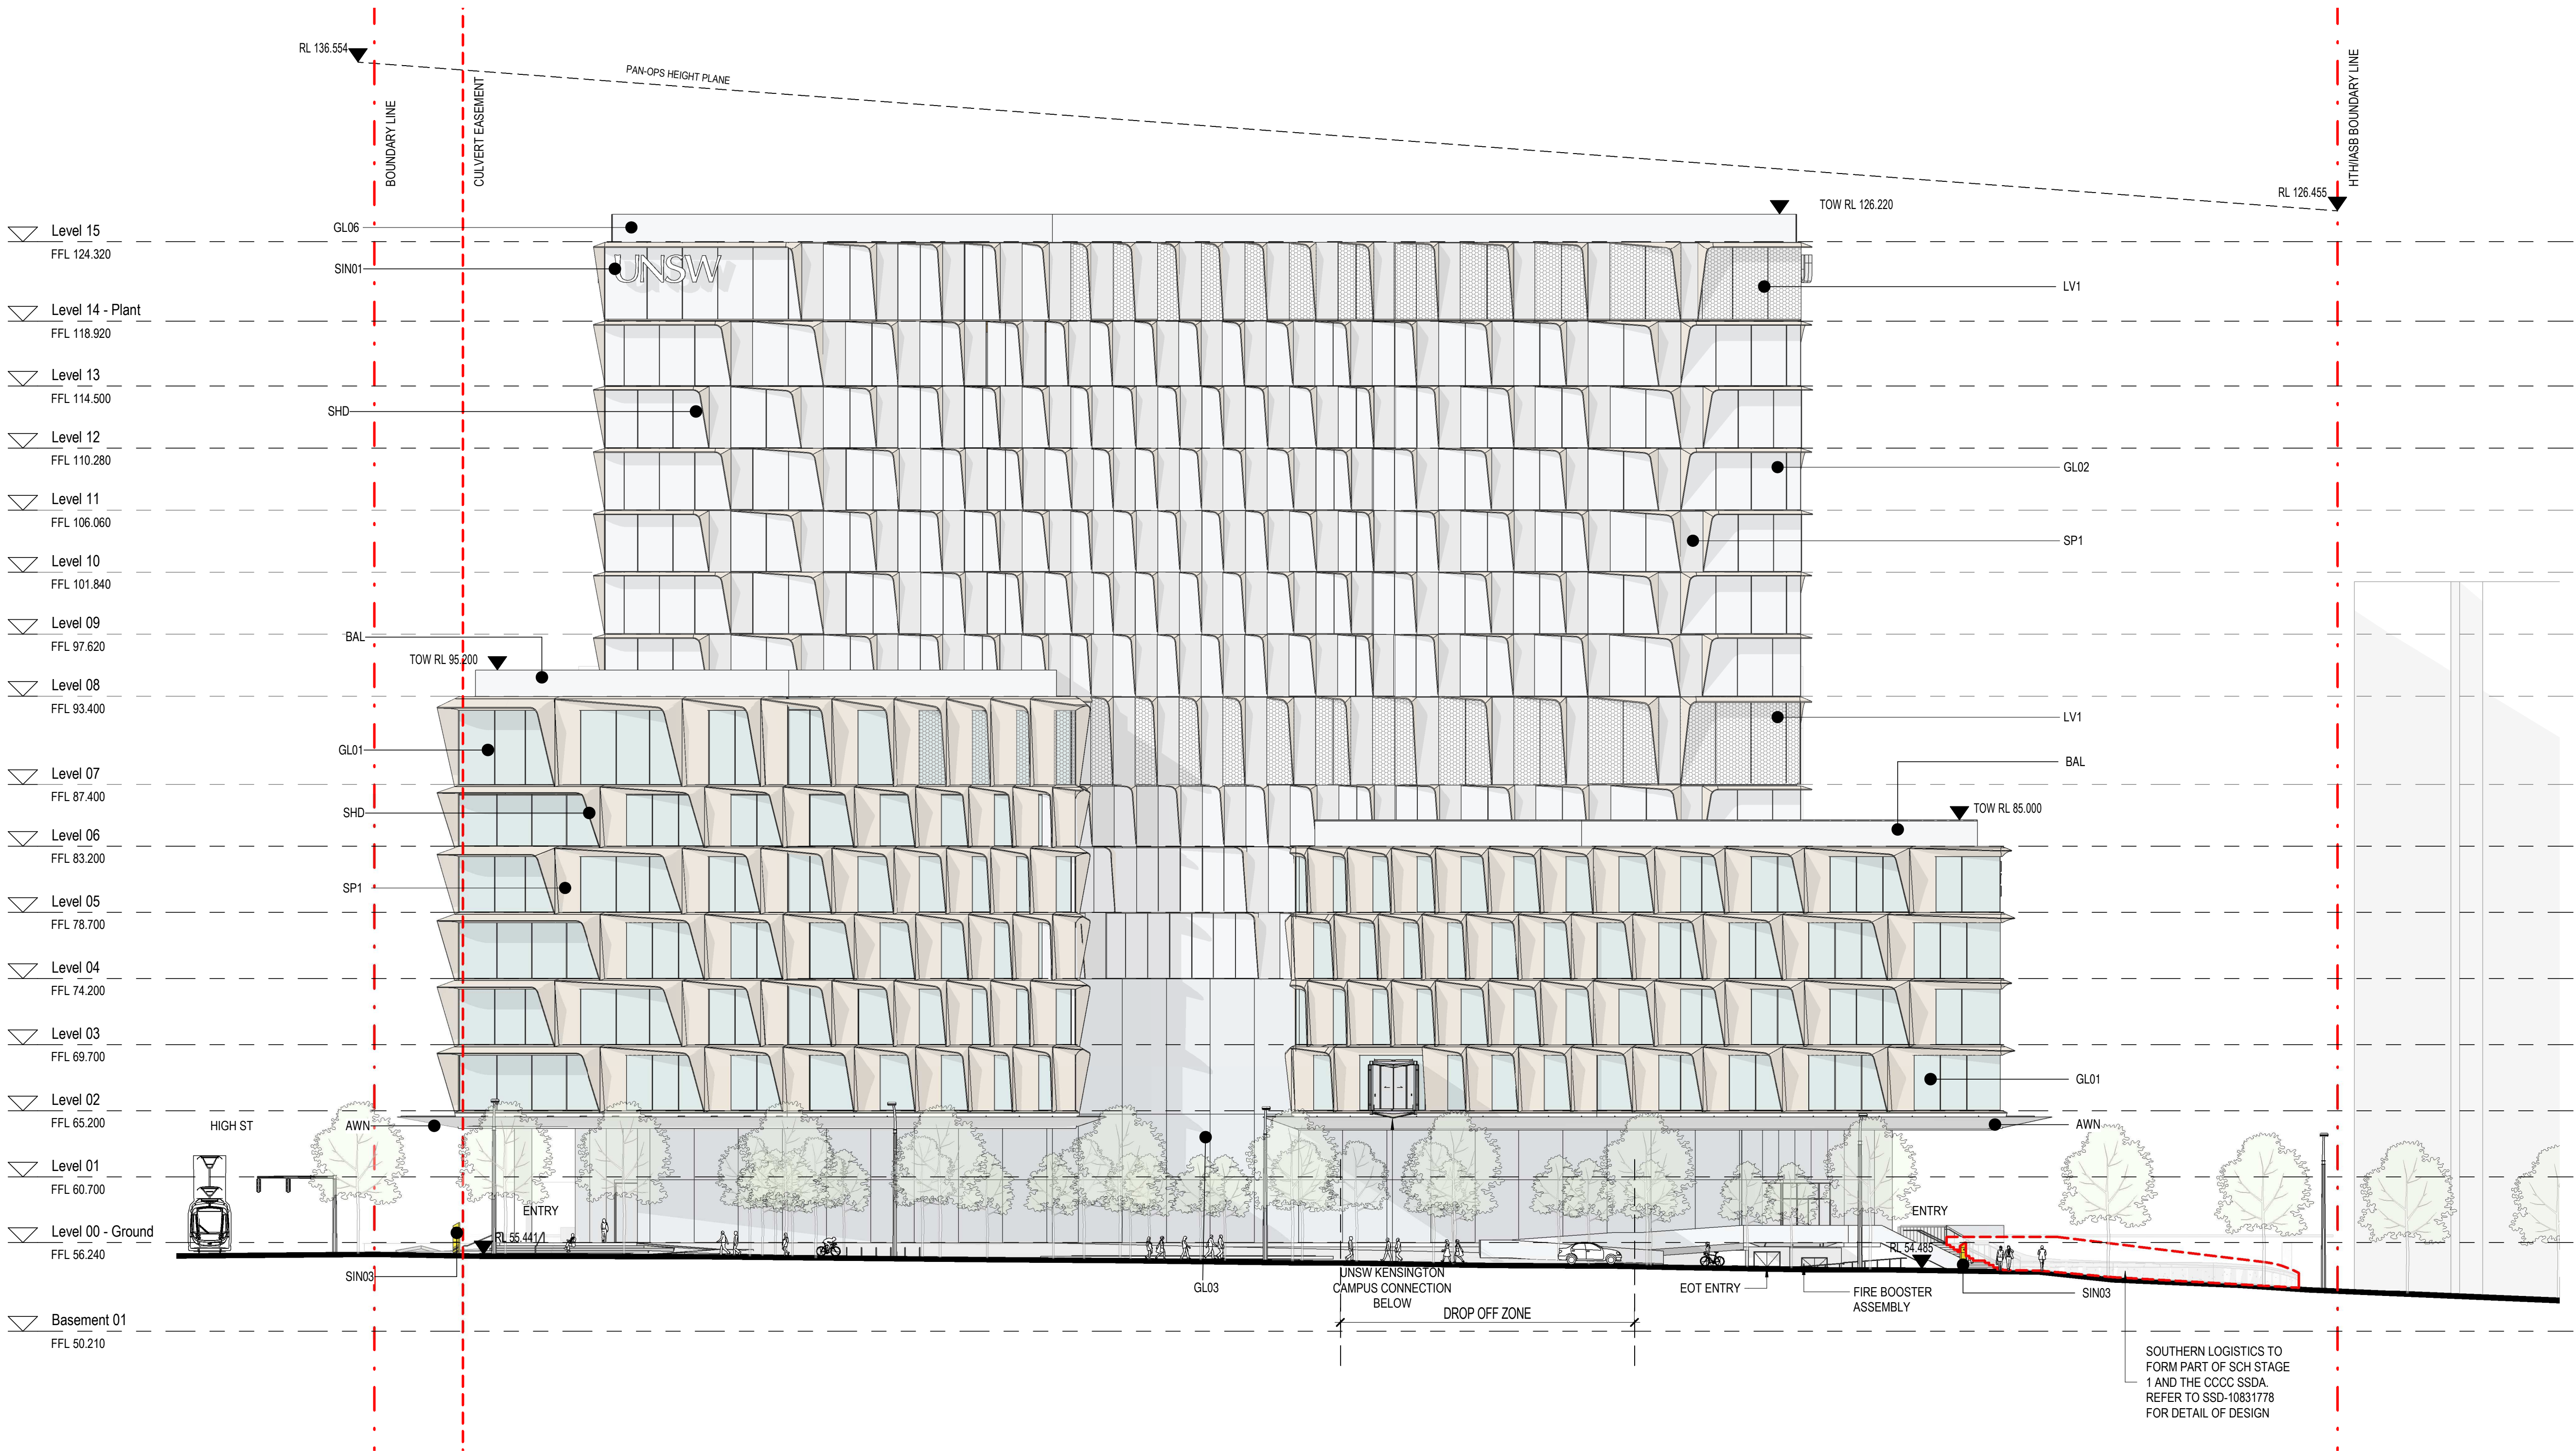

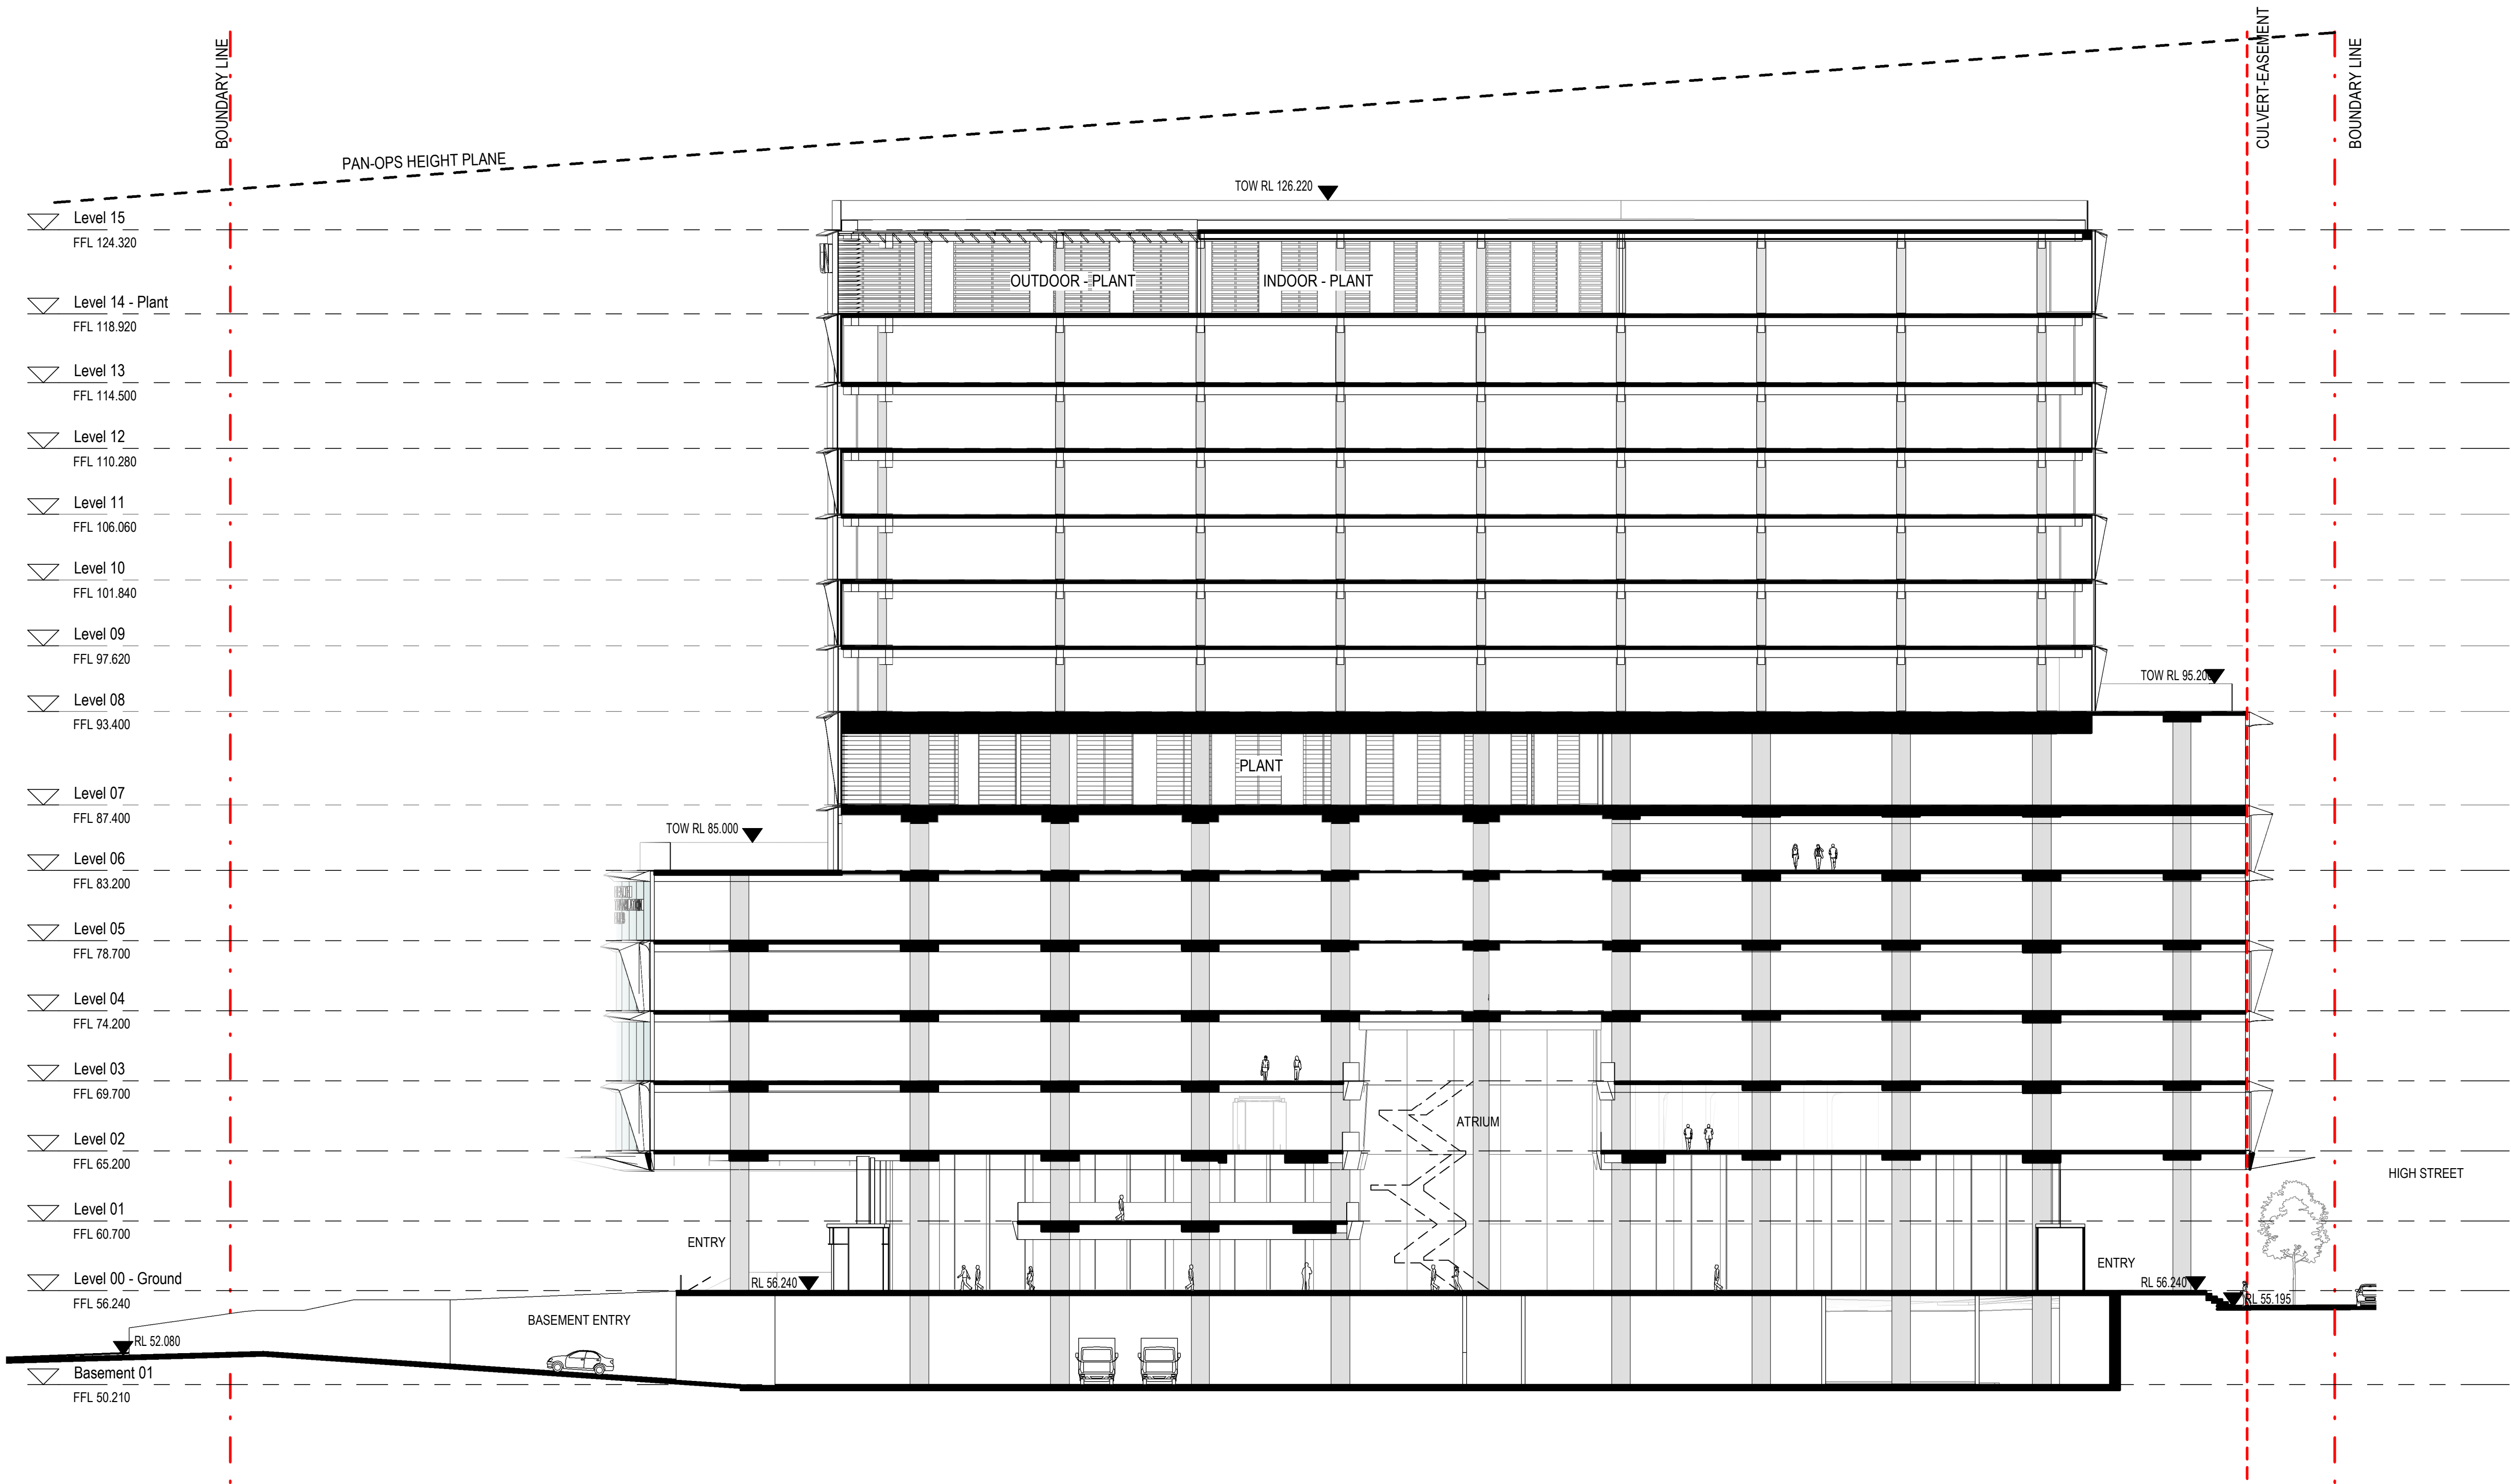

architectus

Architectus Australia Pty Ltd is the owner of the copyright subsisting in these drawings, plans, designs and specifications. They must not be used, reproduced or copied, in whole or in part, nor may the information, ideas and concepts therein contained (which are confidential to Architectus Australia Pty Ltd) be disclosed to any person without the prior written consent of that company.


Nominated Architect
Ray Brown, NSWARB 6359

Do not scale drawings. Verify all dimensions on site

issue	amendment	date
A	ISSUED FOR STATE SIGNIFICANT DEVELOPMENT APPLICATION	18.02.21

GENERAL NOTES:

- DO NOT SCALE FROM THE DRAWINGS. USE ONLY FIGURED DIMENSIONS.
- ALL DIMENSIONS ARE IN MILLIMETRES UNLESS OTHERWISE STATED.
- REDUCED LEVELS (RL) ARE TO AUSTRALIAN HEIGHT DATUM (AHD).
- COORDINATES ARE TO MAP GRID AUSTRALIA (MGA).
- THE ARCHITECTURAL DOCUMENTATION IS ONLY ALLOWED TO BE USED FOR THE PURPOSE FOR WHICH IT WAS COMMISSIONED. UNAUTHORISED USE OF THE DOCUMENTATION IS PROHIBITED.

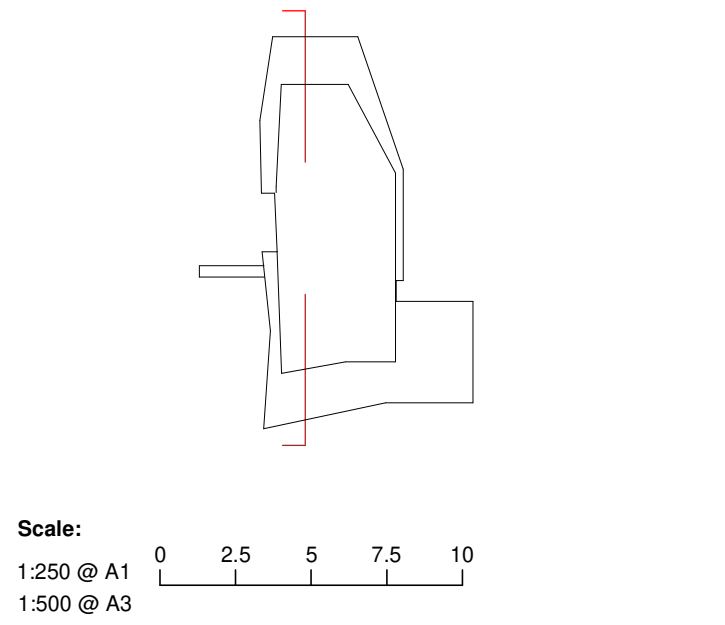

architectus™



UNSW
SYDNEY

ABN 90 131 245 684

project

UNSW Health Translation Hub

drawing

Section A	
scale	1 : 250@A1
drawn	TH
checked	JC
project no	190551.00
drawing no.	DA2101
issue	A


Nominated Architect
Ray Brown, NSWARB 6359

Do not scale drawings. Verify all dimensions on site

[illegible]

GENERAL NOTES:

- DO NOT SCALE FROM THE DRAWINGS. USE ONLY FIGURED DIMENSIONS.
ALL DIMENSIONS ARE IN MILLIMETRES UNLESS OTHERWISE STATED.
REDUCED LEVELS (RL) ARE TO AUSTRALIAN HEIGHT DATUM (AHD).
COORDINATES ARE TO MAP GRID AUSTRALIA (MGA).
THE ARCHITECTURAL DOCUMENTATION IS ONLY ALLOWED TO BE USED
FOR THE PURPOSE FOR WHICH IT WAS COMMISSIONED. UNAUTHORISED
USE OF THE DOCUMENTATION IS PROHIBITED.

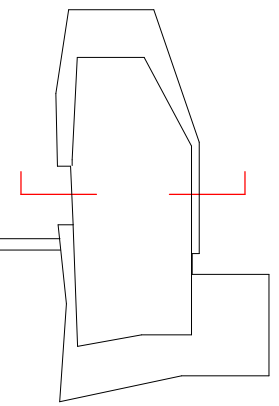

Scale:

0 2.5 5 7.5 10

1:250 @ A1

1:500 @ A3

architectus™



ABN 90 131 245 684


project

UNSW Health Translation Hub

rawing

Section B

scale	1 : 250@A1	drawing no.
drawn	TH	DA2102
checked	JC	issue
project no	190551.00	A

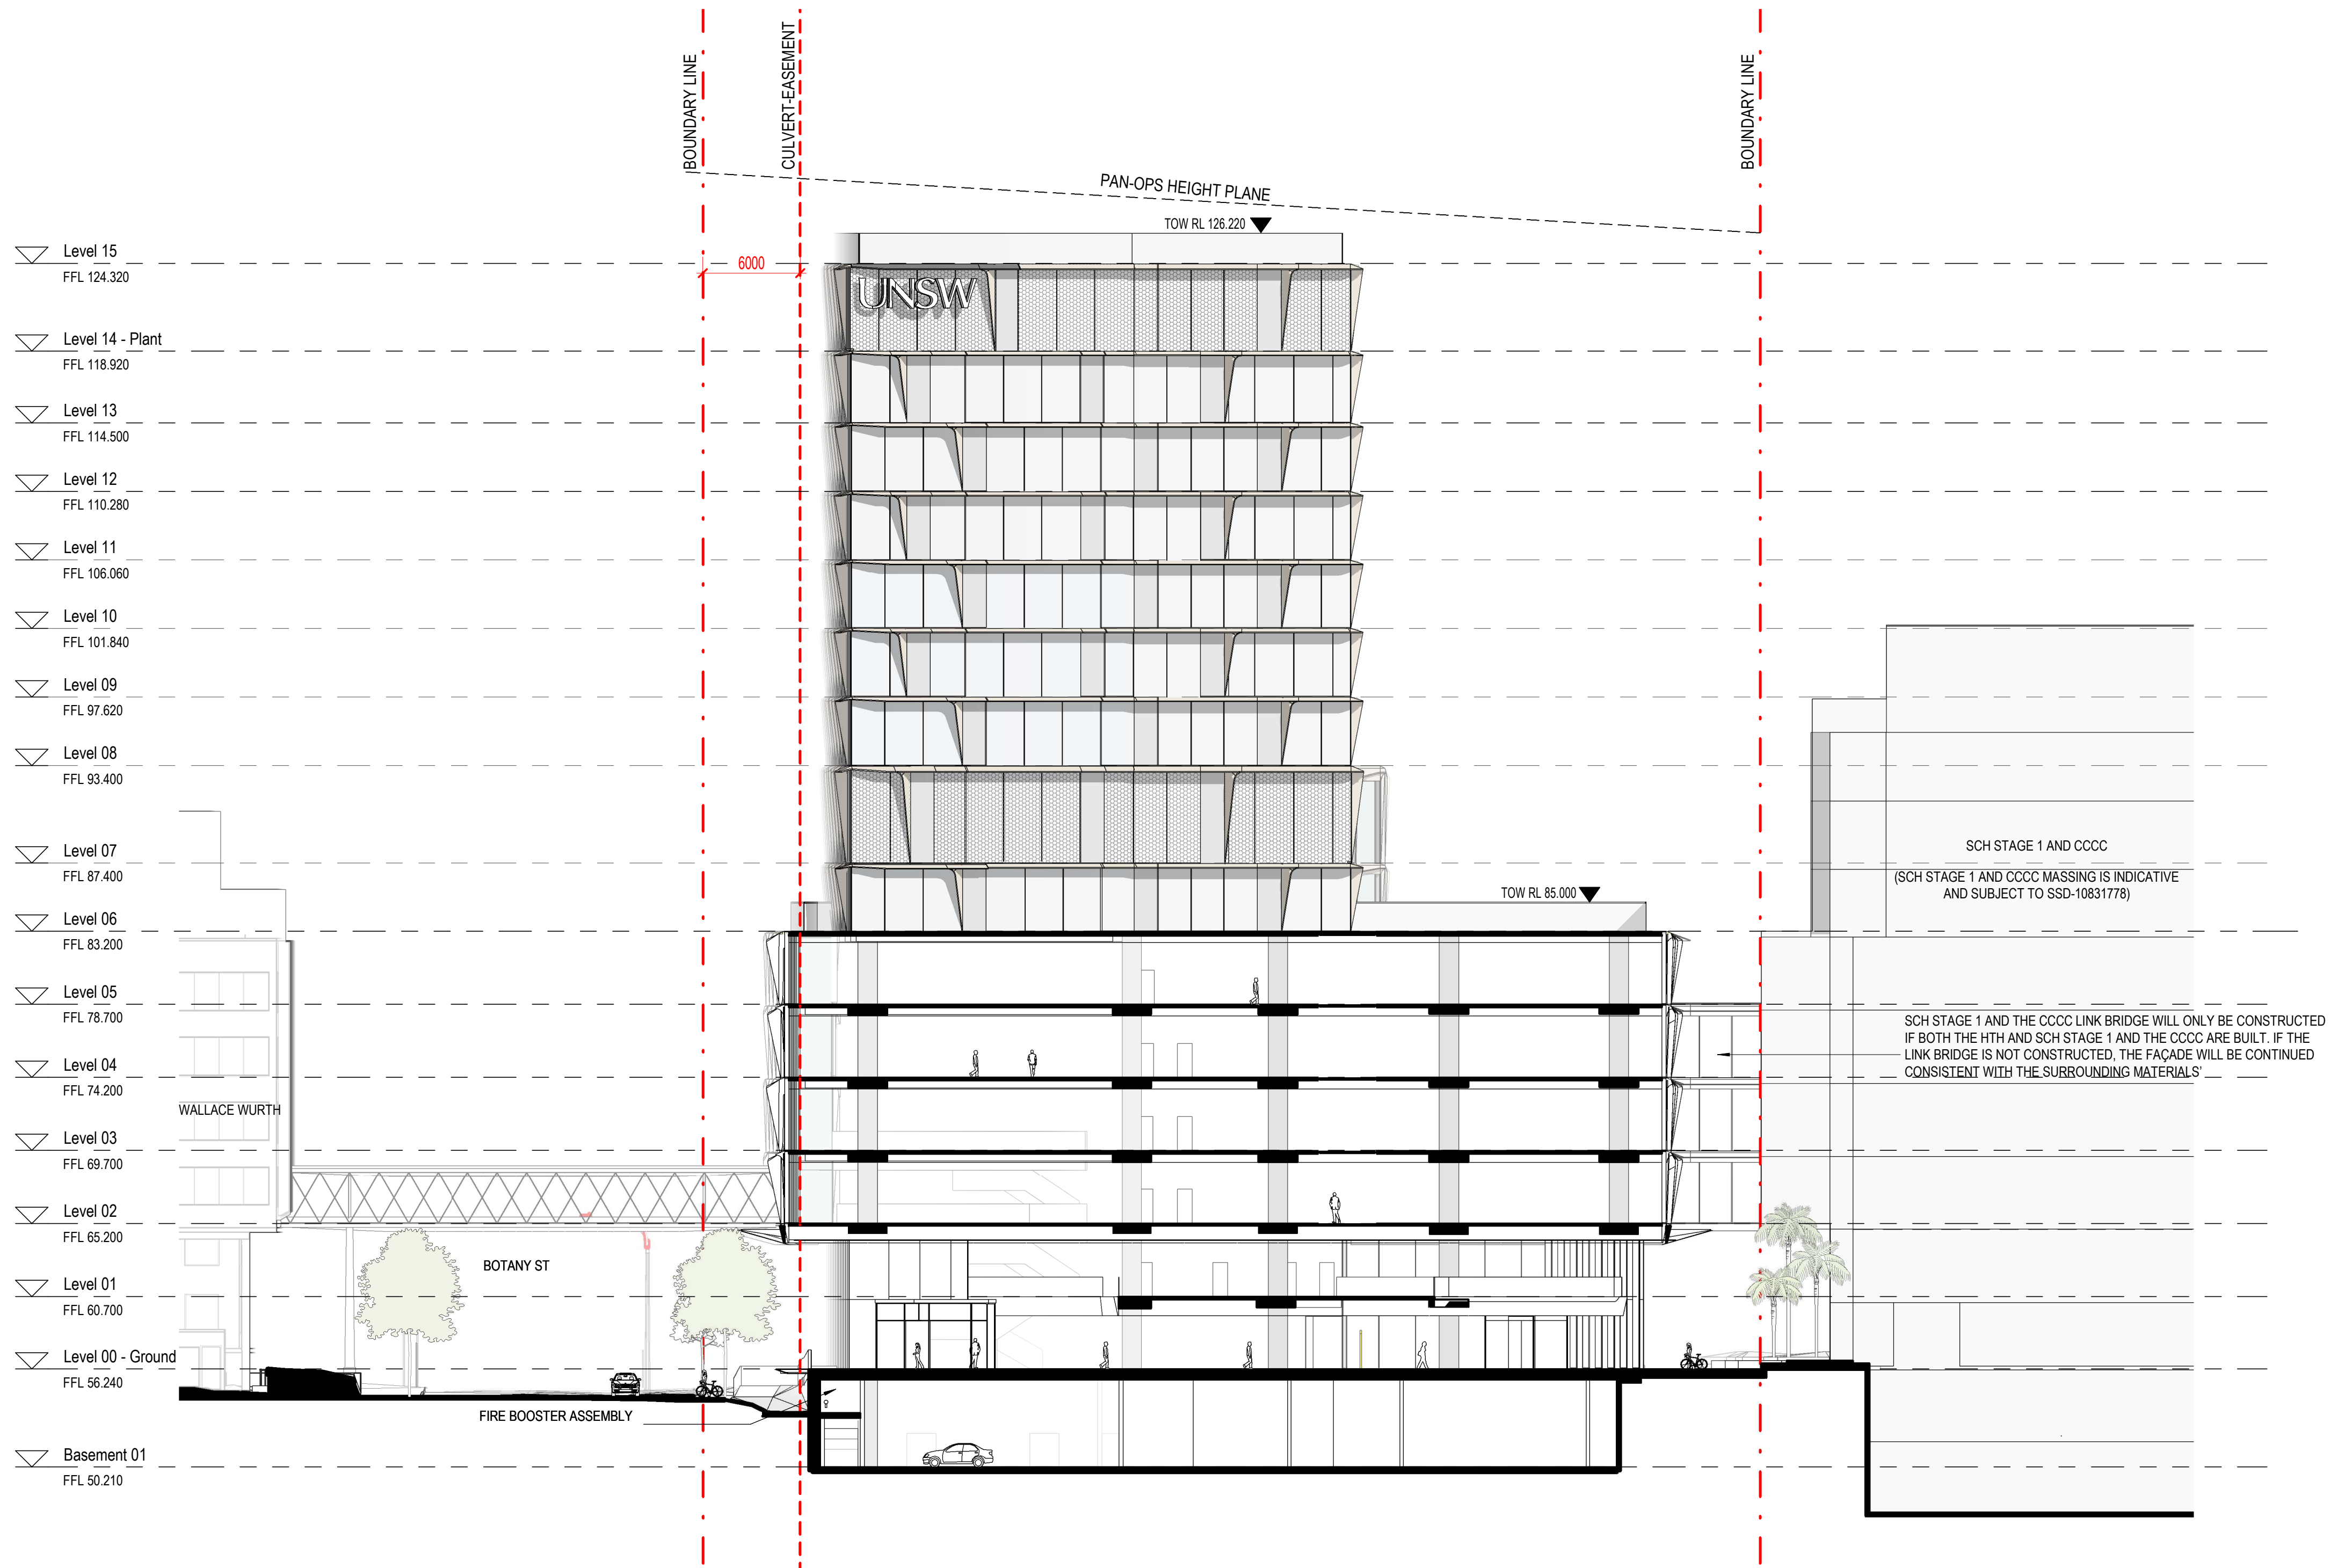

architectus


Architectus Australia Pty Ltd is the owner of the copyright subsisting in these drawings, plans, designs and specifications. They must not be used, reproduced or copied, in whole or in part, nor may the information, ideas and concepts therein contained (which are confidential to Architectus Australia Pty Ltd) be disclosed to any person without the prior written consent of that company.

Nominated Architect
Ray Brown, NSWARB 6359


Do not scale drawings. Verify all dimensions on site

issue	amendment	date
A	ISSUED FOR STATE SIGNIFICANT DEVELOPMENT APPLICATION	18.02.21

- GENERAL NOTES:
- DO NOT SCALE FROM THE DRAWINGS. USE ONLY FIGURED DIMENSIONS.
 - ALL DIMENSIONS ARE IN MILLIMETRES UNLESS OTHERWISE STATED.
 - REDUCED LEVELS (RL) ARE TO AUSTRALIAN HEIGHT DATUM (AHD).
 - COORDINATES ARE TO MAP GRID AUSTRALIA (MGA).
 - THE ARCHITECTURAL DOCUMENTATION IS ONLY ALLOWED TO BE USED FOR THE PURPOSE FOR WHICH IT WAS COMMISSIONED. UNAUTHORISED USE OF THE DOCUMENTATION IS PROHIBITED.

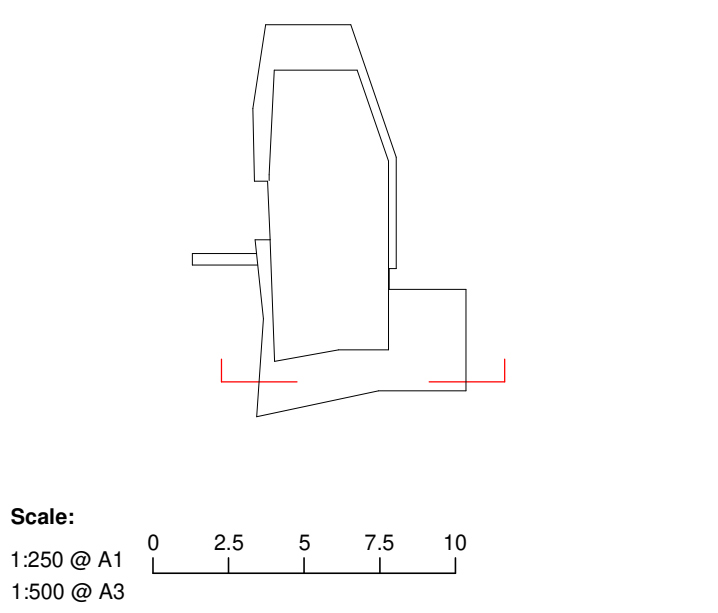

architectus™



ABN 90 131 245 684

project

UNSW Health Translation Hub

drawing

Section C


scale	1 : 250@A1	drawing no.
drawn	TH	DA2103
checked	JC	issue
project no	190551.00	A

issue	amendment	date
A	ISSUED FOR STATE SIGNIFICANT DEVELOPMENT APPLICATION	18.02.21


GENERAL NOTES:

- DO NOT SCALE FROM THE DRAWINGS. USE ONLY FIGURED DIMENSIONS.
- ALL DIMENSIONS ARE IN MILLIMETRES UNLESS OTHERWISE STATED.
- REDUCED LEVELS (RL) ARE TO AUSTRALIAN HEIGHT DATUM (AHD).
- COORDINATES ARE TO MAP GRID AUSTRALIA (MGA).
- THE ARCHITECTURAL DOCUMENTATION IS ONLY ALLOWED TO BE USED FOR THE PURPOSE FOR WHICH IT WAS COMMISSIONED. UNAUTHORISED USE OF THE DOCUMENTATION IS PROHIBITED.


KEY	
	BRIDGE OUTLINE
	DEMOLITION/TRIMMING
	SERVICES RISERS TO BE MAINTAINED
	PROPOSED NEW WORK WITHIN WALLACE WURTH BUILDING

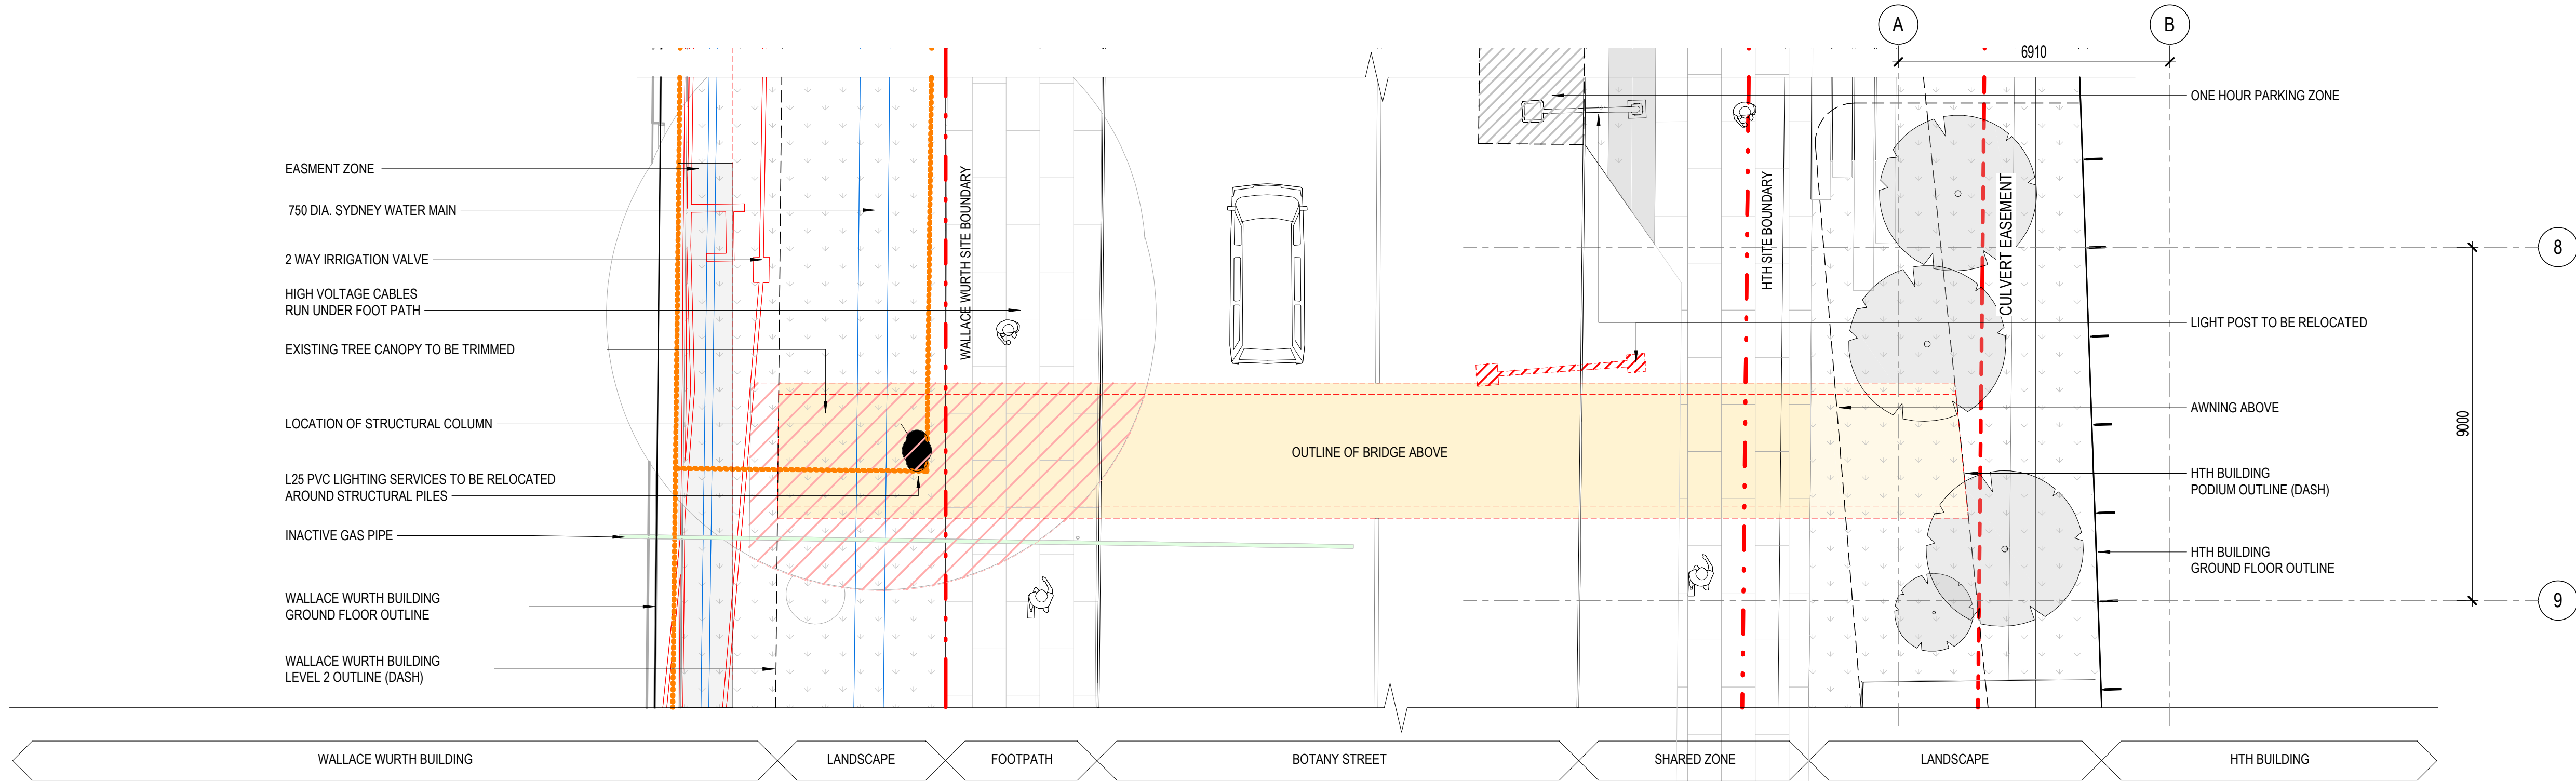


1
DA1001
UNSW Campus Connection_Ground Floor Plan
SCALE: 1 : 100

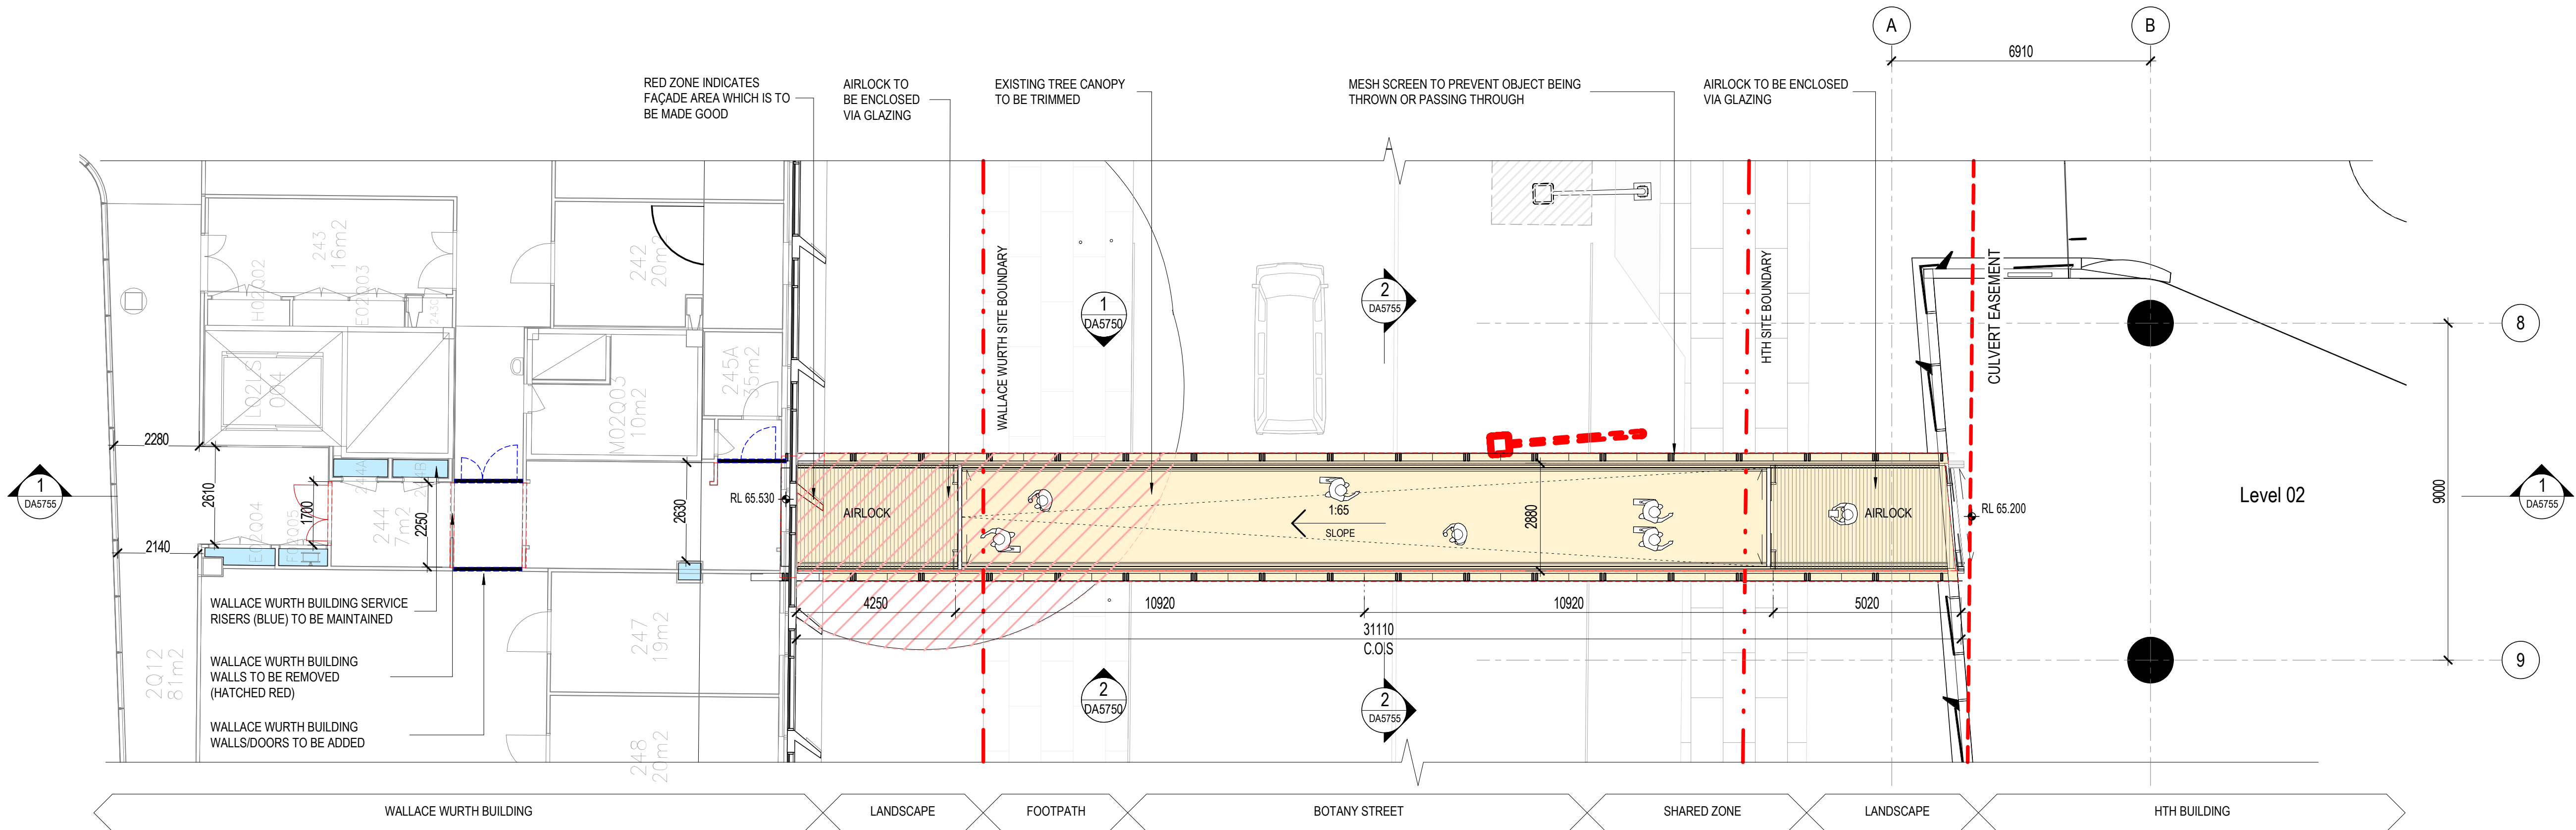


2
DA1003
UNSW Campus Connection_Level 2 Floor Plan
SCALE: 1 : 100

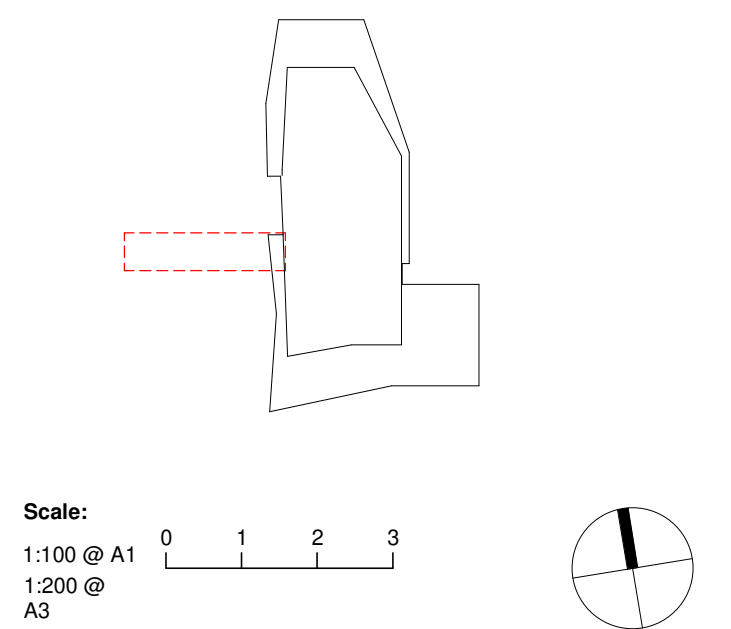

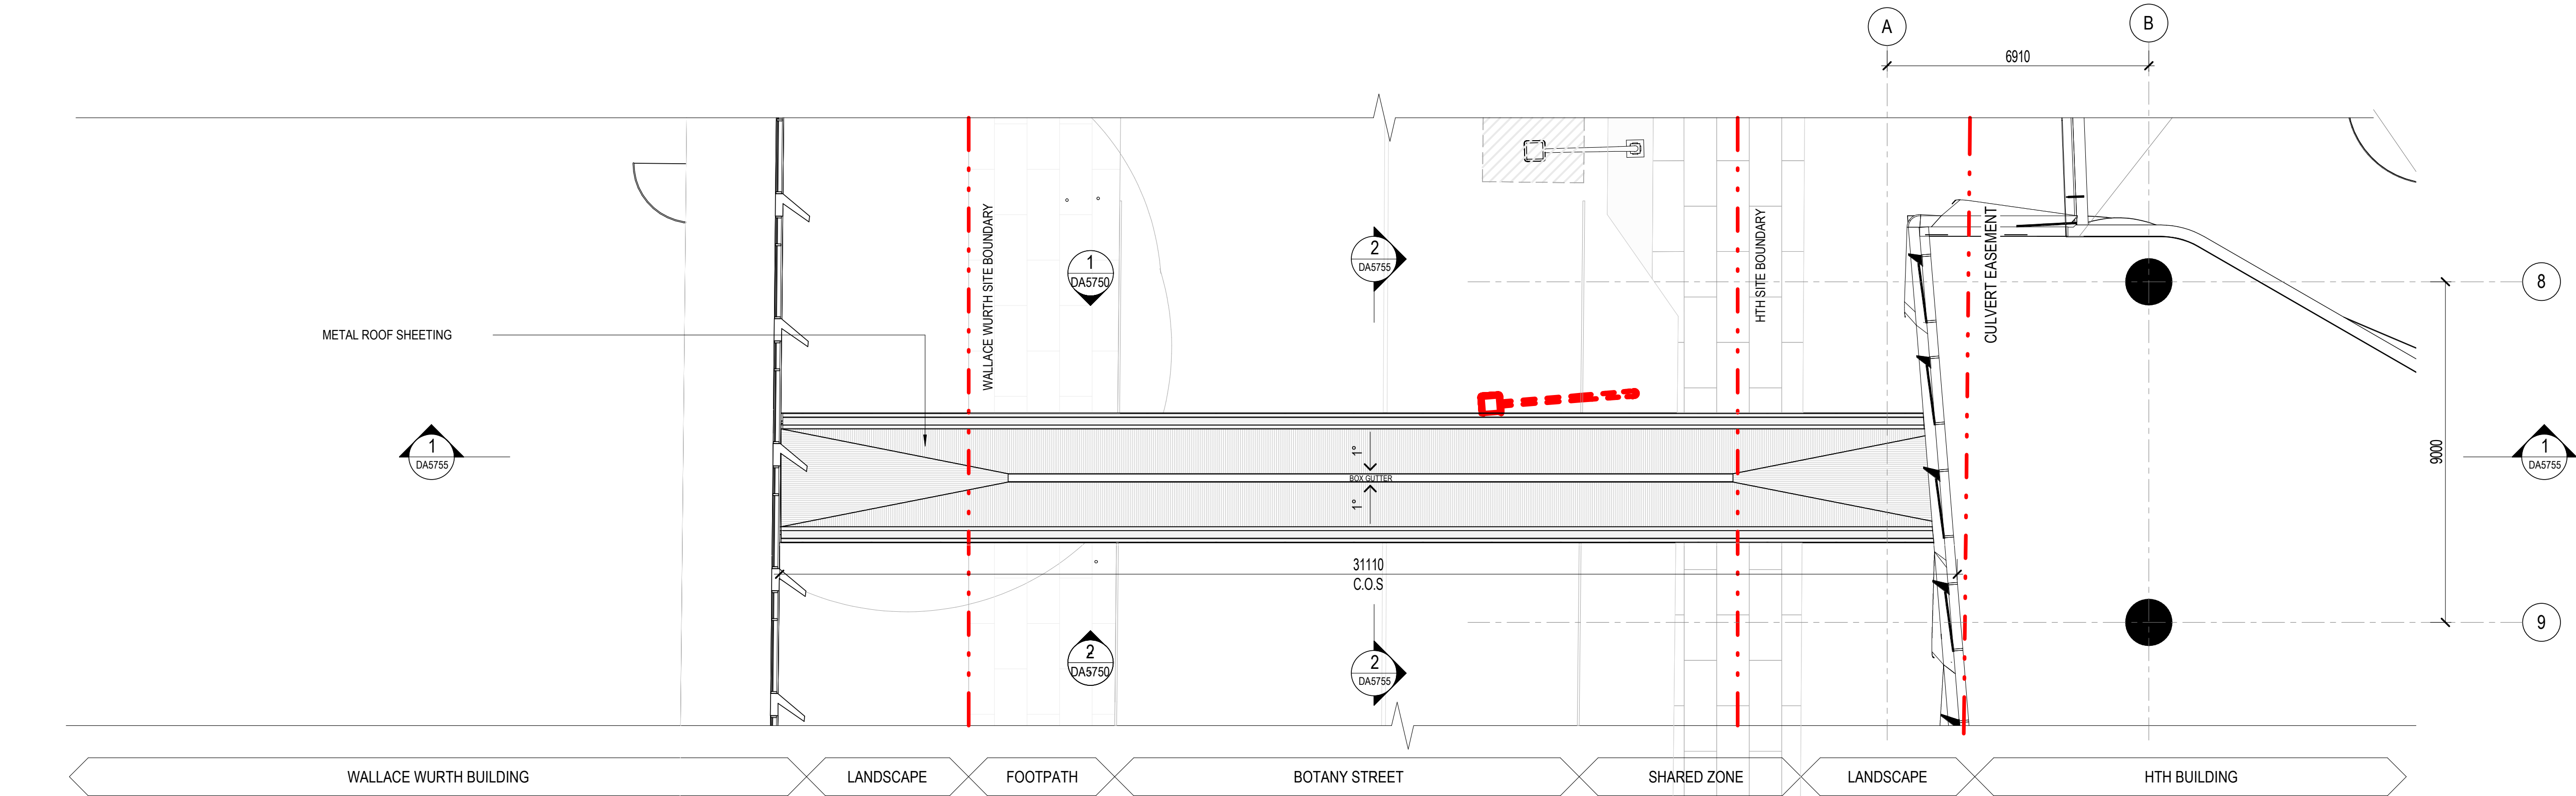

1 UNSW Campus Connection_Roof Plan
DA1004 SCALE: 1 : 100

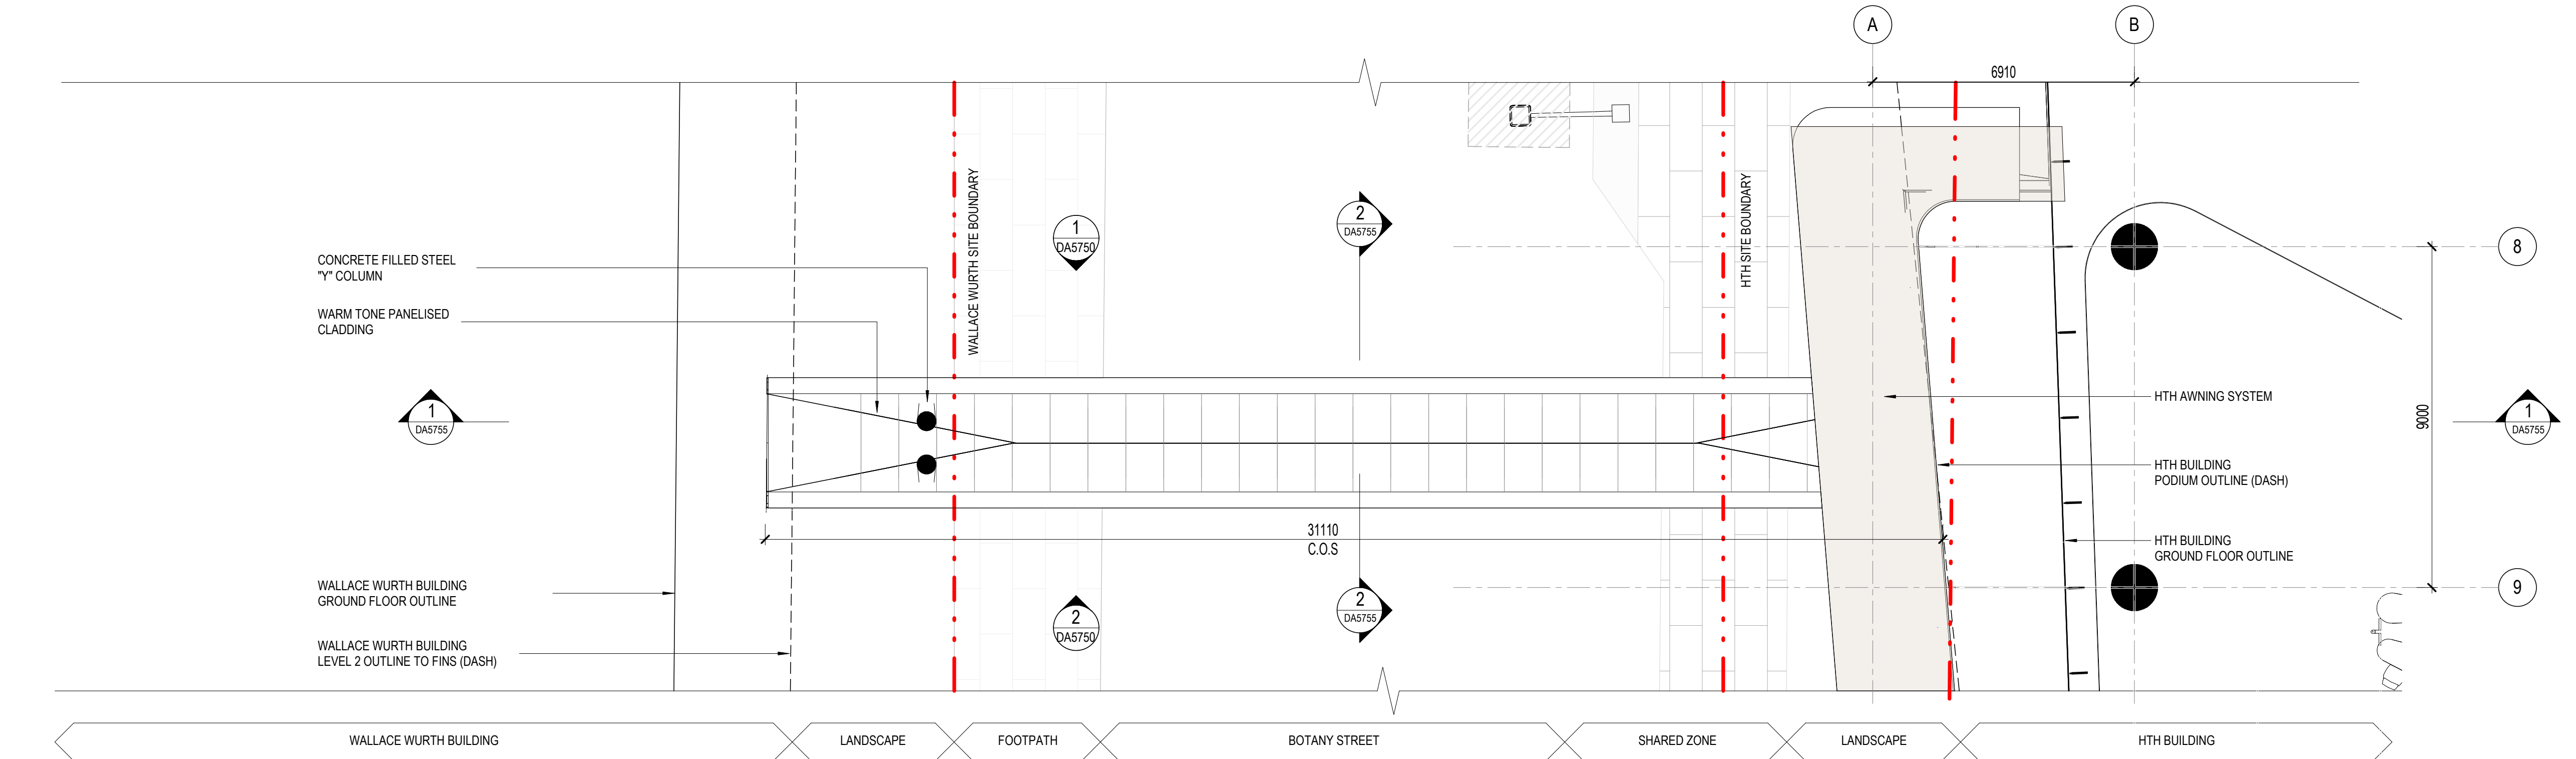

2 WW Bridge Link_Soffit
DA1003 SCALE: 1 : 100

architectus™

Architectus Australia Pty Ltd is the owner of the copyright subsisting in these drawings, plans, designs and specifications. They must not be used, reproduced or copied, in whole or in part, nor may the information, ideas and concepts therein contained (which are confidential to Architectus Australia Pty Ltd) be disclosed to any person without the prior written consent of that company.

Nominated Architect
Ray Brown, NSWARB 6359

Do not scale drawings. Verify all dimensions on site

issue	amendment	date
A	ISSUED FOR STATE SIGNIFICANT DEVELOPMENT APPLICATION	18.02.21

GENERAL NOTES:

- DO NOT SCALE FROM THE DRAWINGS. USE ONLY FIGURED DIMENSIONS.
- ALL DIMENSIONS ARE IN MILLIMETRES UNLESS OTHERWISE STATED.
- REDUCED LEVELS (RL) ARE TO AUSTRALIAN HEIGHT DATUM (AHD).
- COORDINATES ARE TO MAP GRID AUSTRALIA (MGA).
- THE ARCHITECTURAL DOCUMENTATION IS ONLY ALLOWED TO BE USED FOR THE PURPOSE FOR WHICH IT WAS COMMISSIONED. UNAUTHORISED USE OF THE DOCUMENTATION IS PROHIBITED.

KEY

- BRIDGE OUTLINE
- DEMOLITION/TRIMMING
- SERVICES RISERS TO BE MAINTAINED
- PROPOSED NEW WORK WITHIN WALLACE WURTH BUILDING

Scale:

1:100 @ A1
1:200 @ A3

0 1 2 3

architectus™

UNSW SYDNEY

ABN 90 131 245 684

project

UNSW Health Translation Hub

drawing

UNSW Campus Connection - Roof + Soffit Plan

scale 1 : 100@A1 drawing no. DA5701

drawn HD


checked JC issue

project no 190551.00


18/02/2021 12:08:00 PM

issue	amendment	date
A	ISSUED FOR STATE SIGNIFICANT DEVELOPMENT APPLICATION	18.02.21


- GENERAL NOTES:
- DO NOT SCALE FROM THE DRAWINGS. USE ONLY FIGURED DIMENSIONS.
 - ALL DIMENSIONS ARE IN MILLIMETRES UNLESS OTHERWISE STATED.
 - REDUCED LEVELS (RL) ARE TO AUSTRALIAN HEIGHT DATUM (AHD).
 - COORDINATES ARE TO MAP GRID AUSTRALIA (MGA).
 - THE ARCHITECTURAL DOCUMENTATION IS ONLY ALLOWED TO BE USED FOR THE PURPOSE FOR WHICH IT WAS COMMISSIONED. UNAUTHORISED USE OF THE DOCUMENTATION IS PROHIBITED.

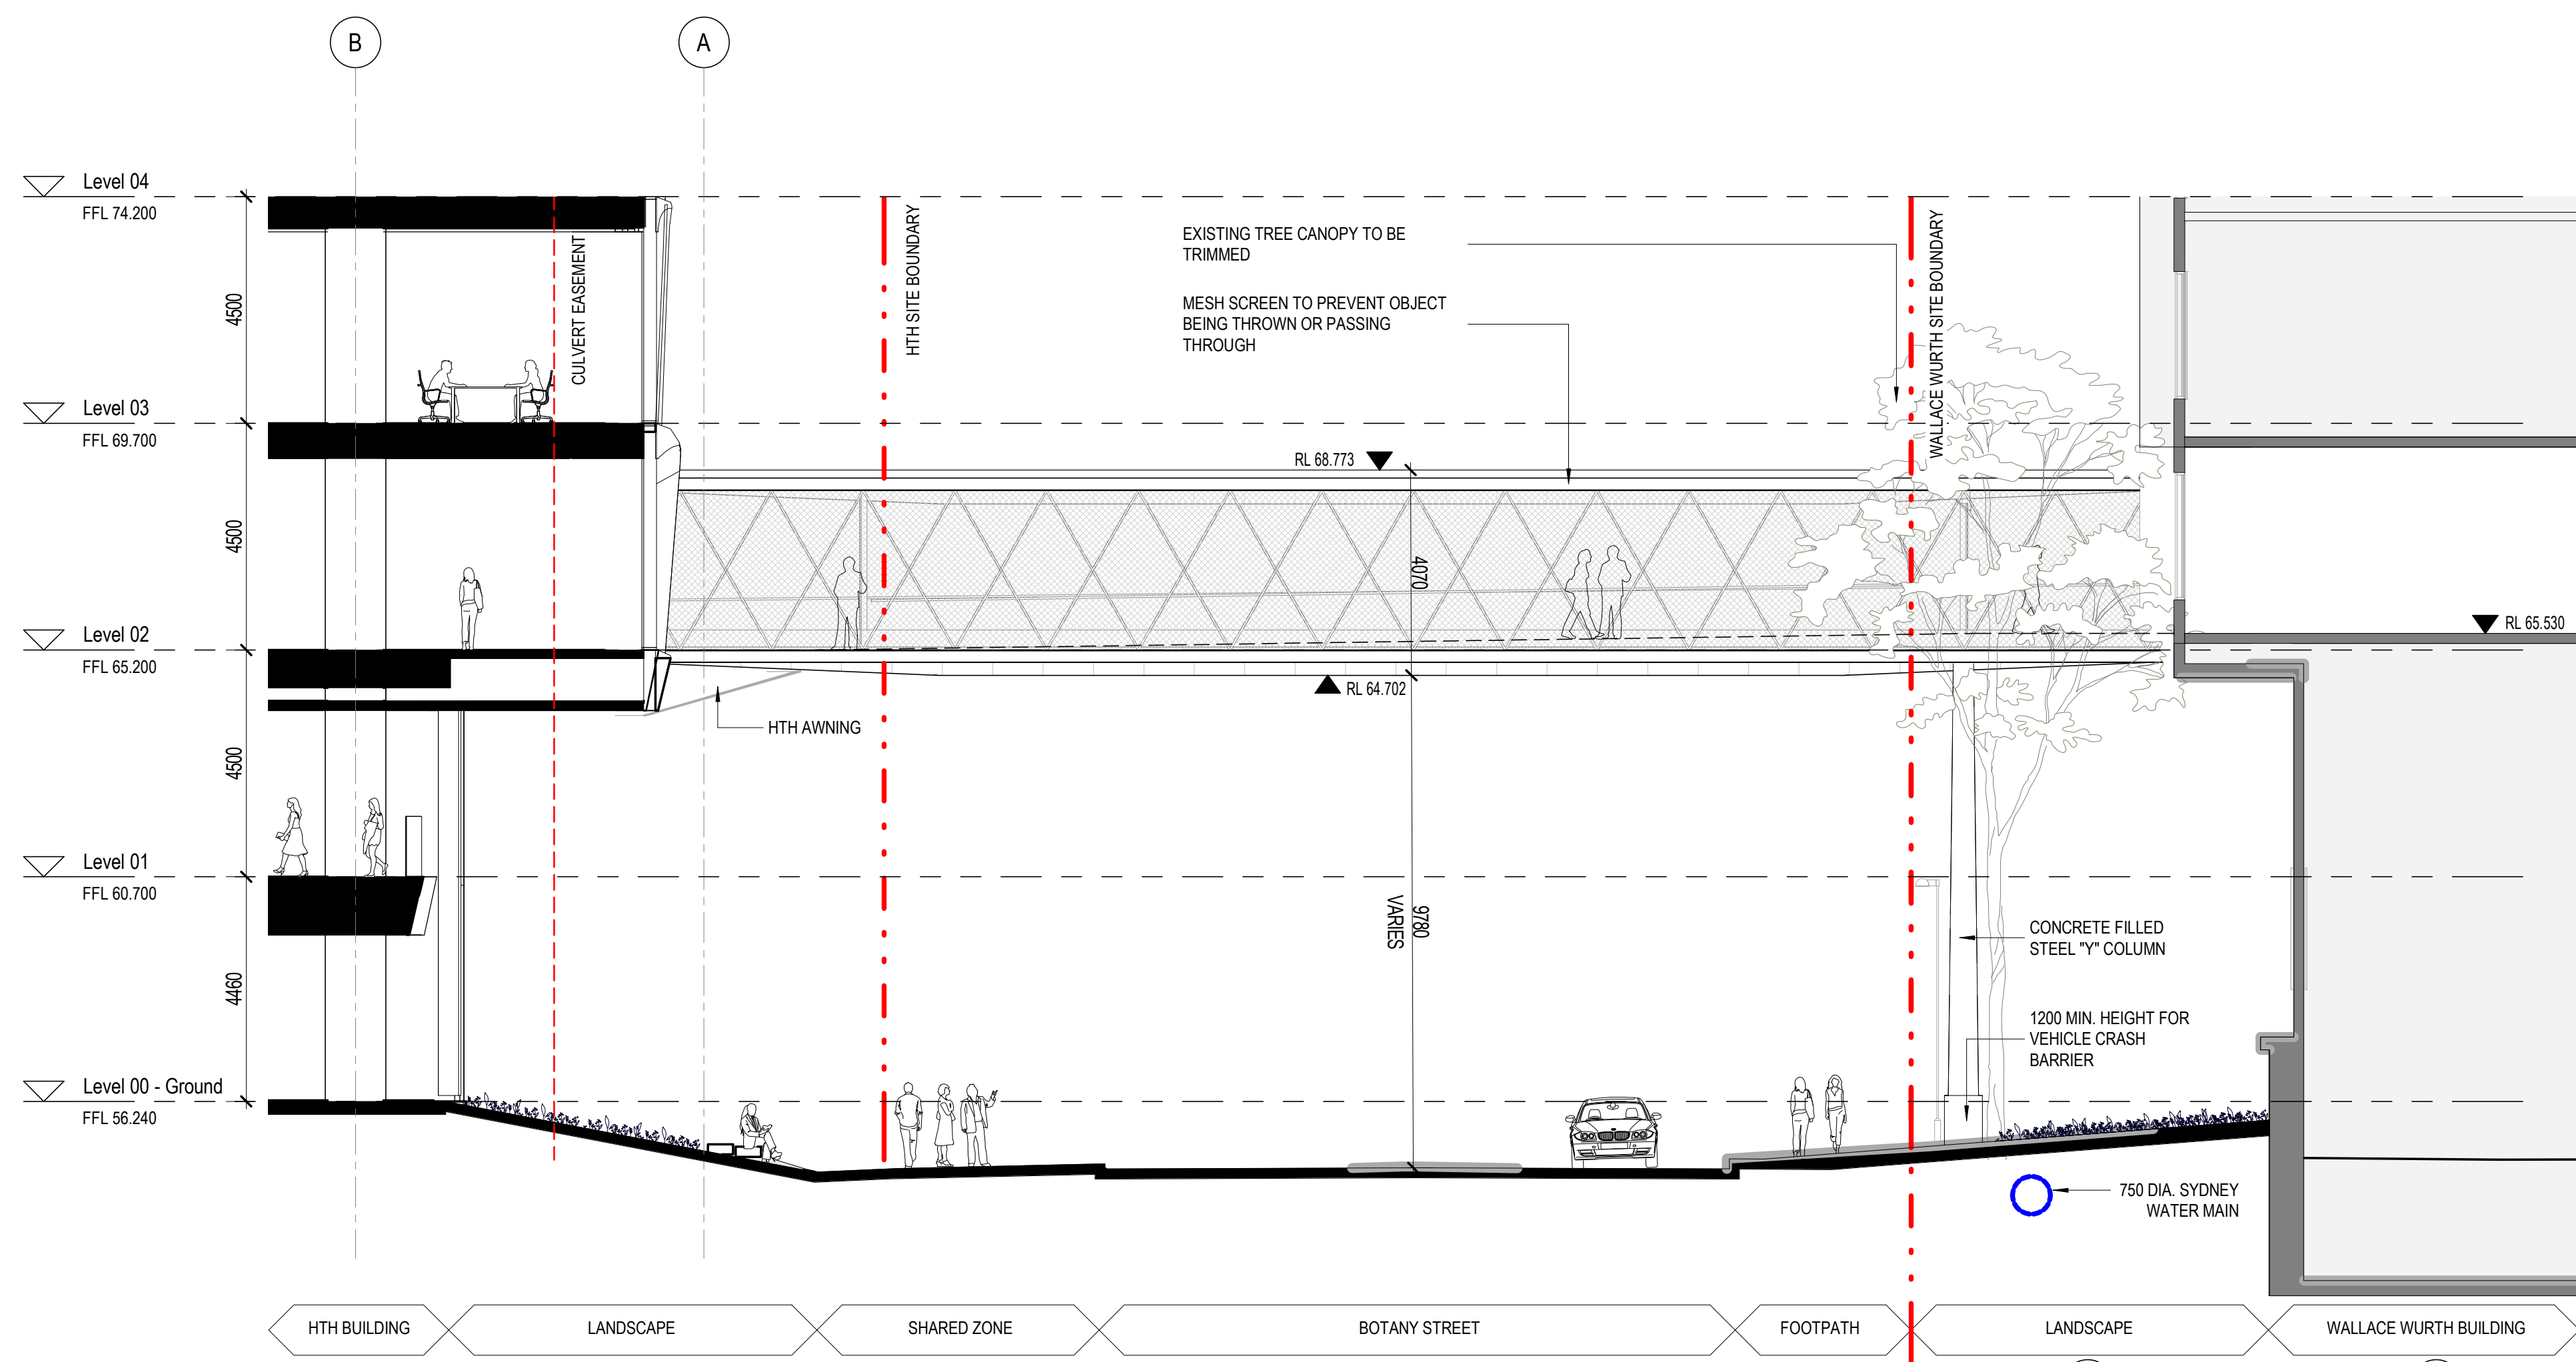

1
DA2001
UNSW Campus Connection_Elevation North
SCALE: 1 : 100

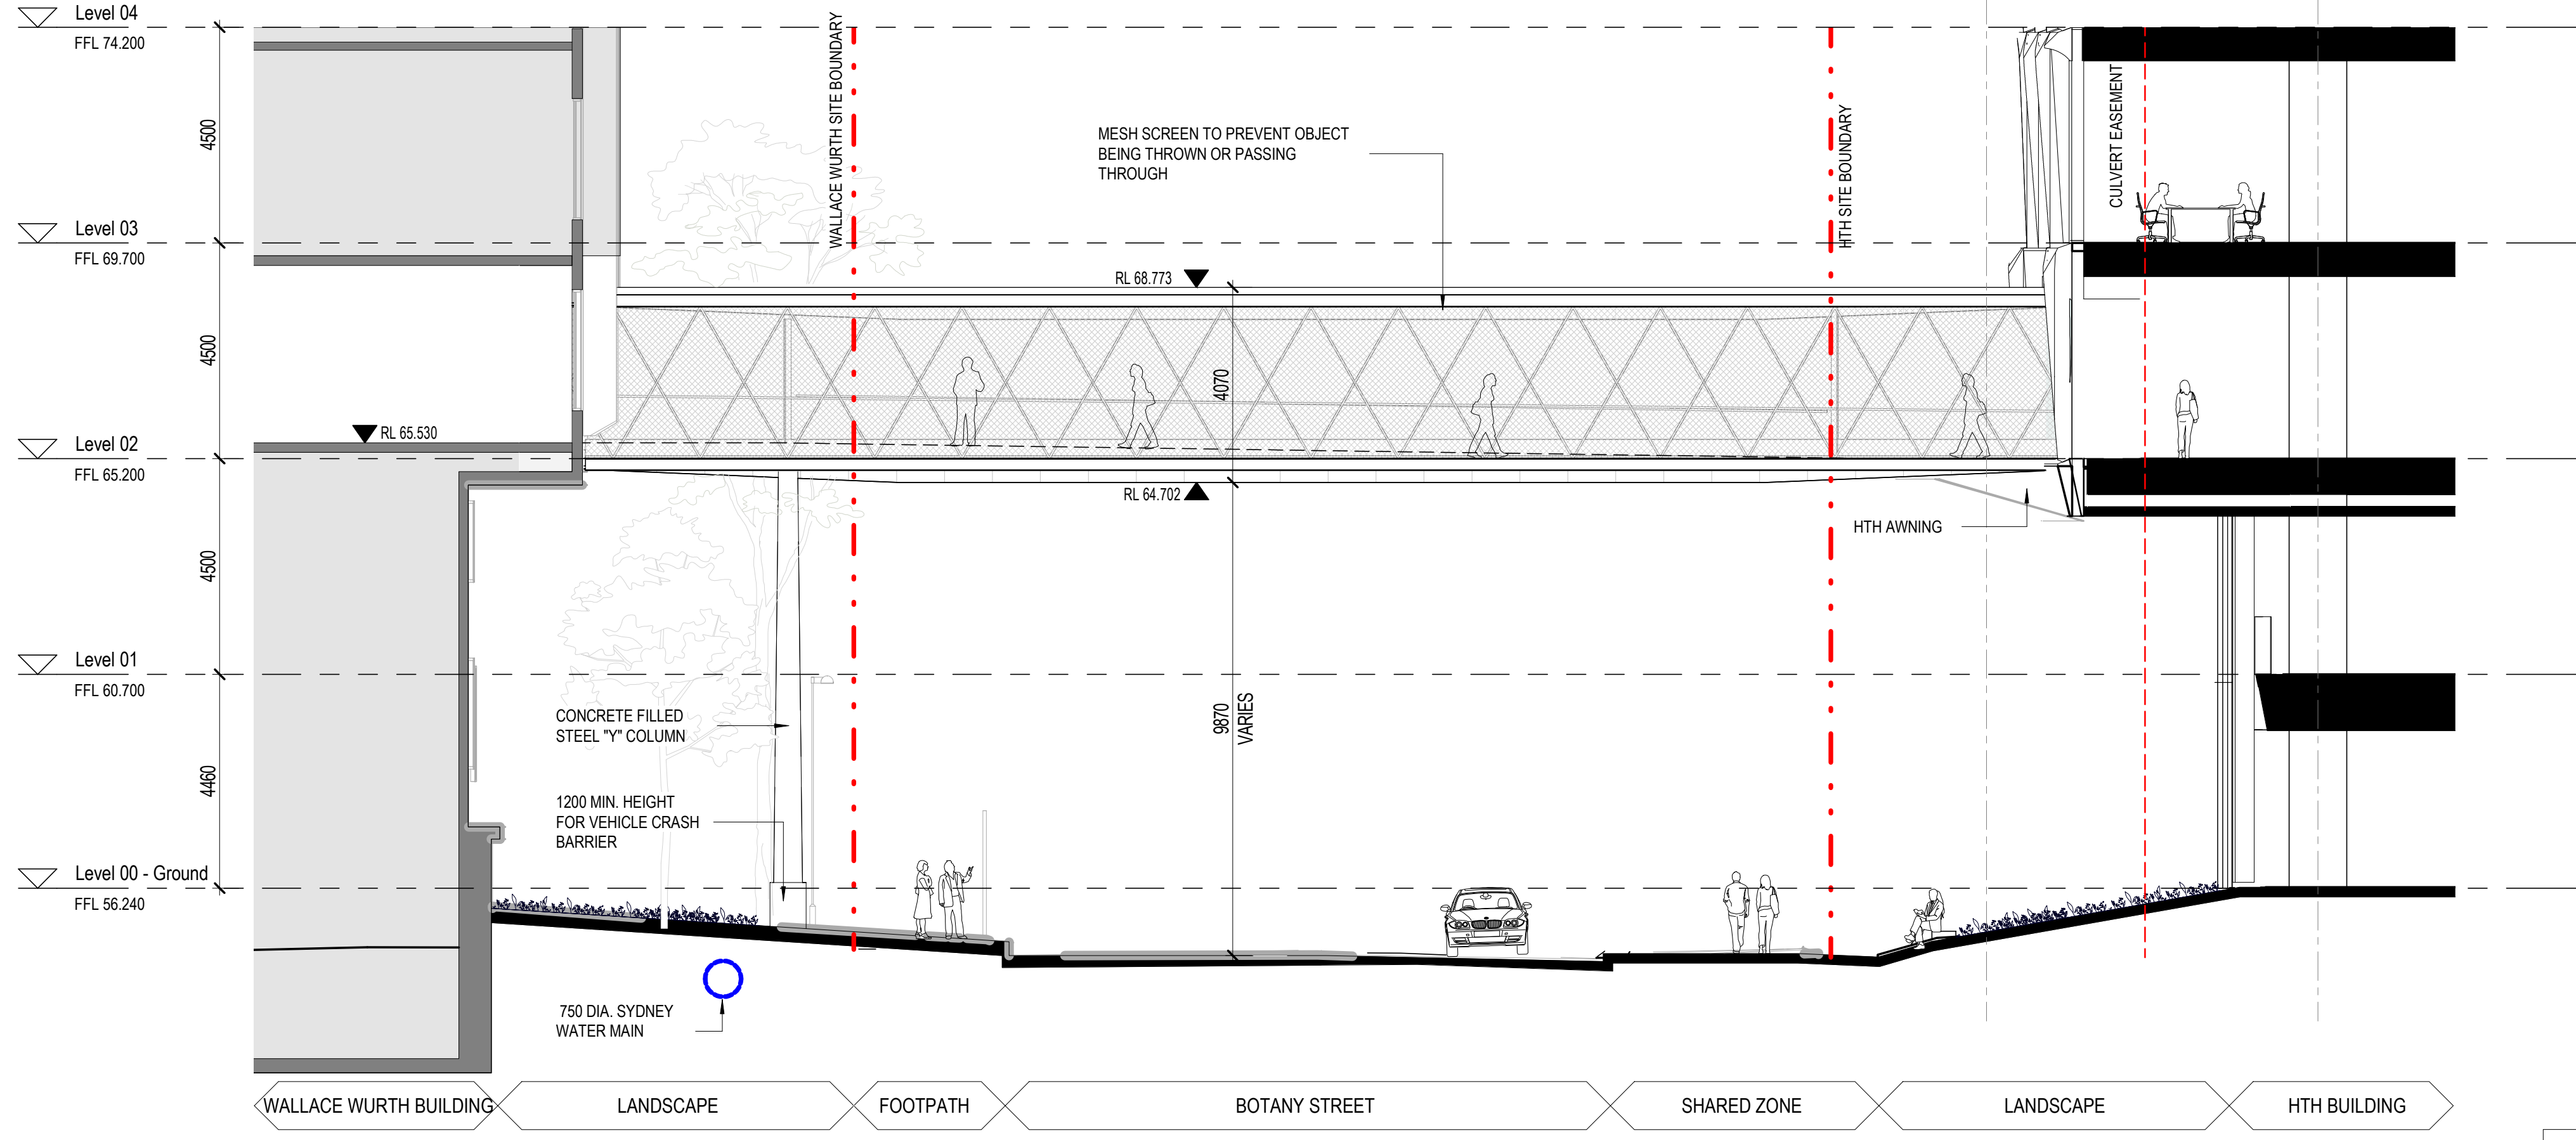

2
DA2002
UNSW Campus Connection_Elevation South
SCALE: 1 : 100

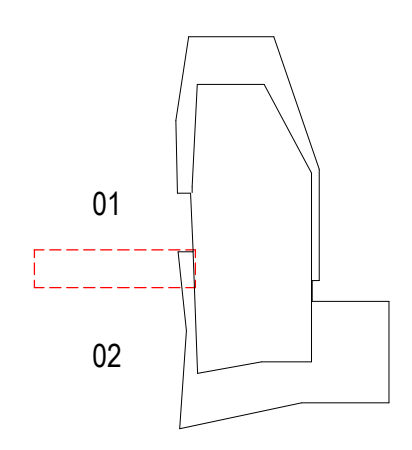

Scale:
1:100 @ A1
1:200 @ A3



ALL SERVICES LOCATION SHOWN
INDICATIVE - TO BE CONFIRMED ONSITE

Nominated Architect
Ray Brown, NSWARB 6359

Do not scale drawings. Verify all dimensions on site

issue	amendment	date
A	ISSUED FOR STATE SIGNIFICANT DEVELOPMENT APPLICATION	18.02.21

- GENERAL NOTES:
- DO NOT SCALE FROM THE DRAWINGS. USE ONLY FIGURED DIMENSIONS. ALL DIMENSIONS ARE IN MILLIMETRES UNLESS OTHERWISE STATED.
 - REDUCED LEVELS (RL) ARE TO AUSTRALIAN HEIGHT DATUM (AHD). COORDINATES ARE TO MAP GRID AUSTRALIA (MGA).
 - THE ARCHITECTURAL DOCUMENTATION IS ONLY ALLOWED TO BE USED FOR THE PURPOSE FOR WHICH IT WAS COMMISSIONED. UNAUTHORISED USE OF THE DOCUMENTATION IS PROHIBITED.

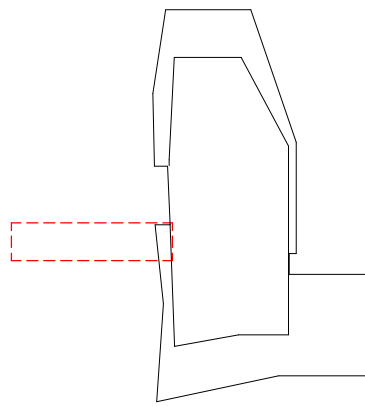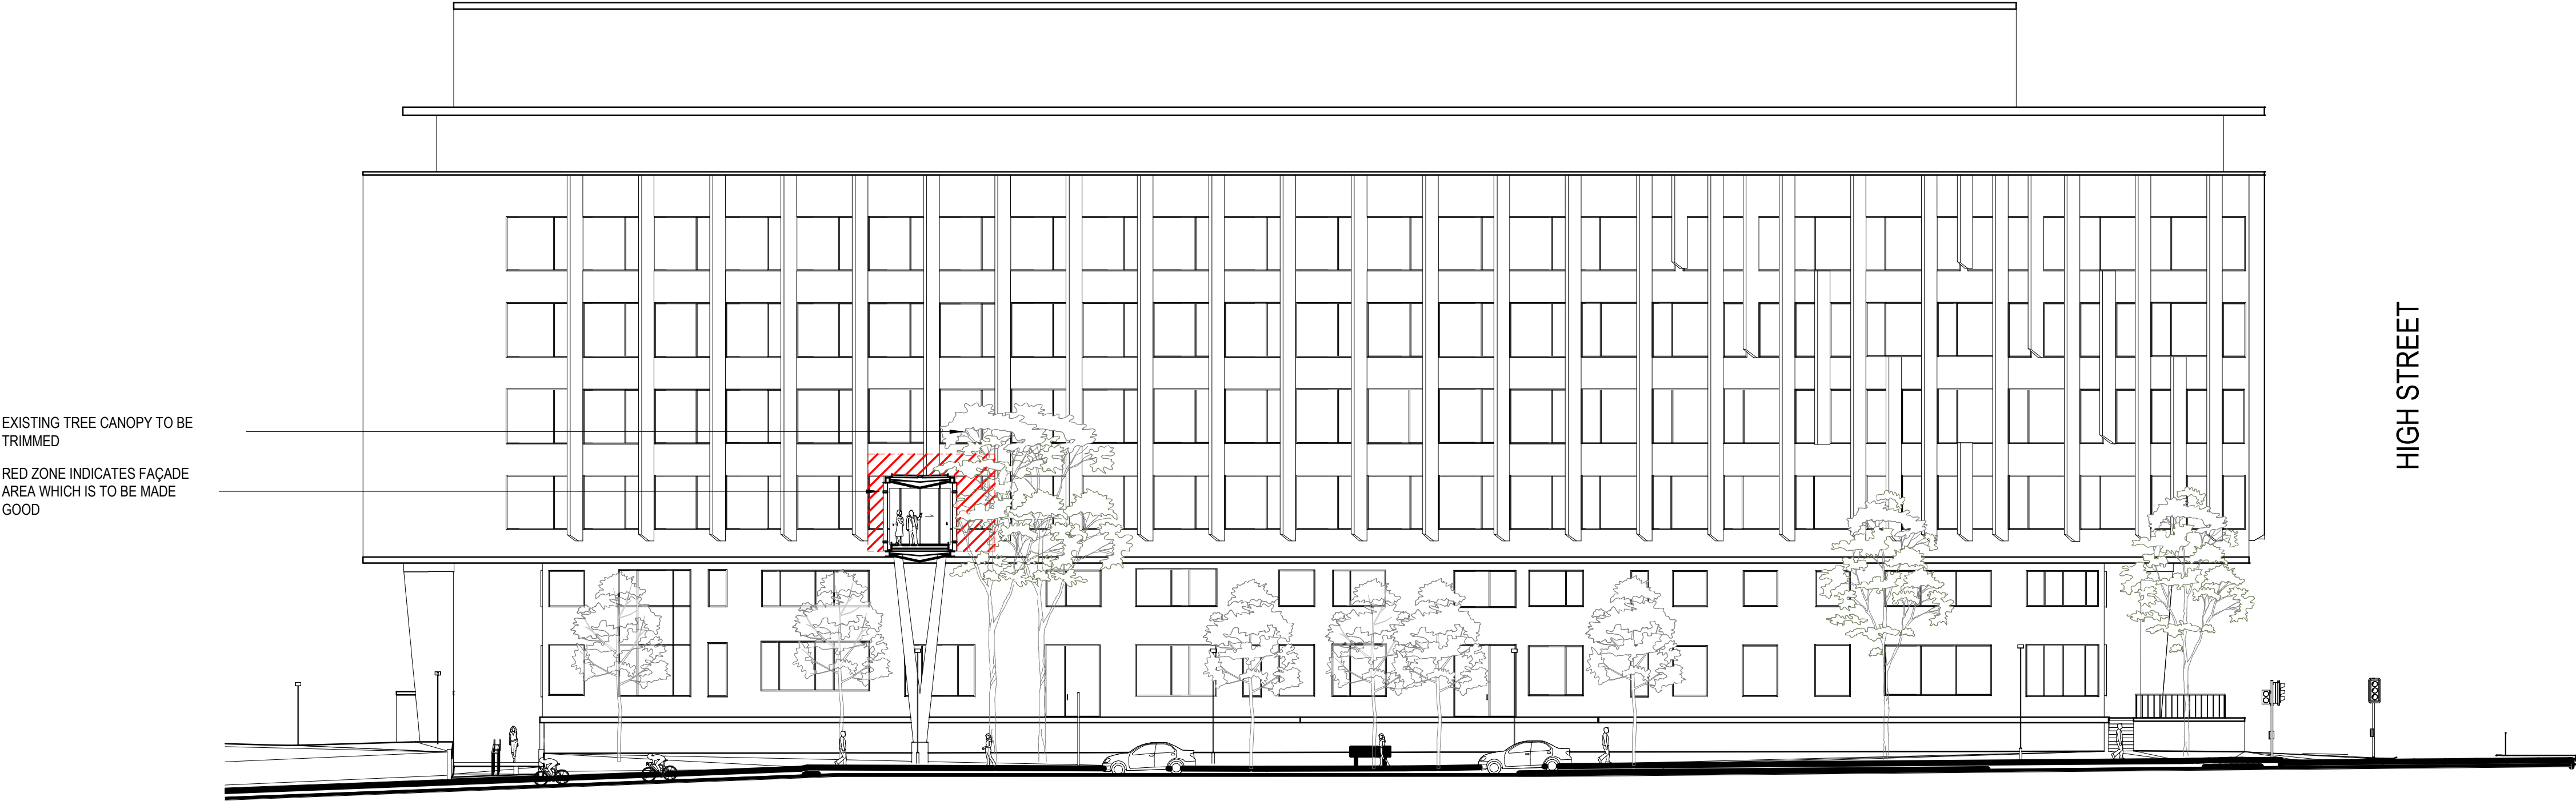

Scale:
1:200 @ A1
1:400 @
A3

0 2 4 6

architectus™



ABN 90 131 245 684

project
UNSW Health Translation Hub

drawing
UNSW Campus Connection -
Elevation Wallace Wurth

scale	1 : 200@A1	drawing no.
drawn	HD	DA5751
checked	JC	issue
project no	190551.00	A


Do not scale drawings. Verify all dimensions on site

Do not scale drawings. Verify all dimensions on site


[illegible]

GENERAL NOTES:

- DO NOT SCALE FROM THE DRAWINGS. USE ONLY FIGURED DIMENSIONS.
ALL DIMENSIONS ARE IN MILLIMETRES UNLESS OTHERWISE STATED.
REDUCED LEVELS (RL) ARE TO AUSTRALIAN HEIGHT DATUM (AHD).
COORDINATES ARE TO MAP GRID AUSTRALIA (MGA).
THE ARCHITECTURAL DOCUMENTATION IS ONLY ALLOWED TO BE USED
FOR THE PURPOSE FOR WHICH IT WAS COMMISSIONED. UNAUTHORISED
USE OF THE DOCUMENTATION IS PROHIBITED.

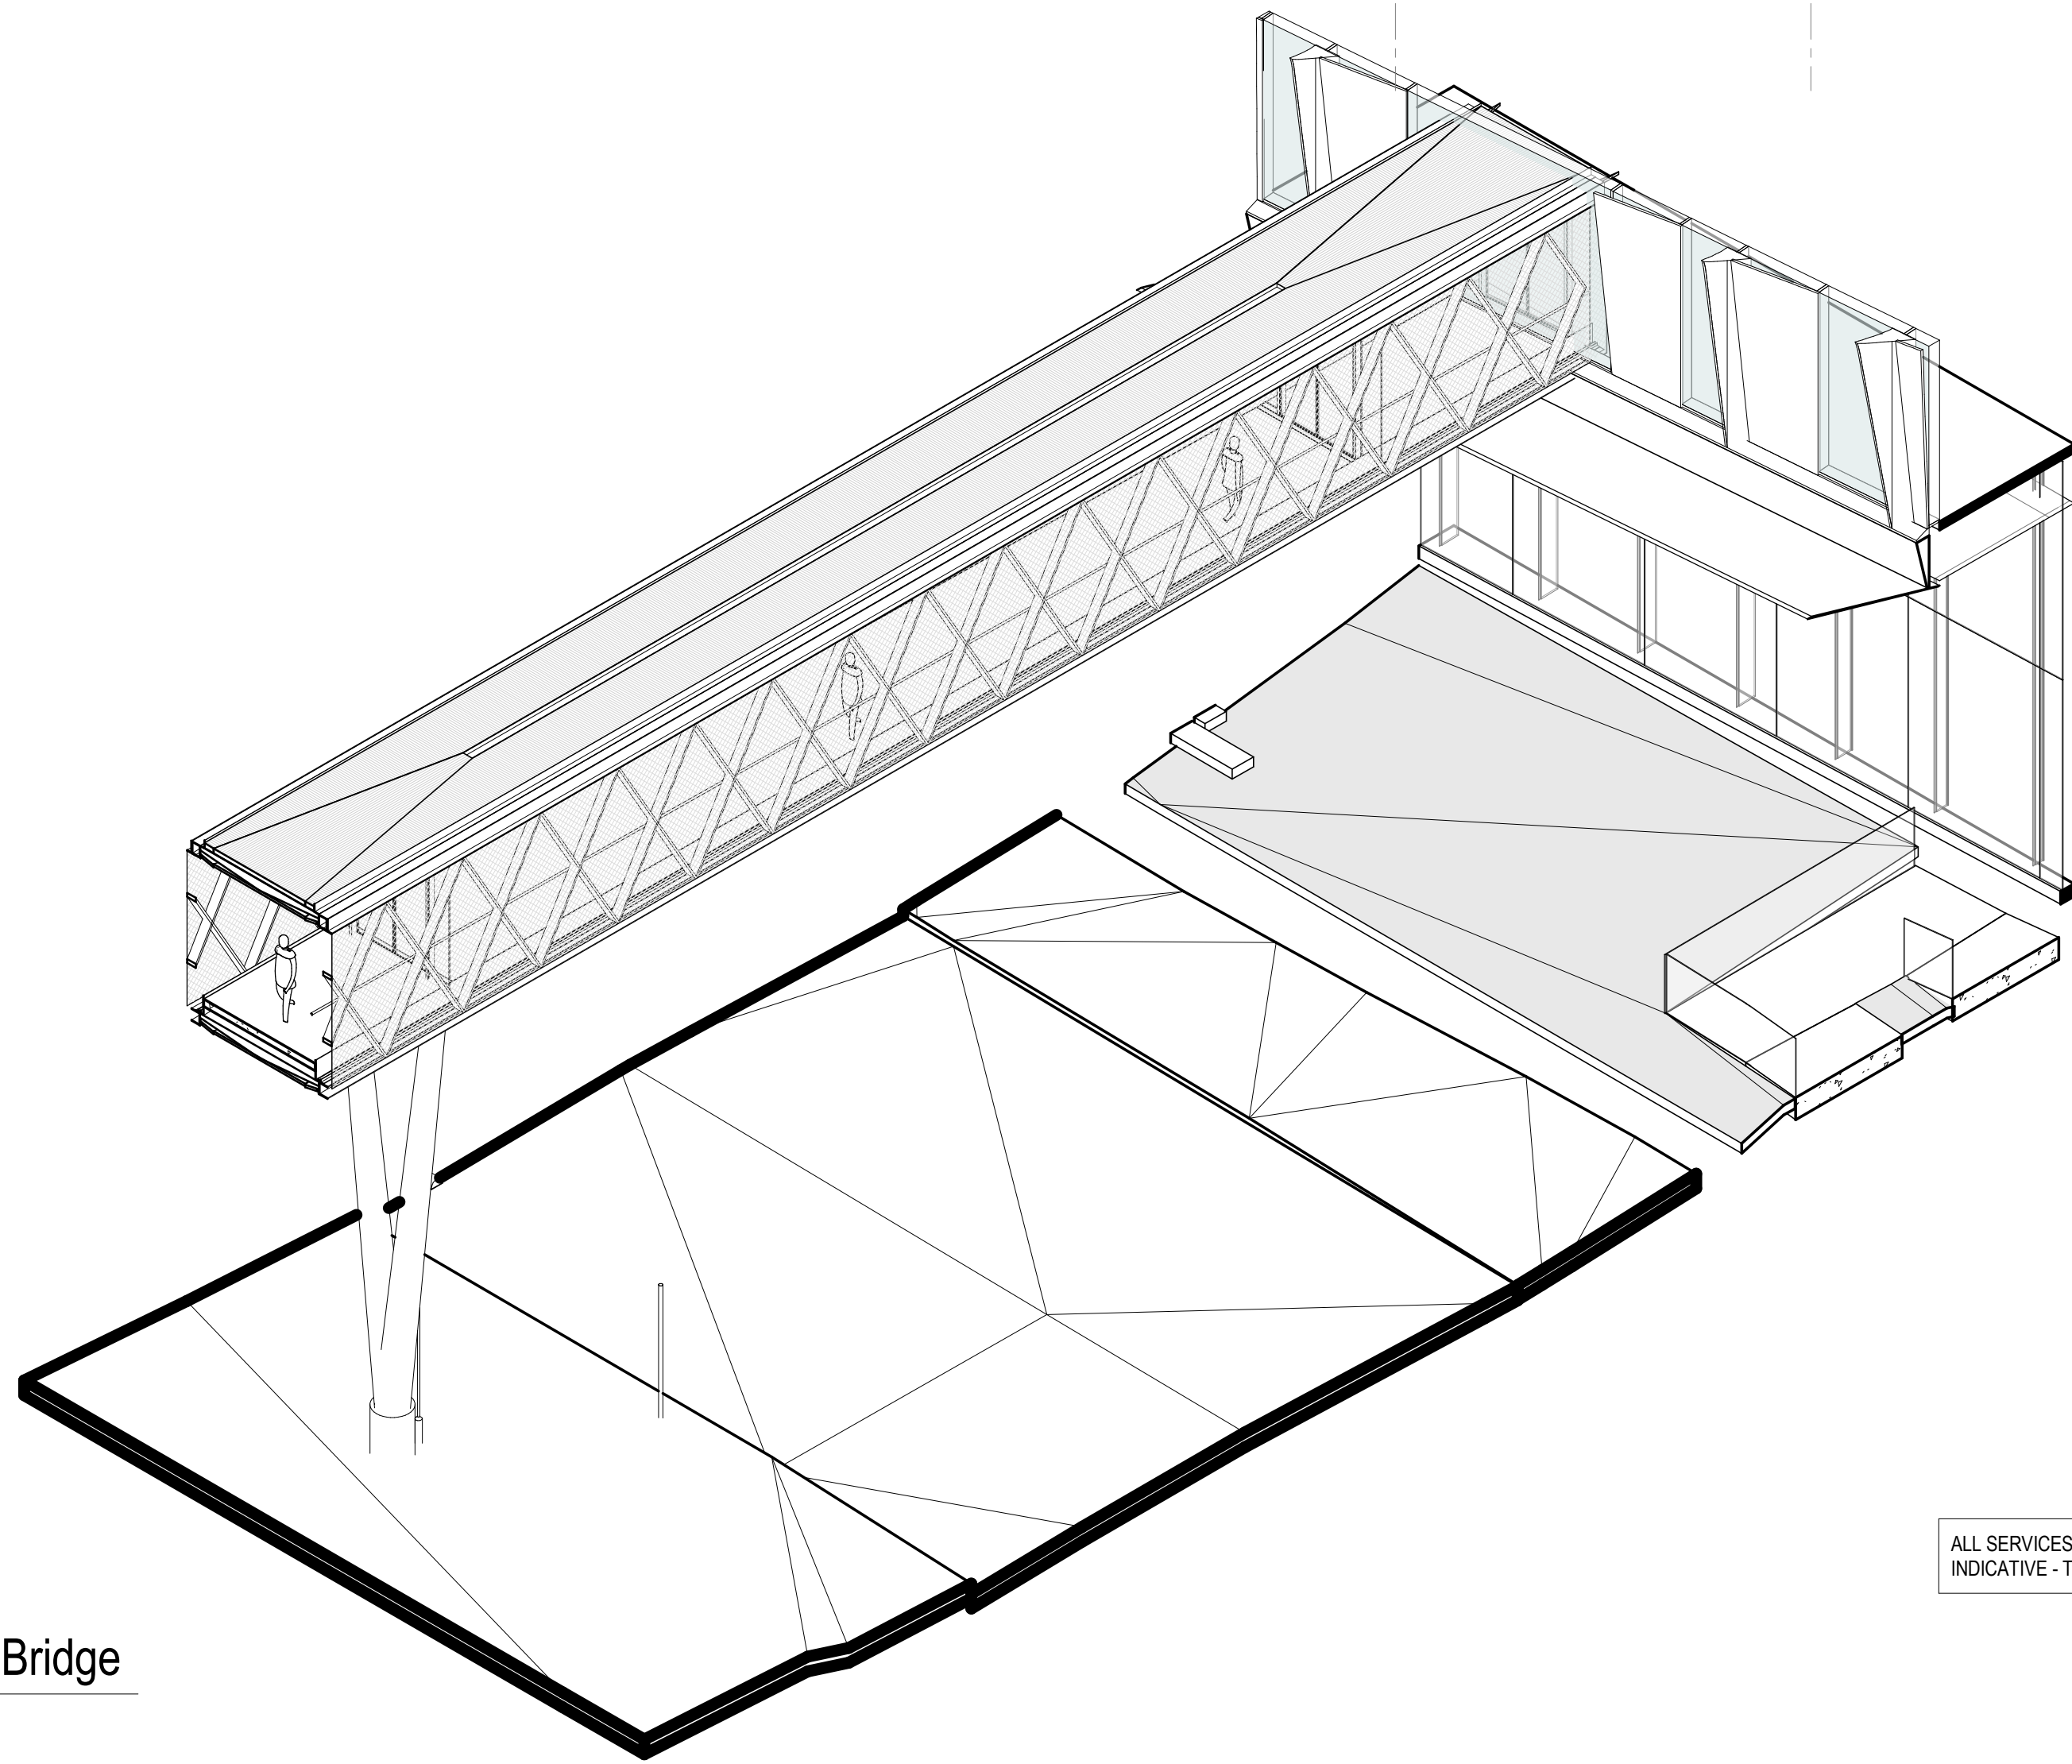

ALL SERVICES LOCATION SHOWN
INDICATIVE - TO BE CONFIRMED ONSITE

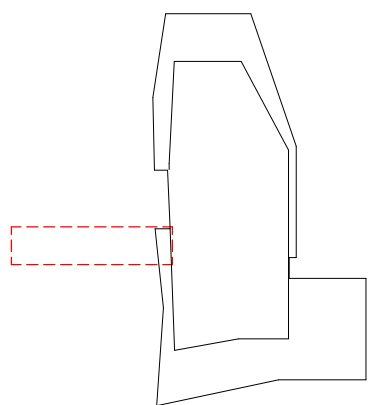


Scale:

1:100 @ A1

1:200 @

A3



architectus™



ABN 90 131 245 684

project


UNSW Health Translation Hub

drawing


UNSW Campus Connection - Section

scale	1 : 100@A1	drawing no.
drawn	HD	DA5755
checked	JC	issue
project no	190551.00	A


18/02/2021 12:04:21 PM

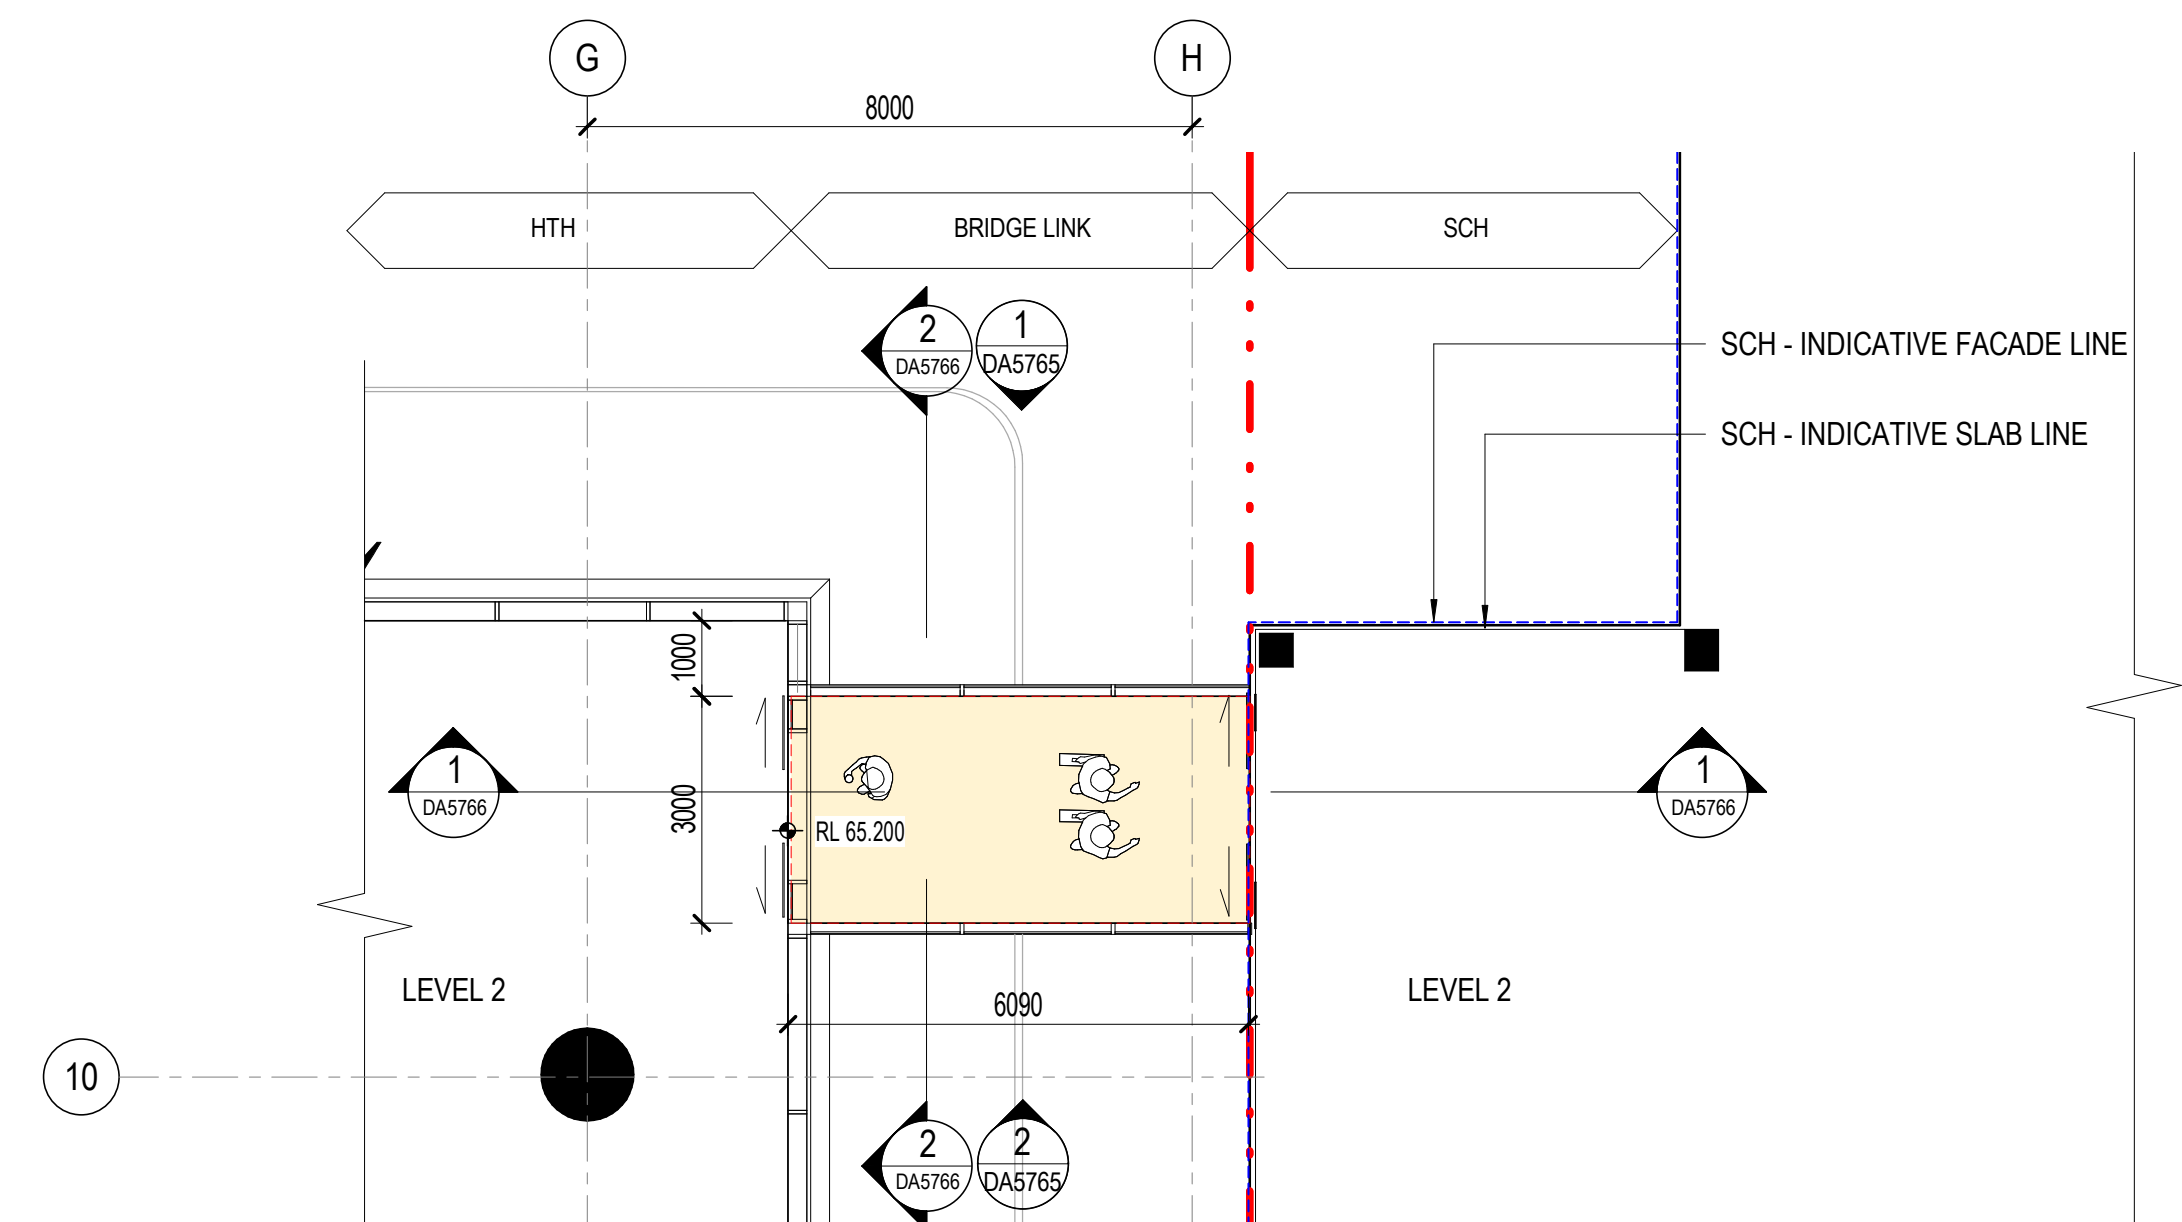


1 SCH Bridge Link_Level 2 Floor Plan
DA1003 SCALE: 1:100

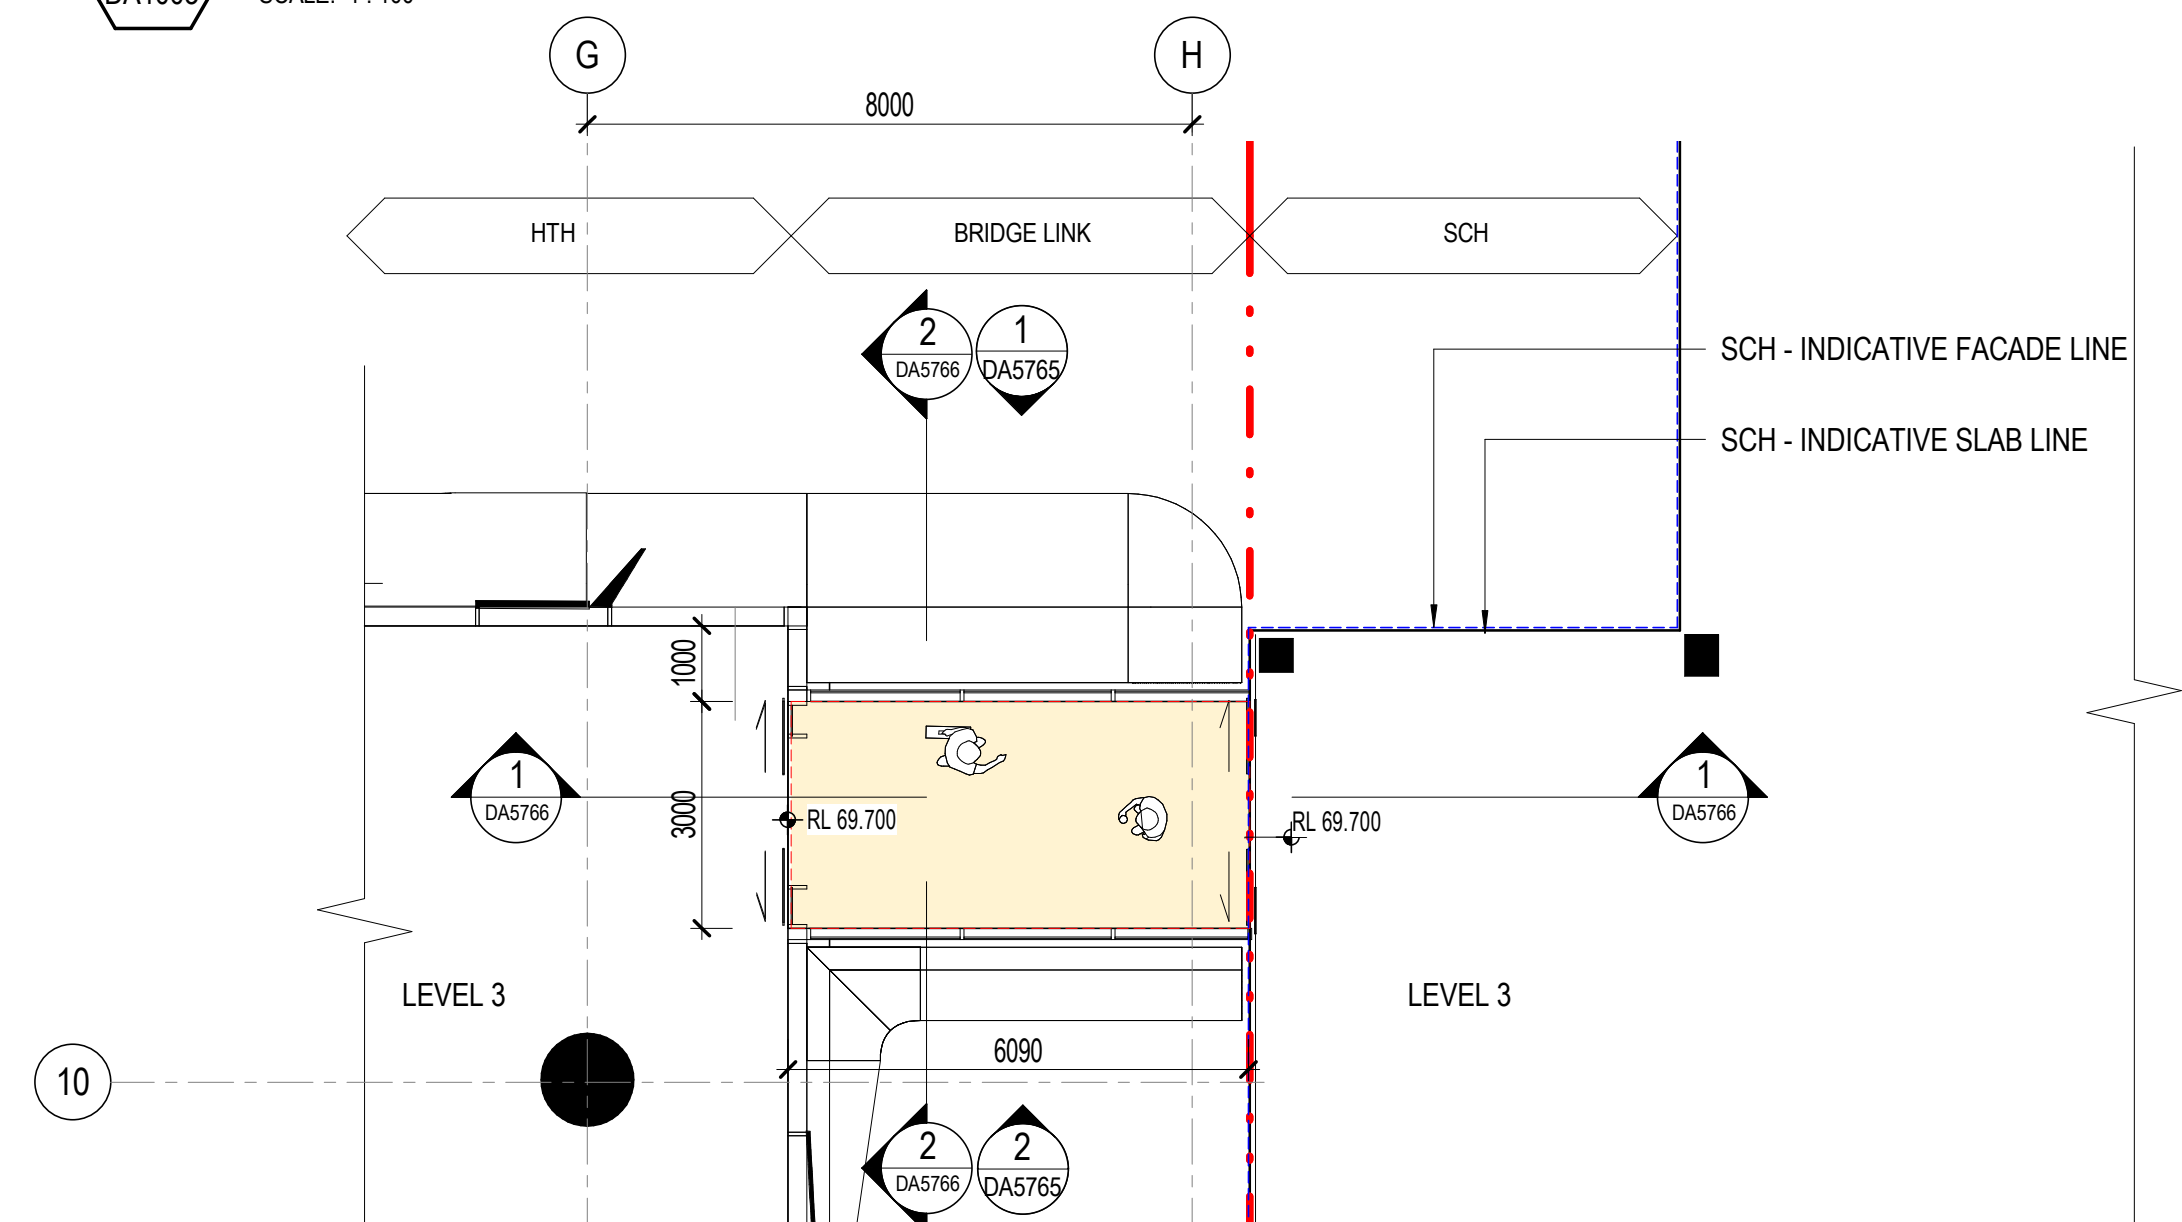

2 SCH Bridge Link_Level 3 Floor Plan
DA1004 SCALE: 1:100

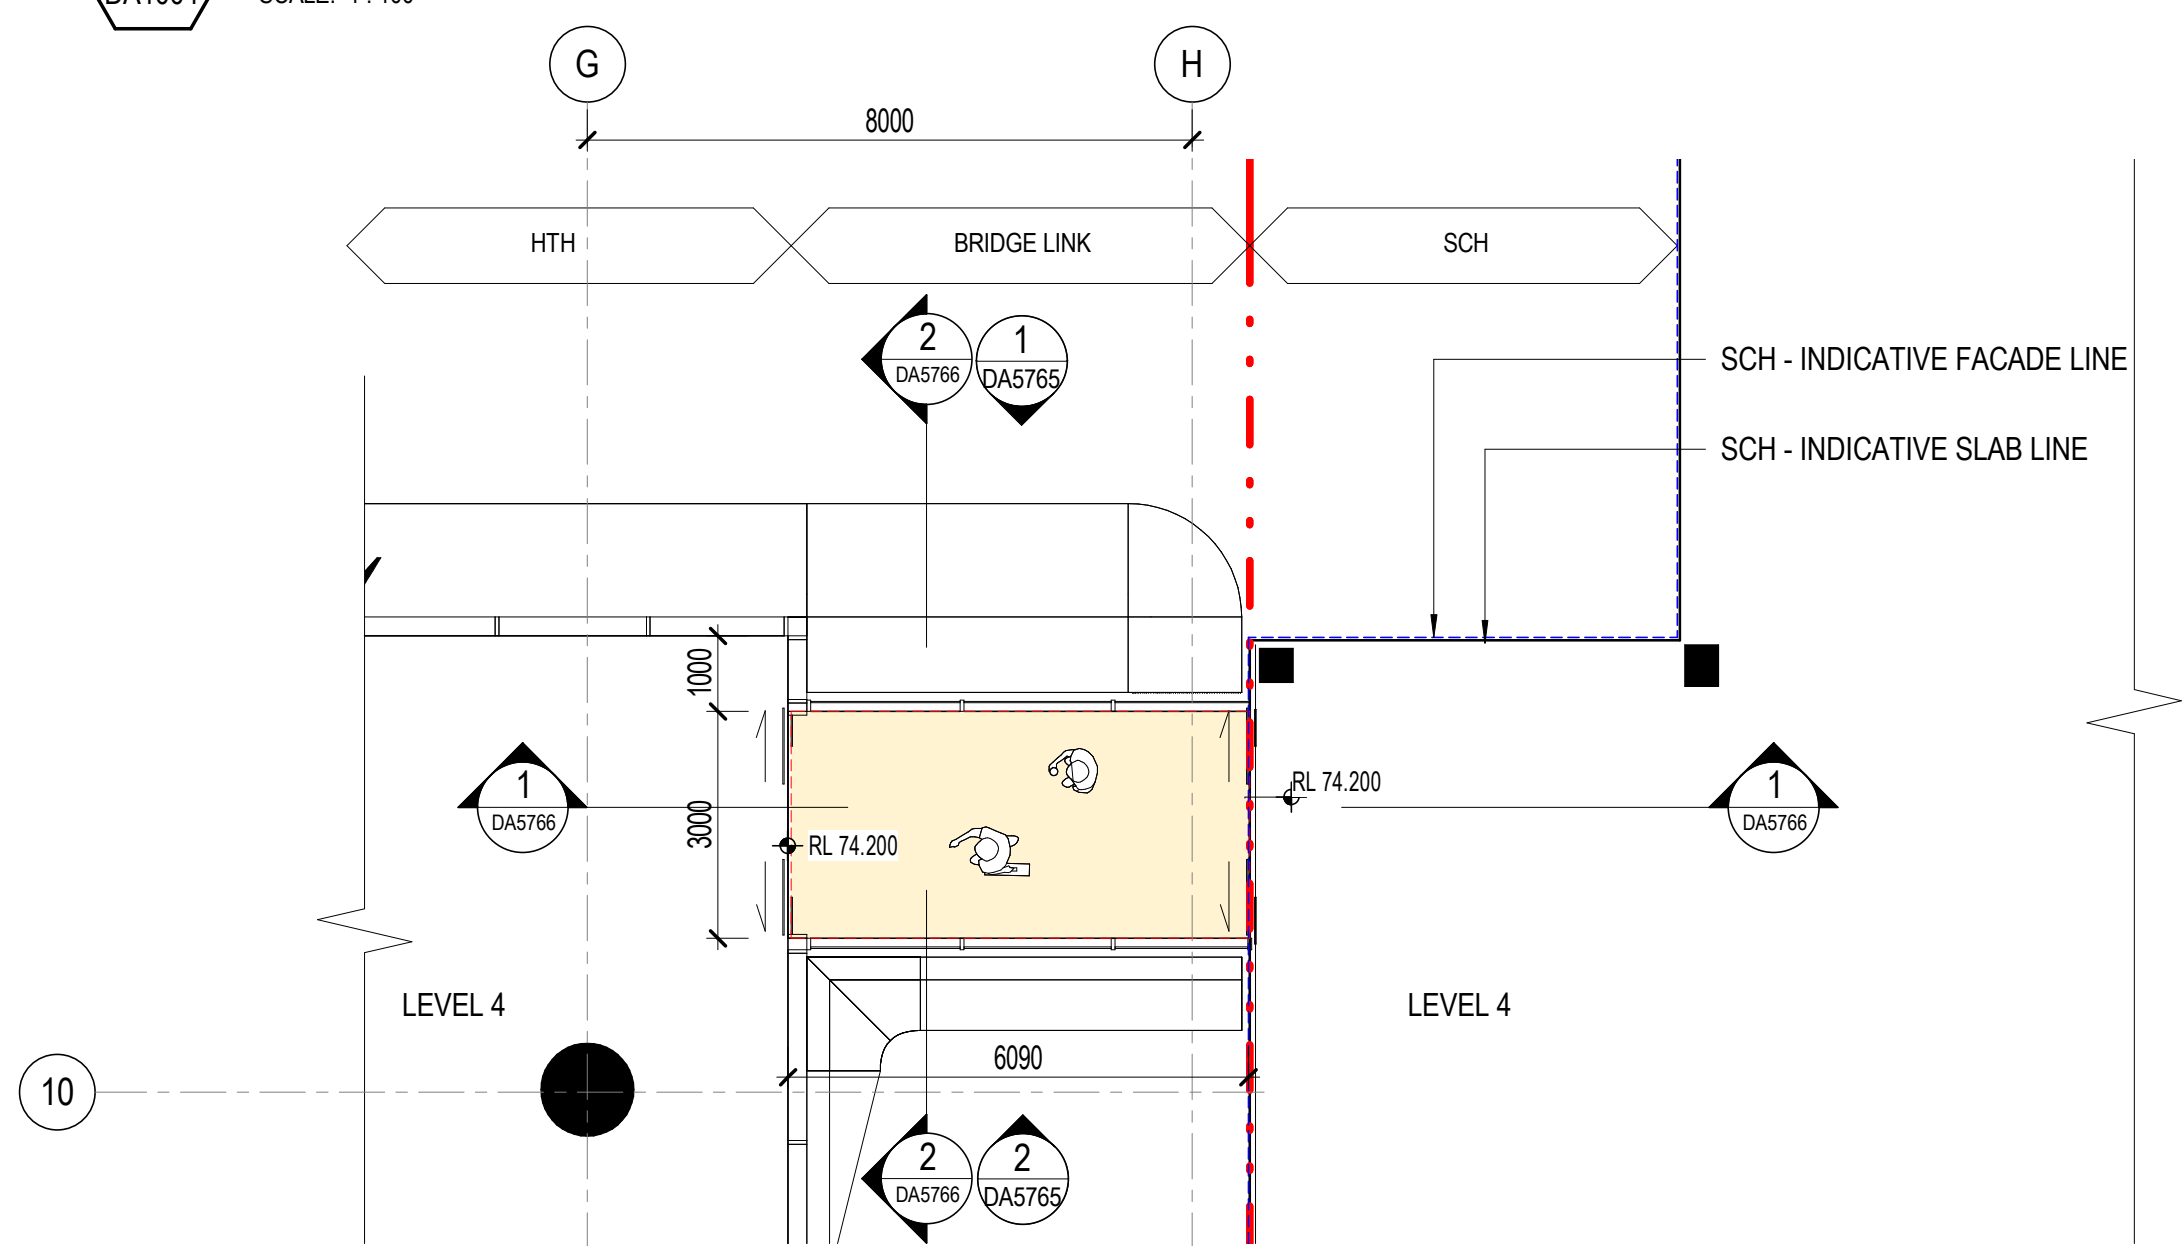

3 SCH Bridge Link_Level 4 Floor Plan
DA1005 SCALE: 1:100

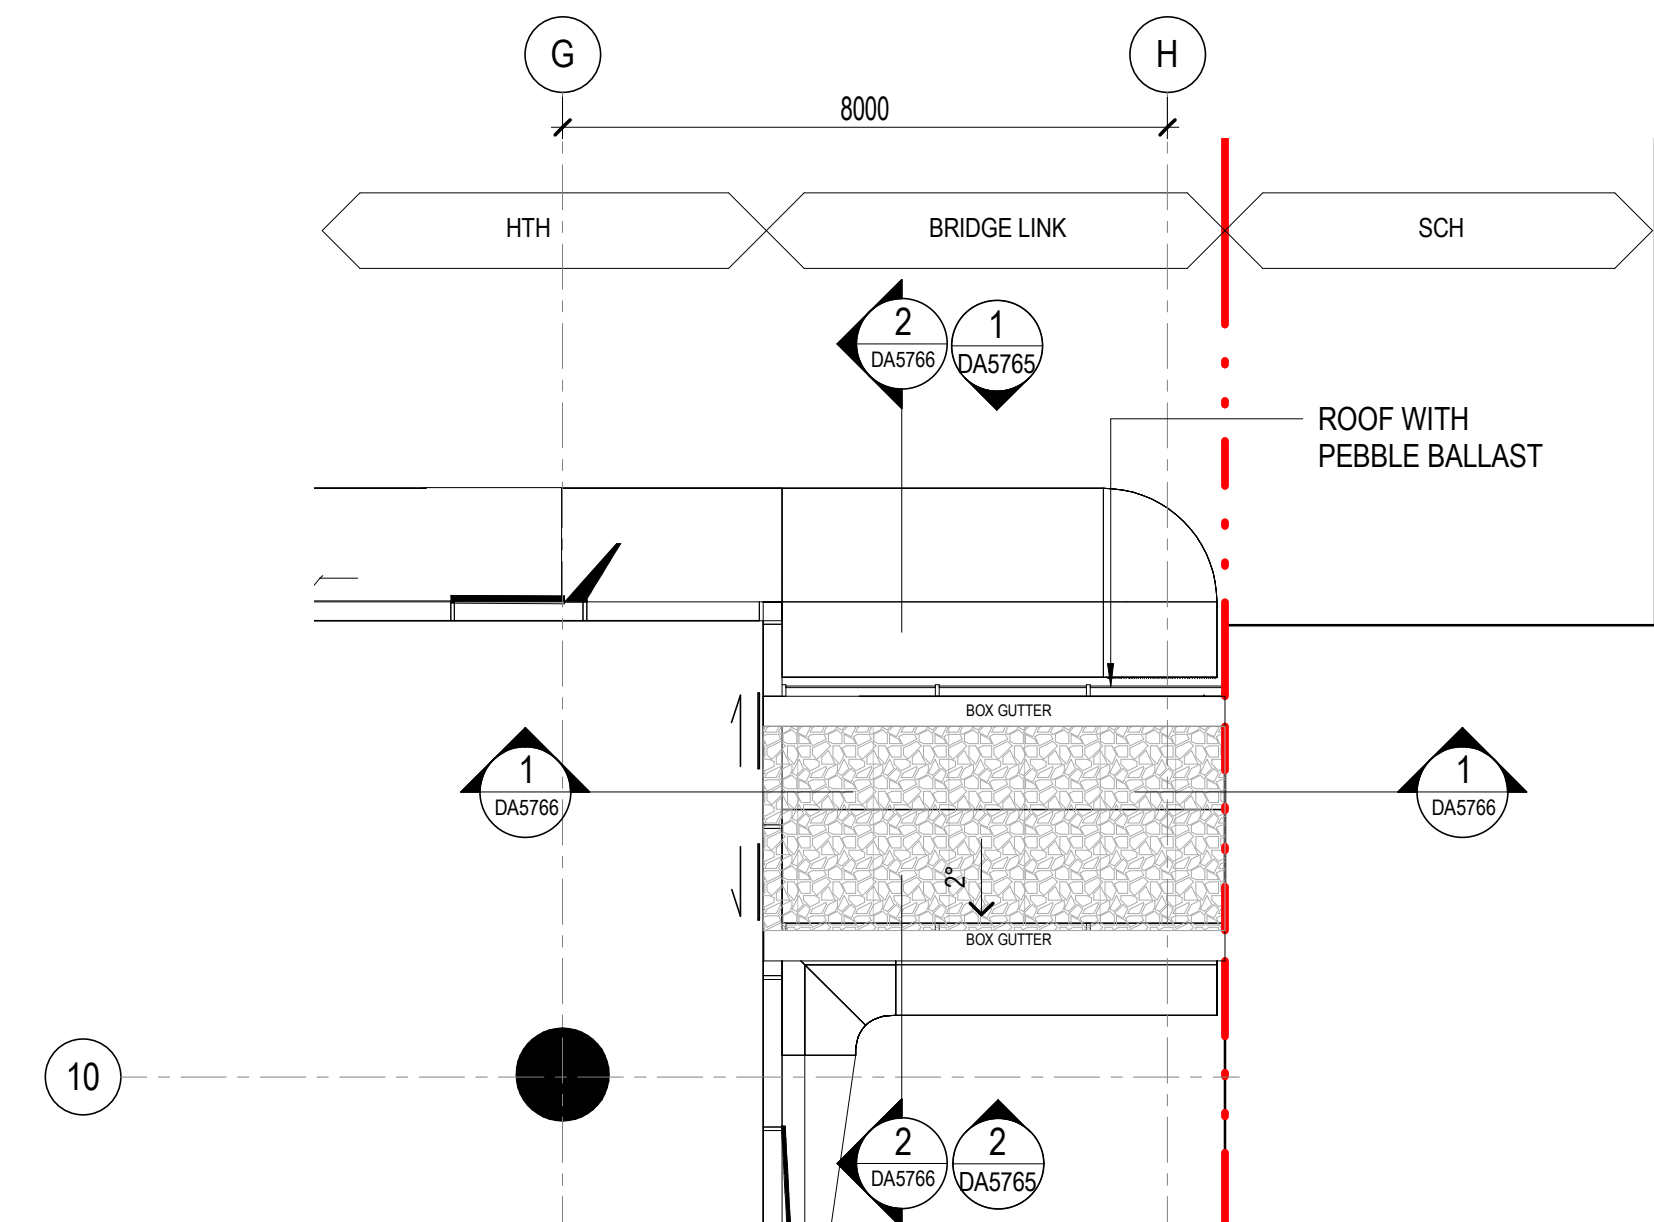

5 SCH Bridge Link_Roof Plan
DA1006 SCALE: 1:100

architectus™

Architectus Australia Pty Ltd is the owner of the copyright subsisting in these drawings, plans, designs and specifications. They must not be used, reproduced or copied, in whole or in part, nor may the information, ideas and concepts therein contained (which are confidential to Architectus Australia Pty Ltd) be disclosed to any person without the prior written consent of that company.


Nominated Architect
Ray Brown, NSWARB 6359

Do not scale drawings. Verify all dimensions on site

issue	amendment	date
A	ISSUED FOR STATE SIGNIFICANT DEVELOPMENT APPLICATION	18.02.21

GENERAL NOTES:

- DO NOT SCALE FROM THE DRAWINGS. USE ONLY FIGURED DIMENSIONS.
- ALL DIMENSIONS ARE IN MILLIMETRES UNLESS OTHERWISE STATED.
- REDUCED LEVELS (RL) ARE TO AUSTRALIAN HEIGHT DATUM (AHD).
- COORDINATES ARE TO MAP GRID AUSTRALIA (MGA).
- THE ARCHITECTURAL DOCUMENTATION IS ONLY ALLOWED TO BE USED FOR THE PURPOSE FOR WHICH IT WAS COMMISSIONED. UNAUTHORISED USE OF THE DOCUMENTATION IS PROHIBITED.

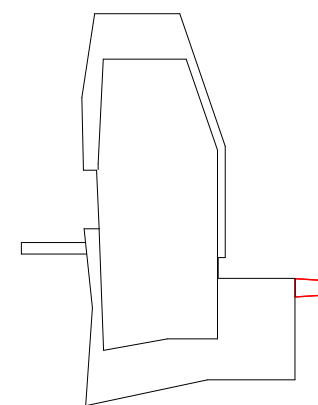

Scale:
1:100 @ A1
1:200 @
A3

architectus™



ABN 90 131 245 684

project


UNSW Health Translation Hub

drawing


SCH - Bridge Connection - Floor Plan

scale	1 : 100@A1	drawing no.
drawn	HD	DA5760
checked	JC	issue
project no	190551.00	A

22/02/2021 5:11:07 PM

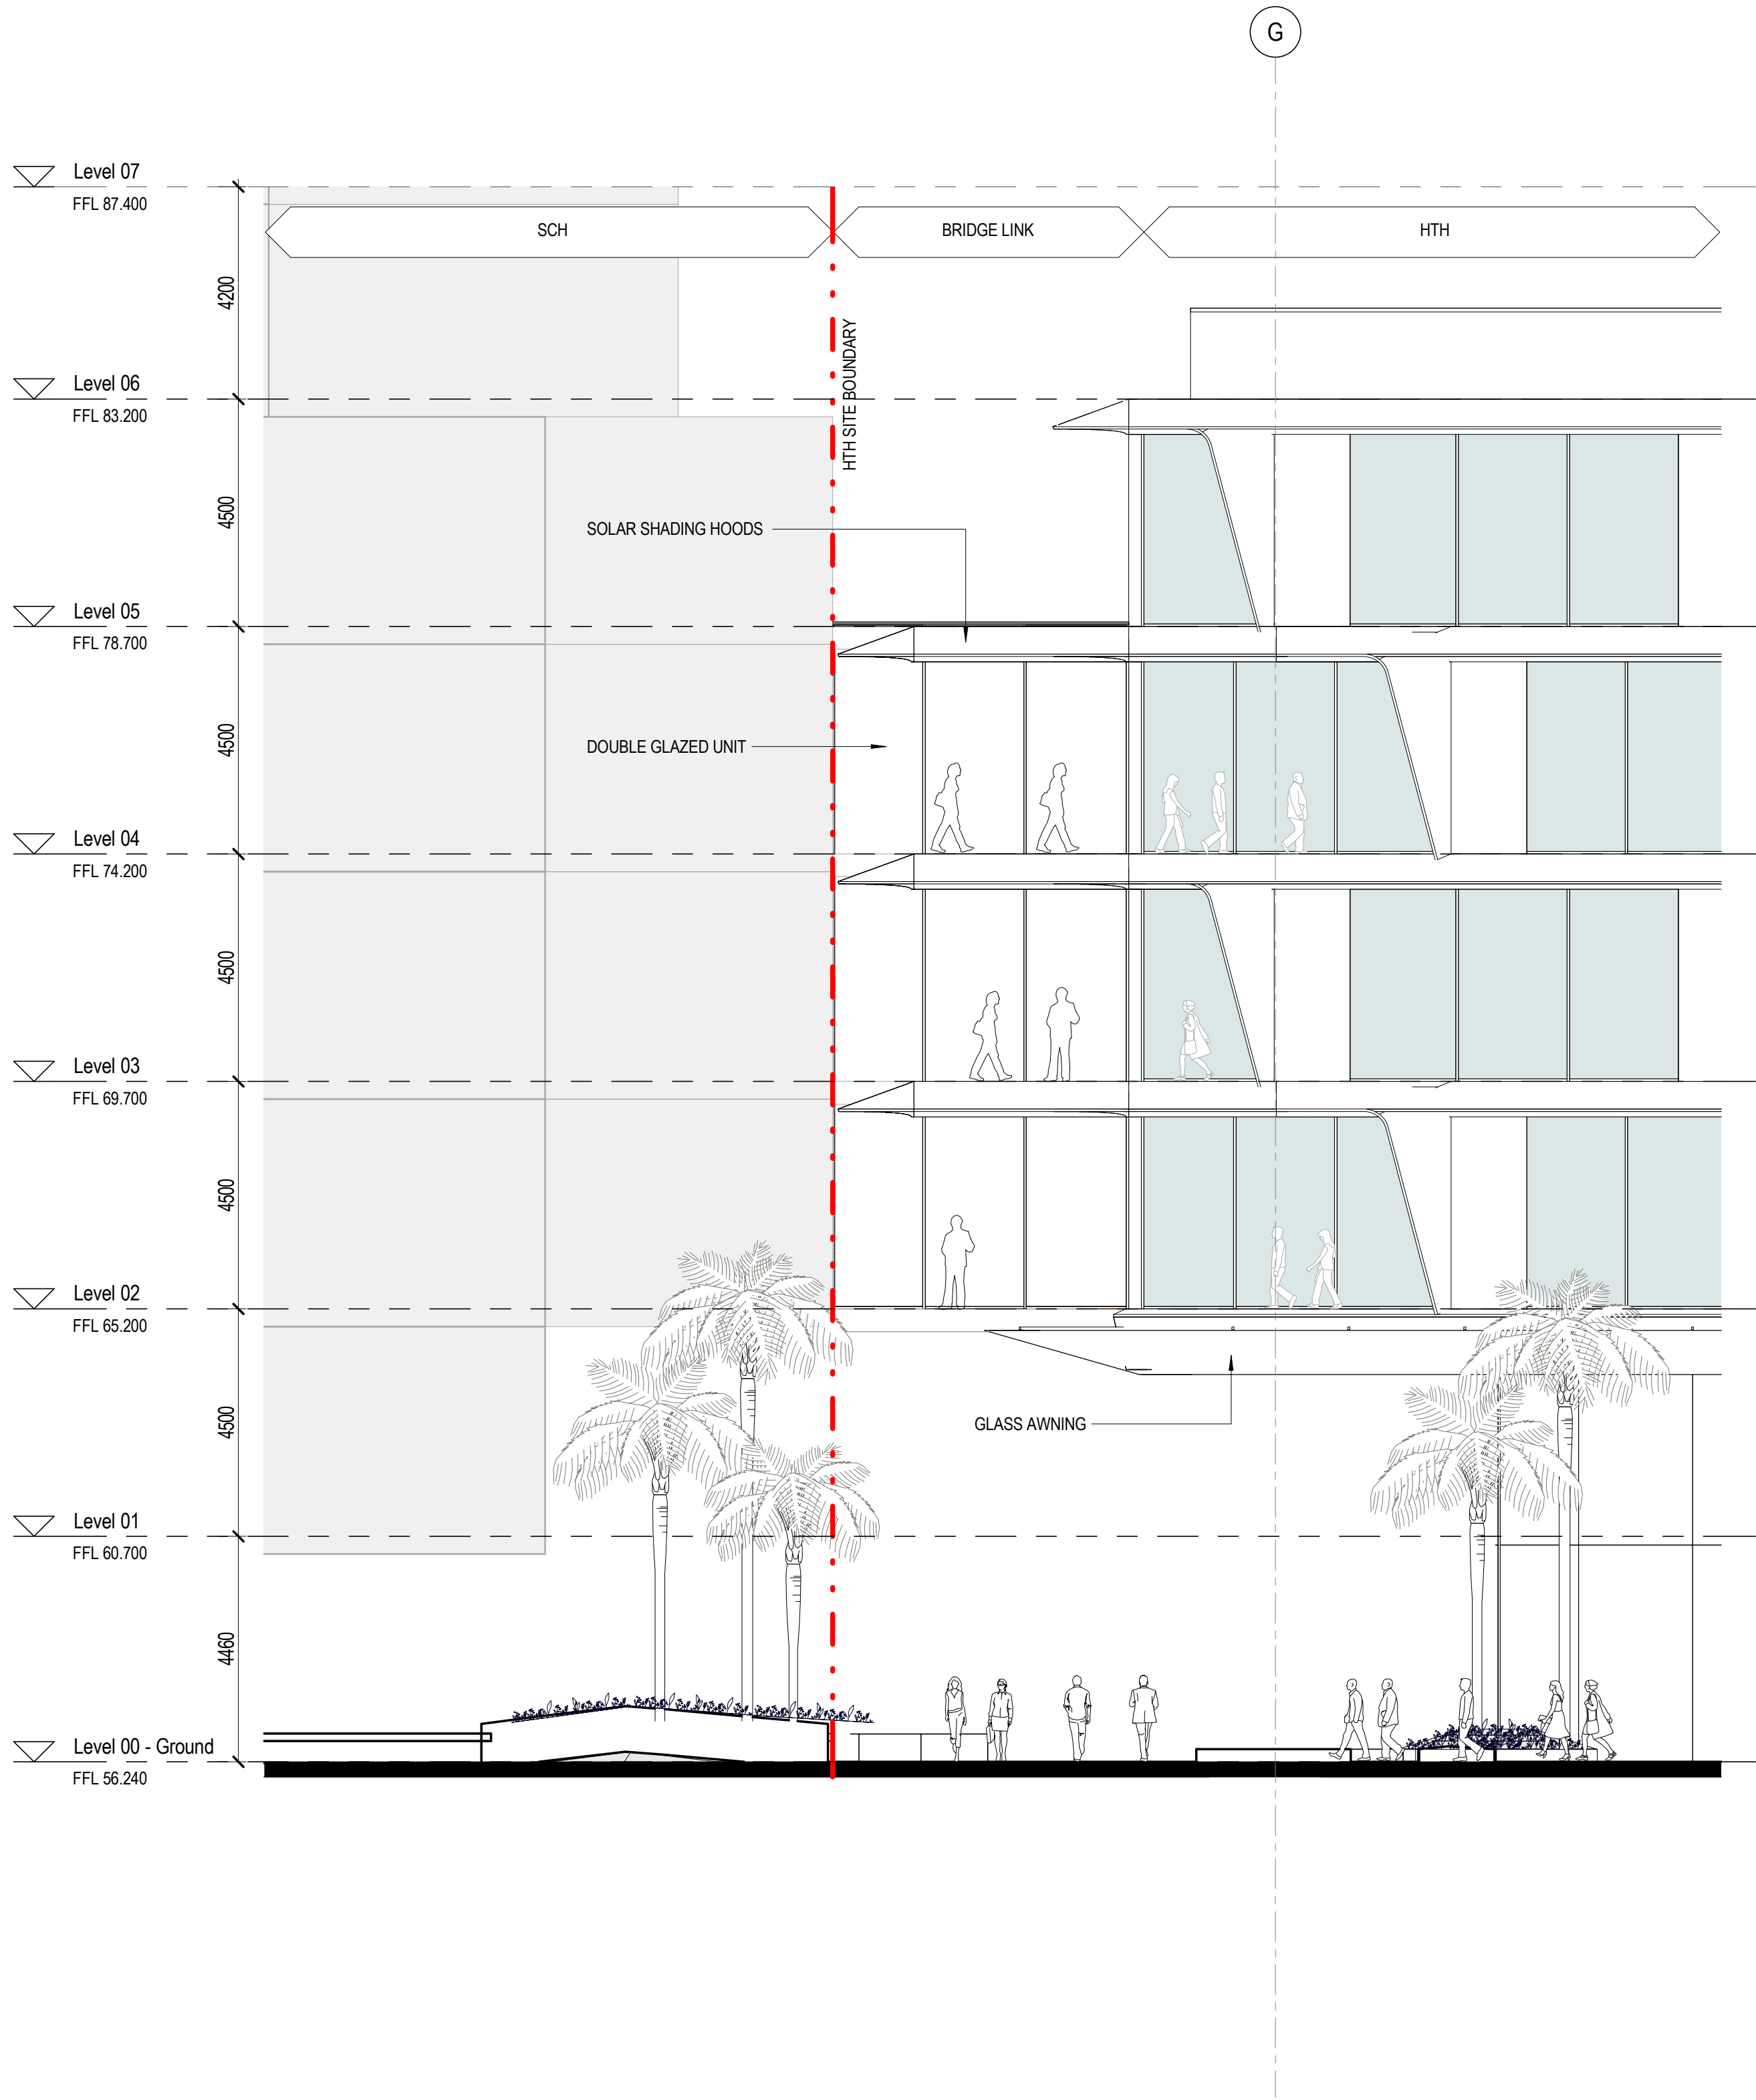

1 SCH Bridge Elevation_North
SCALE: 1:100

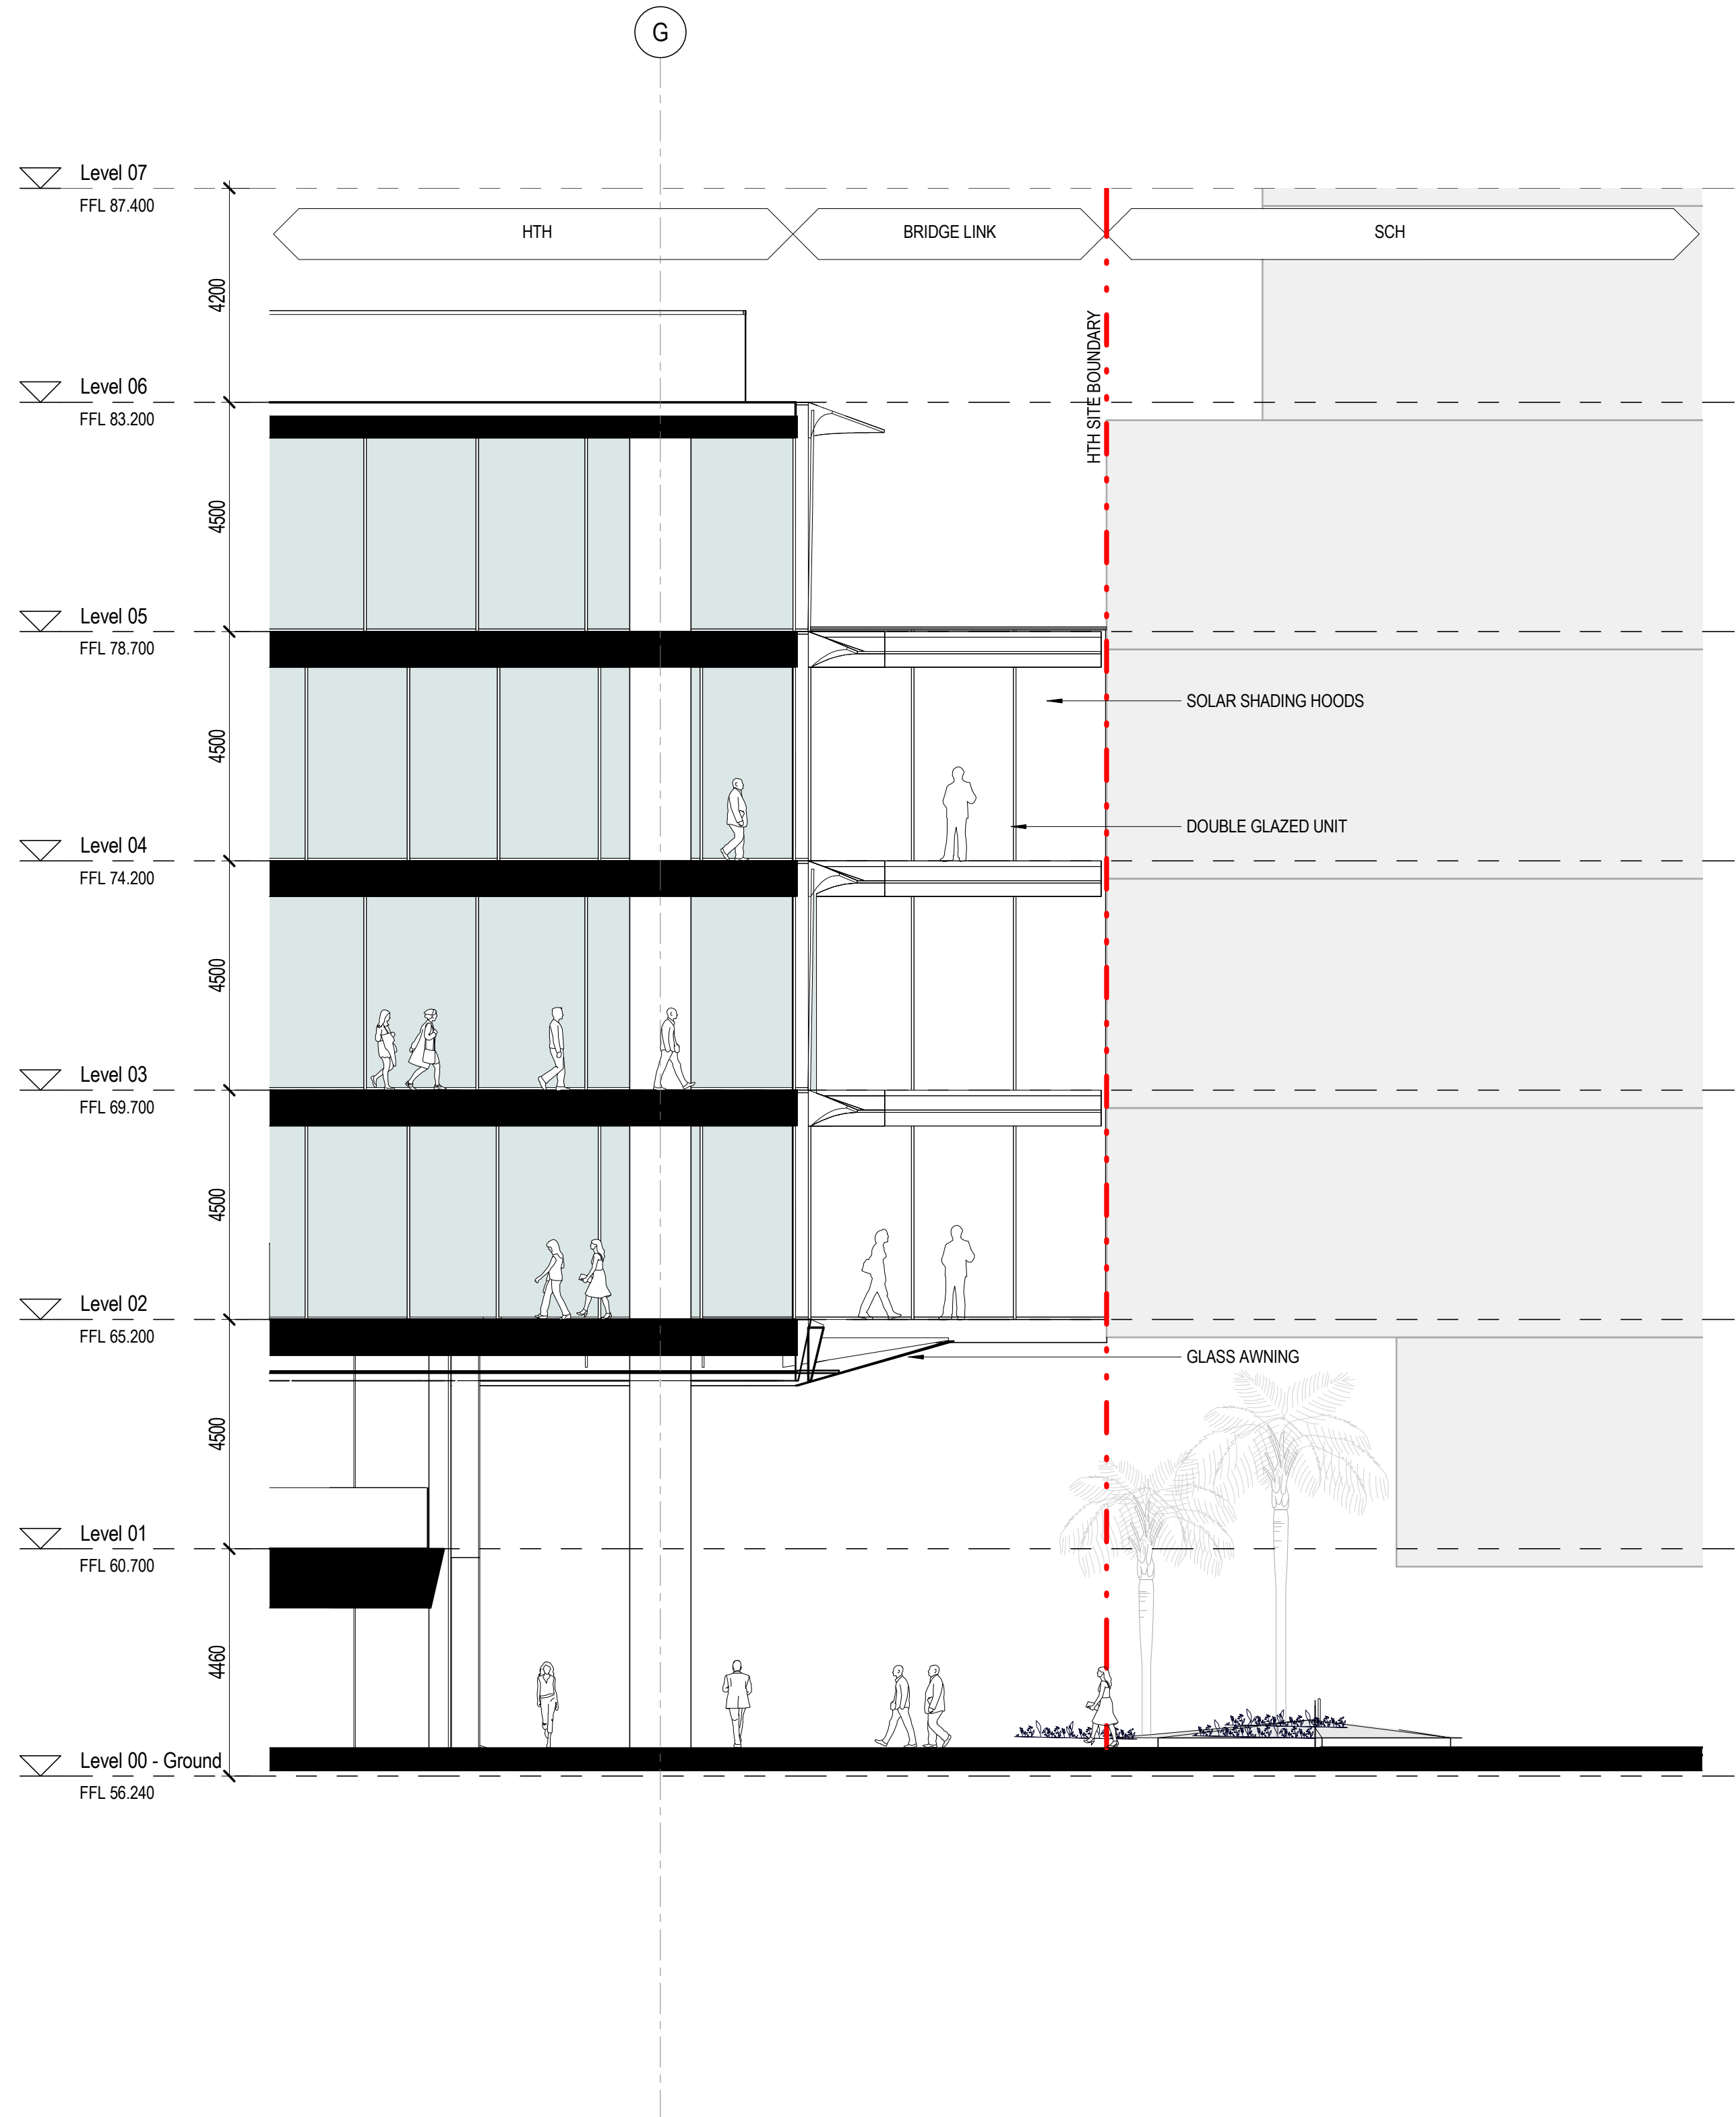

2 SCH Bridge Elevation_South
SCALE: 1:100

architectus

Architectus Australia Pty Ltd is the owner of the copyright subsisting in these drawings, plans, designs and specifications. They must not be used, reproduced or copied, in whole or in part, nor may the information, ideas and concepts therein contained (which are confidential to Architectus Australia Pty Ltd) be disclosed to any person without the prior written consent of that company.


Nominated Architect
Ray Brown, NSWARB 6359

Do not scale drawings. Verify all dimensions on site

issue	amendment	date
A	ISSUED FOR STATE SIGNIFICANT DEVELOPMENT APPLICATION	18.02.21

GENERAL NOTES:

- DO NOT SCALE FROM THE DRAWINGS. USE ONLY FIGURED DIMENSIONS.
- ALL DIMENSIONS ARE IN MILLIMETRES UNLESS OTHERWISE STATED.
- REDUCED LEVELS (RL) ARE TO AUSTRALIAN HEIGHT DATUM (AHD).
- COORDINATES ARE TO MAP GRID AUSTRALIA (MGA).
- THE ARCHITECTURAL DOCUMENTATION IS ONLY ALLOWED TO BE USED FOR THE PURPOSE FOR WHICH IT WAS COMMISSIONED. UNAUTHORISED USE OF THE DOCUMENTATION IS PROHIBITED.

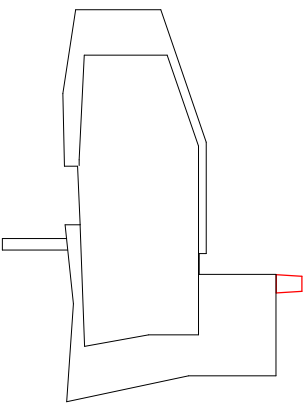

Scale:
1:100 @ A1
1:200 @ A3




project
UNSW Health Translation Hub

drawing


SCH - Bridge Connection - Elevation

scale	1 : 100@A1	drawing no.
drawn	HD	DA5765
checked	JC	issue
project no	190551.00	A


22/02/2021 6:21:32 PM

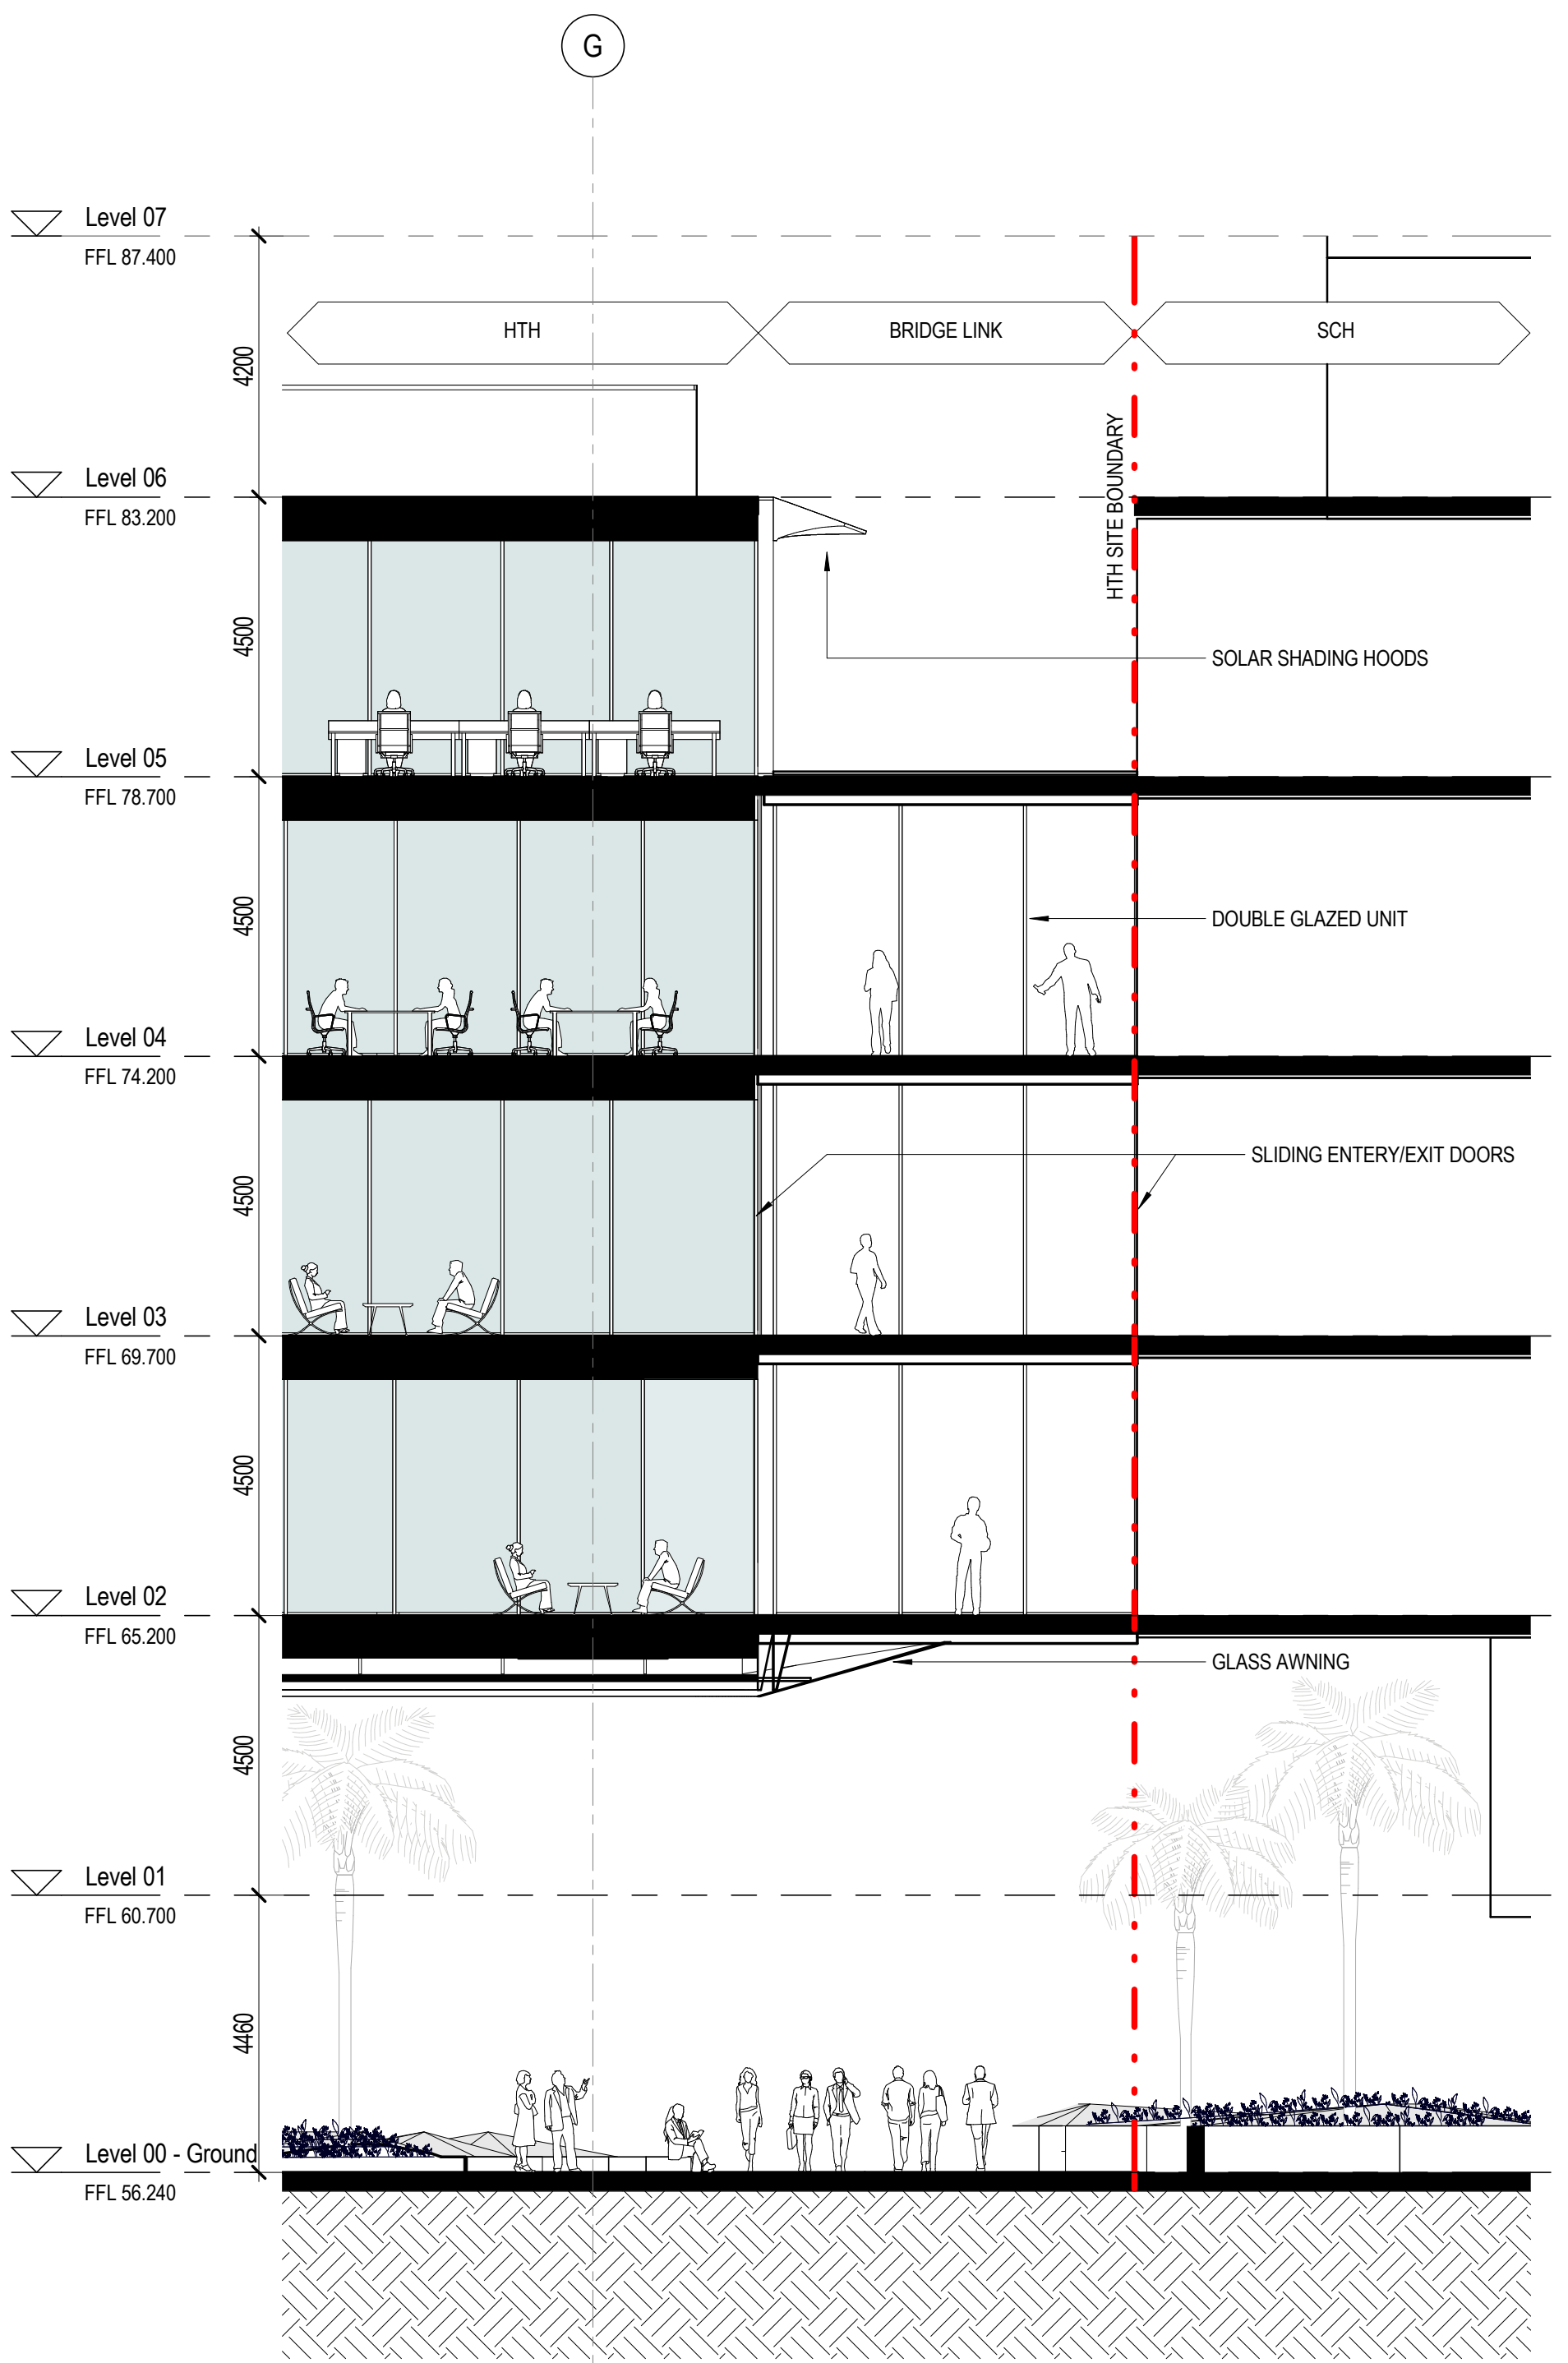

1 SCH Bridge Section_Long
DA5000 SCALE: 1 : 100

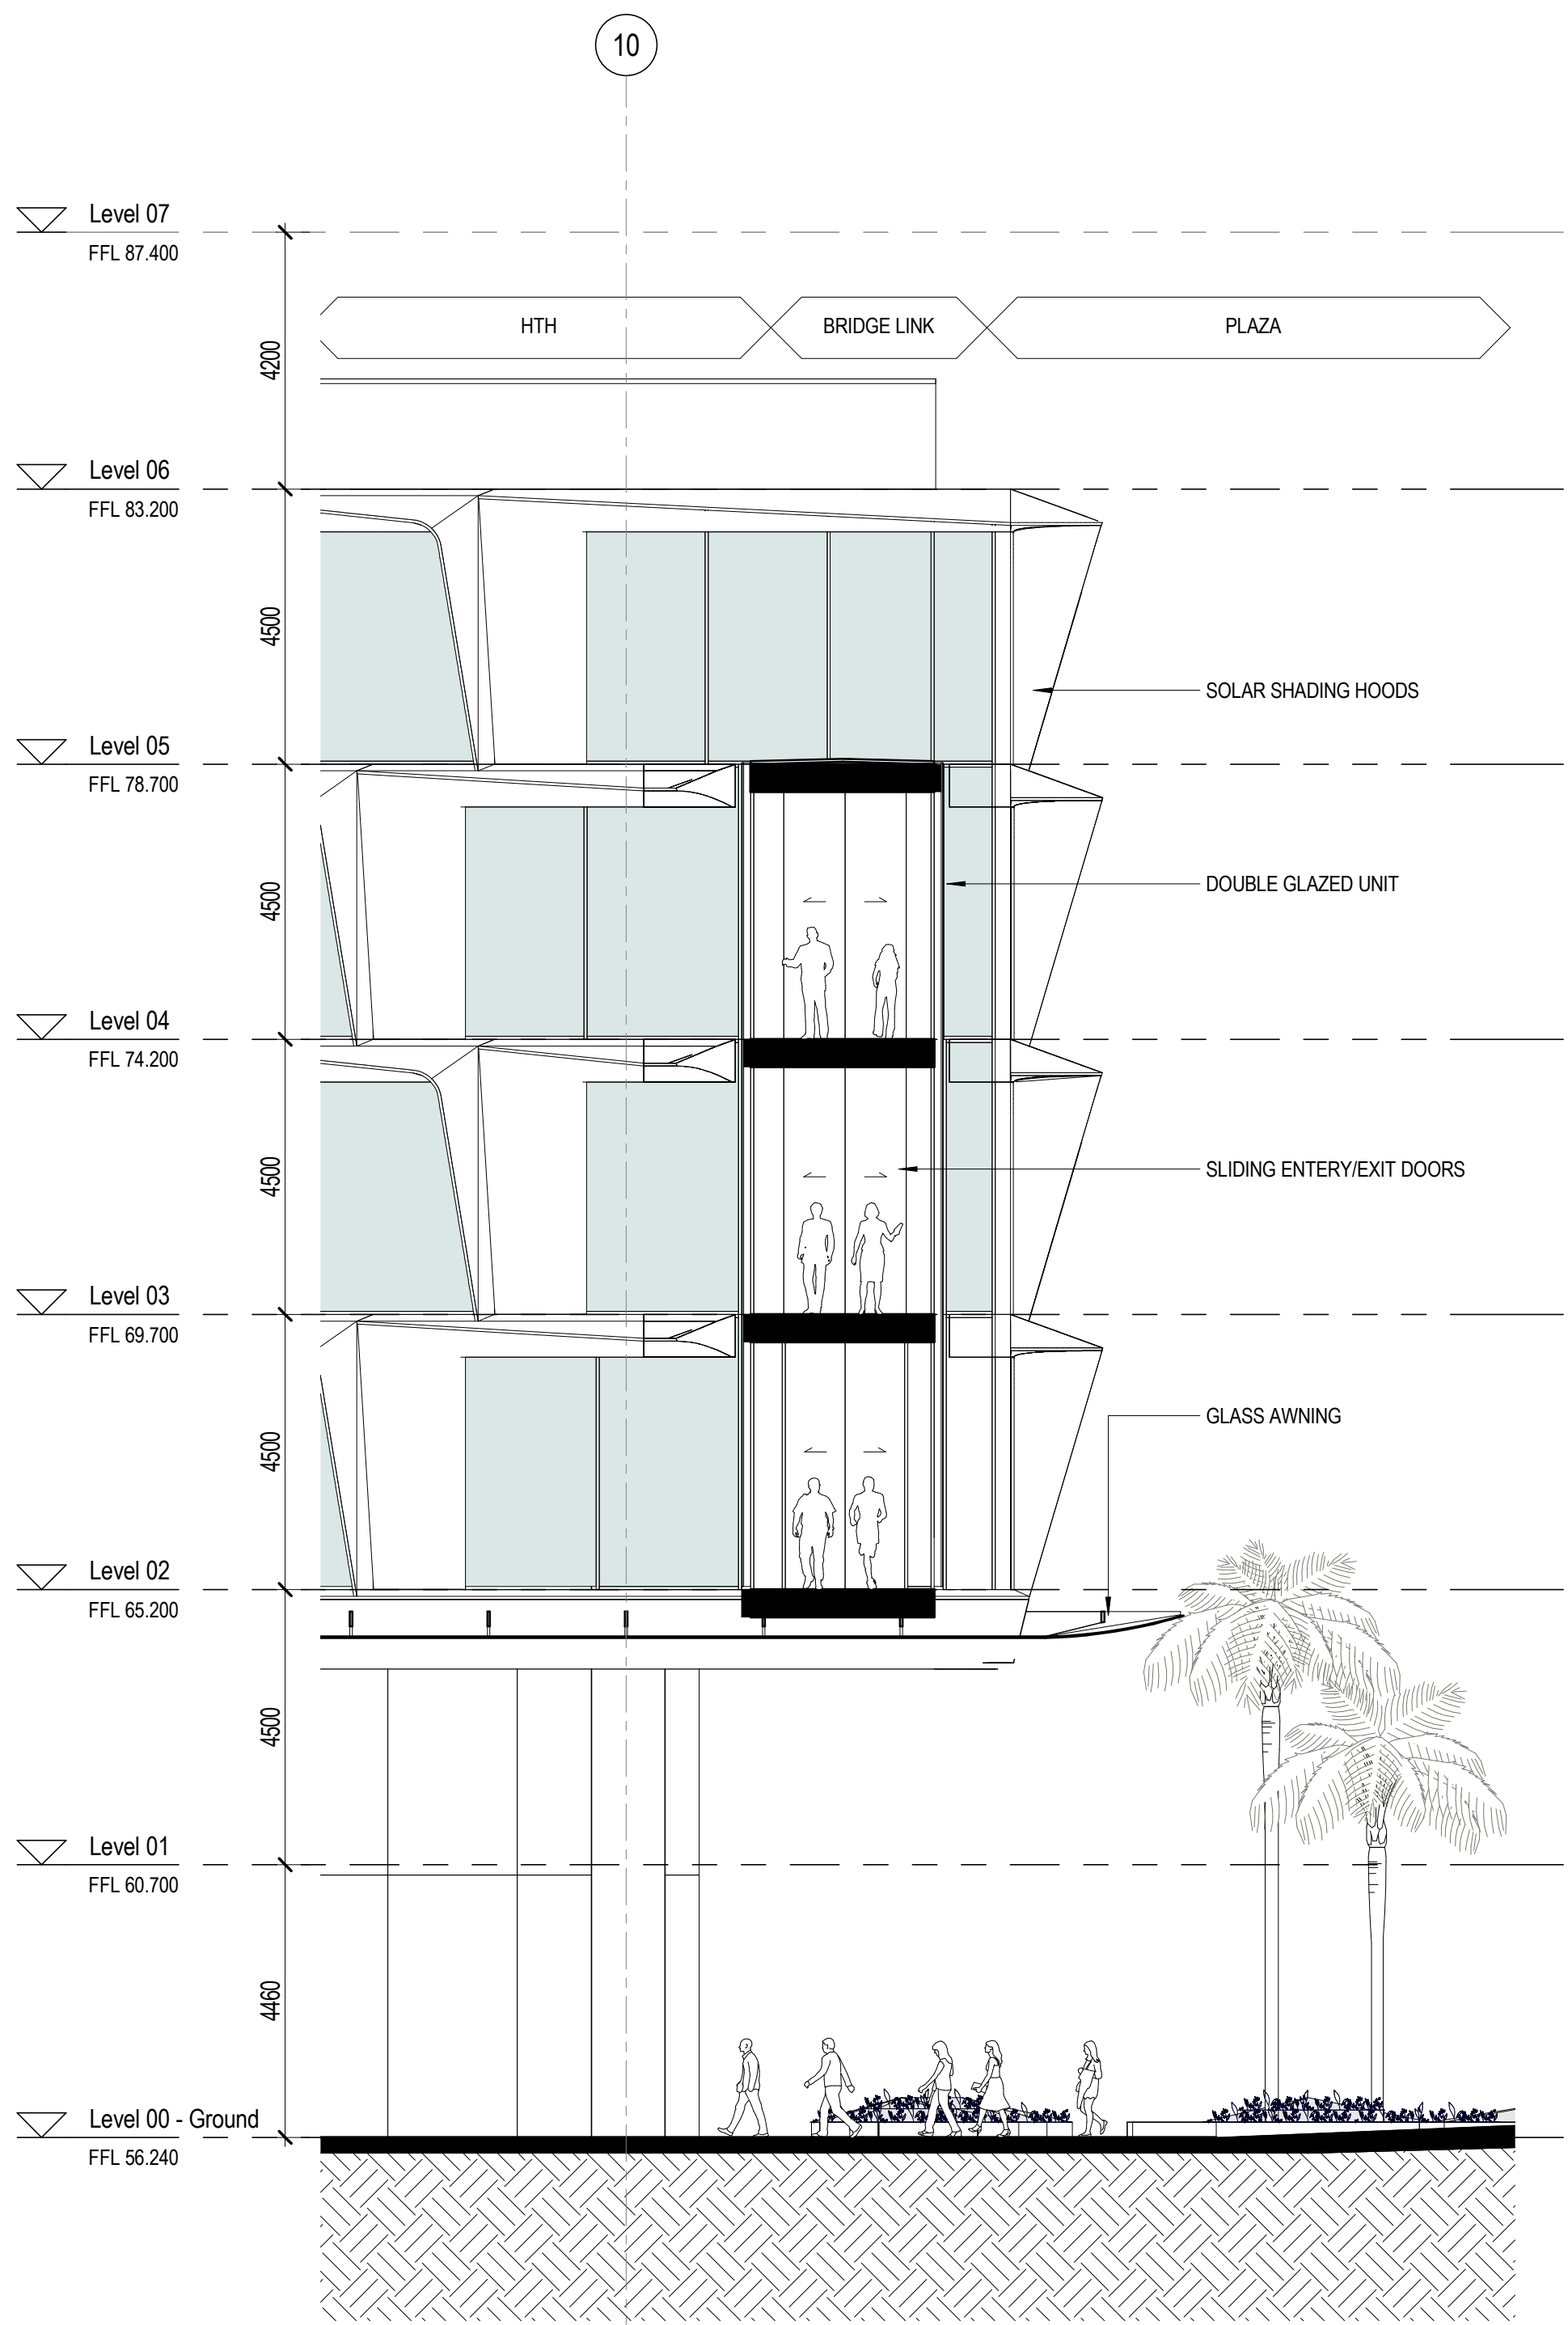

2 SCH Bridge Section_Short
DA5000 SCALE: 1 : 100

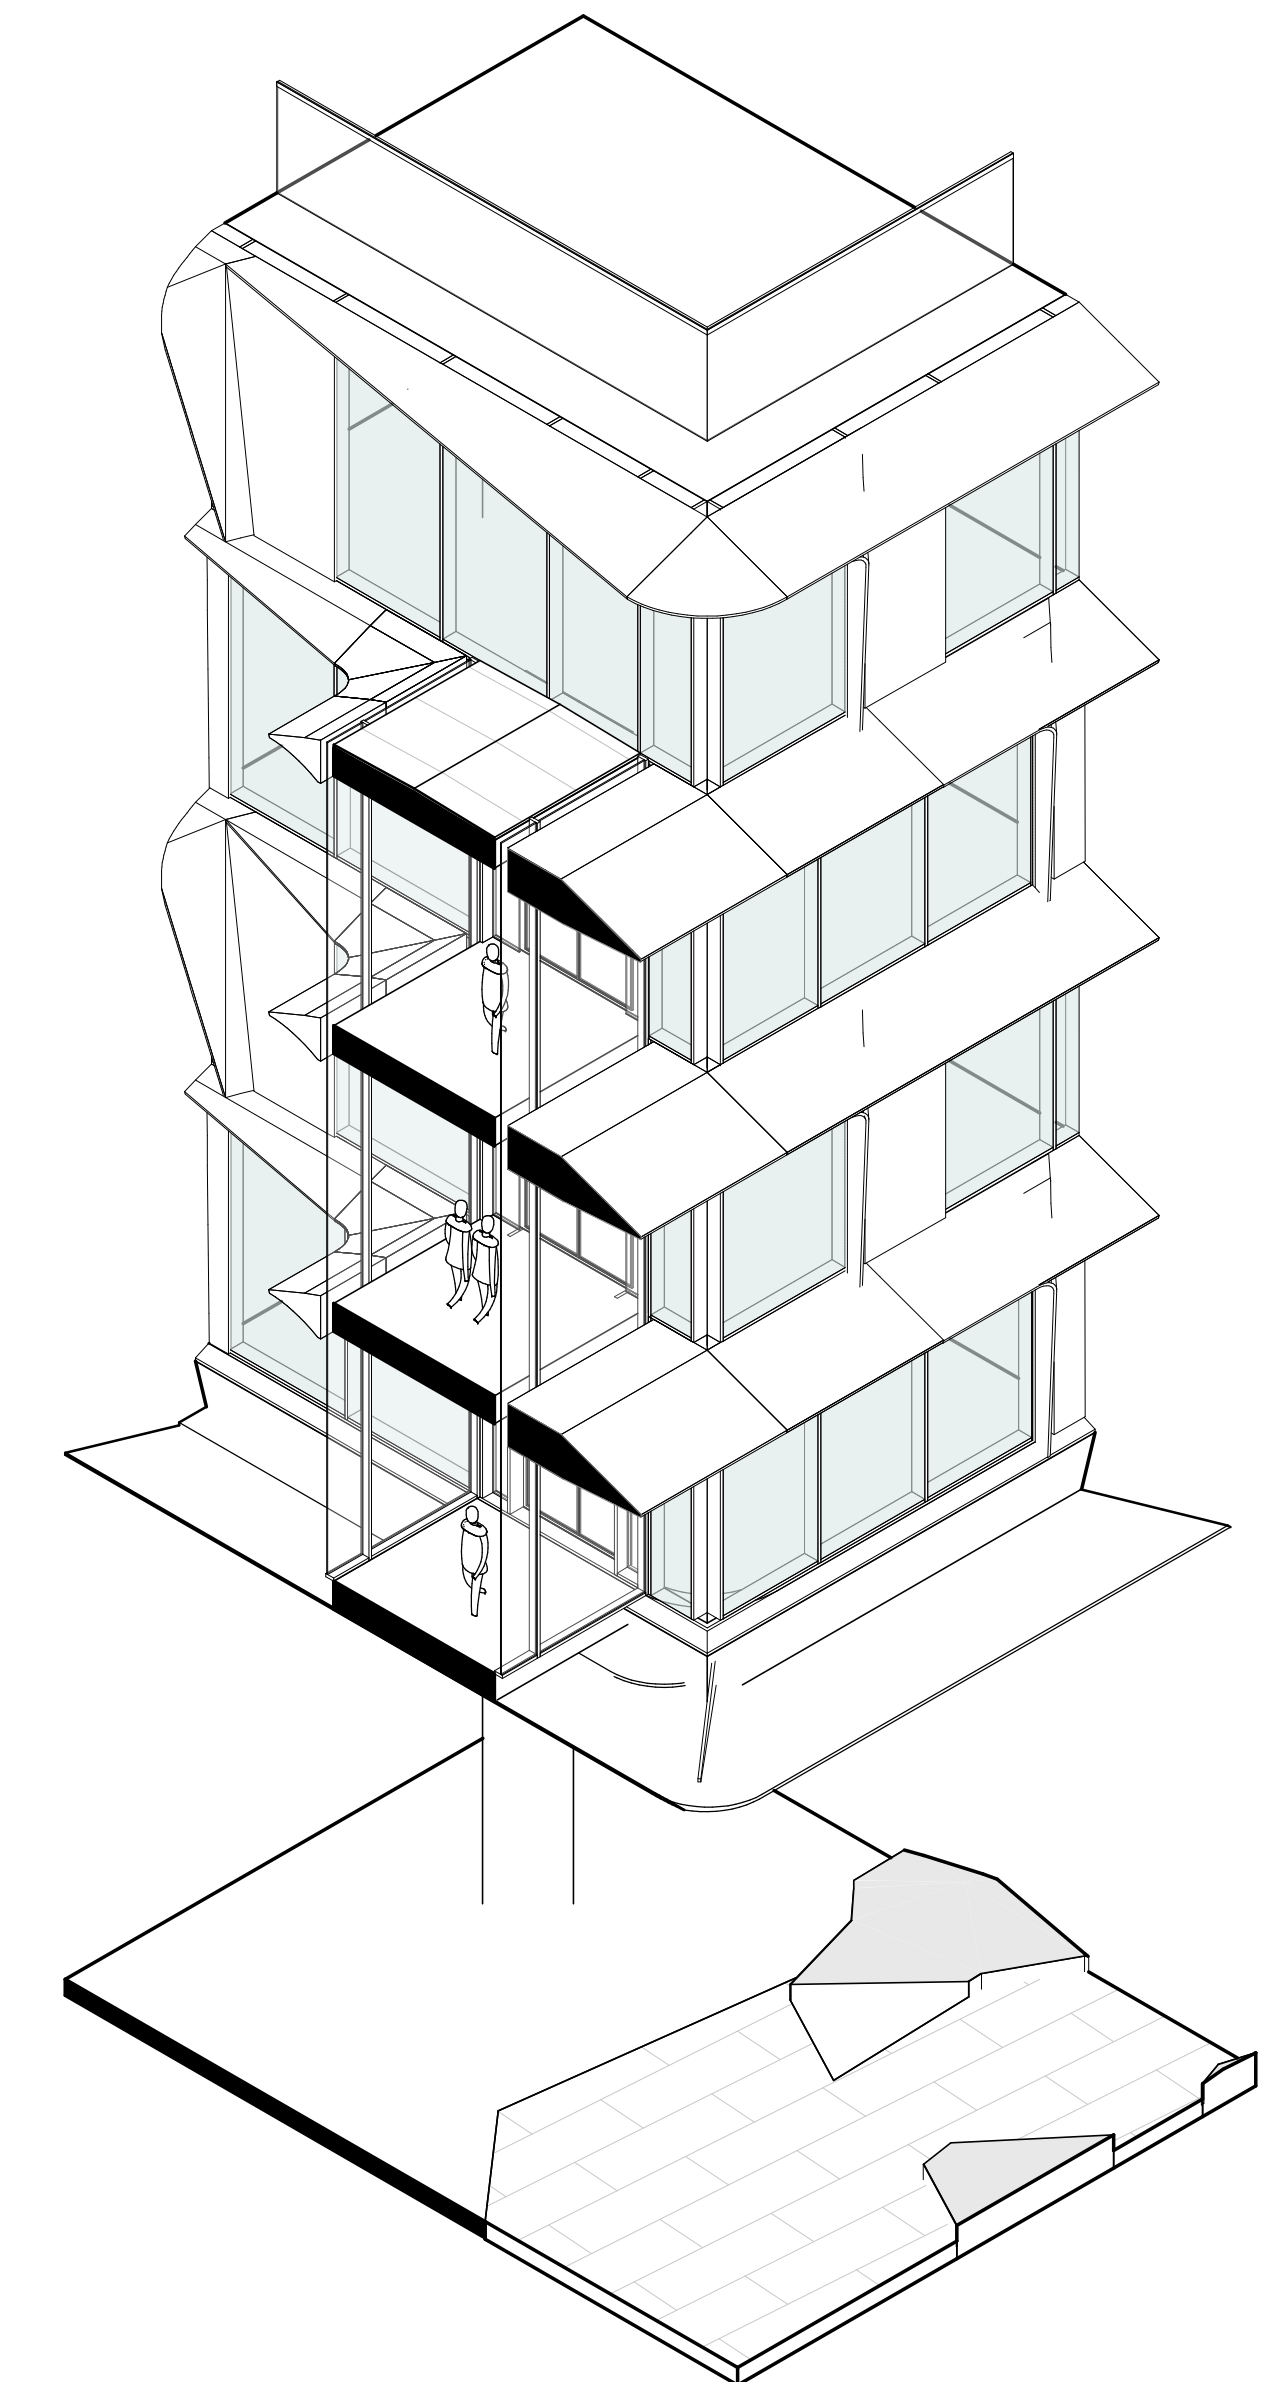

3 3D Axo SCH Bridge
SCALE:

architectus™

Architectus Australia Pty Ltd is the owner of the copyright subsisting in these drawings, plans, designs and specifications. They must not be used, reproduced or copied, in whole or in part, nor may the information, ideas and concepts therein contained (which are confidential to Architectus Australia Pty Ltd) be disclosed to any person without the prior written consent of that company.

Nominated Architect
Ray Brown, NSWARB 6359

Do not scale drawings. Verify all dimensions on site

issue	amendment	date
A	ISSUED FOR STATE SIGNIFICANT DEVELOPMENT APPLICATION	18.02.21

GENERAL NOTES:

- DO NOT SCALE FROM THE DRAWINGS. USE ONLY FIGURED DIMENSIONS.
- ALL DIMENSIONS ARE IN MILLIMETRES UNLESS OTHERWISE STATED.
- REDUCED LEVELS (RL) ARE TO AUSTRALIAN HEIGHT DATUM (AHD).
- COORDINATES ARE TO MAP GRID AUSTRALIA (MGA).
- THE ARCHITECTURAL DOCUMENTATION IS ONLY ALLOWED TO BE USED FOR THE PURPOSE FOR WHICH IT WAS COMMISSIONED. UNAUTHORISED USE OF THE DOCUMENTATION IS PROHIBITED.

Scale:

1:100 @ A1
1:200 @ A3

0 1 2 3

architectus™

UNSW SYDNEY

ABN 90 131 245 684

project


UNSW Health Translation Hub

drawing

SCH - Bridge Connection - Section

scale	1 : 100@A1	drawing no.
drawn	HD	DA5766
checked	JC	issue
project no	190551.00	A

22/02/2021 6:28:56 PM

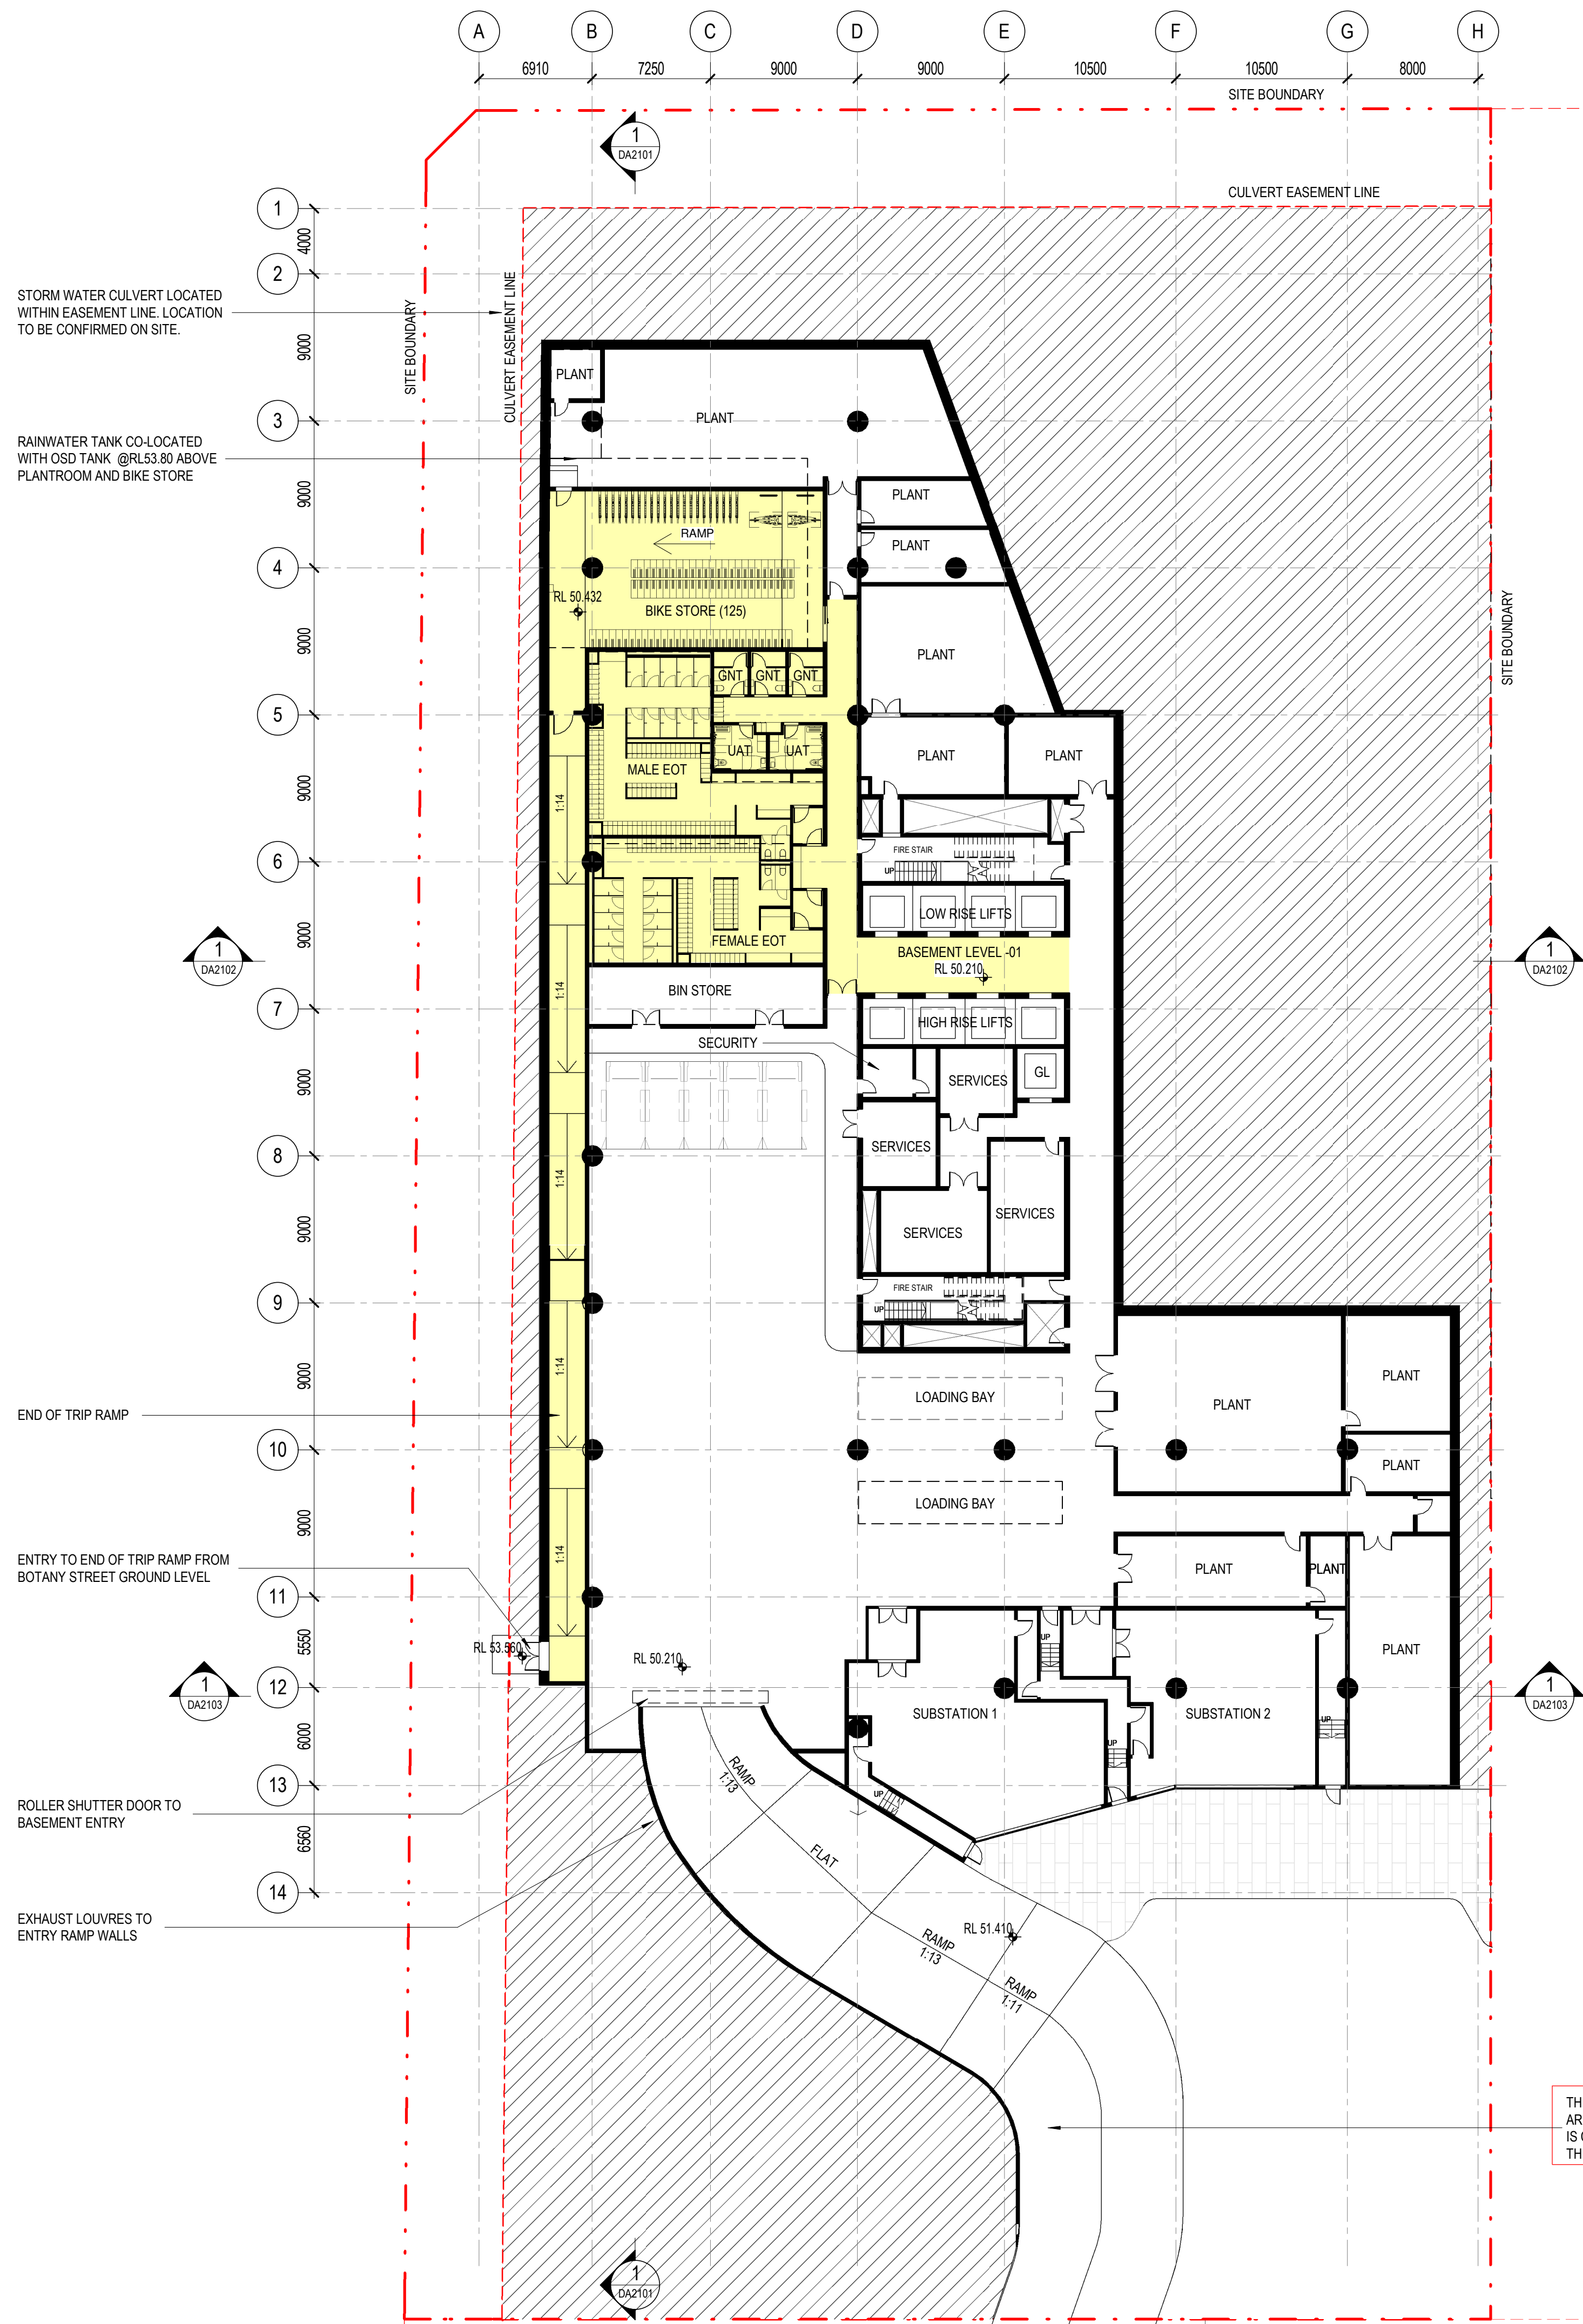

architectus™

Architectus Australia Pty Ltd is the owner of the copyright subsisting in these drawings, plans, designs and specifications. They must not be used, reproduced or copied, in whole or in part, nor may the information, ideas and concepts therein contained (which are confidential to Architectus Australia Pty Ltd) be disclosed to any person without the prior written consent of that company.

Nominated Architect
Ray Brown, NSWARB 6359

Do not scale drawings. Verify all dimensions on site

issue	amendment	date
A	ISSUED FOR STATE SIGNIFICANT DEVELOPMENT APPLICATION	18.02.21

GENERAL NOTES:

- DO NOT SCALE FROM THE DRAWINGS. USE ONLY FIGURED DIMENSIONS.
- ALL DIMENSIONS ARE IN MILLIMETRES UNLESS OTHERWISE STATED.
- REDUCED LEVELS (RL) ARE TO AUSTRALIAN HEIGHT DATUM (AHD).
- COORDINATES ARE TO MAP GRID AUSTRALIA (MGA).
- THE ARCHITECTURAL DOCUMENTATION IS ONLY ALLOWED TO BE USED FOR THE PURPOSE FOR WHICH IT WAS COMMISSIONED. UNAUTHORISED USE OF THE DOCUMENTATION IS PROHIBITED.

ROAD INFRASTRUCTURE LEGEND

- EOT FACILITY AREAS

Scale:

1:250 @ A1
1:500 @ A3

0 2.5 5 7.5 10

architectus™

UNSW SYDNEY

ABN 90 131 245 684

project

UNSW Health Translation Hub

drawing

Independent Basement Plan


scale 1 : 250@A1 drawing no. DA9100

drawn TH

checked JC issue

project no 190551.00

18/02/2021 1:20:15 PM

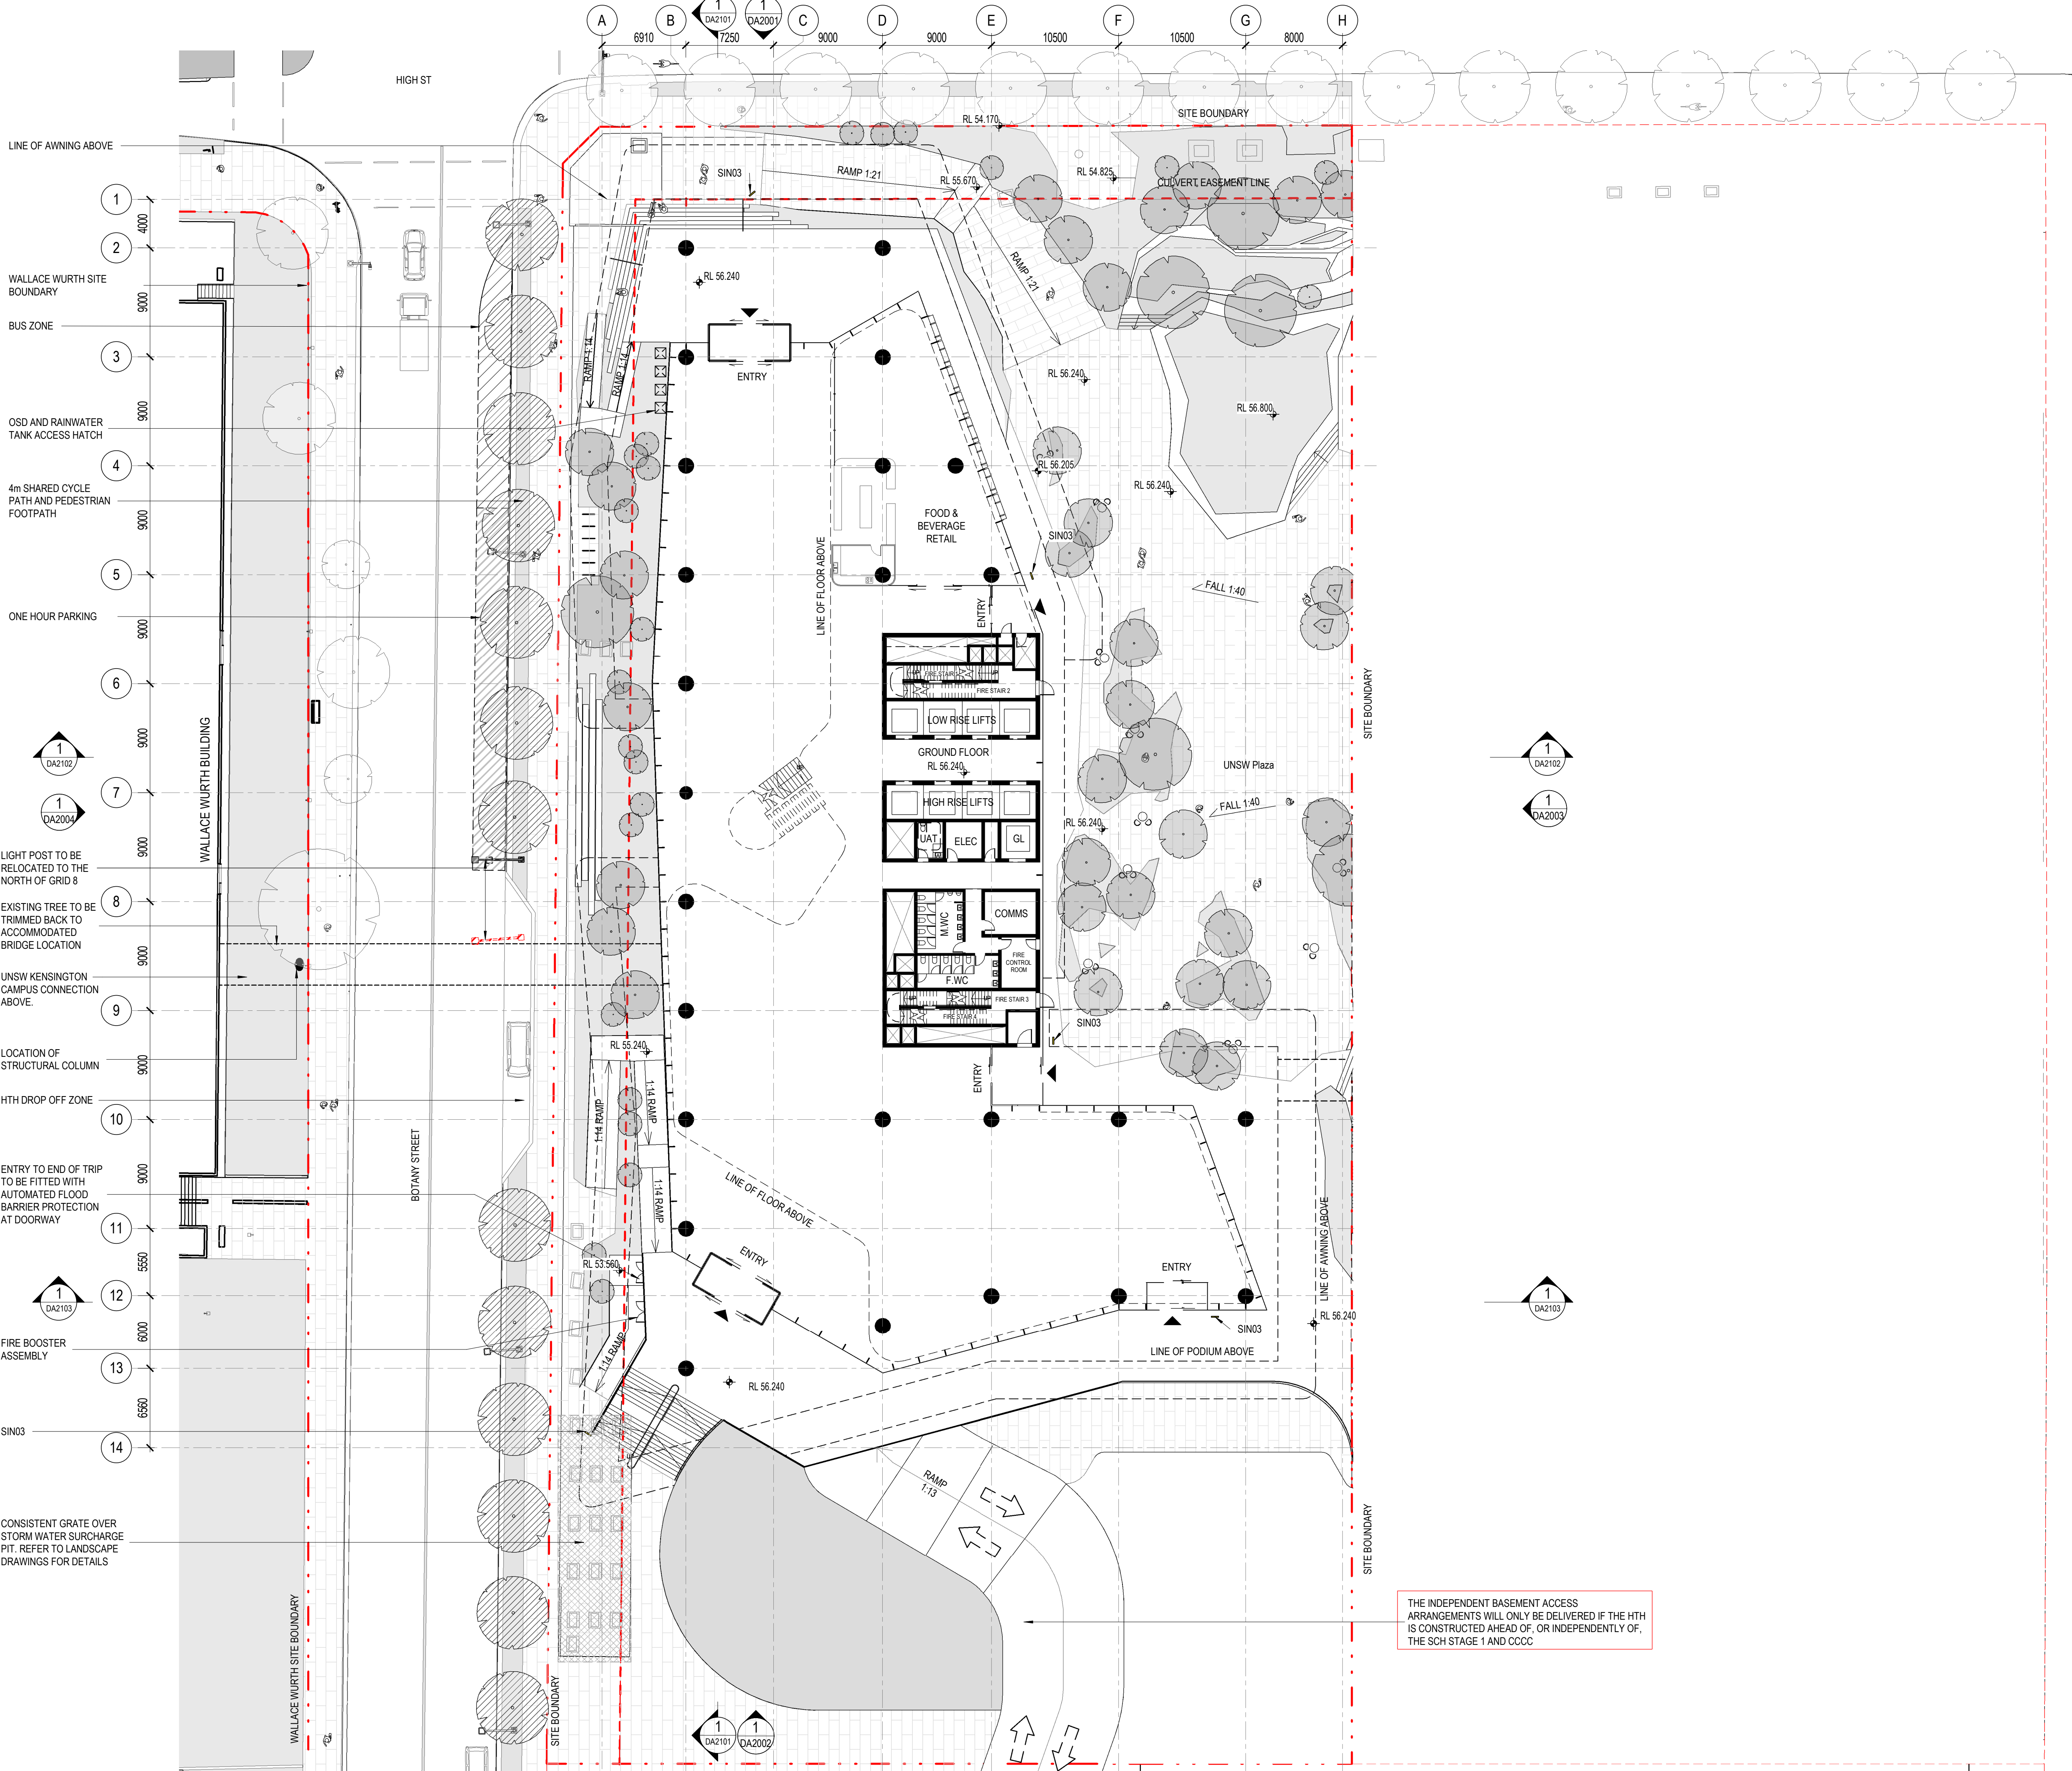

architectus™

Architectus Australia Pty Ltd is the owner of the copyright subsisting in these drawings, plans, designs and specifications. They must not be used, reproduced or copied, in whole or in part, nor may the information, ideas and concepts therein contained (which are confidential to Architectus Australia Pty Ltd) be disclosed to any person without the prior written consent of that company.

Nominated Architect
Ray Brown, NSWARB 6359

Do not scale drawings. Verify all dimensions on site


issue	amendment	date
A	ISSUED FOR STATE SIGNIFICANT DEVELOPMENT APPLICATION	18.02.21

GENERAL NOTES:

- DO NOT SCALE FROM THE DRAWINGS. USE ONLY FIGURED DIMENSIONS.
- ALL DIMENSIONS ARE IN MILLIMETRES UNLESS OTHERWISE STATED.
- REDUCED LEVELS (RL) ARE TO AUSTRALIAN HEIGHT DATUM (AHD).
- COORDINATES ARE TO MAP GRID AUSTRALIA (MGA).
- THE ARCHITECTURAL DOCUMENTATION IS ONLY ALLOWED TO BE USED FOR THE PURPOSE FOR WHICH IT WAS COMMISSIONED. UNAUTHORISED USE OF THE DOCUMENTATION IS PROHIBITED.

LEGEND

SIN03 - STREET LEVEL DIRECTIONAL SIGN

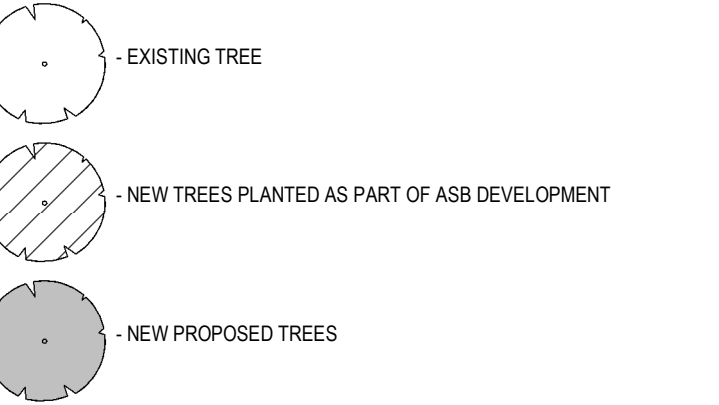

Scale:

1:250 @ A1
1:500 @ A3

0 2.5 5 7.5 10

architectus™

UNSW SYDNEY

ABN 90 131 245 684

project


UNSW Health Translation Hub

drawing


Independent Ground Floor Plan

scale	1 : 250@A1	drawing no.	DA9101
drawn	TH	issue	
checked	JC		
project no	190551.00		A


18/02/2021 1:20:41 PM

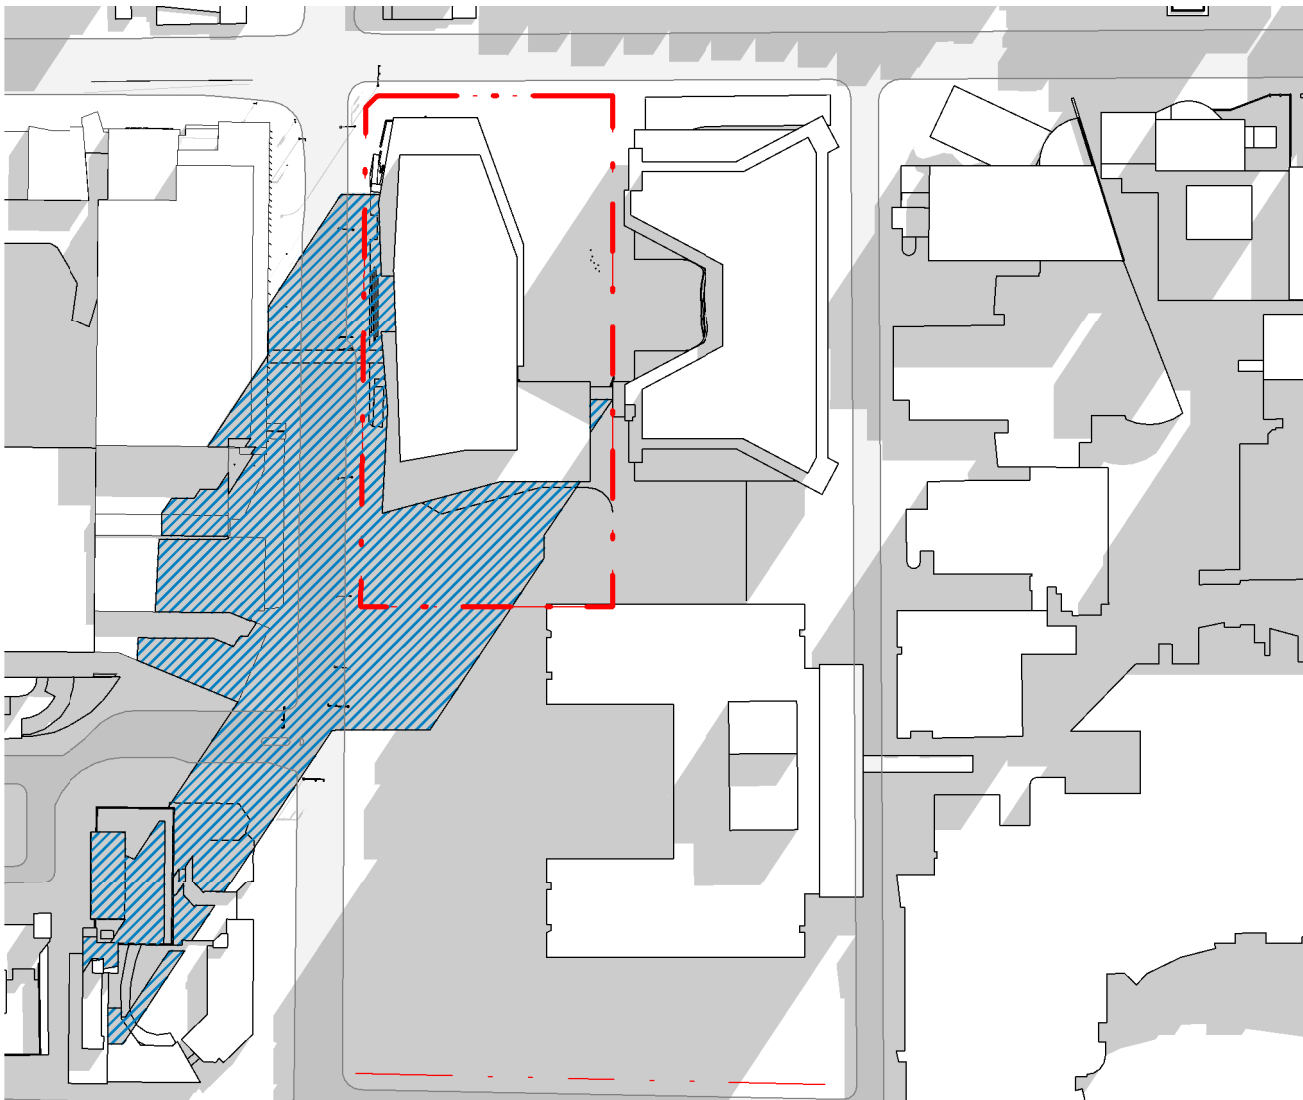


1 Winter Solstice - 9am
SCALE: 1:2000

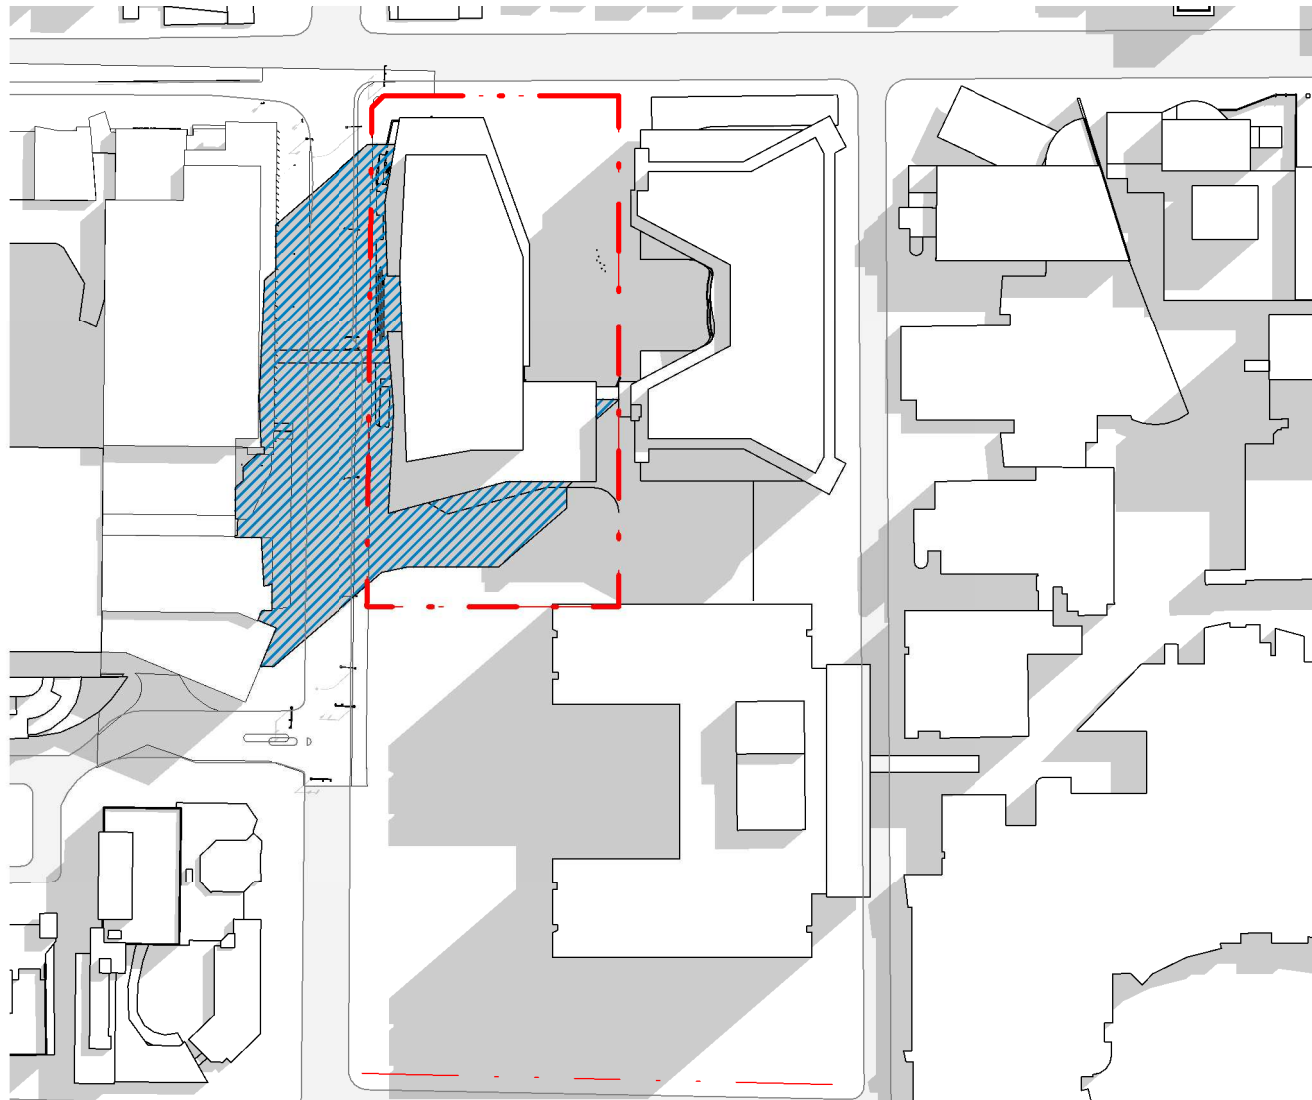


4 Equinox - 9am
SCALE: 1:2000

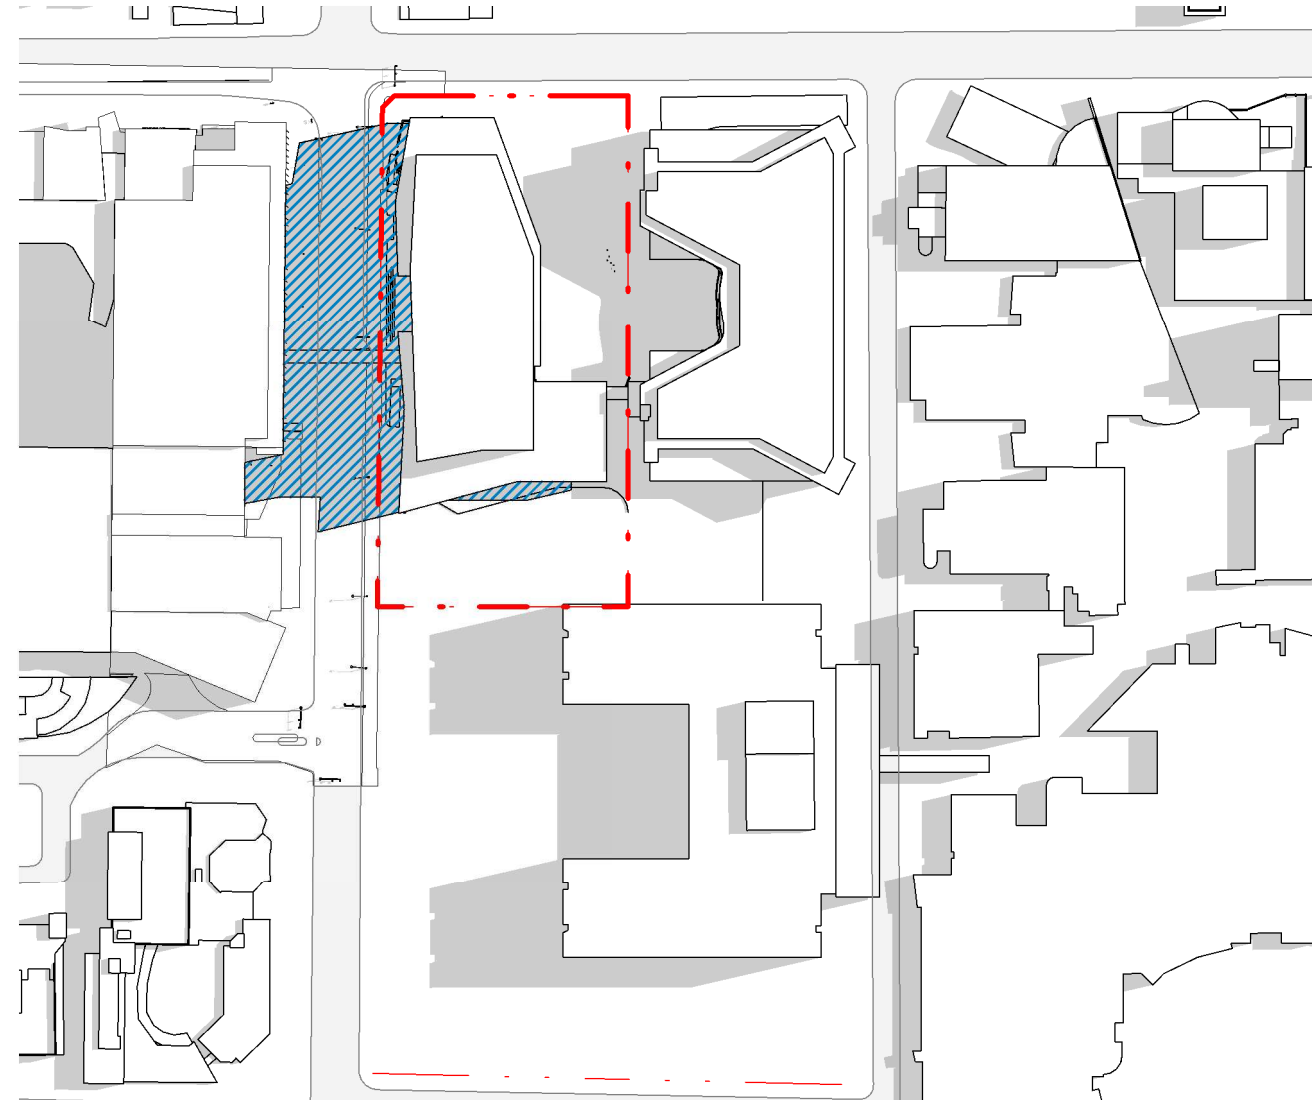


7 Summer Solstice - 9am
SCALE: 1:2000

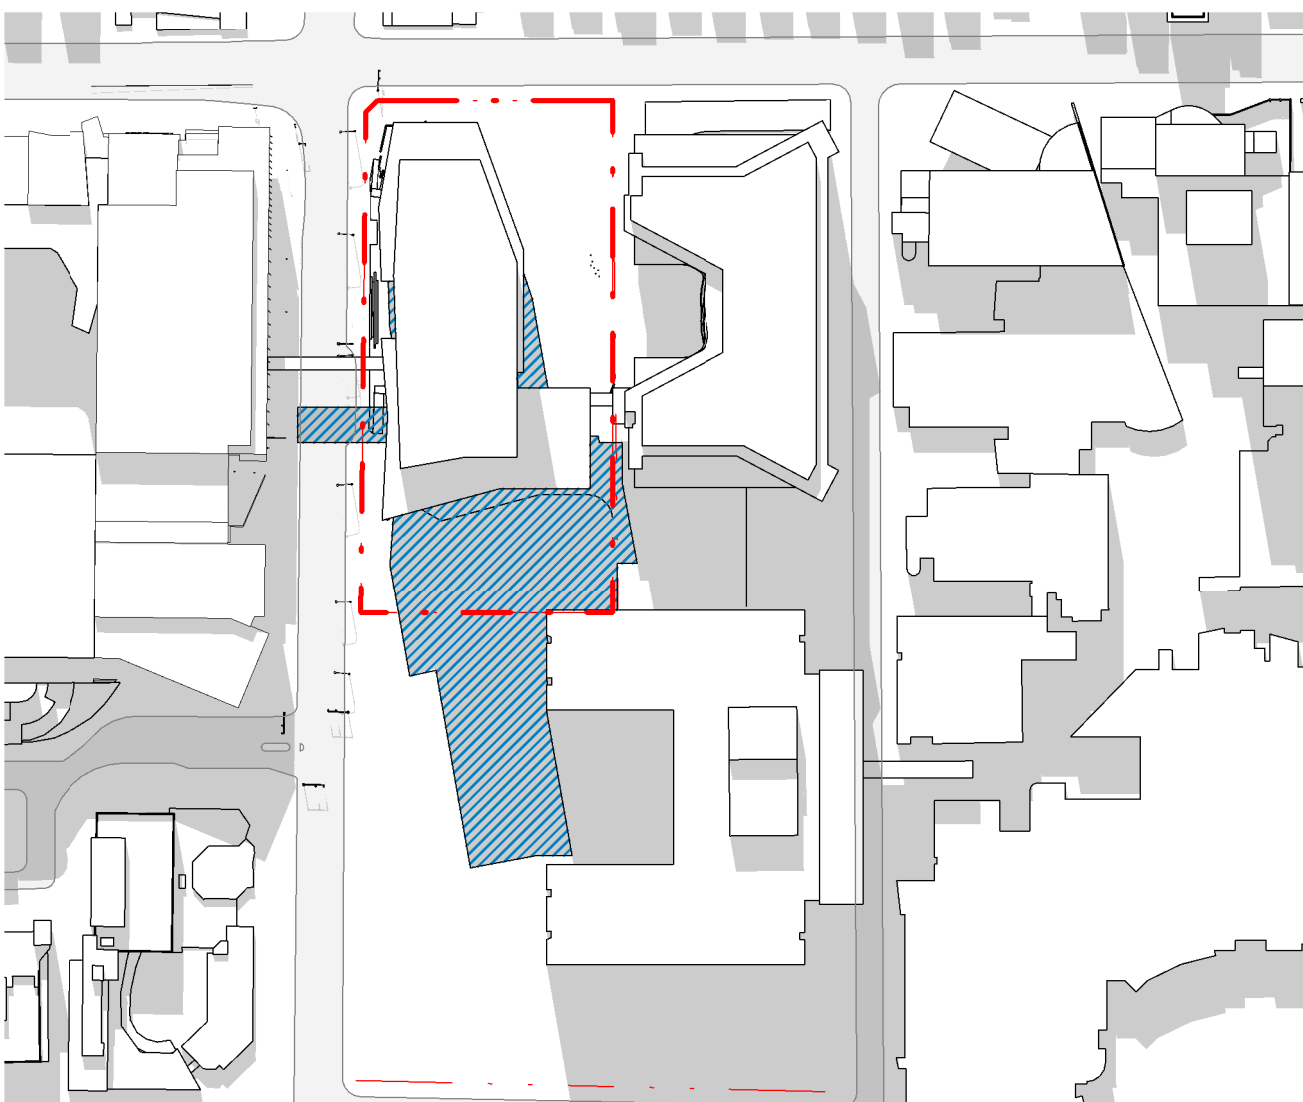


2 Winter Solstice - 12pm
SCALE: 1:2000

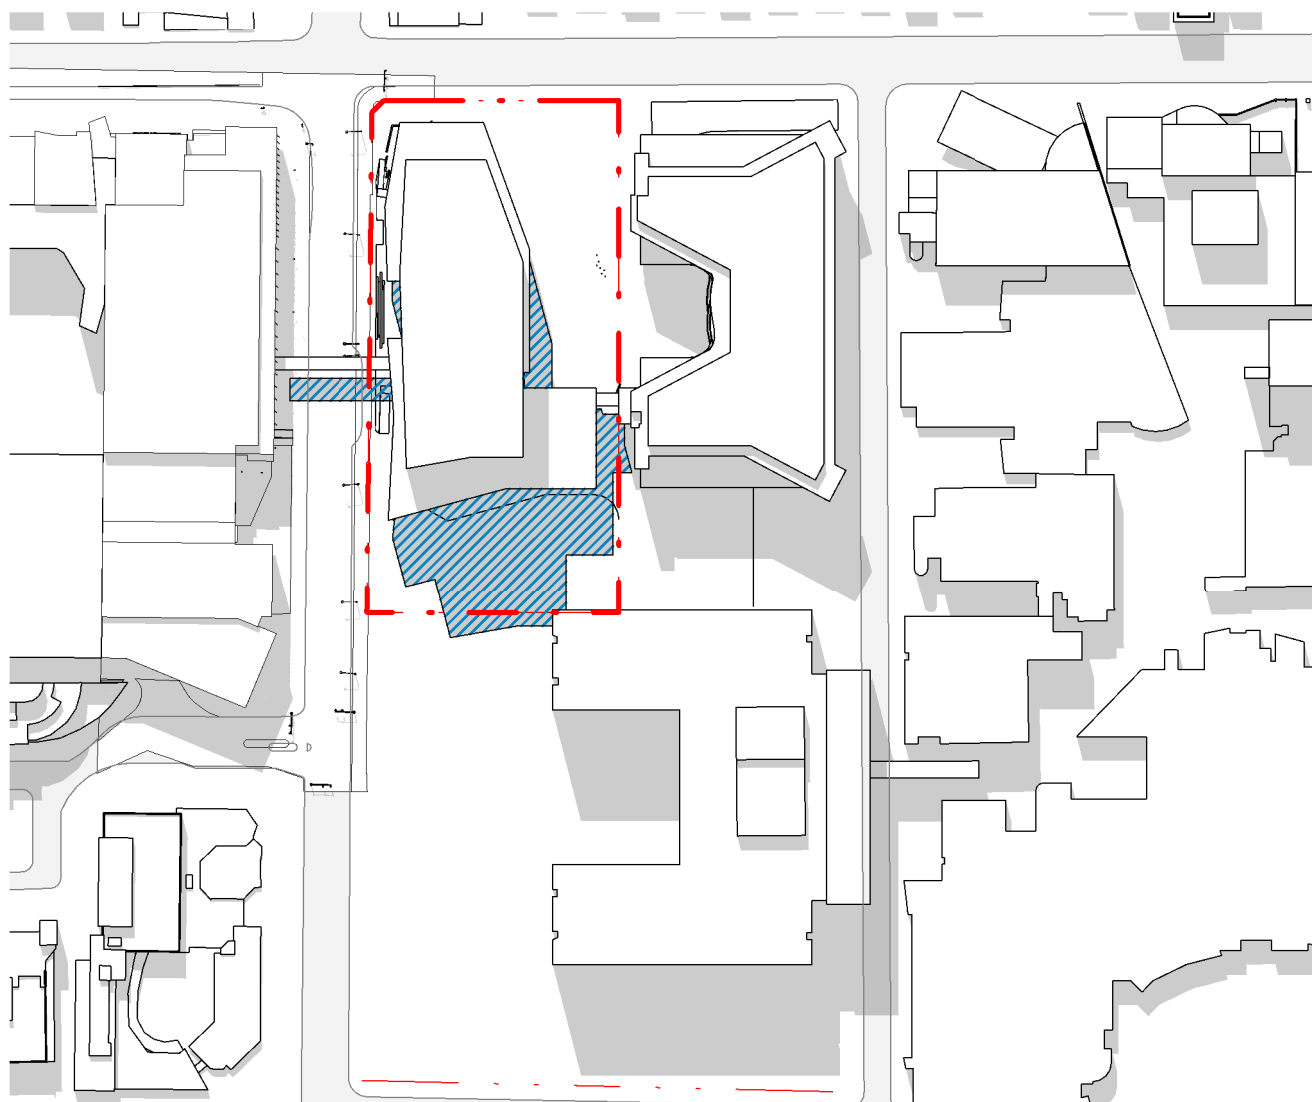


5 Equinox - 12pm
SCALE: 1:2000

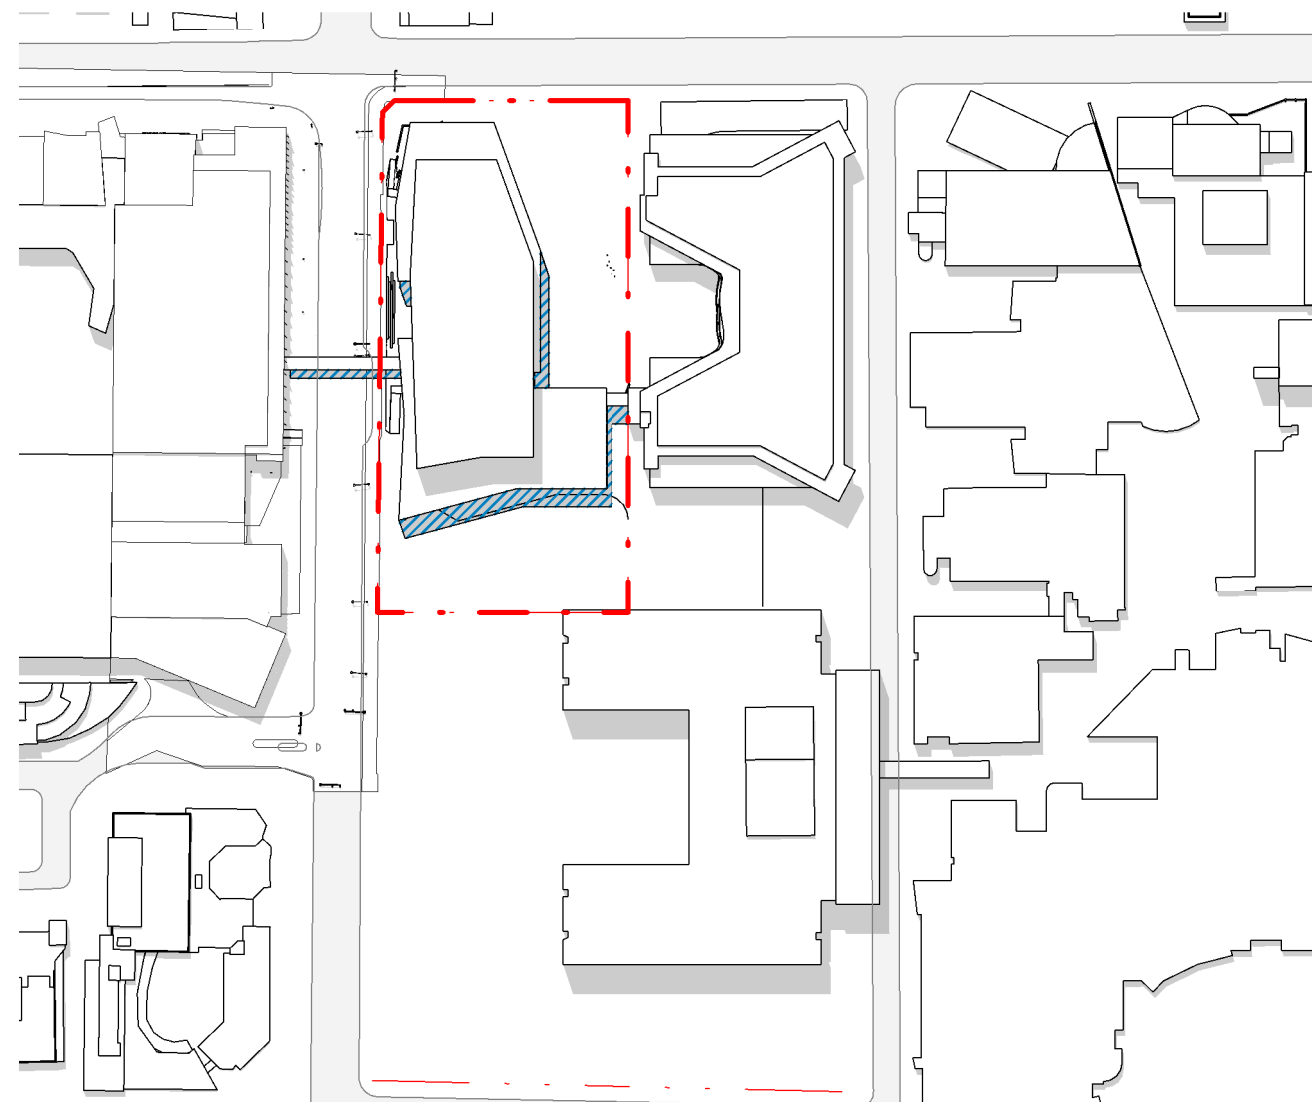


8 Summer Solstice - 12pm
SCALE: 1:2000

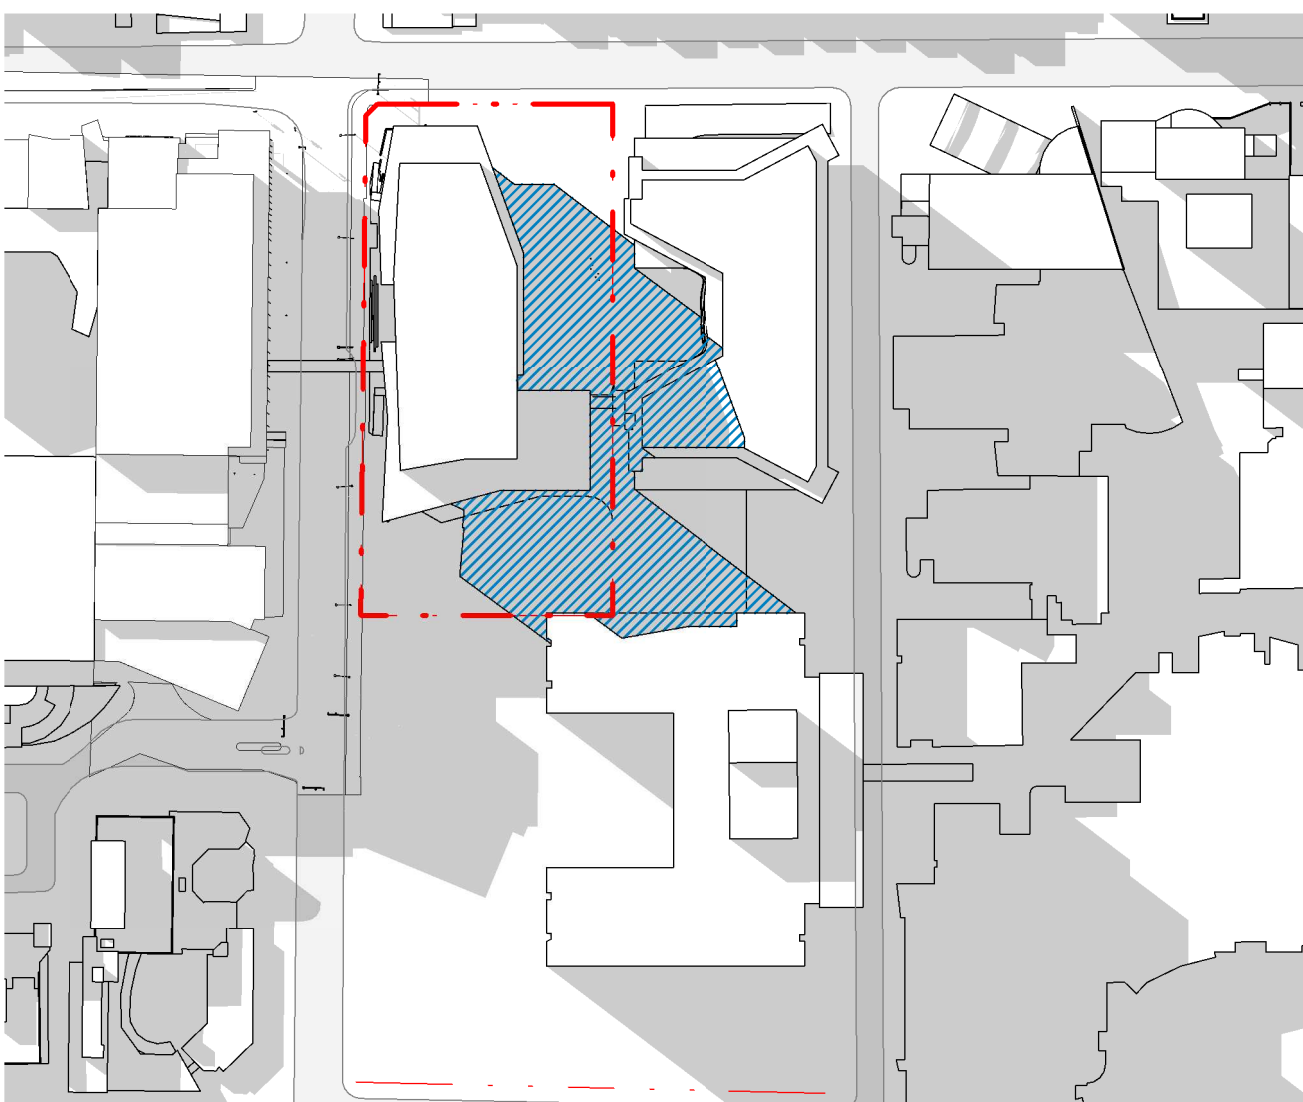

3 Winter Solstice - 3pm
SCALE: 1:2000

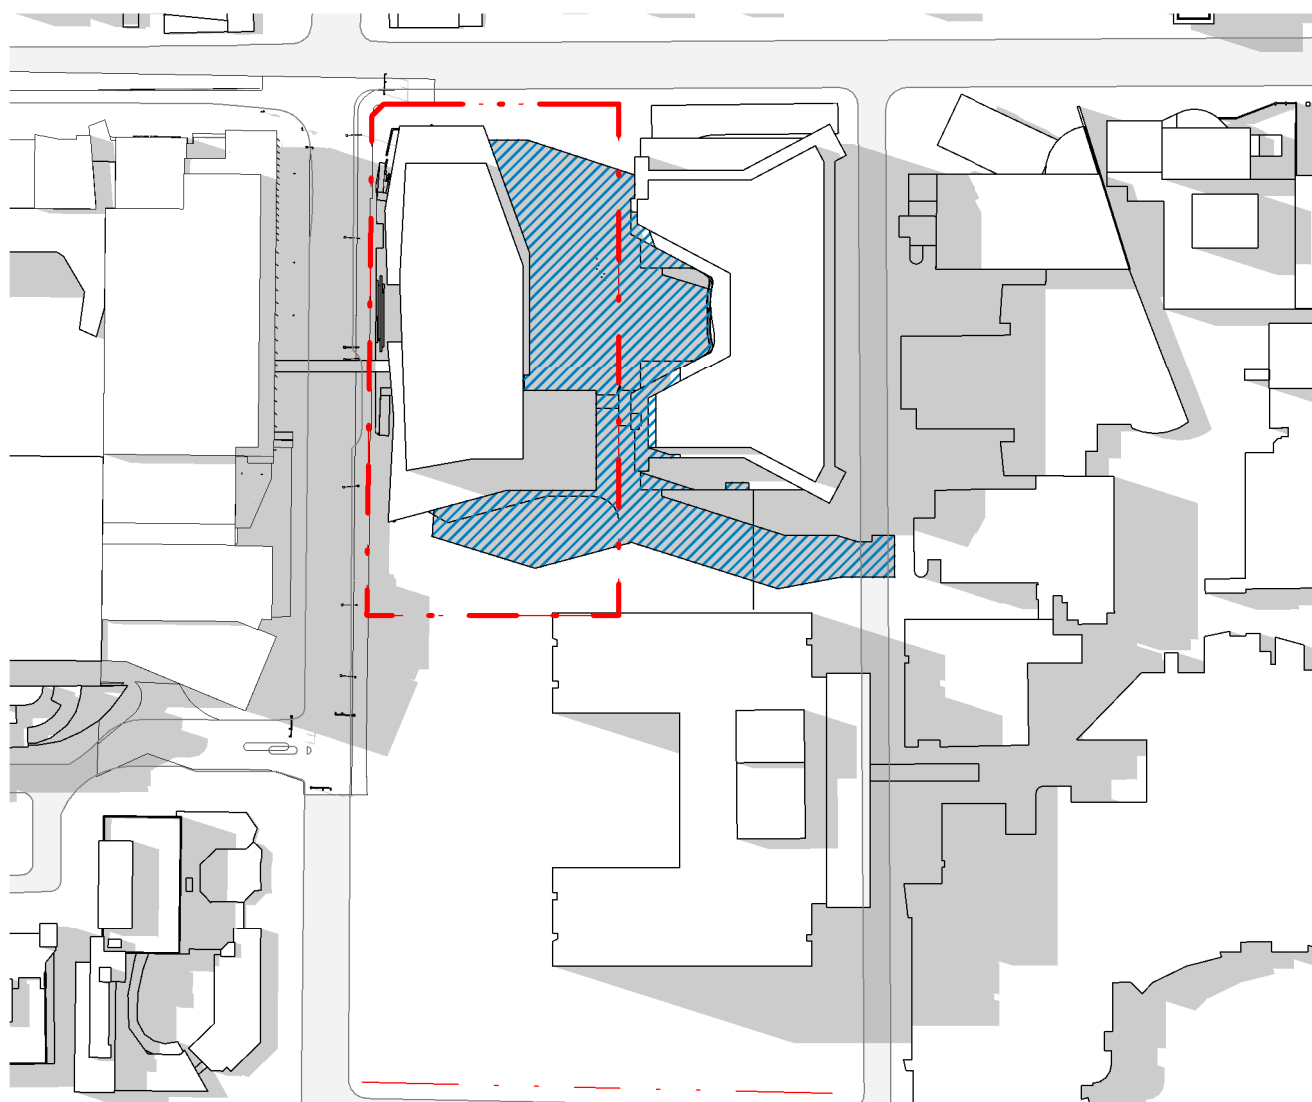

6 Equinox - 3pm
SCALE: 1:2000

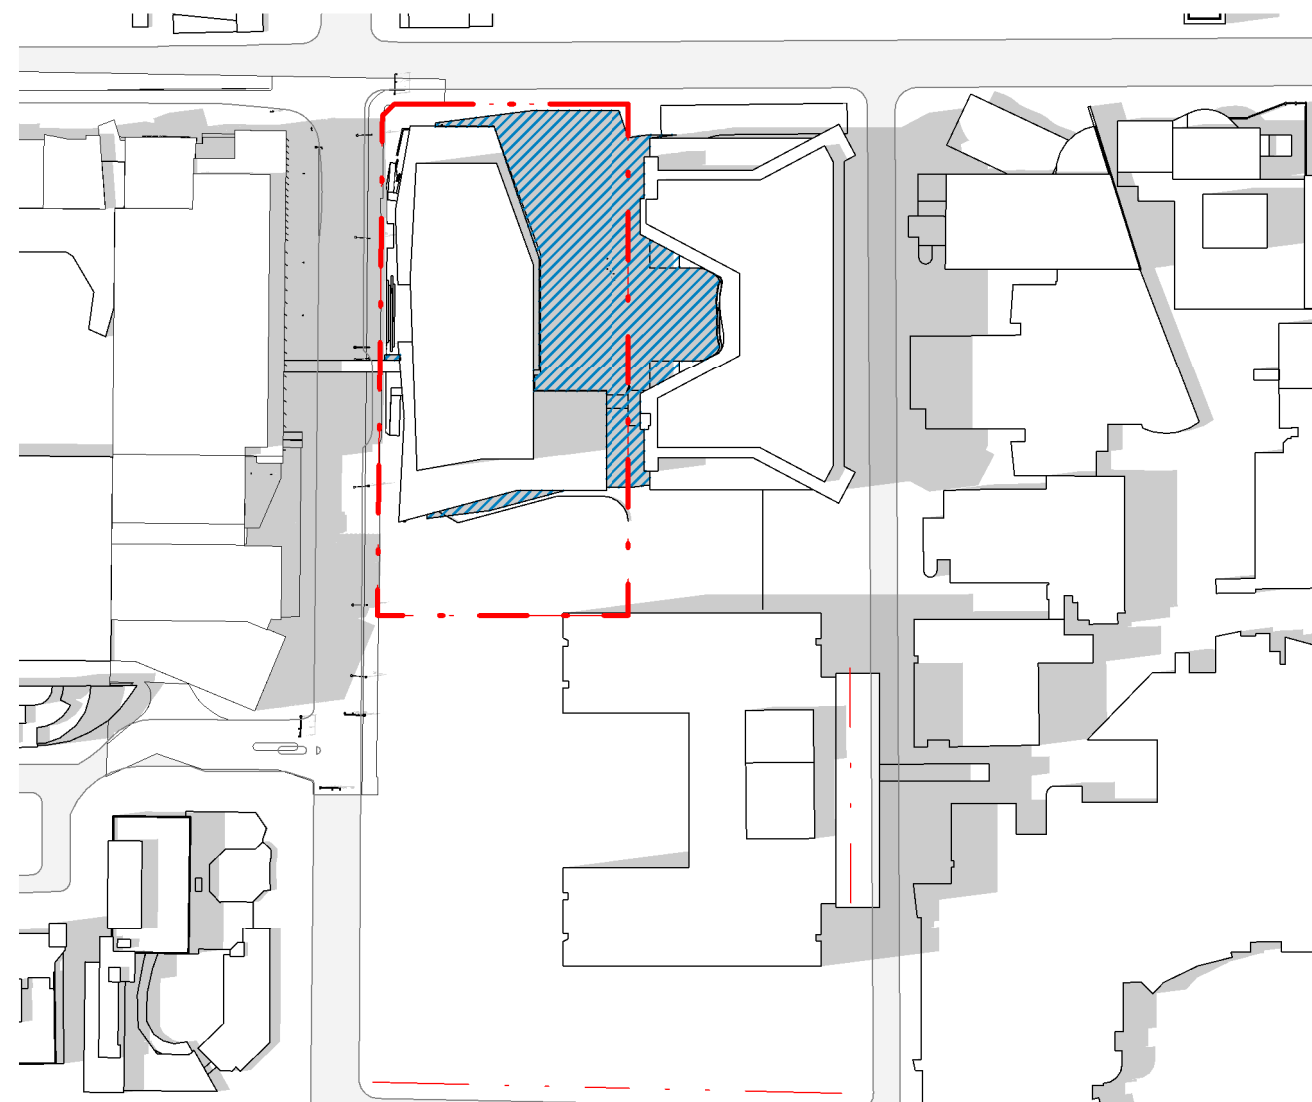

9 Summer Solstice - 3pm
SCALE: 1:2000


issue	amendment	date
A	ISSUED FOR STATE SIGNIFICANT DEVELOPMENT APPLICATION	12.02.21

GENERAL NOTES:

- DO NOT SCALE FROM THE DRAWINGS. USE ONLY FIGURED DIMENSIONS.
- ALL DIMENSIONS ARE IN MILLIMETRES UNLESS OTHERWISE STATED.
- REDUCED LEVELS (RL) ARE TO AUSTRALIAN HEIGHT DATUM (AHD).
- COORDINATES ARE TO MAP GRID AUSTRALIA (MGA).
- THE ARCHITECTURAL DOCUMENTATION IS ONLY ALLOWED TO BE USED FOR THE PURPOSE FOR WHICH IT WAS COMMISSIONED. UNAUTHORISED USE OF THE DOCUMENTATION IS PROHIBITED.

LEGEND

SHADOWS CAST BY UNSW HTH BUILDING

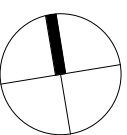

architectus™




ABN 90 131 245 684

project
UNSW Health Translation Hub

drawing

Shadow Analysis

scale	As indicated@A1-	drawing no.
drawn	TH	DA9200
checked	JC	issue
project no	190551.00	A

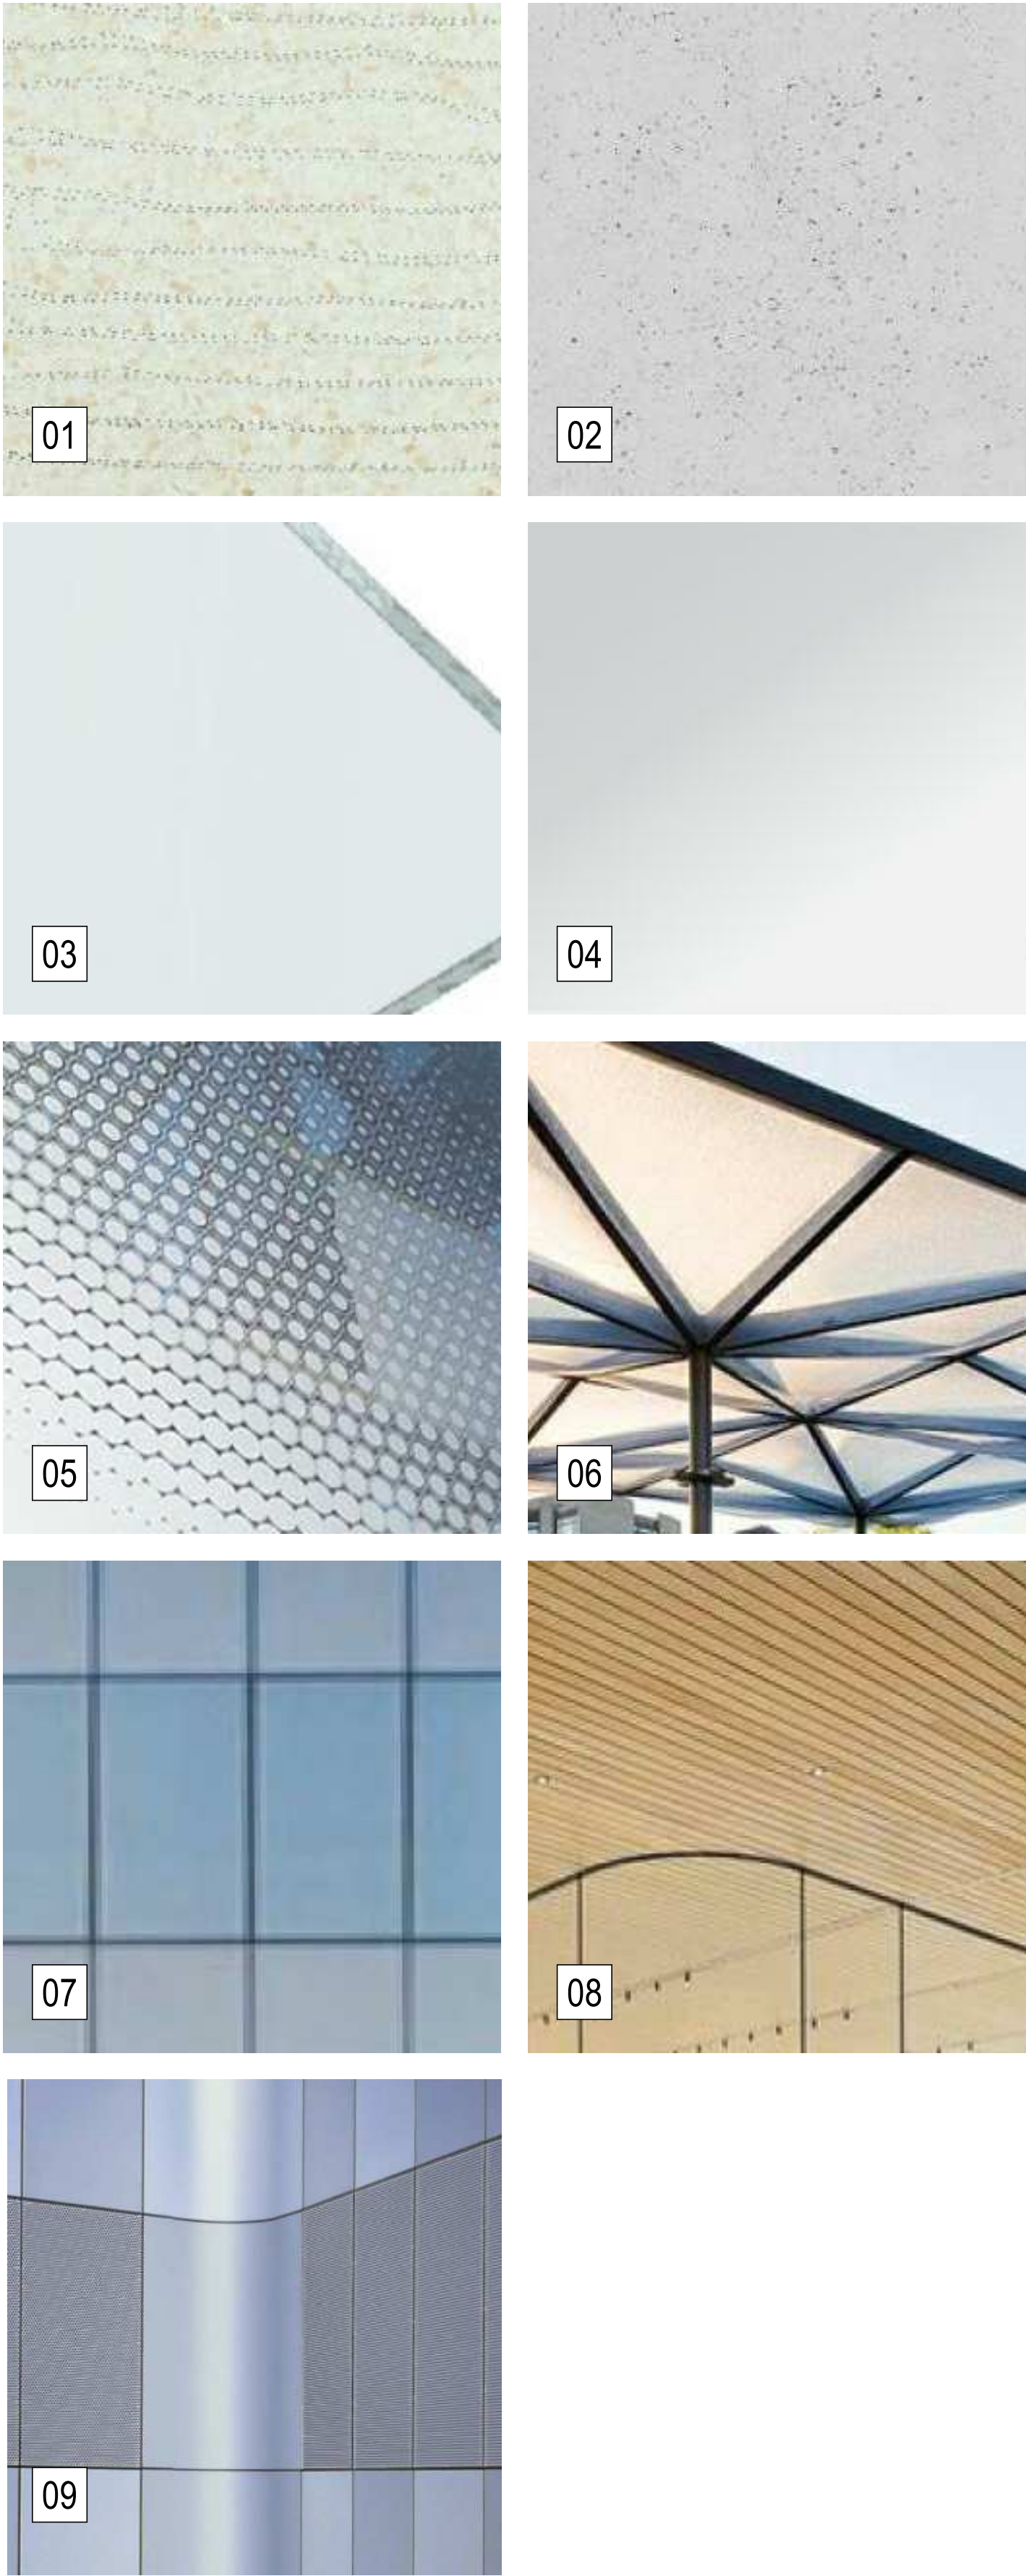

NOTE: SAMPLES ARE
INDICATIVE ONLY



TAG		MATERIAL
01	SHD, SP1	SOLID COMPOSITE MATERIAL SOLAR HOODS
02	CON	CONCRETE COLUMNS
03	GL01, GL03, GL04, GL05, BAL	CLEAR VISION GLASS
04	GL01, GL03, GL04, GL05	WINDOW & DOOR PROFILES
05	AWN	GLASS AWNING - GRADIENT FRIT
06	AWN	GLASS AWNING - LIGHTING
07	GL02/SP2	VISION GLAZING & BACKPAN
08	AWN	SOFFIT - WARM & TACTILE PANELLING
09	LV1	ANODIZED MECHANICAL LOUVRE/GRILL WITH EXTERNAL MESH SCREEN


architectus		
Architectus Australia Pty Ltd is the owner of the copyright subsisting in these drawings, plans, designs and specifications. They must not be used, reproduced or copied, in whole or in part, nor may the information, ideas and concepts therein contained (which are confidential to Architectus Australia Pty Ltd) be disclosed to any person without the prior written consent of that company.		
Nominated Architect Ray Brown, NSWARB 6359		
Do not scale drawings. Verify all dimensions on site		
issue	amendment	date
A	ISSUED FOR STATE SIGNIFICANT DEVELOPMENT APPLICATION	18.02.21

GENERAL NOTES:

- DO NOT SCALE FROM THE DRAWINGS. USE ONLY FIGURED DIMENSIONS.
- ALL DIMENSIONS ARE IN MILLIMETRES UNLESS OTHERWISE STATED.
- REDUCED LEVELS (RL) ARE TO AUSTRALIAN HEIGHT DATUM (AHD).
- COORDINATES ARE TO MAP GRID AUSTRALIA (MGA).
- THE ARCHITECTURAL DOCUMENTATION IS ONLY ALLOWED TO BE USED FOR THE PURPOSE FOR WHICH IT WAS COMMISSIONED. UNAUTHORISED USE OF THE DOCUMENTATION IS PROHIBITED.

- AWN – Glass Awning
- GL01 – Podium Double Glazed Unit
- GL02 – Tower Double Glazed Unit
- GL03 – Ground Floor & Atrium Double Glazed Unit
- GL04 – Glazed Door
- GL05 – Glazed Retail Door
- GL06 – Glazed Veil
- SHD – Solar Shading Hood
- SP1 – Solid Podium Spandrel Panel
- SP2 – Backpan Spandrel Panel
- LV1 – Anodized Mechanical Louvre/Grill with External Mesh screen
- CON – Concrete
- BAL – Balustrade
- SIN01 – Tower UNSW sign
- SIN02 – Podium Health Translation Hub sign
- SIN03 – Street Level Directional Sign
- SN01 – Mesh Screen
- CONS – Concrete Filled Steel Column

architectus™



UNSW
SYDNEY

ABN 90 131 245 684

projectUNSW Health Translation Hub

drawing

External Materials Schedule

scaleNOT TO SCALE

drawnindicated@A1-LB

checkedJC

project no190551.00

drawing no.

DA9300

issue

A

26/02/2021 4:11:19 PM



ARTIST IMPRESSION - VIEW 01

architectus

Architectus Australia Pty Ltd is the owner of the copyright subsisting in these drawings, plans, designs and specifications. They must not be used, reproduced or copied, in whole or in part, nor may the information, ideas and concepts therein contained (which are confidential to Architectus Australia Pty Ltd) be disclosed to any person without the prior written consent of that company.

Nominated Architect
Ray Brown, NSWARB 6359

Do not scale drawings. Verify all dimensions on site


issue	amendment	date
A	ISSUED FOR STATE SIGNIFICANT DEVELOPMENT APPLICATION	18.02.21

GENERAL NOTES:

- DO NOT SCALE FROM THE DRAWINGS. USE ONLY FIGURED DIMENSIONS.
- ALL DIMENSIONS ARE IN MILLIMETRES UNLESS OTHERWISE STATED.
- REDUCED LEVELS (RL) ARE TO AUSTRALIAN HEIGHT DATUM (AHD).
- COORDINATES ARE TO MAP GRID AUSTRALIA (MGA).
- THE ARCHITECTURAL DOCUMENTATION IS ONLY ALLOWED TO BE USED FOR THE PURPOSE FOR WHICH IT WAS COMMISSIONED. UNAUTHORISED USE OF THE DOCUMENTATION IS PROHIBITED.

Scale:

architectus



UNSW
SYDNEY

ABN 90 131 245 684

project

UNSW Health Translation Hub

drawing

External Renders

scale	1 : 100@A1	drawing no.
drawn	TH	DA9310
checked	JC	issue
project no	190551.00	A



ARTIST IMPRESSION - VIEW 02

architectus

Architectus Australia Pty Ltd is the owner of the copyright subsisting in these drawings, plans, designs and specifications. They must not be used, reproduced or copied, in whole or in part, nor may the information, ideas and concepts therein contained (which are confidential to Architectus Australia Pty Ltd) be disclosed to any person without the prior written consent of that company.

Nominated Architect
Ray Brown, NSWARB 6359

Do not scale drawings. Verify all dimensions on site

issue	amendment	date
A	ISSUED FOR STATE SIGNIFICANT DEVELOPMENT APPLICATION	18.02.21

GENERAL NOTES:

- DO NOT SCALE FROM THE DRAWINGS. USE ONLY FIGURED DIMENSIONS.
- ALL DIMENSIONS ARE IN MILLIMETRES UNLESS OTHERWISE STATED.
- REDUCED LEVELS (RL) ARE TO AUSTRALIAN HEIGHT DATUM (AHD).
- COORDINATES ARE TO MAP GRID AUSTRALIA (MGA).
- THE ARCHITECTURAL DOCUMENTATION IS ONLY ALLOWED TO BE USED FOR THE PURPOSE FOR WHICH IT WAS COMMISSIONED. UNAUTHORISED USE OF THE DOCUMENTATION IS PROHIBITED.

Scale:

architectus



UNSW
SYDNEY

ABN 90 131 245 684

project
UNSW Health Translation Hub

drawing

External Renders

scale	1 : 100@A1	drawing no.
drawn	TH	DA9311
checked	JC	issue
project no	190551.00	A



ARTIST IMPRESSION - VIEW 03

architectus

Architectus Australia Pty Ltd is the owner of the copyright subsisting in these drawings, plans, designs and specifications. They must not be used, reproduced or copied, in whole or in part, nor may the information, ideas and concepts therein contained (which are confidential to Architectus Australia Pty Ltd) be disclosed to any person without the prior written consent of that company.

Nominated Architect
Ray Brown, NSWARB 6359

Do not scale drawings. Verify all dimensions on site

issue	amendment	date
A	ISSUED FOR STATE SIGNIFICANT DEVELOPMENT APPLICATION	18.02.21

GENERAL NOTES:

- DO NOT SCALE FROM THE DRAWINGS. USE ONLY FIGURED DIMENSIONS.
- ALL DIMENSIONS ARE IN MILLIMETRES UNLESS OTHERWISE STATED.
- REDUCED LEVELS (RL) ARE TO AUSTRALIAN HEIGHT DATUM (AHD).
- COORDINATES ARE TO MAP GRID AUSTRALIA (MGA).
- THE ARCHITECTURAL DOCUMENTATION IS ONLY ALLOWED TO BE USED FOR THE PURPOSE FOR WHICH IT WAS COMMISSIONED. UNAUTHORISED USE OF THE DOCUMENTATION IS PROHIBITED.

Scale:

architectus



UNSW
SYDNEY

ABN 90 131 245 684

project
UNSW Health Translation Hub

drawing

External Renders		
scale	1 : 100@A1	drawing no.
drawn	TH	DA9312
checked	JC	issue
project no	190551.00	A



ARTIST IMPRESSION - VIEW 04

architectus

Architectus Australia Pty Ltd is the owner of the copyright subsisting in these drawings, plans, designs and specifications. They must not be used, reproduced or copied, in whole or in part, nor may the information, ideas and concepts therein contained (which are confidential to Architectus Australia Pty Ltd) be disclosed to any person without the prior written consent of that company.

Nominated Architect
Ray Brown, NSWARB 6359

Do not scale drawings. Verify all dimensions on site

issue	amendment	date
A	ISSUED FOR STATE SIGNIFICANT DEVELOPMENT APPLICATION	18.02.21

GENERAL NOTES:

- DO NOT SCALE FROM THE DRAWINGS. USE ONLY FIGURED DIMENSIONS.
- ALL DIMENSIONS ARE IN MILLIMETRES UNLESS OTHERWISE STATED.
- REDUCED LEVELS (RL) ARE TO AUSTRALIAN HEIGHT DATUM (AHD).
- COORDINATES ARE TO MAP GRID AUSTRALIA (MGA).
- THE ARCHITECTURAL DOCUMENTATION IS ONLY ALLOWED TO BE USED FOR THE PURPOSE FOR WHICH IT WAS COMMISSIONED. UNAUTHORISED USE OF THE DOCUMENTATION IS PROHIBITED.

Scale:

architectus™



UNSW
SYDNEY

ABN 90 131 245 684

project
UNSW Health Translation Hub

drawing

External Renders			
scale	1 : 100@A1	drawing no.	
drawn	TH		DA9313
checked	JC	issue	
project no	190551.00		A



ARTIST IMPRESSION - VIEW 05

architectus

Architectus Australia Pty Ltd is the owner of the copyright subsisting in these drawings, plans, designs and specifications. They must not be used, reproduced or copied, in whole or in part, nor may the information, ideas and concepts therein contained (which are confidential to Architectus Australia Pty Ltd) be disclosed to any person without the prior written consent of that company.

Nominated Architect
Ray Brown, NSWARB 6359

Do not scale drawings. Verify all dimensions on site

issue	amendment	date
A	ISSUED FOR STATE SIGNIFICANT DEVELOPMENT APPLICATION	18.02.21

- GENERAL NOTES:
- DO NOT SCALE FROM THE DRAWINGS. USE ONLY FIGURED DIMENSIONS.
 - ALL DIMENSIONS ARE IN MILLIMETRES UNLESS OTHERWISE STATED.
 - REDUCED LEVELS (RL) ARE TO AUSTRALIAN HEIGHT DATUM (AHD).
 - COORDINATES ARE TO MAP GRID AUSTRALIA (MGA).
 - THE ARCHITECTURAL DOCUMENTATION IS ONLY ALLOWED TO BE USED FOR THE PURPOSE FOR WHICH IT WAS COMMISSIONED. UNAUTHORISED USE OF THE DOCUMENTATION IS PROHIBITED.

Scale:

architectus™



ABN 90 131 245 684

project


UNSW Health Translation Hub

drawing


External Renders

scale	1 : 100@A1	drawing no.
drawn	TH	DA9314
checked	JC	issue
project no	190551.00	A


26/02/2021 5:41:23 PM

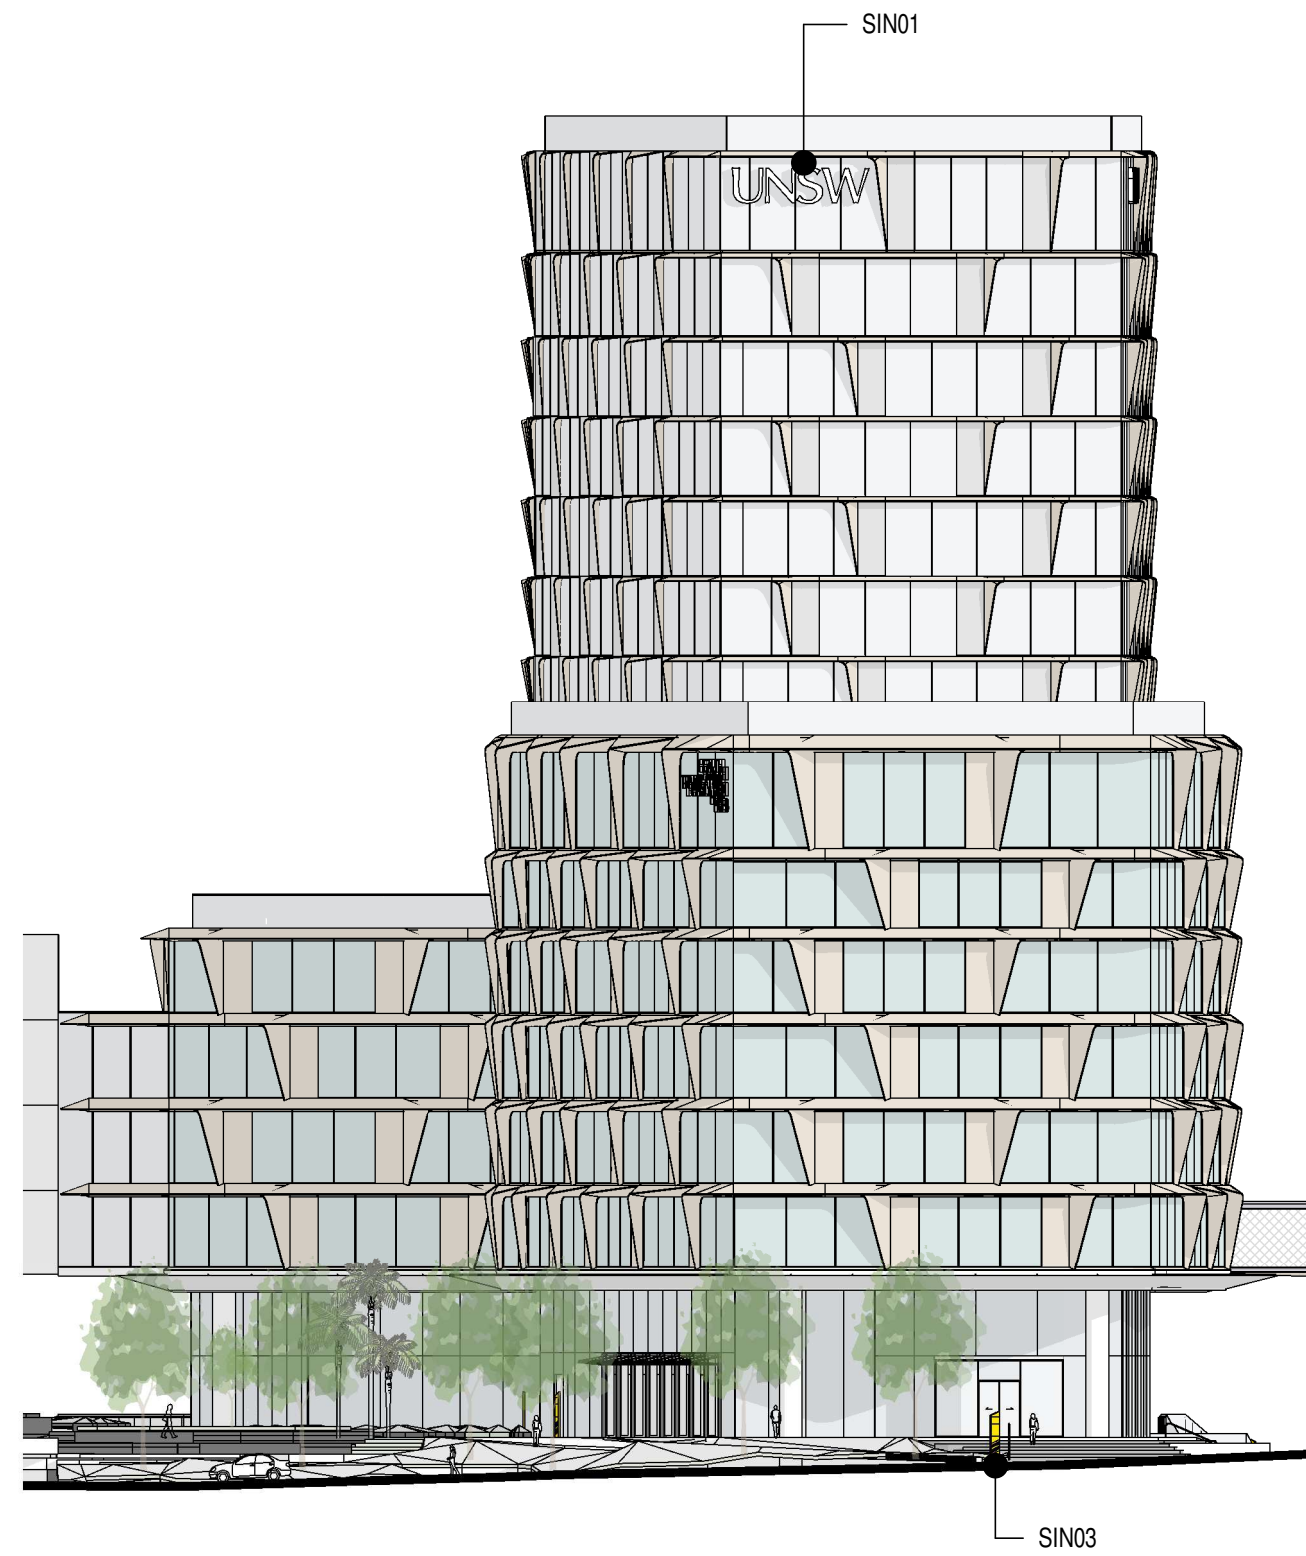

1 North Elevation
SCALE: 1 : 400

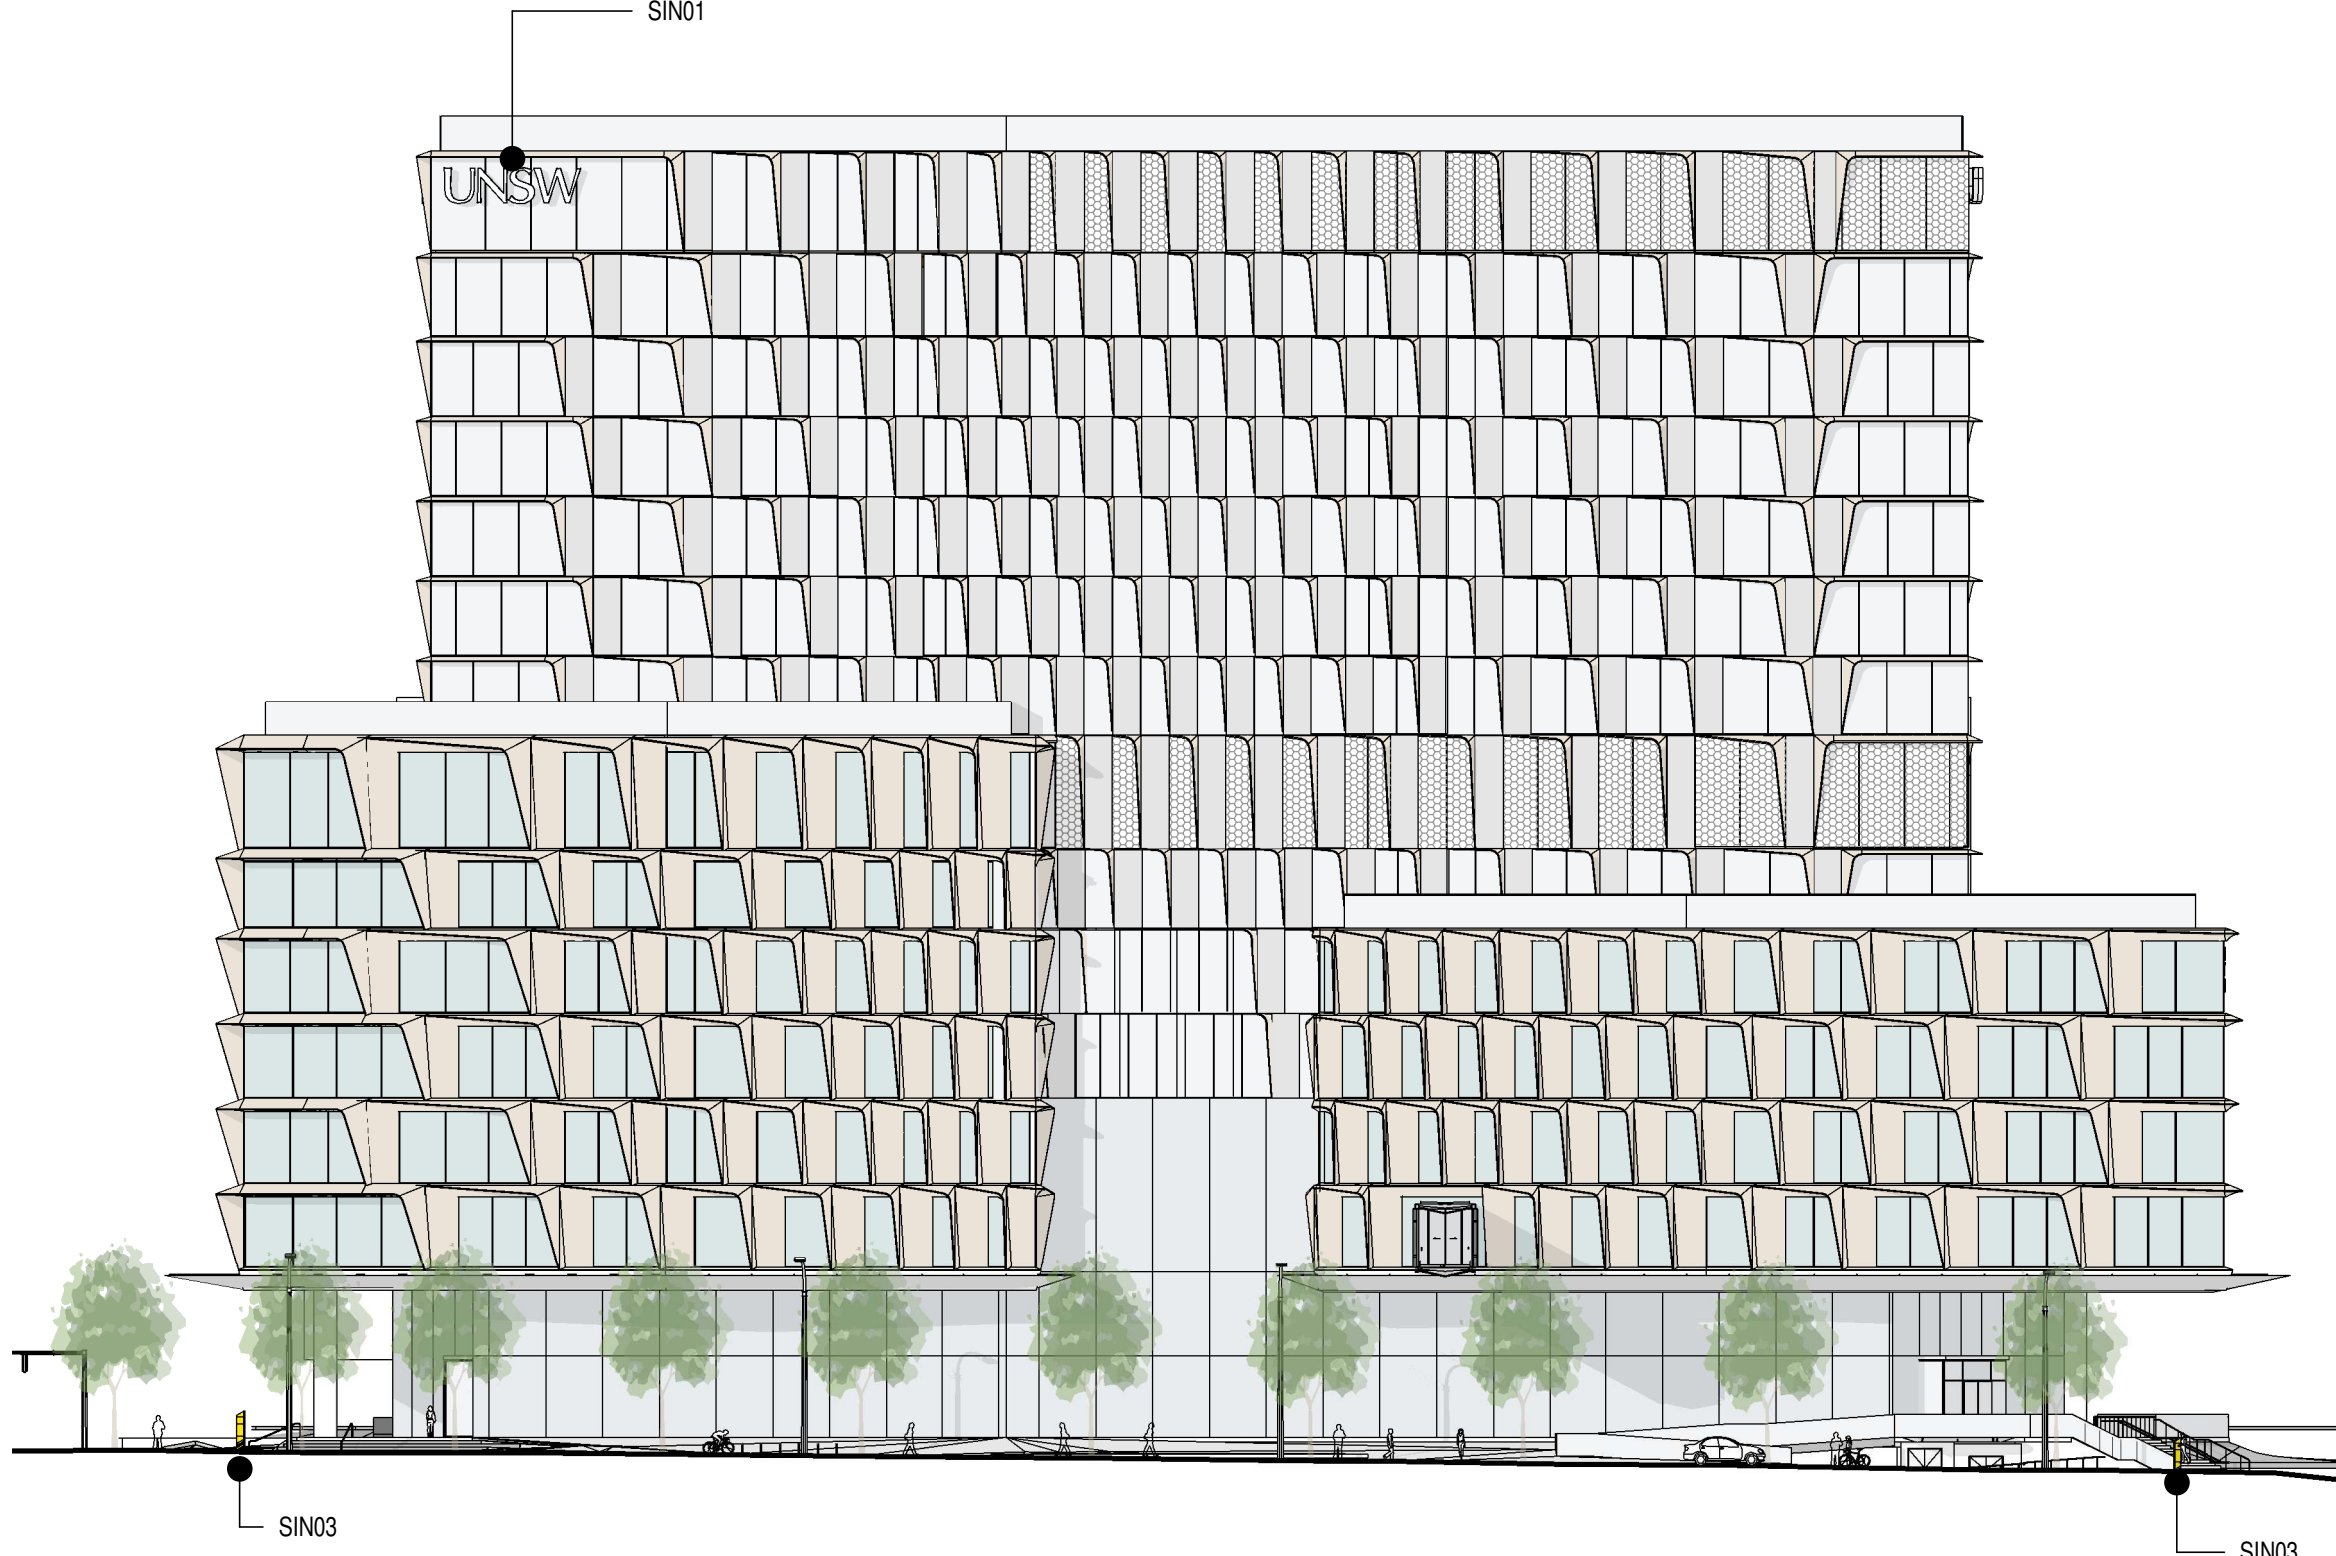


2 West Elevation
SCALE: 1 : 400

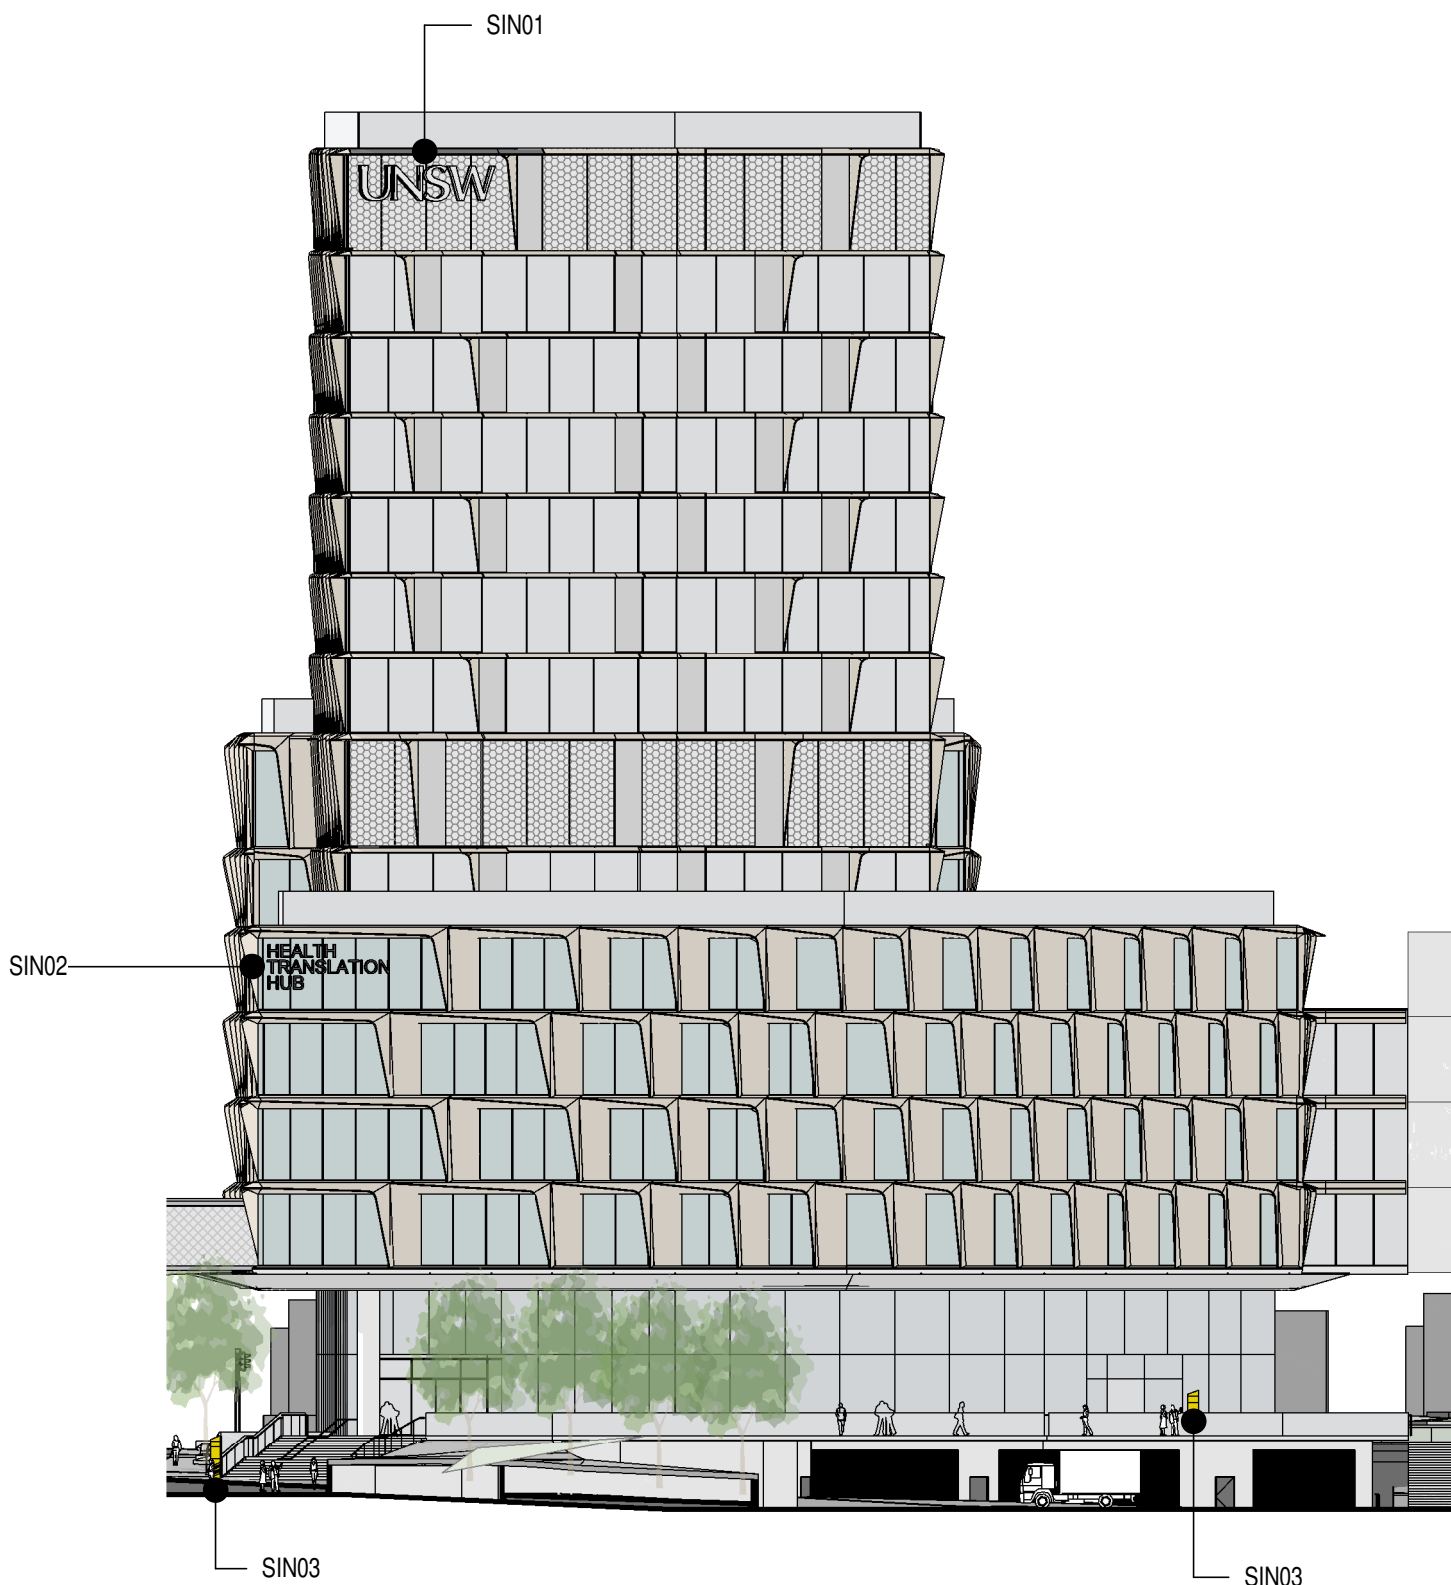


3 South Elevation
SCALE: 1 : 400



4 East Elevation
SCALE: 1 : 400

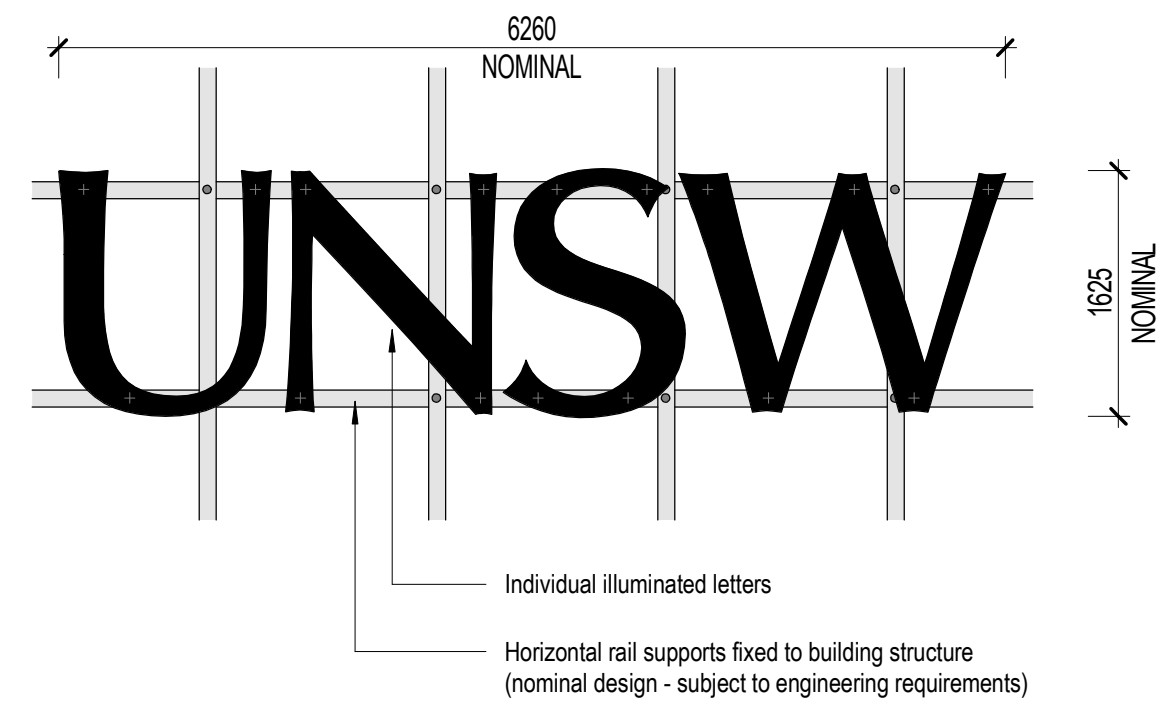

5 SIN01 - Facade Mounted Signage
SCALE: 1 : 50

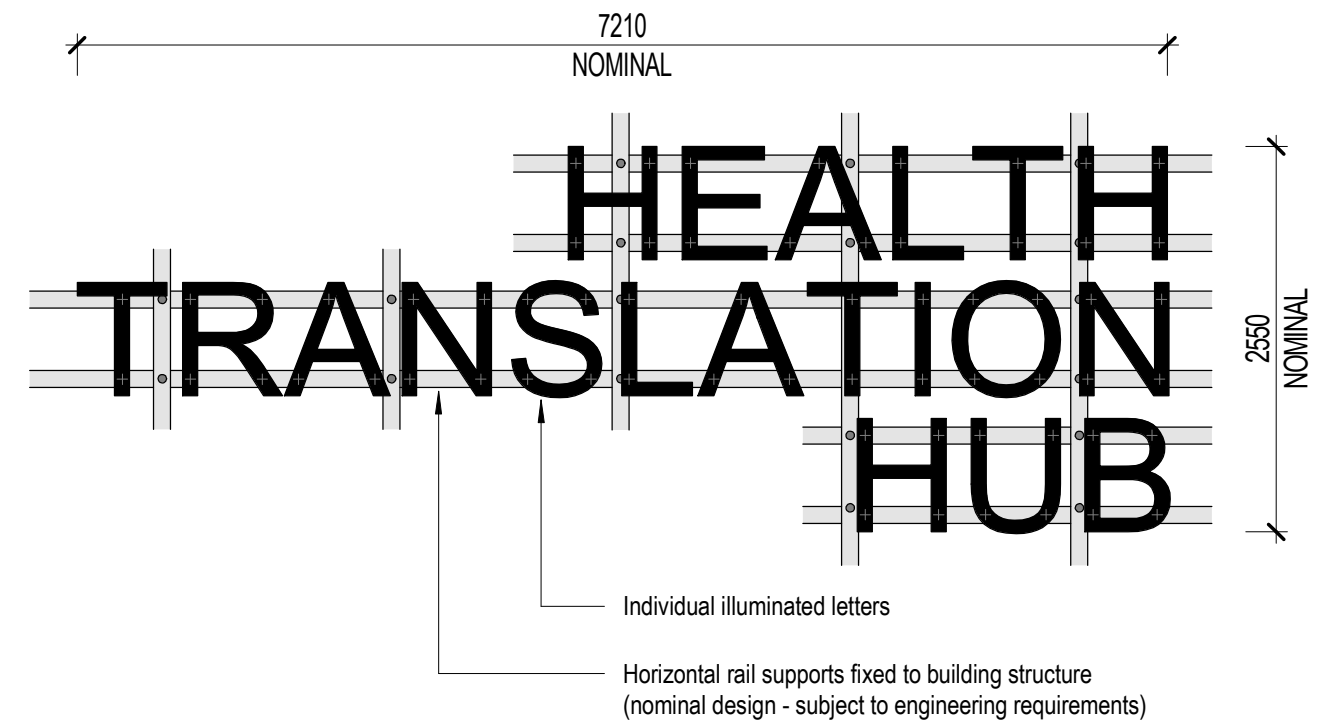

6 SIN02 - Facade Mounted Signage
SCALE: 1 : 50



7 SIN03 - Welcome Totem Detail
SCALE: 1 : 10

© architectus™

Architectus Australia Pty Ltd is the owner of the copyright subsisting in these drawings, plans, designs and specifications. They must not be used, reproduced or copied, in whole or in part, nor may the information, ideas and concepts therein contained (which are confidential to Architectus Australia Pty Ltd) be disclosed to any person without the prior written consent of that company.

Nominated Architect
Ray Brown, NSWARB 6359

Do not scale drawings. Verify all dimensions on site

issue	amendment	date
A	ISSUED FOR STATE SIGNIFICANT DEVELOPMENT APPLICATION	18.02.21

GENERAL NOTES:

- DO NOT SCALE FROM THE DRAWINGS. USE ONLY FIGURED DIMENSIONS.
- ALL DIMENSIONS ARE IN MILLIMETRES UNLESS OTHERWISE STATED.
- REDUCED LEVELS (RL) ARE TO AUSTRALIAN HEIGHT DATUM (AHD).
- COORDINATES ARE TO MAP GRID AUSTRALIA (MGA).
- THE ARCHITECTURAL DOCUMENTATION IS ONLY ALLOWED TO BE USED FOR THE PURPOSE FOR WHICH IT WAS COMMISSIONED. UNAUTHORISED USE OF THE DOCUMENTATION IS PROHIBITED.

URBANITE™
architectus™
UNSW SYDNEY
ABN 90 131 245 684

project
UNSW Health Translation Hub

drawing


Signage
drawing no.

scale As indicated@A1-LB
drawn DA9315


checked JC issue

project no 190551.00 A


26/02/2021 12:09:34 PM

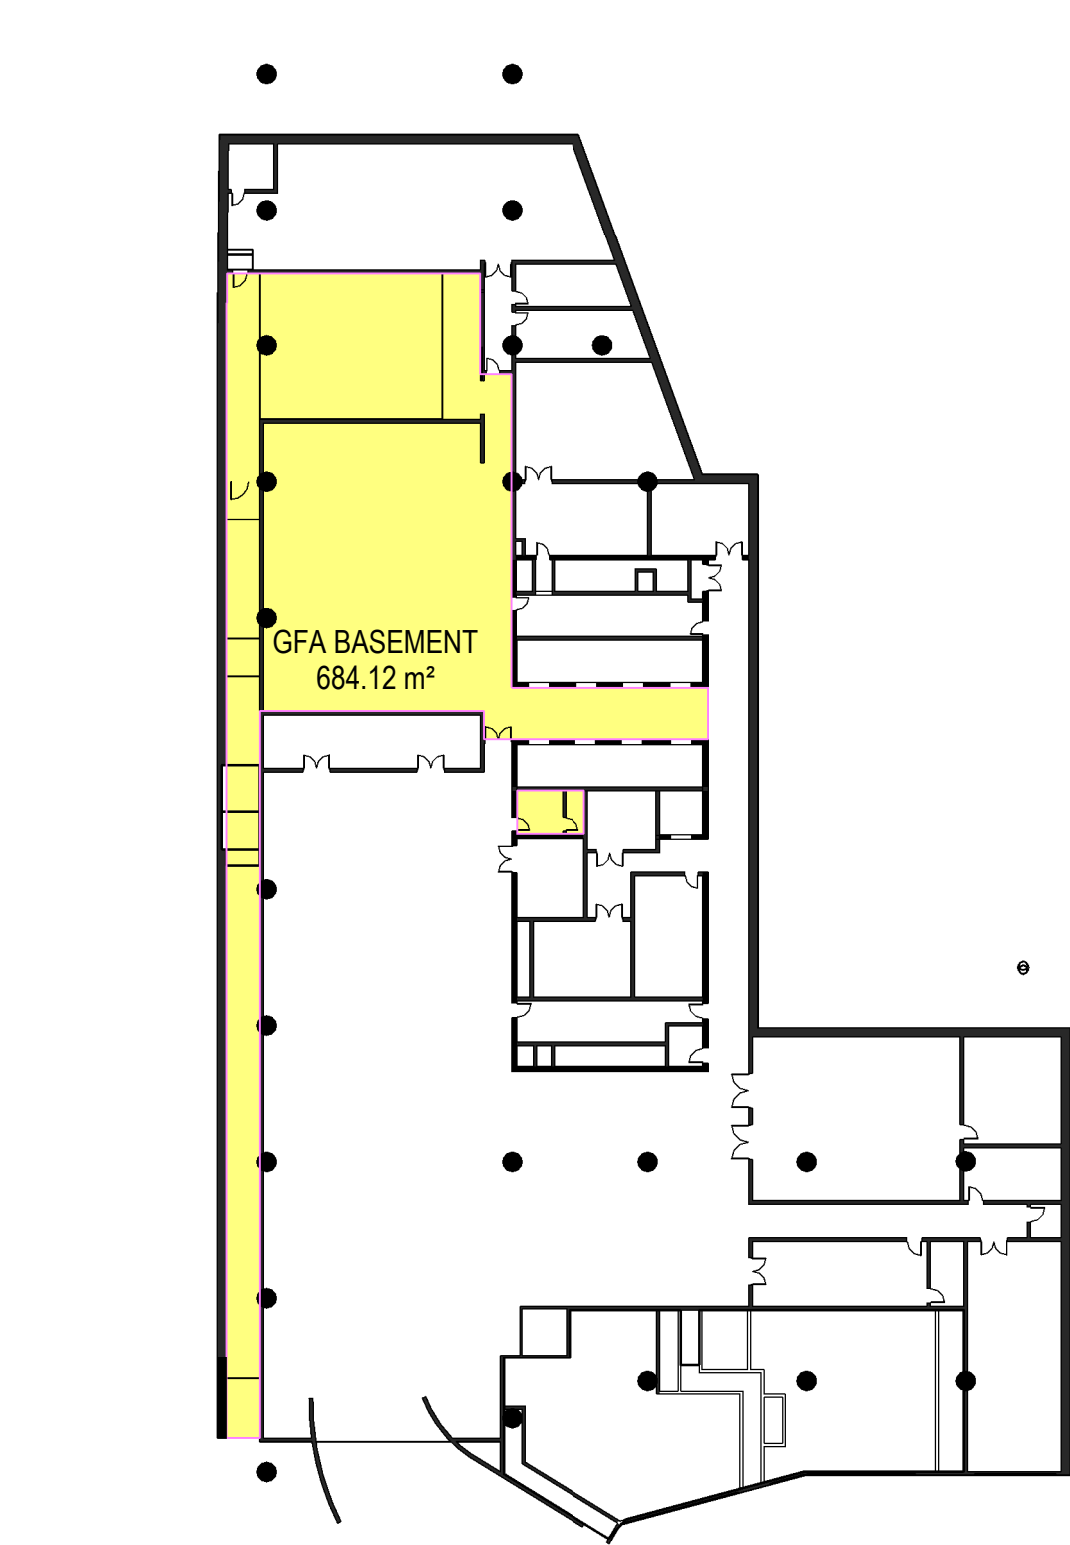


1 Basement 01
SCALE: 1 : 500

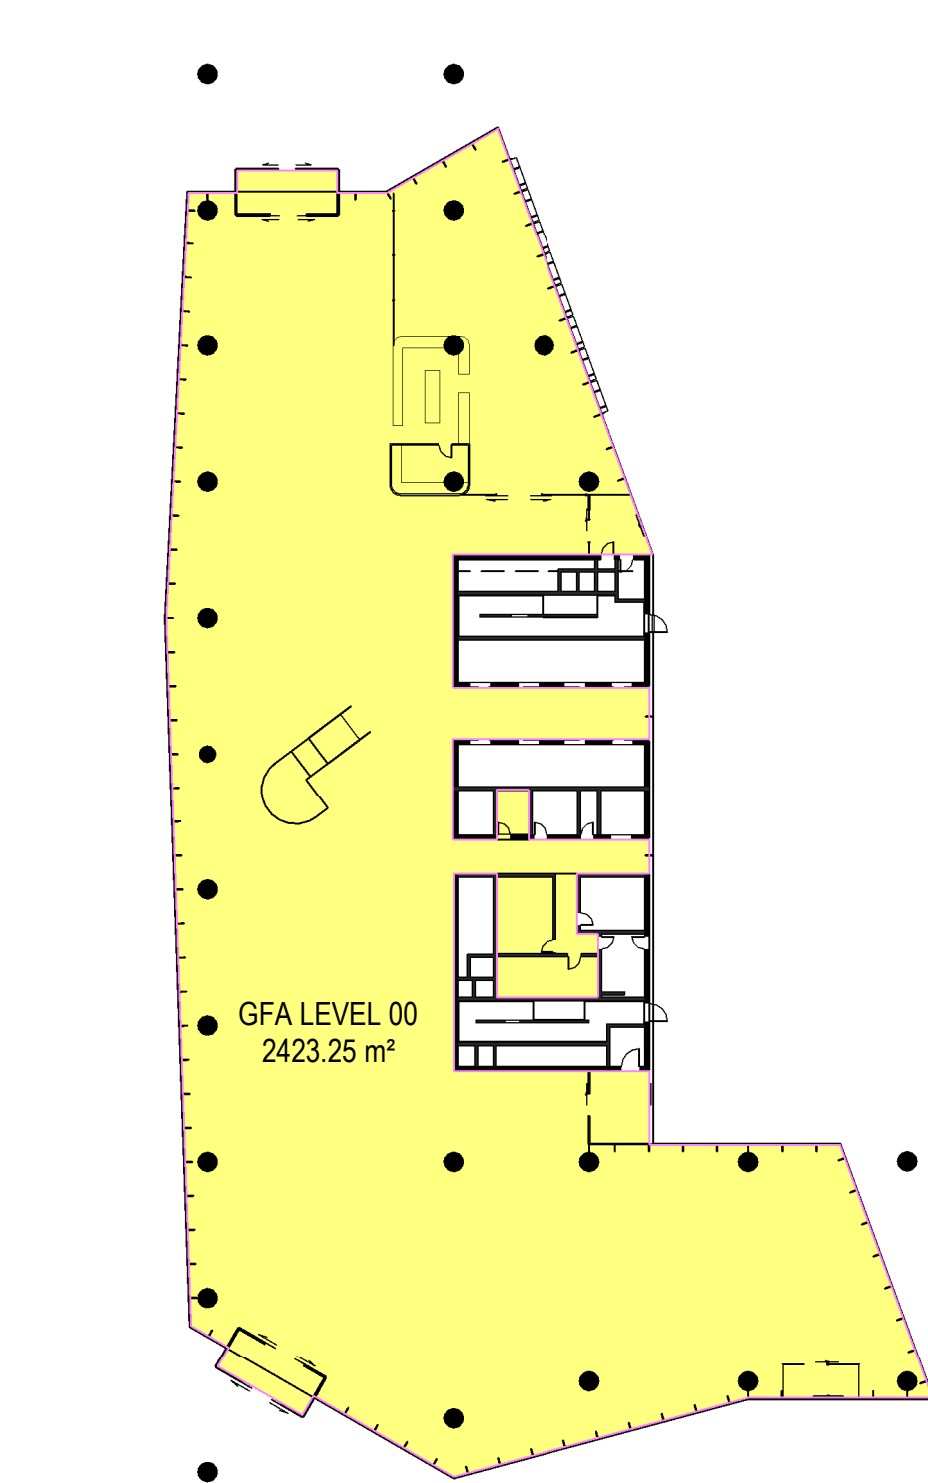


2 Level 00 - Ground
SCALE: 1 : 500

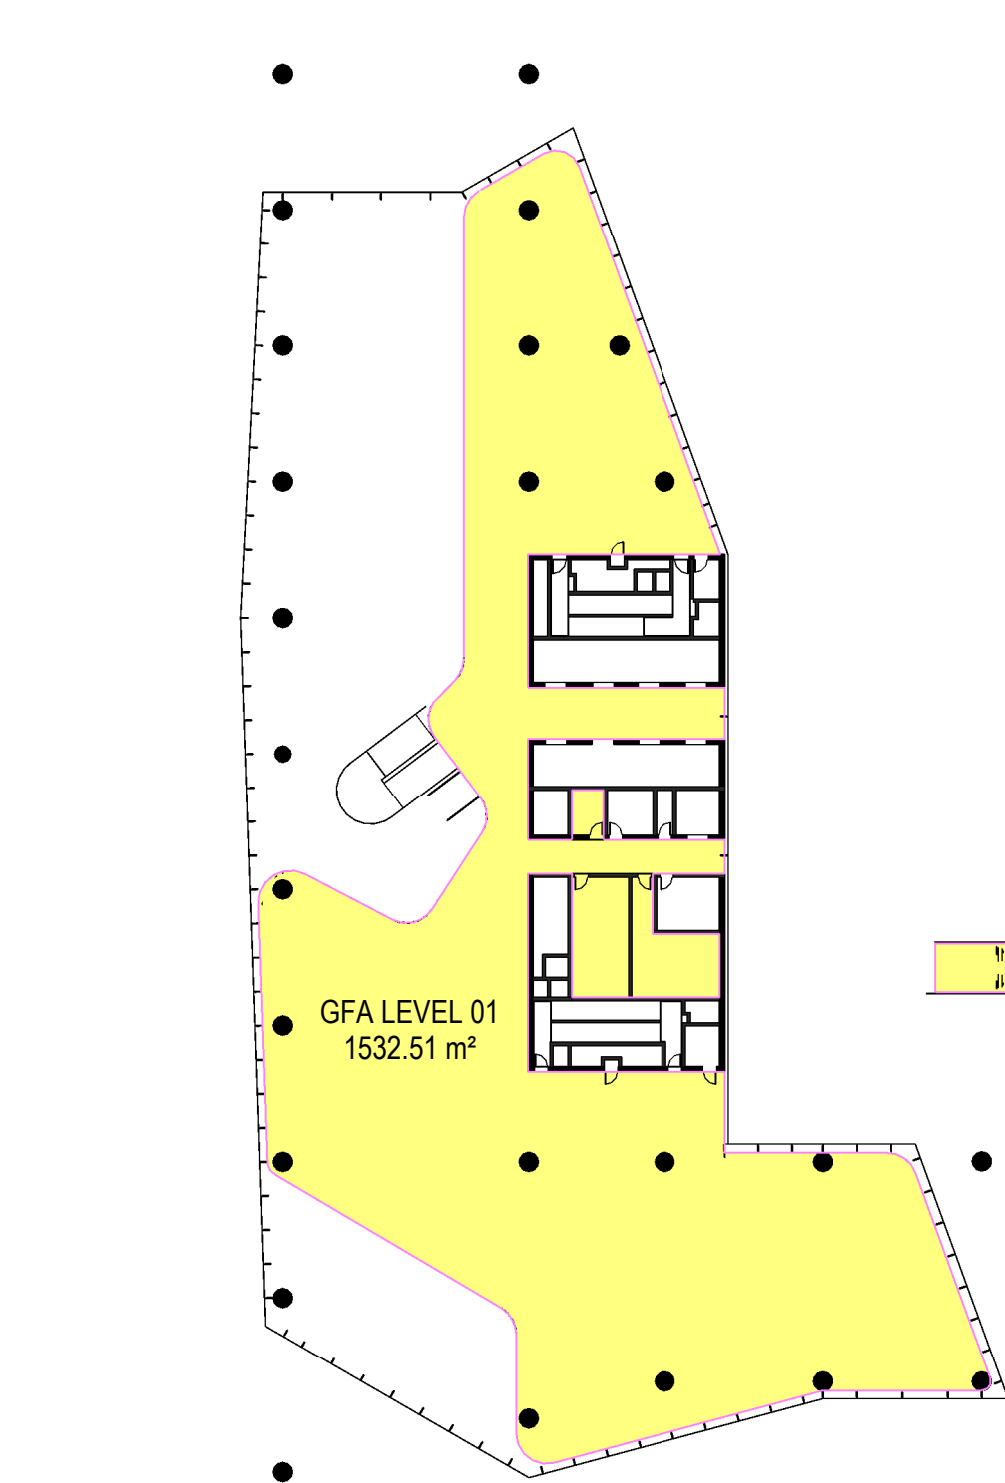


3 Level 01
SCALE: 1 : 500

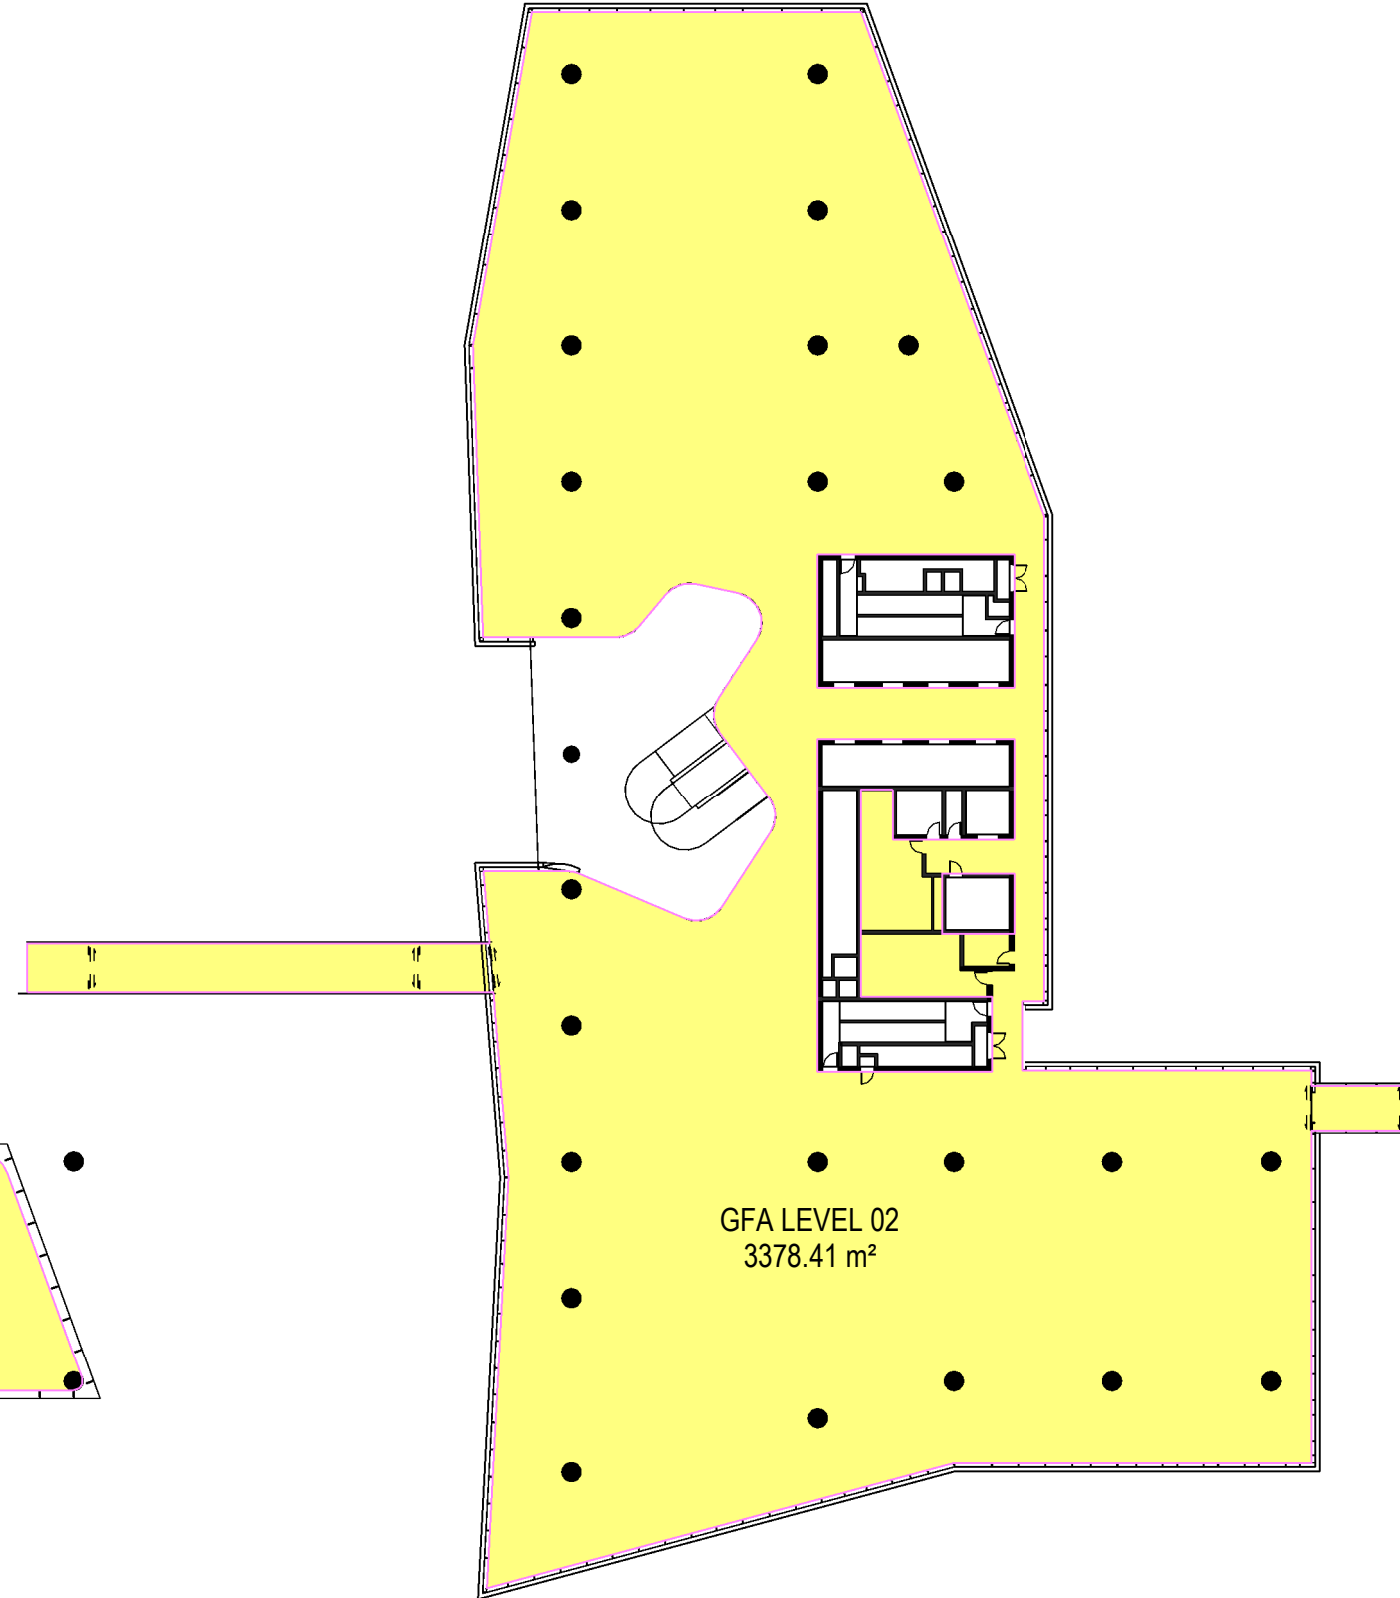


4 Level 02
SCALE: 1 : 500

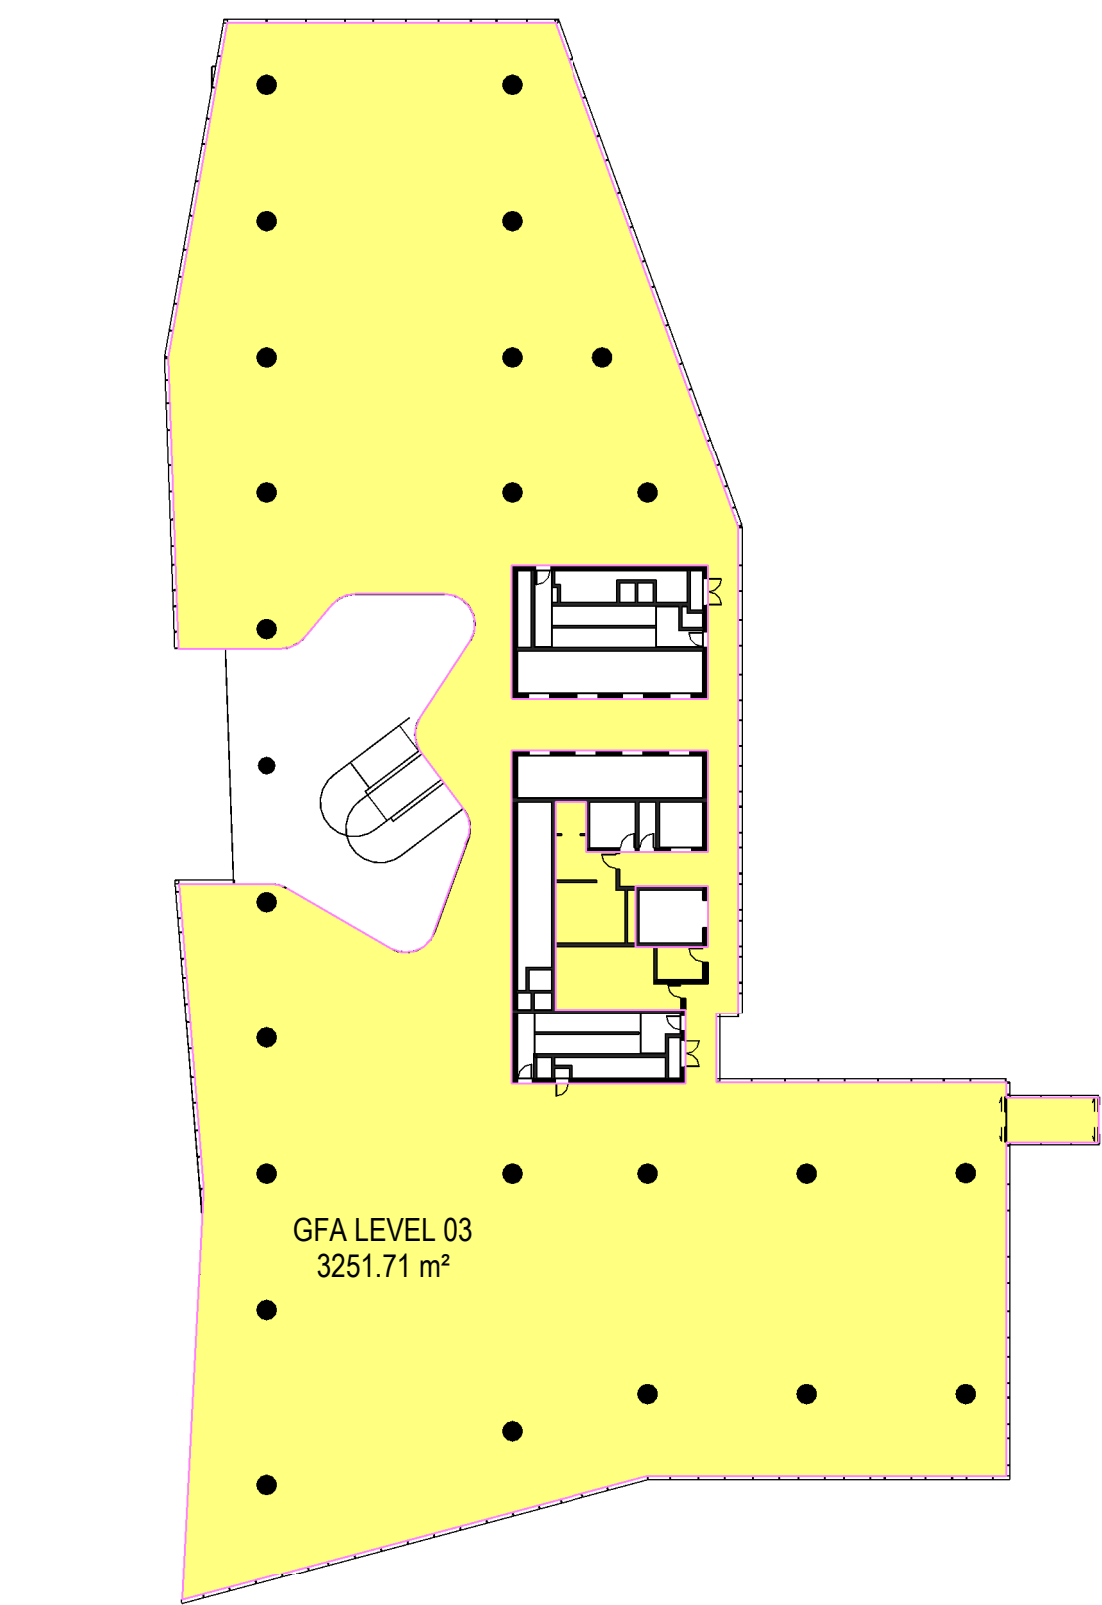


5 Level 03
SCALE: 1 : 500

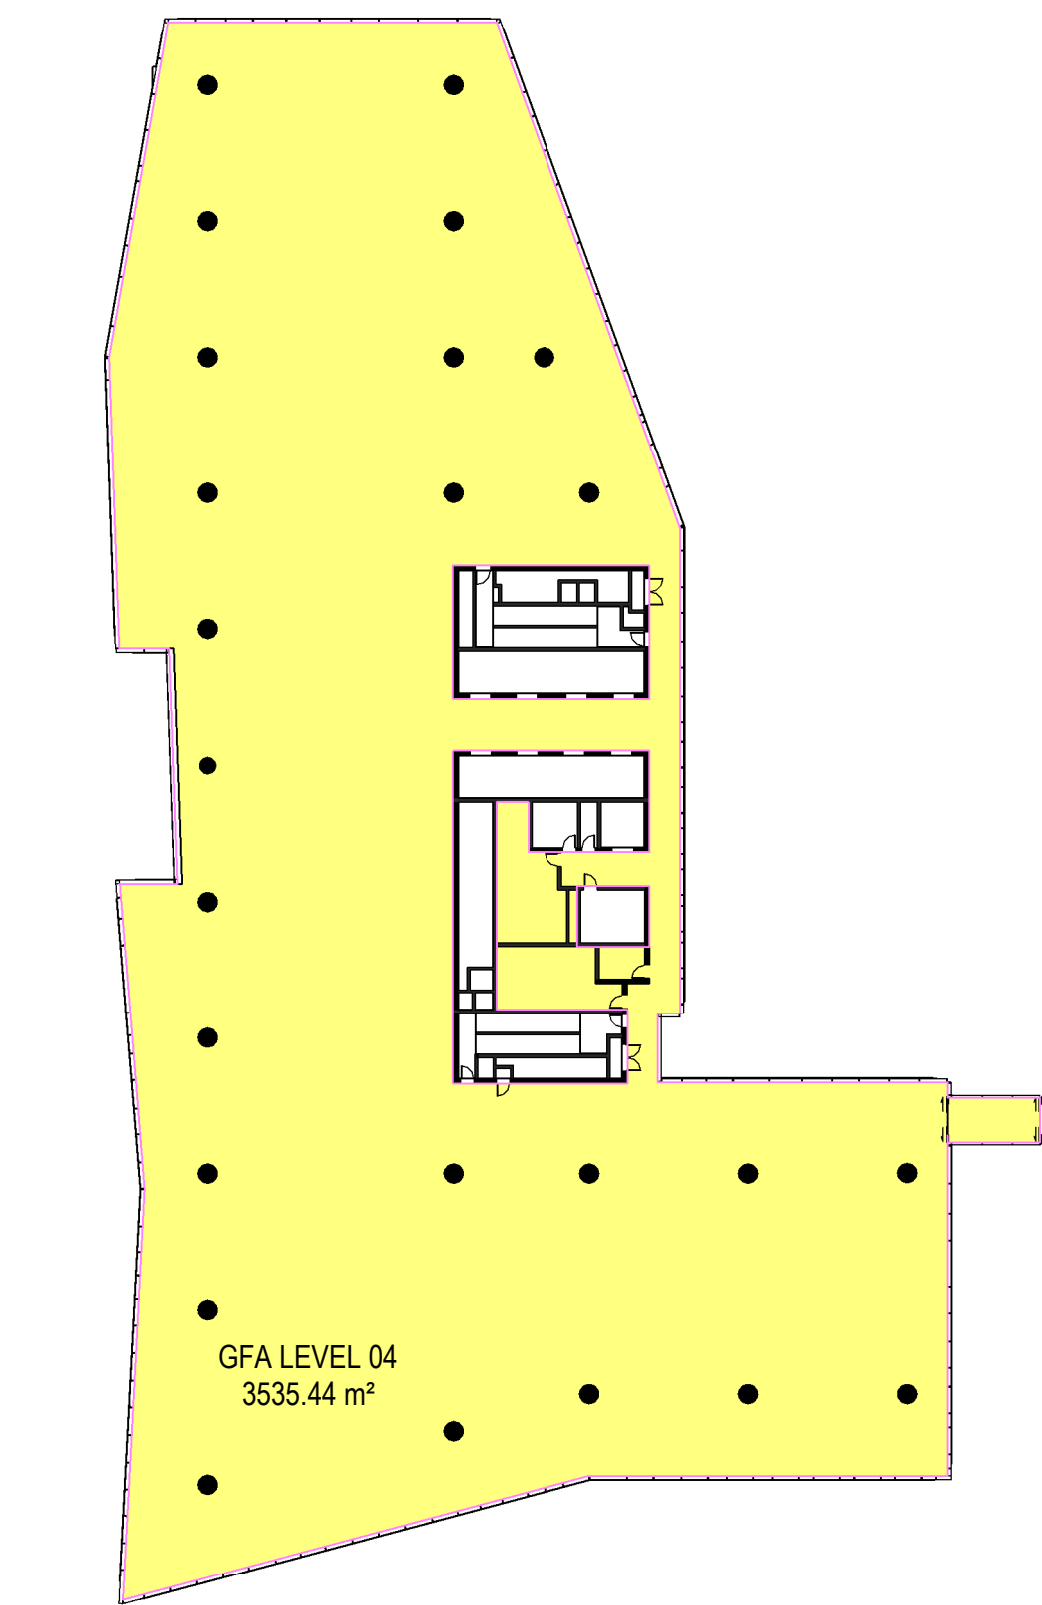

6 Level 04
SCALE: 1 : 500

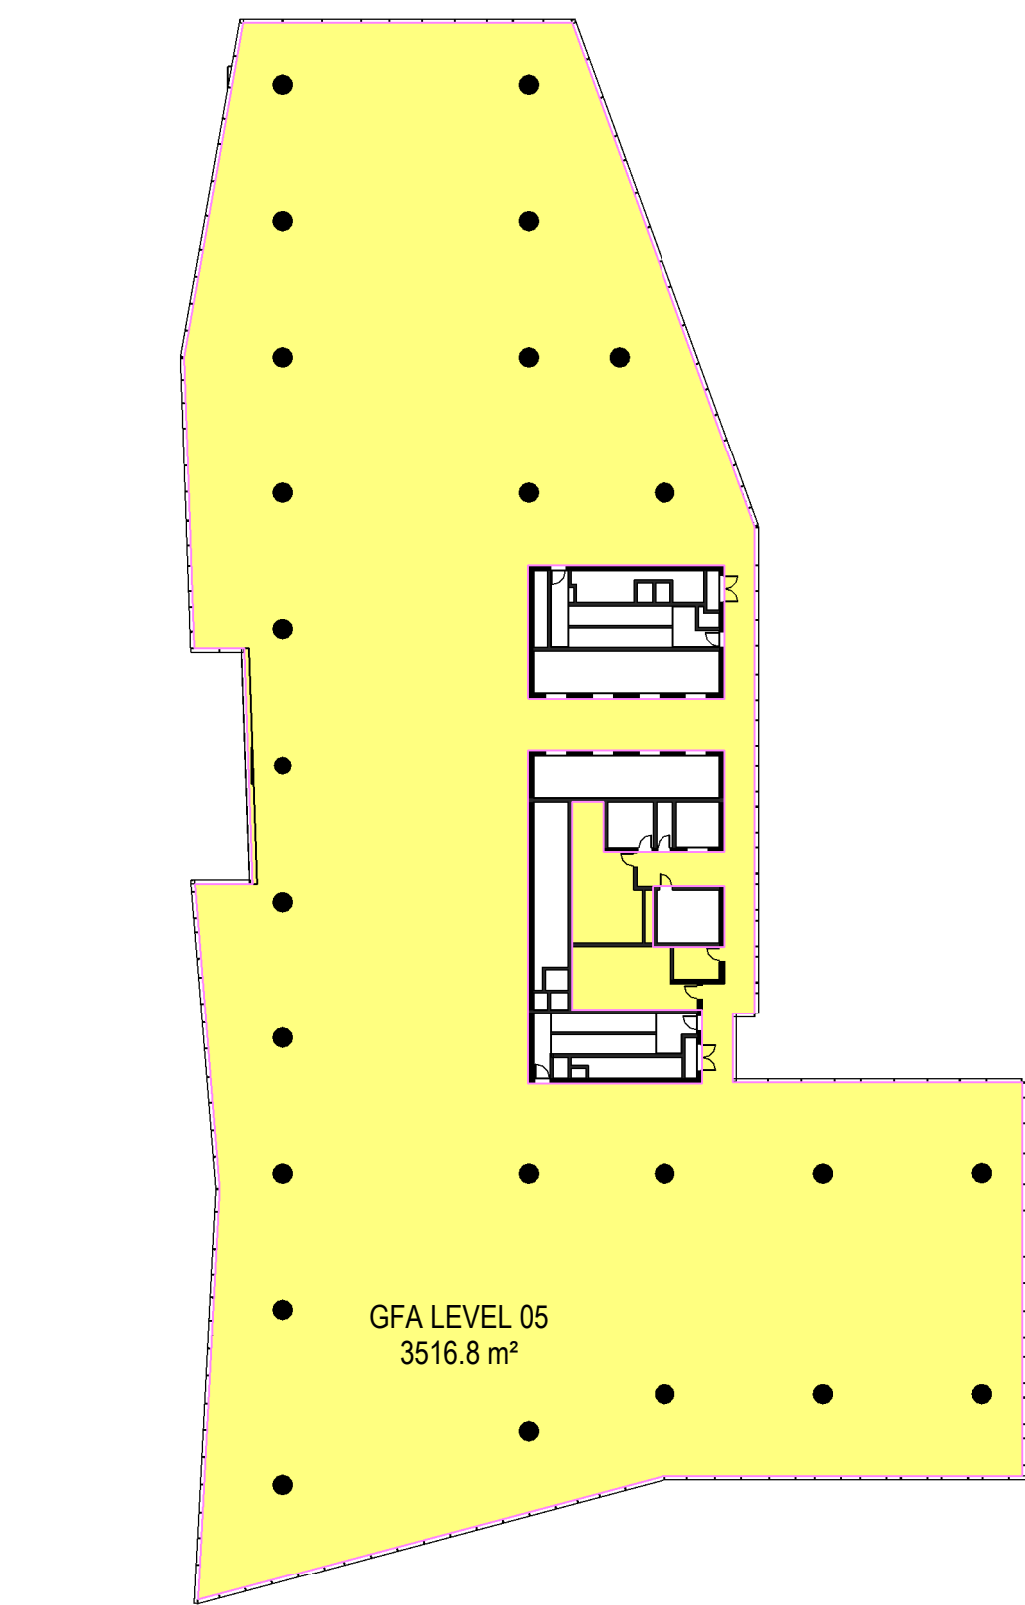

7 Level 05
SCALE: 1 : 500

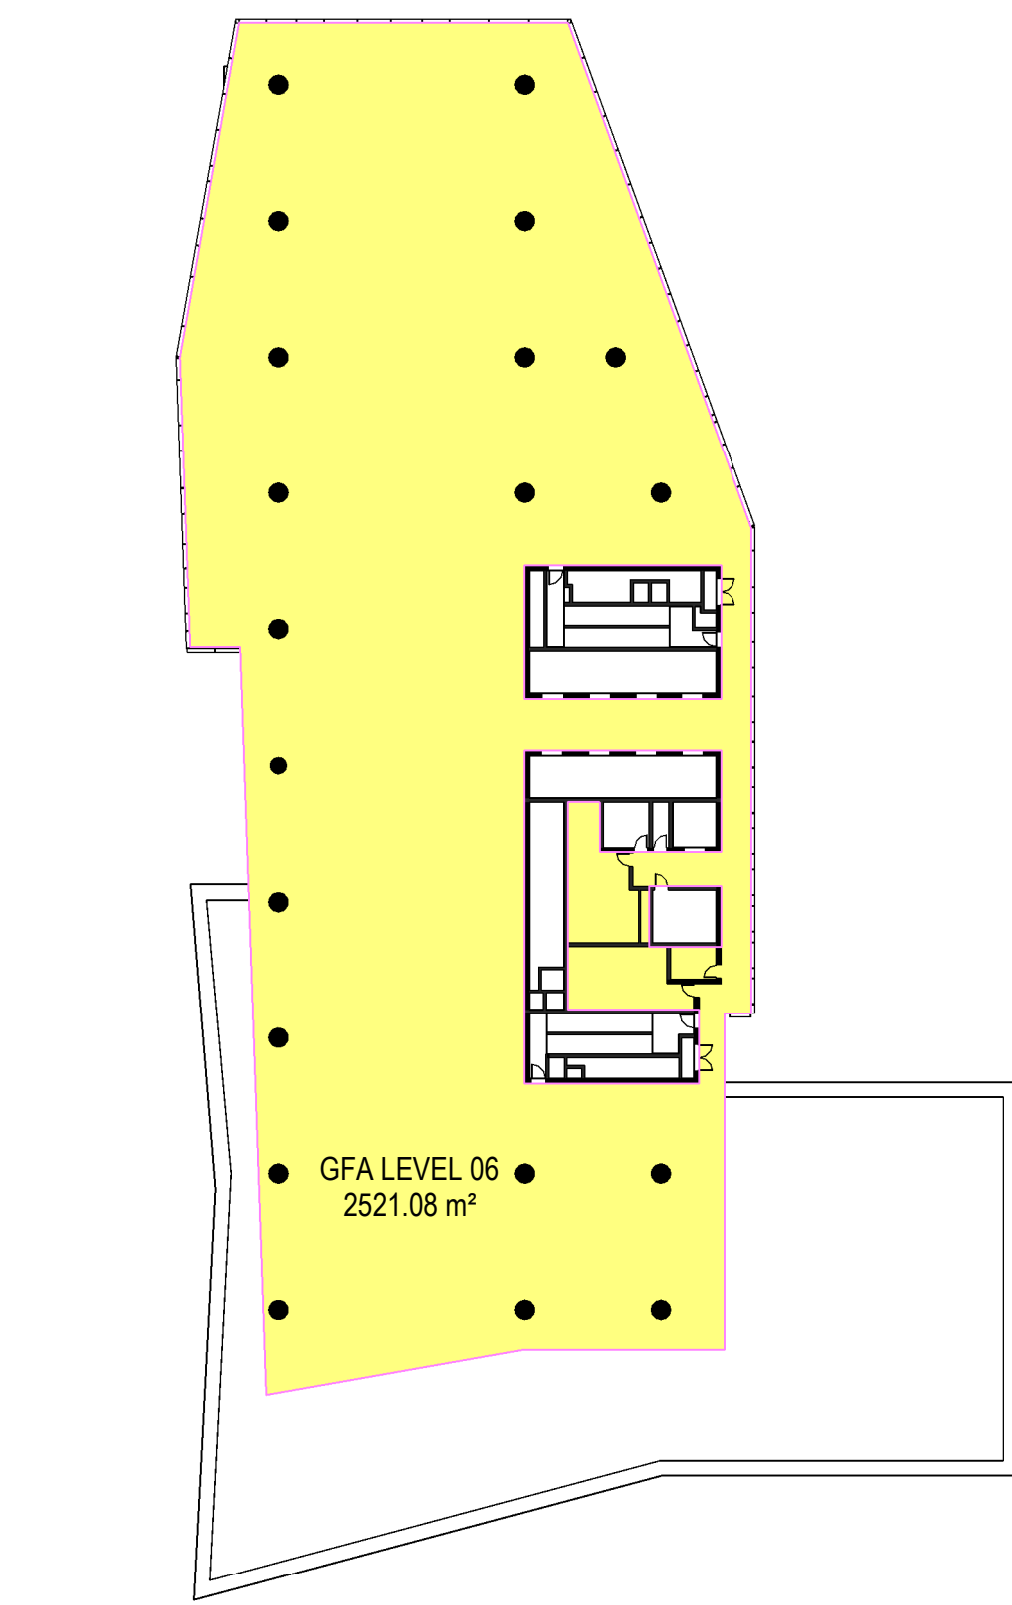

8 Level 06
SCALE: 1 : 500

©architectus™

Architectus Australia Pty Ltd is the owner of the copyright subsisting in these drawings, plans, designs and specifications. They must not be used, reproduced or copied, in whole or in part, nor may the information, ideas and concepts therein contained (which are confidential to Architectus Australia Pty Ltd) be disclosed to any person without the prior written consent of that company.

Nominated Architect
Ray Brown, NSWARB 6359

Do not scale drawings. Verify all dimensions on site

issue	amendment	date
A	ISSUED FOR STATE SIGNIFICANT DEVELOPMENT APPLICATION	18.02.21

GENERAL NOTES:

- DO NOT SCALE FROM THE DRAWINGS. USE ONLY FIGURED DIMENSIONS.
- ALL DIMENSIONS ARE IN MILLIMETRES UNLESS OTHERWISE STATED.
- REDUCED LEVELS (RL) ARE TO AUSTRALIAN HEIGHT DATUM (AHD).
- COORDINATES ARE TO MAP GRID AUSTRALIA (MGA).
- THE ARCHITECTURAL DOCUMENTATION IS ONLY ALLOWED TO BE USED FOR THE PURPOSE FOR WHICH IT WAS COMMISSIONED. UNAUTHORISED USE OF THE DOCUMENTATION IS PROHIBITED.

Gross Floor Area Definition:

This area is computed by measuring internal face of external walls excluding an area used solely for rooftop fixed mechanical plant and/or basement car parking. In the circumstances listed below GFA will be calculated as detailed:

- Stairwells and liftwells should be counted as contributing to GFA once only (these components are not considered to be floor area for subsequent levels).
- Basement parking also incorporates parking for bicycles, where such areas are designed in accordance with the relevant Australian Standard, and can be excluded from the GFA calculation.
- VOIDS within an atrium design can be excluded from the GFA provided the initial floor area of the atrium is included.
- Mezzanines are considered to be a floor and should be included in the calculation.

AREA SCHEDULE GFA	
Level	Area
Basement 01	697 m²
Level 00 - Ground	2423 m²
Level 01	1533 m²
Level 02	3378 m²
Level 03	3252 m²
Level 04	3535 m²
Level 05	3517 m²
Level 06	2521 m²
Level 07	1177 m²
Level 08	2098 m²
Level 09	2098 m²
Level 10	2098 m²
Level 11	2098 m²
Level 12	2098 m²
Level 13	2098 m²
Level 14 - Plant	976 m²
	35600 m²

ALLOWABLE GFA 35,600m²

Scale:
1:500 @ A1
1:1000 @
A3

architectus™



ABN 90 131 245 684


project
UNSW Health Translation Hub

drawing


Area Schedule GFA 01

scale	1 : 500@A1	drawing no.
drawn	TH	DA9502
checked	JC	issue
project no	190551.00	A


22/02/2021 6:51:14 PM

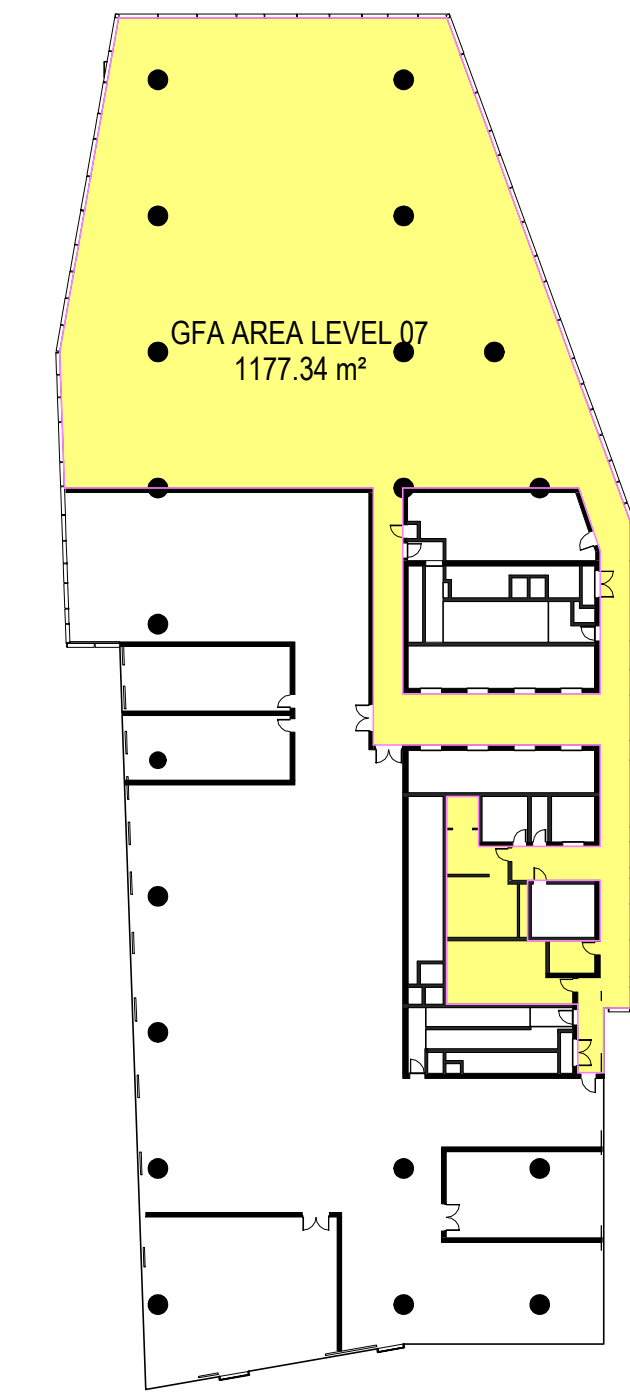


1 Level 07
SCALE: 1 : 500

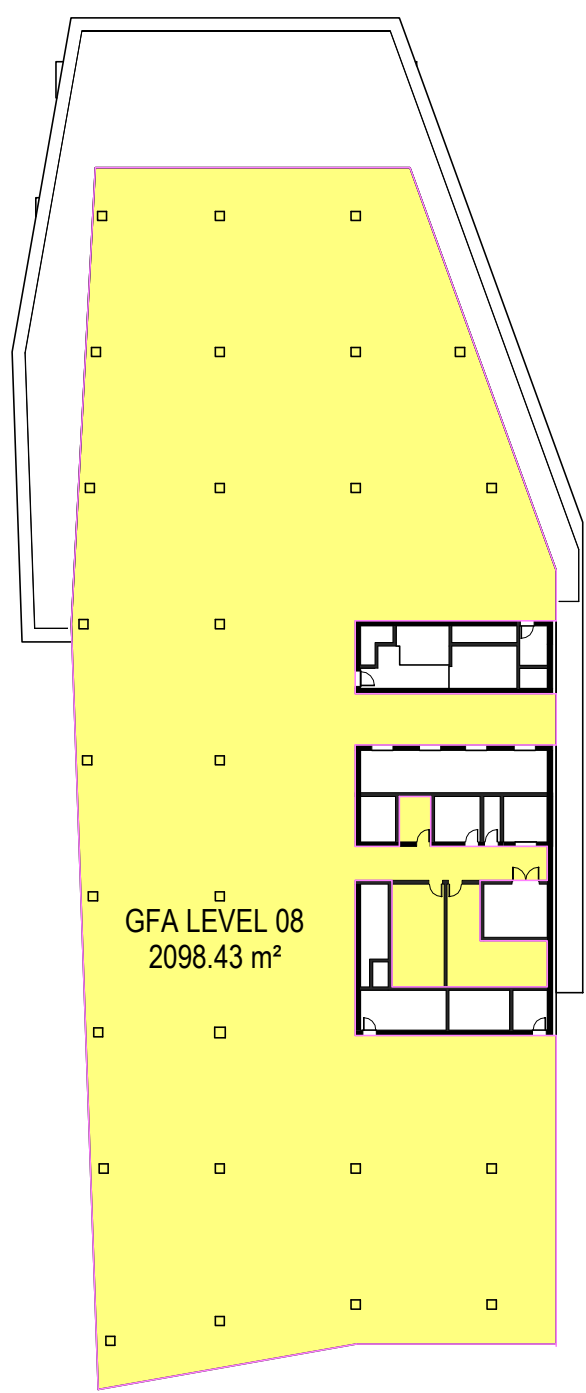


2 Level 08
SCALE: 1 : 500

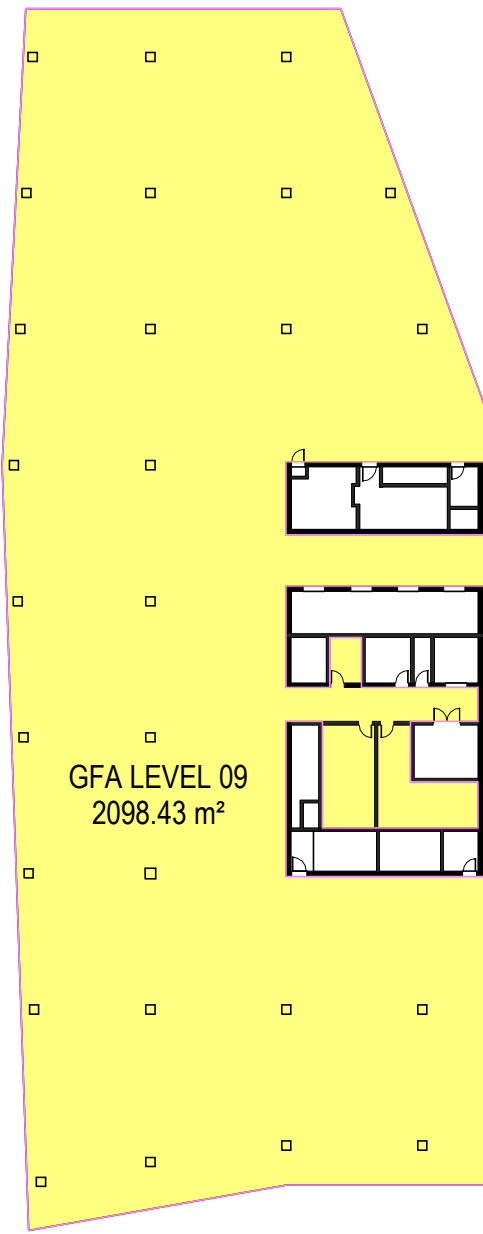


3 Level 09
SCALE: 1 : 500

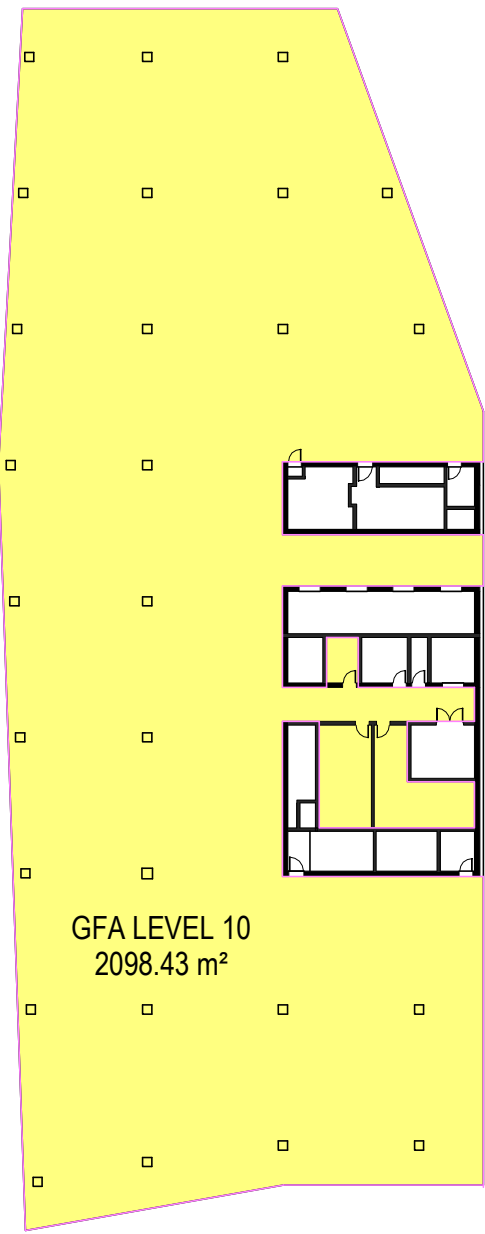


4 Level 10
SCALE: 1 : 500

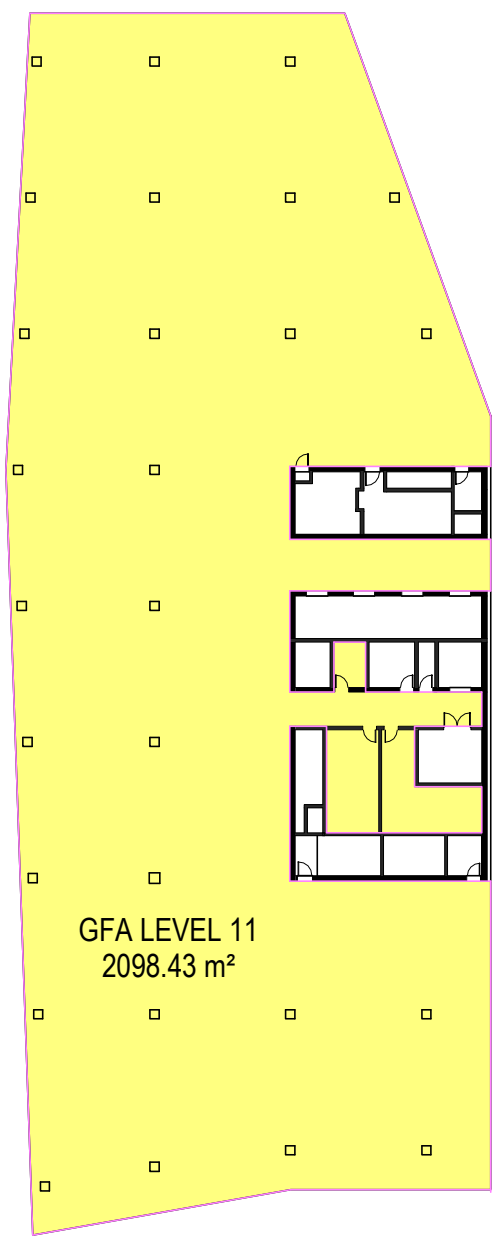


5 Level 11
SCALE: 1 : 500

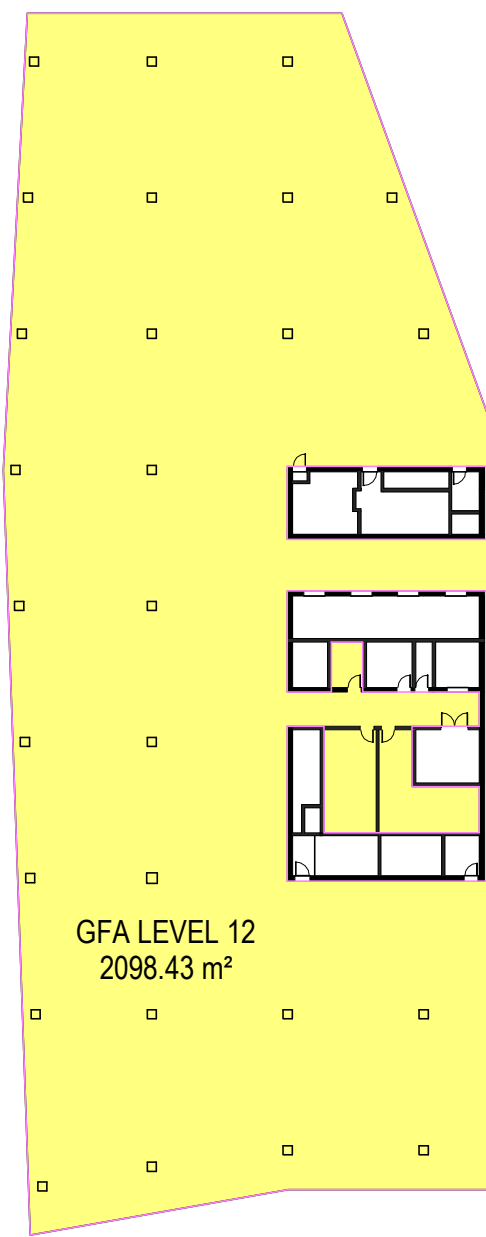

6 Level 12
SCALE: 1 : 500

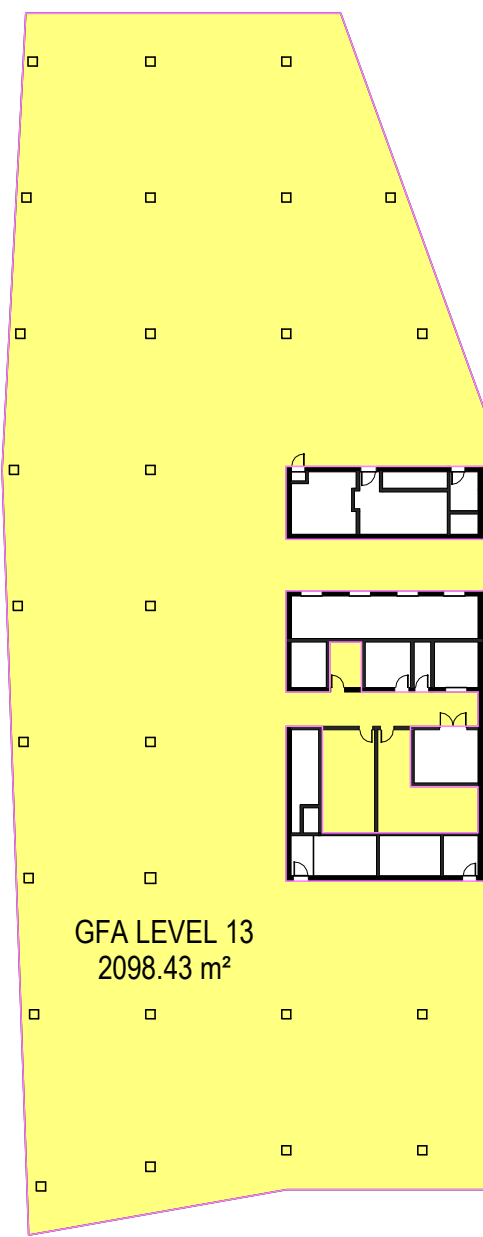

7 Level 13
SCALE: 1 : 500

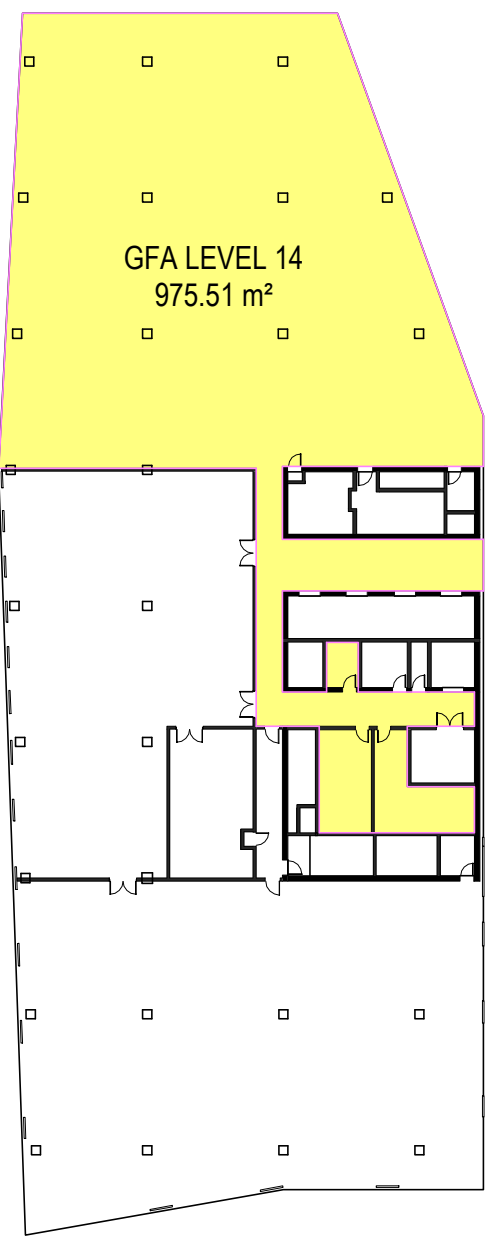

8 Level 14
SCALE: 1 : 500

issue	amendment	date
A	ISSUED FOR STATE SIGNIFICANT DEVELOPMENT APPLICATION	18.02.21

- GENERAL NOTES:
- DO NOT SCALE FROM THE DRAWINGS. USE ONLY FIGURED DIMENSIONS.
 - ALL DIMENSIONS ARE IN MILLIMETRES UNLESS OTHERWISE STATED.
 - REDUCED LEVELS (RL) ARE TO AUSTRALIAN HEIGHT DATUM (AHD).
 - COORDINATES ARE TO MAP GRID AUSTRALIA (MGA).
 - THE ARCHITECTURAL DOCUMENTATION IS ONLY ALLOWED TO BE USED FOR THE PURPOSE FOR WHICH IT WAS COMMISSIONED. UNAUTHORISED USE OF THE DOCUMENTATION IS PROHIBITED.

Gross Floor Area Definition:

This area is computed by measuring internal face of external walls excluding an area used solely for rooftop fixed mechanical plant and/or basement car parking. In the circumstances listed below GFA will be calculated as detailed:

- Stairwells and liftwells should be counted as contributing to GFA once only (these components are not considered to be floor area for subsequent levels).
- Basement parking also incorporates parking for bicycles, where such areas are designed in accordance with the relevant Australian Standard, and can be excluded from the GFA calculation.
- Voids within an atrium design can be excluded from the GFA provided the initial floor area of the atrium is included.
- Mezzanines are considered to be a floor and should be included in the calculation.

AREA SCHEDULE GFA	
Level	Area
Basement 01	697 m²
Level 00 - Ground	2423 m²
Level 01	1533 m²
Level 02	3378 m²
Level 03	3252 m²
Level 04	3535 m²
Level 05	3517 m²
Level 06	2521 m²
Level 07	1177 m²
Level 08	2098 m²
Level 09	2098 m²
Level 10	2098 m²
Level 11	2098 m²
Level 12	2098 m²
Level 13	2098 m²
Level 14 - Plant	976 m²
	35600 m²

ALLOWABLE GFA 35,600m²

Scale:
1:500 @ A1
1:1000 @ A3

0 5 10 15

architectus™



ABN 90 131 245 684

project
UNSW Health Translation Hub

drawing

Area Schedule GFA 02

scale	1 : 500@A1	drawing no.
drawn	TH	DA9503
checked	JC	issue
project no	190551.00	A