

NEW PRIMARY SCHOOL IN MULGOA RISE

1-23 Forestwood Drive, Glenmore Park, NSW 2745



NBRS DRAWING LIST SSDA

DRAWING NUMBER SHEET NAME

20415-NBRS-DR-A-SSDA-0001	COVER
20415-NBRS-DR-A-SSDA-0003	SHADOW DIAGRAMS
20415-NBRS-DR-A-SSDA-0101	SITE SURVEY
20415-NBRS-DR-A-SSDA-0102	SITE ANALYSIS
20415-NBRS-DR-A-SSDA-0110	SITE PLAN
20415-NBRS-DR-A-SSDA-0113	SITE ACCESS AND SECURITY PLAN
20415-NBRS-DR-A-SSDA-0115	SITE SECTIONS
20415-NBRS-DR-A-SSDA-0120	PUBLIC DOMAIN SCOPE OF WORKS
20415-NBRS-DR-A-SSDA-0999	CAR PARK PLAN
20415-NBRS-DR-A-SSDA-1000	OVERALL GROUND FLOOR PLAN
20415-NBRS-DR-A-SSDA-1001	OVERALL L1 PLAN
20415-NBRS-DR-A-SSDA-1002	OVERALL ROOF PLAN
20415-NBRS-DR-A-SSDA-1011	BLOCK A - GF PLAN
20415-NBRS-DR-A-SSDA-1012	BLOCK B3 - GF PLAN
20415-NBRS-DR-A-SSDA-1013	BLOCK B2 - GF PLAN
20415-NBRS-DR-A-SSDA-1014	BLOCK C - GF PLAN
20415-NBRS-DR-A-SSDA-1021	BLOCK A - LEVEL 1 PLAN
20415-NBRS-DR-A-SSDA-1022	BLOCK B3 - LEVEL 1 PLAN
20415-NBRS-DR-A-SSDA-1023	BLOCK B2 - LEVEL 1 PLAN
20415-NBRS-DR-A-SSDA-3010	SITE ELEVATIONS
20415-NBRS-DR-A-SSDA-3011	BUILDING A - ELEVATIONS
20415-NBRS-DR-A-SSDA-3012	BUILDING B3 - ELEVATIONS
20415-NBRS-DR-A-SSDA-3013	BUILDING B2 - ELEVATIONS
20415-NBRS-DR-A-SSDA-3014	BUILDING C - ELEVATIONS
20415-NBRS-DR-A-SSDA-4001	BUILDING A - SECTIONS
20415-NBRS-DR-A-SSDA-4002	BUILDING - SECTIONS
20415-NBRS-DR-A-SSDA-4003	BUILDING - DETAIL SECTIONS
20415-NBRS-DR-A-SSDA-4005	TYPICAL STAIR & TACTILE DETAIL
20415-NBRS-DR-A-SSDA-7001	3D IMAGE 1
20415-NBRS-DR-A-SSDA-7002	3D IMAGE 2
20415-NBRS-DR-A-SSDA-7003	3D IMAGE 3
20415-NBRS-DR-A-SSDA-7004	3D IMAGE 4
20415-NBRS-DR-A-SSDA-7010	SIGNAGE
20415-NBRS-DR-A-SSDA-8001	EXTERNAL FINISHES

Issue No.	Date	Description	Chkd
1	23/04/2021	ISSUE FOR COORDINATION	
2	04/05/2021	SSDA ISSUE	
3	06/08/2021	SSDA ISSUE	JL
4	17/08/2021	SSDA ISSUE	JL

SSDA ISSUE

RICHARD CROOKES
CONSTRUCTIONS

TRAFFIC ENGINEER
PTC
KASIA BALSAM
02 8920 0800
kasia.balsam@pticonsultants.co

TOWN PLANNER
RPS
ROB DWYER
0425 285 778
rob.dwyer@rpsgroup.com.au

MULTI SERVICES
NDY
RYAN HAHN
0407 236 908
r.hahn@ndy.com

CIVIL AND STRUCTURAL ENGINEERING
WOOLACOTTS
JUSTIN CHIRILLO
02 8203 1504
jchirillo@woolacotts.com.au

QUANTITY SURVEYOR
MBM
AUTUMN LU
02 9270 1062
autumn.lu@mbmpl.com.au

PROJECT MANAGER
COLLIERS
ANTHONY MAUGHAN-WRIGHT
0424 189 883
anthony.maughan-wright@colliers.com


Drawing Title
COVER

Project
NEW PRIMARY SCHOOL IN MULGOA
RISE
at
1-23 Forestwood drive, Glenmore Park, NSW 2745, Australia
for
SINSW


Architect
NBRSARCHITECTURE.
Sydney
61 2 9922 2344
Any form of replication of this drawing in full or in part without the written permission of NBRS+PARTNERS Pty Ltd constitutes an infringement of the copyright.
Nominated Architect:
Andrew Duffin NSW 5602
NBRS & Partners Pty Ltd VIC 51197
nbrsarchitecture.com
© 2021
ABN 16 002 247 565

Date 19/08/2021 6:18:46 PM
Scale NOT TO SCALE


Drawing Reference 20415-NBRS-DR-A-SSDA-0001
Revision 4

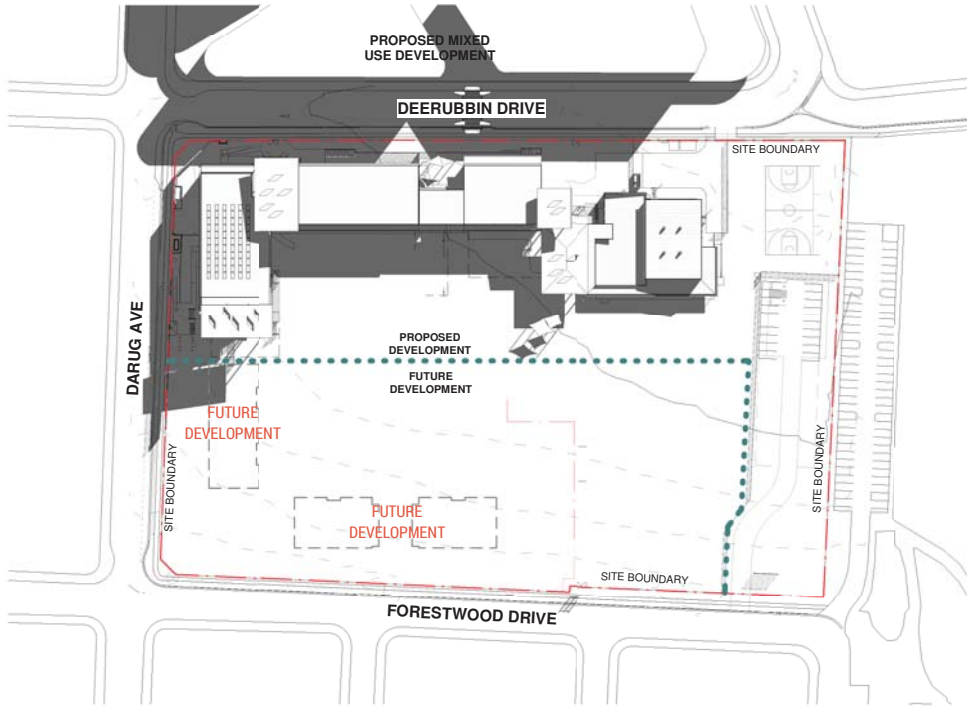


1 SHADOW DIAGRAM JUNE 21 9AM

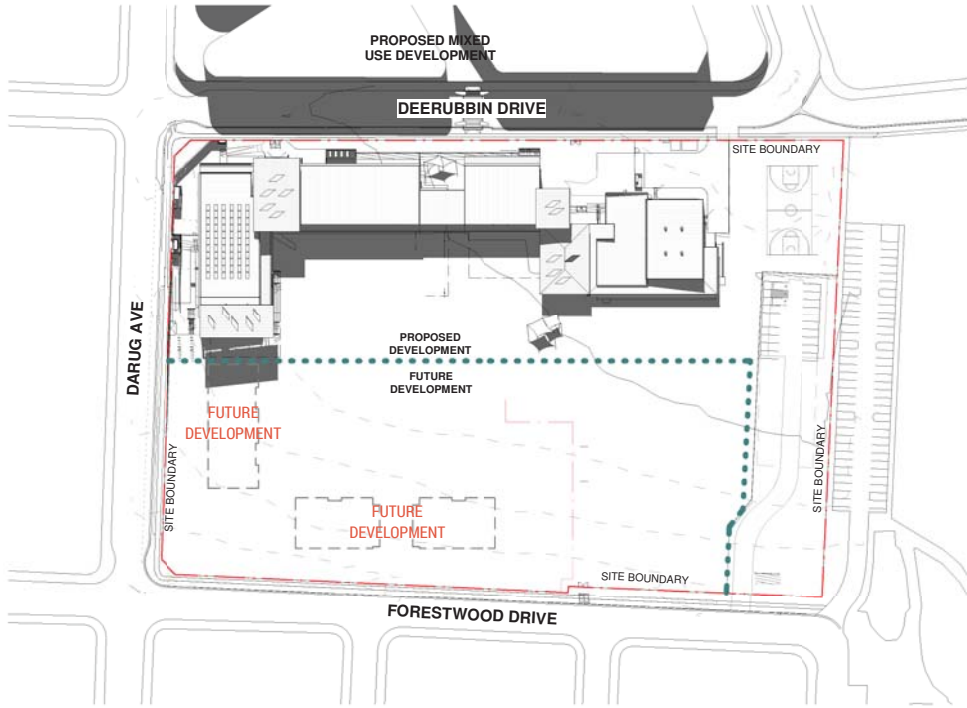


2 SHADOW DIAGRAM JUNE 21 12PM

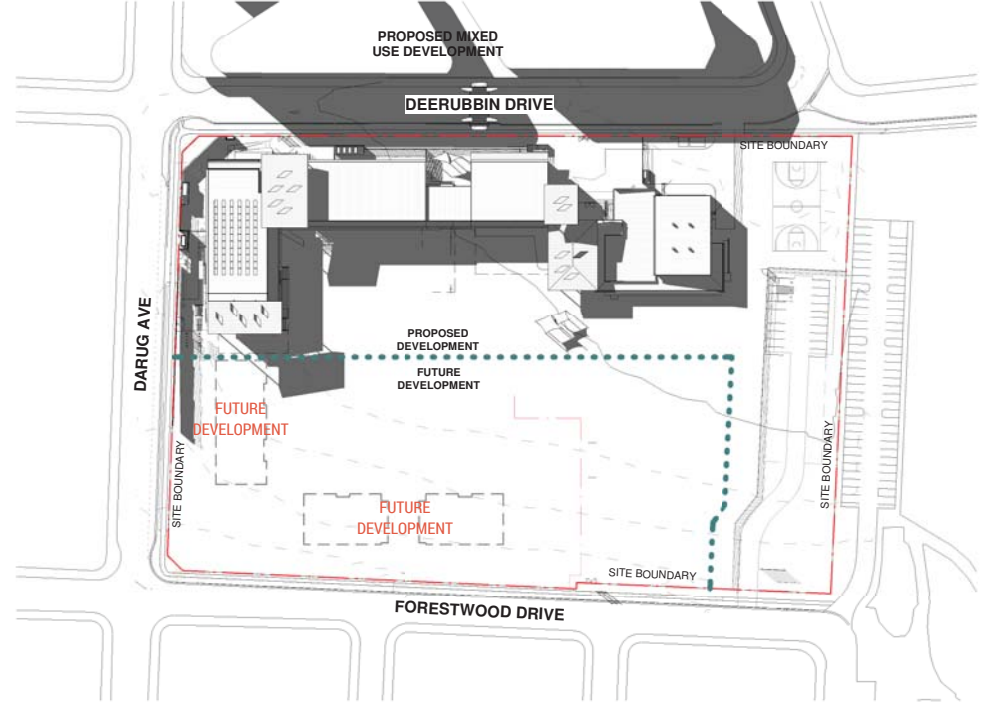


3 SHADOW DIAGRAM JUNE 21 3PM

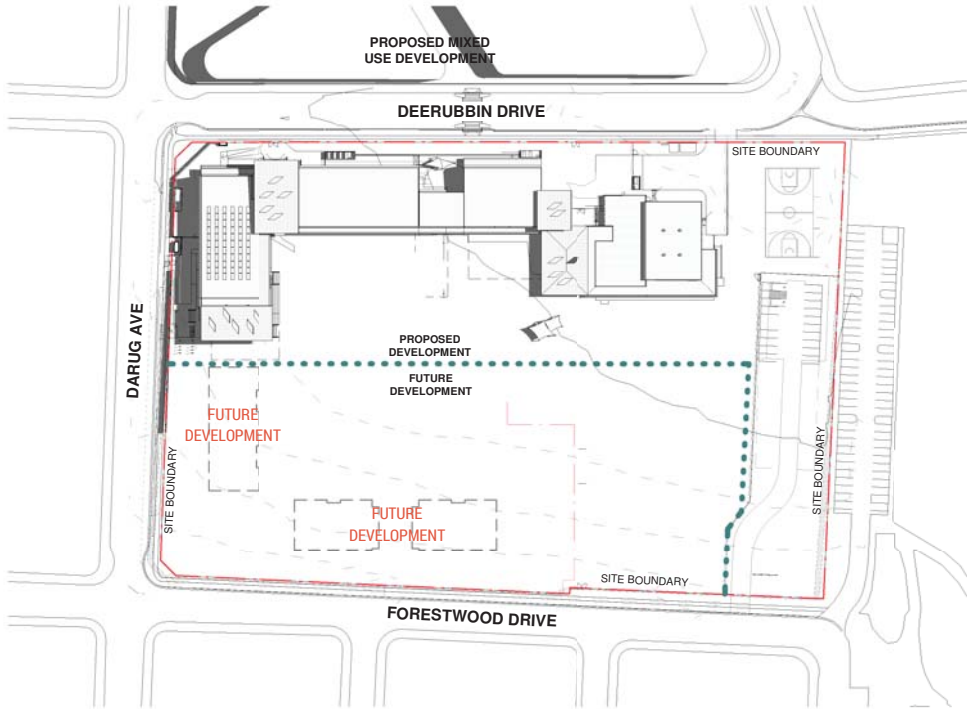

4 SHADOW DIAGRAM DEC 21 9AM

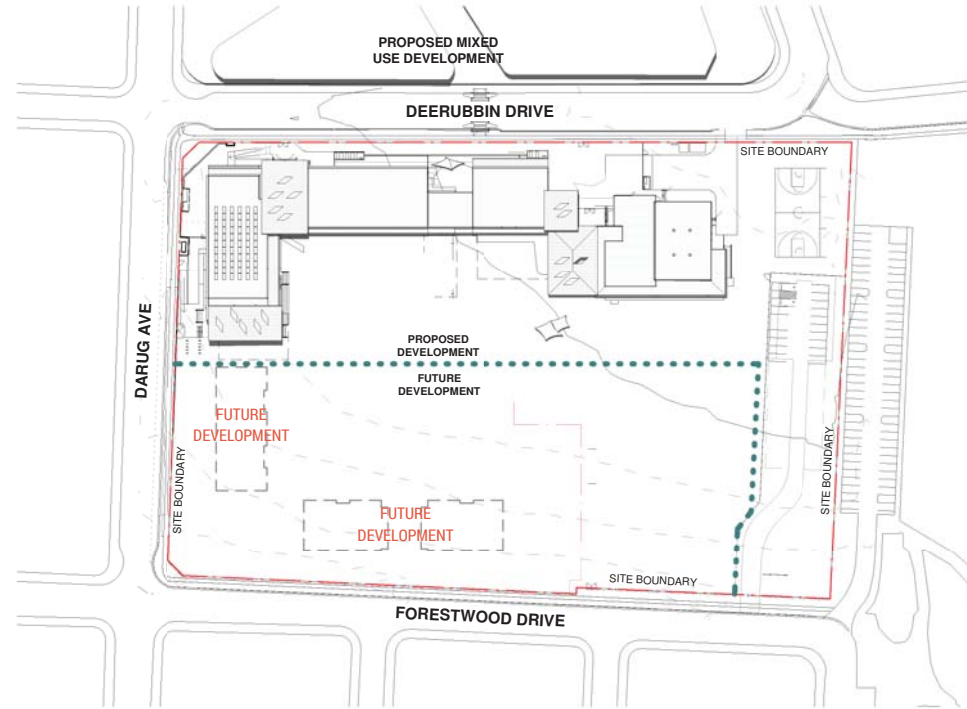

5 SHADOW DIAGRAM DEC 21 12PM

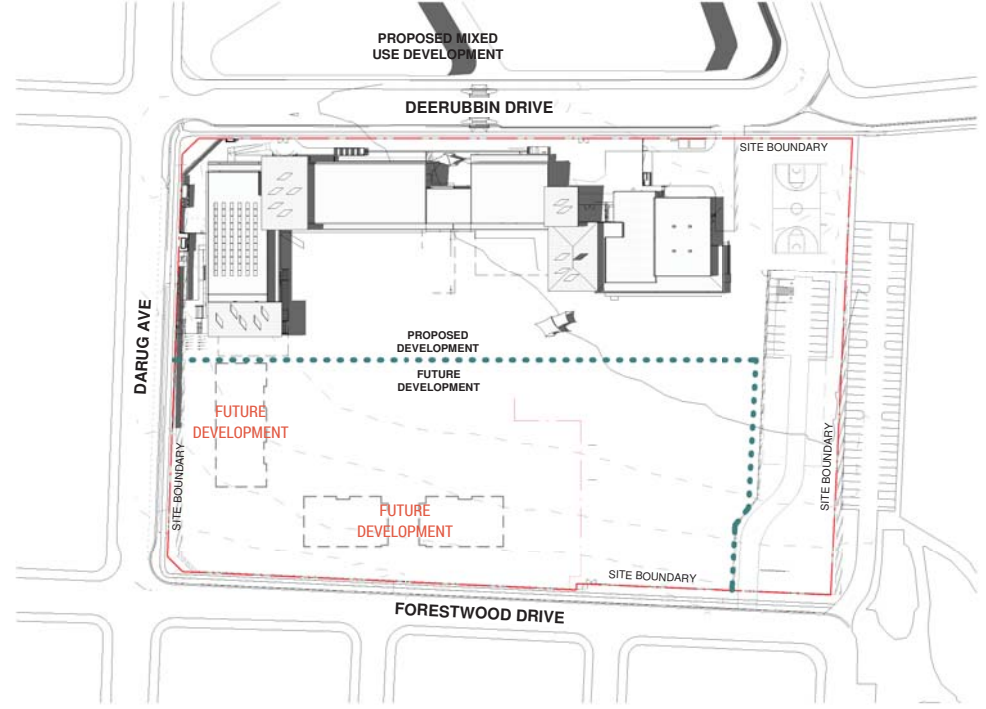

6 SHADOW DIAGRAM DEC 21 3PM

Issue No.	Date	Description	Chkd
1	12/04/2021	ISSUE FOR COORDINATION	
2	23/04/2021	ISSUE FOR COORDINATION	
3	04/05/2021	SSDA ISSUE	
4	06/08/2021	SSDA ISSUE	JL

SSDA ISSUE

RICHARD CROOKES
CONSTRUCTIONS

TRAFFIC ENGINEER
PTC
KASIA BALSAM
02 8920 0800
kasia.balsam@ptccconsultants.com

TOWN PLANNER
RPS
SHALIN SMITH
0425 285 778
shalin.smith@rpsgroup.com.au

MULTI SERVICES
NDY
RYAN HAHN
0407 236 908
r.hahn@ndy.com

CIVIL AND STRUCTURAL ENGINEERING
WOOLACOTTS
JUSTIN CHIRILLO
02 8203 1504
jchirillo@woolacotts.com.au

QUANTITY SURVEYOR
MBM
AUTUMN LU
02 9270 1062
autumn.lu@mbmpl.com.au

PROJECT MANAGER
COLLIERS
ANTHONY MAUGHAN-WRIGHT
0424 189 883
anthony.maughan-wright@colliers.com

 
Drawing Title
SHADOW DIAGRAMS

Project
NEW PRIMARY SCHOOL IN MULGOA
RISE
at
1-23 Forestwood drive, Glenmore Park, NSW 2745, Australia
for
SINSW

Architect
NBRSARCHITECTURE.
Sydney
61 2 9922 2344
Any form of replication of this drawing in full or in part without the written permission of NBR-S PARTNERS Pty Ltd constitutes an infringement of the copyright.
Nominated Architect:
Andrew Duffin NSW 5602
NBR-S & Partners Pty Ltd VIC 51197
nbsarchitecture.com
© 2021
ABN 16 002 247 565

Date 6/08/2021 4:22:24 PM
Scale NOT TO SCALE


Drawing Reference
20415-NBRS-DR-A-SSDA-0003
Revision
4



MGA



- (E3) EASEMENT FOR PADMOUNT SUBSTATION 2.75 WIDE (DP1161693)
 (R1) RESTRICTION ON THE USE OF LAND (DP1161693) (9)
 (R2) RESTRICTION ON THE USE OF LAND (DP1161693) (10)
 (X) RESTRICTION ON THE USE OF LAND (DP1109846)
 RESTRICTION ON THE USE OF LAND (31&14) (DP1153497)
 BENEFITED BY:
 EASEMENT FOR RETAINING WALL SUPPORT 0.5 WIDE (DP1153498)
 EASEMENT FOR RETAINING WALL SUPPORT 0.5 WIDE (DP1153449)

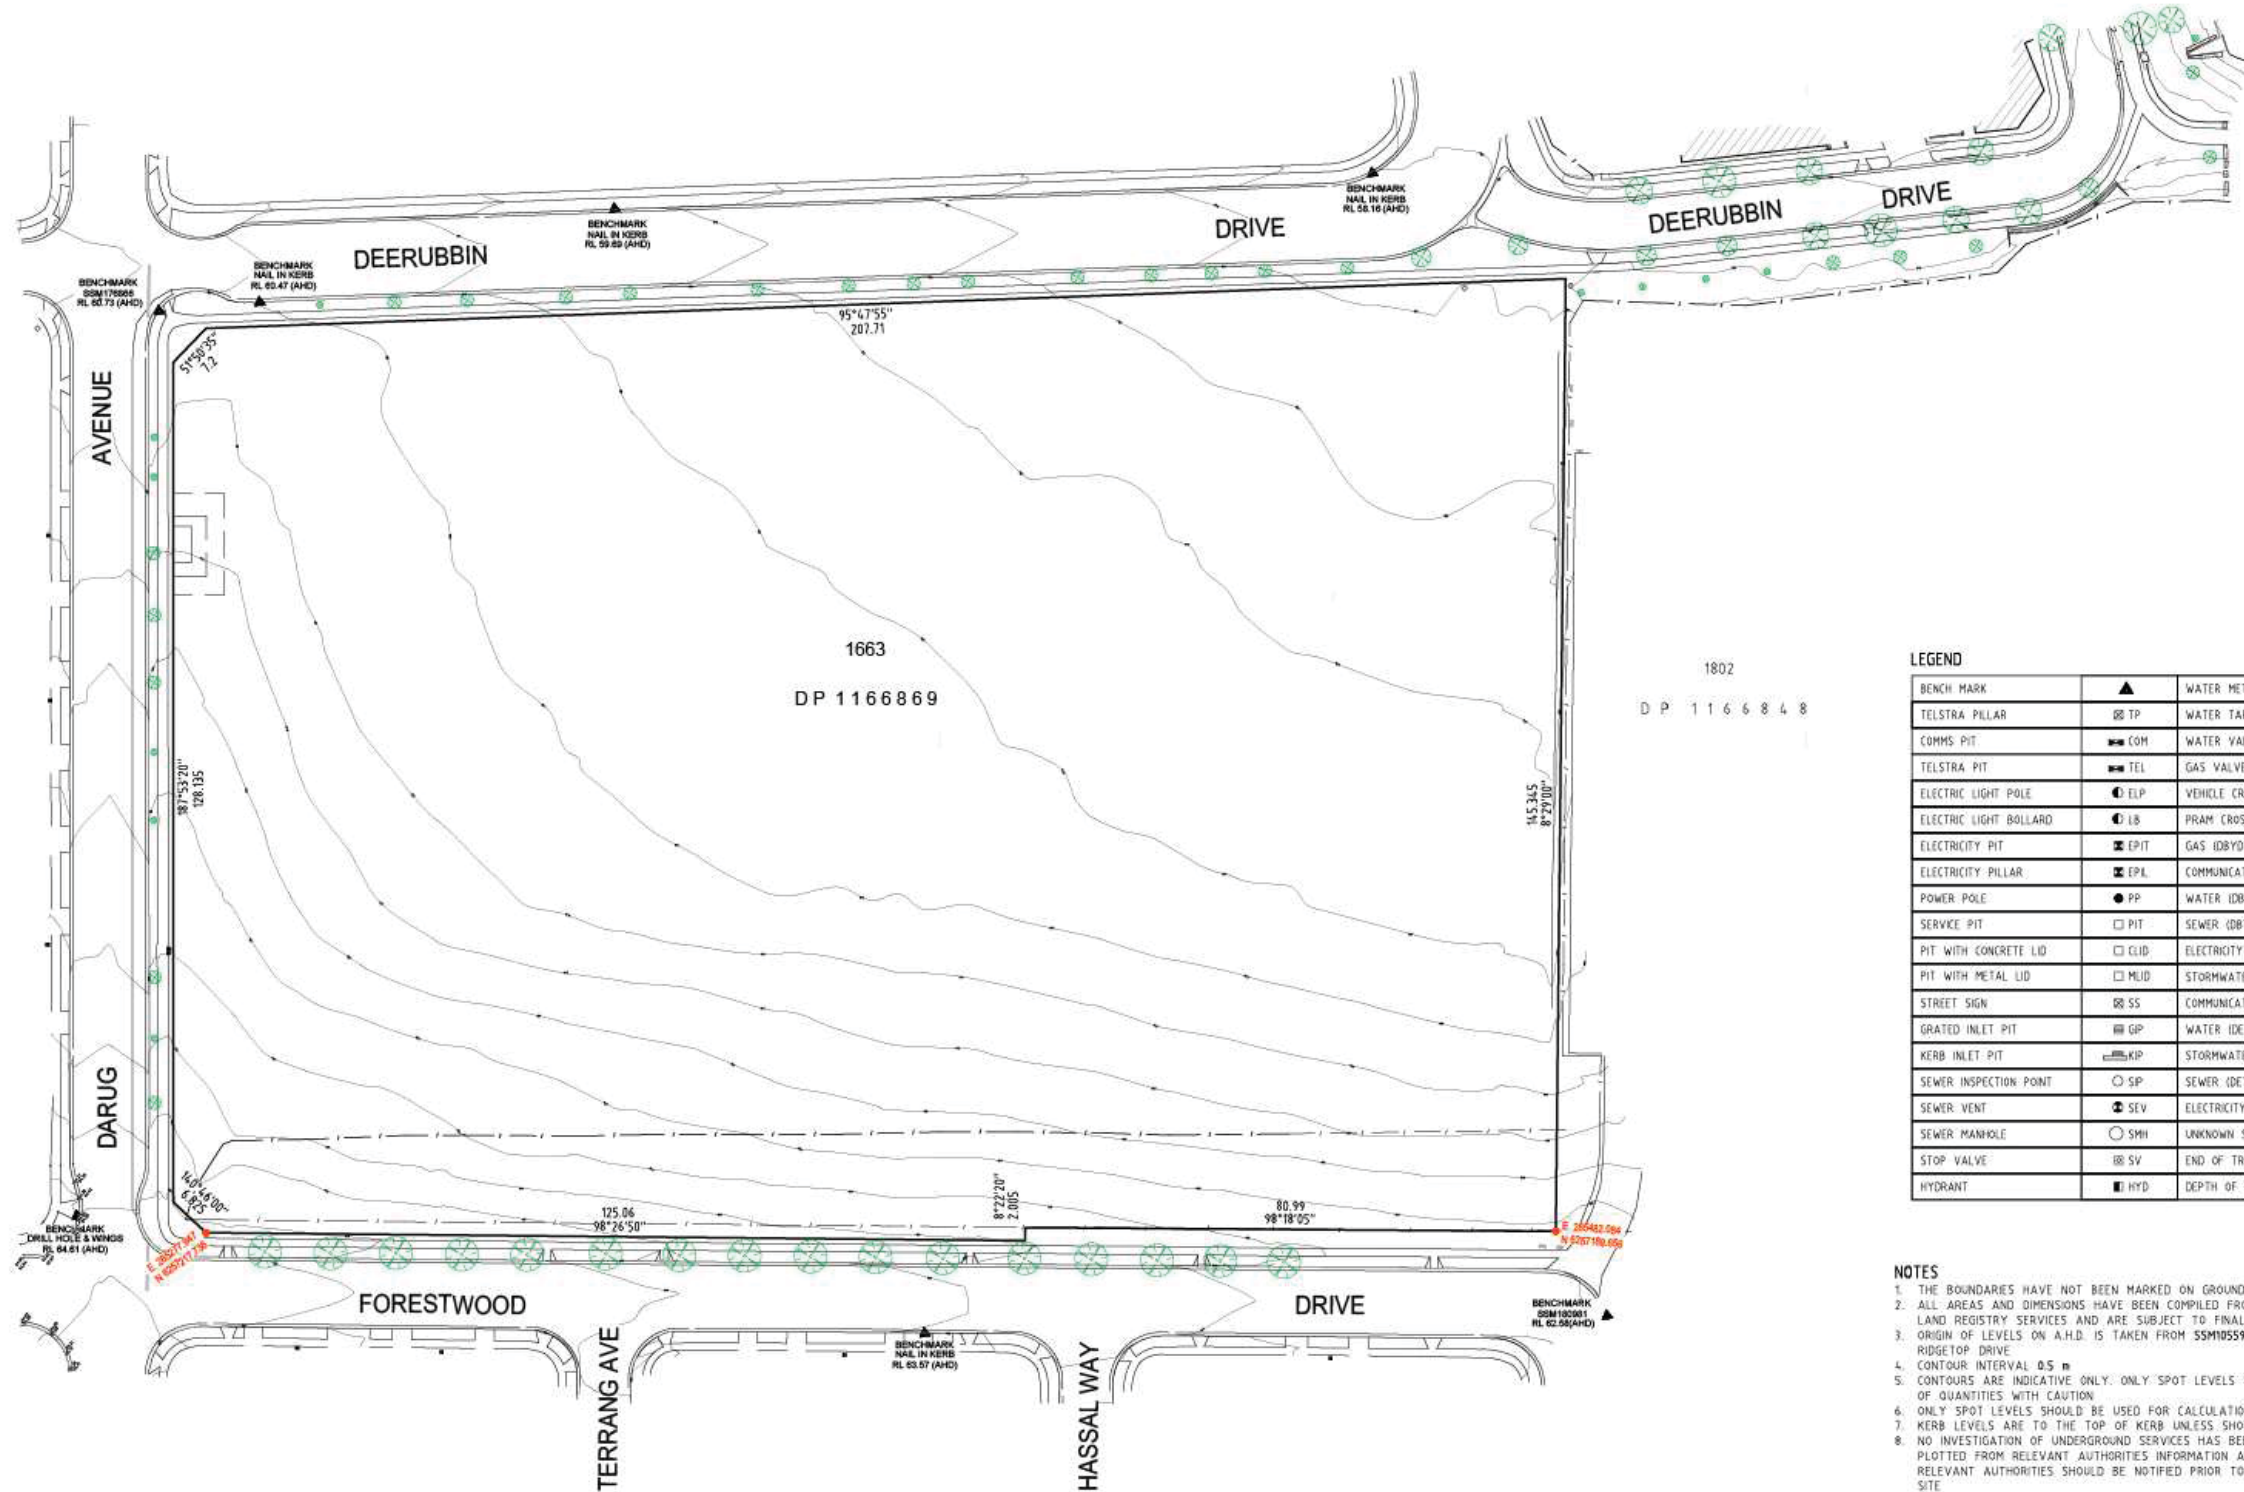

LEGEND

BENCH MARK	▲	WATER METER	⊕ WM
TELSTRA PILLAR	⊕ TP	WATER TAP	⊕ TAP
COMMS PIT	⊕ COM	WATER VALVE	⊕ WV
TELSTRA PIT	⊕ TEL	GAS VALVE	⊕ GAS
ELECTRIC LIGHT POLE	⊕ ELP	VEHICLE CROSSING	⊕ VEC
ELECTRIC LIGHT BOLLARD	⊕ LB	PRAM CROSSING	⊕ PC
ELECTRICITY PIT	⊕ EPI	GAS (DBYD)	⊕ G
ELECTRICITY PILLAR	⊕ EPL	COMMUNICATIONS (DBYD)	⊕ C
POWER POLE	⊕ PP	WATER (DBYD)	⊕ W
SERVICE PIT	⊕ PIT	SEWER (DBYD)	⊕ S
PIT WITH CONCRETE LID	⊕ CLID	ELECTRICITY (U/GROUND) (DBYD)	⊕ E
PIT WITH METAL LID	⊕ MLID	STORMWATER	⊕ SW
STREET SIGN	⊕ SS	COMMUNICATIONS (DETECTED)	⊕ CD
GRADED INLET PIT	⊕ GP	WATER (DETECTED)	⊕ WD
KERB INLET PIT	⊕ KIP	STORMWATER (DETECTED)	⊕ SWD
SEWER INSPECTION POINT	⊕ SP	SEWER (DETECTED)	⊕ SD
SEWER VENT	⊕ SEV	ELECTRICITY (DETECTED)	⊕ ED
SEWER MANHOLE	⊕ SMH	UNKNOWN SERVICE (DETECTED)	⊕ UD
STOP VALVE	⊕ SV	END OF TRACE	⊕ ET
HYDRANT	⊕ HYD	DEPTH OF SERVICE	D.S

NOTES

1. THE BOUNDARIES HAVE NOT BEEN MARKED ON GROUND
2. ALL AREAS AND DIMENSIONS HAVE BEEN COMPILED FROM PLANS MADE AVAILABLE BY NSW LAND REGISTRY SERVICES AND ARE SUBJECT TO FINAL SURVEY
3. ORIGIN OF LEVELS ON A.H.D. IS TAKEN FROM SSM105591 R.L. 64.225 (A.H.D.) IN RIDGETOP DRIVE
4. CONTOUR INTERVAL 0.5 m
5. CONTOURS ARE INDICATIVE ONLY. ONLY SPOT LEVELS SHOULD BE USED FOR CALCULATIONS OF QUANTITIES WITH CAUTION
6. ONLY SPOT LEVELS SHOULD BE USED FOR CALCULATIONS OF QUANTITIES WITH CAUTION
7. KERB LEVELS ARE TO THE TOP OF KERB UNLESS SHOWN OTHERWISE
8. NO INVESTIGATION OF UNDERGROUND SERVICES HAS BEEN MADE. SERVICES HAVE BEEN PLOTTED FROM RELEVANT AUTHORITIES INFORMATION AND HAVE NOT BEEN SURVEYED. ALL RELEVANT AUTHORITIES SHOULD BE NOTIFIED PRIOR TO ANY EXCAVATION ON OR NEAR THE SITE
9. 81/4/7 DENOTES TREE SPREAD OF 8m, TRUNK DIAMETER OF 0.4m & APPROX HEIGHT OF 7m
10. SHOWS APPROXIMATE POSITION OF ROAD LINEMARKING AND IS INDICATIVE ONLY
11. BEARINGS SHOWN ARE MGA (MAP GRID OF AUSTRALIA) ADD APPROX. 1°00' FOR TRUE NORTH



SCALE 1:500 @ A1

D	00/00/00	-	00
C	00/00/00	-	00
B	08/02/21	ROAD DETAIL & LEVELS ADDED, DETECTED SERVICES ADDED	002
A	26/11/20	ELECTRICAL DBYD UPDATED, 3D CONTOURS & BDY COORDINATES ADDED	001
Revision	Date	Description	Reference



THIS IS THE PLAN REFERRED TO IN MY LETTER DATED:
 Client: NSW DEPARTMENT OF EDUCATION
 Drawing title: PLAN OF DETAIL AND LEVELS OVER LOT 1663 IN DP1166869
 KNOWN AS 1-23 FORESTWOOD DRIVE, GLENMORE PARK
 Registered Surveyor NSW

Client: NSW DEPARTMENT OF EDUCATION
 Drawing title: PLAN OF DETAIL AND LEVELS OVER LOT 1663 IN DP1166869
 KNOWN AS 1-23 FORESTWOOD DRIVE, GLENMORE PARK

datum: AHD
 site Area: 3.001 ha
 LGA: PENRITH

reference number: 51025 001DT
 scale: @A1
 date of survey: 14/05/2020
 SHEET: 1 OF 6

Issue No.	Date	Description	Chkd
1	12/04/2021	ISSUE FOR COORDINATION	
2	23/04/2021	ISSUE FOR COORDINATION	
3	04/05/2021	SSDA ISSUE	
4	06/08/2021	SSDA ISSUE	JL

SSDA ISSUE

RICHARD CROOKES CONSTRUCTIONS

TRAFFIC ENGINEER
 PTC
 KASIA BALSAM
 02 8920 0800
 kasia.balsam@ptcconsultants.com.au

TOWN PLANNER
 RPS
 SHAUN SMITH
 0425 285 778
 shaun.smith@rpsgroup.com.au

MULTI SERVICES
 NDY
 RYAN HAHN
 0407 236 908
 r.hahn@ndy.com

CIVIL AND STRUCTURAL ENGINEERING
 WOOLACOTTS
 JUSTIN CHIRILLO
 02 8203 1504
 jchirillo@woolacotts.com.au

QUANTITY SURVEYOR
 MBM
 AUTUMN LU
 02 9270 1062
 autumn.lu@mbmpl.com.au


PROJECT MANAGER
 COLLIER'S
 ANTHONY MAUGHAN-WRIGHT
 0424 189 883
 anthony.maughan-wright@colliers.com

Drawing Title
 SITE SURVEY

Project
 NEW PRIMARY SCHOOL IN MULGOA
 RISE
 at
 1-23 Forestwood drive, Glenmore Park, NSW 2745, Australia
 for
 SINSW

Architect
NBR ARCHITECTURE.
 Sydney
 61 2 9922 2344
 Any form of replication of this drawing in full or in part without the written permission of NBR ARCHITECTURE Pty Ltd constitutes an infringement of the copyright.
 Nominated Architect:
 Andrew Duffin NSW 5602
 NBR & Partners Pty Ltd VIC 51197
 © 2021
 ABN 16 002 247 565

Date: 6/08/2021 4:22:32 PM
 Scale: 1:600 @ A1
 Drawing Reference: 20415-NBR-DR-A-SSDA-0101
 Revision: 4

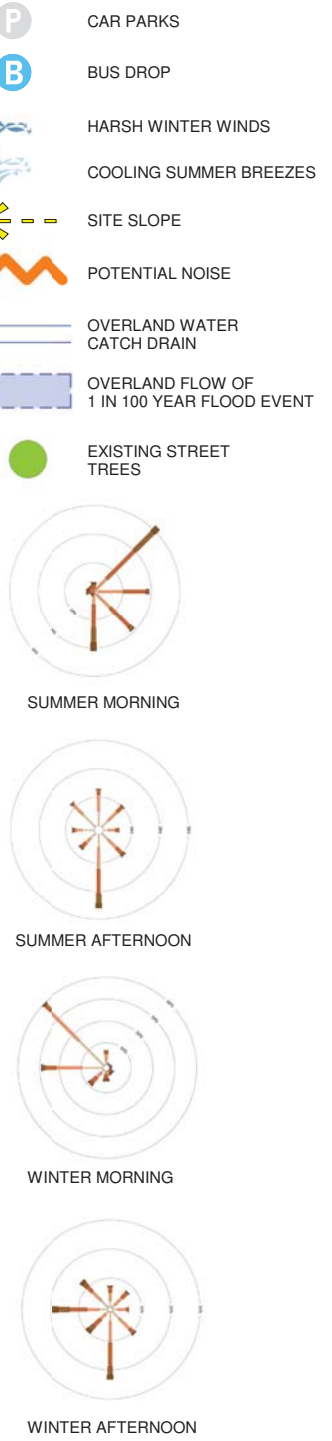

Issue No.	Date	Description	Chkd.
1	12/04/2021	ISSUE FOR COORDINATION	
2	23/04/2021	ISSUE FOR COORDINATION	
3	04/05/2021	SSDA ISSUE	
4	06/08/2021	SSDA ISSUE	JL

SSDA ISSUE

RICHARD CROOKES
CONSTRUCTIONS

TRAFFIC ENGINEER
PTC
KASIA BALSAM
02 8920 0800
kasia.balsam@ptccconsultants.co

TOWN PLANNER
RPS
SHALIN SMITH
0425 285 778
shalin.smith@rpsgroup.com.au

MULTI SERVICES
NDY
RYAN HAHN
0407 236 908
r.hahn@ndy.com

CIVIL AND STRUCTURAL ENGINEERING
WOOLACOTTS
JUSTIN CHIRILLO
02 8203 1504
jchirillo@woolacotts.com.au

QUANTITY SURVEYOR
MBM
AUTUMN LU
02 9270 1062
autumn.lu@mbmpl.com.au


PROJECT MANAGER
COLLIERS
ANTHONY MAUGHAN-WRIGHT
0424 189 883
anthony.maughan-wright@colliers.com

Drawing Title
SITE ANALYSIS

Project
NEW PRIMARY SCHOOL IN MULGOA RISE
at
1-23 Forestwood drive, Glenmore Park, NSW 2745, Australia
for
SINSW

Architect
NBRSPARTNERS
Sydney
61 2 9922 2344
Any form of replication of this drawing in full or in part without the written permission of NBRSPARTNERS Pty Ltd constitutes an infringement of the copyright.
Nominated Architect:
Andrew Duffin NSW 5602
NBRSPARTNERS Pty Ltd VIC 51197
nbrsarchitecture.com
ABN 16 002 247 565

Date 6/08/2021 4:22:43 PM
Scale 1:1000 @ A1
Drawing Reference
20415-NBRS-DR-A-SSDA-0102
Revision
4

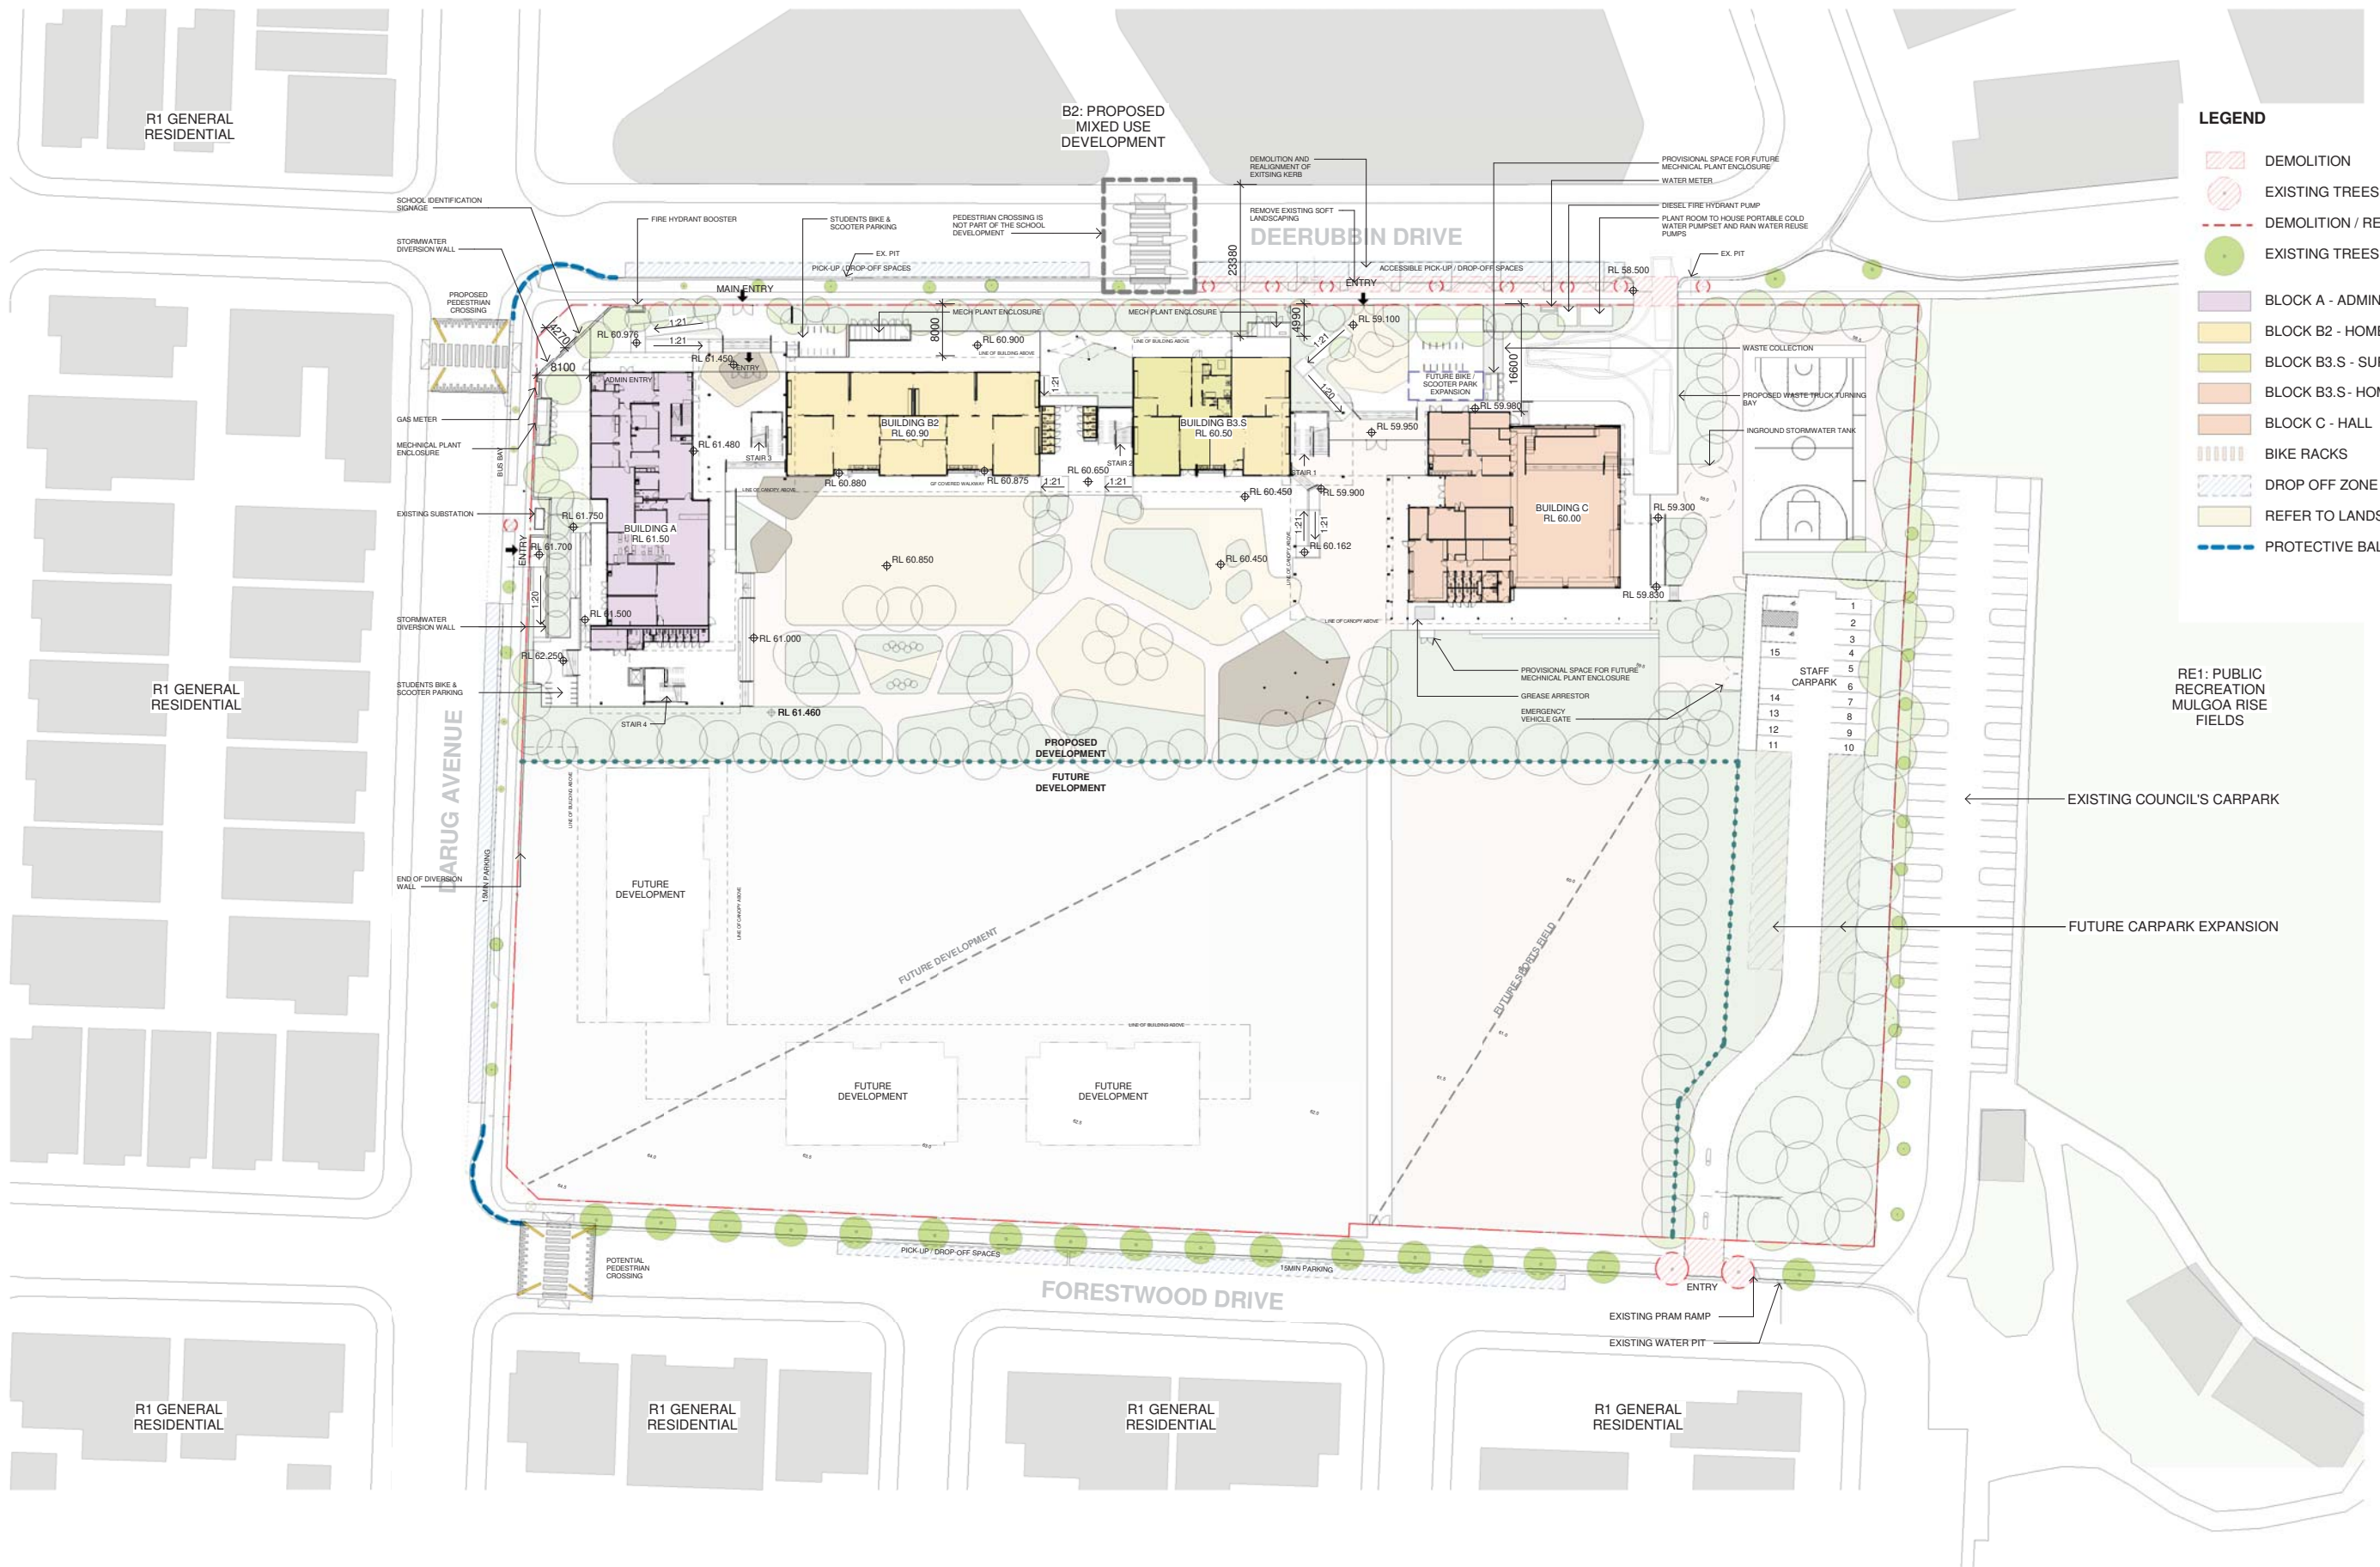

Issue			
No.	Date	Description	Chkd
2	16/04/2021	SD ISSUE	
3	23/04/2021	ISSUE FOR COORDINATION	
4	04/05/2021	SSDA ISSUE	
5	14/07/2021	FOR INFORMATION	
6	19/07/2021	COORDINATION ISSUE	JL
7	28/07/2021	ISSUE FOR COORDINATION	
8	06/08/2021	SSDA ISSUE	JL
9	11/08/2021	SSDA ISSUE	JL
10	17/08/2021	SSDA ISSUE	JL

SSDA ISSUE

RICHARD CROOKES

CONSTRUCTIONS

TRAFFIC ENGINEER
PTC
KASIA BALSAM
02 8920 0800
kasia.balsam@ptcconsultants.co

TOWN PLANNER
RPS
ROB DWYER
0425 285 778
rob.dwyer@rpsgroup.com.au

**MULTI SERVICES
NDY**
RYAN HAHN
0407 236 908
r.hahn@ndy.com

CIVIL AND STRUCTURAL ENGINEERING
WOOLACOTTS
JUSTIN CHIRILLO
02 8203 1504
jchirillo@woolacotts.com.au

QUANTITY SURVEYOR
MBM
AUTUMN LU
02 9270 1062
autumn.lu@mbmpl.com.au

PROJECT MANAGER
COLLIERS
ANTHONY MAUGHAN-WRIGHT
0424 189 883
anthony.maughan-wright@colliers.com

Drawing Title
SITE PLAN

Project
NEW PRIMARY SCHOOL IN MULGOA
RISE
at
1-23 Forestwood drive, Glenmore Park, NSW 2745, Australia
for
SINSW

Architect
NBRARCHITECTURE.


Sydney
61 2 9922 2344
nbrsarchitecture.com

Any form of replication of this drawing in full or in part without the written permission of NBR&PARTNERS Pty Ltd constitutes an infringement of the copyright.

Nominated Architect:
Andrew Duffin NSW 5602
NBR& Partners Pty Ltd VIC 51197

© 2021
ABN 16 002 247 565


 Date 19/08/2021 6:20:54 PM
 Scale 1:500 @ A1
 Drawing Reference Revision
 20415-NBRS-DR-A-SSDA-0110 10

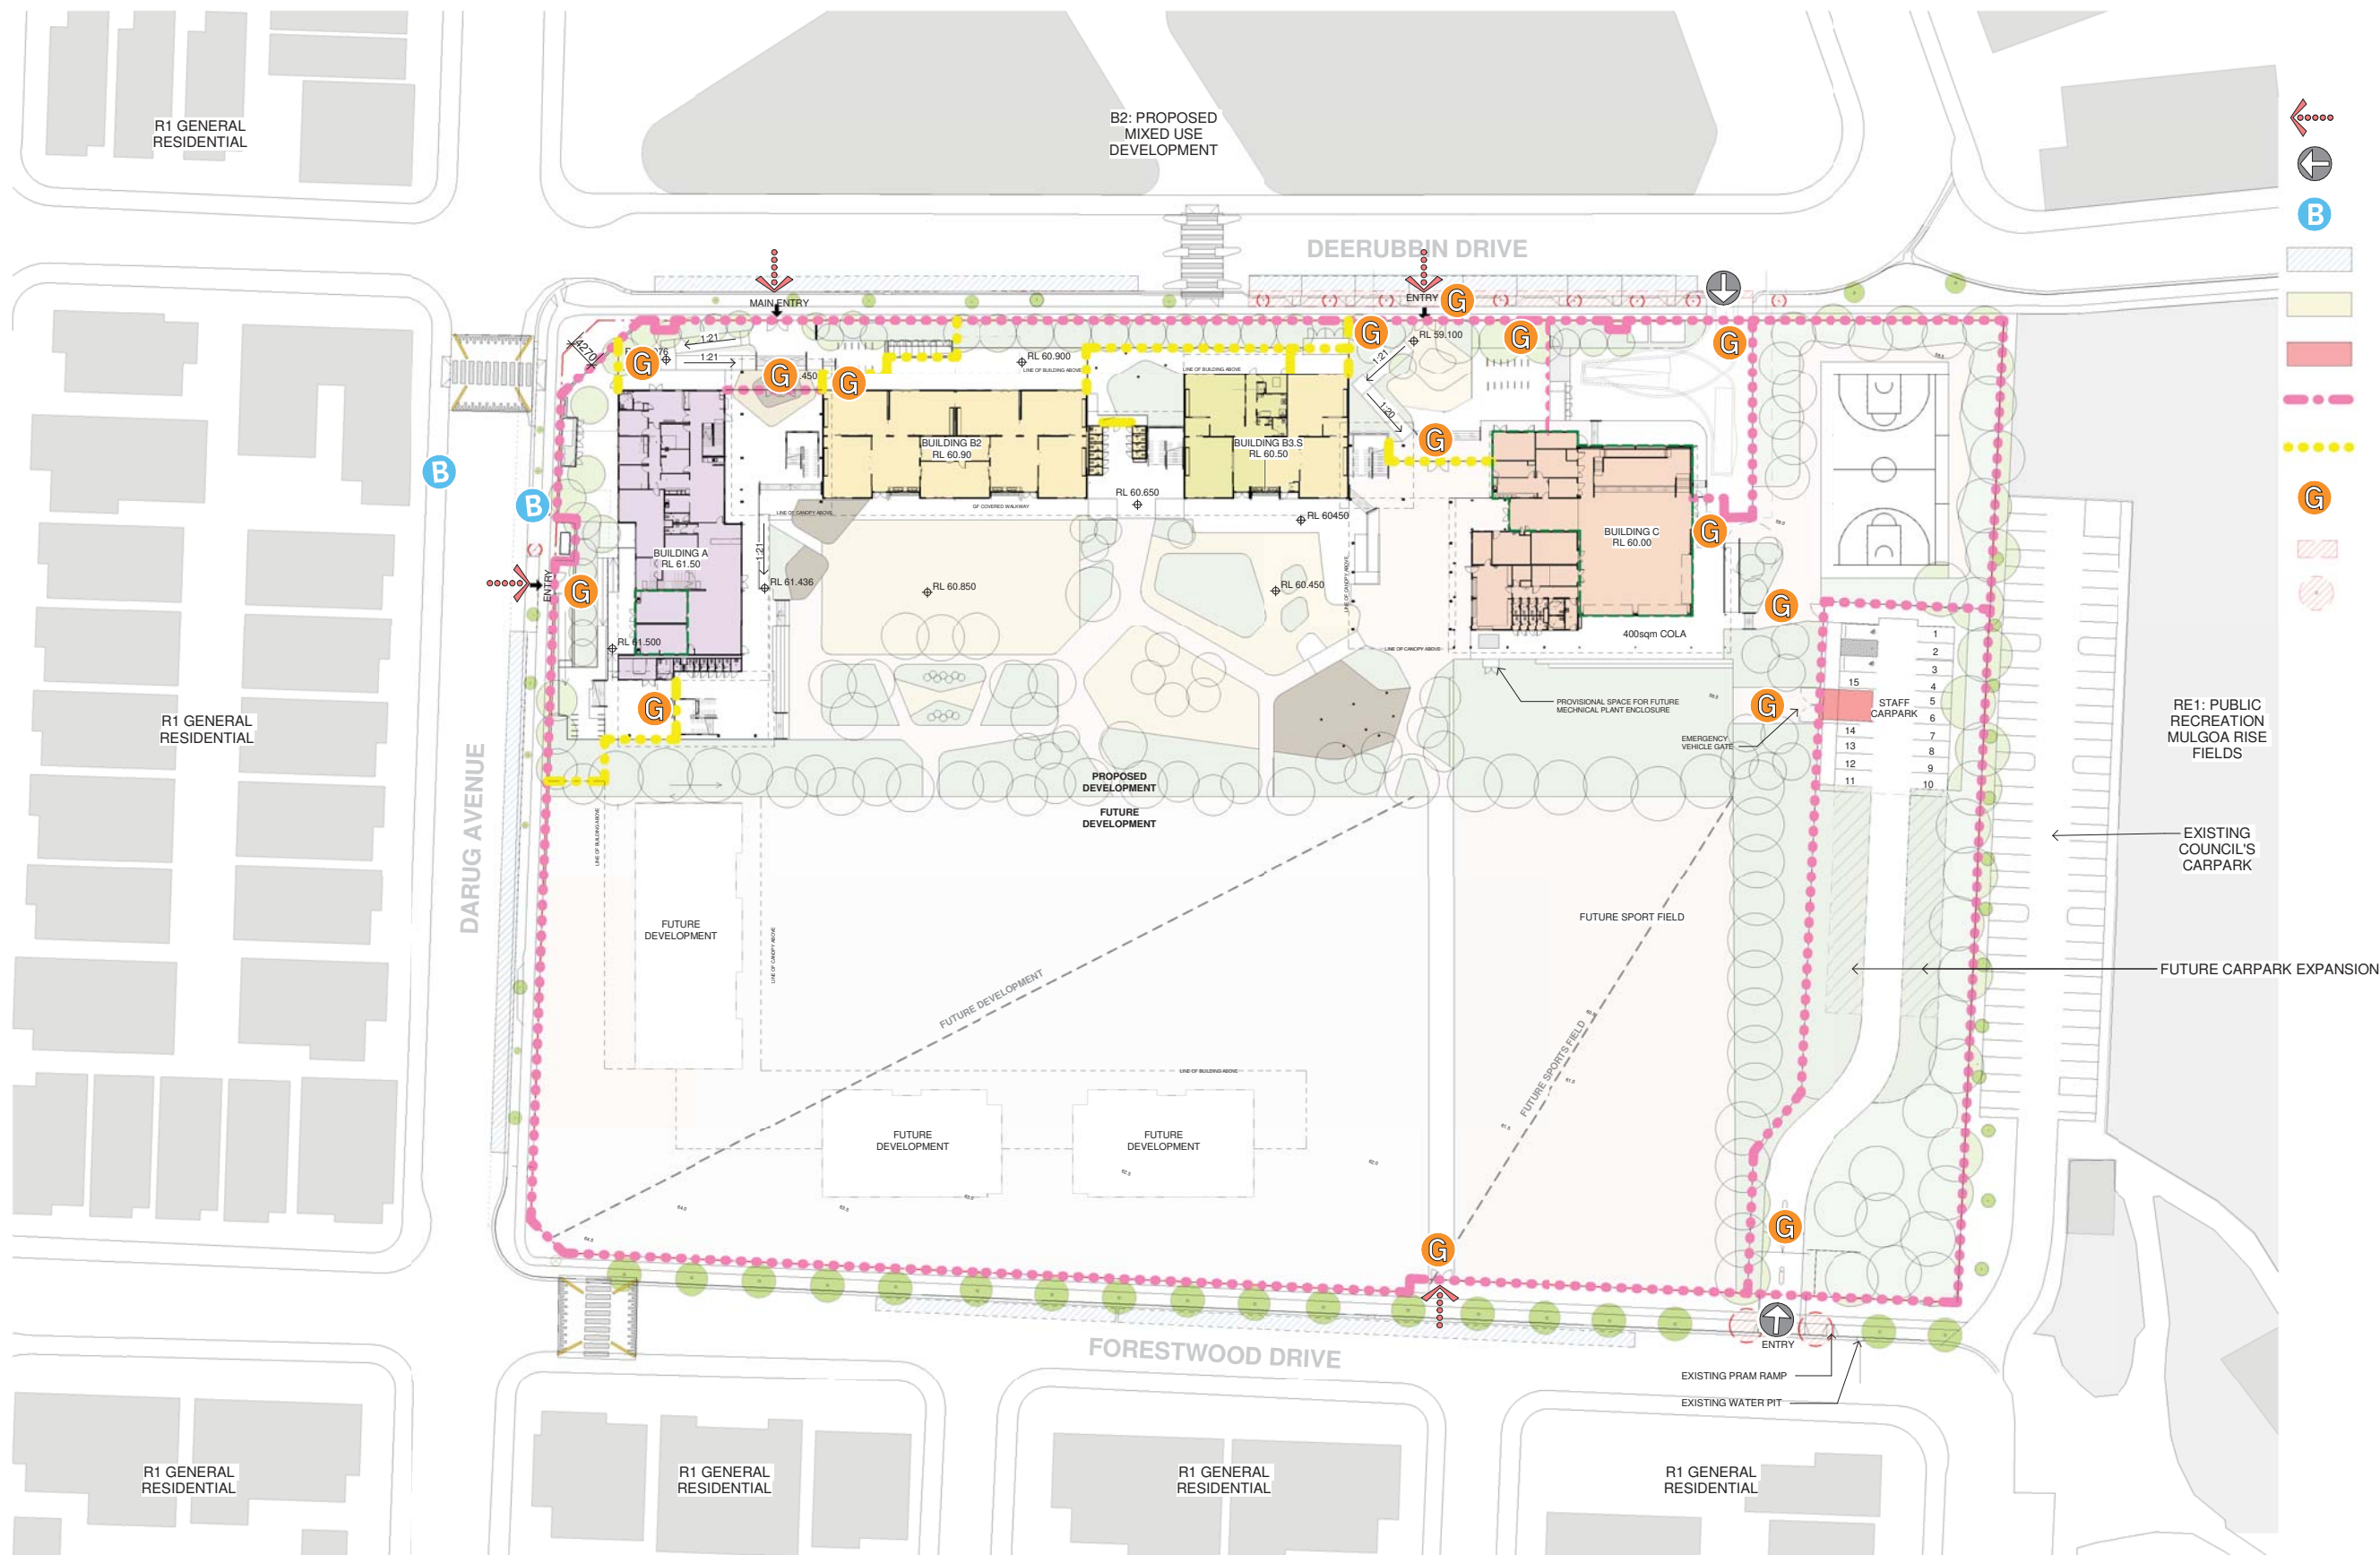

- PEDESTRIAN ACCESS
- VEHICULAR ACCESS
- PUBLIC TRANSPORT
- DROP OFF ZONES
- WASTE COLLECTION
- EMERGENCY
- 2100 H PERIMETER FENCE
- SECONDARY SECURE FENCE
- GATE
- DEMOLITION
- EXISTING TREES TO BE REMOVED

Issue No.	Date	Description	Chkd
1	12/04/2021	ISSUE FOR COORDINATION	
2	16/04/2021	SD ISSUE	
3	23/04/2021	ISSUE FOR COORDINATION	
4	04/05/2021	SSDA ISSUE	JL
5	06/08/2021	SSDA ISSUE	JL
6	11/08/2021	SSDA ISSUE	JL
7	17/08/2021	SSDA ISSUE	JL

SSDA ISSUE

RICHARD CROOKES
CONSTRUCTIONS

TRAFFIC ENGINEER
PTC
KASIA BALSAM
02 8920 0800
kasia.balsam@ptccconsultants.co

TOWN PLANNER
RPS
ROB DWYER
0425 285 778
rob.dwyer@rpsgroup.com.au

MULTI SERVICES
NDY
RYAN HAHN
0407 236 908
r.hahn@ndy.com

CIVIL AND STRUCTURAL ENGINEERING
WOOLACOTTS
JUSTIN CHIRILLO
02 8203 1504
jchirillo@woolacotts.com.au

QUANTITY SURVEYOR
MBM
AUTUMN LU
02 9270 1062
autumn.lu@mbmpl.com.au

PROJECT MANAGER
COLLIERS
ANTHONY MAUGHAN-WRIGHT
0424 189 883
anthony.maughan-wright@colliers.com

Drawing Title
SITE ACCESS AND SECURITY PLAN

Project
NEW PRIMARY SCHOOL IN MULGOA RISE
at
1-23 Forestwood drive, Glenmore Park, NSW 2745, Australia
for
SINSW

Architect
NBRSARCHITECTURE.
Sydney
61 2 9922 2344
Any form of replication of this drawing in full or in part without the written permission of NBR-S+PARTNERS Pty Ltd constitutes an infringement of the copyright.
Nominated Architect:
Andrew Duffin NSW 5602
NBR-S & Partners Pty Ltd VIC 51197


© 2021
ABN 16 002 247 565

Date 17/08/2021 5:25:06 PM
Scale 1:500 @ A1


Drawing Reference
20415-NBRS-DR-A-SSDA-0113

Revision
7


0 5m 10m 15m 20m 25m 30m 35m 40m 1:500

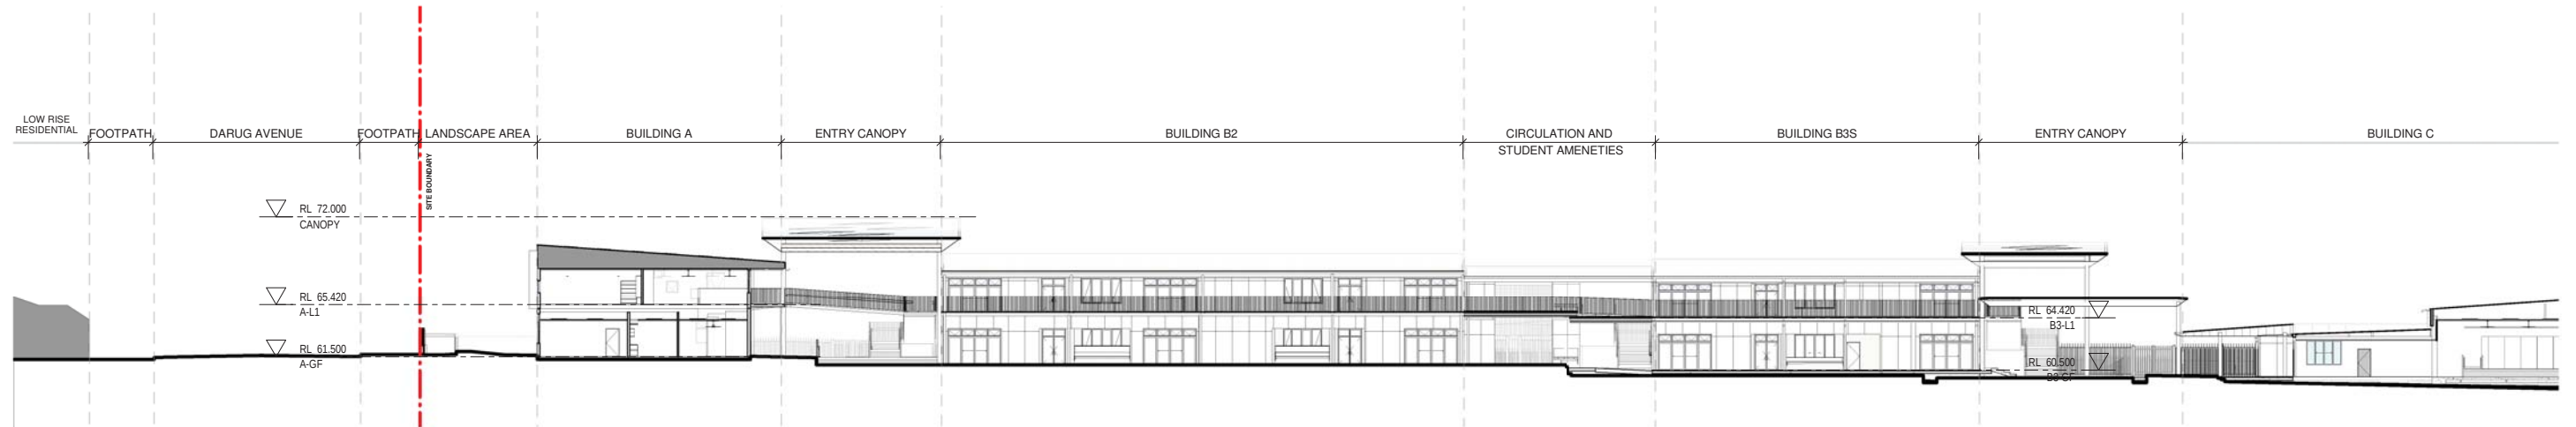

1 SITE SECTION 01 PART 1
1 : 250

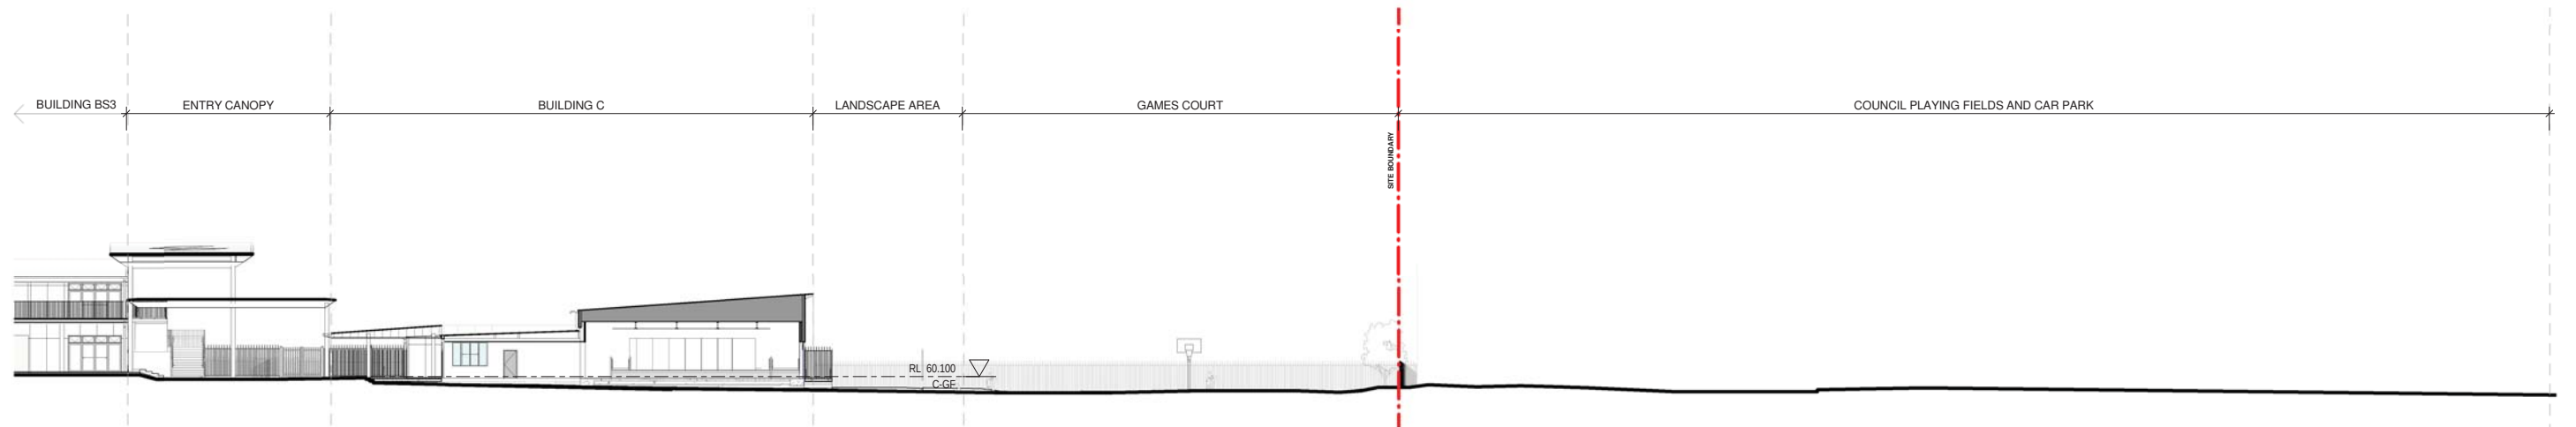

2 SITE SECTION 01 PART 2
1 : 250

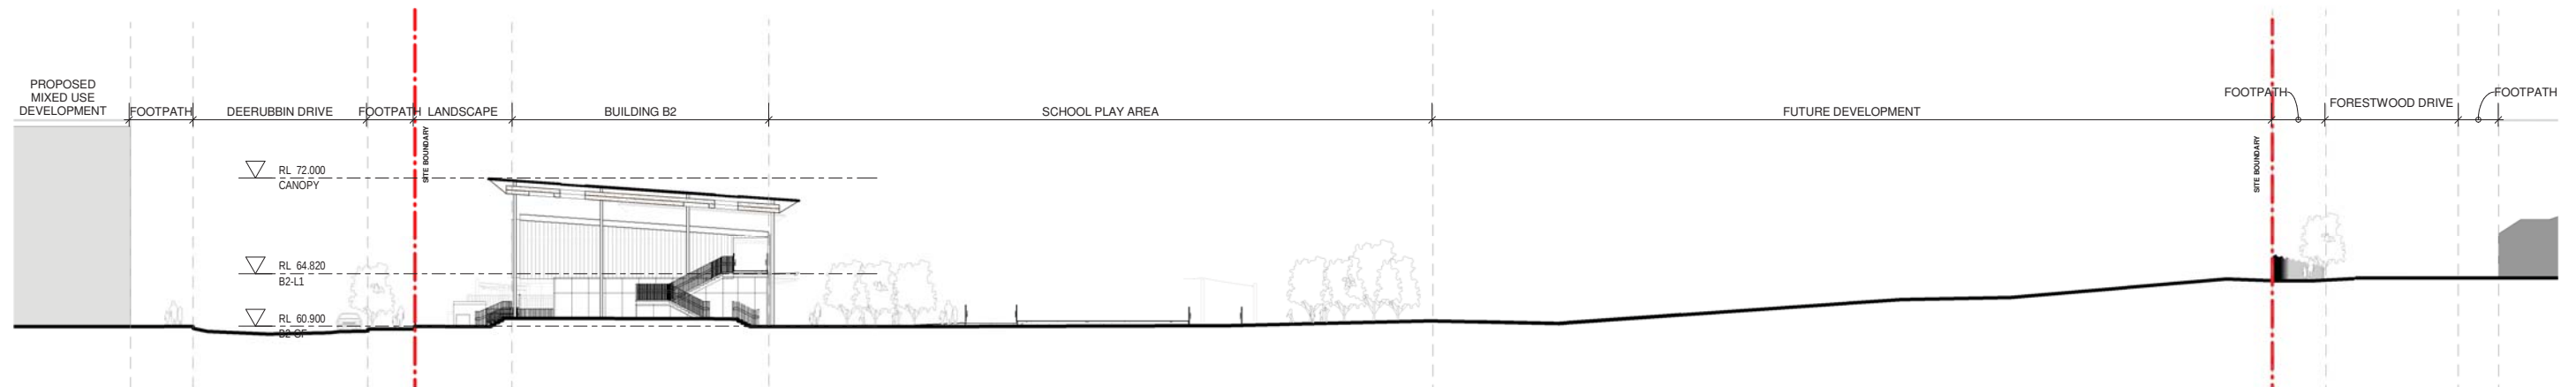

3 SITE SECTION 02
1 : 250

Issue No.	Date	Description	Chkd
1	12/04/2021	ISSUE FOR COORDINATION	
2	23/04/2021	ISSUE FOR COORDINATION	
3	04/05/2021	SSDA ISSUE	
4	06/08/2021	SSDA ISSUE	JL

SSDA ISSUE

RICHARD CROOKES
CONSTRUCTIONS

TRAFFIC ENGINEER
PTC
KASIA BALSAM
02 8920 0800
kasia.balsam@ptcconsultants.co

TOWN PLANNER
RPS
SHALIN SMITH
0425 285 778
shalin.smith@rpsgroup.com.au

MULTI SERVICES
NDY
RYAN HAHN
0407 236 908
r.hahn@ndy.com

CIVIL AND STRUCTURAL ENGINEERING
WOOLACOTTS
JUSTIN CHIRILLO
02 8203 1504
jchirillo@woolacotts.com.au

QUANTITY SURVEYOR
MBM
AUTUMN LU
02 9270 1062
autumn.lu@mbmpl.com.au

PROJECT MANAGER
COLLIERS
ANTHONY MAUGHAN-WRIGHT
0424 189 883
anthony.maughan-wright@colliers.com

Drawing Title
SITE SECTIONS


Project
NEW PRIMARY SCHOOL IN MULGOA
RISE
at
1-23 Forestwood drive, Glenmore Park, NSW 2745, Australia
for
SINSW

Architect
NBRSARCHITECTURE.
Sydney
61 2 9922 2344
Any form of replication of this drawing in full or in part without the written permission of NBR-SPARTNERS Pty Ltd constitutes an infringement of the copyright.
Nominated Architect:
Andrew Duffin NSW 5602
NBR & Partners Pty Ltd VIC 51197
nbsarchitecture.com
© 2021
ABN 16 002 247 565

Date 6/08/2021 4:25:29 PM
Scale 1:250 @ A1

Drawing Reference
20415-NBRS-DR-A-SSDA-0115
Revision
4

0 2.5m 5m 7.5m 10m 12.5m 15m 17.5m 20m 1:250

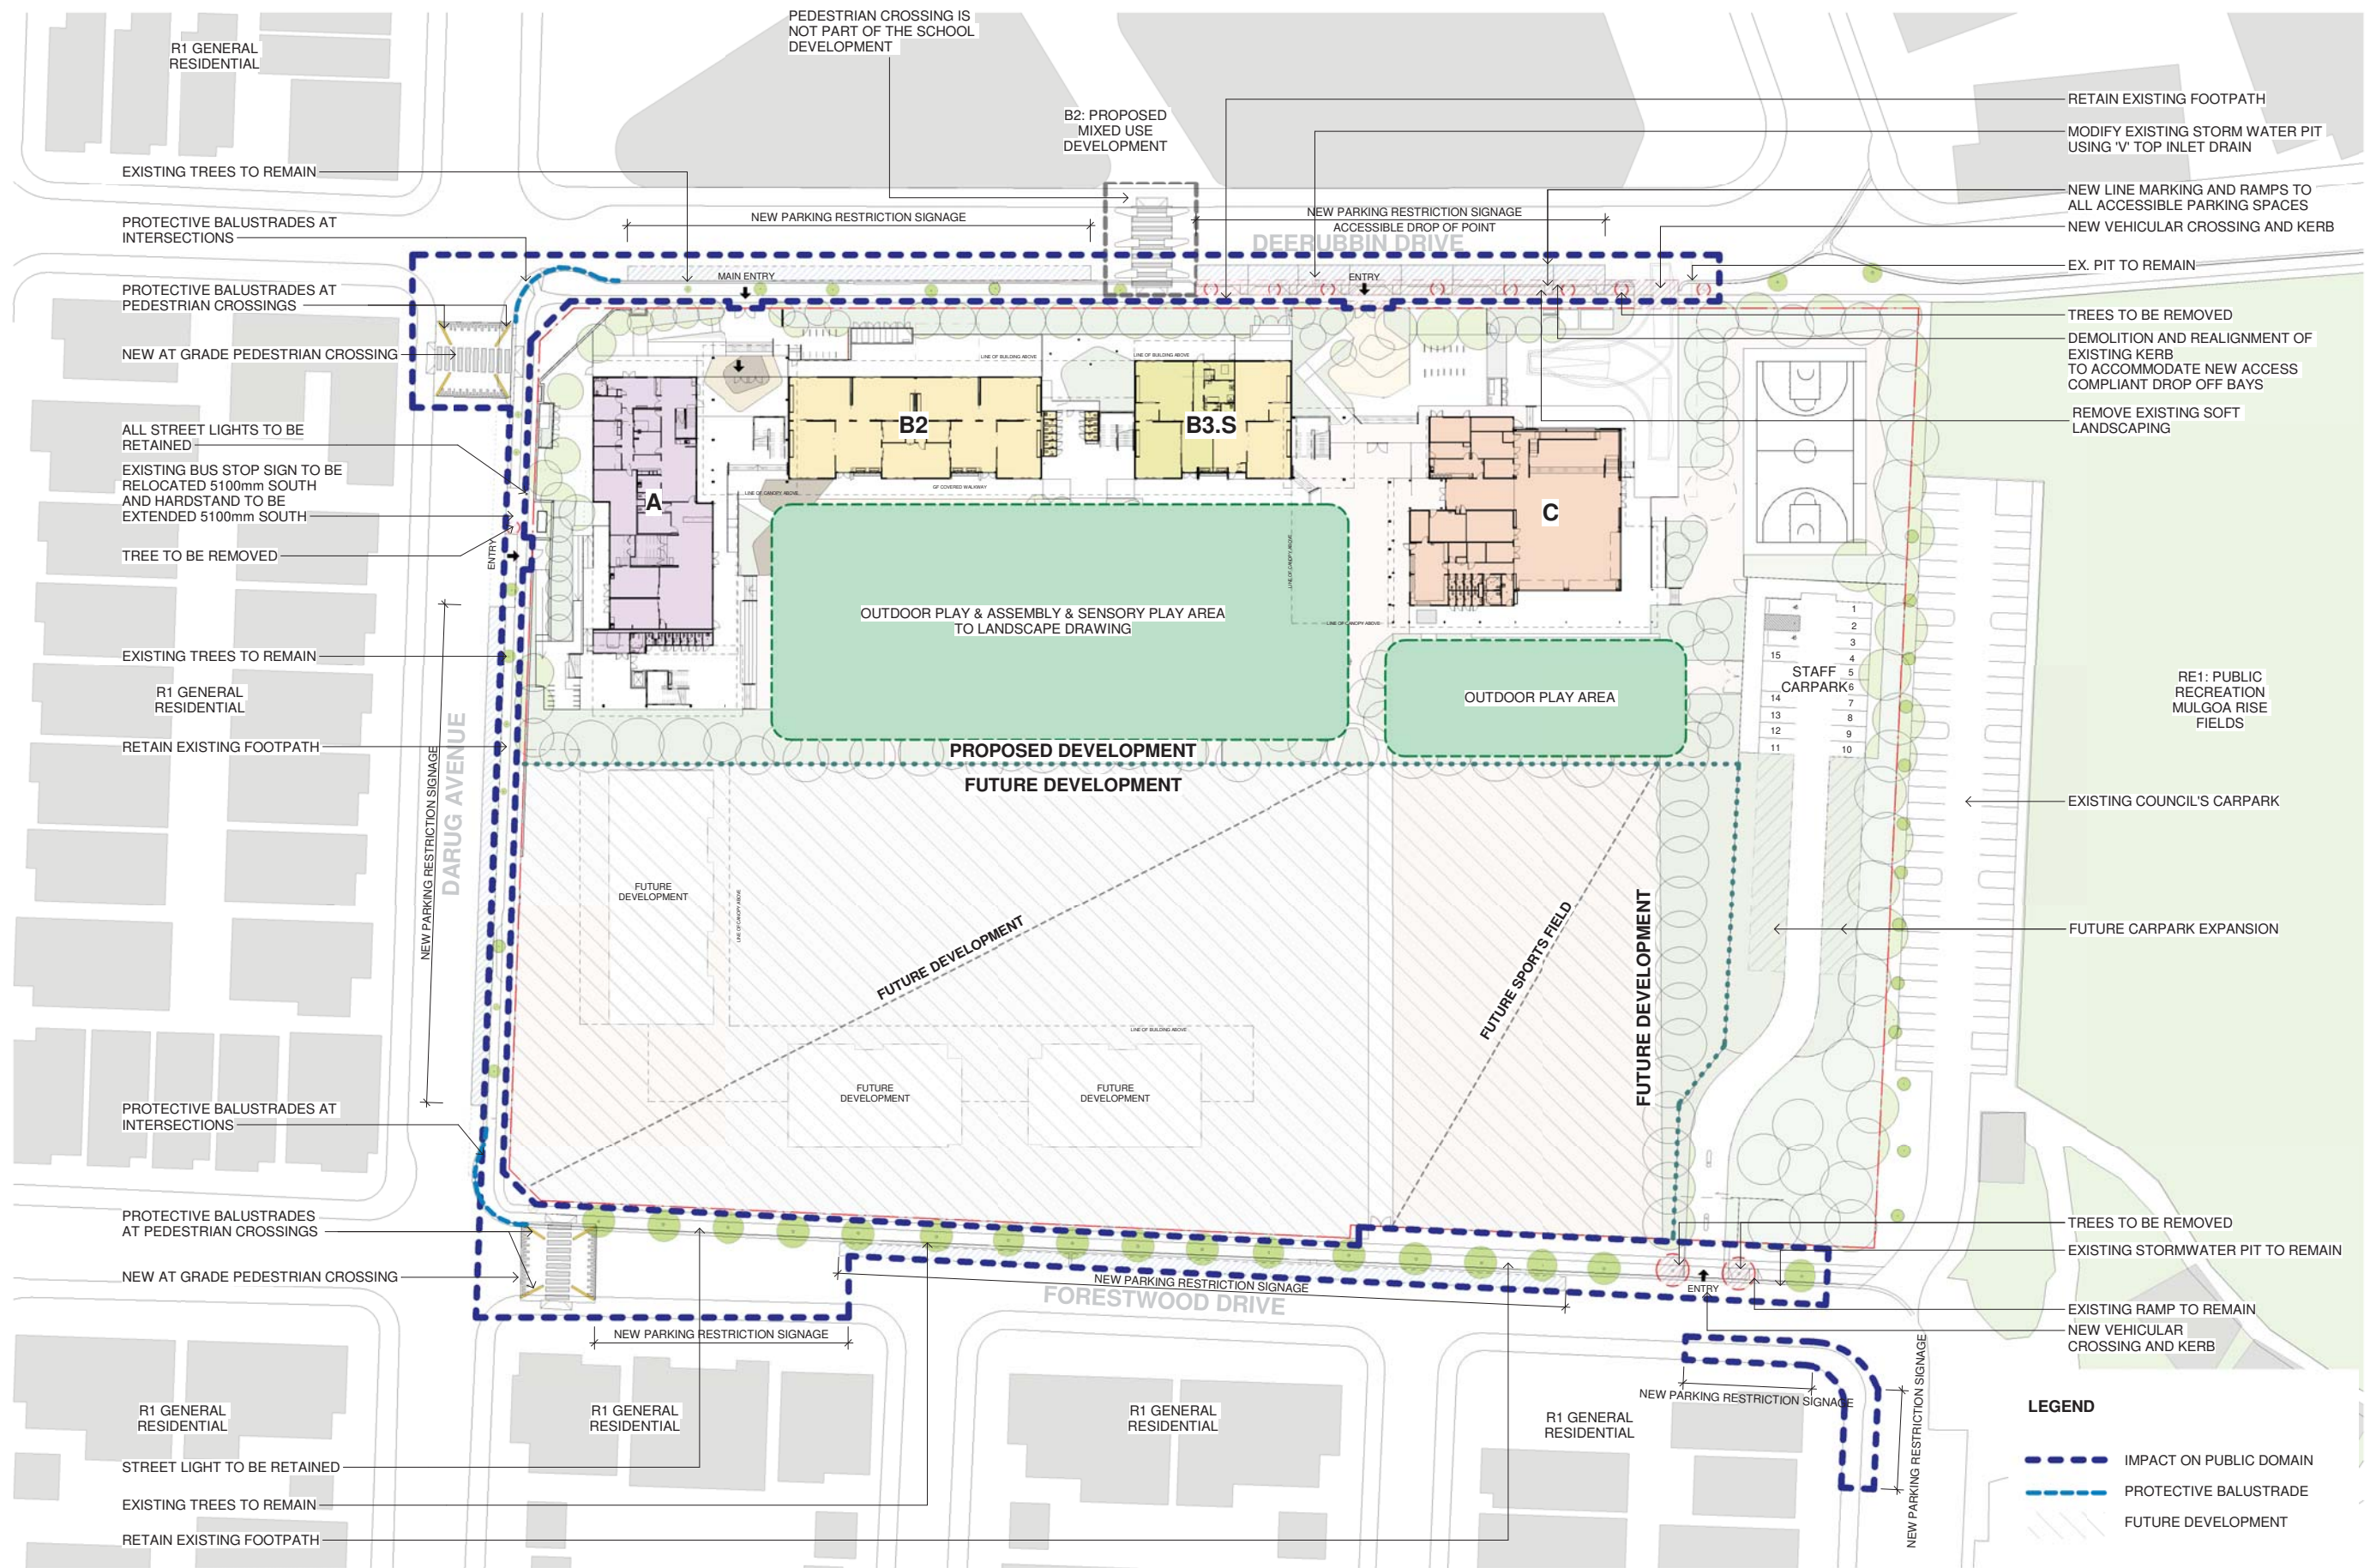

Issue No.	Date	Description	Chkd
1	17/08/2021	SSDA ISSUE	JL

SSDA ISSUE

RICHARD CROOKES
CONSTRUCTIONS

TRAFFIC ENGINEER
PTC
KASIA BALSAM
02 8920 0800
kasia.balsam@ptccconsultants.co

TOWN PLANNER
RPS
ROB DWYER
0425 285 778
rob.dwyer@rpsgroup.com.au

MULTI SERVICES
NDY
RYAN HAHN
0407 236 908
r.hahn@ndy.com

CIVIL AND STRUCTURAL ENGINEERING
WOOLACOTTS
JUSTIN CHIRILLO
02 8203 1504
jchirillo@woolacotts.com.au

QUANTITY SURVEYOR
MBM
AUTUMN LU
02 9270 1062
autumn.lu@mbmpl.com.au

PROJECT MANAGER
COLLIERS
ANTHONY MAUGHAN-WRIGHT
0424 189 883
anthony.maughan-wright@colliers.com


Drawing Title
PUBLIC DOMAIN SCOPE OF WORKS

Project
NEW PRIMARY SCHOOL IN MULGOA RISE
at
1-23 Forestwood drive, Glenmore Park, NSW 2745, Australia
for
SINSW


Architect
NBRSARCHITECTURE.
Sydney
61 2 9922 2344
Any form of replication of this drawing in full or in part without the written permission of NBR-S+PARTNERS Pty Ltd constitutes an infringement of the copyright.
Nominated Architect:
Andrew Duffin NSW 5602
NBR & Partners Pty Ltd VIC 51197
nbrsarchitecture.com
© 2021
ABN 16 002 247 565

Date 19/08/2021 6:21:41 PM
Scale 1 : 500 @ A1

Drawing Reference
20415-NBRS-DR-A-SSDA-0120
Revision
1

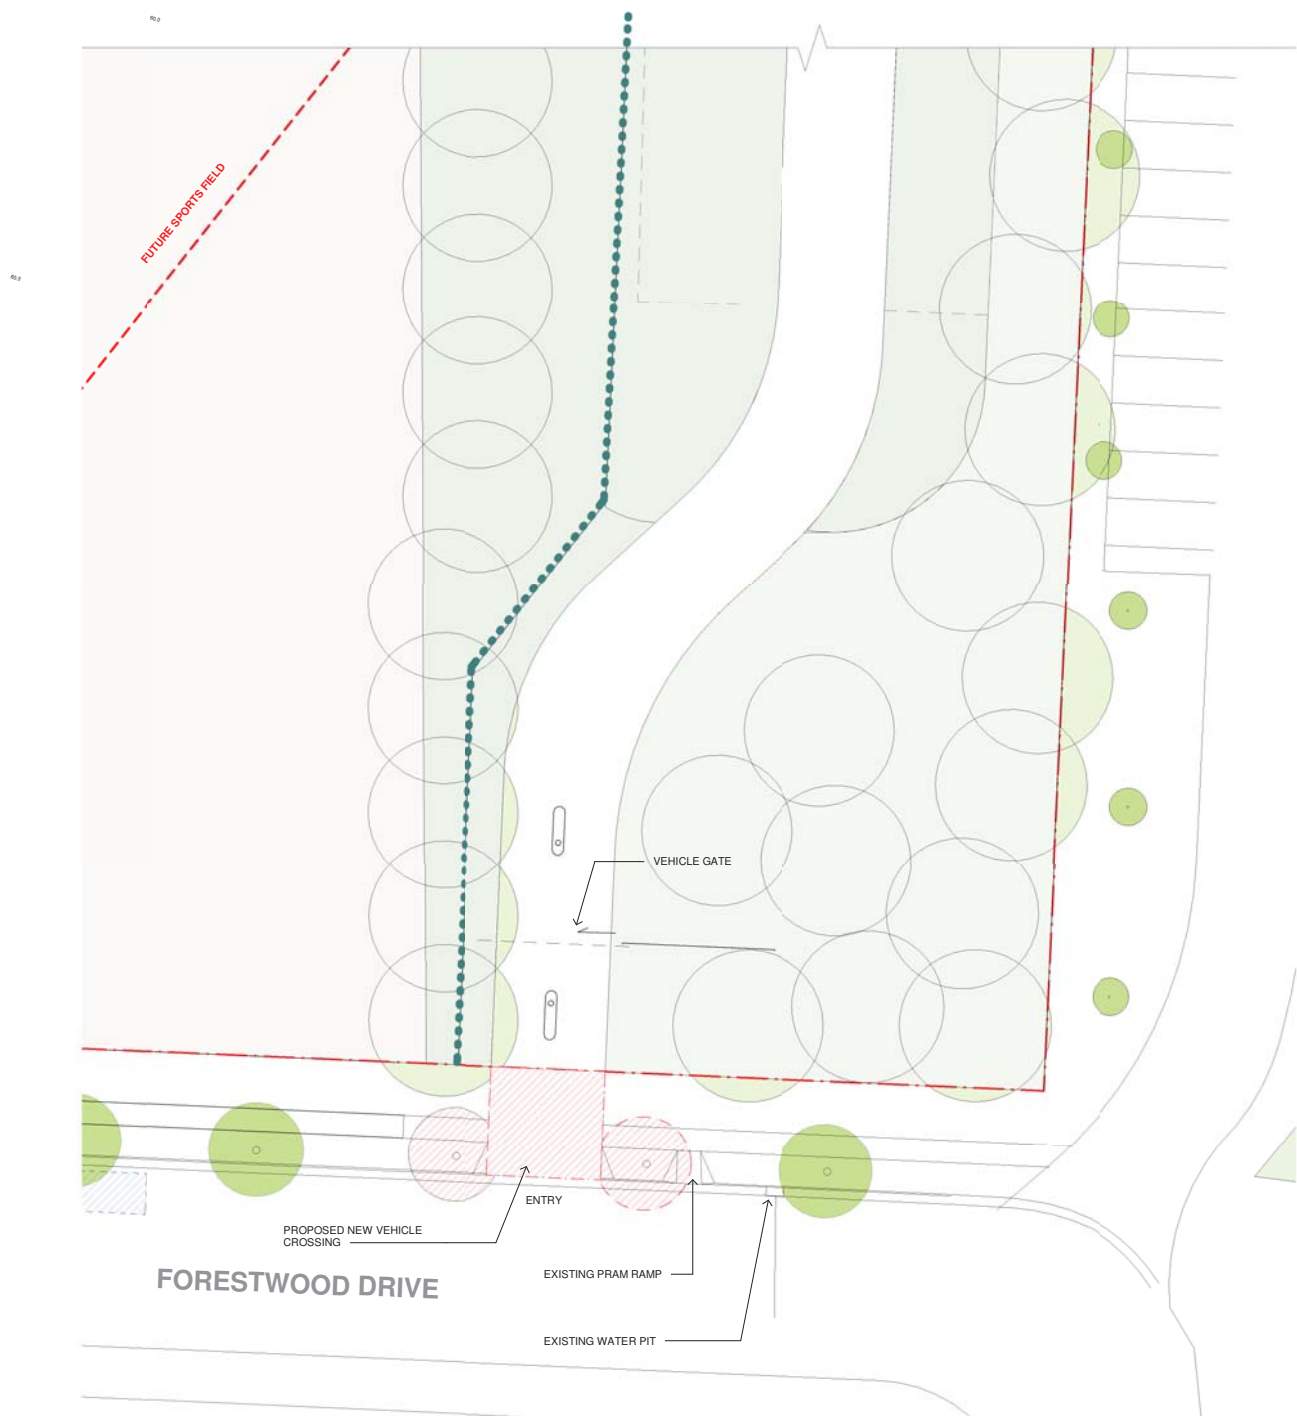

1 CAR PARK PLAN 01
1 : 200

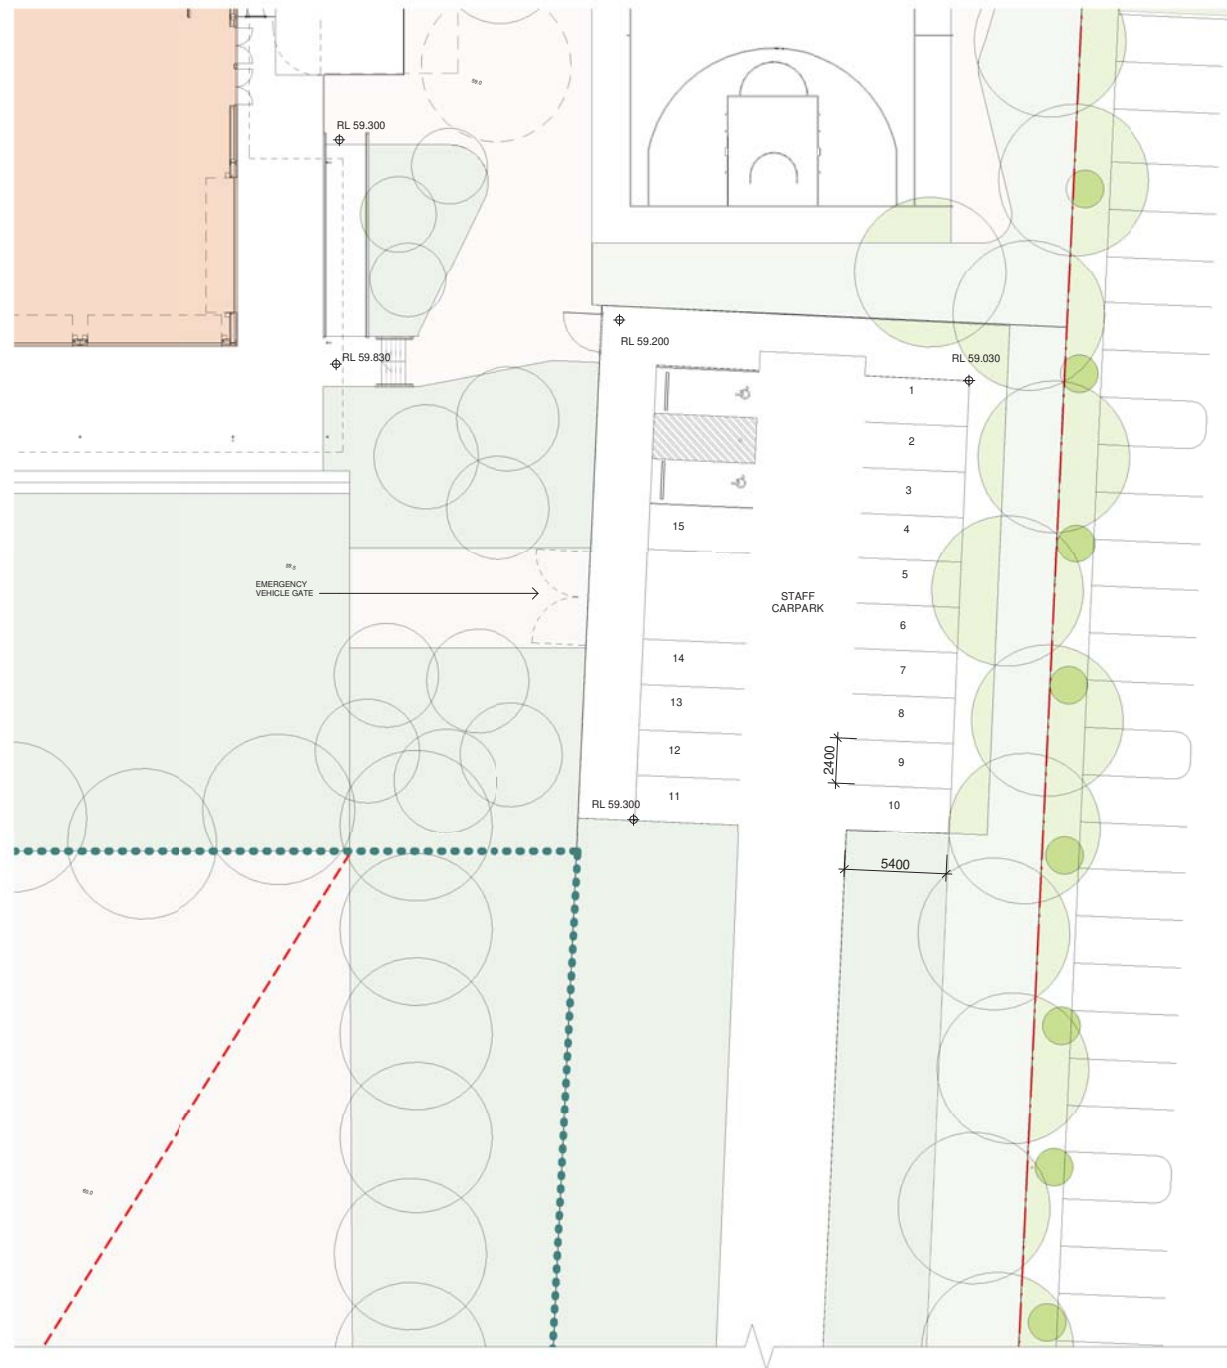

2 CARPARK PLAN 02
1 : 200

Issue No.	Date	Description	Chkd
1	23/04/2021	ISSUE FOR COORDINATION	
2	04/05/2021	SSDA ISSUE	
3	06/08/2021	SSDA ISSUE	JL

SSDA ISSUE

RICHARD CROOKES
CONSTRUCTIONS

TRAFFIC ENGINEER
PTC
KASIA BALSAM
02 8920 0800
kasia.balsam@pticonsultants.co

TOWN PLANNER
RPS
SHALIN SMITH
0425 285 778
shalin.smith@rpsgroup.com.au

MULTI SERVICES
NDY
RYAN HAHN
0407 236 908
r.hahn@ndy.com

CIVIL AND STRUCTURAL ENGINEERING
WOOLACOTTS
JUSTIN CHIRILLO
02 8203 1504
jchirillo@woolacotts.com.au

QUANTITY SURVEYOR
MBM
AUTUMN LU
02 9270 1062
autumn.lu@mbmpl.com.au

PROJECT MANAGER
COLLIERS
ANTHONY MAUGHAN-WRIGHT
0424 189 883
anthony.maughan-wright@colliers.com

Drawing Title
CAR PARK PLAN

Project
NEW PRIMARY SCHOOL IN MULGOA
RISE
at
1-23 Forestwood drive, Glenmore Park, NSW 2745, Australia
for
SINSW

Architect
NBRSARCHITECTURE.
Sydney
61 2 9922 2344
Any form of replication of this drawing in full or in part without the written permission of NBR-S PARTNERS Pty Ltd constitutes an infringement of the copyright.
Nominated Architect:
Andrew Duffin NSW 5602
NBR & Partners Pty Ltd VIC 51197
nbrsarchitecture.com
© 2021
ABN 16 002 247 565




Date 6/08/2021 4:25:43 PM
Scale 1:200 @ A1

Drawing Reference

20415-NBR-DR-A-SSDA-0999

Revision

3

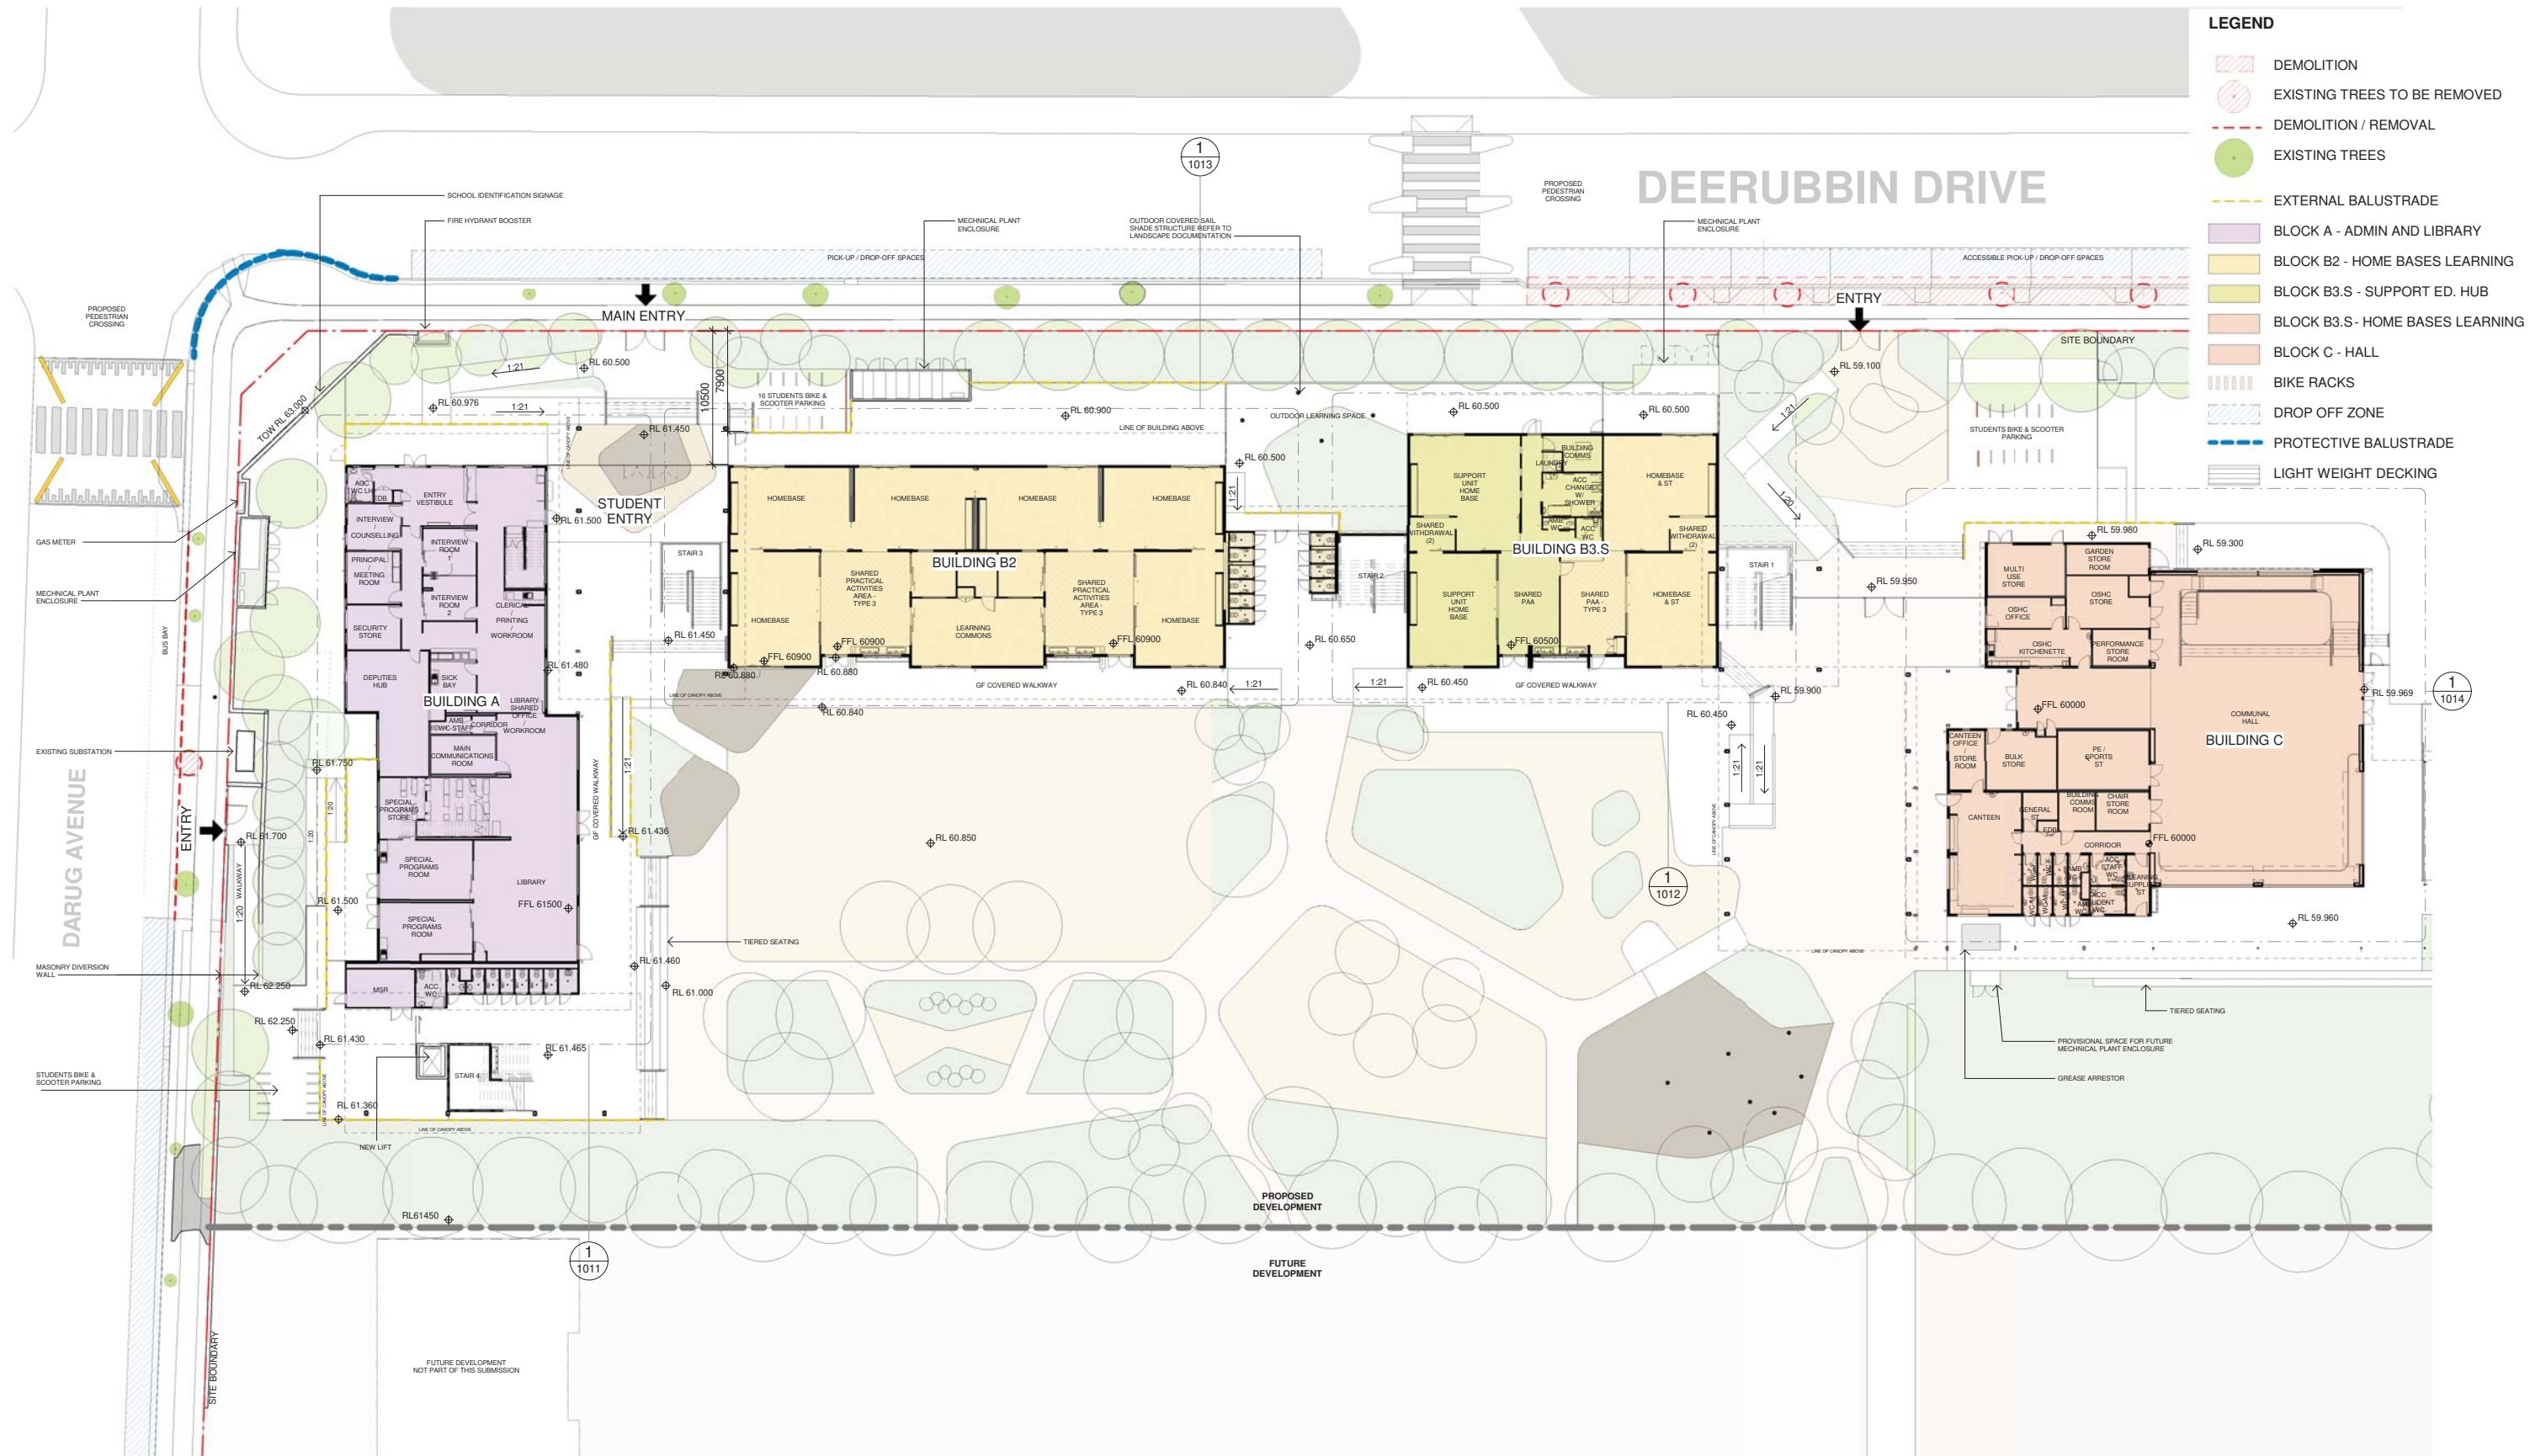

Issue No.	Date	Description	Chkd
1	12/04/2021	ISSUE FOR COORDINATION	
2	16/04/2021	SD ISSUE	
3	23/04/2021	ISSUE FOR COORDINATION	
4	04/05/2021	SSDA ISSUE	JL
5	19/07/2021	COORDINATION ISSUE	
6	28/07/2021	ISSUE FOR COORDINATION	
7	06/08/2021	SSDA ISSUE	JL
8	11/08/2021	SSDA ISSUE	JL
9	17/08/2021	SSDA ISSUE	JL

SSDA ISSUE

RICHARD CROOKES CONSTRUCTIONS

TRAFFIC ENGINEER
PTC
KASIA BALSAM
02 8920 0800
kasia.balsam@ptccconsultants.co

TOWN PLANNER
RPS
ROB DWYER
0425 285 778
rob.dwyer@rpsgroup.com.au

MULTI SERVICES
NDY
RYAN HAHN
0407 236 908
r.hahn@ndy.com

CIVIL AND STRUCTURAL ENGINEERING
WOOLACOTTS
JUSTIN CHIRILLO
02 8203 1504
jchirillo@woolacotts.com.au

QUANTITY SURVEYOR
MBM
AUTUMN LU
02 9270 1062
autumn.lu@mbmpl.com.au

PROJECT MANAGER
COLLIERS
ANTHONY MAUGHAN-WRIGHT
0424 189 883
anthony.maughan-wright@colliers.com

Drawing Title
OVERALL GROUND FLOOR PLAN

Project
NEW PRIMARY SCHOOL IN MULGOA RISE
at
1-23 Forestwood drive, Glenmore Park, NSW 2745, Australia
for
SINSW

Architect
NBR ARCHITECTURE.
Sydney
61 2 9922 2344
Any form of replication of this drawing in full or in part without the written permission of NBR ARCHITECTURE Pty Ltd constitutes an infringement of the copyright.
Nominated Architect:
Andrew Duffin NSW 5602
NBR & Partners Pty Ltd VIC 51197

nbrsarchitecture.com
ABN 16 002 247 565

Date 17/08/2021 5:25:32 PM
Scale 1:250 @ A1

Drawing Reference
20415-NBRS-DR-A-SSDA-1000

Revision
9

0 2.5m 5m 7.5m 10m 12.5m 15m 17.5m 20m 1:250

LEGEND

- BLOCK A - ADMIN AND LIBRARY
- BLOCK B2 - HOME BASES LEARNING
- BLOCK B3.S - SPECIALIST LEAR. AREA
- BLOCK B3.S - HOME BASES LEARNING
- BLOCK C - HALL
- EXTERNAL BALUSTRADE



Issue No.	Date	Description	Chkd
1	12/04/2021	ISSUE FOR COORDINATION	
2	23/04/2021	ISSUE FOR COORDINATION	
3	04/05/2021	SSDA ISSUE	
4	05/05/2021	SD DESIGN CHANGE	
5	19/07/2021	COORDINATION ISSUE	JL
6	28/07/2021	ISSUE FOR COORDINATION	
7	04/08/2021	ISSUE FOR COORDINATION	
8	06/08/2021	SSDA ISSUE	JL
9	11/08/2021	SSDA ISSUE	JL

SSDA ISSUE

RICHARD CROOKES
CONSTRUCTIONS

TRAFFIC ENGINEER
PTC
KASIA BALSAM
0407 236 908
kasia.balsam@ptcconsultants.co

TOWN PLANNER
RPS
ROB DWYER
0425 285 778
rob.dwyer@rpsgroup.com.au

MULTI SERVICES
NDY
RYAN HAHN
0407 236 908
r.hahn@ndy.com

CIVIL AND STRUCTURAL ENGINEERING
WOOLACOTTS
JUSTIN CHIRILLO
02 8203 1504
jchirillo@woolacotts.com.au

QUANTITY SURVEYOR
MBM
AUTUMN LU
02 9270 1062
autumn.lu@mbmpl.com.au

PROJECT MANAGER
COLLIERS
ANTHONY MAUGHAN-WRIGHT
0424 189 883
anthony.maughan-wright@colliers.com

Drawing Title
OVERALL L1 PLAN

Project
NEW PRIMARY SCHOOL IN MULGOA
RISE
at
1-23 Forestwood drive, Glenmore Park, NSW 2745, Australia
for
SINSW

Architect
NBRSARCHITECTURE.
Sydney
61 2 9922 2344
Any form of replication of this drawing in full or in part without the written permission of NBR-S+PARTNERS Pty Ltd constitutes an infringement of the copyright.
Nominated Architect:
Andrew Duffin NSW 5602
NBR-S & Partners Pty Ltd VIC 51197
nbrsarchitecture.com



Date 19/08/2021 6:21:59 PM
Scale 1:250 @ A1

Drawing Reference

20415-NBRS-DR-A-SSDA-1001

Revision
9

0 2.5m 5m 7.5m 10m 12.5m 15m 17.5m 20m 1:250

NOTE:

- Contractor is responsible for the design, documentation and construction of roof access, roof mounted walkways and fall prevention anchors. The design and documentation of roof access and fall prevention to be carried out in the consultation with the architect.
- Contractor to allow for a minimum of 1 (one) roof access hatch & permanent ladder from inside an enclosed room.



Issue No.	Date	Description	Chkd
1	12/04/2021	ISSUE FOR COORDINATION	
2	23/04/2021	ISSUE FOR COORDINATION	
3	04/05/2021	SSDA ISSUE	
4	21/07/2021	ISSUE FOR COORDINATION	
5	28/07/2021	ISSUE FOR COORDINATION	
6	06/08/2021	SSDA ISSUE	JL
7	11/08/2021	SSDA ISSUE	JL

SSDA ISSUE

RICHARD CROOKES
CONSTRUCTIONS

TRAFFIC ENGINEER
PTC
KASIA BALSAM
02 8920 0800
kasia.balsam@ptccconsultants.co

TOWN PLANNER
RPS
SHALIN SMITH
0425 285 778
shalin.smith@rpsgroup.com.au

MULTI SERVICES
NDY
RYAN HAHN
0407 236 908
r.hahn@ndy.com

CIVIL AND STRUCTURAL ENGINEERING
WOOLACOTTS
JUSTIN CHIRILLO
02 8203 1504
jchirillo@woolacotts.com.au

QUANTITY SURVEYOR
MBM
AUTUMN LU
02 9270 1062
autumn.lu@mbmpl.com.au

PROJECT MANAGER
COLLIERS
ANTHONY MAUGHAN-WRIGHT
0424 189 883
anthony.maughan-wright@colliers.com

Drawing Title
OVERALL ROOF PLAN

PRELIMINARY

Project
NEW PRIMARY SCHOOL IN MULGOA
RISE
at
1-23 Forestwood drive, Glenmore Park, NSW 2745, Australia
for
SINSW

Architect
NBRSARCHITECTURE.
Sydney
61 2 9922 2344
Any form of replication of this drawing in full or in part without the written permission of NBR&PARTNERS Pty Ltd constitutes an infringement of the copyright.
Nominated Architect:
Andrew Duffin NSW 5602
NBR& Partners Pty Ltd VIC 51197



© 2021
ABN 16 002 247 565

Date 11/08/2021 1:14:10 PM
Scale 1:250 @ A1

Drawing Reference
20415-NBRS-DR-A-SSDA-1002

Revision
7

0 2.5m 5m 7.5m 10m 12.5m 15m 17.5m 20m 1:250

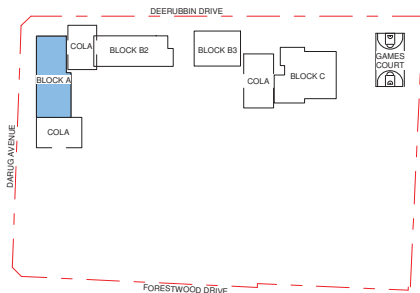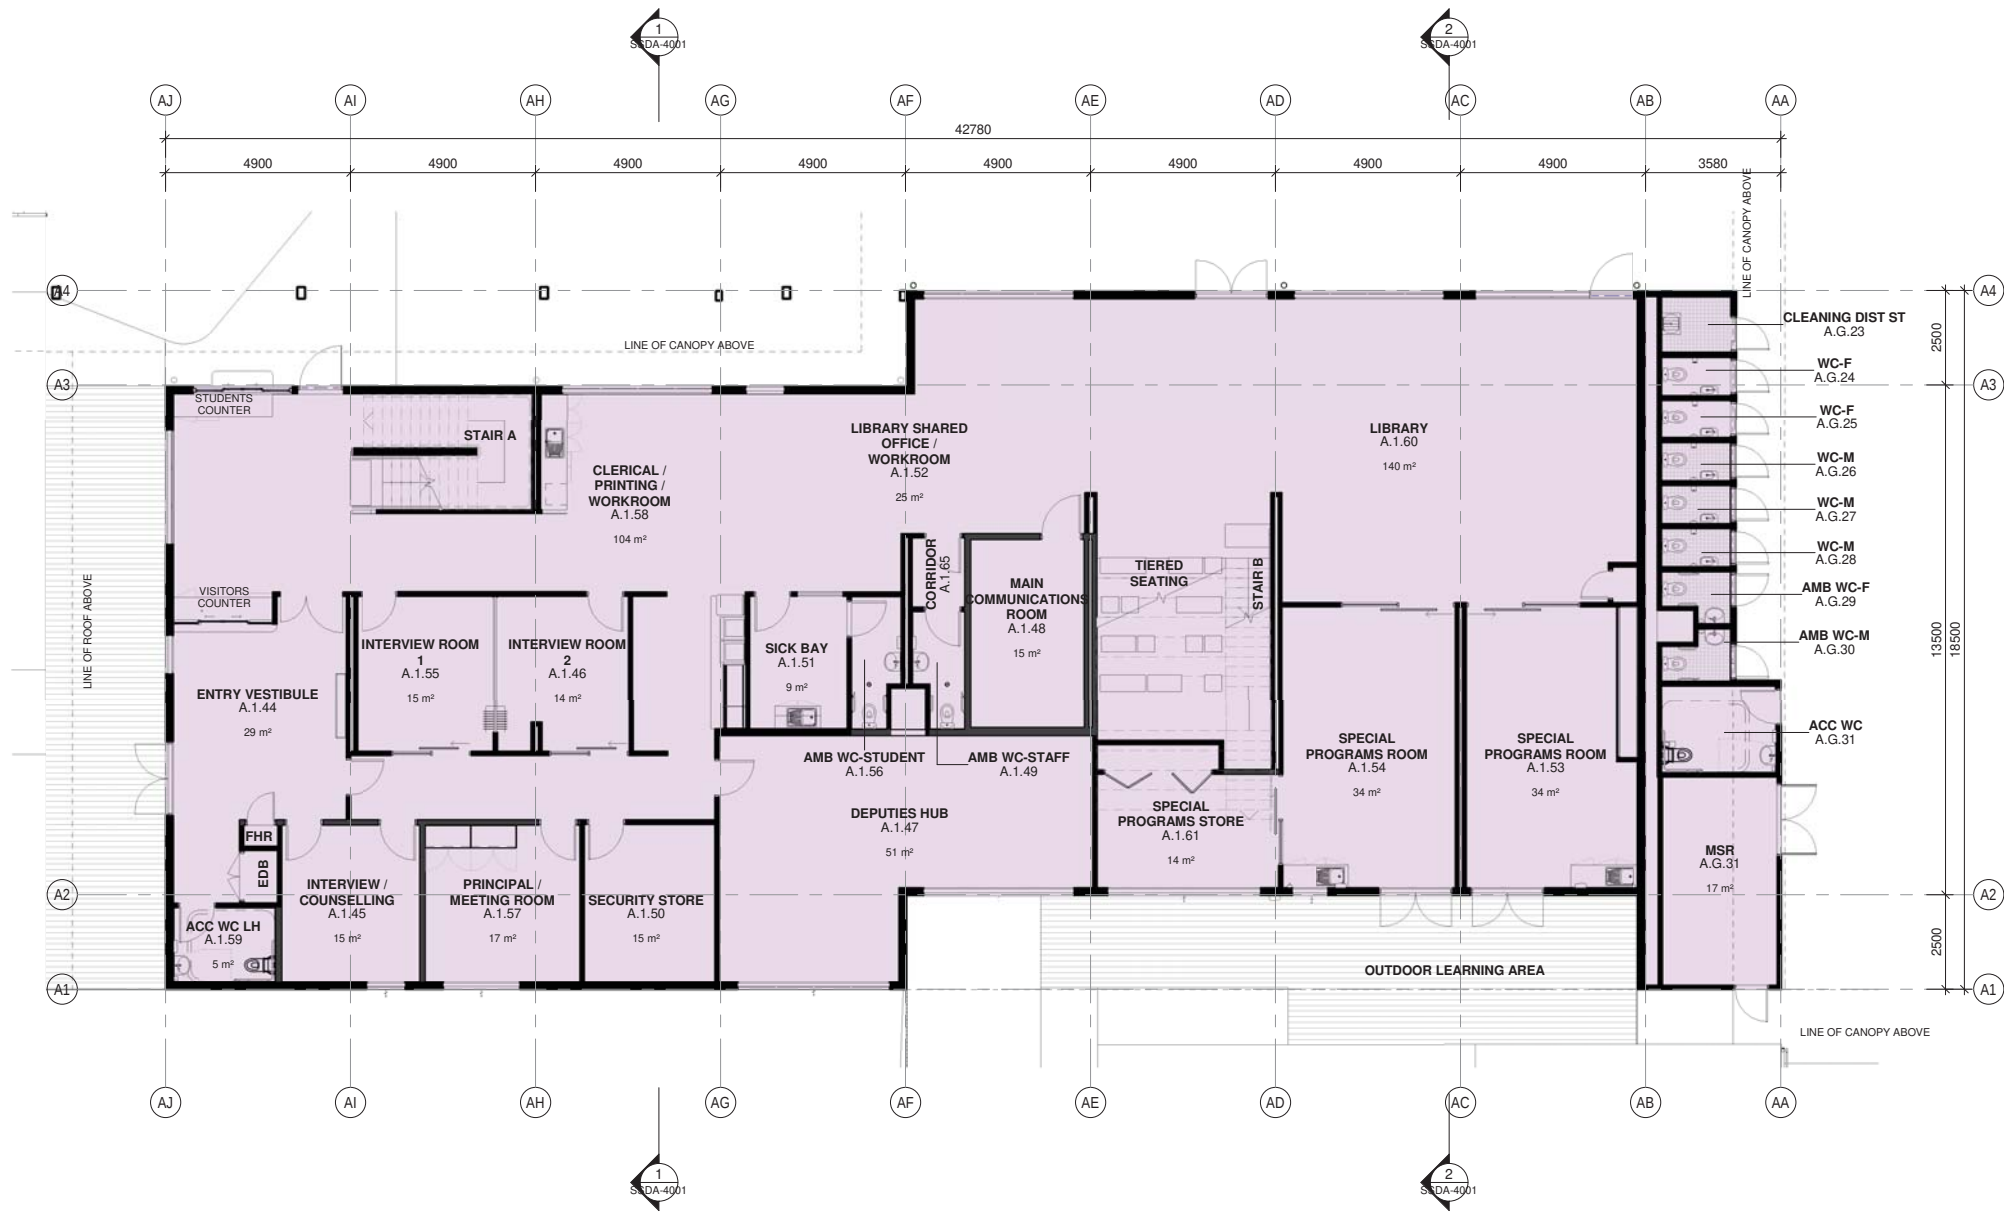

SITE KEY PLAN
N.T.S.

Issue No.	Date	Description	Chkd
1	12/04/2021	ISSUE FOR COORDINATION	
2	23/04/2021	ISSUE FOR COORDINATION	
3	04/05/2021	SSDA ISSUE	
4	06/08/2021	SSDA ISSUE	JL

PHASE 3 - SCHEMATIC DESIGN

**RICHARD CROOKES
CONSTRUCTIONS**

TRAFFIC ENGINEER
PTC
KASIA BALSAM
02 8920 0800
kasia.balsam@ptcconsultants.co

TOWN PLANNER
RPS
SHALIN SMITH
0425 285 778
shalin.smith@rpsgroup.com.au

MULTI SERVICES
NDY
RYAN HAHN
0407 236 908
r.hahn@ndy.com

CIVIL AND STRUCTURAL ENGINEERING
WOOLACOTTS
JUSTIN CHIRILLO
02 8203 1504
jchirillo@woolacotts.com.au

QUANTITY SURVEYOR
MBM
AUTUMN LU
02 9270 1062
autumn.lu@mbmpl.com.au



PROJECT MANAGER
COLLIERS
ANTHONY MAUGHAN-WRIGHT
0424 189 883
anthony.maughan-wright@colliers.com

Drawing Title
BLOCK A - GF PLAN

Project
NEW PRIMARY SCHOOL IN MULGOA
RISE
at
1-23 Forestwood drive, Glenmore Park, NSW 2745, Australia
for
SINSW

Architect
NBRSARCHITECTURE.
Sydney
61 2 9922 2344
Any form of replication of this drawing in full or in part without the written permission of NBRSPARTNERS Pty Ltd constitutes an infringement of the copyright.
Nominated Architect:
Andrew Duffin NSW 5602
NBRSPARTNERS Pty Ltd VIC 51197
nbrsarchitecture.com
© 2021
ABN 16 002 247 565

Date 6/08/2021 4:26:30 PM
Scale 1:100 @ A1
Drawing Reference
20415-NBRS-DR-A-SSDA-1011
Revision
4
0 1m 2m 3m 4m 5m 6m 7m 8m 1:100

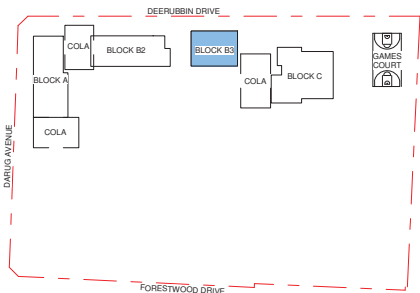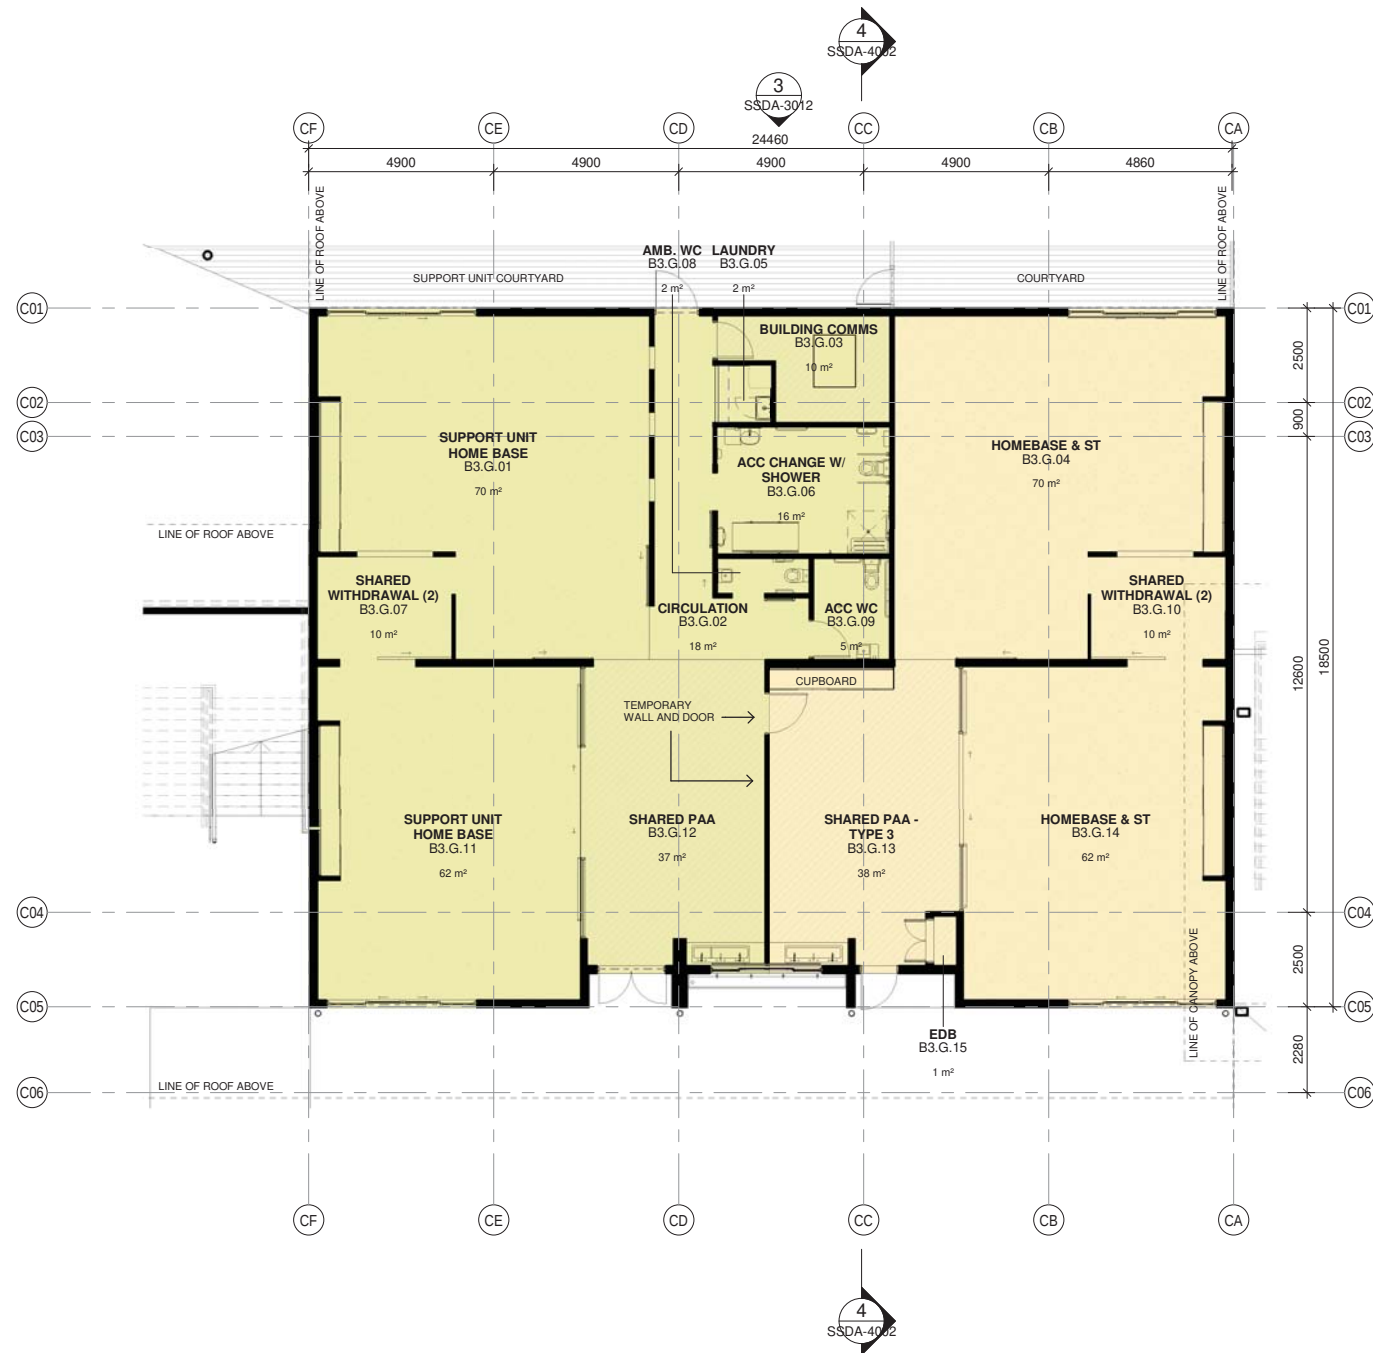

SITE KEY PLAN
N.T.S.

Issue No.	Date	Description	Chkd
1	12/04/2021	ISSUE FOR COORDINATION	
2	23/04/2021	ISSUE FOR COORDINATION	
3	04/05/2021	SSDA ISSUE	
4	28/07/2021	ISSUE FOR COORDINATION	
5	06/08/2021	SSDA ISSUE	JL

SSDA ISSUE

RICHARD CROOKES
CONSTRUCTIONS

TRAFFIC ENGINEER
PTC
KASIA BALSAM
02 8920 0800
kasia.balsam@pticonsultants.co

TOWN PLANNER
RPS
SHALIN SMITH
0425 285 778
shalin.smith@rpsgroup.com.au

MULTI SERVICES
NDY
RYAN HAHN
0407 236 908
r.hahn@ndy.com

CIVIL AND STRUCTURAL ENGINEERING
WOOLACOTTS
JUSTIN CHIRILLO
02 8203 1504
jchirillo@woolacotts.com.au

QUANTITY SURVEYOR
MBM
AUTUMN LU
02 9270 1062
autumn.lu@mbmpl.com.au



PROJECT MANAGER
COLLIERS
ANTHONY MAUGHAN-WRIGHT
0424 189 883
anthony.maughan-wright@colliers.com

Drawing Title
BLOCK B3 - GF PLAN

Project
NEW PRIMARY SCHOOL IN MULGOA RISE
at
1-23 Forestwood drive, Glenmore Park, NSW 2745, Australia
for
SINSW

Architect
NBR ARCHITECTURE.
Sydney
61 2 9922 2344
Any form of replication of this drawing in full or in part without the written permission of NBR ARCHITECTURE Pty Ltd constitutes an infringement of the copyright.
Nominated Architect:
Andrew Duffin NSW 5602
NBR & Partners Pty Ltd VIC 51197
nbrsarchitecture.com
© 2021
ABN 16 002 247 565

Date 6/08/2021 4:26:40 PM
Scale 1:100 @ A1
Drawing Reference
20415-NBRS-DR-A-SSDA-1012
Revision
5
0 1m 2m 3m 4m 5m 6m 7m 8m 1:100

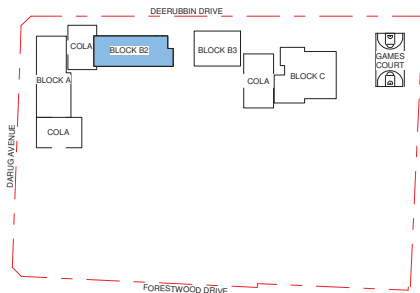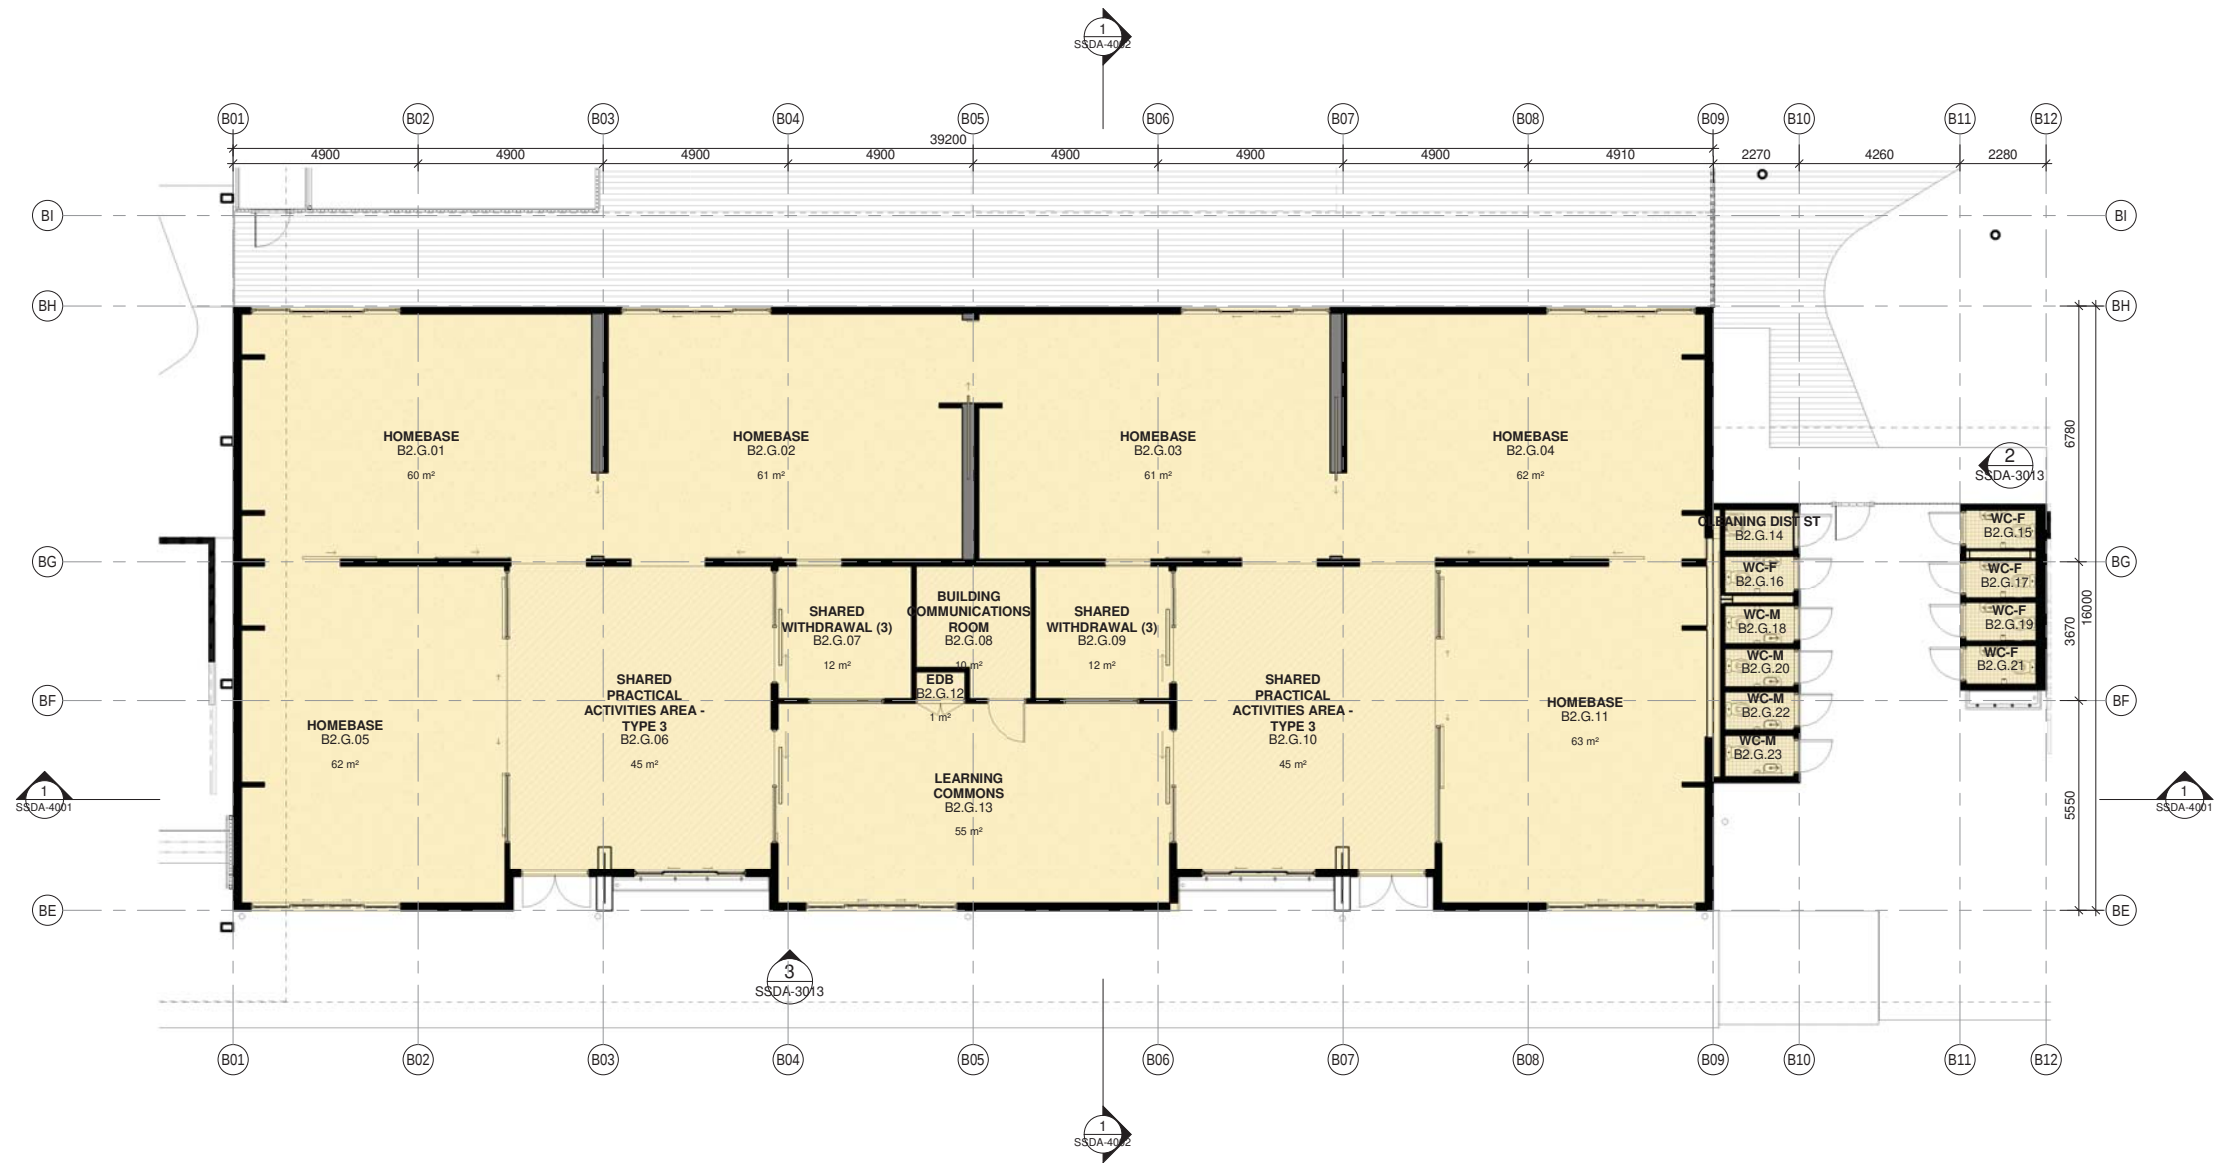

SITE KEY PLAN
N.T.S.

Issue No.	Date	Description	Chkd.
1	12/04/2021	ISSUE FOR COORDINATION	
2	23/04/2021	ISSUE FOR COORDINATION	
3	04/05/2021	SSDA ISSUE	
4	06/08/2021	SSDA ISSUE	JL

SSDA ISSUE

RICHARD CROOKES
CONSTRUCTIONS

TRAFFIC ENGINEER
PTC
KASIA BALSAM
02 8920 0800
kasia.balsam@pticonsultants.co

TOWN PLANNER
RPS
SHALIN SMITH
0425 285 778
shalin.smith@rpsgroup.com.au

MULTI SERVICES
NDY
RYAN HAHN
0407 236 908
r.hahn@ndy.com

CIVIL AND STRUCTURAL ENGINEERING
WOOLACOTTS
JUSTIN CHIRILLO
02 8203 1504
jchirillo@woolacotts.com.au

QUANTITY SURVEYOR
MBM
AUTUMN LU
02 9270 1062
autumn.lu@mbmpl.com.au



PROJECT MANAGER
COLLIERS
ANTHONY MAUGHAN-WRIGHT
0424 189 883
anthony.maughan-wright@colliers.com

Drawing Title
BLOCK B2 - GF PLAN

Project
NEW PRIMARY SCHOOL IN MULGOA
RISE
at
1-23 Forestwood drive, Glenmore Park, NSW 2745, Australia
for
SINSW

Architect
NBRSARCHITECTURE.
Sydney
61 2 9922 2344
Any form of replication of this drawing in full or in part without the written permission of NBRSPARTNERS Pty Ltd constitutes an infringement of the copyright.
Nominated Architect:
Andrew Duffin NSW 5602
NBR & Partners Pty Ltd VIC 51197
nbsarchitecture.com
© 2021
ABN 16 002 247 565

Date 6/08/2021 4:26:53 PM
Scale 1:100 @ A1
Drawing Reference
20415-NBRS-DR-A-SSDA-1013
Revision
4
0 1m 2m 3m 4m 5m 6m 7m 8m 1:100

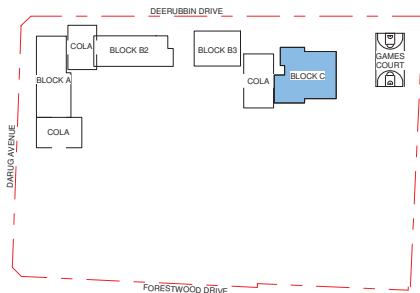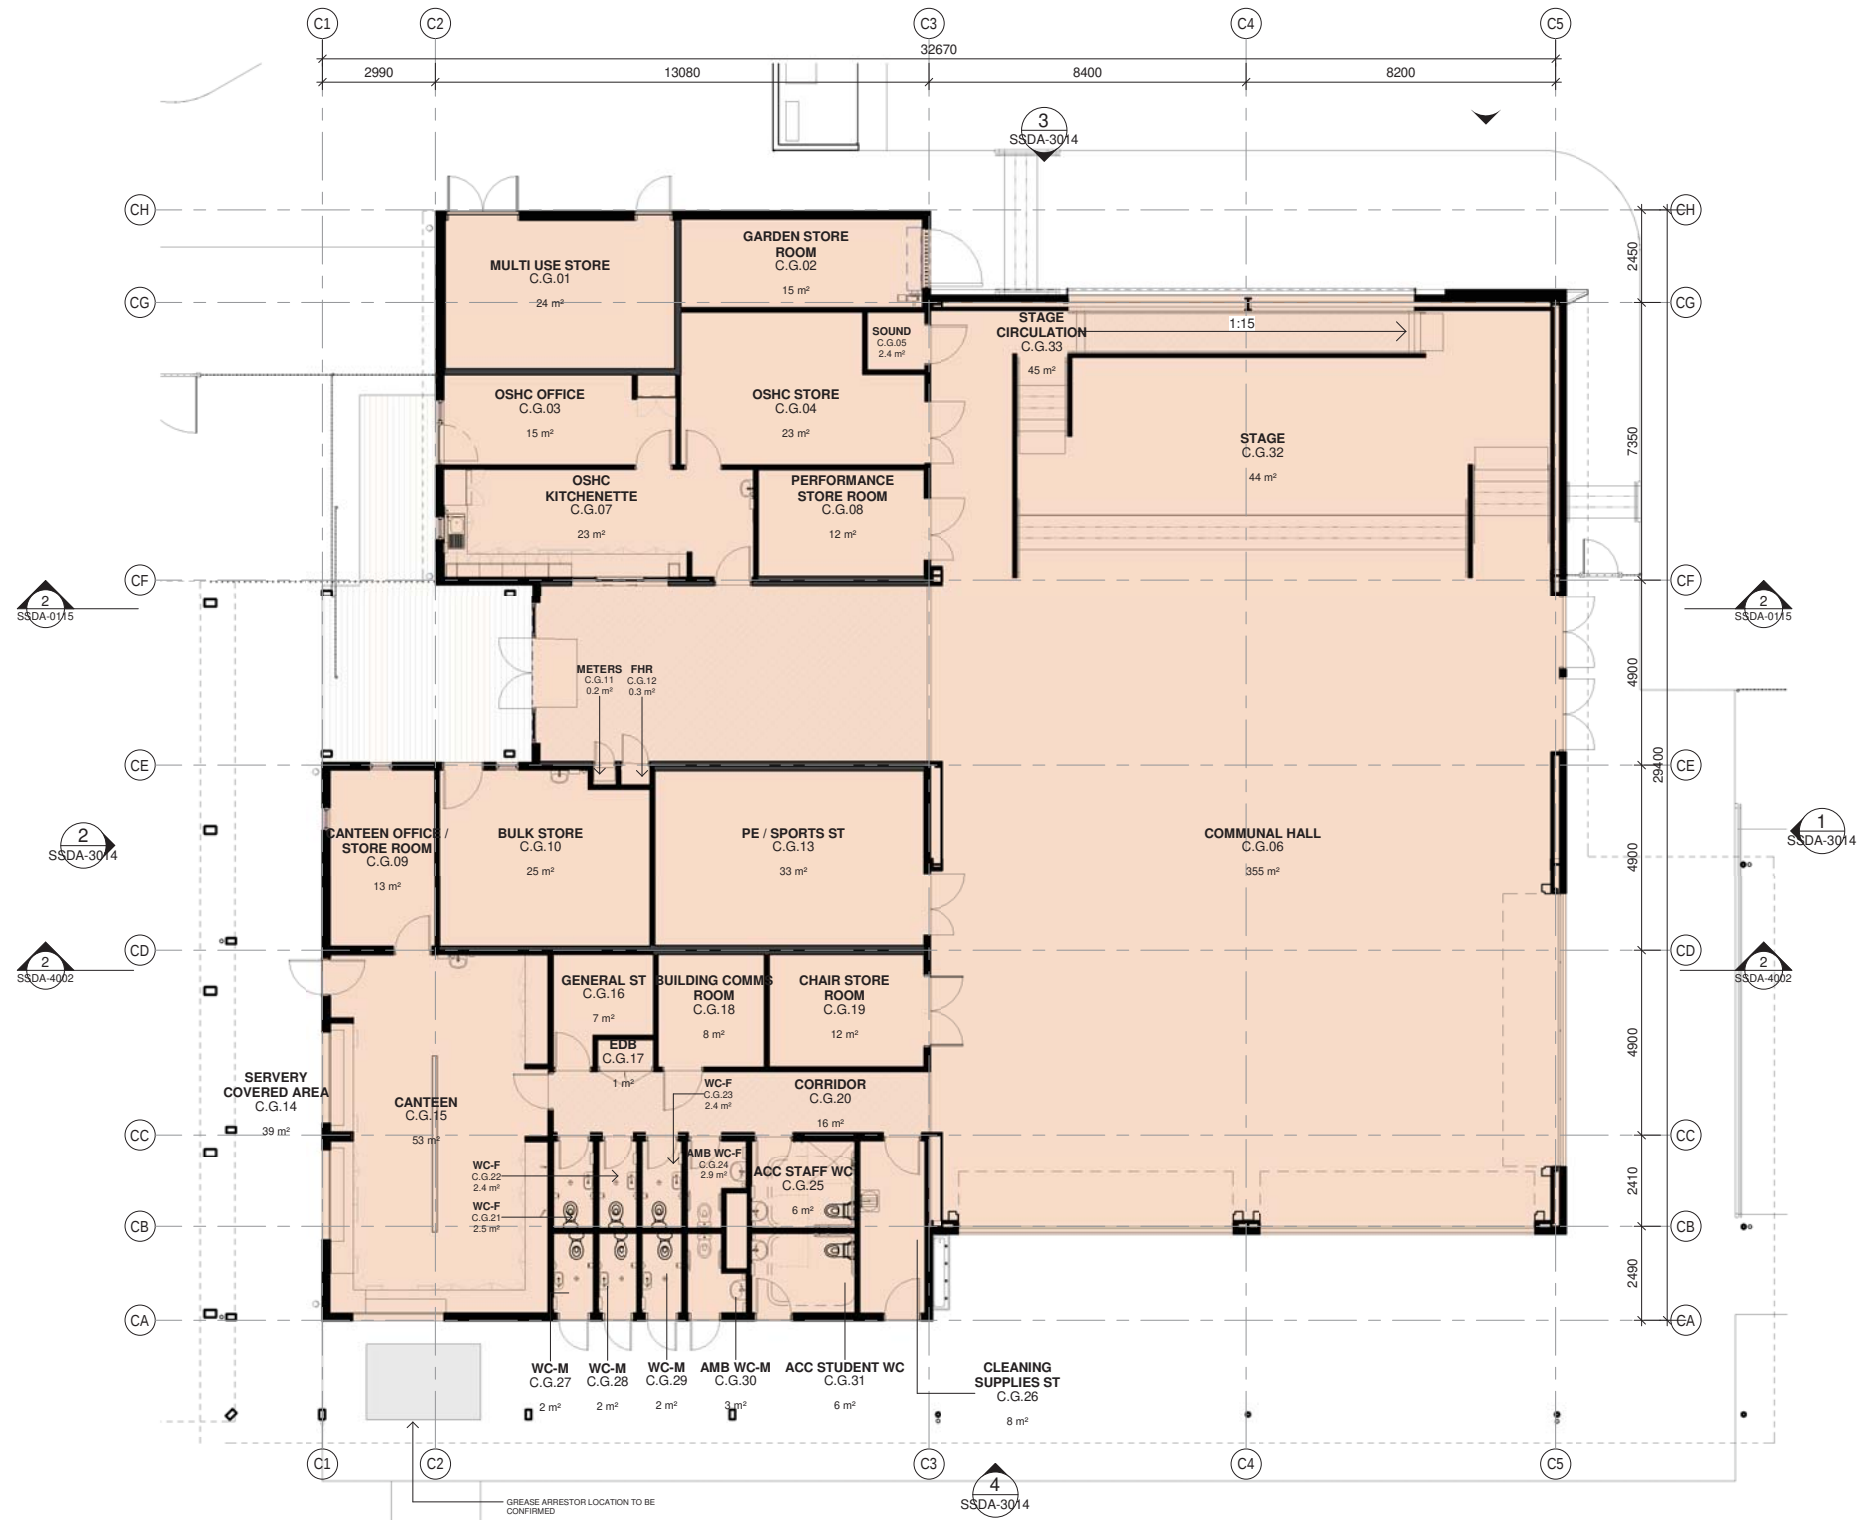

SITE KEY PLAN
N.T.S.

Issue No.	Date	Description	Chkd
1	12/04/2021	ISSUE FOR COORDINATION	
2	23/04/2021	ISSUE FOR COORDINATION	
3	04/05/2021	SSDA ISSUE	
4	06/08/2021	SSDA ISSUE	JL

SSDA ISSUE

RICHARD CROOKES
CONSTRUCTIONS

TRAFFIC ENGINEER
PTC
KASIA BALSAM
02 8920 0800
kasia.balsam@ptcconsultants.co

TOWN PLANNER
RPS
SHALIN SMITH
0425 285 778
shalin.smith@rpsgroup.com.au

MULTI SERVICES
NDY
RYAN HAHN
0407 236 908
r.hahn@ndy.com

CIVIL AND STRUCTURAL ENGINEERING
WOOLACOTTS
JUSTIN CHIRILLO
02 8203 1504
jchirillo@woolacotts.com.au

QUANTITY SURVEYOR
MBM
AUTUMN LU
02 9270 1062
autumn.lu@mbmpl.com.au

PROJECT MANAGER
COLLIERS
ANTHONY MAUGHAN-WRIGHT
0424 189 883
anthony.maughan-wright@colliers.com

Drawing Title
BLOCK C - GF PLAN



Project
NEW PRIMARY SCHOOL IN MULGOA RISE
at
1-23 Forestwood drive, Glenmore Park, NSW 2745, Australia
for
SINSW

Architect
NBR ARCHITECTURE.
Sydney
61 2 9922 2344
Any form of replication of this drawing in full or in part without the written permission of NBR ARCHITECTURE Pty Ltd constitutes an infringement of the copyright.
Nominated Architect:
Andrew Duffin NSW 5602
NBR & Partners Pty Ltd VIC 51197
nbrsarchitecture.com

Date 6/08/2021 4:27:06 PM
Scale 1:100 @ A1

Drawing Reference
20415-NBRS-DR-A-SSDA-1014
Revision
4

© 2021
ABN 16 002 247 565
0 1m 2m 3m 4m 5m 6m 7m 8m 1:100

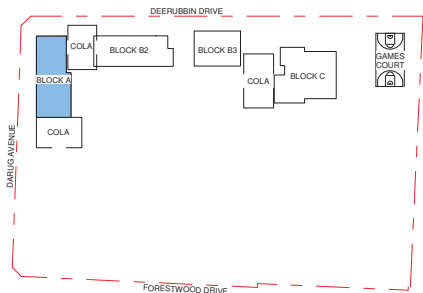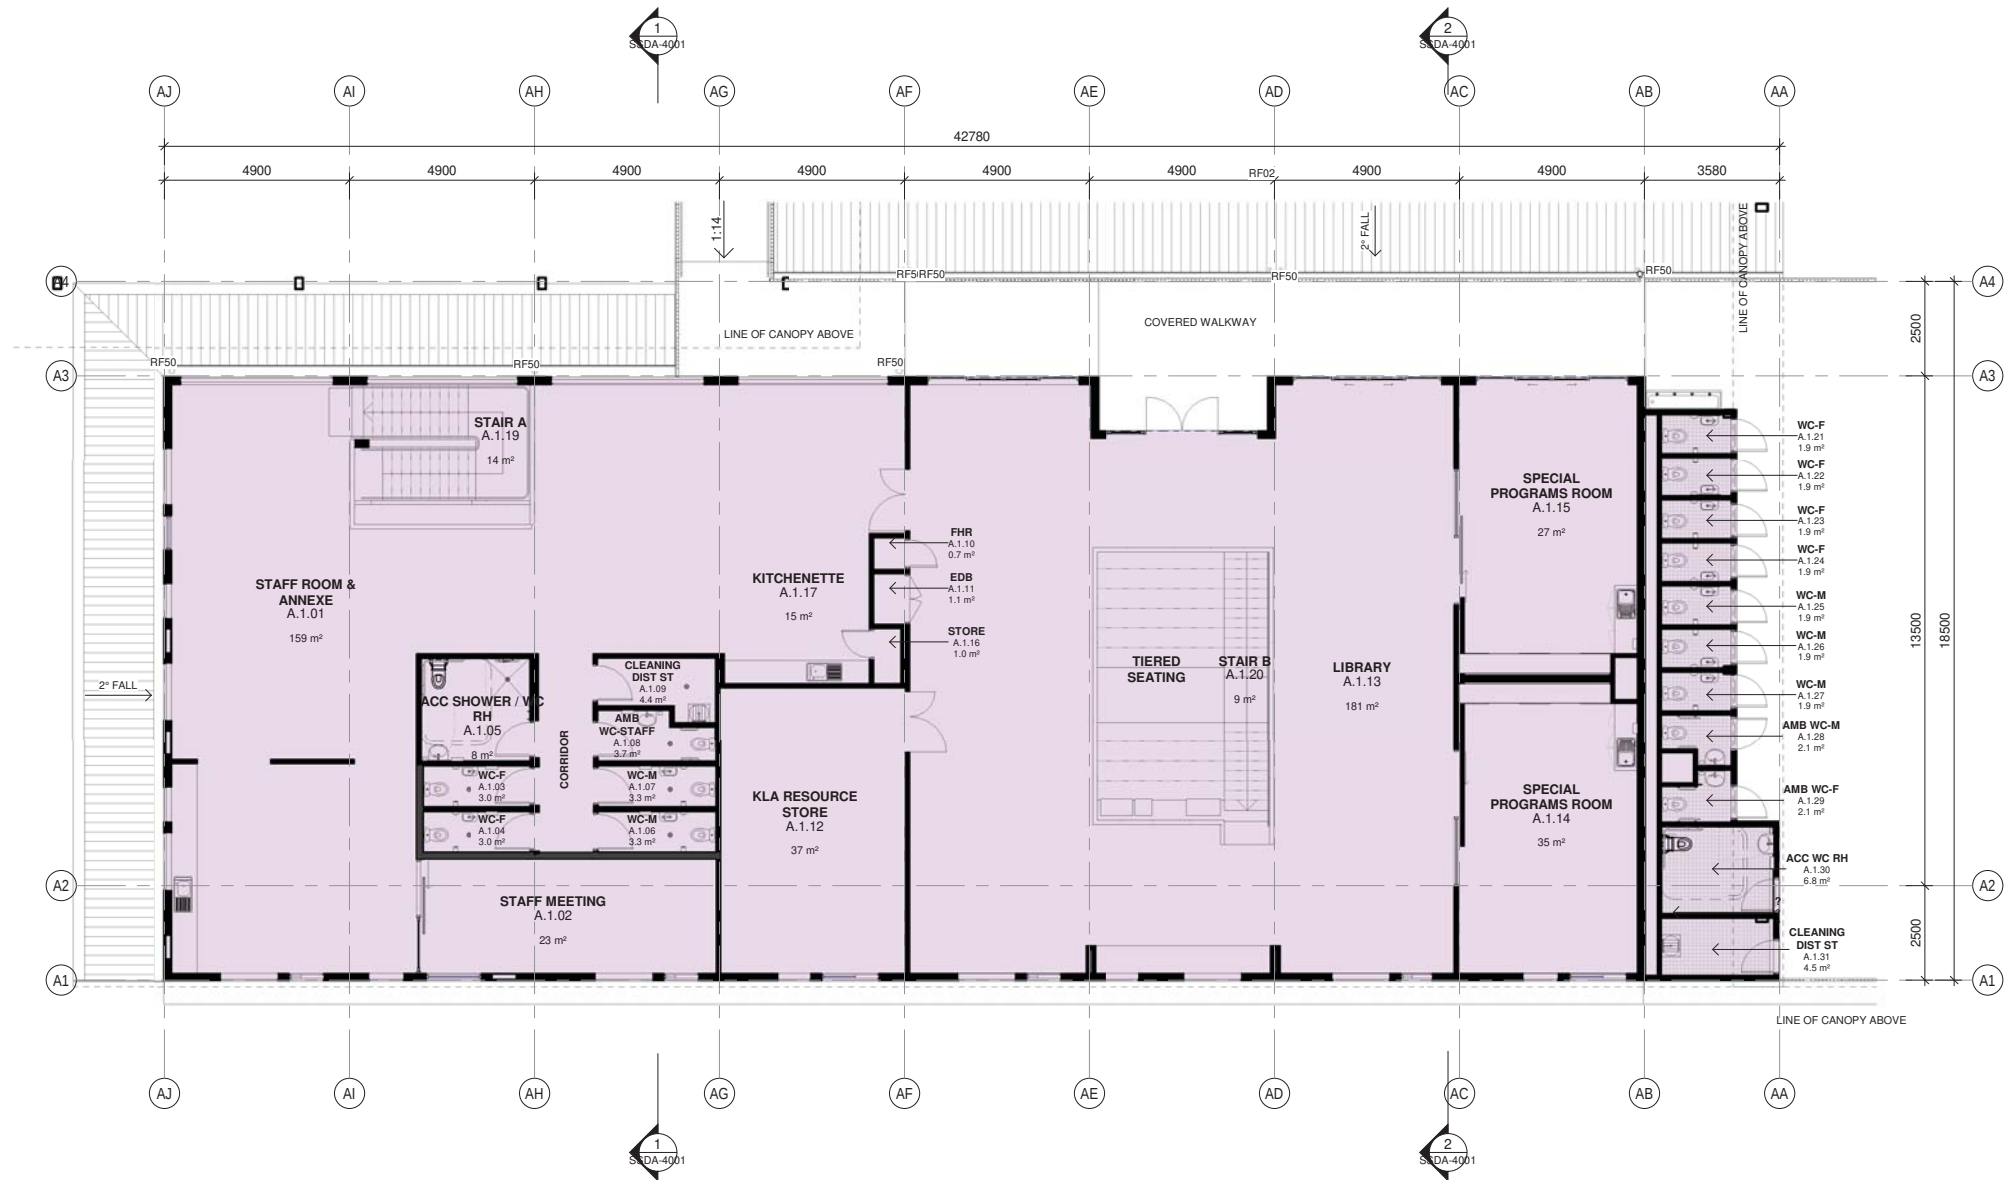

SITE KEY PLAN
N.T.S.

Issue No.	Date	Description	Chkd
1	12/04/2021	ISSUE FOR COORDINATION	
2	23/04/2021	ISSUE FOR COORDINATION	
3	04/05/2021	SSDA ISSUE	
4	06/08/2021	SSDA ISSUE	JL

PHASE 3 - SCHEMATIC DESIGN

**RICHARD CROOKES
CONSTRUCTIONS**

TRAFFIC ENGINEER
PTC
KASIA BALSAM
02 8920 0800
kasia.balsam@ptcconsultants.com

TOWN PLANNER
RPS
SHALIN SMITH
0425 285 778
shalin.smith@rpsgroup.com.au

MULTI SERVICES
NDY
RYAN HAHN
0407 236 908
r.hahn@ndy.com

CIVIL AND STRUCTURAL ENGINEERING
WOOLACOTTS
JUSTIN CHIRILLO
02 8203 1504
jchirillo@woolacotts.com.au

QUANTITY SURVEYOR
MBM
AUTUMN LU
02 9270 1062
autumn.lu@mbmpl.com.au

PROJECT MANAGER
COLLIERS
ANTHONY MAUGHAN-WRIGHT
0424 189 883
anthony.maughan-wright@colliers.com

Drawing Title
BLOCK A - LEVEL 1 PLAN

Project
**NEW PRIMARY SCHOOL IN MULGOA
RISE**
at
1-23 Forestwood drive, Glenmore Park, NSW 2745, Australia
for
SINSW

Architect
NBR ARCHITECTURE.
Sydney
61 2 9922 2344
Any form of replication of this drawing in full or in part without the written permission of NBR ARCHITECTURE Pty Ltd constitutes an infringement of the copyright.
Nominated Architect:
Andrew Duffin NSW 5602
NBR & Partners Pty Ltd VIC 51197
nbrsarchitecture.com




Drawing Reference
20415-NBRS-DR-A-SSDA-1021

Date 6/08/2021 4:27:18 PM
Scale 1:100 @ A1

Revision
4

© 2021
ABN 16 002 247 565
0 1m 2m 3m 4m 5m 6m 7m 8m 1:100

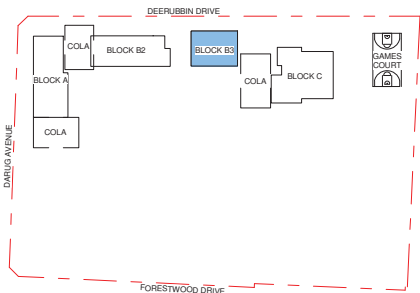

SITE KEY PLAN
N.T.S.

Issue No.	Date	Description	Chkd
1	12/04/2021	ISSUE FOR COORDINATION	
2	23/04/2021	ISSUE FOR COORDINATION	
3	04/05/2021	SSDA ISSUE	
4	06/08/2021	SSDA ISSUE	JL
5	17/08/2021	SSDA ISSUE	JL

SSDA ISSUE

RICHARD CROOKES
CONSTRUCTIONS

TRAFFIC ENGINEER
PTC
KASIA BALSAM
02 8920 0800
kasia.balsam@pticonsultants.co

TOWN PLANNER
RPS
ROB DWYER
0425 285 778
rob.dwyer@rpsgroup.com.au

MULTI SERVICES
NDY
RYAN HAHN
0407 236 908
r.hahn@ndy.com

CIVIL AND STRUCTURAL ENGINEERING
WOOLACOTTS
JUSTIN CHIRILLO
02 8203 1504
jchirillo@woolacotts.com.au

QUANTITY SURVEYOR
MBM
AUTUMN LU
02 9270 1062
autumn.lu@mbmpl.com.au

PROJECT MANAGER
COLLIERS
ANTHONY MAUGHAN-WRIGHT
0424 189 883
anthony.maughan-wright@colliers.com

Drawing Title
BLOCK B3 - LEVEL 1 PLAN

Project
NEW PRIMARY SCHOOL IN MULGOA
RISE
at
1-23 Forestwood drive, Glenmore Park, NSW 2745, Australia
for
SINSW

Architect
NBRSARCHITECTURE.
Sydney
61 2 9922 2344
Any form of replication of this drawing in full or in part without the written permission of NBR-S+PARTNERS Pty Ltd constitutes an infringement of the copyright.
Nominated Architect:
Andrew Duffin NSW 5602
NBR-S & Partners Pty Ltd VIC 51197
nbrsarchitecture.com
© 2021
ABN 16 002 247 565





Date 17/08/2021 5:25:49 PM
Scale 1:100 @ A1

Drawing Reference

20415-NBRS-DR-A-SSDA-1022

Revision

5

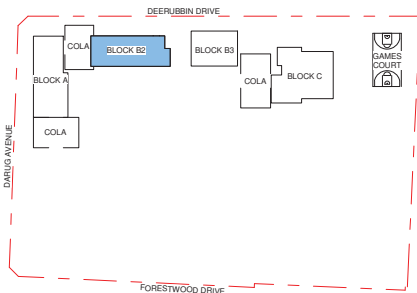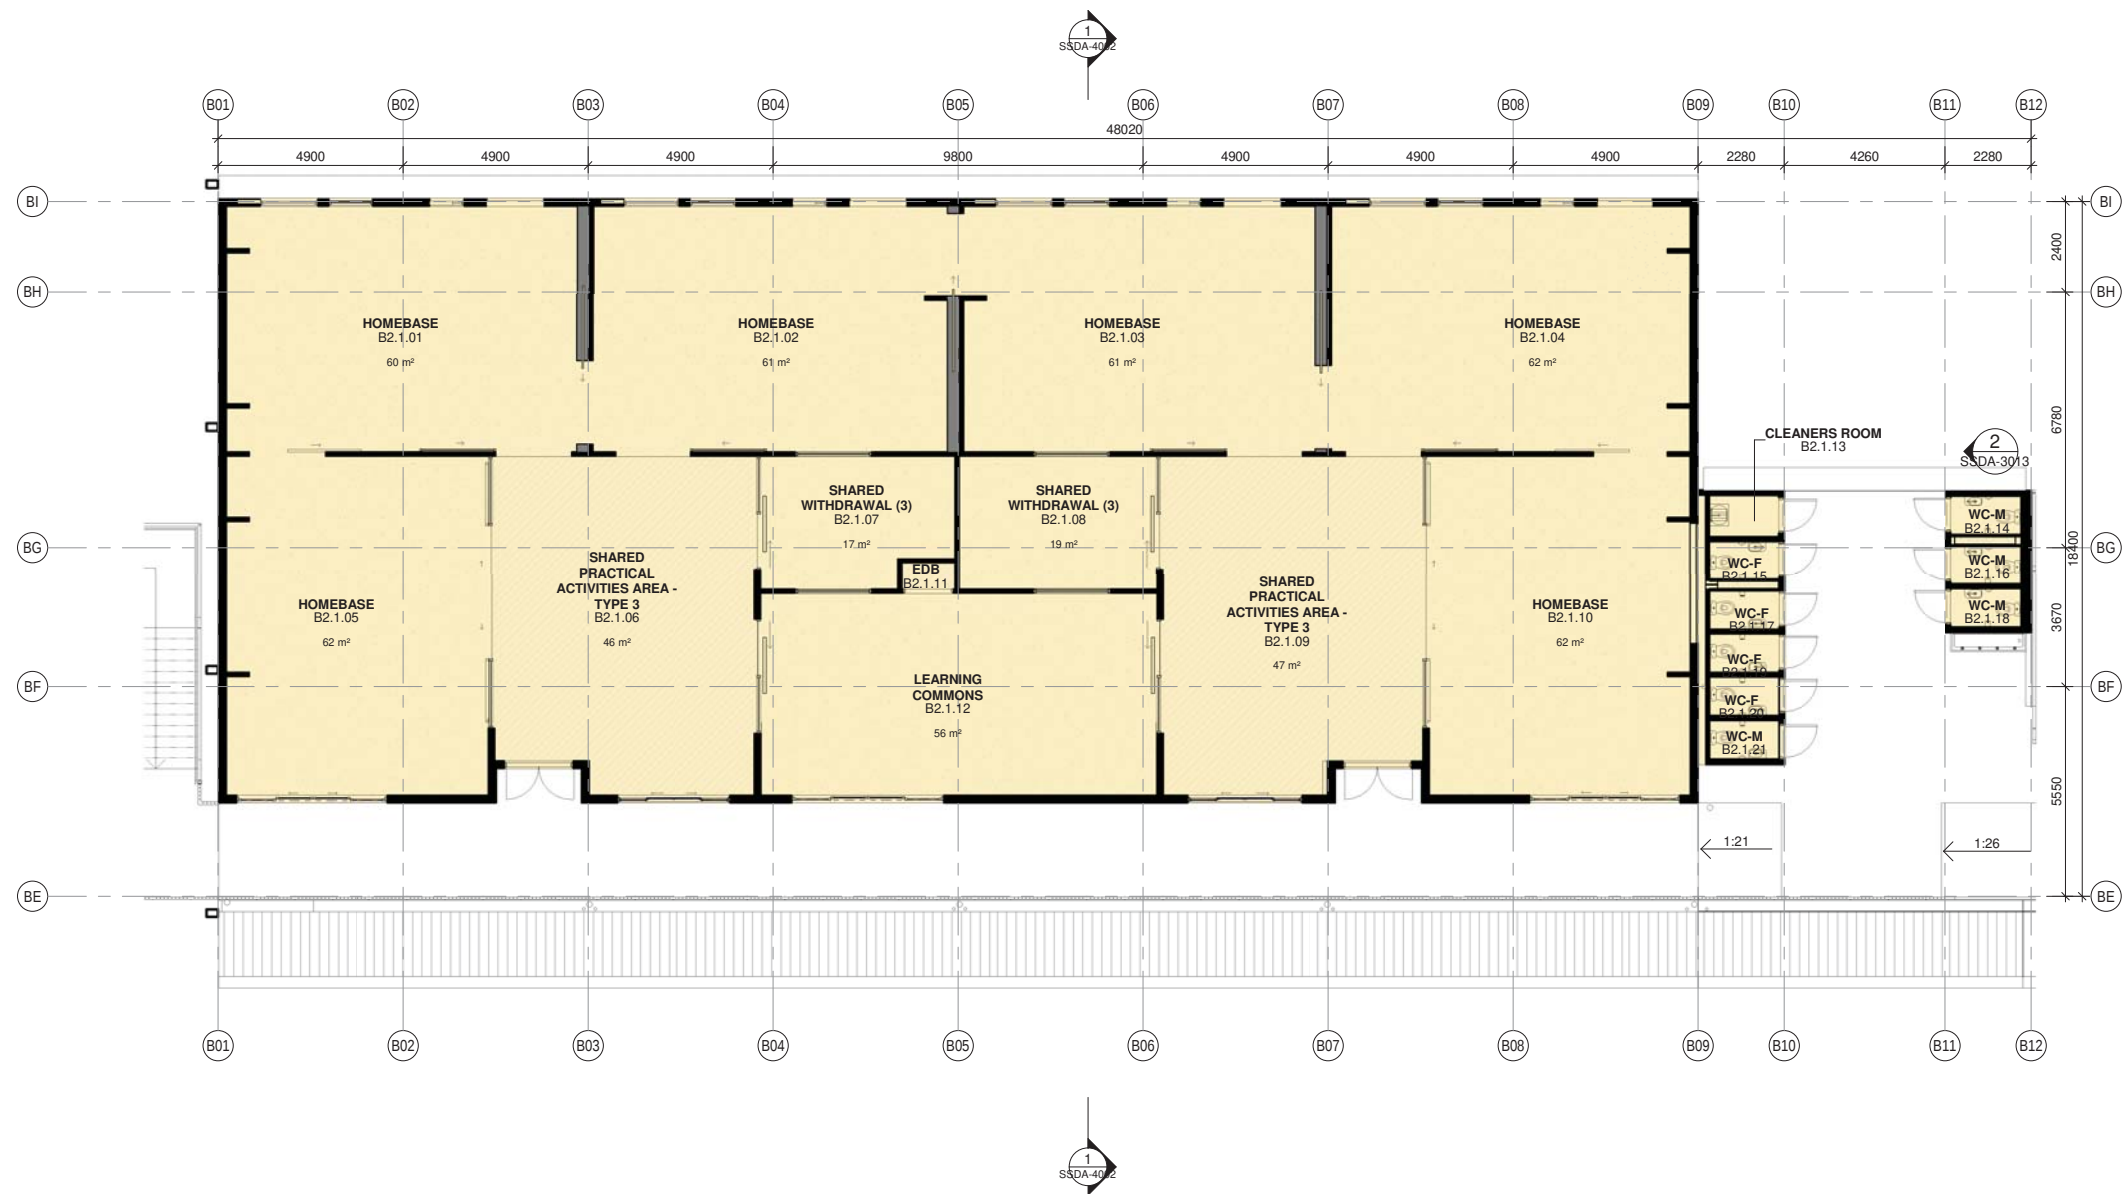

SITE KEY PLAN
N.T.S.

Issue No.	Date	Description	Chkd
1	12/04/2021	ISSUE FOR COORDINATION	
2	23/04/2021	ISSUE FOR COORDINATION	
3	04/05/2021	SSDA ISSUE	
4	06/08/2021	SSDA ISSUE	JL

SSDA ISSUE

RICHARD CROOKES
CONSTRUCTIONS

TRAFFIC ENGINEER
PTC
KASIA BALSAM
02 8920 0800
kasia.balsam@ptccconsultants.co

TOWN PLANNER
RPS
SHALIN SMITH
0425 285 778
shalin.smith@rpsgroup.com.au

MULTI SERVICES
NDY
RYAN HAHN
0407 236 908
r.hahn@ndy.com

CIVIL AND STRUCTURAL ENGINEERING
WOOLACOTTS
JUSTIN CHIRILLO
02 8203 1504
jchirillo@woolacotts.com.au

QUANTITY SURVEYOR
MBM
AUTUMN LU
02 9270 1062
autumn.lu@mbmpl.com.au


PROJECT MANAGER
COLLIERS
ANTHONY MAUGHAN-WRIGHT
0424 189 883
anthony.maughan-wright@colliers.com

Drawing Title
BLOCK B2 - LEVEL 1 PLAN

Project
NEW PRIMARY SCHOOL IN MULGOA
RISE
at
1-23 Forestwood drive, Glenmore Park, NSW 2745, Australia
for
SINSW

Architect
NBRSARCHITECTURE.
Sydney
61 2 9922 2344
Any form of replication of this drawing in full or in part without the written permission of NBRSPARTNERS Pty Ltd constitutes an infringement of the copyright.
Nominated Architect:
Andrew Duffin NSW 5602
NBRSPARTNERS Pty Ltd VIC 51197
nbsarchitecture.com
© 2021
ABN 16 002 247 565


Date 6/08/2021 4:27:41 PM
Scale 1 : 100 @ A1
Drawing Reference
20415-NBRS-DR-A-SSDA-1023
Revision
4
0 10 20 30 40 50 60 70 80 90 100

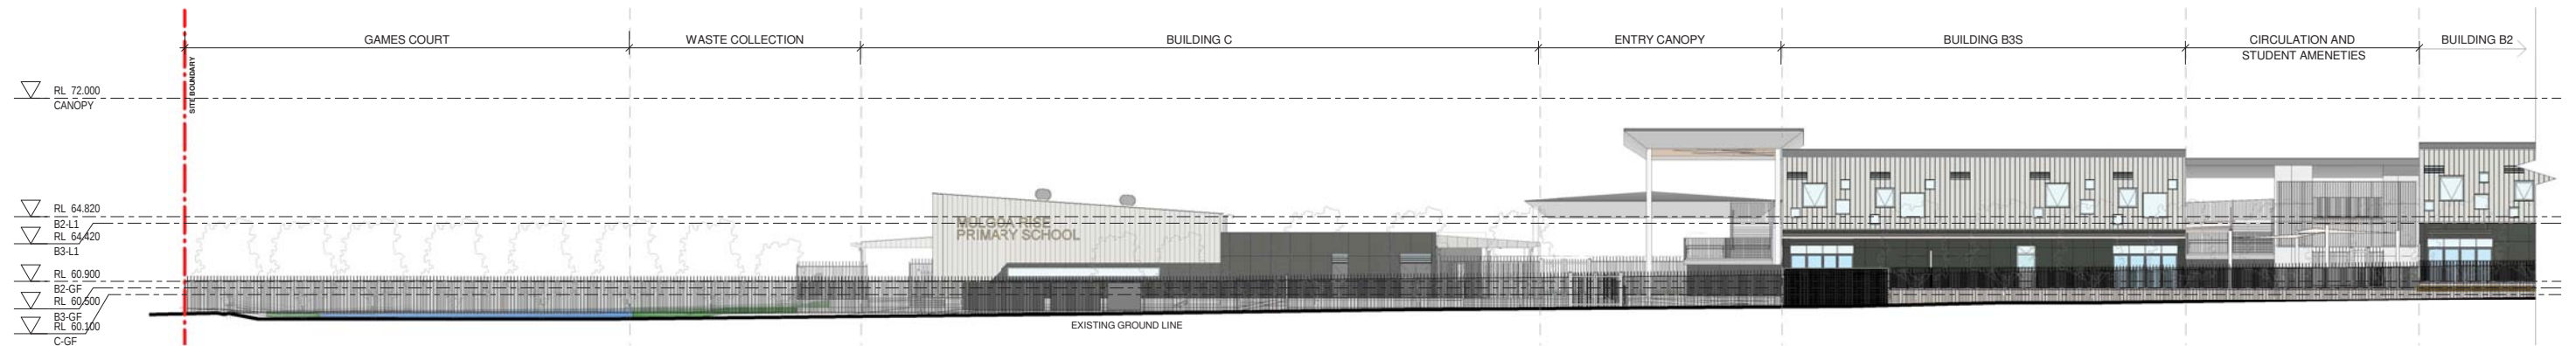

1 DEERUBBIN DRIVE ELEVATION - PART 1
1 : 200



2 DEERUBBIN DRIVE ELEVATION - PART 2
1 : 200

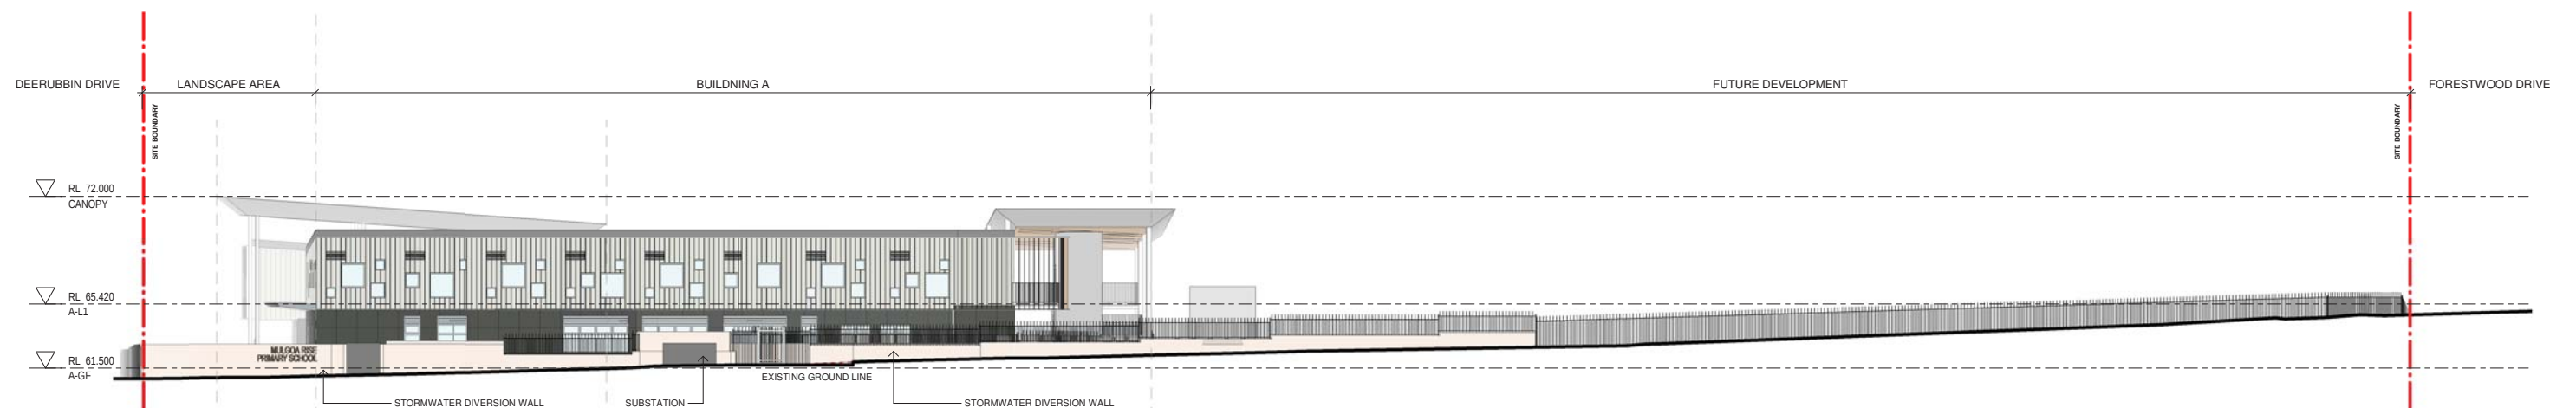

3 DARUG AVENUE STREET ELEVATION
1 : 200

Issue No.	Date	Description	Chkd
1	23/04/2021	ISSUE FOR COORDINATION	
2	04/05/2021	SSDA ISSUE	
3	23/07/2021	COORDINATION ISSUE	JL
4	06/08/2021	SSDA ISSUE	JL
5	11/08/2021	SSDA ISSUE	JL

SSDA ISSUE

RICHARD CROOKES
CONSTRUCTIONS

TRAFFIC ENGINEER
PTC
KASIA BALSAM
02 8920 0800
kasia.balsam@ptcconsultants.co

TOWN PLANNER
RPS
SHAUN SMITH
0425 285 778
shaun.smith@rpsgroup.com.au

MULTI SERVICES
NDY
RYAN HAHN
0407 236 908
r.hahn@ndy.com

CIVIL AND STRUCTURAL ENGINEERING
WOOLACOTTS
JUSTIN CHIRILLO
02 8203 1504
jchirillo@woolacotts.com.au

QUANTITY SURVEYOR
MBM
AUTUMN LU
02 9270 1062
autumn.lu@mbmpl.com.au

PROJECT MANAGER
COLLIERS
ANTHONY MAUGHAN-WRIGHT
0424 189 883
anthony.maughan-wright@colliers.com

Drawing Title
SITE ELEVATIONS

PRELIMINARY

Project
NEW PRIMARY SCHOOL IN MULGOA
RISE
at
1-23 Forestwood drive, Glenmore Park, NSW 2745, Australia
for
SINSW

Architect
NBRSARCHITECTURE.
Sydney
61 2 9922 2344
Any form of replication of this drawing in full or in part without the written permission of NBR-S&PARTNERS Pty Ltd constitutes an infringement of the copyright.
Nominated Architect:
Andrew Duffin NSW 5602
NBR-S & Partners Pty Ltd VIC 51197
nbsarchitecture.com
© 2021
ABN 16 002 247 565

Date 11/08/2021 1:15:34 PM
Scale 1:200 @ A1

Drawing Reference
20415-NBRS-DR-A-SSDA-3010
Revision
5


0 2m 4m 6m 8m 10m 12m 14m 16m 1:200



1 A NORTH ELEVATION
1 : 100



2 A SOUTH ELEVATION
1 : 100

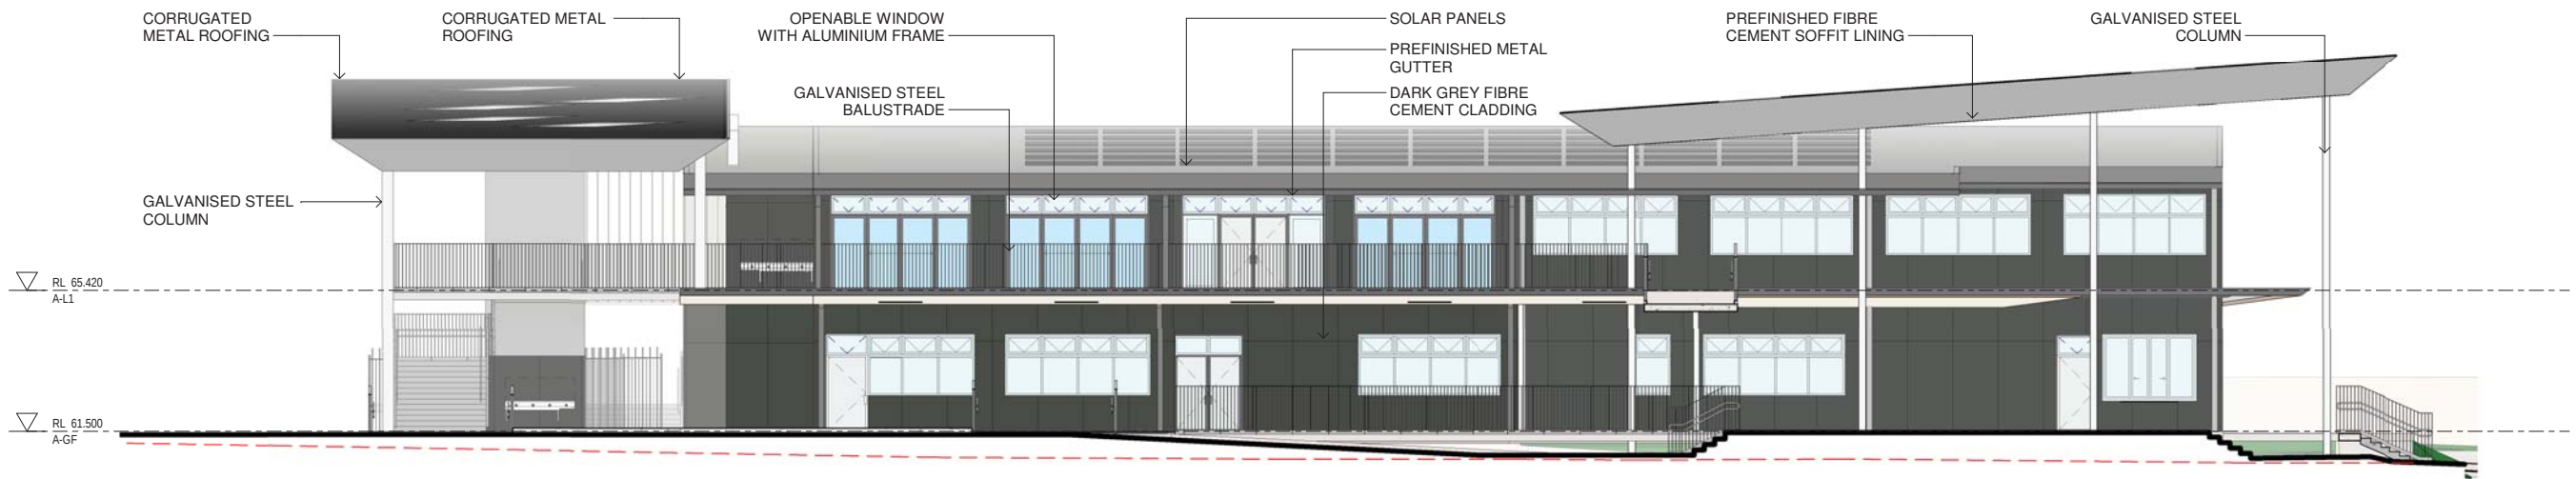

3 A EAST ELEVATION
1 : 100



4 A WEST ELEVATION
1 : 100

Issue No.	Date	Description	Chkd
1	12/04/2021	ISSUE FOR COORDINATION	
2	23/04/2021	ISSUE FOR COORDINATION	
3	04/05/2021	SSDA ISSUE	
4	06/08/2021	SSDA ISSUE	JL
5	11/08/2021	SSDA ISSUE	JL

SSDA ISSUE

RICHARD CROOKES
CONSTRUCTIONS

TRAFFIC ENGINEER
PTC
KASIA BALSAM
02 8920 0800
kasia.balsam@ptccconsultants.co

TOWN PLANNER
RPS
SHALIN SMITH
0425 285 778
shalin.smith@rpsgroup.com.au

MULTI SERVICES
NDY
RYAN HAHN
0407 236 908
r.hahn@ndy.com

CIVIL AND STRUCTURAL ENGINEERING
WOOLACOTTS
JUSTIN CHIRILLO
02 8203 1504
jchirillo@woolacotts.com.au

QUANTITY SURVEYOR
MBM
AUTUMN LU
02 9270 1062
autumn.lu@mbmpl.com.au

PROJECT MANAGER
COLLIERS
ANTHONY MAUGHAN-WRIGHT
0424 189 883
anthony.maughan-wright@colliers.com

Drawing Title
BUILDING A - ELEVATIONS





Project
NEW PRIMARY SCHOOL IN MULGOA
RISE
at
1-23 Forestwood drive, Glenmore Park, NSW 2745, Australia
for
SINSW

Architect
NBRSARCHITECTURE.
Sydney
61 2 9922 2344
Any form of replication of this drawing in full or in part without the written permission of NBR-S PARTNERS Pty Ltd constitutes an infringement of the copyright.
Nominated Architect:
Andrew Duffin NSW 5602
NBR & Partners Pty Ltd VIC 51197
nbsarchitecture.com
© 2021
ABN 16 002 247 565

Date 11/08/2021 1:16:21 PM
Scale 1:100 @ A1

Drawing Reference
20415-NBRS-DR-A-SSDA-3011
Revision
5

0 1m 2m 3m 4m 5m 6m 7m 8m 9m 10m 11m 12m 13m 14m 15m 16m 17m 18m 19m 20m 1:100

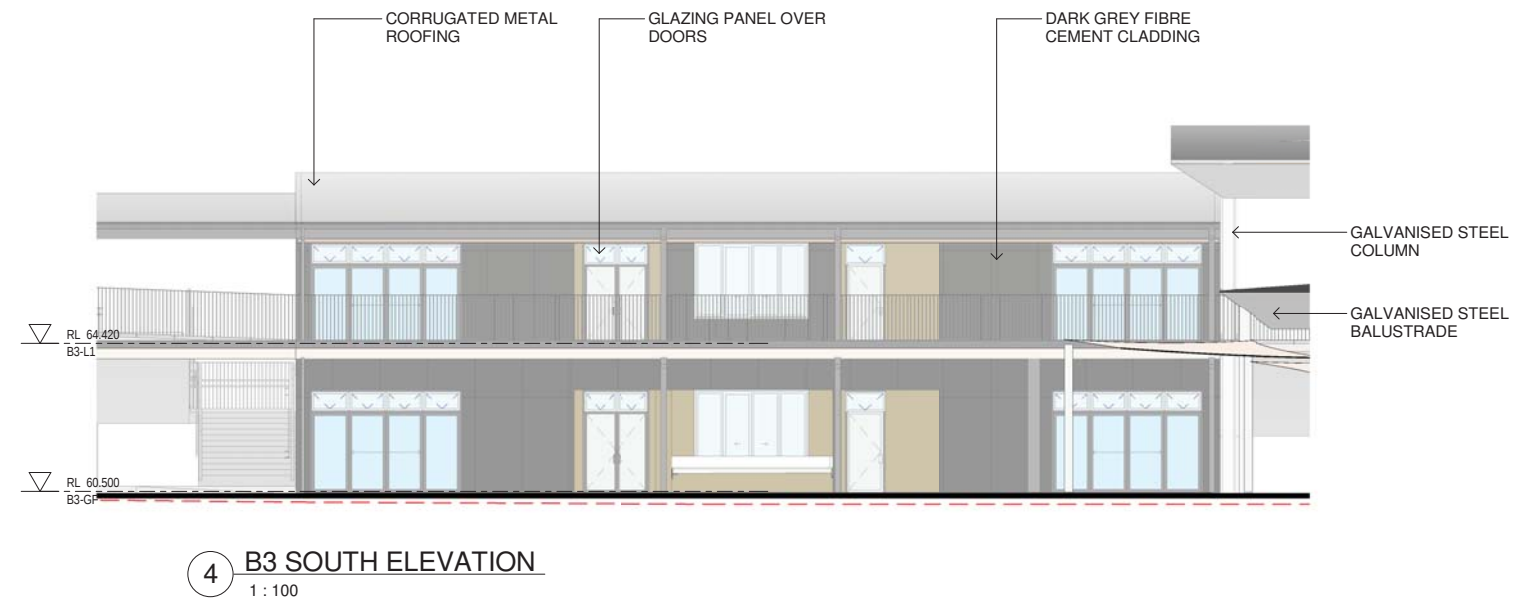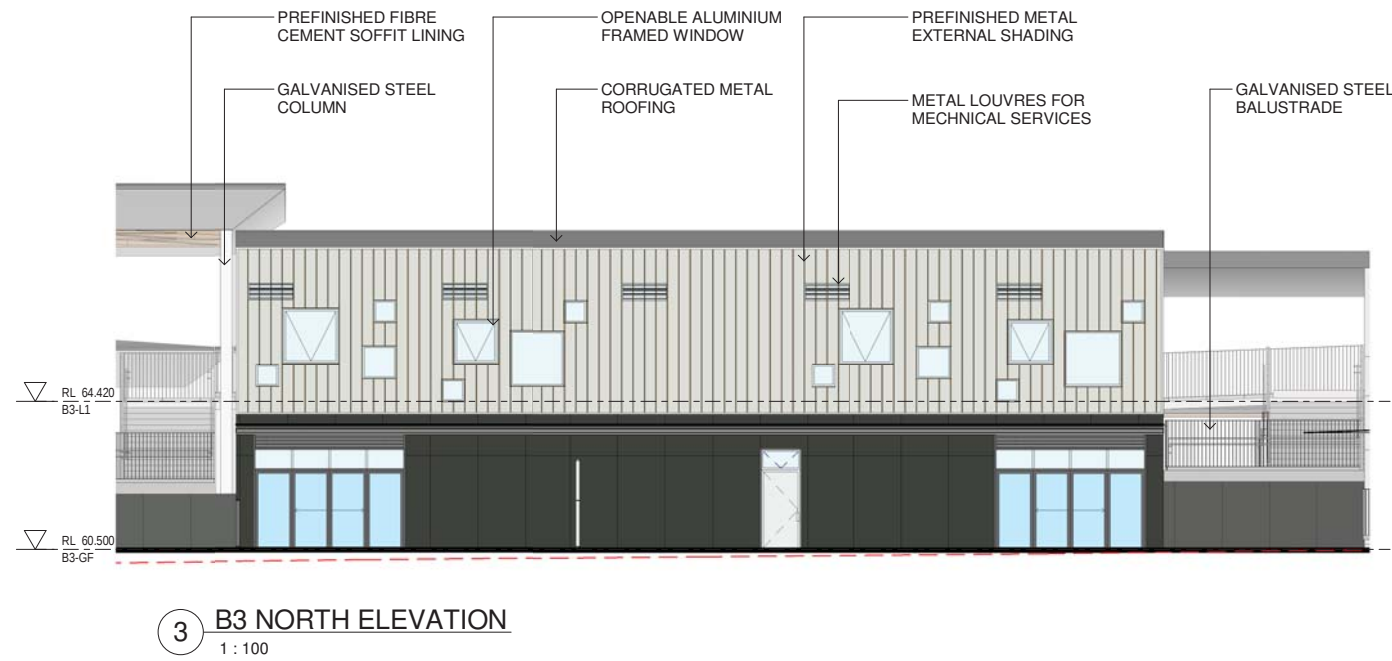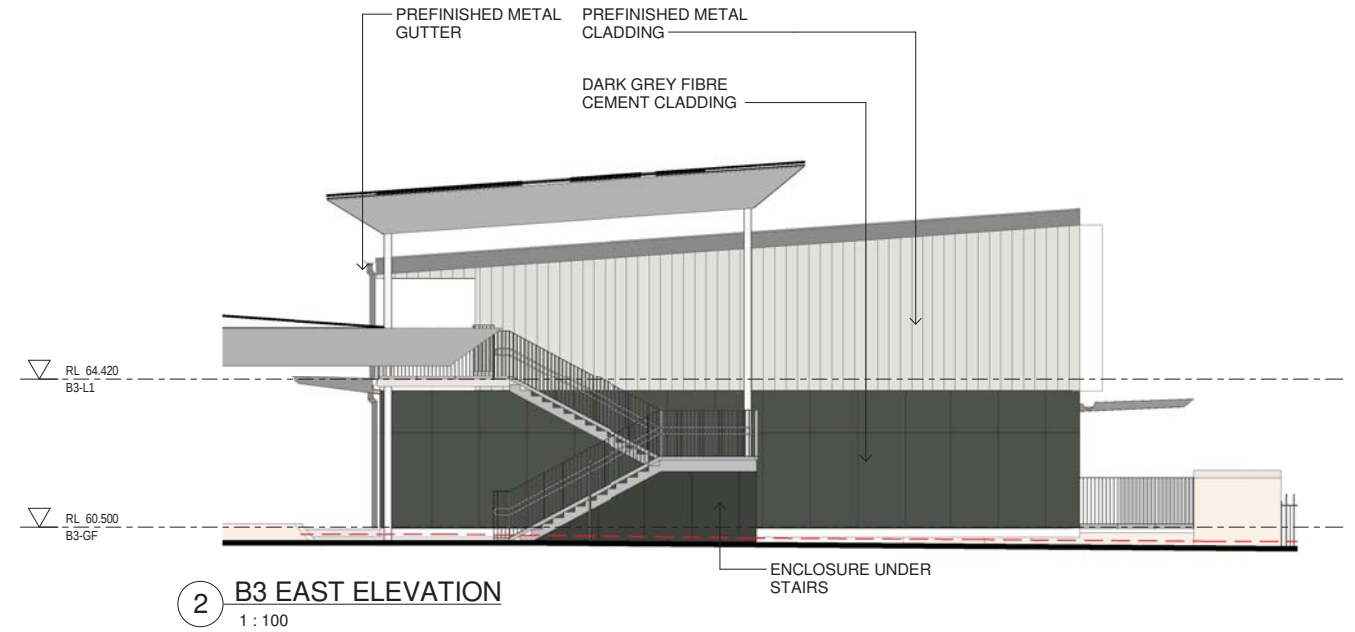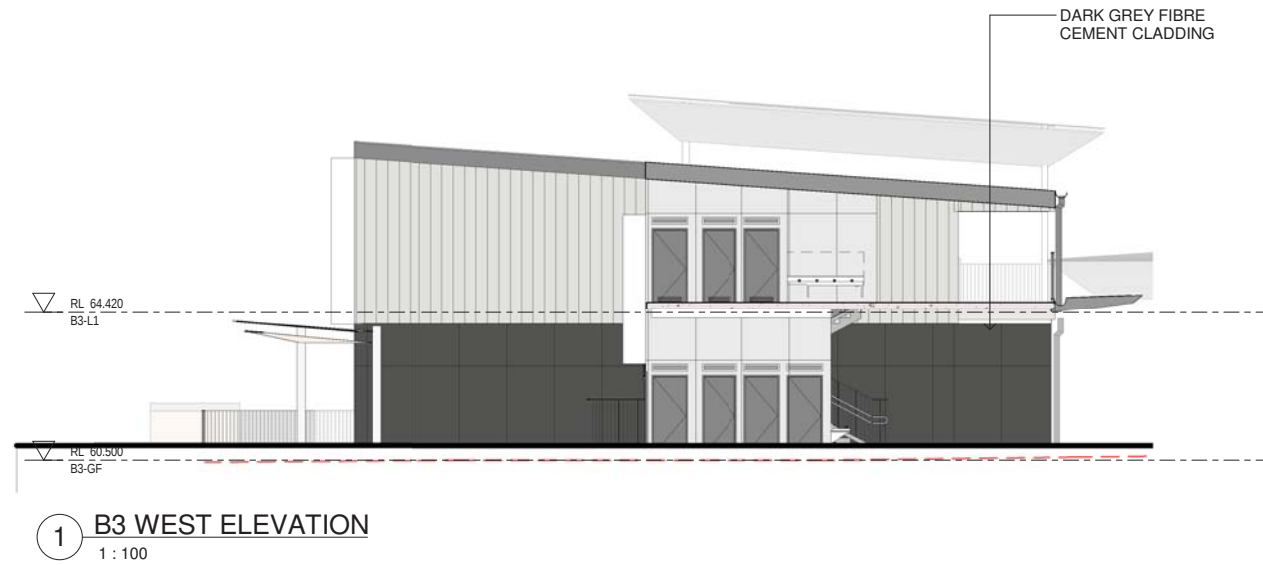

Issue No.	Date	Description	Chkd
1	12/04/2021	ISSUE FOR COORDINATION	
2	23/04/2021	ISSUE FOR COORDINATION	
3	04/05/2021	SSDA ISSUE	
4	06/08/2021	SSDA ISSUE	JL
5	11/08/2021	SSDA ISSUE	JL
6	17/08/2021	SSDA ISSUE	JL

SSDA ISSUE

RICHARD CROOKES
CONSTRUCTIONS

TRAFFIC ENGINEER
PTC
KASIA BALSAM
02 8920 0800
kasia.balsam@ptccconsultants.co

TOWN PLANNER
RPS
ROB DWYER
0425 285 778
rob.dwyer@rpsgroup.com.au

MULTI SERVICES
NDY
RYAN HAHN
0407 236 908
r.hahn@ndy.com

CIVIL AND STRUCTURAL ENGINEERING
WOOLACOTTS
JUSTIN CHIRILLO
02 8203 1504
jchirillo@woolacotts.com.au

QUANTITY SURVEYOR
MBM
AUTUMN LU
02 9270 1062
autumn.lu@mbmpl.com.au


PROJECT MANAGER
COLLIERS
ANTHONY MAUGHAN-WRIGHT
0424 189 883
anthony.maughan-wright@colliers.com

Drawing Title
BUILDING B3 - ELEVATIONS


Project
NEW PRIMARY SCHOOL IN MULGOA
RISE
at
1-23 Forestwood drive, Glenmore Park, NSW 2745, Australia
for
SINSW

Architect
NBRSARCHITECTURE.
Sydney
61 2 9922 2344
Any form of replication of this drawing in full or in part without the written permission of NBR-SPARTNERS Pty Ltd constitutes an infringement of the copyright.
Nominated Architect:
Andrew Duffin NSW 5602
NBR & Partners Pty Ltd VIC 51197
nbsarchitecture.com
© 2021
ABN 16 002 247 565


Date 18/08/2021 1:22:24 PM
Scale 1:100 @ A1
Drawing Reference 20415-NBRS-DR-A-SSDA-3012
Revision 6

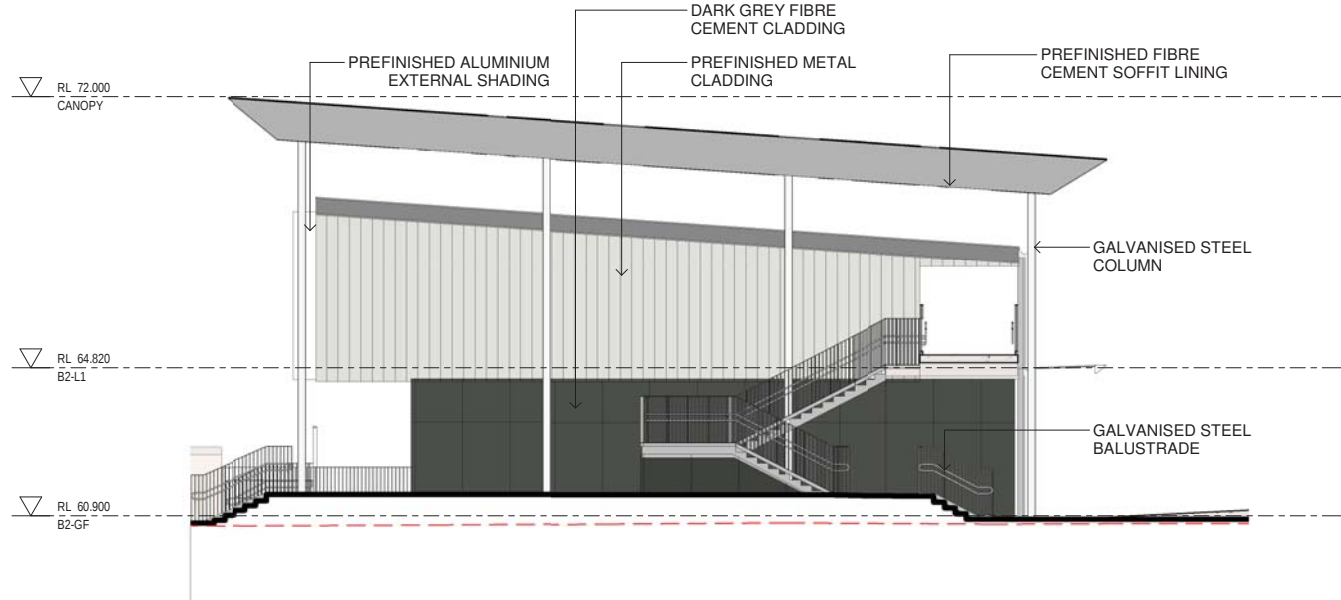

1 B2 WEST ELEVATION
1 : 100

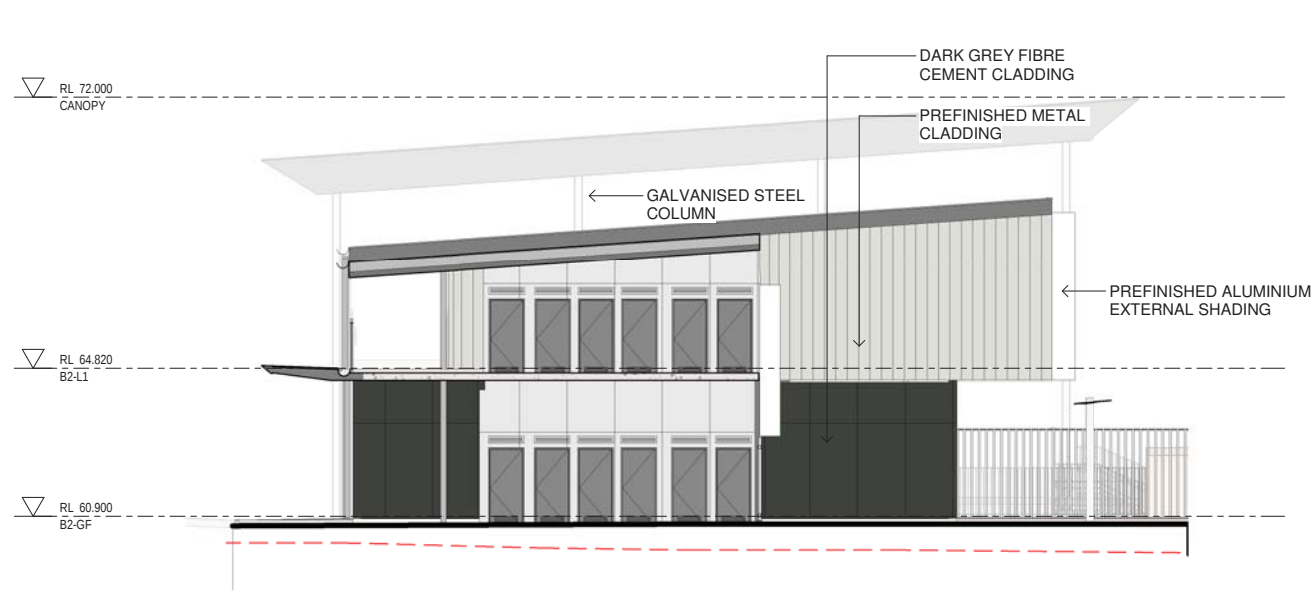

2 B2 EAST ELEVATION
1 : 100

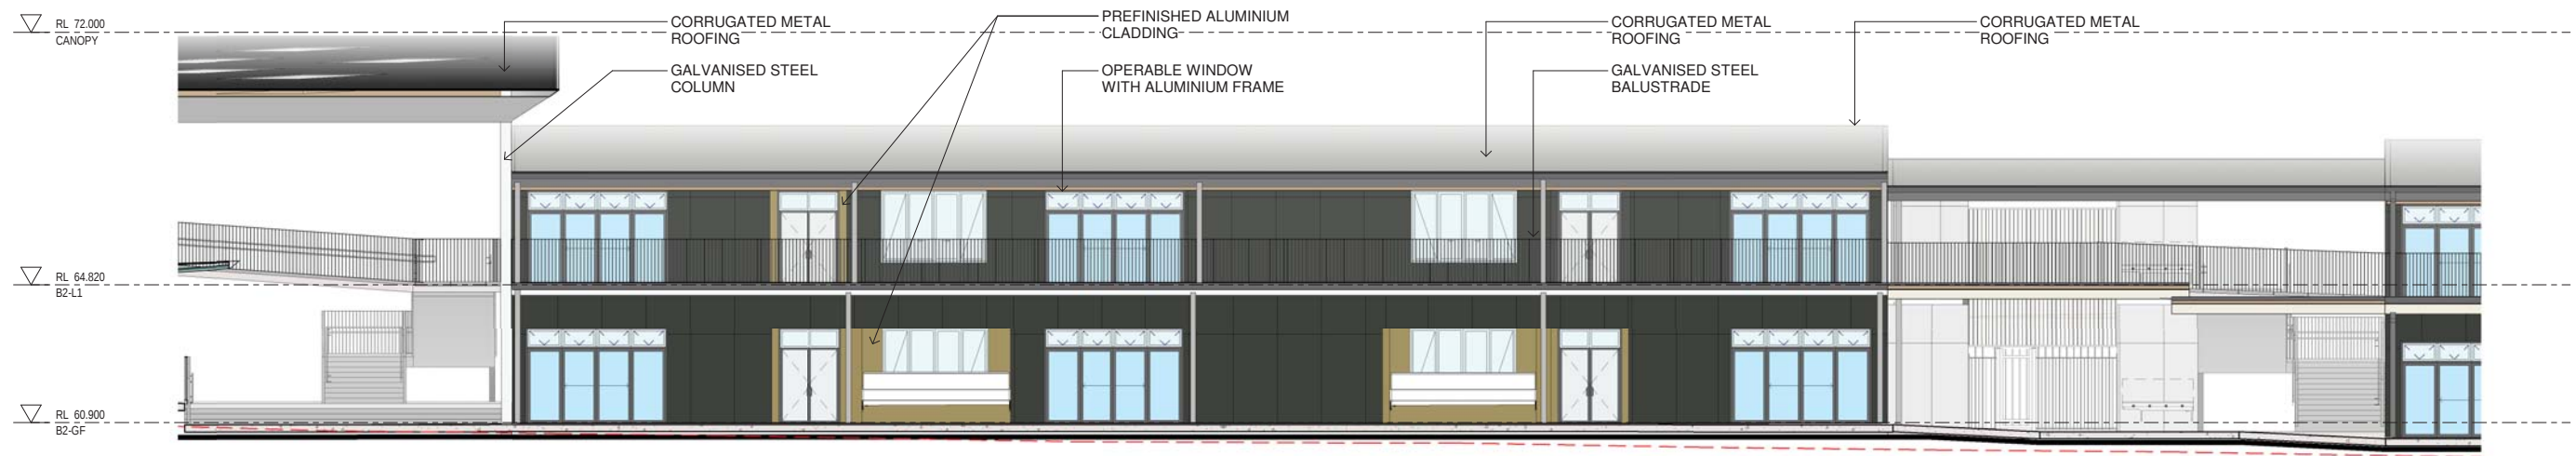

3 B2 SOUTH ELEVATION
1 : 100



4 B2 NORTH ELEVATION
1 : 100

Issue No.	Date	Description	Chkd
1	12/04/2021	ISSUE FOR COORDINATION	
2	23/04/2021	ISSUE FOR COORDINATION	
3	04/05/2021	SSDA ISSUE	JL
4	06/08/2021	SSDA ISSUE	JL
5	11/08/2021	SSDA ISSUE	JL

SSDA ISSUE

RICHARD CROOKES
CONSTRUCTIONS

TRAFFIC ENGINEER
PTC
KASIA BALSAM
02 8920 0800
kasia.balsam@ptcconsultants.co

TOWN PLANNER
RPS
SHALIN SMITH
0425 285 778
shalin.smith@rpsgroup.com.au

MULTI SERVICES
NDY
RYAN HAHN
0407 236 908
r.hahn@ndy.com

QUANTITY SURVEYOR
MBM
AUTUMN LU
02 9270 1062
autumn.lu@mbmpl.com.au

CIVIL AND STRUCTURAL ENGINEERING
WOOLACOTTS
JUSTIN CHIRILLO
02 8203 1504
jchirillo@woolacotts.com.au

PROJECT MANAGER
COLLIERS
ANTHONY MAUGHAN-WRIGHT
0424 189 883
anthony.maughan-wright@colliers.com

Drawing Title
BUILDING B2 - ELEVATIONS

Project
NEW PRIMARY SCHOOL IN MULGOA
RISE
at
1-23 Forestwood drive, Glenmore Park, NSW 2745, Australia
for
SINSW

Architect
NBRSARCHITECTURE.
Sydney
61 2 9922 2344
Any form of replication of this drawing in full or in part without the written permission of NBR-S PARTNERS Pty Ltd constitutes an infringement of the copyright.
Nominated Architect:
Andrew Duffin NSW 5602
NBR & Partners Pty Ltd VIC 51197



nbrsarchitecture.com
© 2021
ABN 16 002 247 565

Date 11/08/2021 1:17:35 PM
Scale 1:100 @ A1

Drawing Reference
20415-NBRS-DR-A-SSDA-3013

Revision
5

0 1m 2m 3m 4m 5m 6m 7m 8m 1:100

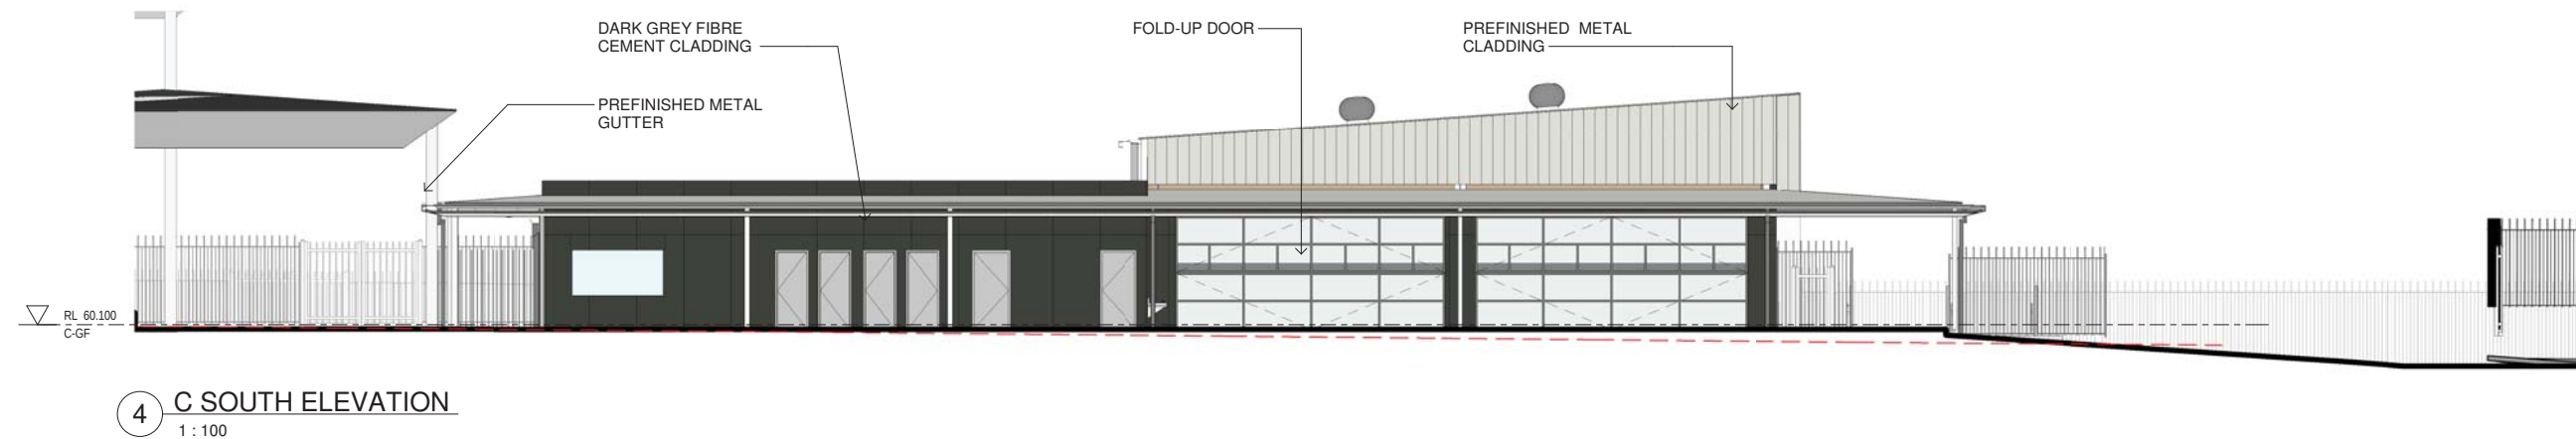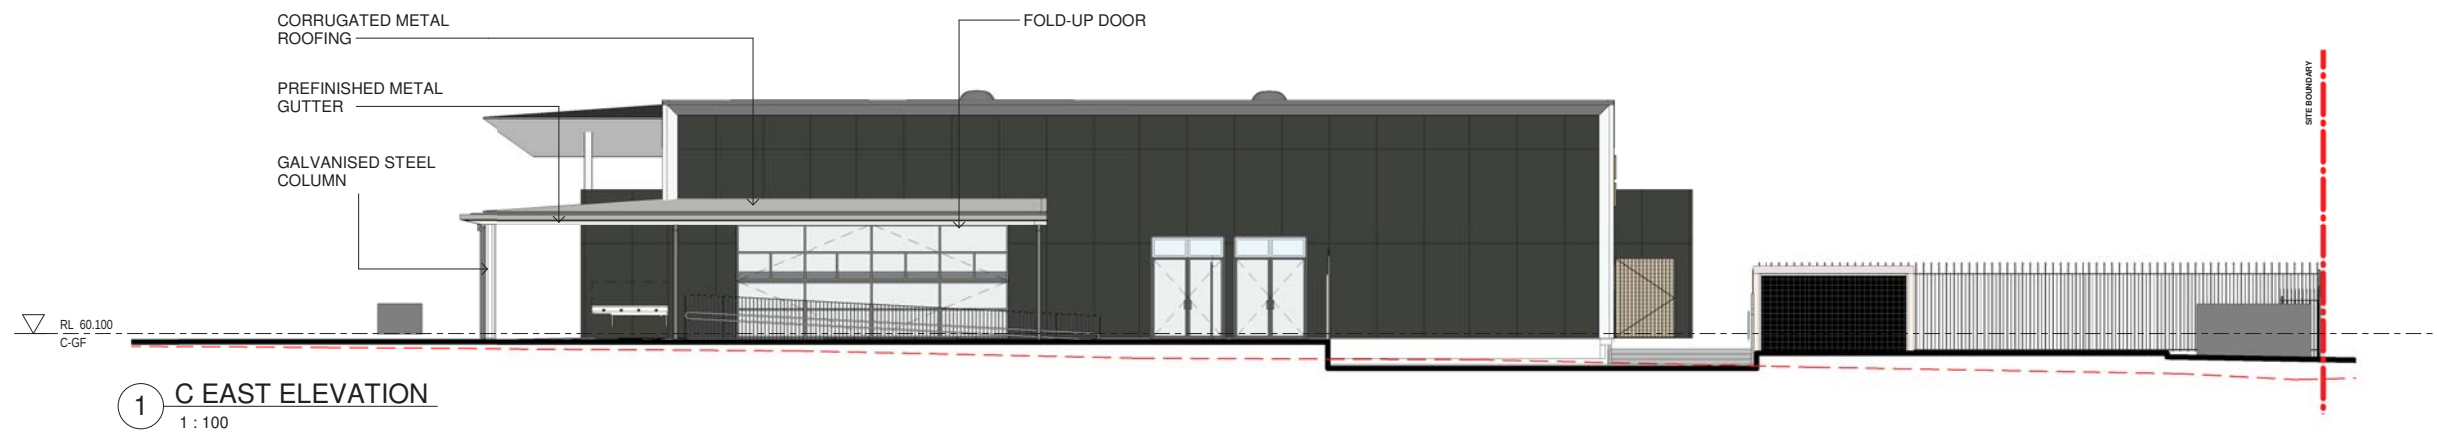

Issue No.	Date	Description	Chkd
1	12/04/2021	ISSUE FOR COORDINATION	
2	23/04/2021	ISSUE FOR COORDINATION	
3	04/05/2021	SSDA ISSUE	
4	06/08/2021	SSDA ISSUE	JL
5	11/08/2021	SSDA ISSUE	JL

SSDA ISSUE

RICHARD CROOKES
CONSTRUCTIONS

TRAFFIC ENGINEER
PTC
KASIA BALSAM
02 8920 0800
kasia.balsam@pticonsultants.co

TOWN PLANNER
RPS
SHAUN SMITH
0425 285 778
shaun.smith@rpsgroup.com.au

MULTI SERVICES
NDY
RYAN HAHN
0407 236 908
r.hahn@ndy.com

CIVIL AND STRUCTURAL ENGINEERING
WOOLACOTTS
JUSTIN CHIRILLO
02 8203 1504
jchirillo@woolacotts.com.au

QUANTITY SURVEYOR
MBM
AUTUMN LU
02 9270 1062
autumn.lu@mbmpl.com.au

PROJECT MANAGER
COLLIERS
ANTHONY MAUGHAN-WRIGHT
0424 189 883
anthony.maughan-wright@colliers.com

Drawing Title
BUILDING C - ELEVATIONS


Project
NEW PRIMARY SCHOOL IN MULGOA
RISE
at
1-23 Forestwood drive, Glenmore Park, NSW 2745, Australia
for
SINSW

Architect
NBRSARCHITECTURE.
Sydney
61 2 9922 2344
Any form of replication of this drawing in full or in part without the written permission of NBR-S PARTNERS Pty Ltd constitutes an infringement of the copyright.
Nominated Architect:
Andrew Duffin NSW 5602
NBR-S & Partners Pty Ltd VIC 51197
nbsarchitecture.com
© 2021
ABN 16 002 247 565


Date 11/08/2021 1:18:13 PM
Scale 1:100 @ A1

Drawing Reference
20415-NBRS-DR-A-SSDA-3014
Revision
5

0 1m 2m 3m 4m 5m 6m 7m 8m 1:100

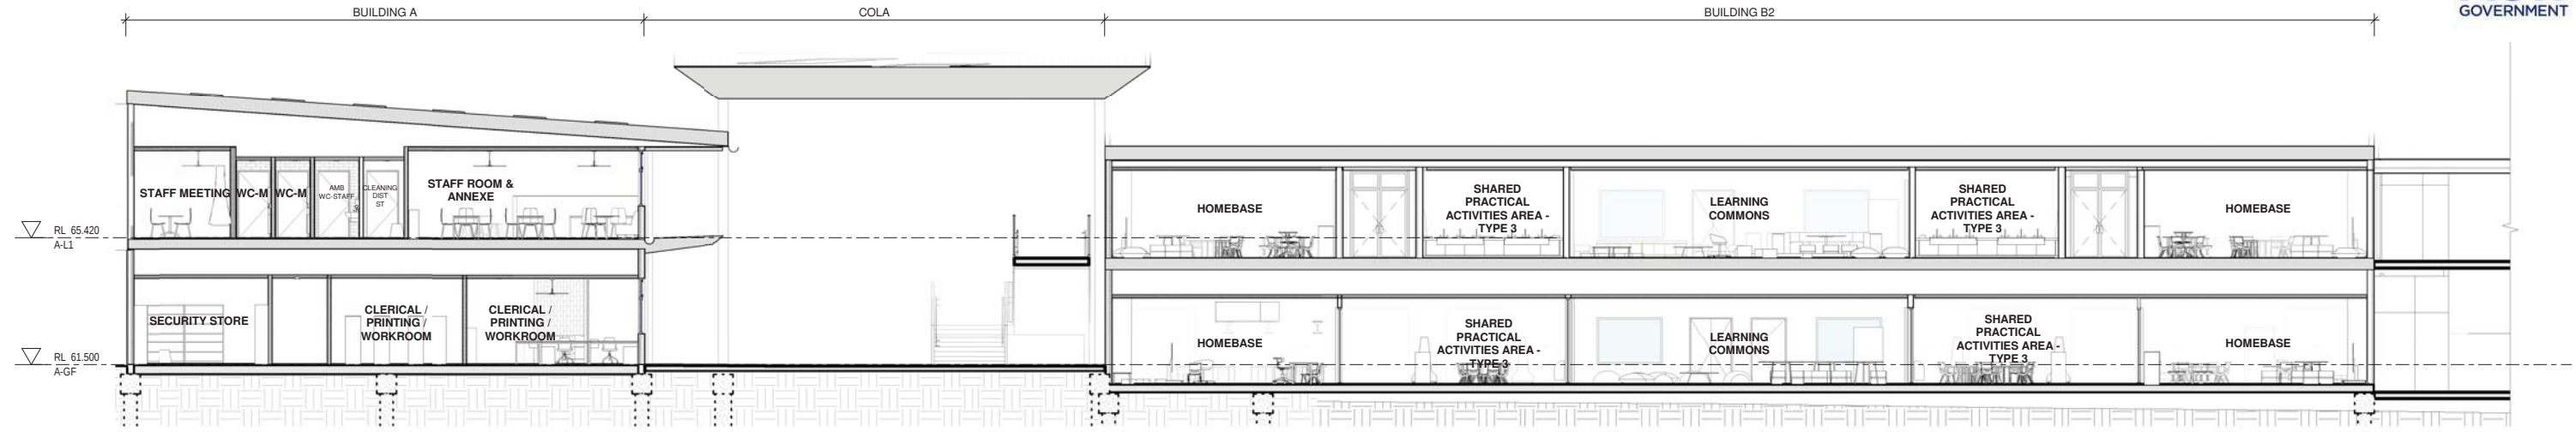

1 SECTION 1 - MAIN ENTRY CANOPY
1 : 100

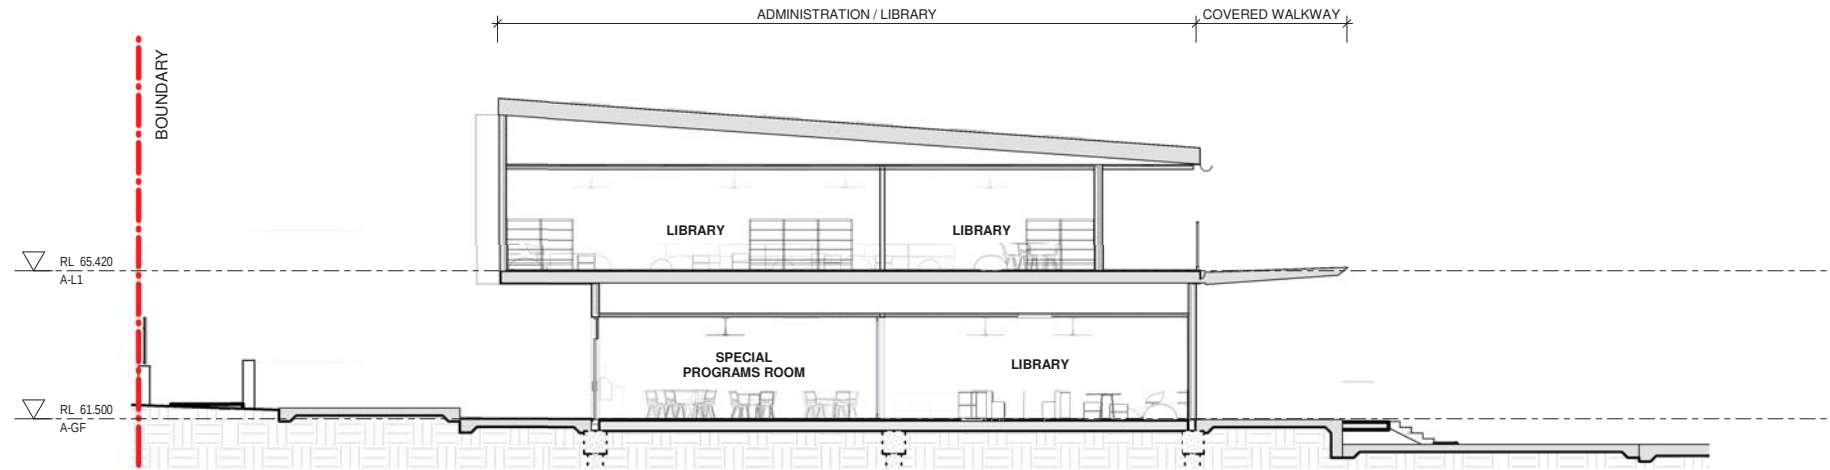

2 SECTION 2 - LIBRARY
1 : 100

Issue No.	Date	Description	Chkd
1	12/04/2021	ISSUE FOR COORDINATION	
2	23/04/2021	ISSUE FOR COORDINATION	
3	04/05/2021	SSDA ISSUE	
4	06/08/2021	SSDA ISSUE	JL

SSDA ISSUE

RICHARD CROOKES
CONSTRUCTIONS

TRAFFIC ENGINEER
PTC
KASIA BALSAM
02 8920 0800
kasia.balsam@ptcconsultants.co

TOWN PLANNER
RPS
SHAUN SMITH
0425 285 778
shaun.smith@rpsgroup.com.au

MULTI SERVICES
NDY
RYAN HAHN
0407 236 908
r.hahn@ndy.com

CIVIL AND STRUCTURAL ENGINEERING
WOOLACOTTS
JUSTIN CHIRILLO
02 8203 1504
jchirillo@woolacotts.com.au

QUANTITY SURVEYOR
MBM
AUTUMN LU
02 9270 1062
autumn.lu@mbmpl.com.au

PROJECT MANAGER
COLLIERS
ANTHONY MAUGHAN-WRIGHT
0424 189 883
anthony.maughan-wright@colliers.com

Drawing Title
BUILDING A - SECTIONS

Project
NEW PRIMARY SCHOOL IN MULGOA
RISE
at
1-23 Forestwood drive, Glenmore Park, NSW 2745, Australia
for
SINSW

Architect
NBRSARCHITECTURE.
Sydney
61 2 9922 2344
Any form of replication of this drawing in full or in part without the written permission of NBR-SPARTNERS Pty Ltd constitutes an infringement of the copyright.
Nominated Architect:
Andrew Duffin NSW 5602
NBR & Partners Pty Ltd VIC 51197


nbrsarchitecture.com
© 2021
ABN 16 002 247 565

Date 6/08/2021 4:29:38 PM
Scale 1:100 @ A1


Drawing Reference
20415-NBR-DR-A-SSDA-4001

Revision
4


0 1m 2m 3m 4m 5m 6m 7m 8m 1:100

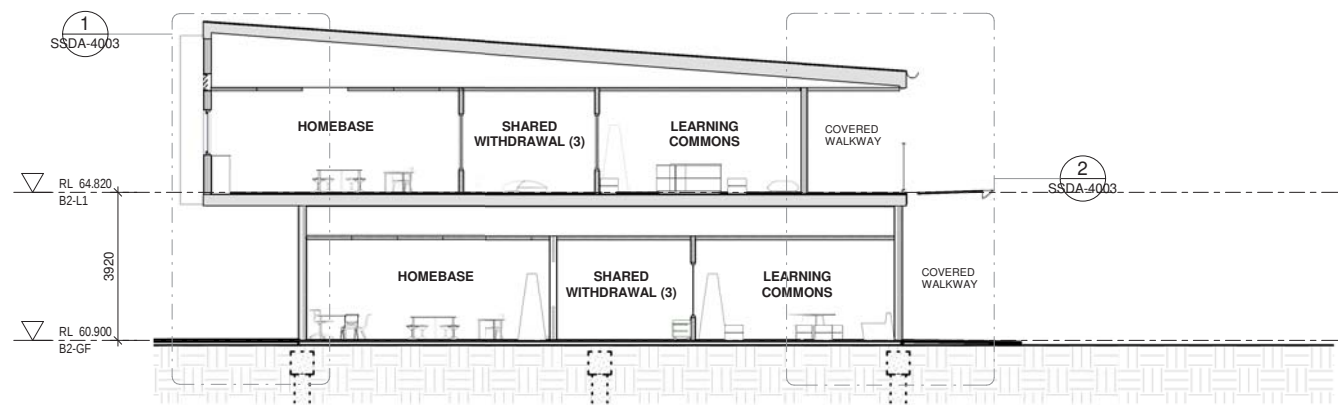


1 SECTION 1 - B2 BUILDING
1 : 100

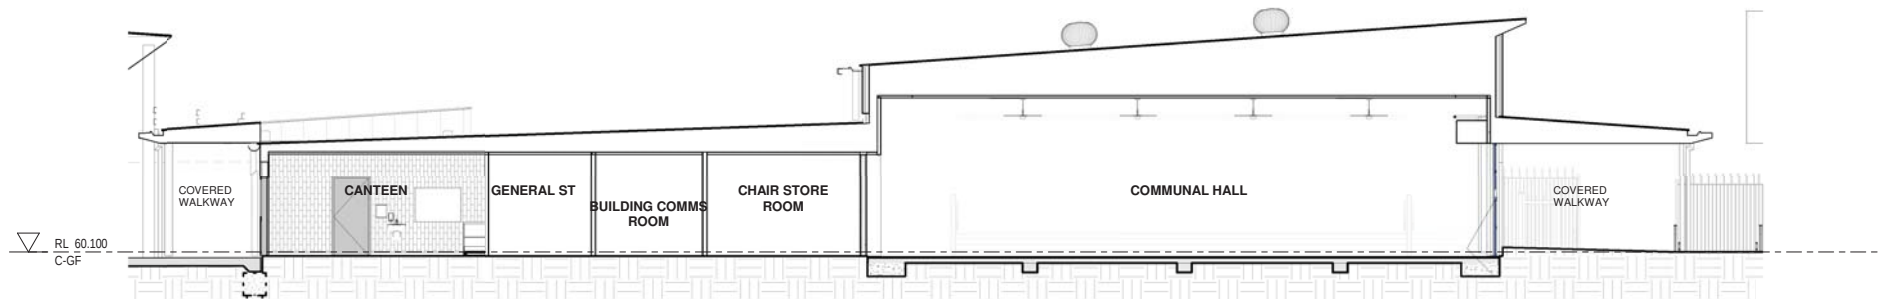

2 SECTION 2 - HALL
1 : 100

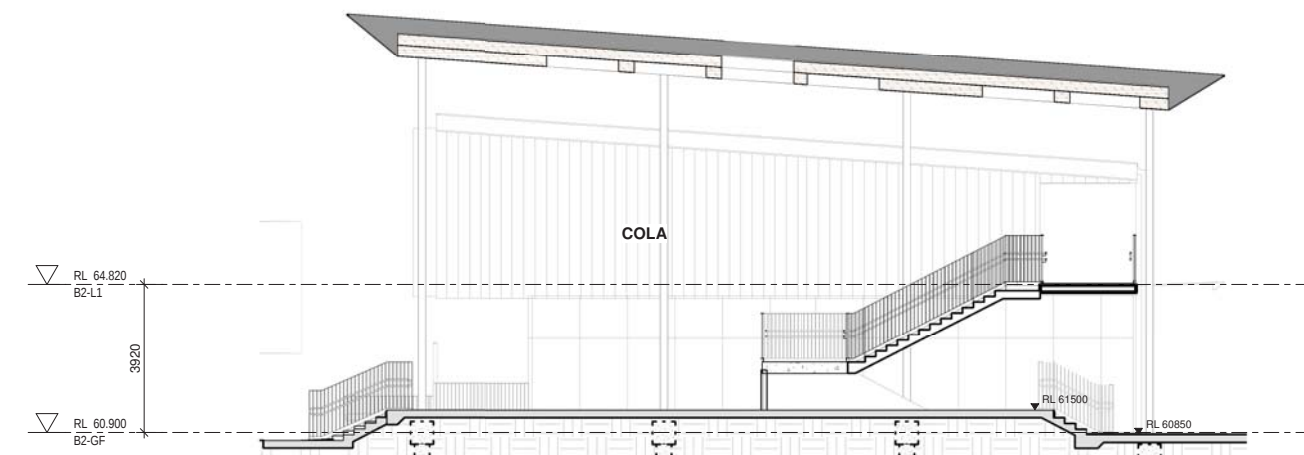

3 SECTION 3 - MAIN ENTRY CANOPY
1 : 100

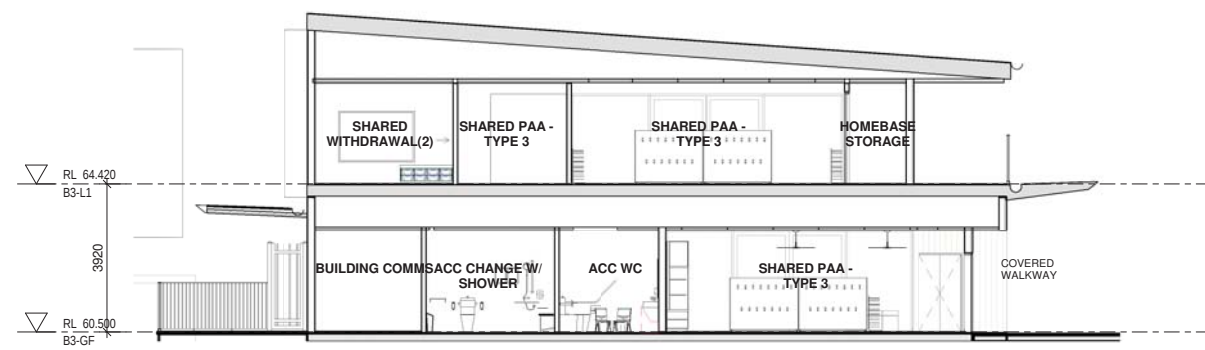

4 SECTION 4 - B3 BUILDING
1 : 100

Issue No.	Date	Description	Chkd
1	12/04/2021	ISSUE FOR COORDINATION	
2	23/04/2021	ISSUE FOR COORDINATION	
3	04/05/2021	SSDA ISSUE	
4	06/08/2021	SSDA ISSUE	JL

SSDA ISSUE

RICHARD CROOKES
CONSTRUCTIONS

TRAFFIC ENGINEER
PTC
KASIA BALSAM
02 8920 0800
kasia.balsam@ptcconsultants.co

TOWN PLANNER
RPS
SHALIN SMITH
0425 285 778
shalin.smith@rpsgroup.com.au

MULTI SERVICES
NDY
RYAN HAHN
0407 236 908
r.hahn@ndy.com

CIVIL AND STRUCTURAL ENGINEERING
WOOLACOTTS
JUSTIN CHIRILLO
02 8203 1504
jchirillo@woolacotts.com.au

QUANTITY SURVEYOR
MBM
AUTUMN LU
02 9270 1062
autumn.lu@mbmpl.com.au

PROJECT MANAGER
COLLIERS
ANTHONY MAUGHAN-WRIGHT
0424 189 883
anthony.maughan-wright@colliers.com

Drawing Title
BUILDING - SECTIONS


Project
NEW PRIMARY SCHOOL IN MULGOA
RISE
at
1-23 Forestwood drive, Glenmore Park, NSW 2745, Australia
for
SINSW

Architect
NBRSARCHITECTURE.
Sydney
61 2 9922 2344
Any form of replication of this drawing in full or in part without the written permission of NBR-S+PARTNERS Pty Ltd constitutes an infringement of the copyright.
Nominated Architect:
Andrew Duffin NSW 5602
NBR-S & Partners Pty Ltd VIC 51197
nbrsarchitecture.com
© 2021
ABN 16 002 247 565

Date 6/08/2021 4:29:58 PM
Scale 1:100 @ A1

Drawing Reference
20415-NBRS-DR-A-SSDA-4002
Revision
4

0 1m 2m 3m 4m 5m 6m 7m 8m 1:100

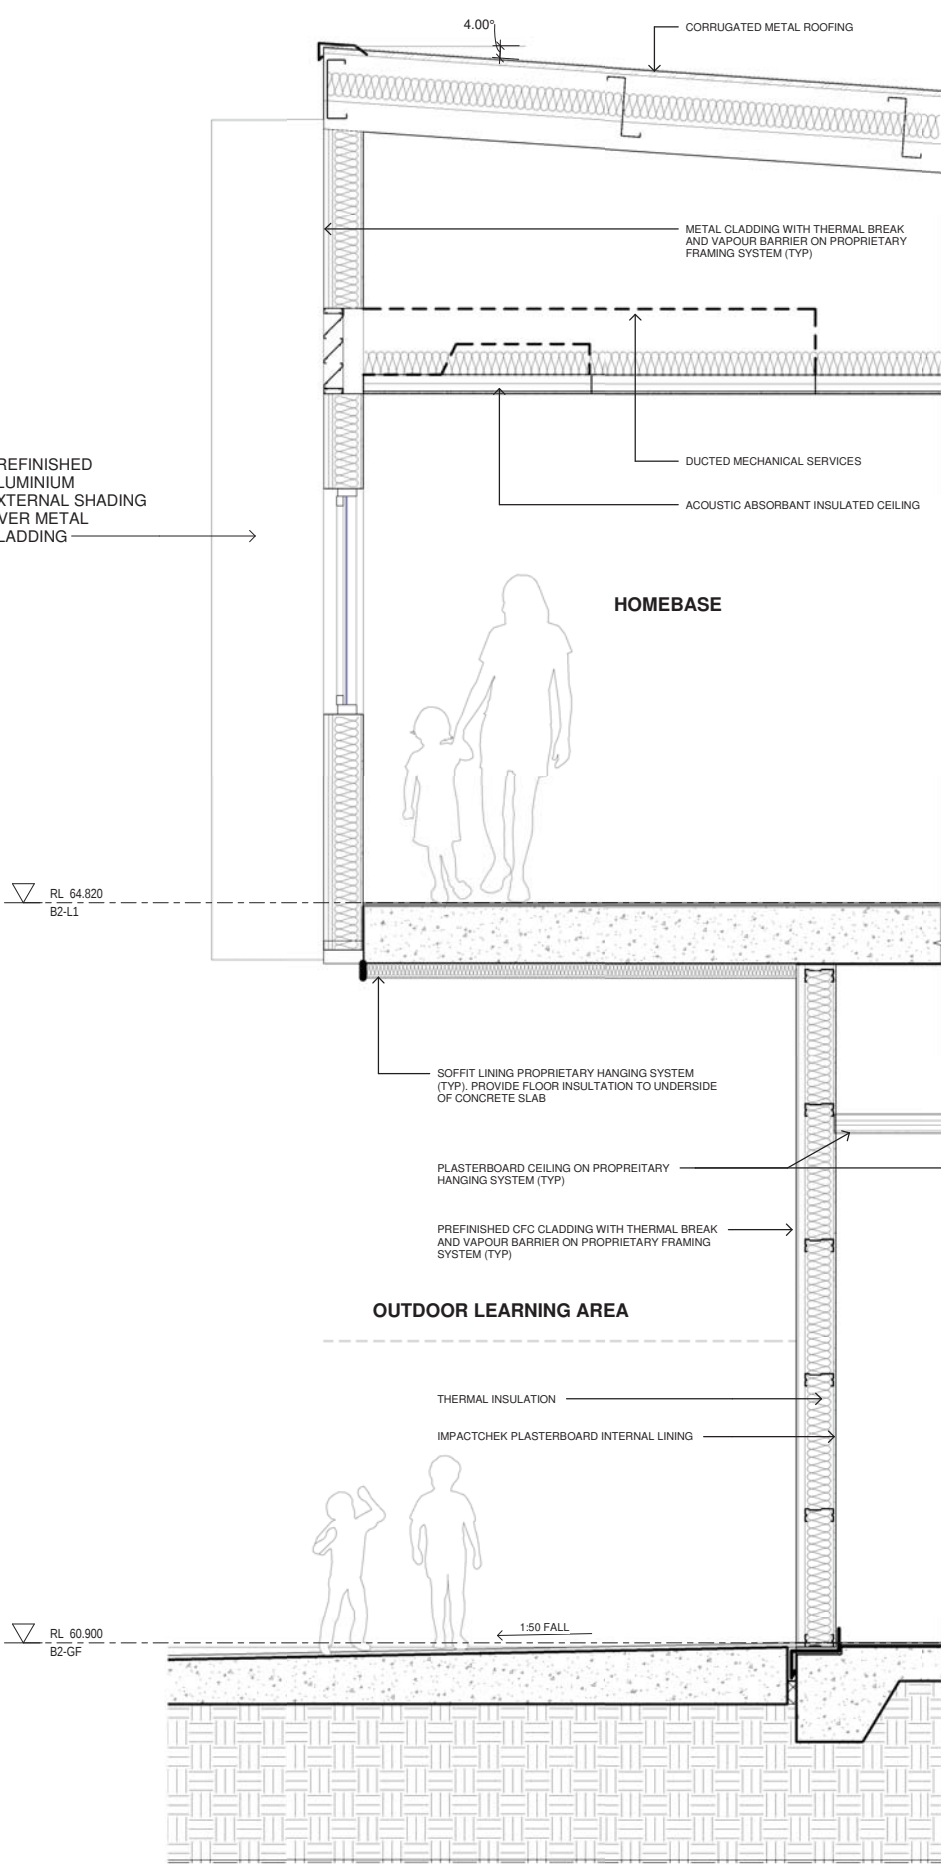

1
SECTION 1 - TYPICAL BUILDING DETAIL
1 : 20

Issue No.	Date	Description	Chkd
1	12/04/2021	ISSUE FOR COORDINATION	
2	23/04/2021	ISSUE FOR COORDINATION	
3	04/05/2021	SSDA ISSUE	
4	06/08/2021	SSDA ISSUE	JL

SSDA ISSUE

RICHARD CROOKES
CONSTRUCTIONS

TRAFFIC ENGINEER
PTC
KASIA BALSAM
02 8920 0800
kasia.balsam@ptcconsultants.co

TOWN PLANNER
RPS
SHALIN SMITH
0425 285 778
shalin.smith@rpsgroup.com.au

2
SECTION 1 - B2 BUILDING - Callout 2
1 : 20

Issue No.	Date	Description	Chkd
1	12/04/2021	ISSUE FOR COORDINATION	
2	23/04/2021	ISSUE FOR COORDINATION	
3	04/05/2021	SSDA ISSUE	
4	06/08/2021	SSDA ISSUE	JL

SSDA ISSUE

RICHARD CROOKES
CONSTRUCTIONS

TRAFFIC ENGINEER
PTC
KASIA BALSAM
02 8920 0800
kasia.balsam@ptcconsultants.co

TOWN PLANNER
RPS
SHALIN SMITH
0425 285 778
shalin.smith@rpsgroup.com.au

3
SECTION 3 - TYPICAL CANOPY DETAIL
1 : 20

Drawing Title
BUILDING - DETAIL SECTIONS

Project
NEW PRIMARY SCHOOL IN MULGOA
RISE
at
1-23 Forestwood drive, Glenmore Park, NSW 2745, Australia
for
SINSW

Architect

NBR
ARCHITECTURE

Sydney
61 2 9922 2344
Any form of replication of this drawing in full or in part without the written permission of NBR&PARTNERS Pty Ltd constitutes an infringement of the copyright.
Nominated Architect:
Andrew Duffin NSW 5602
NBR& Partners Pty Ltd VIC 51197

nbrsarchitecture.com

Date 6/08/2021 4:30:05 PM
Scale 1:20 @ A1

Drawing Reference
20415-NBRS-DR-A-SSDA-4003

Revision
4

0 0.2m 0.4m 0.6m 0.8m 1m 1.2m 1.4m 1.6m 1.8m 2m



AERIAL PERSPECTIVE - CORNER OF DEERUBBIN DRIVE & DARUG AVE (NTS)

Issue No.	Date	Description	Chkd
1	23/04/2021	ISSUE FOR COORDINATION	
2	04/05/2021	SSDA ISSUE	
3	06/08/2021	SSDA ISSUE	JL
4	17/08/2021	SSDA ISSUE	JL

SSDA ISSUE

RICHARD CROOKES
CONSTRUCTIONS

TRAFFIC ENGINEER
PTC
KASIA BALSAM
02 8920 0800
kasia.balsam@pticonsultants.co

TOWN PLANNER
RPS
ROB DWYER
0425 285 778
rob.dwyer@rpsgroup.com.au

MULTI SERVICES
NDY
RYAN HAHN
0407 236 908
r.hahn@ndy.com

CIVIL AND STRUCTURAL ENGINEERING
WOOLACOTTS
JUSTIN CHIRILLO
02 8203 1504
jchirillo@woolacotts.com.au

QUANTITY SURVEYOR
MBM
AUTUMN LU
02 9270 1062
autumn.lu@mbmpl.com.au

PROJECT MANAGER
COLLIERS
ANTHONY MAUGHAN-WRIGHT
0424 189 883
anthony.maughan-wright@colliers.com

Drawing Title
3D IMAGE 1

Project
NEW PRIMARY SCHOOL IN MULGOA
RISE
at
1-23 Forestwood drive, Glenmore Park, NSW 2745, Australia
for
SINSW

Architect
NBRSARCHITECTURE.

Sydney
61 2 9922 2344
Any form of replication of this drawing in full or in part without the written permission of NBR-S PARTNERS Pty Ltd constitutes an infringement of the copyright.
Nominated Architect:
Andrew Duffin NSW 5602
NBR & Partners Pty Ltd VIC 51197

nbrsarchitecture.com
© 2021
ABN 16 002 247 565

Date 19/08/2021 11:06:37 AM
Scale NOT TO SCALE

Drawing Reference 20415-NBR-DR-A-SSDA-7001
Revision 4



PERSPECTIVE - CORNER OF BUILDING A, ADMINISTRATION & LIBRARY



PERSPECTIVE - FROM SOUTH EAST CORNER OF THE MULTIPURPOSE HALL

Issue No.	Date	Description	Chkd
1	04/05/2021	SSDA ISSUE	
3	06/08/2021	SSDA ISSUE	JL

SSDA ISSUE

RICHARD CROOKES
CONSTRUCTIONS

TRAFFIC ENGINEER
PTC
KASIA BALSAM
02 8920 0800
kasia.balsam@pticonsultants.co

TOWN PLANNER
RPS
SHAUN SMITH
0425 285 778
shaun.smith@rpsgroup.com.au

MULTI SERVICES
NDY
RYAN HAHN
0407 236 908
r.hahn@ndy.com

CIVIL AND STRUCTURAL ENGINEERING
WOOLACOTTS
JUSTIN CHIRILLO
02 8203 1504
jchirillo@woolacotts.com.au

QUANTITY SURVEYOR
MBM
AUTUMN LU
02 9270 1062
autumn.lu@mbmpl.com.au

PROJECT MANAGER
COLLIERS
ANTHONY MAUGHAN-WRIGHT
0424 189 883
anthony.maughan-wright@colliers.com

Drawing Title
3D IMAGE 3

Project
NEW PRIMARY SCHOOL IN MULGOA
RISE
at
1-23 Forestwood drive, Glenmore Park, NSW 2745, Australia
for
SINSW

Architect
NBRSARCHITECTURE.
Sydney
61 2 9922 2344
Any form of replication of this drawing in full or in part without the written permission of NBRSPARTNERS Pty Ltd constitutes an infringement of the copyright.
Nominated Architect:
Andrew Duffin NSW 5602
NBRSPARTNERS Pty Ltd VIC 51197
nbrsarchitecture.com
© 2021
ABN 16 002 247 565

Date 6/08/2021 5:24:04 PM
Scale NOT TO SCALE

Drawing Reference
20415-NBRS-DR-A-SSDA-7003

Revision
3



PERSPECTIVE FROM THE ASSEMBLY / MEETING POINT LOOKING TOWARD THE MAIN COVERED ENTRY

Issue No.	Date	Description	Chkd
1	23/04/2021	ISSUE FOR COORDINATION	
2	04/05/2021	SSDA ISSUE	
3	06/08/2021	SSDA ISSUE	JL
4	17/08/2021	SSDA ISSUE	JL

SSDA ISSUE

RICHARD CROOKES
CONSTRUCTIONS

TRAFFIC ENGINEER
PTC
KASIA BALSAM
02 8920 0800
kasia.balsam@pticonsultants.co

TOWN PLANNER
RPS
ROB DWYER
0425 285 778
rob.dwyer@rpsgroup.com.au

MULTI SERVICES
NDY
RYAN HAHN
0407 236 908
r.hahn@ndy.com

CIVIL AND STRUCTURAL ENGINEERING
WOOLACOTTS
JUSTIN CHIRILLO
02 8203 1504
jchirillo@woolacotts.com.au

QUANTITY SURVEYOR
MBM
AUTUMN LU
02 9270 1062
autumn.lu@mbmpl.com.au

PROJECT MANAGER
COLLIERS
ANTHONY MAUGHAN-WRIGHT
0424 189 883
anthony.maughan-wright@colliers.com

Drawing Title
3D IMAGE 4

Project
NEW PRIMARY SCHOOL IN MULGOA
RISE
at
1-23 Forestwood drive, Glenmore Park, NSW 2745, Australia
for
SINSW


Architect
NBRSARCHITECTURE.
Sydney
61 2 9922 2344
Any form of replication of this drawing in full or in part without the written permission of NBR-S PARTNERS Pty Ltd constitutes an infringement of the copyright.
Nominated Architect:
Andrew Duffin NSW 5602
NBR & Partners Pty Ltd VIC 51197

nbrsarchitecture.com
© 2021
ABN 16 002 247 565


Date 19/08/2021 11:07:02 AM
Scale NOT TO SCALE

Drawing Reference
20415-NBRS-DR-A-SSDA-7004


Revision
4

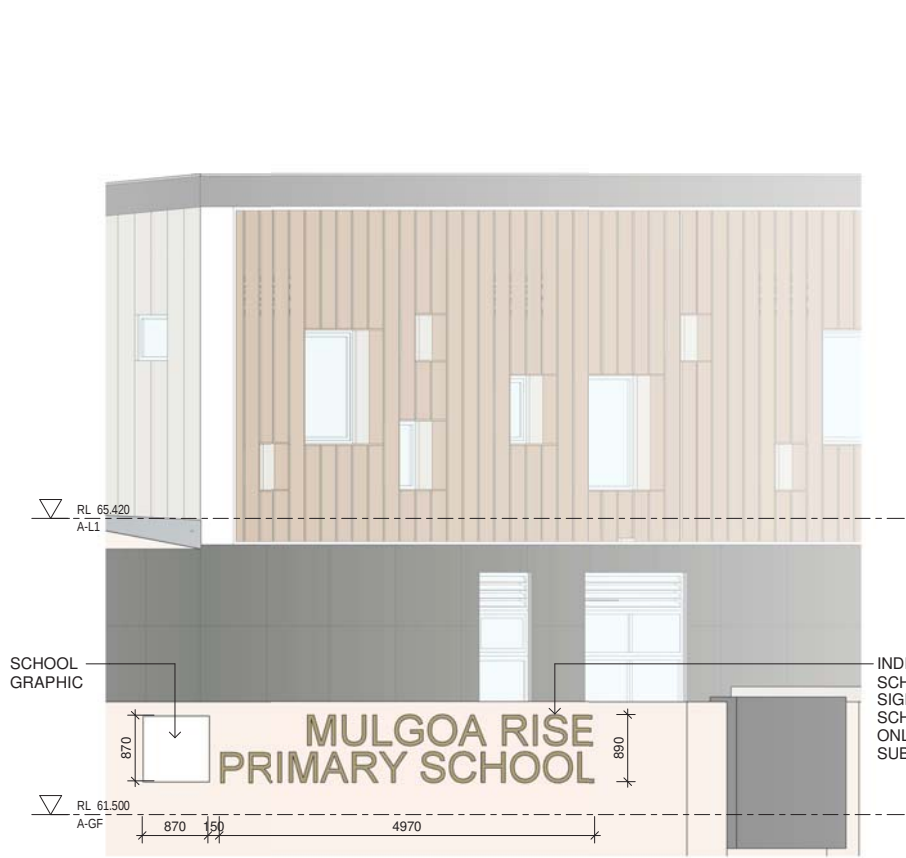


1 MAIN SCHOOL SIGNAGE 01

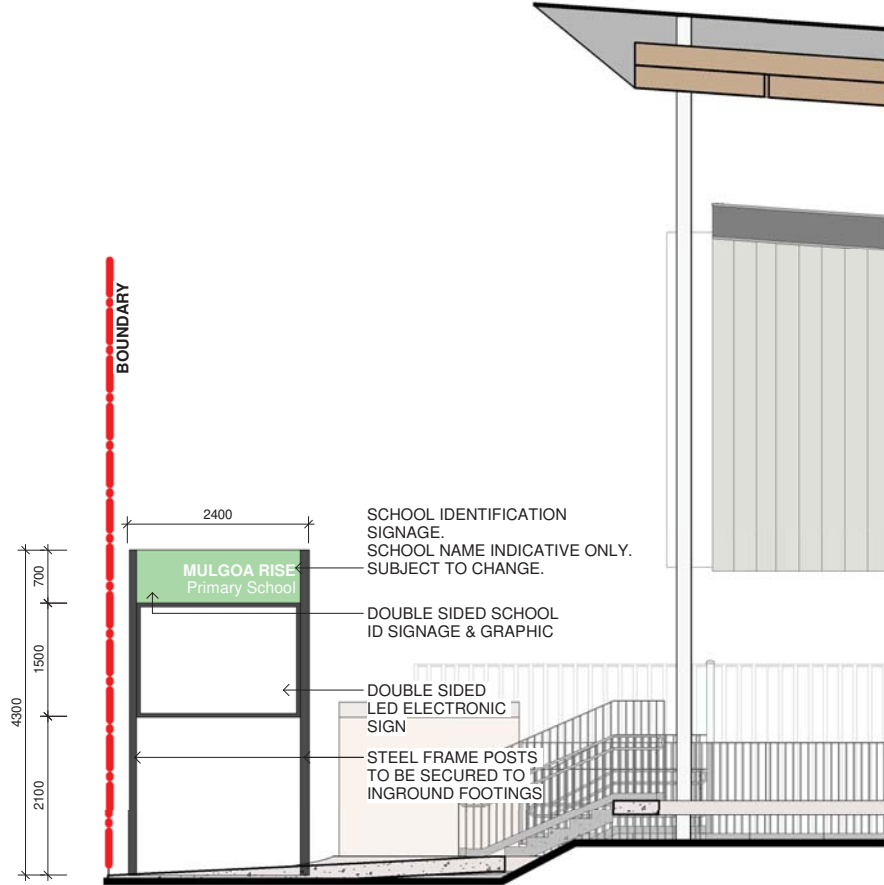


2 DIGITAL ELECTRONIC LED SIGNAGE
1 : 50

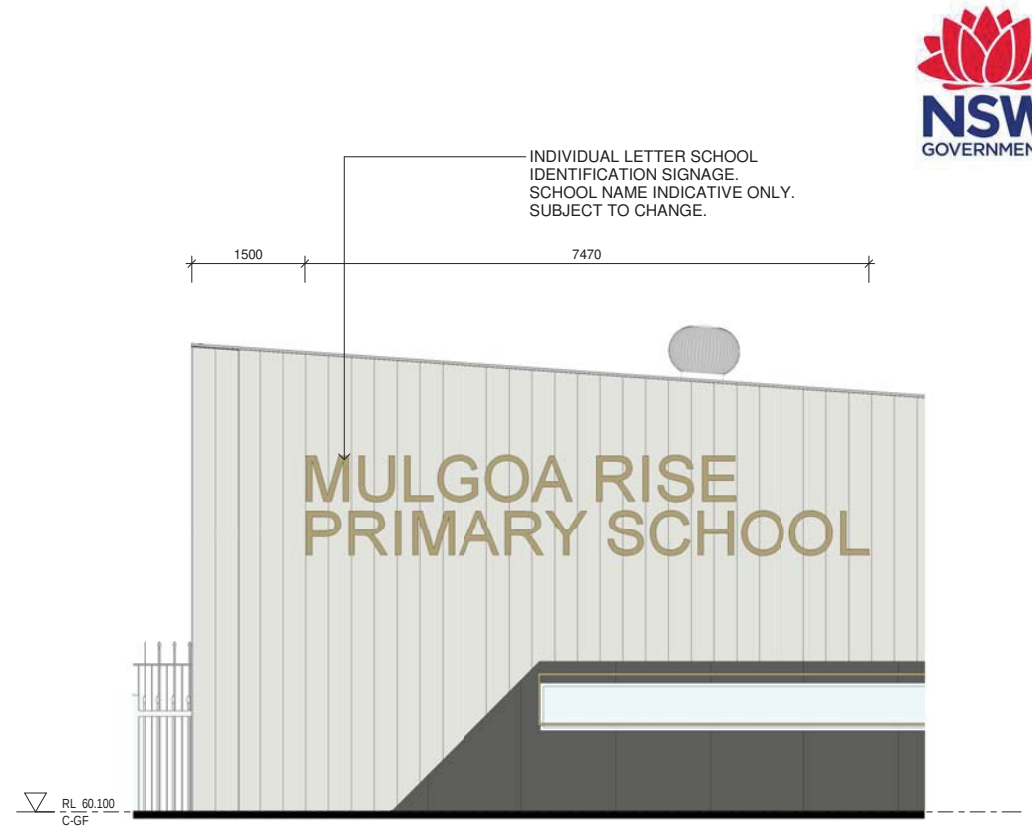


3 MAIN SCHOOL SIGNAGE 02
1 : 50

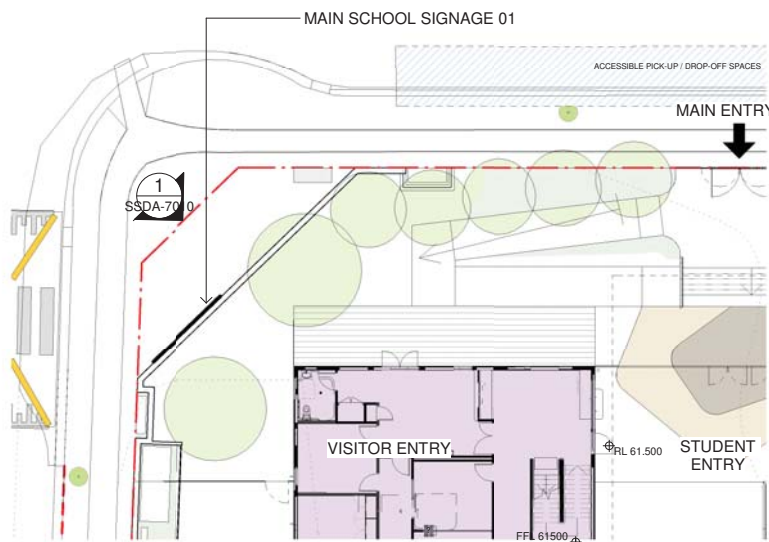


4 MAIN SCHOOL SIGNAGE 01
1 : 200

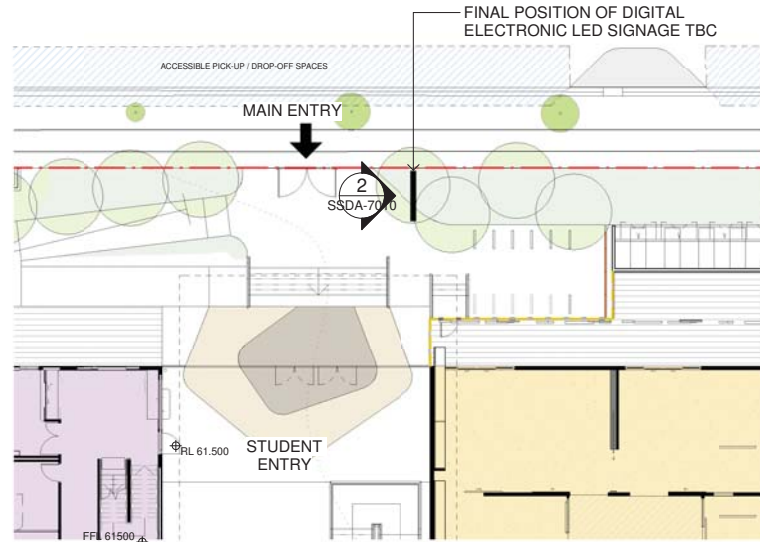

5 DIGITAL ELECTRONIC LED SIGNAGE
1 : 200

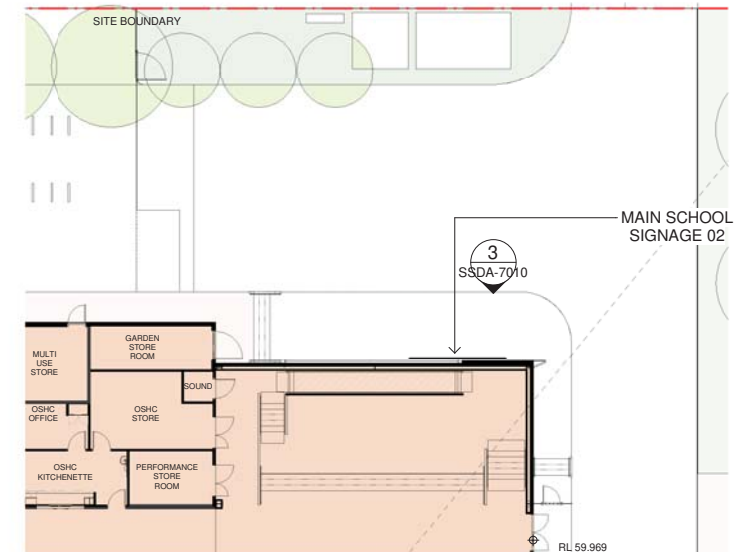

6 MAIN SCHOOL SIGNAGE 02
1 : 200

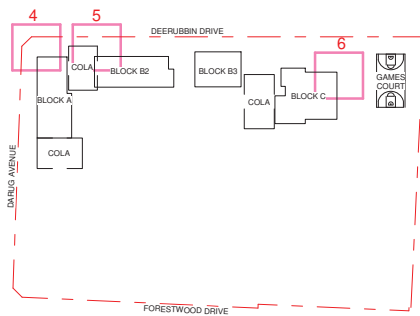

SITE KEY PLAN
N.T.S.

Issue No.	Date	Description	Chkd
1	04/05/2021	SSDA ISSUE	
2	06/08/2021	SSDA ISSUE	JL

SSDA ISSUE

RICHARD CROOKES
CONSTRUCTIONS

TRAFFIC ENGINEER
PTC
KASIA BALSAM
0407 236 908
kasia.balsam@ptccconsultants.co

TOWN PLANNER
RPS
SHALIN SMITH
0425 285 778
shalin.smith@rpsgroup.com.au

MULTI SERVICES
NDY
RYAN HAHN
0407 236 908
r.hahn@ndy.com

CIVIL AND STRUCTURAL ENGINEERING
WOOLACOTTS
JUSTIN CHIRILLO
02 8203 1504
jchirillo@woolacotts.com.au

QUANTITY SURVEYOR
MBM
AUTUMN LU
02 9270 1062
autumn.lu@mbmpl.com.au

PROJECT MANAGER
COLLIERS
ANTHONY MAUGHAN-WRIGHT
0424 189 883
anthony.maughan-wright@colliers.com

Drawing Title
SIGNAGE

Project
NEW PRIMARY SCHOOL IN MULGOA
RISE
at
1-23 Forestwood drive, Glenmore Park, NSW 2745, Australia
for
SINSW

Architect
NBRSARCHITECTURE.
Sydney
61 2 9922 2344
Any form of replication of this drawing in full or in part without the written permission of NBR-S+PARTNERS Pty Ltd constitutes an infringement of the copyright.
Nominated Architect:
Andrew Duffin NSW 5602
NBR-S & Partners Pty Ltd VIC 51197
nbsarchitecture.com
© 2021
ABN 16 002 247 565

Date 6/08/2021 5:24:21 PM
Scale As indicated @ A1

Drawing Reference
20415-NBR-S-DR-A-SSDA-7010
Revision
2

NOTE: THIS DRAWING FEATURES SCHOOL IDENTIFICATION SIGNS ONLY. THESE SIGNS ARE VISIBLE FROM THE NEIGHBOURING STREET AND NEIGHBOURHOOD




PREFINISHED FIBRE CEMENT
SOFFIT LINING



CORRUGATED METAL ROOF
'SHALE GREY'



PREFINISHED METAL CLADDING
'SHALE GREY'

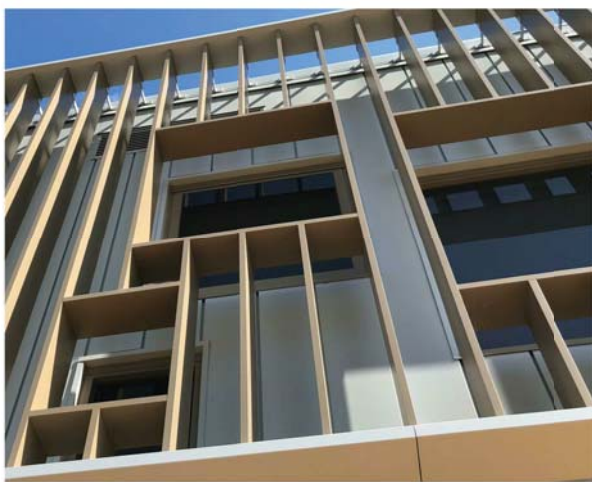

PREFINISHED ALUMINIUM EXTERNAL SHADING



PREFINISHED METAL GUTTER AND
FLASHING COLOUR TO MATCH
DARK GREY OF WALLS



GALVANISED STEEL BALUSTRADE



GALVANISED STEEL COLUMN



ON-GRADE PAVEMENT



PREFINISHED CFC CLADDING
'DARK GREY'



Issue No.	Date	Description	Chkd
1	12/04/2021	ISSUE FOR COORDINATION	
2	23/04/2021	ISSUE FOR COORDINATION	
3	04/05/2021	SSDA ISSUE	
4	06/08/2021	SSDA ISSUE	JL

SSDA ISSUE

RICHARD CROOKES
CONSTRUCTIONS

TRAFFIC ENGINEER
PTC
KASIA BALSAM
02 8920 0800
kasia.balsam@ptccconsultants.co

TOWN PLANNER
RPS
SHALIN SMITH
0425 285 778
shalin.smith@rpsgroup.com.au

MULTI SERVICES
NDV
RYAN HAHN
0407 236 908
r.hahn@ndv.com

CIVIL AND STRUCTURAL ENGINEERING
WOOLACOTTS
JUSTIN CHIRILLO
02 8203 1504
jchirillo@woolacotts.com.au

QUANTITY SURVEYOR
MBM
AUTUMN LU
02 9270 1062
autumn.lu@mbmpl.com.au

PROJECT MANAGER
COLLIERS
ANTHONY MAUGHAN-WRIGHT
0424 189 883
anthony.maughan-wright@colliers.com

Drawing Title
EXTERNAL FINISHES

Project
NEW PRIMARY SCHOOL IN MULGOA
RISE
at
1-23 Forestwood drive, Glenmore Park, NSW 2745, Australia
for
SINSW

Architect
NBRSARCHITECTURE.
Sydney
61 2 9922 2344
Any form of replication of this drawing in full or in part without the written permission of NBR-S PARTNERS Pty Ltd constitutes an infringement of the copyright.
Nominated Architect:
Andrew Duffin NSW 5602
NBR & Partners Pty Ltd VIC 51197
© 2021
ABN 16 002 247 565

Date 6/08/2021 4:31:18 PM
Scale NOT TO SCALE

Drawing Reference

20415-NBR-DR-A-SSDA-8001

Revision

4