


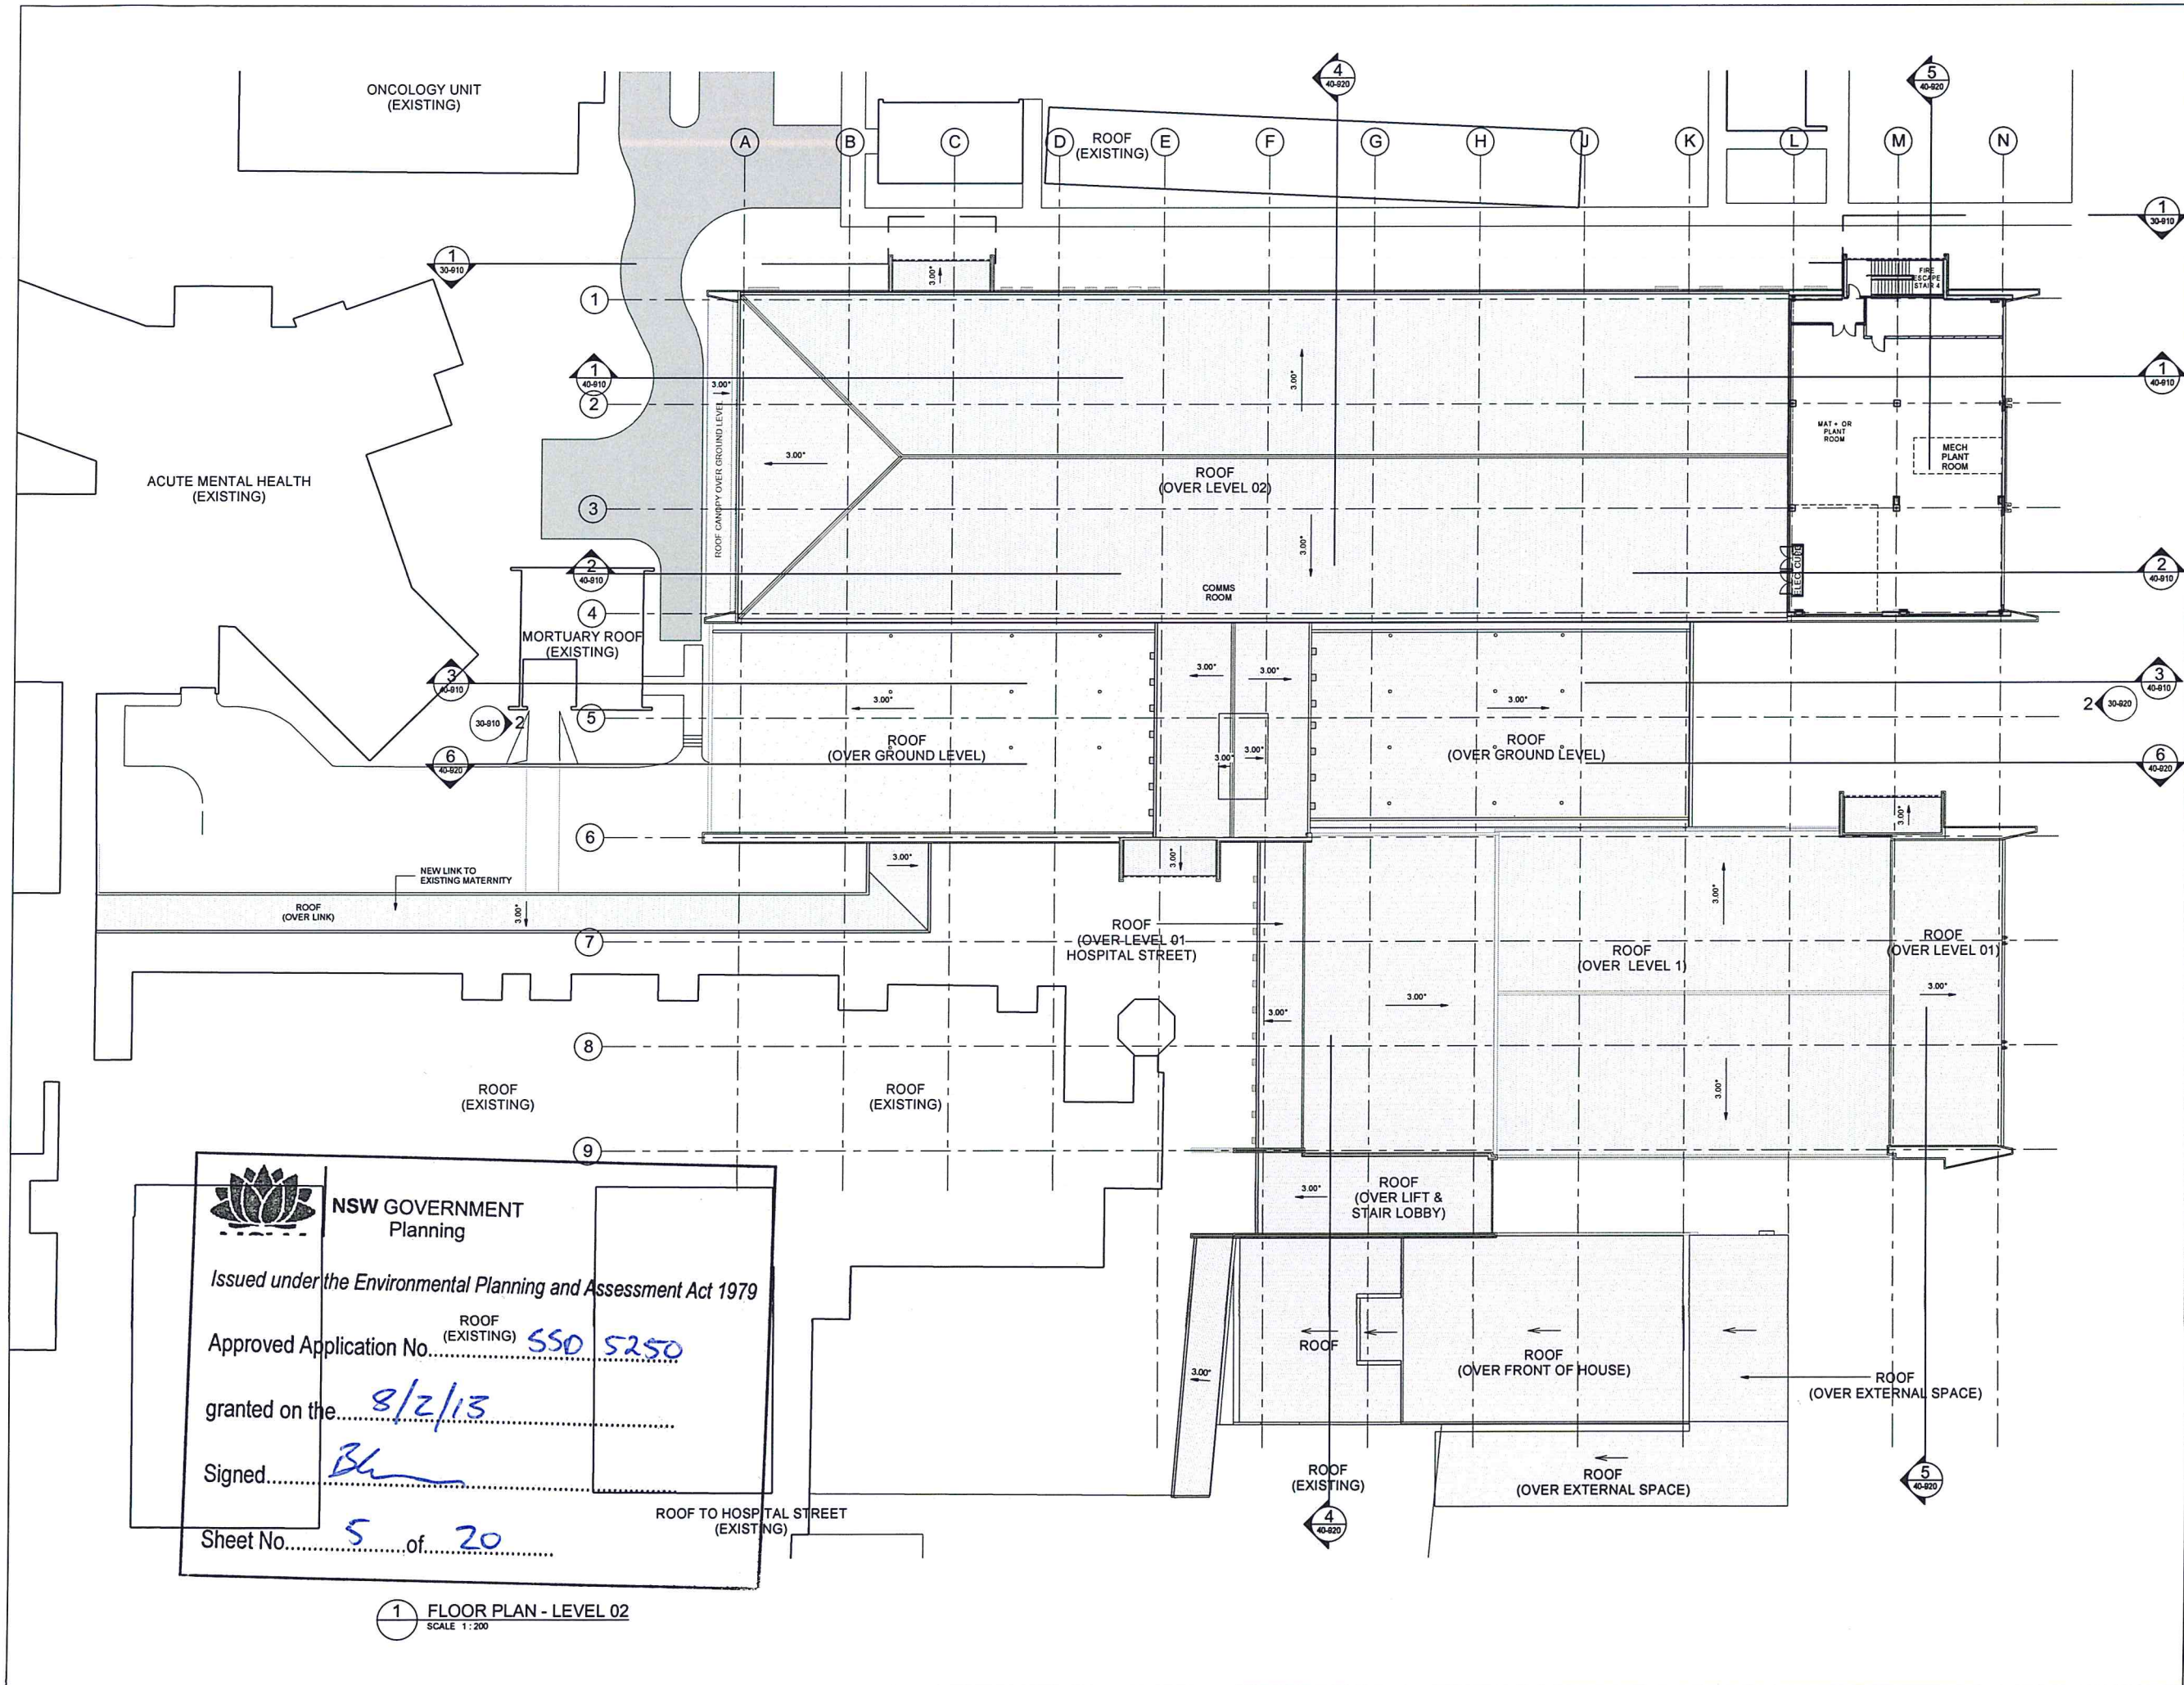

COX ARCHITECTURE PTY LTD
 COPYRIGHT © 2012 COX ARCHITECTURE PTY LTD. ALL RIGHTS RESERVED. THIS DOCUMENT IS THE PROPERTY OF COX ARCHITECTURE PTY LTD. IT IS TO BE USED ONLY FOR THE PROJECT AND SITE SPECIFICALLY IDENTIFIED IN THE TITLE. ANY REUSE OR MODIFICATION OF THIS DOCUMENT WITHOUT THE WRITTEN PERMISSION OF COX ARCHITECTURE PTY LTD CONSTITUTES AN INFRINGEMENT OF COPYRIGHT.

Rev	Description	By	Date
01	FIRST ISSUE - FOR APPROVAL	AB	05/07/2012
02	FOR APPROVAL	AB	24/07/2012
03	FOR APPROVAL	NM	13/08/2012
04	FOR APPROVAL	XL	11/09/2012
05	FOR APPROVAL	SR	05/12/2012

Cox Richardson
 PO Box 193, Sydney NSW 1230
 Level 2, 204 Clarence Street, Sydney NSW 2000 Australia
 T +61 2 9207 5599 F +61 2 9204 5544
 www.coxarchitect.com.au

COX Nominated Architects
 John Richardson no. 2182
 Russell Lee no. 6387

Consultants

PROJECT MANAGEMENT
 NAME: TRA MANAGEMENT
 ADDRESS: LEVEL 16, 331 KENT STREET, NSW 2000
 TEL: 02 9238 8888

STRUCTURAL & CIVIL ENGINEERS
 NAME: ENSTRUCT
 ADDRESS: LEVEL 4, 1 GLEN STREET, MILDURA, NSW 2861
 TEL/FAX: 02 9804 1444 / 02 984 1055

ELECTRICAL & CIVIL ENGINEERS
 NAME: SINCLAIR KNIGHT BERTZ
 ADDRESS: 100 CHRISTIE STREET, SYDNEY, NSW 2001
 TEL/FAX: 02 9252 1200 / 02 9252 1205

MECHANICAL & LIFT ENGINEERS
 NAME: WOOD & GREVE
 ADDRESS: LEVEL 3, 454-456 PACEY HIGHWAY, ST LEONARDS, NSW 2081
 TEL/FAX: 02 9450 7833 / 02 9450 7832

HYDRAULICS & FIRE PROTECTION CONSULTANTS
 NAME: NORTHRUP
 ADDRESS: 80 HICKSON ROAD, NEW 2865
 TEL/FAX: 02 9511 5511 / 02 9511 5522

ACOUSTIC ENGINEERS
 NAME: NORMAN, DIBNEY & YOUNG
 ADDRESS: LEVEL 1, 40 MILLER STREET, NORTH SYDNEY, NSW 2060
 TEL/FAX: 02 9550 8800 / 02 9551 8800

LANDSCAPE DESIGN
 NAME: OCULUS
 ADDRESS: LEVEL 1, 11 WILSON STREET, NEWTOWN, NSW 2042
 TEL/FAX: 02 9571 5333 / 02 9571 5322

TRAFFIC PLANNING
 NAME: CARDMO
 ADDRESS: LEVEL 9, 20 PACEY HIGHWAY, ST LEONARDS, NSW 2081
 TEL/FAX: 02 9252 1200 / 02 9252 1205

NCC & ACCESSIBILITY
 NAME: BCA LOGIC
 ADDRESS: LEVEL 1, 13-15 LACHLAN STREET, CHATSWOOD, NSW 2037
 TEL/FAX: 02 9411 5380 / 02 9411 5420

Client

NSW GOVERNMENT
 Health Infrastructure
 Health Western NSW Local Health District

Project No.
 211097.00



Project
 DUBBO BASE HOSPITAL
 REDEVELOPMENT STAGE 1 & 2
 MYALL STREET, DUBBO NSW 2830

Drawing Title
 FLOOR PLAN - LEVEL 02 (SSD)

Document Control Status:
 FOR APPROVAL

By	Date	Scale	Drawn
Co-ordinated:	NM/ABR	Scale: 1:200 @	Drawn: AS
Project Architect:	MG	Date: 05/12/2012	
Project Director:	JA	Revision: 05	
Drawing Number:	ARC-NB-21-920		

Cox Architecture Pty Ltd ACN 902 100 881

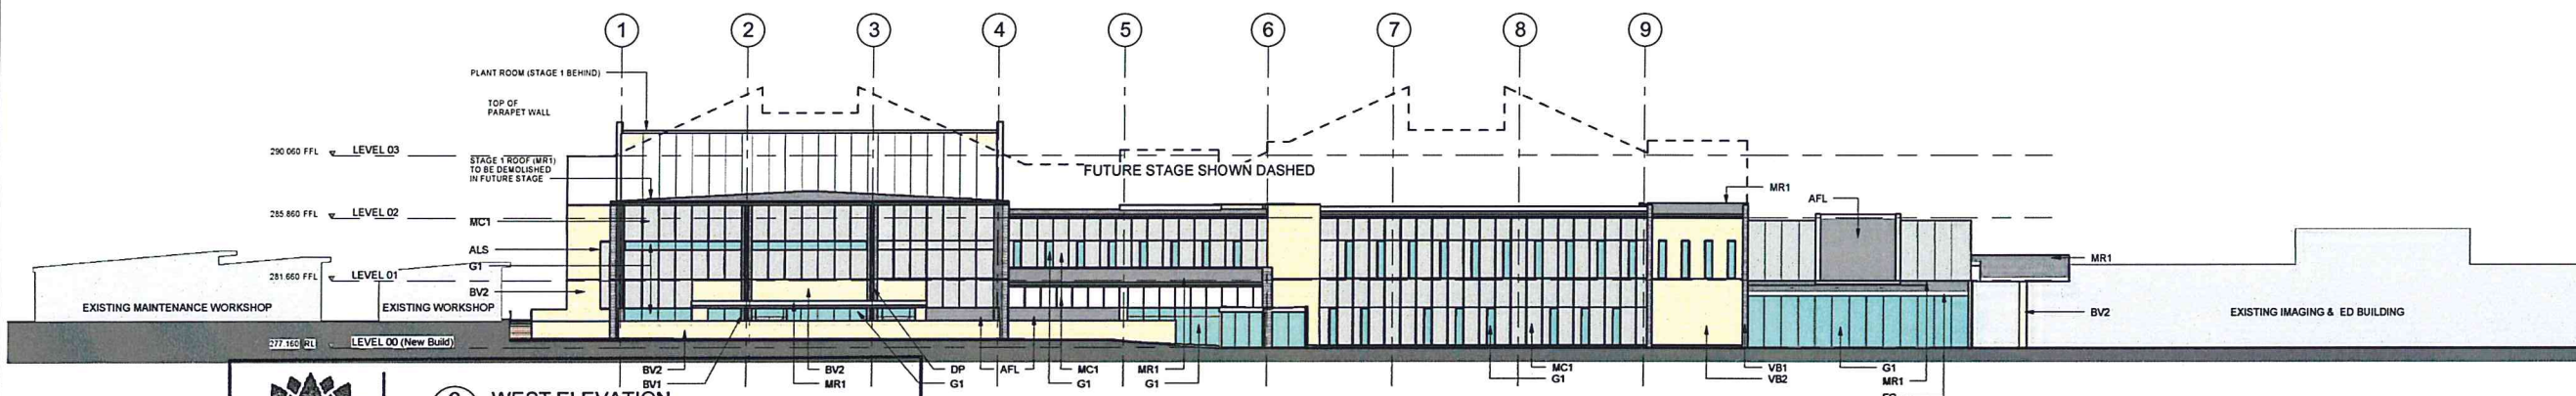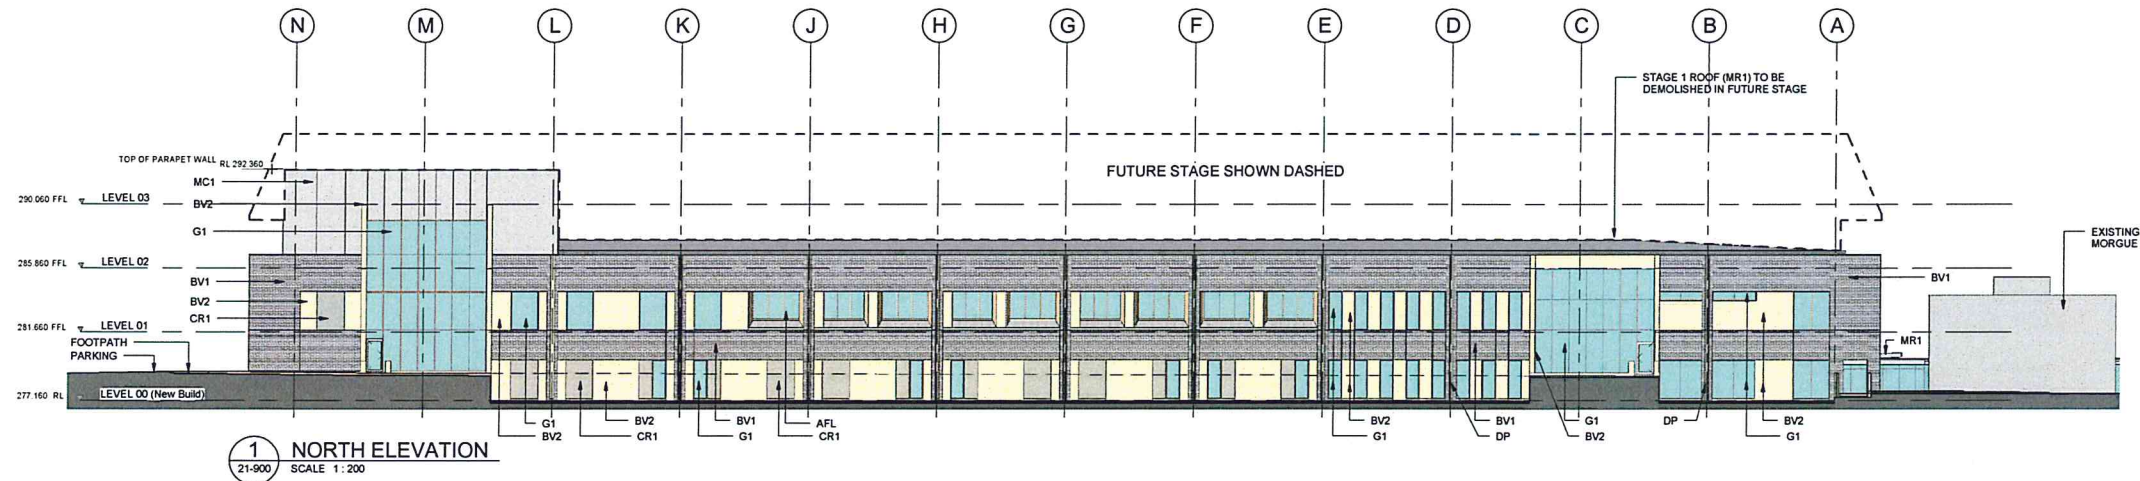

NSW GOVERNMENT
Planning

Issued under the Environmental Planning and Assessment Act 1979

Approved Application No. SSD 5250

granted on the 8/2/13

Signed [Signature]

Sheet No. 7 of 20

- EXTERNAL FINISHES LEGEND:**
- ADS - ALUMINIUM FRAMED AUTOMATIC DOORS AND SIDELIGHTS
 - AFL - ALUMINIUM LOUVRES
 - ALS - ALUMINIUM SUNSHADES
 - BV1 - BRICK VENEER FINISH (TYPE 1)
 - BV2 - BRICK VENEER FINISH (TYPE 2)
 - CG - CORNER GUARDS
 - CPC - COMPOSITE FIBRE CEMENT
 - COF2C - CONCRETE WALL-PAINTED
 - CR1 - CEMENT RENDER FINISH
 - DP - DOWNPIPES
 - FG - FASCIA GUTTER
 - FNC - STEEL FENCE
 - G1 - ALUMINIUM FRAMED GLAZING
 - GCB - ALUMINIUM FRAMED GLAZING-COLOURBACK
 - MF - METAL APRON FLASHING
 - MC1 - METAL CLADDING (TYPE 1)
 - MC2 - METAL CLADDING (TYPE 2)
 - MR1 - METAL ROOF SHEETING
 - MPC - METAL PARAPET CAPPING
 - ST - STEEL STRUTT
 - W - OPERABLE WINDOWS

Rev	Description	By	Date
01	FIRST ISSUE - FOR APPROVAL	SR	05/07/2012
02	FOR APPROVAL	SR	20/07/2012
03	FOR APPROVAL	SR	24/07/2012
04	FOR APPROVAL	SR	25/07/2012
05	FOR APPROVAL	SR	06/08/2012
06	FOR APPROVAL	SR	13/08/2012
07	FOR APPROVAL	XL	11/09/2012

Cox Richardson
PO Box 1123, Sydney NSW 1501
Level 2, 204 Clarence Street, Sydney NSW 2000 Australia
T +61 2 9257 9599 F +61 2 9254 5444
www.coxrichardson.com.au

COX
Nominated Architects
John Richardson no. 3142
Russell Lee no. 4247

Consultants

PROJECT MANAGEMENT
NAME: T&A MANAGEMENT
ADDRESS: LEVEL 11, 227 KENT STREET, NEW 2000
TEL: 02 9257 9599

STRUCTURAL & CIVIL ENGINEERS
NAME: ENSTRUCT
ADDRESS: LEVEL 4, 2 GLEN STREET, MELB. VIC 3001
TEL: 03 9594 1444

ELECTRICAL & ICT ENGINEERS
NAME: SINGLEMAN WRIGHT WEEZ
ADDRESS: 188 CHURCH STREET, ST LEONARDS, NSW 2081
TEL: 02 9375 1300

MECHANICAL & LIFT ENGINEERS
NAME: WOOD & GRIEVE
ADDRESS: LEVEL 3, 254 PACIFIC HIGHWAY, ST LEONARDS, NSW 2081
TEL: 02 9375 1300

HYDRAULICS & FIRE PROTECTION CONSULTANTS
NAME: ROBTROOP
ADDRESS: 88 HICKSON ROAD, NEW 2000
TEL: 02 9375 1300

ACOUSTIC ENGINEERS
NAME: NORMAN, DISNEY & YOUNG
ADDRESS: LEVEL 1, 80 WILSON STREET, NORTH SYDNEY, NSW 2060
TEL: 02 9375 1300

LANDSCAPE DESIGN
NAME: OCULUS
ADDRESS: LEVEL 1/1 WILSON STREET, NEW 2000
TEL: 02 9375 1300

TRAFFIC PLANNING
NAME: CARDO
ADDRESS: LEVEL 8, 254 PACIFIC HIGHWAY, ST LEONARDS, NSW 2081
TEL: 02 9375 1300

NCC & ACCESSIBILITY
NAME: BCA LOGIC
ADDRESS: LEVEL 1, 170 KINGS STREET, CHATSWOOD, NSW 2057
TEL: 02 9375 1300

Client

NSW GOVERNMENT
Health Infrastructure
NSW GOVERNMENT
Health Western NSW
Local Health District

Project No.
211097.00



Project
DUBBO BASE HOSPITAL
REDEVELOPMENT STAGE 1 / 2
MYALL STREET, DUBBO NSW

Drawing Title
ELEVATIONS - NORTH & WEST (SSD)

Document Control Status:
FOR APPROVAL

Drawn: SR	Scale: 1:200 @
Co-ordinated: NJ/ABR	Date: 11/09/2012
Project Architect: MG	Revision: 07
Project Director: JA	North:
Drawing Number:	
ARC-NB-30-910	

Cox Richardson Pty Ltd ACN 802 531 881

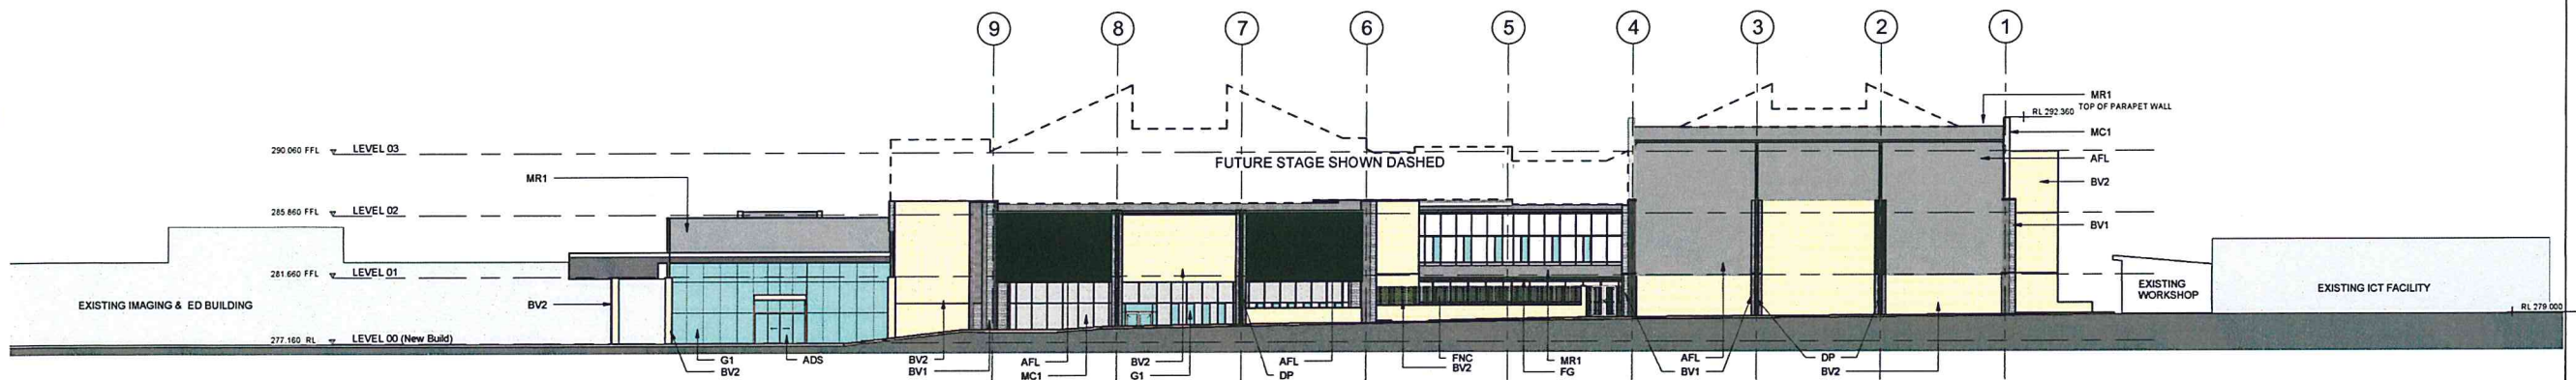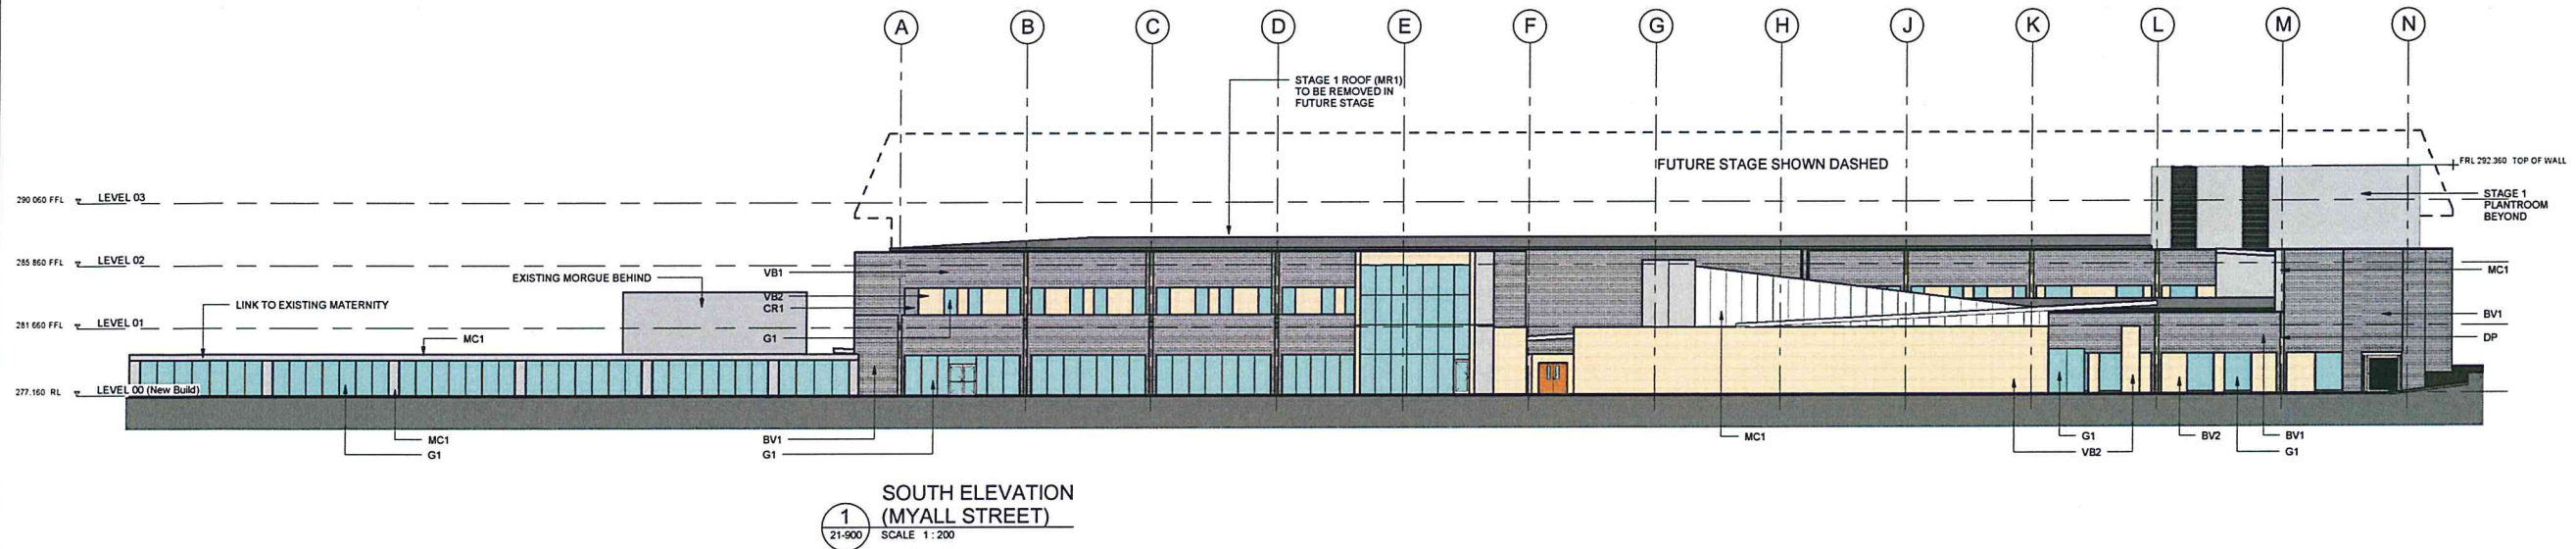

NSW GOVERNMENT
Planning

2 EAST ELEVATION
21-900 SCALE 1:200

Issued under the Environmental Planning and Assessment Act 1979

Approved Application No. SSD 5250

granted on the 8/2/13

Signed Be

Sheet No. 8 of 20

EXTERNAL FINISHES LEGEND:

- ADS - ALUMINIUM FRAMED AUTOMATIC DOORS AND SIDELIGHTS
- AFL - ALUMINIUM LOUVRES
- ALS - ALUMINIUM SUNSHADES
- BV1 - BRICK VENEER FINISH (TYPE 1)
- BV2 - BRICK VENEER FINISH (TYPE 2)
- CG - CORNER GUARDS
- CFC - COMPOSITE FIBRE CEMENT
- COF2C - CONCRETE WALL-PAINTED
- CR1 - CEMENT RENDER FINISH
- DP - DOWNPIPES
- FG - FASCIA GUTTER
- FNC - STEEL FENCE
- G1 - ALUMINIUM FRAMED GLAZING
- GCB - ALUMINIUM FRAMED GLAZING-COLOURBACK
- MF - METAL APRON FLASHING
- MC1 - METAL CLADDING (TYPE 1)
- MC2 - METAL CLADDING (TYPE 2)
- MR1 - METAL ROOF SHEETING
- MPC - METAL PARAPET CAPPING
- ST - STEEL STRUTTY
- W - OPERABLE WINDOWS

Rev	Description	By	Date
01	FIRST ISSUE - FOR APPROVAL	SR	06/07/2012
02	FOR APPROVAL	SR	20/07/2012
03	FOR APPROVAL	SR	24/07/2012
04	FOR APPROVAL	SR	26/07/2012
05	FOR APPROVAL	SR	06/08/2012
06	FOR APPROVAL	SR	13/08/2012
07	FOR APPROVAL	XL	11/09/2012

Cox Richardson
PO Box 9193, Sydney NSW 1500
Level 2, 204 Clarence Street, Sydney NSW 2000 Australia
T +61 2 9207 5599 F +61 2 9204 0244
www.coxarchitects.com.au

COX
Nominated Architects
Joint Return No. 2142
Return No. 6267

Consultants
PROJECT MANAGEMENT NAME: TSA MANAGEMENT ADDRESS: LEVEL 16, 281 KENT STREET, NEW 2000 TEL: 02 9274 1800
STRUCTURAL & CIVIL ENGINEERS NAME: ENSTRUCT ADDRESS: LEVEL 4, 3 GLEN STREET, MULLUM POINT, NSW 2481 TEL/FAX: 02 9944 4441/02 9944 1015
ELECTRICAL & ICT ENGINEERS NAME: SINCLAIR BRIGHT BERZ ADDRESS: 105 CHURCH STREET, SYDNEY NSW 2005 TEL/FAX: 02 9254 1200/02 9254 1205
MECHANICAL & LIFT ENGINEERS NAME: WOOD & GREVE ADDRESS: LEVEL 3, 454-456 PACIFIC HIGHWAY, ST LEONARDS NSW 2085 TEL/FAX: 02 9438 7800/02 9438 7805
HYDRAULICS & FIRE PROTECTION CONSULTANTS NAME: NORTHROP ADDRESS: 80 WOODSON ROAD, NEW 2000 TEL/FAX: 02 9438 7800/02 9438 7805
ACOUSTIC ENGINEERS NAME: NORMAN, DINEY & YOUNG ADDRESS: LEVEL 1, 80 MILLER STREET, NORTH SYDNEY NSW 2060 TEL/FAX: 02 9438 7800/02 9438 7805
LANDSCAPE DESIGN NAME: OCULUS ADDRESS: LEVEL 1/1 WILSON STREET, NEWTOWN NSW 2042 TEL/FAX: 02 9577 6333/02 9577 6333
TRAFFIC PLANNING NAME: CARDNO ADDRESS: LEVEL 8, 201 PACIFIC HIGHWAY, ST LEONARDS NSW 2085 TEL/FAX: 02 9438 7800/02 9438 7805
NCC & ACCESSIBILITY NAME: BCA LOGIC ADDRESS: LEVEL 1, 171-173 KENNER STREET, CHATSWOOD NSW 2037 TEL/FAX: 02 9438 7800/02 9438 7805

Client
NSW Health
Infrastructure
NSW Health
Western NSW
Local Health District

Project No.
211097.00

Project
**DUBBO BASE HOPITAL
REDEVELOPMENT STAGE 1 / 2
MYALL STREET, DUBBO NSW**


Drawing Title
**ELEVATIONS - SOUTH & EAST
(SSD)**

Document Control Status:
FOR APPROVAL

BY DRAWING SHEET	Drawn: SR
Co-ordinated: NM/ABR	Scale: 1:200 @
Project Architect: MG	Date: 11/09/2012
Project Director: JA	Revision: 07
Drawing Number:	North:

ARC-NB-30-920

Cox Architecture Pty Ltd ACN 902 100 981

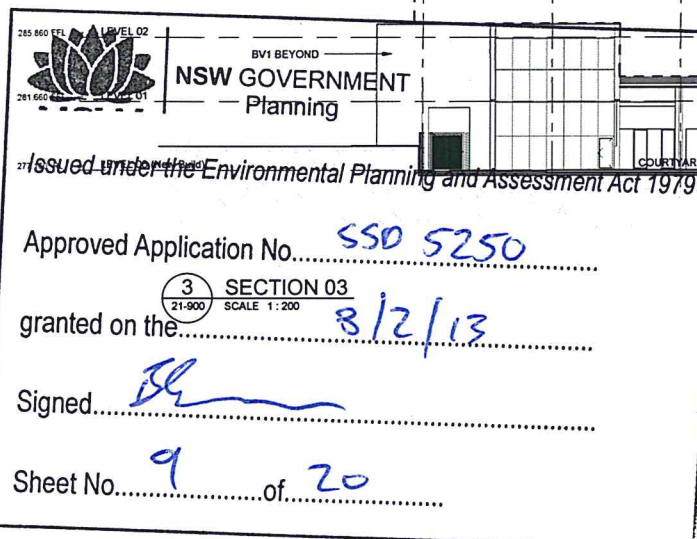

- [illegible]

Cox Richardson
PO Box Q193, Sydney NSW 1230
Level 2, 204 Clarence Street, Sydney NSW 2000 Australia
T + 61 2 9267 9599 F + 61 2 9264 5544
www.coxrichardson.com.au

COX

Nominated Architects
John Richardson no. 316
Russell no. 674

Consultants

PROJECT MANAGEMENT
NAME: TASA MANAGEMENT
ADDRESS: LEVEL 10, 20 WEST STREET, NEW 2000
TEL: 82 6714 1400

STRUCTURAL & CIVIL ENGINEERS
NAME: ENTRUST
ADDRESS: LEVEL 4, 1 GLENVIEW MILSON POINT, NEW 2061
TEL/FAX: 82 8996 1440 / 82 8996 1055

ELECTRICAL & ELECTRONIC ENGINEERS
NAME: SIMICLARK KNIGHT BEEZ
ADDRESS: 100 COWPSTE STREET, WILSONS, NEW 2065
TEL: 82 759 1700 / 82 759 1700

MECHANICAL & LIFT ENGINEERS
NAME: WOOD & CRUICK
ADDRESS: LEVEL 3, 54 STANFORD HIGHWAY ST, LEONARDS, NEW 2065
TEL/FAX: 82 161 100 / 82 161 100

HYDRAULIC & FIRE PROTECTION CONSULTANTS
NAME: NORTHROP
ADDRESS: 80 HUGHES ROAD, NEW 2060
TEL/FAX: 82 5141 1180 / 82 5141 1180

AQUATIC ENGINEERS
NAME: NORMAN, DAVIES & YOUNG
ADDRESS: LEVEL 1, 9 MILLER STREET, NORTH SYDNEY, NEW 2060
TEL/FAX: 82 163 8872 / 82 163 8855

LANDSCAPE DESIGN
NAME: OCULUS
ADDRESS: LEVEL 1, 11 WILSON STREET, NEWTON, NEW 2042
TEL/FAX: 82 8071 5510 / 82 8071 5523

TRAFFIC PLANNING
NAME: CARDNO
ADDRESS: LEVEL 1, 70 STANFORD HIGHWAY, ST LEONARDS, NEW 2065
TEL: 82 897 670 / 82 897 670

MISC & ACCESSIBILITY
NAME: PCA LOGIC
ADDRESS: LEVEL 1, 1-7/3 ACHER STREET, CHATSWOOD, NEW 2057
TEL: 82 897 670 / 82 897 670

Client

 NSW GOVERNMENT	Health Infrastructure
 NSW GOVERNMENT	Health Western NSW Local Health District

Project No. 211097.00

Project
DUBBO BASE HOPITAL
REDEVELOPMENT STAGE 1 / 2
MYALL STREET, DUBBO NSW

Drawing Title

GENERAL SECTIONS 1, 2 & 3
(SSD)

Document Control Status:

FOR APPROVAL

BY DRAWING SHEET	Drawn: SR
Co-ordinated: NM/AB/SR	Scale: 1 : 200 @ B1
Project Architect: MG	Date: 11/09/2012
Project Director: JA	Revision: 05
Drawing Number:	Month:

ARC-NB-40-910



Approved Application No. SSD 5250

granted on the 8/2/13

Signed.....

Sheet No. 10 of 20

PLOT STAMP DATE: 13/09/2012 11:16:43 AM

Cox Richardson
PO Box Q193, Sydney NSW 1230
Level 2, 204 Clarence Street, Sydney NSW 2000 Australia
T + 61 2 9267 9599 F + 61 2 9264 5544
www.coxarchitecture.com.au

COX

Nominated Architects
John Richardson: 31163
Russell Lee: 6367

Consultants

PROJECT MANAGEMENT
NAME: TSA MANAGEMENT
ADDRESS: 16 251 NORTH STREET, NEW YORK 200
TELEPHONE: 87-273-1400

STRUCTURAL & CIVIL ENGINEERS
NAME: ENRUSTECT
ADDRESS: 4 GLEN STREET, WILMINGTON, NEW YORK 201
TELEPHONE: 87-843-1100

ELECTRICAL & ELECTRICAL ENGINEERS
NAME: SINCLAIR KNIGHT BREE
ADDRESS: 180 CROFT STREET, ST. LEONARDS, NEW YORK 205
TELEPHONE: 87-898-2100 / 87-203-7000

MECHANICAL & ELEVATORS ENGINEERS
NAME: WOOD & GREVE
ADDRESS: 15 HANNAH STREET, ST. LEONARDS, NEW YORK 205
TELEPHONE: 87-100-7570 / 87-200-1000

HOROLOGICAL & FIRE PROTECTION CONTACTS
NAME: HORN & THORP
ADDRESS: 82 HICKSON ROAD, NEW YORK 200
TELEPHONE: 87-419-1811 / 87-531-1326

ACOUSTIC ENGINEERS
NAME: NORRAN, DISNEY & YOUNG
ADDRESS: 15 E. WALLER STREET, NORTH SYDNEY, NEW YORK 204
TELEPHONE: 87-880-6800 / 87-185-8000

LANDSCAPE DESIGN
NAME: OCULUS
ADDRESS: 1 E. WILSON STREET, NEWTOWN, NEW YORK 204
TELEPHONE: 87-837-5555 / 87-186-0200

TRAFFIC PLANNING
NAME: CARINO
ADDRESS: 5-25 PARKWAY, ST. LEONARDS, NEW YORK 205
TELEPHONE: 87-844-7771 / 87-319-1700

RACE & ACCESSIBILITY
NAME: RAC LOGIC



Project No. 211097.00

Project
DUBBO BASE HOPITAL
REDEVELOPMENT STAGE 1 / 2
MYALL STREET, DUBBO NSW

Drawing Title

GENERAL SECTION 4, 5 & 6
(SSD)

Document Control Status:
FOR APPROVAL


B1 DRAWING SHEET	Drawn: SR
Co-ordinated: NM/AB/SR	Scale: 1 : 200 @ B1
Project Architect: MG	Date: 11/09/2012
Project Director: JA	Revision: 05

Drawing Number:	North:
ARC-NB-40-920	

Cox Architecture Pty Ltd ACN 002 531 883

EXTERNAL FINISHES LEGEND:

- | | |
|-------|---|
| ADS | ALUMINIUM FRAMED AUTOMATIC DOORS AND SIDELIGHTS |
| ALF | ALUMINIUM LOUVRES |
| ALS | ALUMINIUM SUNSHADES |
| BV1 | BRICK VENEER FINISH (TYPE 1) |
| BV2 | BRICK VENEER FINISH (TYPE 2) |
| CG | CORNER GUARDS |
| CFC | COMPOSITE FIBRE CEMENT |
| COF2C | CONCRETE WALL-PAINTED |
| R1 | CEMENT RENDER FINISH |
| DP | DOWNPIPES |
| FG | FASCIA GUTTER |
| FNC | STEEL FENCE |
| G1 | ALUMINIUM FRAMED GLAZING |
| GCB | ALUMINIUM FRAMED GLAZING-COLOURBACK |
| MF | METAL APRON FLASHING |
| MC1 | METAL CLADDING (TYPE 1) |
| MC2 | METAL CLADDING (TYPE 2) |
| MR1 | METAL ROOF SHEETING |
| MPC | METAL PARAPET CAPPING |
| ST | STEEL STRUTT |
| W | OPERABLE WINDOWS |

 


Issued under the Environmental Planning and Assessment Act 1979

Approved Application No. SSD 5250

granted on the 8/2/13

Signed Bl

Sheet No. 11 of 20

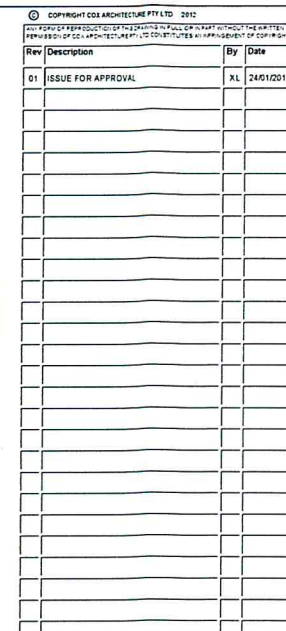

Cox Richardson
PO Box Q193, Sydney NSW 1230
Level 2, 204 Clarence Street, Sydney NSW 2000 Australia
T + 61 2 9267 9599 F + 61 2 9264 5344
www.coxarchitect.com.au

COX

Nominated Architects
John Richardson no 3162
Russell Lee no 6367

ConsulTants

PROJECT MANAGEMENT
NAME: TSA MANAGEMENT
ADDRESS: LEVEL 19, 237 NORTH STREET, NEW 2000
TELEFAX: 8727457400

STRUCTURAL & CIVIL ENGINEERS
NAME: ENCEB TRUST
ADDRESS: LEVEL 4, 2/26N STERILIMON POINT, NEW 2061
TELEFAX: 8727457400

ELECTRICAL & ENGINEERS
NAME: ERIC LAR KRIGHT B&B
ADDRESS: 105 COWLEY STREET, NEWCASTLE, NSW 2061
TELEFAX: 8727457400

MECHANICAL & LIFT ENGINEERS
NAME: WOOD & GRIVIE
ADDRESS: 3/15-16N FUCHSBURG HIGHWAY 5 STREET, NEW 2065
TELEFAX: 8727457400

CONCRETE & PROTECTION CONTRACTORS
NAME: NORTHPRO
ADDRESS: 48/49KORRO ROAD, NEW 2061
TELEFAX: 8727457400

AQUATIC ENGINEERS
NAME: NORMAN, DIBNEY & YOUNG
ADDRESS: LEVEL 8, 8/ MILLERS STREET NORTH SYDNEY, NEW 2060
TELEFAX: 8727457400

LANDSCAPE DESIGN
NAME: OCULUS
ADDRESS: LEVEL 1/15 MILLS STREET, NEW TOWN, NSW 2042
TELEFAX: 8727457400

PLUMBING PLANNING
NAME: CARBONO
ADDRESS: LEVEL 2, 732 PACIFIC HIGHWAY, STEELDONADE, NEW 2061
TELEFAX: 8727457400

NCC & ACCESSIBILITY
NAME: RACA LOGIC
ADDRESS: LEVEL 1/1-3/24N ARCADE STREET, CHATSWOOD, NSW 2037
TELEFAX: 8727457400

Client

NSW
GOVERNMENT
Health
Infrastructure

NSW
GOVERNMENT
Health
Western NSW
Local Health District

Project No. 211097.10

Project
DUBBO BASE HOPITAL
REDEVELOPMENT STAGE 1 & 2
MYALL STREET, DUBBO NSW

Drawing Title
EXTENDED FRONT OF
HOUSE DEMOLITION PLAN

Document Control Status:


APPROVAL

B1 DRAWING SHEET		Drawn: XL
Co-ordinated:	NM/AB/SR	Scale: 1 : 100 @
Project Architect:	MG 	B1 Date: XX
Project Director:	JA 	Revision: 01

Drawing Number: **ARC-FH-15-900**

North: 

 Cox Architecture Pty Ltd ACN 002 535 961



Issued under the Environmental Planning and Assessment Act 1979

Approved Application No. SSD 5250

granted on the 8/2/13

Signed. Blm



Sheet No. 12 of 20

Gas: Acetylene (B) 1 M A/CN 507 535 884



Sheet No. 15 of 20

PLOT STAMP DATE: 24/01/2013 4:55:36 PM

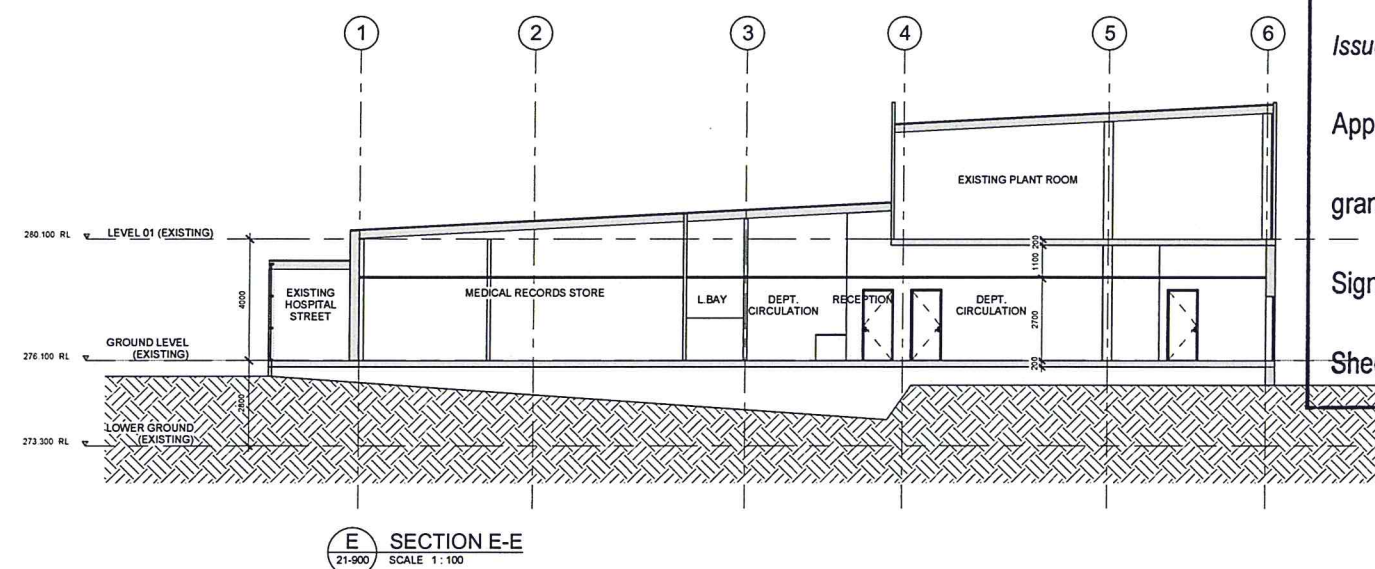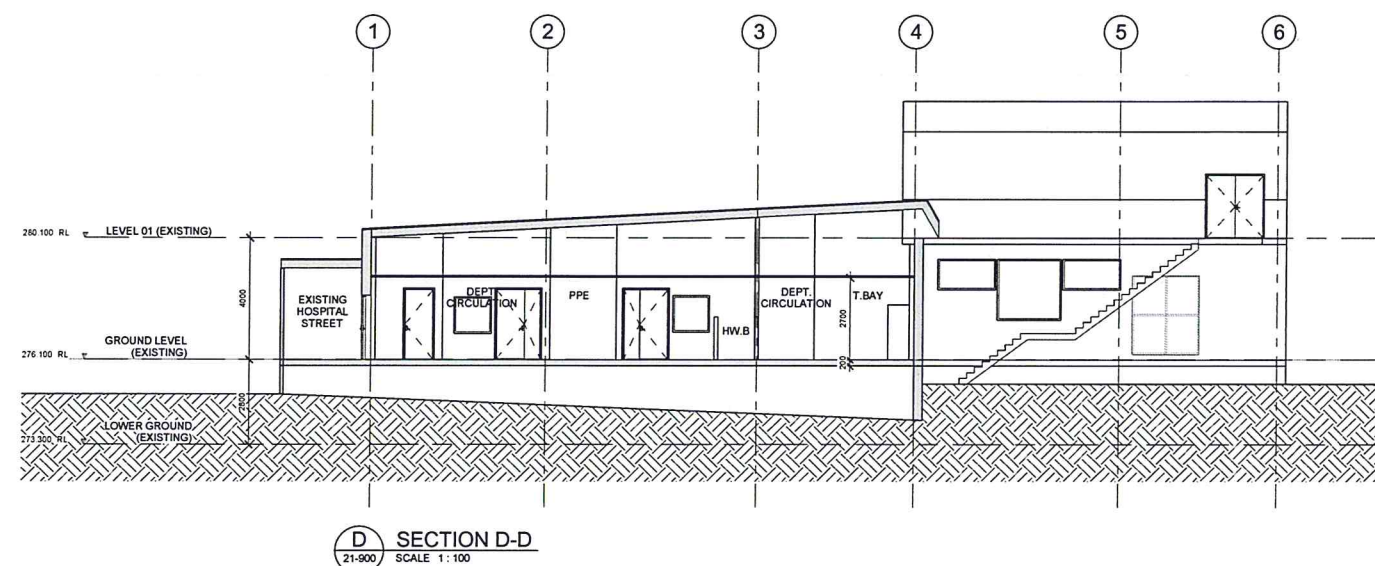NSW GOVERNMENT
Planning

Issued under the Environmental Planning and Assessment Act 1979

Approved Application No. SSD 5256

granted on the 8/2/13

Signed B9

Sheet No. 18 of 20

[illegible]

Cox Richardson
PO Box Q193, Sydney NSW 1230
Level 2, 204 Clarence Street, Sydney NSW 2000 Australia
T + 61 2 9267 9599 F + 61 2 9264 5844

COX

Nominated Architects
John Richardson no. 3162
RustieEllen no. 6361

Consultants

PROJECT MANAGEMENT
NAME: TSA MANAGEMENT
ADDRESS: 10 N 30 WEST STREET, NEW YORK
TEL: 82 8736 1426

STRUCTURAL CIVIL ENGINEERS
NAME: ENR STRUCT
ADDRESS: LEVEL 4, 2 ELM STREET, WILSON POINT, NEW YORK
TEL: 82 8086 1441

ELECTRICAL CIVIL ENGINEERS
NAME: ENR CLASH RIGHT BEEZ
ADDRESS: 105 CHATEAU STREET, ILLIONDALE, NEW YORK
TEL: 82 8086 1441

MECHANICAL CIVIL ENGINEERS
NAME: WOOD & CRIVIE
ADDRESS: LEVEL 3, 400 WEST 60TH HIGHWAY #7 & LEONARDS, NEW YORK
TEL: 82 7616 1031

HYDRAULICS & FIVE PROTECTION CONSULTANTS
NAME: HORTCHUP
ADDRESS: 80 HUNTERS ROAD, NEW YORK
TEL: 82 7616 1031

AQUATIC ENGINEERS
NAME: HORTCHUP, DARRMAN, DARRMAN & YOUNG
ADDRESS: LEVEL 1, 9 MILLER STREET, NORTH YONK, NEW YORK
TEL: 82 7616 1031

LANDSCAPE DESIGN
NAME: OCULUS
ADDRESS: LEVEL 1, 11 WILSON STREET, NEWTON, NEW YORK
TEL: 82 7616 1031

TRAFFIC PLANNING
NAME: CARDNO
ADDRESS: LEVEL 9, 20 PACIFIC HIGHWAY, NEW YORK
TEL: 82 7616 1031

NCC ACCESSIBILITY
NAME: RICA LOGIC
ADDRESS: LEVEL 1, 1172 MADISON STREET, CHATTAHOOC, NEW YORK
TEL: 82 7616 1031

Client	 NSW GOVERNMENT	Health Infrastructure
	 NSW GOVERNMENT	Health Western NSW Local Health District

Project No. 211097.00

Project
DUBBO BASE HOSPITAL
REDEVELOPMENT STAGE 1 & 2
MYALL STREET, DUBBO NSW 2830

Drawing Title

SECTIONS D-D & E-E (SSD)

Document Control Status: **APPROVAL**

BY DRAWING SHEET	Drawn: XL
Co-ordinated: MG	Scale: 1:100 @ B1
Project Architect: MG	Date: 24/01/2013
Project Director: JA	Revision: 01

Drawing Number: **ARC-RD-40-902**

North: 

Ces Architectes Pte Ltd ACH 202 535 881

