



STORMWATER DRAINAGE LAYOUT SHOWN IS CONCEPTUAL AND FOR DA PURPOSES ONLY

STORMWATER NOTE:  
HAY-LACKEY CULVERT ALIGNMENT BASED ON AVAILABLE DATA. LOCATION TO BE CONFIRMED

- PAVEMENT NOTES
1. REFER SITE CLEARANCE & DEMOLITION PLANS FOR REMOVAL OF EXISTING KERB & TRAFFIC ISLANDS
  2. RESURFACING AND OVERLAY PAVEMENTS ARE SUBJECT TO DETAILED SITE INVESTIGATION TO DETERMINE WHETHER THE EXISTING PAVEMENT AND FORMATION IS SUITABLE FOR REUSE/OVERLAY CONSIDERING THE DESIGN ESA EXPECTED. IN THE EVENT THAT THE EXISTING PAVEMENT IS NOT SUITABLE FOR REUSE/OVERLAY IT SHALL BE REMOVED AND REPLACED WITH NEW FULL DEPTH PAVEMENT.
  3. ALL PAVEMENTS SUBJECT TO DESIGN BY QUALIFIED GEOTECHNICAL ENGINEER.

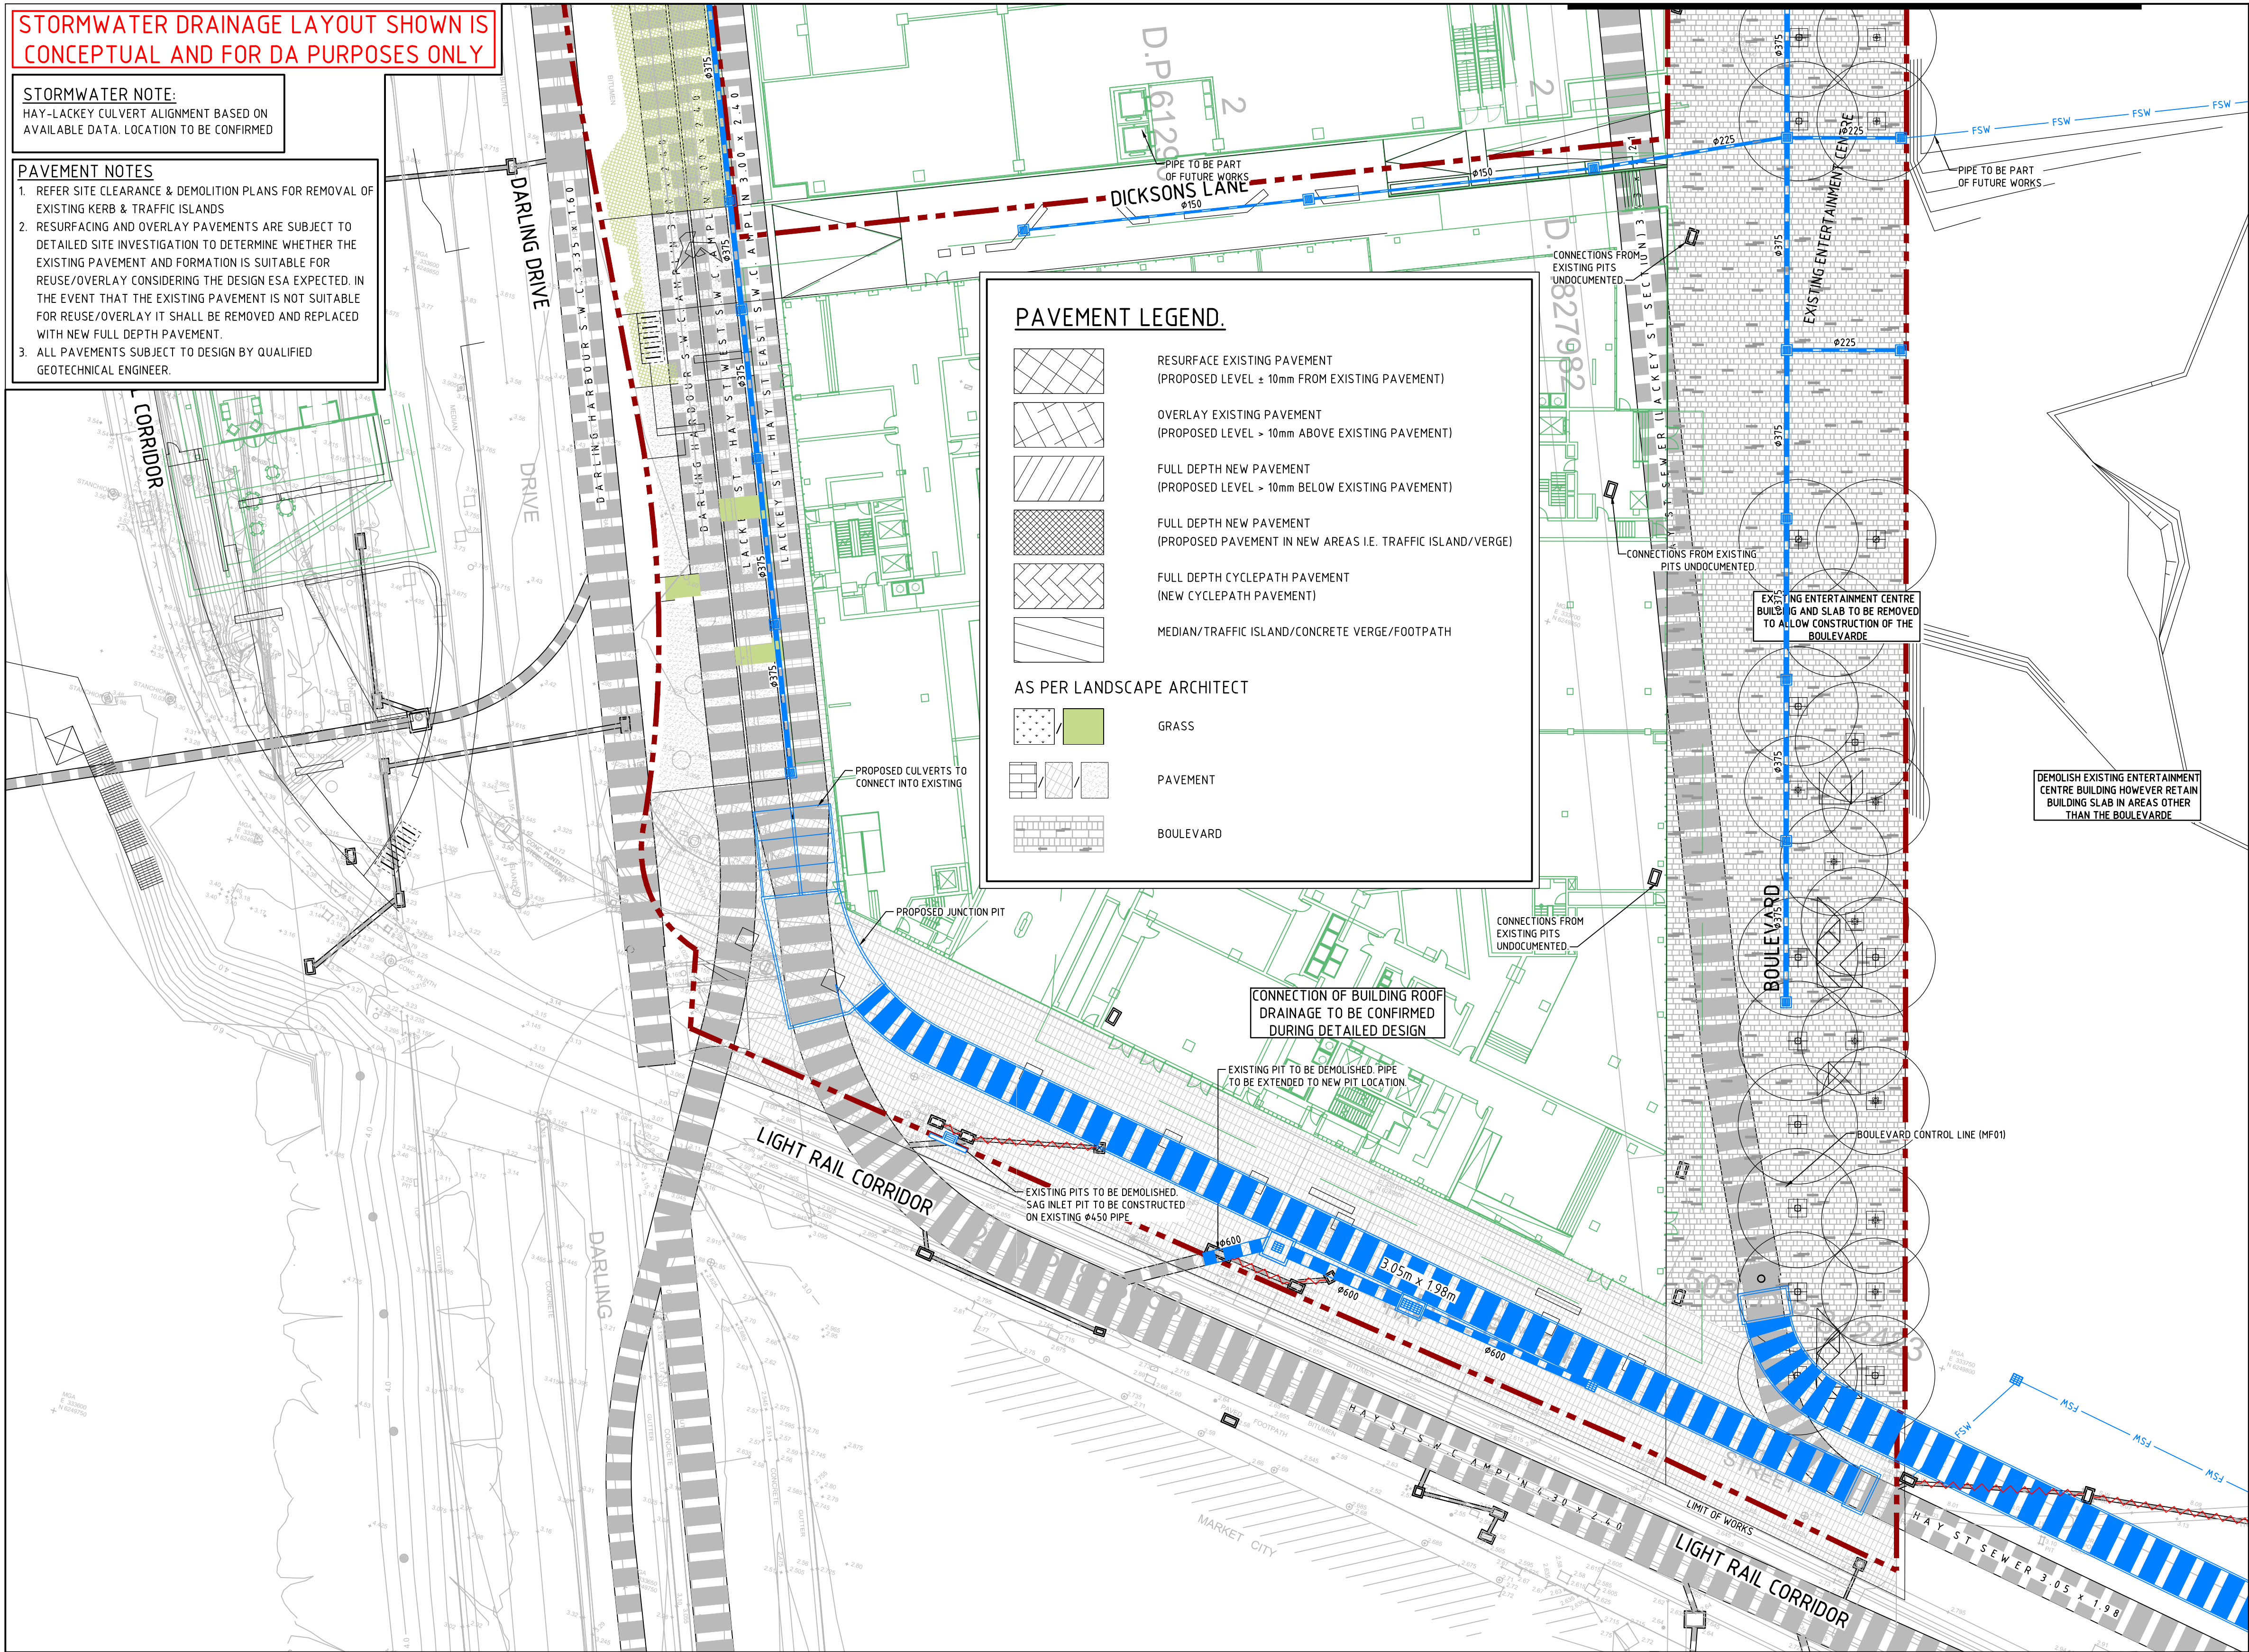


REFER TO MAIN PLAN FOR CONTINUATION  
**INSET A**  
1: 300

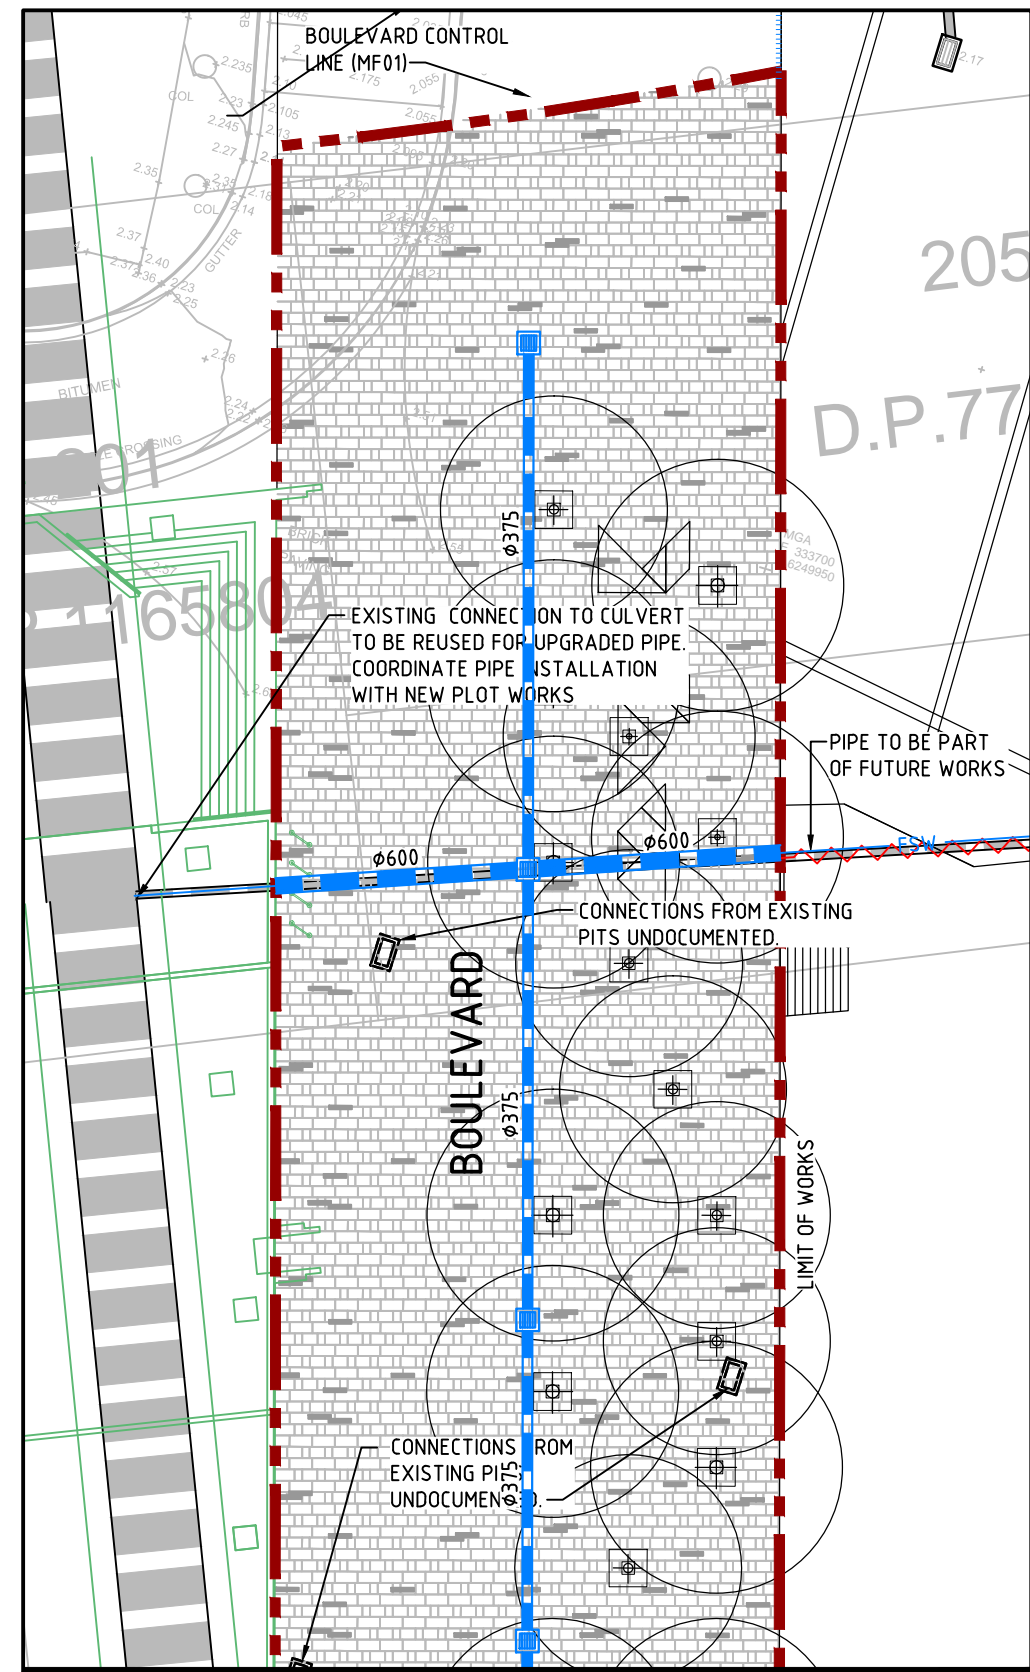

REFER TO MAIN PLAN FOR CONTINUATION  
**INSET B**  
1: 300


DARLING HARBOUR LIVE

REFERENCE MAP

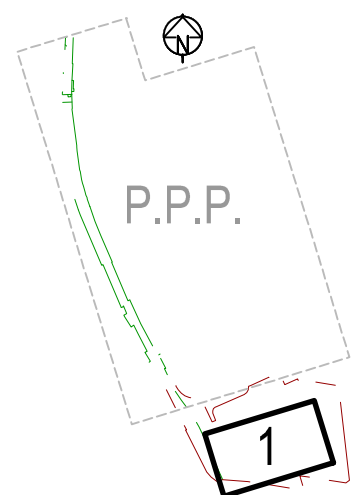

NOTES:

1. DO NOT SCALE FROM DRAWINGS. WORK TO WRITTEN DIMENSIONS ONLY.
2. ALL DIMENSIONS IN METRES UNLESS NOTED OTHERWISE.
3. ALL COORDINATES TO MGA. ALL LEVELS TO AHD.
4. ALL DIMENSIONS, COORDINATES AND LEVELS TO BE VERIFIED ON SITE BEFORE PROCEEDING WITH WORK. HYDER SHALL BE NOTIFIED IN WRITING OF ANY DISCREPANCIES.
5. THIS DRAWING MUST BE READ IN CONJUNCTION WITH ALL RELEVANT CONTRACTS, SPECIFICATIONS AND DRAWINGS.

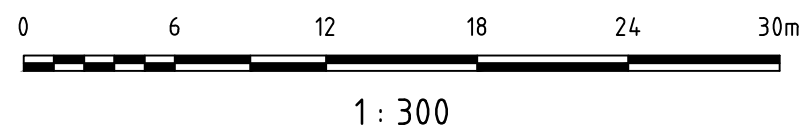

REV	DESCRIPTION	DATE
05	AMENDED AS PER CLIENT REQUEST	18/02/2014
04	ISSUE FOR DA	28/05/2013
03	DRAFT ISSUE	01/05/2013
02	DRAFT ISSUE	24/04/2013
01	DRAFT ISSUE	12/04/2013

CLIENT

**Lend Lease** LEND LEASE BUILDING PTY. LTD.  
LEVEL 4, THE BOND, 30 HICKSON RD  
MILLERS POINT, NSW 2000

CONSULTANTS

**HASSELL + POPULOUS** LANDSCAPE ARCHITECT  
LEVEL 2, 88 CLUMBERLAND STREET,  
SYDNEY NSW 2000

**DENTON CORKER MARSHALL** ARCHITECT  
49 EXHIBITION STREET,  
MELBOURNE VICTORIA 3000

CIVIL / TRAFFIC / FACADES

**HYDER CONSULTING PTY LTD**  
ABN 76 104 485 289  
LEVEL 5, 141 WALKER ST,  
NORTH SYDNEY NSW 2060  
AUSTRALIA

Tel: +61 (0)2 8907 9000  
Fax: +61 (0)2 8907 9001  
www.hyderconsulting.com  
© Copyright reserved

PROJECT

**SICEEP - DARLING HARBOUR  
HAYMARKET (PDA)  
SOUTH WEST PLOT**

DRAWING TITLE


**CIVIL WORKS AND  
STORMWATER PLAN**

STATUS


**PRELIMINARY ONLY**

SCALE @ A1	DRAWN	DESIGNED	REVIEWED	APPROVED
1: 300	RD	RR		
PROJECT NUMBER	DRAWING NUMBER	REV		
AA004399	PD-CI-3301	05		




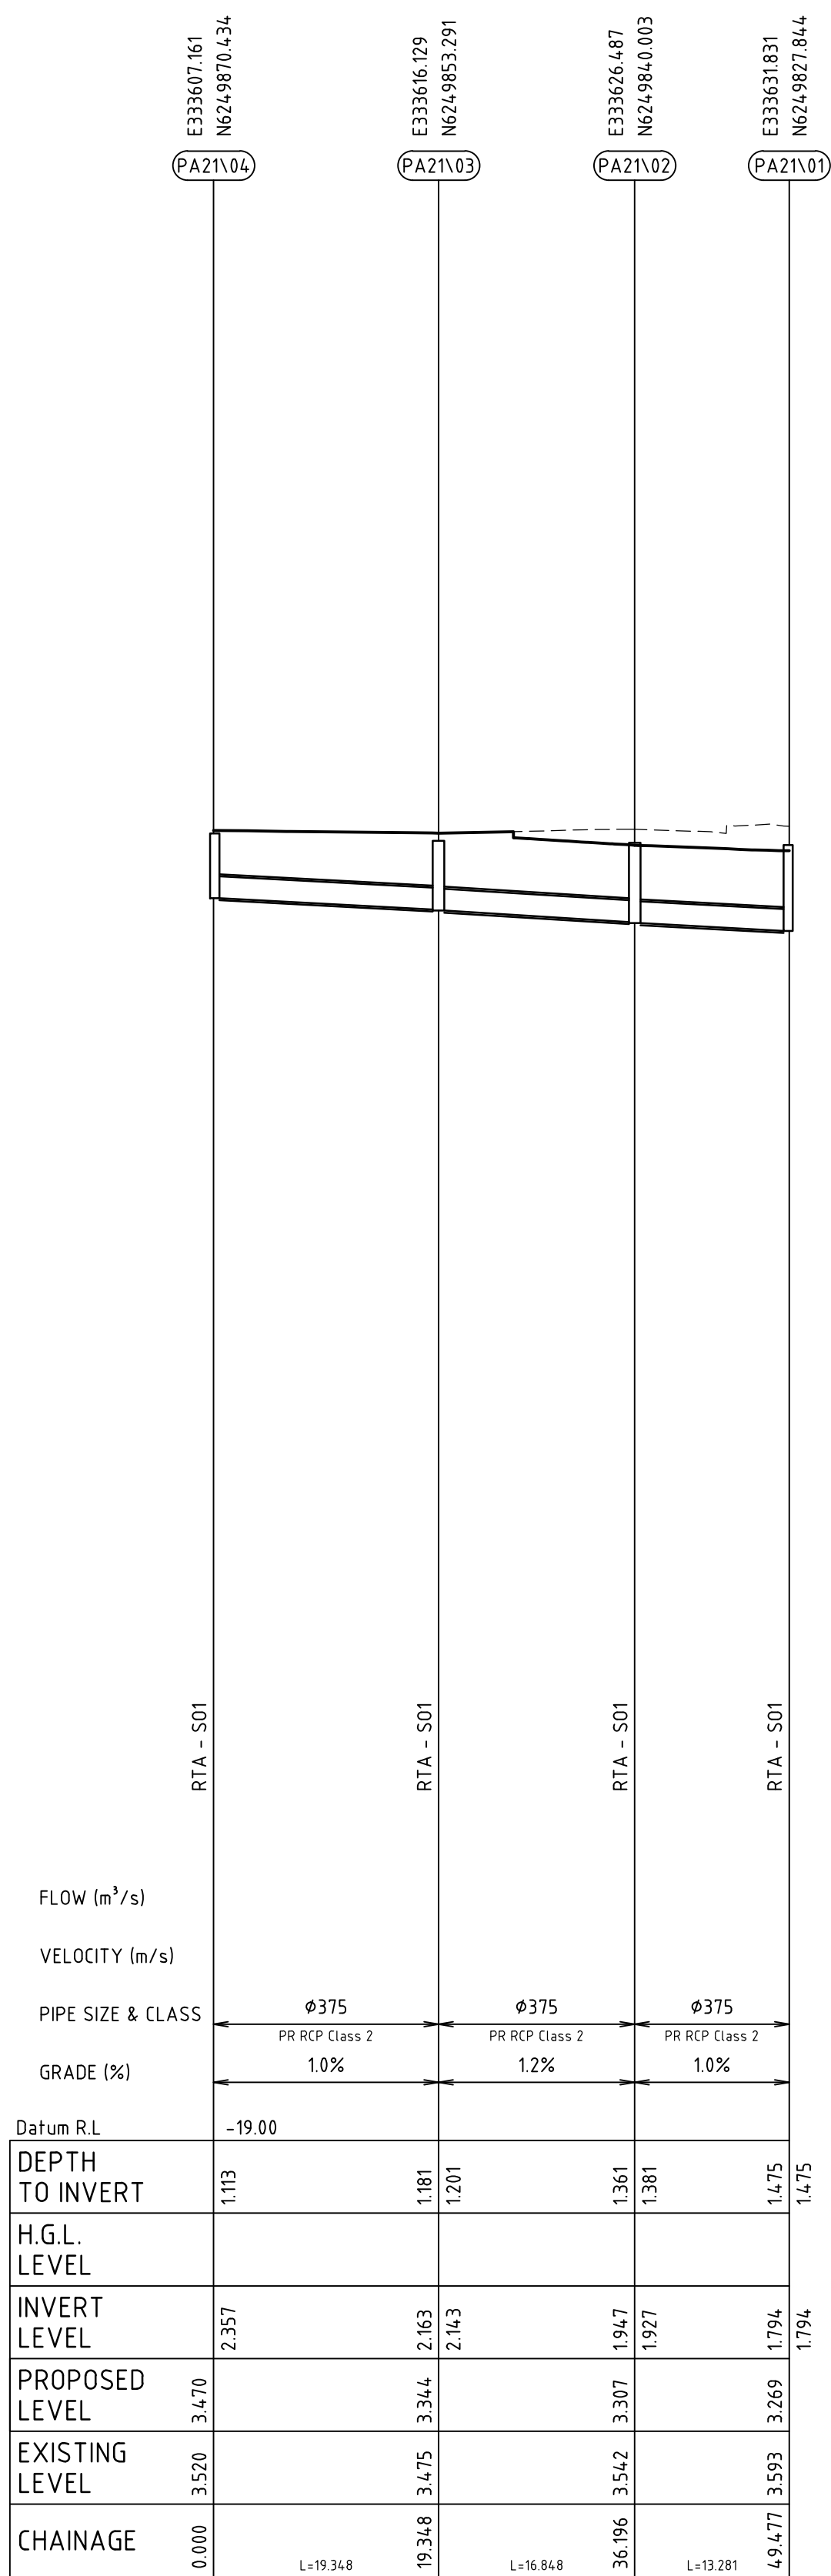


LINE PA21

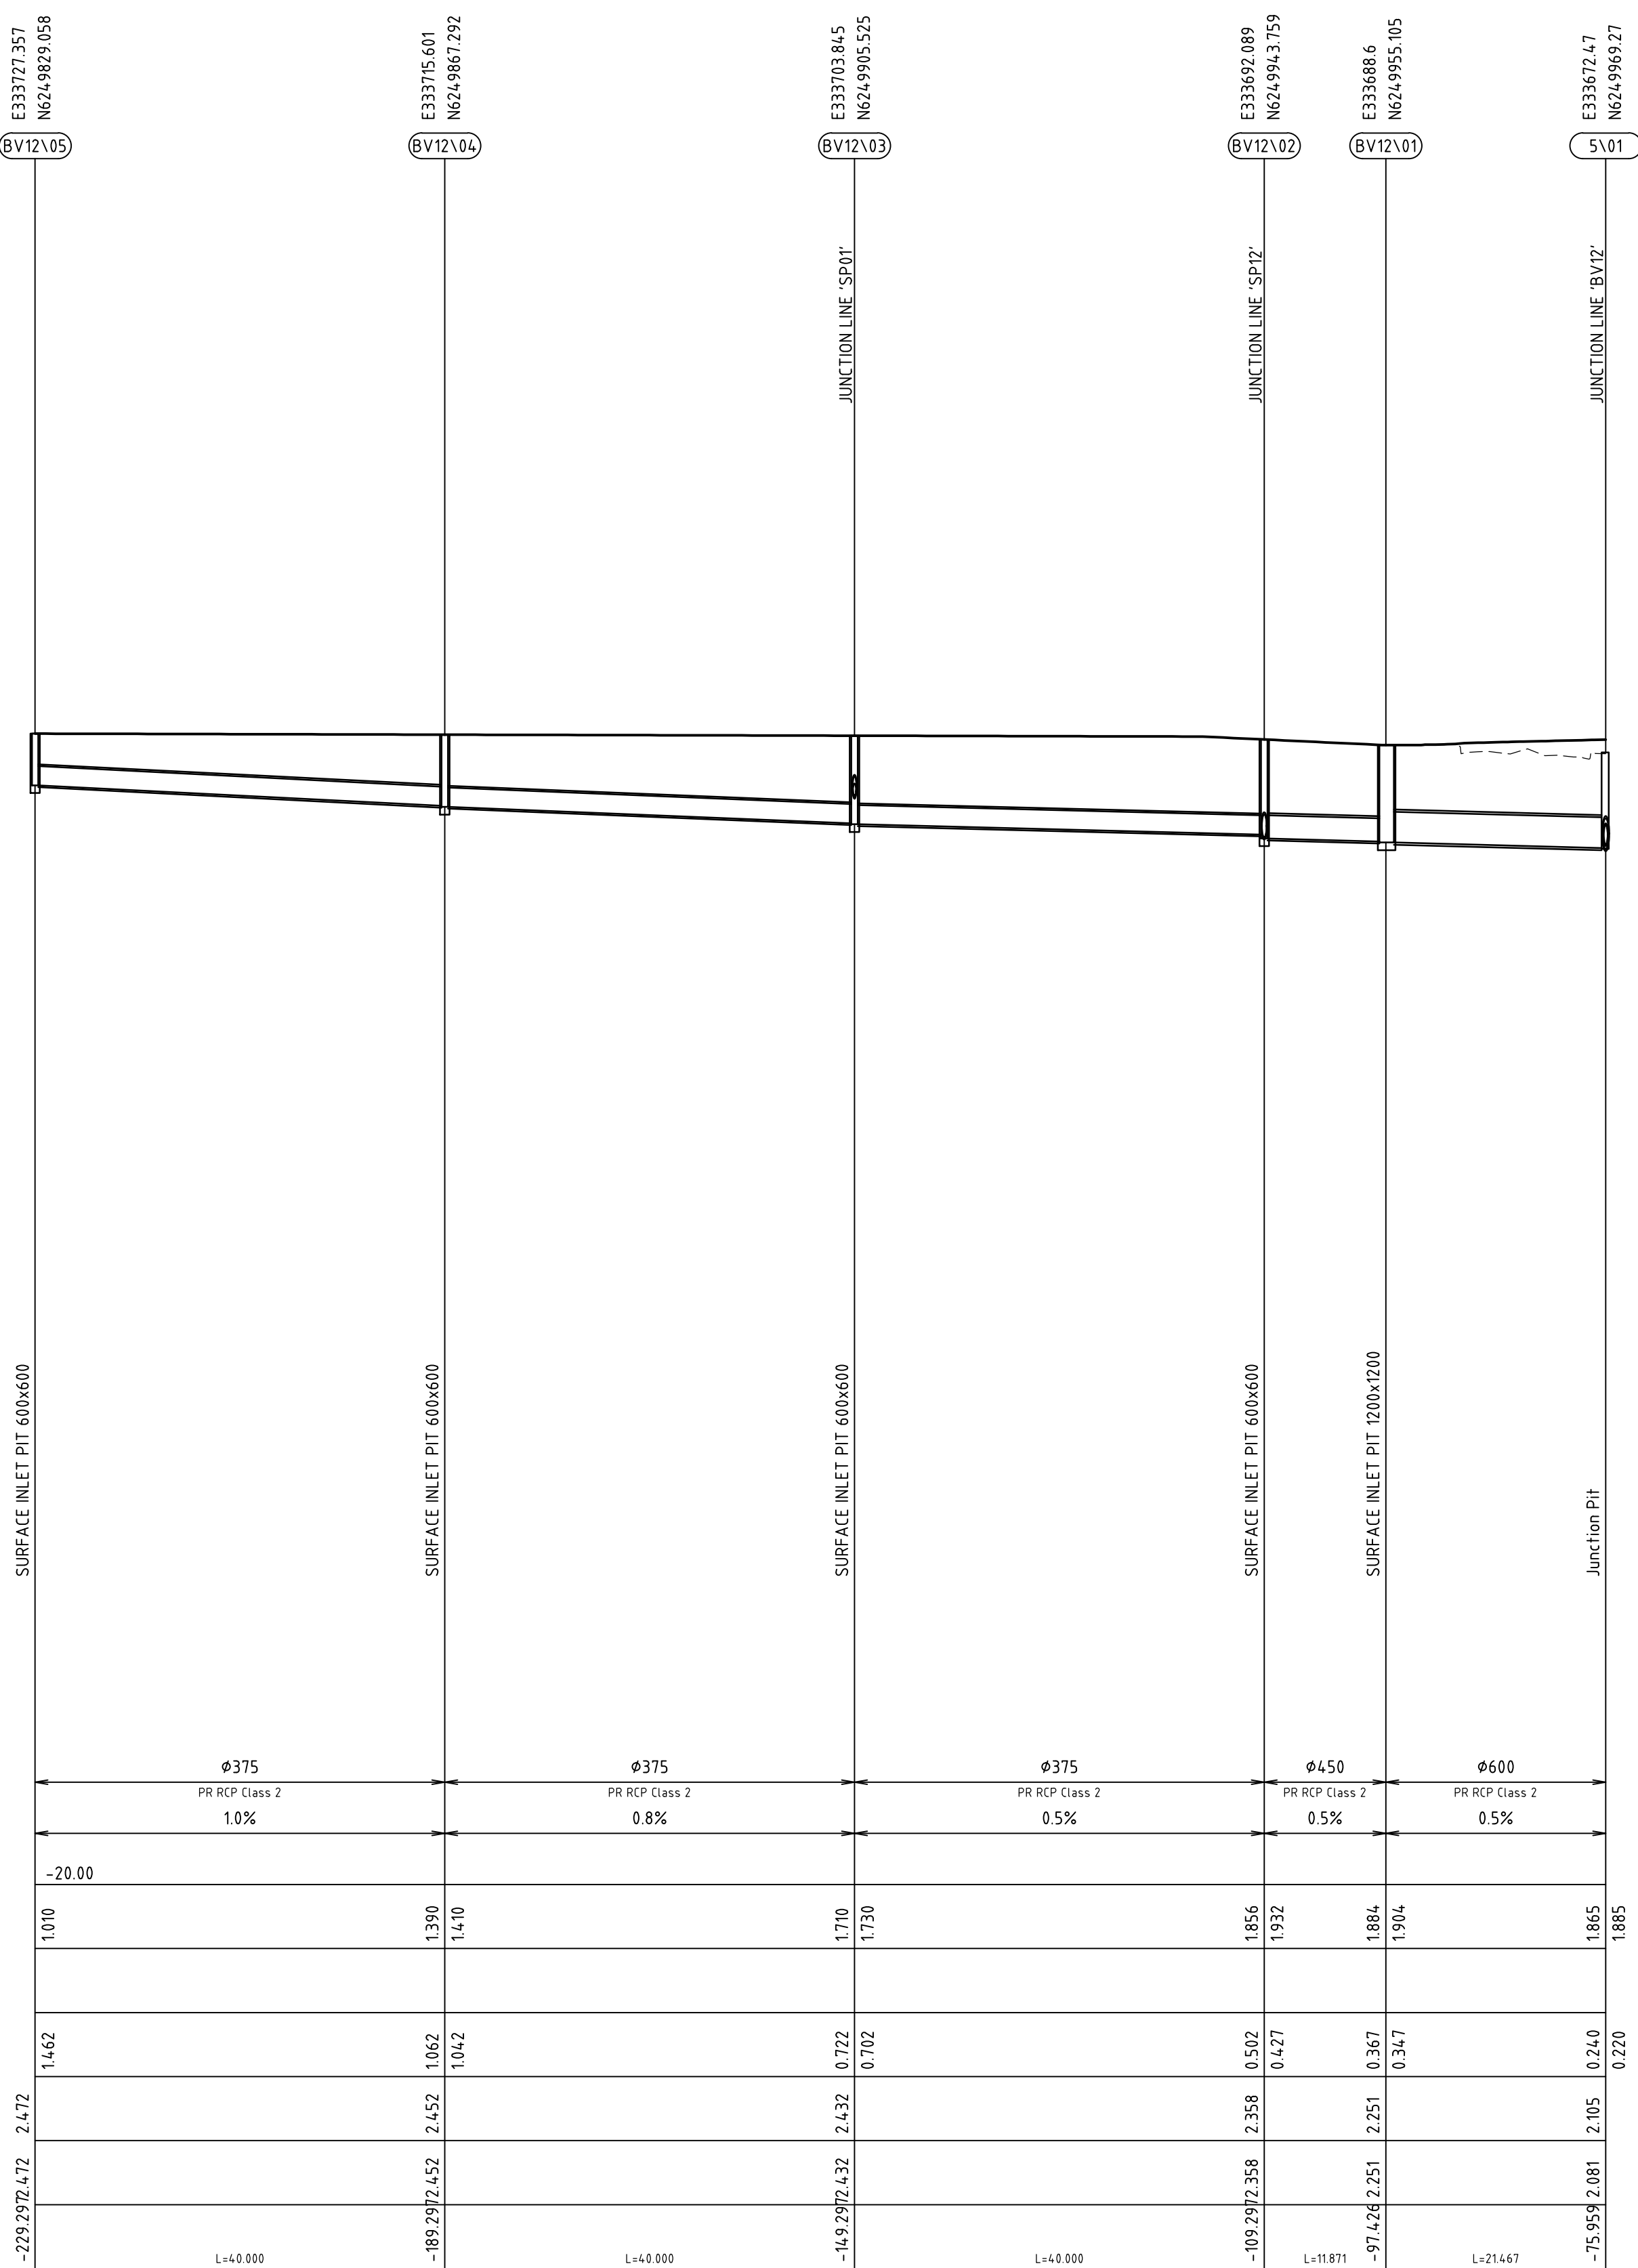

LINE BV12

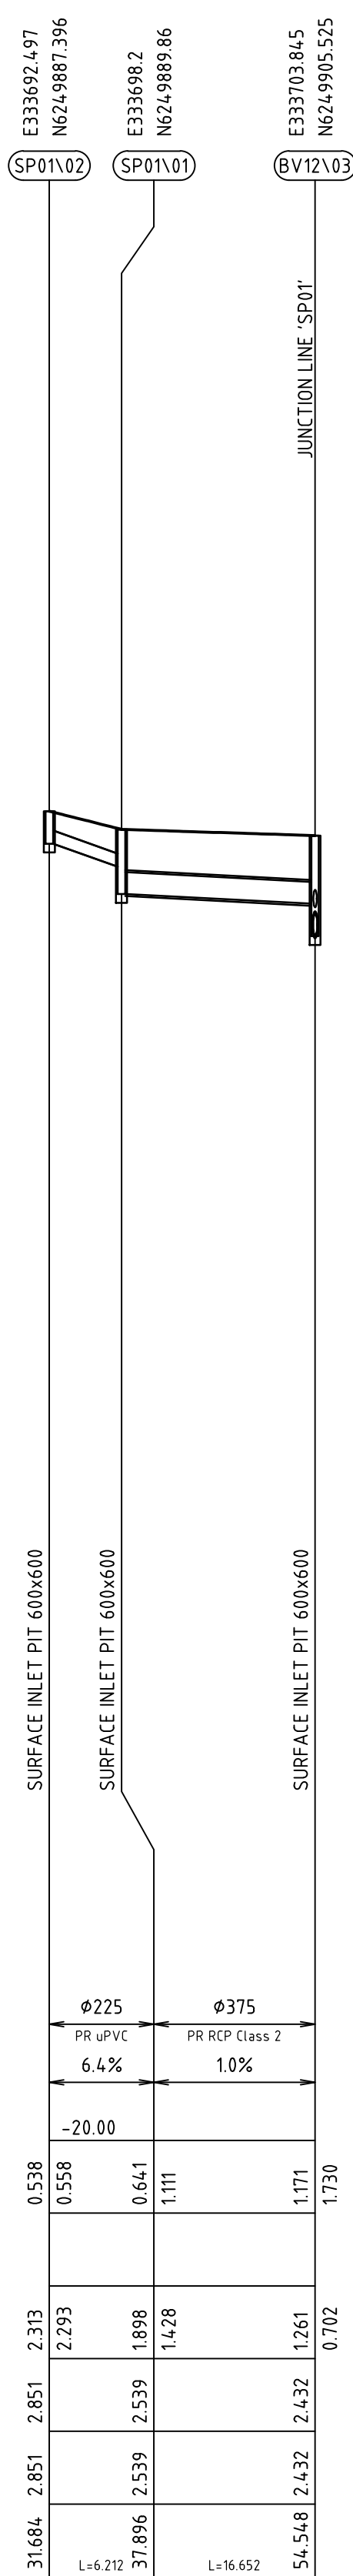


LINE SP01

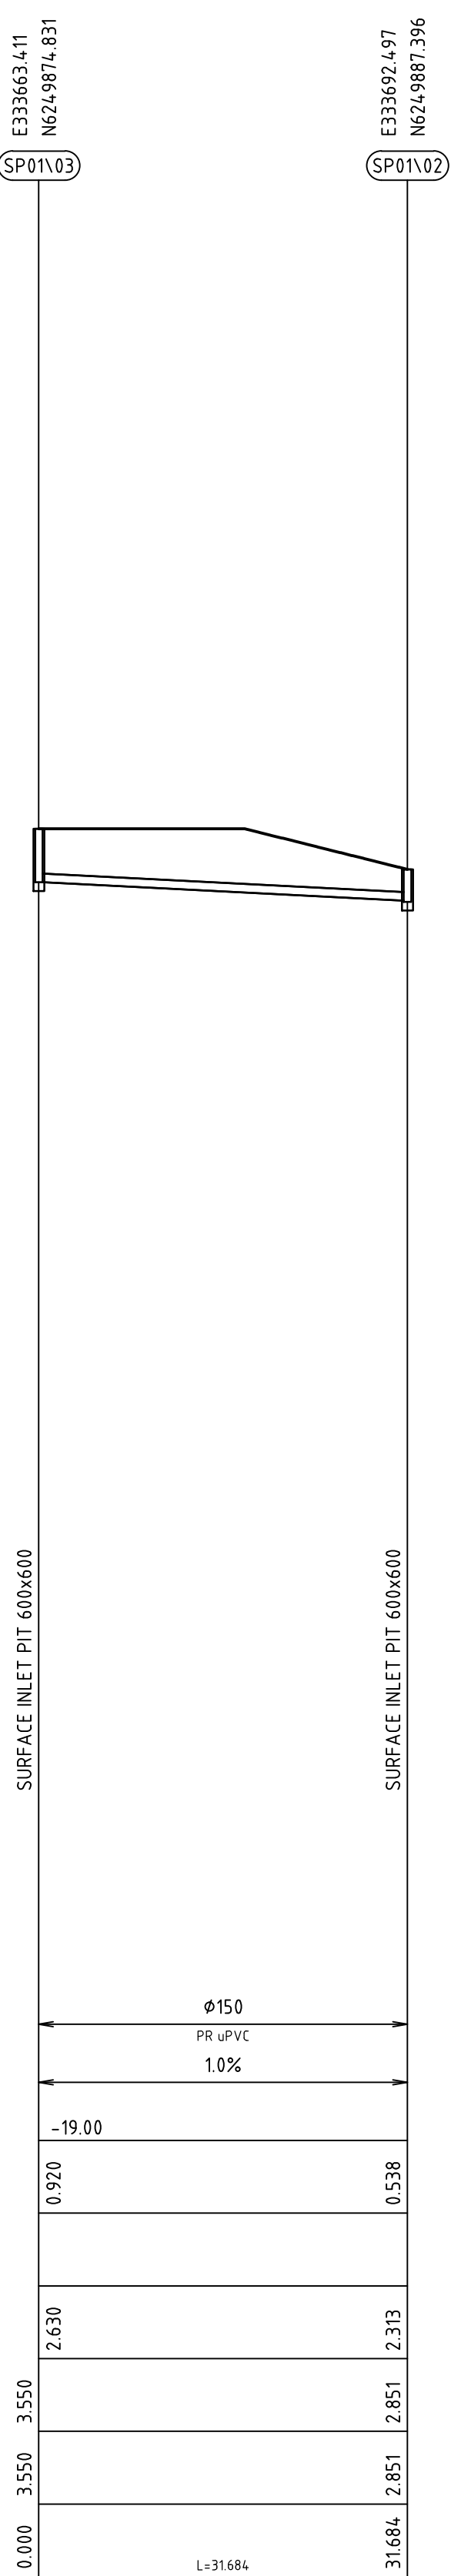

LINE SP01


DARLING HARBOUR LIVE

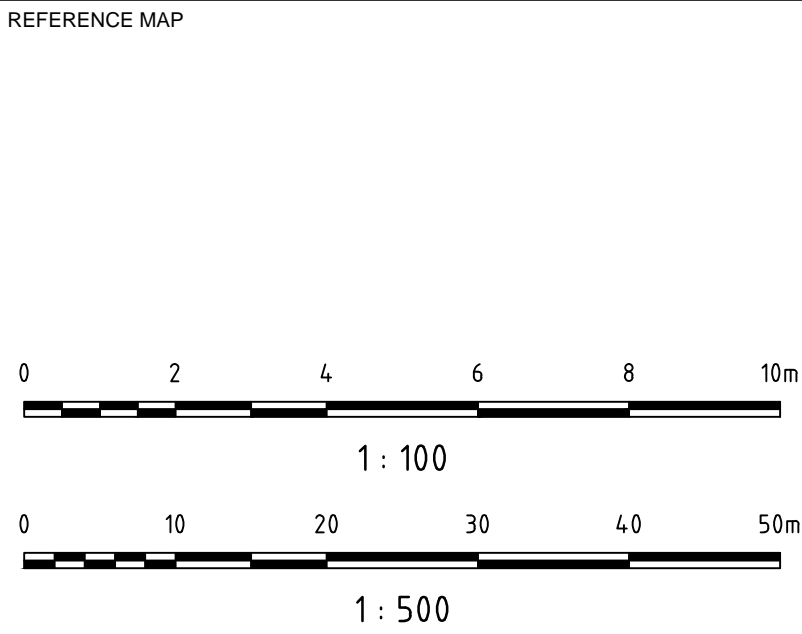

- NOTES:**
1. DO NOT SCALE FROM DRAWINGS. WORK TO WRITTEN DIMENSIONS ONLY.
  2. ALL DIMENSIONS IN METRES UNLESS NOTED OTHERWISE.
  3. ALL COORDINATES TO MGA. ALL LEVELS TO AHD.
  4. ALL DIMENSIONS, COORDINATES AND LEVELS TO BE VERIFIED ON SITE BEFORE PROCEEDING WITH WORK. HYDER SHALL BE NOTIFIED IN WRITING OF ANY DISCREPANCIES.
  5. THIS DRAWING MUST BE READ IN CONJUNCTION WITH ALL RELEVANT CONTRACTS, SPECIFICATIONS AND DRAWINGS.

02	AMENDED AS PER CLIENT REQUEST	18/02/2014
01	ISSUE FOR TENDER	20/11/2013
REV	DESCRIPTION	DATE

CLIENT

**Lend Lease**

LEND LEASE BUILDING PTY. LTD.  
LEVEL 4, THE BOND, 30 HICKSON RD  
MILLERS POINT, NSW 2000

CONSULTANTS

**HASSELL +  
POPULOUS**

**LANDSCAPE ARCHITECT**  
LEVEL 2, 88 CUMBERLAND STREET,  
SYDNEY NSW 2000

**DENTON  
CORKER  
MARSHALL**

**ARCHITECT**  
49 EXHIBITION STREET,  
MELBOURNE VICTORIA 3000

**CIVIL / TRAFFIC / FACADES**  
**HYDER CONSULTING PTY LTD**  
ABN 76 104 485 289  
LEVEL 5, 141 WALKER ST,  
NORTH SYDNEY NSW 2060  
AUSTRALIA

Tel: +61 (0)2 8907 9000  
Fax: +61 (0)2 8907 9001  
[www.hyderconsulting.com](http://www.hyderconsulting.com)  
© Copyright reserved



PROJECT

SICEEP - DARLING HARBOUR  
HAYMARKET (PDA)  
SOUTH WEST PLOT


DRAWING TITLE

STORMWATER DRAINAGE  
LONGITUDINAL SECTIONS  
SHEET 1


STATUS

TENDER DESIGN


SCALE @ A1	DRAWN	DESIGNED	REVIEWED	APPROVED
AS SHOWN	VWM	CM	JH	GI
PROJECT NUMBER	DRAWING NUMBER			REV
AA004399	PP-CI-3305			02

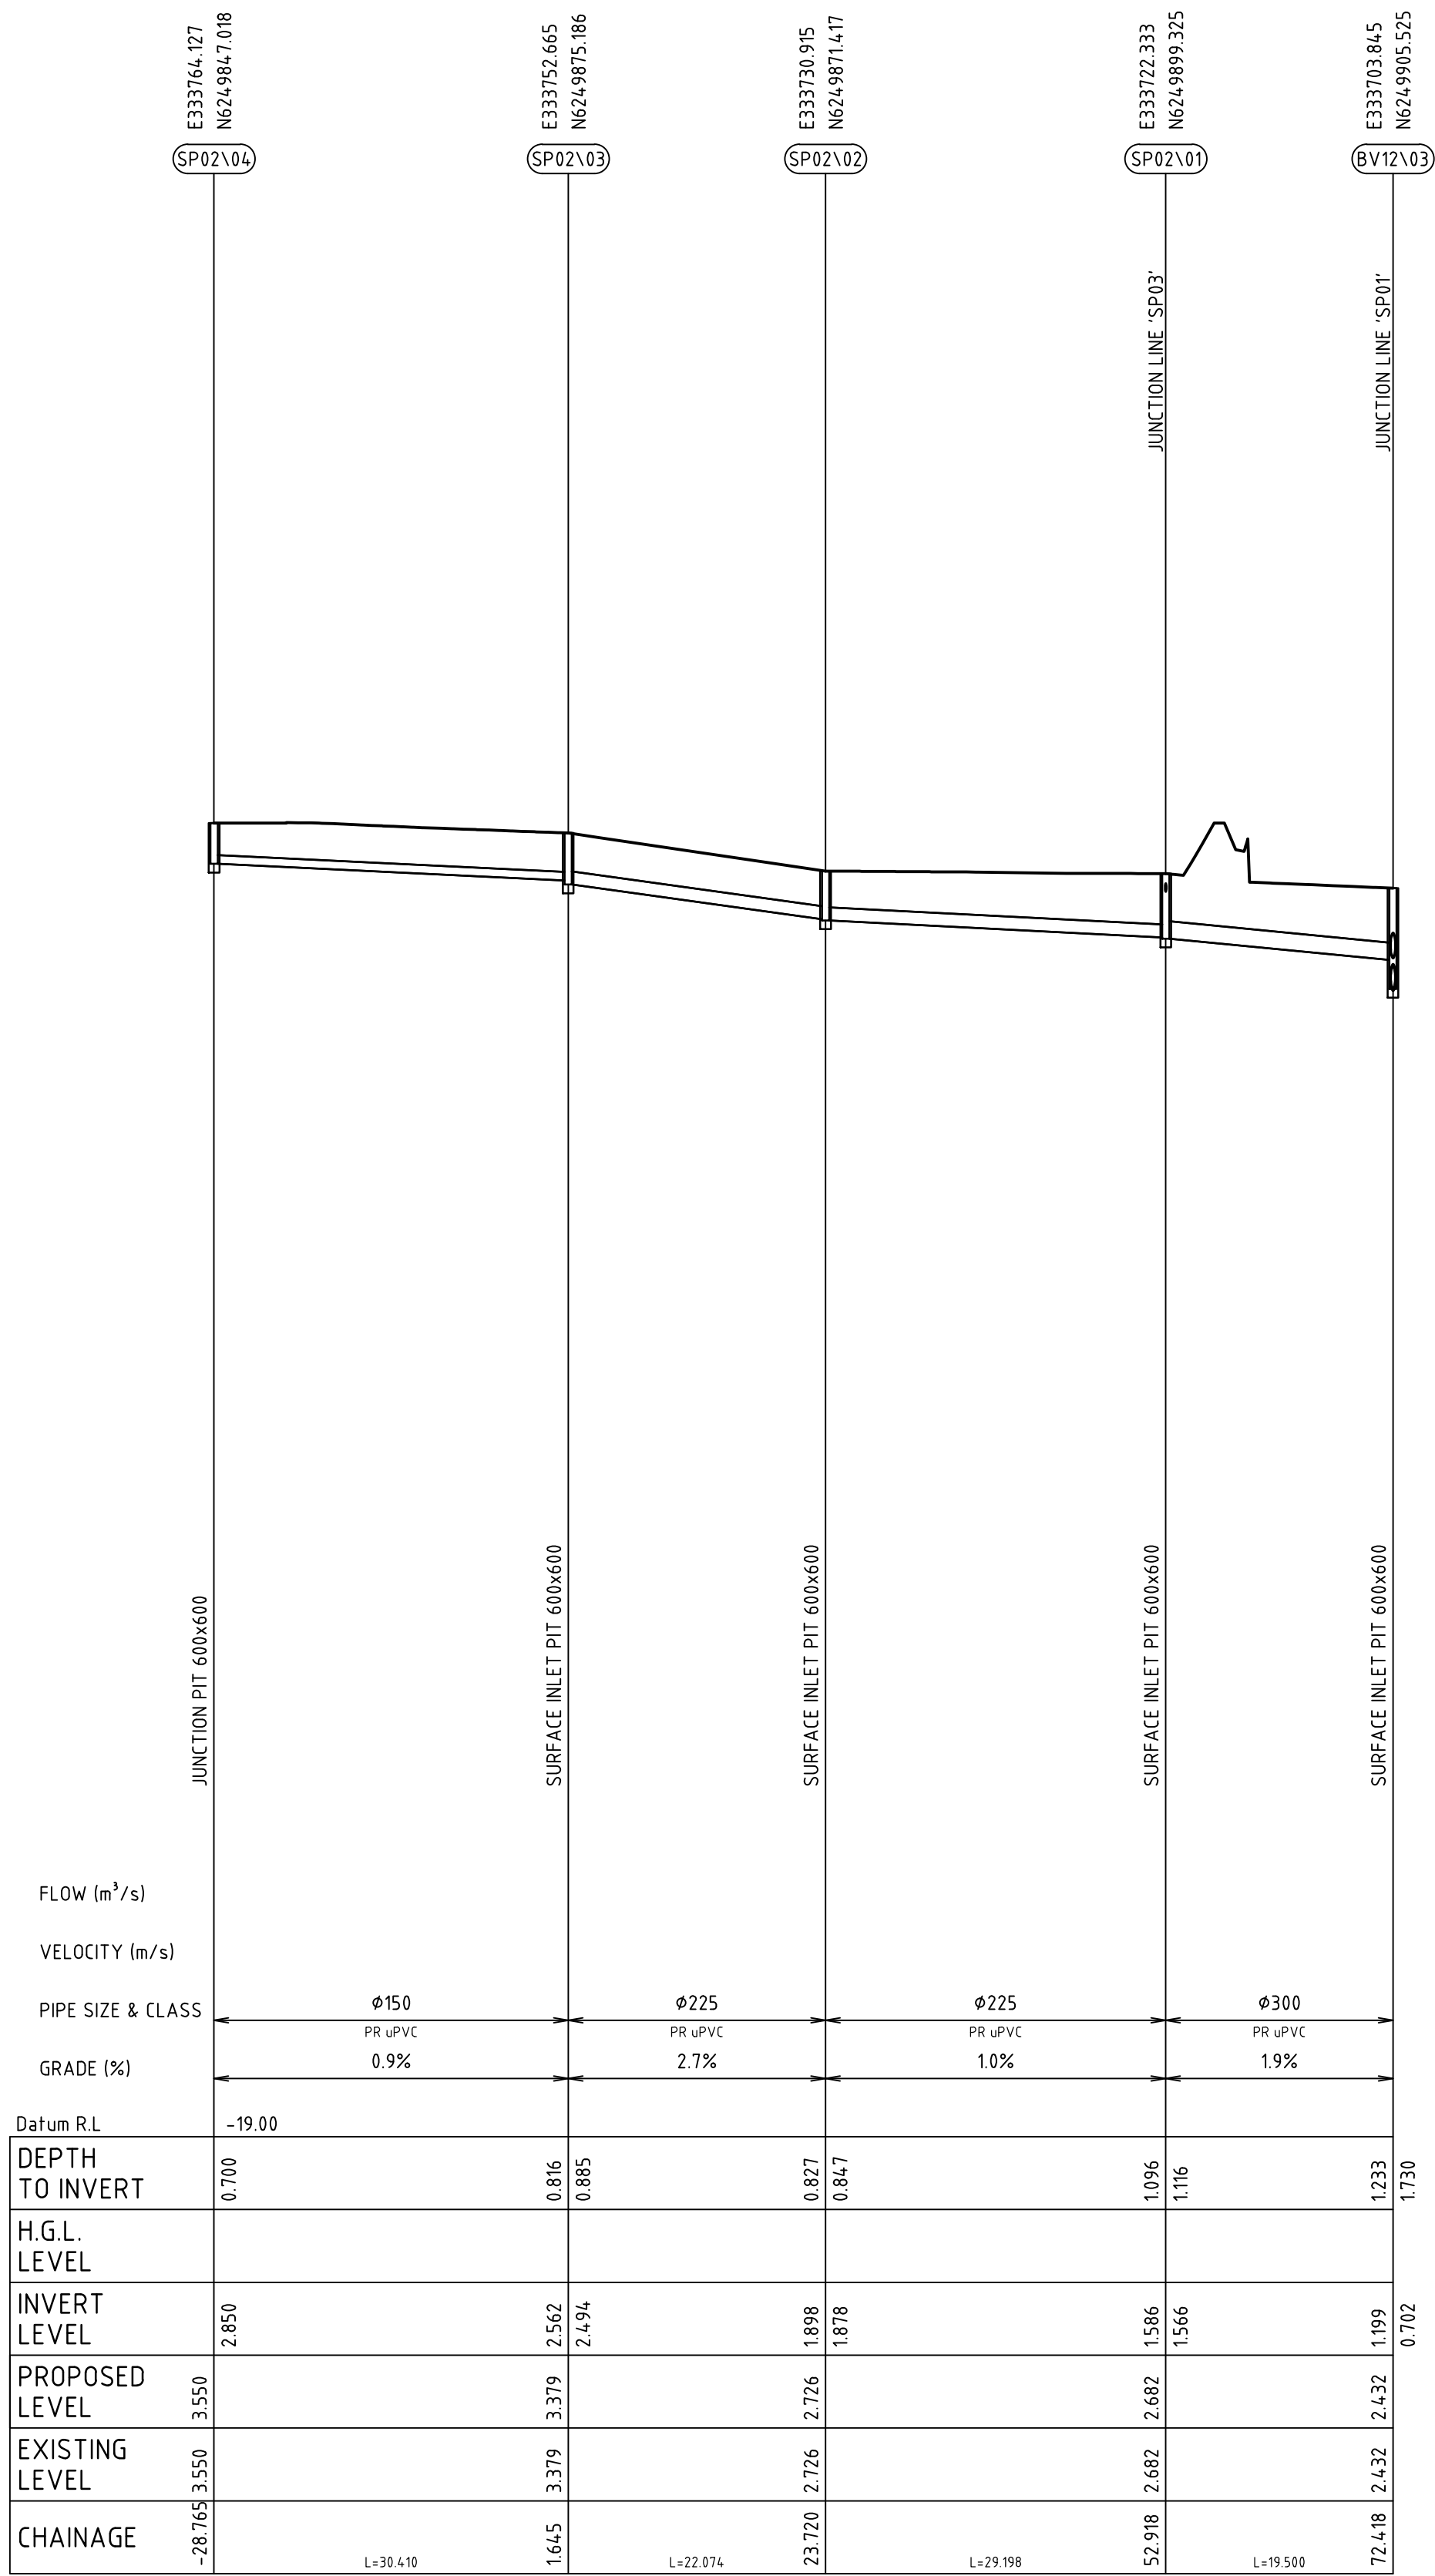

LINE SP02


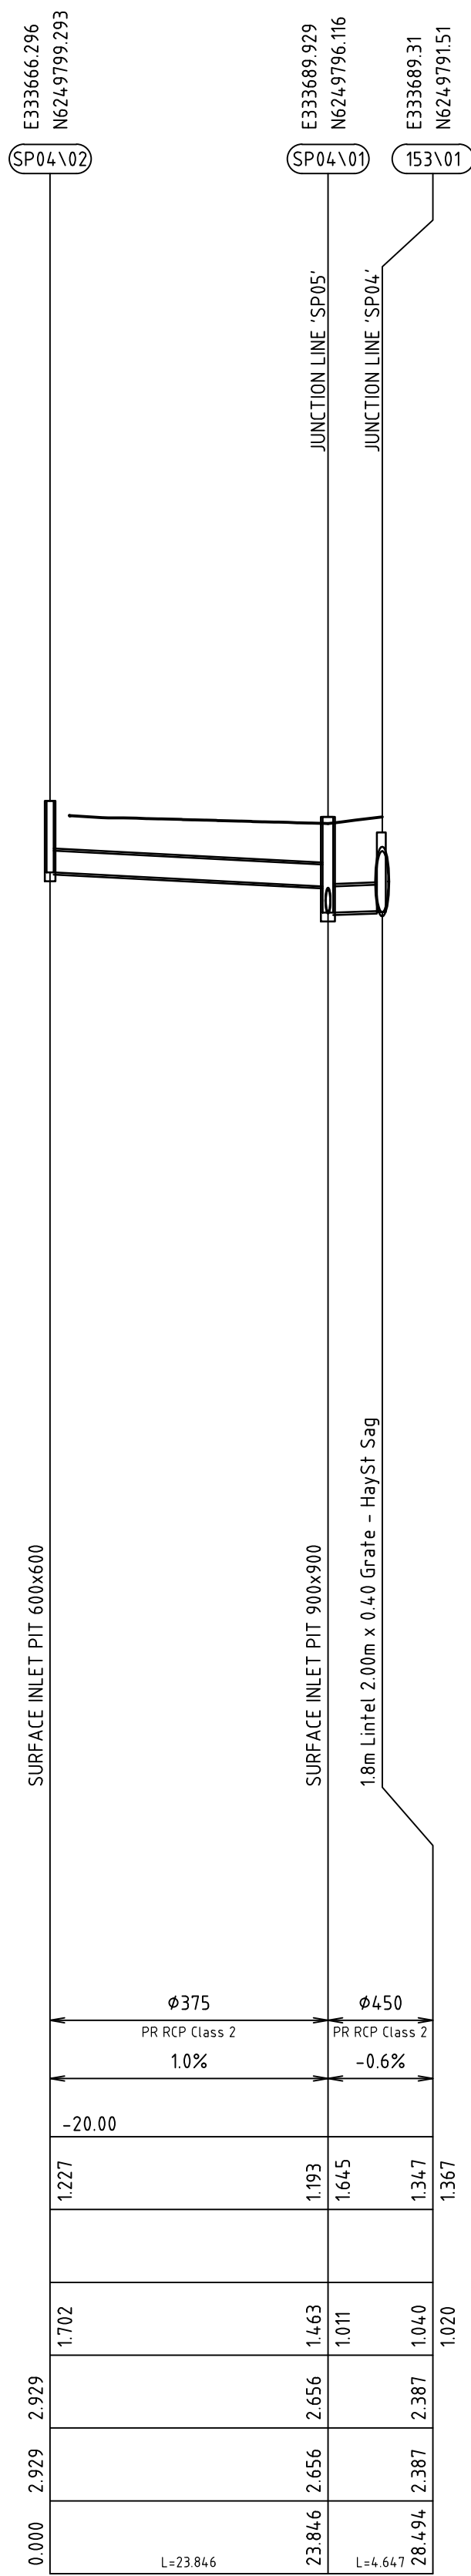


LINE SP04

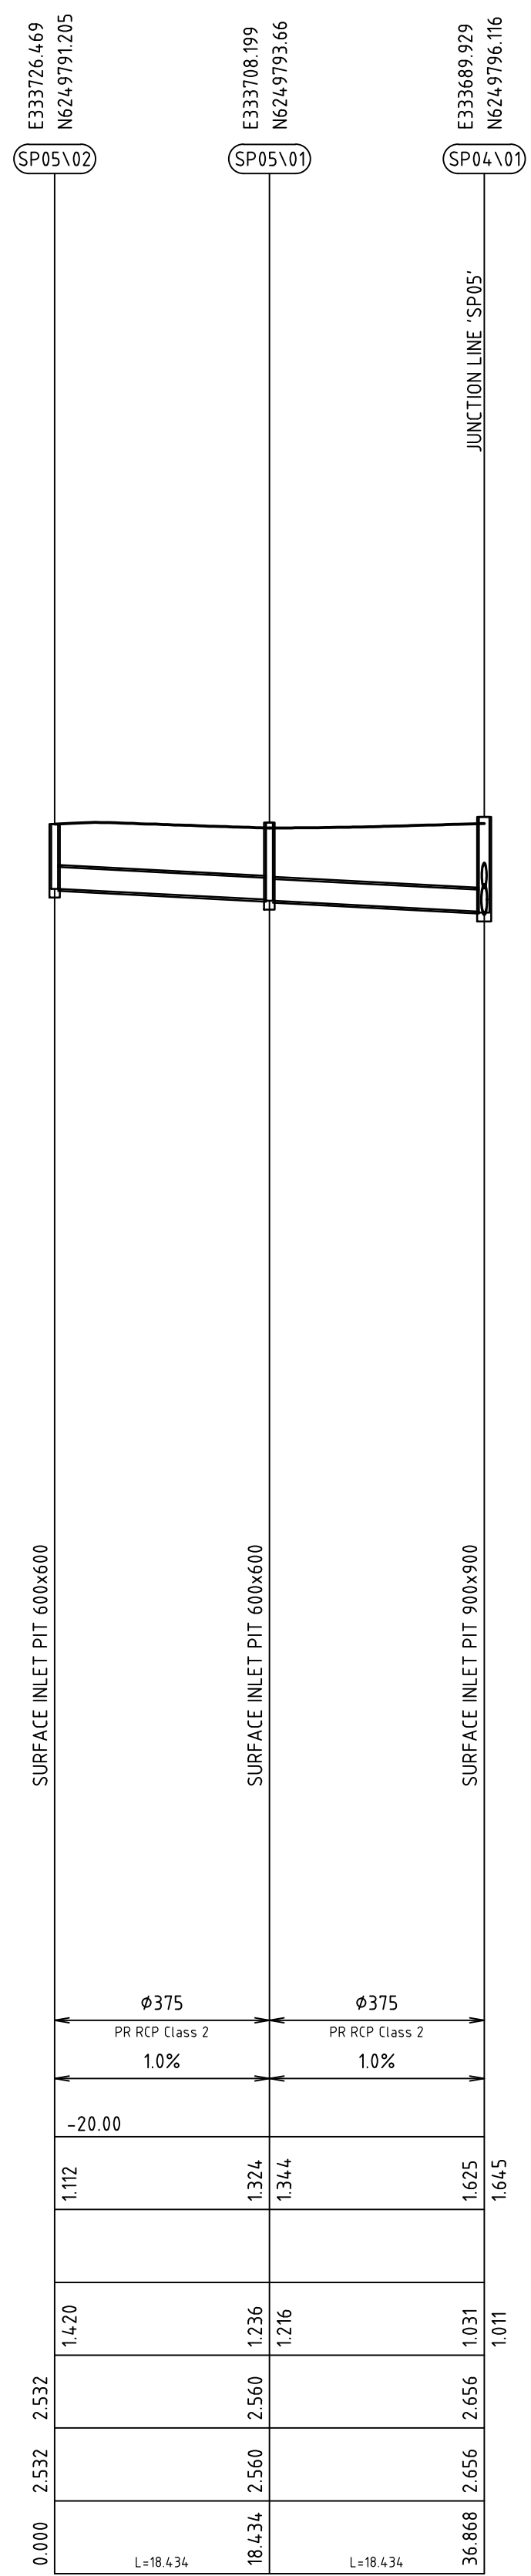

LINE SP05

 DARLING HARBOUR LIVE

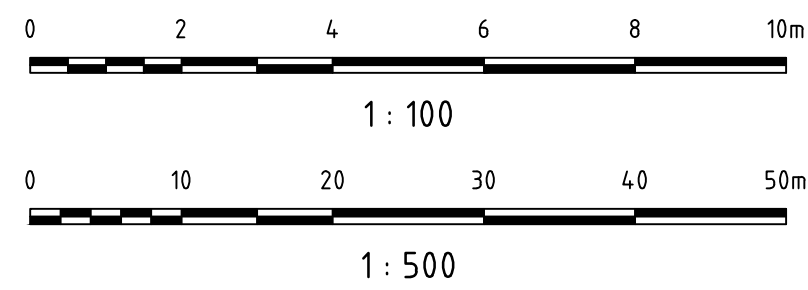

NOTES:

1. DO NOT SCALE FROM DRAWINGS. WORK TO WRITTEN DIMENSIONS ONLY.
2. ALL DIMENSIONS IN METRES UNLESS NOTED OTHERWISE.
3. ALL COORDINATES TO MGA. ALL LEVELS TO AHD.
4. ALL DIMENSIONS, COORDINATES AND LEVELS TO BE VERIFIED ON SITE BEFORE PROCEEDING WITH WORK. HYDER SHALL BE NOTIFIED IN WRITING OF ANY DISCREPANCIES.
5. THIS DRAWING MUST BE READ IN CONJUNCTION WITH ALL RELEVANT CONTRACTS, SPECIFICATIONS AND DRAWINGS.

02	AMENDED AS PER CLIENT REQUEST	18/02/2014
01	ISSUE FOR TENDER	20/11/2013
<b>REV</b>	<b>DESCRIPTION</b>	<b>DATE</b>

CLIENT



LEND LEASE BUILDING PTY. LTD.  
LEVEL 4, THE BOND, 30 HICKSON RD  
MILLERS POINT, NSW 2000

## CONSULTANTS

**HASSELL + POPULOUS** LANDSCAPE ARCHITECT  
LEVEL 2, 88 CUMBERLAND STREET,  
SYDNEY NSW 2000

DENTON ARCHITECT  
CORKER 49 EXHIBITION STREET,  
MARSHALL MELBOURNE VICTORIA 3000

CIVIL / TRAFFIC / FACADES

**HYDER CONSULTING PTY LTD**  
ABN 76 104 485 289  
LEVEL 5, 141 WALKER ST,  
NORTH SYDNEY NSW 2060  
AUSTRALIA

Tel: +61 (0)2 8907 9000  
Fax: +61 (0)2 8907 9001  
www.hyderconsulting.com  
© Copyright reserved

PROJECT

SICEEP - DARLING HARBOUR  
HAYMARKET (PDA)  
SOUTH WEST PLOT



DRAWING TITLE


# STORMWATER DRAINAGE LONGITUDINAL SECTIONS SHEET 1

STATUS

## TENDER DESIGN

SCALE @ A1	DRAWN	DESIGNED	REVIEWED	APPROVED
AS SHOWN	VWM	CM	JH	GI

PROJECT NUMBER	DRAWING NUMBER	REV
AA004399	PP-CI-3306	02

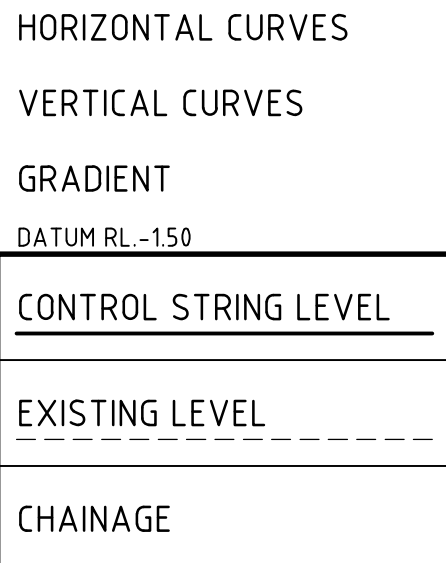


MF01 LONGITUDINAL SECTION

**DARLING HARBOUR LIVE**

## REFERENCE MAP

NOTES:-

1. DO NOT SCALE FROM DRAWINGS. WORK TO WRITTEN DIMENSIONS ONLY.
2. ALL DIMENSIONS IN METRES UNLESS NOTED OTHERWISE.
3. ALL COORDINATES TO MGA. ALL LEVELS TO AHD.
4. ALL DIMENSIONS, COORDINATES AND LEVELS TO BE VERIFIED ON SITE BEFORE PROCEEDING WITH WORK. HYDER SHALL BE NOTIFIED IN WRITING OF ANY DISCREPANCIES.
5. THIS DRAWING MUST BE READ IN CONJUNCTION WITH ALL RELEVANT CONTRACTS, SPECIFICATIONS AND DRAWINGS.

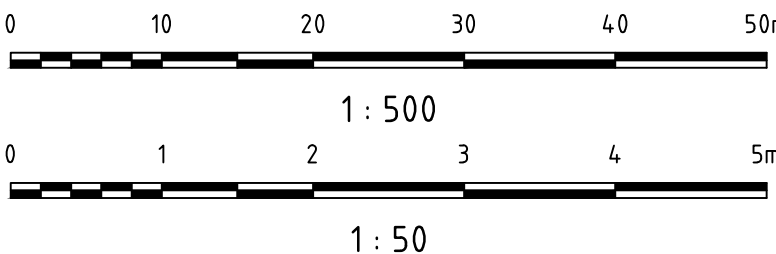

04	AMENDED AS PER CLIENT REQUEST	18/02/2014
03	ISSUE FOR DA	28/05/2013
02	DRAFT ISSUE	01/05/2013
01	DRAFT ISSUE	24/04/2013
<b>REV</b>	<b>DESCRIPTION</b>	<b>DATE</b>

CLIENT



LEND LEASE BUILDING PTY. LTD.  
LEVEL 4, THE BOND, 30 HICKSON RD  
MILLERS POINT, NSW 2000

CONSULTANT

**HASSELL +  
POPOULOUS** LANDSCAPE ARCHITECT  
LEVEL 2, 88 CUMBERLAND STREET  
SYDNEY NSW 2000

**DENTON ARCHITECT**  
**CORKER** 49 EXHIBITION STREET,  
**MARSHALL** MELBOURNE VICTORIA 300

CIVIL / TRAFFIC / FACADES

**HYDER CONSULTING PTY LTD**  
ABN 76 104 485 289  
LEVEL 5, 141 WALKER ST,  
NORTH SYDNEY NSW 2060  
AUSTRALIA

Tel: +61 (0)2 8907 9000  
Fax: +61 (0)2 8907 9001  
[www.hyderconsulting.com](http://www.hyderconsulting.com)  
© Copyright reserved

PROJECT

SICEEP - DARLING HARBOUR  
HAYMARKET (PDA)  
SOUTH WEST PLOT



DRAWING TITLE

FOOTPATH LONGITUDINAL SECTION  
BOULEVARD MF01

STAT19


PRELIMINARY ONLY

SCALE @ A1	DRAWN	DESIGNED	REVIEWED	APPROVED
------------	-------	----------	----------	----------


AS SHOWN	RD	HM		
----------	----	----	--	--

PROJECT NUMBER	DRAWING NUMBER	REV
AA004399	PD-CI-3351	04



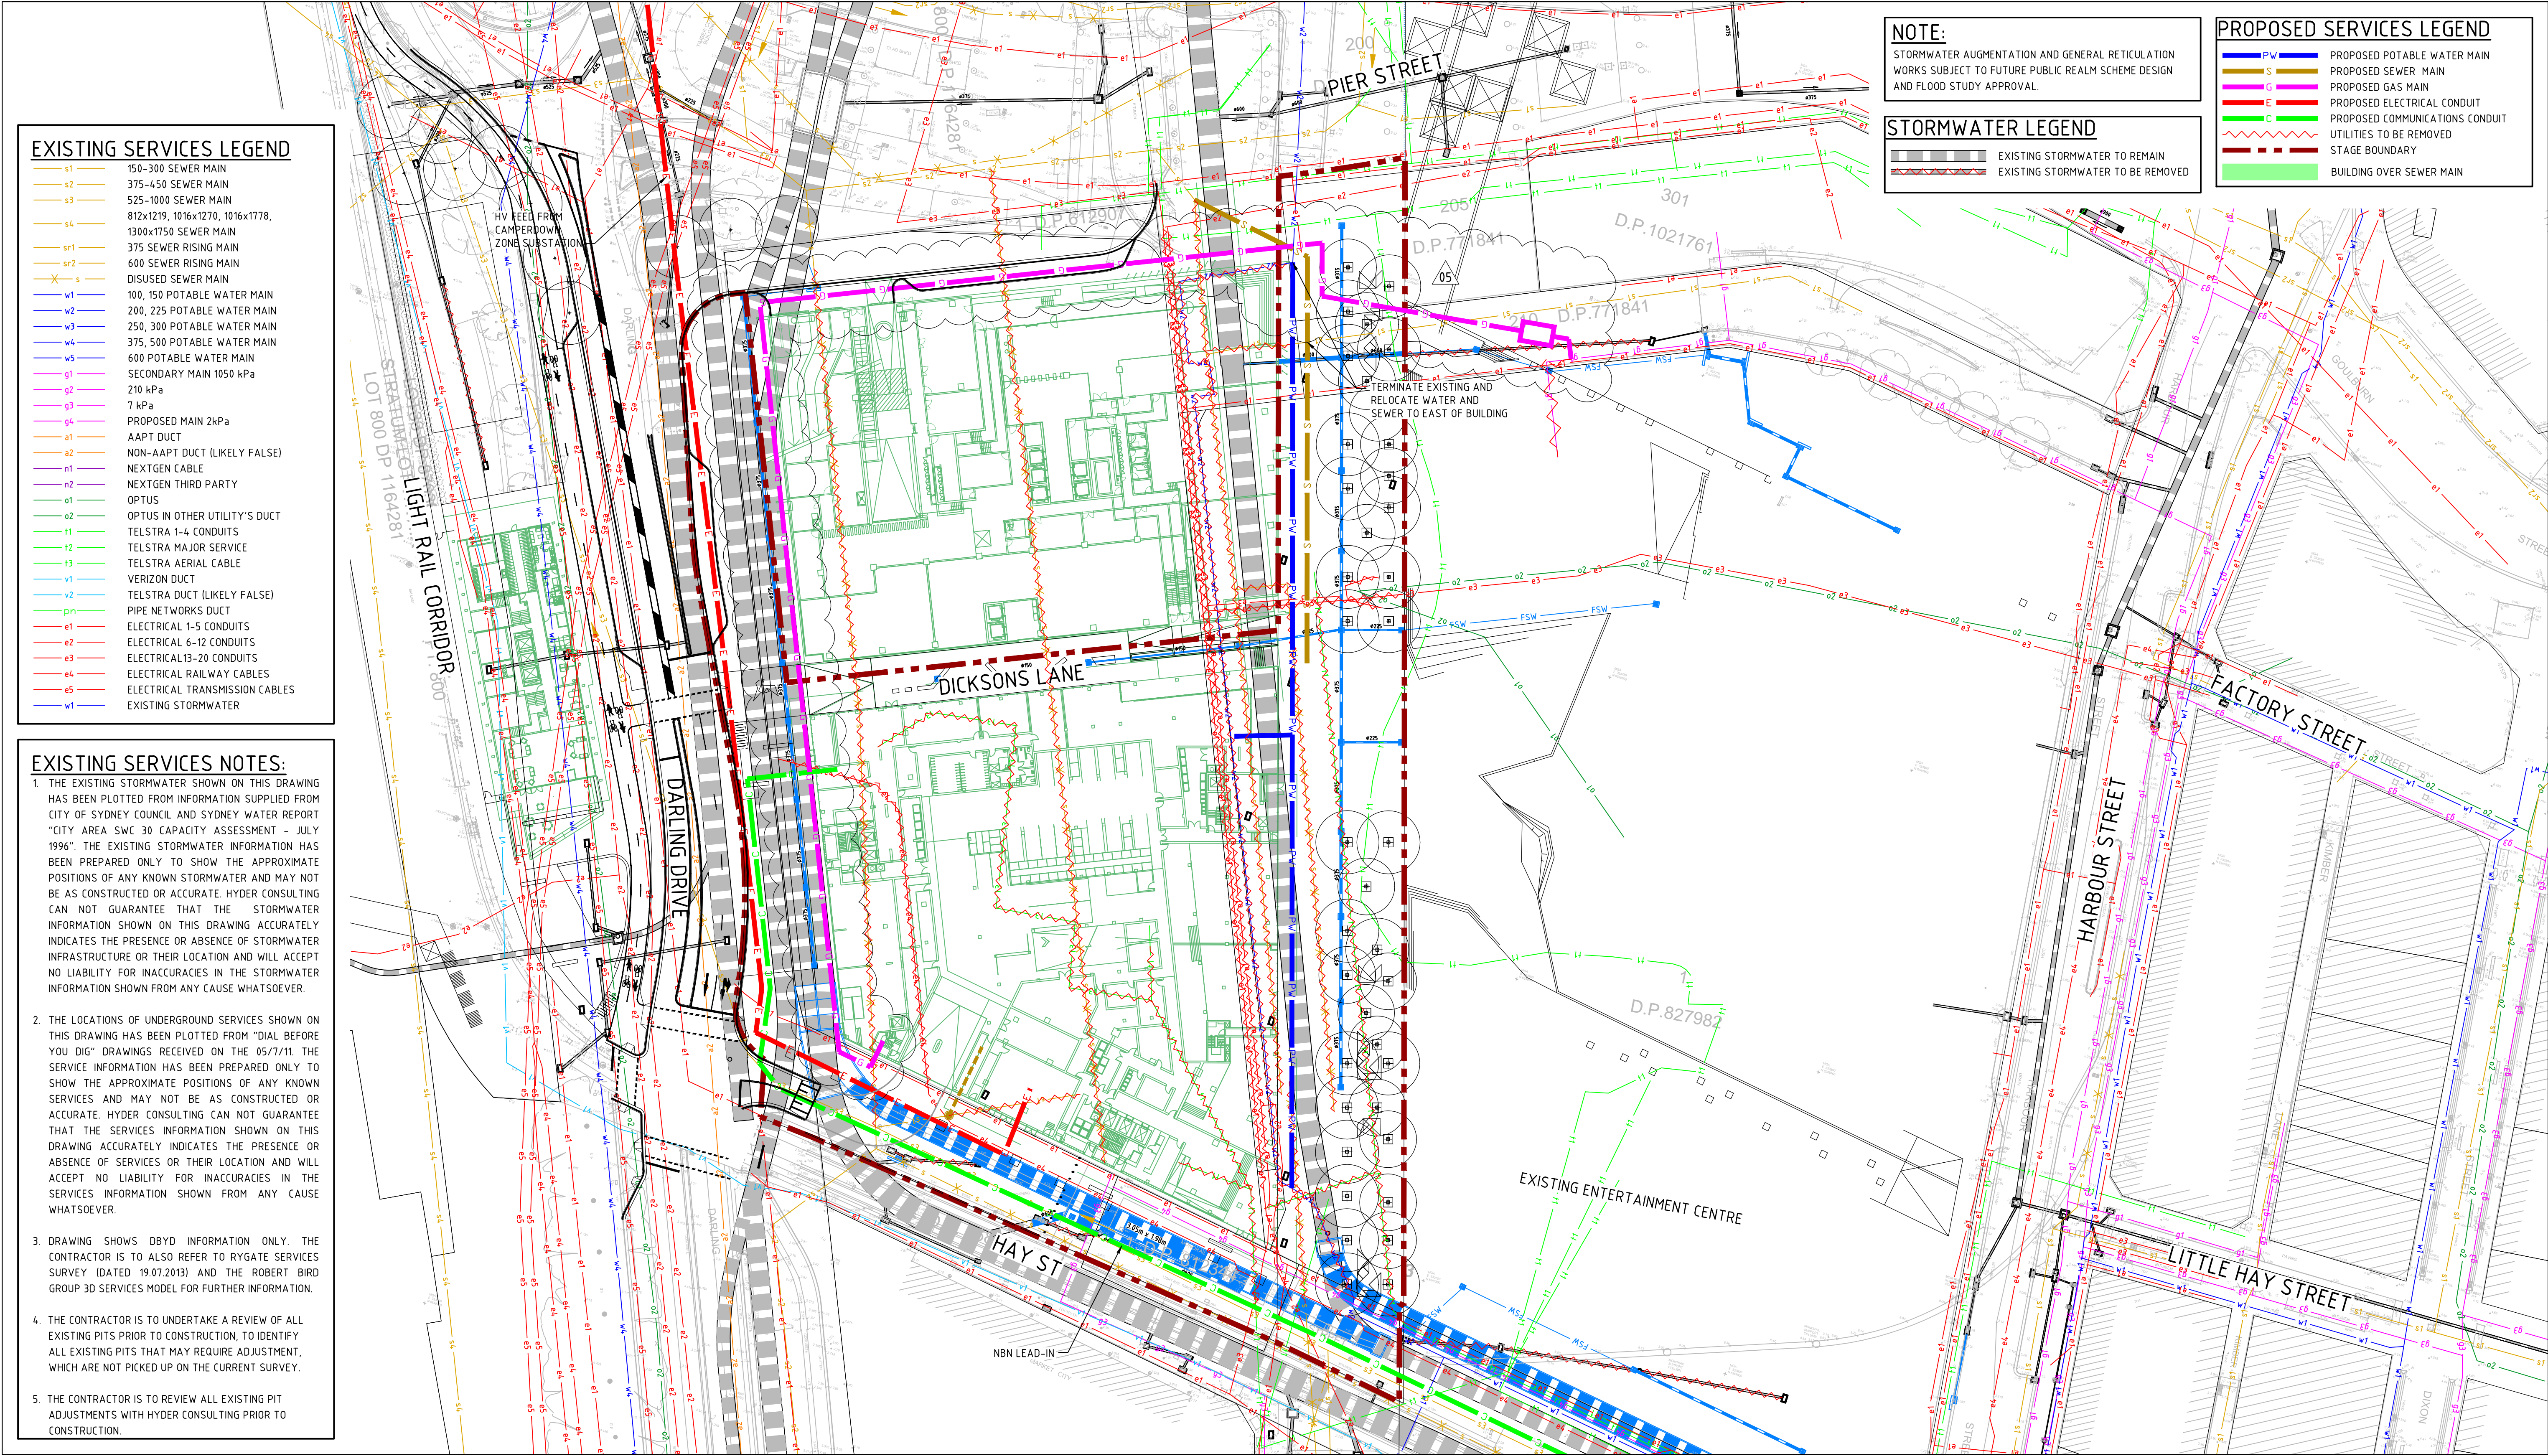

DARLING HARBOUR LIVE

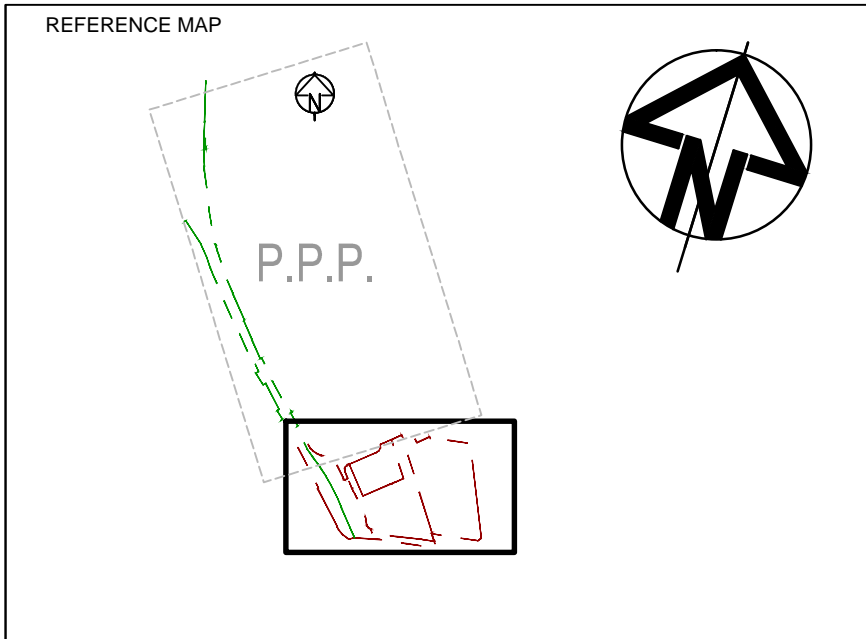

**NOTES:**

- DO NOT SCALE FROM DRAWINGS. WORK TO WRITTEN DIMENSIONS ONLY.
- ALL DIMENSIONS IN METRES UNLESS NOTED OTHERWISE.
- ALL COORDINATES TO MGA. ALL LEVELS TO AHD.
- DIMENSIONS, COORDINATES AND LEVELS TO BE VERIFIED ON SITE BEFORE PROCEEDING WITH WORK. HYDER SHALL BE NOTIFIED IN WRITING OF ANY DISCREPANCIES.
- THIS DRAWING MUST BE READ IN CONJUNCTION WITH ALL RELEVANT CONTRACTS, SPECIFICATIONS AND DRAWINGS.

0 10 20 30 40 50m

1 : 500

REV	DESCRIPTION	DATE
06	AMENDED AS PER CLIENT REQUEST	18/02/2014
05	PROPOSED GAS UPDATED	17/01/2014
04	ISSUE FOR DA	28/05/2013
03	DRAFT ISSUE	01/05/2013
02	DRAFT ISSUE	24/04/2013
01	DRAFT ISSUE	12/04/2013

**CLIENT**

**Lend Lease** LEND LEASE BUILDING PTY. LTD.  
LEVEL 4, THE BOND, 30 WICKSON RD  
MILLERS POINT, NSW 2000

**CONSULTANTS**

**HASSELL + POPULOUS** LANDSCAPE ARCHITECT  
LEVEL 2, 88 CUMBERLAND STREET,  
SYDNEY NSW 2000

**DENTON CORKER MARRAS HALL** ARCHITECT  
49 EXHIBITION STREET,  
MELBOURNE VICTORIA 3000

**CIVIL / TRAFFIC / FACADES**

**HYDER CONSULTING PTY LTD**  
ABN 76 104 485 289  
LEVEL 5, 141 WALKER ST,  
NORTH SYDNEY NSW 2060  
AUSTRALIA


Tel: +61 (0)2 8907 9000  
Fax: +61 (0)2 8907 9001  
www.hyderconsulting.com  
© Copyright reserved

**PROJECT**


**SICEP - DARLING HARBOUR  
HAYMARKET (PDA)  
SOUTH WEST PLOT**

DRAWING TITLE				
COMBINED SERVICES PLAN				
STATUS				
PRELIMINARY ONLY				
SCALE @ A1	DRAWN	DESIGNED	REVIEWED	APPROVED
1 : 500	RD	HM		
PROJECT NUMBER	DRAWING NUMBER		REV	
AA004399	PD-CI-3401		06	




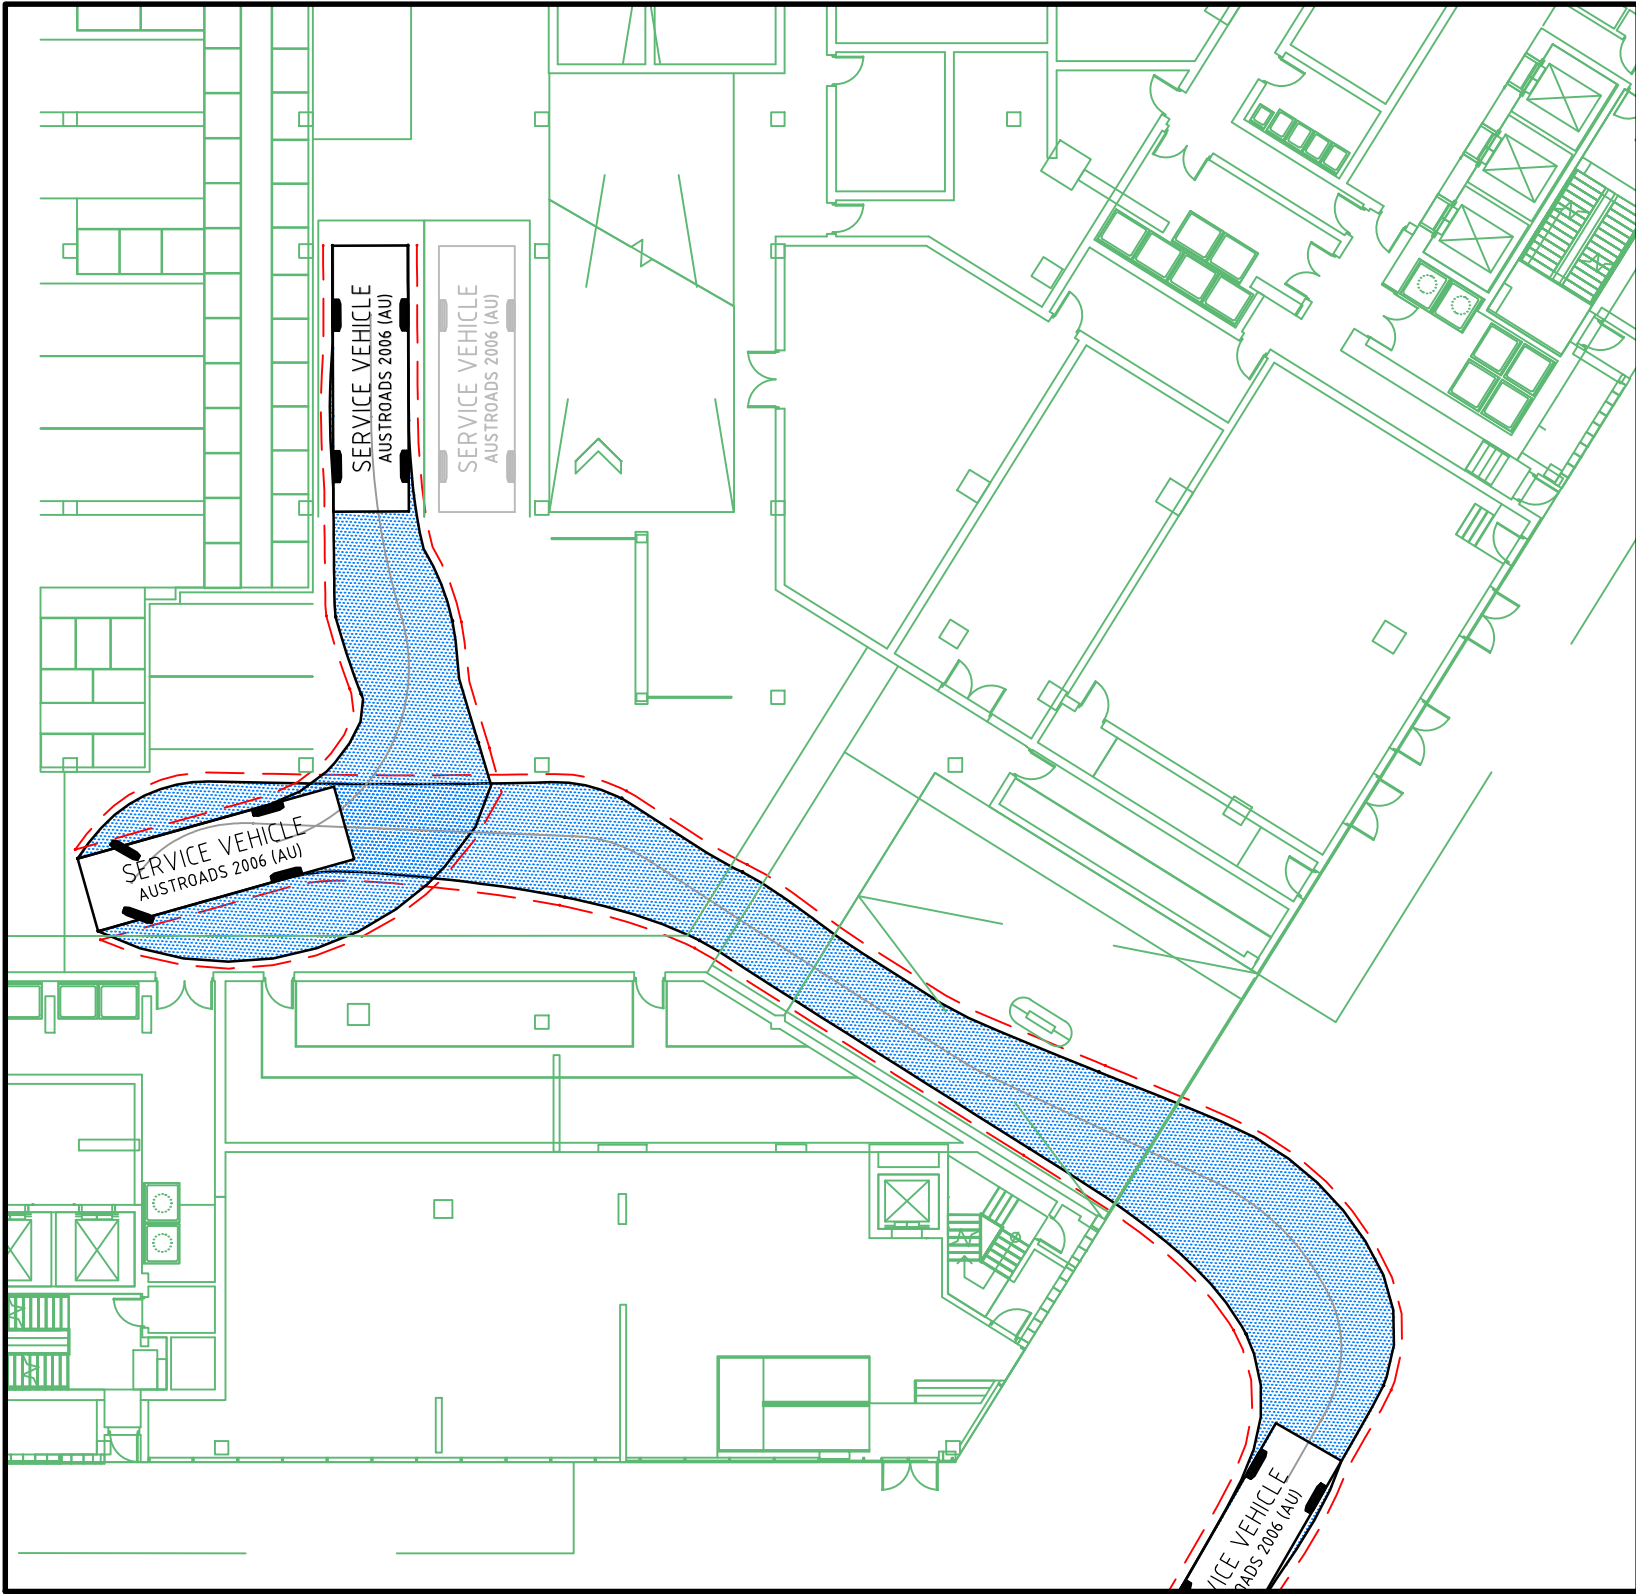


AUSTRADS 2006 8.8m SERVICE VEHICLE (MRV) - 01 IN @ 5km/hr  
1 : 250

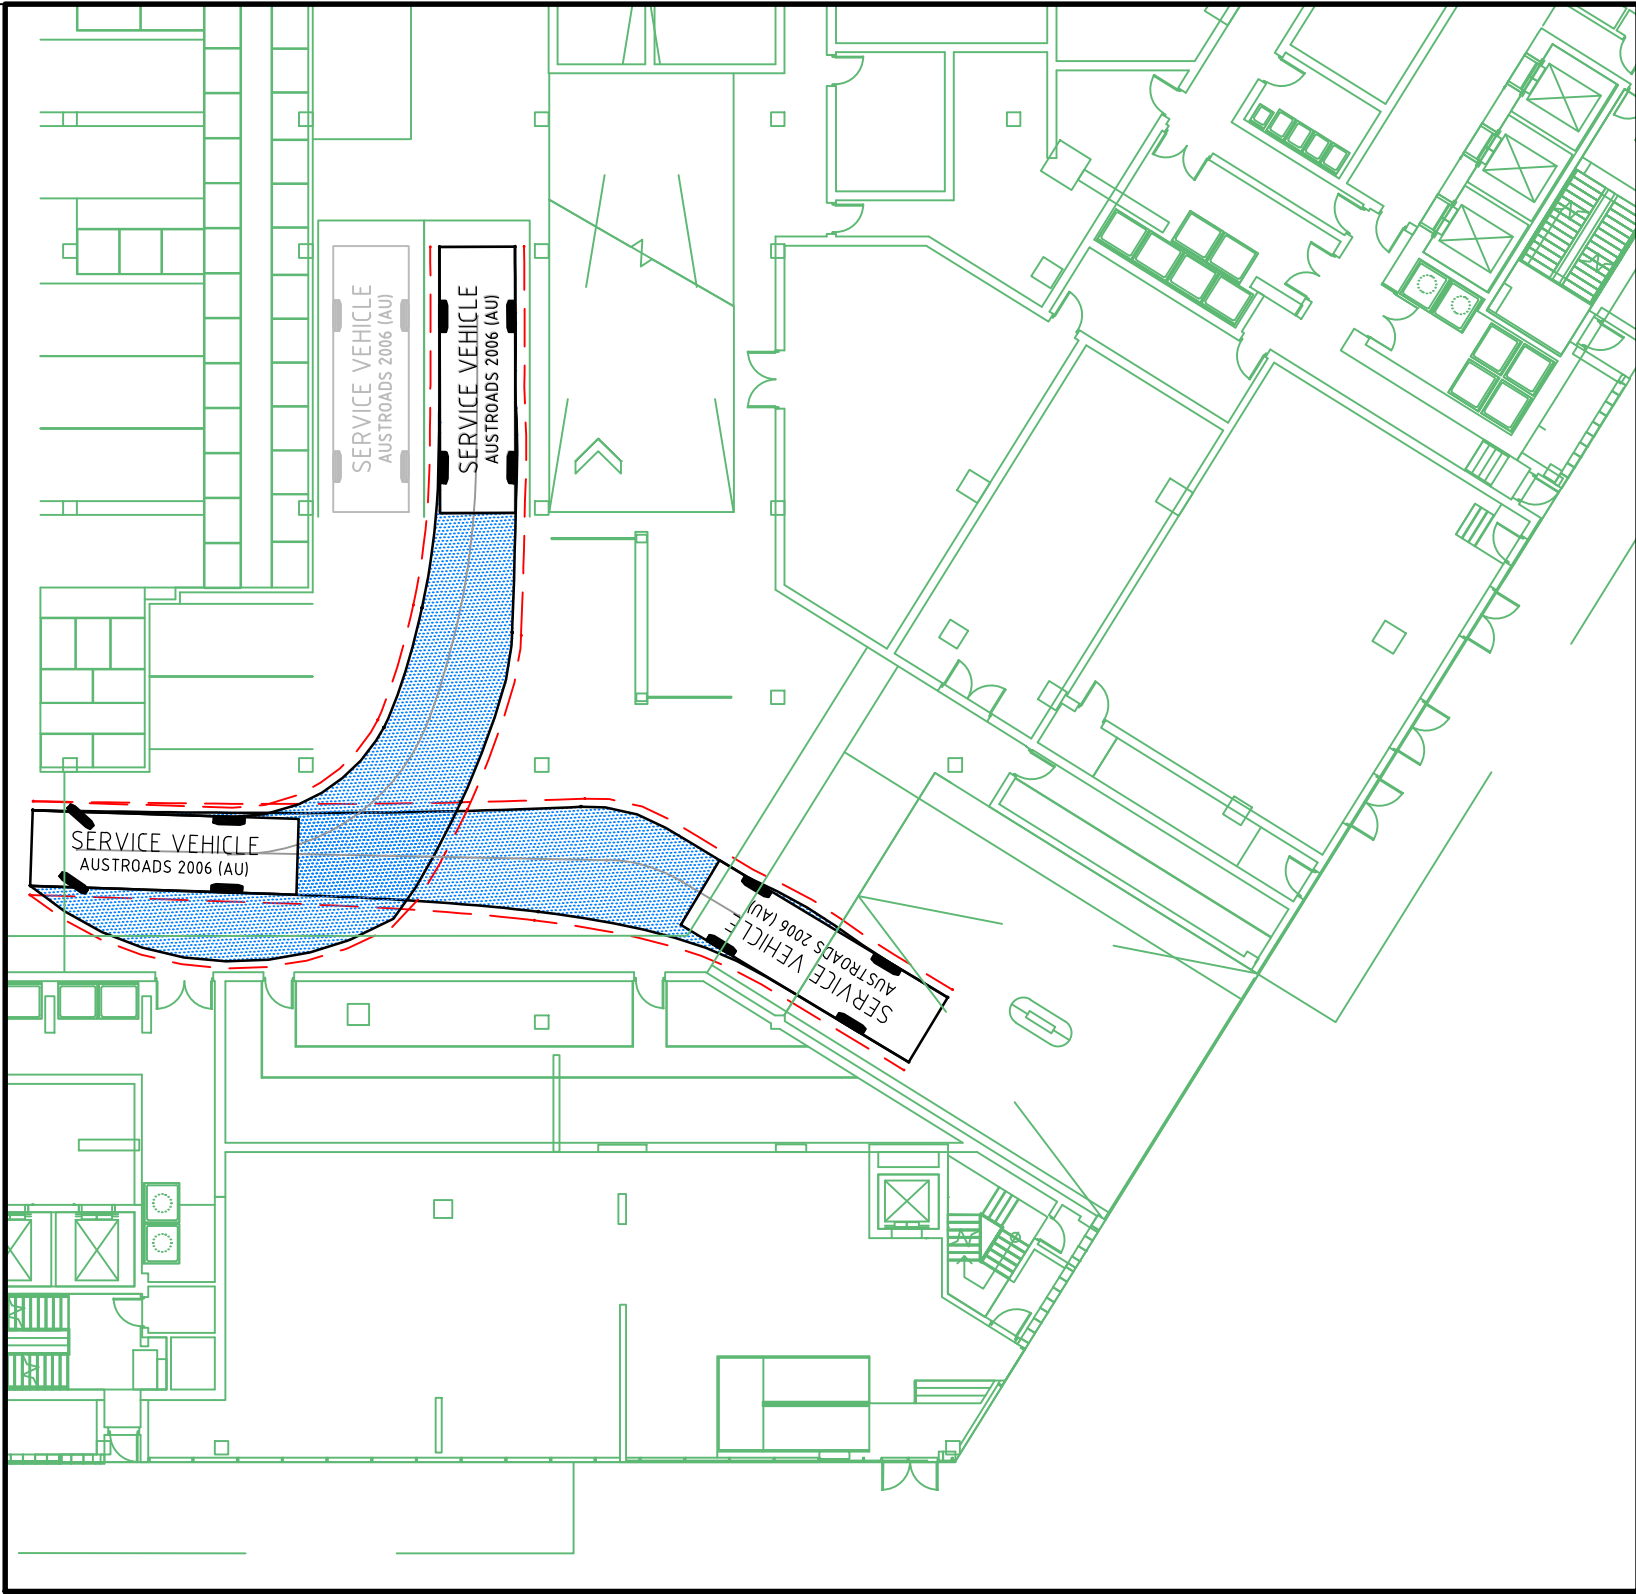


AUSTRADS 2006 8.8m SERVICE VEHICLE (MRV) - 02 IN @ 5km/hr  
1 : 250

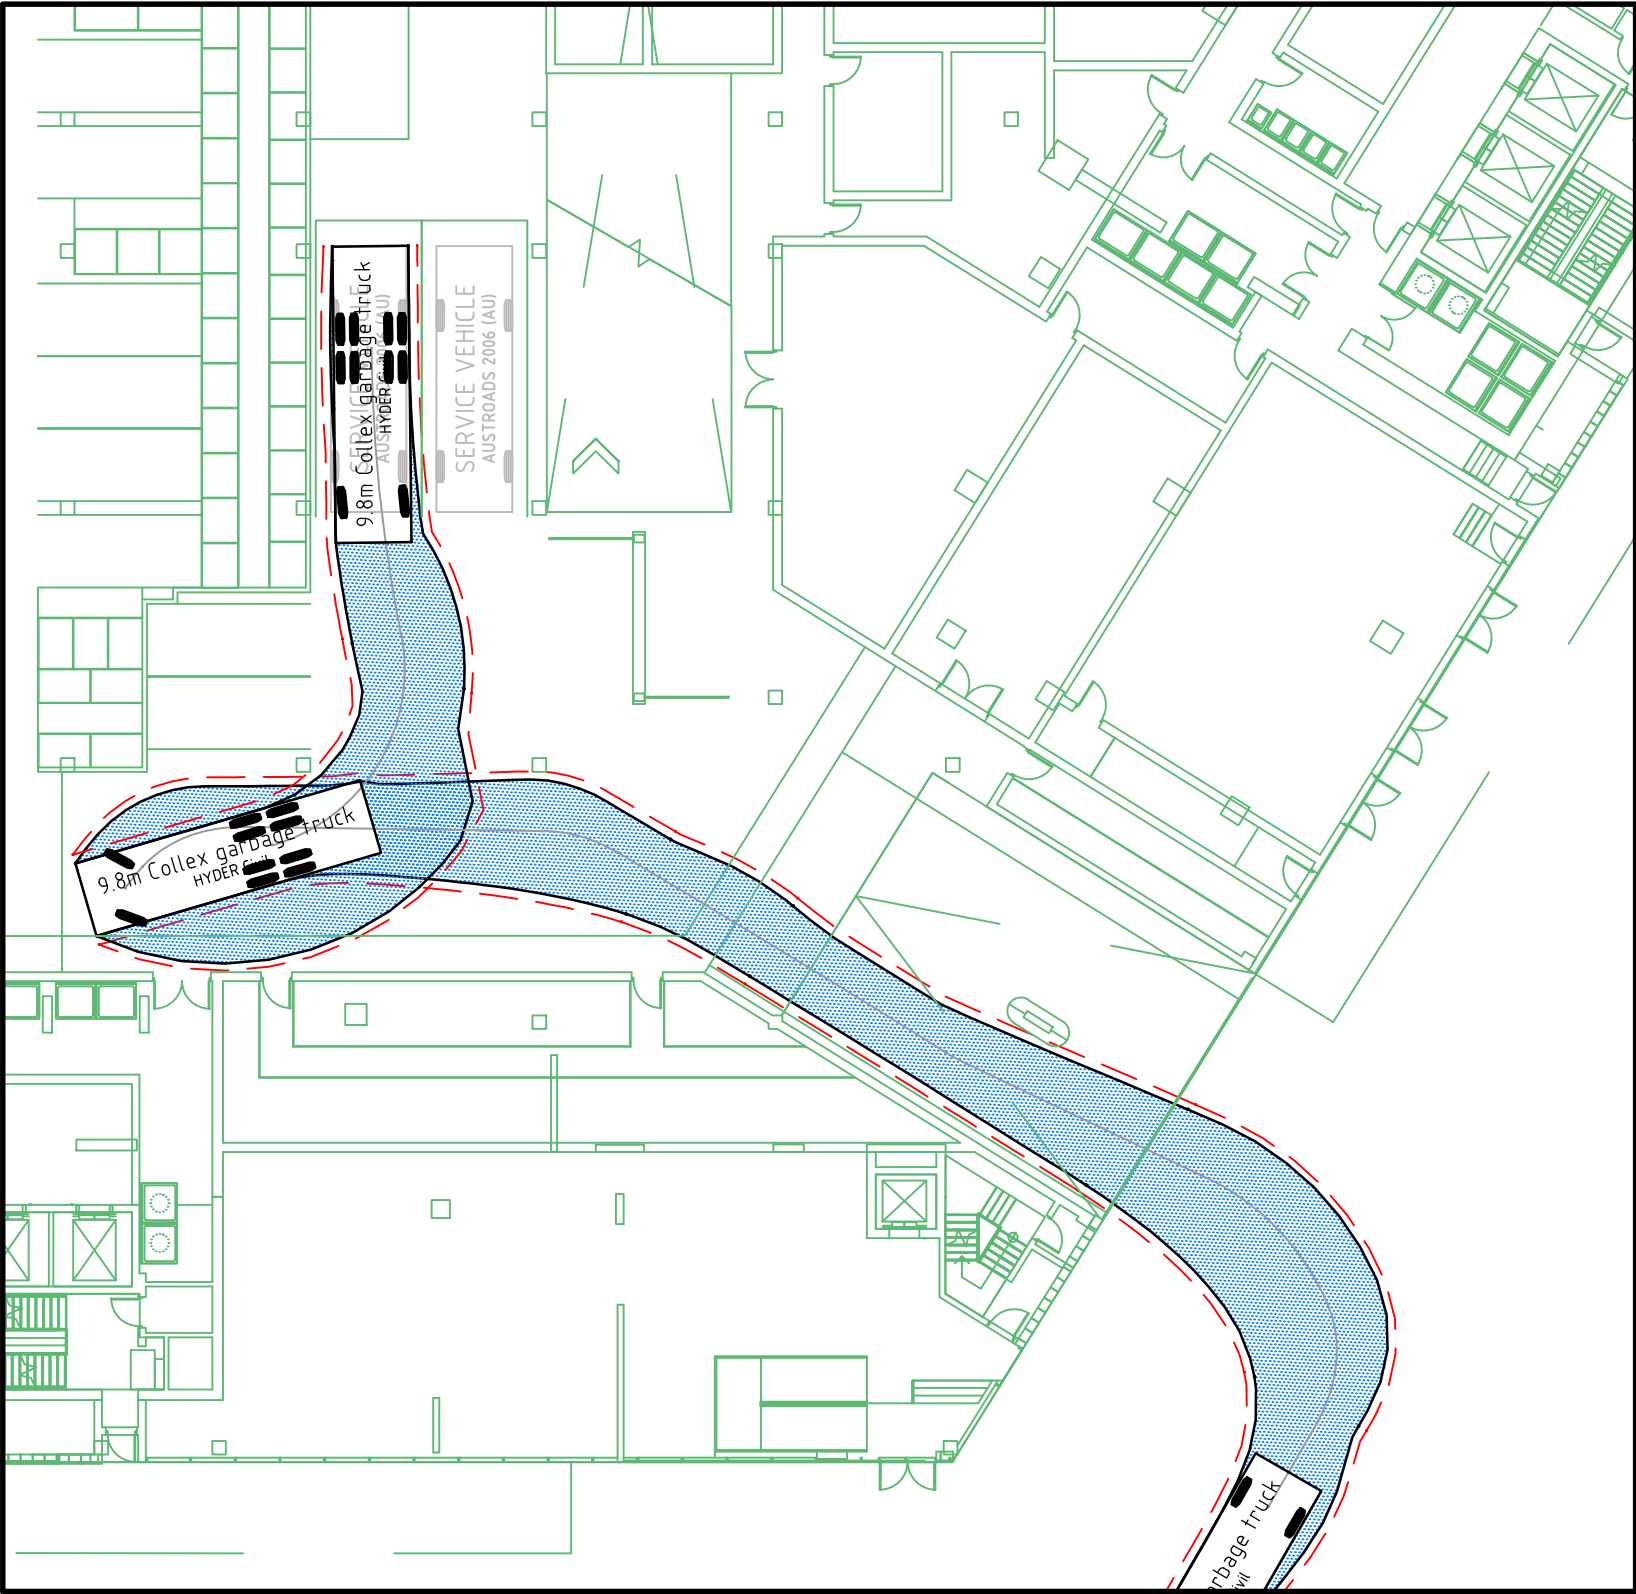


HYDER CIVIL 9.8m GARBAGE TRUCK - 01 IN @ 5km/hr  
1 : 250

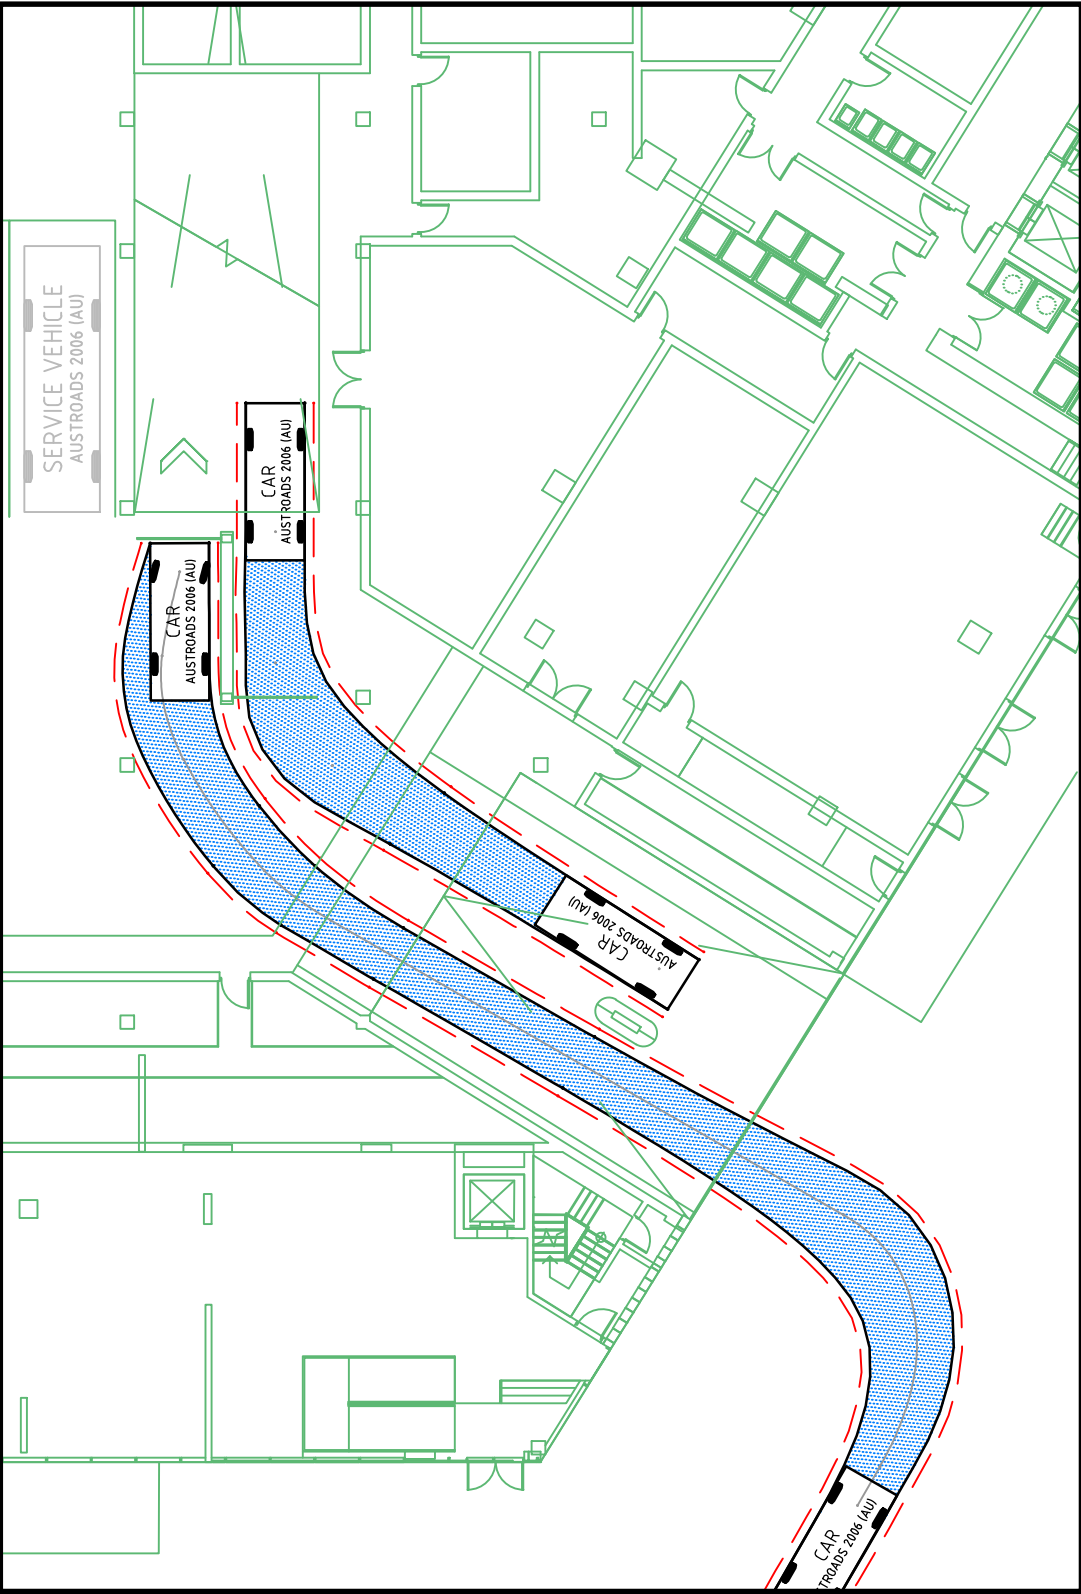


AUSTRADS 2006 5.2m CAR (B99) -  
IN AND OUT @ 10km/hr  
1 : 250

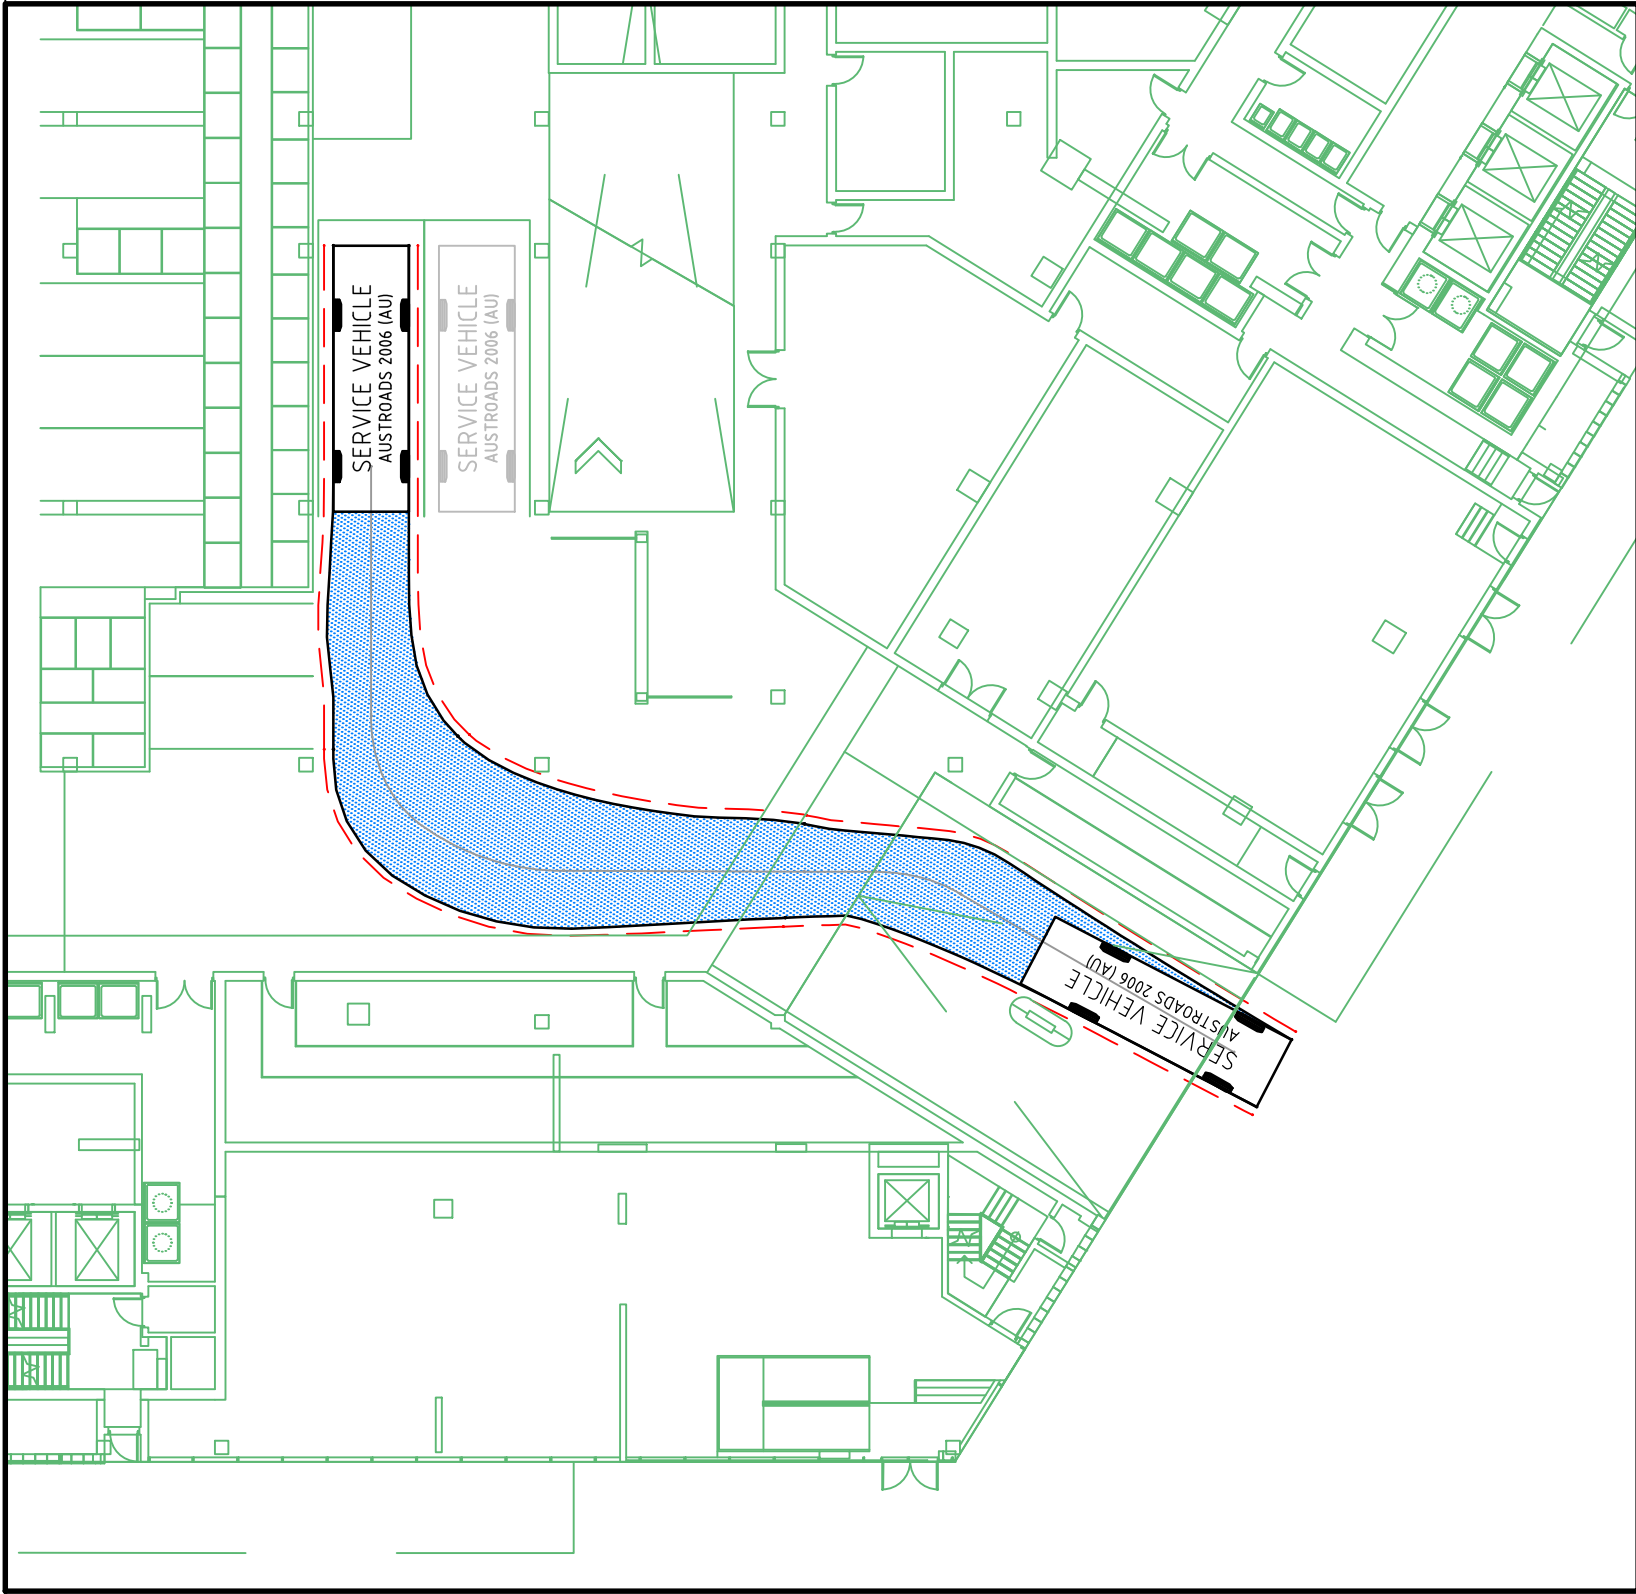


AUSTRADS 2006 8.8m SERVICE VEHICLE (MRV) - 01 OUT @ 5km/hr  
1 : 250

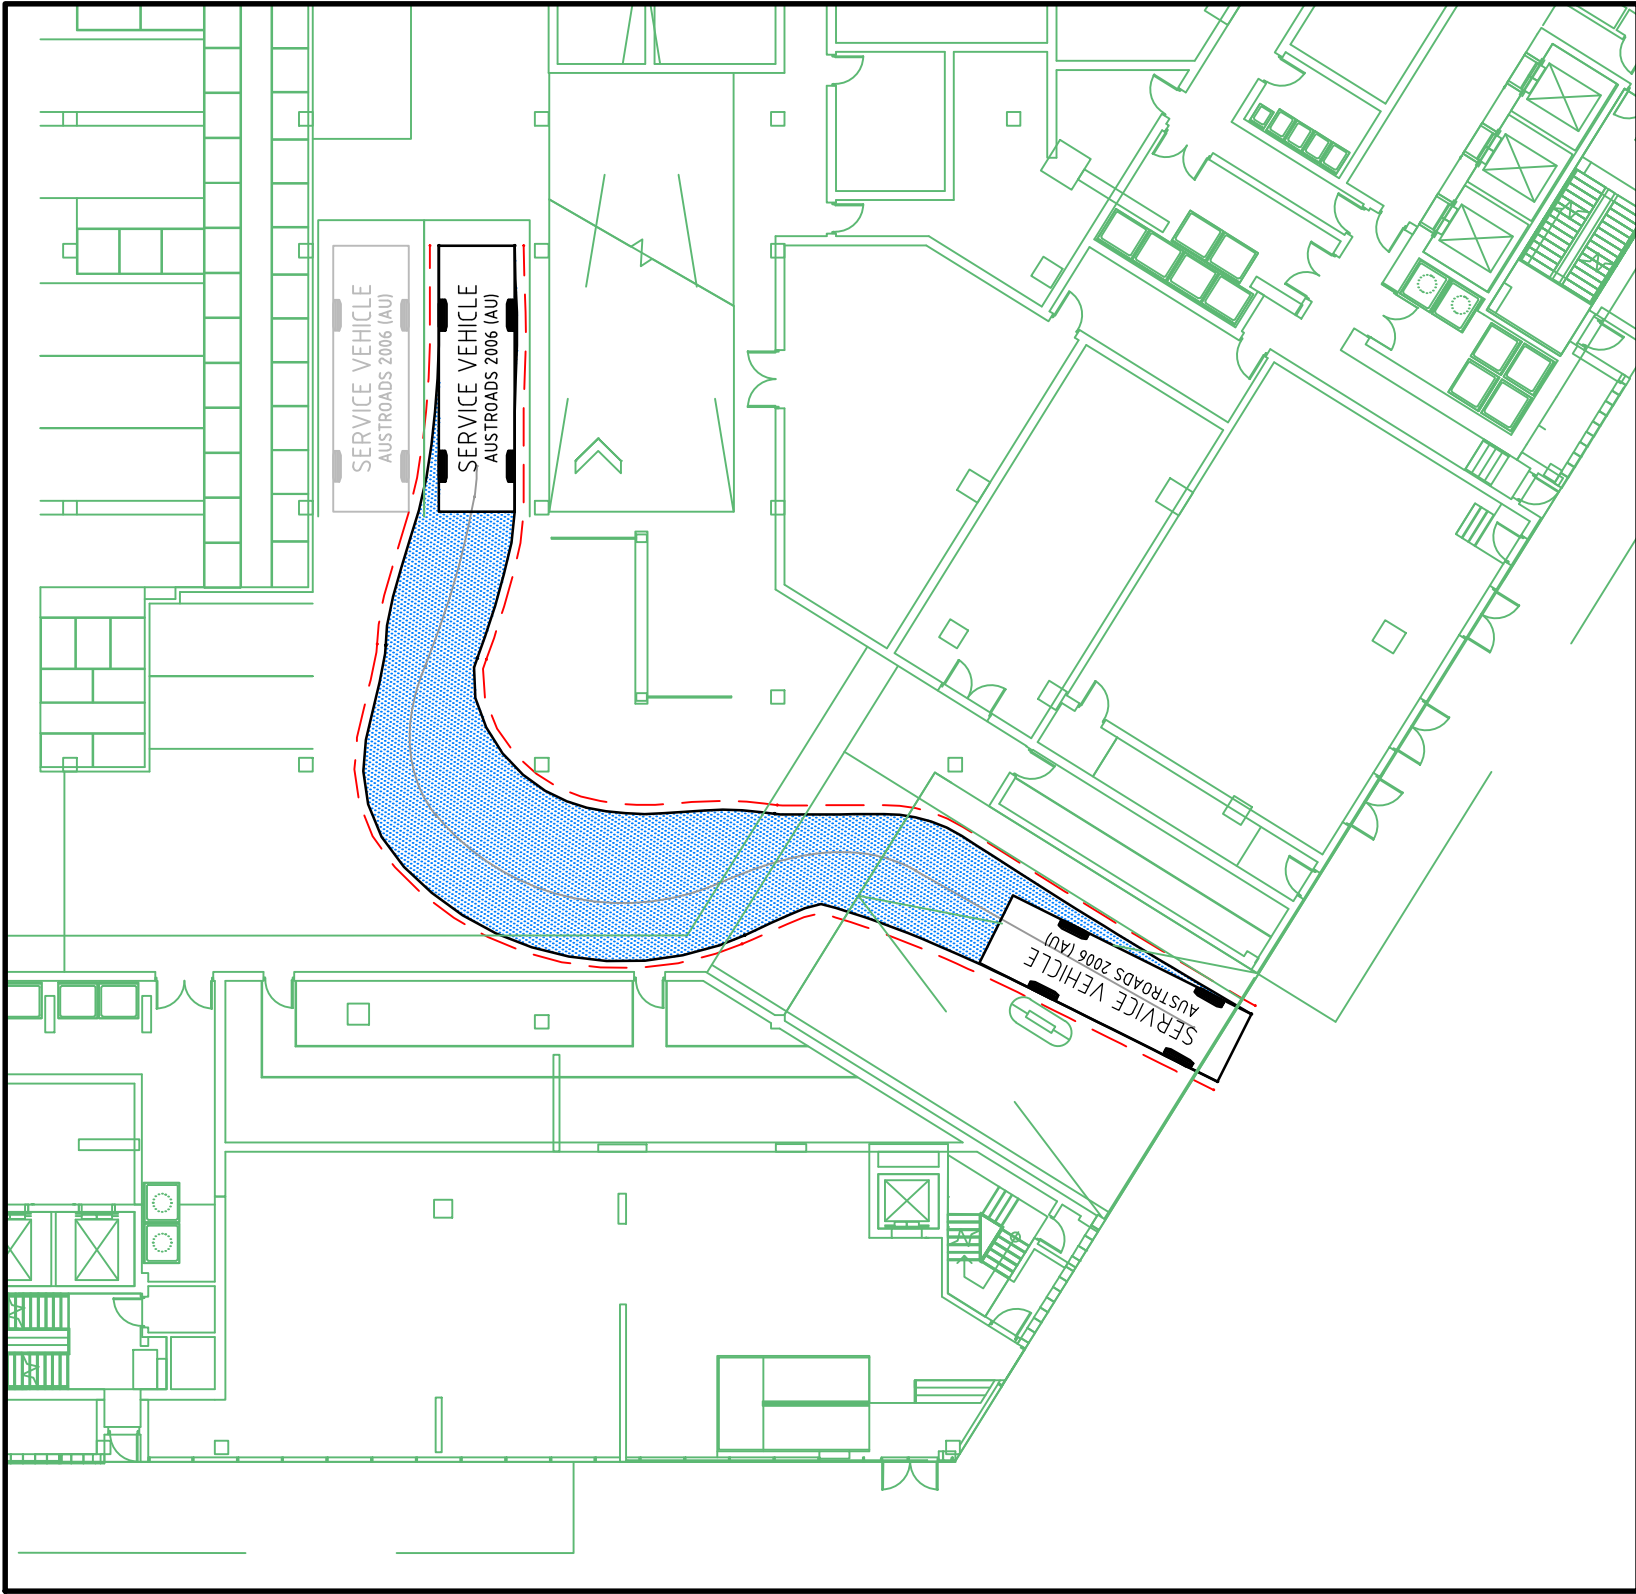


AUSTRADS 2006 8.8m SERVICE VEHICLE (MRV) - 02 OUT @ 5km/hr  
1 : 250

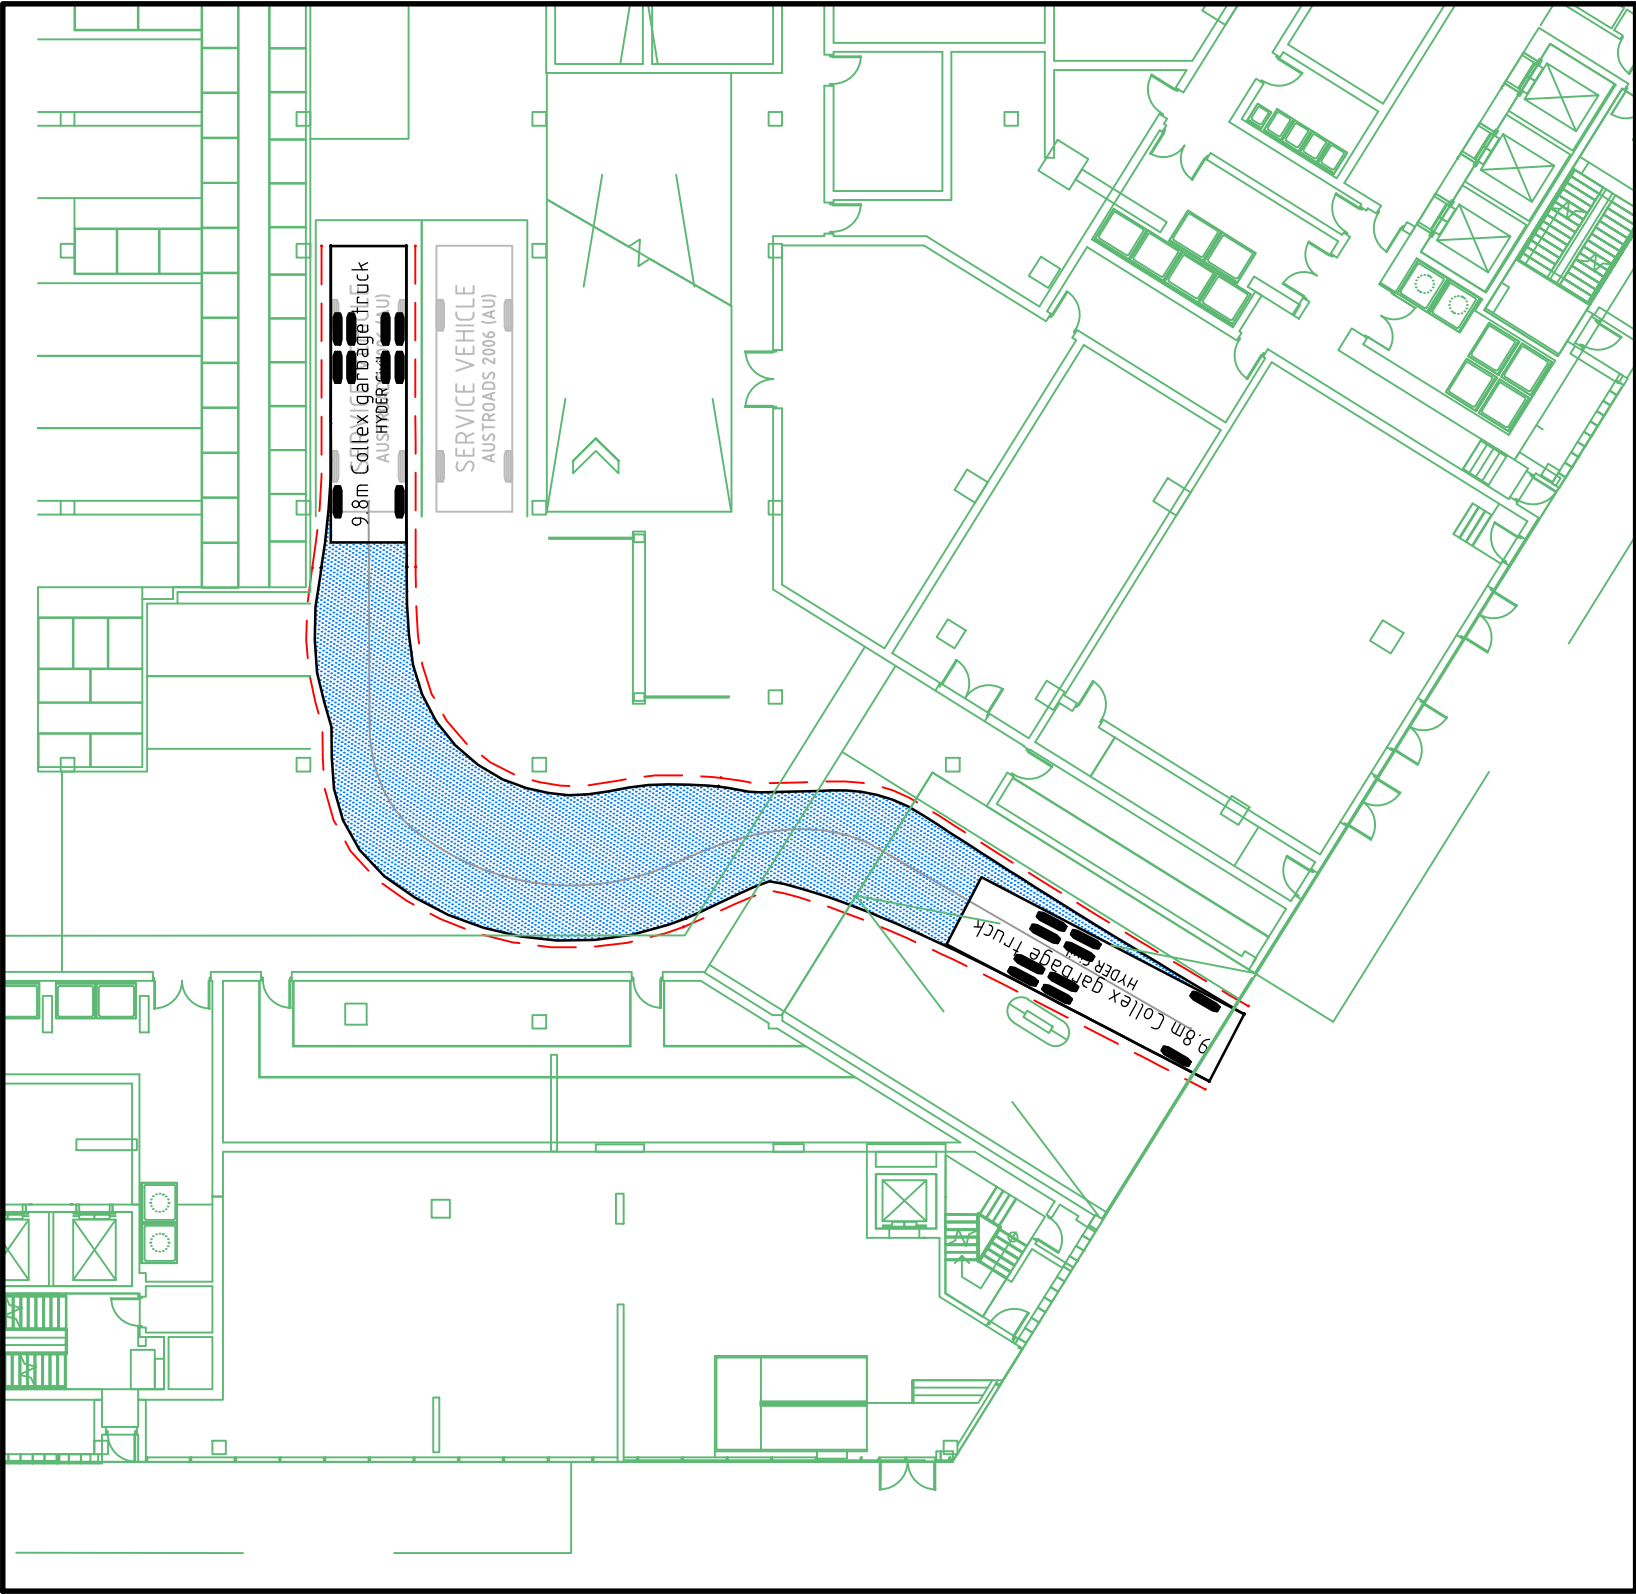


HYDER CIVIL 9.8m GARBAGE TRUCK - 01 OUT @ 5km/hr  
1 : 250

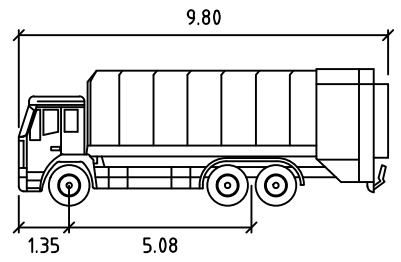

9.8m garbage truck meters  
Width : 2.50  
Track : 2.30  
Lock to Lock Time : 6.0  
Steering Angle : 38.0

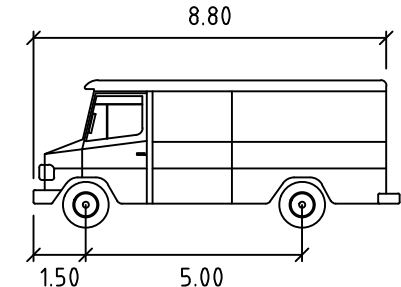


SERVICE VEHICLE meters  
Width : 2.50  
Track : 2.50  
Lock to Lock Time : 6.0  
Steering Angle : 38.7

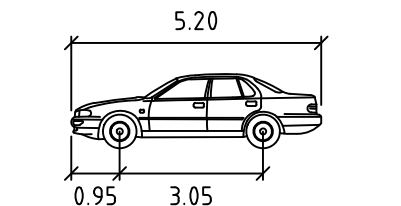

CAR meters  
Width : 1.94  
Track : 1.84  
Lock to Lock Time : 6.0  
Steering Angle : 33.5


DARLING HARBOUR LIVE

REFERENCE MAP

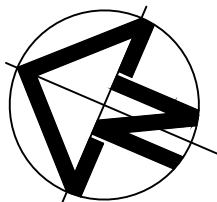

NOTES:

- DO NOT SCALE FROM DRAWINGS. WORK TO WRITTEN DIMENSIONS ONLY.
- ALL DIMENSIONS IN METRES UNLESS NOTED OTHERWISE.
- ALL COORDINATES TO MGA. ALL LEVELS TO AHD.
- ALL DIMENSIONS, COORDINATES AND LEVELS TO BE VERIFIED ON SITE BEFORE PROCEEDING WITH WORK. HYDER SHALL BE NOTIFIED IN WRITING OF ANY DISCREPANCIES.
- THIS DRAWING MUST BE READ IN CONJUNCTION WITH ALL RELEVANT CONTRACTS, SPECIFICATIONS AND DRAWINGS.

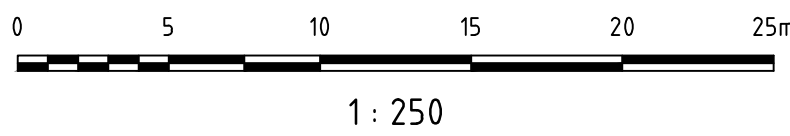

DRAFT

REV	DESCRIPTION	DATE
03	AMENDED AS PER CLIENT REQUEST	18/02/2014
02	DRAFT ISSUE	01/05/2013
01	DRAFT ISSUE	24/04/2013

CLIENT

**Lend Lease** LEND LEASE BUILDING PTY. LTD.  
LEVEL 4, THE BOND, 30 HICKSON RD  
MILLERS POINT, NSW 2000

CONSULTANTS

**HASSELL + POPULOUS** LANDSCAPE ARCHITECT  
LEVEL 2, 88 CUMBERLAND STREET,  
SYDNEY NSW 2000

**DENTON ARCHITECT**  
49 EXHIBITION STREET,  
MELBOURNE VICTORIA 3000

CIVIL / TRAFFIC / FACADES

**HYDER CONSULTING PTY LTD**  
ABN 76 104 485 289  
LEVEL 5, 141 WALKER ST,  
NORTH SYDNEY NSW 2060  
AUSTRALIA

Tel: +61 (0)2 8907 9000  
Fax: +61 (0)2 8907 9001  
www.hyderconsulting.com  
© Copyright reserved

PROJECT

**SICEP - DARLING HARBOUR  
HAYMARKET (PDA)  
SOUTH WEST PLOT**



DRAWING TITLE


**TURNING PATHS  
LOADING DOCK PLAN**

STATUS

**PRELIMINARY ONLY**

SCALE @ A1	DRAWN	DESIGNED	REVIEWED	APPROVED
1 : 250	RD	KM		
PROJECT NUMBER	DRAWING NUMBER	REV		
AA004399	PD-CI-3901	03		



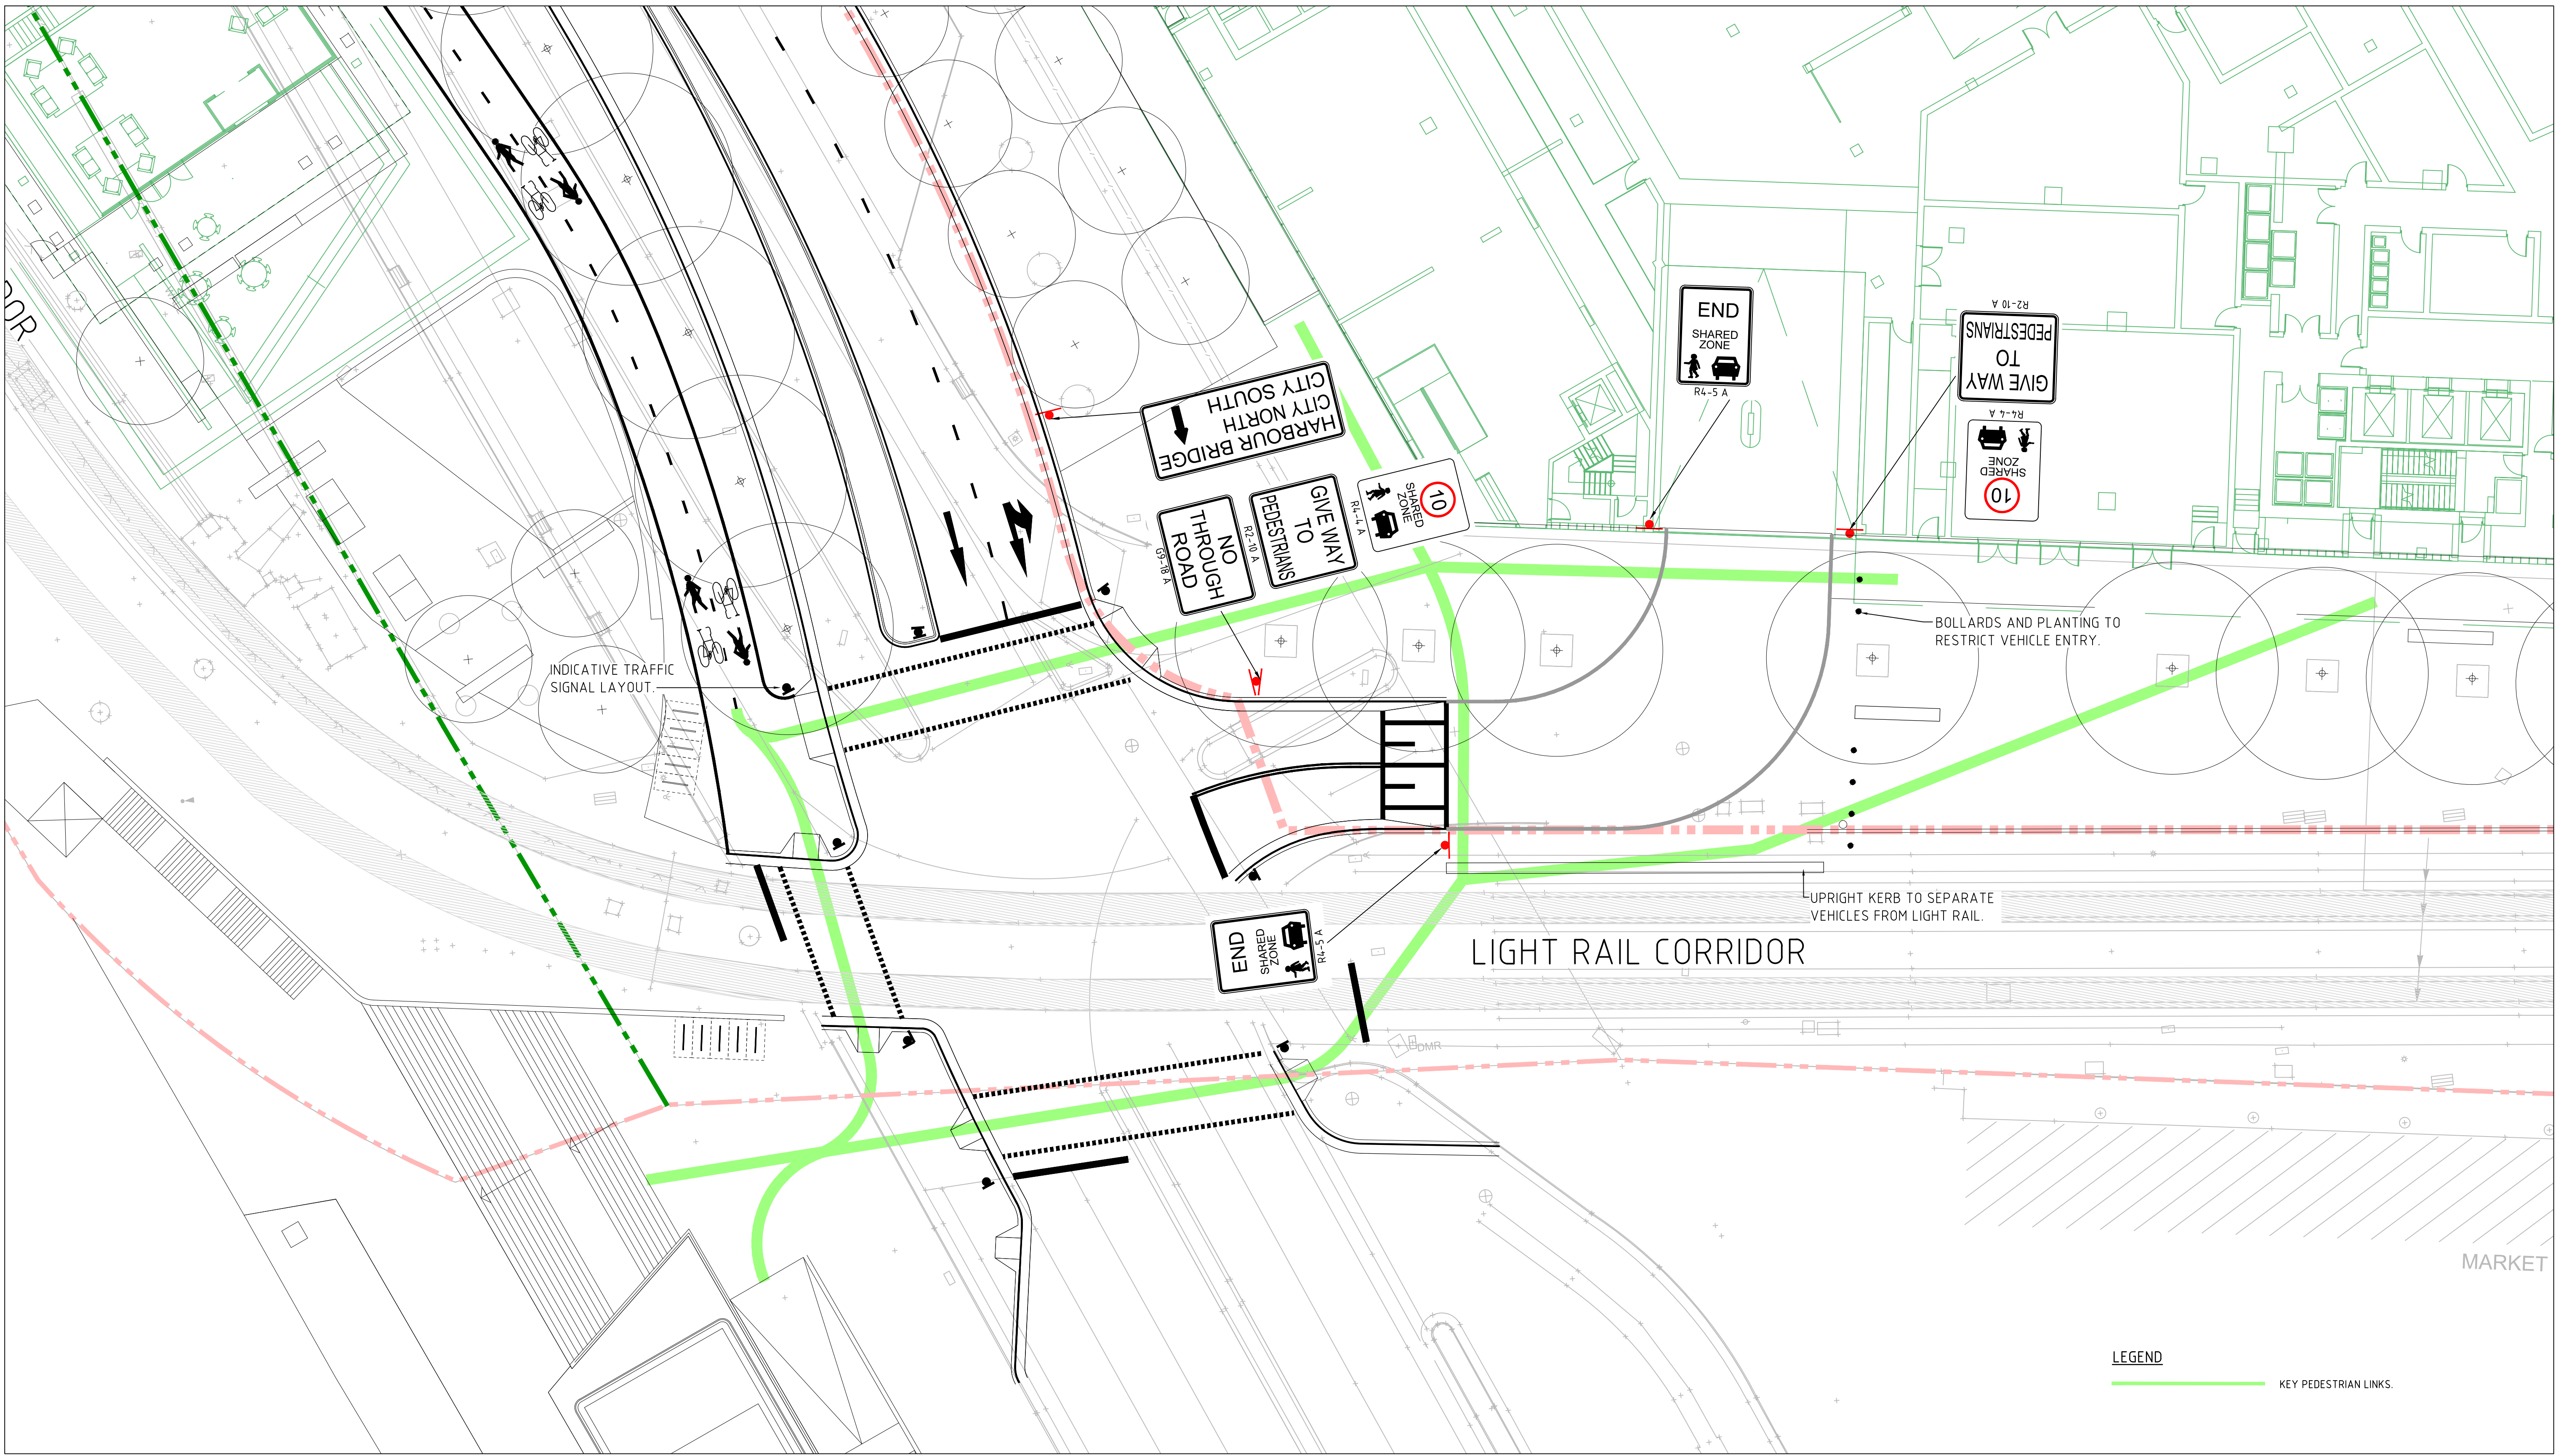

DARLING HARBOUR LIVE

REFERENCE MAP

**NOTES:**

- DO NOT SCALE FROM DRAWINGS. WORK TO WRITTEN DIMENSIONS ONLY.
- ALL DIMENSIONS IN METRES UNLESS NOTED OTHERWISE.
- ALL COORDINATES TO MGA. ALL LEVELS TO AHD.
- ALL DIMENSIONS, COORDINATES AND LEVELS TO BE VERIFIED ON SITE BEFORE PROCEEDING WITH WORK. HYDER SHALL BE NOTIFIED IN WRITING OF ANY DISCREPANCIES.
- THIS DRAWING MUST BE READ IN CONJUNCTION WITH ALL RELEVANT CONTRACTS, SPECIFICATIONS AND DRAWINGS.

0 3 6 9 12 15m

1 : 150

REV	DESCRIPTION	DATE
07	TURNING HEAD REMOVED	27/02/2014
06	INDICATIVE PEDESTRIAN ROUTES ADDED	18/02/2014
05	SCALE AMENDED	18/02/2014
04	COORDINATED WITH LANDSCAPE ARCHITECT	17/02/2014
03	NO STOPPING SIGNS REMOVED	07/02/2014
02	ISSUE FOR INFORMATION	31/01/2014
01	ISSUE FOR INFORMATION	30/01/2014

CLIENT

**Lend Lease** LEND LEASE BUILDING PTY. LTD.  
LEVEL 4, THE BOND, 30 HICKSON RD  
MILLERS POINT, NSW 2000

CONSULTANTS

**HASSELL + POPULOUS** LANDSCAPE ARCHITECT  
LEVEL 2, 88 CUMBERLAND STREET,  
SYDNEY NSW 2000

**DENTON CORKER MARSHALL** ARCHITECT  
49 EXHIBITION STREET,  
MELBOURNE VICTORIA 3000

CIVIL / TRAFFIC / FACADES

**HYDER CONSULTING PTY LTD**  
ABN 76 104 485 289  
LEVEL 5, 141 WALKER ST,  
NORTH SYDNEY NSW 2060  
AUSTRALIA

Tel: +61 (0)2 8907 9000  
Fax: +61 (0)2 8907 9001  
www.hyderconsulting.com  
© Copyright reserved

PROJECT

**SICEP - DARLING HARBOUR  
HAYMARKET (PDA)  
SOUTH WEST PLOT**

DRAWING TITLE

**HAY STREET  
SHARED ZONE PLAN**


STATUS

**PRELIMINARY ONLY**

SCALE @ A1	DRAWN	DESIGNED	REVIEWED	APPROVED
1 : 150	JJB	MK		


PROJECT NUMBER	DRAWING NUMBER	REV
AA004399	SKCPD095	07



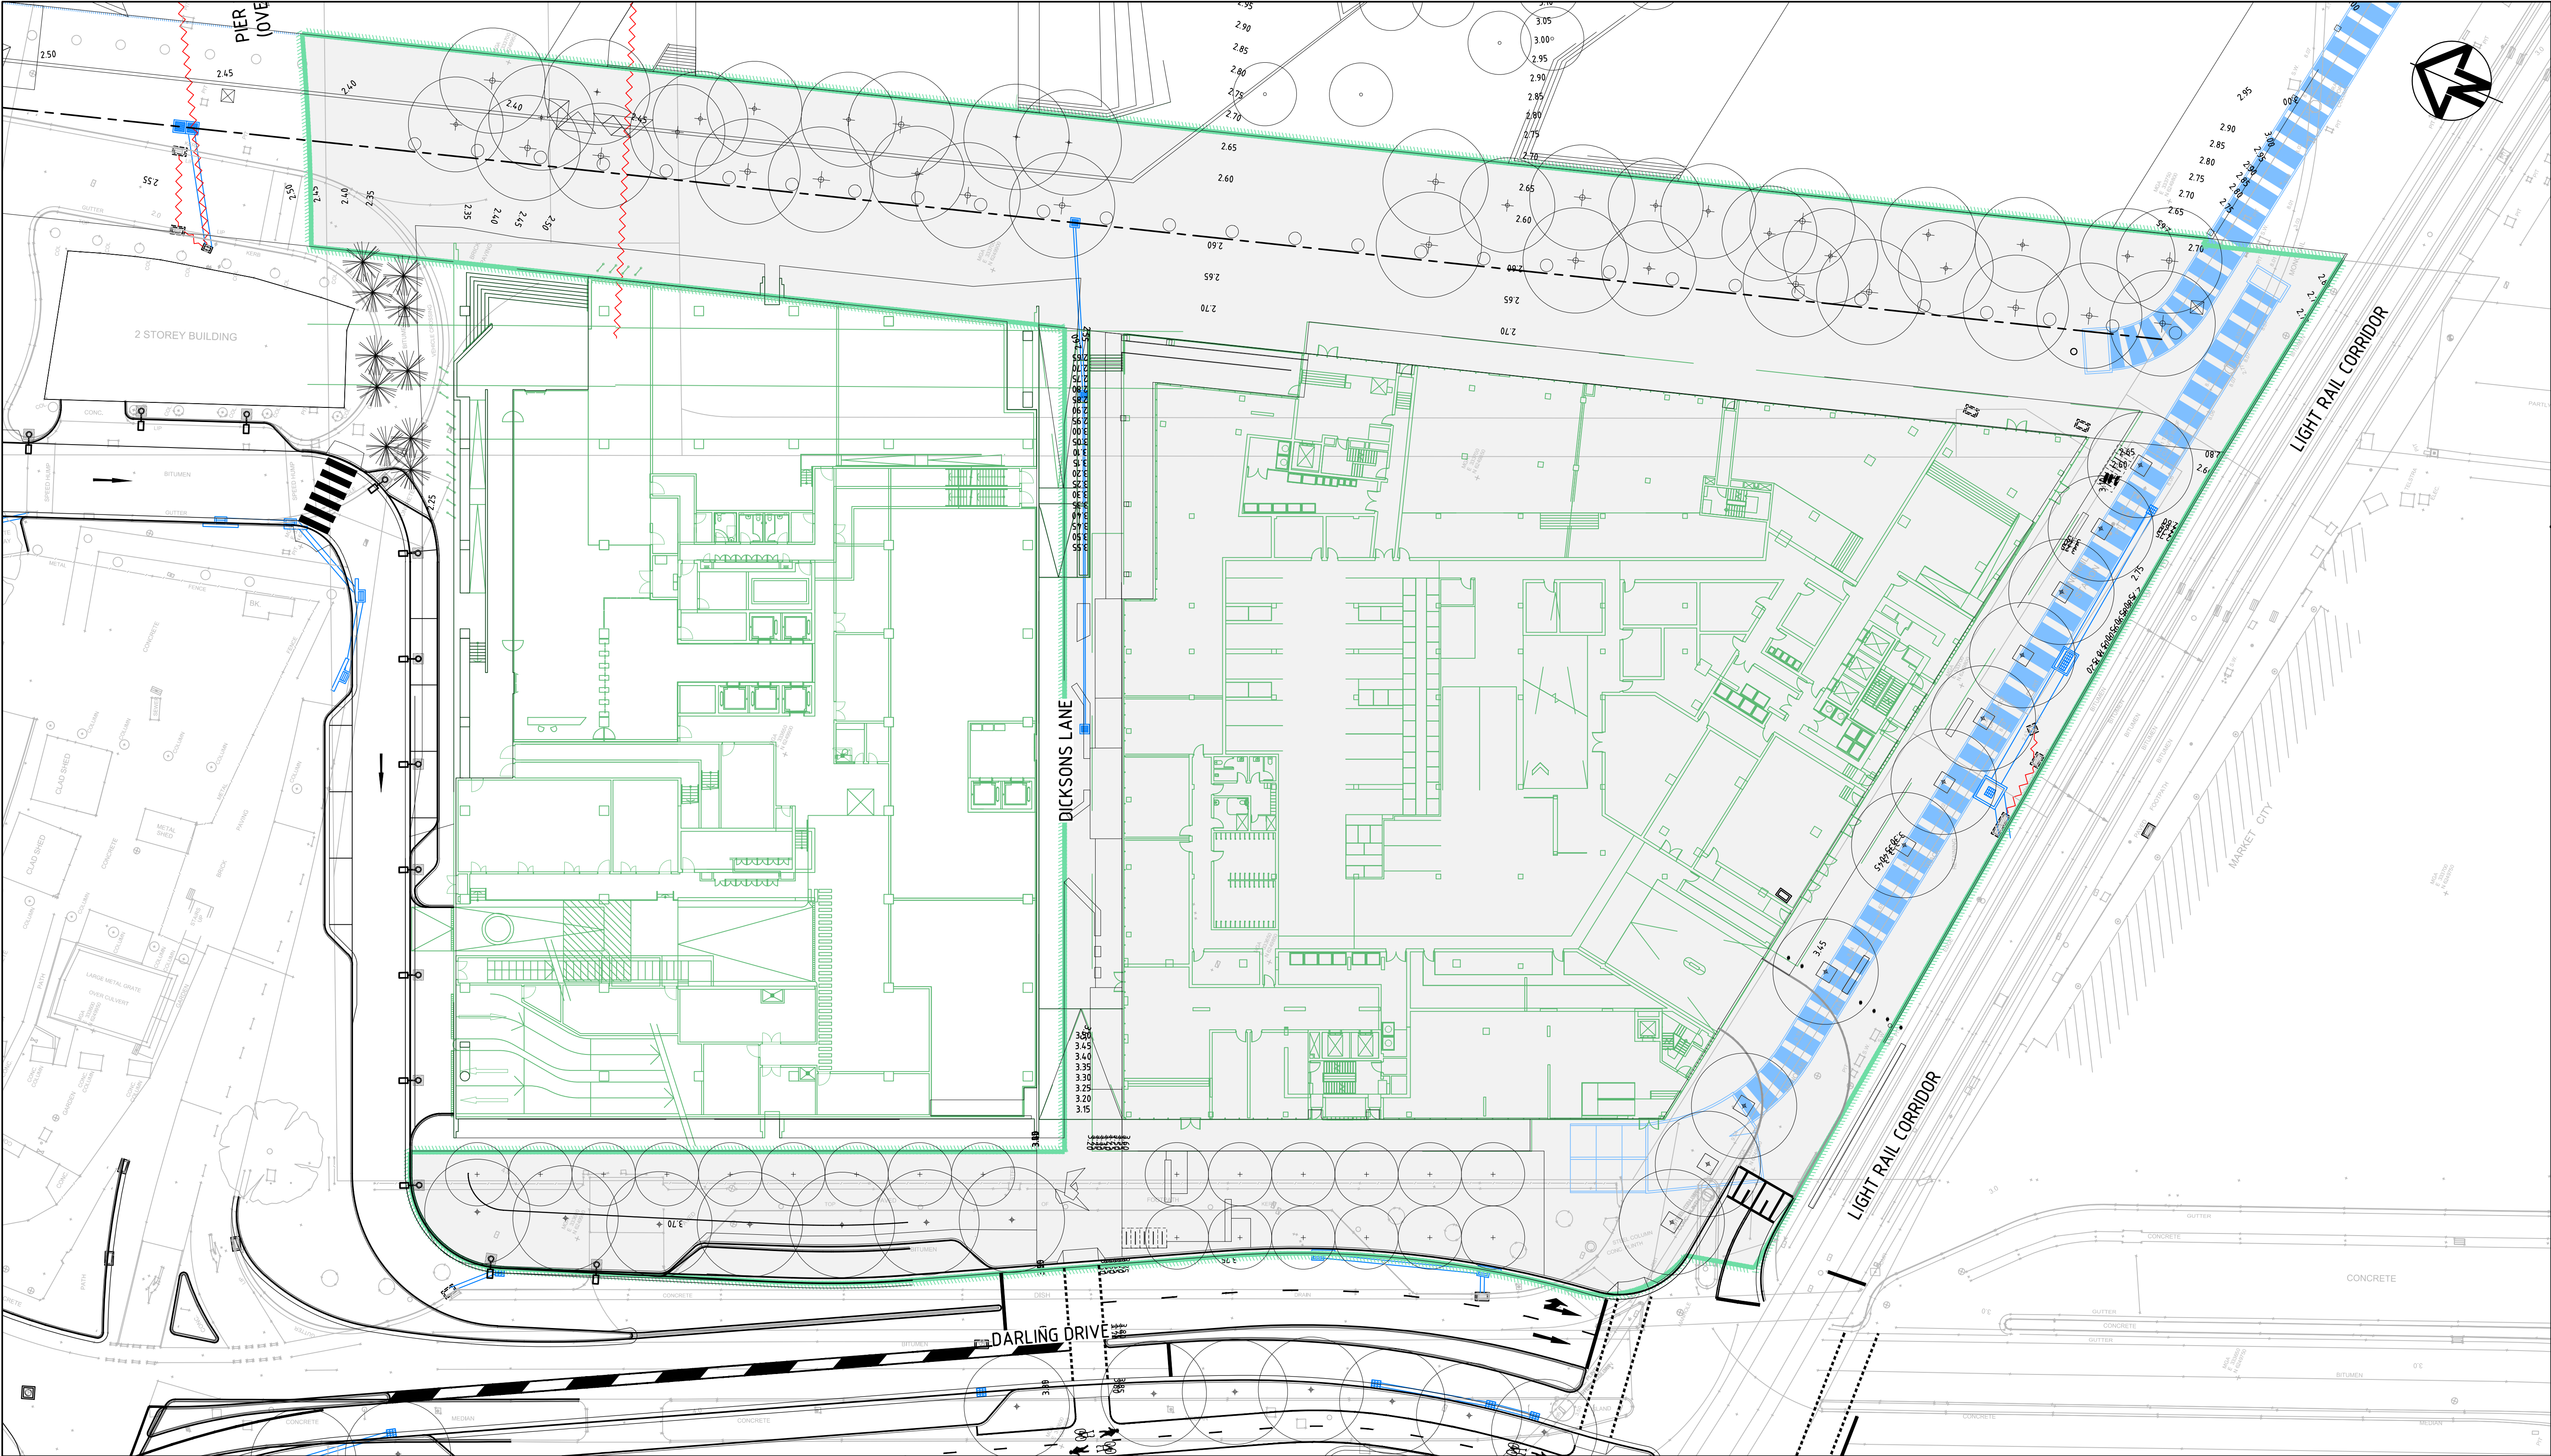


DARLING HARBOUR LIVE

REFERENCE MAP

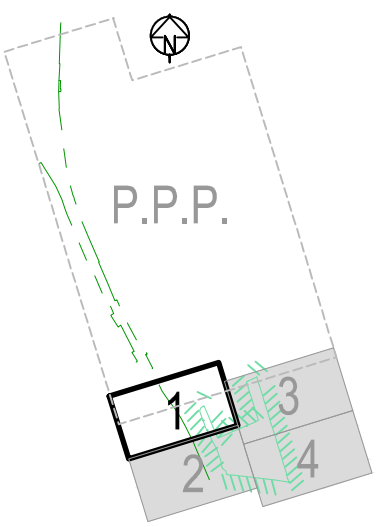

NOTES:

- DO NOT SCALE FROM DRAWINGS. WORK TO WRITTEN DIMENSIONS ONLY.
- ALL DIMENSIONS IN METRES UNLESS NOTED OTHERWISE.
- ALL COORDINATES TO MGA. ALL LEVELS TO AHD.
- ALL DIMENSIONS, COORDINATES AND LEVELS TO BE VERIFIED ON SITE BEFORE PROCEEDING WITH WORK. HYDER SHALL BE NOTIFIED IN WRITING OF ANY DISCREPANCIES.
- THIS DRAWING MUST BE READ IN CONJUNCTION WITH ALL RELEVANT CONTRACTS, SPECIFICATIONS AND DRAWINGS.

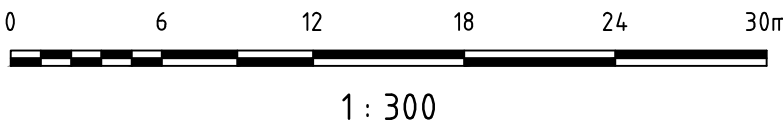

REV	DESCRIPTION	DATE
03	HAY STREET AMENDED	27/02/2014
02	HAY STREET AMENDED	18/02/2014
01	ISSUE FOR REVIEW	03/02/14

CLIENT

**Lend Lease** LEND LEASE BUILDING PTY. LTD.  
LEVEL 4, THE BOND, 30 HICKSON RD  
MILLERS POINT, NSW 2000

CONSULTANTS

**HASSELL + POPULOUS** LANDSCAPE ARCHITECT  
LEVEL 2, 88 CUMBERLAND STREET,  
SYDNEY NSW 2000

**DENTON ARCHITECT**  
49 EXHIBITION STREET,  
**MARSHALL** MELBOURNE VICTORIA 3000

CIVIL / TRAFFIC / FACADES

**HYDER CONSULTING PTY LTD**  
ABN 76 104 485 289  
LEVEL 5, 141 WALKER ST,  
NORTH SYDNEY NSW 2060  
AUSTRALIA

Tel: +61 (0)2 8907 9000  
Fax: +61 (0)2 8907 9001  
www.hyderconsulting.com  
© Copyright reserved

PROJECT

**SICEEP - DARLING HARBOUR  
HAYMARKET (PDA)  
SOUTH WEST PLOT**



DRAWING TITLE

**SOUTH WEST  
BUILDING**

STATUS

**PRELIMINARY ONLY**

SCALE @ A1

**1 : 300**

PROJECT NUMBER  
**AA004399**

DRAWN

**MBK**

DRAWING NUMBER  
**SKCPD096**

DESIGNED

**MBK**

REVIEWED

**03**

Original Sheet Size A1 - 841 x 594mm