


Appendix C – Proposed expansion plans

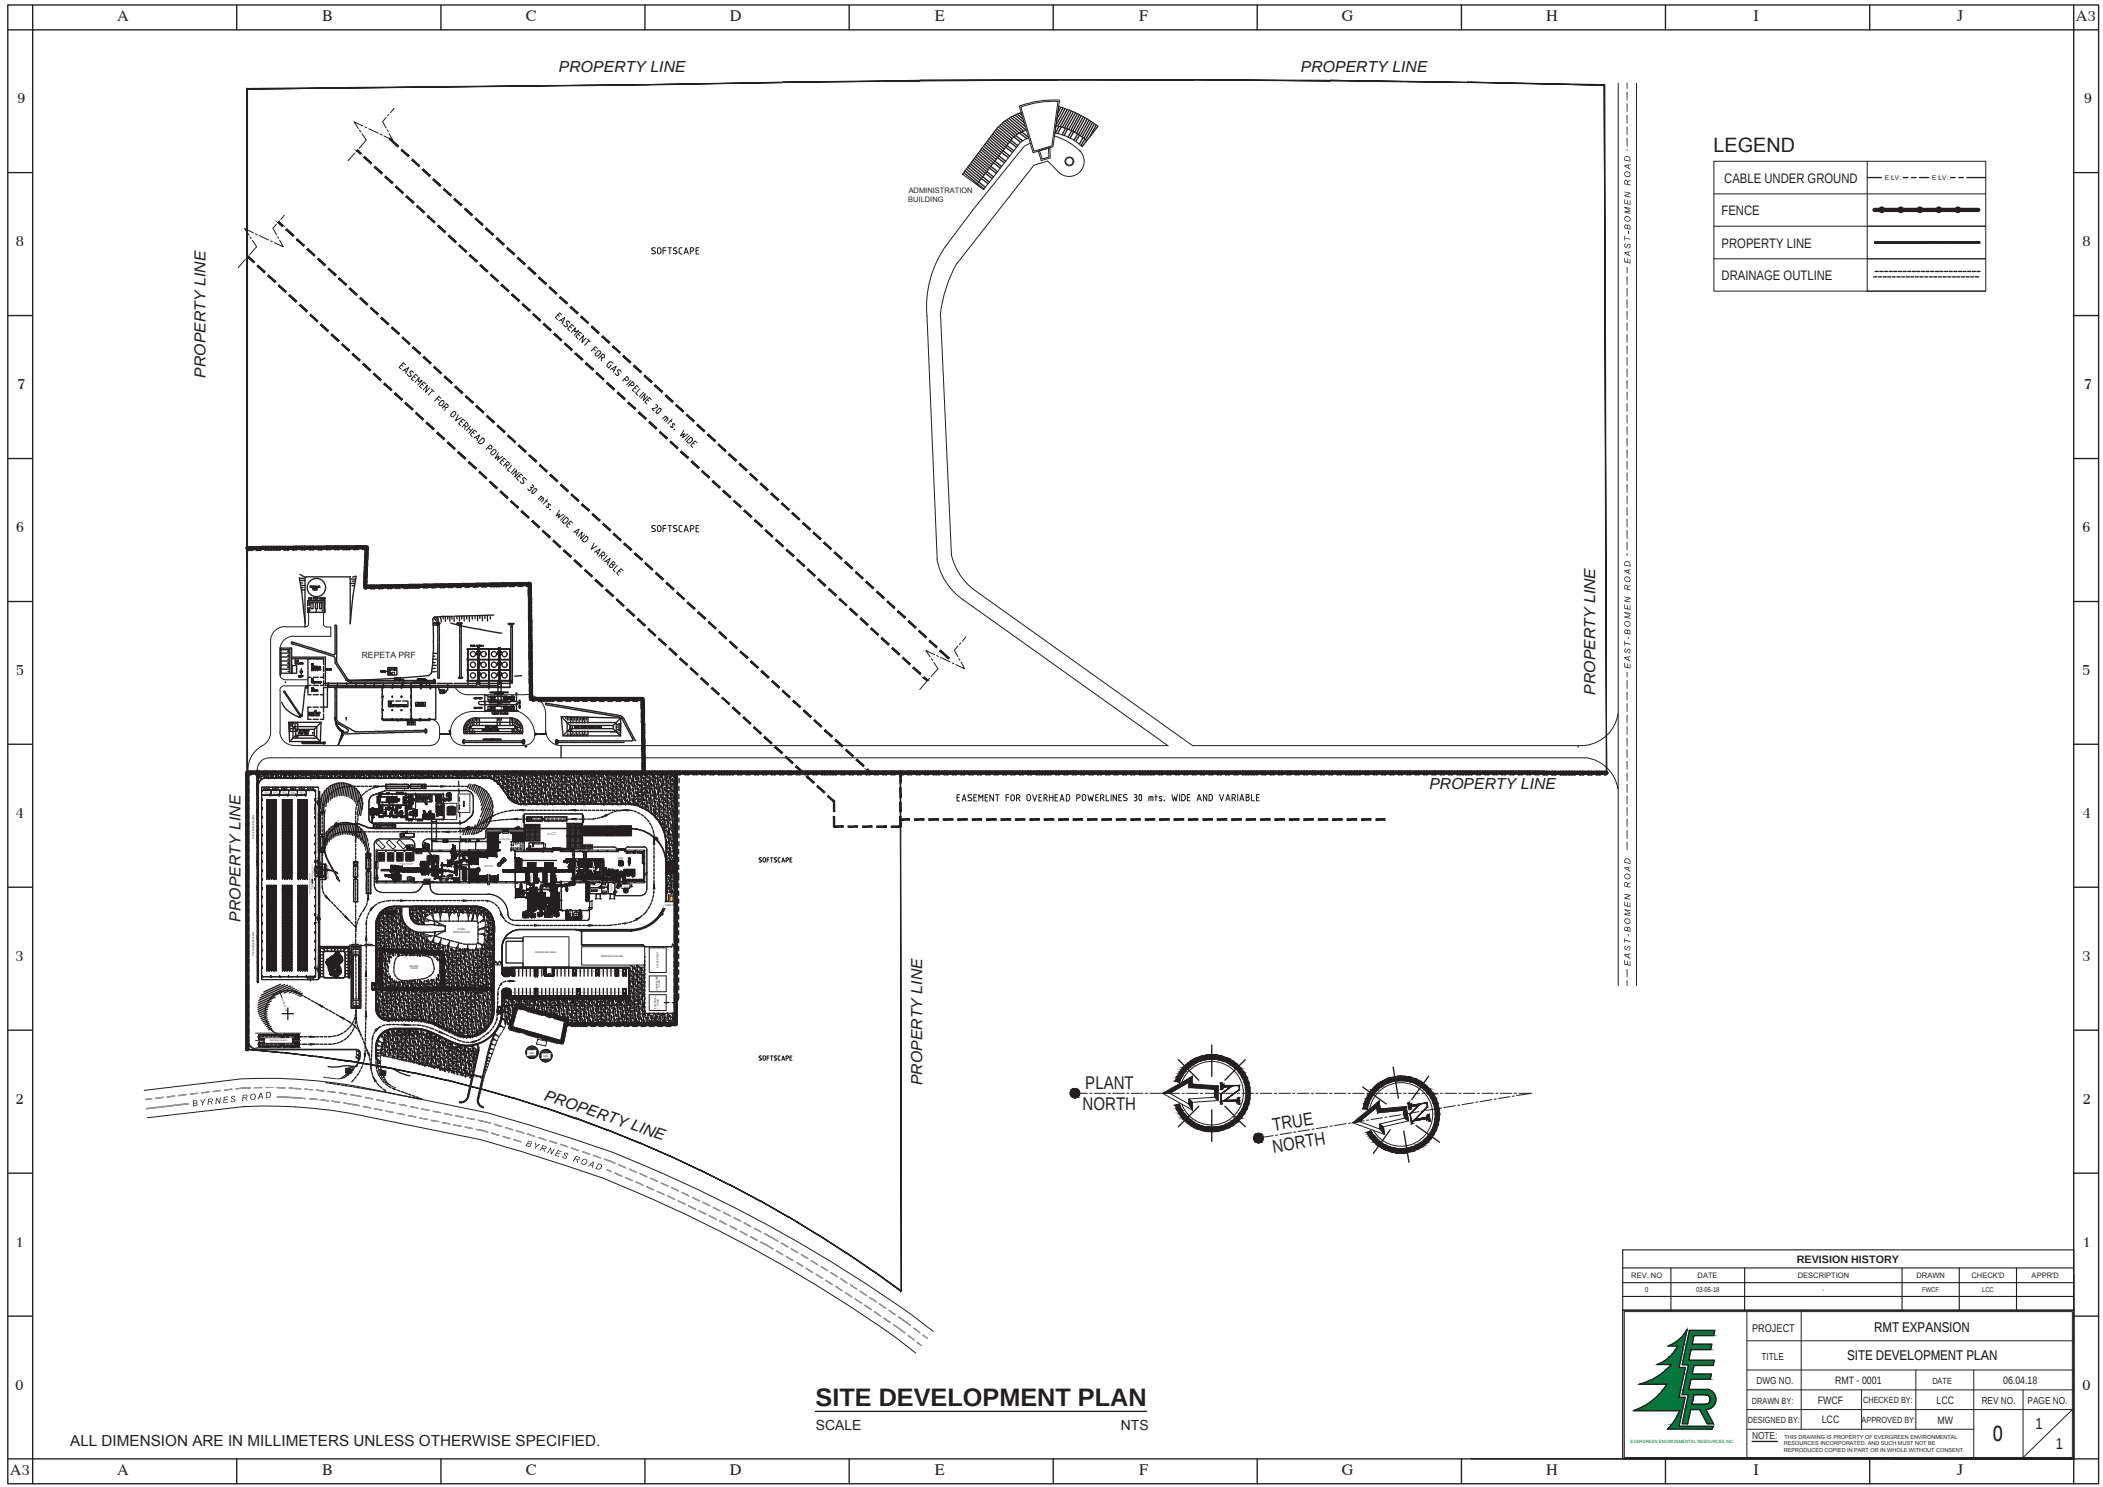


LEGEND


CABLE UNDER GROUND	— ELV — ELV —
FENCE	— — — — —
PROPERTY LINE	— — — — —
DRAINAGE OUTLINE	— — — — —

REVISION HISTORY					
REV. NO.	DATE	DESCRIPTION	DRAWN	CHECKED	APPROD.
0	03-05-18		FWCF	LCC	
PROJECT		RMT EXPANSION			
TITLE		SITE DEVELOPMENT PLAN			
DWG NO.	RMT - 0001	DATE	06.04.18		
DRAWN BY:	FWCF	CHECKED BY:	LCC	REV NO.	PAGE NO.
DESIGNED BY:	LCC	APPROVED BY:	MW	0	1
NOTE: THIS DRAWING IS PROPERTY OF EVERGREEN ENVIRONMENTAL. REPRODUCED IN WHOLE OR IN PART WITHOUT CONSENT.					

SITE DEVELOPMENT PLAN
SCALE NTS

ALL DIMENSION ARE IN MILLIMETERS UNLESS OTHERWISE SPECIFIED.

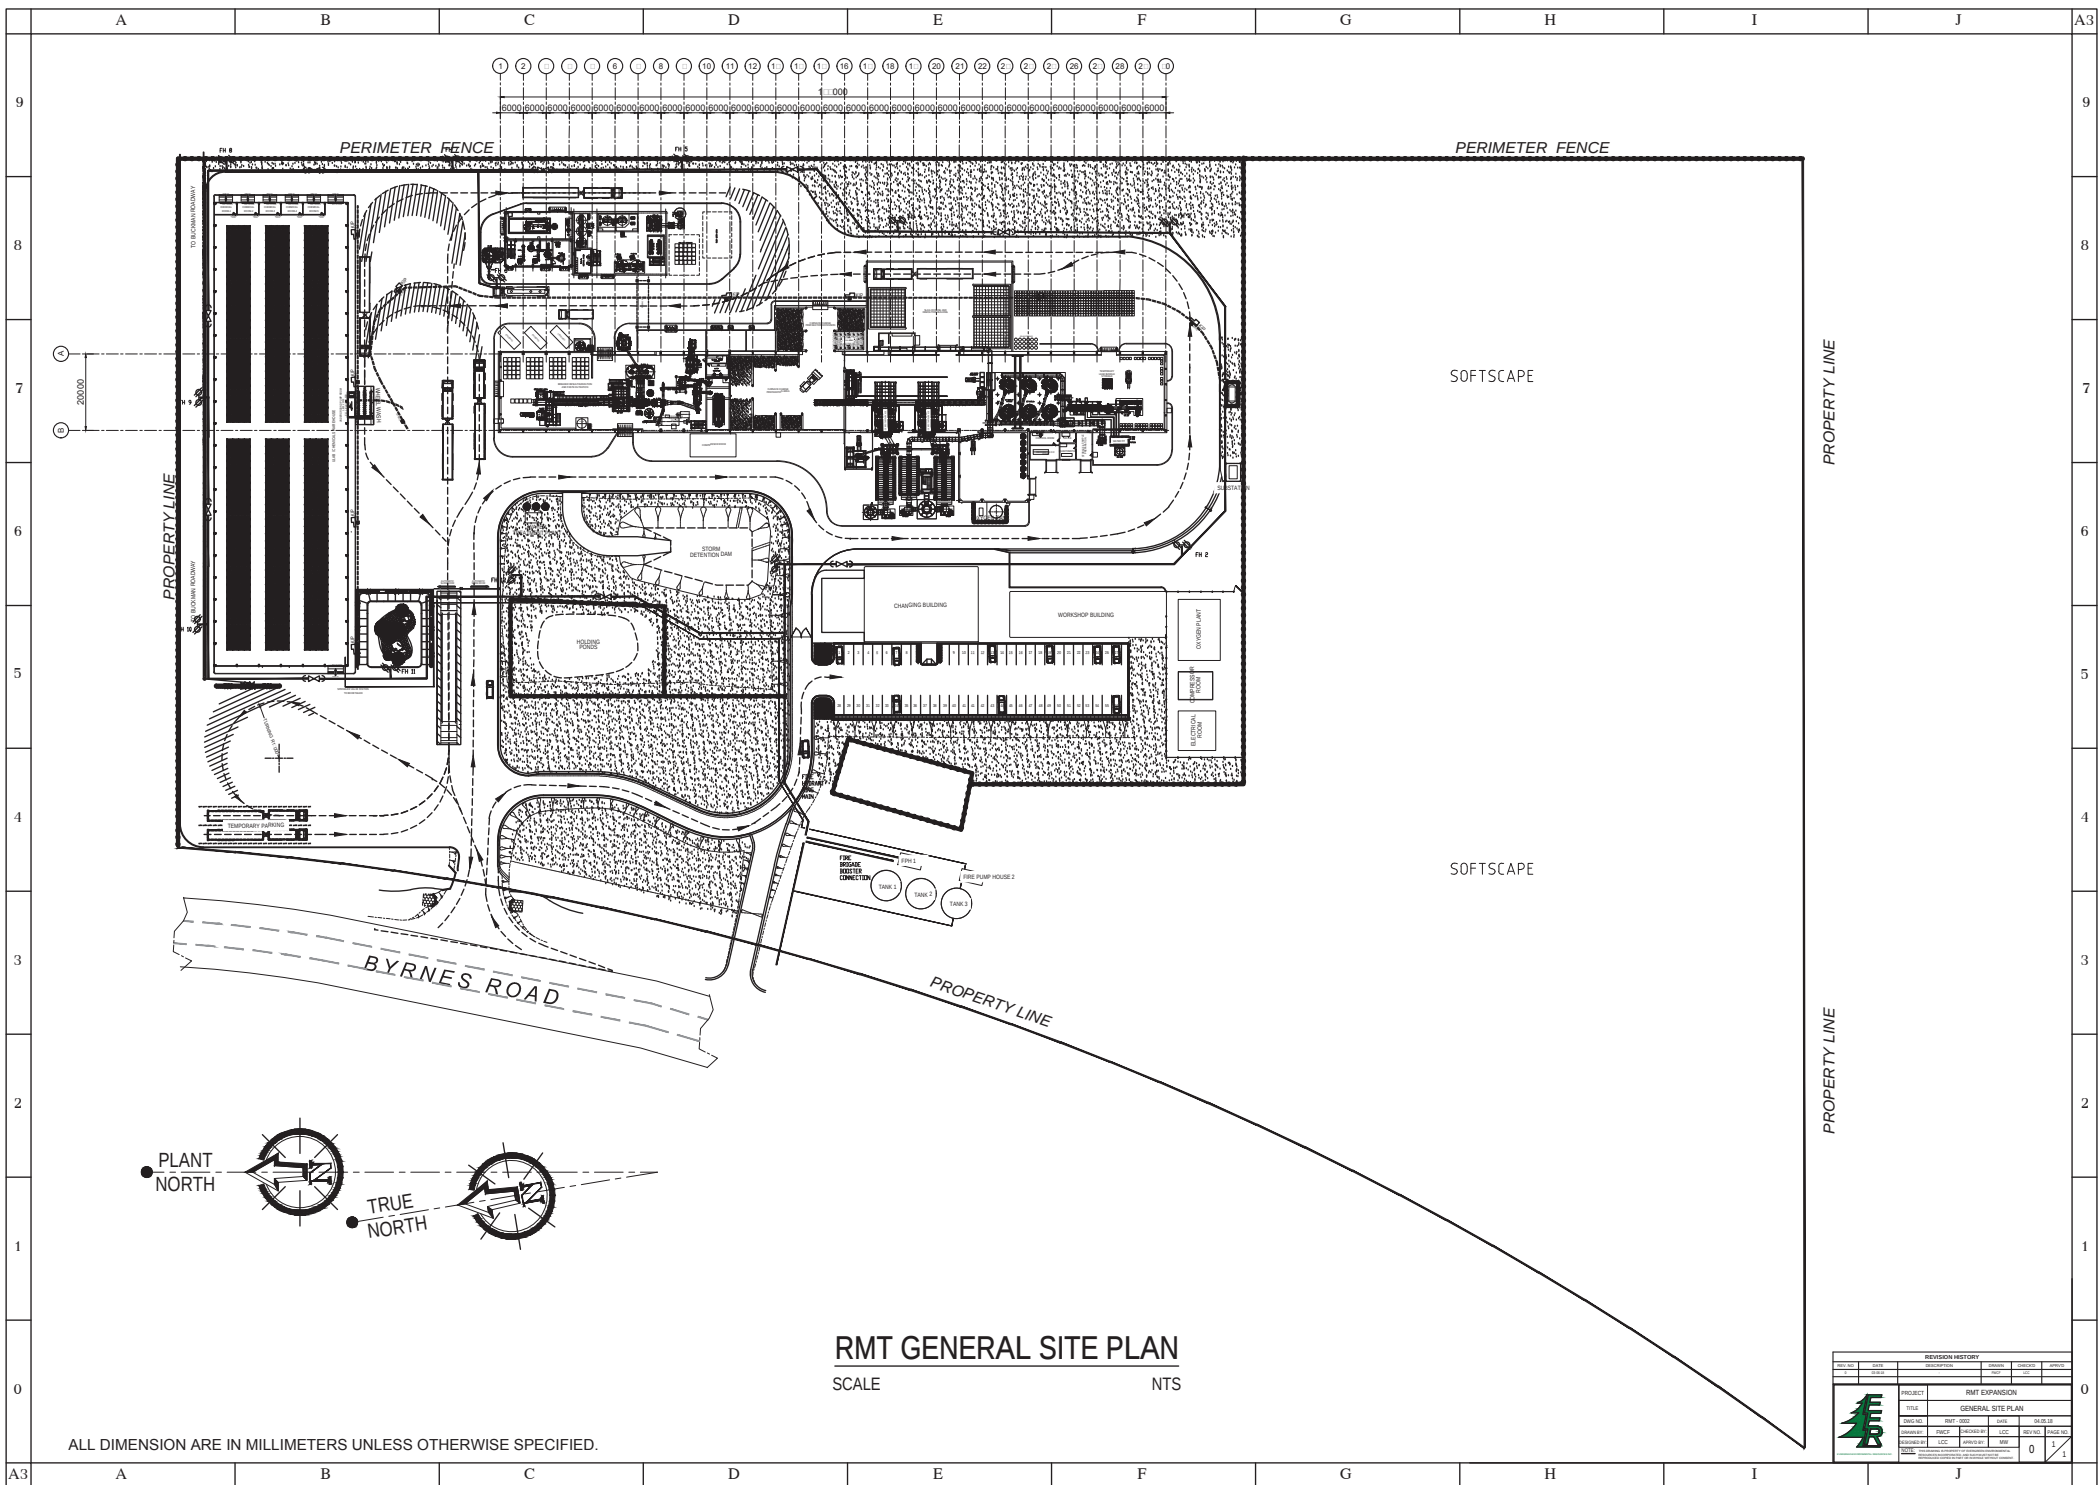

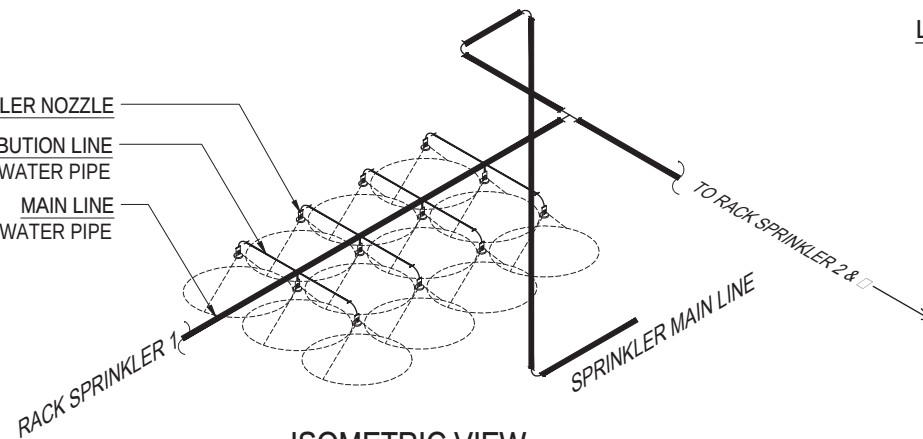

 - TEE JOINT
 - ELBOW 90°

SCALE	NTS
-------	-----




SCALE	NTS
-------	-----


ALL DIMENSION ARE IN MILLIMETERS UNLESS OTHERWISE SPECIFIED.

REVISION HISTORY					
REV. NO.	DATE	DESCRIPTION	DRAWN:	CHECKED:	APPROVED
0	03-18		FWC	LCC	


 ENVIRONMENTAL INVESTIGATIONS, REMEDIATION & RECONSTRUCTION	PROJECT		RMT EXPANSION			
	TITLE					FIRE WATER SYSTEM
	WDO NO.	RMT - 0014	DATE	03.18		
	DRAWN BY:	FWC	CHECKED BY:	LCC	REV NO.	PAGE NO.
	DESIGNED BY:	LCC	APPROVED BY:	MW		
	NOTES: THE PROJECT IS THE PROPERTY OF ENVIRONMENTAL INVESTIGATIONS, REMEDIATION & RECONSTRUCTION, AND IS NOT TO BE REPRODUCED OR TRANSMITTED IN ANY FORM OR BY ANY MEANS, ELECTRONIC OR MECHANICAL, WITHOUT PERMISSION IN WRITING FROM ENVIRONMENTAL INVESTIGATIONS, REMEDIATION & RECONSTRUCTION.					
			0 / 1			

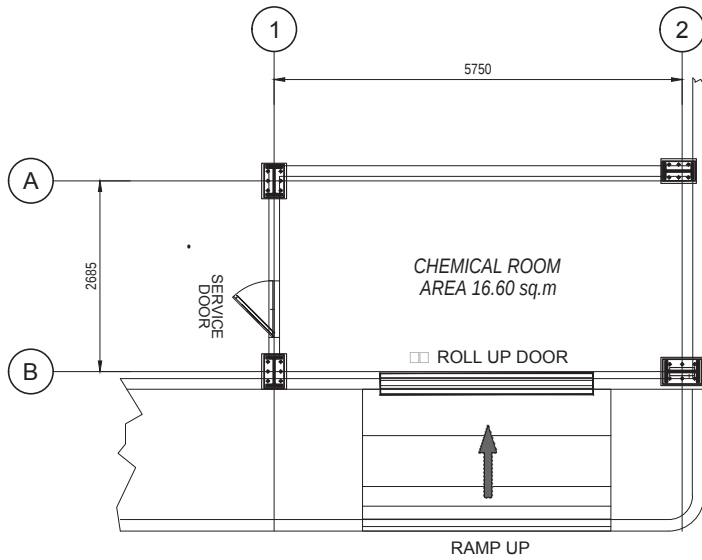


PLAN VIEW
SCALE NTS

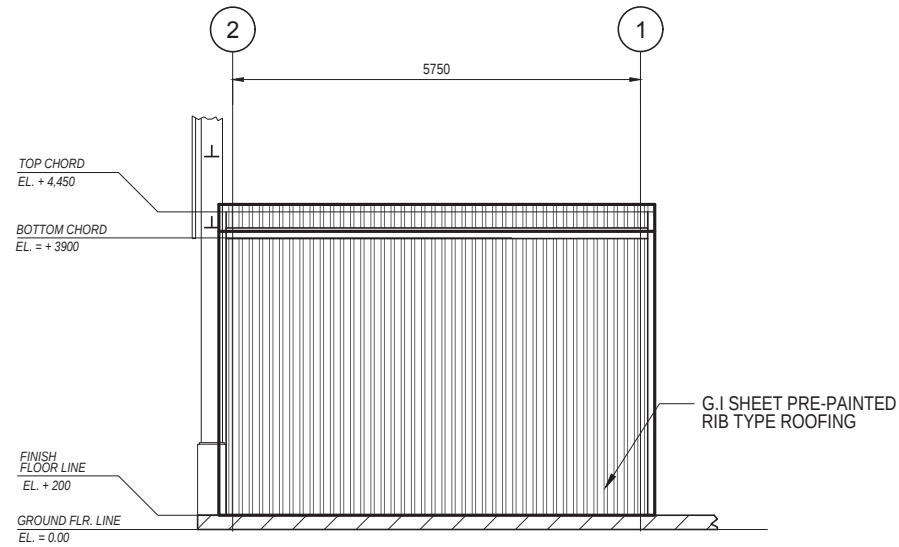


REAR ELEVATION
SCALE NTS

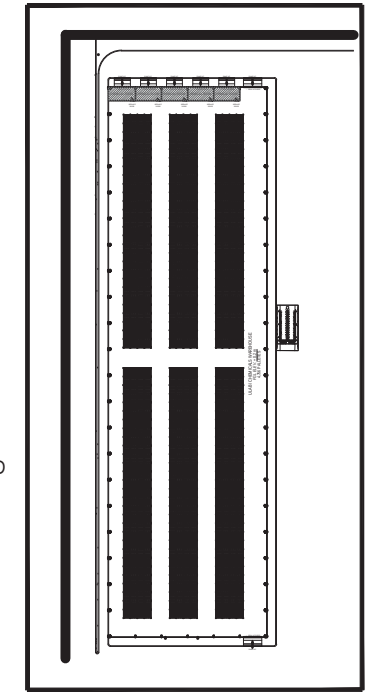

KEY MAP

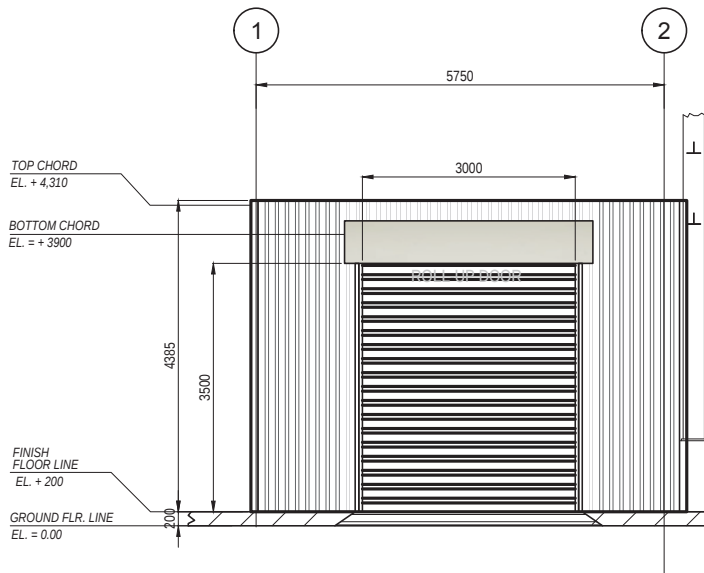

FRONT ELEVATION
SCALE NTS

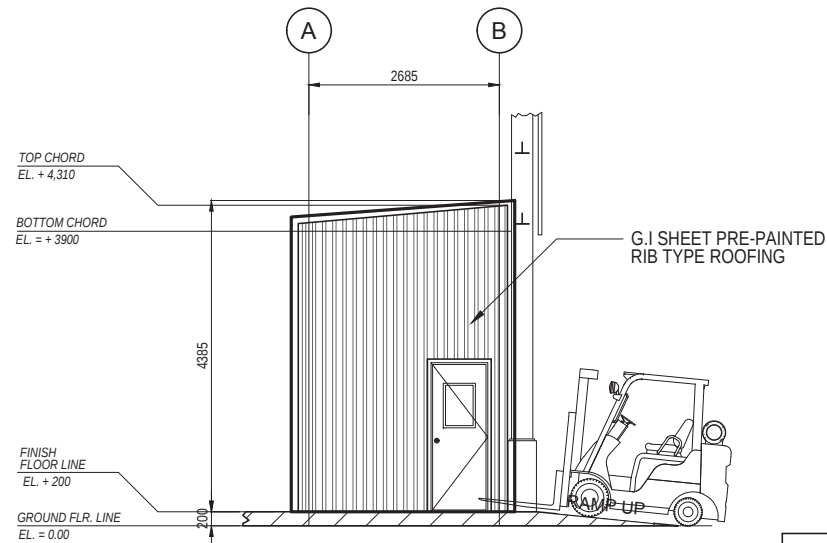

SIDE ELEVATION
SCALE NTS


**CHEMICAL ROOM
ELEVATIONS**

SCALE NTS


ALL DIMENSION ARE IN MILLIMETERS UNLESS OTHERWISE SPECIFIED.

REVISION HISTORY					
REV. NO	DATE	DESCRIPTION	DRAWN	CHECKD	APPRD
0	03-07-18		FWCF	LCC	


	PROJECT	RMT EXPANSION			
	TITLE	ULAB WAREHOUSE			
	DWG NO.	RMT - 0006	DATE	03.04.18	
	DRAWN BY:	FWCF	CHECKED BY:	LCC	
	DESIGNED BY:	LCC	APPROVED BY:	MW	
NOTE		THIS DRAWING IS PROPERTY OF EVERGREEN ENVIRONMENTAL RESOURCES INCORPORATED AND SHALL NOT BE REPRODUCED COPIED IN PART OR IN WHOLE WITHOUT CONSENT.			
		REV NO.	0	PAGE NO.	3

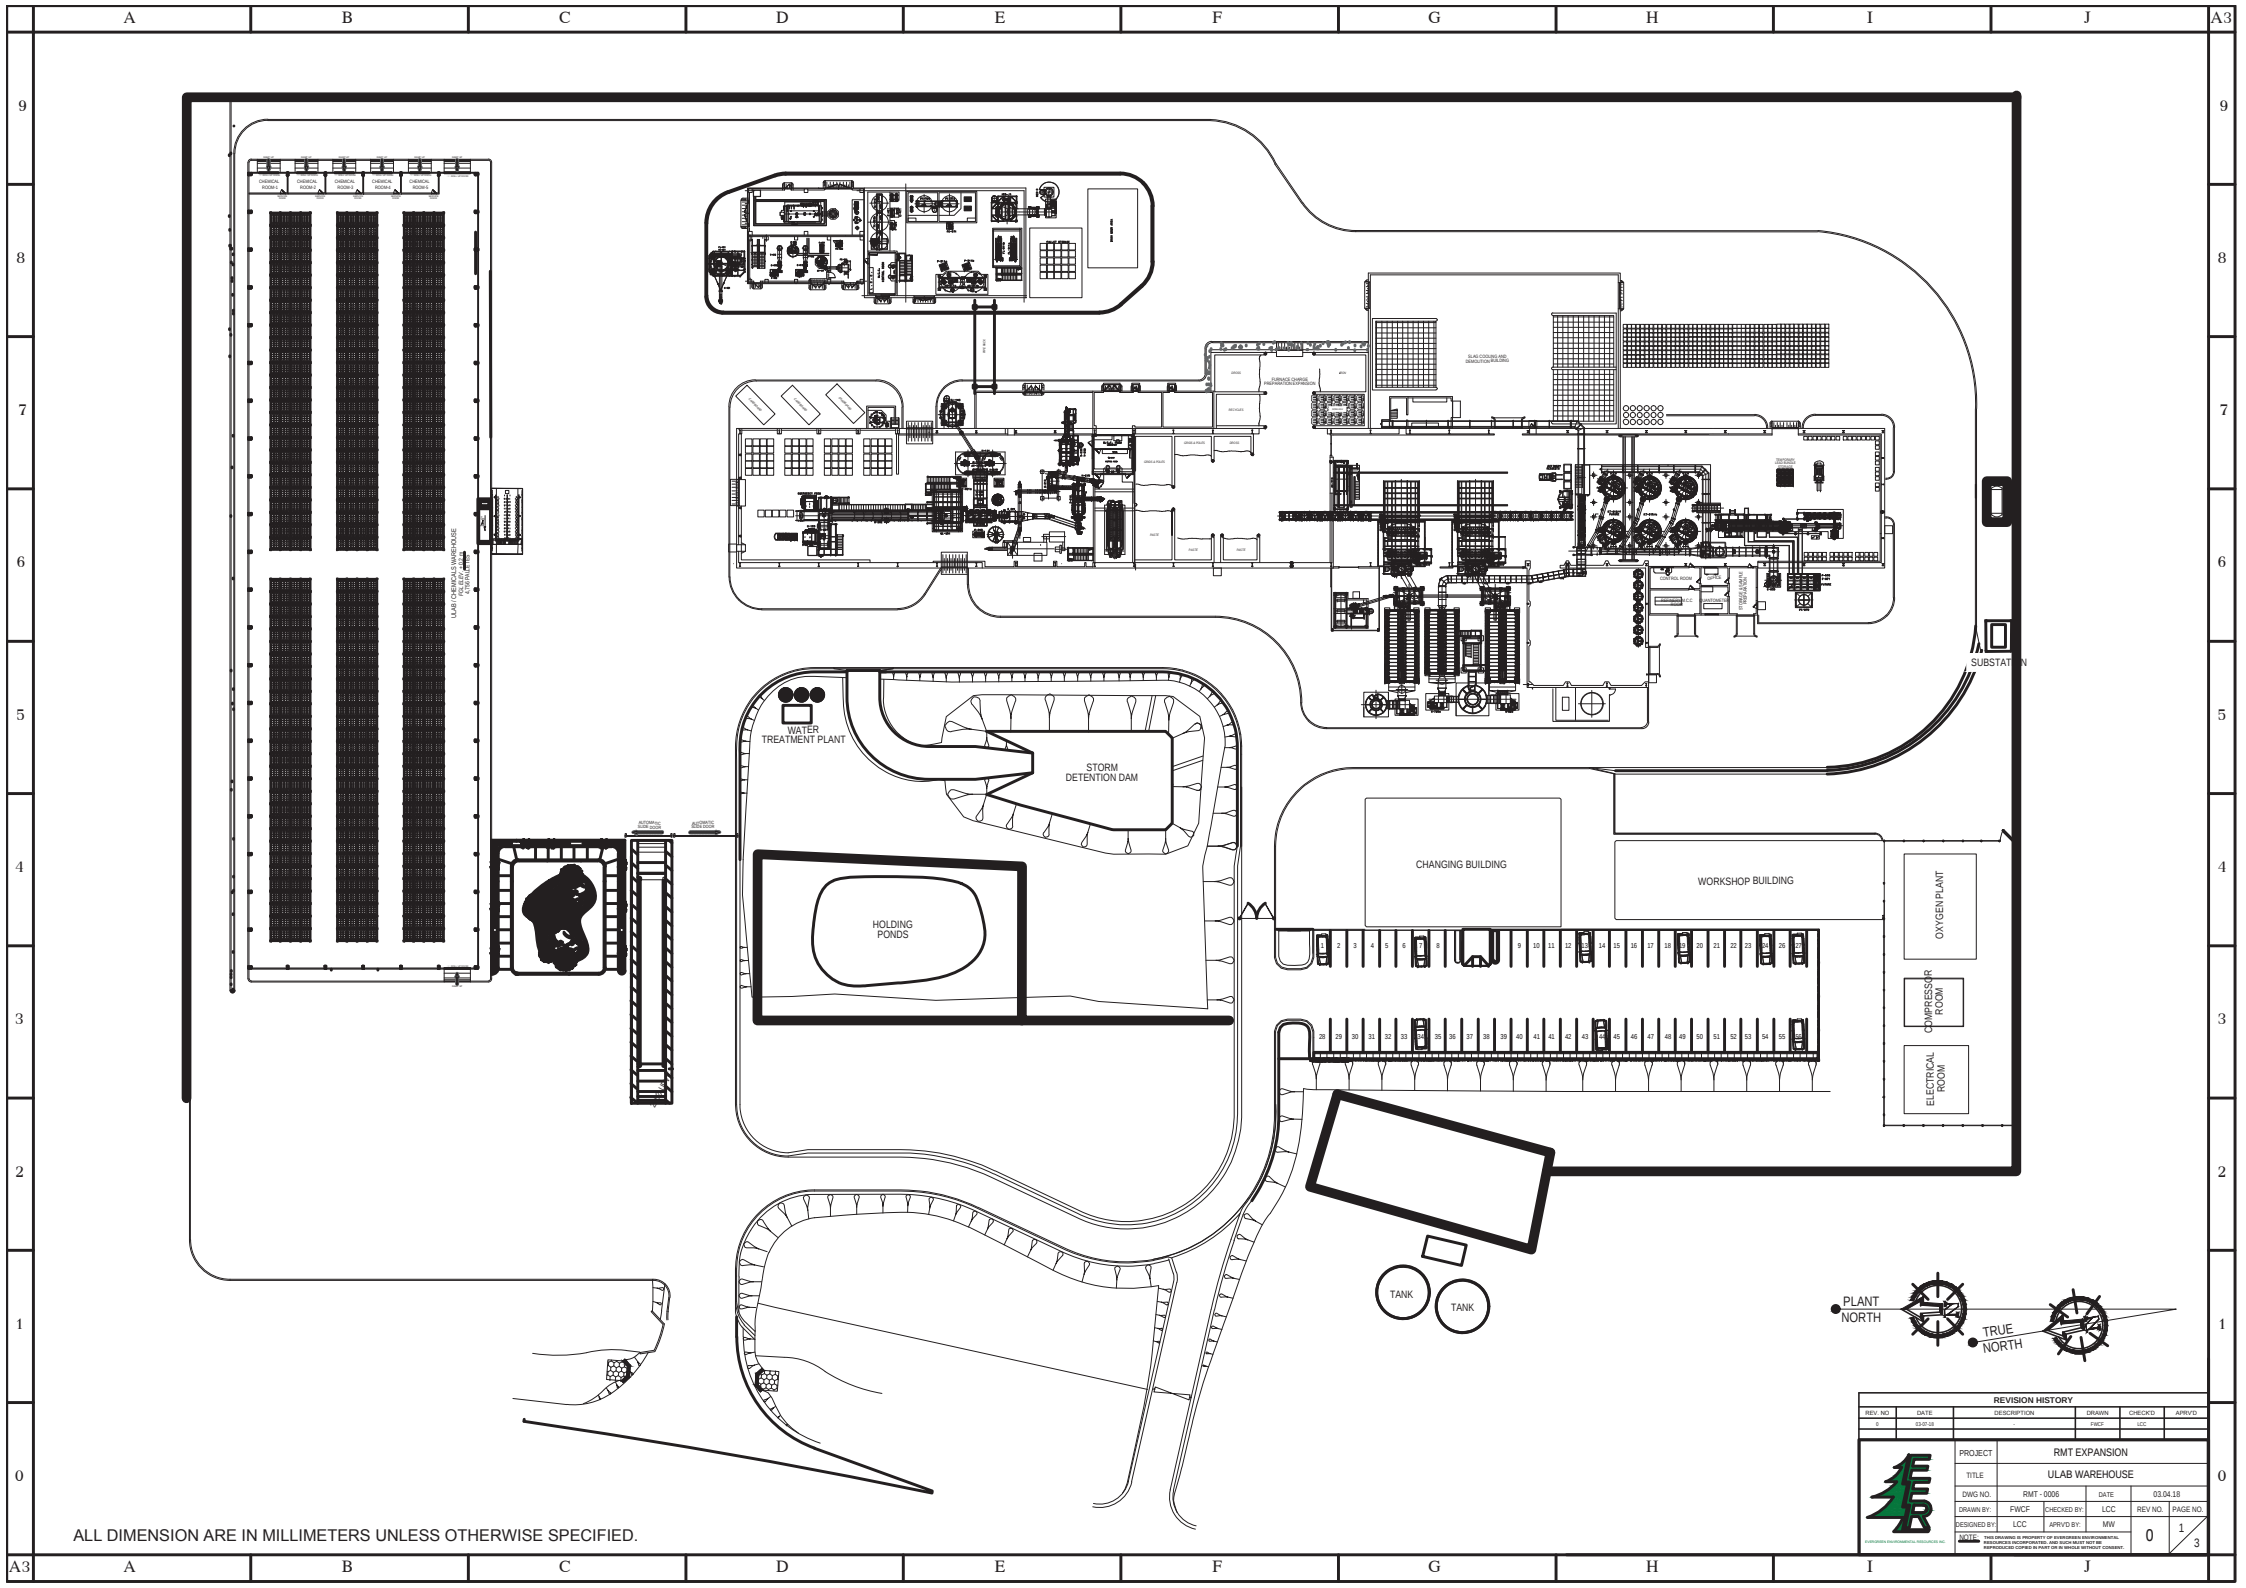


REVISION HISTORY					
REV. NO.	DATE	DESCRIPTION	DESIGN	CHECKED	APPROVED
1	03.03.18		FWO	LCC	
PROJECT RMT EXPANSION					
TITLE ULAB WAREHOUSE					
DWG. NO.	RMT - 0006	DATE	03.04.18		
DRAWN BY	FWO	CHECKED BY	LCC	REV. NO.	PAGE NO.
DESIGNED BY	LCC	APPROVED BY	MM	0	1
NOTE: THIS DRAWING IS PROPERTY OF THE COMPANY AND IS NOT TO BE REPRODUCED OR COPIED IN ANY FORM OR BY ANY MEANS WITHOUT THE WRITTEN PERMISSION OF THE COMPANY.					

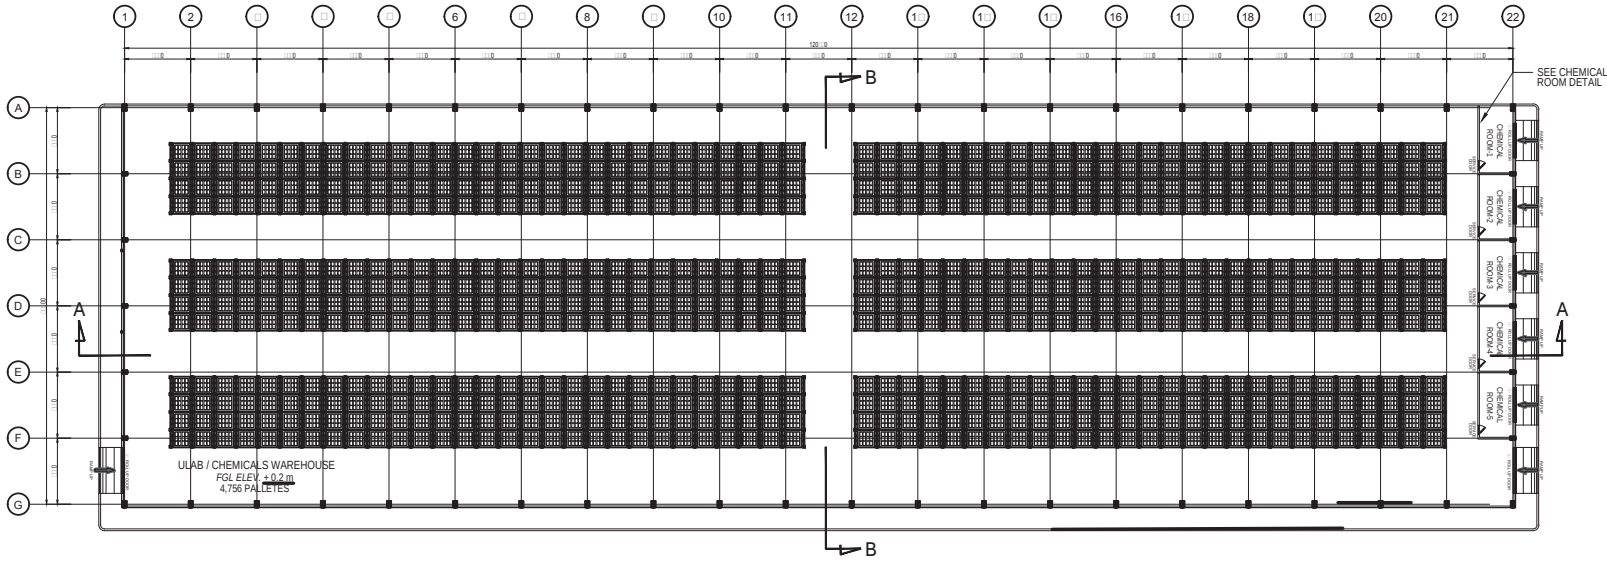

PLAN VIEW
SCALE NTS

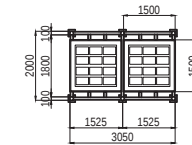


PLAN VIEW

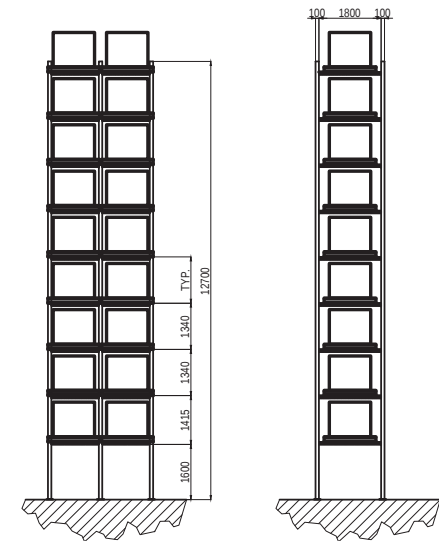


SIDE VIEW

FRONT VIEW


PALLET RACK ELVATION
SCALE NTS

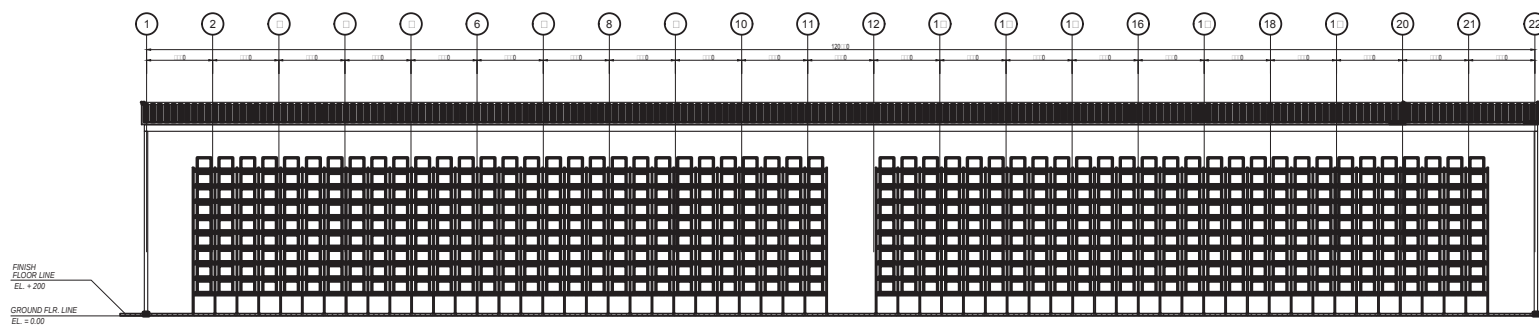

SECTION THRU "A - A"
SCALE NTS

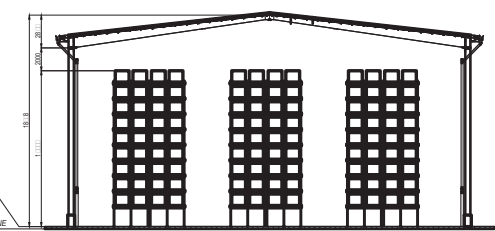


SECTION THRU "B - B"
SCALE NTS

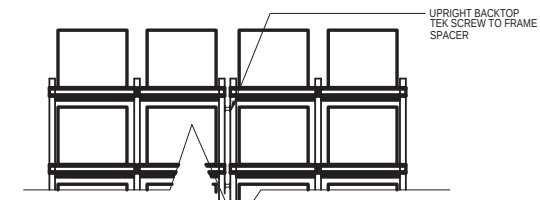

DETAIL - A
SCALE NTS

ALL DIMENSION ARE IN MILLIMETERS UNLESS OTHERWISE SPECIFIED.


REVISION HISTORY					
REV. NO.	DATE	DESCRIPTION	DRAWN	CHECKED	APPROVED
0	02/18		FWCF	LCC	
PROJECT RMT EXPANSION					
TITLE ULAB WAREHOUSE					
DWG. NO.	RMT - 0006	DATE	03.04.18		
DRAWN BY:	FWCF	CHECKED BY:	LCC	REV. NO.	PAGE NO.
DESIGNED BY:	LCC	APPROVED BY:	MW	0	2
NOTE: THIS DRAWING IS PROPERTY OF SUBMITTER AND IS NOT TO BE REPRODUCED OR COPIED IN ANY FORM OR MANNER WITHOUT CONSENT.					

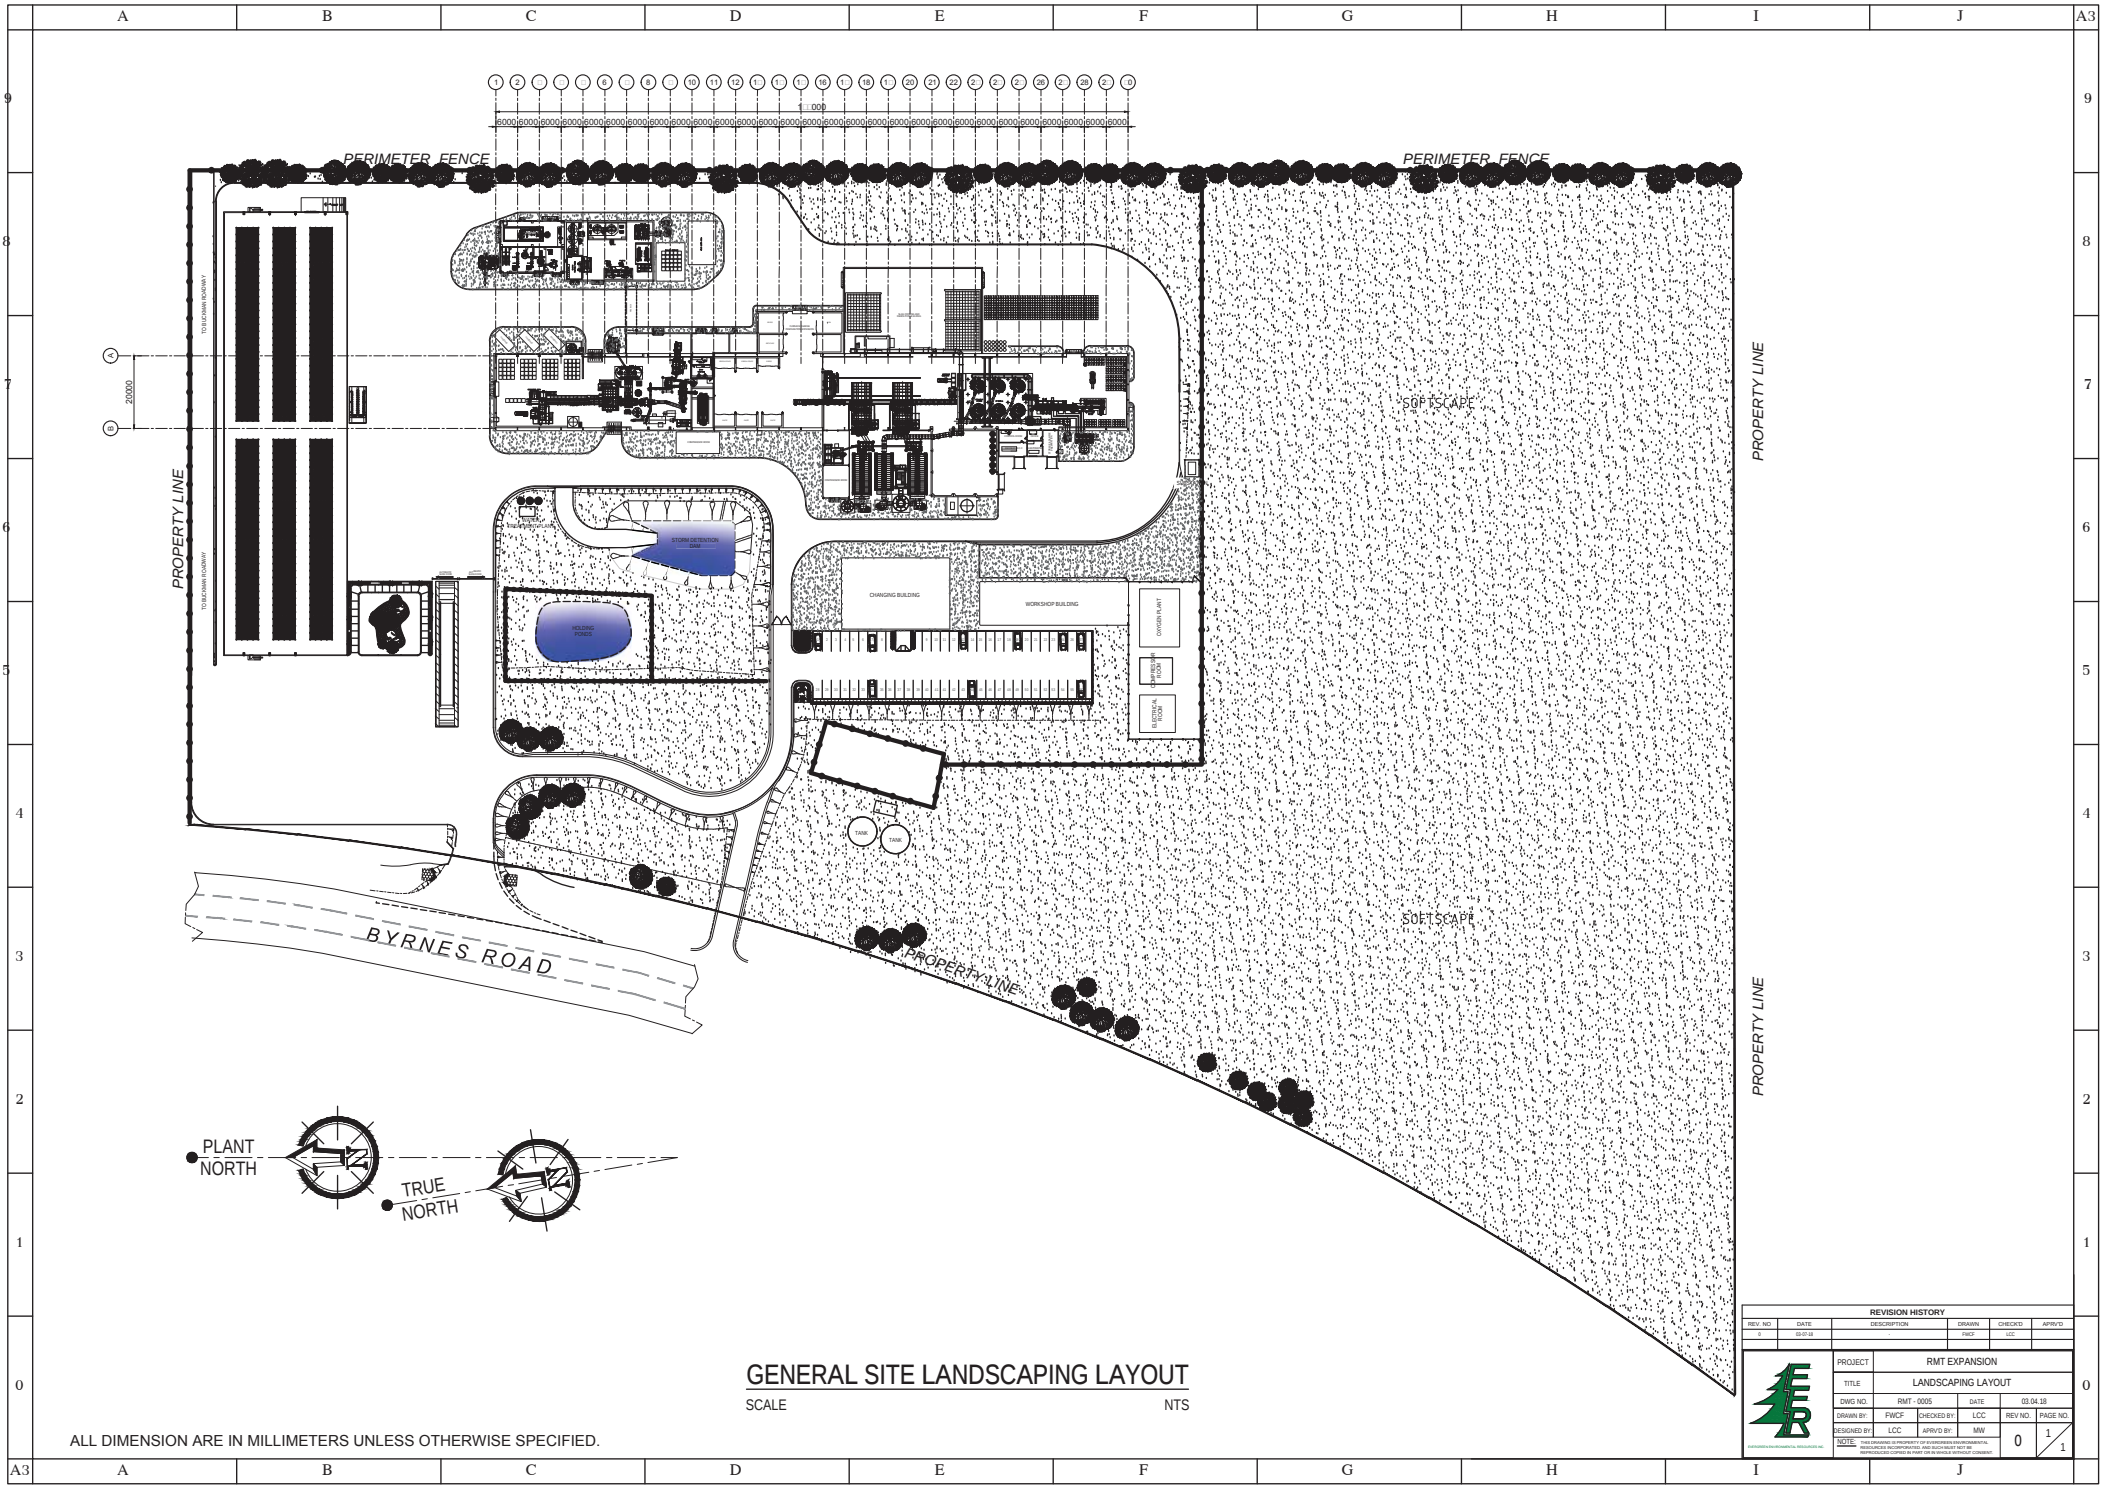



GENERAL SITE LANDSCAPING LAYOUT
SCALE NTS

ALL DIMENSION ARE IN MILLIMETERS UNLESS OTHERWISE SPECIFIED.

REVISION HISTORY					
REV. NO.	DATE	DESCRIPTION	DRAWN	CHECKED	APPROVED
1	03/07/18		FWCF	LCC	
PROJECT RMT EXPANSION					
TITLE LANDSCAPING LAYOUT					
DWG. NO.	RMT - 0005	DATE	03/04/18		
DRAWN BY:	FWCF	CHECKED BY:	LCC	REV. NO.	PAGE NO.
DESIGNED BY:	LCC	APPROVED BY:	MM	0	1
NOTE: 1. THIS DRAWING IS A PRELIMINARY DESIGN AND SHOULD NOT BE USED FOR CONSTRUCTION WITHOUT THE APPROVAL OF THE DESIGNER.					

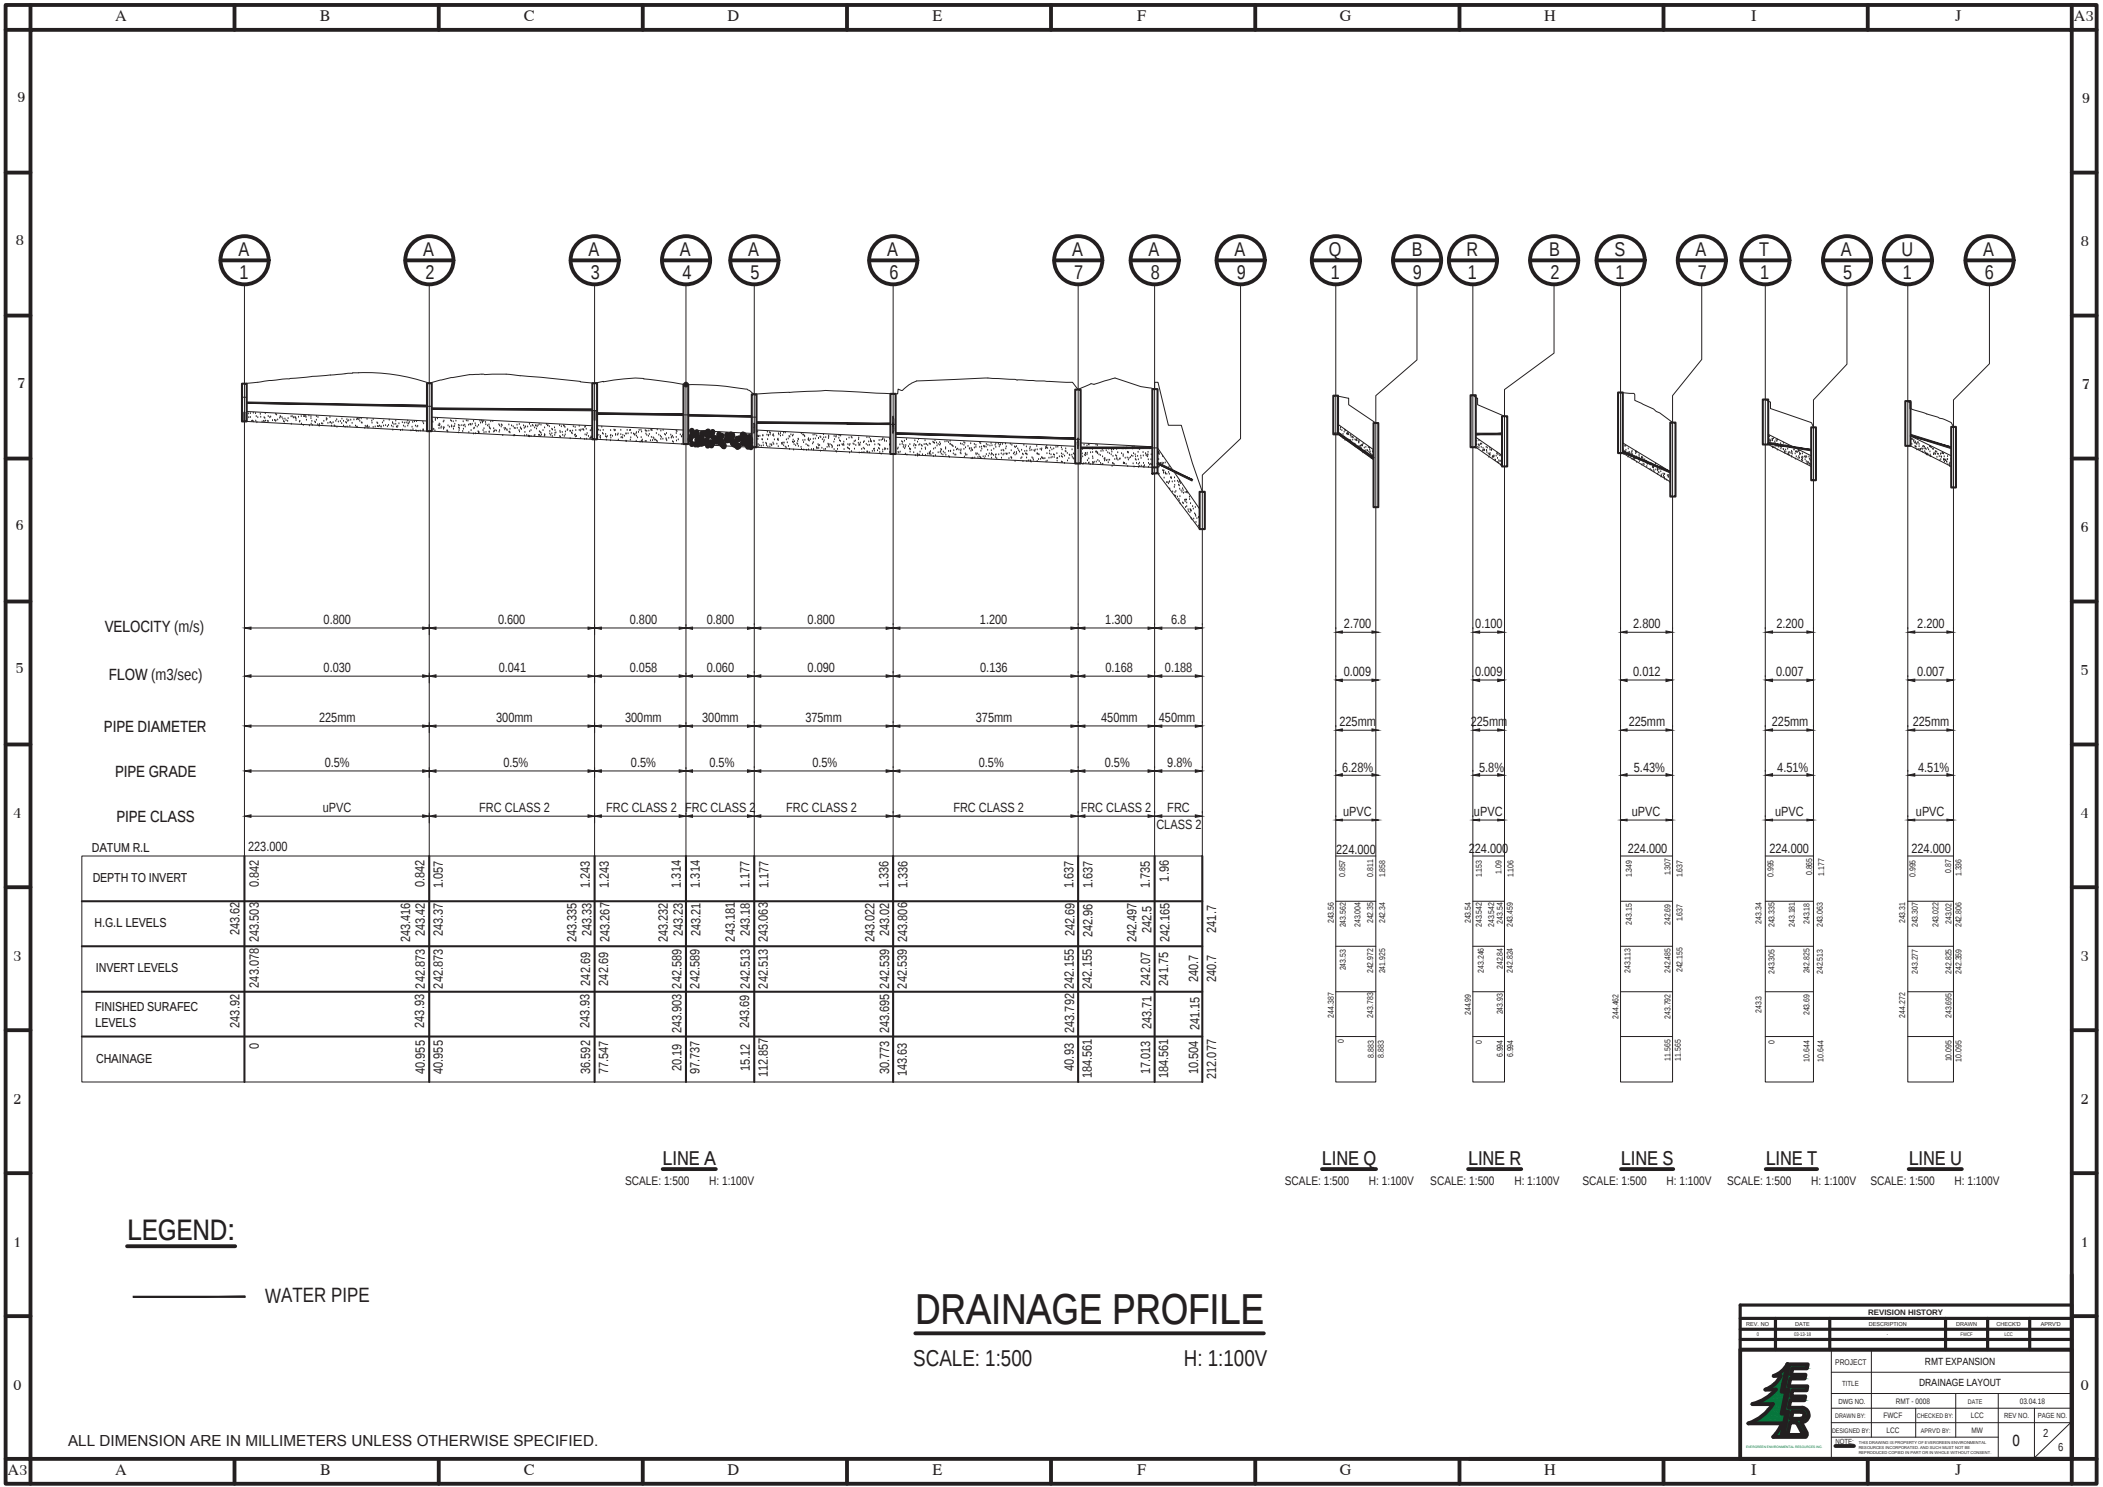

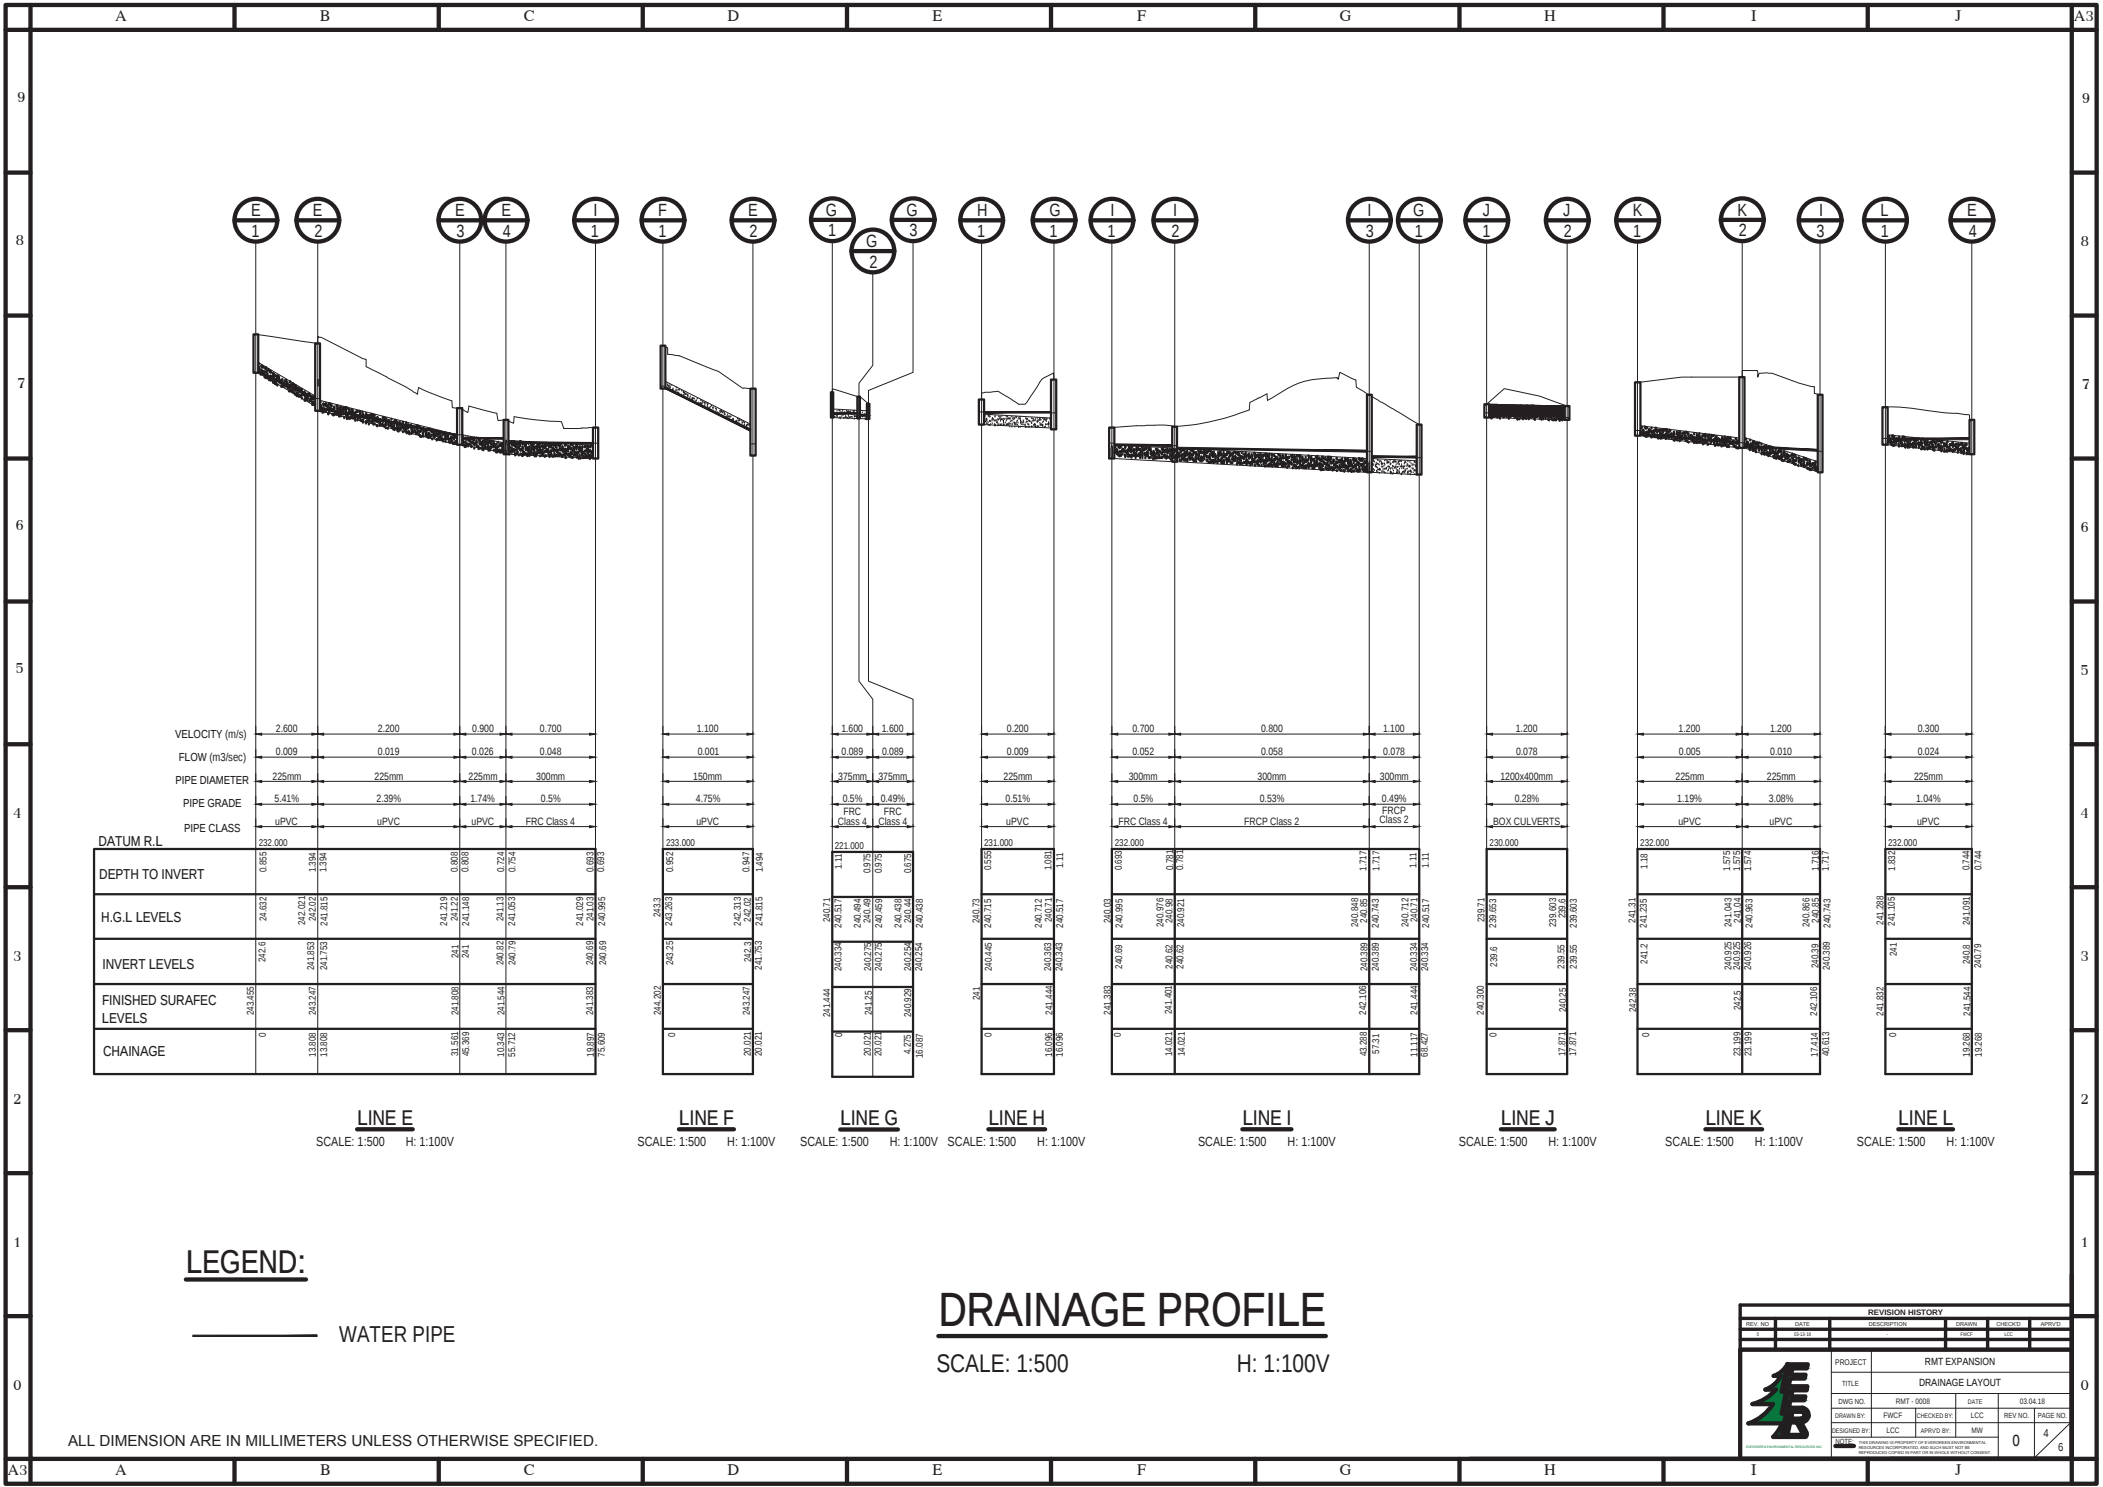

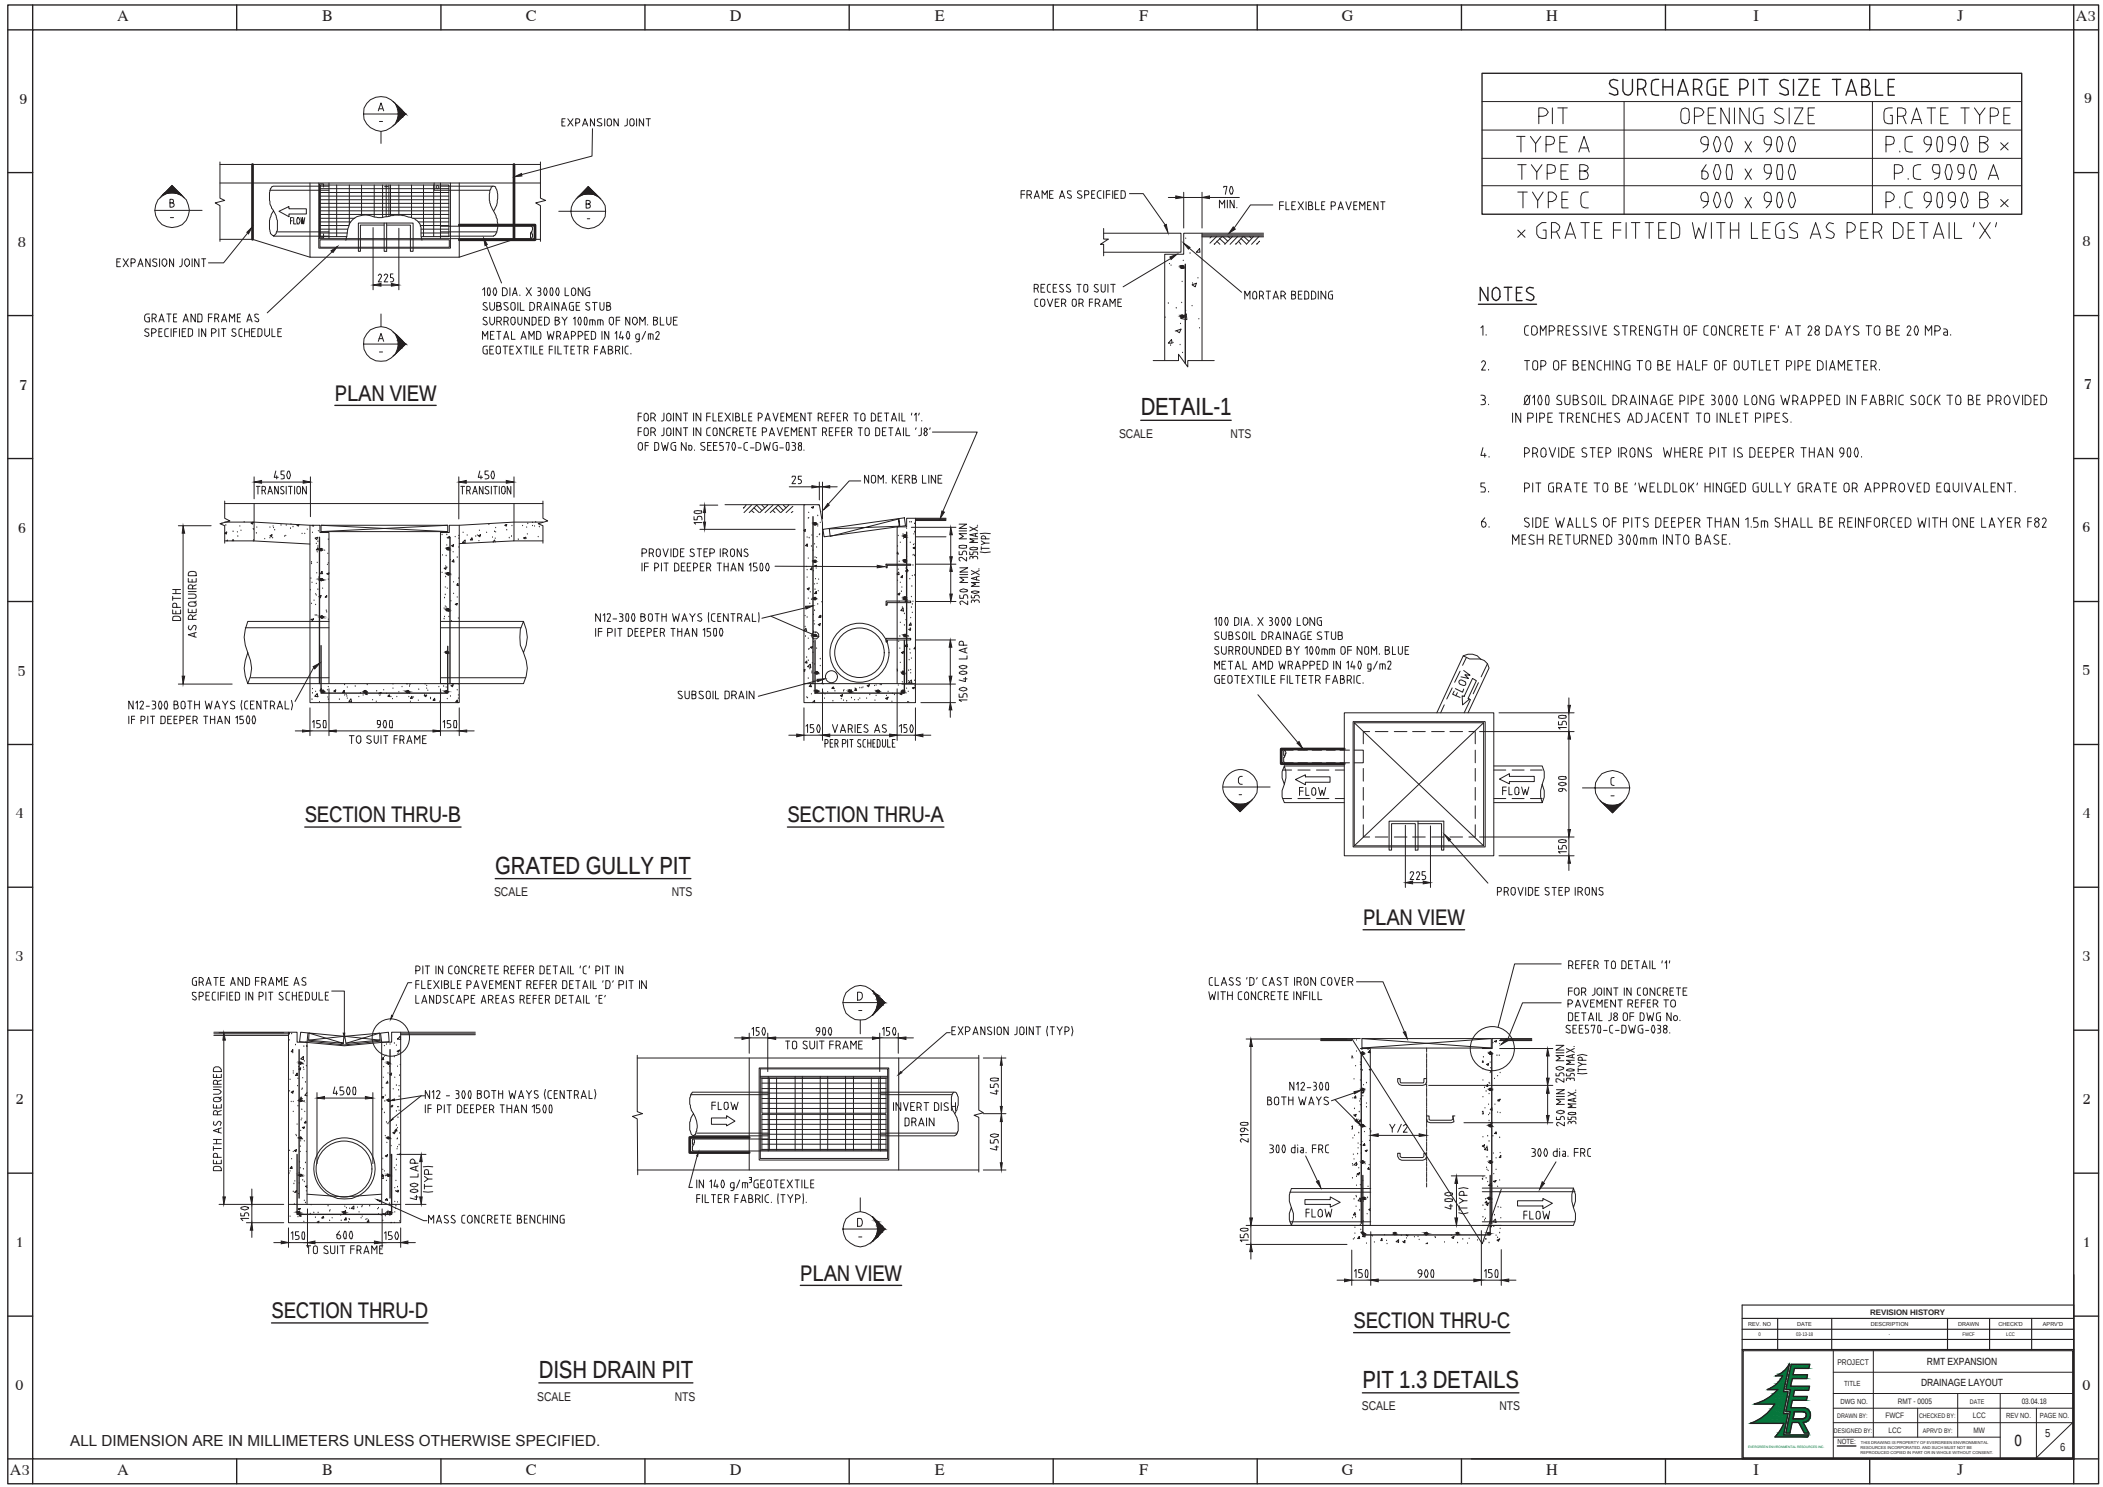

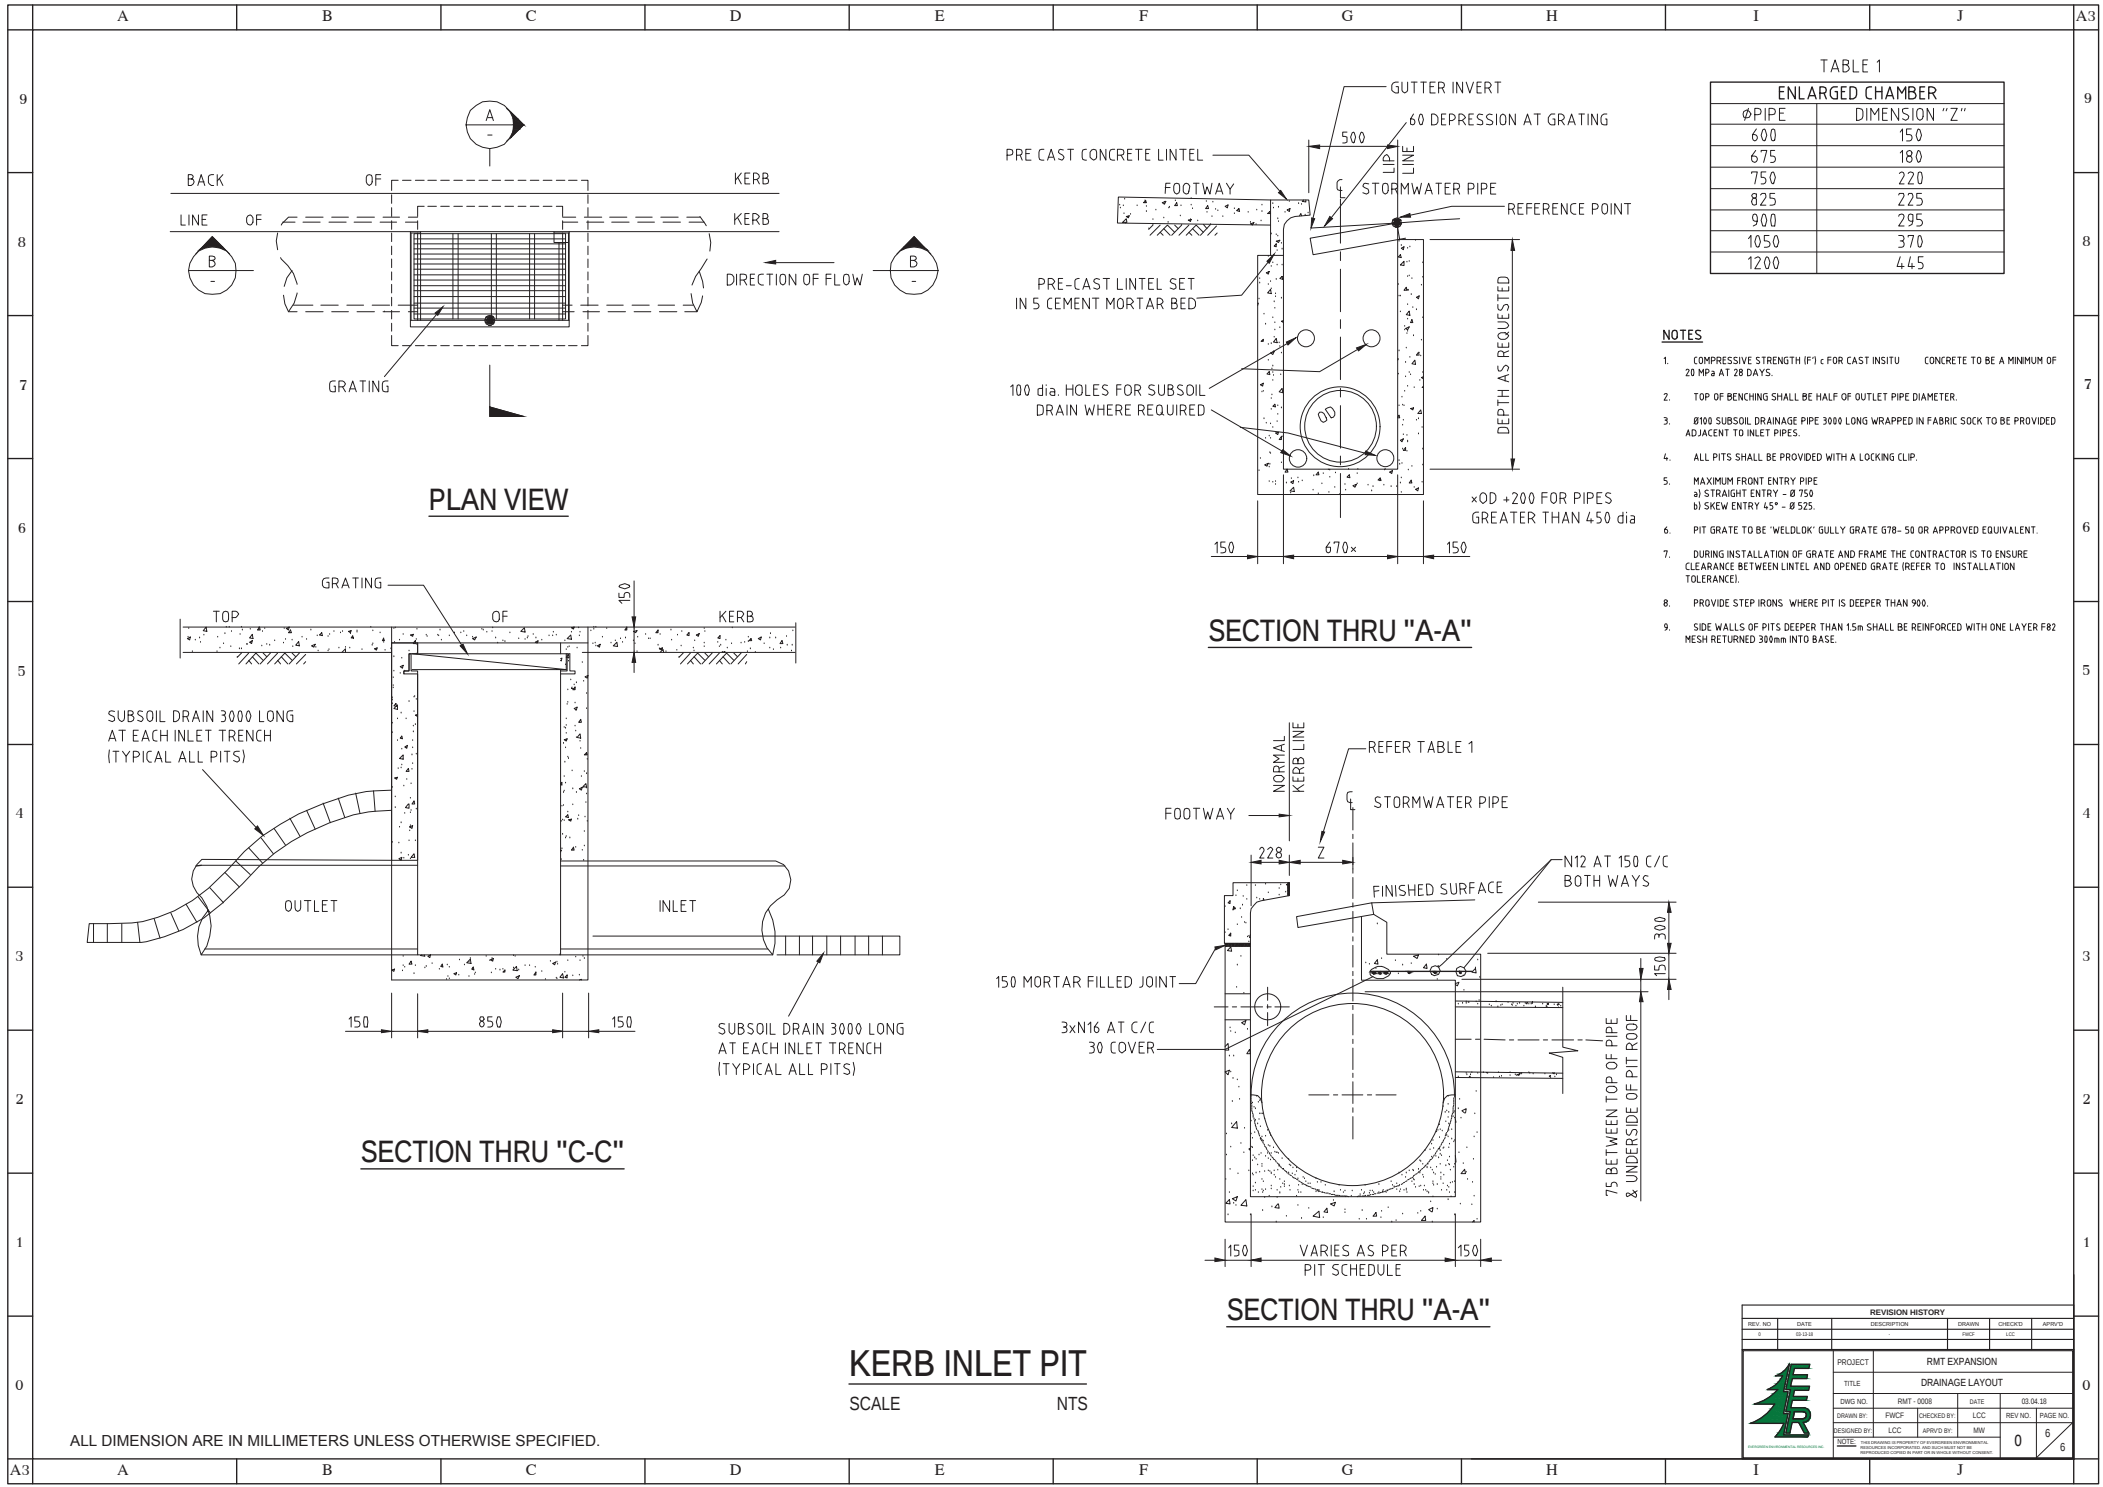



TABLE 1	
ENLARGED CHAMBER	
ØPIPE	DIMENSION "Z"
600	150
675	180
750	220
825	225
900	295
1050	370
1200	445

- NOTES**
1. COMPRESSIVE STRENGTH (F_c) FOR CAST INSITU CONCRETE TO BE A MINIMUM OF 20 MPa AT 28 DAYS.
 2. TOP OF BENCHING SHALL BE HALF OF OUTLET PIPE DIAMETER.
 3. Ø100 SUBSOIL DRAINAGE PIPE 3000 LONG WRAPPED IN FABRIC SOCK TO BE PROVIDED ADJACENT TO INLET PIPES.
 4. ALL PITS SHALL BE PROVIDED WITH A LOCKING CLIP.
 5. MAXIMUM FRONT ENTRY PIPE
a) STRAIGHT ENTRY - Ø 750
b) SKEW ENTRY 45° - Ø 525.
 6. PIT GRATE TO BE 'WELDLOK' GULLY GRATE 678- 50 OR APPROVED EQUIVALENT.
 7. DURING INSTALLATION OF GRATE AND FRAME THE CONTRACTOR IS TO ENSURE CLEARANCE BETWEEN LINTEL AND OPENED GRATE (REFER TO INSTALLATION TOLERANCE).
 8. PROVIDE STEP IRONS WHERE PIT IS DEEPER THAN 900.
 9. SIDE WALLS OF PITS DEEPER THAN 15m SHALL BE REINFORCED WITH ONE LAYER F82 MESH RETURNED 300mm INTO BASE.

REVISION HISTORY					
REV. NO.	DATE	DESCRIPTION	DRAWN	CHECKED	APPROVED
1	03-10-18		FWC	LCC	
PROJECT: RMT EXPANSION					
TITLE: DRAINAGE LAYOUT					
DWG. NO.	RMT - 0008	DATE	03-04-18		
DRAWN BY:	FWC	CHECKED BY:	LCC	REV. NO.	PAGE NO.
DESIGNED BY:	LCC	APPROVED BY:	MM	0	6
NOTE: THESE DRAWINGS ARE PRELIMINARY AND NOT TO BE USED FOR CONSTRUCTION. ANY CHANGES TO BE MADE BY THE ENGINEER IN CHARGE.					


KERB INLET PIT
SCALE NTS

ALL DIMENSION ARE IN MILLIMETERS UNLESS OTHERWISE SPECIFIED.

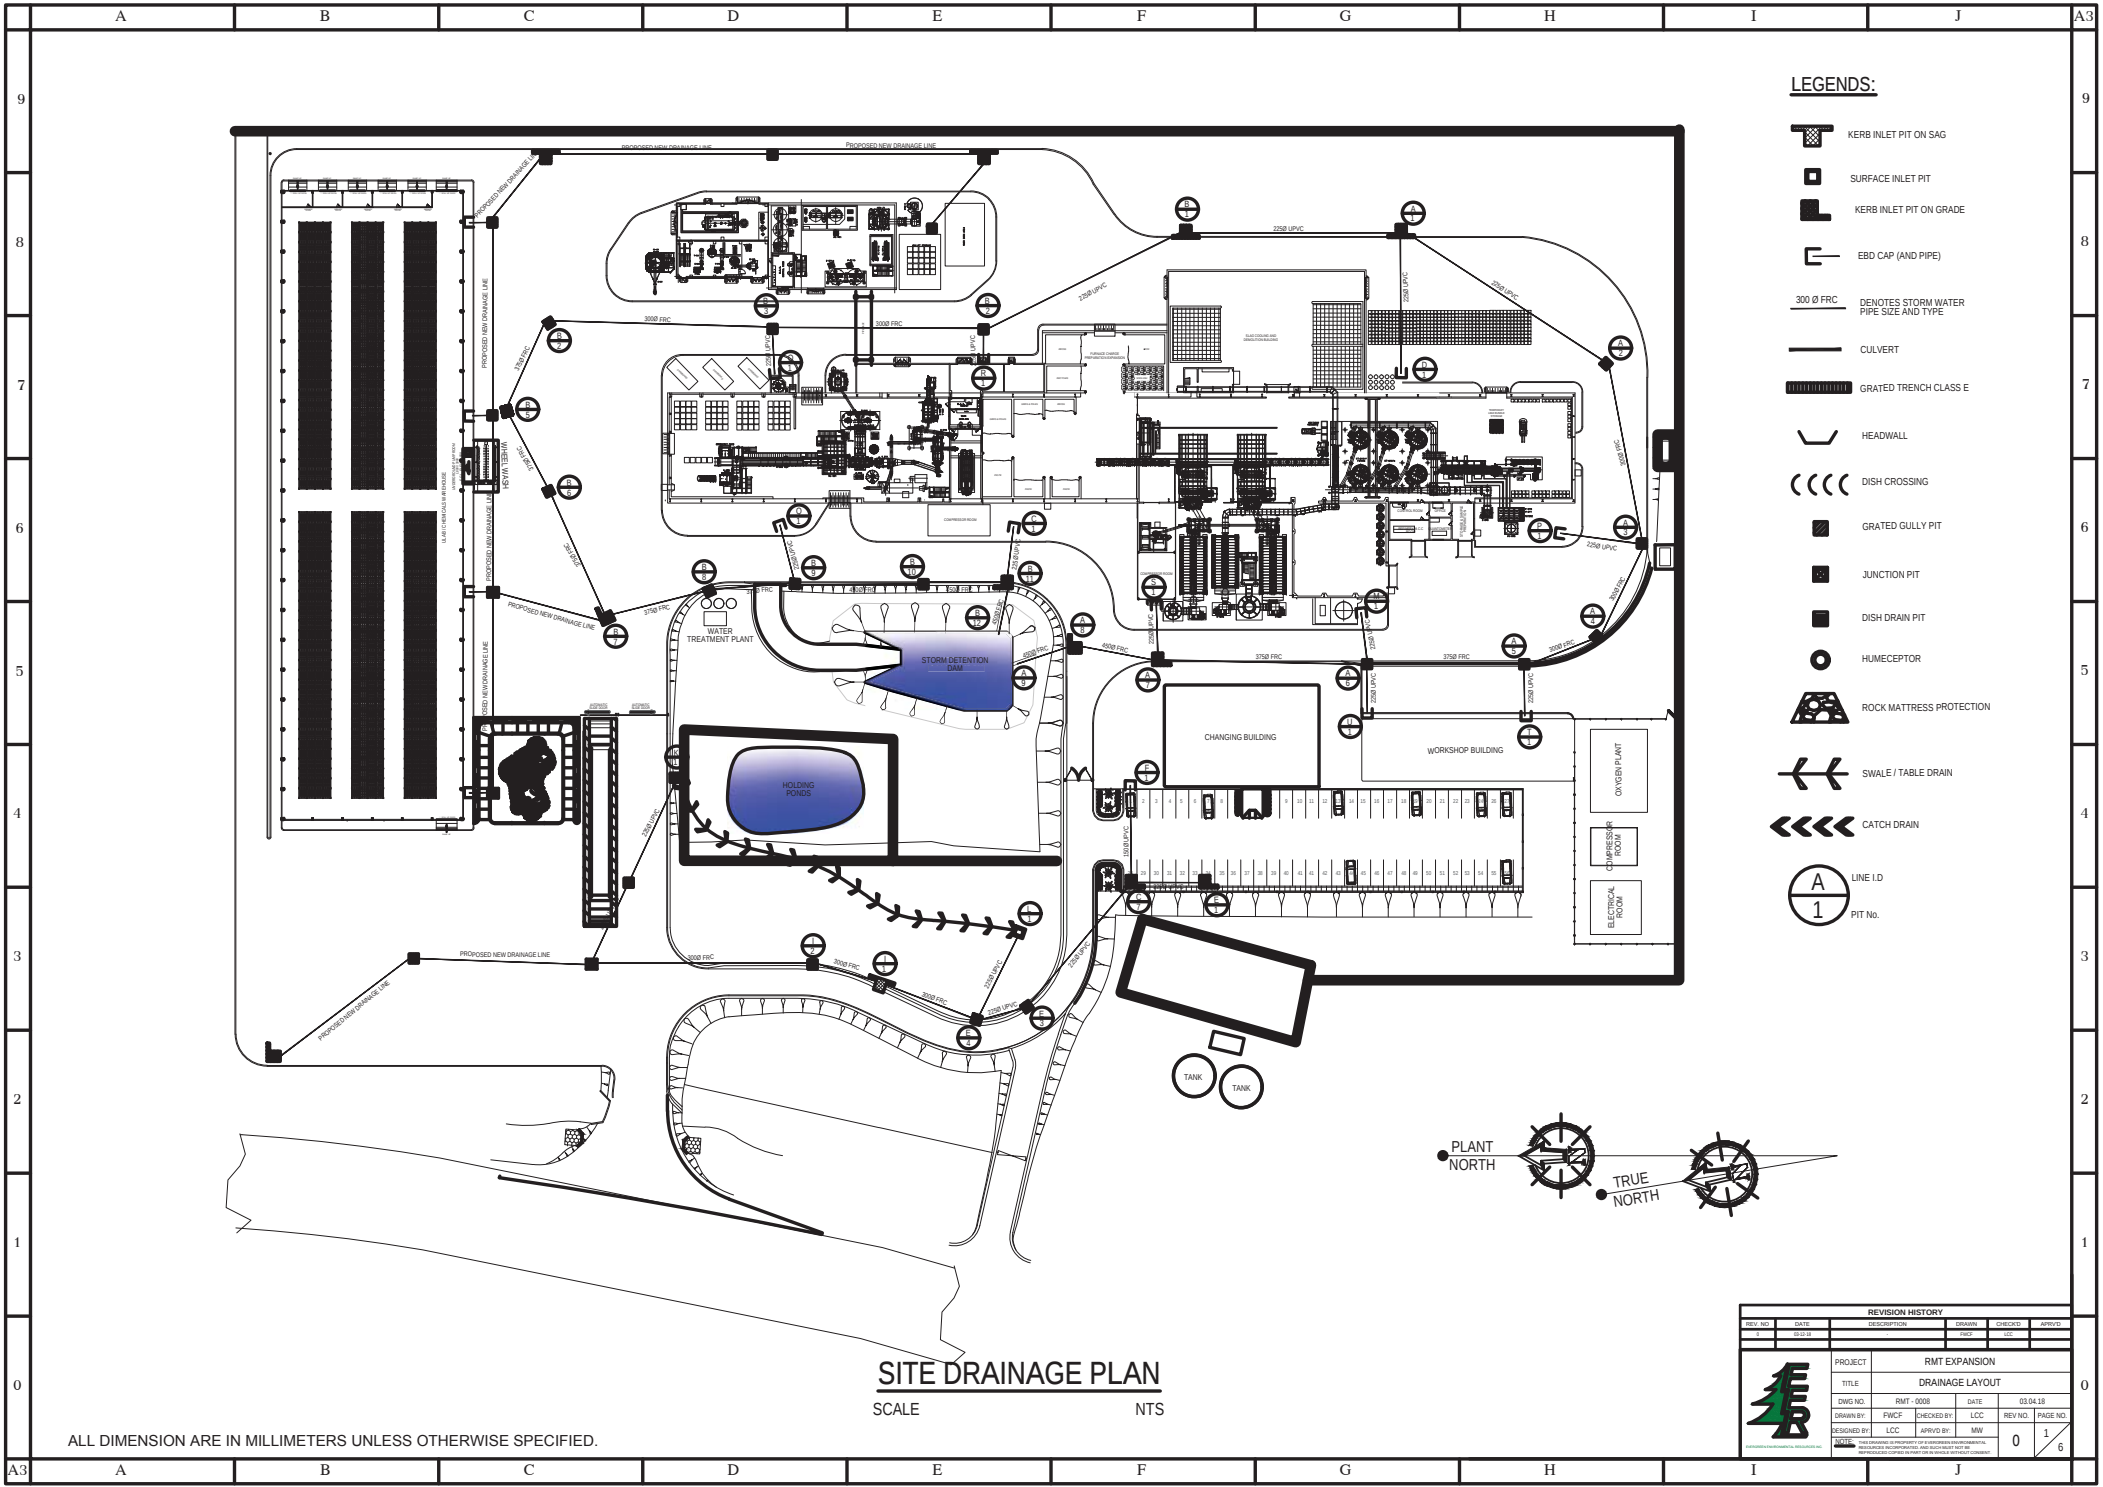

LEGENDS:

 - KERB INLET PIT ON SAG
- SURFACE INLET PIT
- KERB INLET PIT ON GRADE
- EBD CAP (AND PIPE)
- 300 Ø FRC DENOTES STORM WATER PIPE SIZE AND TYPE
- CULVERT
- GRADED TRENCH CLASS E
- HEADWALL
- DISH CROSSING
- GRADED GULLY PIT
- JUNCTION PIT
- DISH DRAIN PIT
- HUMECEPTOR
- ROCK MATTRESS PROTECTION
- SWALE / TABLE DRAIN
- CATCH DRAIN
- LINE I.D
- PIT No.



SITE DRAINAGE PLAN

SCALE NTS

ALL DIMENSION ARE IN MILLIMETERS UNLESS OTHERWISE SPECIFIED.

REVISION HISTORY					
REV. NO.	DATE	DESCRIPTION	DRAWN	CHECKED	APPROVED
1	03.04.18				
PROJECT RMT EXPANSION					
TITLE DRAINAGE LAYOUT					
DWG NO.	RMT - 0008	DATE	03.04.18		
DRAWN BY	FWFC	CHECKED BY	LCC	REV. NO.	PAGE NO.
DESIGNED BY	LCC	APPROVED BY	MW	0	1
NOTES				0	6

