




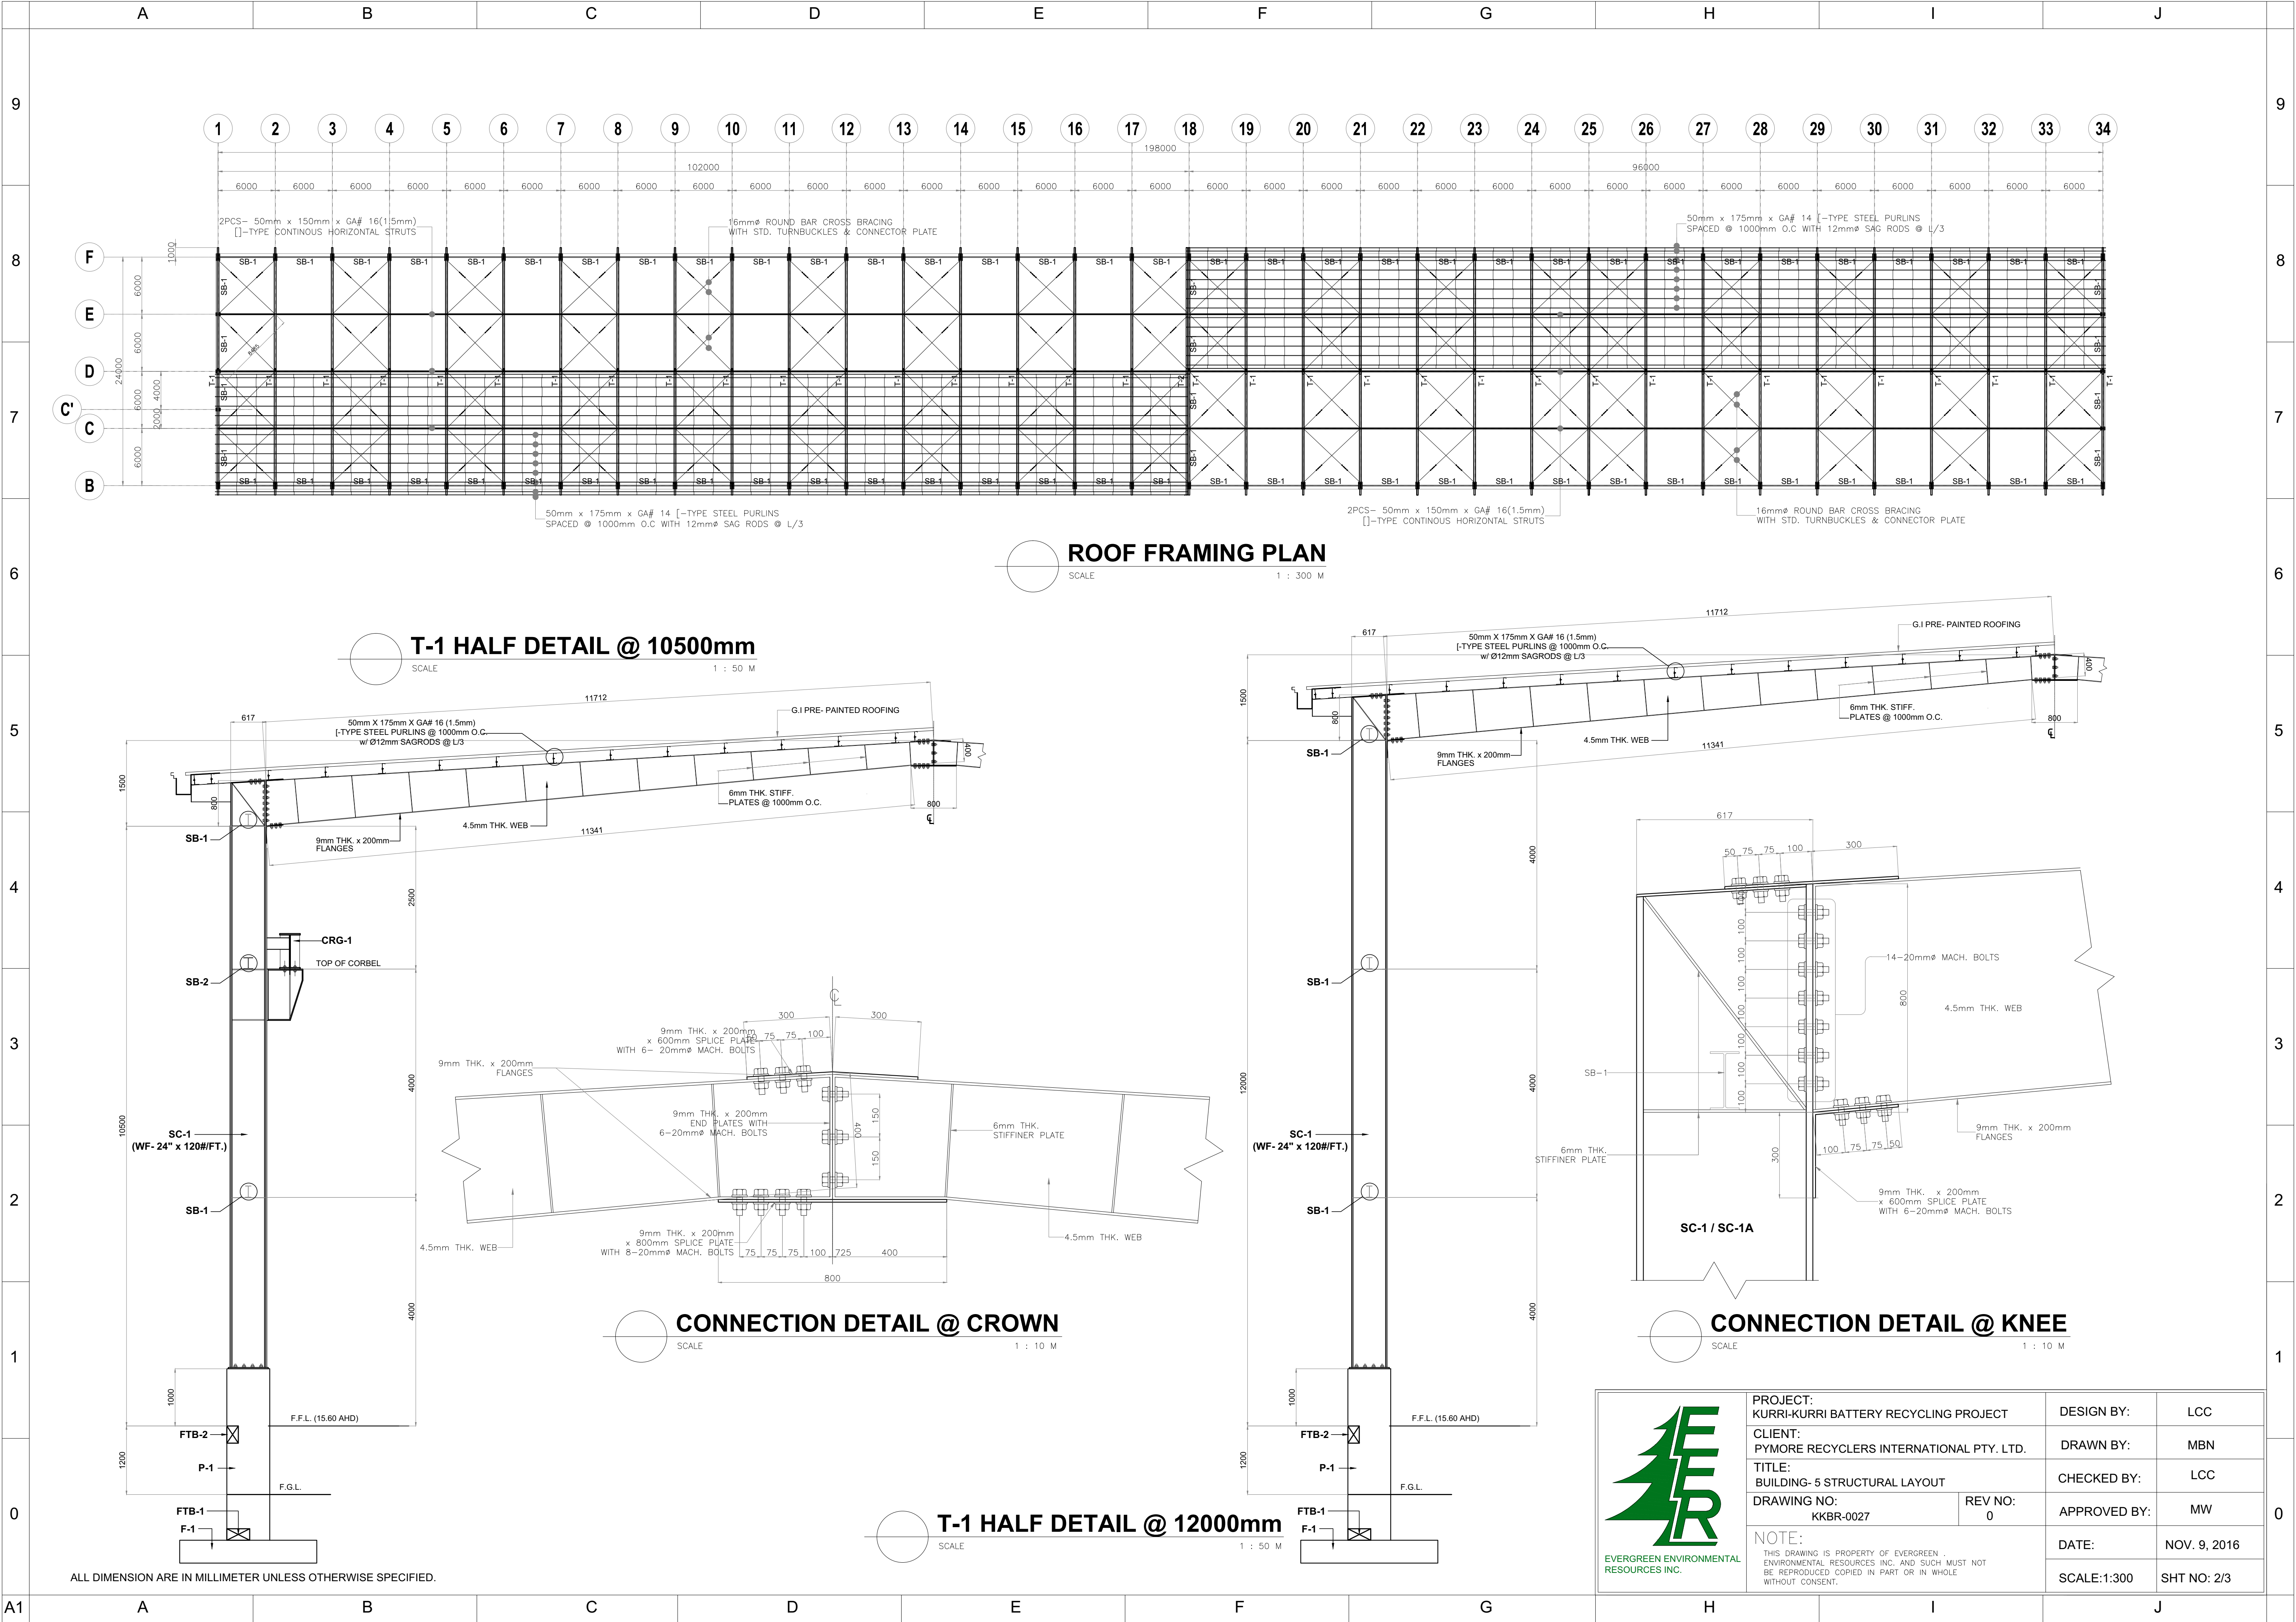

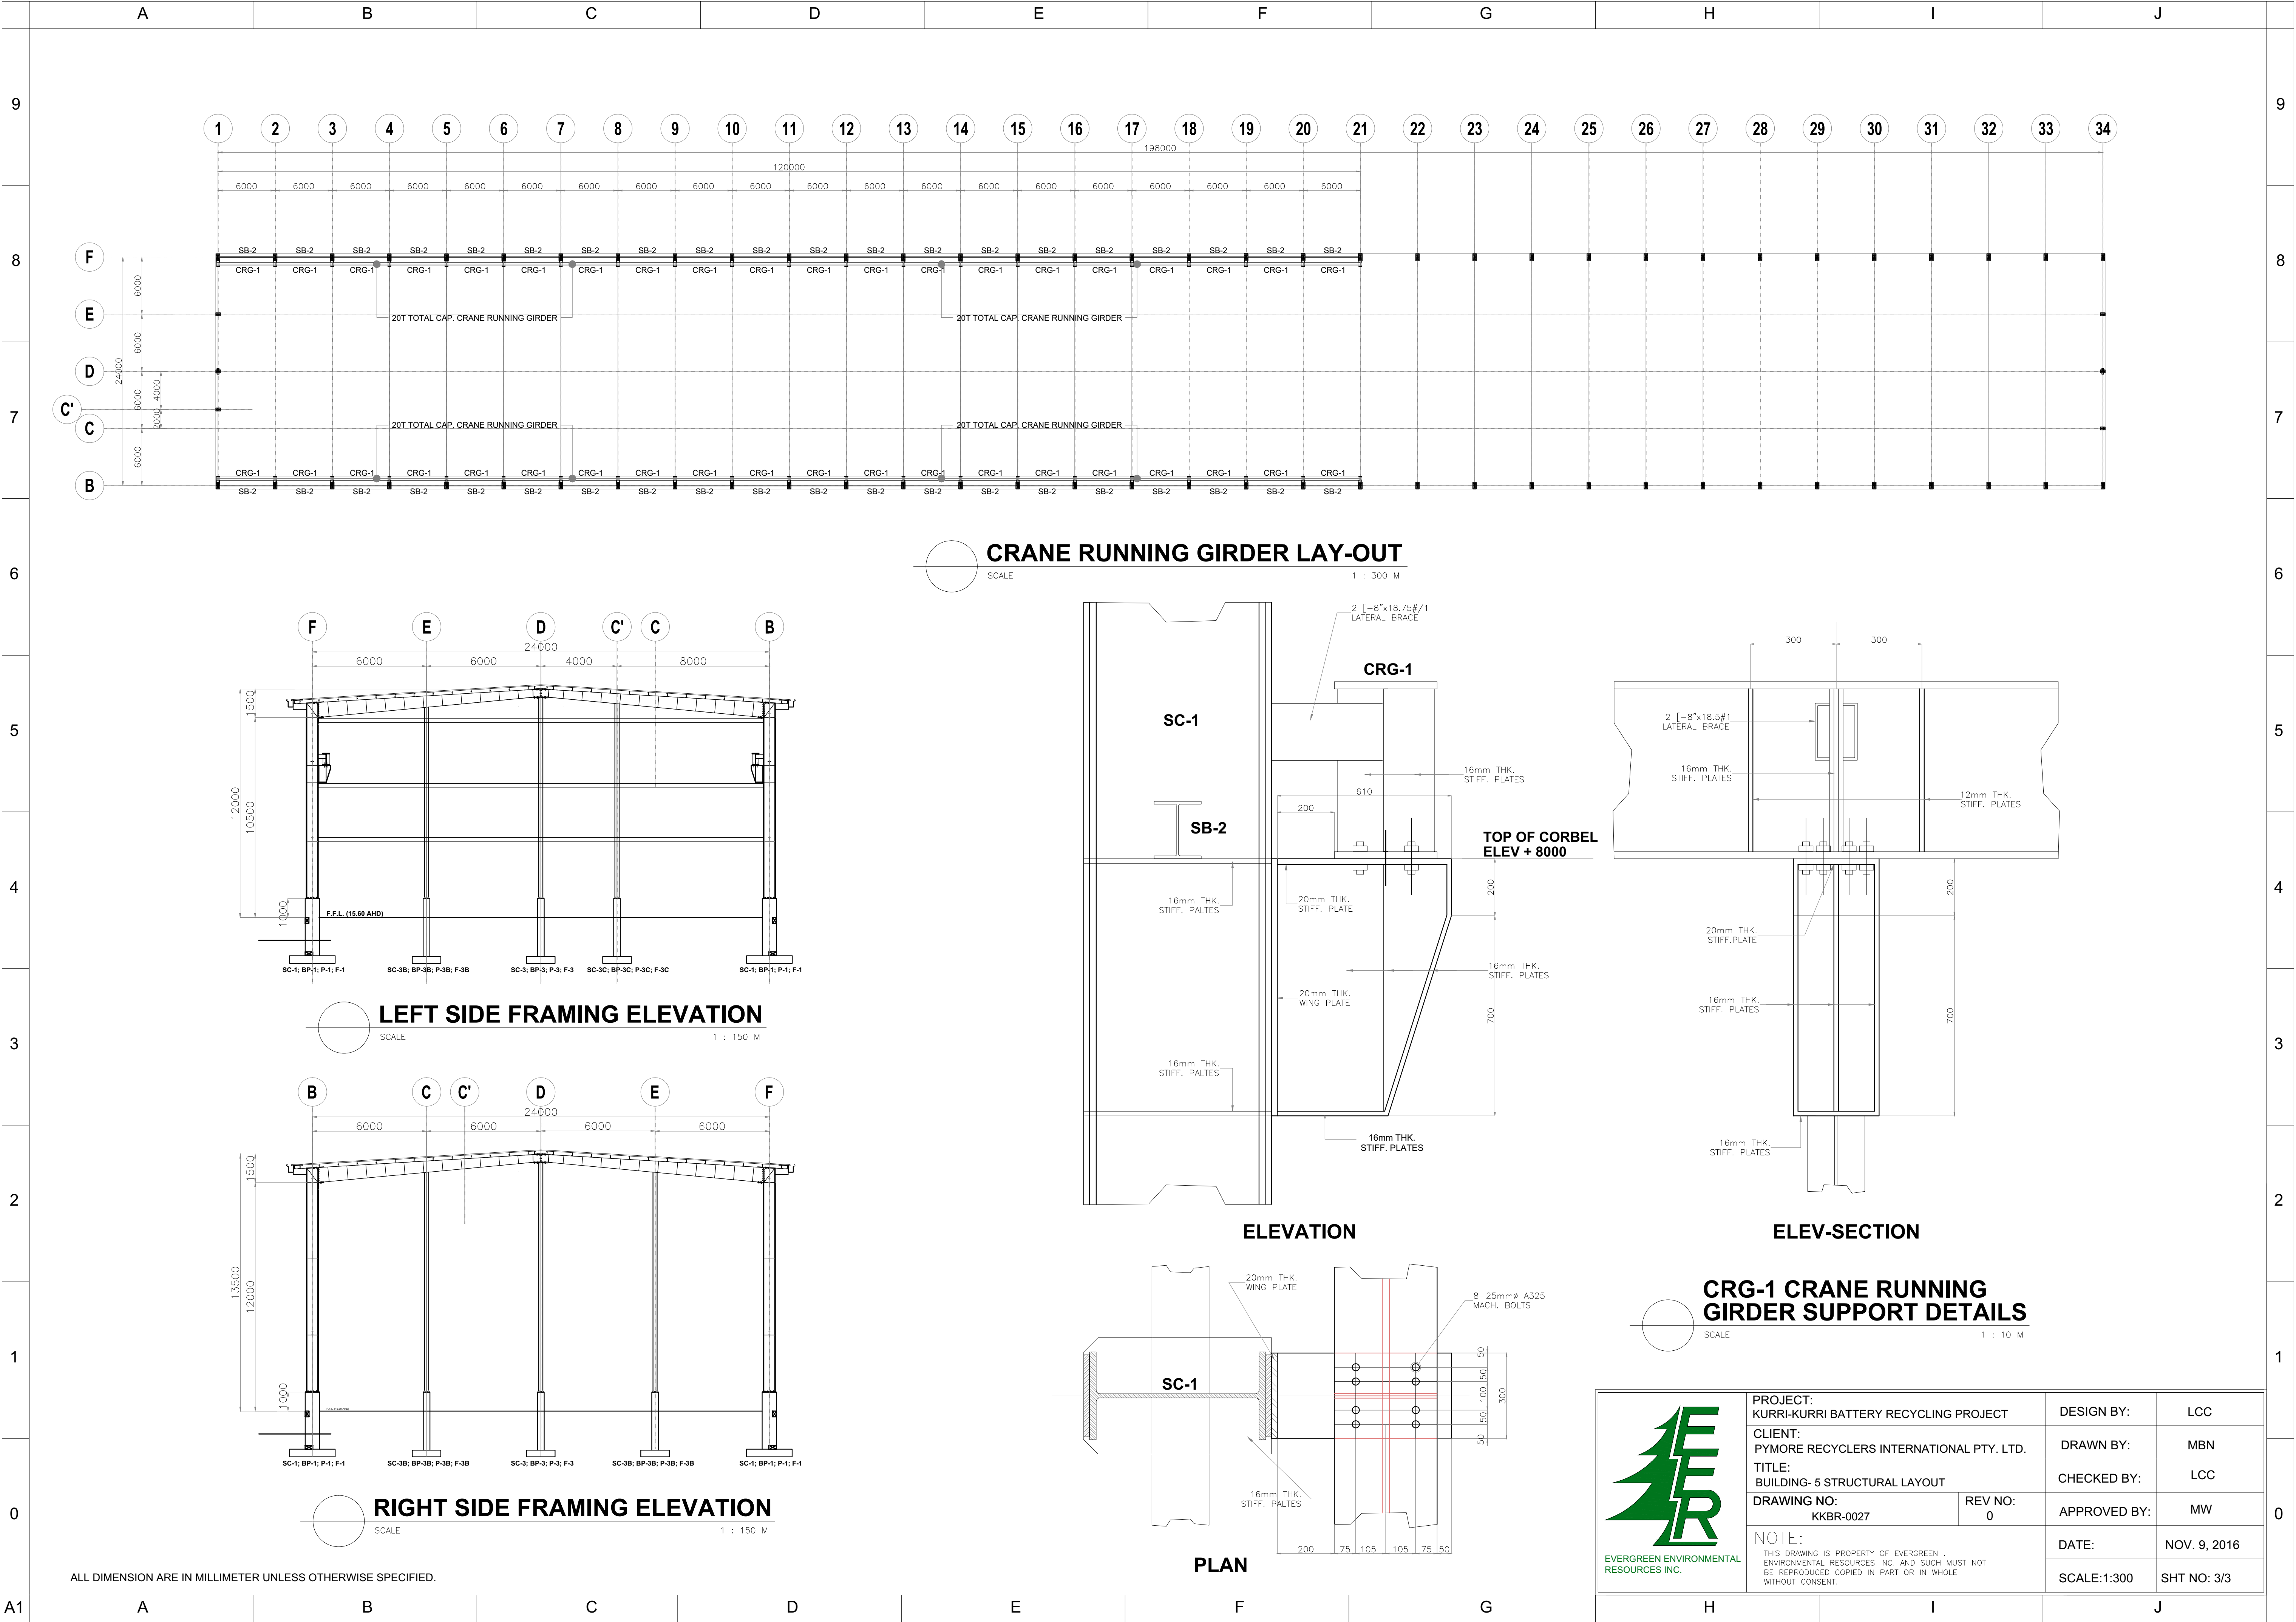

ALL DIMENSION ARE IN MILLIMETER UNLESS OTHERWISE SPECIFIED.


 EVERGREEN ENVIRONMENTAL RESOURCES INC.	PROJECT: KURRI-KURRI BATTERY RECYCLING PROJECT		DESIGN BY:	LCC
	CLIENT: PYMORE RECYCLERS INTERNATIONAL PTY. LTD.		DRAWN BY:	MBN
	TITLE: BUILDING- 5 STRUCTURAL LAYOUT		CHECKED BY:	LCC
	DRAWING NO: KKBR-0027	REV NO: 0	APPROVED BY:	MW
	NOTE: THIS DRAWING IS PROPERTY OF EVERGREEN . ENVIRONMENTAL RESOURCES INC. AND SUCH MUST NOT BE REPRODUCED COPIED IN PART OR IN WHOLE WITHOUT CONSENT.		DATE:	NOV. 9, 2016
			SCALE:1:300	SHT NO: 3/3

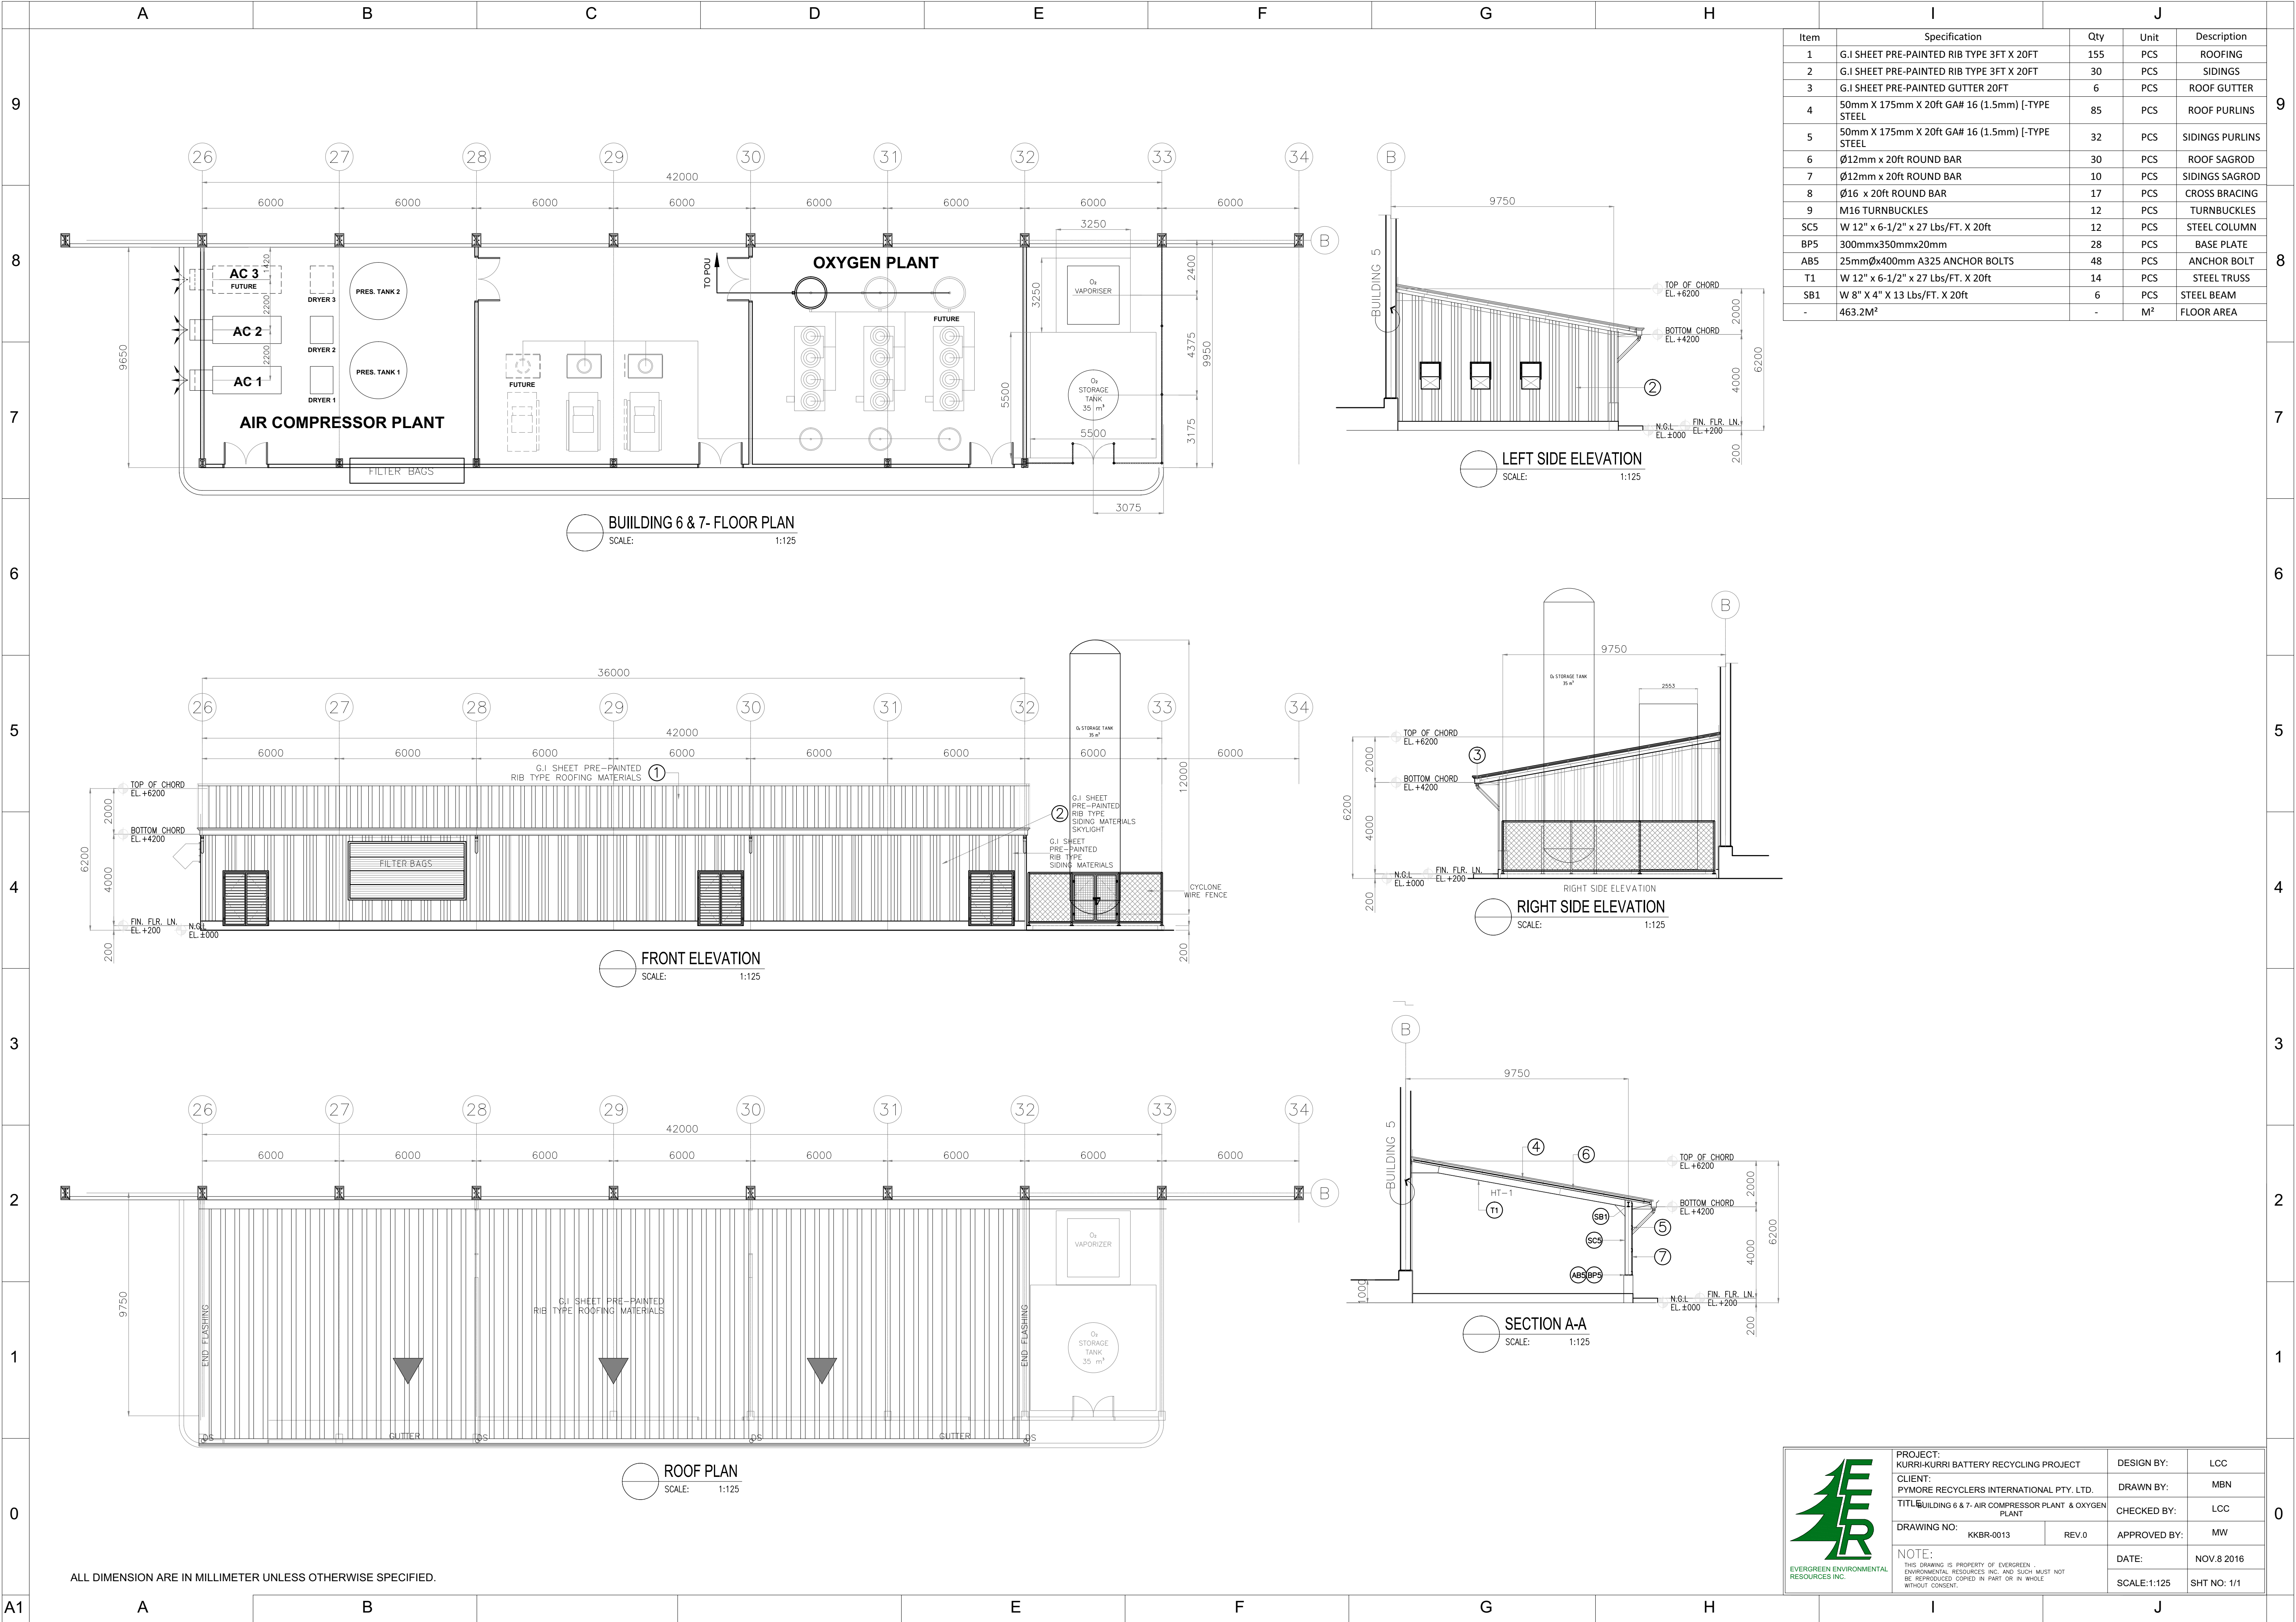


Item	Specification	Qty	Unit	Description
1	G.I SHEET PRE-PAINTED RIB TYPE 3FT X 20FT	155	PCS	ROOFING
2	G.I SHEET PRE-PAINTED RIB TYPE 3FT X 20FT	30	PCS	SIDINGS
3	G.I SHEET PRE-PAINTED GUTTER 20FT	6	PCS	ROOF GUTTER
4	50mm X 175mm X 20ft GA# 16 (1.5mm) [-TYPE STEEL	85	PCS	ROOF PURLINS
5	50mm X 175mm X 20ft GA# 16 (1.5mm) [-TYPE STEEL	32	PCS	SIDINGS PURLINS
6	Ø12mm x 20ft ROUND BAR	30	PCS	ROOF SAGROD
7	Ø12mm x 20ft ROUND BAR	10	PCS	SIDINGS SAGROD
8	Ø16 x 20ft ROUND BAR	17	PCS	CROSS BRACING
9	M16 TURNBUCKLES	12	PCS	TURNBUCKLES
SC5	W 12" x 6-1/2" x 27 Lbs/FT. X 20ft	12	PCS	STEEL COLUMN
BP5	300mmx350mmx20mm	28	PCS	BASE PLATE
AB5	25mmØx400mm A325 ANCHOR BOLTS	48	PCS	ANCHOR BOLT
T1	W 12" x 6-1/2" x 27 Lbs/FT. X 20ft	14	PCS	STEEL TRUSS
SB1	W 8" X 4" X 13 Lbs/FT. X 20ft	6	PCS	STEEL BEAM
-	463.2M²	-	M²	FLOOR AREA

 EVERGREEN ENVIRONMENTAL RESOURCES INC.	PROJECT: KURRI-KURRI BATTERY RECYCLING PROJECT		DESIGN BY:	LCC
	CLIENT: PYMORE RECYCLERS INTERNATIONAL PTY. LTD.		DRAWN BY:	MBN
	TITLE: BUILDING 6 & 7 - AIR COMPRESSOR PLANT & OXYGEN PLANT		CHECKED BY:	LCC
	DRAWING NO: KKBR-0013	REV.0	APPROVED BY:	MW
	NOTE: THIS DRAWING IS PROPERTY OF EVERGREEN ENVIRONMENTAL RESOURCES INC. AND SUCH MUST NOT BE REPRODUCED, COPIED, IN PART OR IN WHOLE WITHOUT CONSENT.		DATE:	NOV.8 2016
SCALE: 1:125			SHT NO: 1/1	

ALL DIMENSION ARE IN MILLIMETER UNLESS OTHERWISE SPECIFIED.

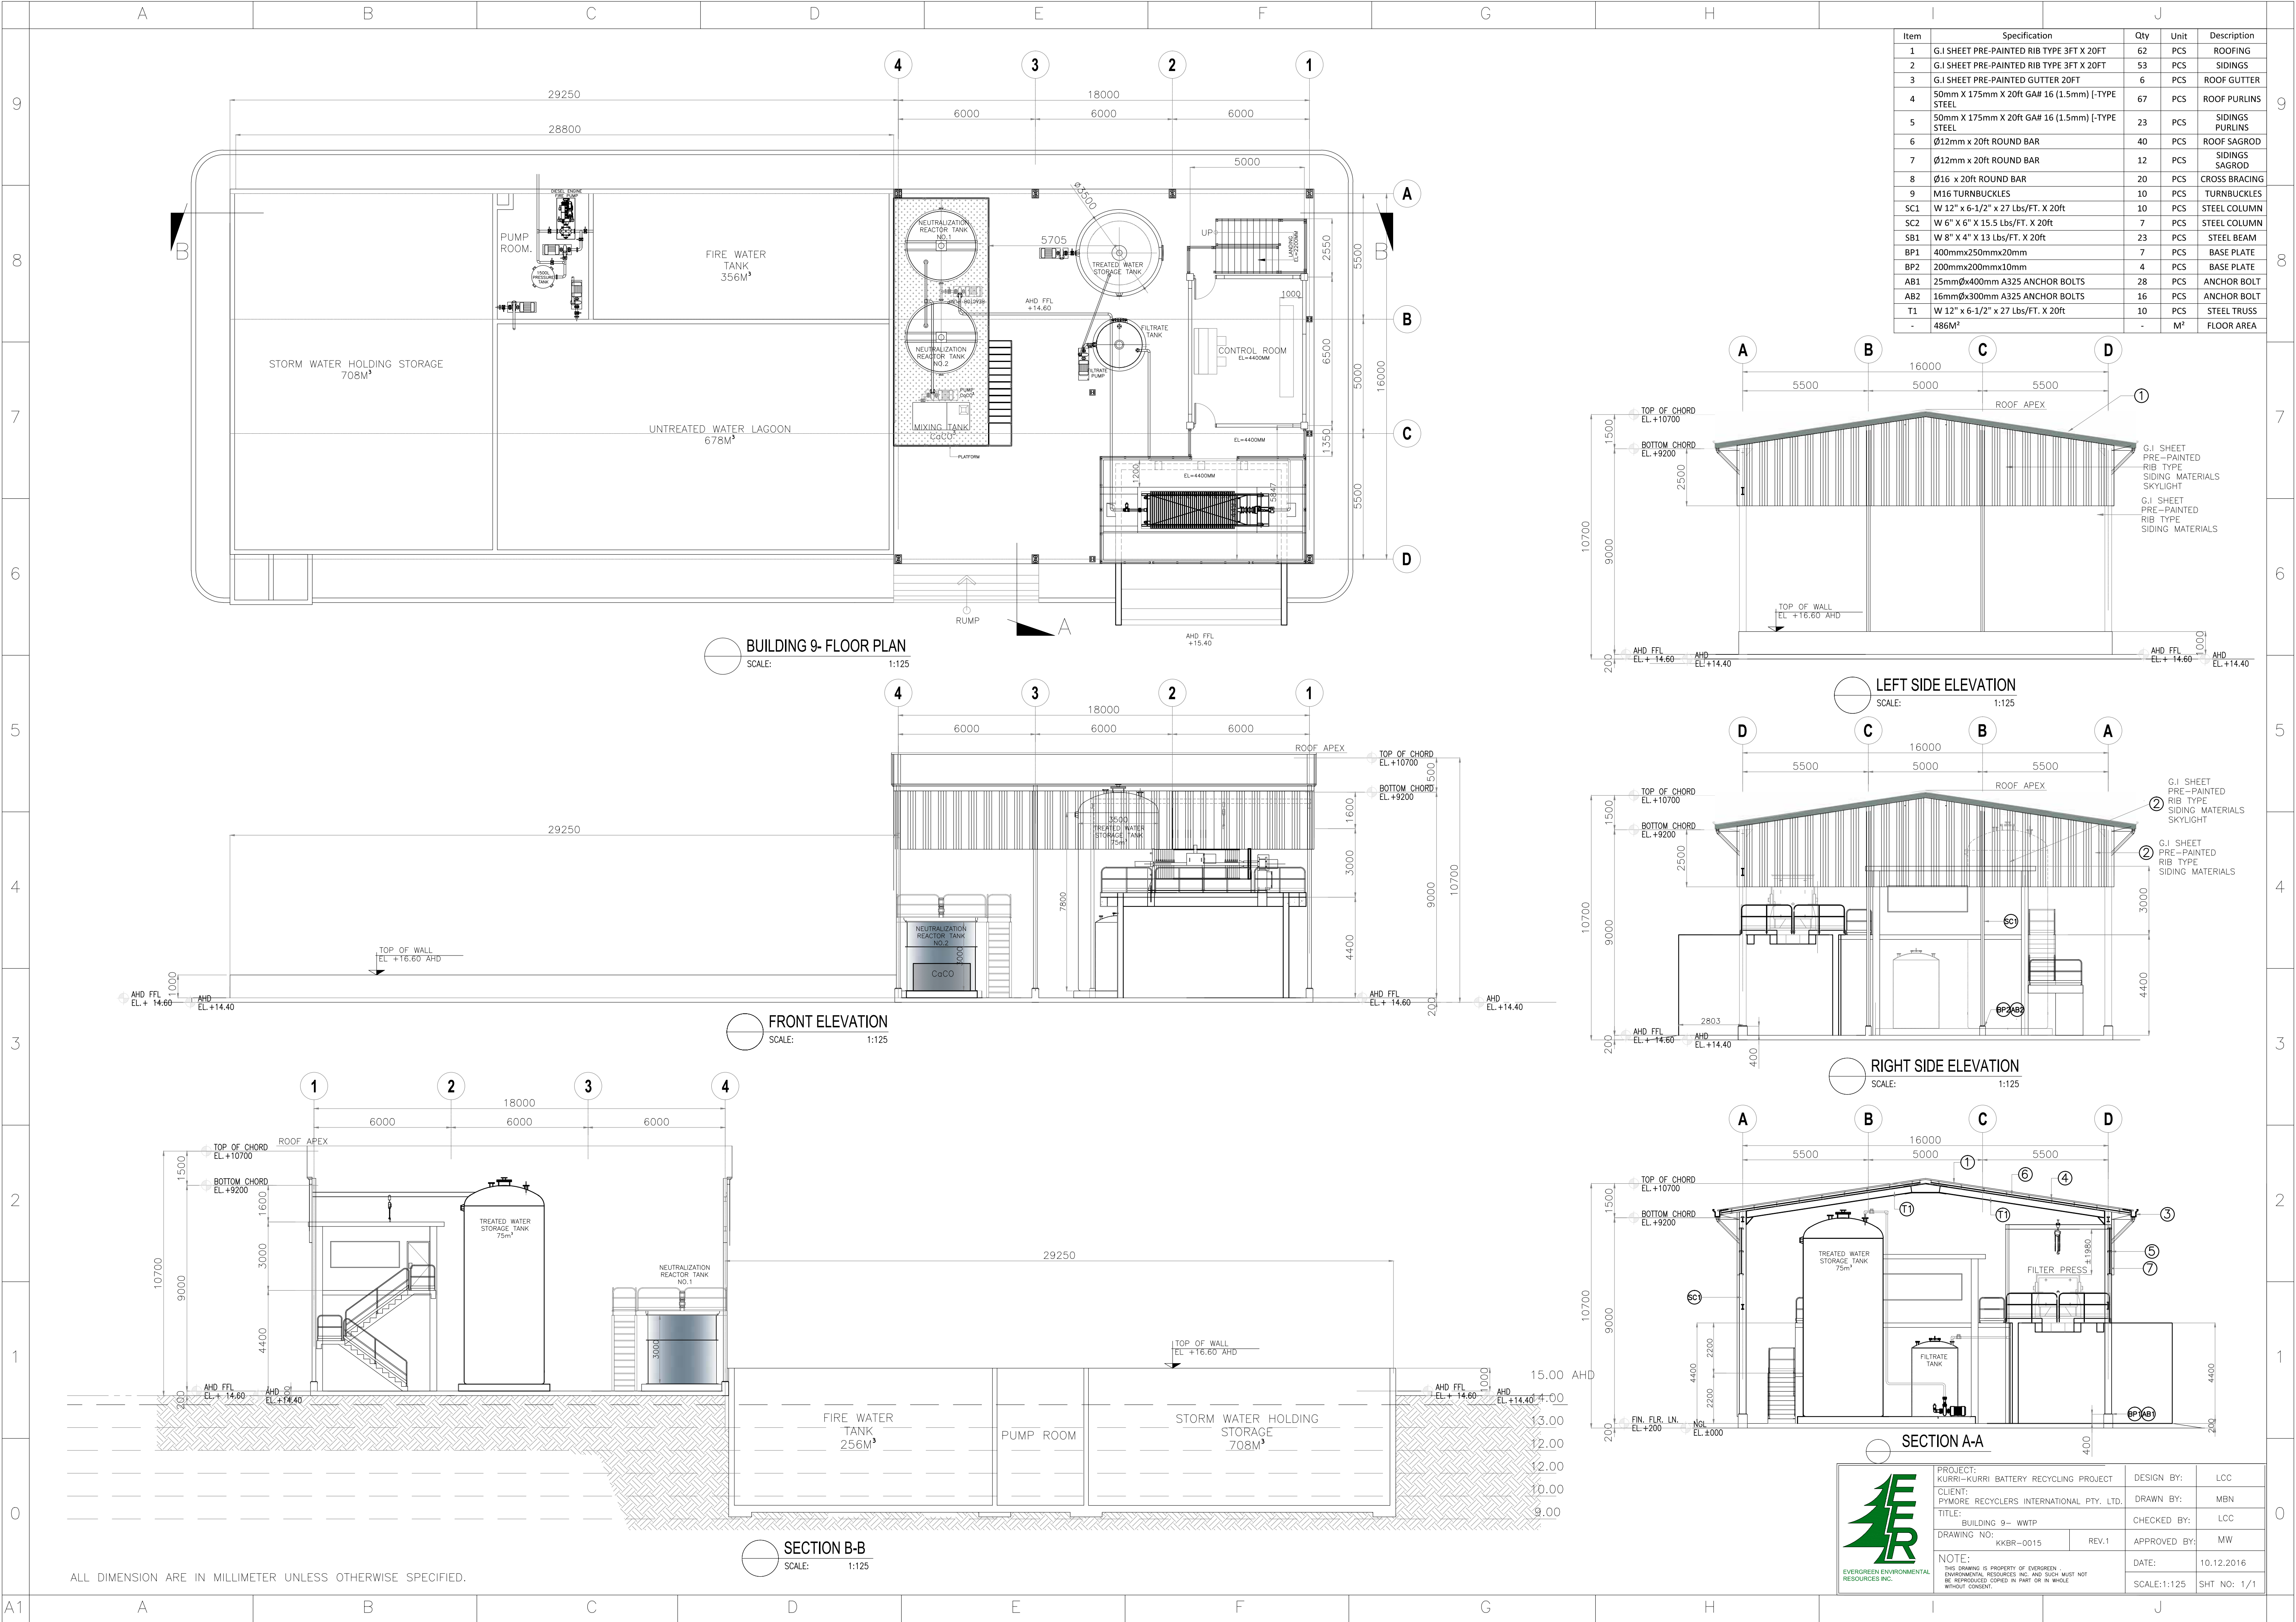

ALL DIMENSION ARE IN MILLIMETER UNLESS OTHERWISE SPECIFIED.

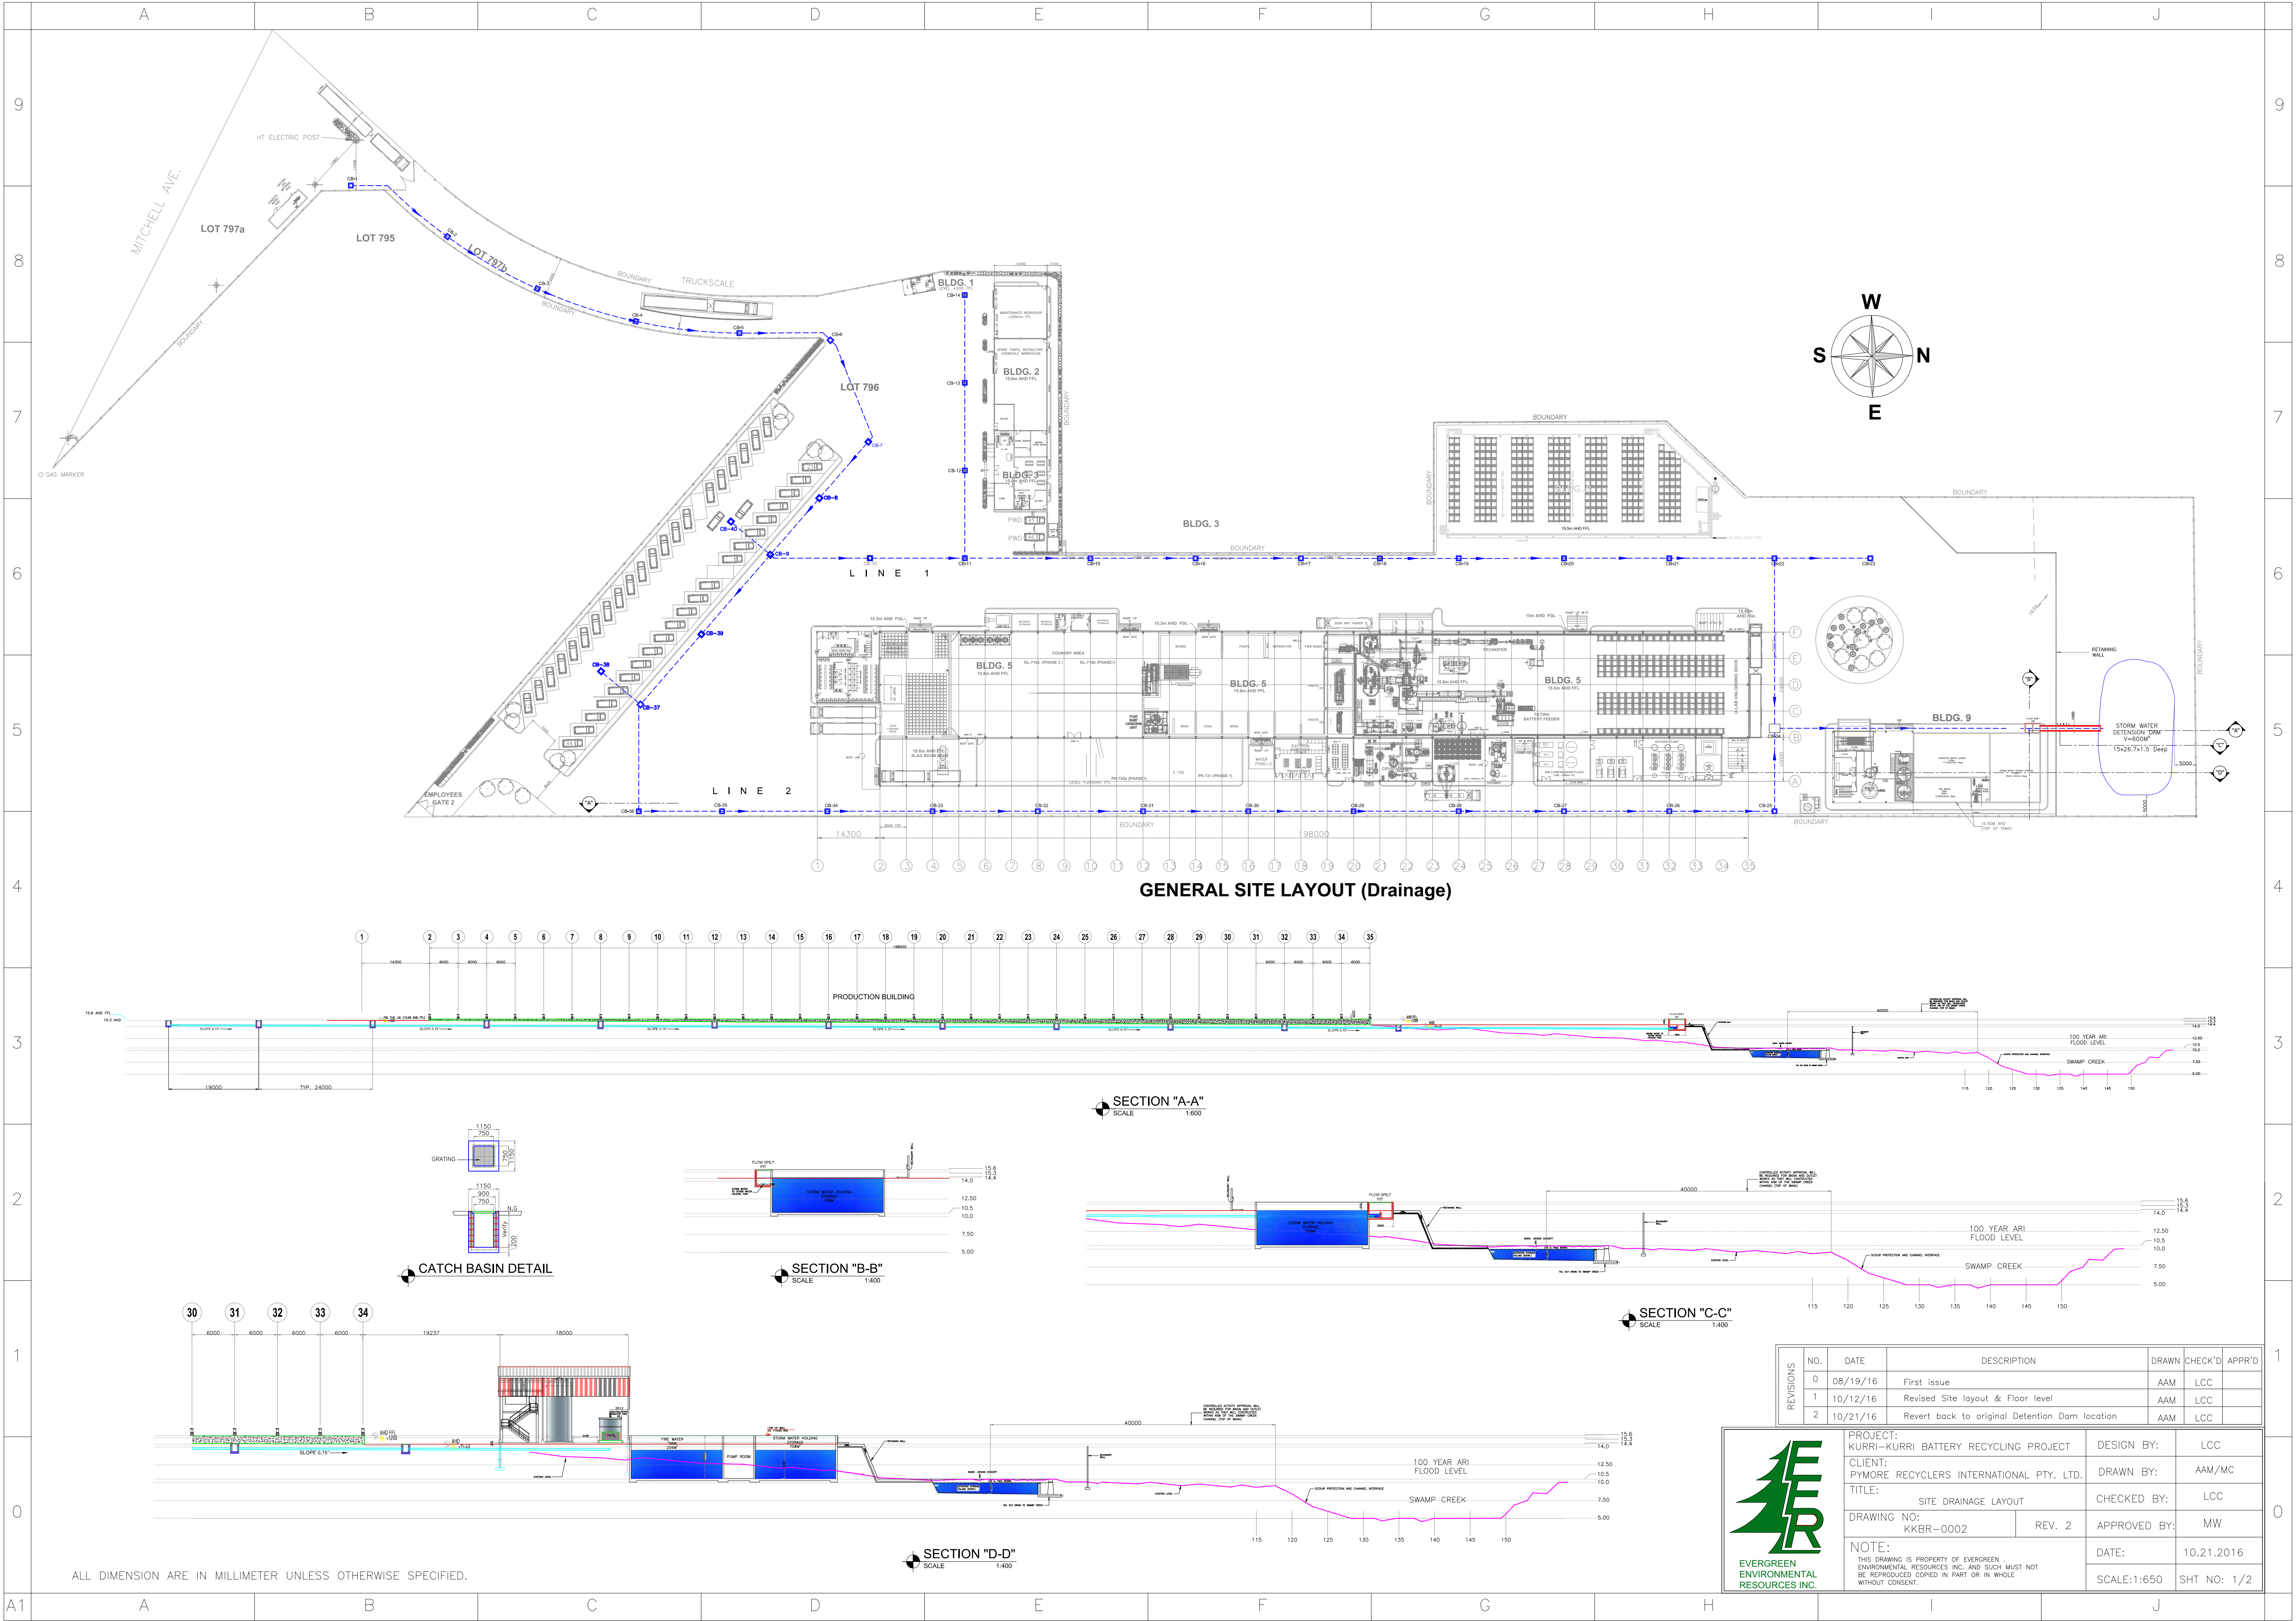

GENERAL SITE LAYOUT (Drainage)

SECTION "A-A"
SCALE 1:500

SECTION "B-B"
SCALE 1:400

SECTION "C-C"
SCALE 1:400

SECTION "D-D"
SCALE 1:400

CATCH BASIN DETAIL

NO.	DATE	DESCRIPTION	DRAWN	CHECK'D	APPR'D
0	08/19/16	First issue	AAM	LCC	
1	10/12/16	Revised Site layout & Floor level	AAM	LCC	
2	10/21/16	Revert back to original Detention Dam location	AAM	LCC	



EVERGREEN
ENVIRONMENTAL
RESOURCES INC.

PROJECT:
KURRI-KURRI BATTERY RECYCLING PROJECT

CLIENT:
PYMORE RECYCLERS INTERNATIONAL PTY. LTD.

TITLE:
SITE DRAINAGE LAYOUT

DRAWING NO:
KKBR-0002

NOTE:
THIS DRAWING IS PROPERTY OF EVERGREEN ENVIRONMENTAL RESOURCES INC. AND SUCH MUST NOT BE REPRODUCED COPIED IN PART OR IN WHOLE WITHOUT CONSENT.

DESIGN BY:
LCC

DRAWN BY:
AAM/MC

CHECKED BY:
LCC


APPROVED BY:
MW

DATE:
10.21.2016

SCALE:1:650

SHT NO: 1/2

ALL DIMENSION ARE IN MILLIMETER UNLESS OTHERWISE SPECIFIED.

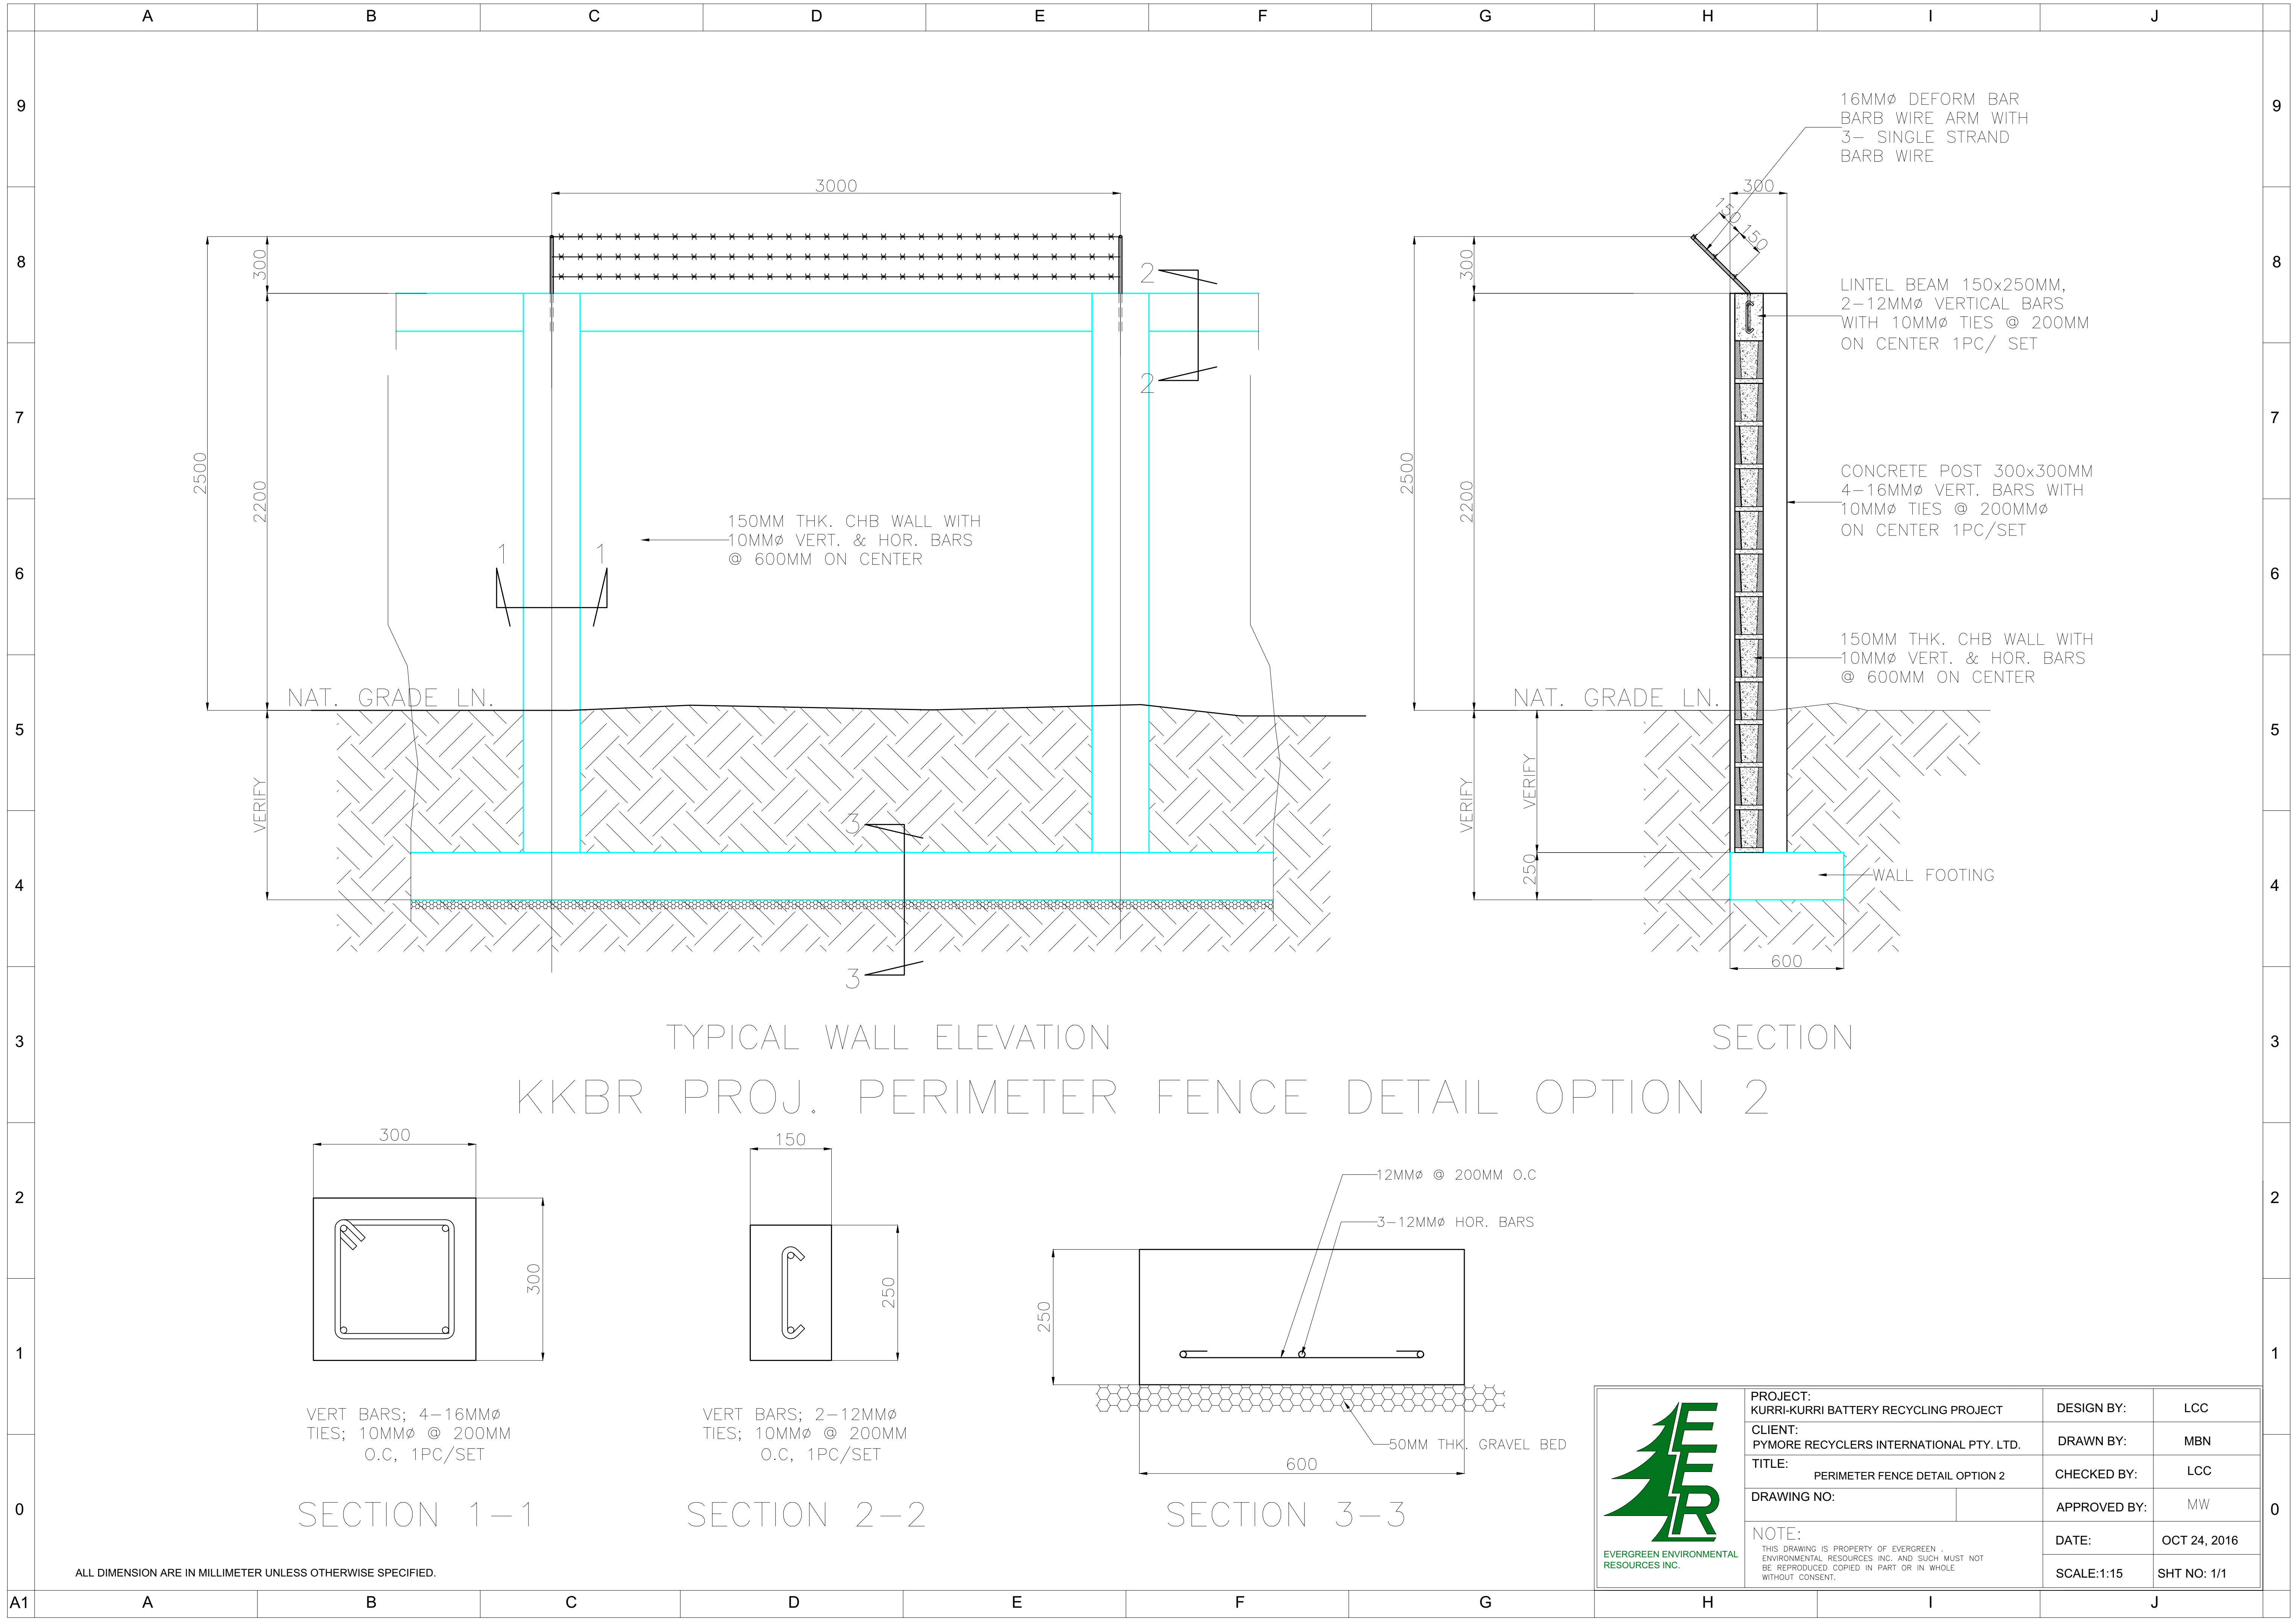


TYPICAL WALL ELEVATION

SECTION 1-1

SECTION 2-2


SECTION 3-3

KKBR PROJ. PERIMETER FENCE DETAIL OPTION 2

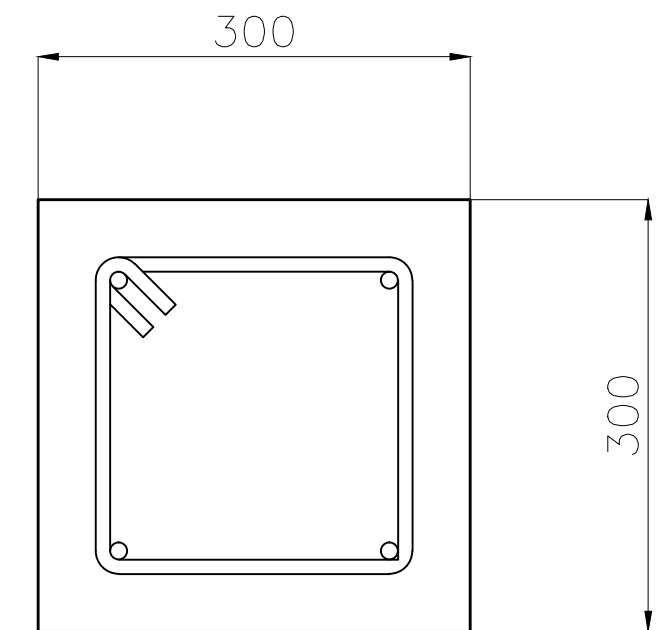


VERT BARS; 4-16MMØ
TIES; 10MMØ @ 200MM
O.C, 1PC/SET

SECTION 1-1

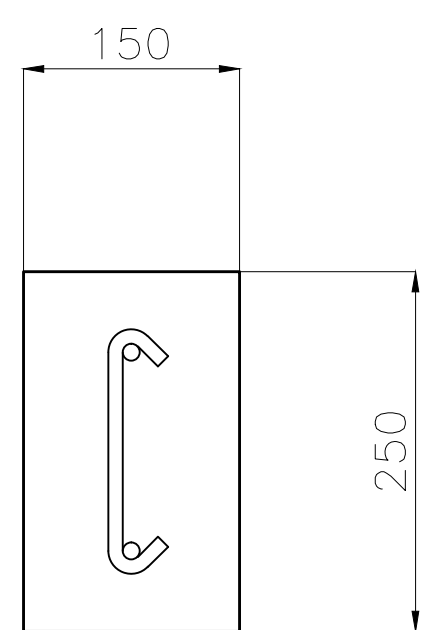

VERT BARS; 2-12MMØ
TIES; 10MMØ @ 200MM
O.C, 1PC/SET

SECTION 2-2

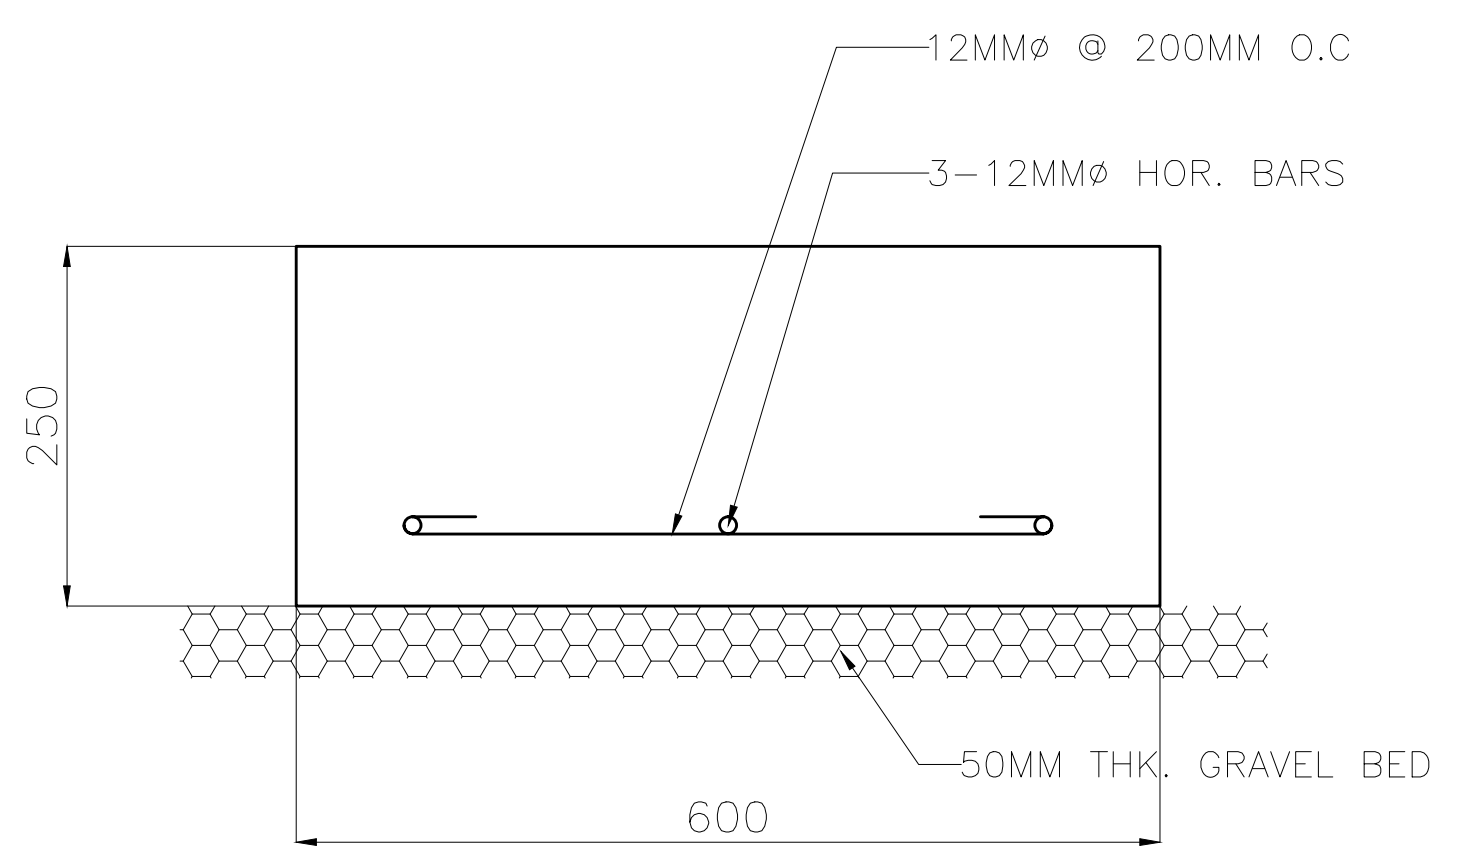


SECTION 3-3



PROJECT:	KURRI-KURRI BATTERY RECYCLING PROJECT	DESIGN BY:	LCC
CLIENT:	PYMORE RECYCLERS INTERNATIONAL PTY. LTD.	DRAWN BY:	MBN
TITLE:	PERIMETER FENCE DETAIL OPTION 2	CHECKED BY:	LCC
DRAWING NO:		APPROVED BY:	MW
NOTE: THIS DRAWING IS PROPERTY OF EVERGREEN . ENVIRONMENTAL RESOURCES INC. AND SUCH MUST NOT BE REPRODUCED COPIED IN PART OR IN WHOLE WITHOUT CONSENT.		DATE:	OCT 24, 2016
		SCALE:1:15	SHT NO: 1/1

ALL DIMENSION ARE IN MILLIMETER UNLESS OTHERWISE SPECIFIED.

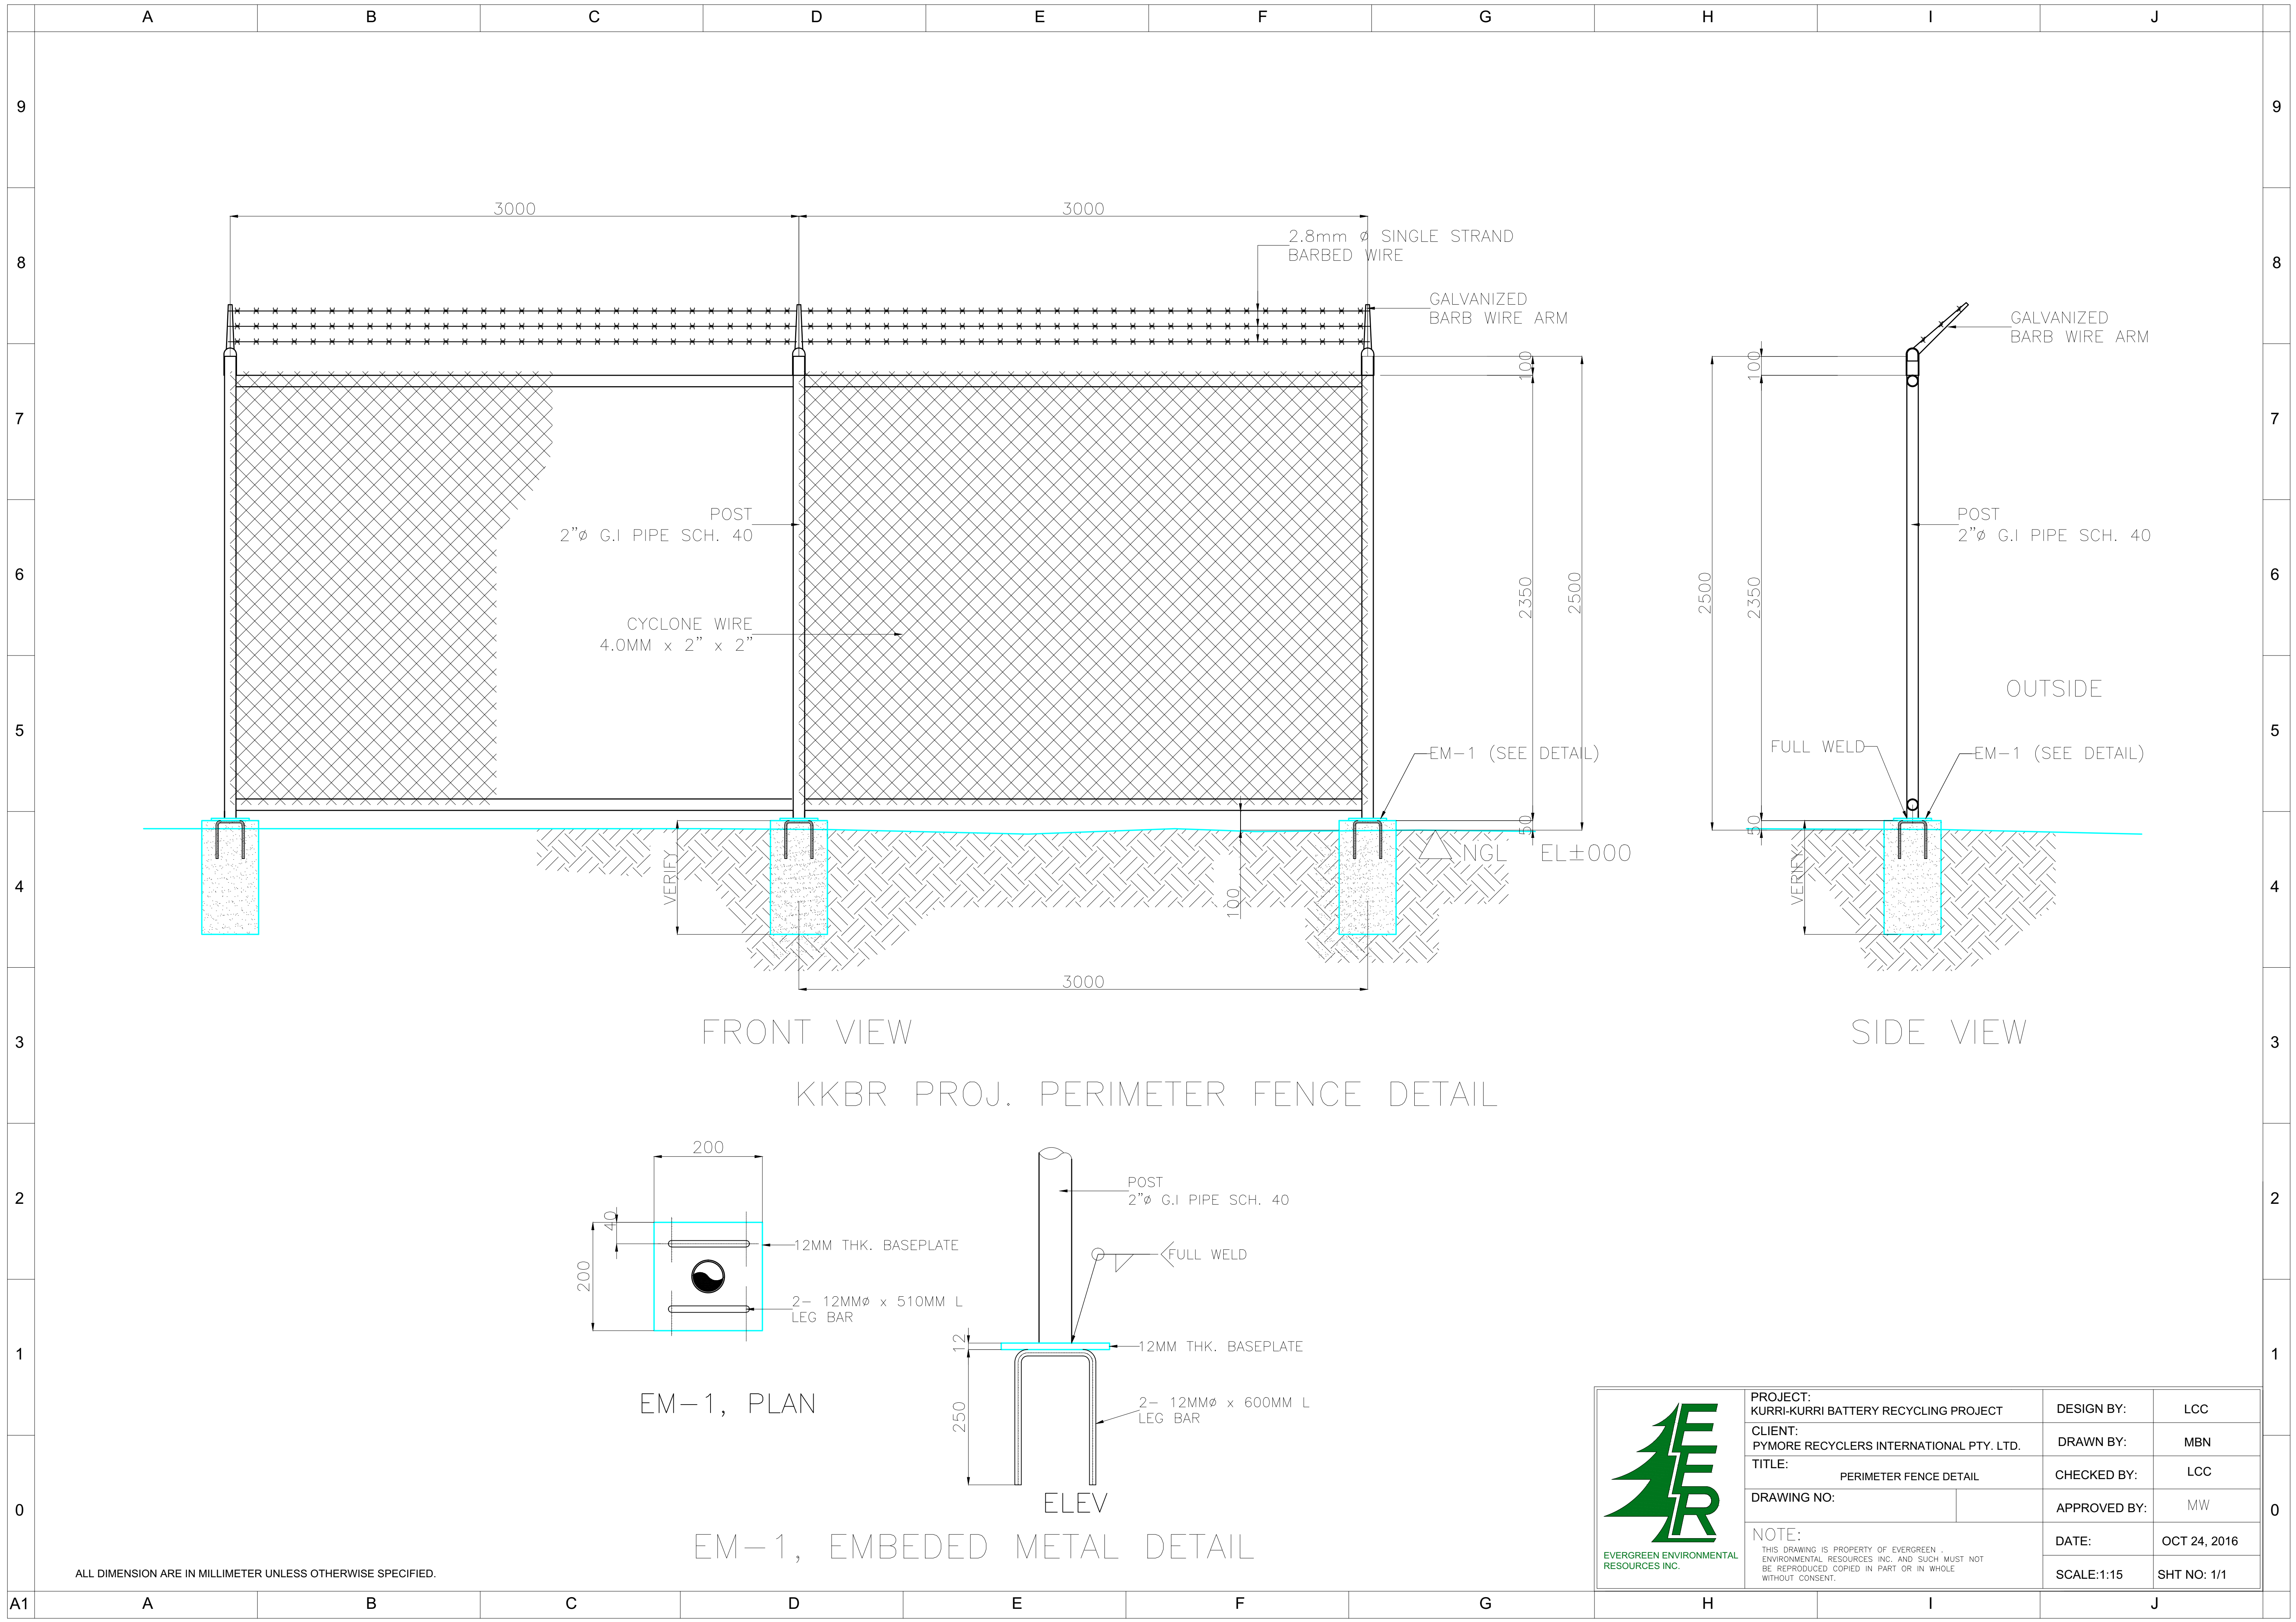

ALL DIMENSION ARE IN MILLIMETER UNLESS OTHERWISE SPECIFIED.

	PROJECT: KURRI-KURRI BATTERY RECYCLING PROJECT	DESIGN BY:	LCC
	CLIENT: PYMORE RECYCLERS INTERNATIONAL PTY. LTD.	DRAWN BY:	MBN
	TITLE: PERIMETER FENCE DETAIL	CHECKED BY:	LCC
	DRAWING NO:	APPROVED BY:	MW
	NOTE: THIS DRAWING IS PROPERTY OF EVERGREEN ENVIRONMENTAL RESOURCES INC. AND SUCH MUST NOT BE REPRODUCED COPIED IN PART OR IN WHOLE WITHOUT CONSENT.	DATE:	OCT 24, 2016
		SCALE: 1:15	SHT NO: 1/1