


DO NOT SCALE DRAWINGS. VERIFY ALL DIMENSIONS ON SITE.
© 2015 FRASERS PROPERTY AUSTRALIA PTY LTD.
This drawing is confidential and is subject to copyright. It may not be copied, used, reproduced or transmitted in any way or in any form without the express permission of Frasers Property Australia Pty Ltd.

REVISION	DESCRIPTION	DATE
A	DA ISSUE	06.04.17

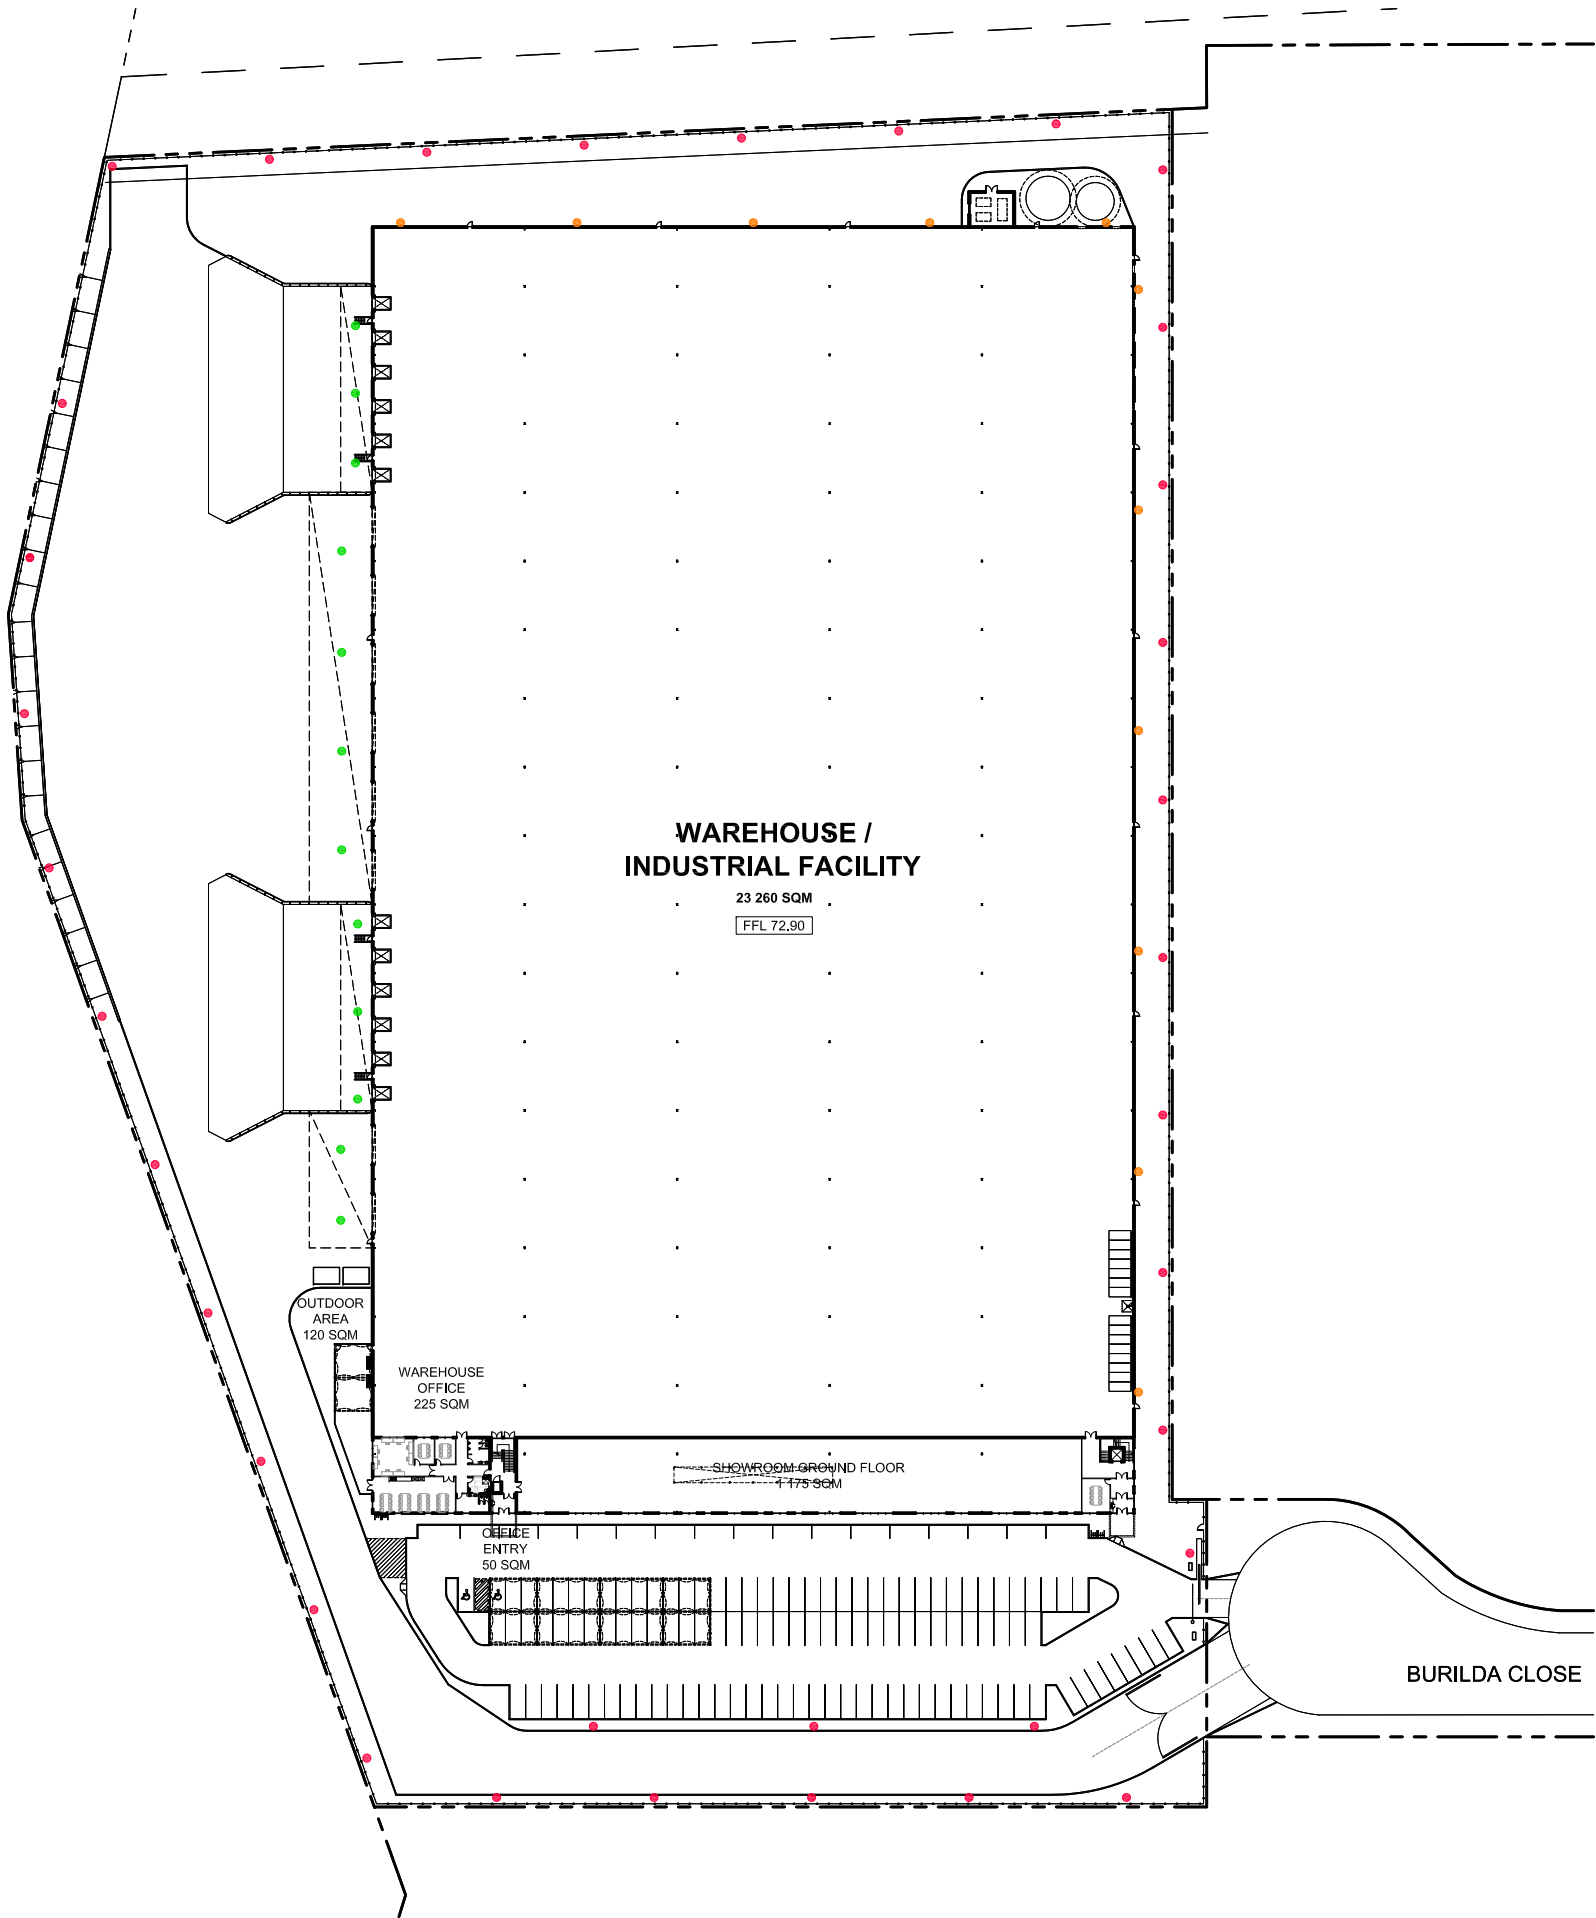

LEGEND

- CAR PARK LIGHT APPROX 5M HIGH
- WALL MOUNTED LIGHTING
- LIGHT TO UNDERSIDE OF AWNING

FINAL LIGHT POSITIONS SUBJECT TO BCA REQUIREMENTS



COMMERCIAL & INDUSTRIAL DIVISION
1 HOMERUSH BAY DRIVE
BUILDING C, LEVEL 5
RHODES NSW 2138
PO BOX 3307
RHODES NSW 2138
PHONE 02 9767 2000
FAX 02 9767 2908

PROJECT
PROPOSED WAREHOUSE & SPECULATIVE
FACILITY FOR VIVIN IMPORTS

ADDRESS
PROPOSED LOT 3, DP 1213567
No 6 BURILDA CLOSE, WETHERILL PARK

DRAWING TITLE
LIGHTING PLAN

SCALE 1:500 @ B1
DRAWN MP
CHECKED JQ
DATE 06.04.17
JOB NUMBER 0000-00-000

DRAWING NUMBER VI-WSPT-DA-400
ISSUE A

ALL LEVELS ARE INDICATIVE AND SHOULD BE READ IN
CONJUNCTION WITH CIVIL ENGINEER'S DRAWINGS.
FOR FINAL LEVELS OF ALL EARTHWORKS.

ALL LEVELS ARE TO BE +/- 1000mm.

01 LIGHTING PLAN
1:500 @ B1