


1. REFER TO DRG 21-26108-KN-SD-CI-1010 FOR DRAINAGE NOTES.


	NEW GRATED TRENCH DRAIN (300W x 200D)
	NEW STORMWATER PIPE
	NEW STORMWATER PIT
	PIPE FLOW DIRECTION
	NEW GRASSSED DRAINAGE SWALE
	NEW SUBSOL DRAINAGE
	NEW RAINWATER TANK
	NEW DOWNPIPE CONNECTION LINE Ø150 UPVC
	NEW FLUSH POINT
	OVERLAND FLOW DIRECTION

PIT SCHEDULE	
PIT NUMBER	PIT DETAILS
1	600 x 600 GRATED INLET PIT
2	900 x 900 GRATED INLET PIT
3	900 x 900 GRATED INLET PIT
4	900 x 900 GRATED INLET PIT
5	900 x 900 GRATED INLET PIT
6	1200 x 1200 DEEP DROP PIT
7	900 x 900 GRATED INLET PIT
8	900 x 900 GRATED INLET PIT
9	900 x 900 GRATED INLET PIT
10	900 x 900 GRATED INLET PIT
11	900 x 900 GRATED INLET PIT
12	900 x 900 GRATED INLET PIT
13	900 x 900 GRATED INLET PIT
14	900 x 900 GRATED INLET PIT
15	600 x 600 GRATED INLET PIT
16	900 x 900 GRATED INLET PIT
17	600 x 600 GRATED INLET PIT
18	1200 x 1200 DEEP DROP PIT
19	900 x 900 GRATED INLET PIT
20	900 x 900 GRATED INLET PIT
21	900 x 900 GRATED INLET DROP PIT
22	900 x 900 GRATED INLET PIT
23	900 x 900 GRATED INLET PIT
24	900 x 900 GRATED INLET PIT
25	900 x 900 GRATED INLET PIT
26	GPT-HUMEGARD
27	3000 x 900 IN-SITU ACCESS PIT
28	3000 x 900 IN-SITU ACCESS PIT
29	1200 x 1200 DEEP DROP PIT
30	900 x 900 GRATED INLET PIT
31	900 x 900 GRATED INLET PIT
32	900 x 900 GRATED INLET PIT
33	900 x 900 GRATED INLET PIT
34	900 x 900 GRATED INLET PIT
35	900 x 900 GRATED INLET PIT
36	900 x 900 GRATED INLET PIT
37	900 x 900 GRATED INLET PIT
38	900 x 900 GRATED INLET PIT
39	900 x 900 GRATED INLET PIT
40	600 x 600 GRATED INLET PIT
41	600 x 600 GRATED INLET PIT
42	600 x 600 GRATED INLET PIT

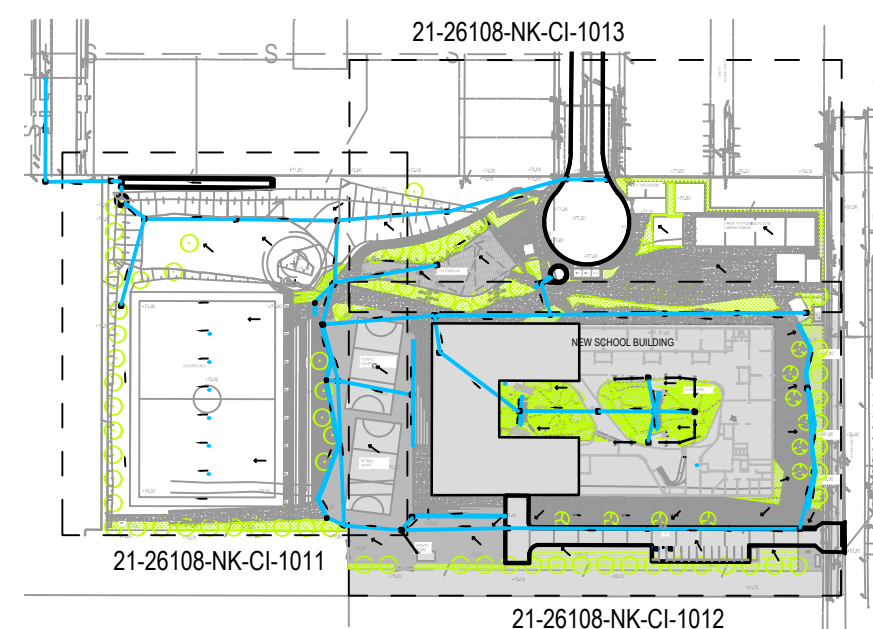

KEY PLAN
SCALE 1:2500


PRELIMINARY

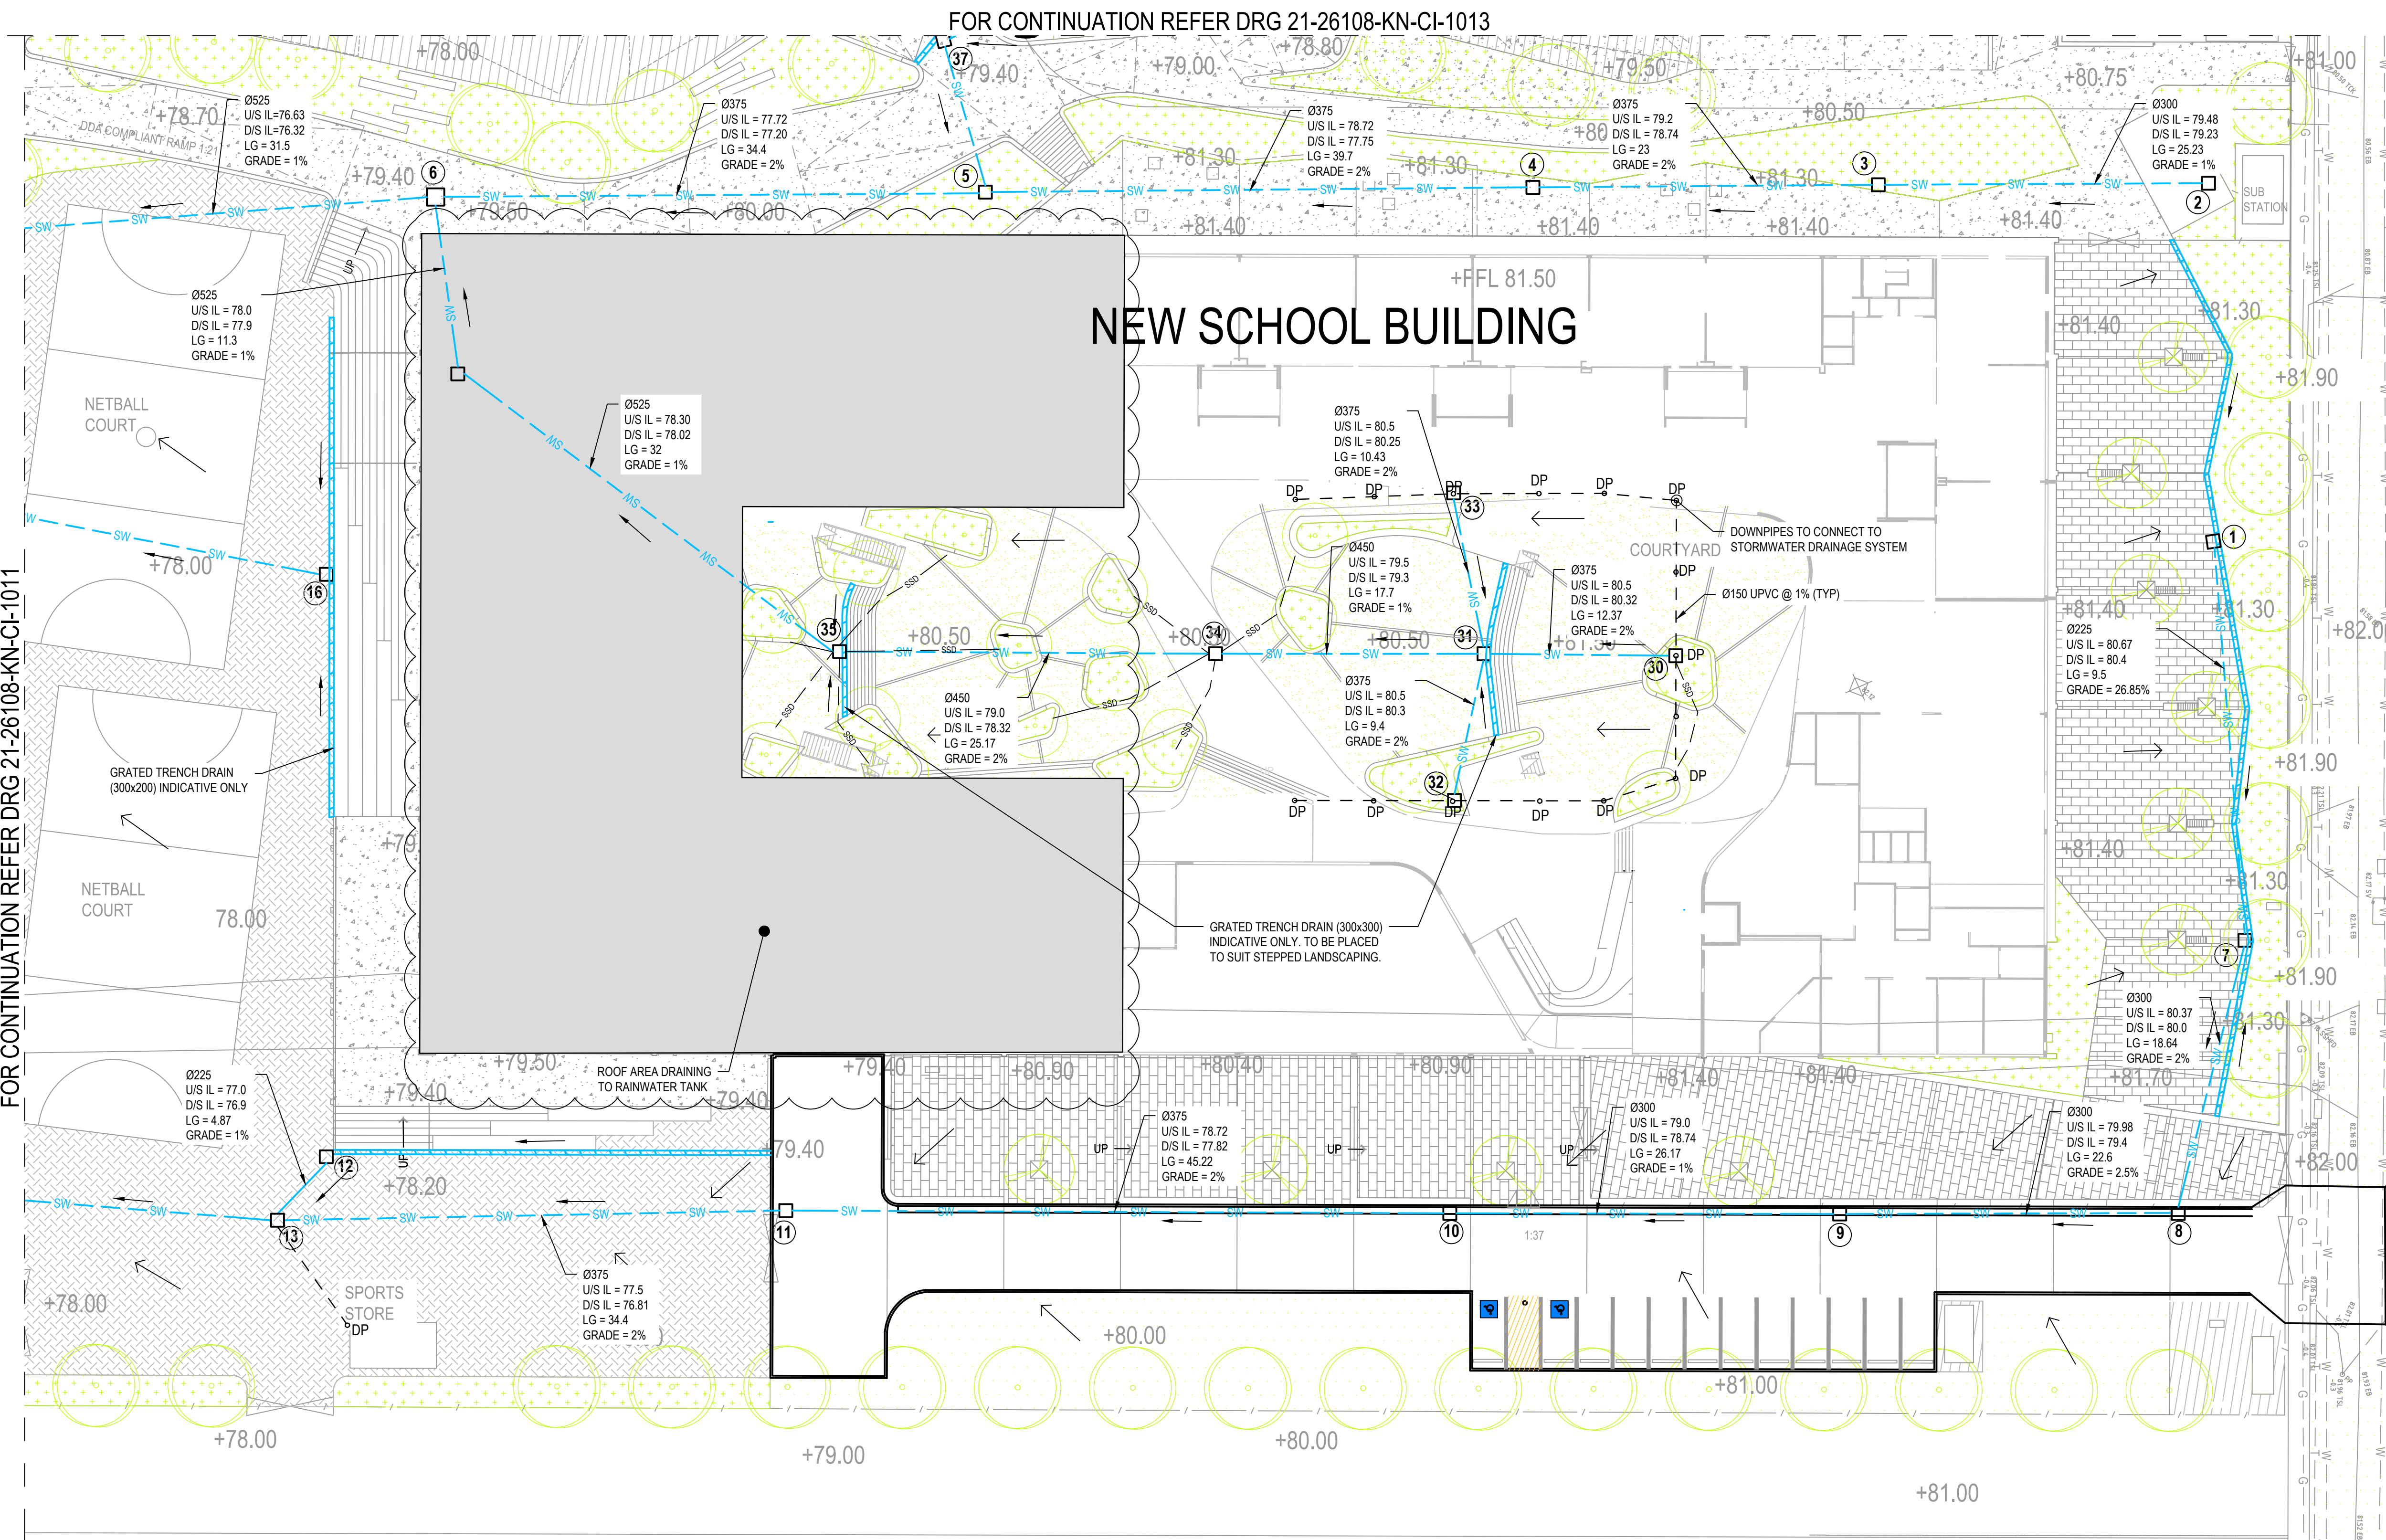

STORMWATER DRAINAGE PLAN

SCALE 1:250

H	ISSUED FOR SSD SUBMISSION		MR	MD*	BM*	02.02.18
G	ISSUED FOR SSD SUBMISSION		MR	MD*	BM*	30.01.18
F	ISSUED FOR SSD SUBMISSION		MR	PM*	MD*	24.11.17
E	SCHEME DESIGN FOR APPROVAL		MR	PM*	MD*	15.09.17
D	ISSUED FOR SD SUBMISSION		MR	PM*	MD*	05.09.17
No	Revision	Note: * indicates signatures on original issue of drawing or last revision of drawing	Drawn	Job checker	Project Manager	Date

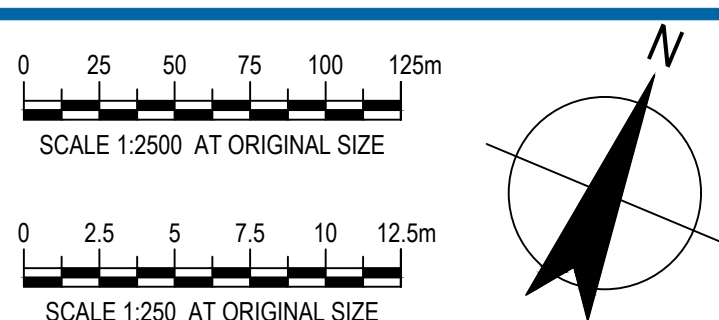

Conditions of Use.
This document may only be used by GHD's client (and any other person who GHD has agreed can use this document) for the purpose for which it was prepared and must not be used by any other person or for any other purpose.

Drawn	M.RANGWALA	Designer	G.DE SWARDT
Drafting Check	A.MACLEAN*	Design Check	A.RAHMAN*
Approved (Project Director) Date			
Scale	1:500	This Drawing must not be used for Construction unless	

Client	NSW DEPARTMENT OF EDUCATION		
Project	NORTH KELLYVILLE PUBLIC SCHOOL		
Title	CIVIL STORMWATER DRAINAGE PLAN-SHEET 2 OF 3		
Original Size			
ss	A1	Drawing No: 21-26108-KN-SD-CI-1012	Rev: G