





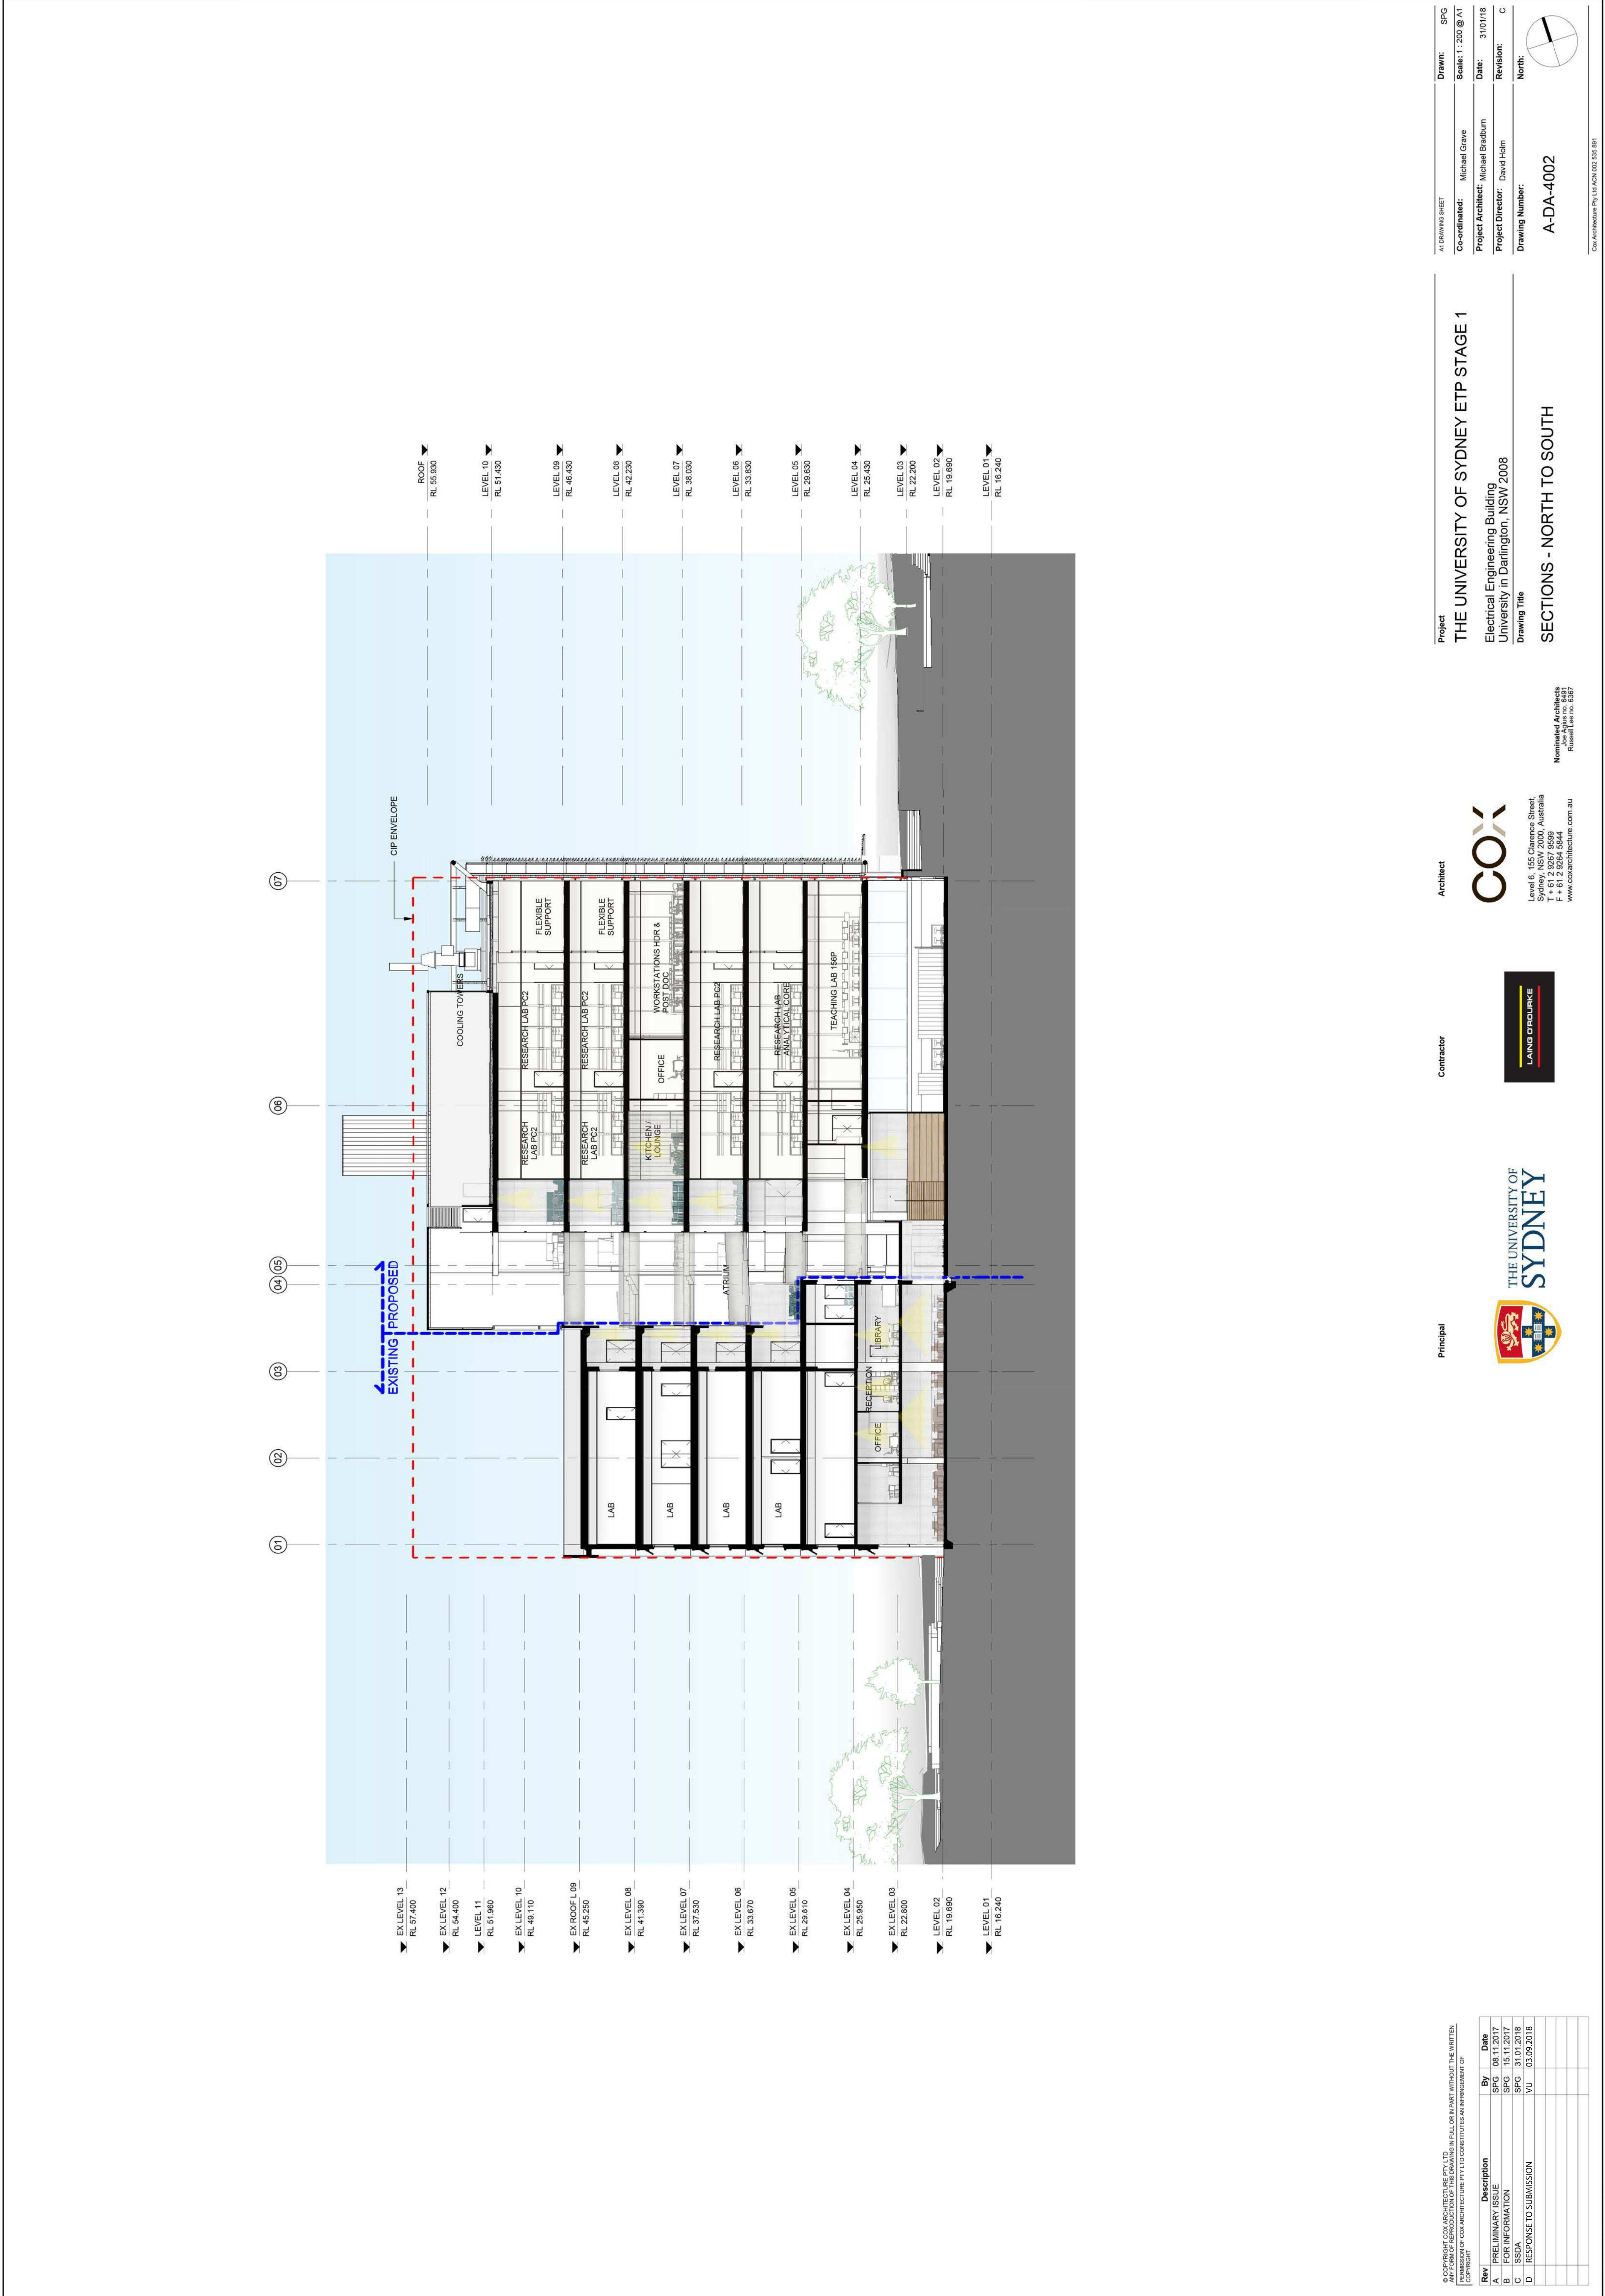

1 EQUINOX - 9AM
30-01 SCALE 1 : 750

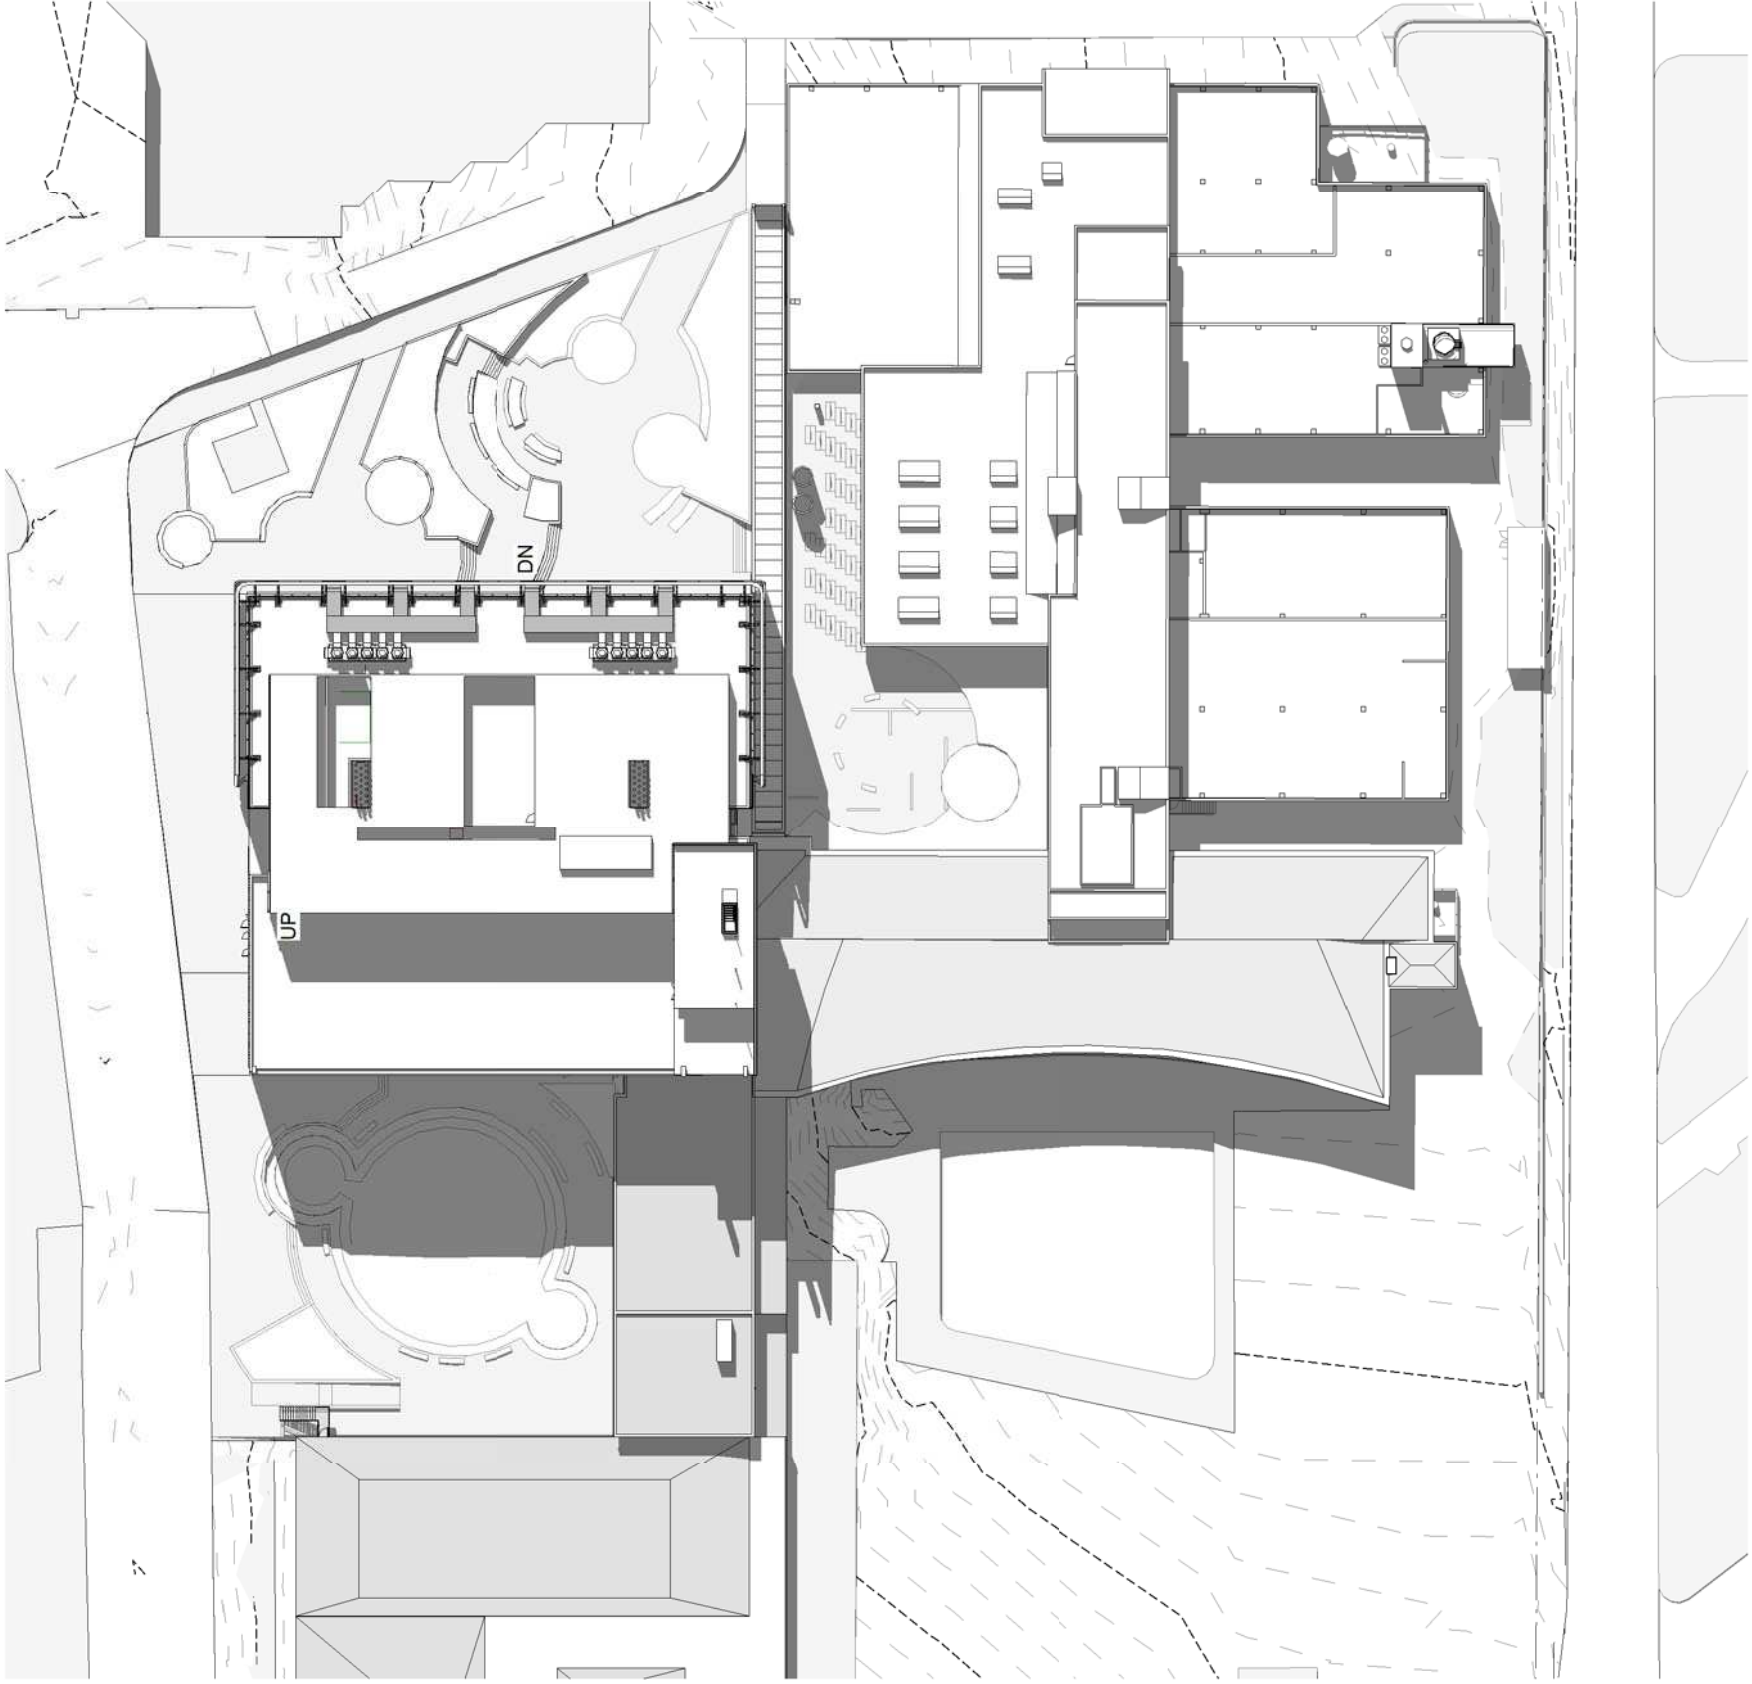

2 EQUINOX - 12PM
30-01 SCALE 1 : 750



3 EQUINOX - 3PM
30-01 SCALE 1 : 750

© COX ARCHITECTURE PTY LTD.
PERMISSION OF COX ARCHITECTURE PTY LTD CONSTITUTES AN INFRINGEMENT OF
COPYRIGHT

Rev	Description	By	Date
A	PRELIMINARY ISSUE	SPG	06.11.2017
B	FOR INFORMATION	SPG	31.07.2018
C	SSDA	SPG	03.07.2018
D	SSDA Response	SPG	03.07.2018

Principal



Contractor



Architect



Level 6, 155 Clarence Street,
Sydney, NSW 2000, Australia
T + 61 2 9287 9599
F + 61 2 9284 3544
www.coxarchitecture.com.au

Nominated Architects
Joe Agius no. 5191
Richard Lee no. 5207

EQUINOX

Drawing Title

Electrical Engineering Building
University in Darling, NSW 2008

Project
THE UNIVERSITY OF SYDNEY ETP STAGE 1

A1 DRAWING SHEET

Drawn: SPG

Scale: 1 : 750 @ A1

Date: 31/07/18


Project Architect: Michael Bradburn

Project Director: David Holm

Revision: D

North:

A-DA-8003

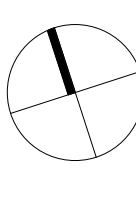




1 SUMMER SOLSTICE - 9AM
30-01 SCALE 1 : 750




2 SUMMER SOLSTICE - 3PM
30-01 SCALE 1 : 750

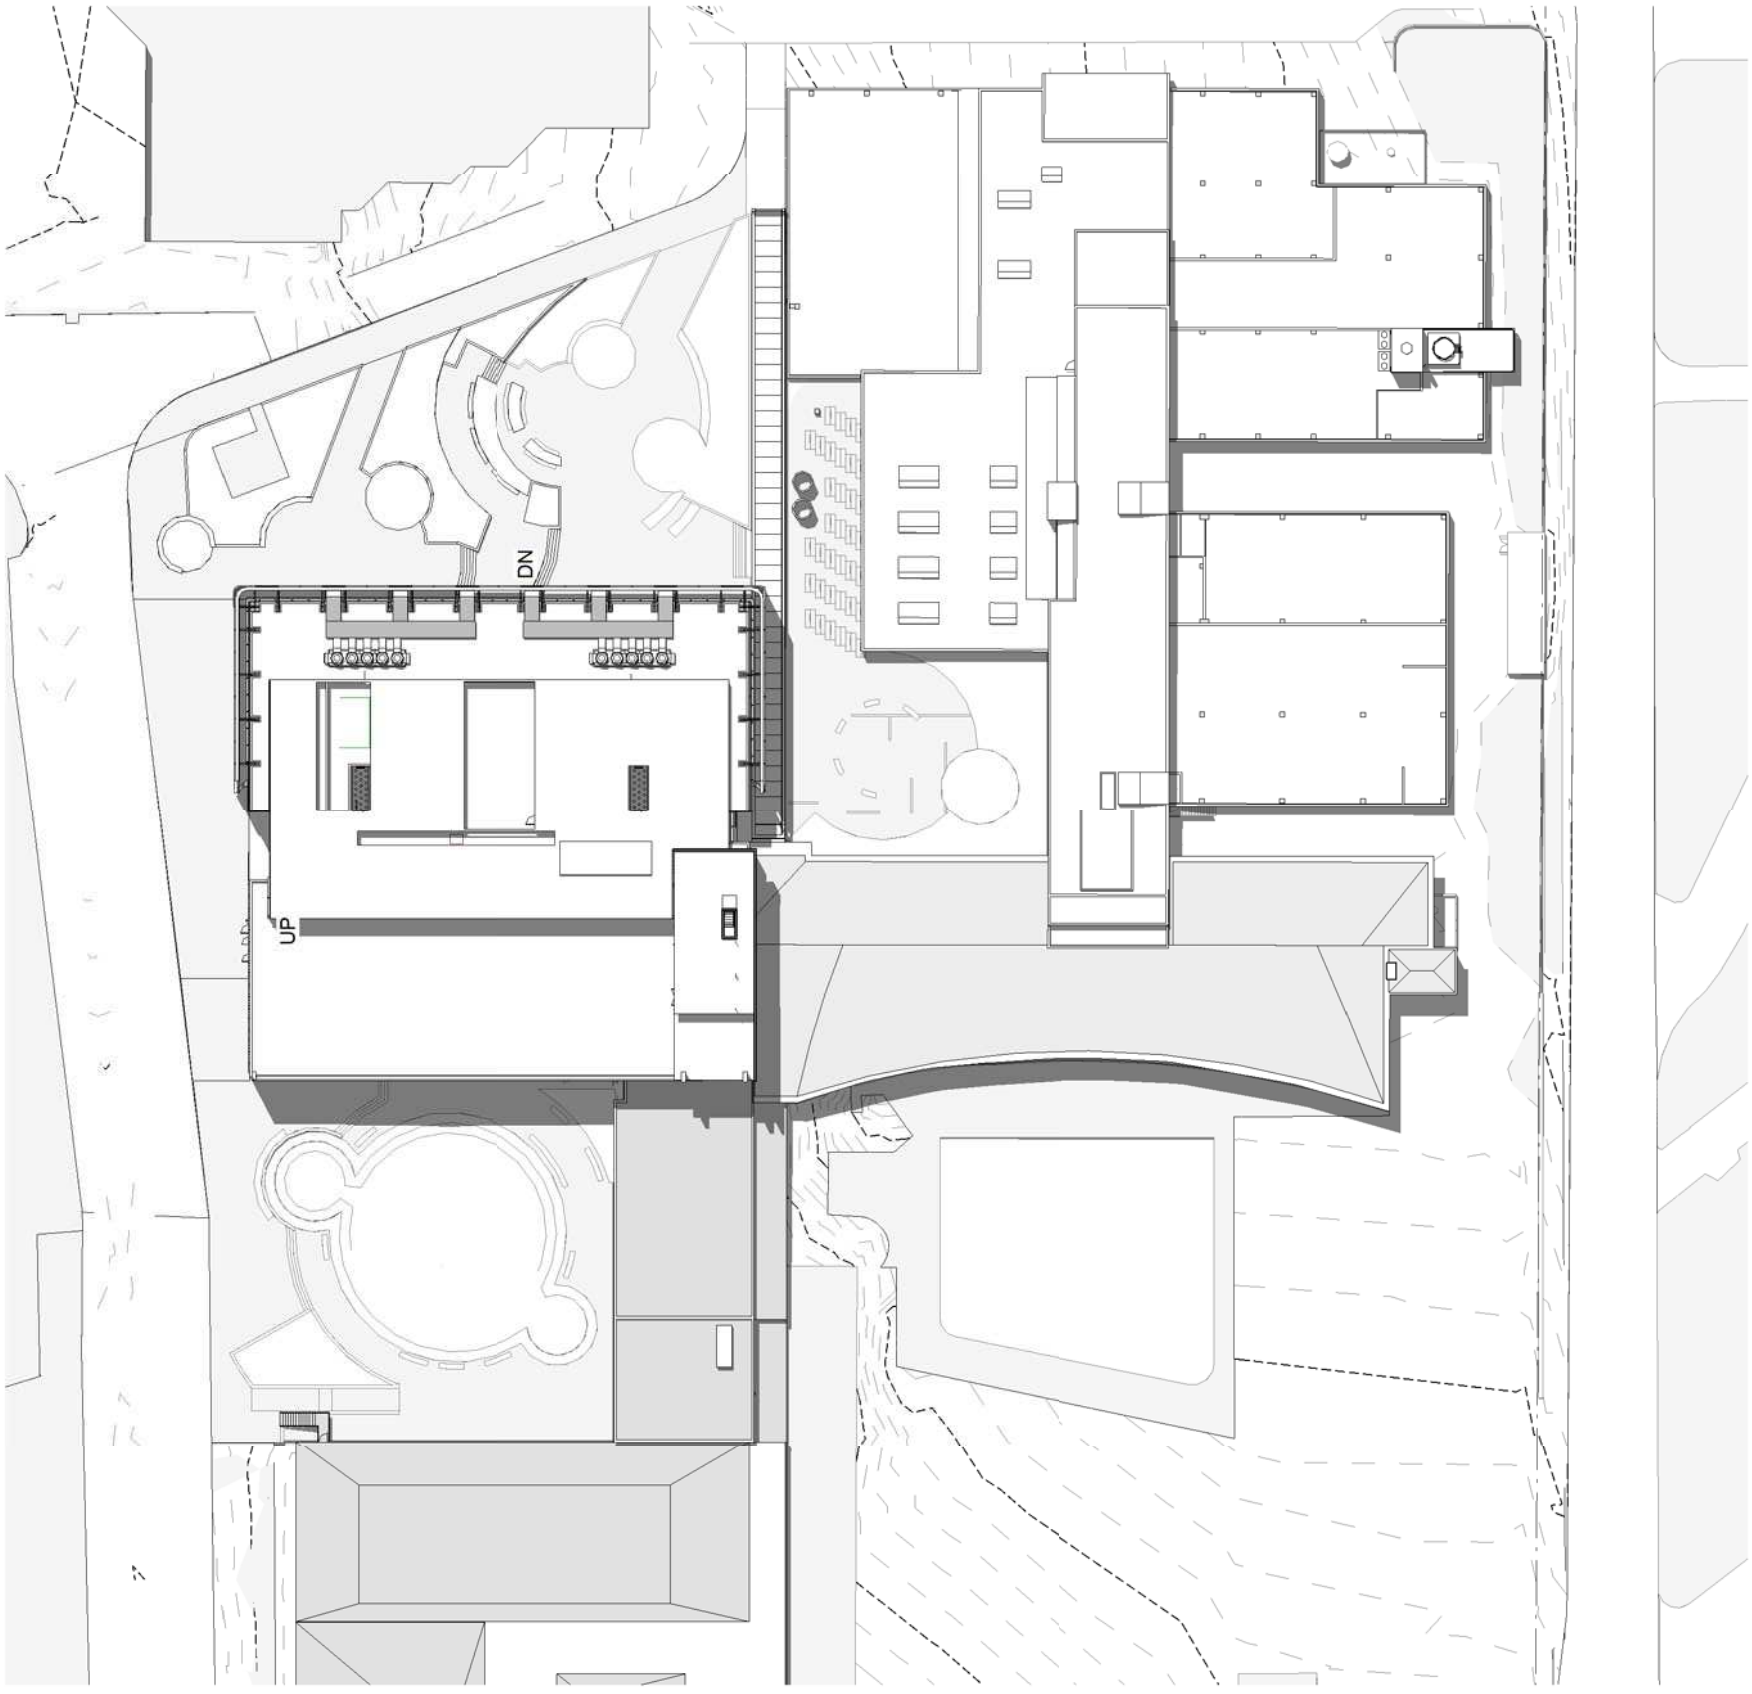

3 SUMMER SOLSTICE - 12PM
30-01 SCALE 1 : 750

© COX ARCHITECTS PTY LTD.
PERMISSION OF COX ARCHITECTURE PTY LTD CONSTITUTES AN INFRINGEMENT OF
COPYRIGHT

Rev	SSJA Response	Description	By	Date
A			SPG	03/07/2016

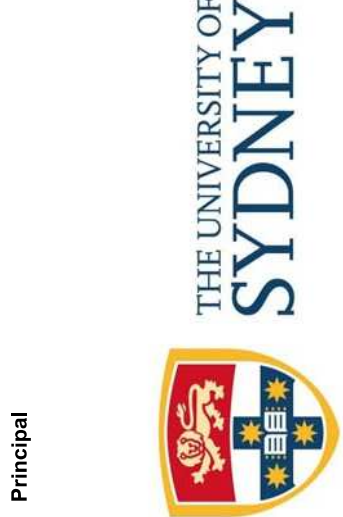


Architect
COX
Level 6, 155 Clarence Street,
Sydney, NSW 2000, Australia
T + 61 2 9287 9599
F + 61 2 9284 3544
www.coxarchitecture.com.au

Nominated Architects
Joe Agius no. 5191
Richard Lee no. 5207

Project
THE UNIVERSITY OF SYDNEY ETP STAGE 1
Electrical Engineering Building
University in Darlington, NSW 2008
Drawing Title
SUMMER SOLSTICE

Project
THE UNIVERSITY OF SYDNEY ETP STAGE 1
Electrical Engineering Building
University in Darlington, NSW 2008
Drawing Title
SUMMER SOLSTICE

Drawn: SPG
Co-ordinated: Michael Grave
Project Architect: Michael Bradburn
Project Director: David Holm
Date: 07/03/16
Revision: A
North:
Drawing Number:
A-DA-8004

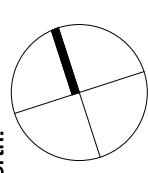



2 WINTER SOLSTICE - 9AM
30-01 SCALE 1 : 750



3 WINTER SOLSTICE - 12PM
30-01 SCALE 1 : 750

© COX ARCHITECTURE PTY LTD.
PERMISSION OF COX ARCHITECTURE PTY LTD CONSTITUTES AN INFRINGEMENT OF
COPYRIGHT

Rev	Description	By	Date
A	SSA Response	SPG	03/07/2016

Principal



Contractor



Architect





Level 6, 155 Clarence Street,
Sydney, NSW 2000, Australia
T + 61 2 9287 9599
F + 61 2 9284 3544
www.coxarchitecture.com.au

Nominated Architects
Johanna Allen no. 5491
Richard Lee no. 5207

Project
THE UNIVERSITY OF SYDNEY ETP STAGE 1
Electrical Engineering Building
University in Darlington, NSW 2008
Drawing Title
WINTER SOLSTICE

Drawn: SPG
Co-ordinated: Michael Grave
Project Architect: Michael Bradburn
Project Director: David Holm
Date: 07/03/16
Revision: A
Drawing Number:
A-DA-8005

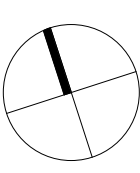

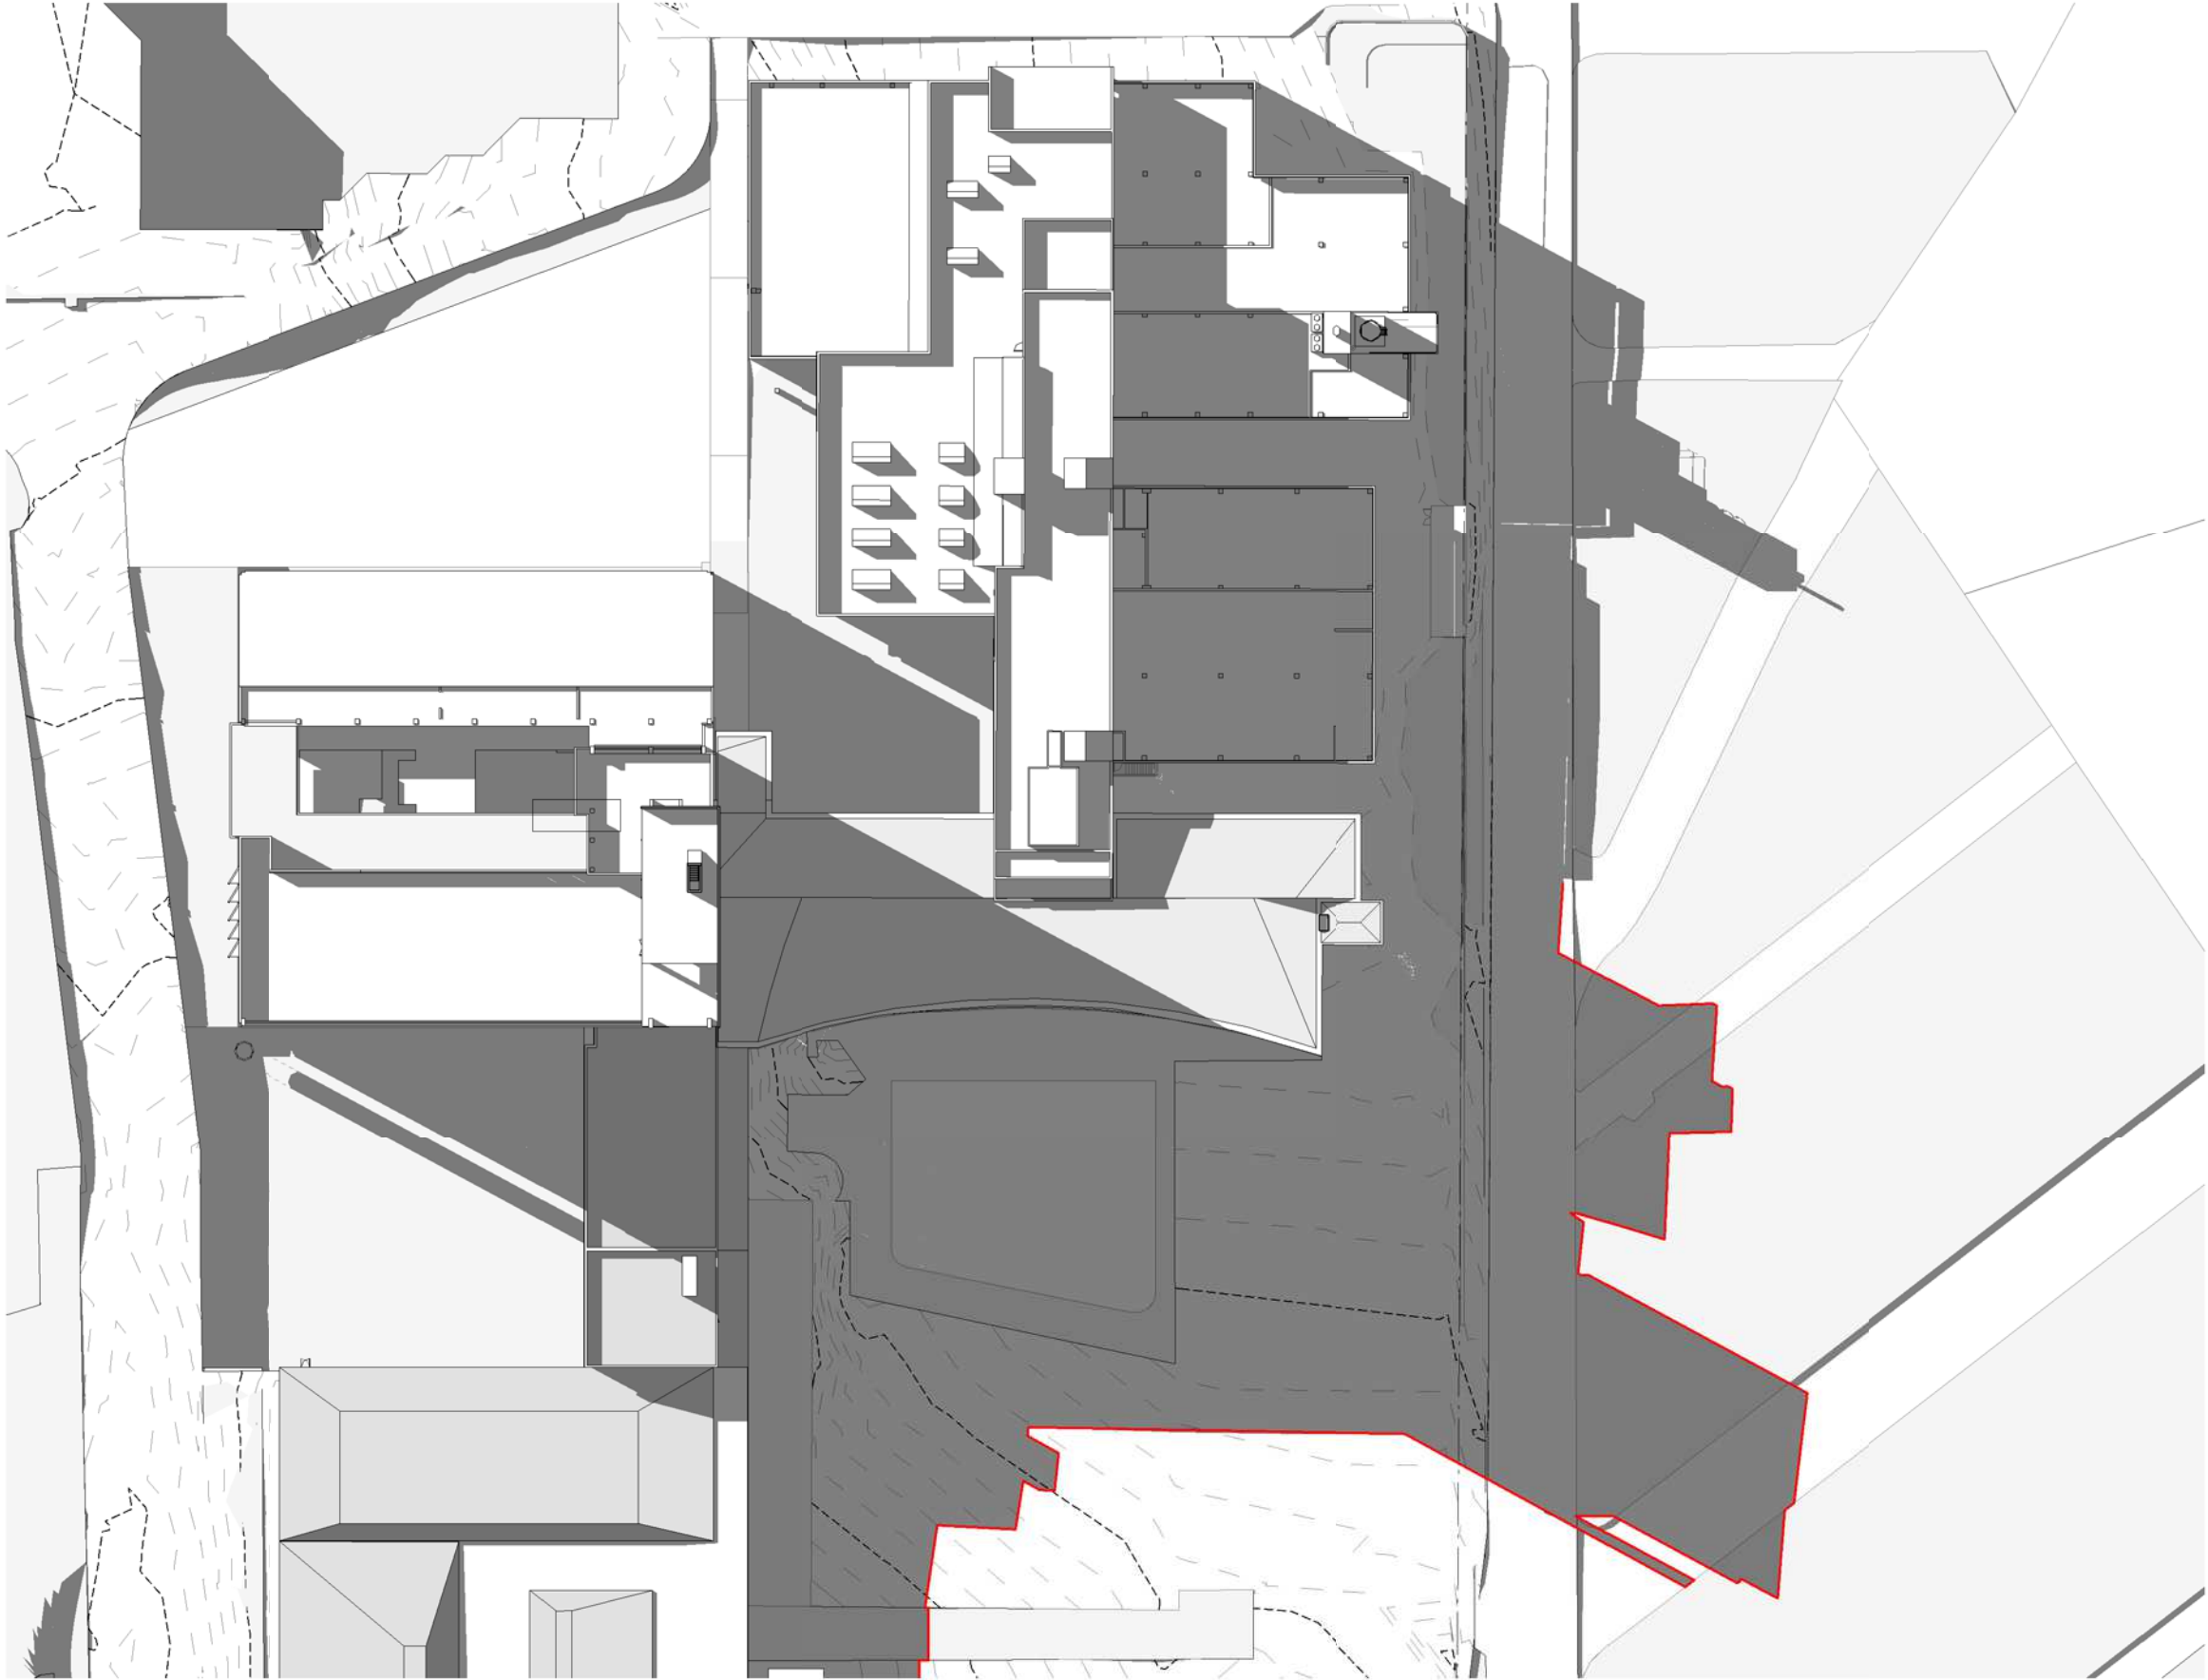

2 WINTER SOLSTICE - 3PM Existing Building

SCALE 1 : 750



02 WINTER SOLSTICE - 3PM Proposed Building

SCALE 1 : 750

© COX ARCHITECTURE PTY LTD.
PERMISSION OF COX ARCHITECTURE PTY LTD CONSTITUTES AN INFRINGEMENT OF
COPYRIGHT

Rev	Description	By	Date
A	SSA Response	SPG	03/07/2016

Principal



THE UNIVERSITY OF
SYDNEY

Contractor



Architect



Level 6, 155 Clarence Street,
Sydney, NSW 2000, Australia
T + 61 2 9287 9599
F + 61 2 9284 3844
www.coxarchitecture.com.au

Nominated Architects
Joe Agius no. 5491
Richard Lee no. 5207

Project
THE UNIVERSITY OF SYDNEY ETP STAGE 1

Electrical Engineering Building
University in Darling, NSW 2008

Drawing Title

WINTER SOLSTICE COMPARISON

AT DRAWING SHEET

Drawn: SPG

Co-ordinated: Michael Grave

Scale: 1 : 750 @ A1

Project Architect: Michael Bradburn


Date: 07/03/16

Project Director: David Holm

Revision: A

Drawing Number:

A-DA-8006

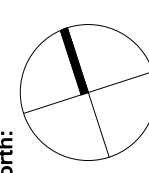




01
LOCATION
NORTH, EAST & WEST LAB FACADES
FINISH
VISION GLASS



02
LOCATION
NORTH, EAST & WEST LAB FACADES
FINISH
ZINCALUME SPANDREL



 03
LOCATION
NORTH FACADE
FINISH
STAINLESS STEEL EXTERNAL DUCT,
EXPOSED FANS



04
LOCATION
NORTH FACADE
FINISH
PAINTED STEEL 'EXO SKELETON'
FRAME TO DUCT



05
LOCATION
NORTH, EAST & WEST LAB
FACADES
FINISH
ALUMINIUM EXTERNAL LOUVRES



06
LOCATION
NORTH, EAST & WEST FACADES
FINISH
PAINTED STEEL, ALUMINIUM




07
LOCATION
EAST & WEST ATRIUM FACADES
FINISH
FULL HEIGHT VISION GLASS




08
LOCATION
SOUTH FACADES
FINISH
VISION GLASS

LOCATION
NORTH, EAST, WEST & SOUTH FACADE
FINISH
FEATURE SCREEN

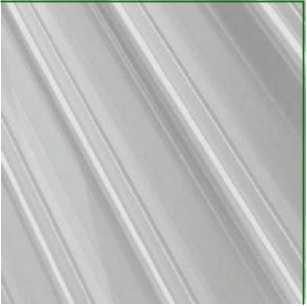

 
09
LOCATION
ROOF PLANT FACADES
FINISH
GLASS PLANK




10
LOCATION
EAST, WEST & SOUTH FACADE
FINISH
EXISTING CONCRETE FRAMES &
WALLS PAINT FINISH



 
11
LOCATION
EAST, WEST & SOUTH FACADE
FINISH
EXISTING CONCRETE FRAMES &
WALLS PAINT FINISH




12
LOCATION
EAST, WEST & SOUTH FACADE
FINISH
WINDOW FRAMES, LOUVRES PAINT
FINISH

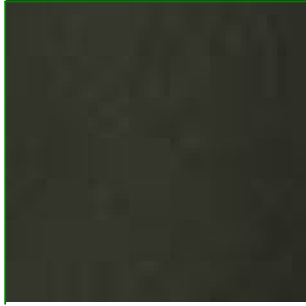



13
LOCATION
ROOF PLANT FACADE
FINISH
WEATHERPROOF LOUVRES,
2 STAGE

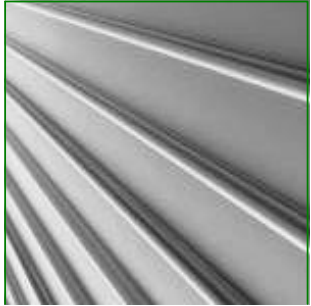

14
LOCATION
ROOF
FINISH
METAL DECK ROOF

 

 15
LOCATION
EAST, WEST & SOUTH FACADE
FINISH
EXISTING BRICK WALLS
PAINT FINISH

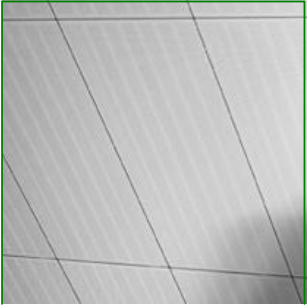

17
LOCATION
WEST FACADE
FINISH
PAINTED STEEL, ALUMINIUM

© COX ARCHITECTS COX ARCHITECTS ARE PTY. LTD.
PERMISSION OF COX ARCHITECTURE PTY LTD CONSTITUTES AN ACKNOWLEDGEMENT OF
COPYRIGHT

Rev	Description	By	Date
A	FOR INFORMATION	SPG	15/11/2018
B	FOR SUBMISSION	SPG	30/08/2018
C	RESPONSE TO SUBMISSION	VJ	03/09/2018



Principal

Contractor



Nominated Architects
Johanna Ayles
Johanna Ayles Pty Ltd
Johanna Ayles Pty Ltd
Johanna Ayles Pty Ltd

Project
THE UNIVERSITY OF SYDNEY ETP STAGE 1
Electrical Engineering Building
University in Darlingtown, NSW 2008
Drawing Title
MATERIALS LEGEND - EXTERIOR

Drawn:	SPG
Co-ordinated:	Michael Grave
Project Architect:	Michael Bradburn
Project Director:	David Holm
Drawing Number:	North

A-DA-9001