



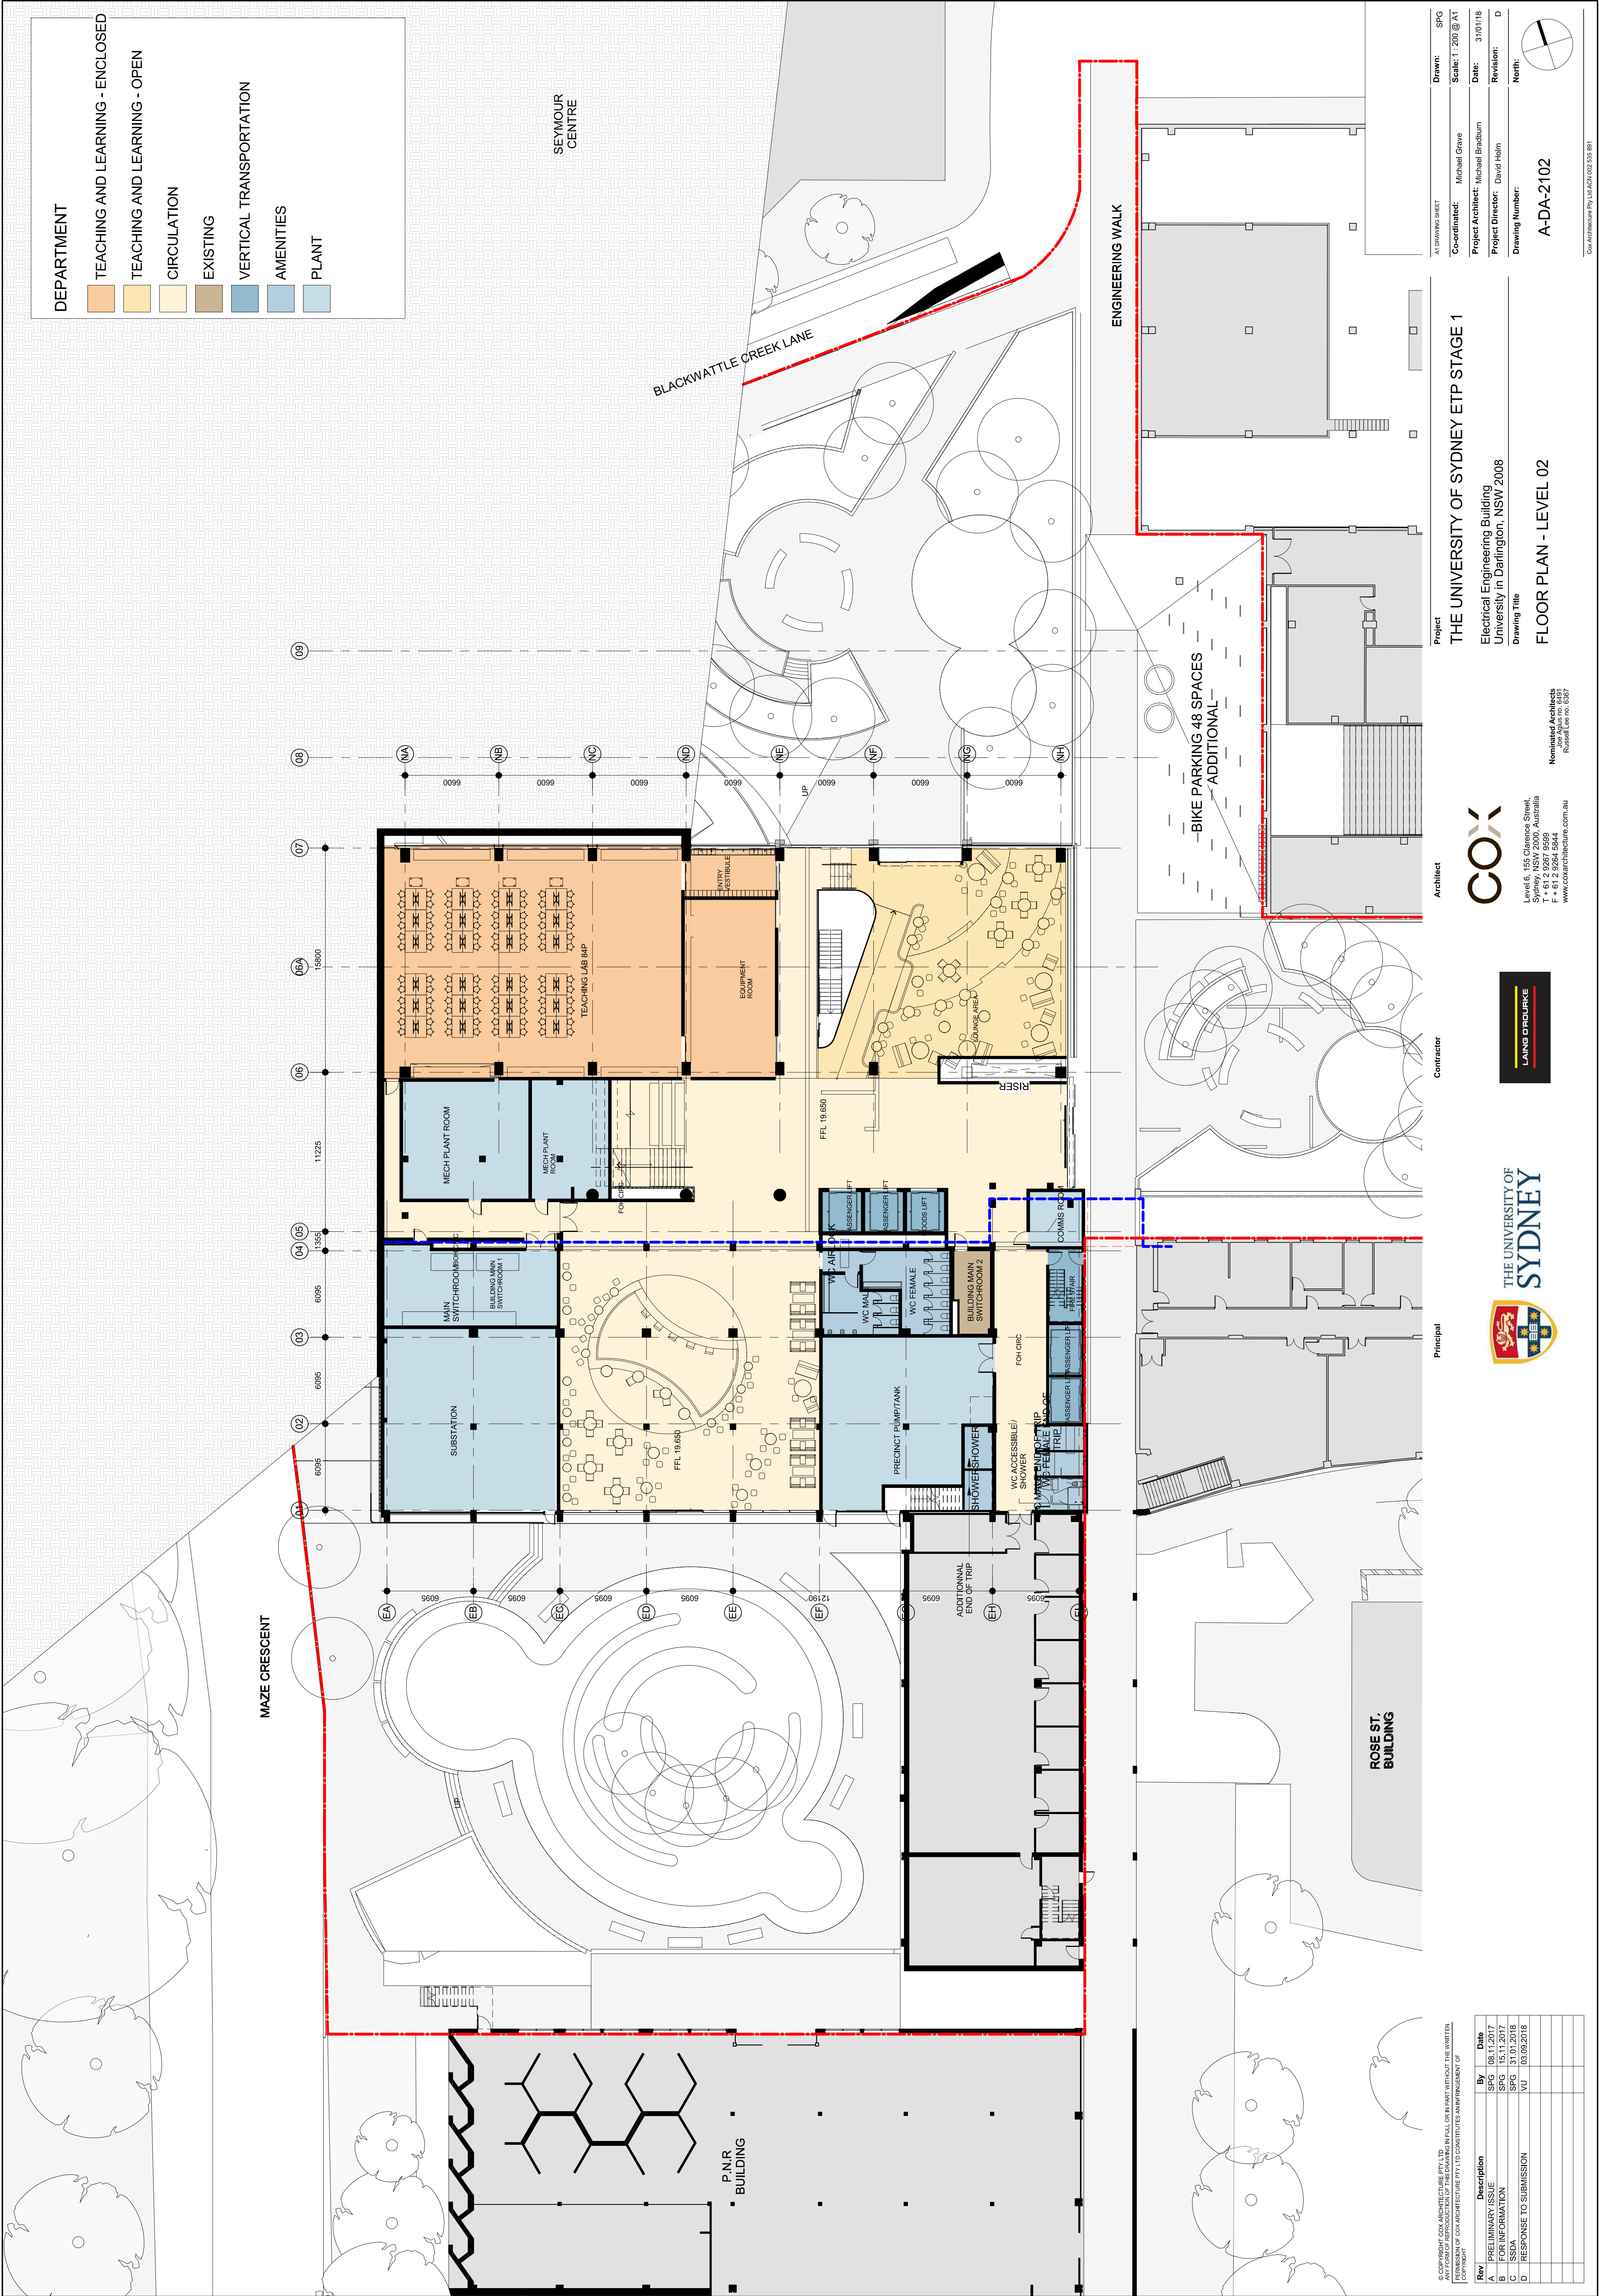

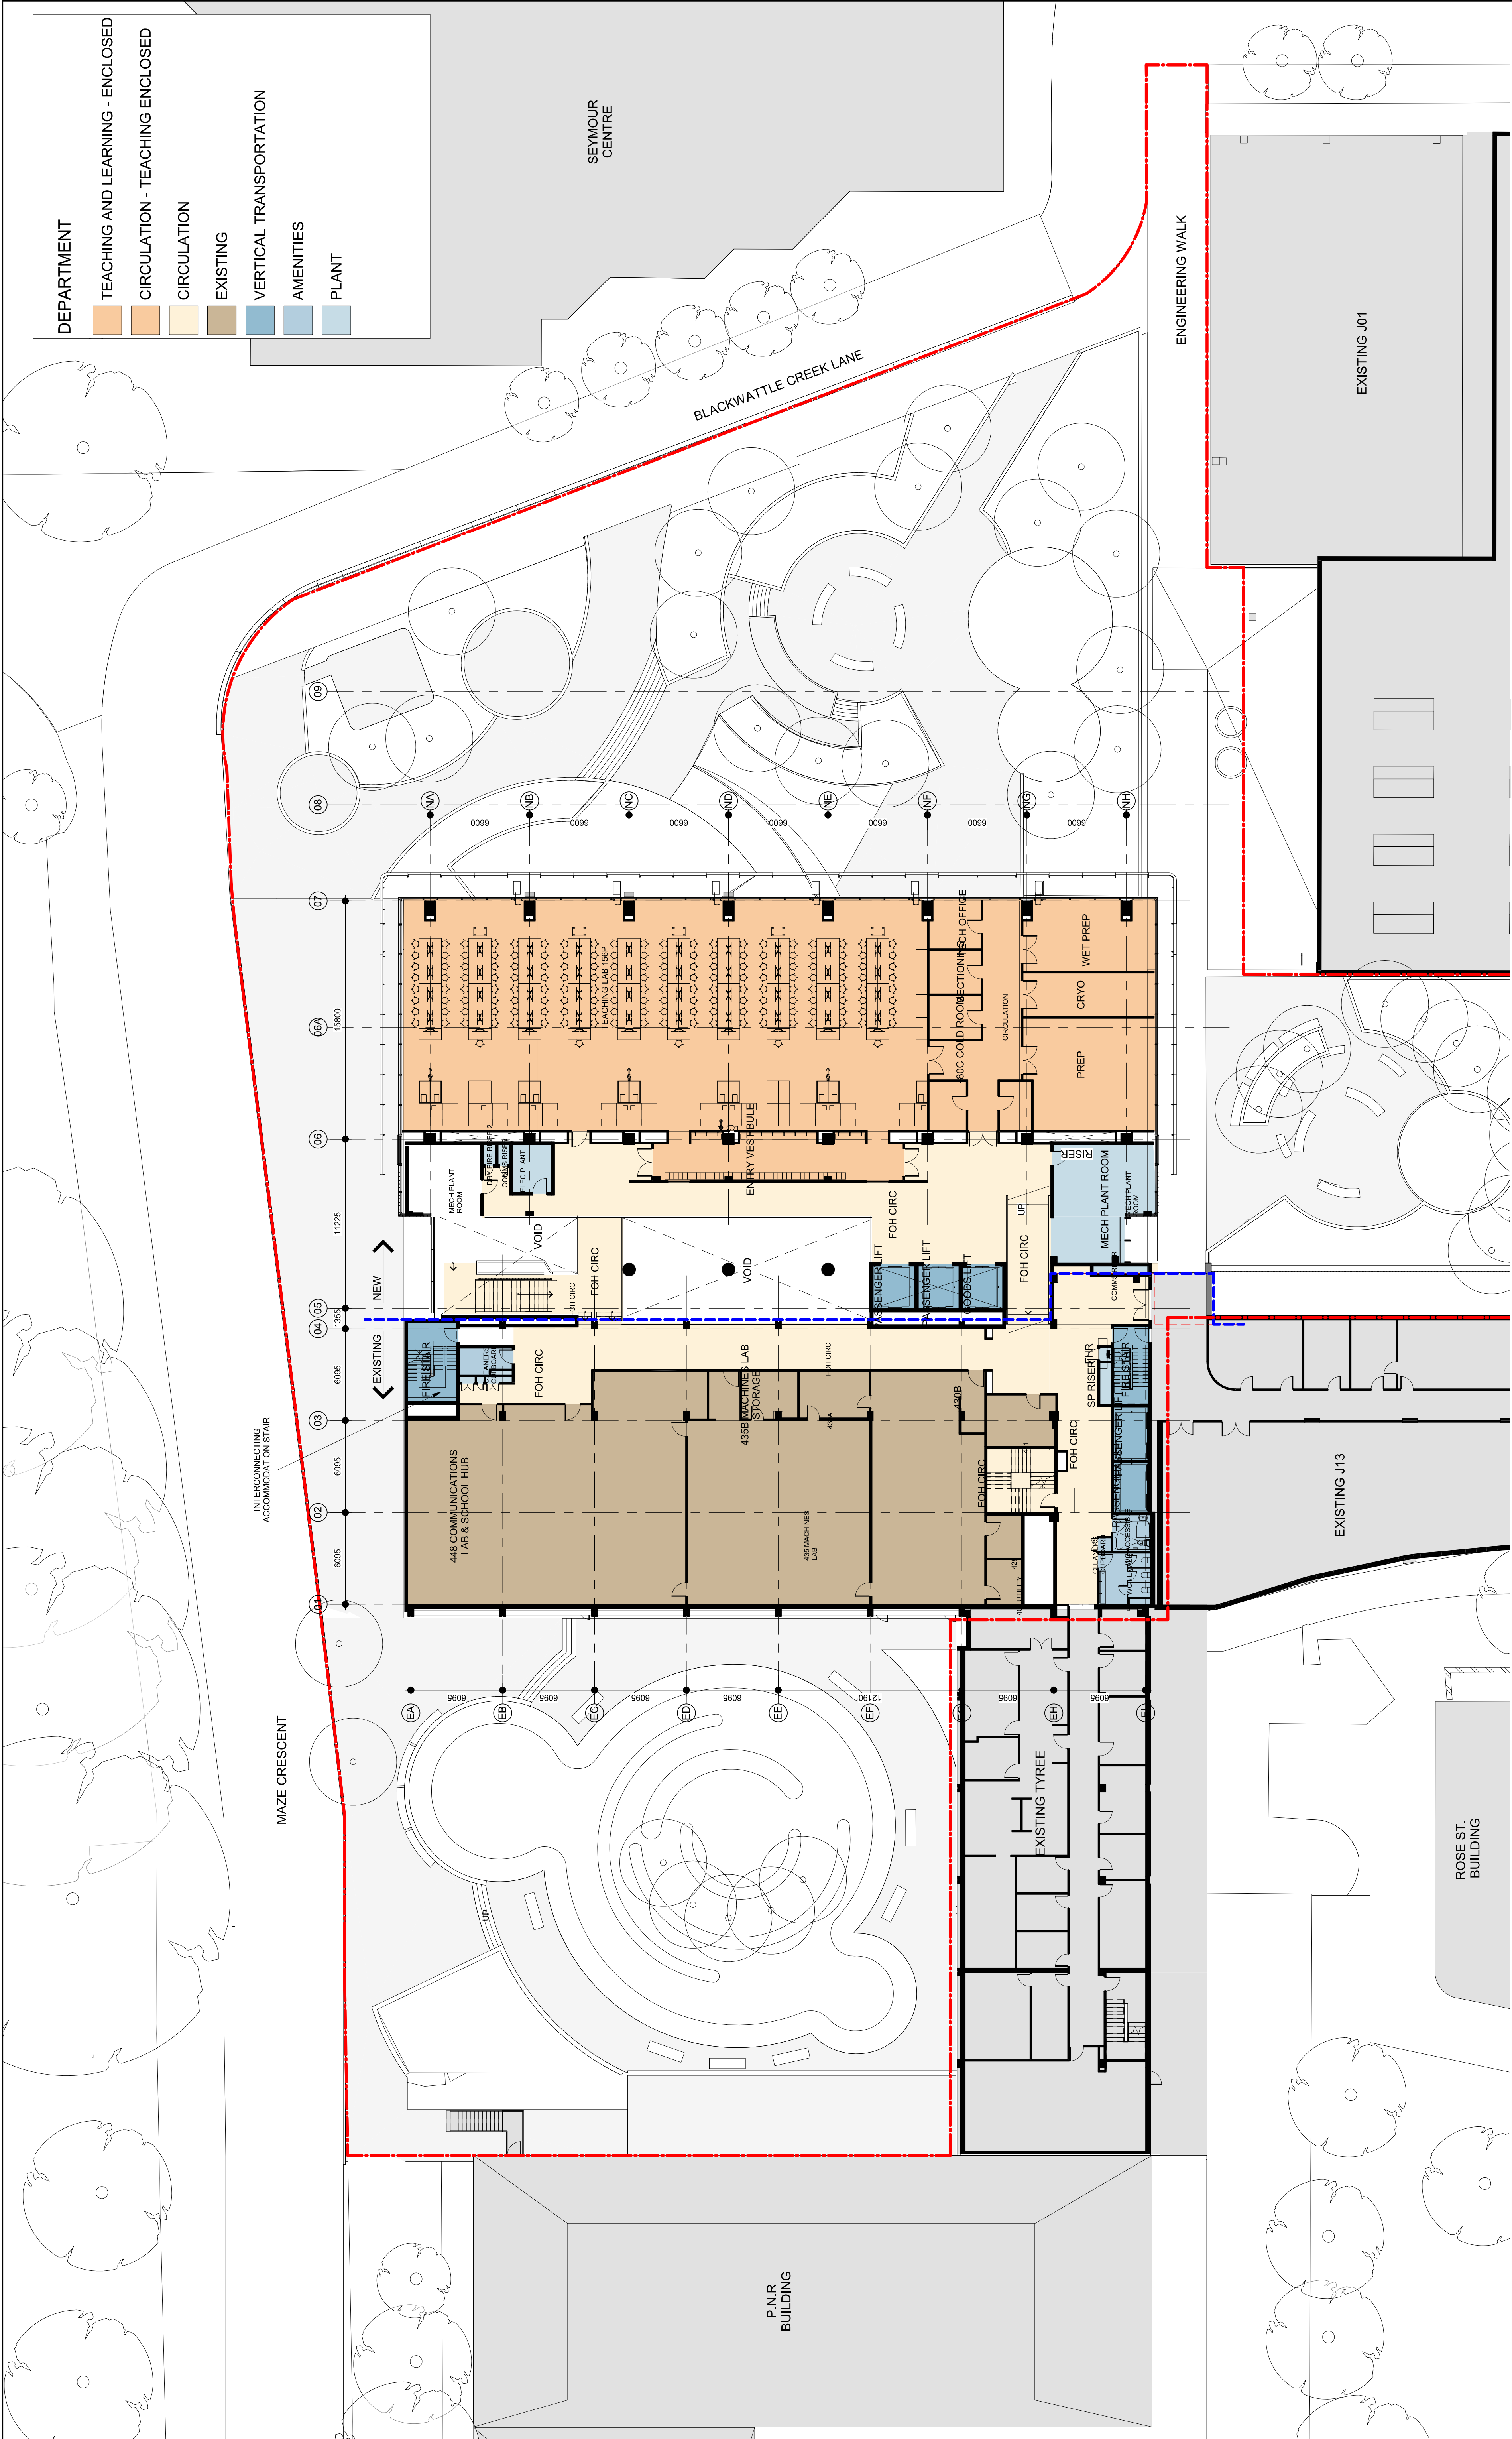

Rev	Description	By	Date
A	PRELIMINARY ISSUE	SPG	06/11/2017
B	FOR INFORMATION	SPG	31/01/2018
C	ISSUED	SPG	31/01/2018
D	RESPONSE TO SUBMISSION	VU	03/02/2018

© COX ARCHITECTS. COX ARCHITECTS ARE NOT RESPONSIBLE FOR THE REPRODUCTION OF THIS DRAWING IN FULL OR IN PART WITHOUT THE WRITTEN PERMISSION OF COX ARCHITECTS PTY LTD. ANY REPRODUCTION OF THIS DRAWING IN FULL OR IN PART WITHOUT THE WRITTEN PERMISSION OF COX ARCHITECTS PTY LTD CONSTITUTES AN INFRINGEMENT OF COPYRIGHT.

Project

THE UNIVERSITY OF SYDNEY ETP STAGE 1

Co-ordinated:

Michael Grave

Project Architect:

Michael Braddum

Project Director:

David Holm

Drawing Number:

A-DA-2104

Scale:

1 : 200 @ A1

Date:

31/01/18

Revision:

D

North:

Architect

Level 6, 155 Clarence Street,
Sydney, NSW 2000, Australia
T + 61 2 9287 9599
F + 61 2 9284 5844
www.coxarchitects.com.au

Contractor

Principal

THE UNIVERSITY OF
SYDNEY

Drawn:

SPG

Co-ordinated:

Michael Grave

Project Architect:

Michael Braddum

Project Director:

David Holm

Drawing Number:

A-DA-2104

Scale:

1 : 200 @ A1


Date:

31/01/18

Revision:

D

North:

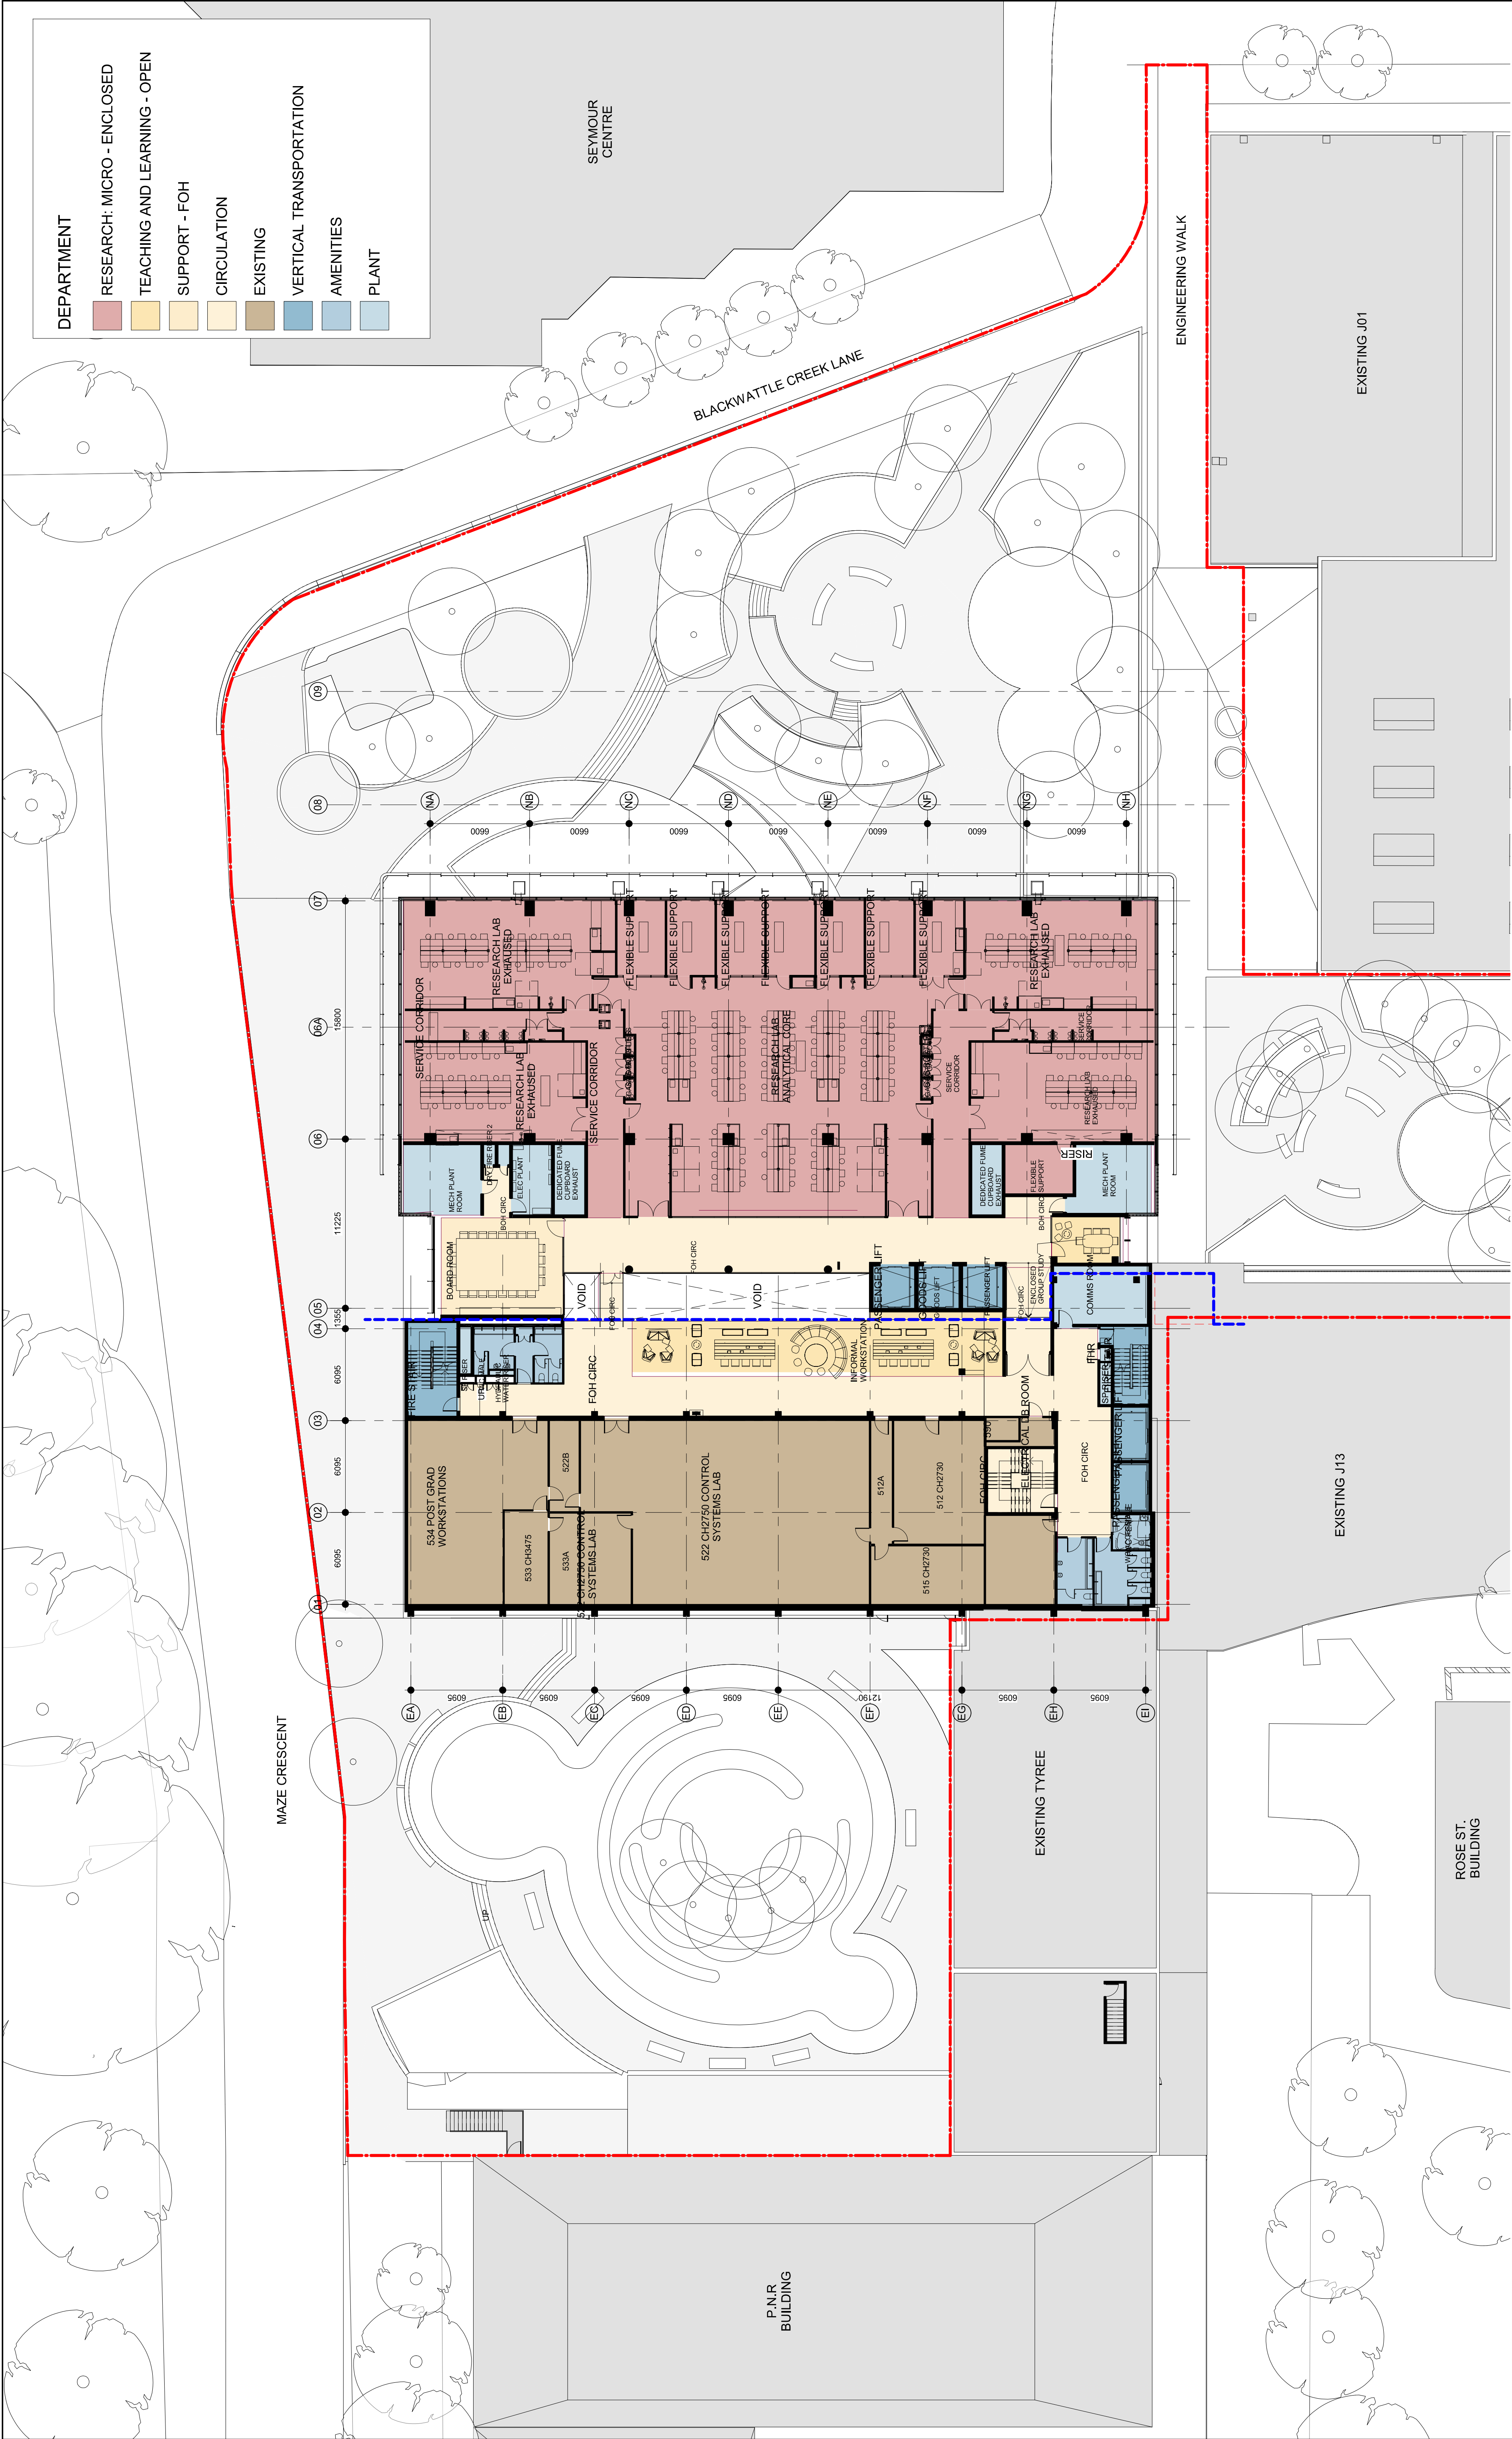

© 2018 COX ARCHITECTURE PTY LTD.
PERMISSION OF COX ARCHITECTURE PTY LTD CONSTITUTES AN ASSIGNMENT OF
COPYRIGHT

Rev	Description	By	Date
A	PRELIMINARY ISSUE	SPG	06.11.2017
B	FOR INFORMATION	SPG	01.02.2018
C	ISSUED	SPG	31.07.2018
D	RESPONSE TO SUBMISSION	VU	03.03.2018





Level 6, 155 Clarence Street,
Sydney, NSW 2000, Australia
T + 61 2 9287 9599
F + 61 2 9284 5844
www.coxarchitecture.com.au


Project
THE UNIVERSITY OF SYDNEY ETP STAGE 1
Electrical Engineering Building
University in Darlington, NSW 2008

Architect

Contractor

Principal

Drawn:	SPG
Co-ordinated:	Michael Grave
Project Architect:	Michael Bradburn
Project Director:	David Holm
Revision:	D
North:	
Drawing Number:	A-DA-2105

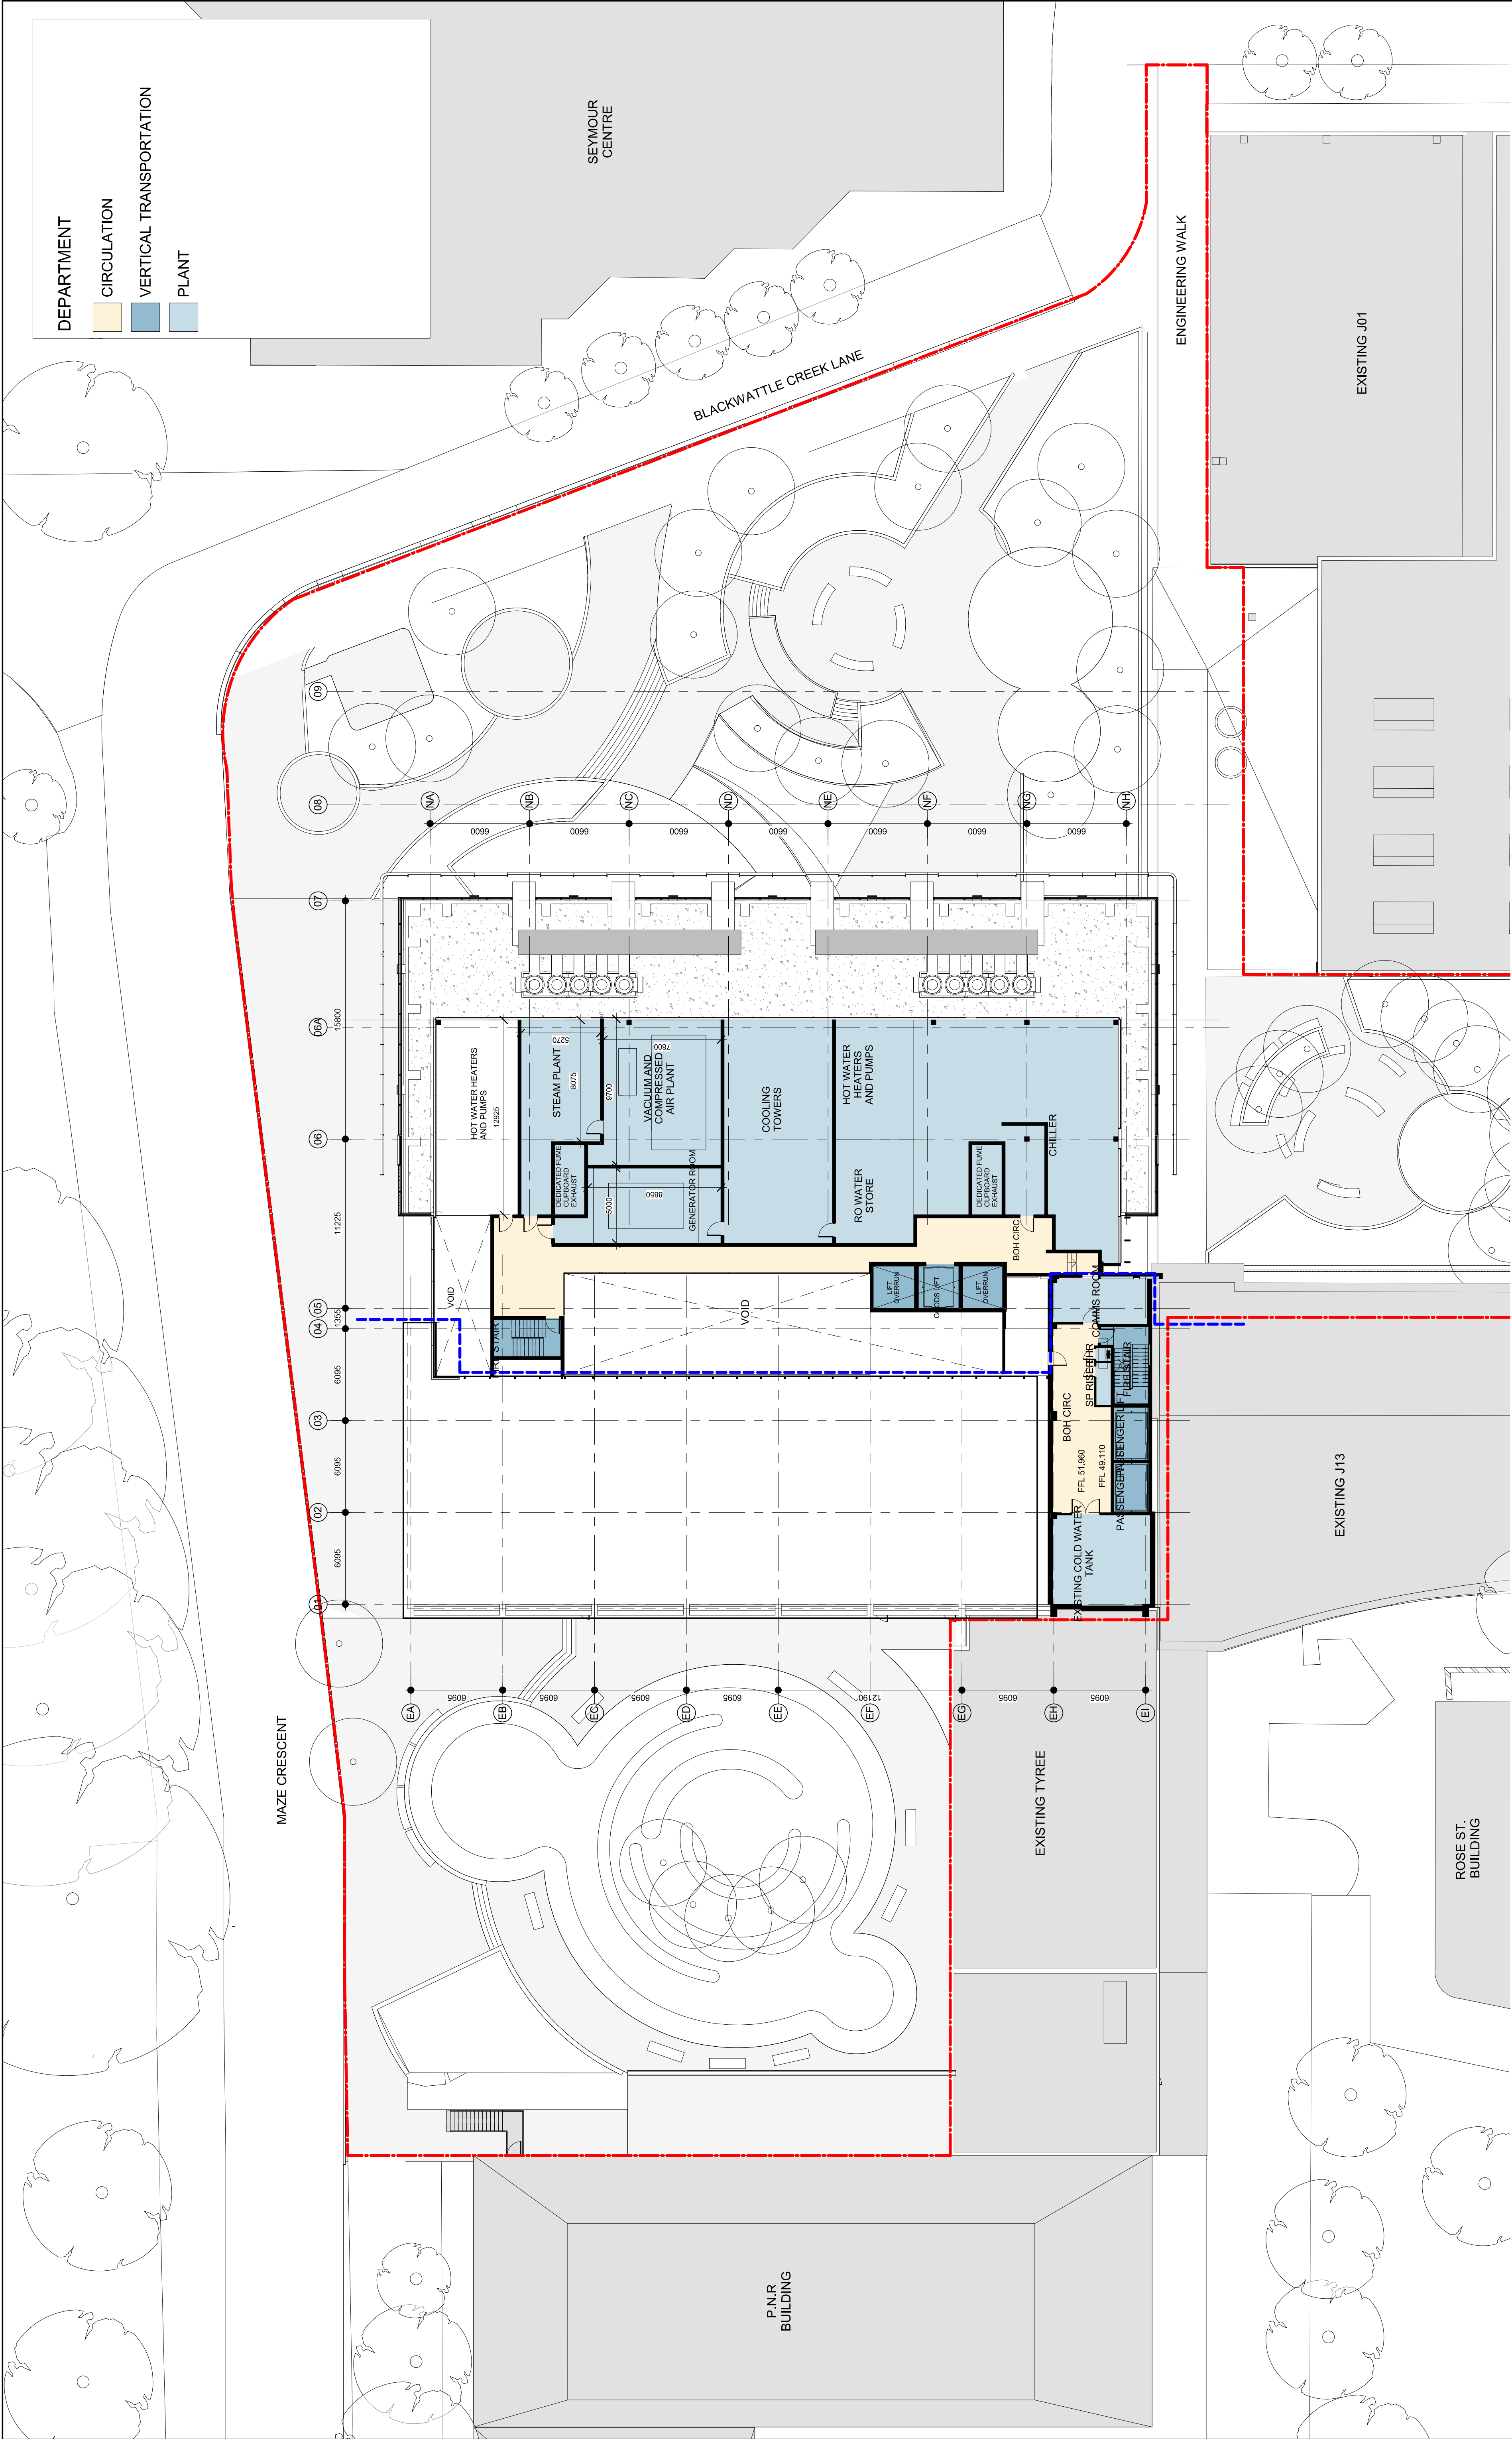

DEPARTMENT


CIRCULATION

VERTICAL TRANSPORTATION

PLANT

Rev	Description	By	Date
A	PRELIMINARY ISSUE	SPG	06.11.2017
B	FOR INFORMATION	SPG	31.07.2018
C	ISSUED	SPG	31.07.2018
D	RESPONSE TO SUBMISSION	VU	03.03.2018

© COX ARCHITECTS. COX ARCHITECTS ARE NOT TO BE REPRODUCED OR TRANSMITTED IN ANY FORM OR BY ANY MEANS, ELECTRONIC OR MECHANICAL, INCLUDING PHOTOCOPYING, RECORDING, OR BY ANY INFORMATION STORAGE AND RETRIEVAL SYSTEM, WITHOUT THE WRITTEN PERMISSION OF COX ARCHITECTS PTY LTD. ANY UNAUTHORIZED REPRODUCTION OF THIS DRAWING IS STRICTLY PROHIBITED AND WILL BE PROSECUTED TO THE FULL EXTENT OF THE LAW.

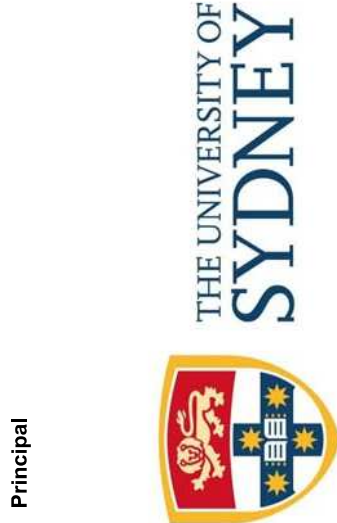

Architect

COX

Level 6, 155 Clarence Street,
Sydney, NSW 2000, Australia
T + 61 2 9287 9599
F + 61 2 9284 5844
www.coxarchitects.com.au

Nominated Architects
John Ayles no. 5491
Richard Lane no. 5207

Project
THE UNIVERSITY OF SYDNEY ETP STAGE 1
Electrical Engineering Building
University in Darlington, NSW 2008
Drawing Title
FLOOR PLAN - LEVEL 10

Drawn: SPG
Co-ordinated: Michael Grave
Project Architect: Michael Bradburn
Project Director: David Holm
Drawing Number: A-DA-2110
North: