


- DEPARTMENT
- AMENITIES
 - CIRCULATION
 - PLANT
 - RESEARCH: MICRO - ENCLOSED
 - SUPPORT - BOH
 - VERTICAL TRANSPORTATION

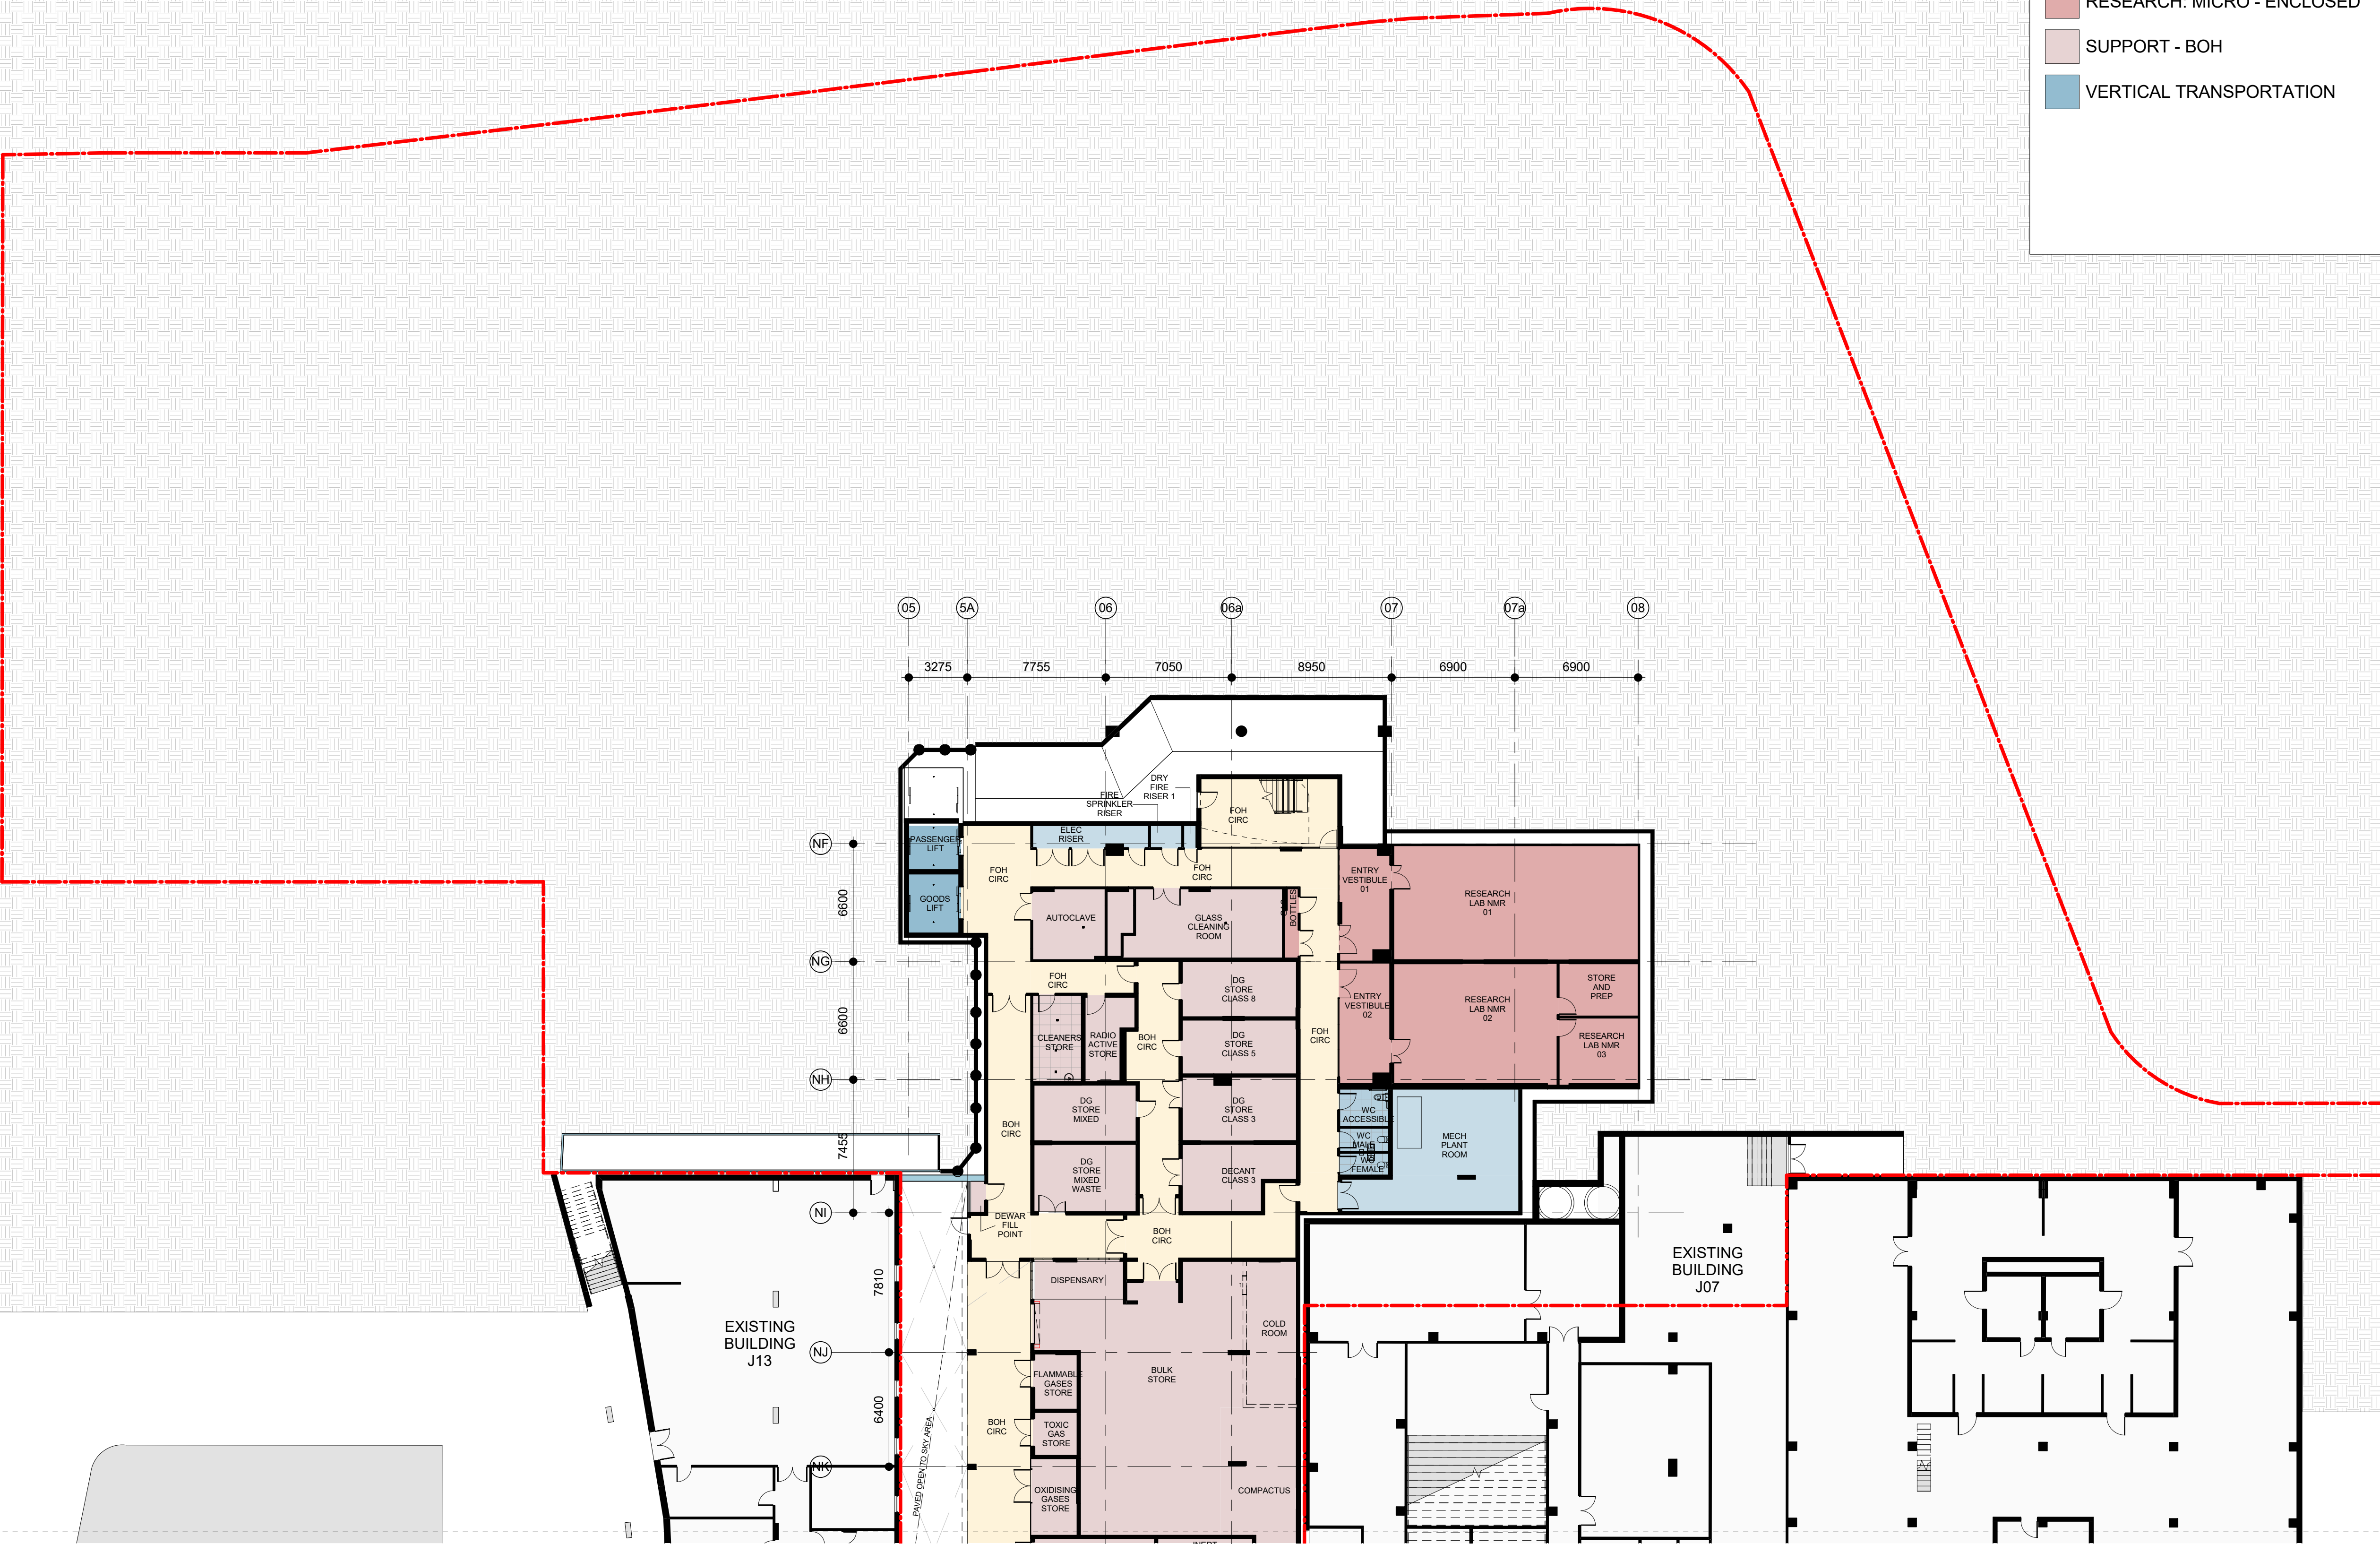

Rev	Description	By	Date
A	PRELIMINARY ISSUE	SPG	08.11.2017
B	FOR INFORMATION	SPG	15.11.2017
C	SSDA	SPG	31.01.2018
D	RESPONSE TO SUBMISSION 2	MS	04.12.2018



Level 6, 155 Clarence Street,
Sydney, NSW 2000, Australia
T + 61 2 9267 9599
F + 61 2 9264 5844
www.coxarchitecture.com.au

Nominated Architects
Joe Agius no. 6491
Russell Lee no. 6367

Project
THE UNIVERSITY OF SYDNEY ETP STAGE 1
Electrical Engineering Building
University in Darlingtown, NSW 2008
Drawing Title
FLOOR PLAN - LEVEL 01 (SHEET 01 OF 02)

A1 DRAWING SHEET
Co-ordinated: Michael Grave
Project Architect: Michael Bradburn
Project Director: David Holm
Drawing Number:
Drawn: MS
Scale: 1 : 200 @ A1
Date: 12/03/18
Revision: D
North:

A-DA-2101A

