


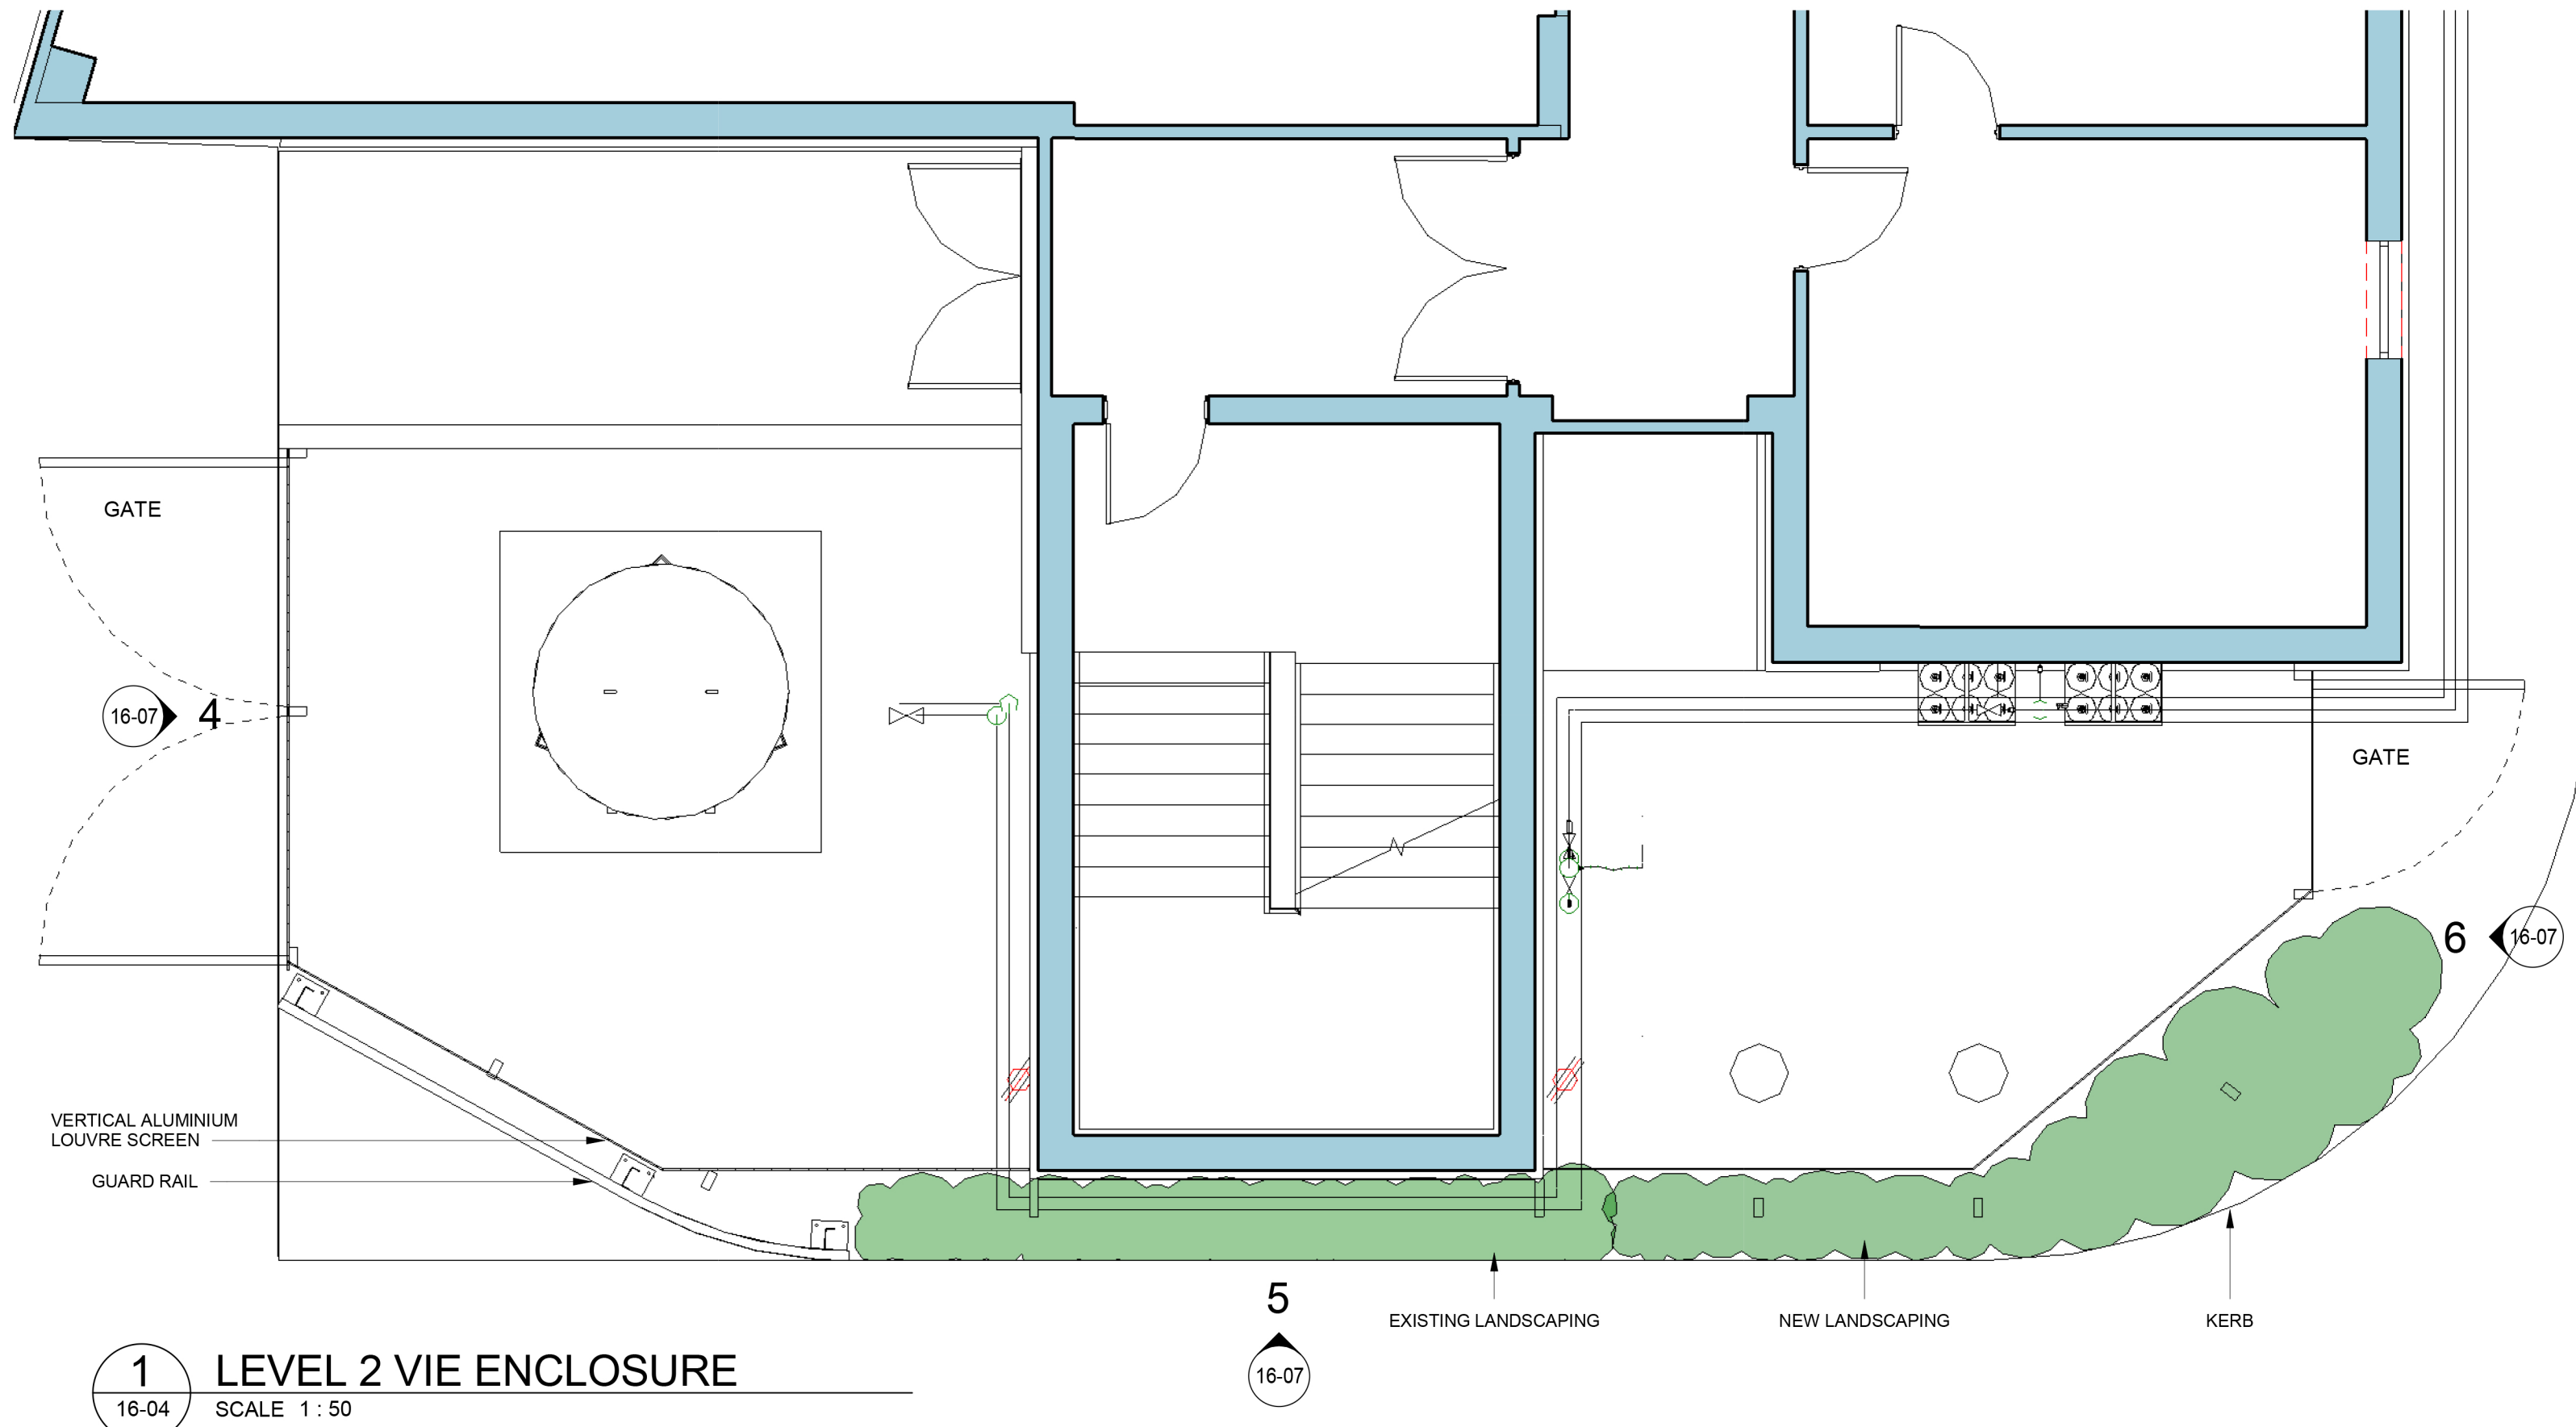


1 LEVEL 2 VIE ENCLOSURE
16-04 SCALE 1 : 50




VERTICAL ALUMINIUM LOUVRE SCREEN




2 VIE ENCLOSURE PHOTOMONTAGE

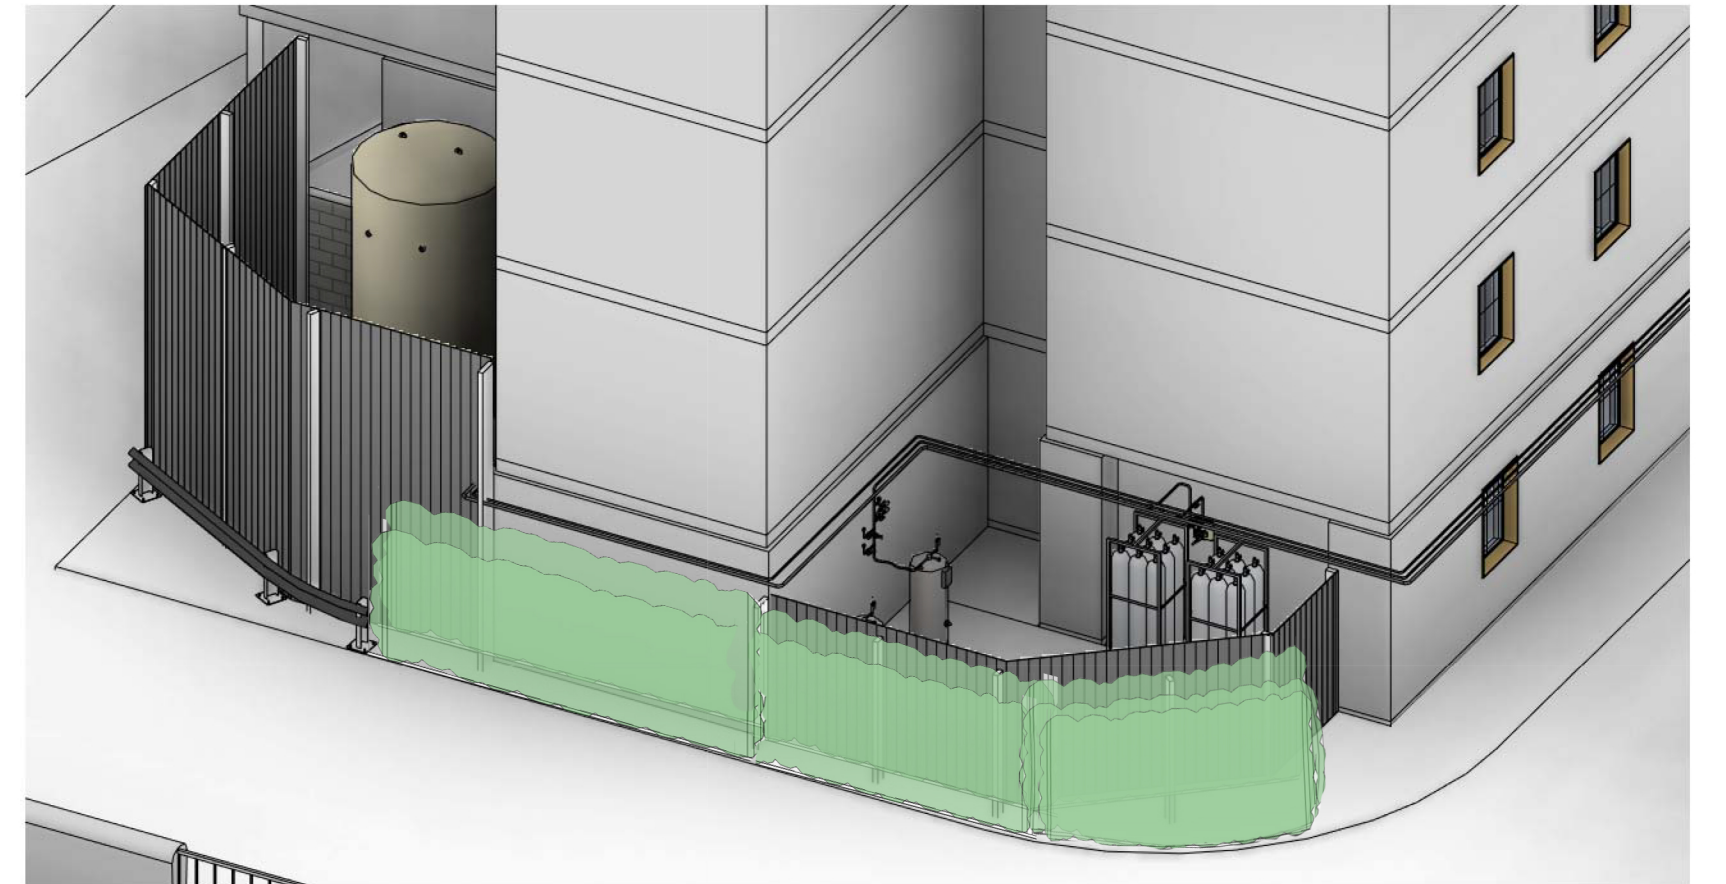


3 VIE ENCLOSURE ISOMETRIC
SCALE

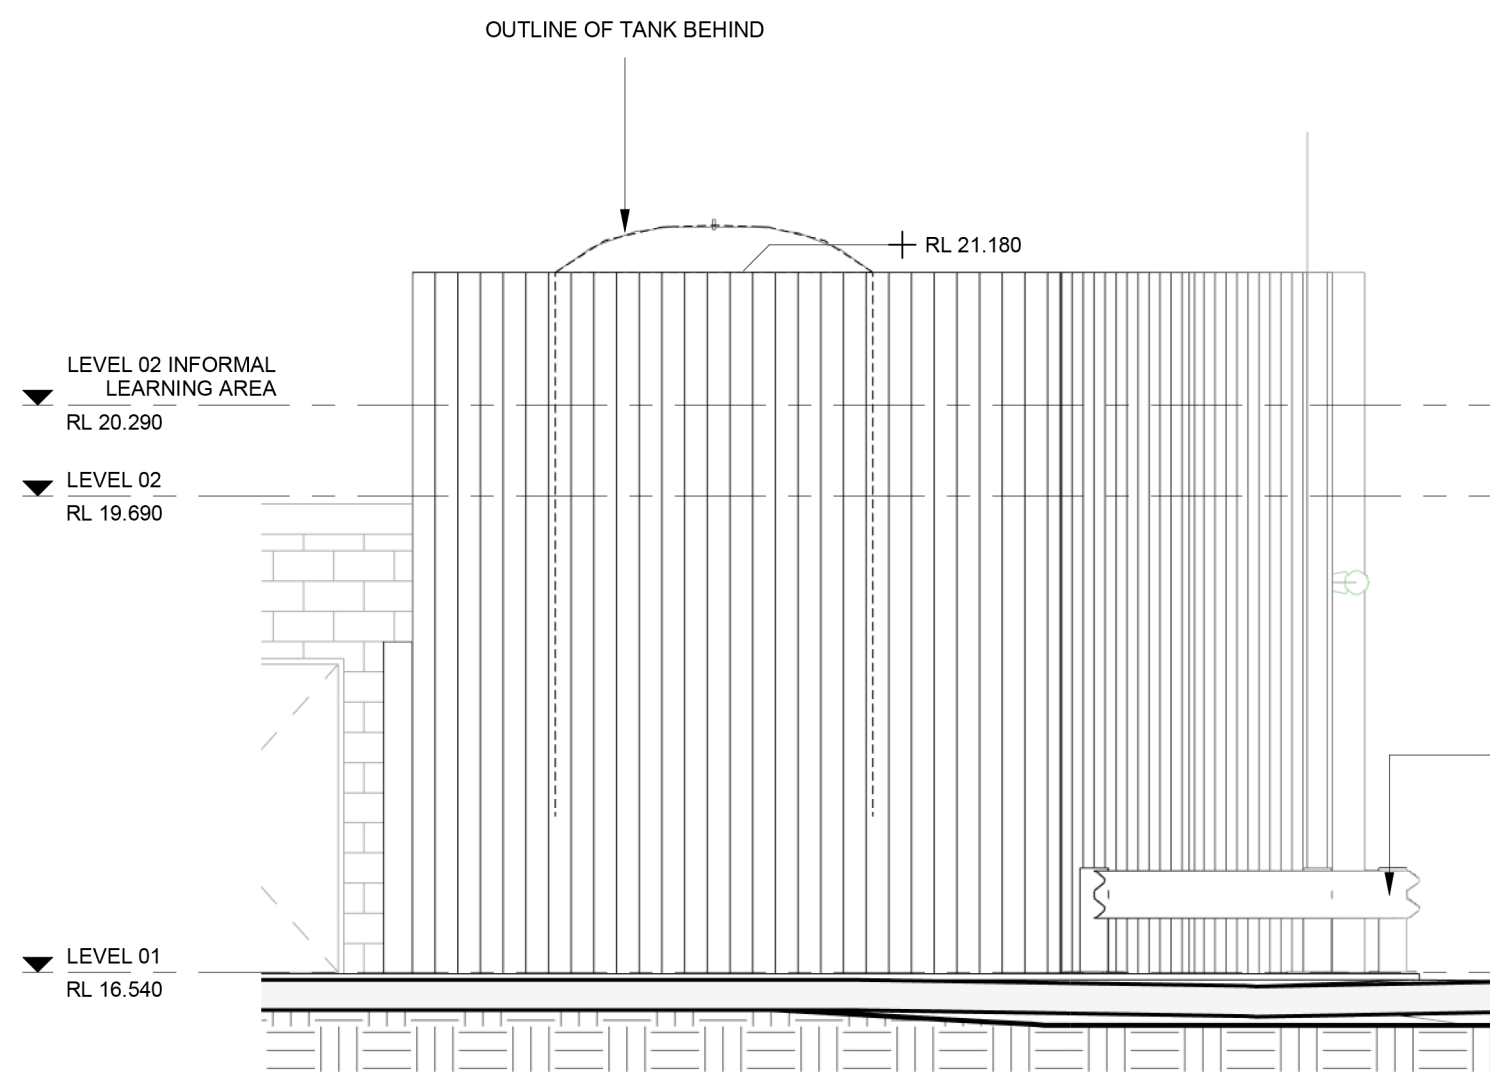

4 VIE ENCLOSURE - SOUTH ELEVATION
16-05 SCALE 1 : 50

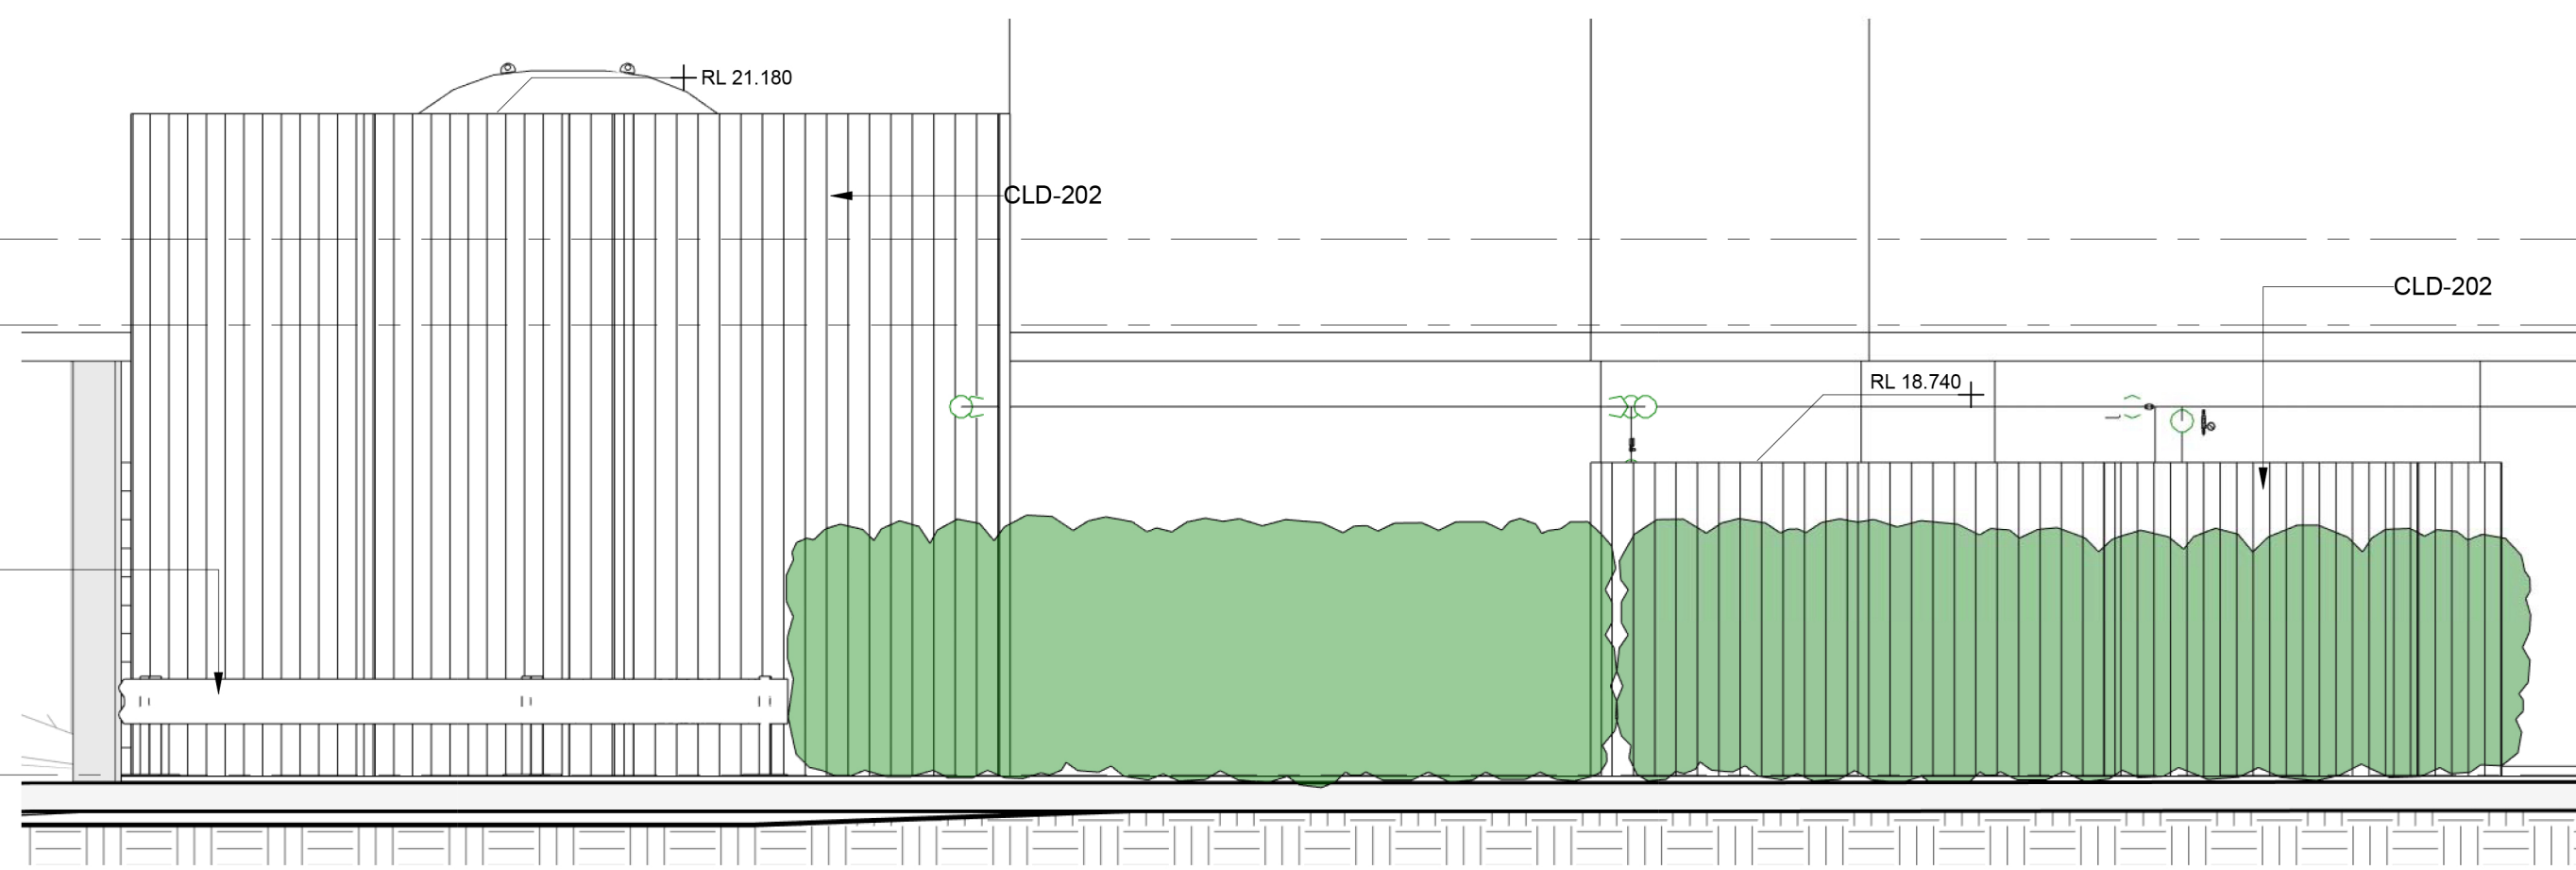

5 VIE ENCLOSURE - EAST ELEVATION
16-05 SCALE 1 : 50

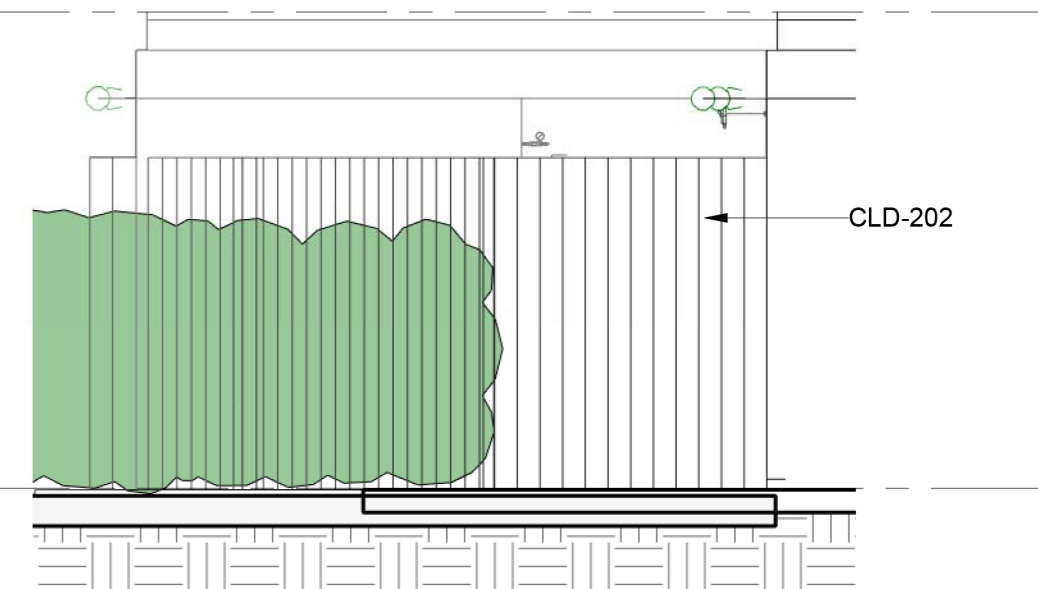

6 VIE ENCLOSURE - NORTH ELEVATION 3
16-05 SCALE 1 : 50

© COPYRIGHT COX ARCHITECTURE PTY LTD. ANY FORM OF REPRODUCTION OF THIS DRAWING IN FULL OR IN PART WITHOUT THE WRITTEN PERMISSION OF COX ARCHITECTURE PTY LTD CONSTITUTES AN INFRINGEMENT OF COPYRIGHT			
Rev	Description	By	Date
A	RESPONSE TO SUBMISSION	MS	14/12/2018

Principal



Contractor



Architect



Level 6, 155 Clarence Street,
Sydney, NSW 2000, Australia
T + 61 2 9267 9599
F + 61 2 9264 5844
www.coxarchitecture.com.au

Nominated Architects
Joe Agius no. 6491
Russell Lee no. 6367

Project

THE UNIVERSITY OF SYDNEY ETP STAGE 1

Electrical Engineering Building
University in Darlingtown, NSW 2008

Drawing Title

EXTERNAL WORKS - VIE ENCLOSURE


A1 DRAWING SHEET

Co-ordinated: Michael Grave
Scale: 1 : 50 @ A1

Project Architect: Michael Bradburn
Date: 12/14/18

Project Director: David Holm
Revision: A

Drawing Number: A-DA-16-07
North:

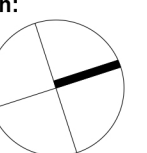

Cox Architecture Pty Ltd ACN 002 535 891