

Rev	Description	By	Date
A	PRELIMINARY ISSUE	SPG	08.11.2017
B	FOR INFORMATION	SPG	15.11.2017
C	SSDA	SPG	31.01.2018

Principal



Contractor



Architect



Level 6, 155 Clarence Street,
Sydney, NSW 2000, Australia
T + 61 2 9267 9599
F + 61 2 9264 5844
www.coxarchitecture.com.au

Nominated Architects
Joe Agius no. 6491
Russell Lee no. 6367

Project

THE UNIVERSITY OF SYDNEY ETP STAGE 1

Electrical Engineering Building
University in Darlington, NSW 2008

Drawing Title

FLOOR PLAN - LEVEL 01 (SHEET 02 OF 02)

A1 DRAWING SHEET

Co-ordinated: Michael Grave

Project Architect: Michael Bradburn

Project Director: David Holm

Drawing Number:

A-DA-2101B


Drawn: SPG

Scale: 1 : 200 @ A1


Date: 31/01/18

Revision: C

North:

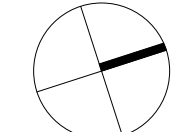

- DEPARTMENT
- TEACHING AND LEARNING - ENCLOSED
 - TEACHING AND LEARNING - OPEN
 - CIRCULATION
 - EXISTING
 - VERTICAL TRANSPORTATION
 - AMENITIES
 - PLANT

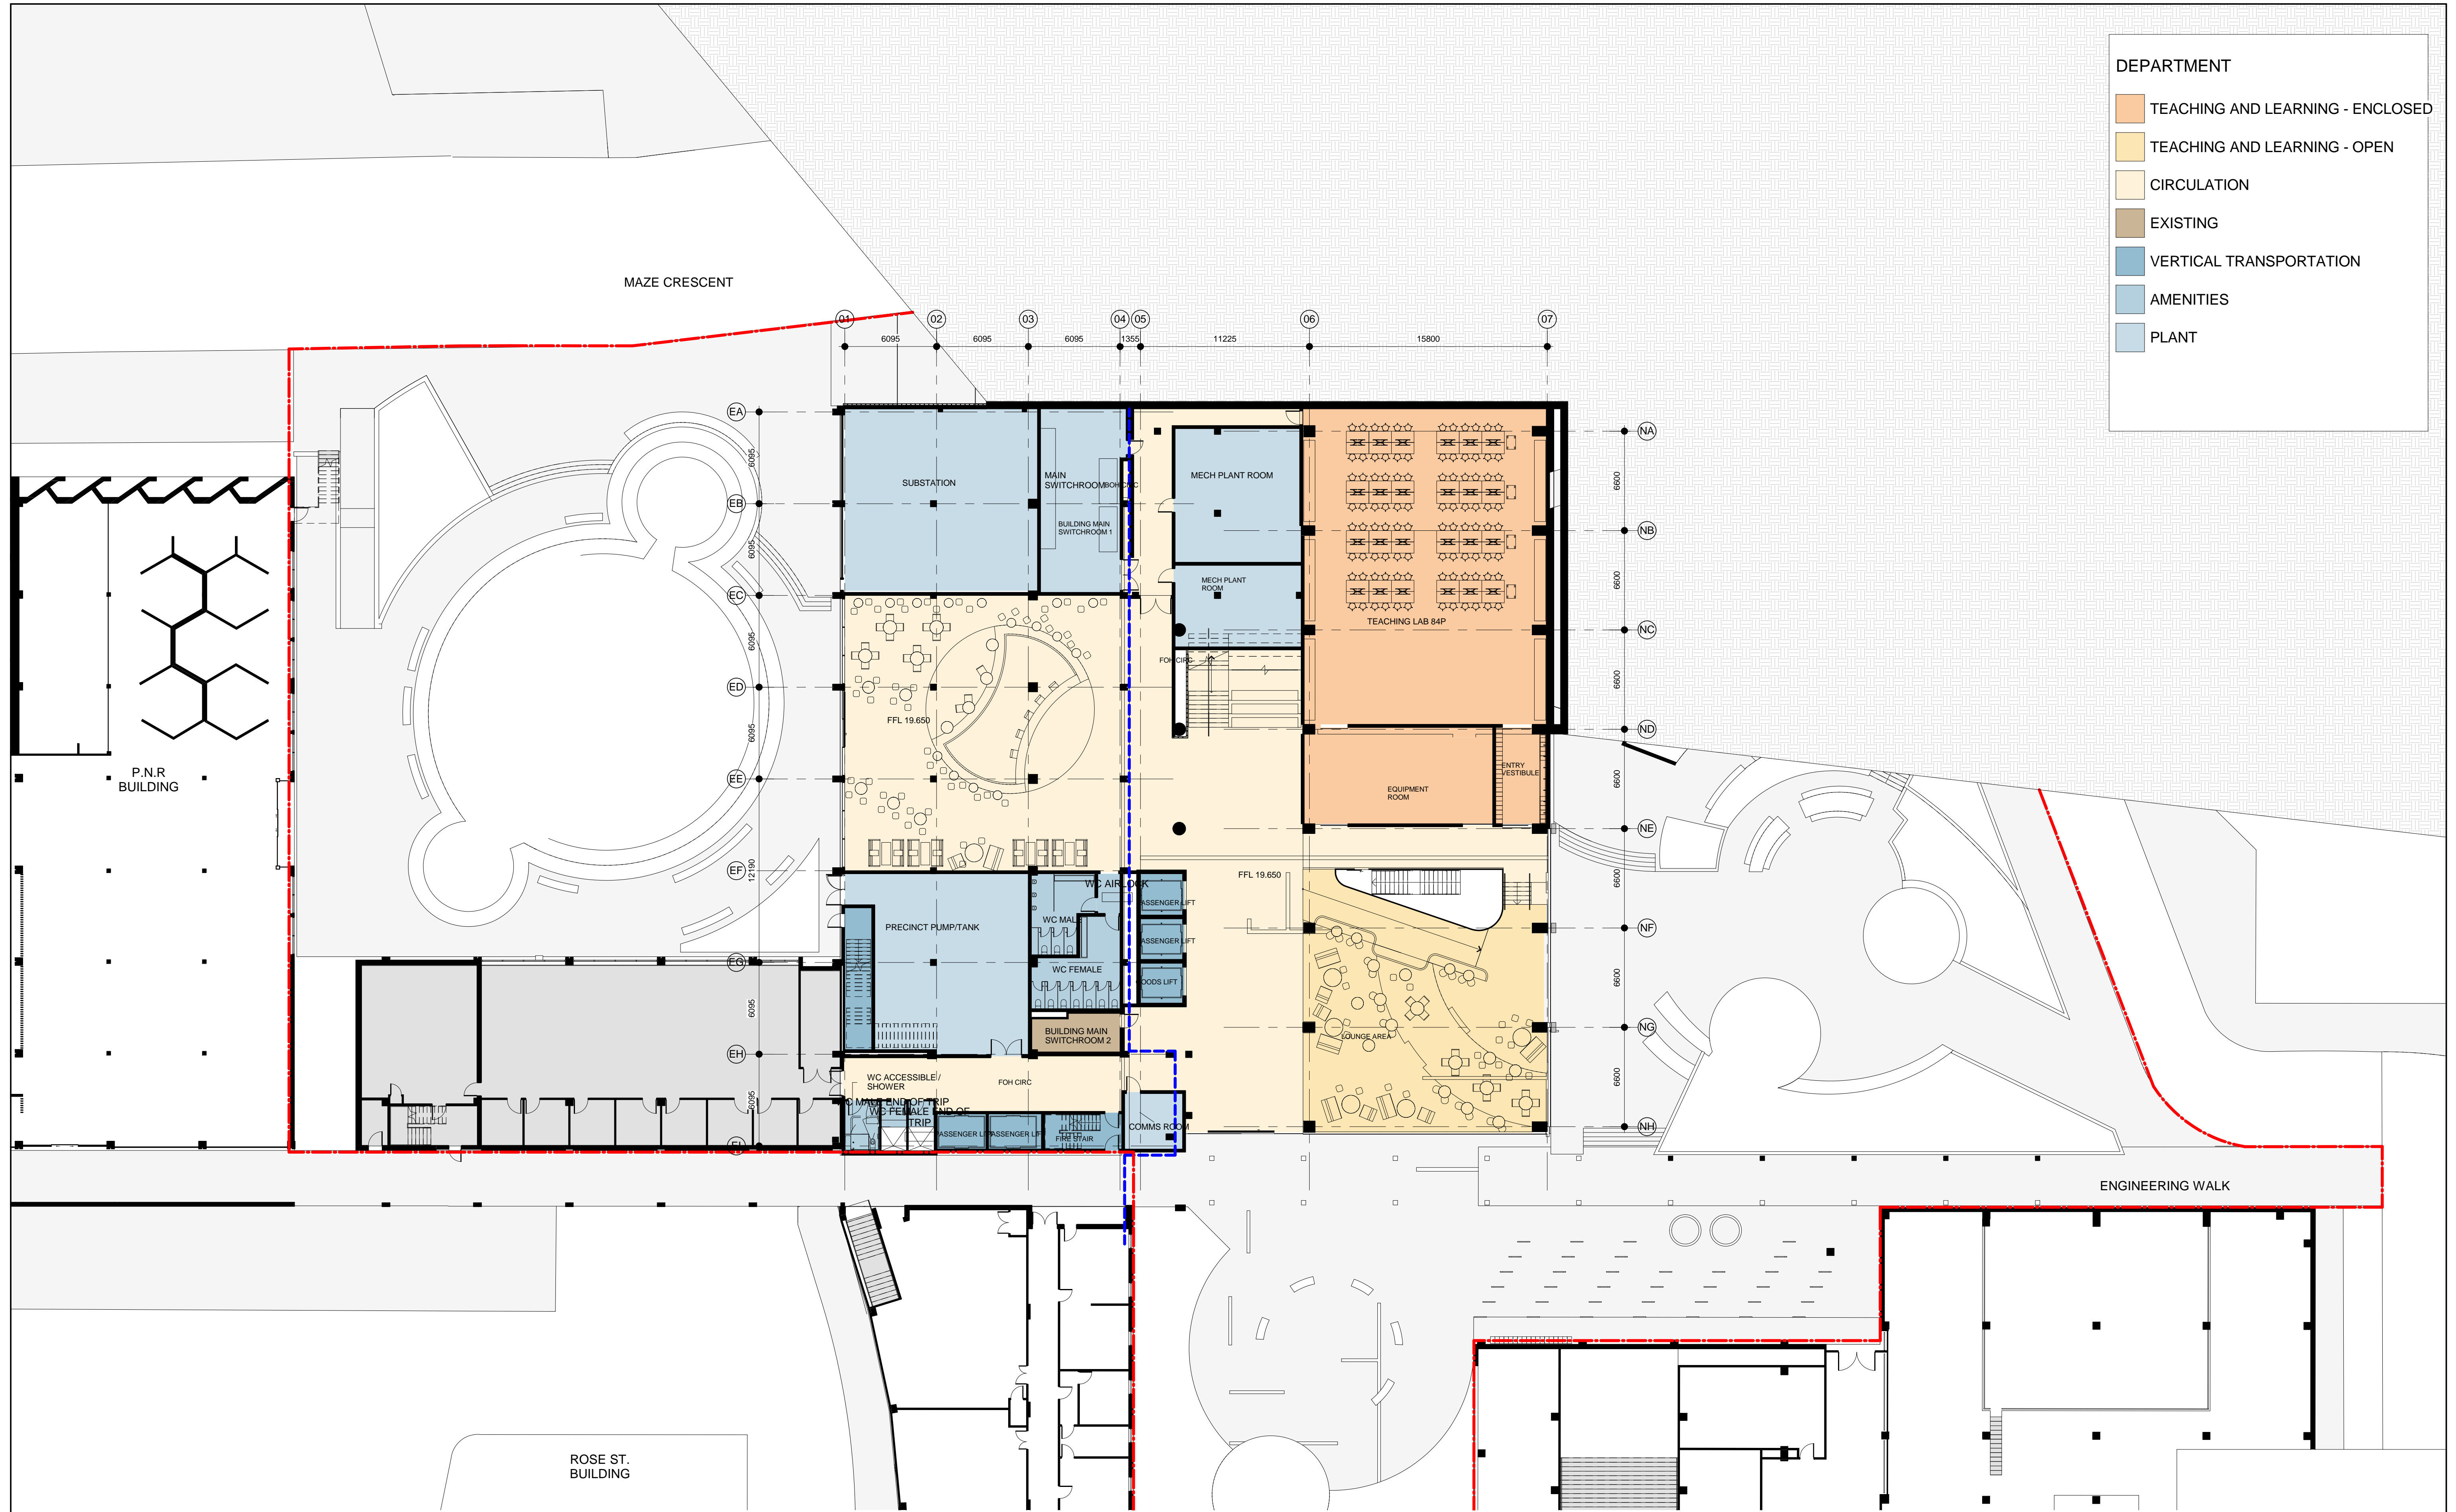


Rev	Description	By	Date
A	PRELIMINARY ISSUE	SPG	08.11.2017
B	FOR INFORMATION	SPG	15.11.2017
C	SSDA	SPG	31.01.2018



Nominated Architects
Joe Agius no. 6491
Russell Lee no. 6367

Project
THE UNIVERSITY OF SYDNEY ETP STAGE 1
Electrical Engineering Building
University in Darlingtown, NSW 2008
Drawing Title
FLOOR PLAN - LEVEL 02

A1 DRAWING SHEET	Drawn: SPG
Co-ordinated: Michael Grave	Scale: 1 : 200 @ A1
Project Architect: Michael Bradburn	Date: 31/01/18
Project Director: David Holm	Revision: C
Drawing Number:	North:
A-DA-2102	

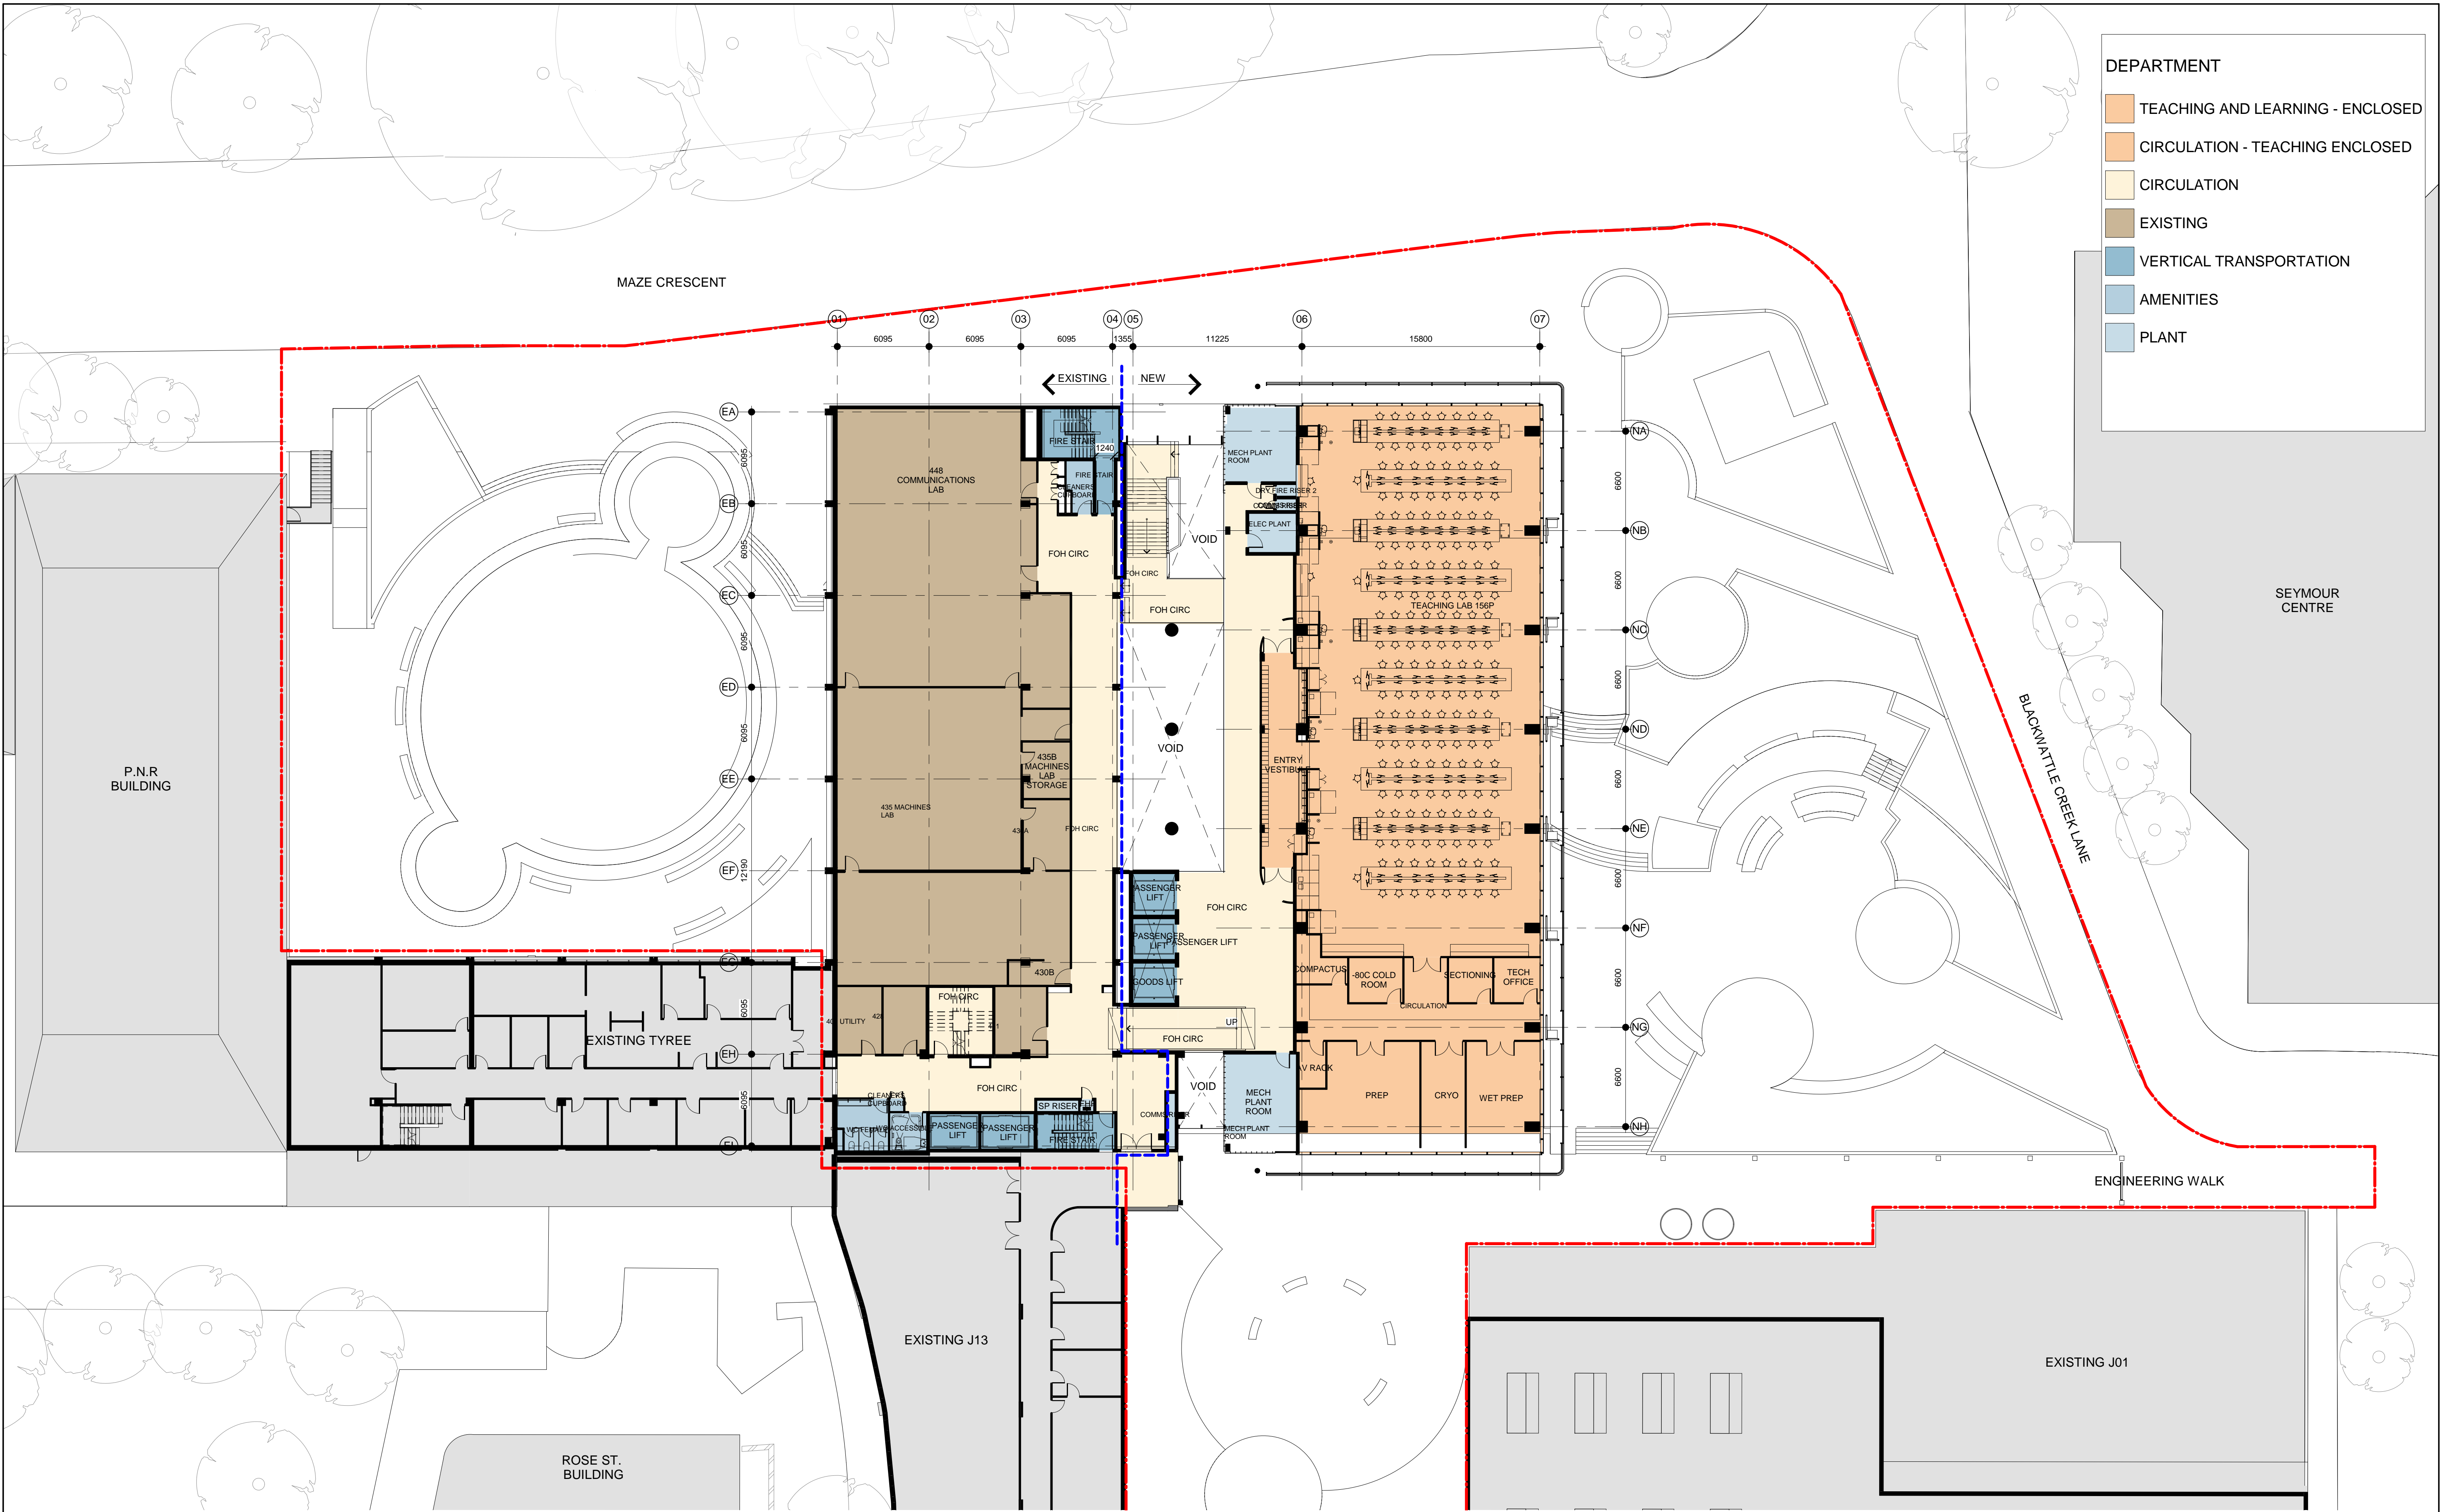

Rev	Description	By	Date
A	PRELIMINARY ISSUE	SPG	08.11.2017
B	FOR INFORMATION	SPG	15.11.2017
C	SSDA	SPG	31.01.2018




Level 6, 155 Clarence Street,
Sydney, NSW 2000, Australia
T + 61 2 9267 9599
F + 61 2 9264 5844
www.coxarchitecture.com.au

Nominated Architects
Joe Agius no. 6491
Russell Lee no. 6367

Project
THE UNIVERSITY OF SYDNEY ETP STAGE 1
Electrical Engineering Building
University in Darlingtown, NSW 2008
Drawing Title
FLOOR PLAN - LEVEL 04

A1 DRAWING SHEET
Co-ordinated: Michael Grave
Project Architect: Michael Bradburn
Project Director: David Holm
Drawing Number: A-DA-2104
Drawn: SPG
Scale: 1 : 200 @ A1
Date: 31/01/18
Revision: C
North:

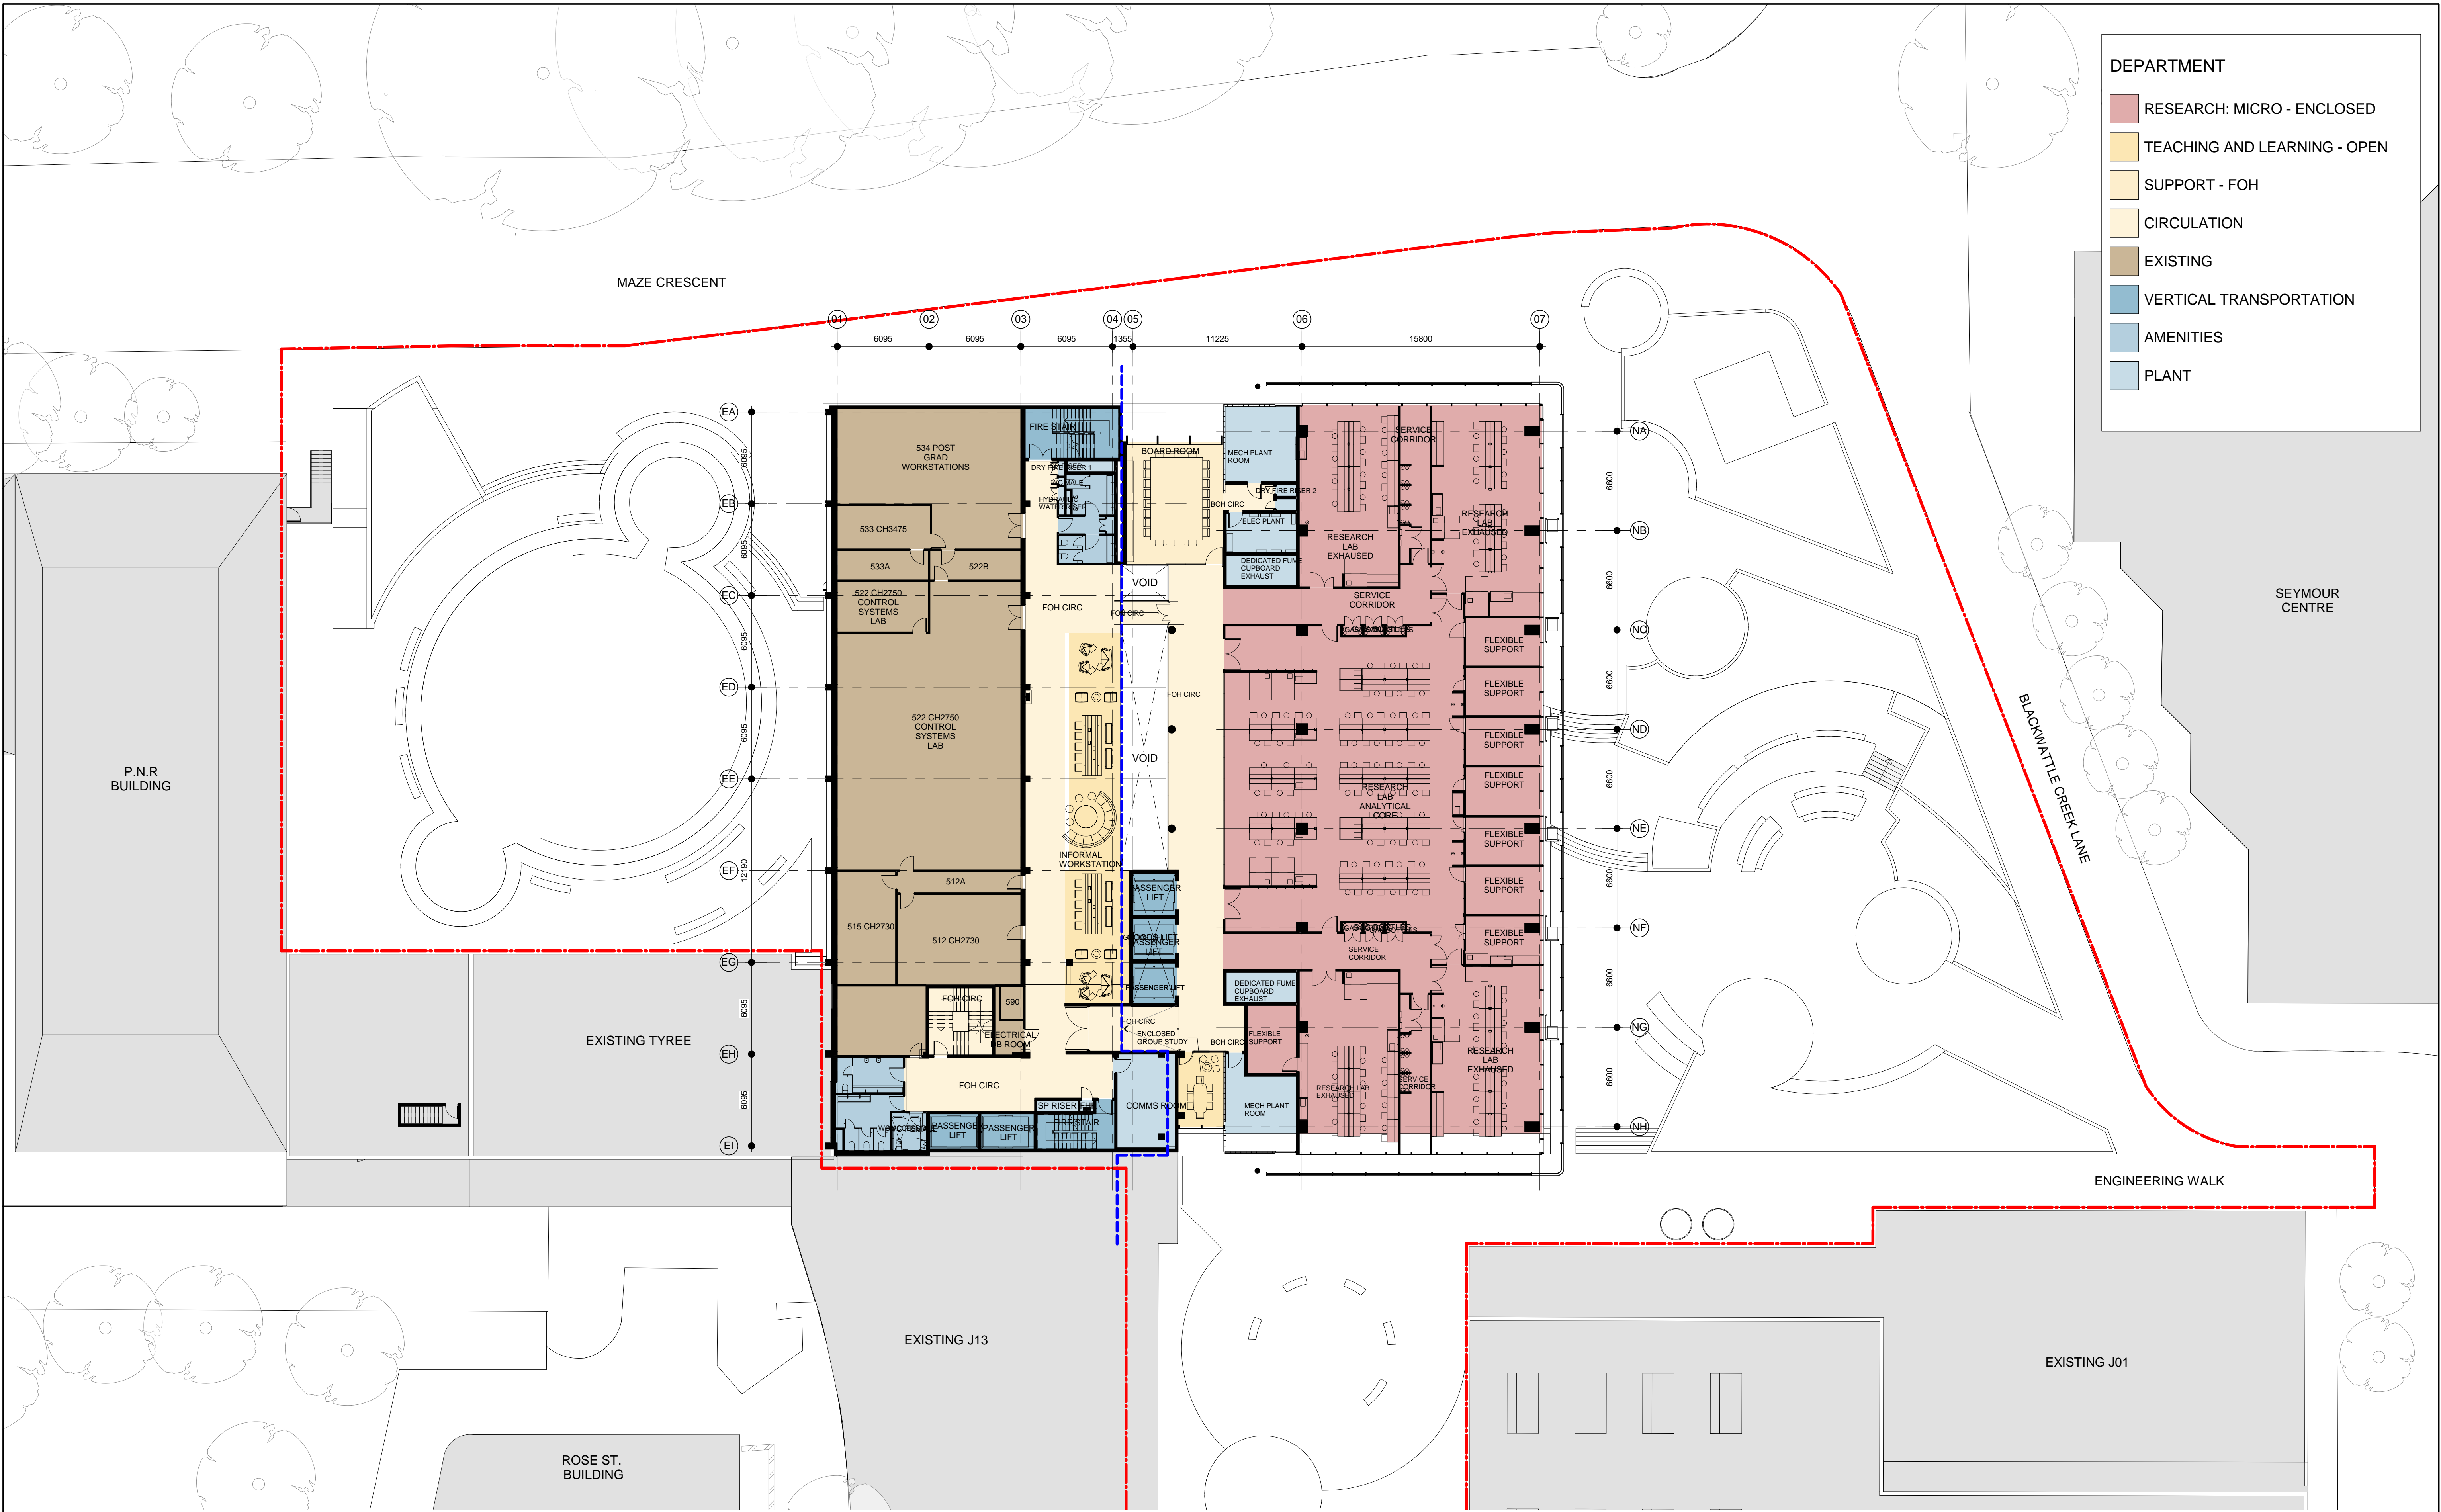

DEPARTMENT

RESEARCH: MICRO - ENCLOSED

TEACHING AND LEARNING - OPEN

SUPPORT - FOH

CIRCULATION

EXISTING

VERTICAL TRANSPORTATION

AMENITIES

PLANT

© COPYRIGHT COX ARCHITECTURE PTY LTD. ANY FORM OF REPRODUCTION OF THIS DRAWING IN FULL OR IN PART WITHOUT THE WRITTEN PERMISSION OF COX ARCHITECTURE PTY LTD CONSTITUTES AN INFRINGEMENT OF COPYRIGHT			
Rev	Description	By	Date
A	PRELIMINARY ISSUE	SPG	08.11.2017
B	FOR INFORMATION	SPG	15.11.2017
C	SSDA	SPG	31.01.2018

Principal



Contractor



Architect



Level 6, 155 Clarence Street,
Sydney, NSW 2000, Australia
T + 61 2 9267 9599
F + 61 2 9264 5844
www.coxarchitecture.com.au

Nominated Architects
Joe Agius no. 6491
Russell Lee no. 6367

Project

THE UNIVERSITY OF SYDNEY ETP STAGE 1

Electrical Engineering Building
University in Darlingtown, NSW 2008

Drawing Title

FLOOR PLAN - LEVEL 05

A1 DRAWING SHEET

Co-ordinated: Michael Grave

Project Architect: Michael Bradburn

Project Director: David Holm

Drawing Number:

A-DA-2105

 
Drawn: SPG


Scale: 1 : 200 @ A1

Date: 31/01/18

Revision: C

North:



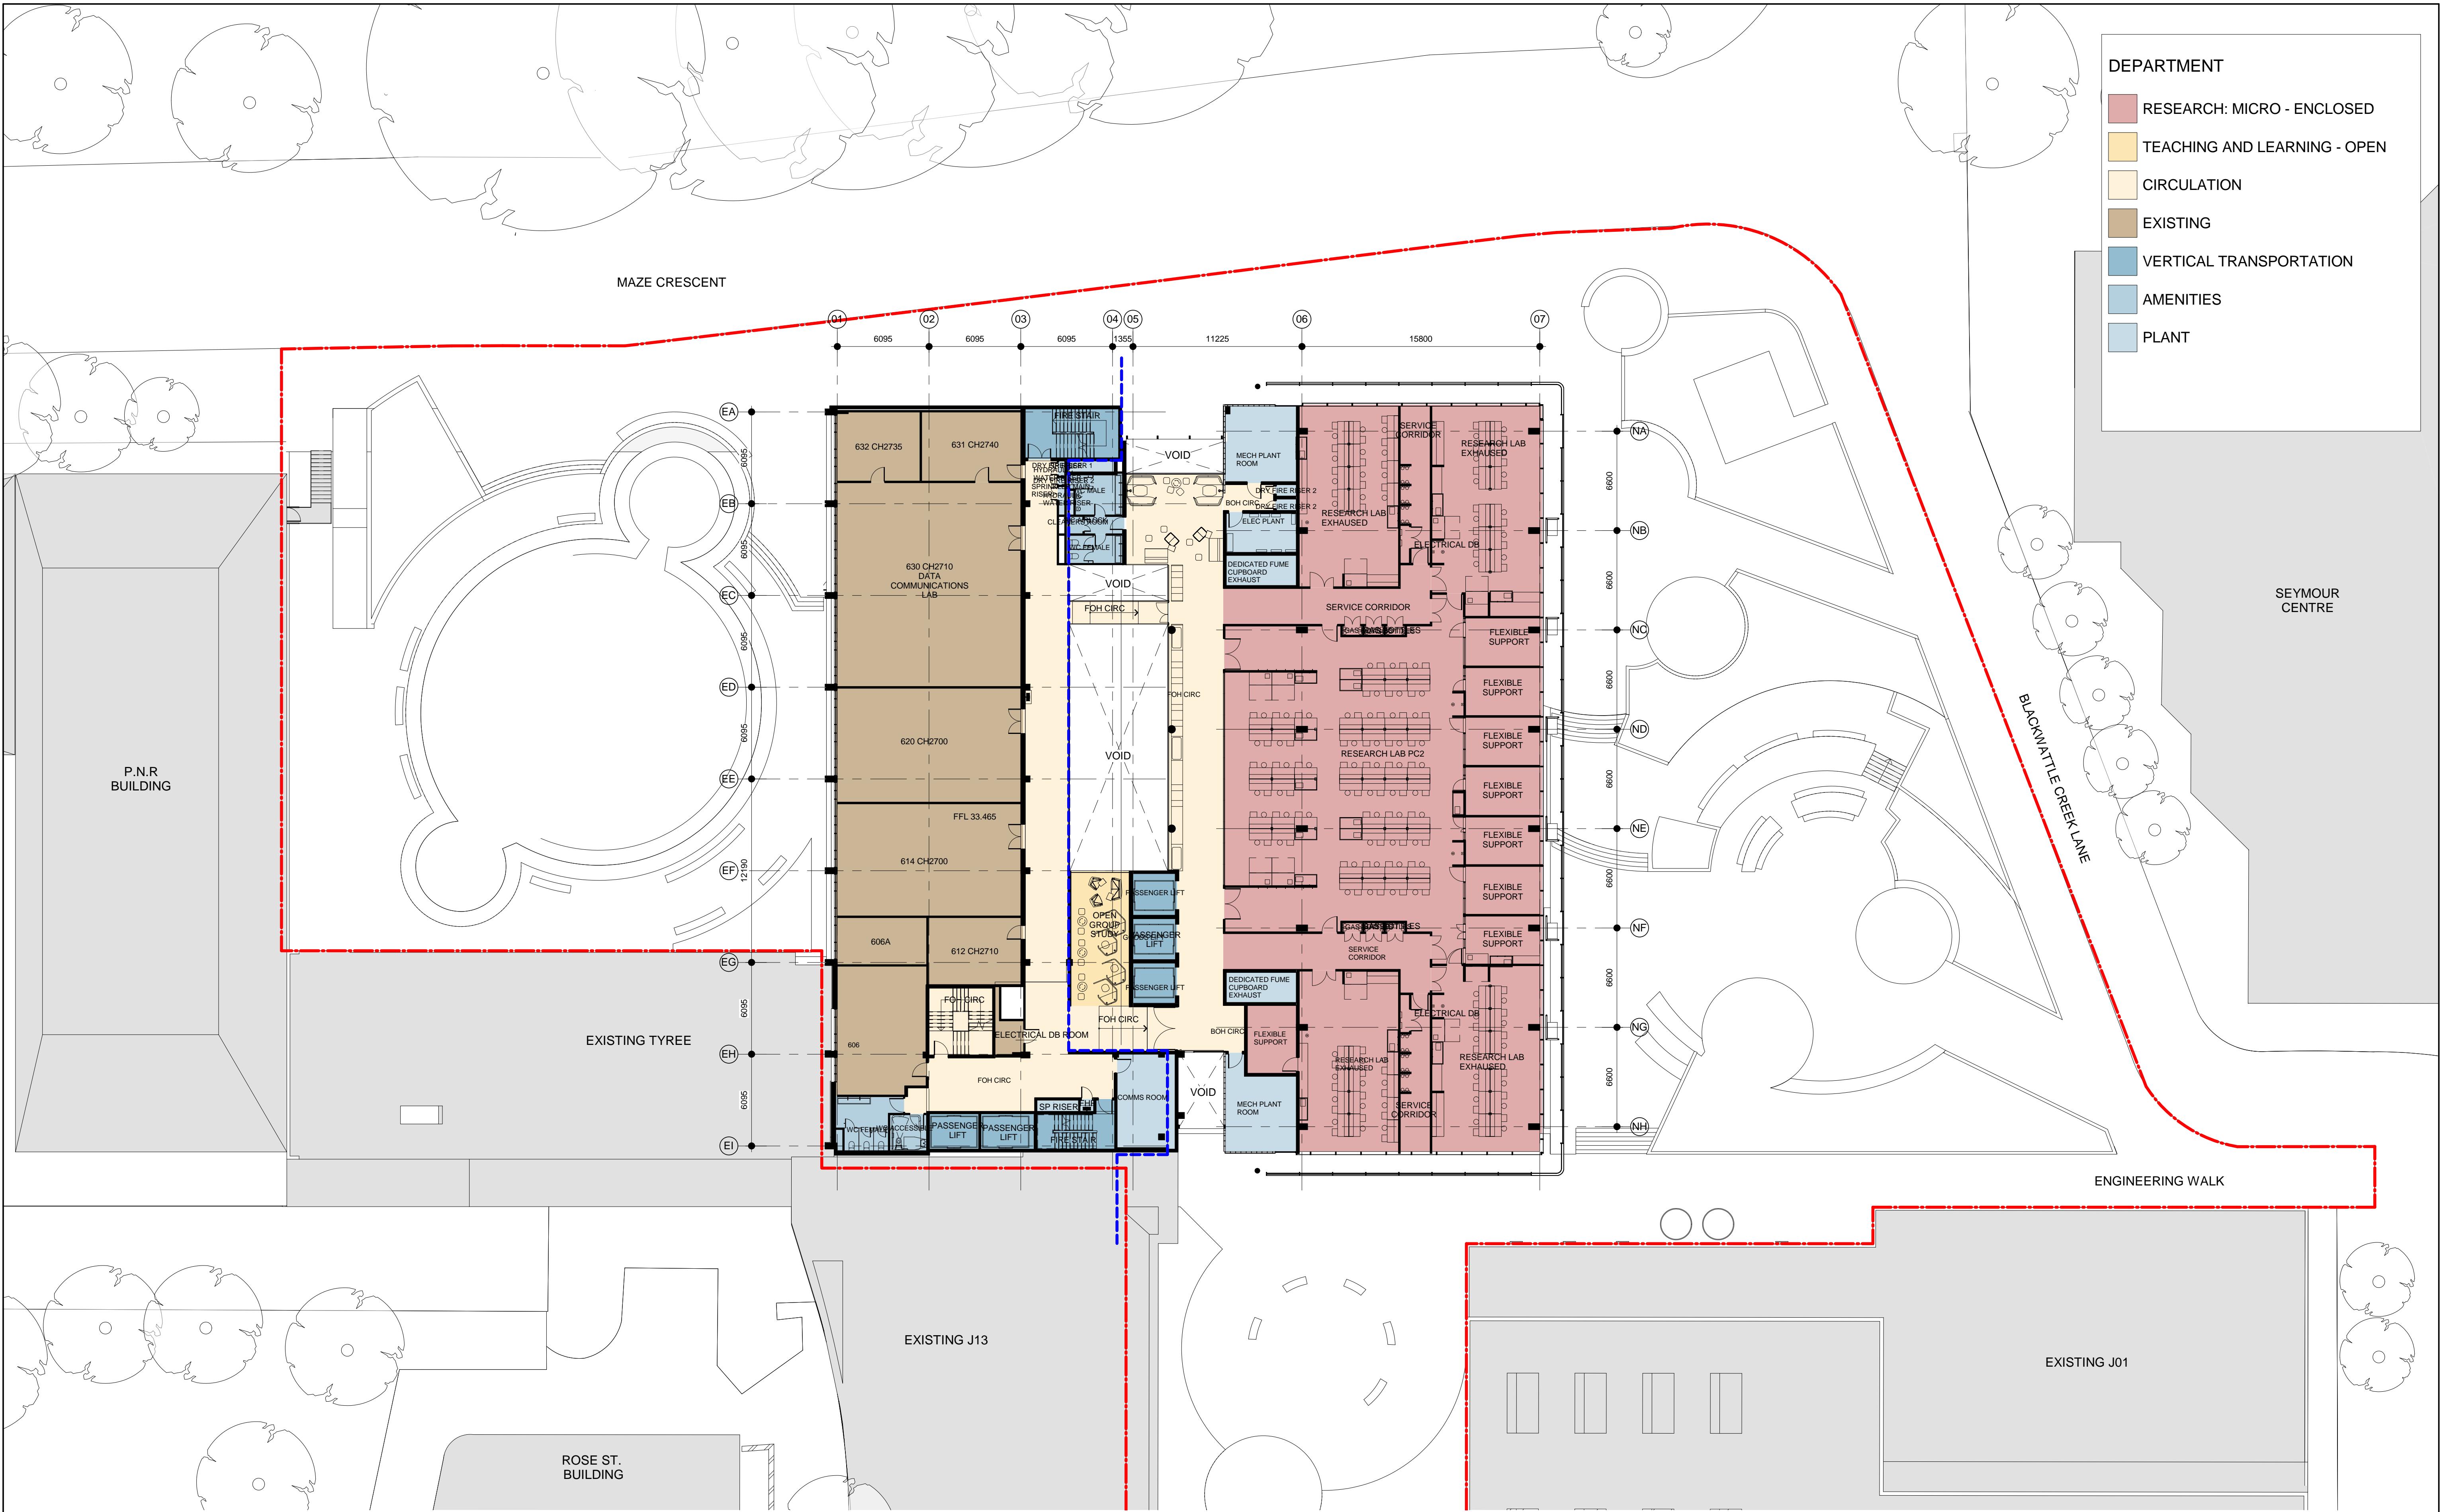

© COPYRIGHT COX ARCHITECTURE PTY LTD. ANY FORM OF REPRODUCTION OF THIS DRAWING IN FULL OR IN PART WITHOUT THE WRITTEN PERMISSION OF COX ARCHITECTURE PTY LTD CONSTITUTES AN INFRINGEMENT OF COPYRIGHT			
Rev	Description	By	Date
A	PRELIMINARY ISSUE	SPG	08.11.2017
B	FOR INFORMATION	SPG	15.11.2017
C	SSDA	SPG	31.01.2018

Principal



Contractor



Architect



Level 6, 155 Clarence Street,
Sydney, NSW 2000, Australia
T + 61 2 9267 9599
F + 61 2 9264 5844
www.coxarchitecture.com.au

Nominated Architects
Joe Agius no. 6491
Russell Lee no. 6367

Project

THE UNIVERSITY OF SYDNEY ETP STAGE 1

Electrical Engineering Building
University in Darlingtown, NSW 2008

Drawing Title

FLOOR PLAN - LEVEL 06

ENGINEERING WALK

EXISTING J01

A1 DRAWING SHEET


Co-ordinated: Michael Grave

Project Architect: Michael Bradburn


Project Director: David Holm

Drawing Number: A-DA-2106

North

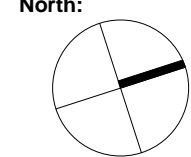


Cox Architecture Pty Ltd ACN 002 535 891

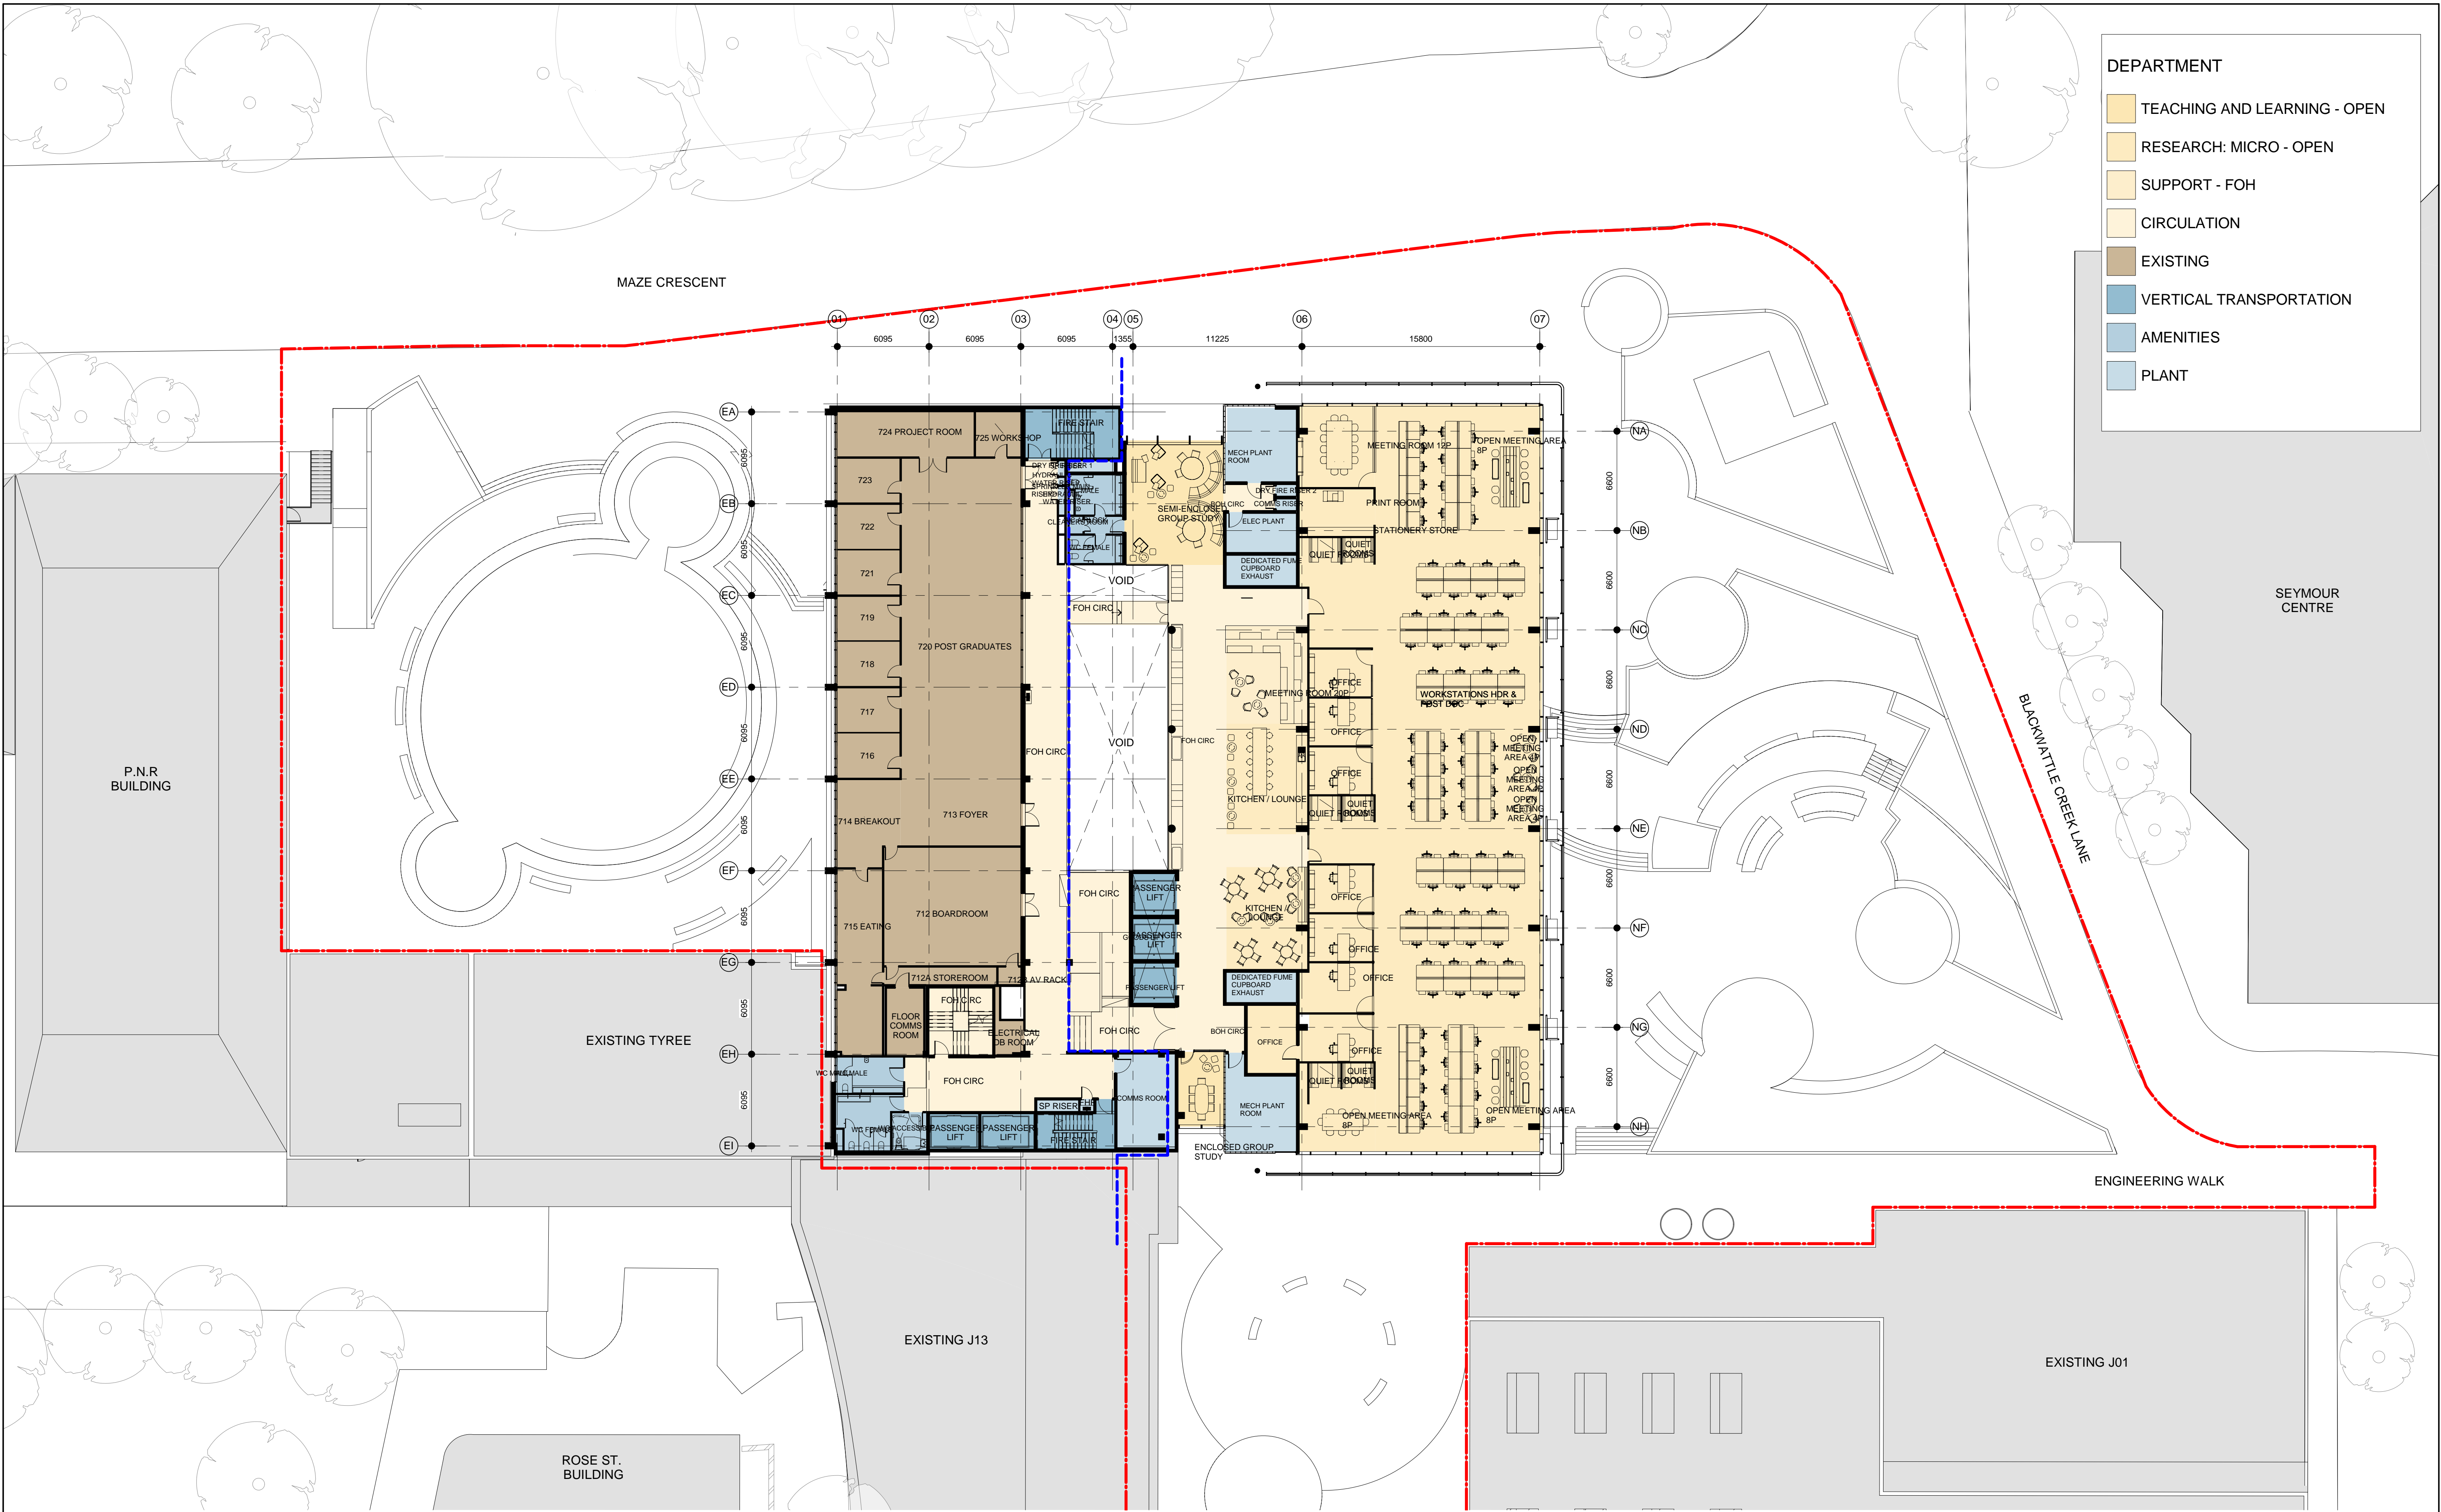

- DEPARTMENT
- TEACHING AND LEARNING - OPEN
 - RESEARCH: MICRO - OPEN
 - SUPPORT - FOH
 - CIRCULATION
 - EXISTING
 - VERTICAL TRANSPORTATION
 - AMENITIES
 - PLANT


Rev	Description	By	Date
A	PRELIMINARY ISSUE	SPG	08.11.2017
B	FOR INFORMATION	SPG	15.11.2017
C	SSDA	SPG	31.01.2018

Principal




THE UNIVERSITY OF SYDNEY

Contractor



LANG O'ROURKE

Architect



COX

Level 6, 155 Clarence Street,
Sydney, NSW 2000, Australia
T + 61 2 9267 9599
F + 61 2 9264 5844
www.coxarchitecture.com.au

Nominated Architects
Joe Agius no. 6491
Russell Lee no. 6367

Project

THE UNIVERSITY OF SYDNEY ETP STAGE 1

Electrical Engineering Building
University in Darlington, NSW 2008

Drawing Title

FLOOR PLAN - LEVEL 07

A1 DRAWING SHEET

Co-ordinated: Michael Grave

Project Architect: Michael Bradburn

Project Director: David Holm

Drawing Number:

Drawn: SPG

Scale: 1 : 200 @ A1

Date: 31/01/18

Revision: C

North:

