

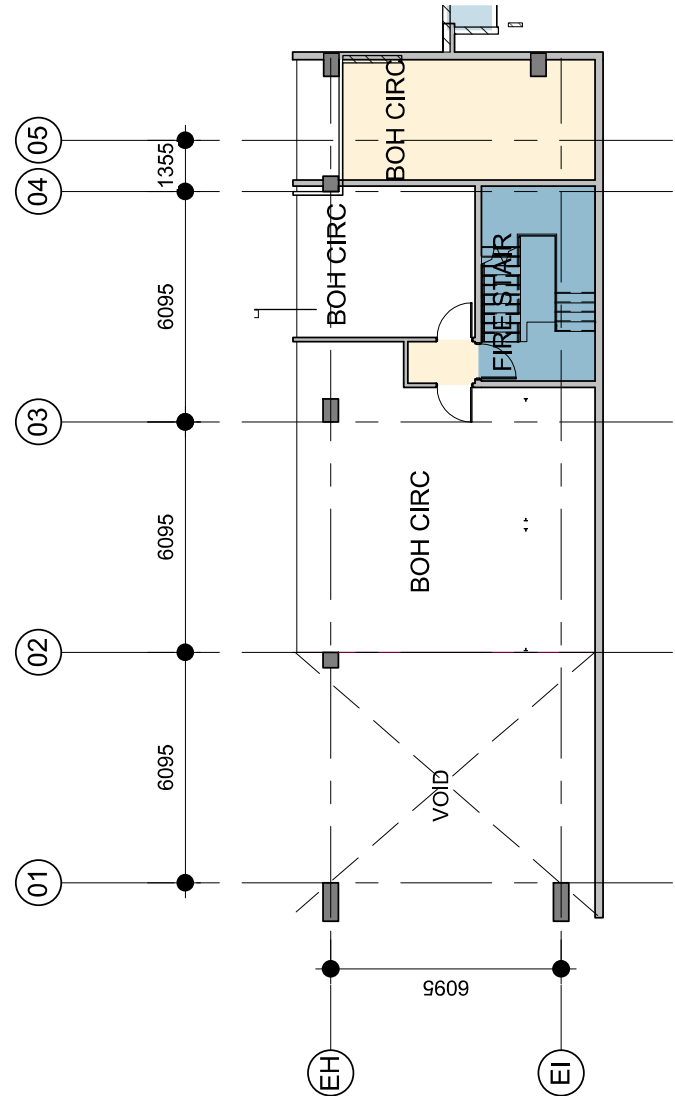


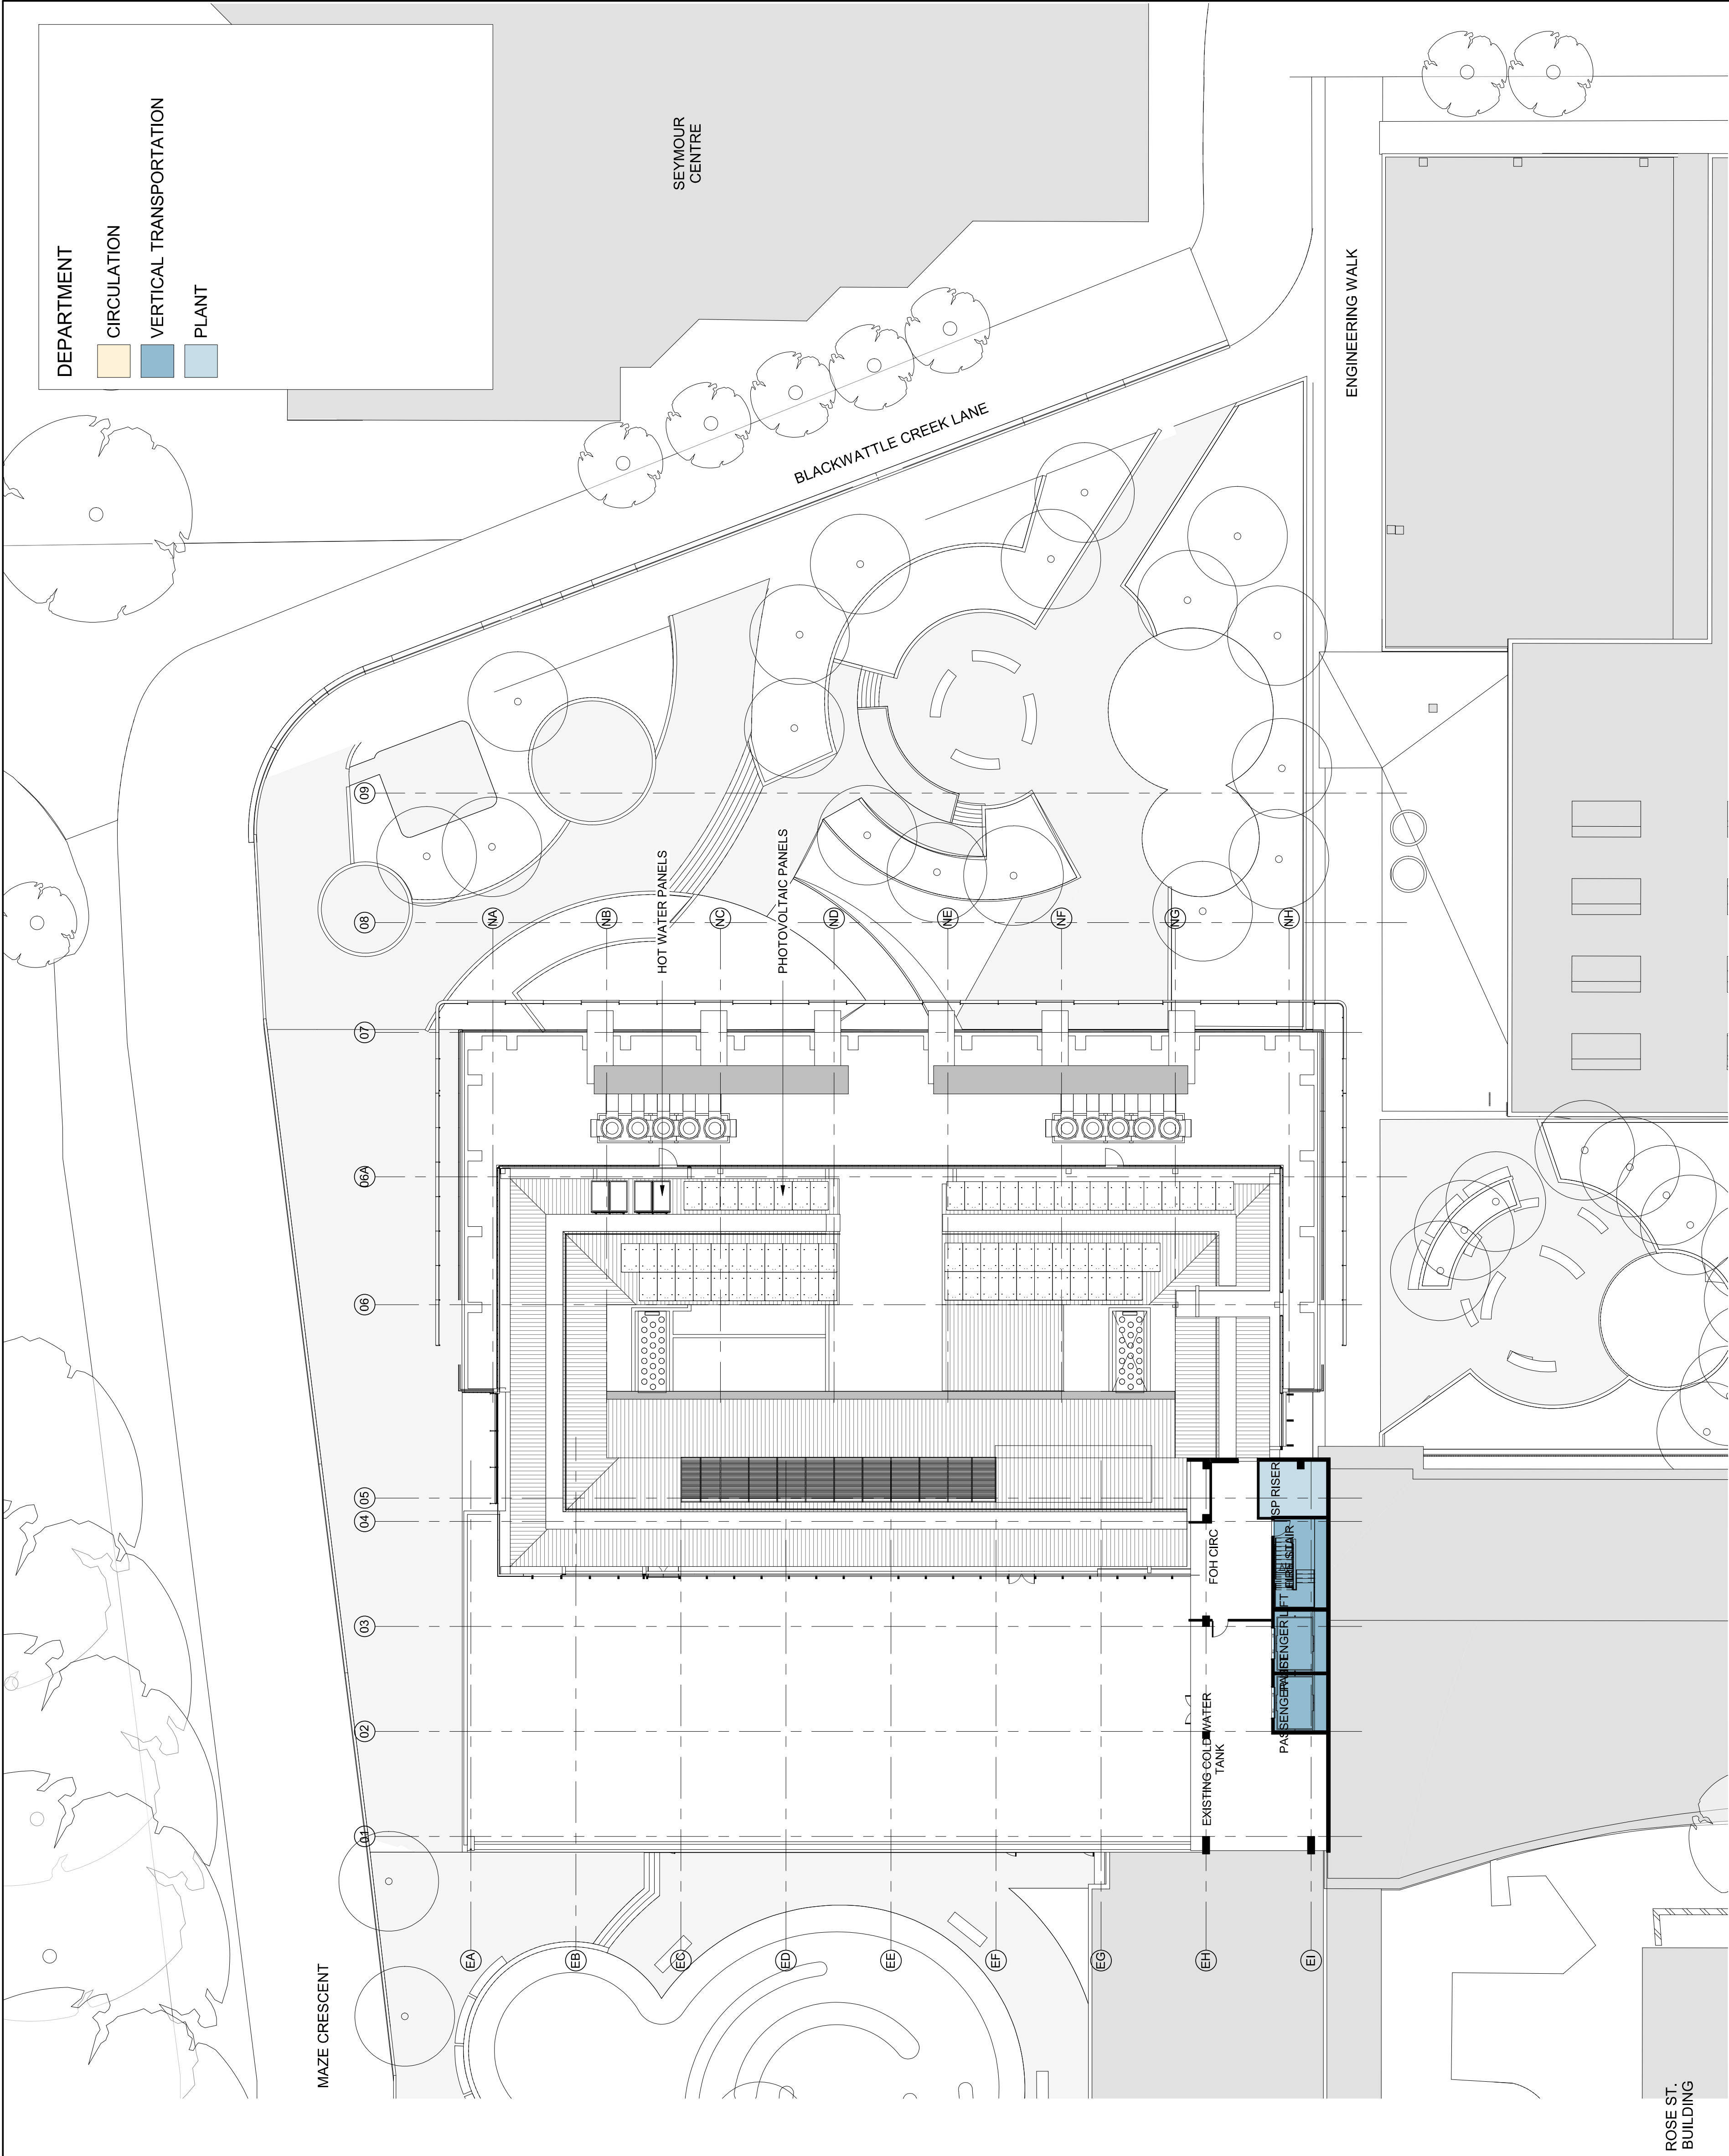

2 LEVEL 12
SCALE 1:200
ADA-2112

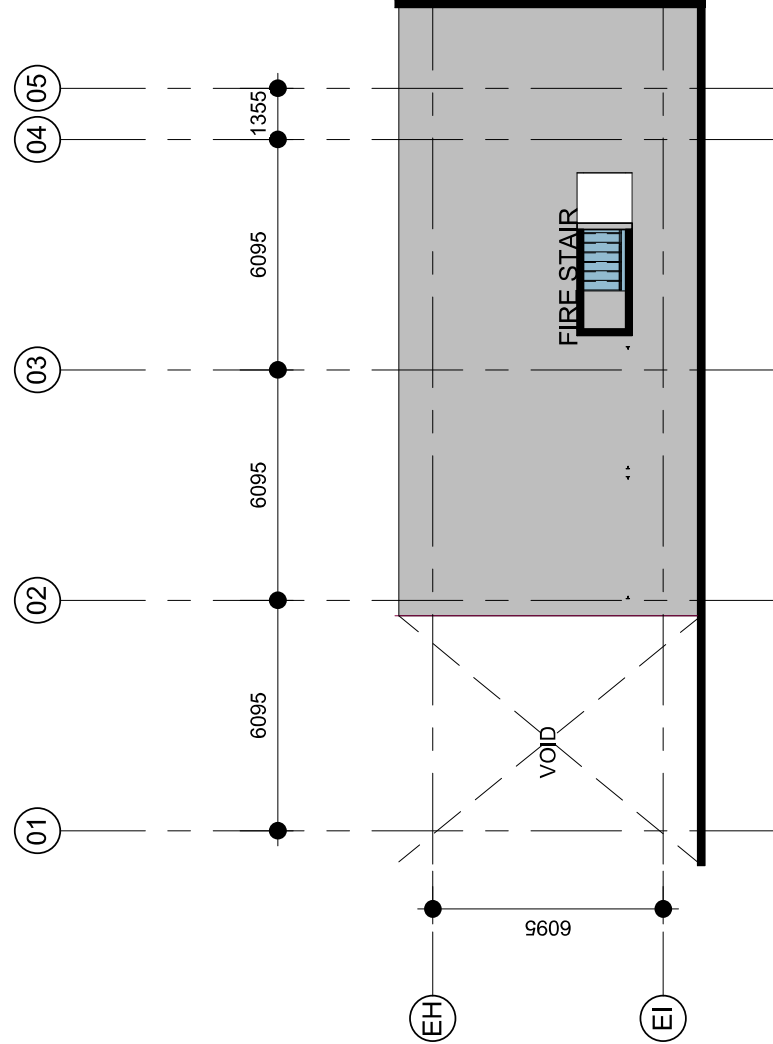

3 LEVEL 13 - ROOF
SCALE 1:200
ADA-2113

© 2018 COX ARCHITECTURE PTY LTD.
PERMISSION OF COX ARCHITECTURE PTY LTD CONSTITUTES AN INFRINGEMENT OF
COPYRIGHT

Rev	Description	By	Date
A	PRELIMINARY ISSUE	SPG	06.11.2017
B	FOR INFORMATION	SPG	31.07.2018
C	ISSUED	SPG	31.07.2018
D	RESPONSE TO SUBMISSION	VU	03.05.2018

Principal



Contractor

Architect



Level 6, 155 Clarence Street,
Sydney, NSW 2000, Australia
T + 61 2 9287 9599
F + 61 2 9284 5844
www.coxarchitecture.com.au

Nominated Architects
John Ayles no. 5491
Richard Lane no. 5207

Project

THE UNIVERSITY OF SYDNEY ETP STAGE 1

Electrical Engineering Building
University in Darlington, NSW 2008

Drawing Title

FLOOR PLAN - LEVEL 11,12,13

AT DRAWING SHEET

Drawn: SPG


Co-ordinated: Michael Grave

Project Architect: Michael Braddum

Project Director: David Holm

Drawing Number: A-DA-2111

North:

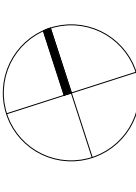



© COX ARCHITECTS COX ARCHITECTS ARE PTY. LTD.
PERMISSION OF COX ARCHITECTURE PTY LTD CONSTITUTES AN INFRINGEMENT OF
COPYRIGHT

Rev	SSOA	Description	By	Date
A	SSOA	RESPONSE TO SUBMISSION	SPG	31/07/18
B			YU	02/02/2018

Principal



Contractor



Architect



Level 6, 155 Clarence Street,
Sydney, NSW 2000, Australia
T + 61 2 9287 9599
F + 61 2 9284 5844
www.coxarchitects.com.au

Nominated Architects
Johr Agius no. 6491
Richard Lane no. 6207

Project
THE UNIVERSITY OF SYDNEY ETP STAGE 1

Electrical Engineering Building
University in Darlington, NSW 2008

Drawing Title

3D VIEW - NORTH

Drawn: SPG

Co-ordinated: Michael Grave

Project Architect: Michael Bradburn

Project Director: David Holm

Drawing Number: A-DA-3001A

Scale: @ A1

Date: 31/07/18

Revision: B

North:

Cox Architecture Pty Ltd ACN 102 535 891



© COX ARCHITECTS COX ARCHITECTS ARE PTY. LTD.
PERMISSION OF COX ARCHITECTURE PTY LTD CONSTITUTES AN INFRINGEMENT OF
COPYRIGHT

Rev	SSA	Description	By	Date
A	SSA	RESPONSE TO SUBMISSION	SPG	31/07/2018
B	YU		YU	02/02/2018

Principal



Contractor



Architect



Level 6, 155 Clarence Street,
Sydney, NSW 2000, Australia
T + 61 2 9287 9599
F + 61 2 9284 3844
www.coxarchitects.com.au

Nominated Architects
Johannes No. 5491
Richard Lee No. 5207

Project
THE UNIVERSITY OF SYDNEY ETP STAGE 1

Electrical Engineering Building
University in Darlington, NSW 2008

Drawing Title

3D VIEW - SOUTH WEST

Drawn: SPG

Co-ordinated: Michael Grave

Project Architect: Michael Bradburn

Project Director: David Holm

Drawing Number: A-DA-3002A

North:

