


FOR APPROVAL

© COPYRIGHT GRIMSHAW ARCHITECTS PTY LIMITED. UNLESS OTHERWISE AGREED IN WRITING, ALL RIGHTS TO USE THIS DOCUMENT ARE SUBJECT TO PAYMENT IN FULL OF ALL GRIMSHAW CHARGES. THIS DOCUMENT MAY ONLY BE USED FOR THE EXPRESS PURPOSE AND PROJECT FOR WHICH IT HAS BEEN CREATED AND DELIVERED. AS NOTIFIED IN WRITING BY GRIMSHAW. AND THIS DOCUMENT MAY NOT BE OTHERWISE USED, OR COPIED, ANY UNAUTHORISED USE OF THIS DOCUMENT IS AT THE USER'S SOLE RISK AND WITHOUT LIMITING GRIMSHAW'S RIGHTS THE USER RELEASES AND INDEMNIFIES GRIMSHAW FROM AND AGAINST ALL LOSS SO ARISING

REV.	DATE	FOR
01	MAY 2017	STAGE 1 SSDA
02	JUNE 2018	AMENDING STAGE 1 SSDA
03	JANUARY 2019	AMENDING STAGE 1 SSDA UPDATE FOR DPE

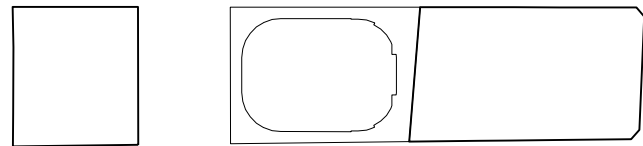

HEAD DESIGN CONSULTANT
GRIMSHAW

GRIMSHAW
LEVEL 3, 24 HECKSON ROAD, SYDNEY
NEW SOUTH WALES 2000 AUSTRALIA
TELEPHONE +61 2 9253 0200
WWW.GRIMSHAW.GLOBAL

NORTH TOWER PRINCIPAL
**JPW
JOHNSON PILTON WALKER**


JOHNSON PILTON WALKER PTY LTD ACN 095 778 886
LEVEL 10 PLAZA BUILDING AUSTRALIA SQUARE
36 PITT STREET SYDNEY
NEW SOUTH WALES 2000 AUSTRALIA
TELEPHONE +61 2 9259 5800
FACSIMILE +61 2 9259 5889
EMAIL JPW@JPW.COM.AU

HEAD ENGINEERING CONSULTANT
ARUP

ARUP
10/201 HENT STREET, SYDNEY 2000
TEL: +61 2 9220 9200
EMAIL: SYDNEY@ARUP.COM

PROJECT
**SYDNEY METRO MARTIN PLACE STATION
MACQUARIE'S UNSOLICITED PROPOSAL**

CLIENT
MACQUARIE GROUP LTD

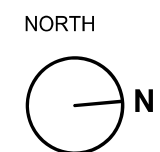


SCALE
1:1000 @ A1
DO NOT SCALE FROM DRAWING. USE MARKED DIMENSIONS TO BE READ IN CONJUNCTION WITH ALL OTHER CONSULTANT'S DRAWINGS.


STATUS
**APPROVED SSD ENVELOPE
(SSD 17_8351 AND 18_9347)**

DRAWING
**LOCATION PLAN
ENVELOPE DRAWINGS**

DRAWN	CHECKED	AUTHORISED
KY	MC	AC

DRAWING NUMBER	REVISION
MPS_COA_000_XX_DR_A_DA1007_03	

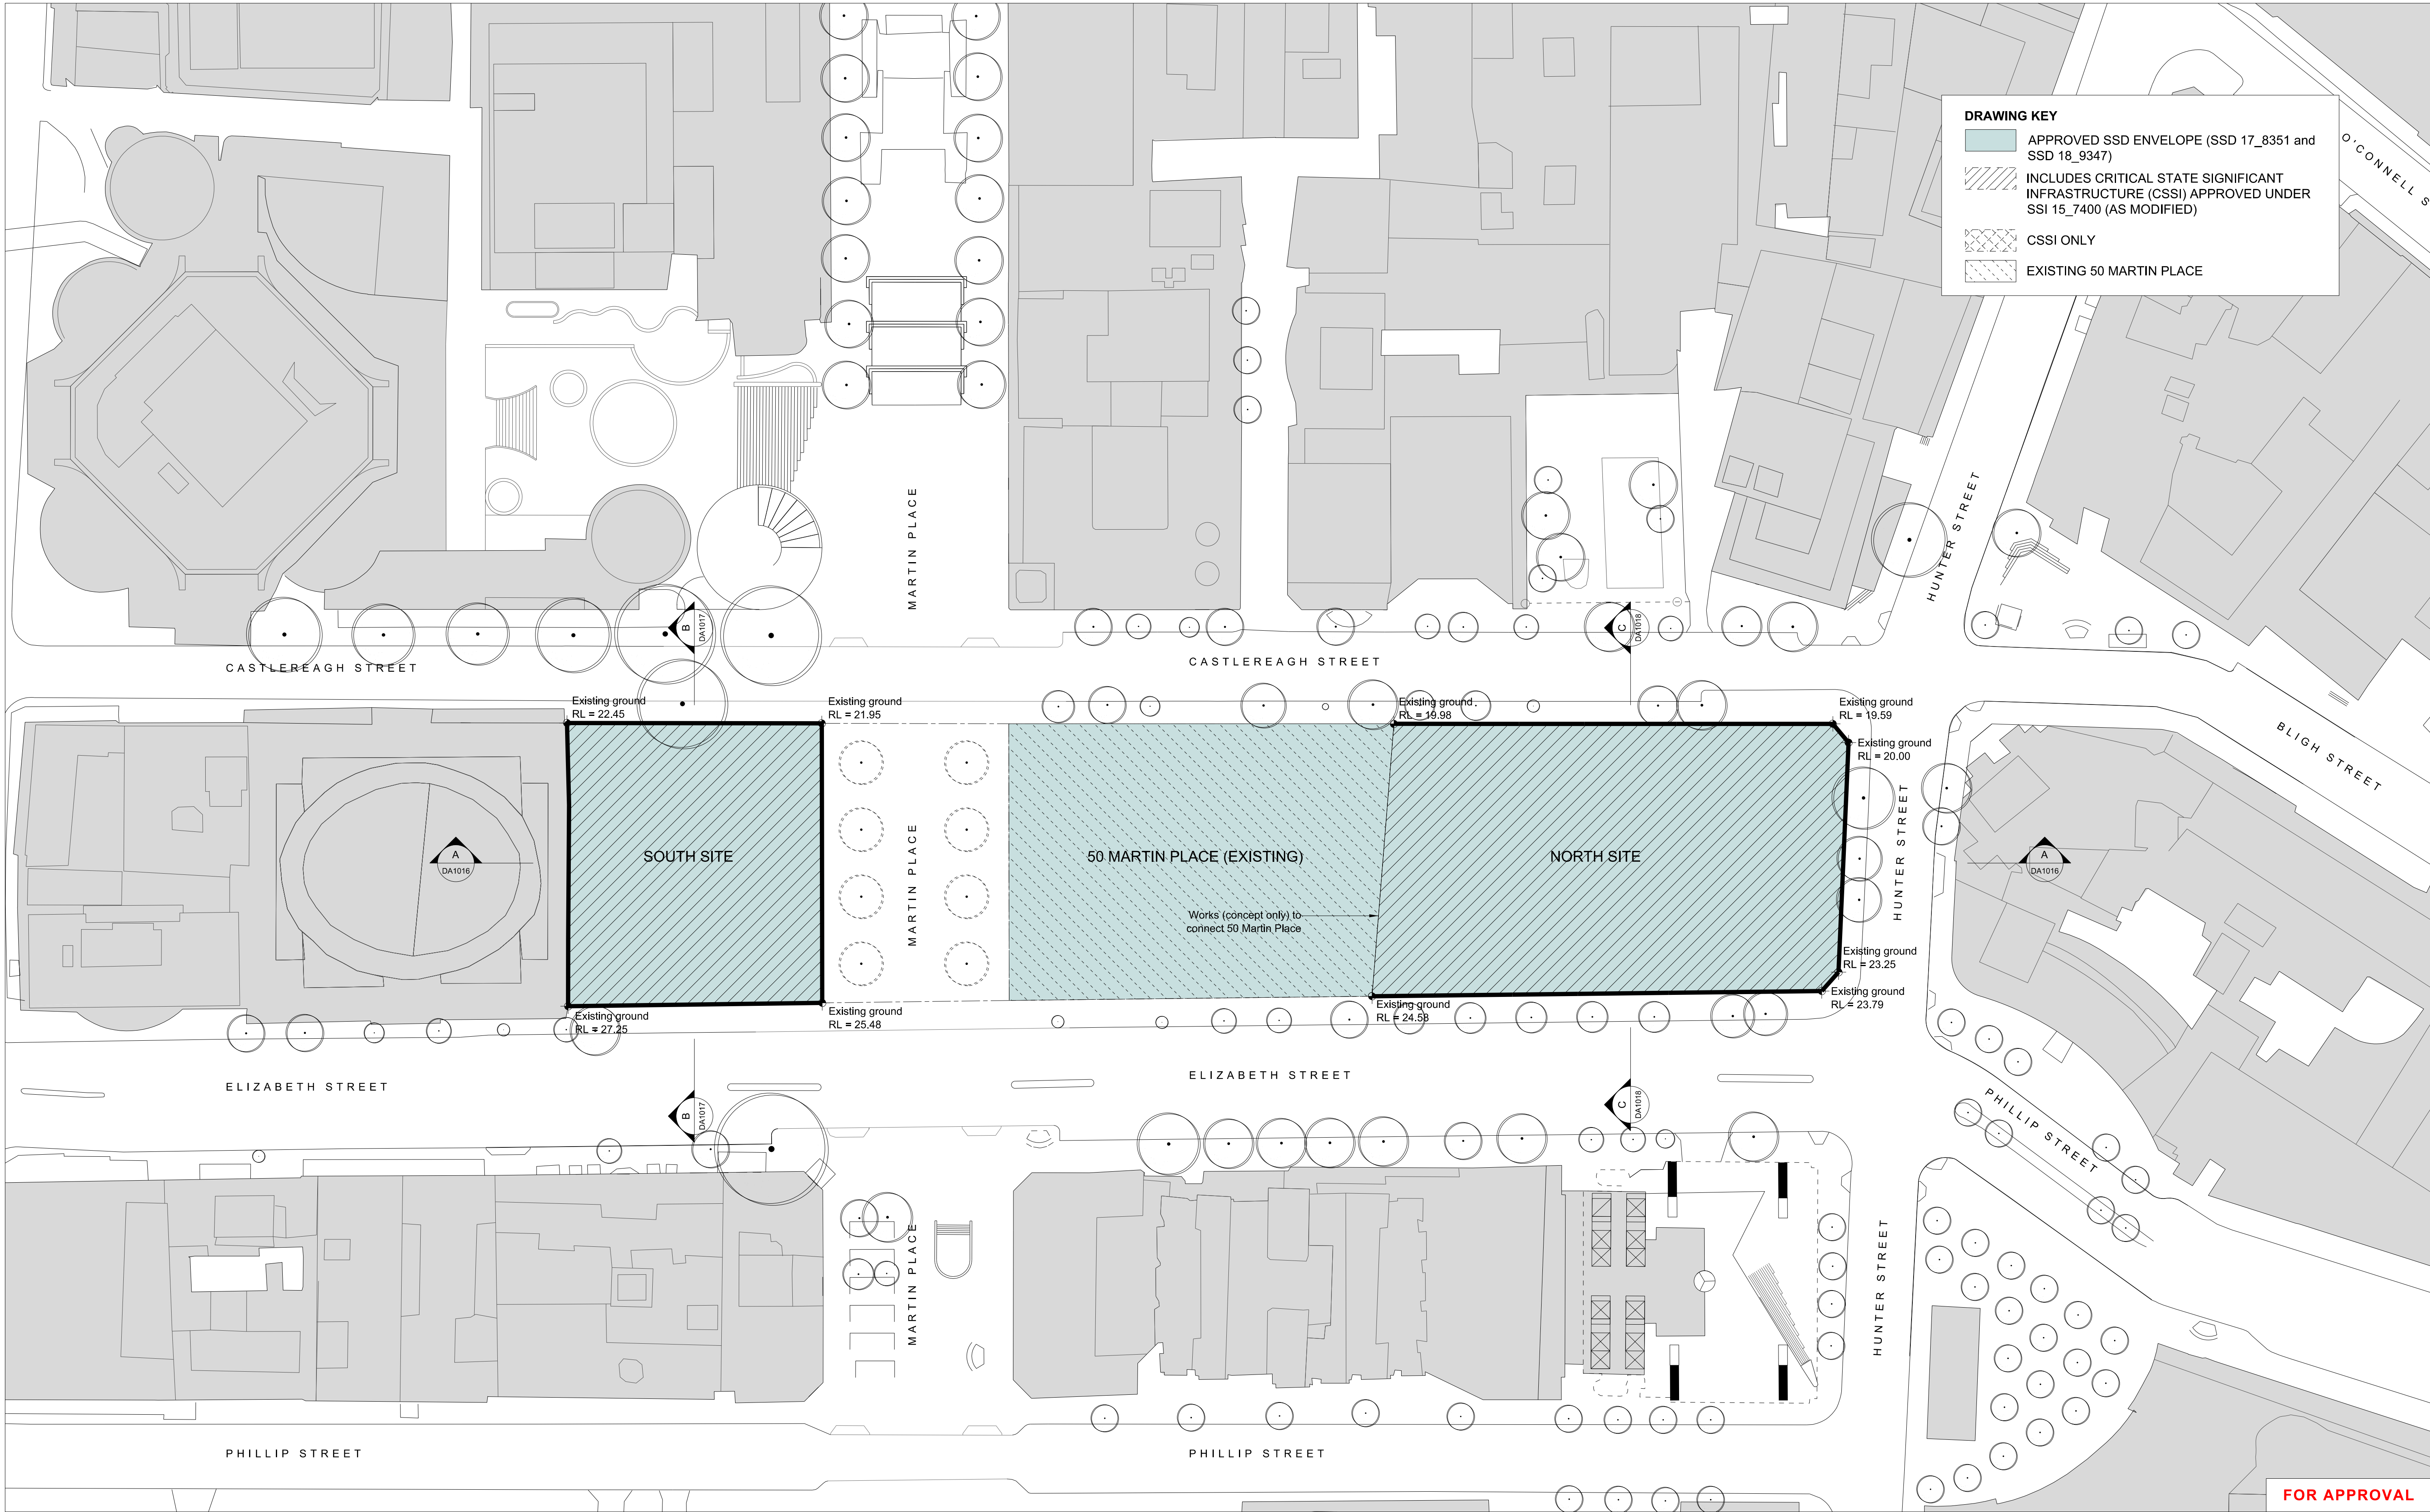
 
<div>© COPYRIGHT GRIMSHAW ARCHITECTS PTY LIMITED. UNLESS OTHERWISE AGREED IN WRITING, ALL RIGHTS TO USE THIS DOCUMENT ARE SUBJECT TO PAYMENT IN FULL OF ALL GRIMSHAW CHARGES. THIS DOCUMENT MAY ONLY BE USED FOR THE EXPRESS PURPOSE AND PROJECT FOR WHICH IT HAS BEEN CREATED AND DELIVERED. AS NOTIFIED IN WRITING BY GRIMSHAW. AND THIS DOCUMENT MAY NOT BE OTHERWISE USED, OR COPIED, ANY UNAUTHORISED USE OF THIS DOCUMENT IS AT THE USER'S SOLE RISK AND WITHOUT LIMITING GRIMSHAW'S RIGHTS THE USER RELEASES AND INDEMNIFIES GRIMSHAW FROM AND AGAINST ALL LOSS SO ARISING</div>	REV.	DATE	FOR	HEAD DESIGN CONSULTANT		NORTH TOWER PRINCIPAL		HEAD ENGINEERING CONSULTANT		PROJECT		DRAWING		GROUND FLOOR PLAN			
	01	MAY 2017	STAGE 1 SSDA	GRIMSHAW		JPW		ARUP		SYDNEY METRO MARTIN PLACE STATION		SCALE		ENVELOPE DRAWINGS			
	02	JUNE 2018	AMENDING STAGE 1 SSDA			JOHNSON PILTON WALKER				MACQUARIE'S UNSOLICITED PROPOSAL		1:500 @ A1					
	03	JANUARY 2019	AMENDING STAGE 1 SSDA UPDATE FOR DPE							CLIENT		DO NOT SCALE FROM DRAWING. USE MARKED DIMENSIONS TO BE READ IN CONJUNCTION WITH ALL OTHER CONSULTANT'S DRAWINGS.					
										MACQUARIE GROUP LTD		STATUS		DRAWING NUMBER			
												APPROVED SSD ENVELOPE (SSD 17_8351 AND 18_9347)		REVISION			
						<div>GRIMSHAW LEVEL 3, 24 HICKSON ROAD, SYDNEY NEW SOUTH WALES 2000 AUSTRALIA TELEPHONE +61 2 9253 0200 WWW.GRIMSHAW.GLOBAL</div>		<div>JOHNSON PILTON WALKER PTY LTD ACN 095 778 886 LEVEL 10 PLAZA BUILDING AUSTRALIA SQUARE 35 PITT STREET SYDNEY NEW SOUTH WALES 2000 AUSTRALIA TELEPHONE +61 2 9259 5800 FACSIMILE +61 2 9259 5889 EMAIL JPW@JPW.COM.AU</div>		<div>ARUP 10/201 KENT STREET, SYDNEY 2000 TEL +61 2 9320 9200 EMAIL: SYDNEY@ARUP.COM</div>		CLIENT MACQUARIE GROUP LTD		DRAWN		CHECKED	
												KY		MC			
														AUTHORISED			
														AC			


DRAWING KEY

APPROVED SSD ENVELOPE (SSD 17_8351 and SSD 18_9347)

INCLUDES CRITICAL STATE SIGNIFICANT INFRASTRUCTURE (CSSI) APPROVED UNDER SSI 15_7400 (AS MODIFIED)

CSSI ONLY


EXISTING 50 MARTIN PLACE

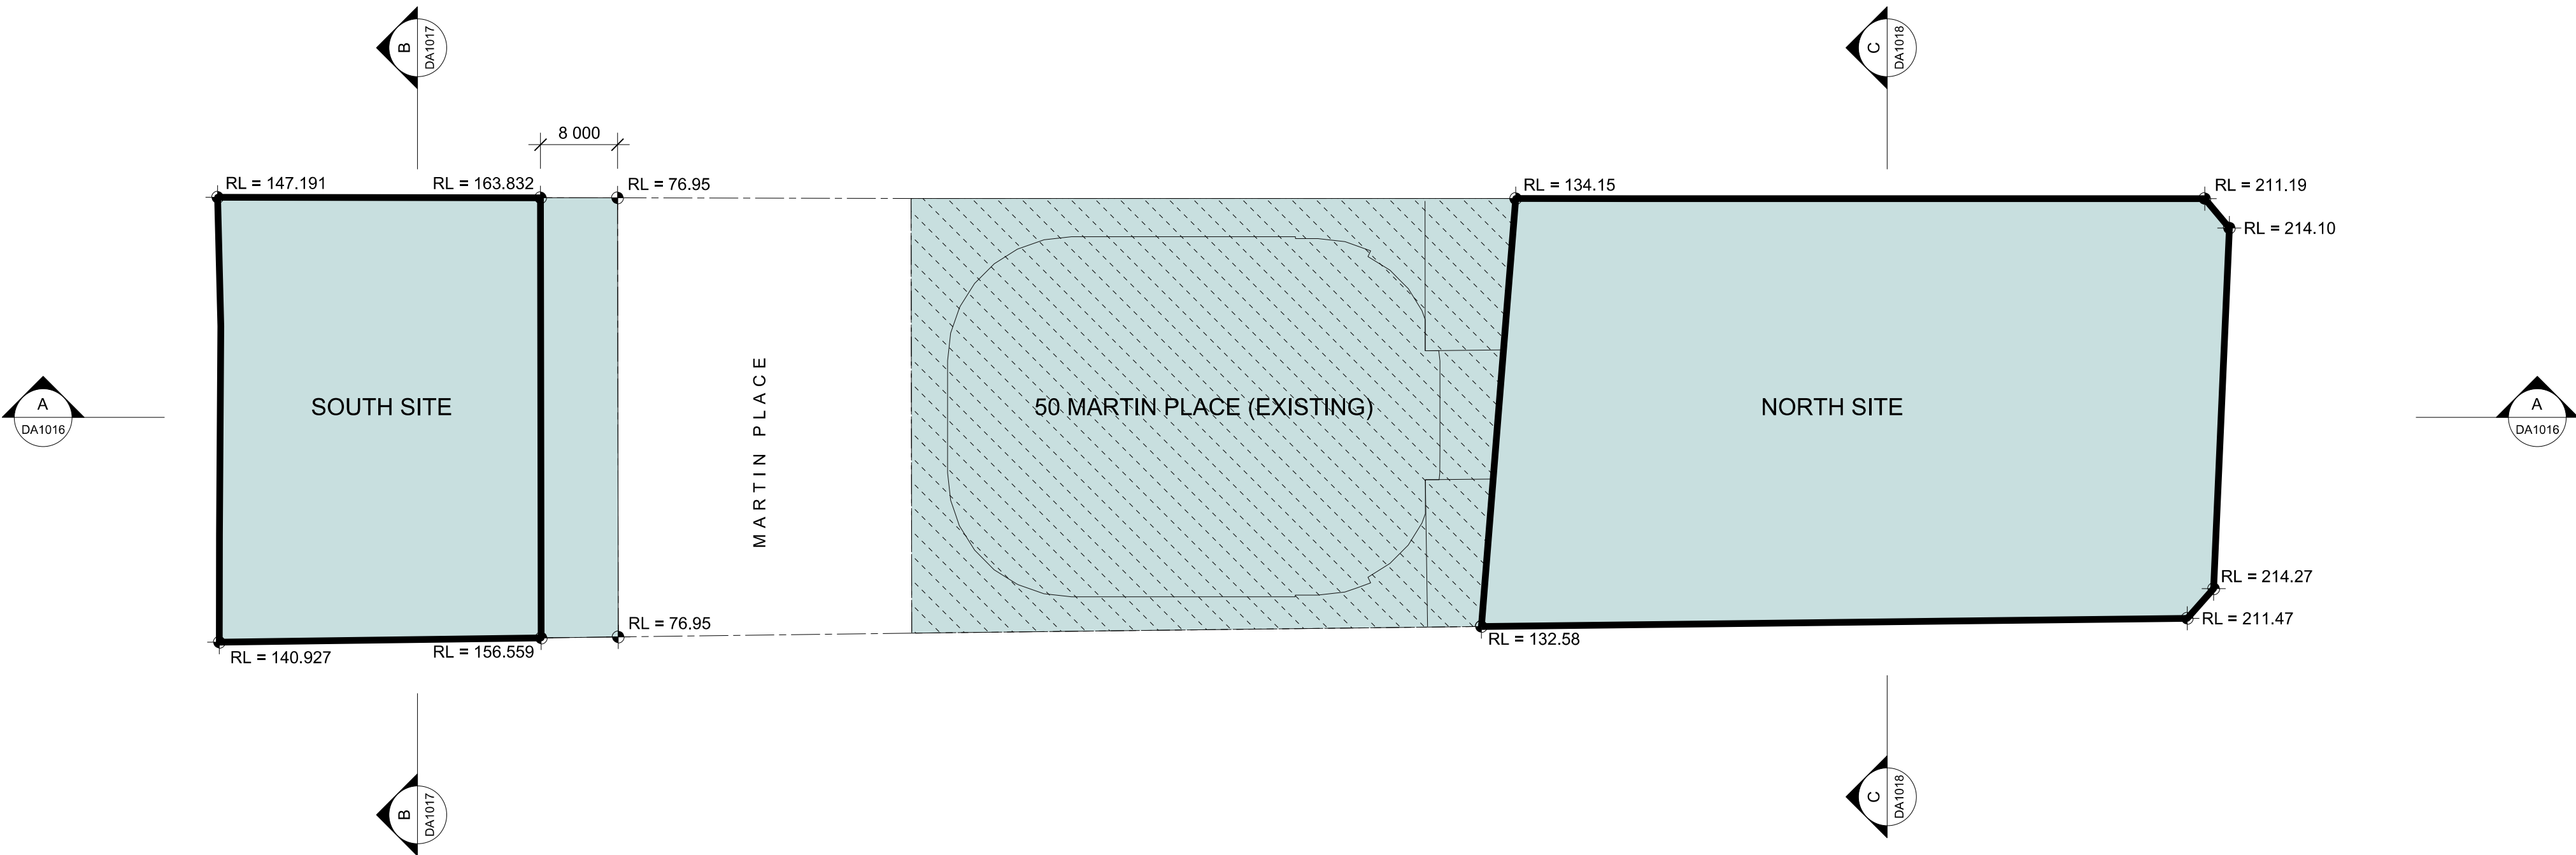

FOR APPROVAL

© COPYRIGHT GRIMSHAW ARCHITECTS PTY LIMITED. UNLESS OTHERWISE AGREED IN WRITING, ALL RIGHTS TO USE THIS DOCUMENT ARE SUBJECT TO PAYMENT IN FULL OF ALL GRIMSHAW CHARGES. THIS DOCUMENT MAY ONLY BE USED FOR THE EXPRESS PURPOSE AND PROJECT FOR WHICH IT HAS BEEN CREATED AND DELIVERED. AS NOTIFIED IN WRITING BY GRIMSHAW. AND THIS DOCUMENT MAY NOT BE OTHERWISE USED, OR COPIED. ANY UNAUTHORISED USE OF THIS DOCUMENT IS AT THE USER'S SOLE RISK AND WITHOUT LIMITING GRIMSHAW'S RIGHTS THE USER RELEASES AND INDEMNIFIES GRIMSHAW FROM AND AGAINST ALL LOSS SO ARISING

REV.	DATE	FOR
01	MAY 2017	STAGE 1 SSDA
02	JUNE 2018	AMENDING STAGE 1 SSDA
03	JANUARY 2019	AMENDING STAGE 1 SSDA UPDATE FOR DPE

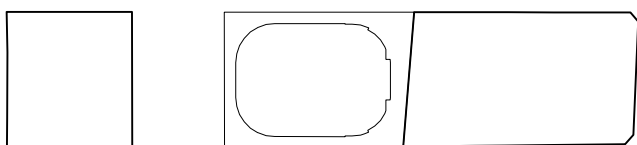

HEAD DESIGN CONSULTANT
GRIMSHAW

GRIMSHAW
LEVEL 3, 24 HICKSON ROAD, SYDNEY
NEW SOUTH WALES 2000 AUSTRALIA
TELEPHONE +61 2 9253 0200
WWW.GRIMSHAW.GLOBAL

NORTH TOWER PRINCIPAL
JPW
JOHNSON PILTON WALKER


JOHNSON PILTON WALKER PTY LTD ACN 095 778 886
LEVEL 10 PLAZA BUILDING AUSTRALIA SQUARE
36 PITT STREET SYDNEY
NEW SOUTH WALES 2000 AUSTRALIA
TELEPHONE +61 2 9259 5800
FACSIMILE +61 2 9259 5899
EMAIL JPW@JPW.COM.AU

HEAD ENGINEERING CONSULTANT
ARUP

ARUP
10/201 HENT STREET, SYDNEY 2000
TEL +61 2 9220 9200
EMAIL: SYDNEY@ARUP.COM

PROJECT
**SYDNEY METRO MARTIN PLACE STATION
MACQUARIE'S UNSOLICITED PROPOSAL**

CLIENT
MACQUARIE GROUP LTD

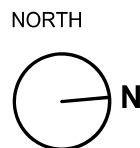

SCALE
1:500 @ A1
DO NOT SCALE FROM DRAWING. USE MARKED DIMENSIONS TO BE READ IN CONJUNCTION WITH ALL OTHER CONSULTANT'S DRAWINGS.


STATUS
**APPROVED SSD ENVELOPE
(SSD 17_8351 AND 18_9347)**

DRAWING
**ROOF PLAN
ENVELOPE DRAWINGS**


DRAWN CHECKED AUTHORISED
KY MC AC

DRAWING NUMBER REVISION
MPS_COA_000_XX_DR_A_DA1009_03

SWEETENED

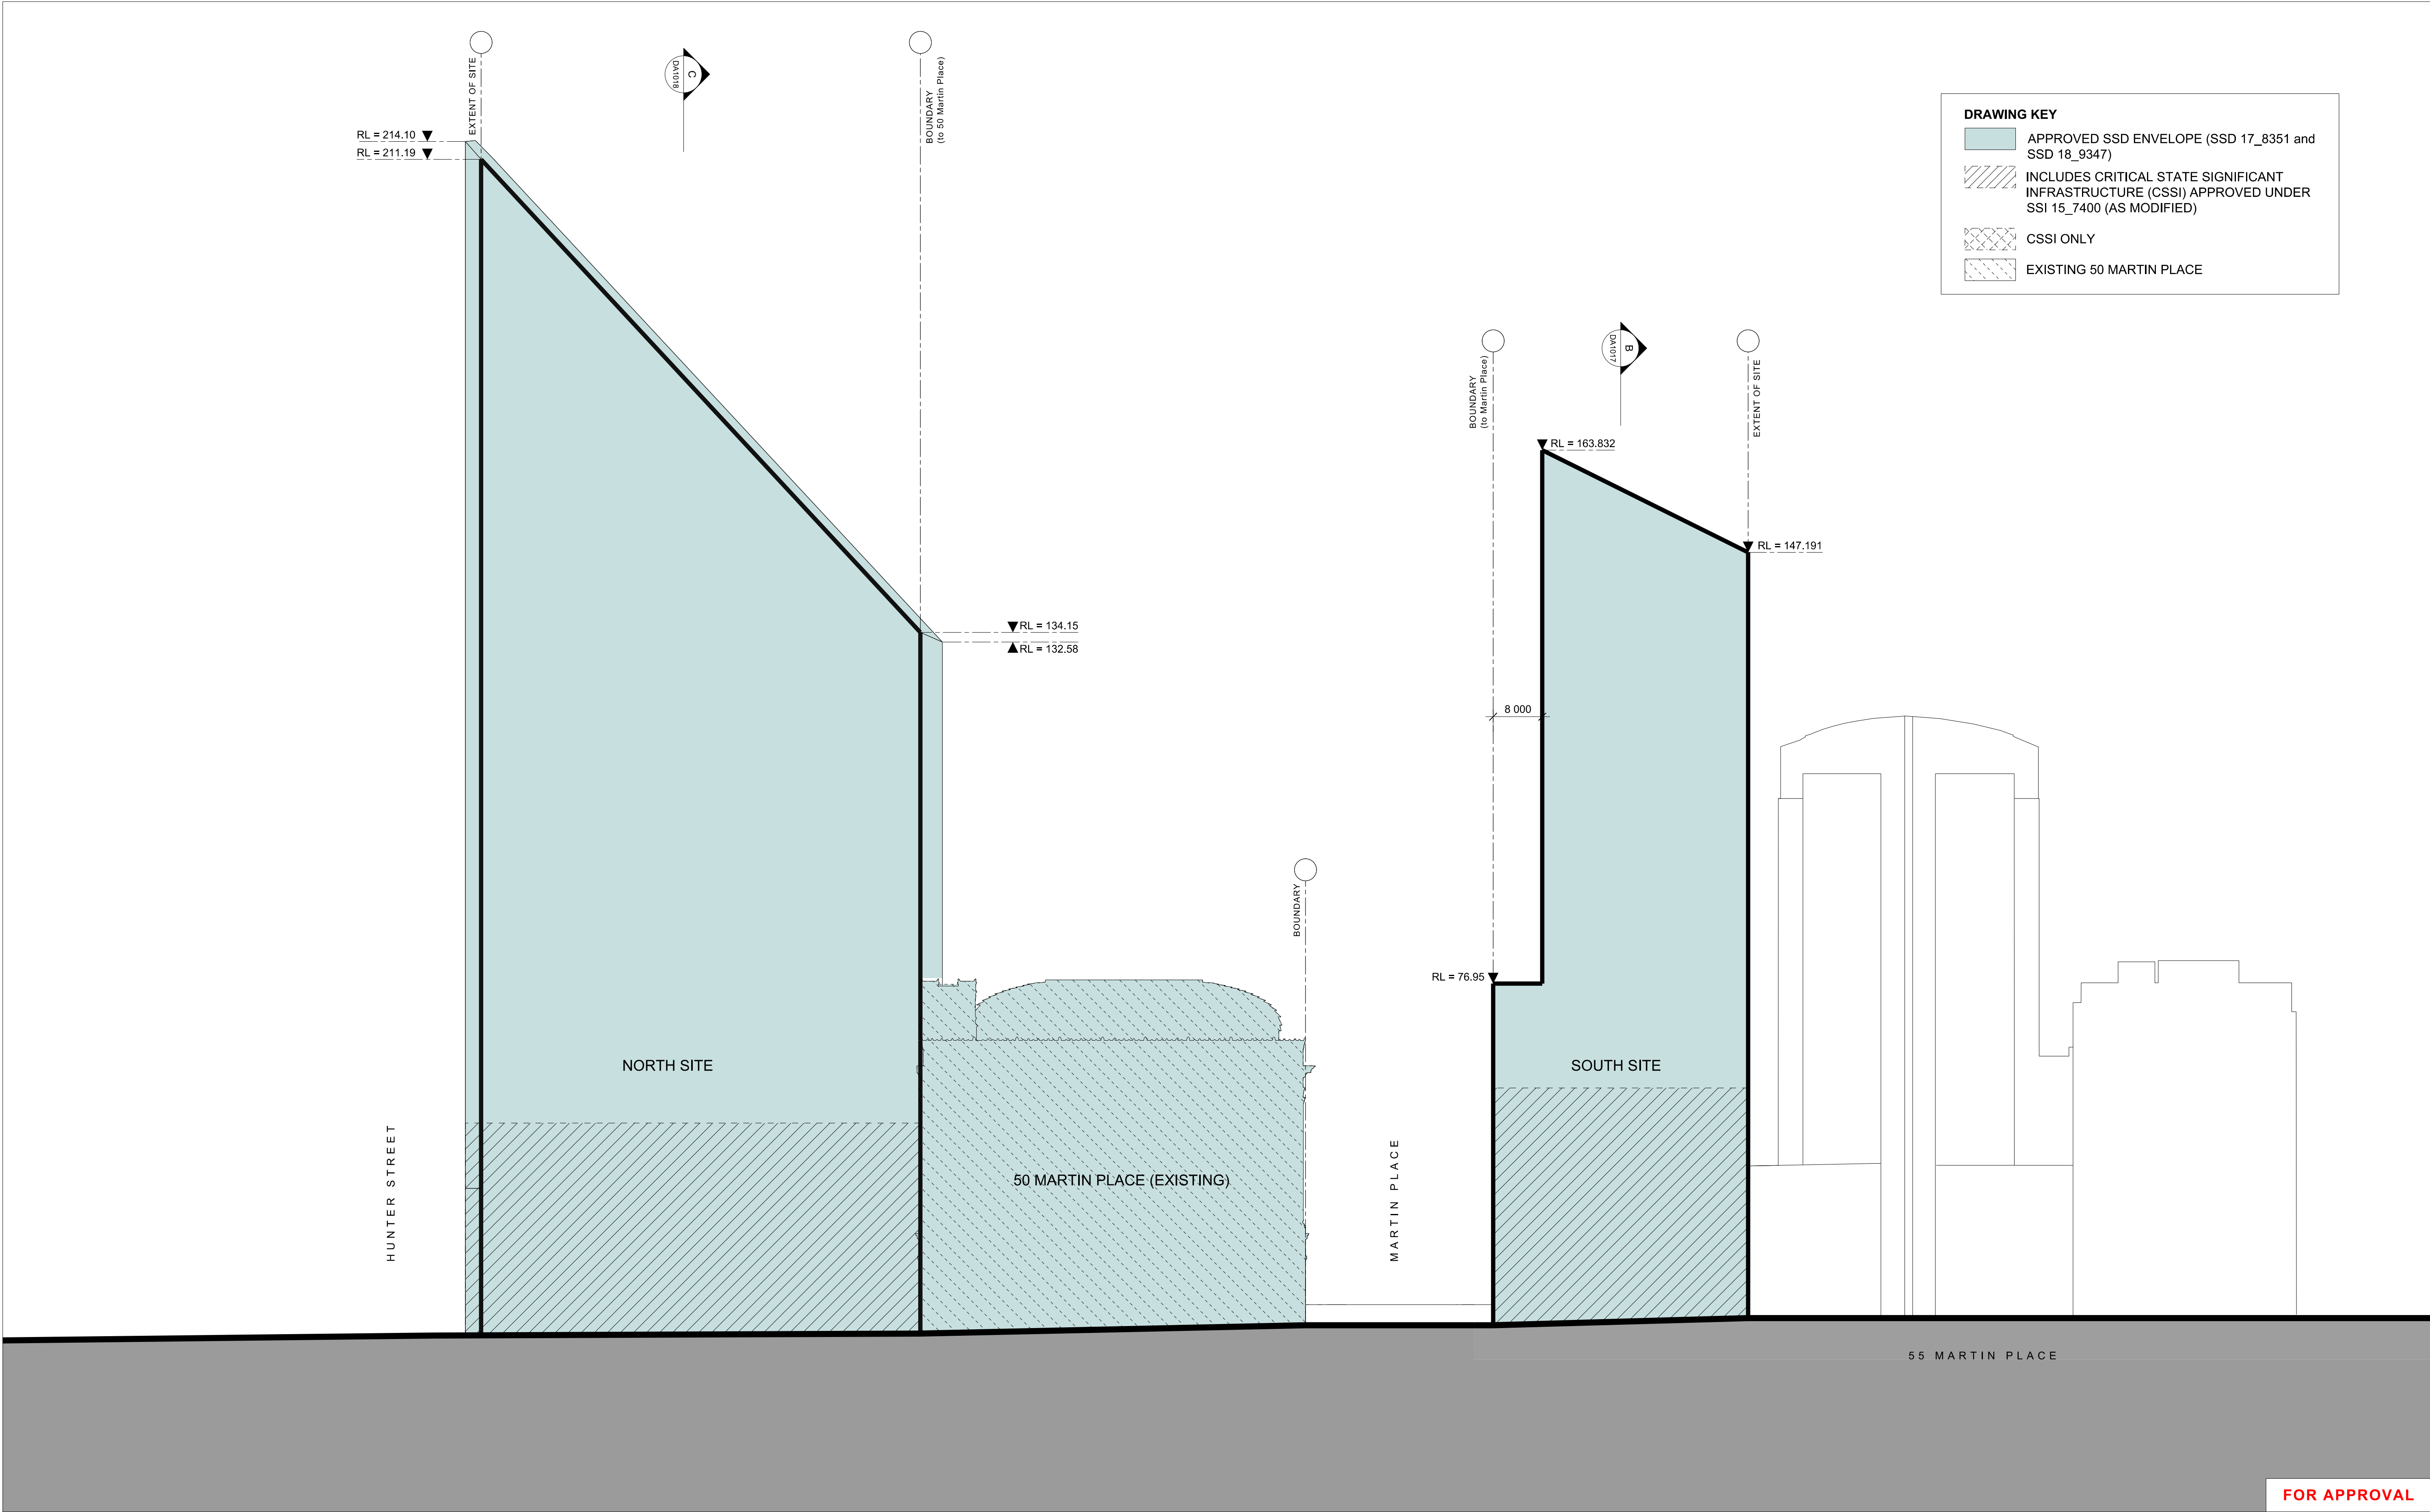

<p>© COPYRIGHT GRIMSHAW ARCHITECTS PTY LIMITED. UNLESS OTHERWISE AGREED IN WRITING, ALL RIGHTS TO USE THIS DOCUMENT ARE SUBJECT TO PAYMENT IN FULL OF ALL GRIMSHAW CHARGES. THIS DOCUMENT MAY ONLY BE USED FOR THE EXPRESS PURPOSE AND PROJECT FOR WHICH IT HAS BEEN CREATED AND DELIVERED. AS NOTIFIED IN WRITING BY GRIMSHAW. AND THIS DOCUMENT MAY NOT BE OTHERWISE USED, OR COPIED, ANY UNAUTHORISED USE OF THIS DOCUMENT IS AT THE USER'S SOLE RISK AND WITHOUT LIMITING GRIMSHAW'S RIGHTS THE USER RELEASES AND INDEMNIFIES GRIMSHAW FROM AND AGAINST ALL LOSS SO ARISING</p>			<table><tr><th>REV.</th><th>DATE</th><th>FOR</th></tr><tr><td>01</td><td>MAY 2017</td><td>STAGE 1 SSDA</td></tr><tr><td>02</td><td>JUNE 2018</td><td>AMENDING STAGE 1 SSDA</td></tr><tr><td>03</td><td>JANUARY 2019</td><td>AMENDING STAGE 1 SSDA UPDATE FOR DPE</td></tr></table>			REV.	DATE	FOR	01	MAY 2017	STAGE 1 SSDA	02	JUNE 2018	AMENDING STAGE 1 SSDA	03	JANUARY 2019	AMENDING STAGE 1 SSDA UPDATE FOR DPE	<div><div></div><div></div><div></div></div>			<p>HEAD DESIGN CONSULTANT</p> <p>GRIMSHAW</p> <p>GRIMSHAW LEVEL 3, 24 HICKSON ROAD, SYDNEY NEW SOUTH WALES 2000 AUSTRALIA TELEPHONE +61 2 9253 0200 WWW.GRIMSHAW.GLOBAL</p>			<p>NORTH TOWER PRINCIPAL</p> <p>JPW JOHNSON PILTON WALKER</p> <p>JOHNSON PILTON WALKER PTY LTD ACN 095 778 886 LEVEL 10 PLAZA BUILDING AUSTRALIA SQUARE 36 PITT STREET SYDNEY NEW SOUTH WALES 2000 AUSTRALIA TELEPHONE +61 2 9259 5800 FACSIMILE +61 2 9259 5889 EMAIL JPW@JPW.COM.AU</p>			<p>HEAD ENGINEERING CONSULTANT</p> <p>ARUP</p> <p>ARUP 10/201 KENT STREET, SYDNEY 2000 TEL +61 2 9220 9200 EMAIL: SYDNEY@ARUP.COM</p>			<p>PROJECT</p> <p>SYDNEY METRO MARTIN PLACE STATION MACQUARIE'S UNSOLICITED PROPOSAL</p> <p>CLIENT</p> <p>MACQUARIE GROUP LTD</p>			<p>NORTH</p> <p>SCALE</p> <p>1:500 @ A1</p> <p>DO NOT SCALE FROM DRAWING. USE MARKED DIMENSIONS TO BE READ IN CONJUNCTION WITH ALL OTHER CONSULTANT'S DRAWINGS.</p> <p>STATUS</p> <p>APPROVED SSD ENVELOPE (SSD 17_8351 AND 18_9347)</p>			<p>DRAWING</p> <p>WEST ELEVATION ENVELOPE DRAWINGS</p> <p>DRAWN CHECKED AUTHORISED</p> <p>KY MC AC</p> <p>DRAWING NUMBER</p> <p>MPS_COA_000_XX_DR_A_DA1011_03</p> <p>REVISION</p>		
REV.	DATE	FOR																																				
01	MAY 2017	STAGE 1 SSDA																																				
02	JUNE 2018	AMENDING STAGE 1 SSDA																																				
03	JANUARY 2019	AMENDING STAGE 1 SSDA UPDATE FOR DPE																																				

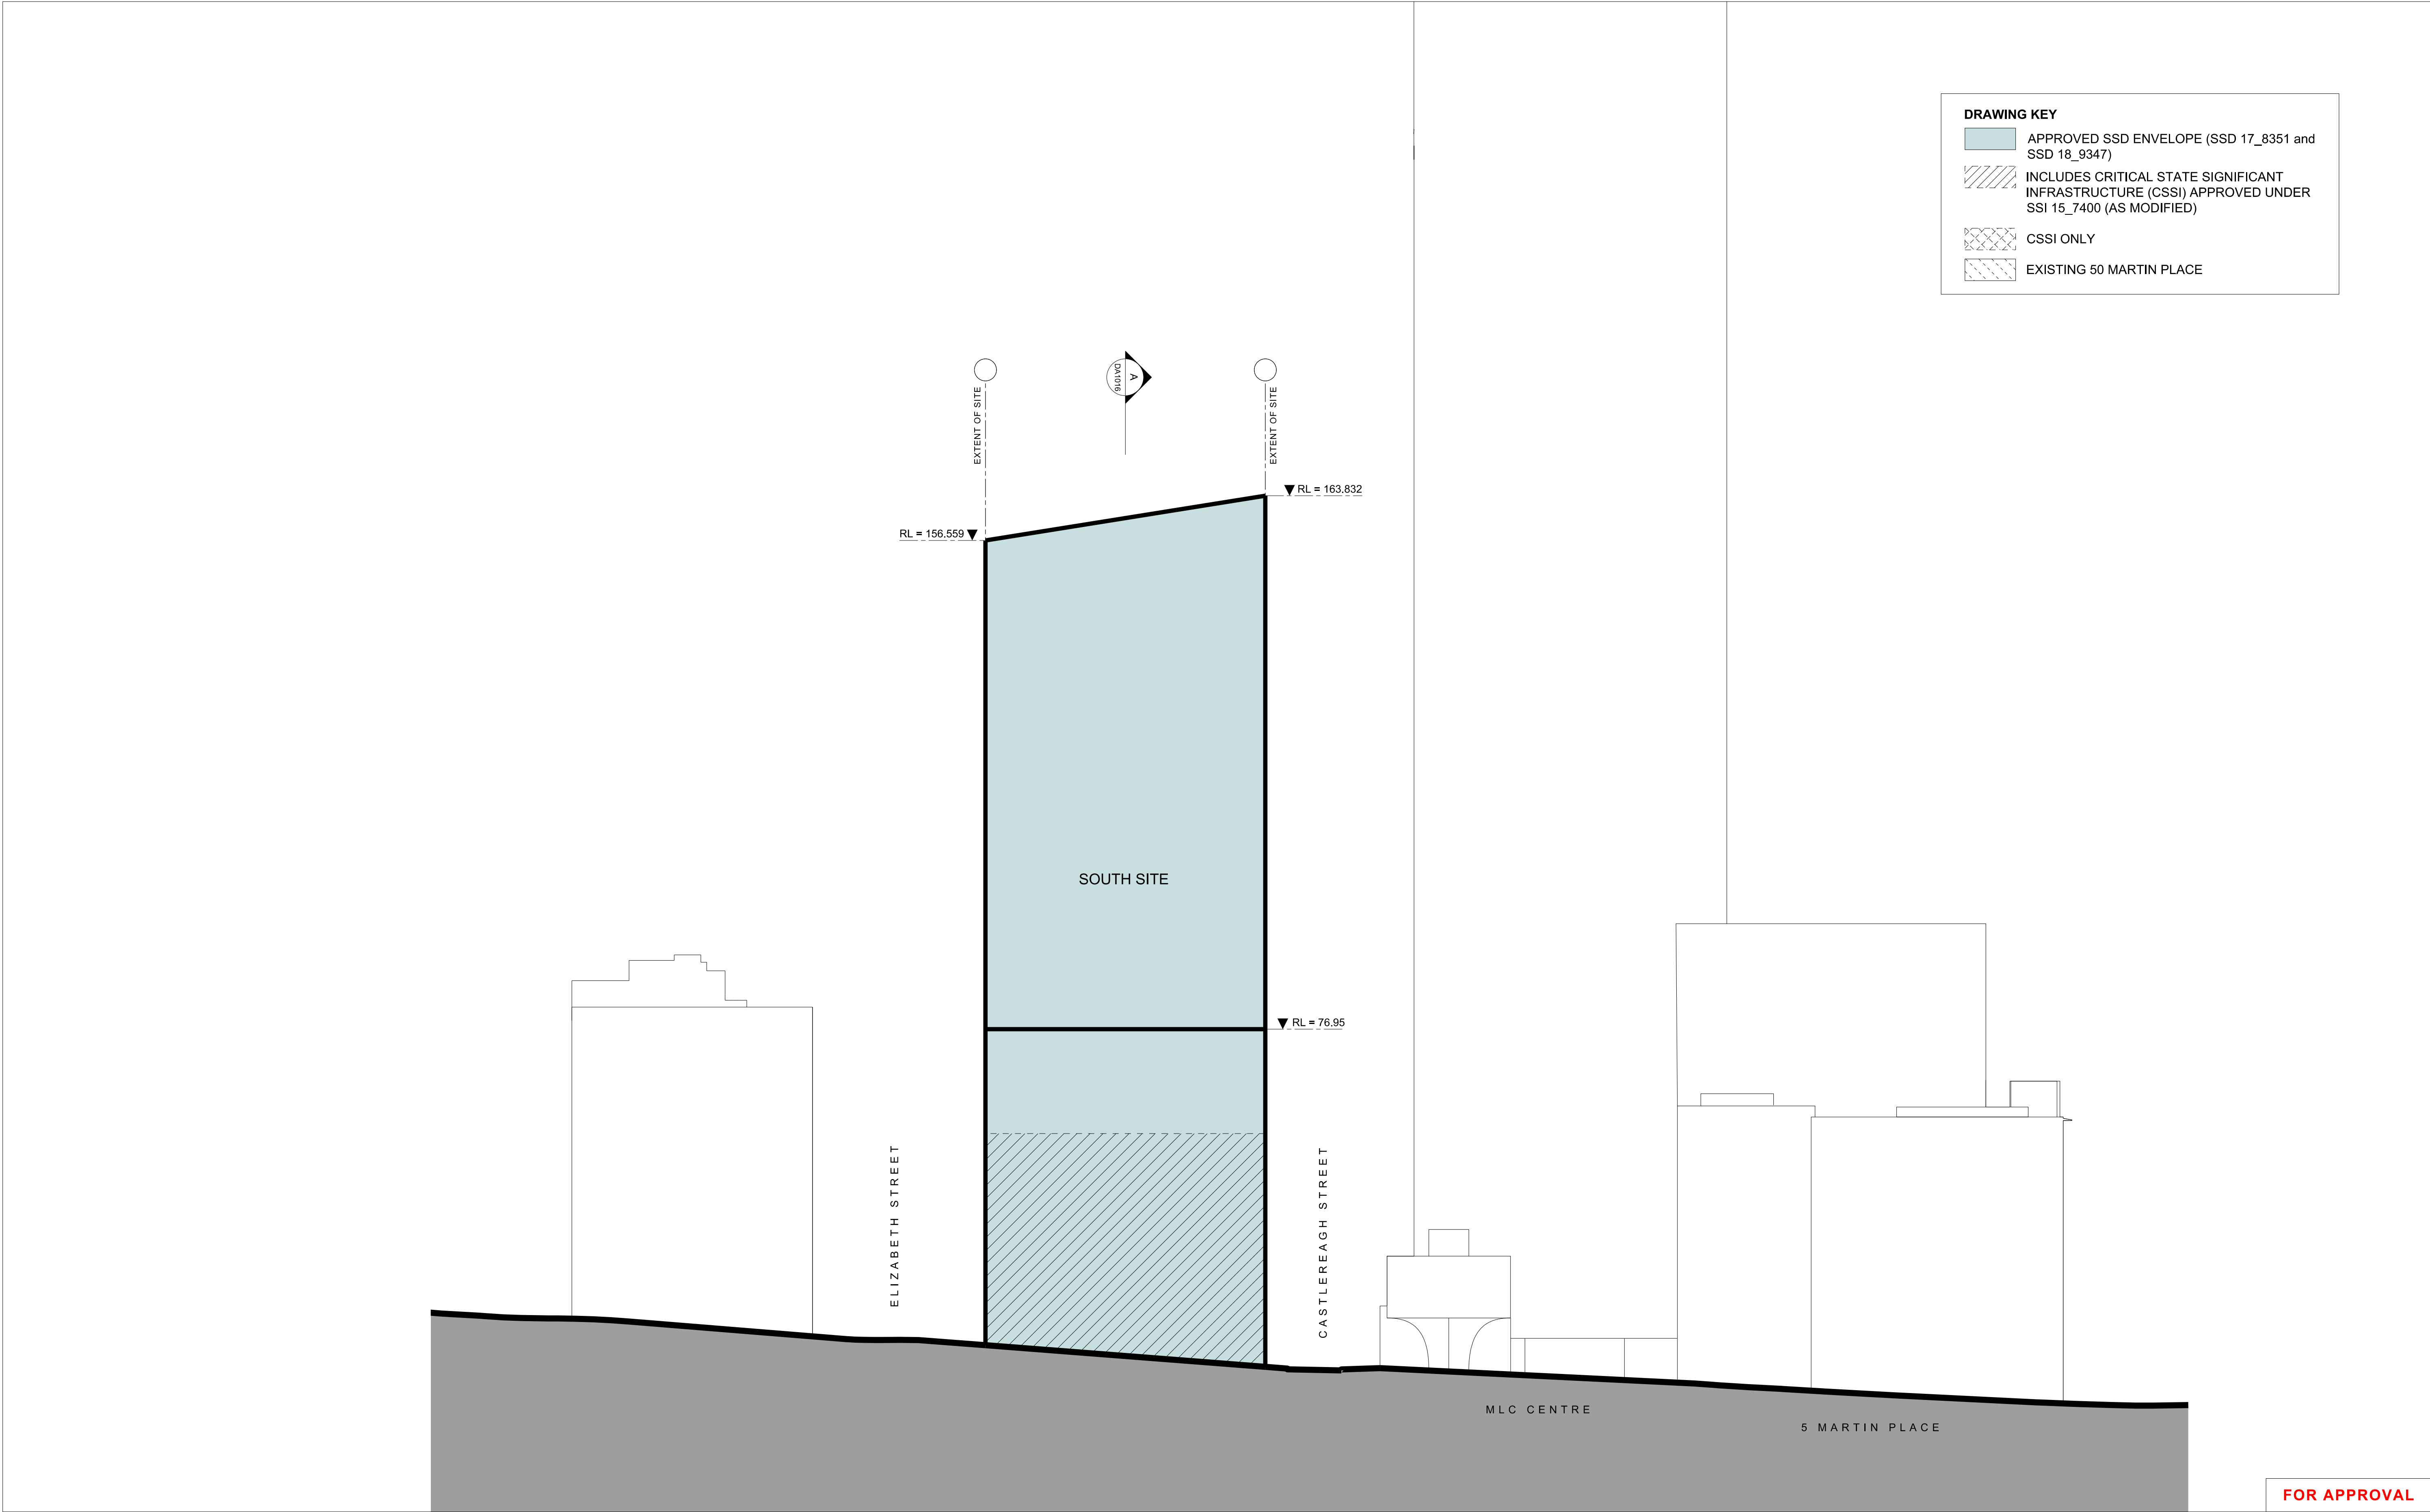


<p>© COPYRIGHT GRIMSHAW ARCHITECTS PTY LIMITED. UNLESS OTHERWISE AGREED IN WRITING, ALL RIGHTS TO USE THIS DOCUMENT ARE SUBJECT TO PAYMENT IN FULL OF ALL GRIMSHAW CHARGES. THIS DOCUMENT MAY ONLY BE USED FOR THE EXPRESS PURPOSE AND PROJECT FOR WHICH IT HAS BEEN CREATED AND DELIVERED. AS NOTIFIED IN WRITING BY GRIMSHAW. AND THIS DOCUMENT MAY NOT BE OTHERWISE USED, OR COPIED, ANY UNAUTHORISED USE OF THIS DOCUMENT IS AT THE USER'S SOLE RISK AND WITHOUT LIMITING GRIMSHAW'S RIGHTS THE USER RELEASES AND INDEMNIFIES GRIMSHAW FROM AND AGAINST ALL LOSS SO ARISING</p>			<table><tr><th>REV.</th><th>DATE</th><th>FOR</th></tr><tr><td>01</td><td>MAY 2017</td><td>STAGE 1 SSDA</td></tr><tr><td>02</td><td>JUNE 2018</td><td>AMENDING STAGE 1 SSDA</td></tr><tr><td>03</td><td>JANUARY 2019</td><td>AMENDING STAGE 1 SSDA UPDATE FOR DPE</td></tr></table>			REV.	DATE	FOR	01	MAY 2017	STAGE 1 SSDA	02	JUNE 2018	AMENDING STAGE 1 SSDA	03	JANUARY 2019	AMENDING STAGE 1 SSDA UPDATE FOR DPE	<div><div></div><div></div></div>			<p>HEAD DESIGN CONSULTANT</p> <p>GRIMSHAW</p> <p>GRIMSHAW LEVEL 3, 24 HICKSON ROAD, SYDNEY NEW SOUTH WALES 2000 AUSTRALIA TELEPHONE +61 2 9253 0200 WWW.GRIMSHAW.GLOBAL</p>			<p>NORTH TOWER PRINCIPAL</p> <p>JPW JOHNSON PILTON WALKER</p> <p>JOHNSON PILTON WALKER PTY LTD ACN 095 778 886 LEVEL 10 PLAZA BUILDING AUSTRALIA SQUARE 35 PITT STREET SYDNEY NEW SOUTH WALES 2000 AUSTRALIA TELEPHONE +61 2 9259 5800 FACSIMILE +61 2 9259 5889 EMAIL JPW@JPW.COM.AU</p>			<p>HEAD ENGINEERING CONSULTANT</p> <p>ARUP</p> <p>ARUP 10/201 KENT STREET, SYDNEY 2000 TEL +61 2 9220 9200 EMAIL: SYDNEY@ARUP.COM</p>			<p>PROJECT</p> <p>SYDNEY METRO MARTIN PLACE STATION MACQUARIE'S UNSOLICITED PROPOSAL</p> <p>CLIENT</p> <p>MACQUARIE GROUP LTD</p>			<p>NORTH</p> <p>SCALE</p> <p>1:500 @ A1</p> <p>DO NOT SCALE FROM DRAWING. USE MARKED DIMENSIONS TO BE READ IN CONJUNCTION WITH ALL OTHER CONSULTANT'S DRAWINGS.</p> <p>STATUS</p> <p>APPROVED SSD ENVELOPE (SSD 17_8351 AND 18_9347)</p>			<p>DRAWING</p> <p>NORTH ELEVATION (MARTIN PLACE) ENVELOPE DRAWINGS</p> <table><tr><th>DRAWN</th><th>CHECKED</th><th>AUTHORISED</th></tr><tr><td>KY</td><td>MC</td><td>AC</td></tr></table> <p>DRAWING NUMBER</p> <p>MPS_COA_000_XX_DR_A_DA1012_03</p> <p>REVISION</p>			DRAWN	CHECKED	AUTHORISED	KY	MC	AC
REV.	DATE	FOR																																										
01	MAY 2017	STAGE 1 SSDA																																										
02	JUNE 2018	AMENDING STAGE 1 SSDA																																										
03	JANUARY 2019	AMENDING STAGE 1 SSDA UPDATE FOR DPE																																										
DRAWN	CHECKED	AUTHORISED																																										
KY	MC	AC																																										

NORTH ELEVATION (HUNTER STREET)

© COPYRIGHT GRIMSHAW ARCHITECTS PTY LIMITED. UNLESS OTHERWISE AGREED IN WRITING, ALL RIGHTS TO USE THIS DOCUMENT ARE SUBJECT TO PAYMENT IN FULL OF ALL GRIMSHAW CHARGES. THIS DOCUMENT MAY ONLY BE USED FOR THE EXPRESS PURPOSE AND PROJECT FOR WHICH IT HAS BEEN CREATED AND DELIVERED. AS NOTIFIED IN WRITING BY GRIMSHAW. AND THIS DOCUMENT MAY NOT BE OTHERWISE USED, OR COPIED, ANY UNAUTHORISED USE OF THIS DOCUMENT IS AT THE USER'S SOLE RISK AND WITHOUT LIMITING GRIMSHAW'S RIGHTS THE USER RELEASES AND INDEMNIFIES GRIMSHAW FROM AND AGAINST ALL LOSS SO ARISING

SSHE17MPS08

REV.	DATE	FOR
01	MAY 2017	STAGE 1 SSDA
02	JUNE 2018	AMENDING STAGE 1 SSDA
03	JANUARY 2019	AMENDING STAGE 1 SSDA UPDATE FOR DPE

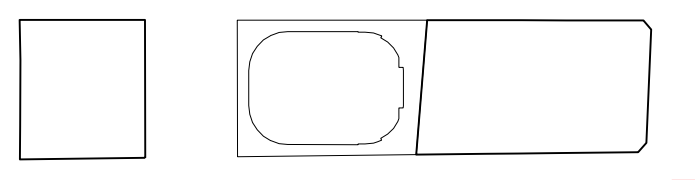

HEAD DESIGN CONSULTANT
GRIMSHAW

GRIMSHAW
LEVEL 3, 24 HICKSON ROAD, SYDNEY
NEW SOUTH WALES 2000 AUSTRALIA
TELEPHONE +61 2 9253 0200
WWW.GRIMSHAW.GLOBAL

NORTH TOWER PRINCIPAL
**JPW
JOHNSON PILTON WALKER**

JOHNSON PILTON WALKER PTY LTD ACN 095 778 886
LEVEL 10 PLAZA BUILDING AUSTRALIA SQUARE
35 PITT STREET SYDNEY
NEW SOUTH WALES 2000 AUSTRALIA
TELEPHONE +61 2 9259 5800
FACSIMILE +61 2 9259 5889
EMAIL JPW@JPW.COM.AU

HEAD ENGINEERING CONSULTANT
ARUP

ARUP
10/201 HENT STREET, SYDNEY 2000
TEL +61 2 9220 9200
EMAIL: SYDNEY@ARUP.COM

PROJECT
**SYDNEY METRO MARTIN PLACE STATION
MACQUARIE'S UNSOLICITED PROPOSAL**

CLIENT
MACQUARIE GROUP LTD

NORTH

SCALE
1:500 @ A1
DO NOT SCALE FROM DRAWING. USE MARKED DIMENSIONS TO BE READ IN CONJUNCTION WITH ALL OTHER CONSULTANT'S DRAWINGS.

STATUS
**APPROVED SSD ENVELOPE
(SSD 17_8351 AND 18_9347)**

DRAWING
**NORTH ELEVATION (HUNTER STREET)
ENVELOPE DRAWINGS**

DRAWN	CHECKED	AUTHORISED
KY	MC	AC

DRAWING NUMBER	REVISION
MPS_COA_000_XX_DR_A_DA1013_03	

DRAWING KEY

- APPROVED SSD ENVELOPE (SSD 17_8351 and SSD 18_9347)
- INCLUDES CRITICAL STATE SIGNIFICANT INFRASTRUCTURE (CSSI) APPROVED UNDER SSI 15_7400 (AS MODIFIED)
- CSSI ONLY
- EXISTING 50 MARTIN PLACE

ELIZABETH STREET

CASTLEREAGH STREET

NORTH SITE

CHIFLEY SQUARE


FOR APPROVAL

SOUTHERLY (SOUTH) SITE

© GRIMSHAW ARCHITECTS PTY LIMITED. ALL RIGHTS TO USE THIS DOCUMENT ARE SUBJECT TO PAYMENT IN FULL OF ALL GRIMSHAW CHARGES. THIS DOCUMENT MAY ONLY BE USED FOR THE EXPRESS PURPOSE AND PROJECT FOR WHICH IT HAS BEEN CREATED AND DELIVERED. AS NOTIFIED IN WRITING BY GRIMSHAW. AND THIS DOCUMENT MAY NOT BE OTHERWISE USED, OR COPIED. ANY UNAUTHORISED USE OF THIS DOCUMENT IS AT THE USER'S SOLE RISK AND WITHOUT LIMITING GRIMSHAW'S RIGHTS THE USER RELEASES AND INDEMNIFIES GRIMSHAW FROM AND AGAINST ALL LOSS SO ARISING

SSHE17MPS08

REV.	DATE	FOR
01	MAY 2017	STAGE 1 SSDA
02	JUNE 2018	AMENDING STAGE 1 SSDA
03	JANUARY 2019	AMENDING STAGE 1 SSDA UPDATE FOR DPE

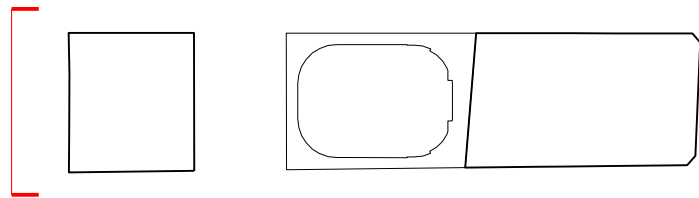

HEAD DESIGN CONSULTANT
GRIMSHAW

GRIMSHAW
LEVEL 3, 24 HICKSON ROAD, SYDNEY
NEW SOUTH WALES 2000 AUSTRALIA
TELEPHONE +61 2 9253 0200
WWW.GRIMSHAW.GLOBAL

NORTH TOWER PRINCIPAL

JPW
JOHNSON PILTON WALKER

JOHNSON PILTON WALKER PTY LTD ACN 095 778 886
LEVEL 10 PLAZA BUILDING AUSTRALIA SQUARE
35 PITT STREET SYDNEY
NEW SOUTH WALES 2000 AUSTRALIA
TELEPHONE +61 2 9259 5800
FACSIMILE +61 2 9259 5889
EMAIL JPW@JPW.COM.AU

HEAD ENGINEERING CONSULTANT

ARUP

ARUP
10/201 HENT STREET, SYDNEY 2000
TEL +61 2 9220 9200
EMAIL: SYDNEY@ARUP.COM

PROJECT

**SYDNEY METRO MARTIN PLACE STATION
MACQUARIE'S UNSOLICITED PROPOSAL**

CLIENT

MACQUARIE GROUP LTD

NORTH

SCALE
1:500 @ A1

DO NOT SCALE FROM DRAWING. USE MARKED
DIMENSIONS TO BE READ IN CONJUNCTION WITH
ALL OTHER CONSULTANT'S DRAWINGS.

STATUS

**APPROVED SSD ENVELOPE
(SSD 17_8351 AND 18_9347)**

DRAWING

**SOUTH ELEVATION (SOUTH SITE)
ENVELOPE DRAWINGS**

DRAWN	CHECKED	AUTHORISED
KY	MC	AC

DRAWING NUMBER


MPS_COA_000_XX_DR_A_DA1014_03

REVISION


DRAWING KEY

- APPROVED SSD ENVELOPE (SSD 17_8351 and SSD 18_9347)
- INCLUDES CRITICAL STATE SIGNIFICANT INFRASTRUCTURE (CSSI) APPROVED UNDER SSI 15_7400 (AS MODIFIED)
- CSSI ONLY
- EXISTING 50 MARTIN PLACE

FOR APPROVAL

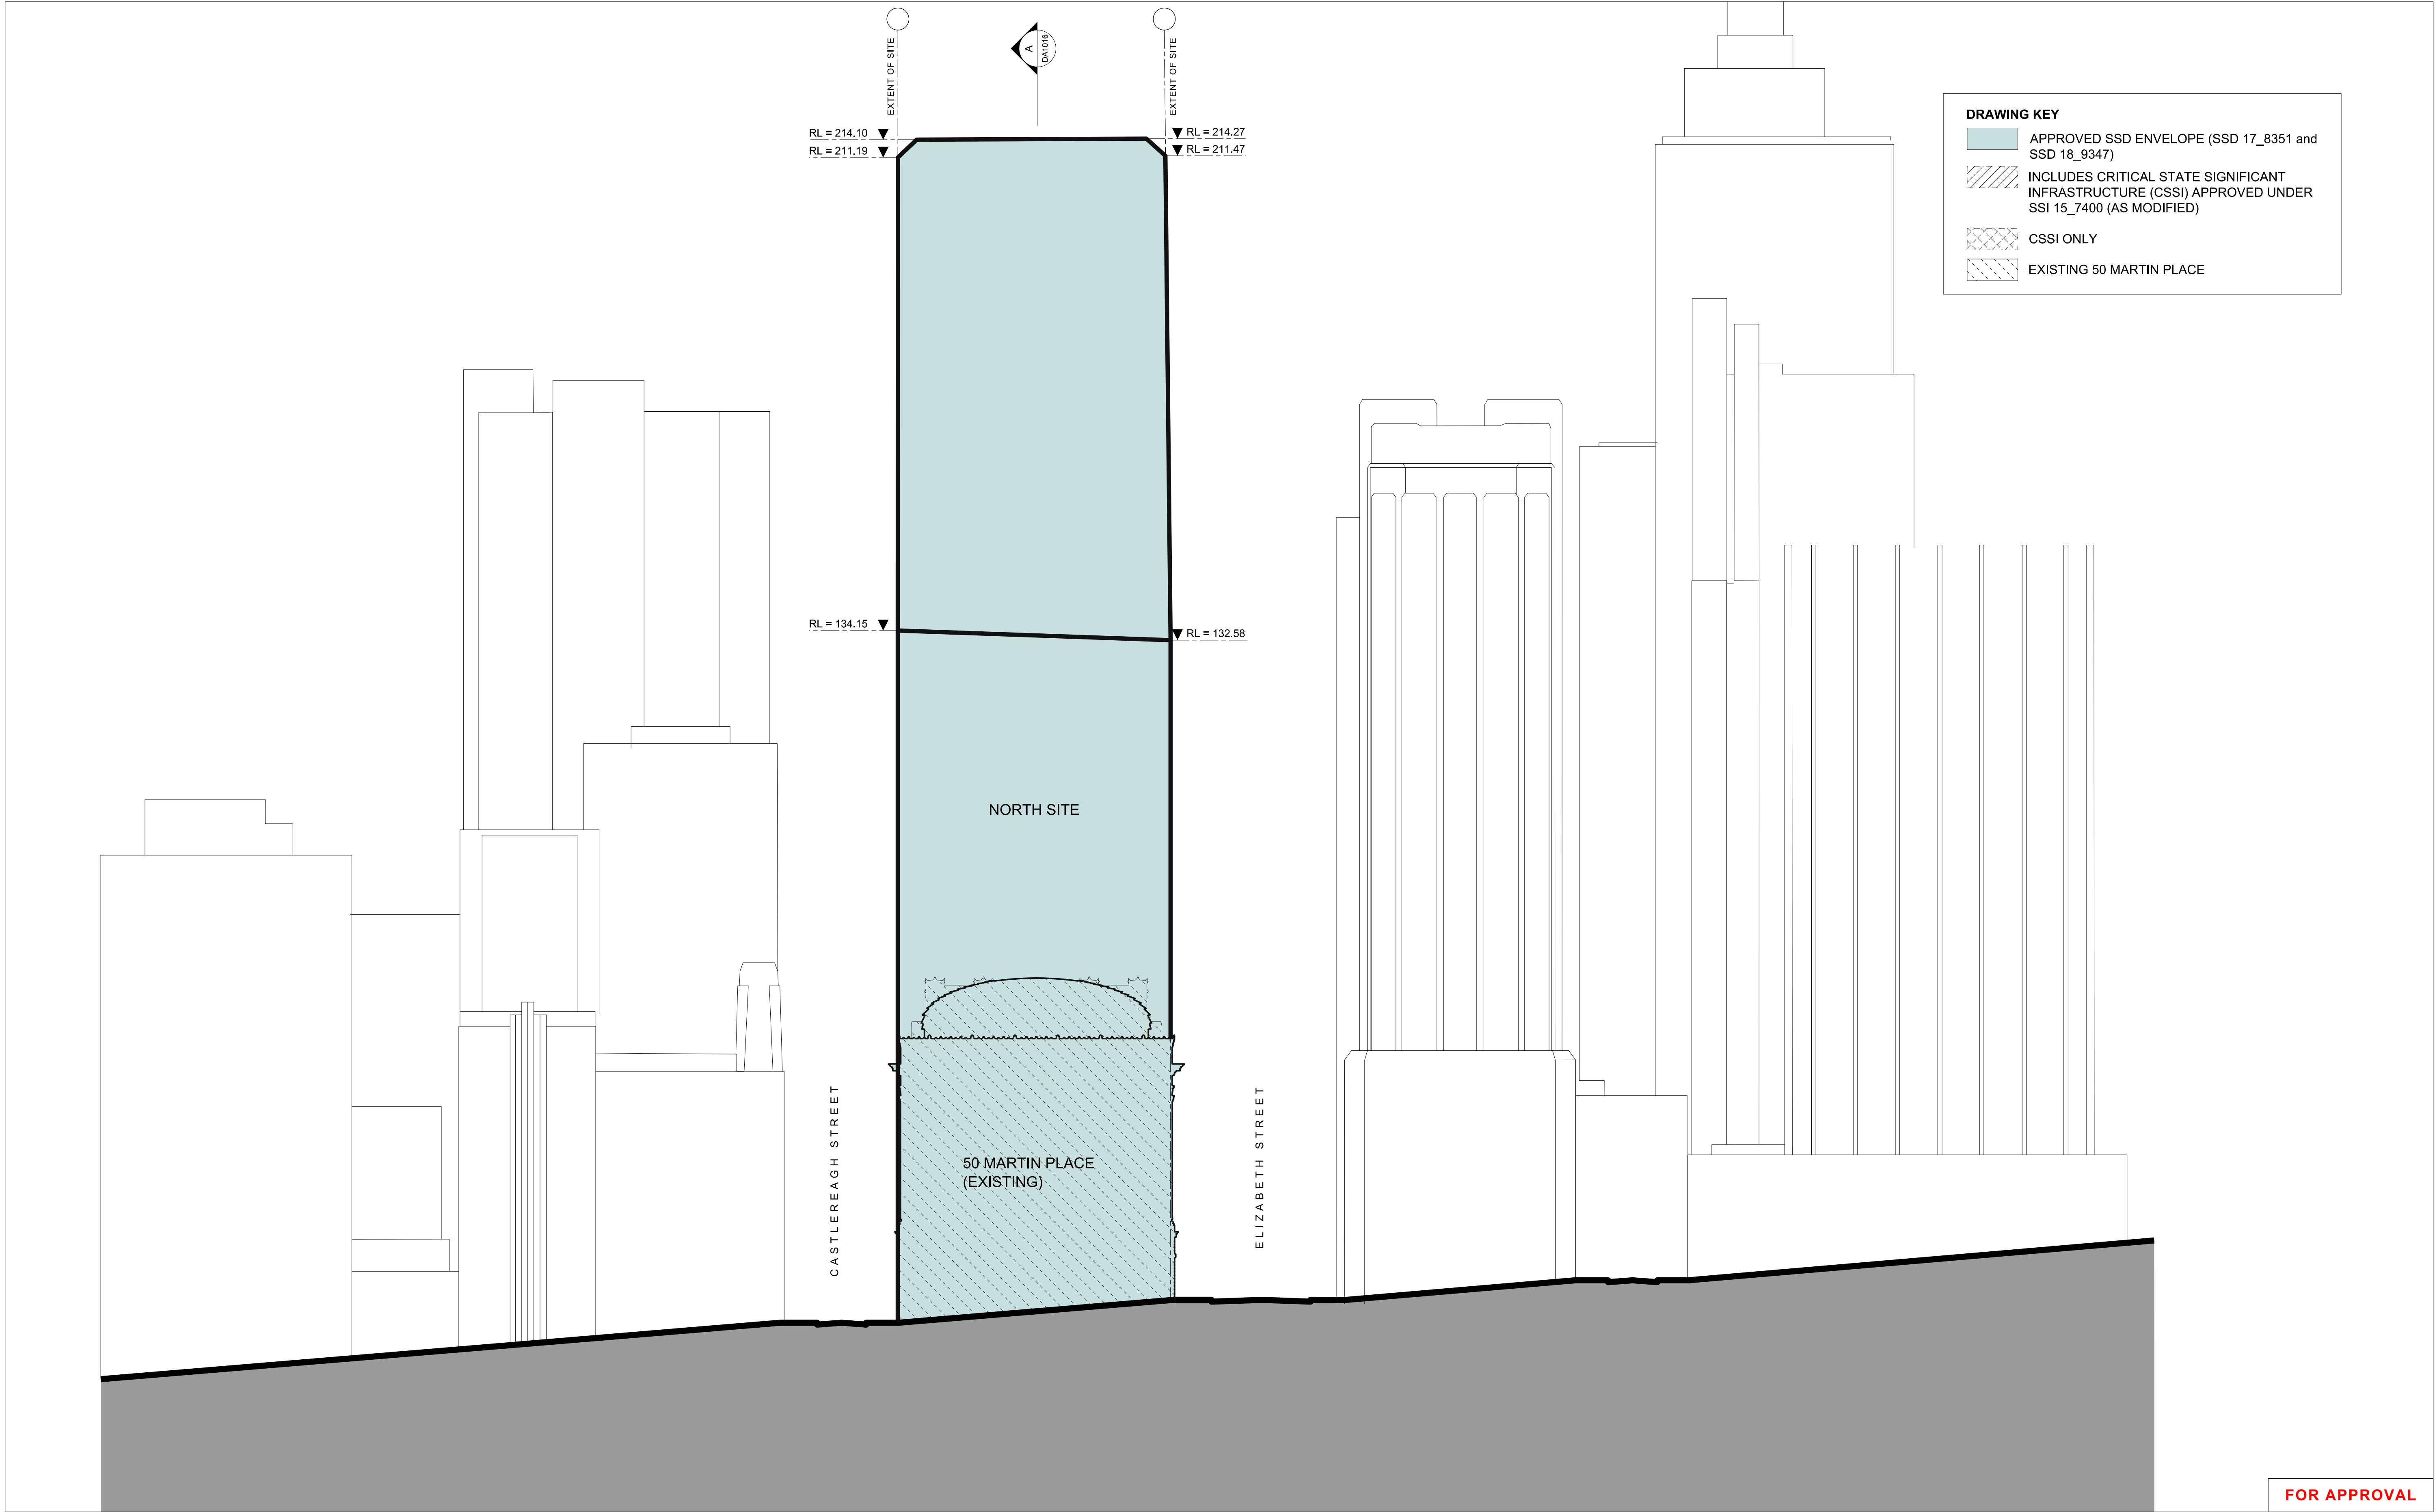


<p>© COPYRIGHT GRIMSHAW ARCHITECTS PTY LIMITED. UNLESS OTHERWISE AGREED IN WRITING, ALL RIGHTS TO USE THIS DOCUMENT ARE SUBJECT TO PAYMENT IN FULL OF ALL GRIMSHAW CHARGES. THIS DOCUMENT MAY ONLY BE USED FOR THE EXPRESS PURPOSE AND PROJECT FOR WHICH IT HAS BEEN CREATED AND DELIVERED. AS NOTIFIED IN WRITING BY GRIMSHAW. AND THIS DOCUMENT MAY NOT BE OTHERWISE USED, OR COPIED. ANY UNAUTHORISED USE OF THIS DOCUMENT IS AT THE USER'S SOLE RISK AND WITHOUT LIMITING GRIMSHAW'S RIGHTS THE USER RELEASES AND INDEMNIFIES GRIMSHAW FROM AND AGAINST ALL LOSS SO ARISING</p>			<p>REV. DATE FOR</p> <table><tr><td>01</td><td>MAY 2017</td><td>STAGE 1 SSDA</td></tr><tr><td>02</td><td>JUNE 2018</td><td>AMENDING STAGE 1 SSDA</td></tr><tr><td>03</td><td>JANUARY 2019</td><td>AMENDING STAGE 1 SSDA UPDATE FOR DPE</td></tr></table>			01	MAY 2017	STAGE 1 SSDA	02	JUNE 2018	AMENDING STAGE 1 SSDA	03	JANUARY 2019	AMENDING STAGE 1 SSDA UPDATE FOR DPE	<div><div></div><div></div></div>			<p>HEAD DESIGN CONSULTANT</p> <p>GRIMSHAW</p> <p>GRIMSHAW LEVEL 3, 24 HICKSON ROAD, SYDNEY NEW SOUTH WALES 2000 AUSTRALIA TELEPHONE +61 2 9253 0200 WWW.GRIMSHAW.GLOBAL</p>			<p>NORTH TOWER PRINCIPAL</p> <p>JPW JOHNSON PILTON WALKER</p> <p>JOHNSON PILTON WALKER PTY LTD ACN 095 778 886 LEVEL 10 PLAZA BUILDING AUSTRALIA SQUARE 25 PITT STREET SYDNEY NEW SOUTH WALES 2000 AUSTRALIA TELEPHONE +61 2 9229 5800 FACSIMILE +61 2 9229 5899 EMAIL JPW@JPW.COM.AU</p>			<p>HEAD ENGINEERING CONSULTANT</p> <p>ARUP</p> <p>ARUP 10/201 KENT STREET, SYDNEY 2000 TEL +61 2 9220 9200 EMAIL: SYDNEY@ARUP.COM</p>			<p>PROJECT</p> <p>SYDNEY METRO MARTIN PLACE STATION MACQUARIE'S UNSOLICITED PROPOSAL</p> <p>CLIENT</p> <p>MACQUARIE GROUP LTD</p>			<p>NORTH</p> <p>SCALE</p> <p>1:500 @ A1</p> <p>DO NOT SCALE FROM DRAWING. USE MARKED DIMENSIONS TO BE READ IN CONJUNCTION WITH ALL OTHER CONSULTANT'S DRAWINGS.</p> <p>STATUS</p> <p>APPROVED SSD ENVELOPE (SSD 17_8351 AND 18_9347)</p>			<p>DRAWING</p> <p>SOUTH ELEVATION (MARTIN PLACE) ENVELOPE DRAWINGS</p> <table><tr><td>DRAWN</td><td>CHECKED</td><td>AUTHORISED</td></tr><tr><td>KY</td><td>MC</td><td>AC</td></tr></table> <p>DRAWING NUMBER</p> <p>MPS_COA_000_XX_DR_A_DA1015_03</p> <p>REVISION</p>			DRAWN	CHECKED	AUTHORISED	KY	MC	AC
01	MAY 2017	STAGE 1 SSDA																																							
02	JUNE 2018	AMENDING STAGE 1 SSDA																																							
03	JANUARY 2019	AMENDING STAGE 1 SSDA UPDATE FOR DPE																																							
DRAWN	CHECKED	AUTHORISED																																							
KY	MC	AC																																							

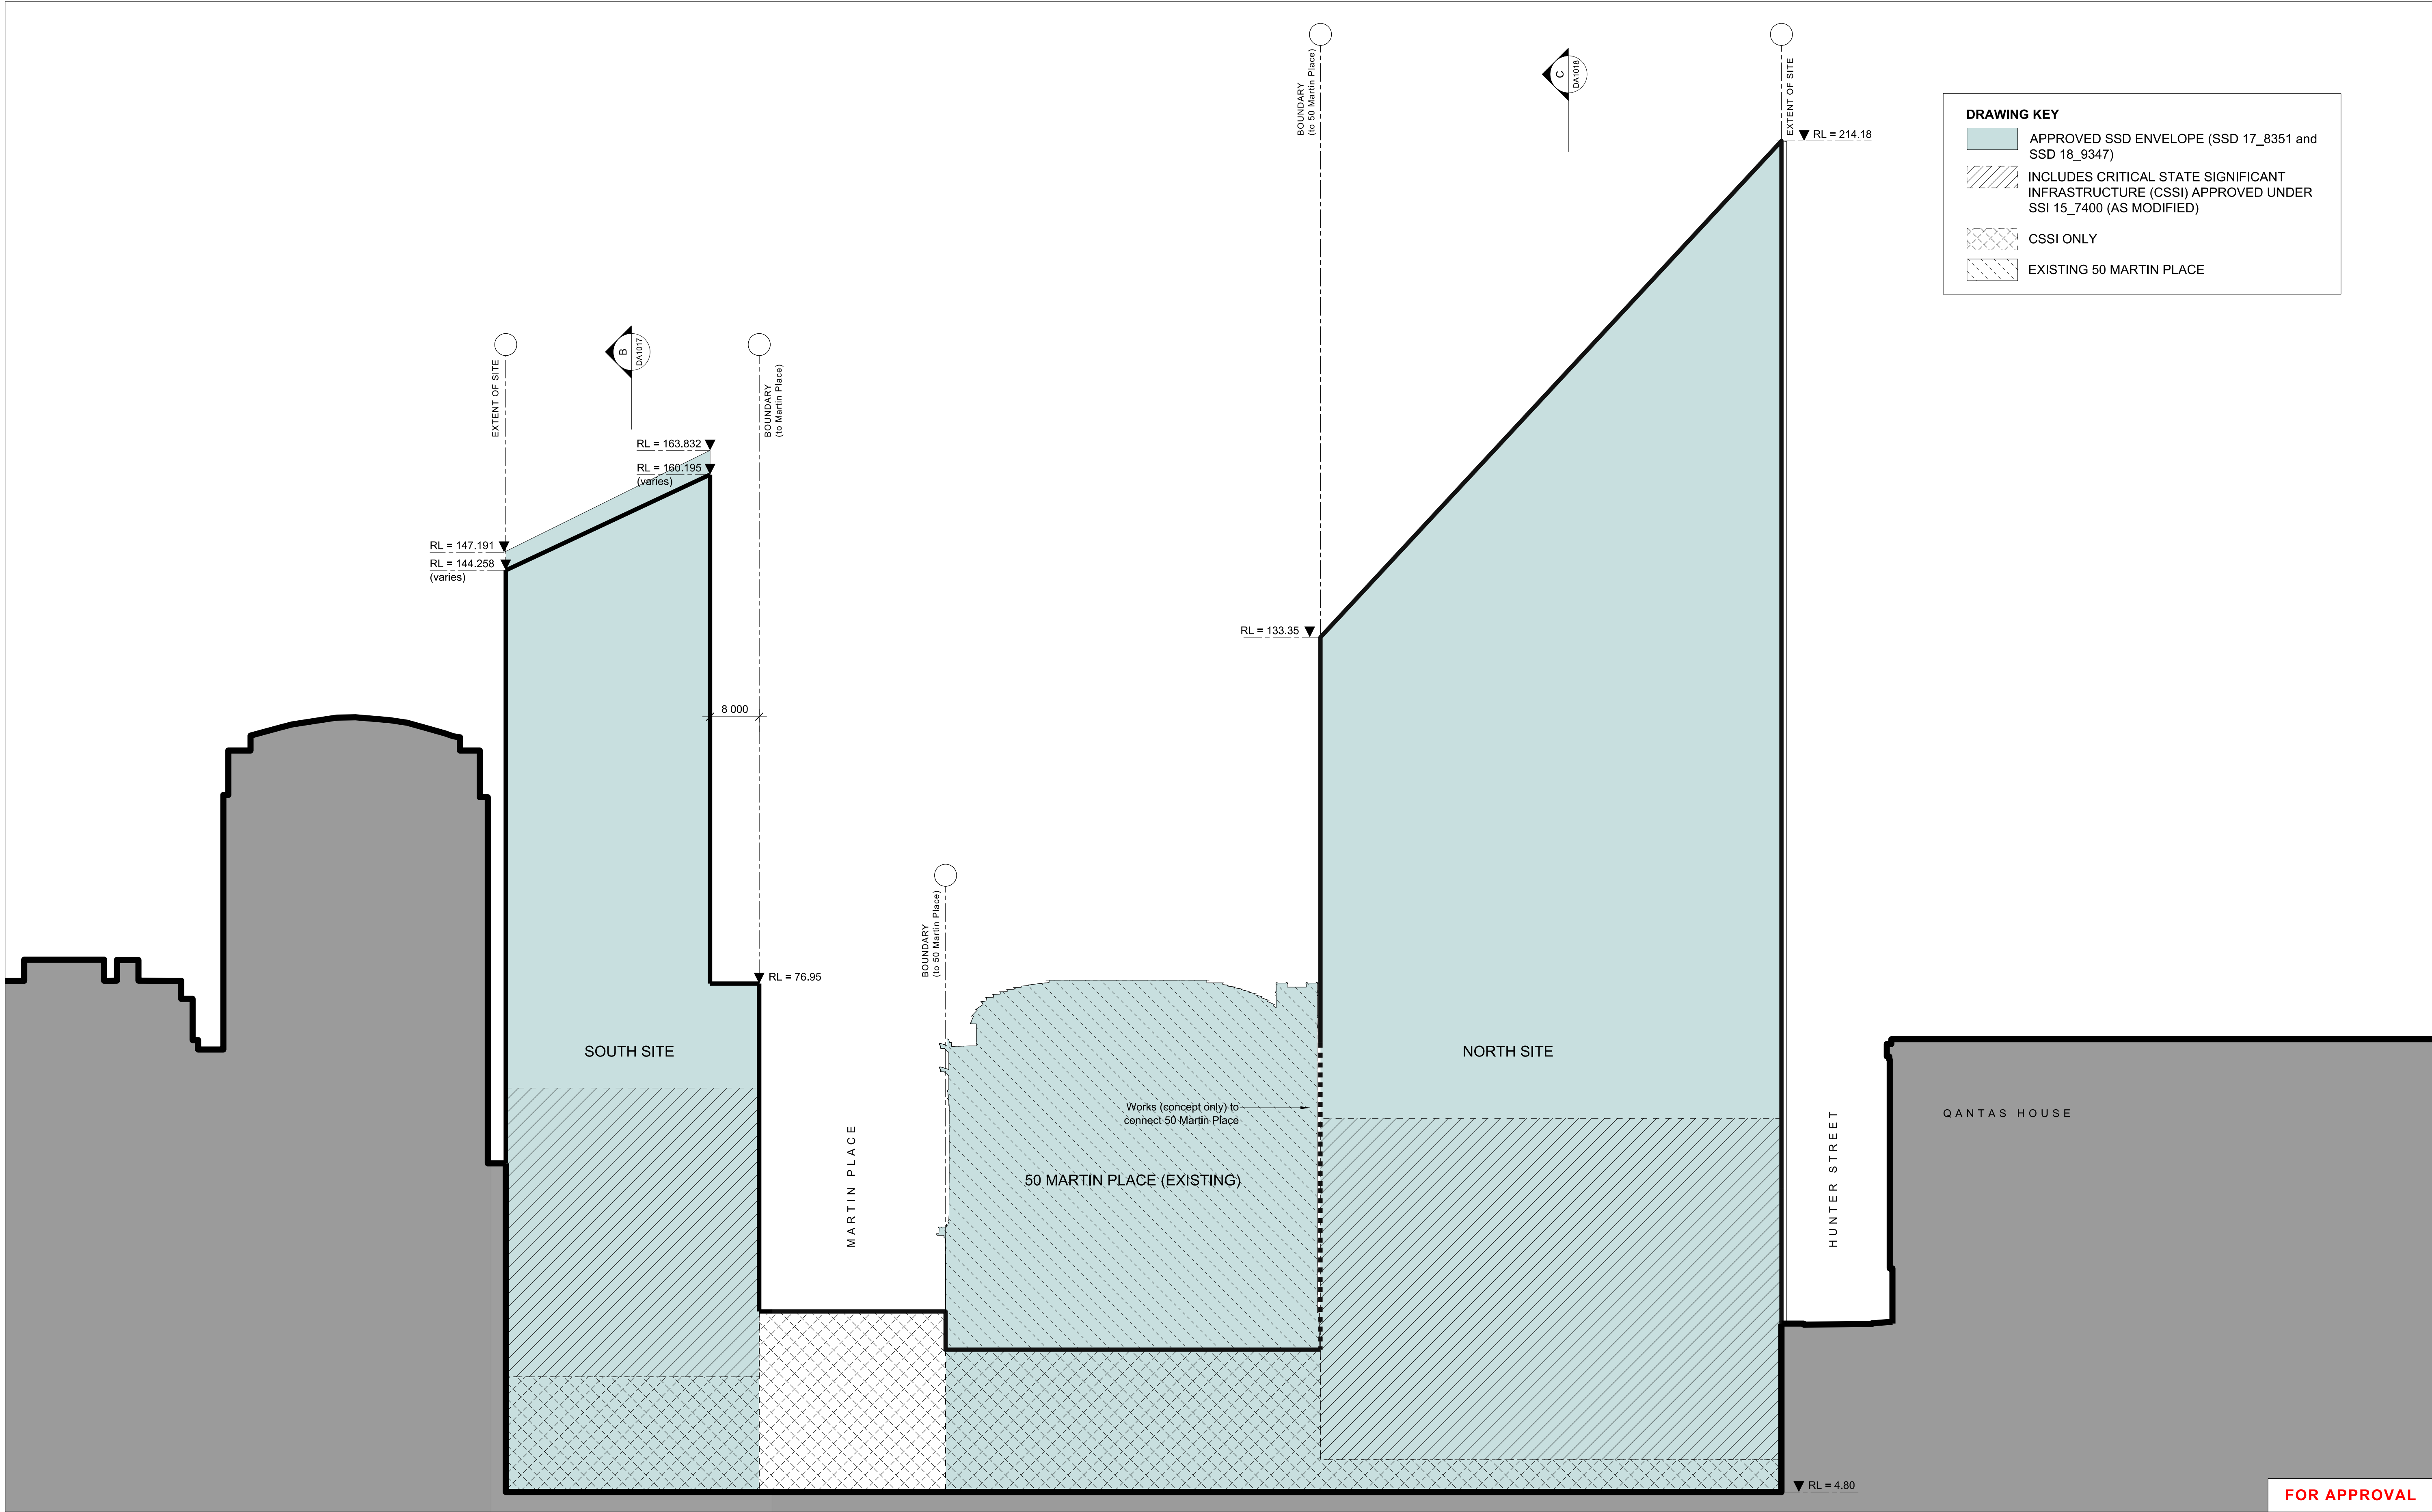

<p>© COPYRIGHT GRIMSHAW ARCHITECTS PTY LIMITED. UNLESS OTHERWISE AGREED IN WRITING, ALL RIGHTS TO USE THIS DOCUMENT ARE SUBJECT TO PAYMENT IN FULL OF ALL GRIMSHAW CHARGES. THIS DOCUMENT MAY ONLY BE USED FOR THE EXPRESS PURPOSE AND PROJECT FOR WHICH IT HAS BEEN CREATED AND DELIVERED. AS NOTIFIED IN WRITING BY GRIMSHAW. AND THIS DOCUMENT MAY NOT BE OTHERWISE USED, OR COPIED. ANY UNAUTHORISED USE OF THIS DOCUMENT IS AT THE USER'S SOLE RISK AND WITHOUT LIMITING GRIMSHAW'S RIGHTS THE USER RELEASES AND INDEMNIFIES GRIMSHAW FROM AND AGAINST ALL LOSS SO ARISING</p>	REV.	DATE	FOR		<p>HEAD DESIGN CONSULTANT</p> <p>GRIMSHAW</p> <p>GRIMSHAW LEVEL 3 24 HICKSON ROAD, SYDNEY NEW SOUTH WALES 2000 AUSTRALIA TELEPHONE +61 2 9253 0200 WWW.GRIMSHAW.GLOBAL</p>	<p>NORTH TOWER PRINCIPAL</p> <p>JPW JOHNSON PILTON WALKER</p> <p>JOHNSON PILTON WALKER PTY LTD ACN 095 778 886 LEVEL 10 PLAZA BUILDING AUSTRALIA SQUARE 55 PITT STREET SYDNEY NEW SOUTH WALES 2000 AUSTRALIA TELEPHONE +61 2 9229 5800 FACSIMILE +61 2 9229 5889 EMAIL JPW@JPW.COM.AU</p>	<p>HEAD ENGINEERING CONSULTANT</p> <p>ARUP</p> <p>ARUP 10/201 HENT STREET, SYDNEY 2000 TEL +61 2 9220 9200 EMAIL: SYDNEY@ARUP.COM</p>	<p>PROJECT</p> <p>SYDNEY METRO MARTIN PLACE STATION MACQUARIE'S UNSOLICITED PROPOSAL</p> <p>CLIENT</p> <p>MACQUARIE GROUP LTD</p>	<p>NORTH</p> <p>SCALE</p> <p>1:500 @ A1</p> <p>DO NOT SCALE FROM DRAWING. USE MARKED DIMENSIONS TO BE READ IN CONJUNCTION WITH ALL OTHER CONSULTANT'S DRAWINGS.</p> <p>STATUS</p> <p>APPROVED SSD ENVELOPE (SSD 17_8351 AND 18_9347)</p>	<p>DRAWING</p> <p>SECTION A-A (N-S) ENVELOPE DRAWINGS</p> <p>DRAWN CHECKED AUTHORISED</p> <p>KY MC AC</p> <p>DRAWING NUMBER</p> <p>MPS_COA_000_XX_DR_A_DA1016_03</p> <p>REVISION</p>
	01	MAY 2017	STAGE 1 SSDA							
	02	JUNE 2018	AMENDING STAGE 1 SSDA							
	03	JANUARY 2019	AMENDING STAGE 1 SSDA UPDATE FOR DPE							

SECTION C-C (E-W, NORTH SITE)


SECTION C-C (E-W, NORTH SITE)

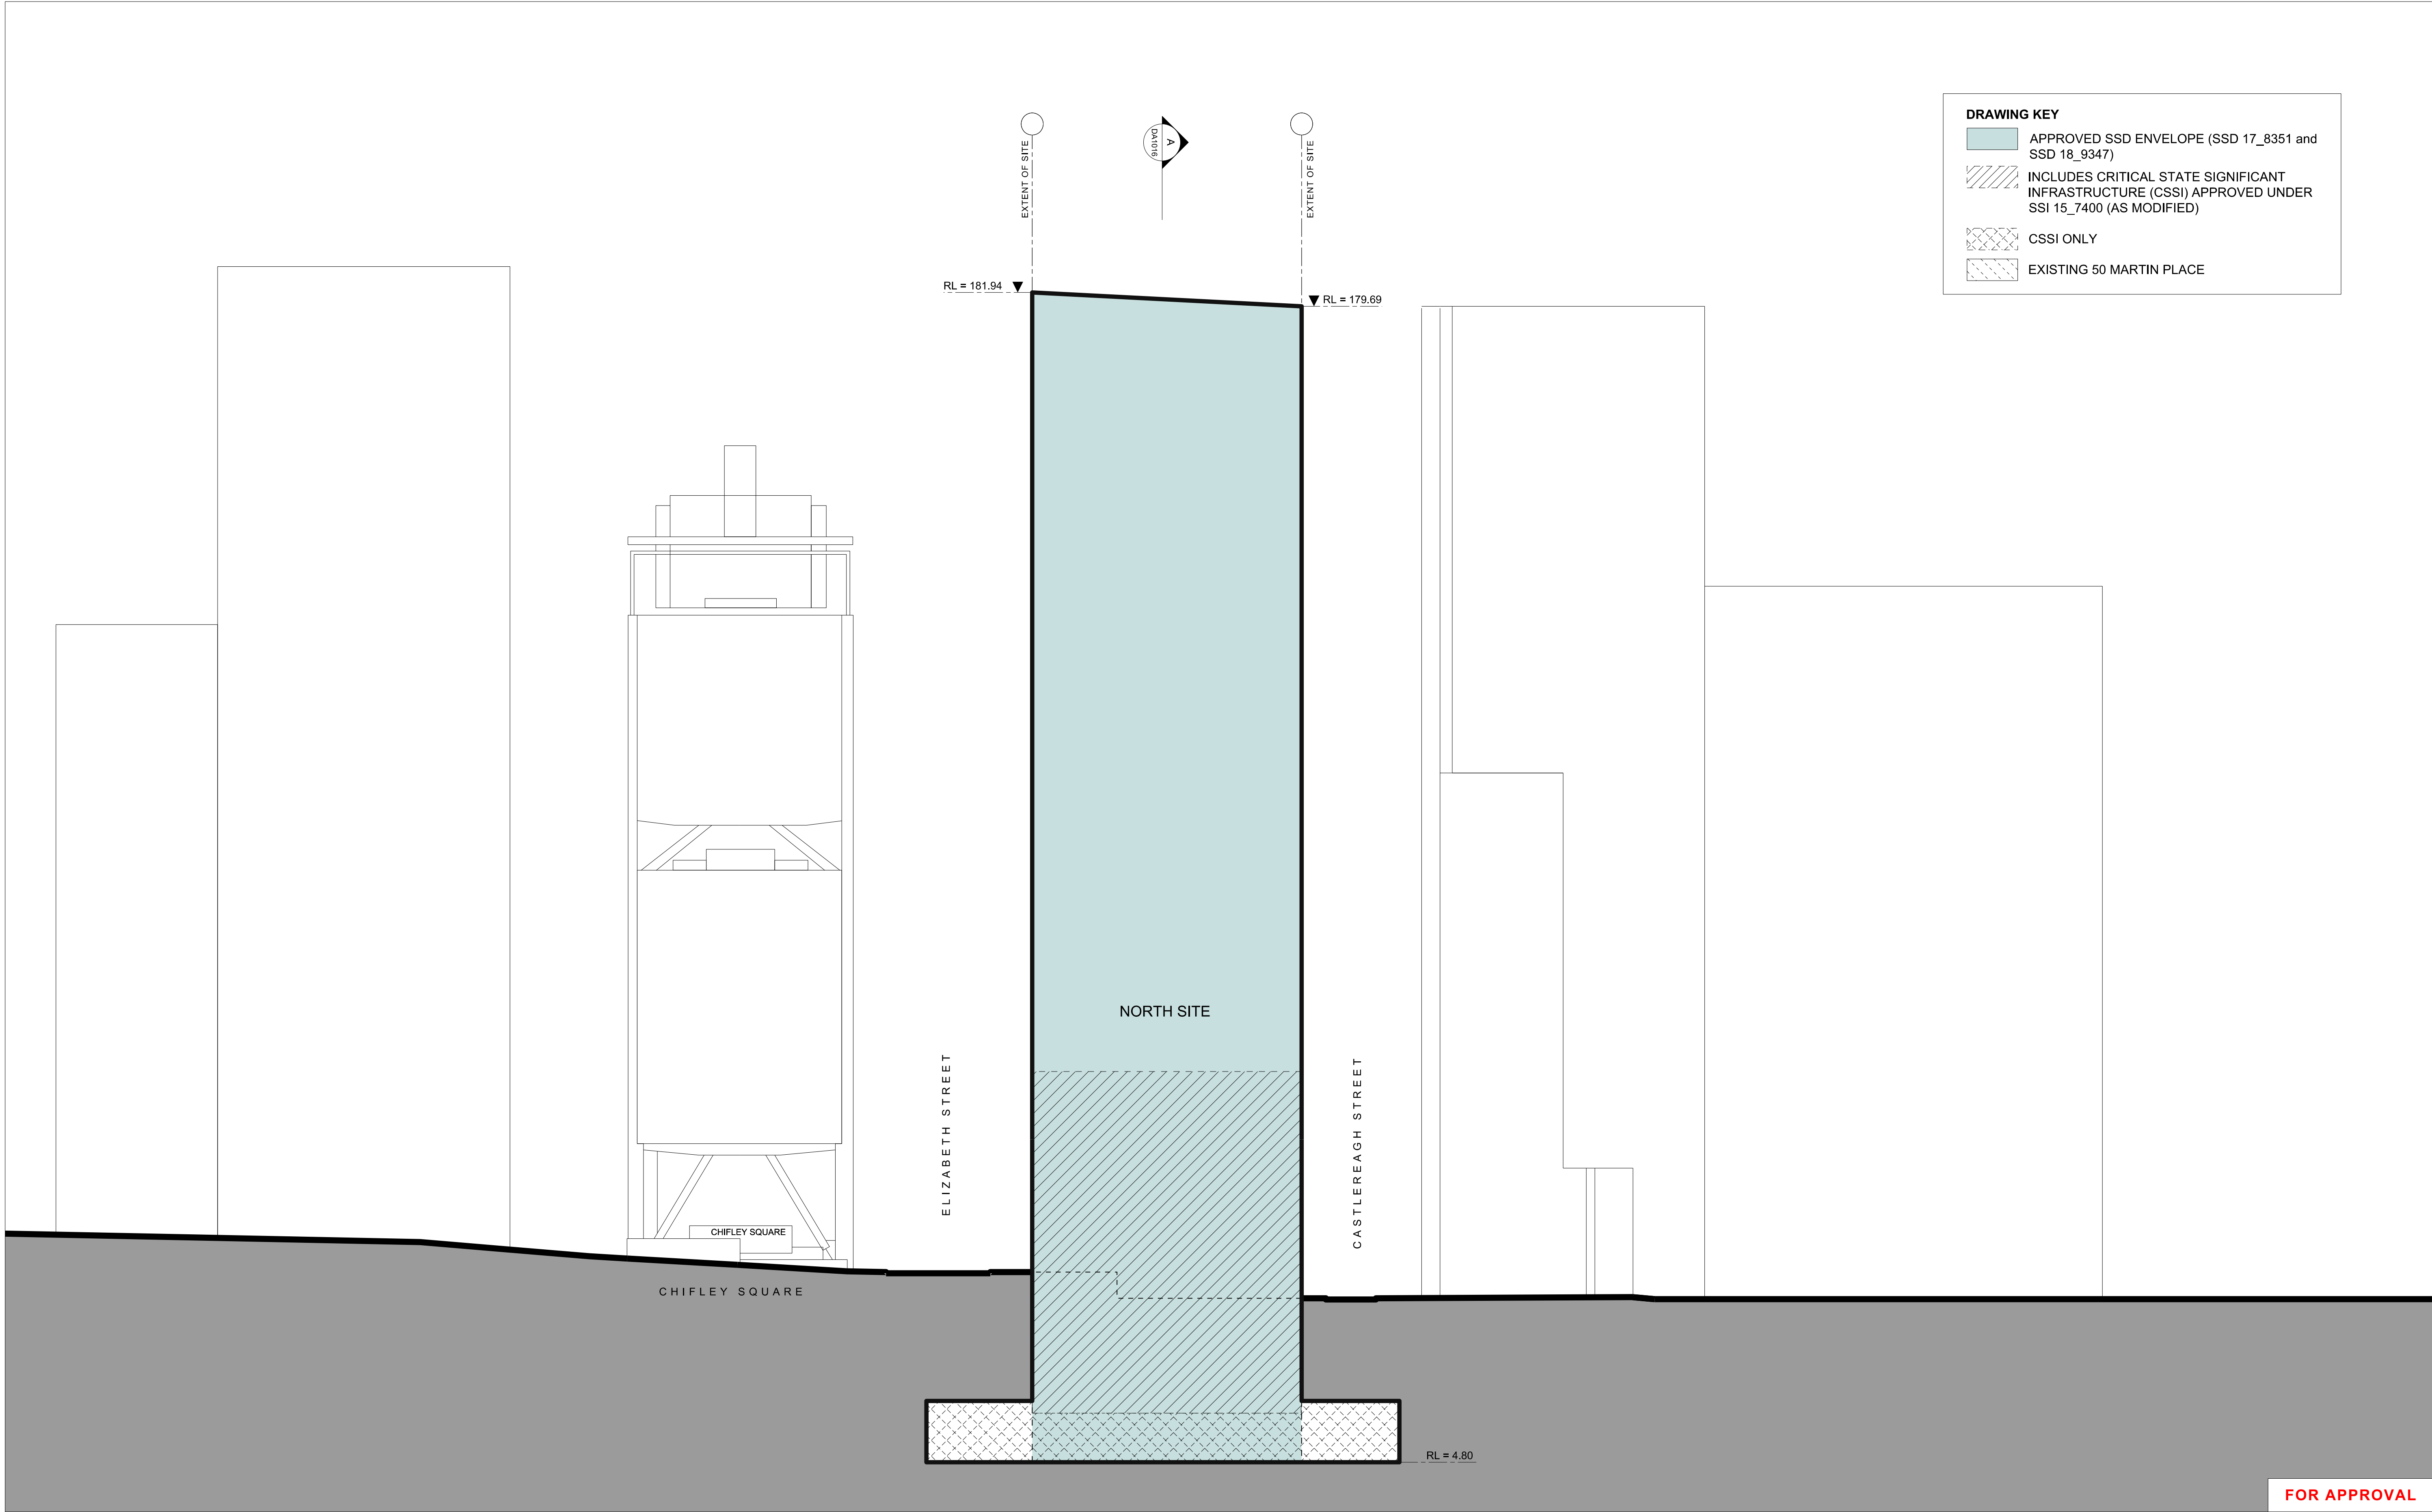

FOR APPROVAL

© COPYRIGHT GRIMSHAW ARCHITECTS PTY LIMITED. UNLESS OTHERWISE AGREED IN WRITING, ALL RIGHTS TO USE THIS DOCUMENT ARE SUBJECT TO PAYMENT IN FULL OF ALL GRIMSHAW CHARGES. THIS DOCUMENT MAY ONLY BE USED FOR THE EXPRESS PURPOSE AND PROJECT FOR WHICH IT HAS BEEN CREATED AND DELIVERED. AS NOTIFIED IN WRITING BY GRIMSHAW. AND THIS DOCUMENT MAY NOT BE OTHERWISE USED, OR COPIED, ANY UNAUTHORISED USE OF THIS DOCUMENT IS AT THE USER'S SOLE RISK AND WITHOUT LIMITING GRIMSHAW'S RIGHTS THE USER RELEASES AND INDEMNIFIES GRIMSHAW FROM AND AGAINST ALL LOSS SO ARISING

REV.	DATE	FOR
01	MAY 2017	STAGE 1 SSDA
02	JUNE 2018	AMENDING STAGE 1 SSDA
03	JANUARY 2019	AMENDING STAGE 1 SSDA UPDATE FOR DPE

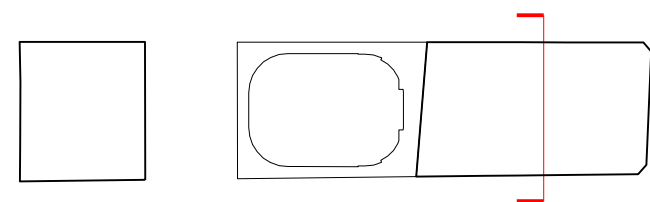

HEAD DESIGN CONSULTANT
GRIMSHAW

GRIMSHAW
LEVEL 3, 24 HICKSON ROAD, SYDNEY
NEW SOUTH WALES 2000 AUSTRALIA
TELEPHONE +61 2 9253 0200
WWW.GRIMSHAW.GLOBAL

NORTH TOWER PRINCIPAL
**JPW
JOHNSON PILTON WALKER**

JOHNSON PILTON WALKER PTY LTD ACN 095 778 886
LEVEL 10 PLAZA BUILDING AUSTRALIA SQUARE
36 PITT STREET SYDNEY
NEW SOUTH WALES 2000 AUSTRALIA
TELEPHONE +61 2 9259 5800
FACSIMILE +61 2 9259 5889
EMAIL JPW@JPW.COM.AU

HEAD ENGINEERING CONSULTANT
ARUP

ARUP
10/201 HENT STREET, SYDNEY 2000
TEL +61 2 9220 9200
EMAIL: SYDNEY@ARUP.COM

PROJECT
**SYDNEY METRO MARTIN PLACE STATION
MACQUARIE'S UNSOLICITED PROPOSAL**

CLIENT
MACQUARIE GROUP LTD

NORTH

SCALE
1:500 @ A1
DO NOT SCALE FROM DRAWING. USE MARKED DIMENSIONS TO BE READ IN CONJUNCTION WITH ALL OTHER CONSULTANT'S DRAWINGS.

STATUS
**APPROVED SSD ENVELOPE
(SSD 17_8351 AND 18_9347)**

DRAWING
**SECTION C-C (E-W, NORTH SITE)
ENVELOPE DRAWINGS**

DRAWN	CHECKED	AUTHORISED
KY	MC	AC

DRAWING NUMBER	REVISION
MPS_COA_000_XX_DR_A_DA1018_03	