 


inSW
Infrastructure
New South Wales

Cox Architecture
Level 6, 155 Clarence Street,
Sydney, NSW 2000, Australia
T + 61 2 8267 9599
F + 61 2 9264 1564
www.coxarchitecture.com.au

ASPECT Studios
78/80 George St, Redfern,
NSW, 2016, Australia
T + 61 2 9699 7162
www.aspect-studios.com/au

PLOT/STAMP DATE: 28/05/2013 2:11:52 PM

ADMINISTRATION FACILITIES
CATERING FACILITIES
CIRCULATION AREAS
CLEANING AND WASTE FACILITIES
COMMERCIAL FACILITIES
ENGINEERING SERVICES
EVENT DAY FACILITIES
FACILITY MANAGEMENT AREAS
HOSPITALITY AREAS
MEDIA FACILITIES
OTHER
PITCH
SEATING BOWL
TEAM FACILITIES



SUPERSEDES DRAWING: A1000 L0 BASEMENT PLAN



Client

INSW

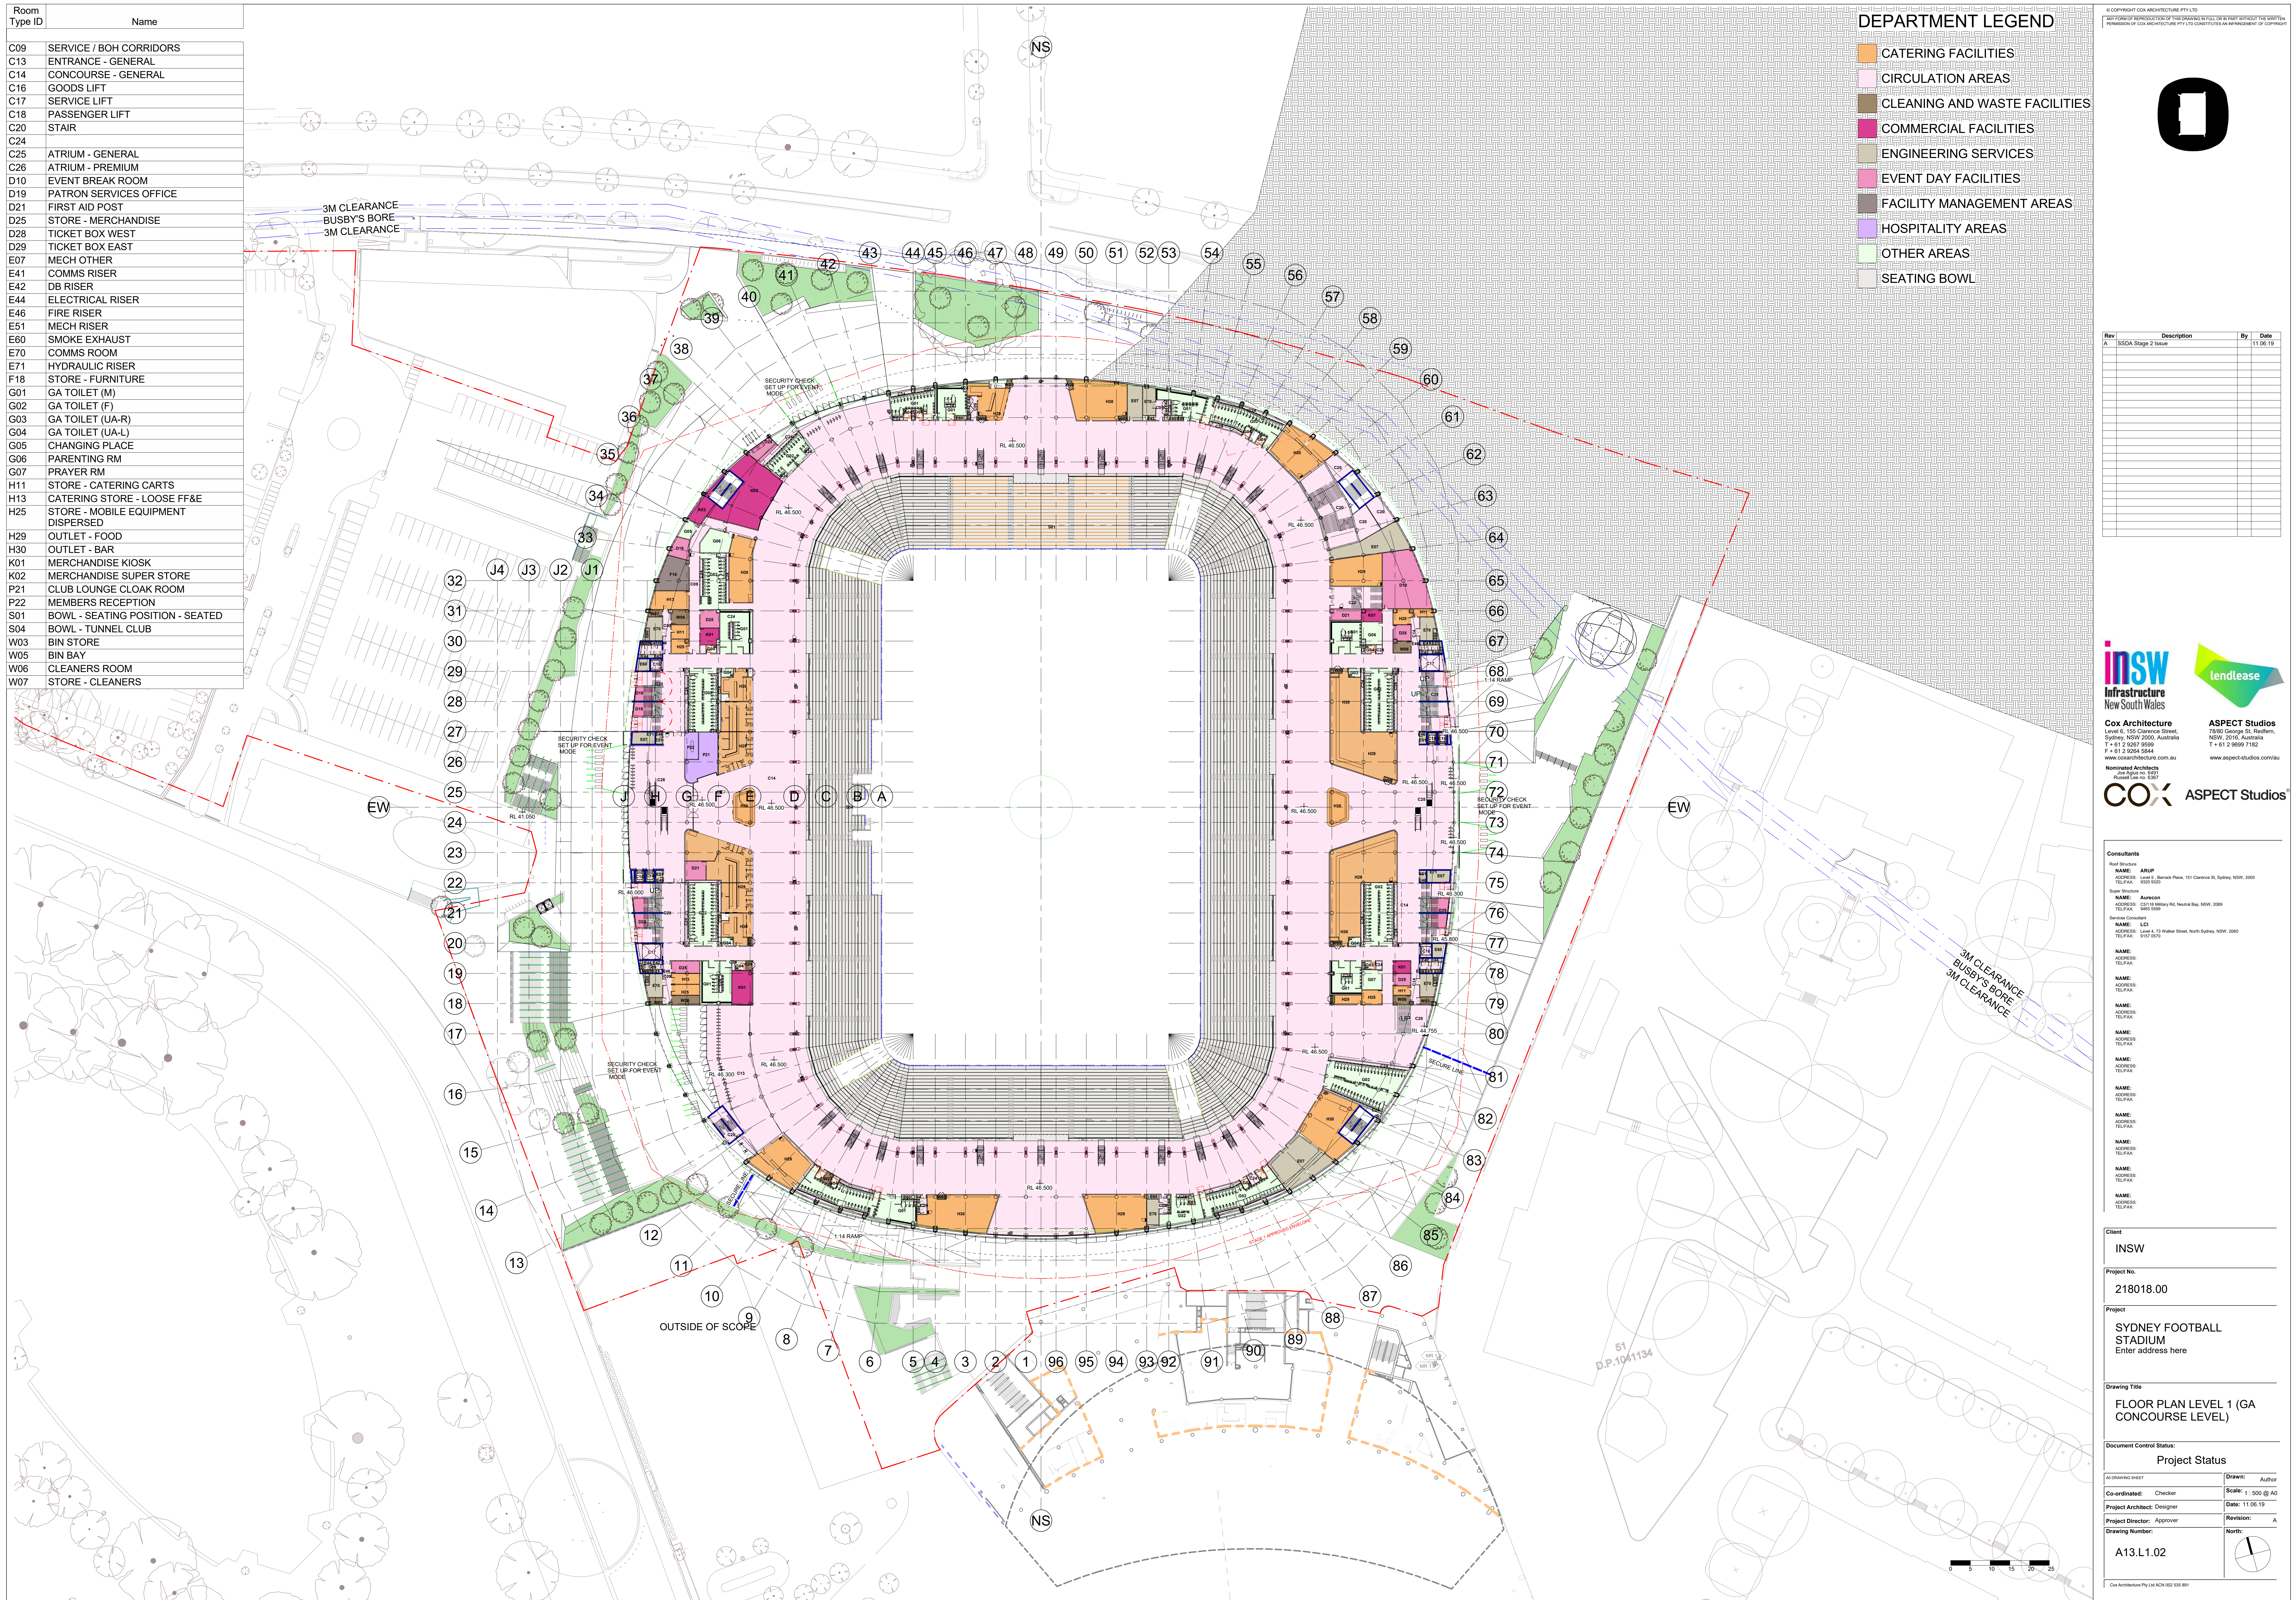
Drawing Title

FLOOR PLAN BASEMENT
LEVEL

Document Control Status:

Coa Architecture Pty Ltd ACN 002 535 89

Room Type ID	Name
C09	SERVICE / BOH CORRIDORS
C13	ENTRANCE - GENERAL
C14	CONCOURSE - GENERAL
C16	GOODS LIFT
C17	SERVICE LIFT
C18	PASSENGER LIFT
C20	STAIR
C24	
C25	ATRIUM - GENERAL
C26	ATRIUM - PREMIUM
D10	EVENT BREAK ROOM
D19	PATRON SERVICES OFFICE
D21	FIRST AID POST
D25	STORE - MERCHANDISE
D28	TICKET BOX WEST
D29	TICKET BOX EAST
E07	MECH OTHER
E41	COMMS RISER
E42	DB RISER
E44	ELECTRICAL RISER
E46	FIRE RISER
E51	MECH RISER
E60	SMOKE EXHAUST
E70	COMMS ROOM
E71	HYDRAULIC RISER
F18	STORE - FURNITURE
G01	GA TOILET (M)
G02	GA TOILET (F)
G03	GA TOILET (UA-R)
G04	GA TOILET (UA-L)
G05	CHANGING PLACE
G06	PARENTING RM
G07	PRAYER RM
H11	STORE - CATERING CARTS
H13	CATERING STORE - LOOSE FF&E
H25	STORE - MOBILE EQUIPMENT DISPERSE
H29	OUTLET - FOOD
H30	OUTLET - BAR
K01	MERCHANDISE KIOSK
K02	MERCHANDISE SUPER STORE
P21	CLUB LOUNGE CLOAK ROOM
P22	MEMBERS RECEPTION
S01	BOWL - SEATING POSITION - SEATED
S04	BOWL - TUNNEL CLUB
W03	BIN STORE
W05	BIN BAY
W06	CLEANERS ROOM
W07	STORE - CLEANERS

[illegible]

 
inSW
Infrastructure
New South Wales

Cox Architecture
Level 6, 155 Clarence Street,
Sydney, NSW 2000, Australia
T + 61 2 9267 9599
F + 61 2 9264 5844
www.coxarchitecture.com.au

lendlease

ASPECT Studios
78/80 George St, Redfern,
NSW, 2016, Australia
T + 61 2 9699 7182
www.aspect-studios.com/au

[illegible]

Client	
INSW	
Project No.	
218018.00	
Project	
SYDNEY FOOTBALL STADIUM Enter address here	
Drawing Title	
FLOOR PLAN LEVEL 1 (GA CONCOURSE LEVEL)	
Document Control Status:	
Project Status	
ALPHABETIC SHEET	Drawn: <i>Author</i>
Co-ordinated: ☐ Checker	Scale: 1:500 @ A0
Project Architect: Designer	Date: 11.06.19
Project Director: Approver	Revision: A
Drawing Number:	North: 
A13.L1.02	