



NOTES

- CIVIL DRAWING BASED UPON LANDSCAPE ARCHITECTURAL ISSUE FROM 15TH MARCH 2019.
- FINISHED REDUCED LEVEL TAKEN FROM LANDSCAPE ARCHITECTURAL SET DATED 15TH MARCH 2019.
- EXISTING REDUCED LEVELS FROM EXISTING SURVEY (COX) 12TH MARCH 2019.
- MINOR DRAINAGE LINES FROM PITs AND LINEAR DRAINS NOT SHOWN.

LEGEND:

- LINEAR DRAIN
- REINFORCED CONCRETE PIPES
- SYDNEY WATER DIVERSION
- 650x650 GRATED PIT
- SEALED JUNCTION PIT
- BOUNDARY
- EXISTING STORM PIPEWORK AND PITs
- SUBSOIL DRAINAGE PIPE
- EXISTING DRAINAGE PIPES FROM STRATA CELLS

ATTENTION CONTRACTORS AND SUB-CONTRACTORS:

THESE DRAWINGS AND SPECIFICATIONS ARE INTENDED FOR INDICATIVE PRICING PURPOSES ONLY AND NOT FOR TRADE PACKAGE TENDER PURPOSES OR CONSTRUCTION. THEY ARE BASED ON INFORMATION PROVIDED BY THE CLIENT GROUP AND OTHER KEY STAKEHOLDERS, WHICH MAY CONTAIN CONFLICTING DATA, OMISSIONS AND ERRORS.

AT THE TIME OF ISSUE, THESE DRAWINGS ARE BASED ON PRELIMINARY DESIGNS AND DOCUMENTATION WHICH IS KNOWN TO BE ONLY PARTIALLY COMPLETE. THE SUCCESSFUL CONTRACTOR AND SUB-CONTRACTOR WILL BE REQUIRED TO WORK WITH THE CONSULTANT TEAM, AUTHORITIES, STAKEHOLDERS AND CLIENT GROUPS TO DEVELOP THESE CONCEPTS INTO DETAILED DESIGNS WHICH CAN BE EXPECTED TO DIFFER IN SCOPE, CONCEPT AND DETAIL FROM THAT CURRENTLY SHOWN ON THE DRAWINGS.

THE SUCCESSFUL CONTRACTOR AND SUB-CONTRACTOR ARE ADVISED TO MAKE AN ASSESSMENT, BASED ON THEIR OWN EXPERIENCE WITH PROJECTS OF THIS NATURE, OF THE RISKS INVOLVED IN CHANGES IN REQUIREMENTS, INVESTIGATION OUTCOMES, SCOPE, CONCEPT AND DESIGN DETAIL AND TO PROVIDE IN THEIR TENDER AN ADEQUATE CONTINGENCY TO ENABLE THEM TO ACCOMMODATE ANY CHANGES OR FURTHER DEVELOPMENT.

aurecon
www.aurecongroup.com

CLIENT



REV	DATE	REVISION DETAILS	APPROVED
A	29.03.19	ISSUE FOR GMP PRICING	J. PIRRELLA
B	26.04.19	ISSUED FOR GMP PRICING	J. PIRRELLA

SCALE	SIZE	FOR INFORMATION
1:500	A0	
DRAWN		APPROVED
HANG, NGUYEN		DATE
DESIGNED		
MOROURKE		
REVIEWED		
MATT BURLEY		

PROJECT
SYDNEY FOOTBALL STADIUM REDEVELOPMENT


TITLE
SITE DRAINAGE PLAN

PROJECT NO.	WBS	TYPE	OSG	NUMBER	REV
505100	0000	- DWG -	CC -	00013	- B

DESIGN STATUS NOTES IF DRAWING USED FOR PRICING:
1. REFER TO DRAWING CC00003 FOR A DETAILED SCHEDULE OF ITEMS WHICH ARE EITHER NOT SHOWN OR NOT DESCRIBED IN FULL ON THE CIVIL ENGINEERING DRAWINGS, AND WILL REQUIRE ASSESSMENT OF APPROPRIATE COST ALLOWANCES AND CONTINGENCY AMOUNTS.



SCALE 1:500

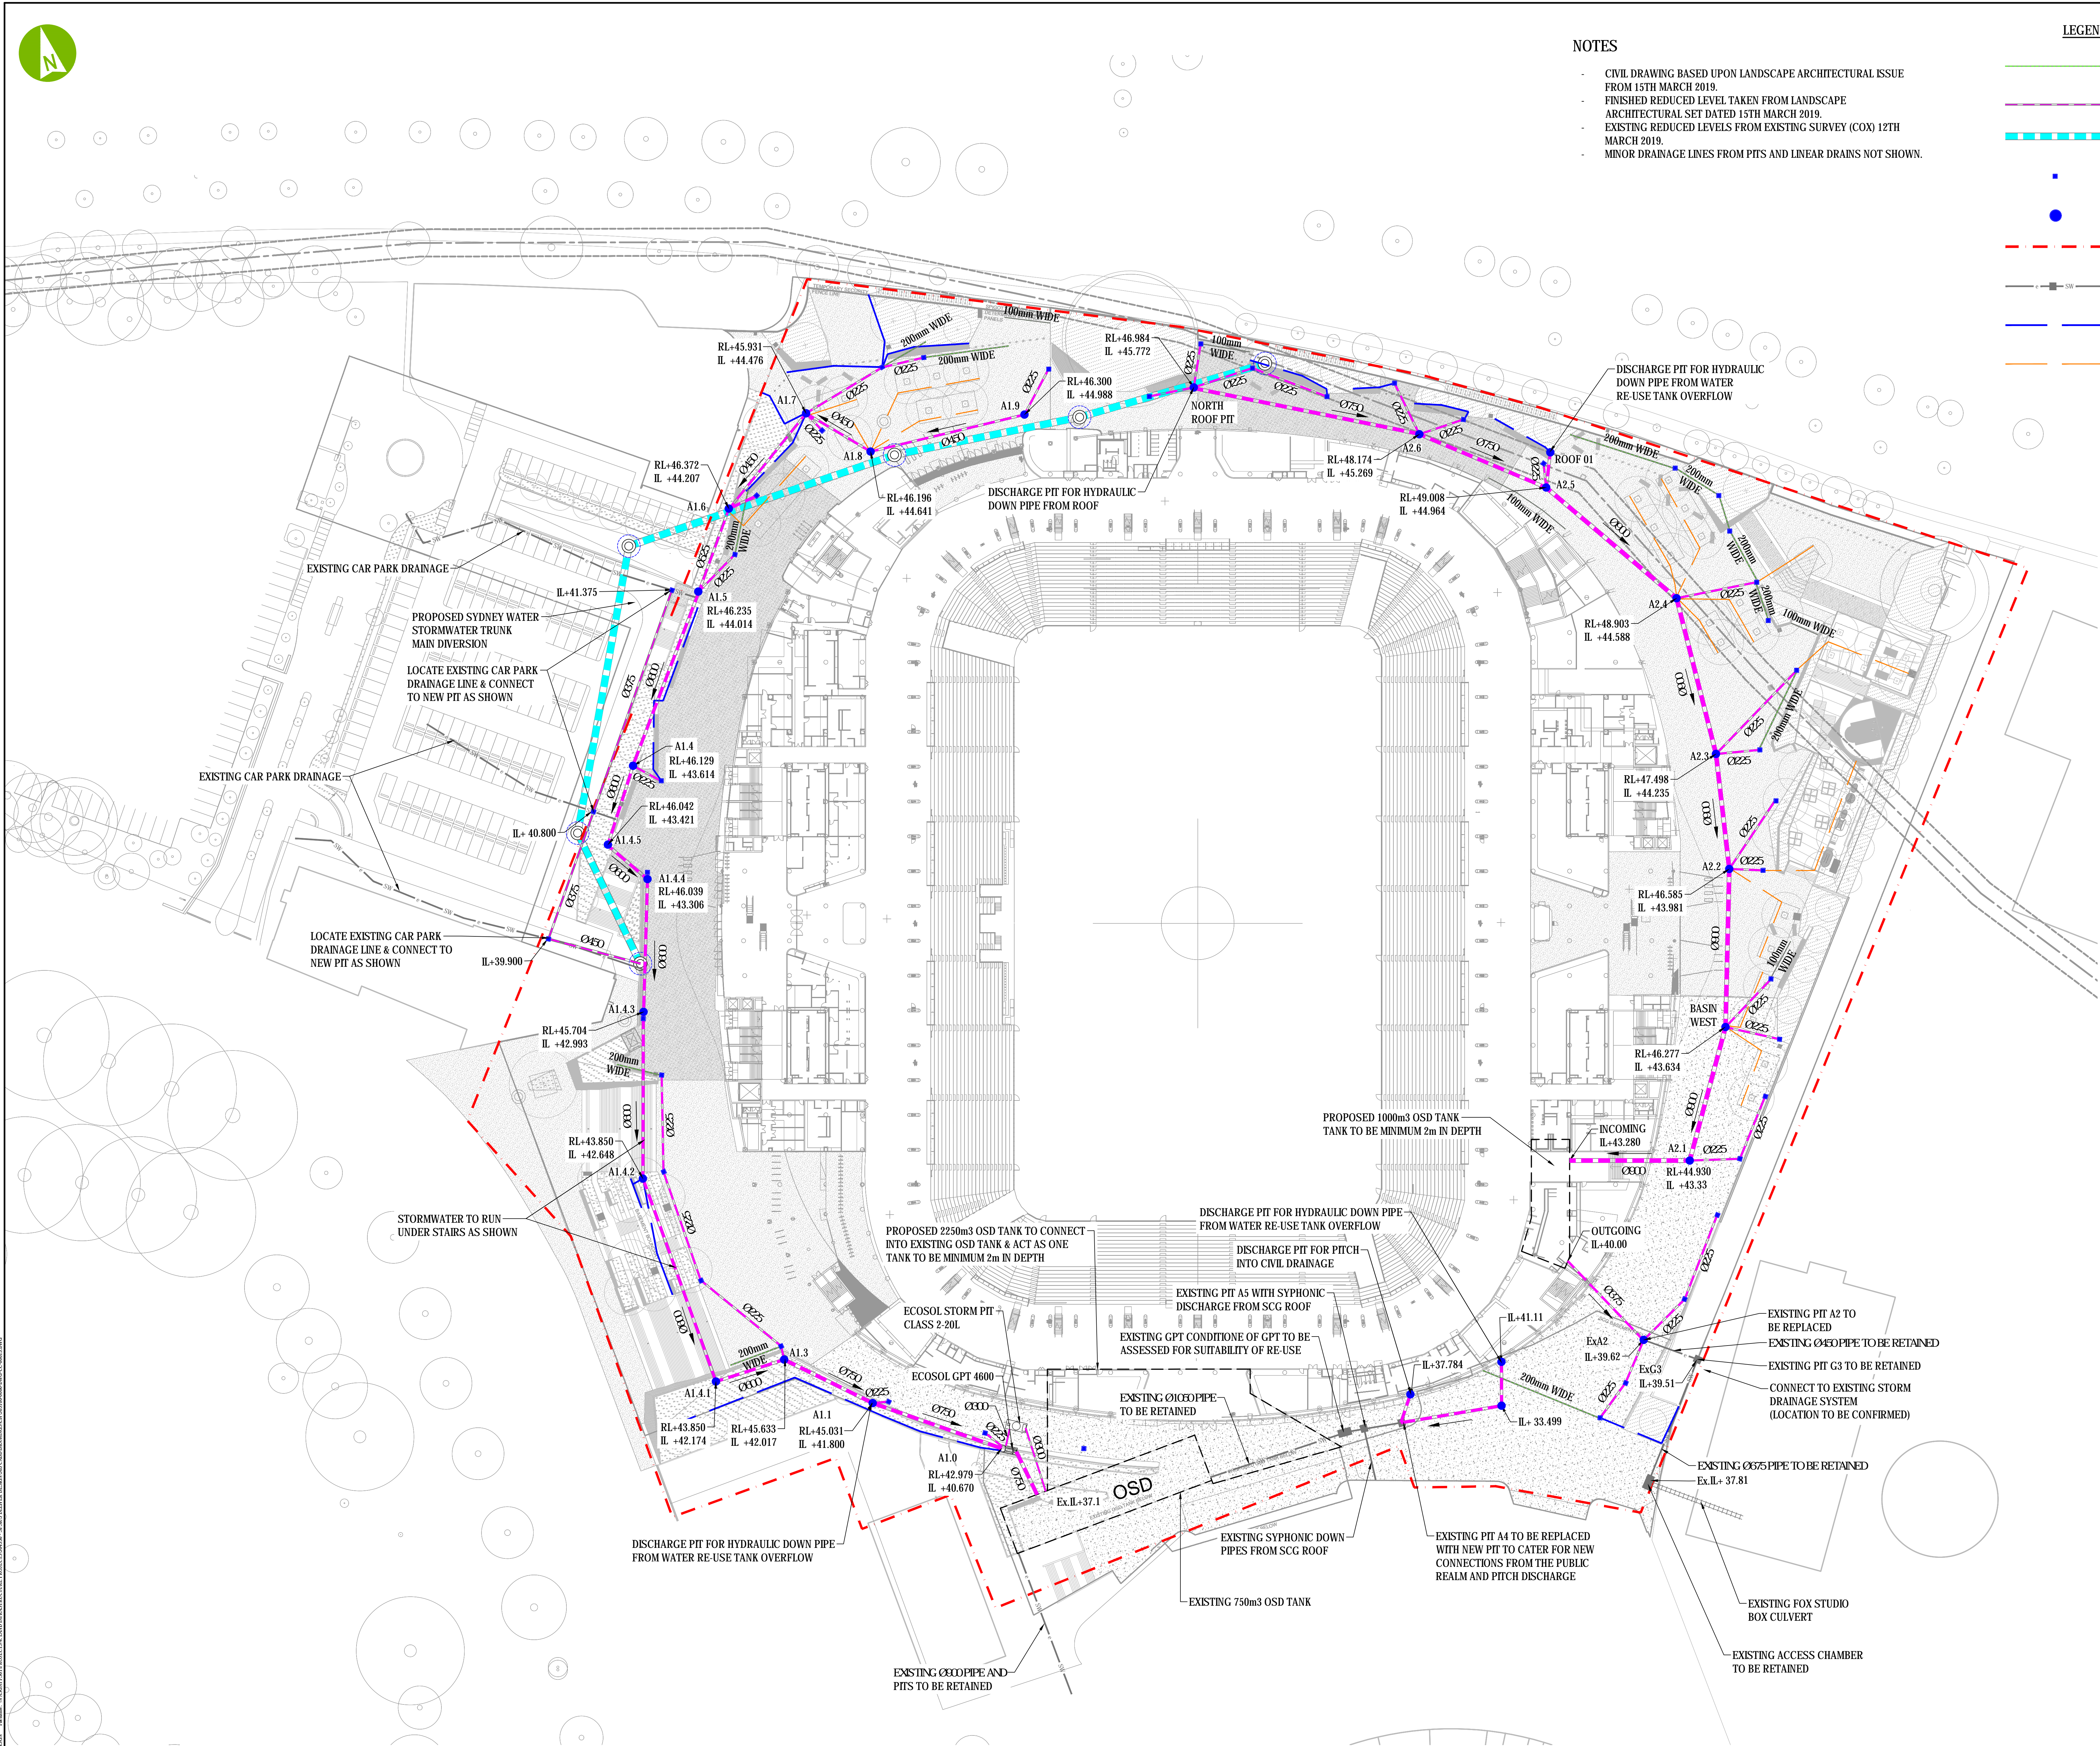

Plot Date: 29/03/2019 14:47 PM | User: JUNGUN | Drawn: VASANTHARAJAN | AutoCAD File Path: C:\Users\JUNGUN\Documents\PROJECTS\SYDNEY FOOTBALL STADIUM REDEVELOPMENT\DWG\CC00013.DWG